

ISSUE	DATE	FOR
1	16.07.10	SPP PDP
2	04.08.10	SPP PDP
3	16.08.10	INFORMATION
4	19.08.10	DA
5	23.08.10	DA
6	25.08.10	DA



PROJECT

**WESTMEAD
MILLENNIUM INSTITUTE &
RESEARCH HUB**

BVN PROJECT NUMBER

s0911005

DRAWING KEY

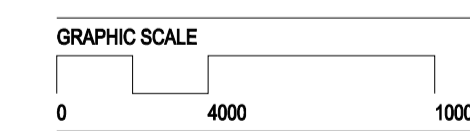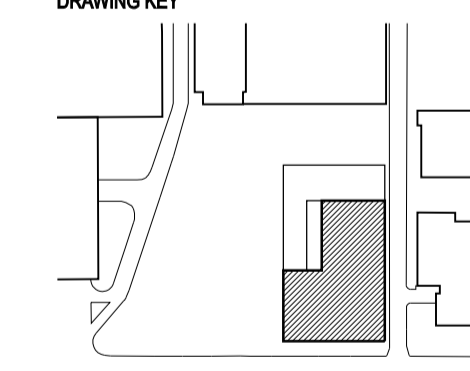

SCALE
1:400 at A3
1:200 at A1

DO NOT SCALE

STATUS

PRELIMINARY


DRAWING

**FLOOR PLAN
LEVEL 07 - PLANT**

DRAWING NUMBER

ISSUE

DA-D-07 6

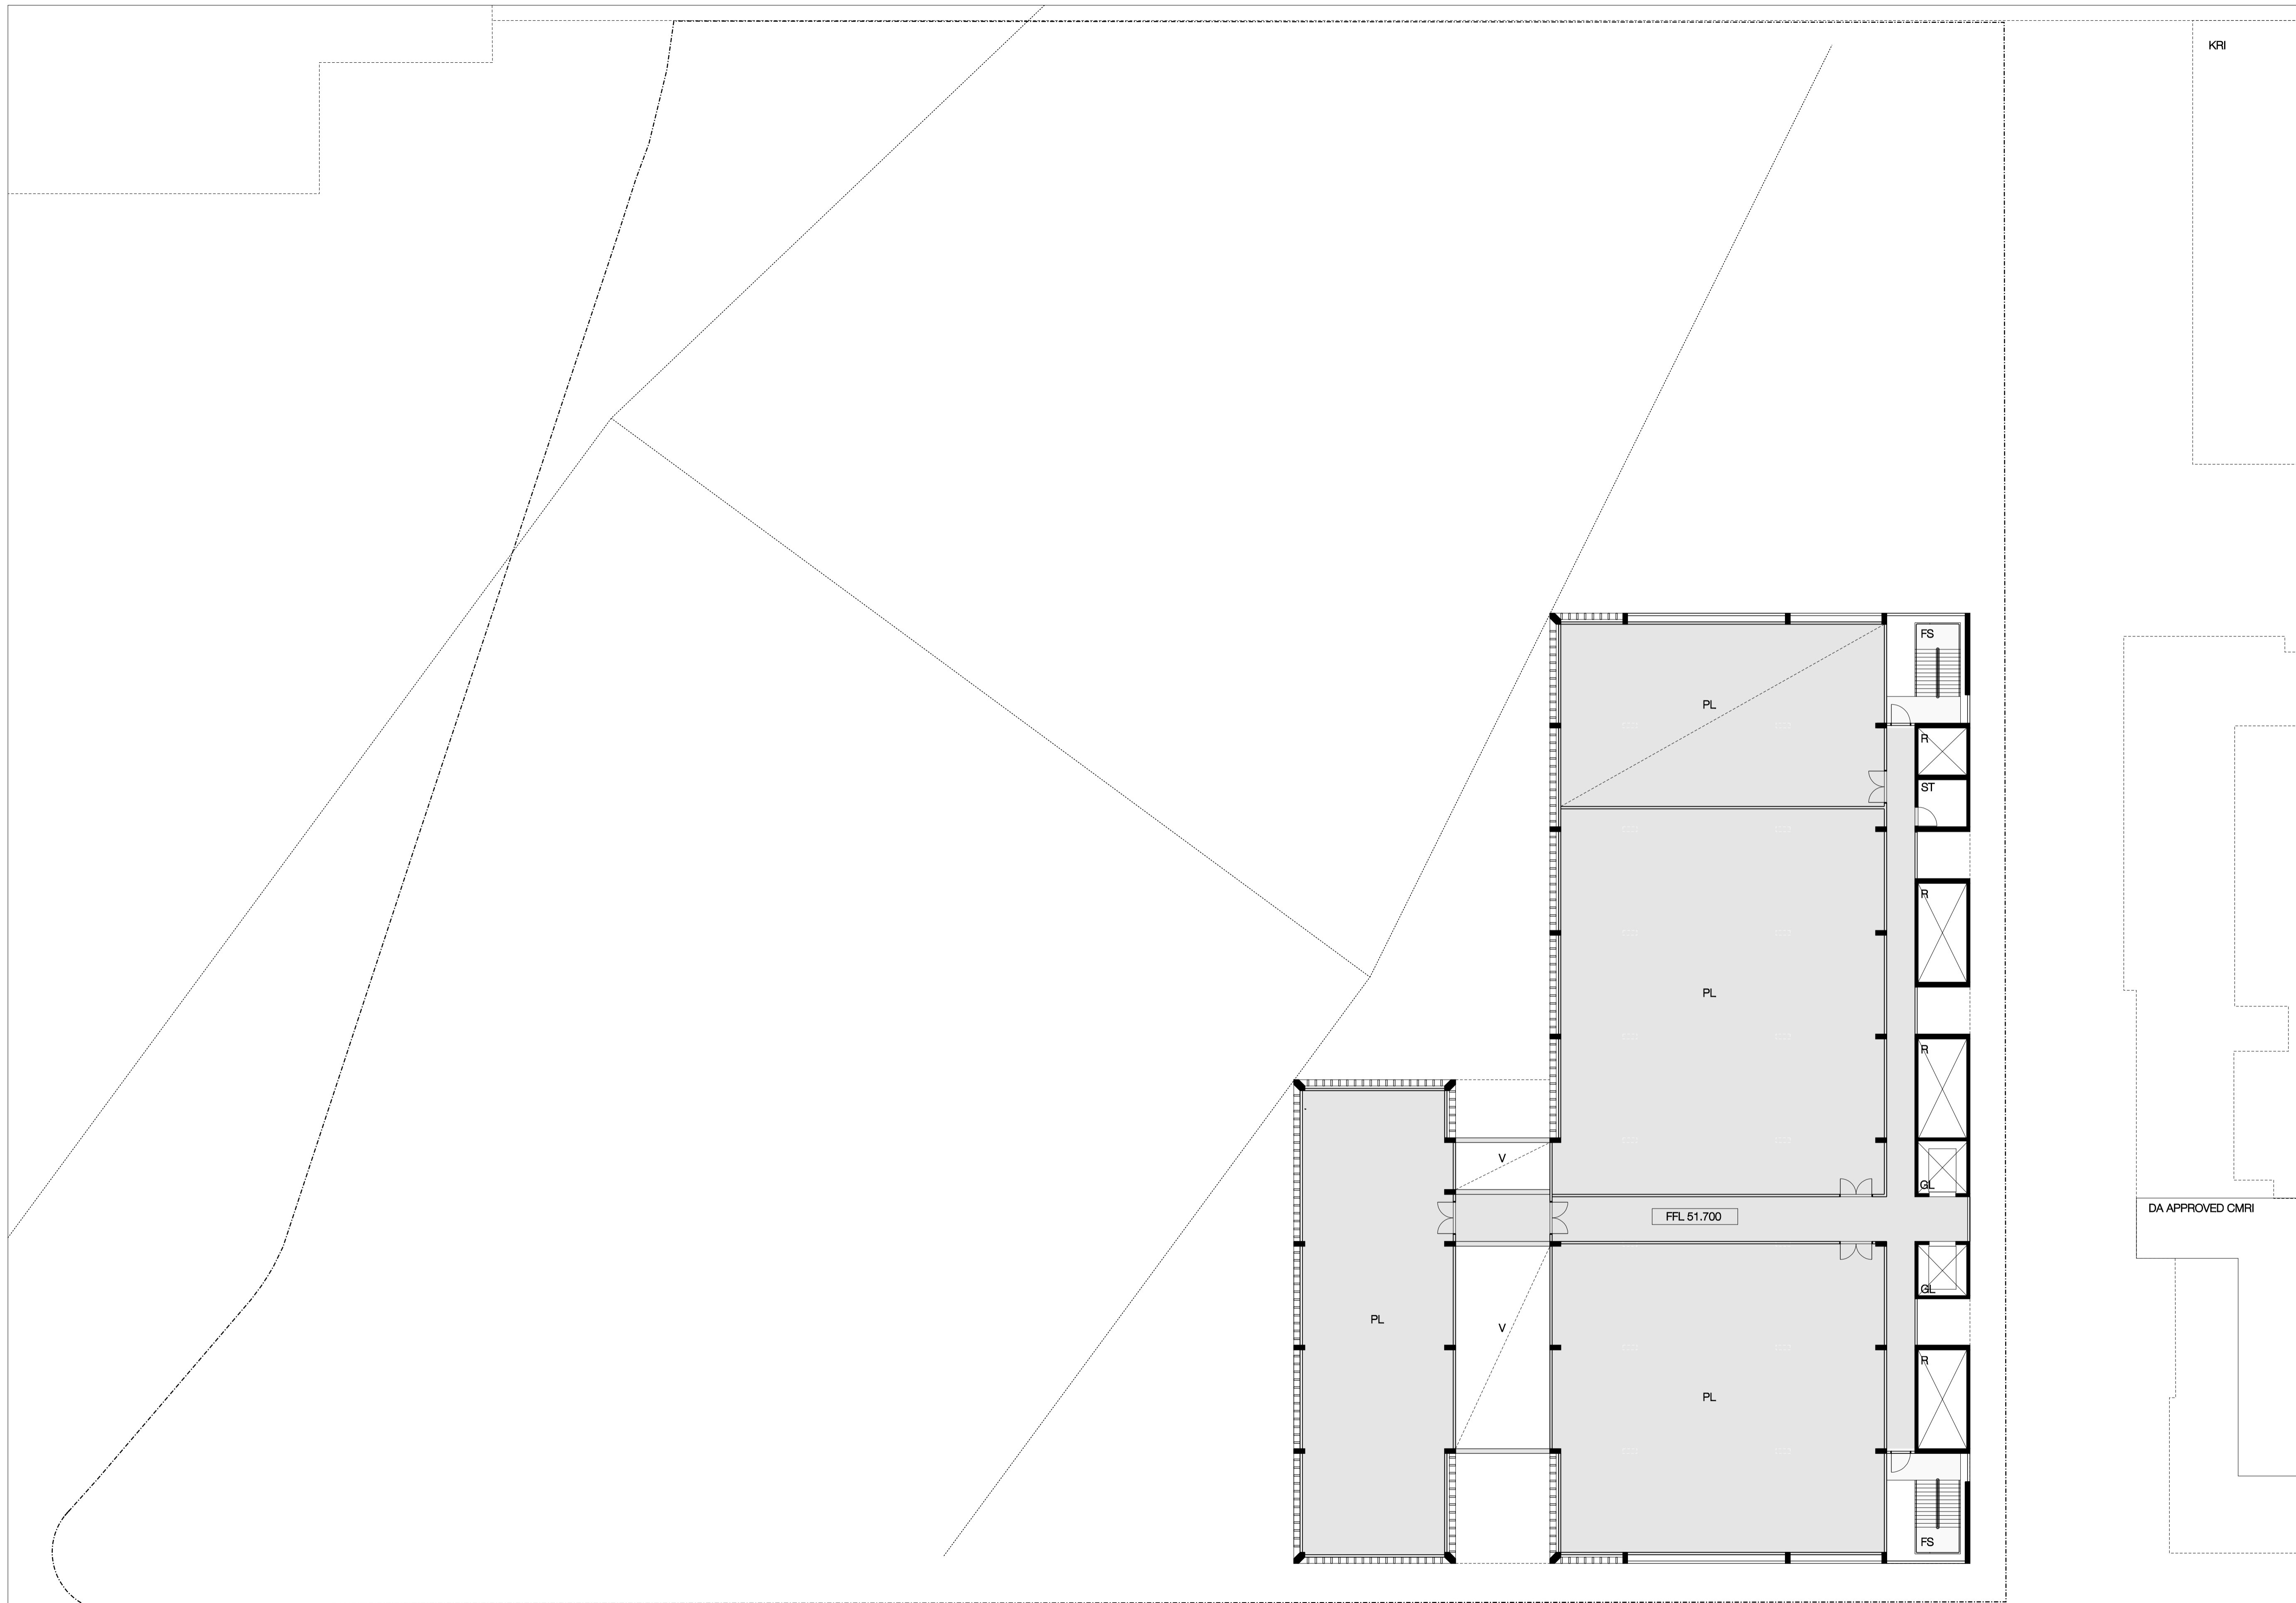

Legend

A Accessible WC	CRT Courtyard	FE Flue Exhaust	KT Kitchenette	MDR Metal Deck Roof	OP Open Plan Work Area	ST Storage	W Waste
AT Atrium	DP Downpipe	FG Feature Glass	L Lift	MEZ Mezzanine	PL Plant Room	TFP Transparent Facade Panel	WTG Waiting Area
BK Breakout Area	E Entry	FS Fire Stair	LAB Laboratory	MFP Metal Facade Panel	R Reception	U Unisex WC	
CFS Cafe Seating	F Female WC	G Glazing	LL Lift Lobby	MTG Meeting Room	RC Reinforced Concrete	V Void	
COR Corridor	FA First Aid Room	GL Goods Lift	M Male WC	N Nitrogen Tank Store	S Skylight	VL Vertical Louvers, Metal Facade Beyond	
CP Car Park	FC Female Change/Showers	GR Green Roof	MC Male Change/Shower	OF Office	SS Substation	VLG Vertical Louvers, Glazing Behind	