


ANNEXURE B – CONCEPT SKETCHES

Mechanical Services

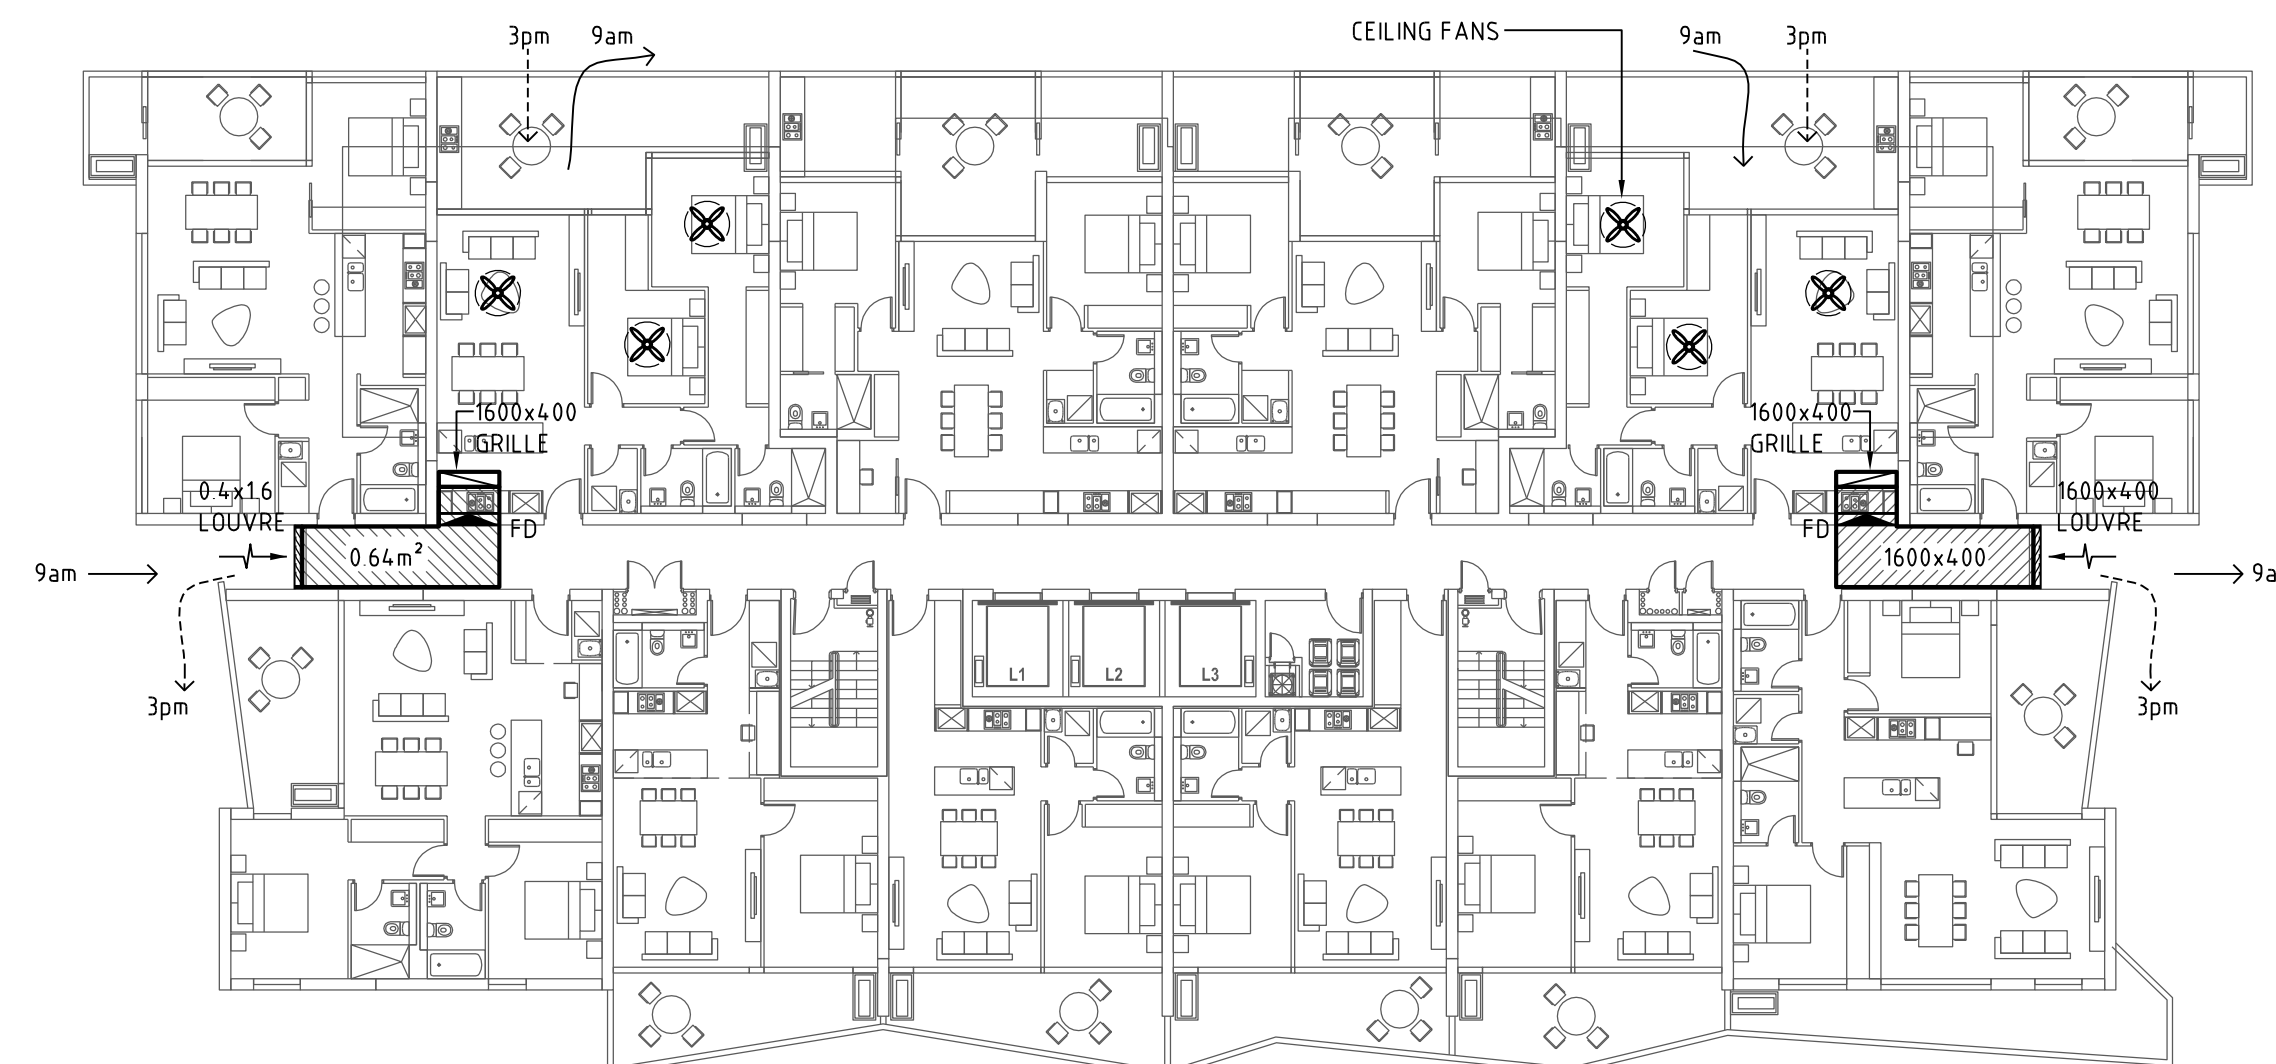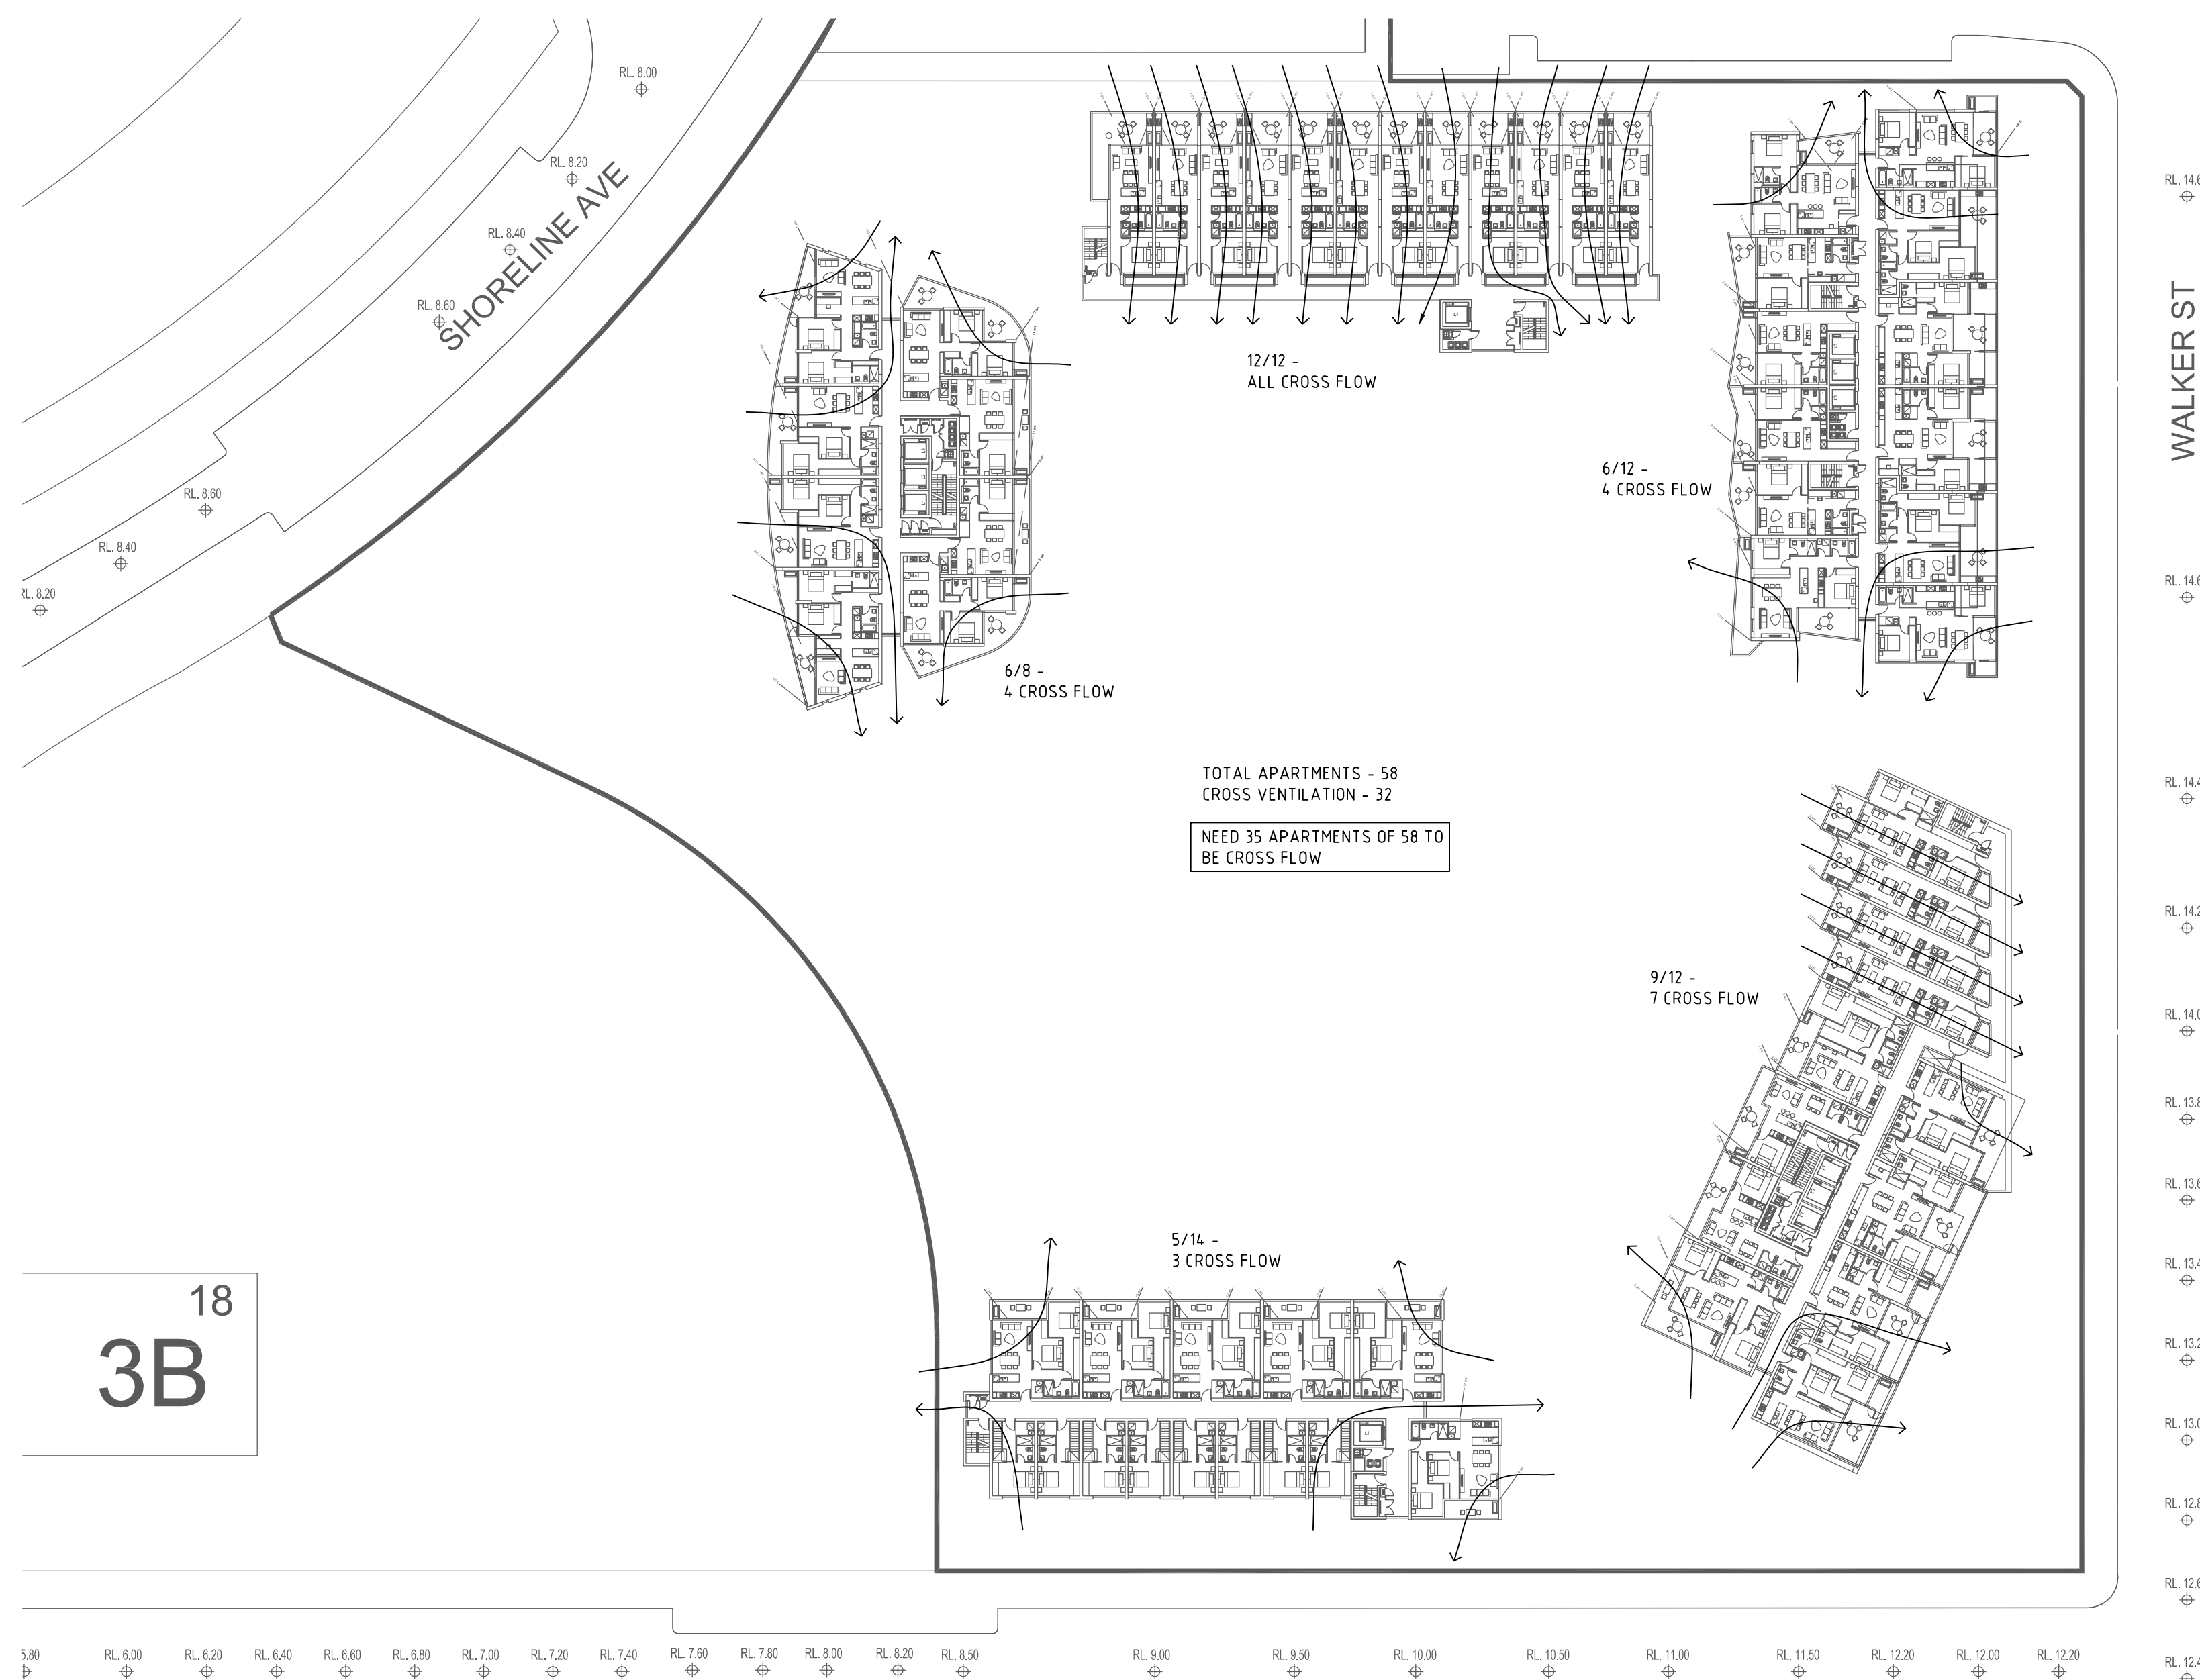

SCALE 1:200

18
3B

SCALE 1:500

[illegible]

CONSULTANT



Shaping the Future

SYDNEY
BRISBANE
CANBERRA
MELBOURNE
PERTH

Cardno ITC Pty. Limited
LEVEL 7, 33 YORK STREET
SYDNEY NSW 2000
Phone: + 61 2 9495 8100
Fax: + 61 2 9495 8111
Email: sydney.itc@cardno.com.au
www.cardnoltp.com.au


CLIENT	
--------	--

BILLBERGIA
Level 2, 25 Angas St
Meadowbank
NSW



SJB Architects

Level 2
490 Crown Street
Surry Hills NSW
2010 Australia
T 61 2 9380 9911
F 61 2 9380 9922
www.sjb.com.au

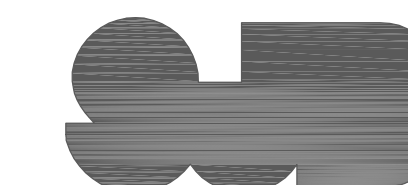

PROJECT


40 Walker St
Rhodes
Stages 2A & 3A


DRAWING TITLE

MECHANICAL SERVICES


CROSS FLOW VENTILATION ASSESSMENT SKETCH

DRAWN	DESIGNED	CHECKED	SCALE (AT FULL SIZE)
K.T.	A.M.	A.M.	AS NOTED
DATE	DRAWING No.		REVISION
Nov '10	N10957-SKM08		01

 

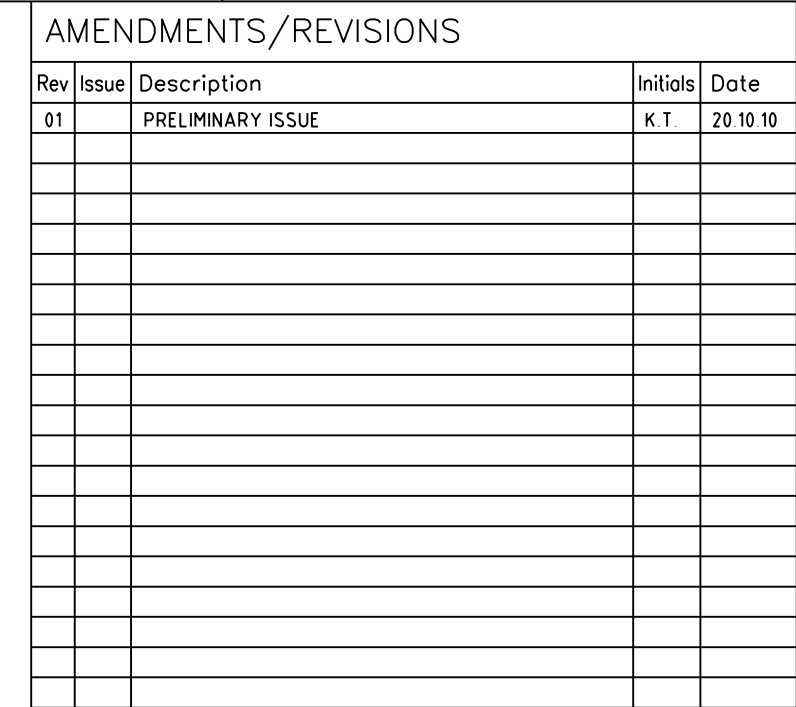

CONSULTANT

 

Cardno
ITC

Shaping the Future

SYDNEY
BRISBANE
CANBERRA
MELBOURNE
PERTH

Cardno ITC Pty. Limited
LEVEL 7, 33 YORK STREET
SYDNEY NSW 2000
Phone: + 61 2 9495 8100
Fax: + 61 2 9495 8111
Email: sydney.itc@cardno.com.au
www.cardnoltd.com.au




Billbergia
creating communities



DRAWING TITLE



MECHANICAL SERVICES
LEVEL 1
AIR CONDITIONING & VENTILATION LAYOUT
SKETCH

DRAWN	DESIGNED	CHECKED	SCALE (AT FULL SIZE)
K.T.	A.M.	A.M.	1:500
DATE	DRAWING No.		REVISION
Oct '10	N10957-SKM04		01

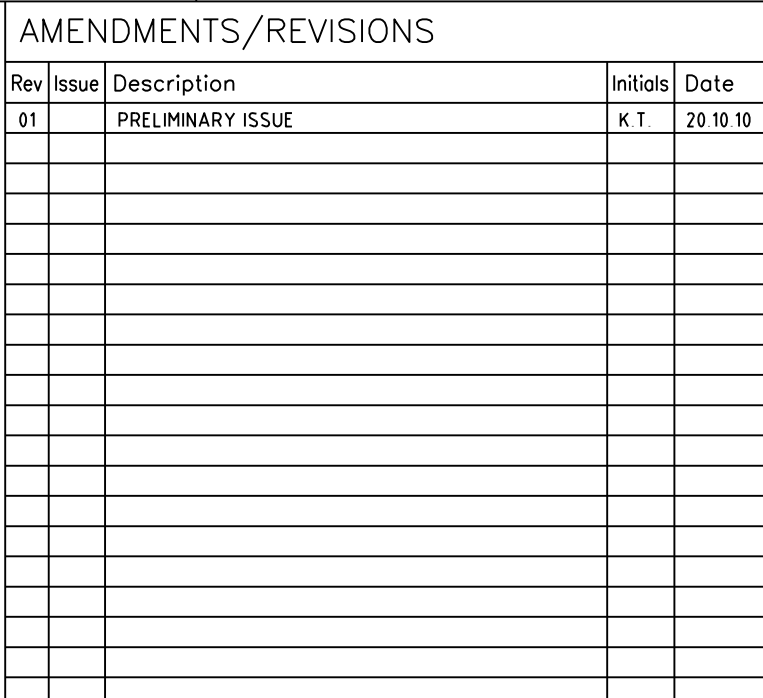


DRAWN	DESIGNED	CHECKED	SCALE (AT FULL SIZE)	
K.T.	A.M.	A.M.	1:500	
DATE		DRAWING No.		REVISION
Oct '10		N10957-SKM03		01

 PODIUM LEVEL

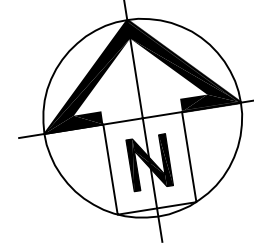

CONSULTANT

 

Cardno
ITC

Shaping the Future

SYDNEY
BRISBANE
CANBERRA
MELBOURNE
PERTH

Cardno ITC Pty. Limited
LEVEL 7, 33 YORK STREET
SYDNEY NSW 2000

Phone: + 61 2 9495 8100
Fax: + 61 2 9495 8111
Email: sydney.itc@cardno.com.au
www.cardnoltc.com.au



Hillbergia
creating communities





DRAWING TITLE

MECHANICAL SERVICES
BASEMENT 1
AIR CONDITIONING & VENTILATION LAYOUT
SKETCH


DRAWN	DESIGNED	CHECKED	SCALE (AT FULL SIZE)	
K.T.	A.M.	A.M.	1:500	
DATE		DRAWING No.		REVISION
Oct '10		N10957-SKM02		01

 BASEMENT 01

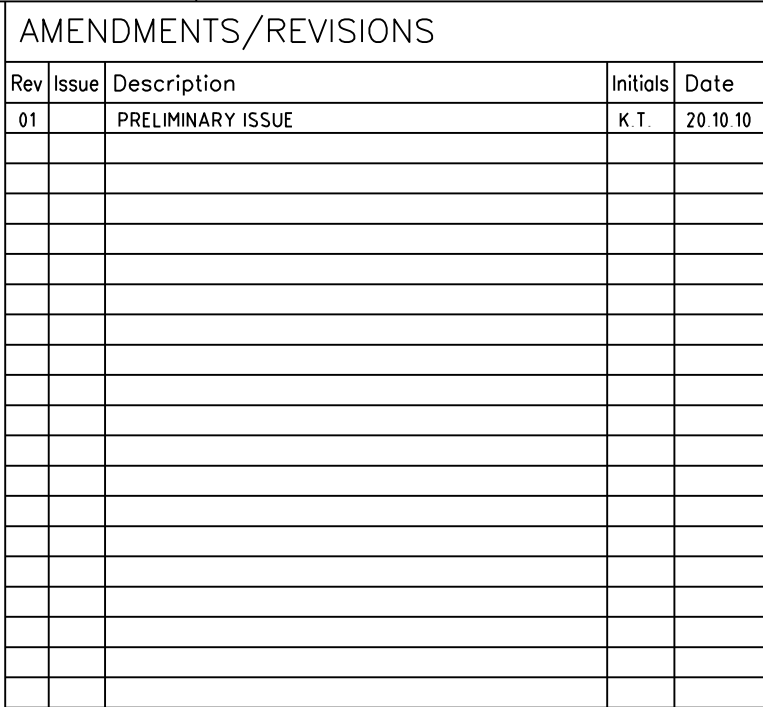


DRAWN	DESIGNED	CHECKED	SCALE (AT FULL SIZE)
K.T.	A.M.	A.M.	1:500
DATE	DRAWING No.	REVISION	
Oct '10	N10957-SKM01	01	

 BASEMENT 02



Hydraulic/Fire Services

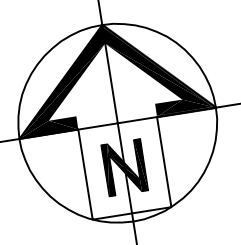

CONSULTANT



Cardno
ITC

Shaping the Future

SYDNEY
BRISBANE
CANNBERRA
MELBOURNE
PERTH

Cardno ITC Pty. Limited
LEVEL 7, 33 YORK STREET
SYDNEY NSW 2000
Phone: + 61 2 9495 8100
Fax: + 61 2 9495 8111
Email: sydney.its@cardno.com.au
www.cardnolic.com.au

SJB Architects

Level 2
490 Crown Street
Surry Hills NSW
2010 Australia
T 61 2 9380 9911
F 61 2 9380 9922
www.sjb.com.au



DRAWING TITLE

HYDRAULIC SERVICES

LEVELS 19 - 24

BUILDING A

SKETCH

DRAWN	DESIGNED	CHECKED	SCALE (AT FULL SIZE)
B.M.	M.T.	M.T.	1:150
DATE		DRAWING No.	REVISION
Oct '10		N10957-H22	01