


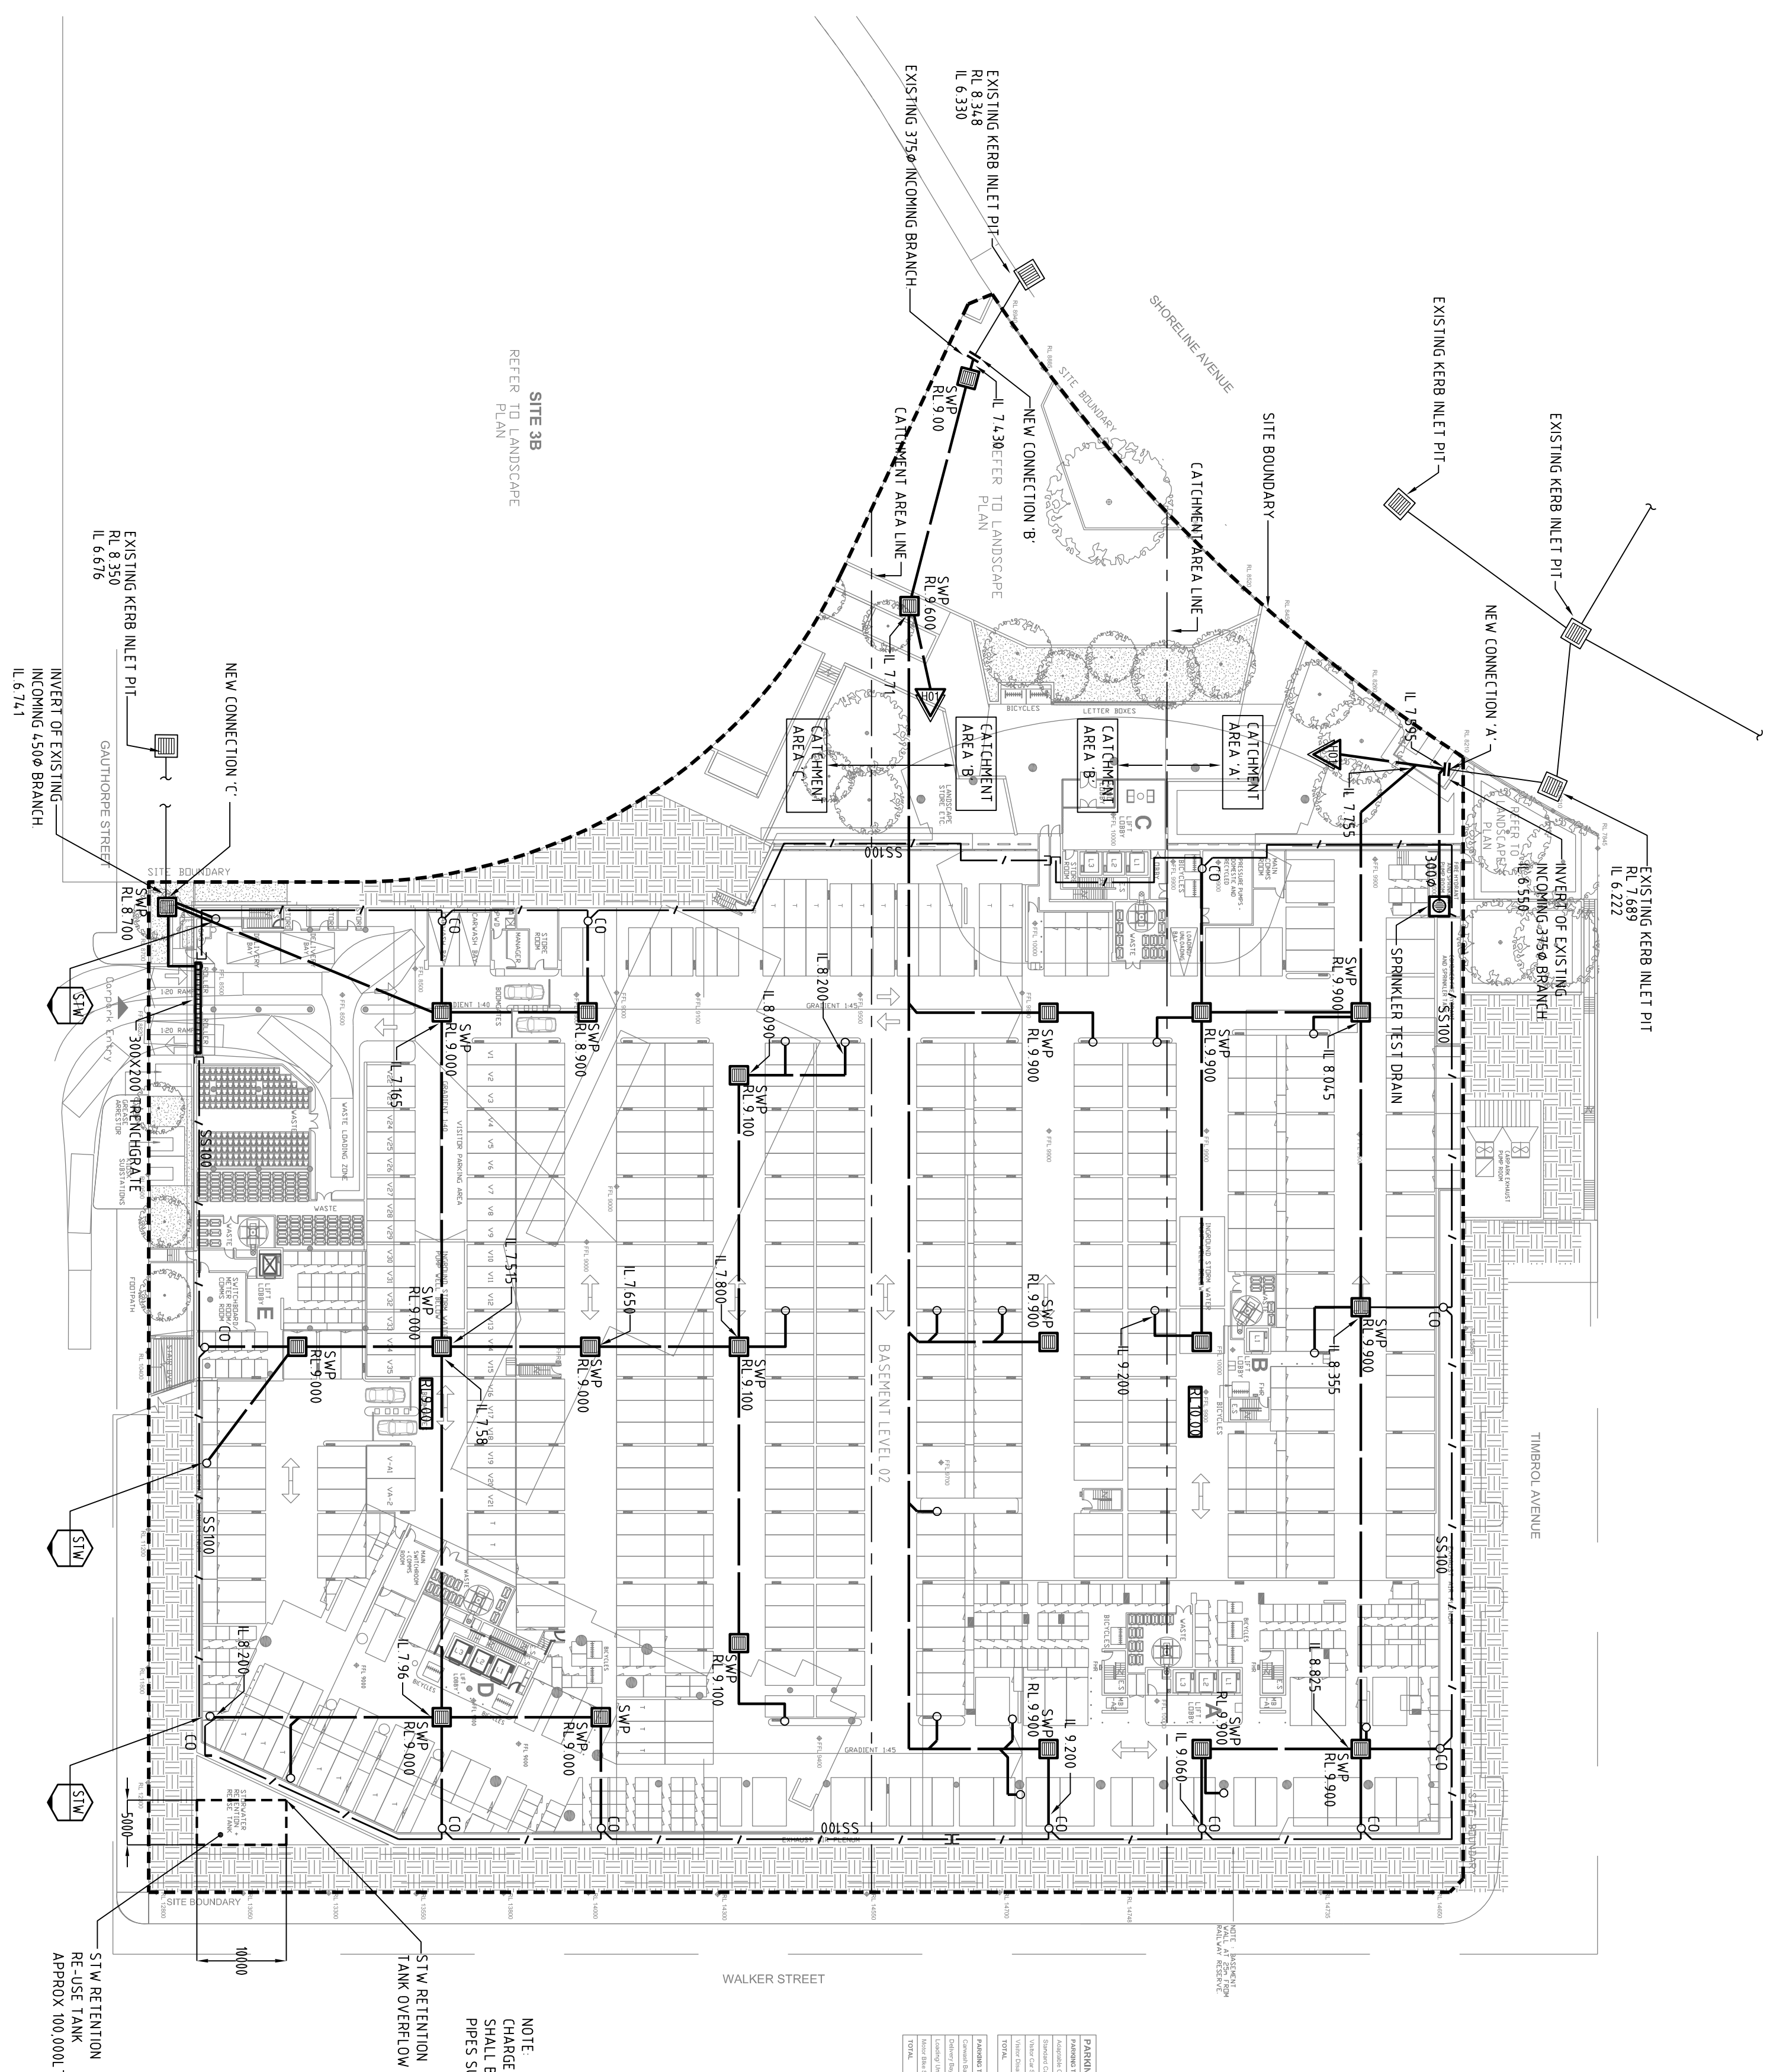


NOTE:  
CHARGED LINE DIRECTED TO RAINWATER RE-USE TANK  
SHALL BE A MINIMUM OF 150Ø, SOL VENT WELDED UPVC  
PIPES SUITABLE FOR PRESSURE APPLICATIONS

| PARINING SCHEDULE - BASEMENT - 02 |           |  |
|-----------------------------------|-----------|--|
| PARINING TYPE                     | NUMBER    |  |
| Assigned Car Space                | 23        |  |
| Standard Car Space                | 504       |  |
| Motor Cycle Space                 | 36        |  |
| Motor Disabled Car Space          | 4         |  |
| <b>TOTAL</b>                      | <b>43</b> |  |

| PARINING TYPE         | NUMBER   |  |
|-----------------------|----------|--|
| General Bay           | 2        |  |
| Delivery Bay          | 2        |  |
| Loading/Unloading Bay | 1        |  |
| Waiting Bay (Queue)   | 2        |  |
| <b>TOTAL</b>          | <b>7</b> |  |

[illegible]

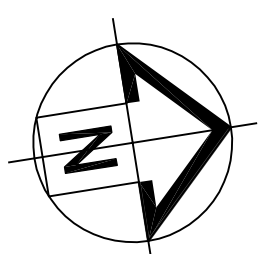CONSULTANT



## Shaping the Future

**SYDNEY**  
**BRISBANE**  
**CANBERRA**  
**MELBOURNE**  
**PERTH**

**Cardno ITC Pty, Limited**  
LEVEL 7, 33 YORK STREET  
SYDNEY NSW 2000

Phone: + 61 2 9495 8100  
Fax: + 61 2 9495 8111  
Email: sydney, itc@cardno.com.au  
www.cardnoic.com.au

Email: [sydney.itt@cardno.com.au](mailto:sydney.itt@cardno.com.au)  
[www.cardnoltc.com.au](http://www.cardnoltc.com.au)


**BILLBERGIA**  
Level 2, 25 Angas St  
Meadowbank  
NSW



**Bilbergia**  
Publishing Community

SJB Architects

490 Crown Street  
Surrey Hills NSW  
2010 Australia  
T 61 2 9380 9911  
F 61 2 9380 9922  
www.sjb.com.au

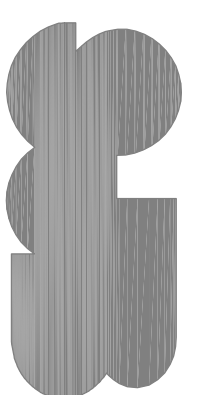

PROJECT:

40 Walker St  
Rhodes  
Stages 2A & 3A

HYDRAULIC SERVICES - BASEMENT LEVEL 2  
SCALE: 1:500

## DRAWING TITLE



# HYDRAULIC SERVICES

## STORMWATER CONCEPT PLAN

|       |             |         |                      |
|-------|-------------|---------|----------------------|
| DRAWN | DESIGNED    | CHECKED | SCALE (AT FULL SIZE) |
| M.T.  | M.T.        | M.T.    | 1:500                |
| DATE  | DRAWING NO. |         |                      |

|         |                |
|---------|----------------|
| Oct '10 | N10957-STW-H01 |
|---------|----------------|

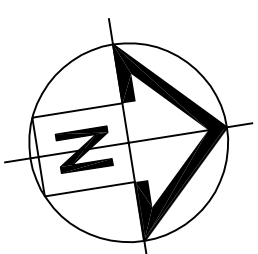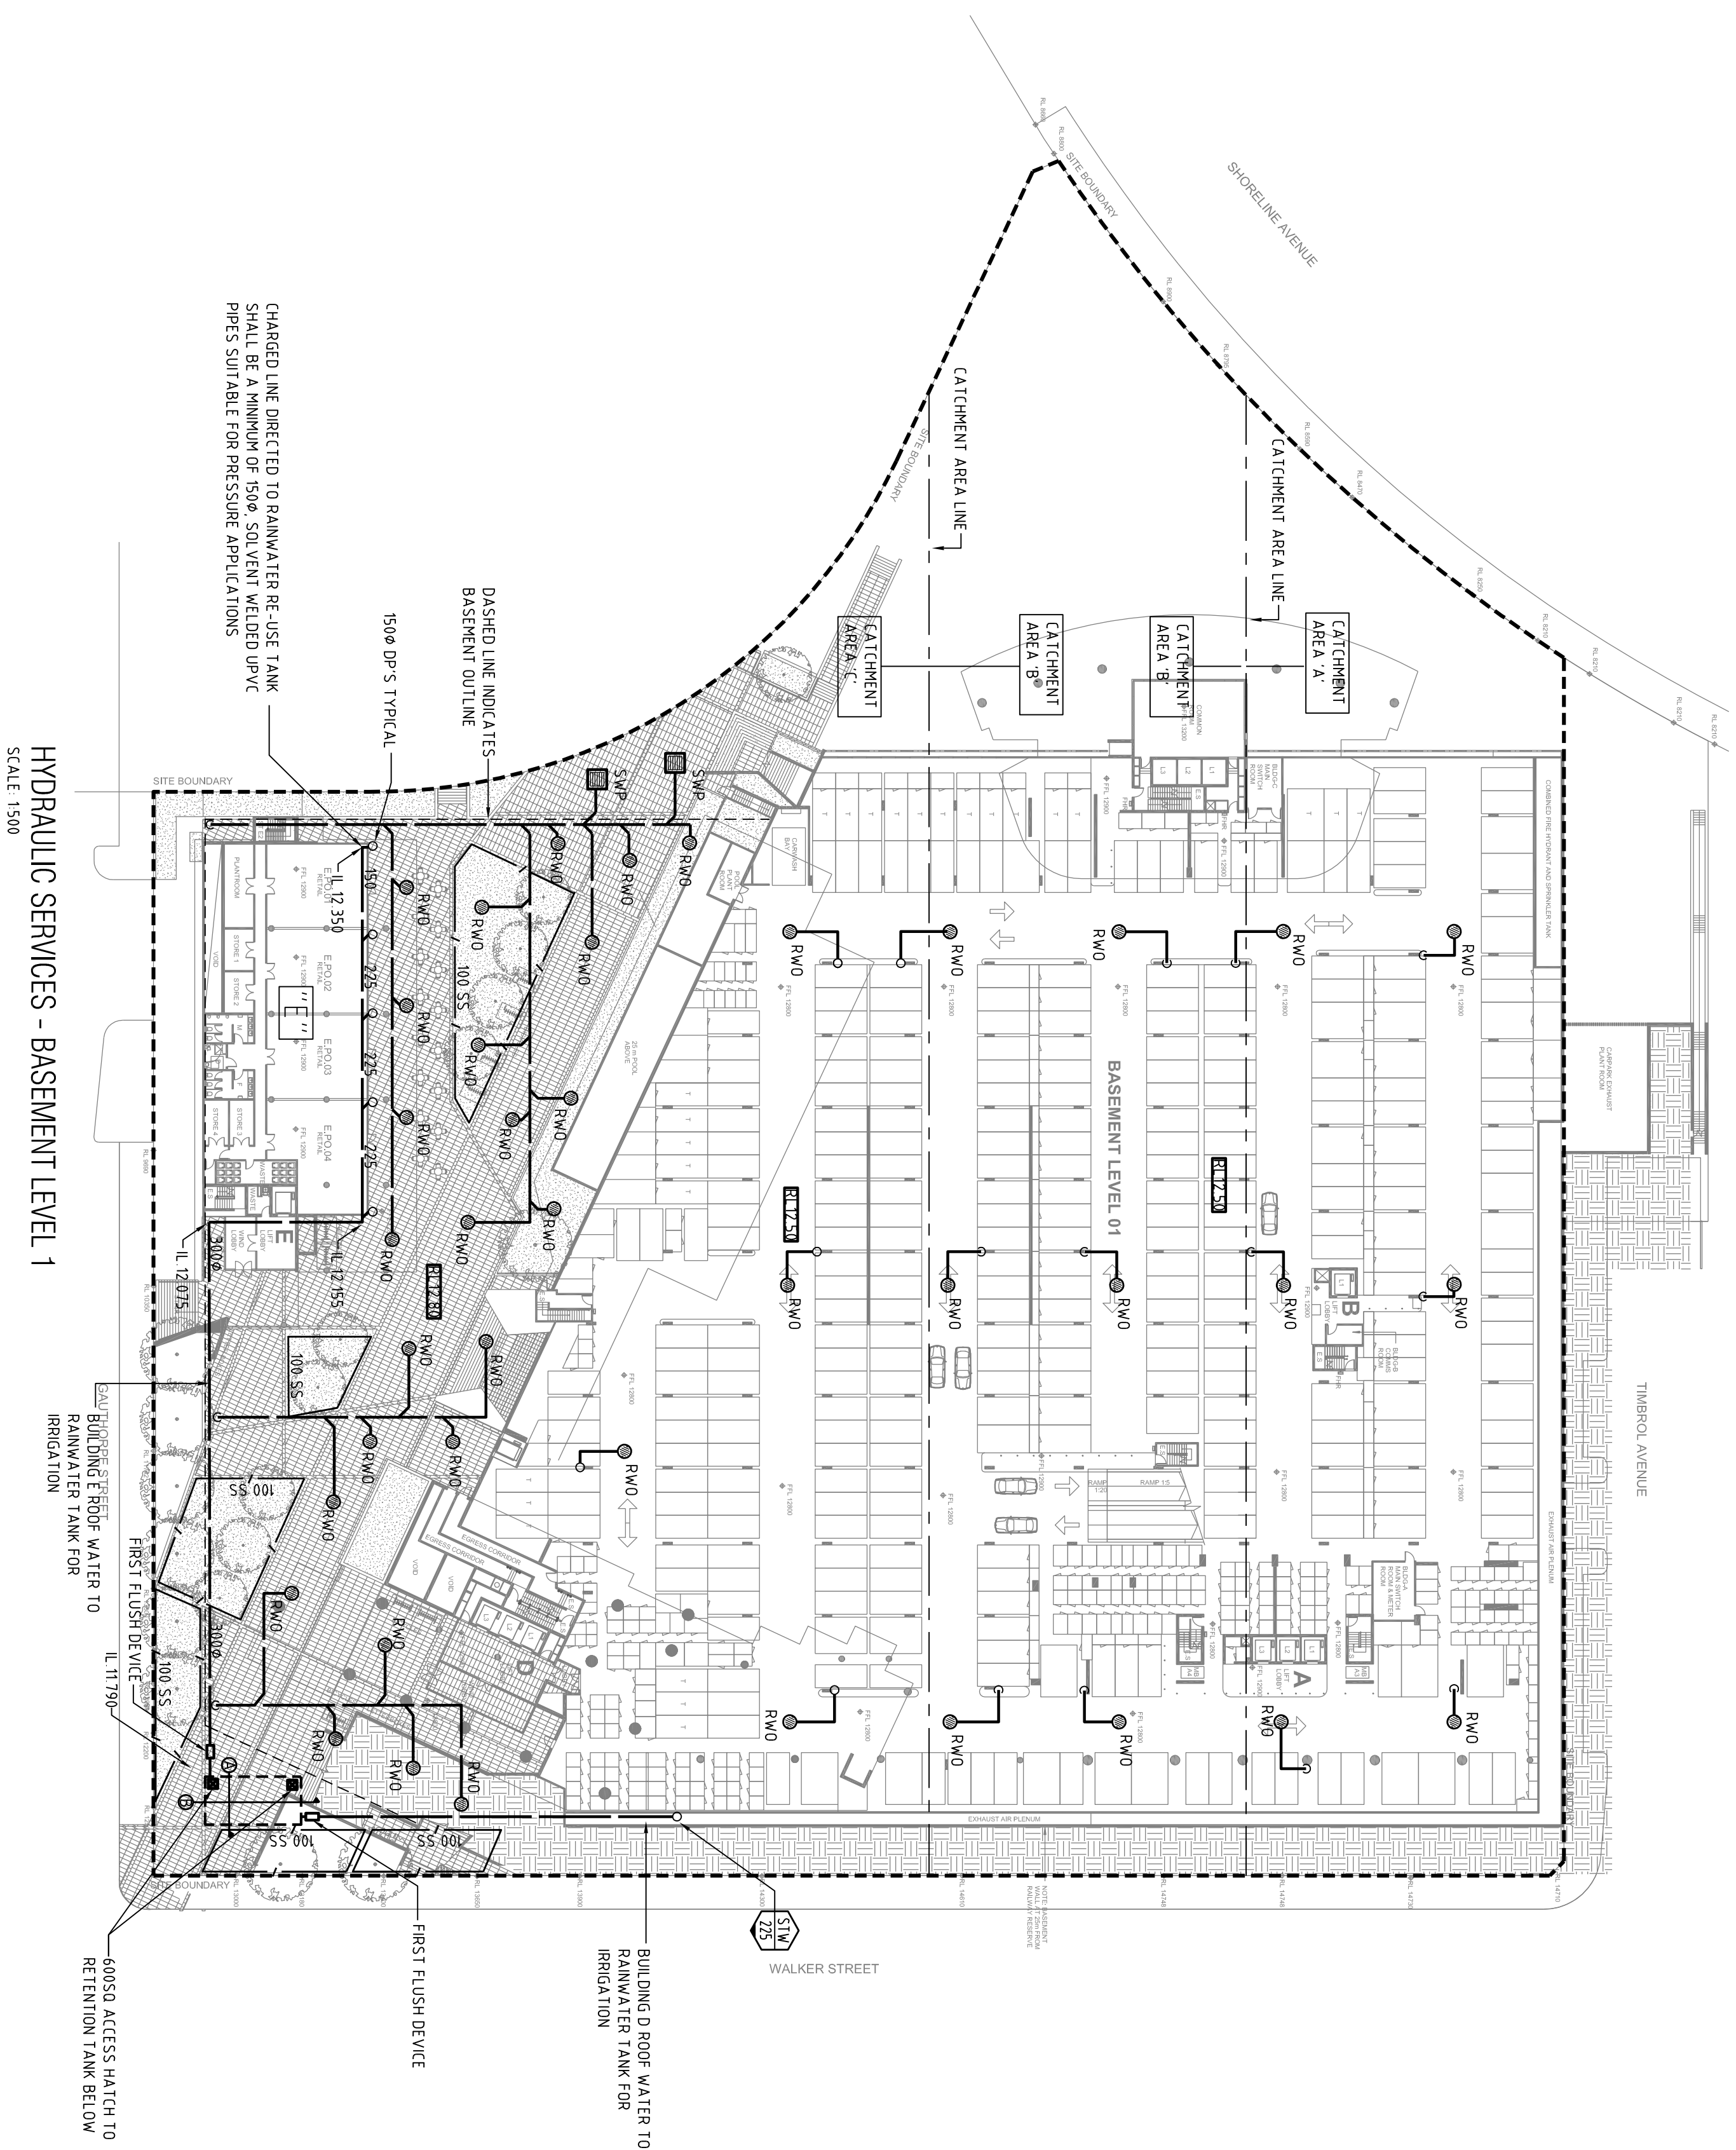

[illegible]

CONSULTANT



## Shaping the Future


**SYDNEY**  
**BRISBANE**  
**CANBERRA**  
**MELBOURNE**  
**PERTH**

**Cardno ITC Pty, Limited**  
LEVEL 7, 33 YORK STREET  
SYDNEY NSW 2000

Phone: + 61 2 9495 8100  
Fax: + 61 2 9495 8111  
Email: sydney, itc@cardno.com.au  
[www.cardnoic.com.au](http://www.cardnoic.com.au)


Email: [sydney.itt@cardno.com.au](mailto:sydney.itt@cardno.com.au)  
[www.cardnoltc.com.au](http://www.cardnoltc.com.au)

**BILLBERGIA**  
Level 2, 25 Angas St  
Meadowbank  
NSW

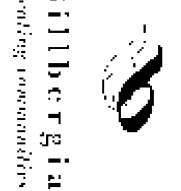

SJB Architects

Level 2  
490 Crown Street  
Surry Hills NSW  
2010 Australia  
T 61 2 9380 9911  
F 61 2 9380 9922  
www.sjb.com.au

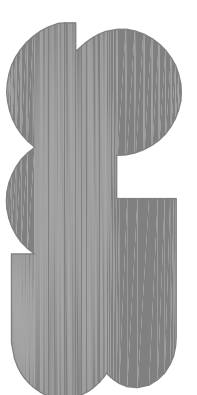



PROJECT  
40 Walker St  
Rhodes  
Stages 2A & 3A

### Stages 2A & 3A

DRAWING TITLE  
HYDRAULIC SERVICES  
BASEMENT 1  
STORMWATER  
CONCEPT PLAN

| DRAWN | DESIGNED    | CHECKED | SCALE (AT FULL SIZE) |
|-------|-------------|---------|----------------------|
| M.T.  | M.T.        | M.T.    | 1:500                |
| DATE  | DRAWING NO. |         |                      |

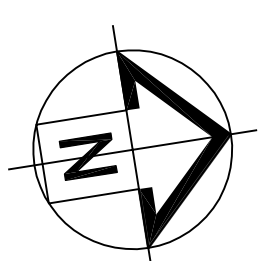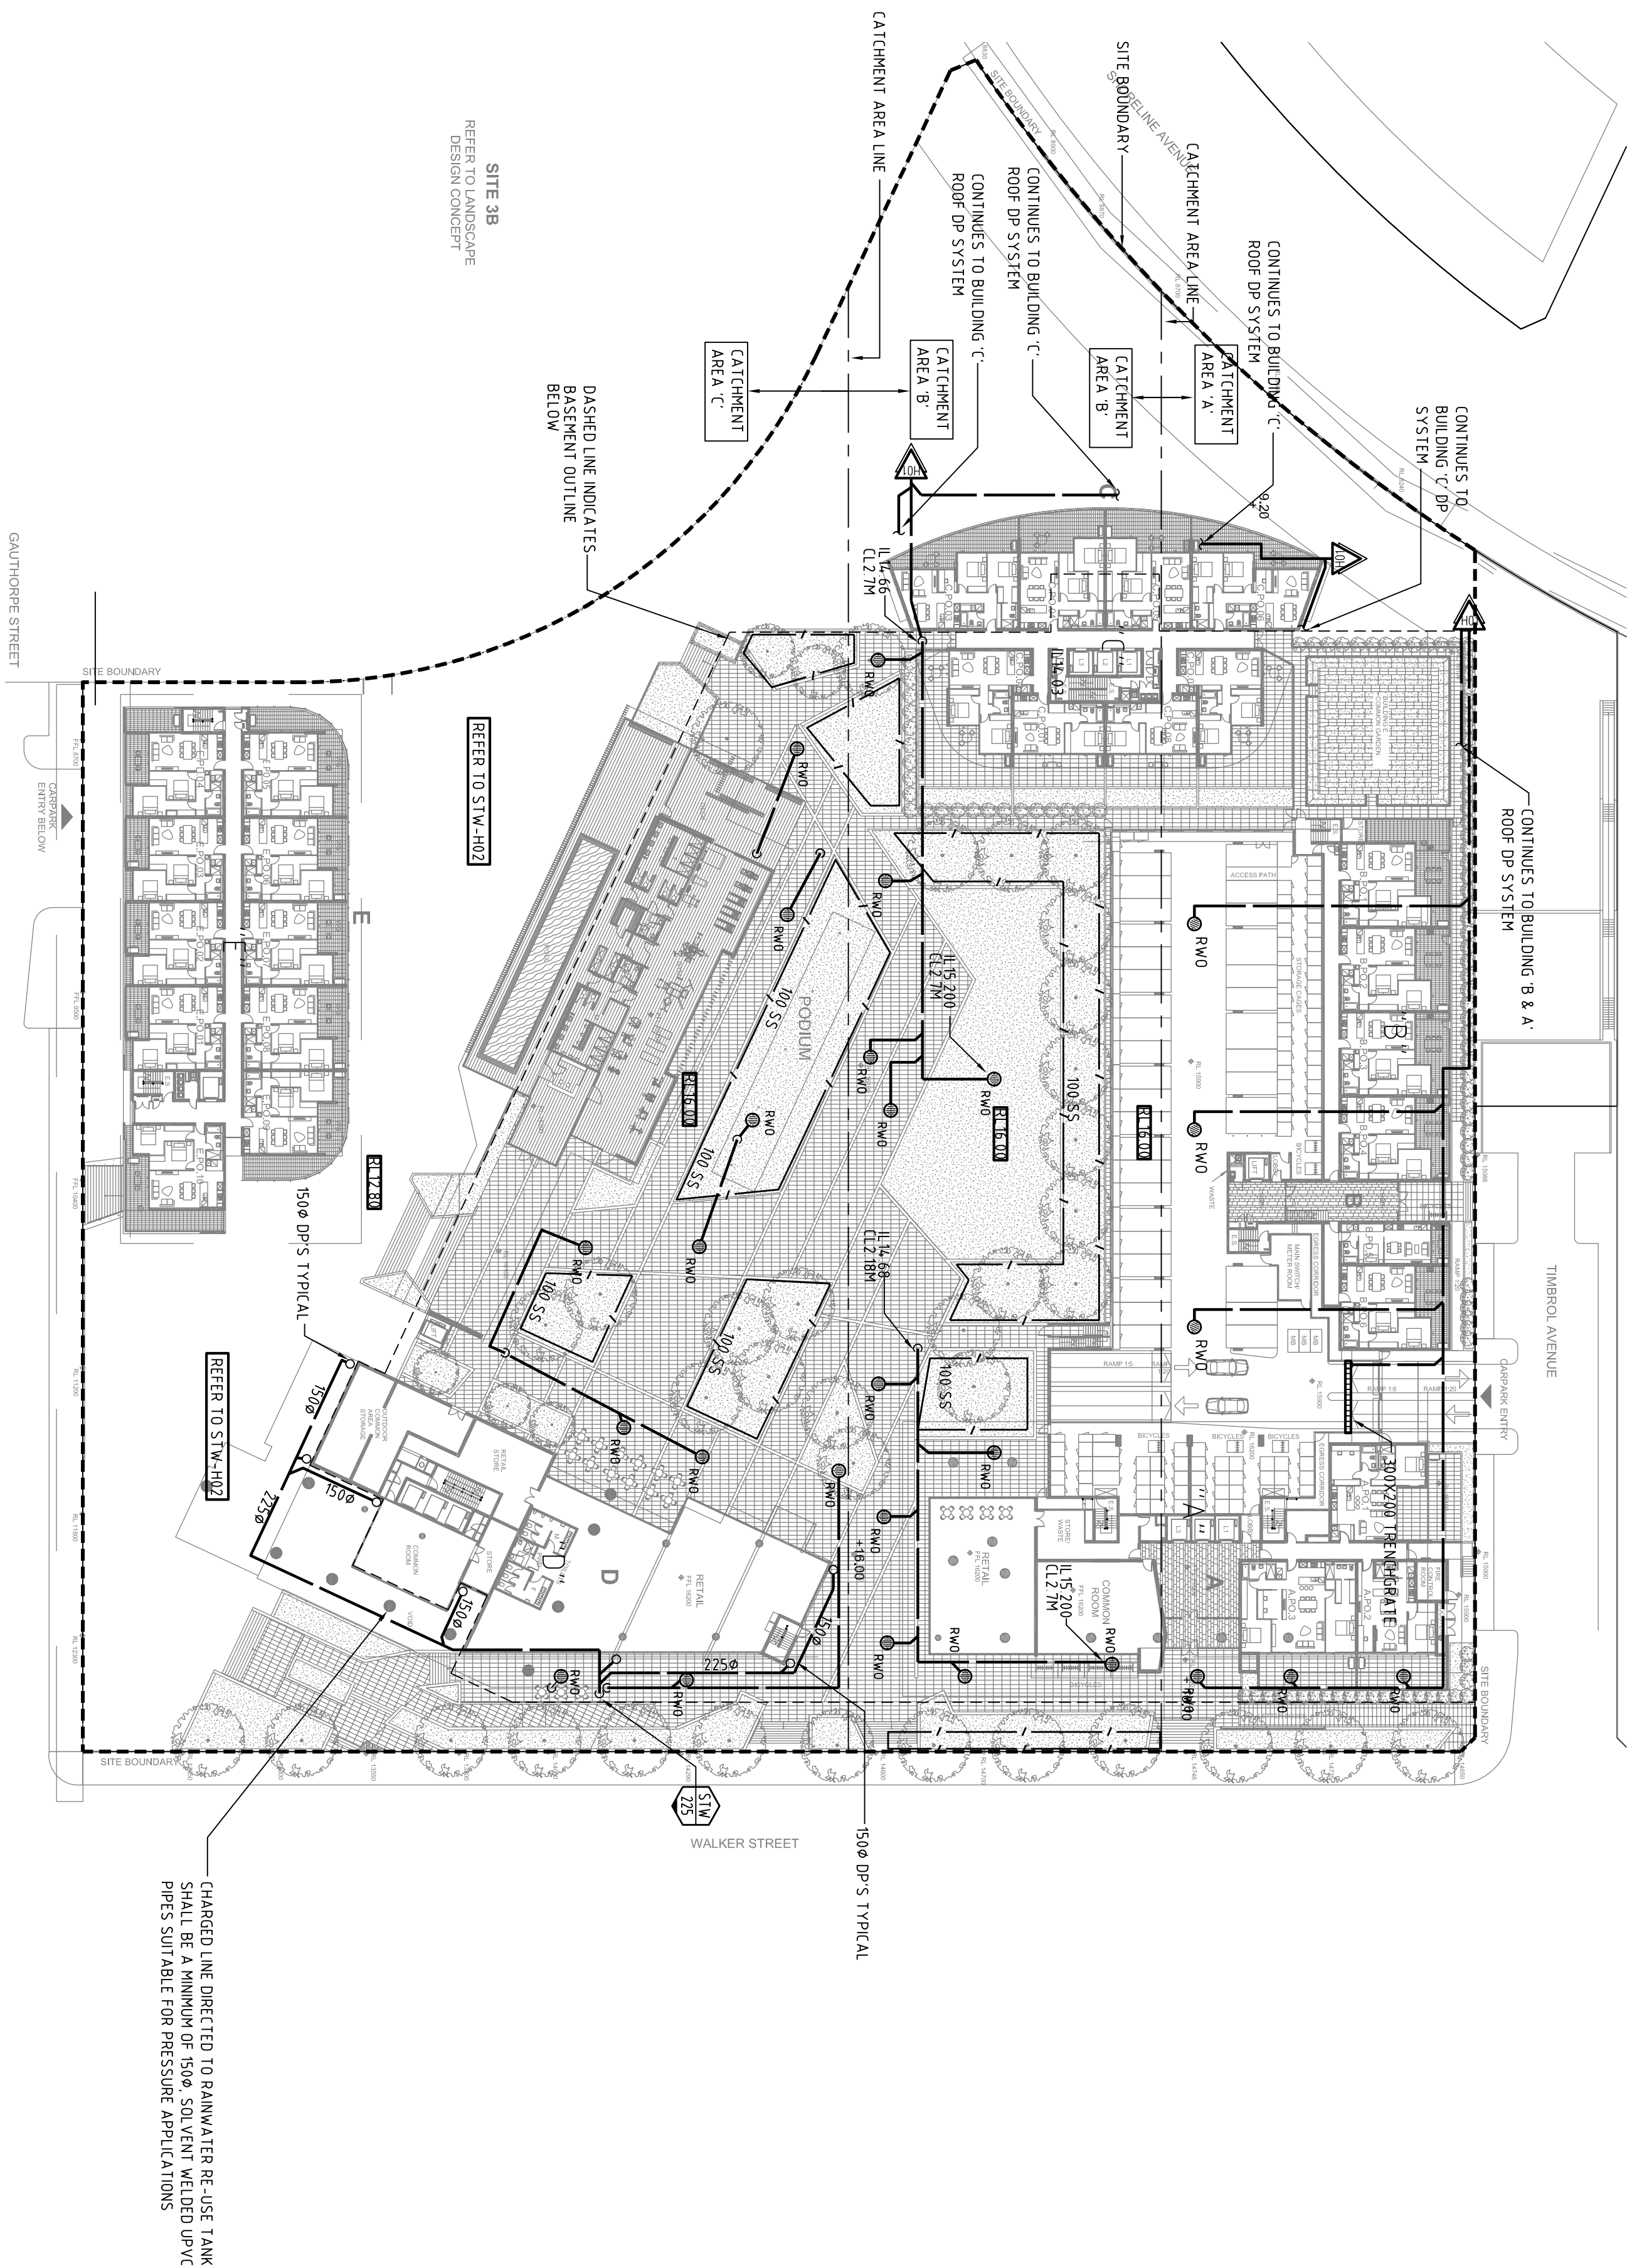

[illegible]

CONSULTANT



## Shaping the Future

**SYDNEY**  
**BRISBANE**  
**CANBERRA**  
**MELBOURNE**  
**PERTH**

**Cardno ITC Pty. Limited**  
LEVEL 7, 33 YORK STREET  
SYDNEY NSW 2000

Phone: + 61 2 9495 8100  
Fax: + 61 2 9495 8111  
Email: [sydney.its@cardno.com.au](mailto:sydney.its@cardno.com.au)  
[www.cardnoitc.com.au](http://www.cardnoitc.com.au)

PERTH

[www.cardnoitc.com.au](http://www.cardnoitc.com.au)


**BILBERGIA**  
Level 2, 25 Angus St  
Meadowbank  
NSW



**Bilbergia**  
Publishing

SJB Architects

Level 2  
490 Crown Street  
Surry Hills NSW  
2010 Australia  
T 61 2 9380 9911  
F 61 2 9380 9922  
[www.sjb.com.au](http://www.sjb.com.au)

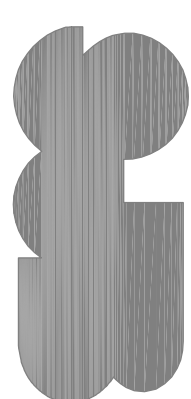


**PROJECT**  
40 Walker St  
Rhodes  
Stages 2A & 3A

DRAWING TITLE  
HYDRAULIC SERVICES  
STORMWATER  
SKETCH


HYDRAULIC SERVICES - PODIUM LEVEL  
SCALE: 1:500

|         |                |         |                      |
|---------|----------------|---------|----------------------|
| DRAWN   | DESIGNED       | CHECKED | SCALE (AT FULL SIZE) |
| M.T.    | M.T.           | M.T.    | 1:500                |
| DATE    | DRAWING No.    |         | REVISION             |
| Oct '10 | N10957-STW-H03 |         | 02                   |




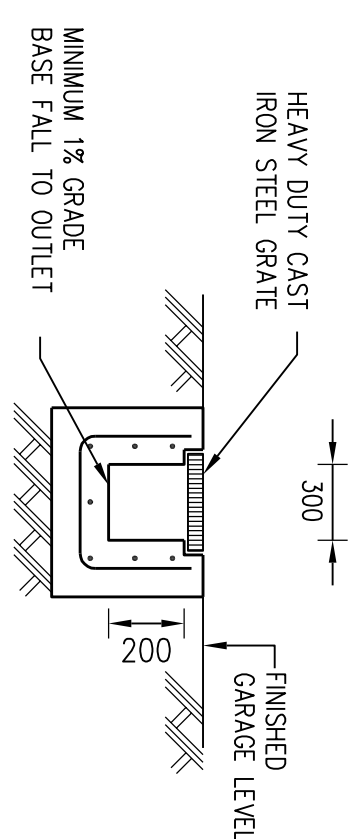


GRATED TRENCH DRAIN  
SCALE: 1:20

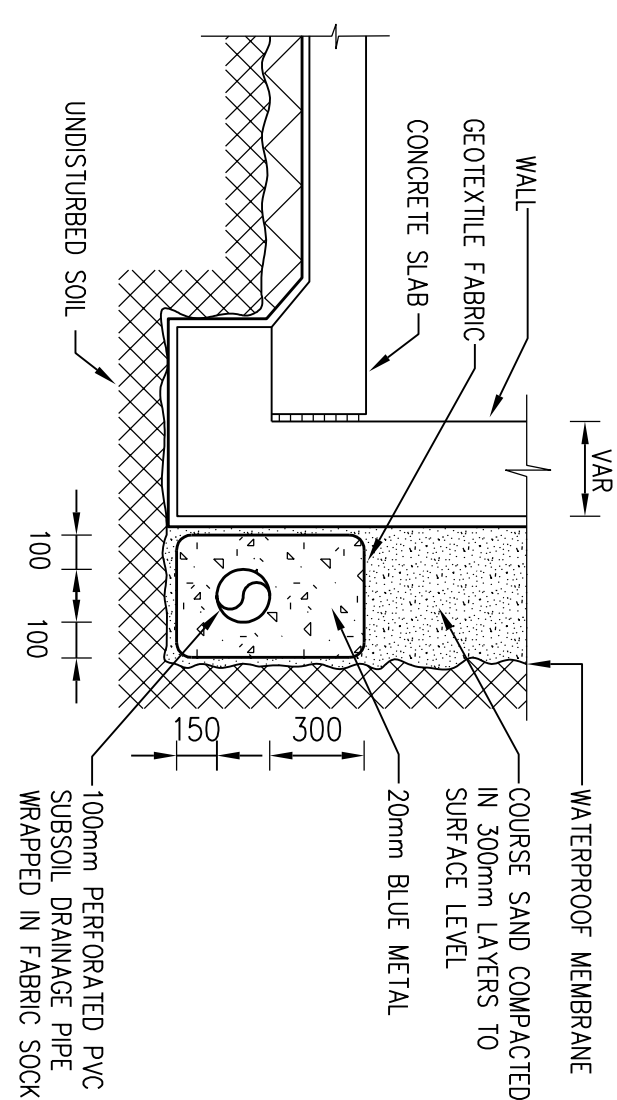


SUBSOIL DRAINAGE  
SCALE: 1:20

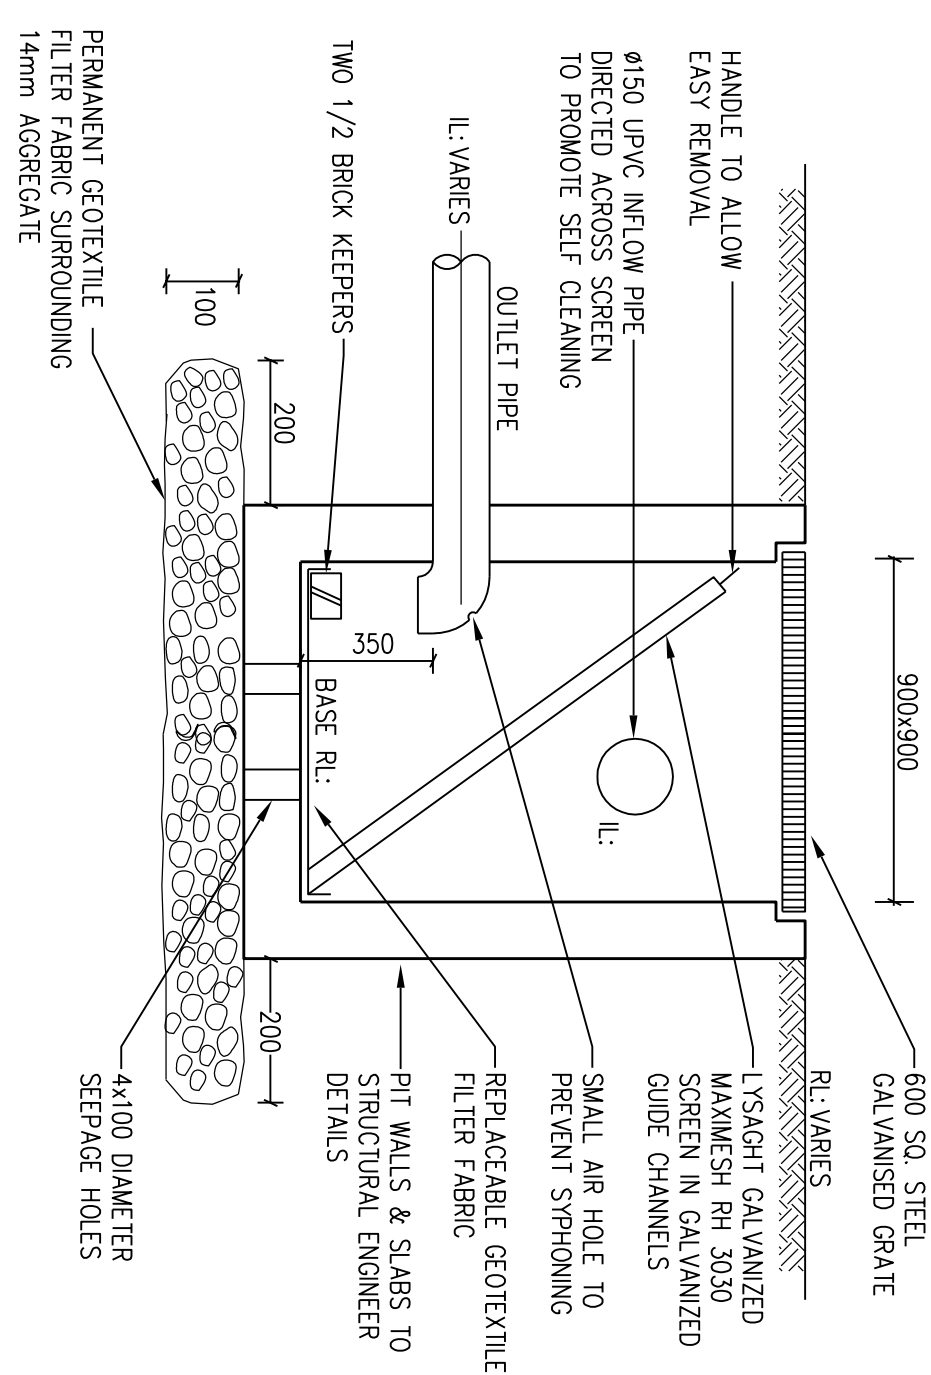

SILT / LITTER ARRESTOR PITS  
SCALE: 1:20

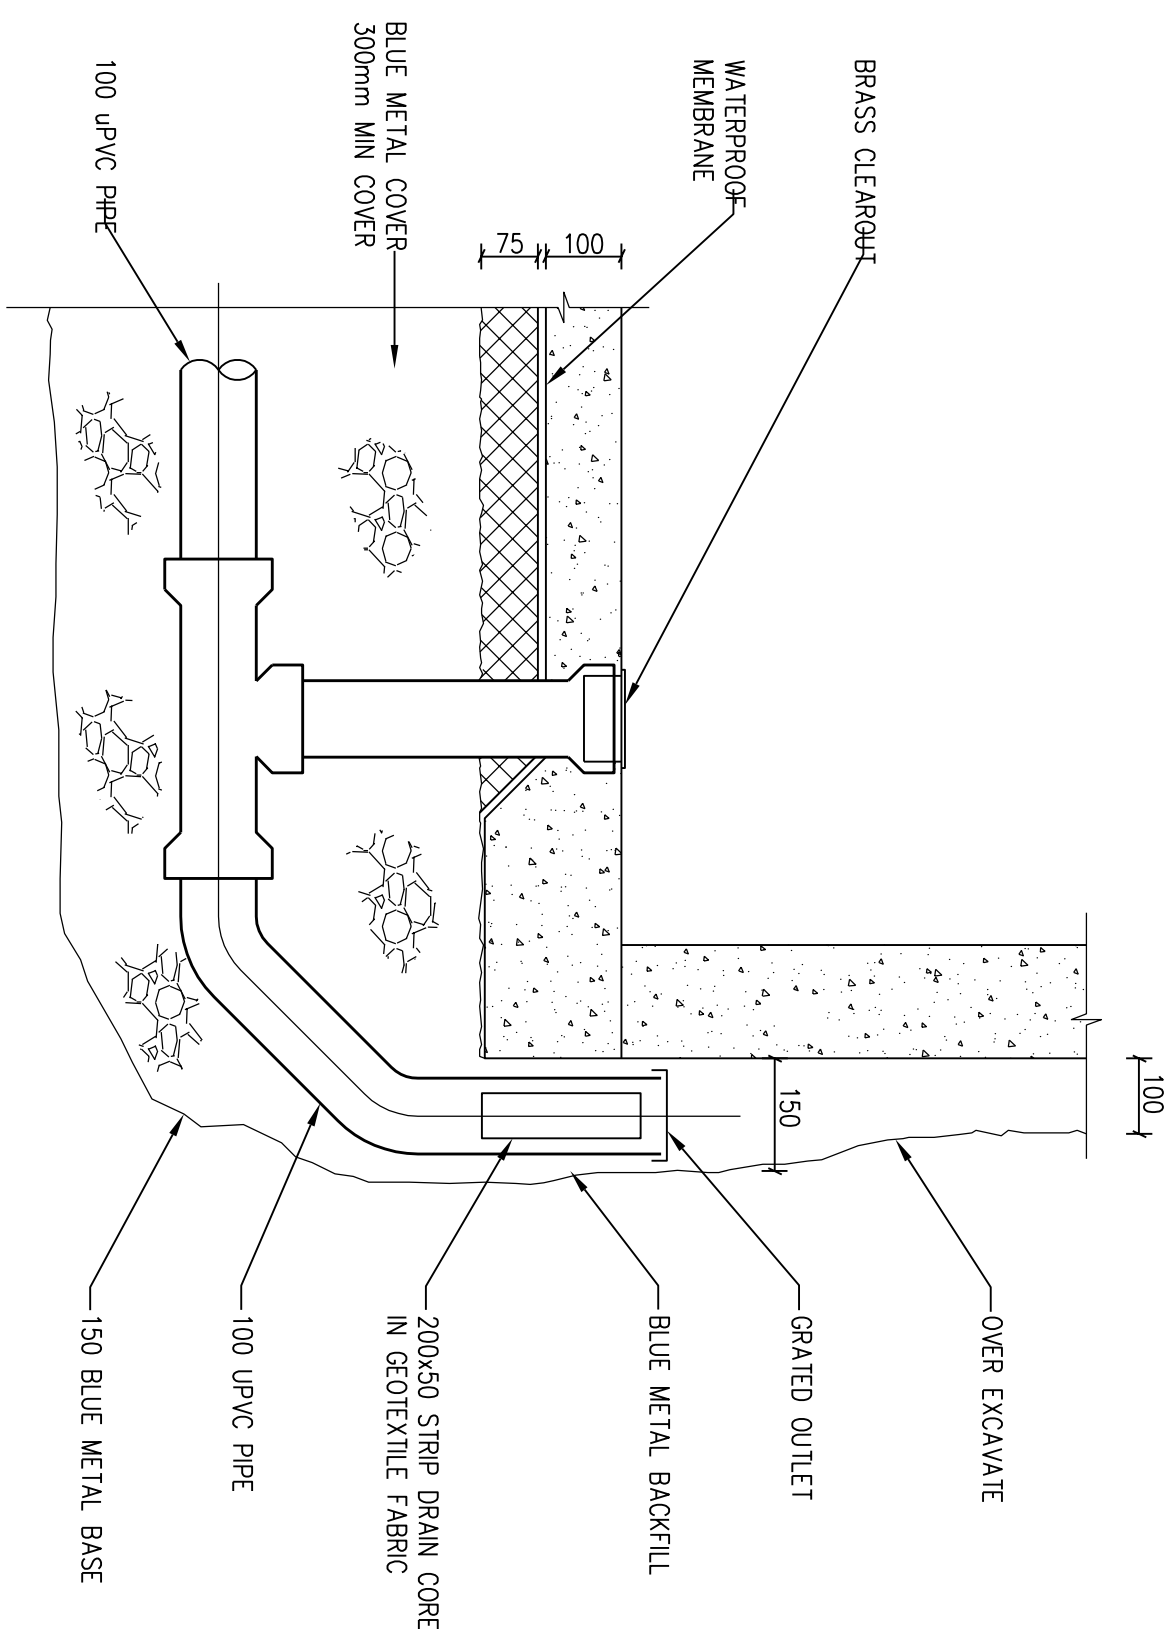

PERIMETER WALL SUBSOIL DRAINAGE  
SCALE: 1:10

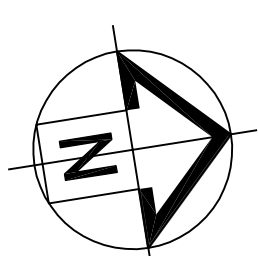
[illegible]

|         |                |         |                      |
|---------|----------------|---------|----------------------|
| DRAWN   | DESIGNED       | CHECKED | SCALE (AT FULL SIZE) |
| M.T.    | M.T.           | M.T.    | 1:500                |
| DATE    | DRAWING No.    |         | REVISION             |
| Oct '10 | N10957-STW-H04 |         | 01                   |






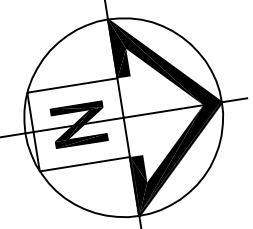

[illegible]

RAINWATER TANK - SECTION 'B'

SCALE: 1:50

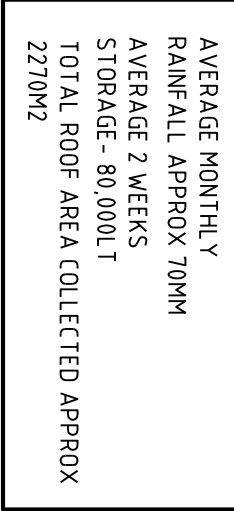

SCALE: 1:500

|         |                |         |                      |
|---------|----------------|---------|----------------------|
| DRAWN   | DESIGNED       | CHECKED | SCALE (AT FULL SIZE) |
| M.T.    | M.T.           | M.T.    | 1:500                |
| DATE    | DRAWING No.    |         | REVISION             |
| Oct '10 | N10957-STW-H05 |         | 02                   |

**BILLBERGIA**  
Level 2, 25 Angus St  
Meadowbank  
NSW

  
**Billbergia**  
*evolving organisations*

**SYDNEY**  
**BRISBANE**  
**CANBERRA**  
**MELBOURNE**  
**PERTH**

**Cardno ITC Pty. Limited**  
LEVEL 7, 33 YORK STREET  
SYDNEY NSW 2000  
Phone: + 61 2 9495 8100  
Fax: + 61 2 9495 8111  
Email: sydney.iti@cardno.com.au  
www.cardnoitic.com.au

## Shaping the Future



CONSULTANT

SJB Architects

490 Crown Street  
Surry Hills NSW  
2010 Australia  
T 61 2 9380 9911  
F 61 2 9380 9922  
www.sjb.com.au




40 Walker St  
Rhodes  
Stages 2A & 3A


DRAWING TITLE  
HYDRAULIC SERVICES  
STORMWATER  
RAINWATER TANK DETAILS




STORMWATER CONCEPT PLANS  
for  
40 WALKER ST, RHODES  
STAGES 2A & 3A  
prepared by  
CARDNO ITC

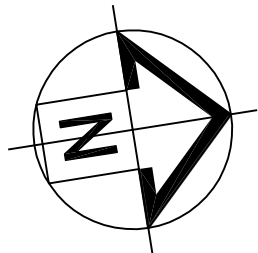[illegible]

## SYMBOLS LEGEND

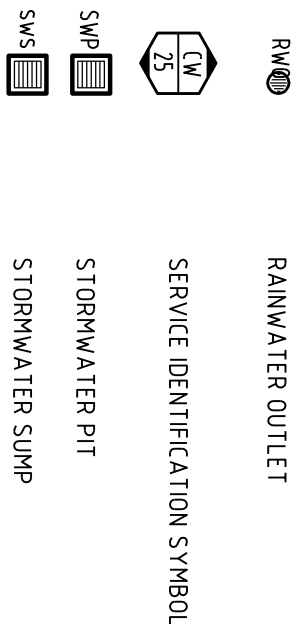

## LINETYPES LEGEND

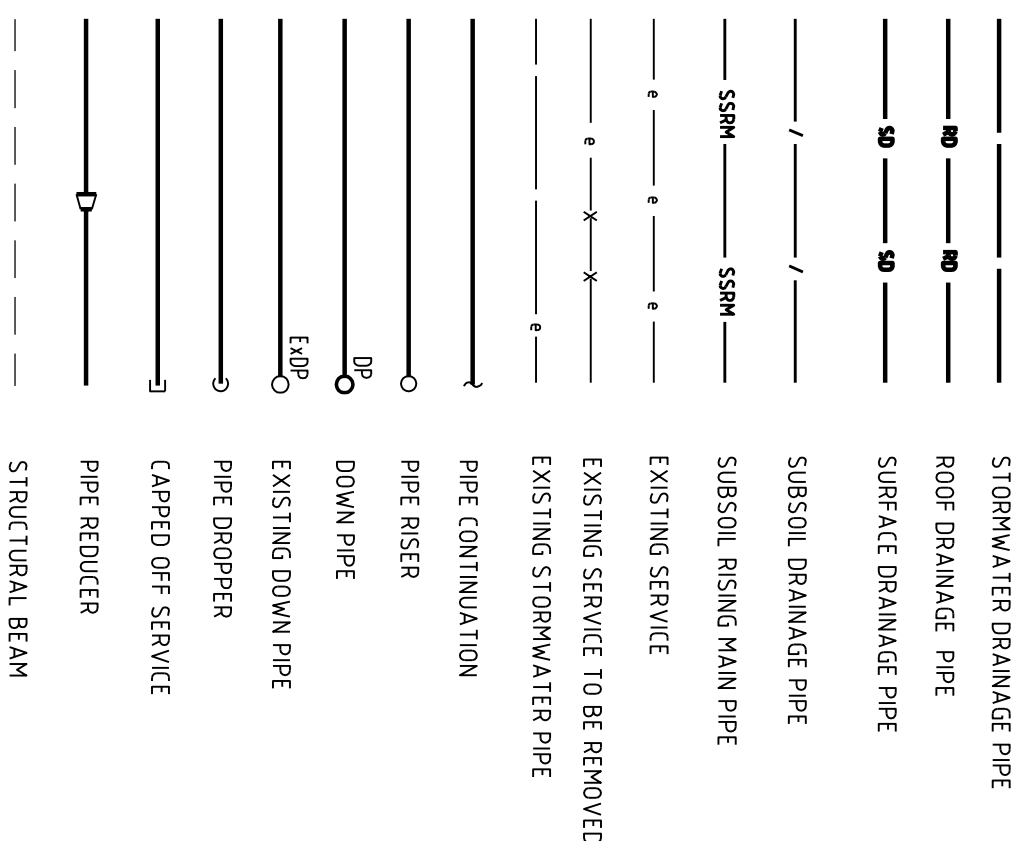


## ABBREVIATIONS

|                      |                            |
|----------------------|----------------------------|
| AFEL                 | ABOVE FINISHED FLOOR LEVEL |
| CL                   | CLEARANCE                  |
| TO                   | TO                         |
| CEILING SPACE        | CEILING SPACE              |
| DOWNPPE              | DOWNPIPE                   |
| DRNAGE               | DRAINAGE                   |
| TURNUP               | TURNUP                     |
| EXISTING             | EXISTING                   |
| FALSE CEILING        | FALSE CEILING              |
| FINISHED FLOOR LEVEL | FINISHED FLOOR LEVEL       |
| FL                   | FLOOR LEVEL                |
| GROUND LEVEL         | GROUND LEVEL               |
| HTG                  | HEATING                    |
| INSTR                | INSULATION                 |
| INSPECT              | INSPECTION                 |
| OPENING              | OPENING                    |
| LOW LEVEL            | LOW LEVEL                  |
| OVERHEAD             | OVERHEAD                   |
| POLYVINYLCHLORIDE    | POLYVINYLCHLORIDE          |
| REDUCED LEVEL        | REDUCED LEVEL              |
| SUPP                 | SUPPLY                     |
| SOFT                 | SOFT                       |
| STIFF                | STIFF                      |
| STOP LAP             | STOP LAP                   |
| STW                  | STORMWATER                 |
| UNDER SIDE           | UNDER SIDE                 |
| VENT PIPE            | VENT PIPE                  |

## DRAWING SCHEDULE

|                |                                 |
|----------------|---------------------------------|
| N10957-STW-H00 | COVERSHEET                      |
| N10957-STW-H01 | BASEMENT 2                      |
| N10957-STW-H02 | BASEMENT 1                      |
| N10957-STW-H03 | PODIUM LEVEL                    |
| N10957-STW-H04 | DETAILS                         |
| N10957-STW-H05 | RAINWATER TANK DETAILS          |
| N10957-STW-H06 | SEDIMENT & EROSION CONTROL PLAN |
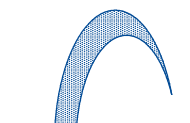
|                   |      |                                                                                                                                                                    |      |                                                                                                                                                |  |
|-------------------|------|--------------------------------------------------------------------------------------------------------------------------------------------------------------------|------|------------------------------------------------------------------------------------------------------------------------------------------------|--|
| CONSULTANT        |      | <br><b>Cardno</b><br><i>ITC</i>                                                 |      | Shaping the Future                                                                                                                             |  |
| CLIENT            |      | BILLBERGIA<br>Level 2, 25 Angus St<br>Meadowbank NSW                                                                                                               |      | <br><b>Billbert R &amp; A</b><br><i>trading consultants</i> |  |
| SJB Architects    |      | Level 2<br>490 Crown Street<br>Surry Hills NSW<br>2007 Australia<br>Tel: 61 2 9380 9911<br>F: 61 2 9380 9922<br><a href="http://www.sjb.com.au">www.sjb.com.au</a> |      |                                                             |  |
| PROJECT           |      | 40 Walker St<br>Rhodes<br>Stages 2A & 3A                                                                                                                           |      |                                                                                                                                                |  |
| DRAWING TITLE     |      | HYDRAULIC SERVICES<br>COVERSHEET<br>STORMWATER<br>CONCEPT PLAN                                                                                                     |      |                                                                                                                                                |  |
| DESIGNED          |      | CHECKED                                                                                                                                                            |      | SCALE (AT FULL SIZE)                                                                                                                           |  |
| M.T.              | M.T. | M.T.                                                                                                                                                               | M.T. | 1:500                                                                                                                                          |  |
| DRAWING No.       |      | REGION                                                                                                                                                             |      |                                                                                                                                                |  |
| M1010957-STW-H100 |      | 02                                                                                                                                                                 |      |                                                                                                                                                |  |