



Department of Planning and Environment

Issued under the Environmental Planning and Assessment Act 1979

Approved Section 5.25 Modification Application


No: 2 Granted on: 20 May 2022

In respect to: 10_0108

Signed: JF

Sheet No: 1 of 2

	EXISTING APPROVED PLANT.
	PROPOSED CO-GEN PLANT, MOD 23.
	APPROVED PLANT YET TO BE CONSTRUCTED.
	APPROVED GAS PRESSURE REDUCTION STATION & GAS PIPELINES.
	PROPOSED RELOCATION OF THE GAS PRESSURE REDUCTION STATION AND GAS PIPELINE.MOD 1.
	PROPOSED FACTORY GAS SUPPLY PIPELINE.MOD 2.

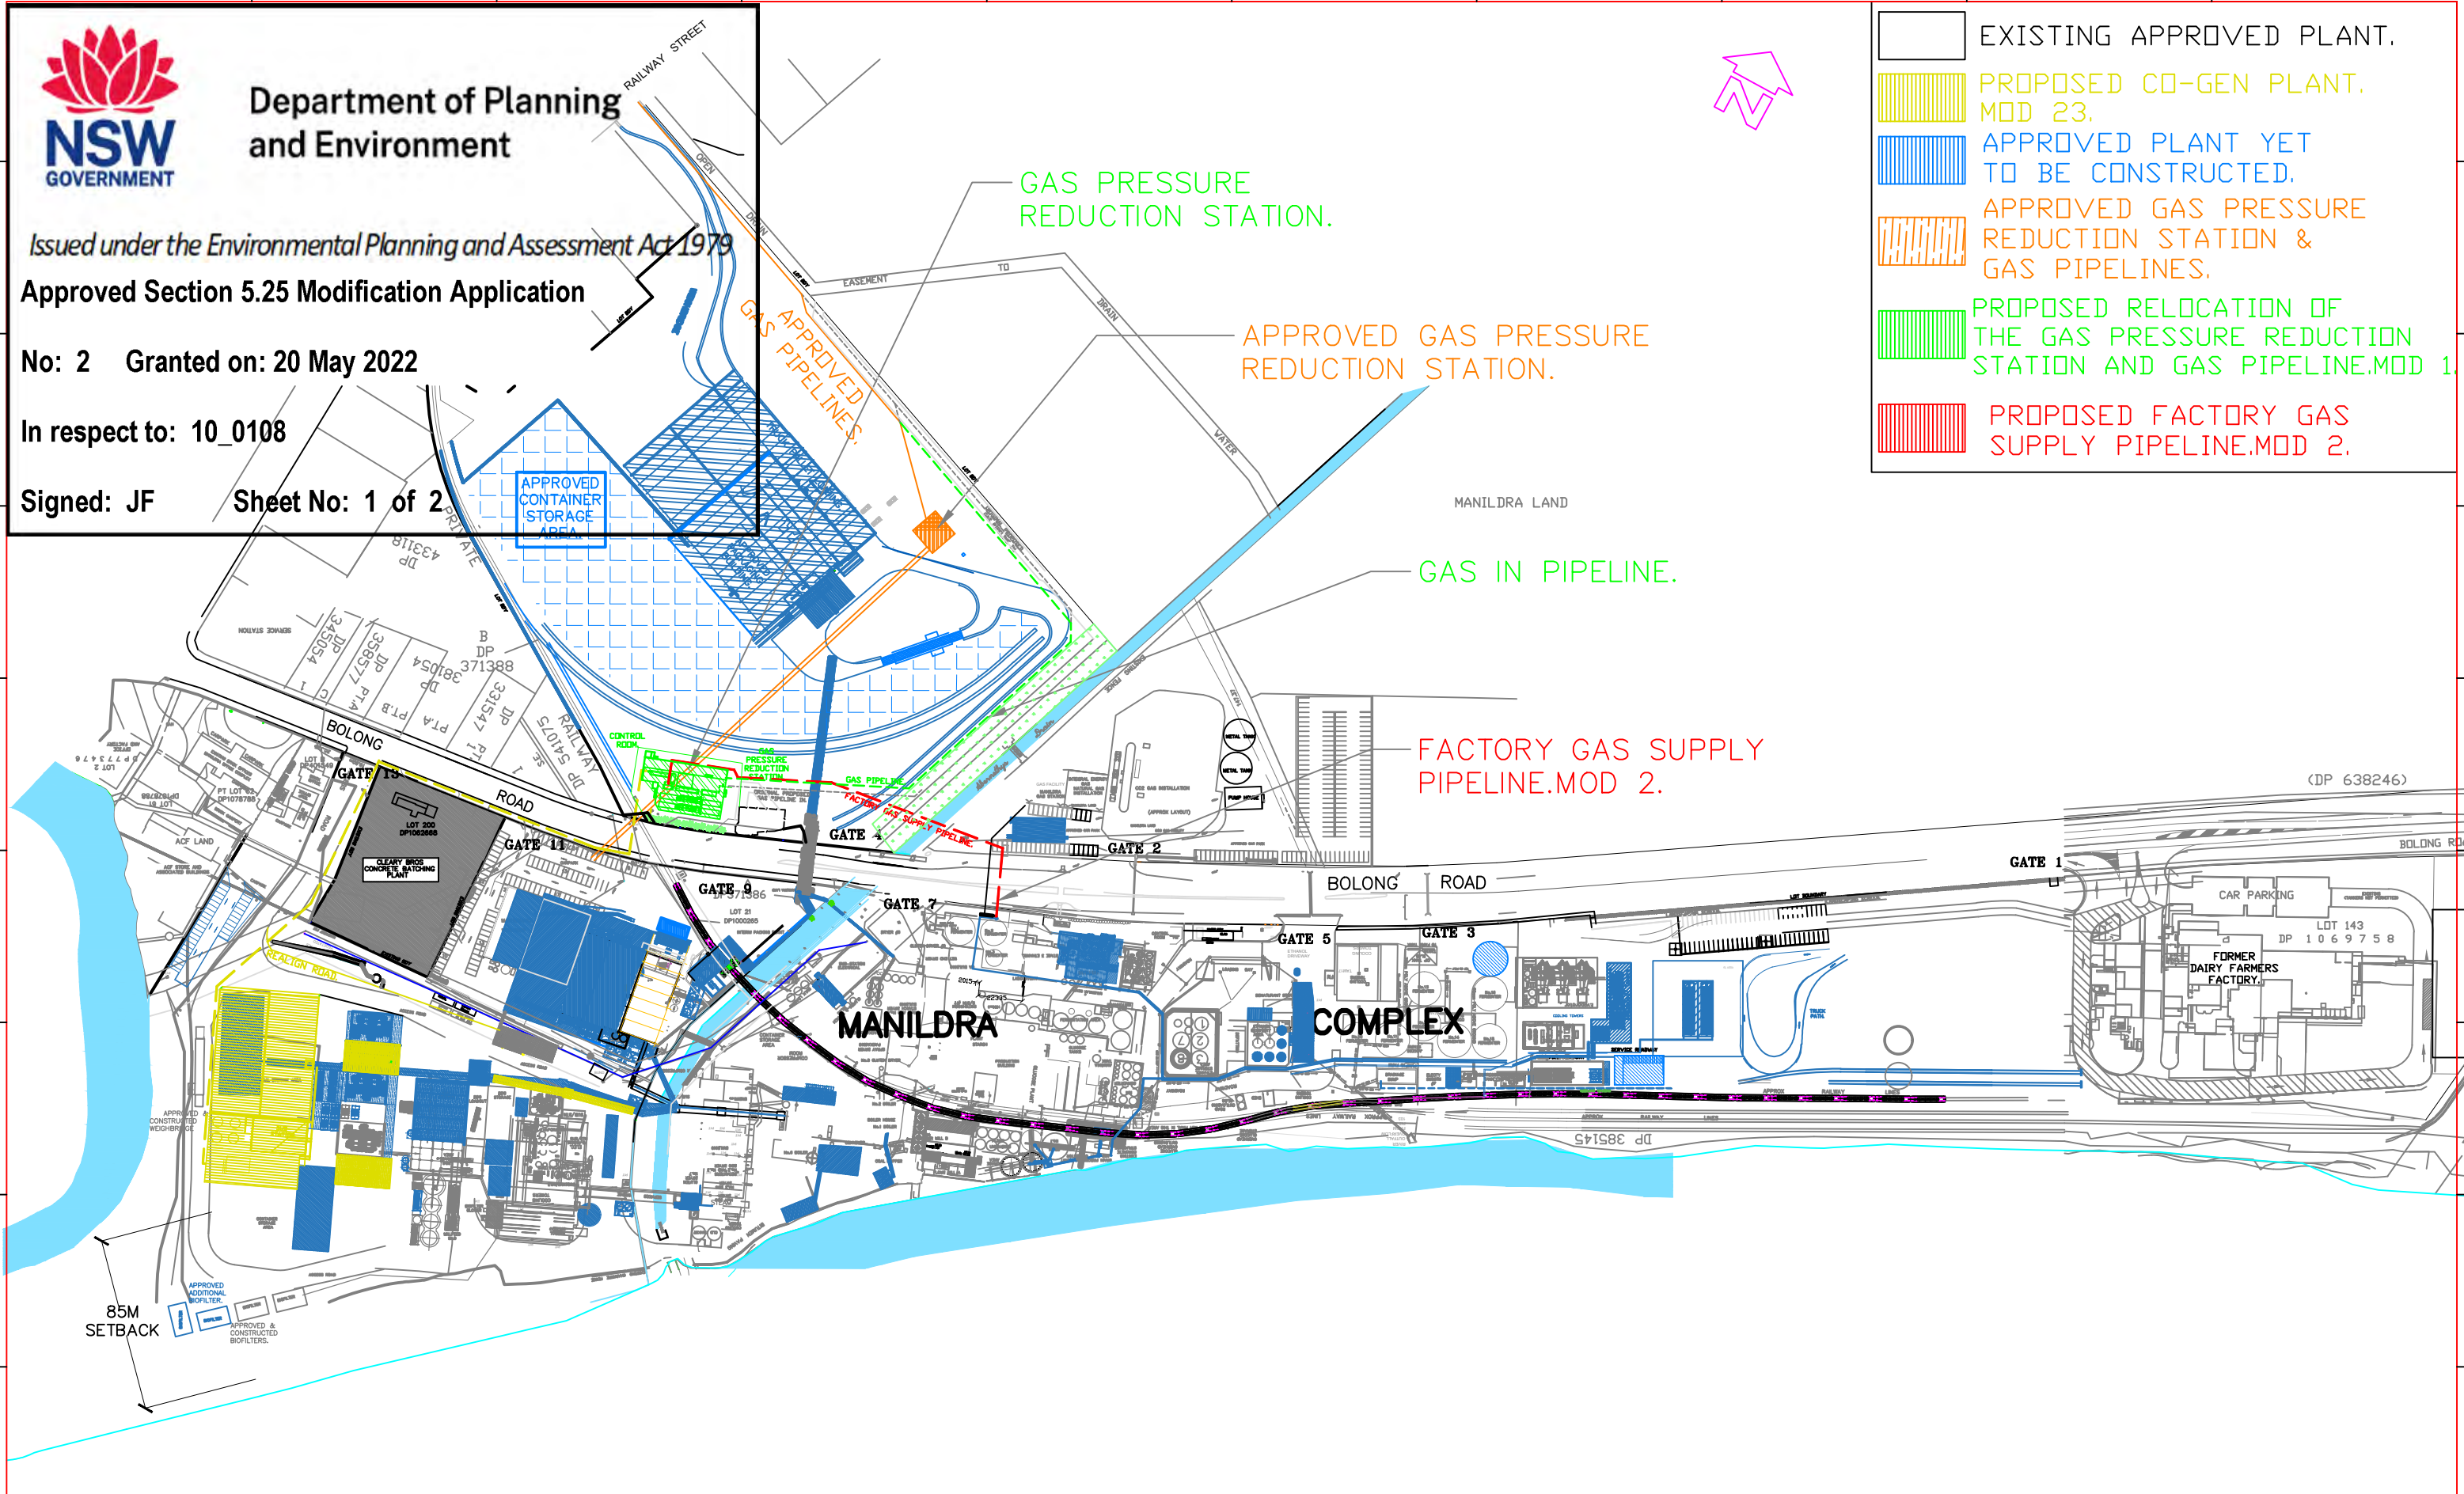

REV	ZONE	DETAILS	DRN	DATE	CHKD	APPD
P05	E5	Gas pipeline moved to 19m from creek bdy.	P.C.	17-12-21	B.H.	
P04	E3	Fence realigned.	P.C.	2-11-21	B.H.	
P03	E3	Station refined.	P.C.	27-10-21	B.H.	
P02	ALL	Low pressure realigned.	P.C.	06-10-21	B.H.	
P01	ALL	Mod 2.	P.C.	06-10-21	B.H.	





MANILDRA GROUP
100% AUSTRALIAN



THIS DRAWING IS A CONFIDENTIAL COMMUNICATION OF MANILDRA GROUP TO TAKE A COPY OR DISCLOSE TO A THIRD PARTY WITHOUT WRITTEN CONSENT CONSTITUTES AS AN INFRINGEMENT OF THE COPYRIGHT

DRAWN PC	DATE 06-10-21	SITE MANILDRA-SHOALHAVEN STARCHES PTY LTD	SHT SIZE A3
DESIGNED. PW	DATE	JOB TITLE NOWRA PLANT.	SHEET
CHKD SR	DATE	DWG TITLE GAS FACILITY.MOD 2. OVER ALL PLANT PLAN.	OF
APPD BH	DATE	PROJECT No. 7208A	REV. P05
SCALE 1:3000	DWG No. MN7297-100		

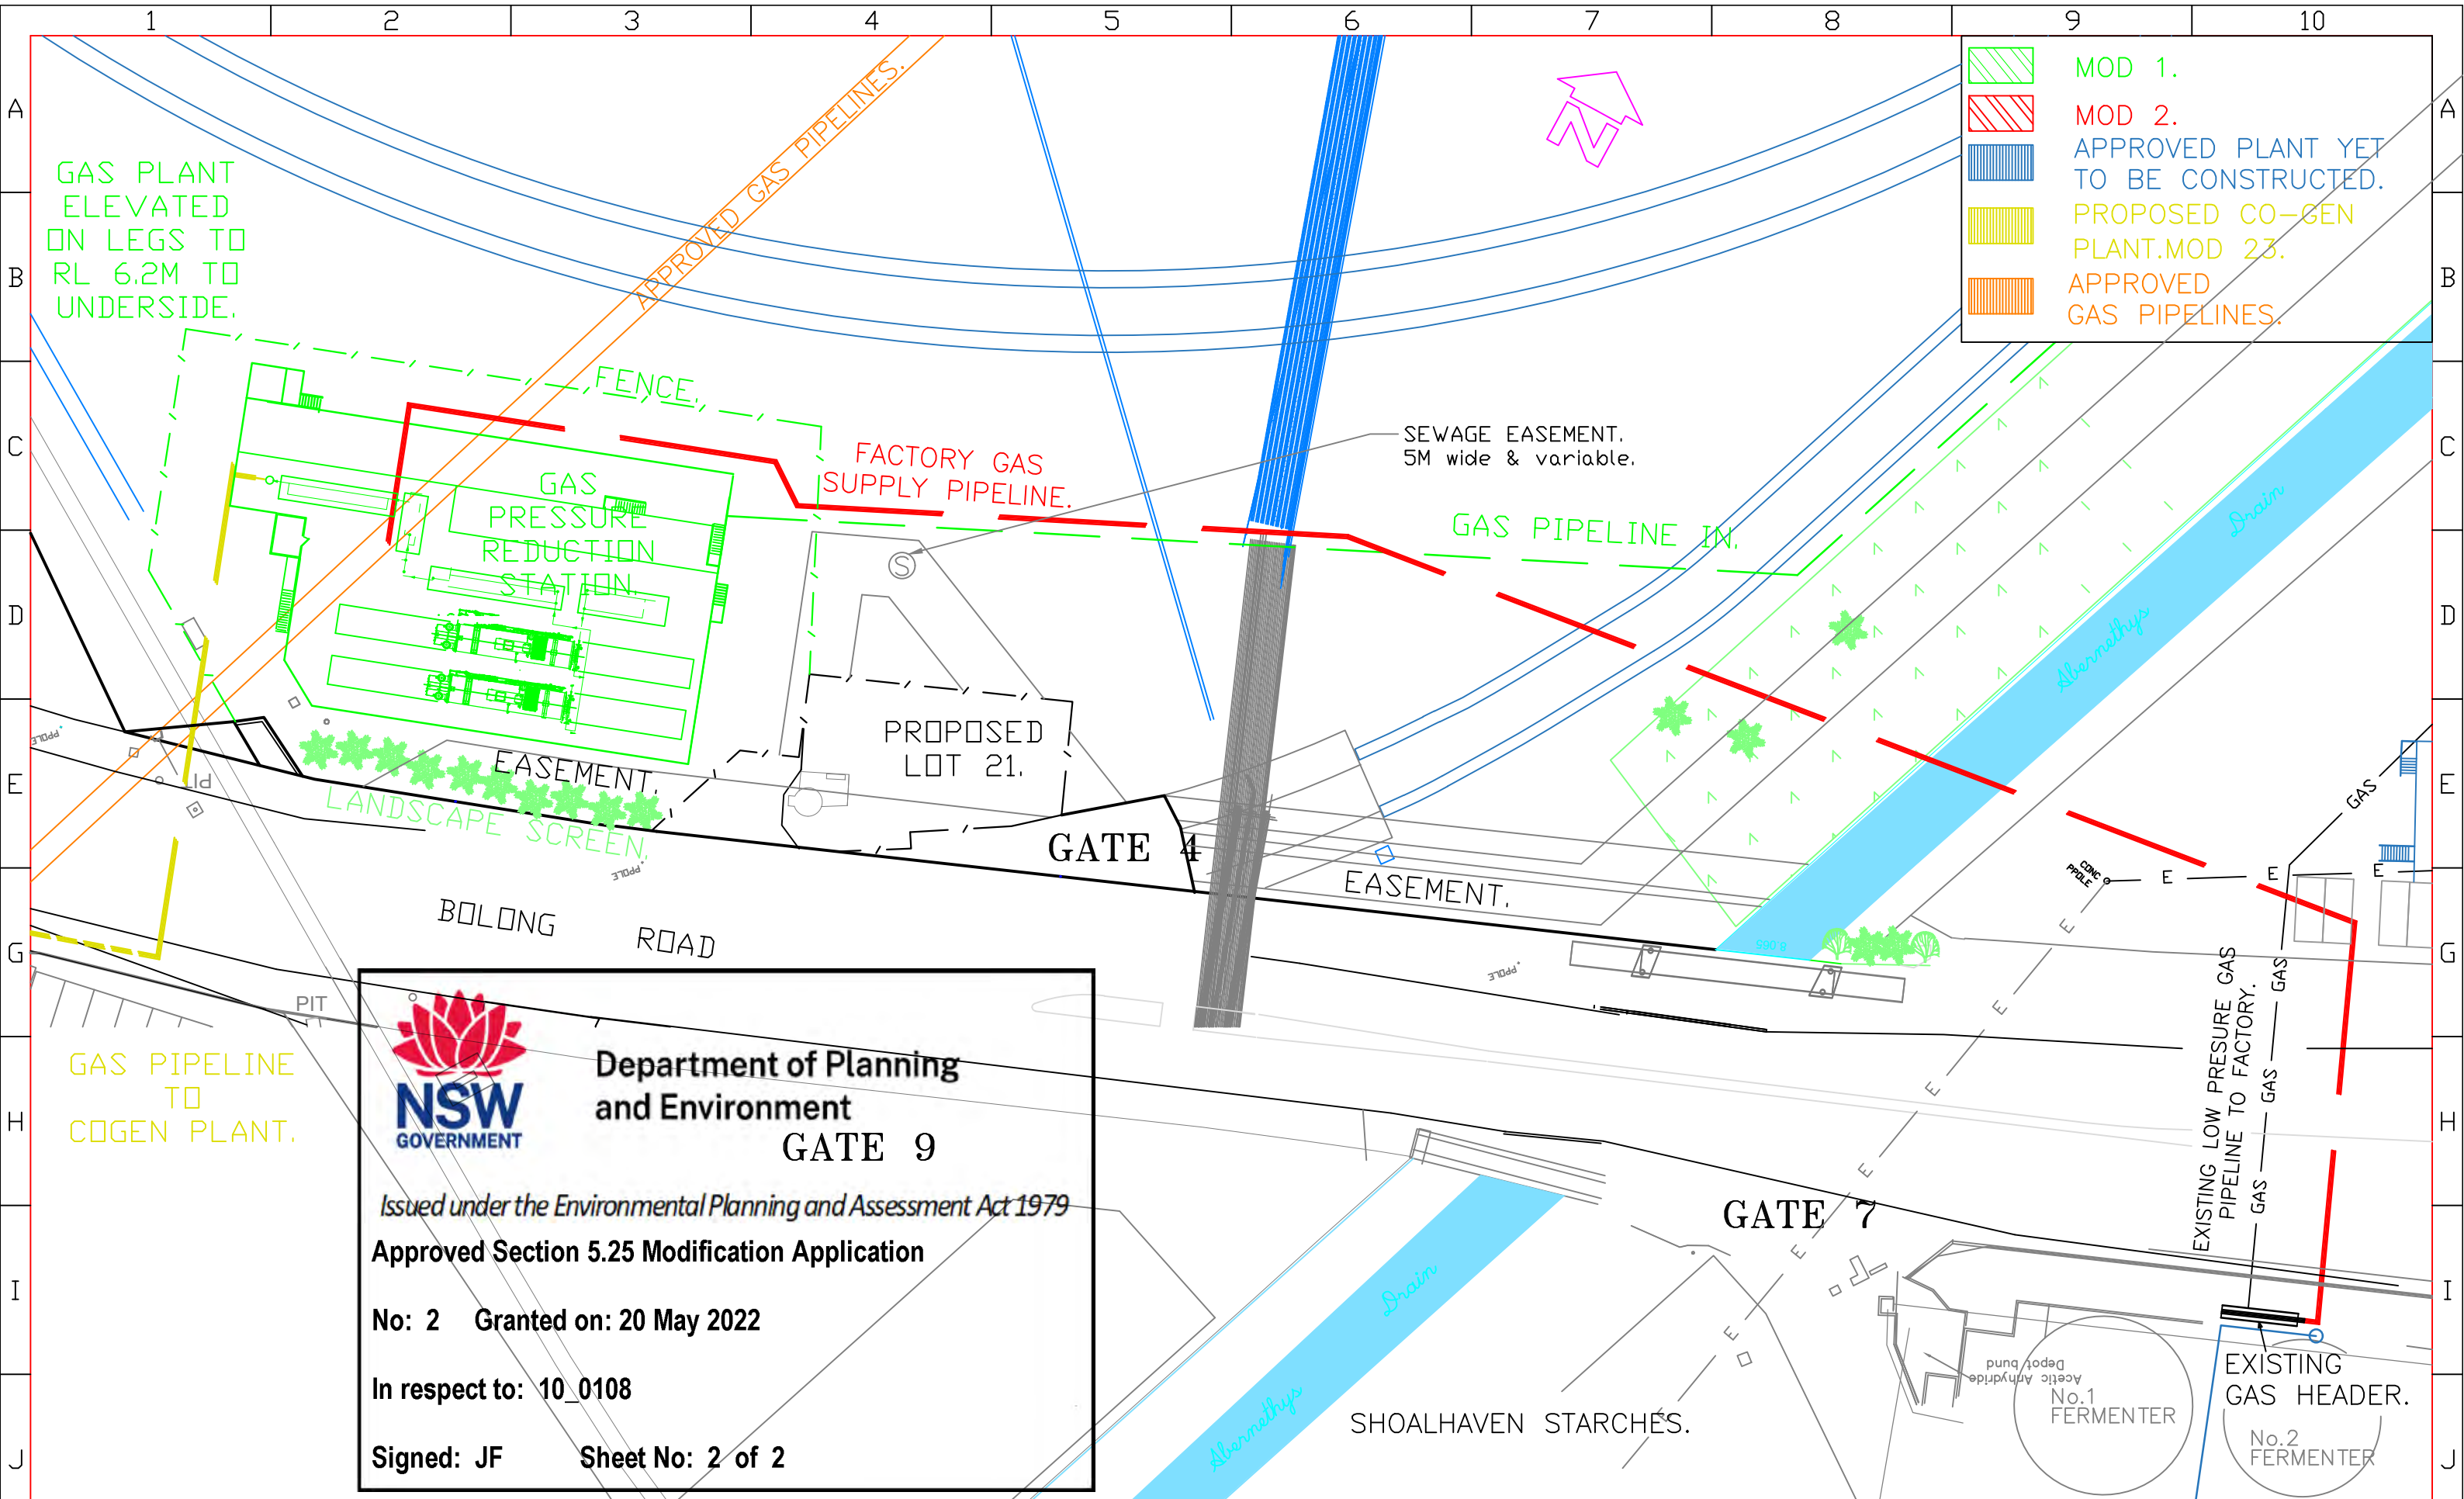


Department of Planning and Environment
GATE 9
 Issued under the Environmental Planning and Assessment Act 1979
Approved Section 5.25 Modification Application
No: 2 Granted on: 20 May 2022
In respect to: 10_0108
Signed: JF Sheet No: 2 of 2

PD6	G10	Gas line In setback was 15m from creek.	P.C.	17-12-21	B.H.	
PD5	G5	Fence realigned.Lot 21 now proposed.	P.C.	3-11-21	B.H.	
PD4	G5	Fence realigned.	P.C.	2-11-21	B.H.	
P03	ALL	Station refined,lot boundary/easements defined.	P.C.	27/10/21	B.H.	
PD2	ALL	Low pressure realigned.	P.C.	6/10/21	B.H.	
PD1	ALL	Mod 2.	P.C.	6/10/21	B.H.	
REV	ZONE	DETAILS	DRN	DATE	CHKD	APPD



MANILDRA GROUP
 100% AUSTRALIAN



P.C.	DATE
CHKD B.H.	06/10/21
APPD	DATE
SCALE	1:500

SHOALHAVEN STARCHES.BOMADERRY.
 DWG TITLE
GAS FACILITY.MOD 2.
FACTORY GAS SUPPLY PIPELINE.SITE PLAN.
 PROJECT No. **7297**
MN7297-101

A3
 REV.
P06