



BAG-01	Bagged Finish
BRK-01	Face Brickwork with flush joints - Bagged
BRK-02	Face Brickwork with raked horizontal joints - Bagged
CJ	Brick Control Joint (Vertical)
DR-04	External Gate within FEN-03
EL-01	Fibre cement cladding
EL-02	Profiled metal sheet wall cladding
FEN-03	Tubular Steel Security Fencing
RFL-01	Fixed skylight 1200x1200
RFS-01	Metal deck roof
RFS-02	Metal Flashings and Cappings
RWS-01	Eaves gutters


Ref	REFERENCE NUMBER
1	A101
	SHEET NUMBER: G-Series for Wall Sections L-Series for Stair/Lift Details

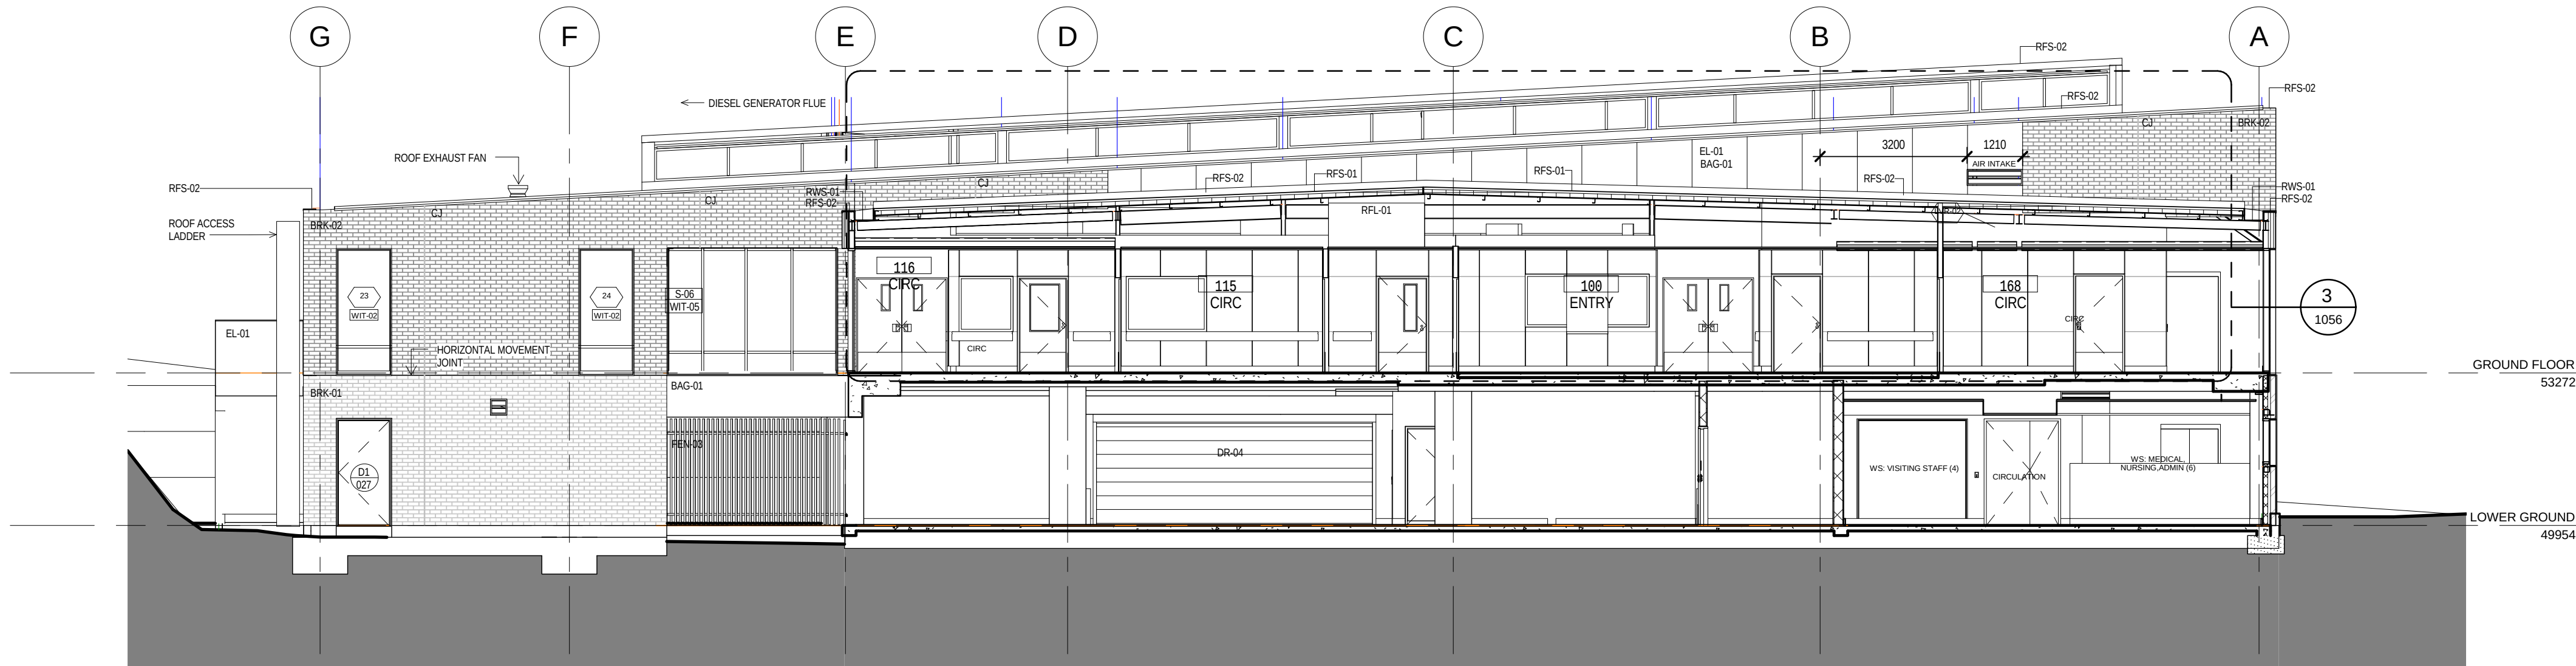


1 SECTION GRID 3-4 EAST
F 02 1:100

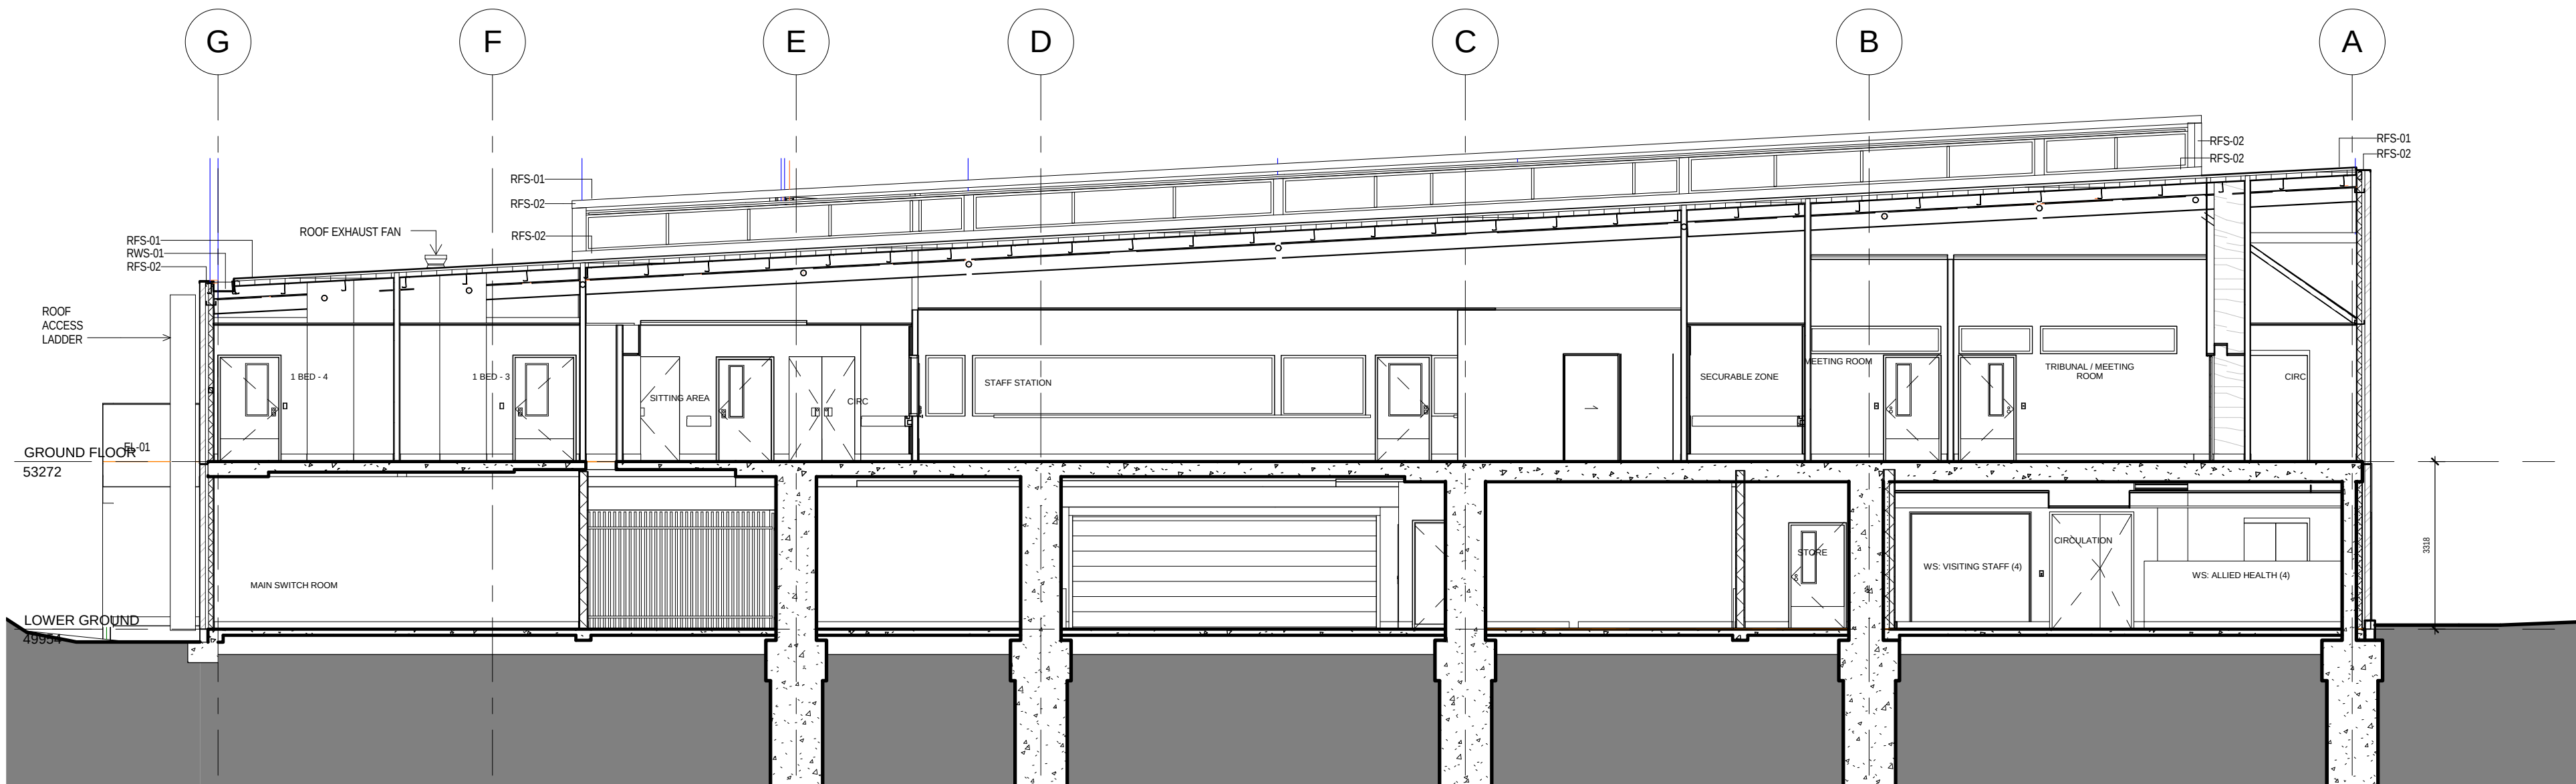

2 SECTION GRID 04 EAST
F 02 1:100

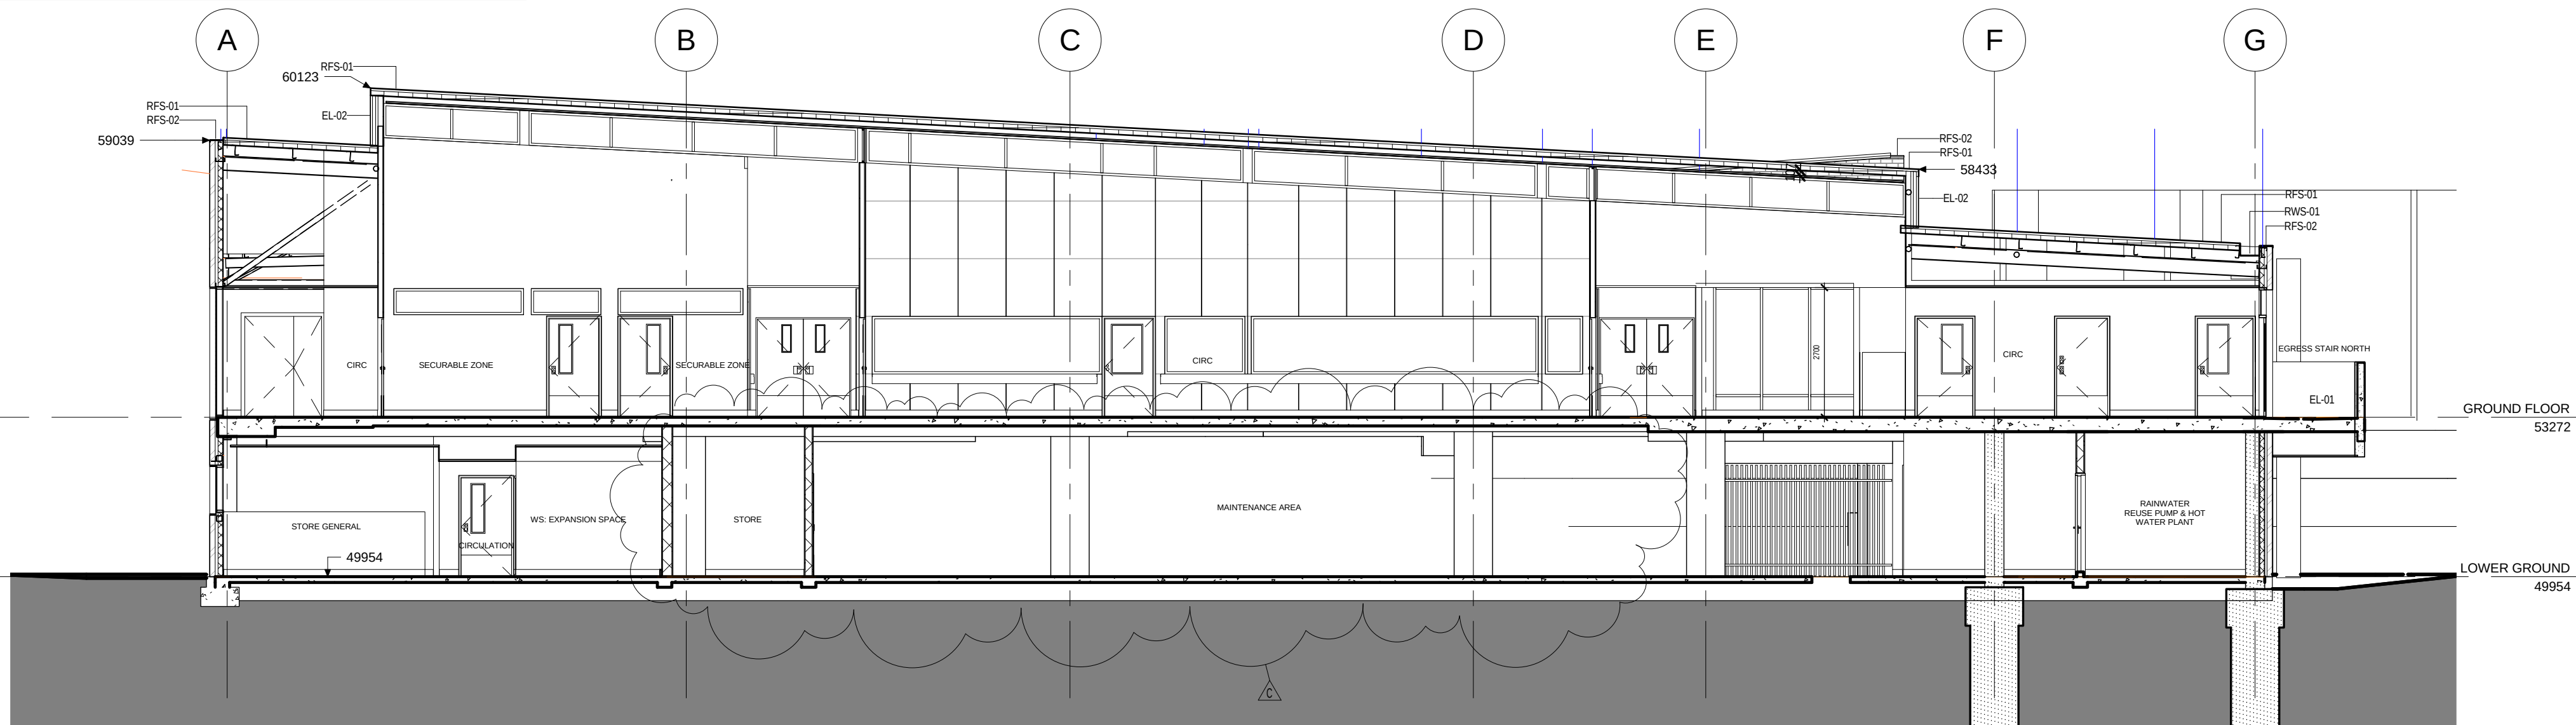

3 SECTION GRID 4-5 WEST
F 02 1:100

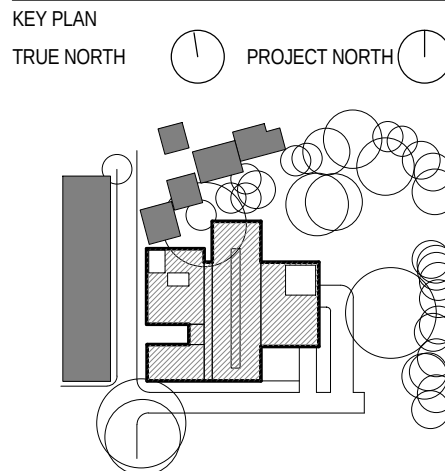

SCALE 1:100 @A1 DO NOT SCALE

CLIENT

HEALTH INFRASTRUCTURE
NSW HEALTH

Health Infrastructure

PROJECT

PRINCE OF WALES HOSPITAL

PROJECT NUMBER

S1009002

BUILDING

POWH MHICU

DESIGN STAGE

CONTRACT DOCUMENTATION

STATUS

DRAWING

SECTIONS NORTH SOUTH

02

DRAWING NUMBER

AR_MHICU_F 02

ISSUE

C