



ISSUE	DATE	FOR
A	08.07.2011	AFC
B	01.02.2012	AFC

BRK-01	Face Brickwork with flush joints - Bagged
BRK-02	Face Brickwork with raked horizontal joints - Bagged
CAN-01	Steel Framed Canopy
CJ	Brick Control Joint (Vertical)
DR-02	Roller shutter - Automatic
RFS-01	Roof shutter - Automatic
RFS-02	Metal deck roof
RFS-03	Metal Flashings and Cappings
RWS-01	Eaves gutters
SCL-01	Solar Panel Hot Water

Ref  
1 REFERENCE NUMBER  
A101 SHEET NUMBER:  
G-Series for Wall Sections  
L-Series for Stair/Lift Details

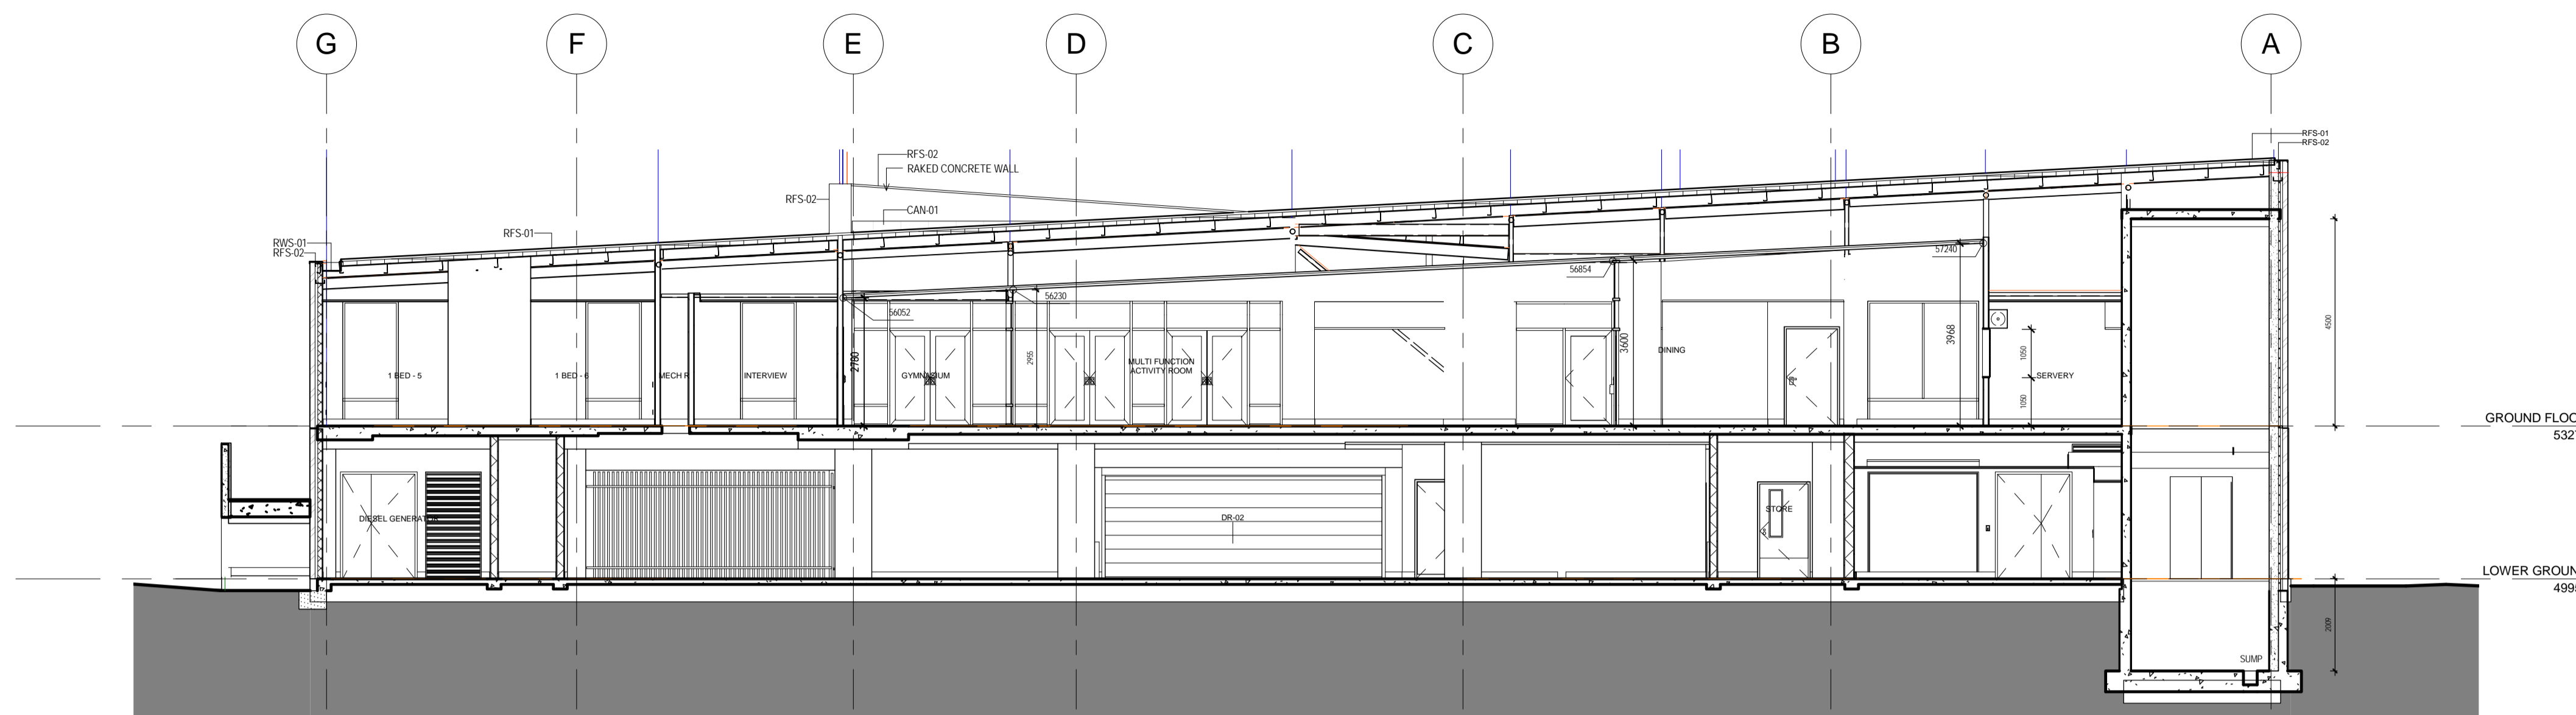


1 SECTION GRID 05 EAST  
F 03 1:100

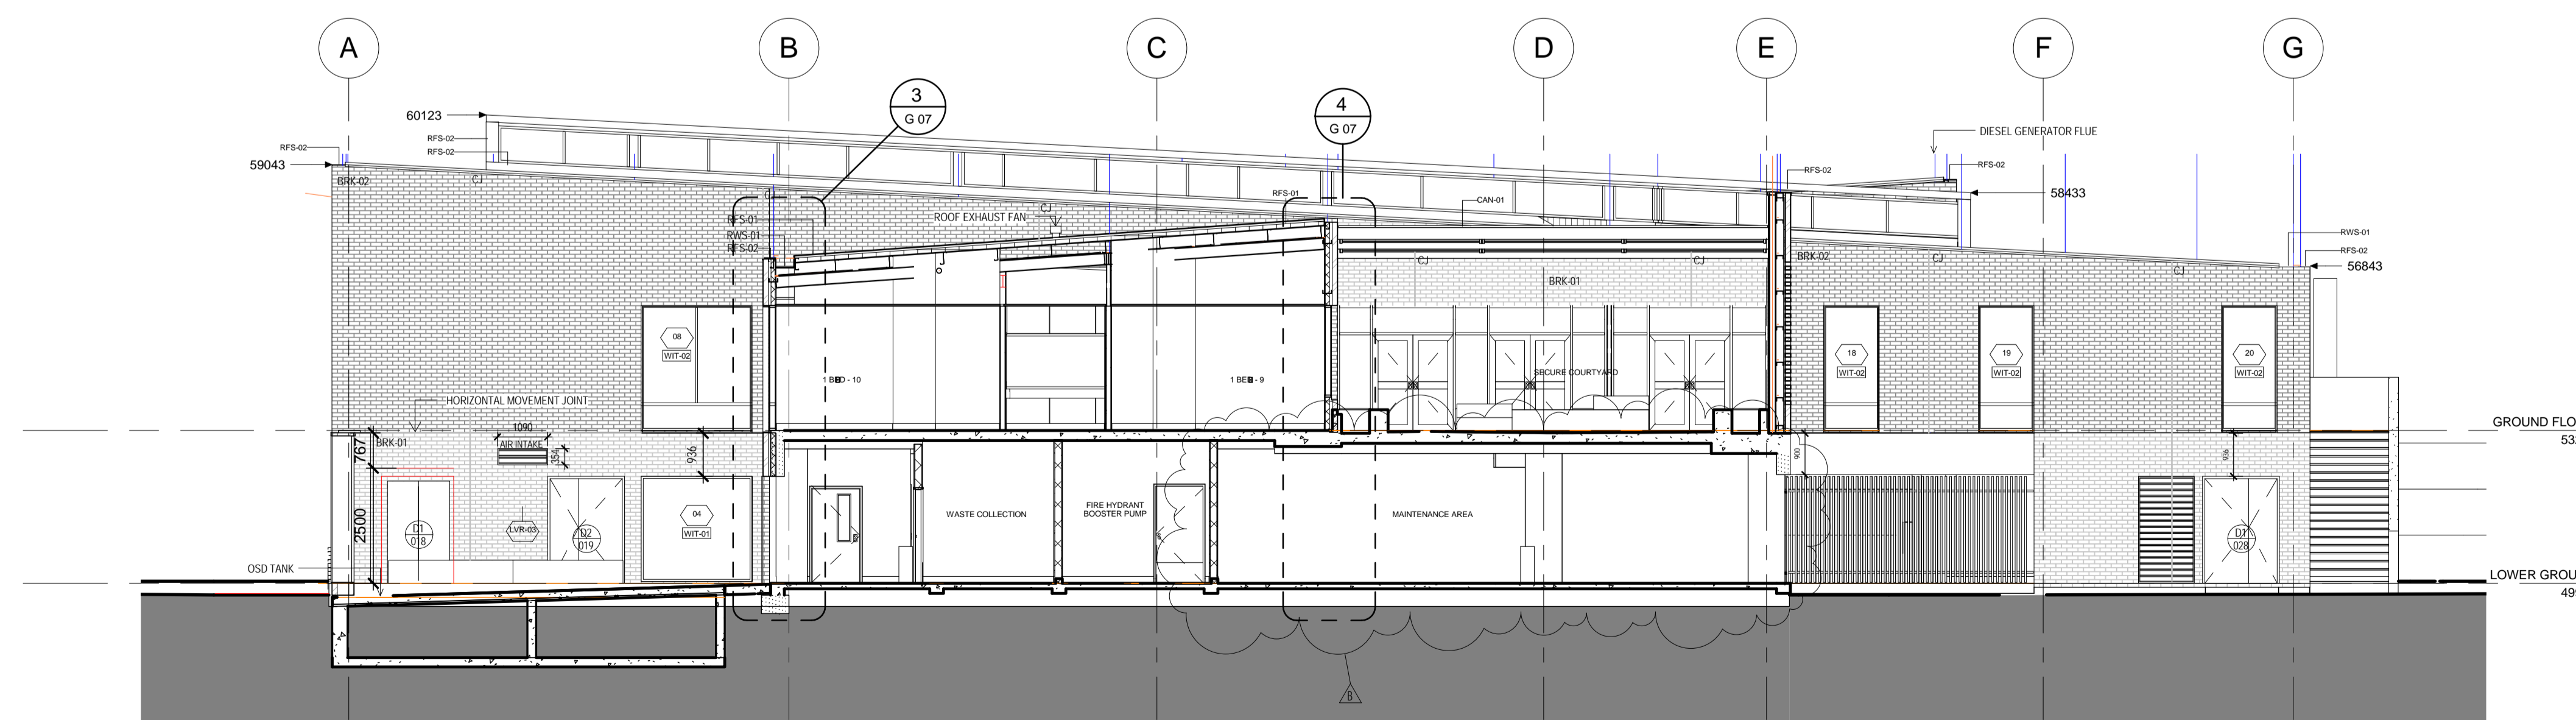

3 SECTION GRID 6-7  
F 03 1:100

KEY PLAN  
TRUE NORTH PROJECT NORTH

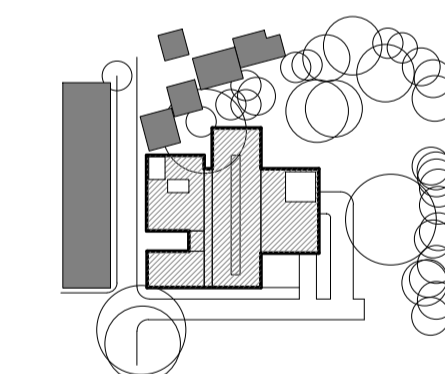

SCALE 1:100 @A1 DO NOT SCALE

CLIENT  
**HEALTH INFRASTRUCTURE  
NSW HEALTH**

Health Infrastructure  
PROJECT

PRINCE OF WALES HOSPITAL  
PROJECT NUMBER

S1009002

BUILDING  
*POWH/MHICU*

DESIGN STAGE

CONTRACT DOCUMENTATION  
STATUS

DRAWING

SECTIONS NORTH SOUTH  
03

DRAWING NUMBER	ISSUE
AR_MHICU_F 03	B