

SYDNEY CHURCH OF ENGLAND GRAMMAR SCHOOL (SHORE)
GRAYTHWAITE
20 EDWARD STREET, NORTH SYDNEY

PART 3A STAGE 1 PROJECT APPLICATION
SECTION 75W


DRAWING SCHEDULE

ARCHITECTURAL

Drawing No.	Drawing Title	Scale	Issue
AR.DA.0001	COVER SHEET / LOCATION PLAN	1:500	E
AR.DA.0002	SITE PLAN	1:500	E
AR.DA.0003	GRAYTHWAITE HOUSE-DEMOLITION PLANS	1:100	D
AR.DA.1001	GRAYTHWAITE HOUSE BASEMENT AND GROUND FLOOR PLANS	1:100	D
AR.DA.1002	GRAYTHWAITE HOUSE FIRST AND ATTIC FLOOR PLANS	1:100	D
AR.DA.1003	GRAYTHWAITE HOUSE ROOF PLAN	1:100	C
AR.DA.2001	GRAYTHWAITE HOUSE ELEVATIONS	1:100	D
AR.DA.2002	GRAYTHWAITE HOUSE SECTIONS	1:100	D
AR.DA.2003	GRAYTHWAITE HOUSE SECTIONS	1:100	C
AR.DA.3001	COACH HOUSE FLOOR PLAN AND ELEVATIONS	1:100	C
AR.DA.4001	TOM O'NEIL CENTRE FLOOR PLAN AND ELEVATIONS	1:100	C
AR.DA.6001	EDWARD STREET GATE - STONE WALL	1:100	A

LANDSCAPE

Drawing No.	Drawing Title	Scale	Issue
LT.000	TITLE SHEET	NTS	F
LT.001	LANDSCAPE MASTER PLAN	1:500	G
LT.002	LANDSCAPE PLAN - NORTH	1:200	G
LT.003	TREE REMOVAL AND RETENTION PLAN	1:500	I
LT.004	EXISTING TREE SCHEDULE - HERITAGE SIGNIFICANCE & ACTION	NTS	E
LT.005	LANDSCAPE HARDWORKS	1:500	E
LT.006	LANDSCAPE SOFTWORKS	1:500	E
LT.007	LANDSCAPE TREE PLAN	1:500	E
LT.008	LANDSCAPE LIGHTING PLAN	1:500	E
LT.009	LANDSCAPE DETAILS	AS SHOWN	A
LT.010	EARLY WORKS PLANTING	1:200	B
LT.011	EARLY WORKS LANDSCAPE DETAILS	AS SHOWN	B

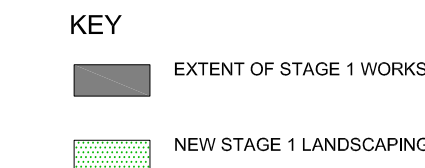


01 LOCATION PLAN
1:500

CLIENT
Sydney Church of England Grammar School (Shore)

Blue Street, North Sydney
NSW 2060

T +61 2 9923 2277
F +61 2 9922 2689

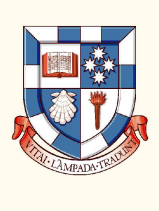

ARCHITECTS
P D Mayoh Pty Ltd Architects

T + 61 2 9958 0488 F +61 2 9958 6424

LANDSCAPE ARCHITECTS
Taylor Brammer

T + 61 2 9387 8855 F +61 2 9387 8155

ARCHITECTS
Tanner Architects

T + 61 2 9281 4399 F +61 2 9281 4337

PROJECT MANAGER
Fitzwalter Group

T + 61 2 8925 6701 F +61 2 8925 6798

Rev	Date	Description	Checked	Auth.
P1	29.07.10	Preliminary Issue	GP	RD
P2	28.09.10	Issue for Client Review	GP	RD
A	16.11.10	Issue for Project Application	GP	RD
B	21.09.11	Revised Project Application Issue	GP	RD
C	01.03.13	Issue for Section 75W	GP	RD
D	17.04.13	Issue for Section 75W - Amended	GP	RD
E	11.09.13	Issue for Section 75W - Amended	GP	RD

Proj. Dir. **RD** Proj. Arch. **GP** Drawn **GP/HS/LA/CR**

Job No. Date Scale

09 0821 Sep 2013 1:500 @ A1

NSW Nominated Architects
Robert Denton Registration No. 5782
Alex Kibbie Registration No. 6015

Do not scale drawings. Verify all dimensions on site. Notify architect of all discrepancies

10 20 30 40 50 100

Project
GRAYTHWAITE STAGE 1 PROJECT APPLICATION

Drawing Title
COVER & LOCATION PLAN

Drawing No. **AR.DA. 0001** Revision **E**

PO Box 660
Darlinghurst
NSW 1300
Australia


52 Albion Street
Surry Hills
NSW 2010
Australia

T +61 2 9281 4399
F +61 2 9281 4337
info@tannerarchitects.com.au
www.tannerarchitects.com.au

60 STRATHALLAN AVENUE,
NORTHBRIDGE
NEW SOUTH WALES 2063
AUSTRALIA
TELEPHONE +02 99580488
FACSIMILE +02 99586424

tanner Architects

MAYOH
ARCHITECTS

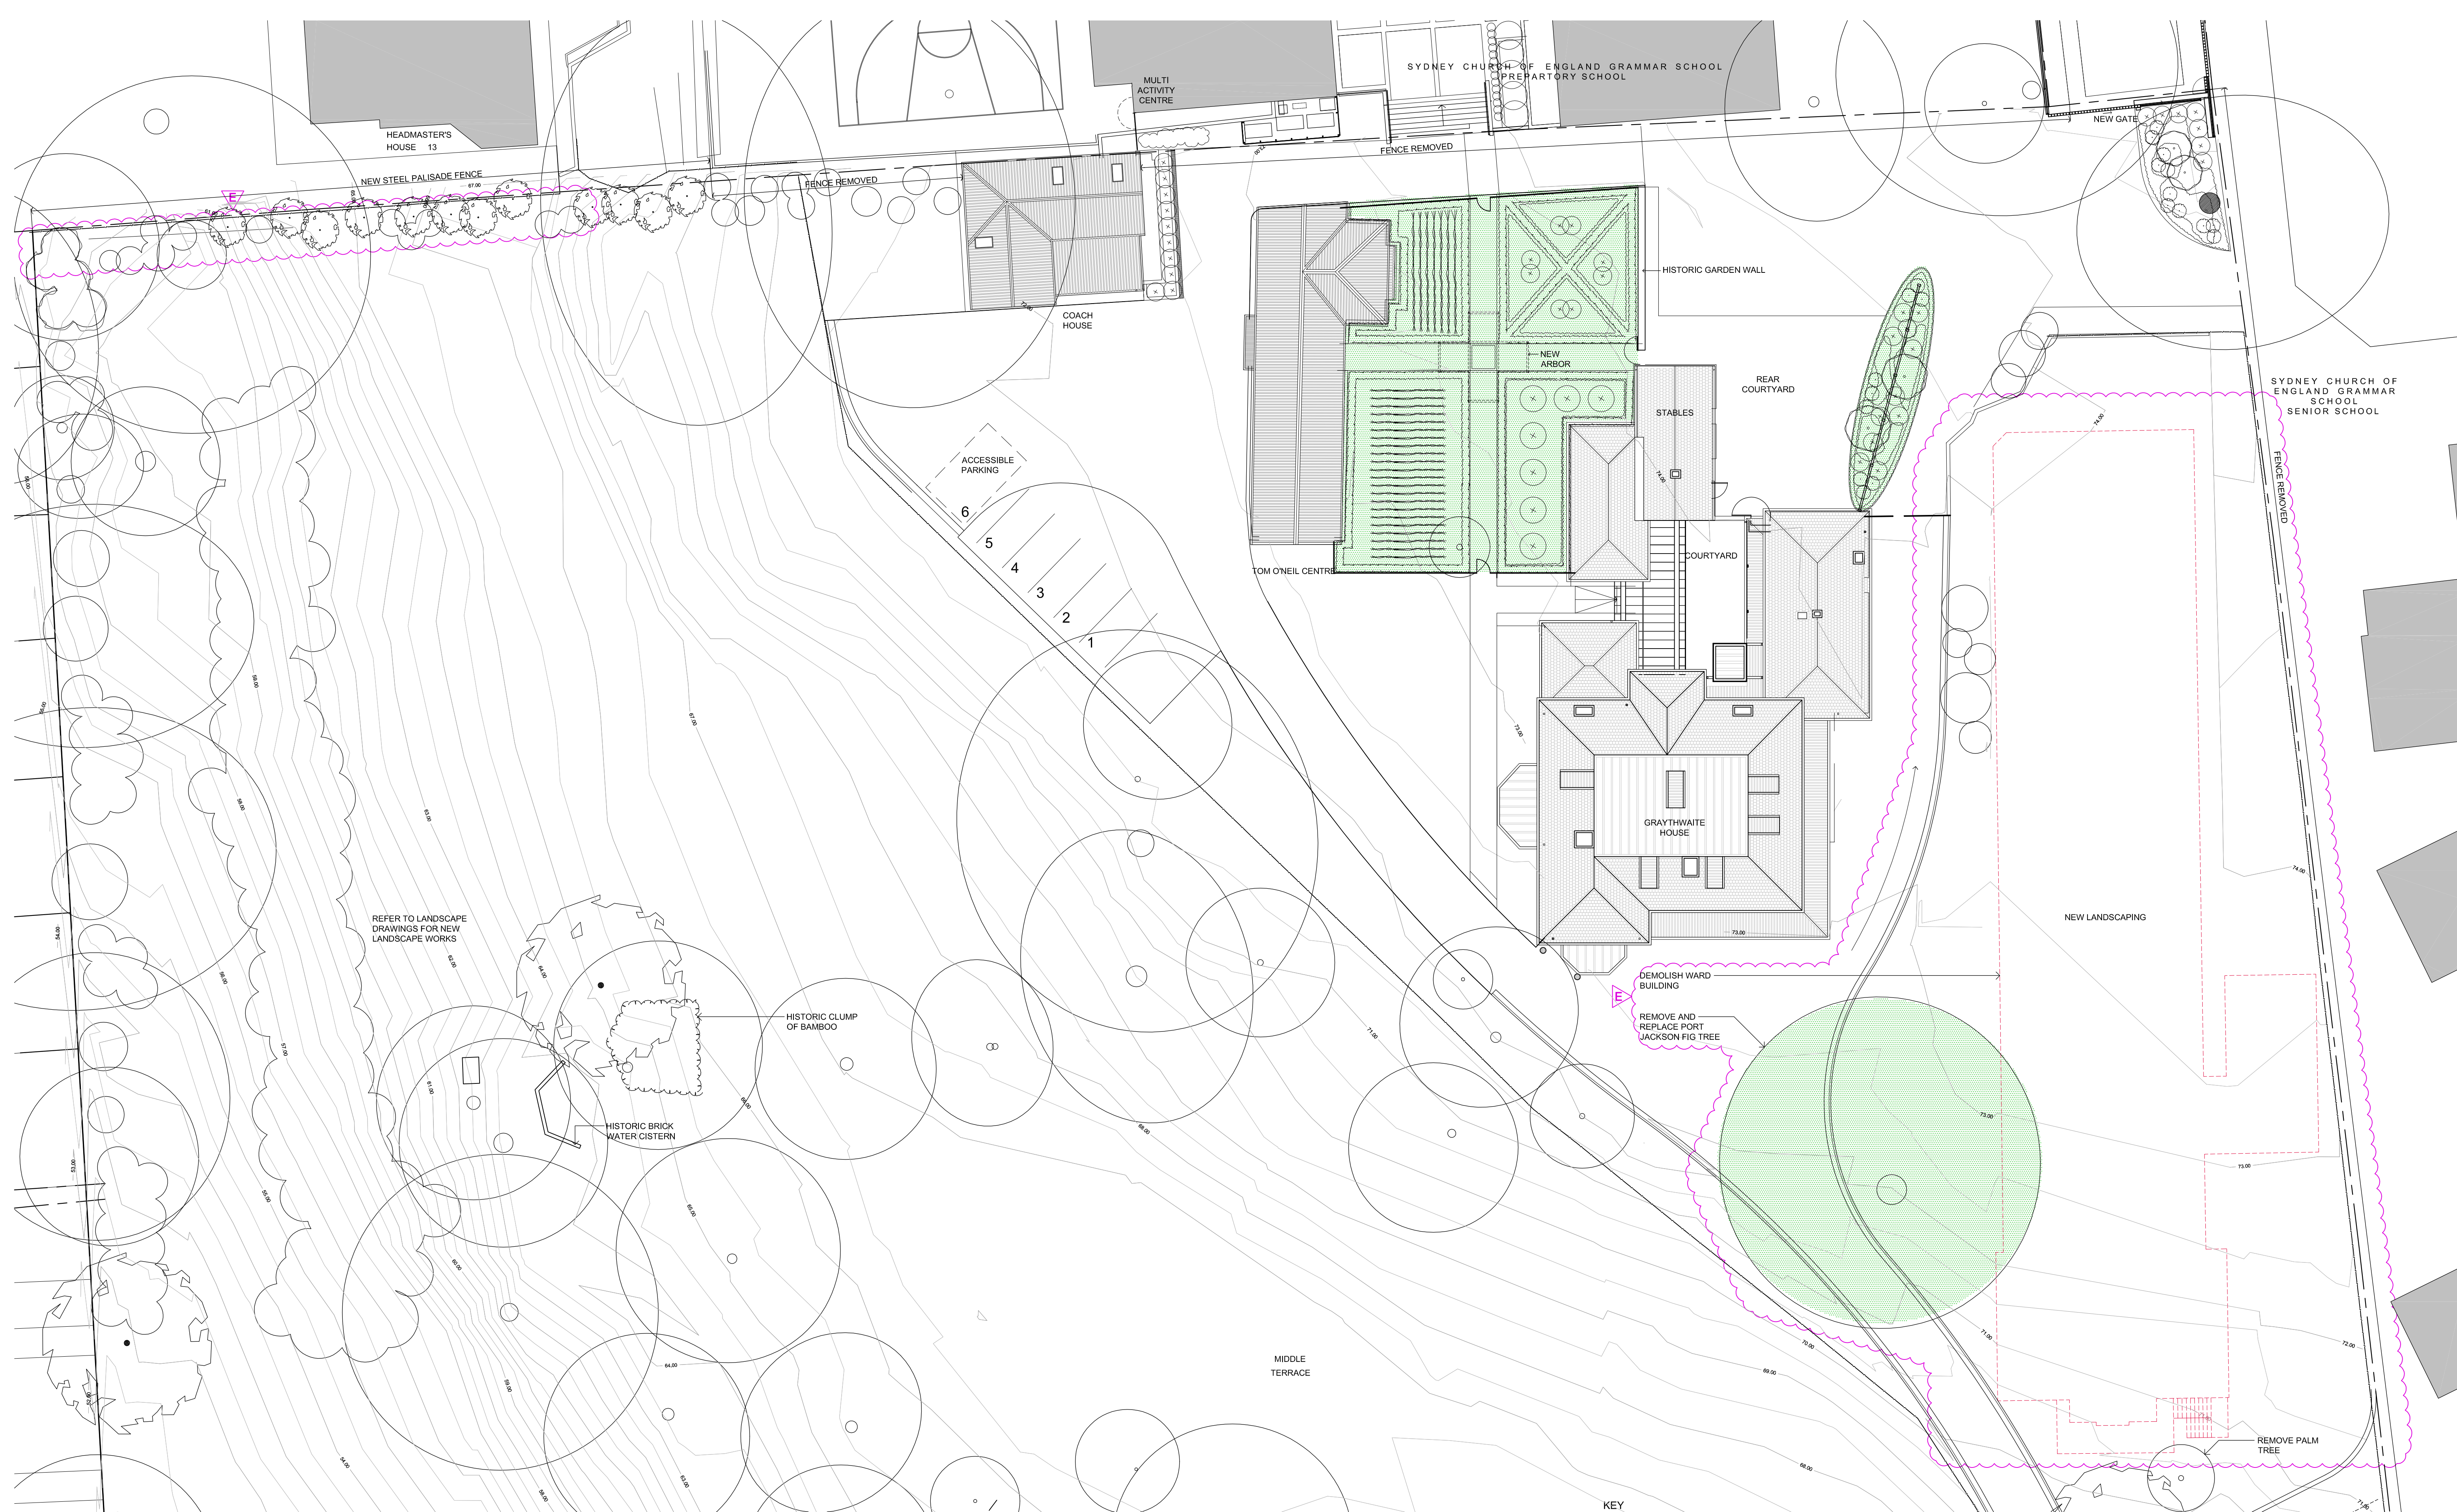

01 SITE PLAN
0001 1:200

CLIENT
Sydney Church of England
Grammar School (Shore)

Blue Street, North Sydney
NSW 2060

T +61 2 9923 2277
F +61 2 9922 2689



ARCHITECTS
P D Mayoh Pty Ltd Architects
T + 61 2 9958 0488 F +61 2 9958 6424

LANDSCAPE ARCHITECTS
Taylor Brammer
T + 61 2 9387 8855 F +61 2 9387 8155

ARCHITECTS
Tanner Architects
T + 61 2 9281 4399 F +61 2 9281 4337

PROJECT MANAGER
Fitzwalter Group
T + 61 2 8925 6701 F +61 2 8925 6798

Rev	Date	Description	Checked	Auth.
P1	31.07.10	Preliminary Issue	GP	RD
P2	28.09.10	Issue for Client Review	GP	RD
A	17.11.10	Issue for Project Application	GP	RD
B	21.09.11	Revised Project Application Issue	GP	RD
C	27.02.13	Issue for Section 75W	GP	RD
D	17.04.13	Issue for Section 75W - Amended	GP	RD
E	11.09.13	Issue for Section 75W - Amended	GP	RD

Proj. Dir
RD GP GP/HS/LA/CR
Job No. Date Scale

09 0821 Sep 2013 1:200 @ A1

NSW Nominated Architects:
Robert Denton Registration No. 5782
Alex Kiddle Registration No. 6015

Do not scale drawings. Verify all dimensions on site. Notify architect of all discrepancies

10 20 30 40 50 100

KEY
EXISTING BUILDING - NO WORKS
NEW STAGE 1 LANDSCAPING

Project
GRAYTHWAITE
STAGE 1 PROJECT
APPLICATION

Drawing Title
SITE PLAN

Drawing No.
AR.DA. 0002

Revision


E

PO Box 660
Darlinghurst
NSW 1300
Australia
52 Albion Street
Sunny Hills
NSW 2010
Australia
T +61 2 9281 4399
F +61 2 9281 4337
info@tannerarchitects.com.au
www.tannerarchitects.com.au


tanner Architects



60 STRATHALLAN AVENUE,
NORTHBRIDGE
NEW SOUTH WALES 2063
AUSTRALIA
TELEPHONE +02 99580488
FACSIMILE +02 99586424

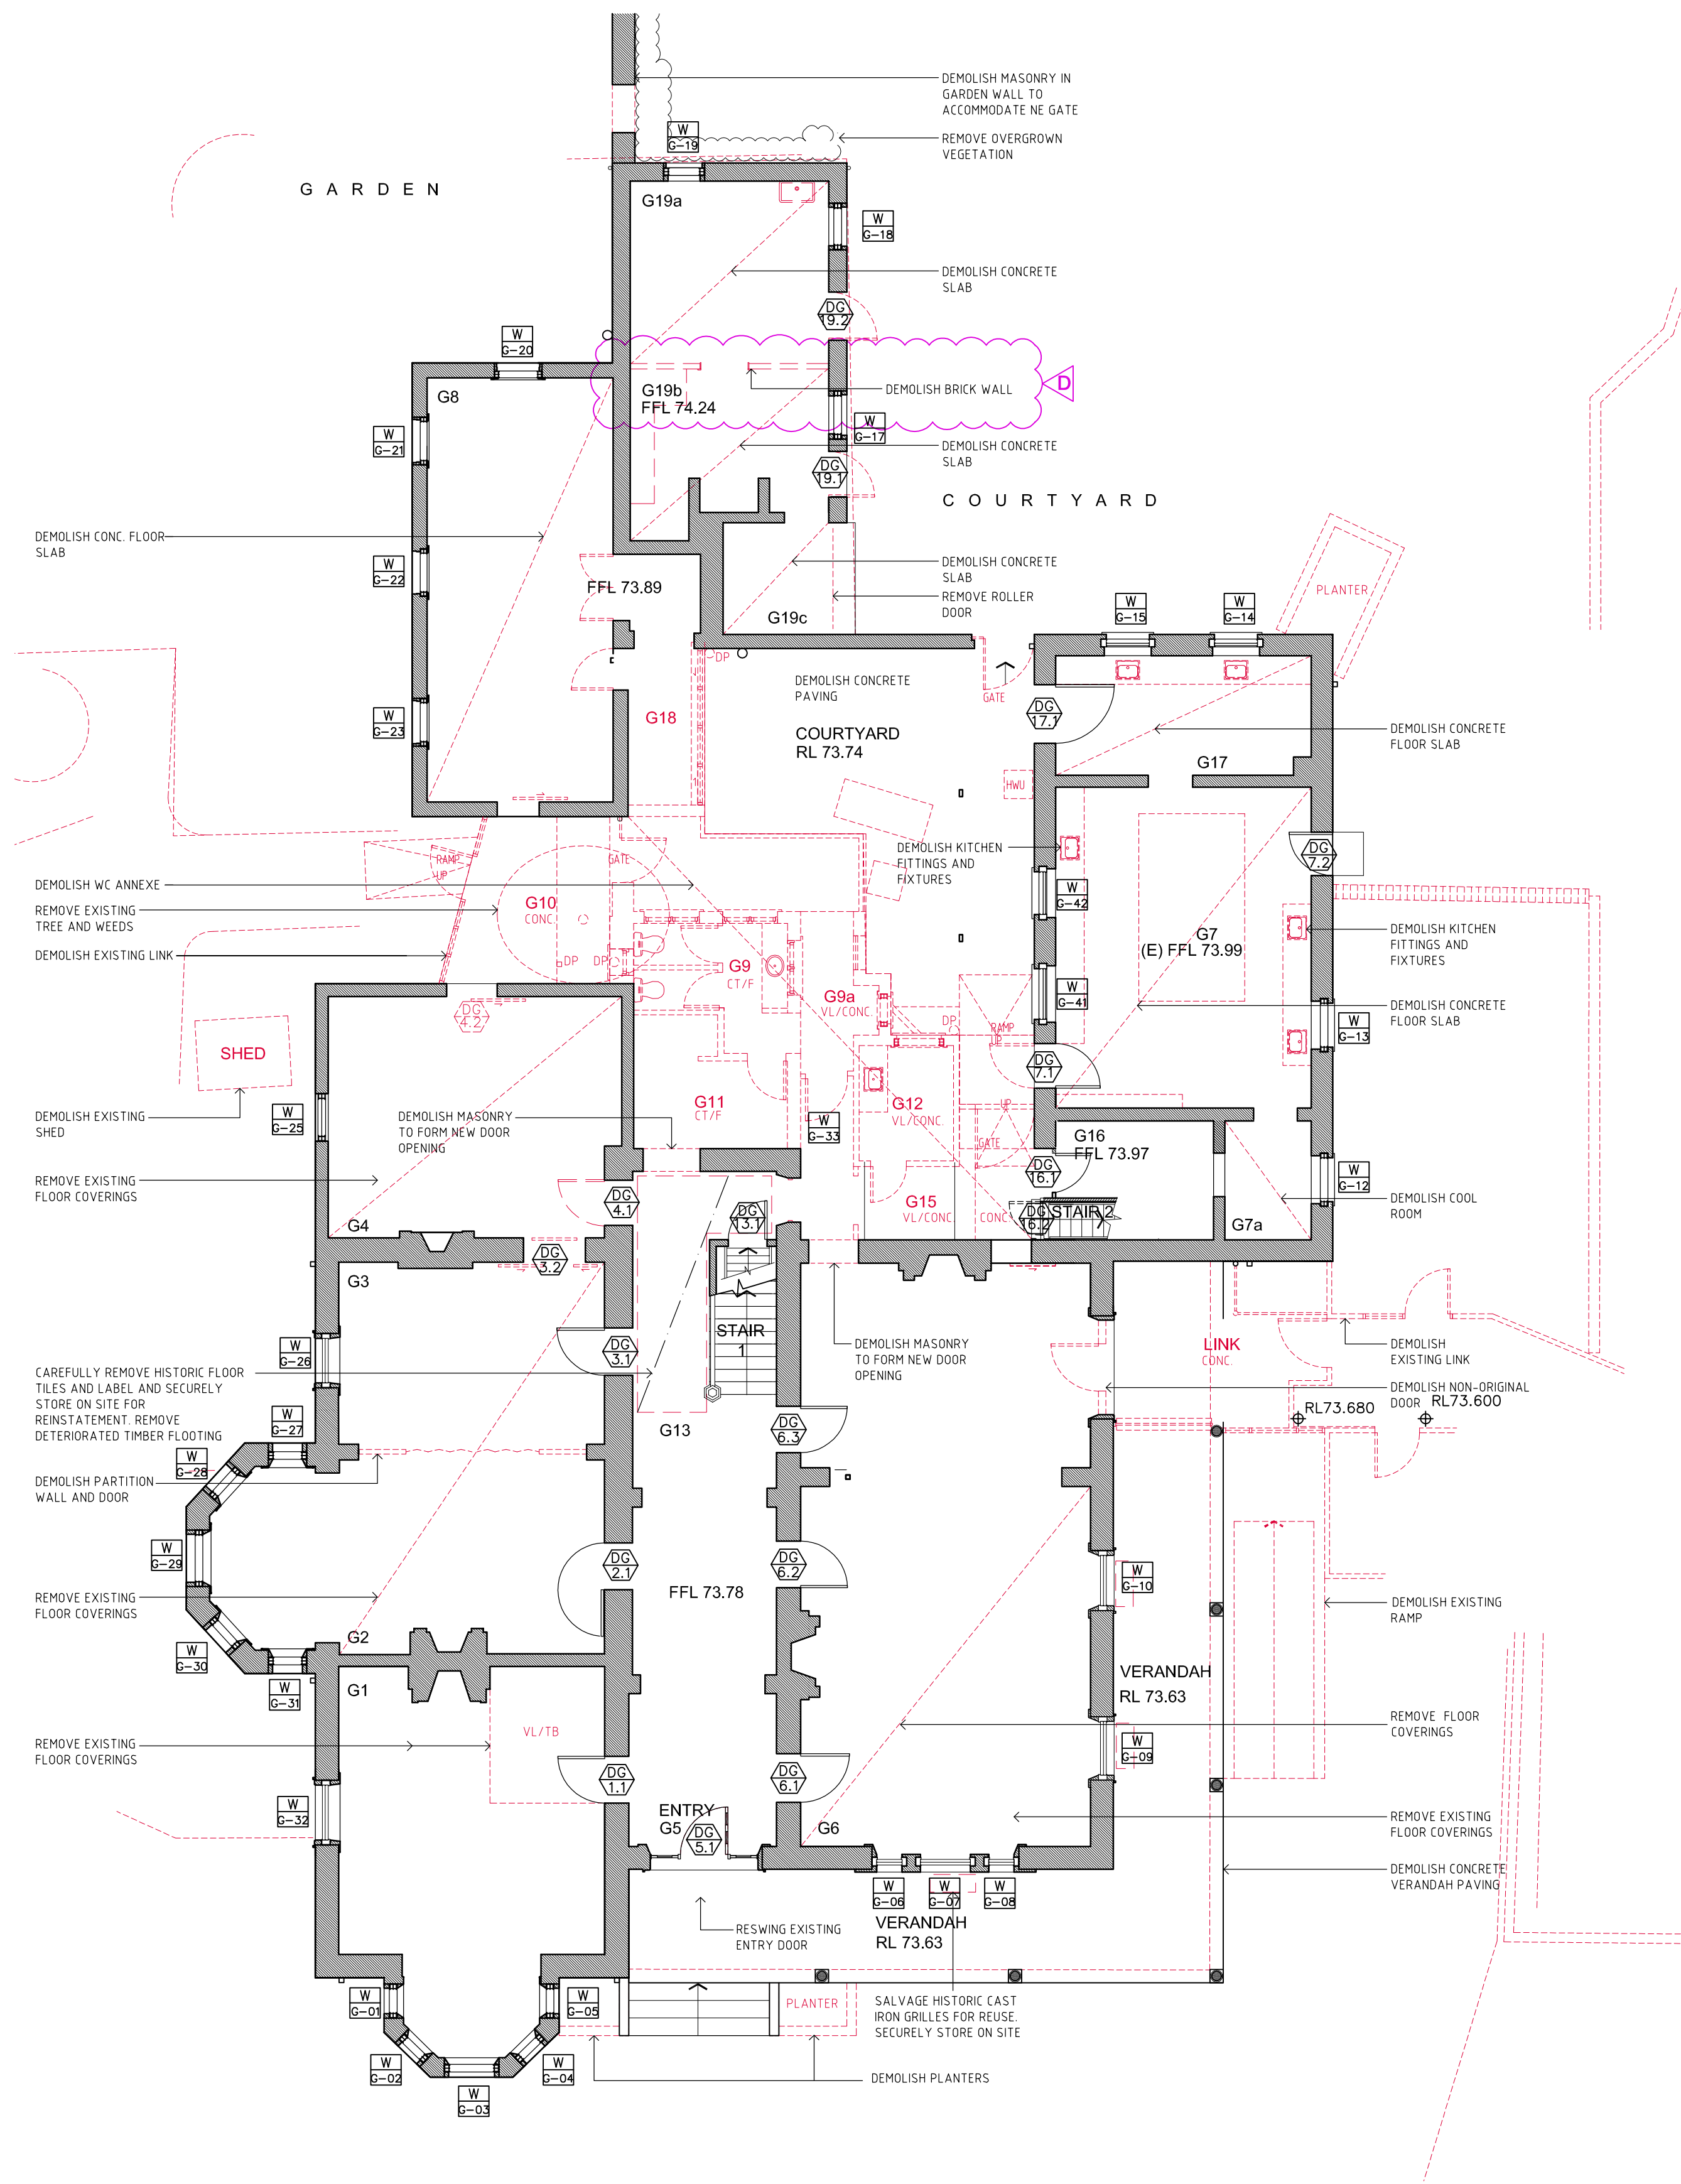

01 GROUND FLOOR DEMOLITION PLAN
1:100

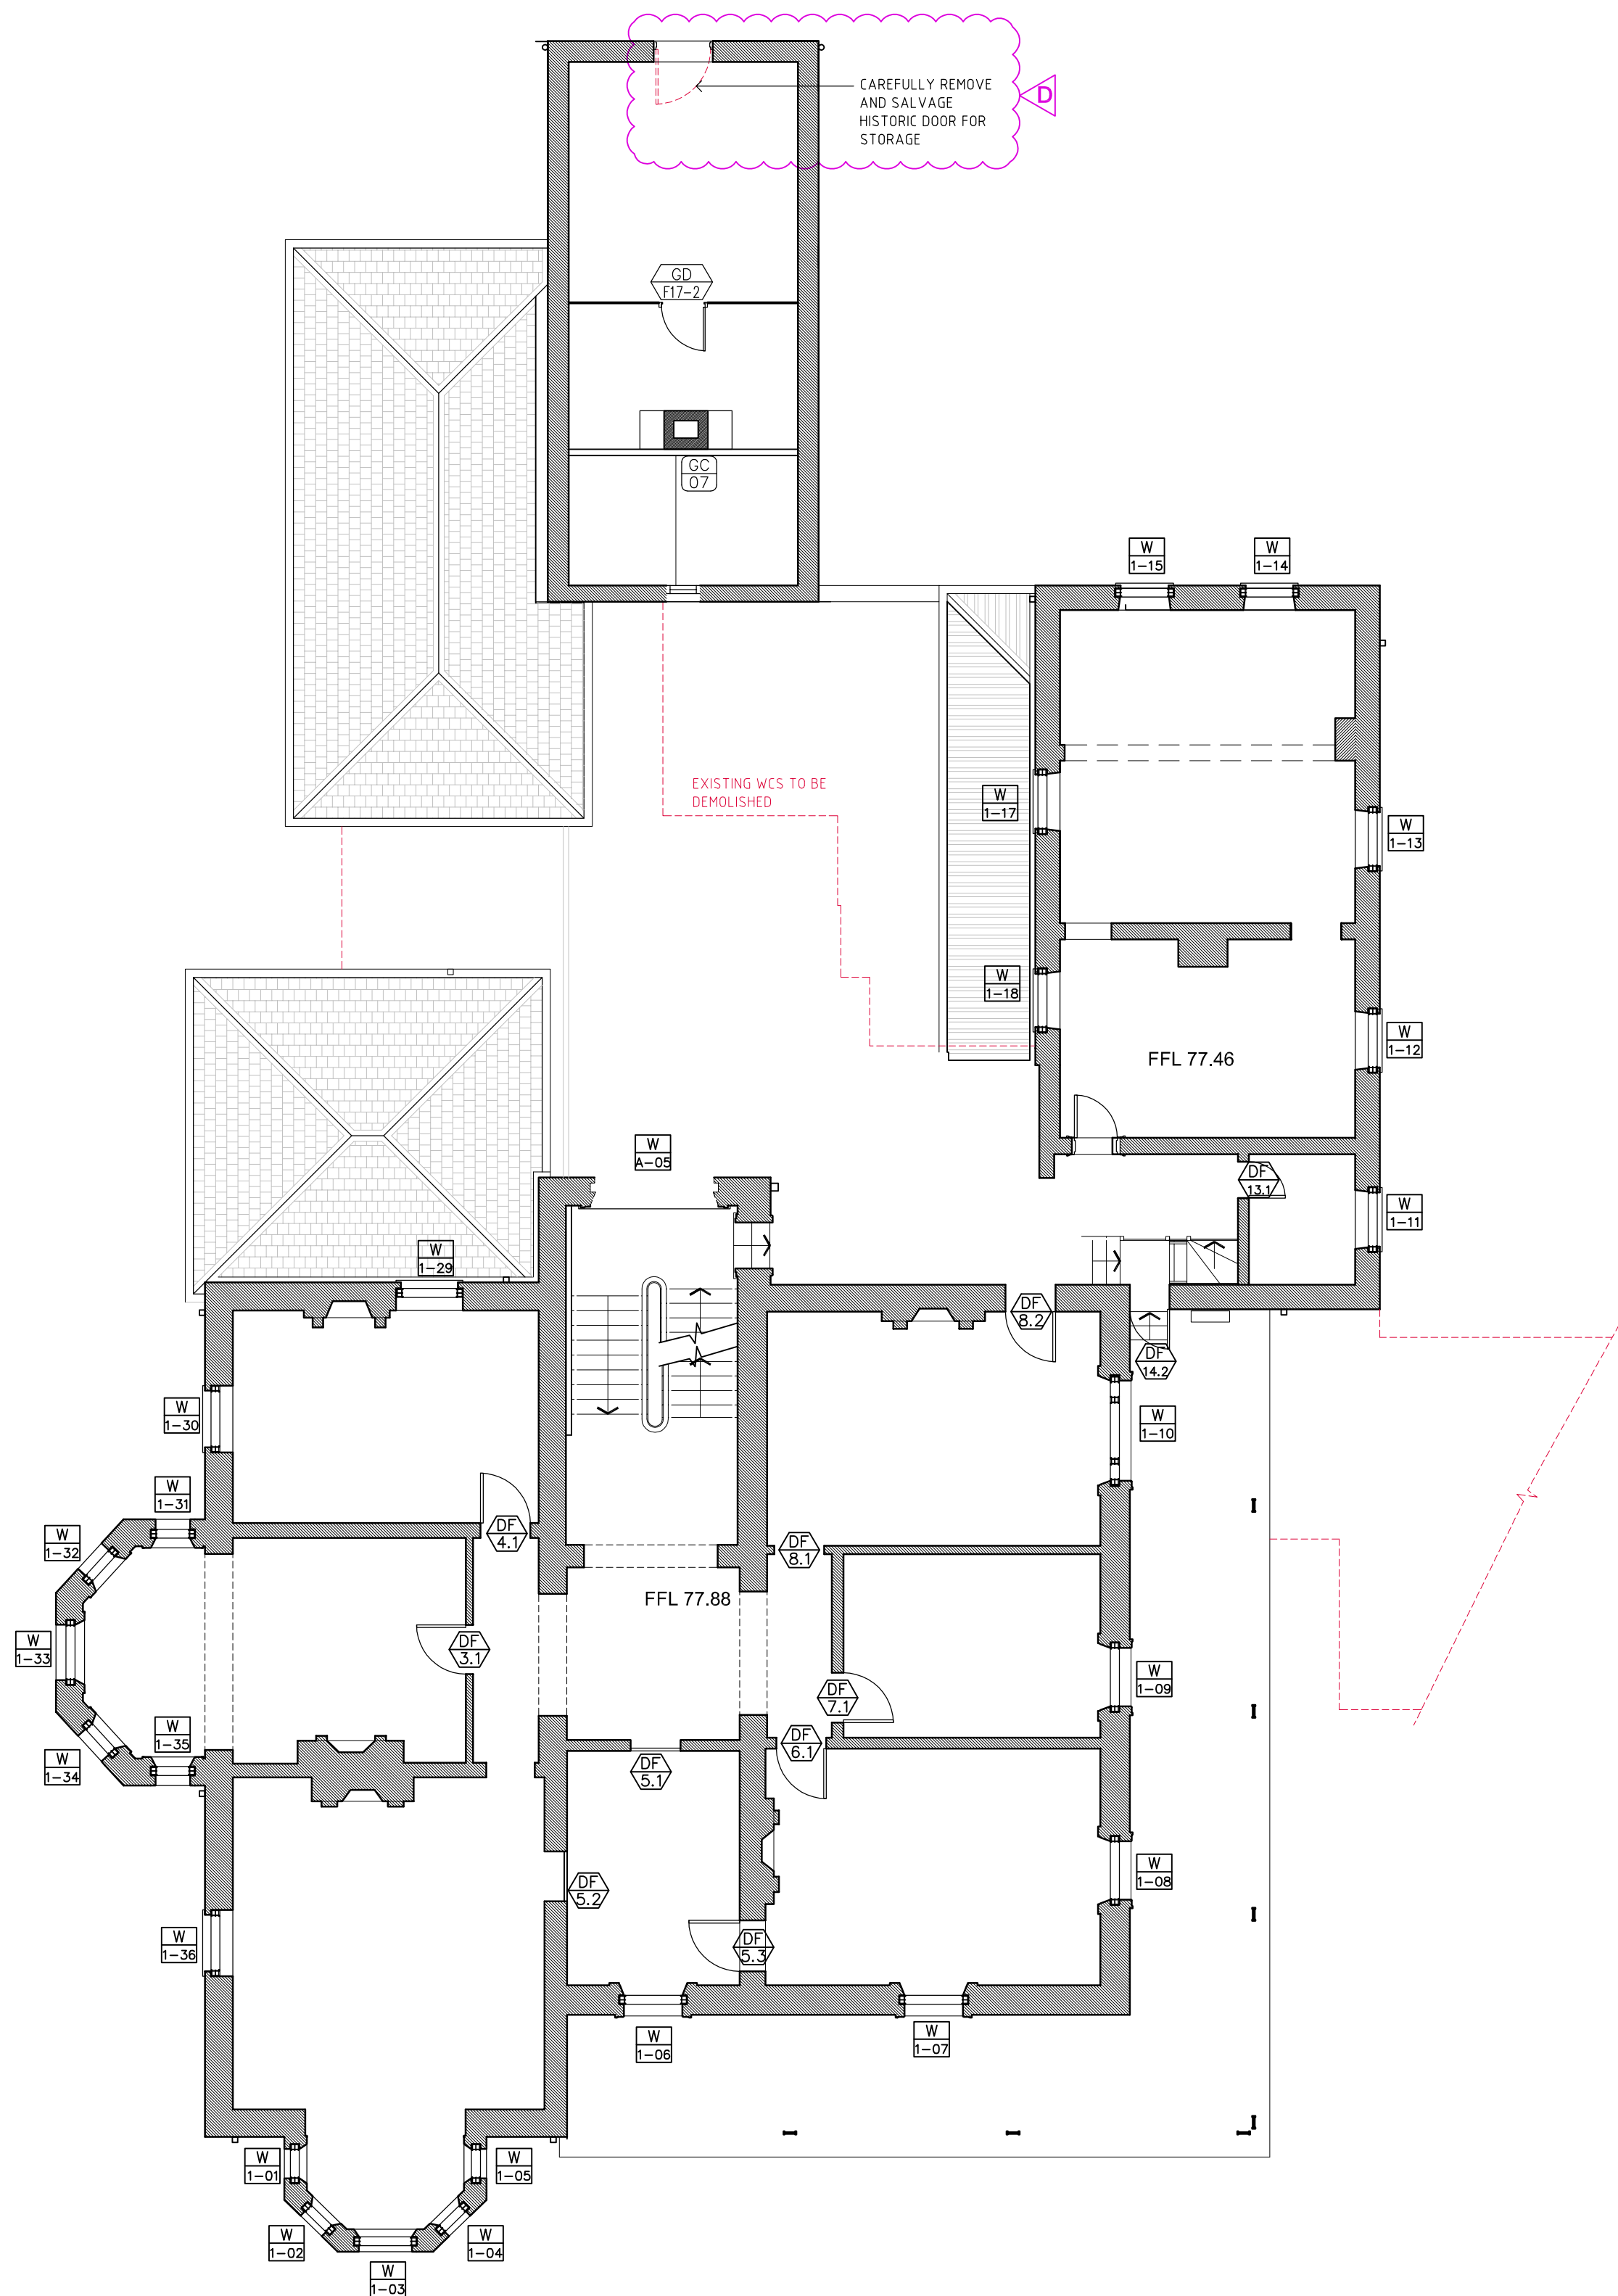

02 FIRST FLOOR DEMOLITION PLAN
1:100

GENERAL NOTES-DEMOLITION

1. REMOVE EXISTING FLOOR COVERINGS TO AREAS AS INDICATED
2. DEMOLISH REDUNDANT AND NON-ORIGINAL FITTINGS AND FIXTURES
3. ARCHAEOLOGIST TO MONITOR WORKS DURING DEMOLITION OF REAR WC ANNEXE AND REMOVAL OF COURTYARD PAVING
4. REMOVE ALL REDUNDANT SERVICES, PIPEWORK, WIRING, CONDUITS AND THE LIKE

WALL TYPE LEGEND

- (E) SANDSTONE
- (E) 270 MASONRY WALL
- (E) 110 MASONRY WALL
- (E) STUD WALL
- (N) SANDSTONE
- (N) MASONRY WALL
- (N) STUD WALL

LEGEND

- BK/F FACE BRICKWORK
- CPT CARPET
- CONC. CONCRETE
- CT/F CERAMIC FLOOR TILES
- DP DOWNPIPE
- ED EXISTING
- FP FIREPLACE
- FT FLOOR TILES
- G GLAZING
- M MARBLE
- MRS METAL ROOF SHEETING
- MT METAL TRAY DECK ROOFING
- N NEW
- PT PAINT FINISH
- PB PLASTERBOARD
- R RENDERED
- SKL SKYLIGHT
- SL SLATE
- SF SHEET RESILIENT FLOORING
- ST STONE
- TB TIMBER
- TF TIMBER FLOOR
- VL VINYL
- VT/VF VITREOUS TILE FLOOR

CLIENT
**Sydney Church of England
Grammar School (Shore)**

Blue Street, North Sydney
NSW 2060

T +61 2 9923 2277
F +61 2 9922 2660



ARCHITECTS
P D Mayoh Pty Ltd Architects

T + 61 2 9958 0488 F +61 2 9958 6424

LANDSCAPE ARCHITECTS
Taylor Brammer

T + 61 2 9387 8855 F +61 2 9387 8155

ARCHITECTS
Tanner Architects

T + 61 2 9281 4399 F +61 2 9281 4337

PROJECT MANAGER
Fitzwalter Group

T + 61 2 8925 6701 F +61 2 8925 6798

Rev	Date	Description	Checked	Auth.
P1	31.08.10	Preliminary Issue	GP	RD
P2	28.09.10	Issue for Client Review	GP	RD
A	17.11.10	Issue for Project Application	GP	RD
B	21.09.11	Revised Project Application Issue	GP	RD
C	27.02.13	Revised Project Application Issue	GP	RD
D	11.09.13	Issue for Section 75W - Amended	GP	RD

Proj. Dir	Proj. Arch	Drawn
RD	GP	CR
Job No.	Date	Scale
09 0821	Sep 2013	1:100@A1

NSW Notified Architects:
Robert Denton Registration No. 5782
Alex Kibble Registration No. 6015

Do not scale drawings. Verify all dimensions on site. Notify architect of all discrepancies

10 20 30 40 50 100

Project
**GRAYTHWAITE
STAGE 1 PROJECT
APPLICATION**

Drawing Title
**GRAYTHWAITE HOUSE- DEMOLITION
BASEMENT AND GROUND FLOOR PLANS**

Drawing No.

Revision

AR.DA. 0003

D

PO Box 660
Darlinghurst
NSW 1300
Australia



52 Albion Street
Surry Hills
NSW 2010
Australia

T +61 2 9281 4399
F +61 2 9281 4337
info@tannerarchitects.com.au
www.tannerarchitects.com.au

tanner Architects



60 STRATHALLAN AVENUE,
NORTHBRIDGE
NEW SOUTH WALES 2063
AUSTRALIA
TELEPHONE +61 99580488
FACSIMILE +61 99580424

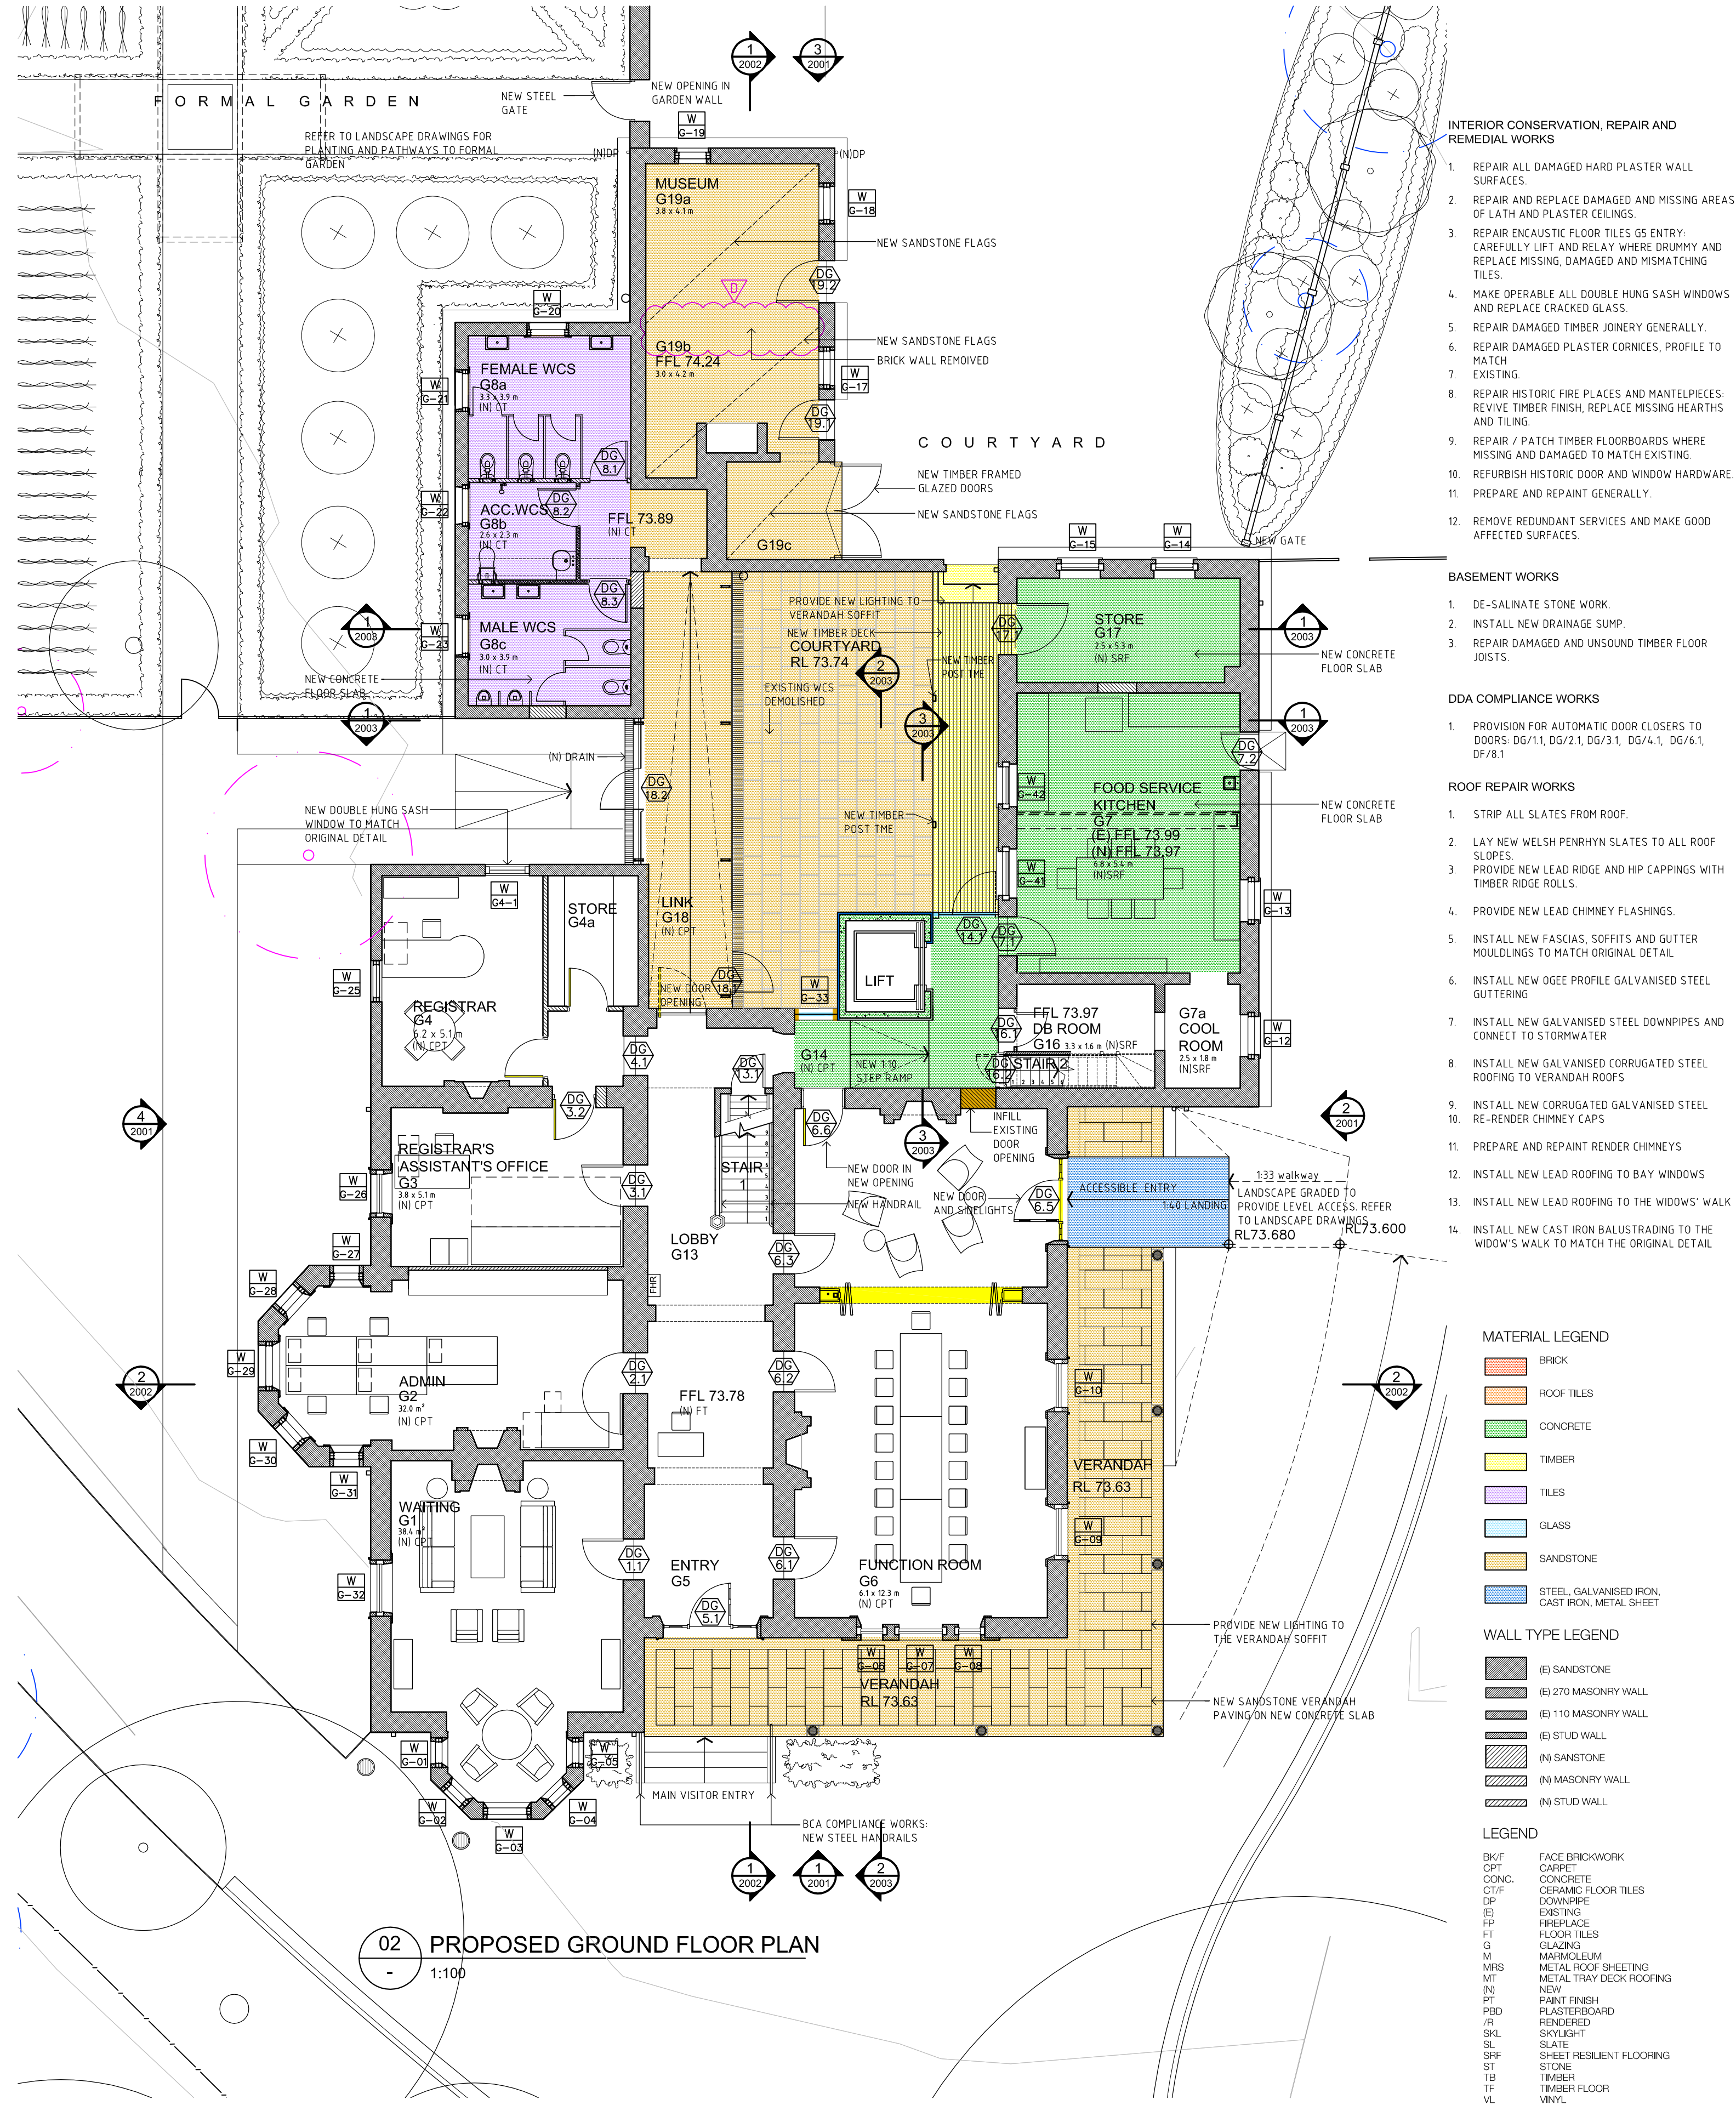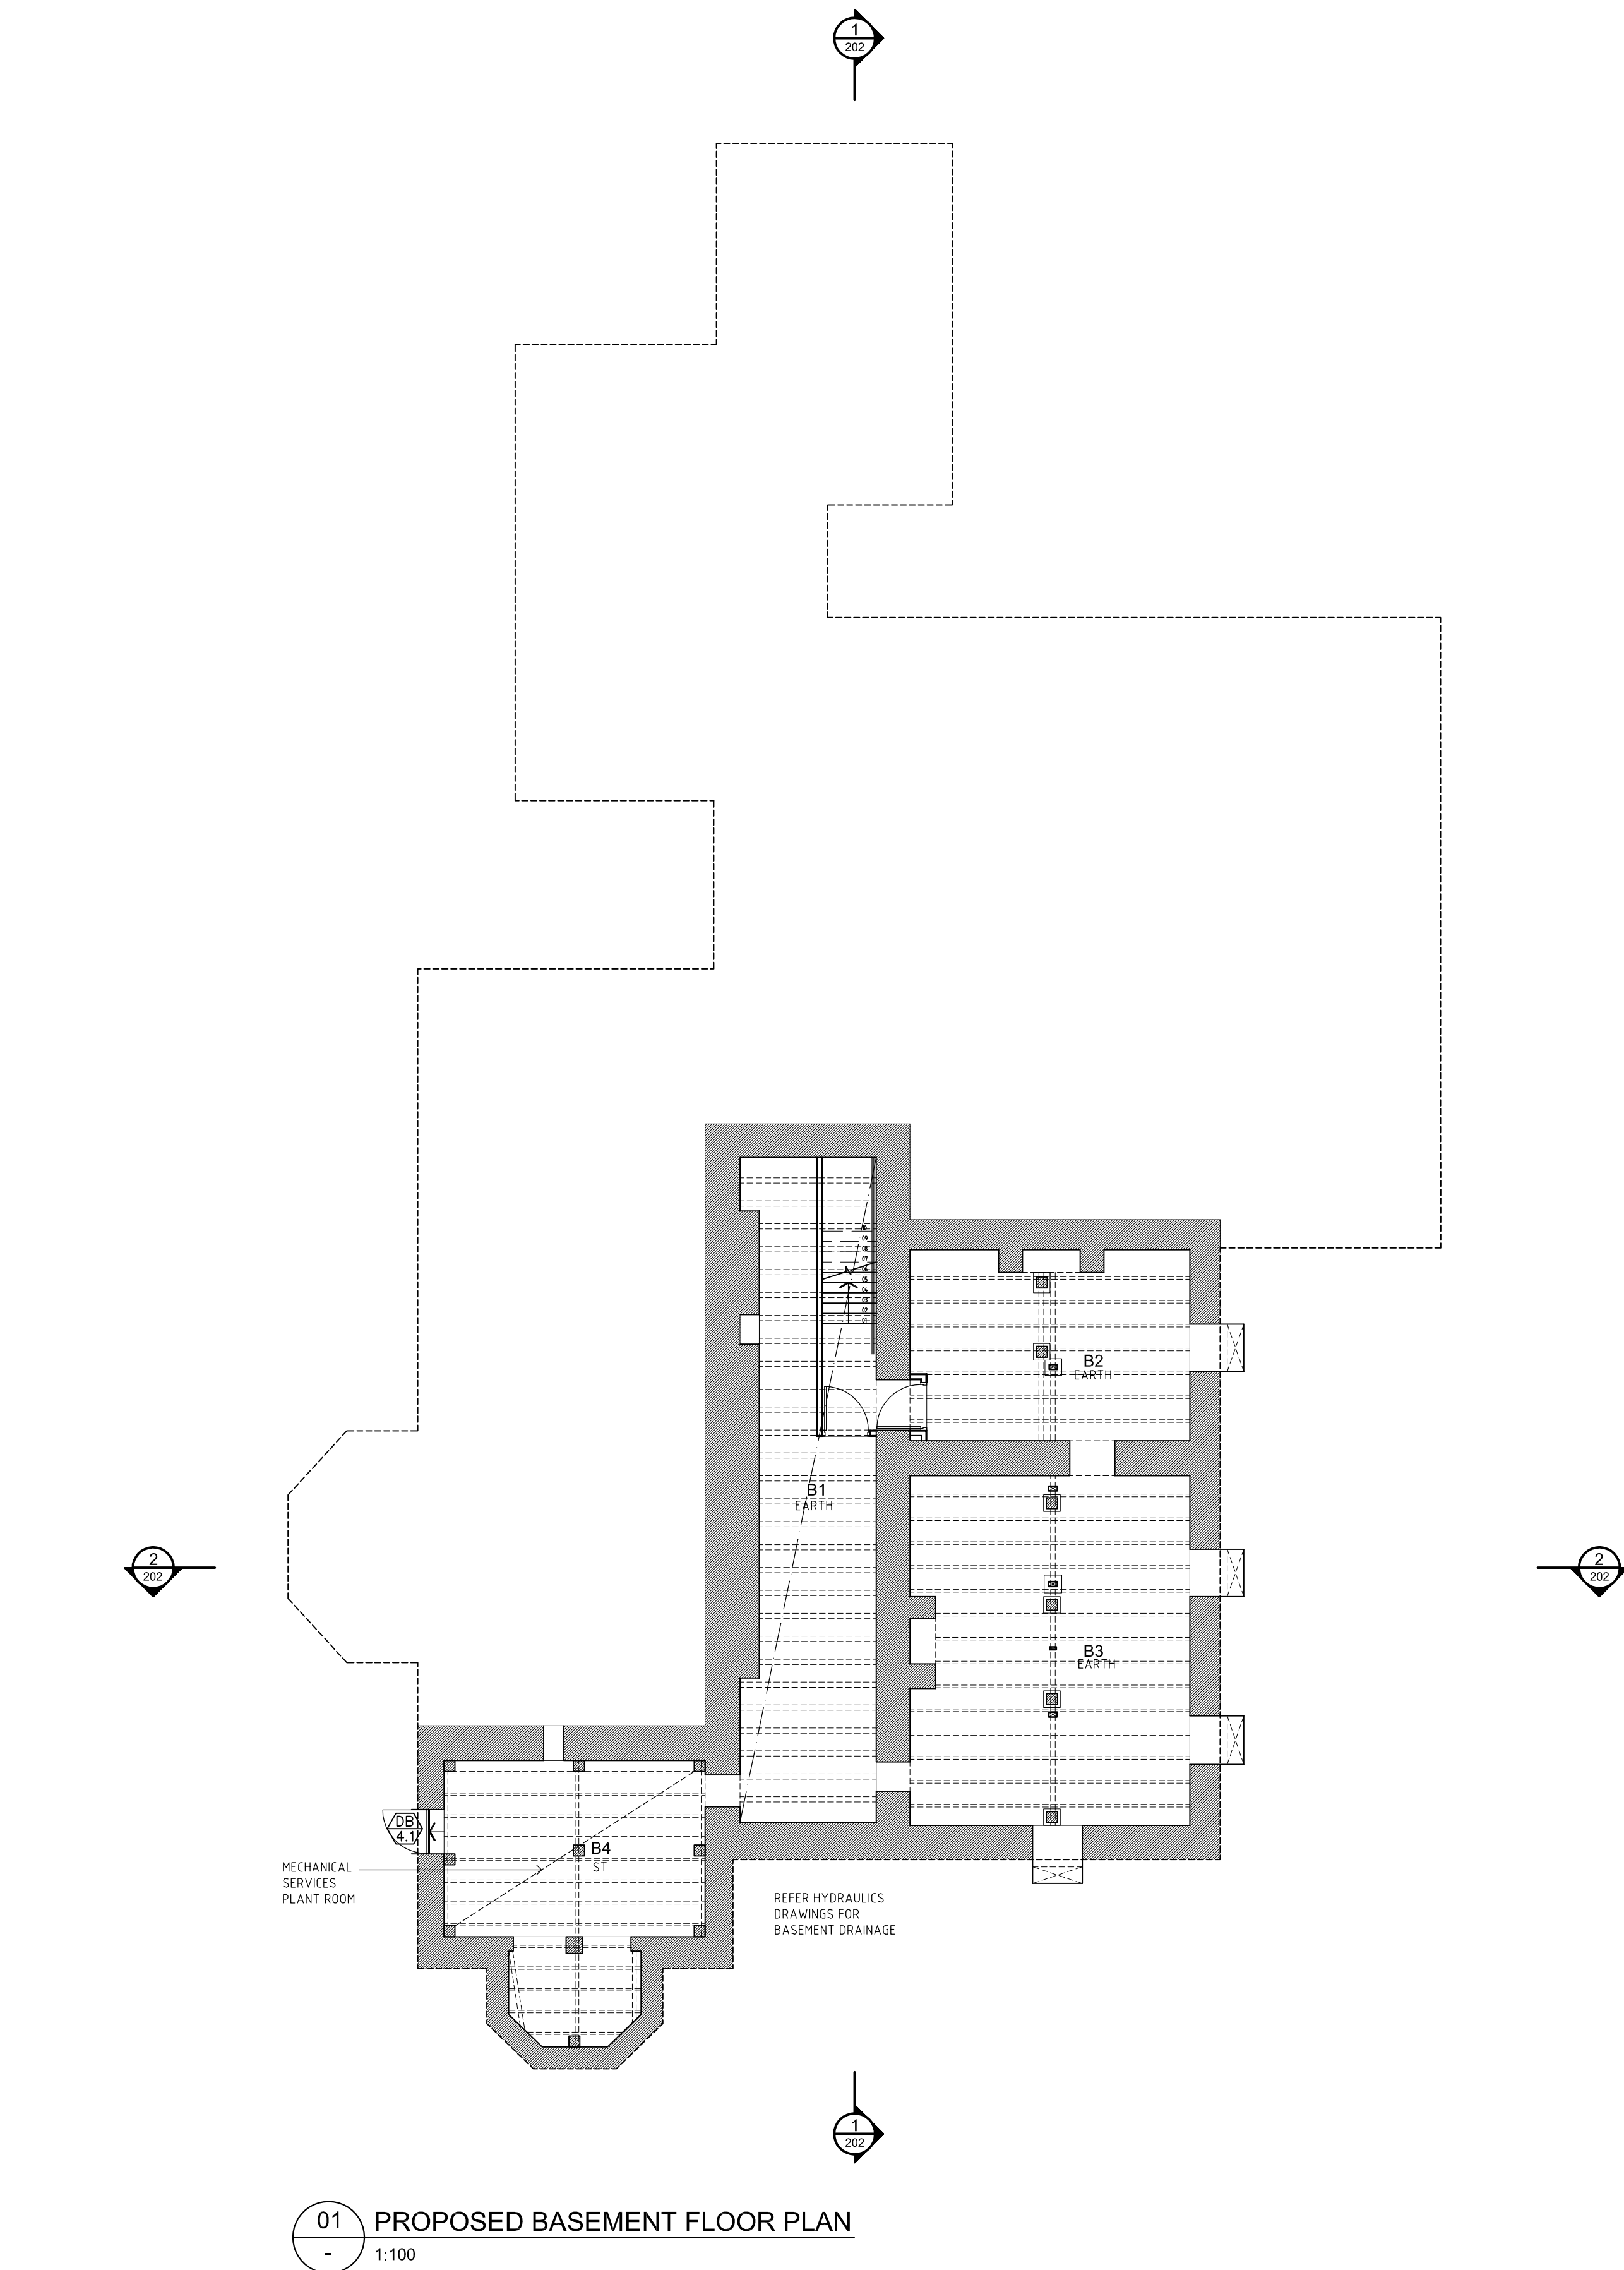

CLIENT
Sydney Church of England
Grammar School (Shore)

Blue Street, North Sydney
NSW 2060

T +61 2 9923 2277
F +61 2 9922 2689



ARCHITECTS
P D Mayoh Pty Ltd Architects

T + 61 2 9958 0488 F +61 2 9958 6424

LANDSCAPE ARCHITECTS
Taylor Brammer

T + 61 2 9387 8855 F +61 2 9387 8155

ARCHITECTS
Tanner Architects

T + 61 2 9281 4399 F +61 2 9281 4337

PROJECT MANAGER
Fitzwalter Group

T + 61 2 8925 6701 F +61 2 8925 6798

Rev	Date	Description	Checked	Auth.
P1	02.08.10	Preliminary Issue	GP	RD
P2	28.08.10	Issue for Client Review	GP	RD
A	17.11.10	Issue for Project Application	GP	RD
B	21.09.11	Revised Project Application Issue	GP	RD
C	27.02.13	Revised Project Application Issue	GP	RD
D	11.09.13	Issue for Section 75W - Amended	GP	RD

Proj. Dir	Proj. Arch	Drawn
RD	GP	GP
Job No.	Date	Scale
09 0821	Sep 2013	1:100 @ A1
Drawing Title GRAYTHWAITE HOUSE BASEMENT AND GROUND FLOOR PLANS		
Drawing No.		
Revision		
Do not scale drawings. Verify all dimensions on site. Notify architect of all discrepancies		

Project
GRAYTHWAITE
STAGE 1 PROJECT
APPLICATION

Drawing Title
GRAYTHWAITE HOUSE
BASEMENT AND GROUND FLOOR PLANS

Drawing No.

Revision

PO Box 660
Darlinghurst
NSW 1500
Australia

52 Albion Street
Sunny Hills
NSW 2010
Australia

T +61 2 9281 4399
F +61 2 9281 4337
info@tannerarchitects.com.au
www.tannerarchitects.com.au

tanner Architects



60 STRATHALLEN AVENUE,
NORTHBRIDGE
NEW SOUTH WALES 2063
AUSTRALIA
TELEPHONE +02 99580488
FACSIMILE +02 99580424