


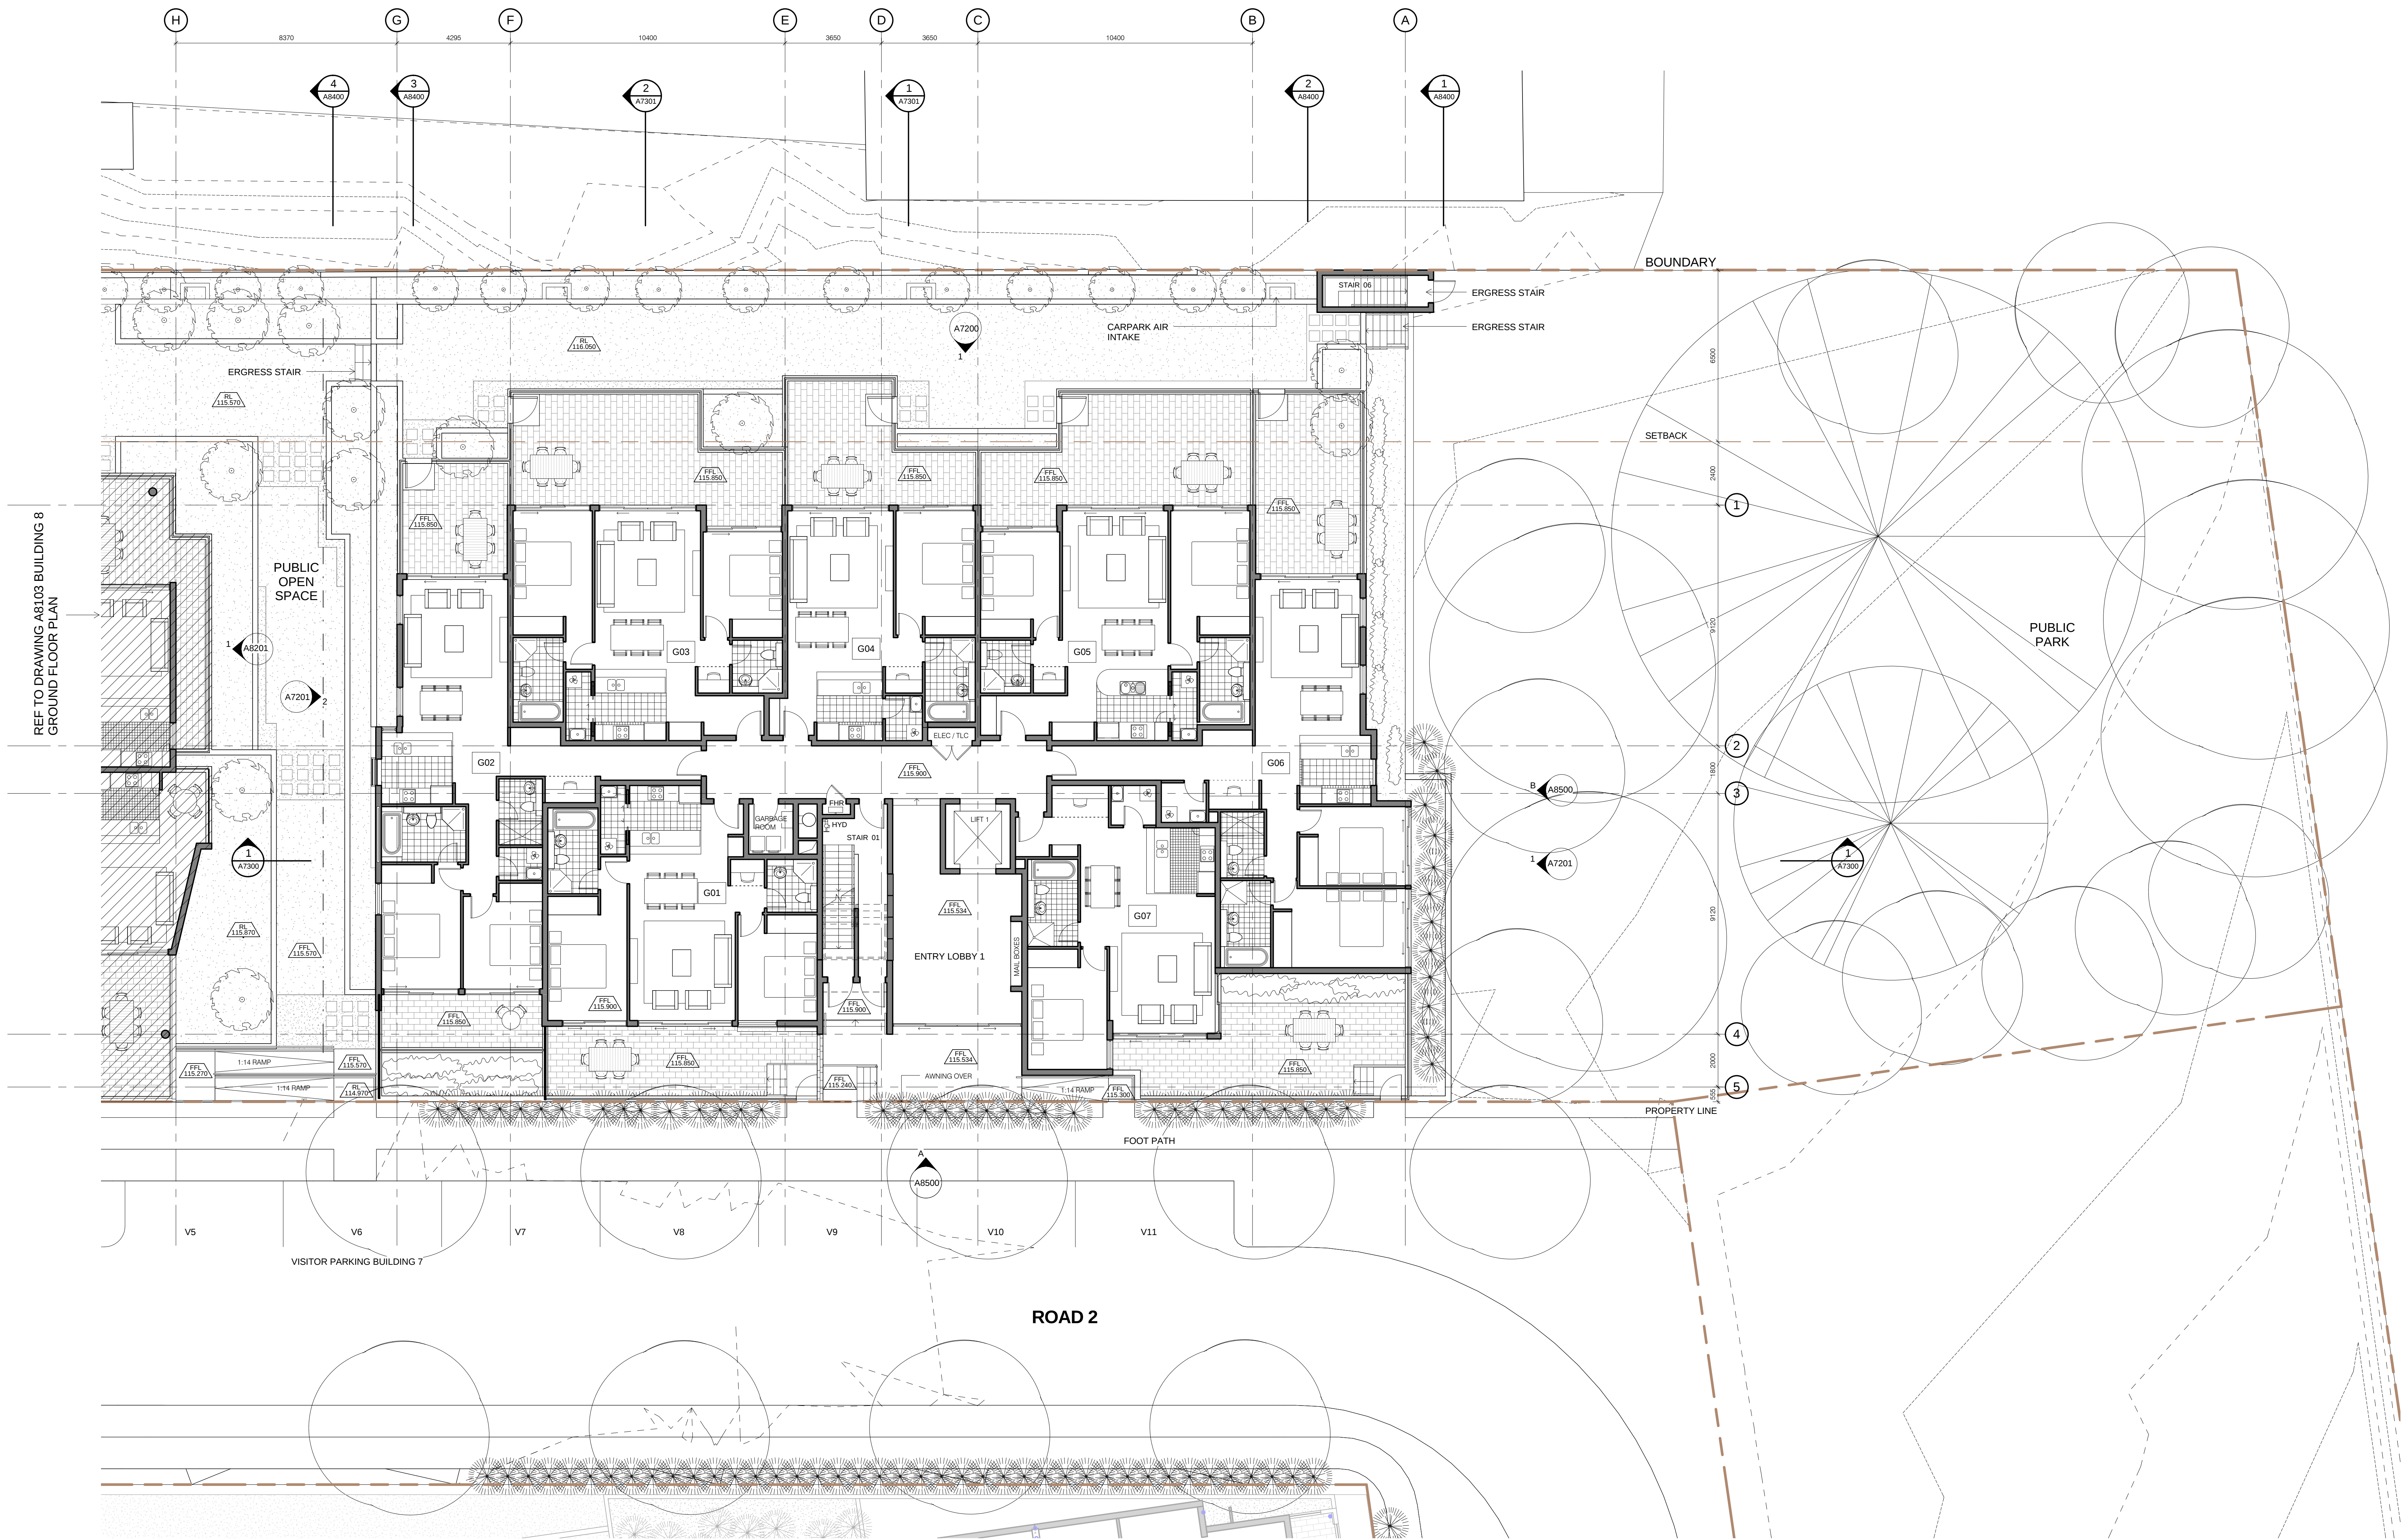

KEY

- FHR FIRE HOSE REEL
HYD FIRE HYDRANT
TLC TELECOM CUPBOARD
ELEC ELECTRICAL CUPBOARD

1 BUILDING 7 GROUND FLOOR PLAN
1:100

NOTE:

1. Furniture layout shown indicative only.
2. Site and Landscape shown for context only. Refer to Landscape Drawings .

Revision	Revision	Revision	Key Plan	Consultants	Client	Architect	Drawing	Project				
PROJECT APPLICATION PROJECT APPLICATION RE-ISSUE	13.12.2010 05.04.2011			Landscape Architects Daylight/Solar Access Traffic Nathers/Bask Acoustic	Sturt Associates Heggies Transport and Traffic Planning Associates Efficient Living Acoustic Logic	Suite 91, Level 5, 330 Wattle Street, Ultimo NSW 2007 2 Lincon Street, Lane Cove NSW 2066 Suite 603, Level 6, 282 Victoria Avenue, Chatswood NSW 2067 24B/176 South Creek Road, Cromer NSW 2099 9 Sarah Street, Mascot NSW 2020	Tel: 9211 3744 Tel: 9427 8100 Tel: 9411 5660 Tel: 9944 0332 Tel: 8338 9888	Meriton Apartments Pty Ltd Level 11, 528 Kent Street Sydney NSW Australia 2000 T (02) 92872888 F (02) 92872777 www.meriton.com.au	PTW Architects Level 17, 9 Castlereagh St Sydney NSW Australia 2000 T 612 9232 5877 F 612 9221 4139 www.ptw.com.au	PTW Title Building 7 Ground Floor Plan 1:100 @ A0	PROJ NO: 209 001 SCALE: 1:100 @A0 DATE: 10/2010 APPROVED: PSC	Epping Park 61 Mollies Lane, Epping Stage 1 (Building 7-8) A7101 PROJECT APPLICATION