



○ SOUTH ELEVATION
1:200

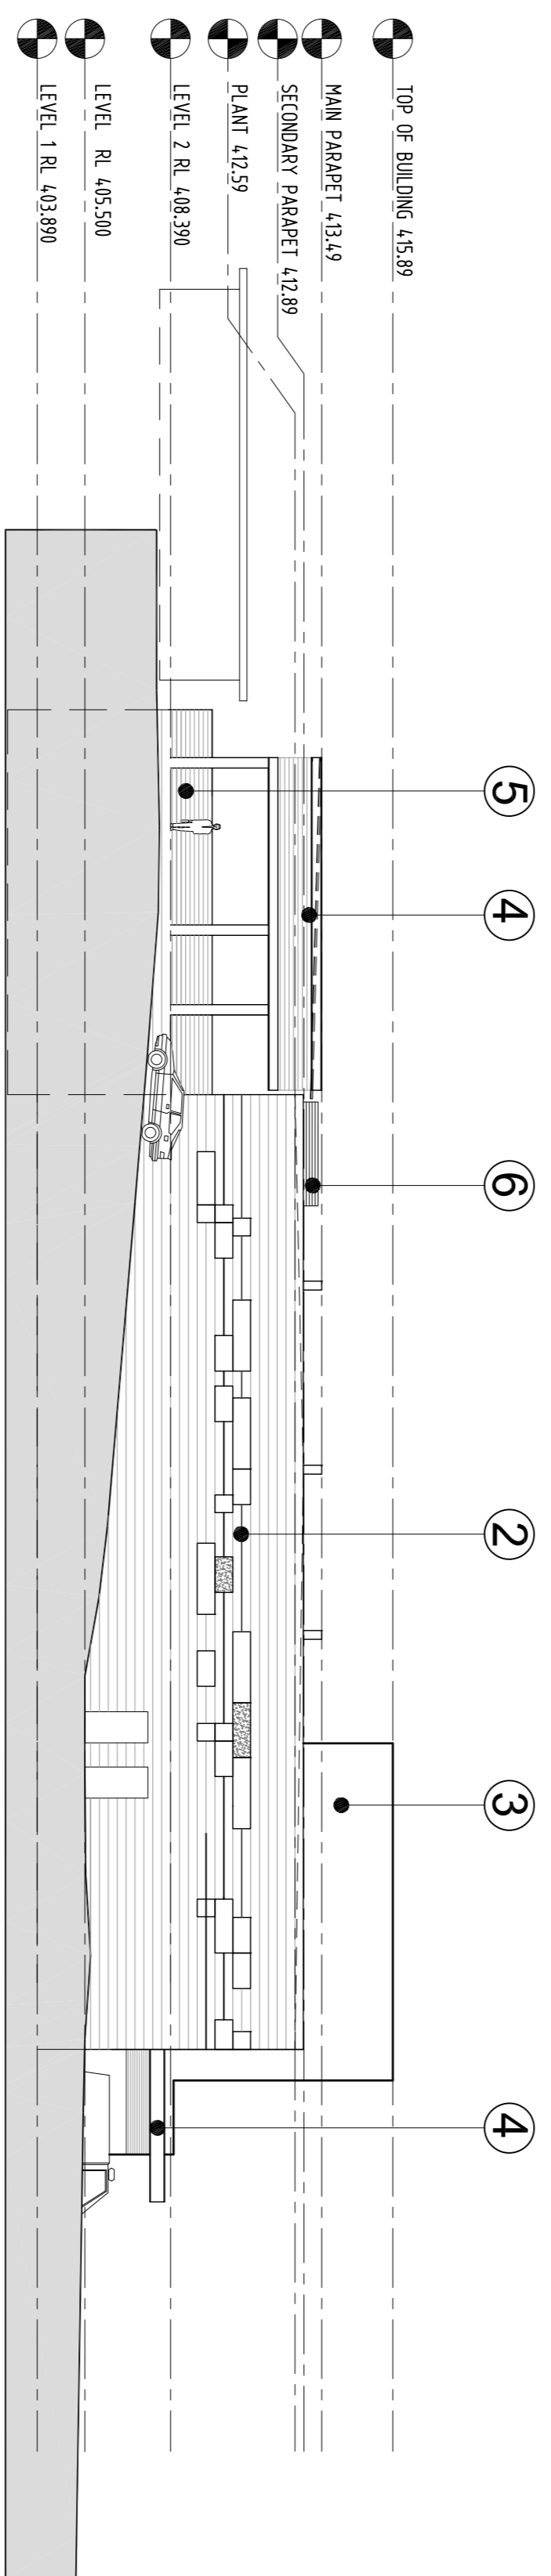

○ WEST ELEVATION
1:200

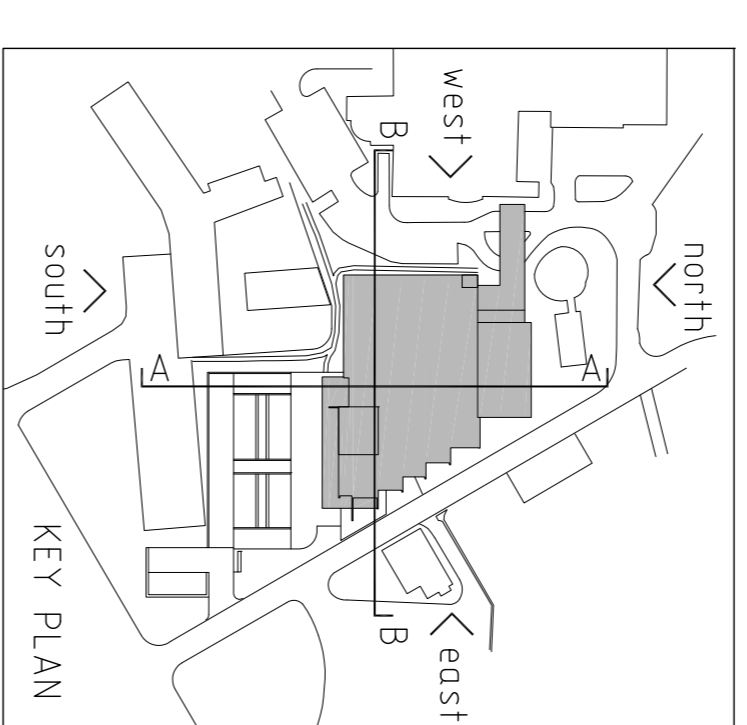

- ① full height glazing + glass spandrel
- ② TYPE A panel and aluminium framed strip windows
- ③ TYPE B panel and aluminium framed window infill
- ④ steel structure awning
- ⑤ off-form concrete (applied texture finish)
- ⑥ mechanical plant room louvre wall
- ⑦ Translucent fibreglass cladding to exterior handrails and awning bulkheads

rev	date	by	description
01	12.11.10 DJM	PART 3A TEST FOR ADEQUACY	
02	19.11.10 DJM	PART 3A TEST FOR ADEQUACY	

HUNTER NEW ENGLAND
NSW HEALTH

THE NEW ENGLAND NORTH WEST
REGIONAL CANCER CENTRE
(NENW RCC) AT TAMMORTH

NSW GOVERNMENT
HEALTH INFRASTRUCTURE
NSW HEALTH
projects
SPECIALIST LEADERS AND MANAGERS

TITLE:
ELEVATIONS & SECTIONS

SCALE:
1 : 200

DATE:
12. Nov. 2010

LEVEL 3, 73 YORK STREET
SYDNEY NSW 2000
AUSTRALIA

T. +61 2 8299 4600
F. +61 2 8299 4646
E. shh@silverthomas.com.au
W. www.sth.com.au

DRG No:
DOP 11

REVISION:
02

© Copyright Silver Thomas Hanley Pty Ltd. All rights reserved. This drawing is the property of Silver Thomas Hanley Pty Ltd. It is to be used only for the project and site for which it was prepared. It is not to be used for any other project or site without the written consent of Silver Thomas Hanley Pty Ltd. Any use of this drawing for any other project or site is strictly prohibited. Any use of this drawing for any other project or site is strictly prohibited. Any use of this drawing for any other project or site is strictly prohibited.