

LEGEND	
	SITE BOUNDARY
	BUILDING AWNING LINE

SOFTWORKS	
	EXISTING TREE TO BE RETAINED AND PROTECTED
	PROPOSED TREE
	MASS PLANTING
	TREE TO BE REMOVED
	TURF

PAVING	
	CONCRETE PAVING TYPE A
	CONCRETE PAVING TYPE B
	CONCRETE PAVING TYPE C
	ASPHALT
	ASPHALT-MULTI PURPOSE COURT
	PLAY MULCH SOFTFALL
	RUBBER SOFTFALL
	UNIT PAVERS
	SAND
	DECK
	ARTIFICIAL TURF
	NATURE PLAY MULCH 150MM DEPTH

EDGES	
	CONCRETE EDGE
	SPADE EDGE
	TIMBER EDGE

WALLS AND SCREENS(Refer to Engineer's Documentation)	
	BLOCKWORK WALL
	BLOCKWORK WALL SANDSTONE CLAD
	SANDSTONE WALL
	MECHANICAL PLANT SCREEN
	BIN STORAGE SCREEN


STAIRS AND SEATING STEPS	
	CONCRETE STAIRS
	TIMBER STAIRS
	CONCRETE SEATING STEPS
	TIMBER SEATING STEPS

FURNITURE	
	SEAT
	BENCH
	BENCH - WALLMOUNT
	PLATFORM SEAT
	TABLE SETTING
	BIN COMBO - 240L
	BIN COMBO - 120L
	BIKE PARKING HOOP
	BOLLARD - REMOVABLE
	DRINKING FOUNTAIN
	RAISED PLANTERS-PRODUCTIVE GARDEN
	WATER TANK-PRODUCTIVE GARDEN
	POTTING TABLE WITH SINK
	GARDEN SHED
	BALUSTRADE
	HANDRAIL
	TACTILES (TGS)
	STAIRS NOSING NOSING
	UMBRELLA
	VOLLEYBALL NET
	VOLLEYBALL POST
	TENNIS NET
	TENNIS WINDER
	NETBALL RING
	BASKETBALL TOWER AND RING
	SANDSTONE BLOCKS LARGE
	SANDSTONE BLOCKS SMALL
	MODULAR BLACK SEAT
	TIMBER PLATFORM
	'CHUCKLE' SEAT
	CONCRETE PLATFORM

PLAY EQUIPMENT	
	GIANT TUNNEL SYSTEM
	STREET CLIMBER SYSTEM
	EMBANKMENT SLIDE
	TIMBER STEPPING LOGS
	TIMBER POSTS
	TEEPEE
	SYMPHONY TUBES
	VOICE TUBES
	MIRROR
	GONG DRUMS
	RAIN WHEEL
	SAND PIPES
	BLACKBOARD



Amendments	Issue Description	Date
A	ADDITIONAL SECTIONS	27/03/2020
B	REVISED ADDITIONAL SECTIONS	31/03/2020

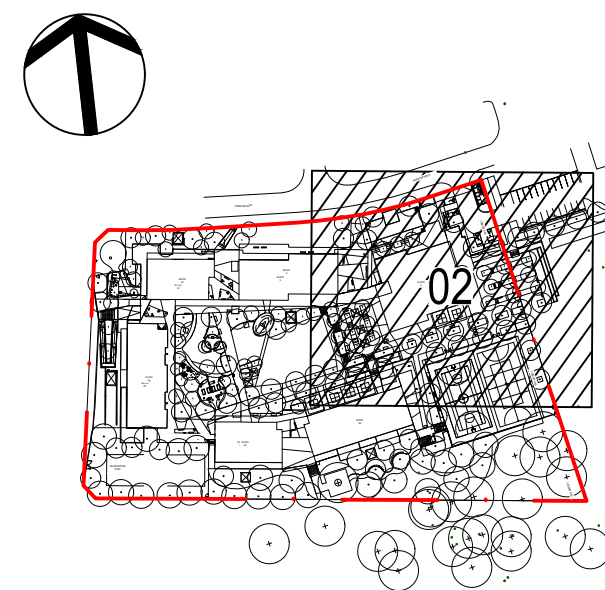

Contractor
RICHARD CROOKES
CONSTRUCTIONS
Client

NSW Education

GROUP GSA

Group GSA Pty Ltd ABN 76 002 113 779
Level 7, 80 William St East Sydney NSW
Australia 2011 www.groupgsa.com


T +612 9361 4144 F +612 9332 3458
architecture interior design urban design landscape
nom architect M. Sheldon 3990

Project Title
**ALEX AVENUE
PUBLIC SCHOOL**


Drawing Title
ADDITIONAL SECTIONS

Scale	1:200 @A1
Drawing created (date)	27/03/2020
By	ZM
Plotted and checked by	ZM
Verified	FR
Approved	FR
Drawing No	180645
Issue	B
File	L-9000
Plot Date	
SFILES	SDATES


This drawing is the copyright of Group GSA Pty Ltd and may not be altered, reproduced or transmitted in any form or by any means in part or in whole without the written permission of Group GSA Pty Ltd. All levels and dimensions are to be checked and verified on site prior to the commencement of any work, making of shop drawings or fabrication of components. Do not scale drawings. Use figured Dimensions.

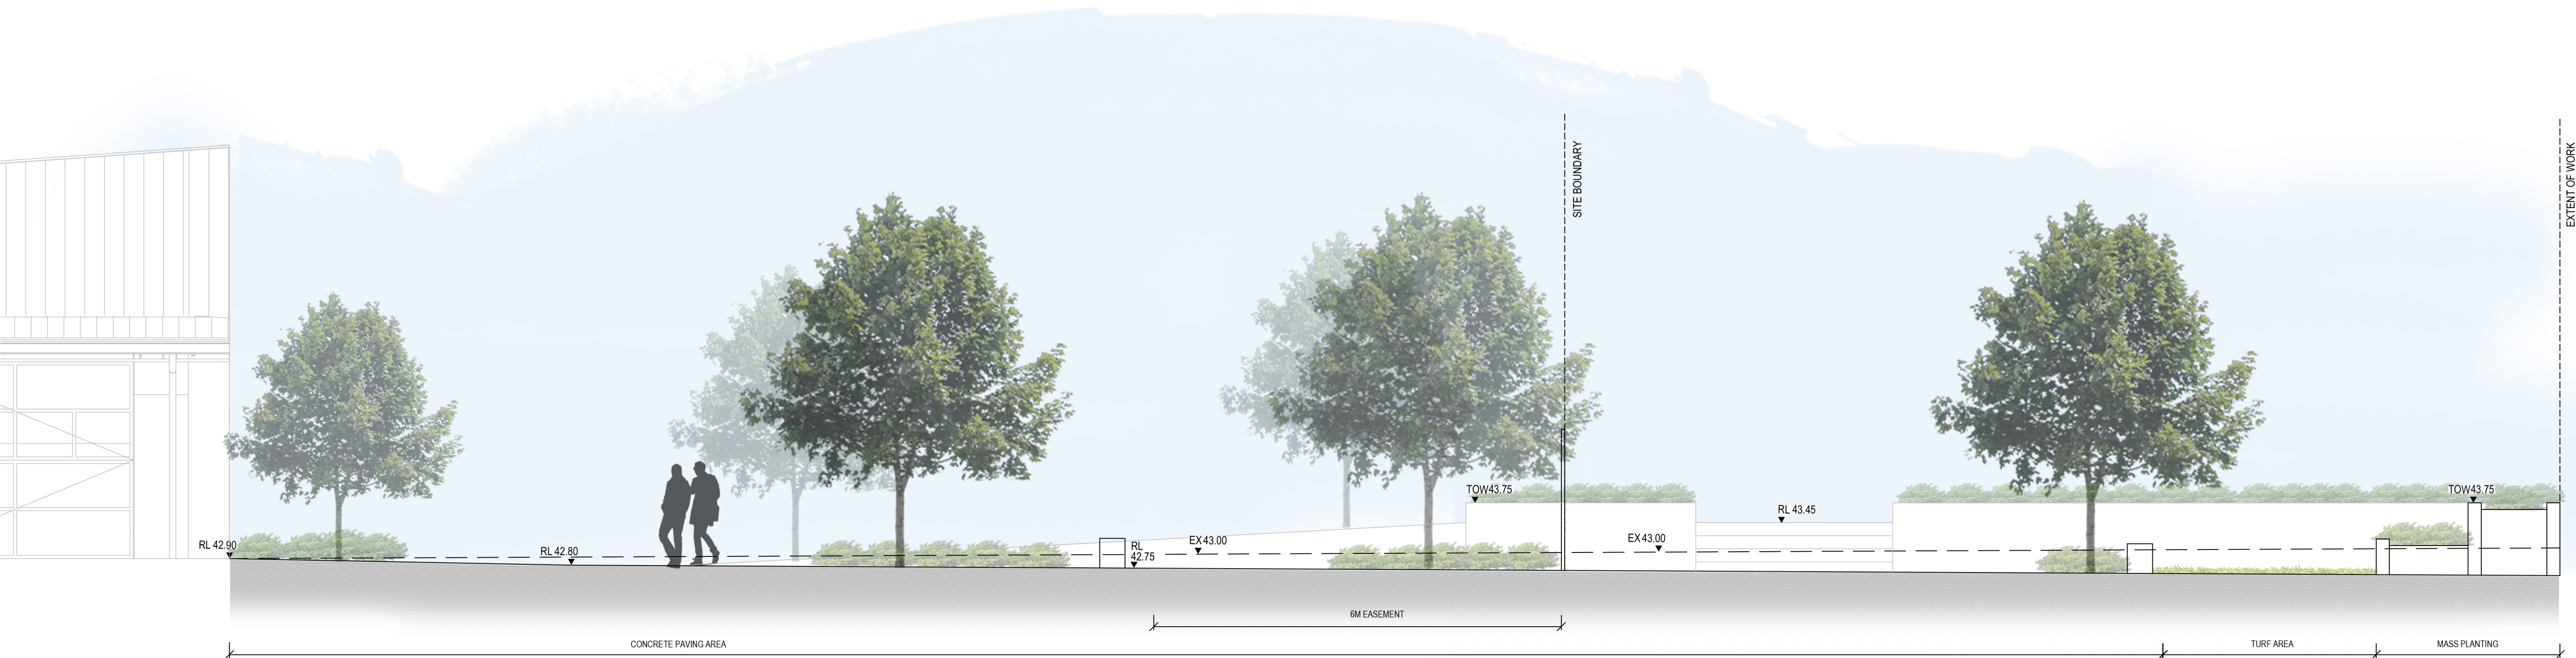


01 SECTION 1 : ENTRY PLAZA (SCENARIO 1)
9001 1:50 SECTION

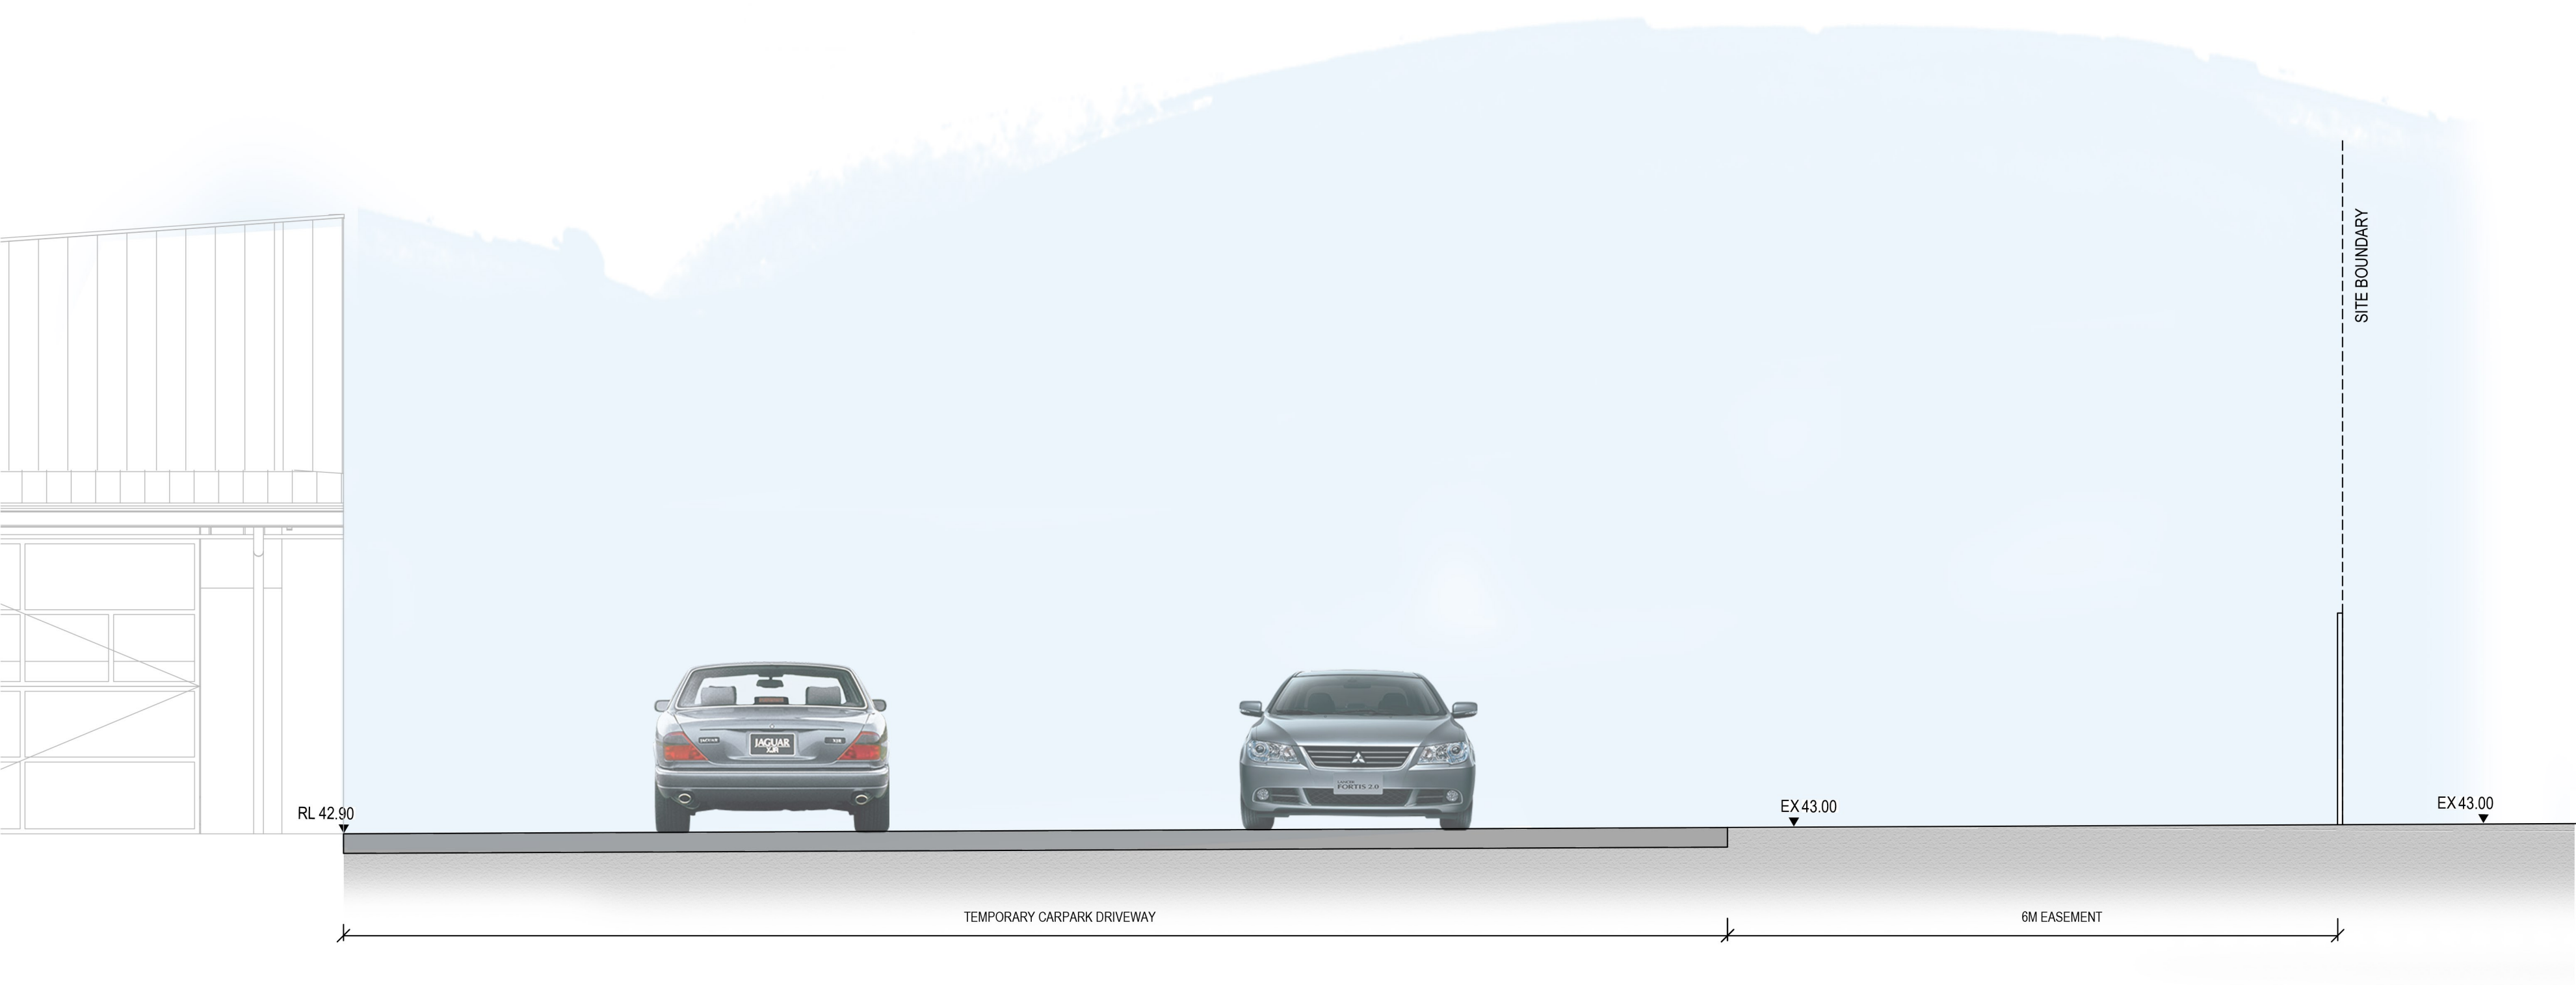


02 SECTION 2 : TEMPORARY CARPARK DRIVEWAY (SCENARIO 2)
9001 1:50 SECTION

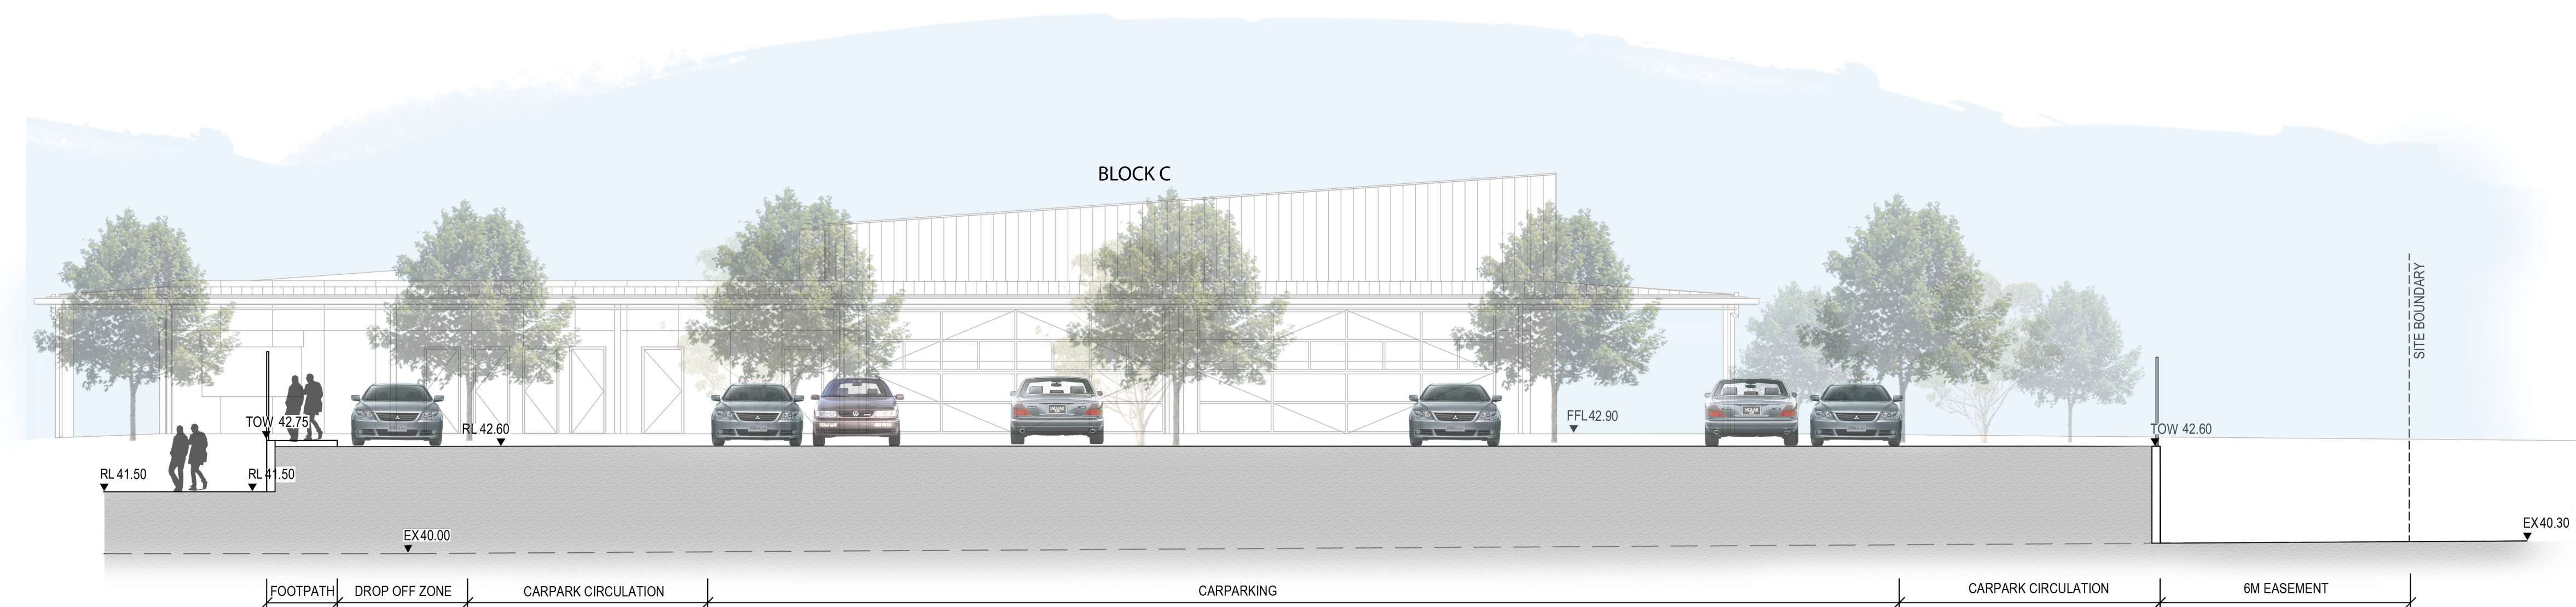

03 SECTION 3 : TEMPORARY CARPARK (SCENARIO 2)
9002 1:100 SECTION

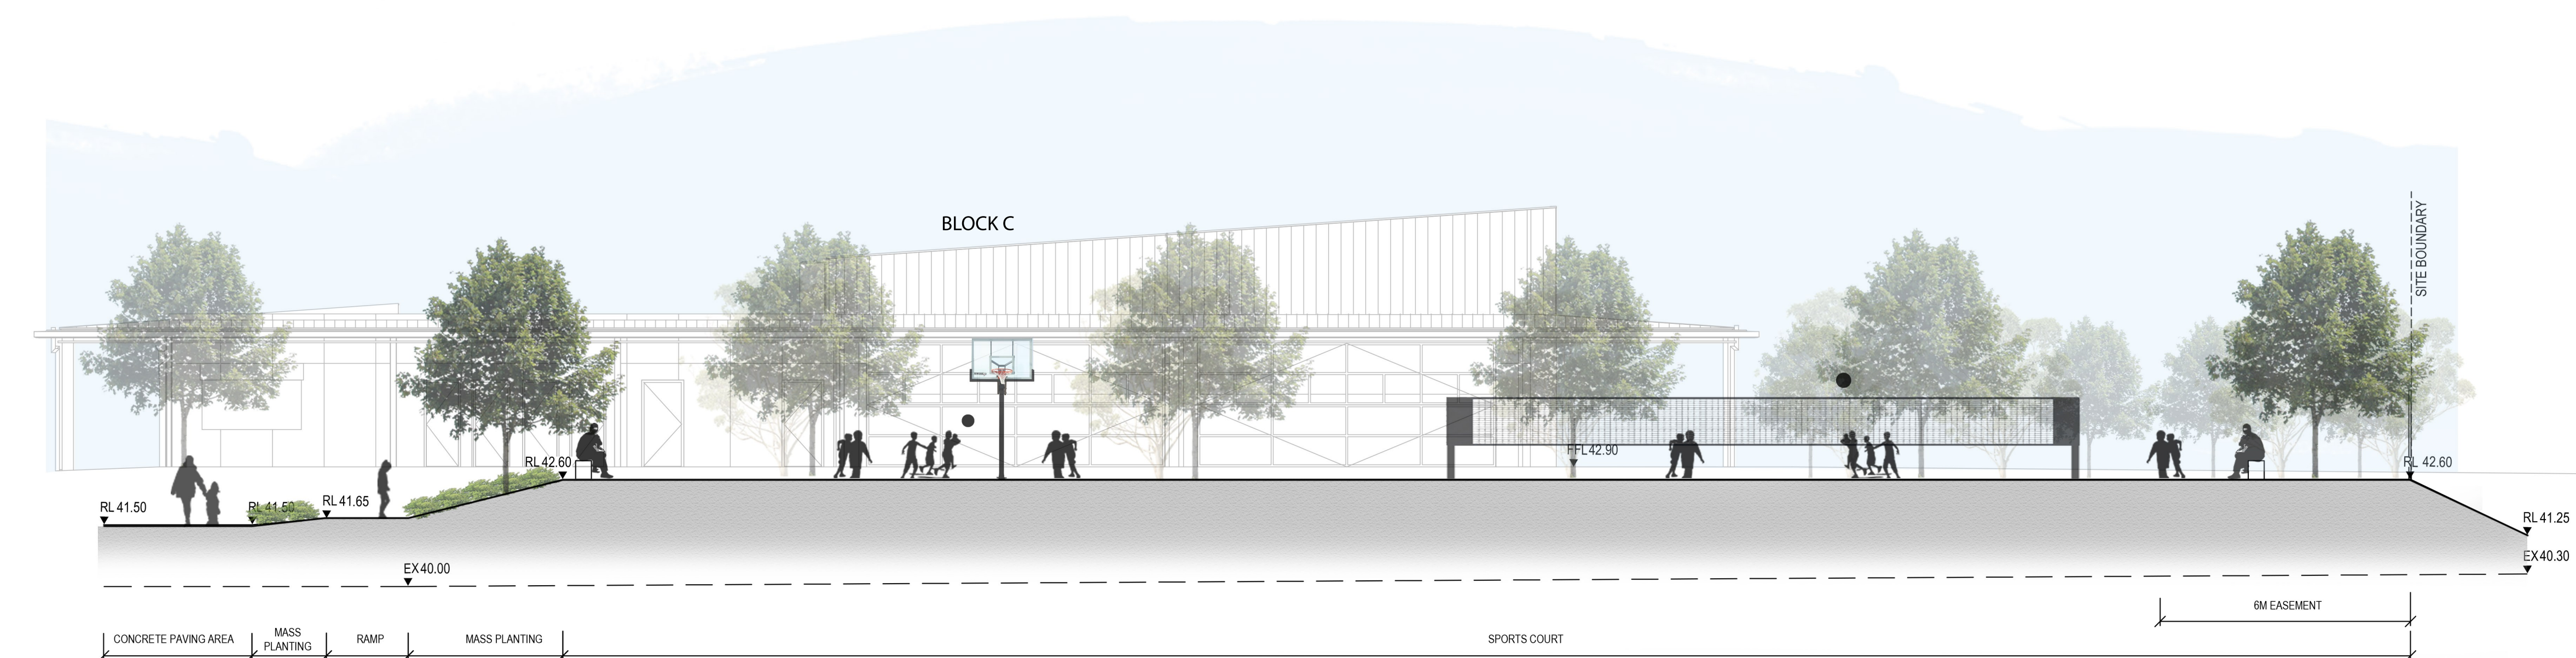

04 SECTION 4 : SPORTS COURTS (SCENARIO 1)
9002 1:100 SECTION

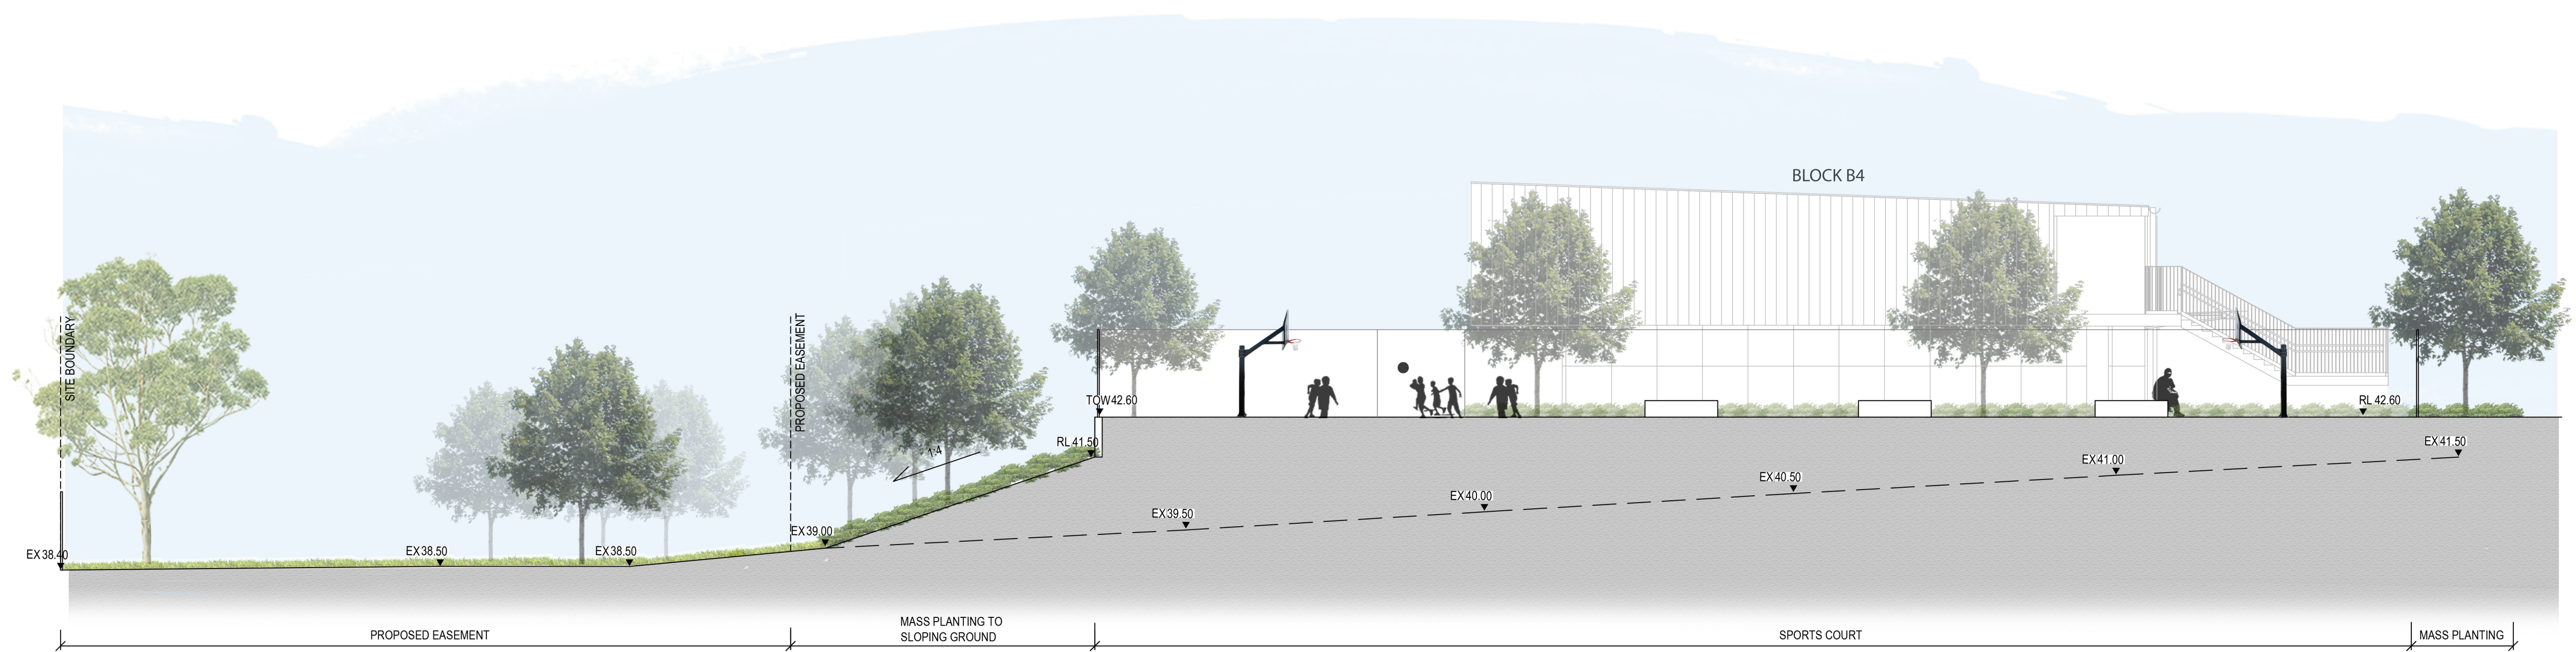

05 SECTION 5 : SPORTS COURTS
9003 1 : 100 SECTION