

MULGOA TEMPORARY SCHOOL  
NEW PRIMARY SCHOOL IN MULGOA RISE

1-23 Forestwood Drive, Glenmore Park, NSW 2745



NBRS DRAWING LIST SSDA

DRAWING NUMBER SHEET NAME

|                           |                                        |
|---------------------------|----------------------------------------|
| 20415-NBRS-DR-A-SSDA-0001 | COVER                                  |
| 20415-NBRS-DR-A-SSDA-0003 | SHADOW DIAGRAMS                        |
| 20415-NBRS-DR-A-SSDA-0101 | SITE SURVEY                            |
| 20415-NBRS-DR-A-SSDA-0102 | SITE ANALYSIS                          |
| 20415-NBRS-DR-A-SSDA-0110 | SITE PLAN                              |
| 20415-NBRS-DR-A-SSDA-0113 | SITE ACCESS AND SECURITY PLAN          |
| 20415-NBRS-DR-A-SSDA-0115 | SITE SECTIONS                          |
| 20415-NBRS-DR-A-SSDA-0120 | PUBLIC DOMAIN SCOPE OF WORKS           |
| 20415-NBRS-DR-A-SSDA-0999 | CAR PARK PLAN                          |
| 20415-NBRS-DR-A-SSDA-1000 | OVERALL GROUND FLOOR PLAN              |
| 20415-NBRS-DR-A-SSDA-1001 | OVERALL L1 PLAN                        |
| 20415-NBRS-DR-A-SSDA-1002 | OVERALL ROOF PLAN                      |
| 20415-NBRS-DR-A-SSDA-1003 | GROUND FLOOR PLAN TEMPORARY SCHOOL MOD |
| 20415-NBRS-DR-A-SSDA-1004 | ROOF PLAN TEMPORARY SCHOOL MOD         |
| 20415-NBRS-DR-A-SSDA-1011 | BLOCK A - GF PLAN                      |
| 20415-NBRS-DR-A-SSDA-1012 | BLOCK B3 - GF PLAN                     |
| 20415-NBRS-DR-A-SSDA-1013 | BLOCK B2 - GF PLAN                     |
| 20415-NBRS-DR-A-SSDA-1014 | BLOCK C - GF PLAN                      |
| 20415-NBRS-DR-A-SSDA-1021 | BLOCK A - LEVEL 1 PLAN                 |
| 20415-NBRS-DR-A-SSDA-1022 | BLOCK B3 - LEVEL 1 PLAN                |
| 20415-NBRS-DR-A-SSDA-1023 | BLOCK B2 - LEVEL 1 PLAN                |
| 20415-NBRS-DR-A-SSDA-3010 | SITE ELEVATIONS                        |
| 20415-NBRS-DR-A-SSDA-3011 | BUILDING A - ELEVATIONS                |
| 20415-NBRS-DR-A-SSDA-3012 | BUILDING B3 - ELEVATIONS               |
| 20415-NBRS-DR-A-SSDA-3013 | BUILDING B2 - ELEVATIONS               |
| 20415-NBRS-DR-A-SSDA-3014 | BUILDING C - ELEVATIONS                |
| 20415-NBRS-DR-A-SSDA-3015 | ELEVATIONS TEMPORARY SCHOOL MOD        |
| 20415-NBRS-DR-A-SSDA-4001 | BUILDING A - SECTIONS                  |
| 20415-NBRS-DR-A-SSDA-4002 | BUILDING - SECTIONS                    |
| 20415-NBRS-DR-A-SSDA-4003 | BUILDING - DETAIL SECTIONS             |
| 20415-NBRS-DR-A-SSDA-4004 | SECTIONS TEMPORARY SCHOOL MOD          |
| 20415-NBRS-DR-A-SSDA-7001 | 3D IMAGE 1                             |
| 20415-NBRS-DR-A-SSDA-7002 | 3D IMAGE 2                             |
| 20415-NBRS-DR-A-SSDA-7003 | 3D IMAGE 3                             |
| 20415-NBRS-DR-A-SSDA-7004 | 3D IMAGE 4                             |
| 20415-NBRS-DR-A-SSDA-7005 | 3D IMAGE 5 MOD                         |
| 20415-NBRS-DR-A-SSDA-7010 | SIGNAGE                                |
| 20415-NBRS-DR-A-SSDA-8001 | EXTERNAL FINISHES                      |

| Issue No. | Date       | Description            | Chkd |
|-----------|------------|------------------------|------|
| 01        | 23/04/2021 | ISSUE FOR COORDINATION |      |
| 02        | 04/05/2021 | SSDA ISSUE             | JL   |
| 03        | 06/08/2021 | SSDA ISSUE             | CHS  |
| 04        | 11/11/2021 | SSDA RIS               |      |
| 05        | 04/07/2022 | MOD SSDA               |      |

MOD SSDA

**RICHARD CROOKES**  
CONSTRUCTIONS

**TRAFFIC ENGINEER**  
**PTC**  
KASIA BALSAM  
02 8920 0800  
kasia.balsam@ptcconsultants.co

**TOWN PLANNER**  
**RPS**  
ROB DWYER  
0425 285 778  
rob.dwyer@rpsgroup.com.au

**MULTI SERVICES**  
**NDY**  
RYAN HAHN  
0407 236 908  
r.hahn@ndy.com

**CIVIL AND STRUCTURAL ENGINEERING**  
**WOOLACOTTS**  
JUSTIN CHIRILLO  
02 8203 1504  
jchirillo@woolacotts.com.au

**QUANTITY SURVEYOR**  
**MBM**  
AUTUMN LU  
02 9270 1062  
autumn.lu@mbmpl.com.au

**PROJECT MANAGER**  
**COLLIERS**  
ANTHONY MAUGHAN-WRIGHT  
0424 189 883  
anthony.maughan-wright@colliers.com

Drawing Title  
COVER


Project  
NEW PRIMARY SCHOOL IN MULGOA RISE  
at  
1-23 Forestwood Drive, Glenmore Park, NSW 2745, Australia  
for  
SINSW

Architect  
**NBRSARCHITECTURE.**  
Sydney  
61 2 9922 2344  
Any form of replication of this drawing in full or in part without the written permission of NBRS+PARTNERS Pty Ltd constitutes an infringement of the copyright.  
Nominated Architect:  
Andrew Duffin NSW 5602  
NBRS & Partners Pty Ltd VIC 51197  
nbrsarchitecture.com  
© 2021  
ABN 16 002 247 565


Date 07/07/2022 1:19:54 pm  
Scale NOT TO SCALE

Drawing Reference  
20415-NBRS-DW-AR-SSDA-0001 05


Revision

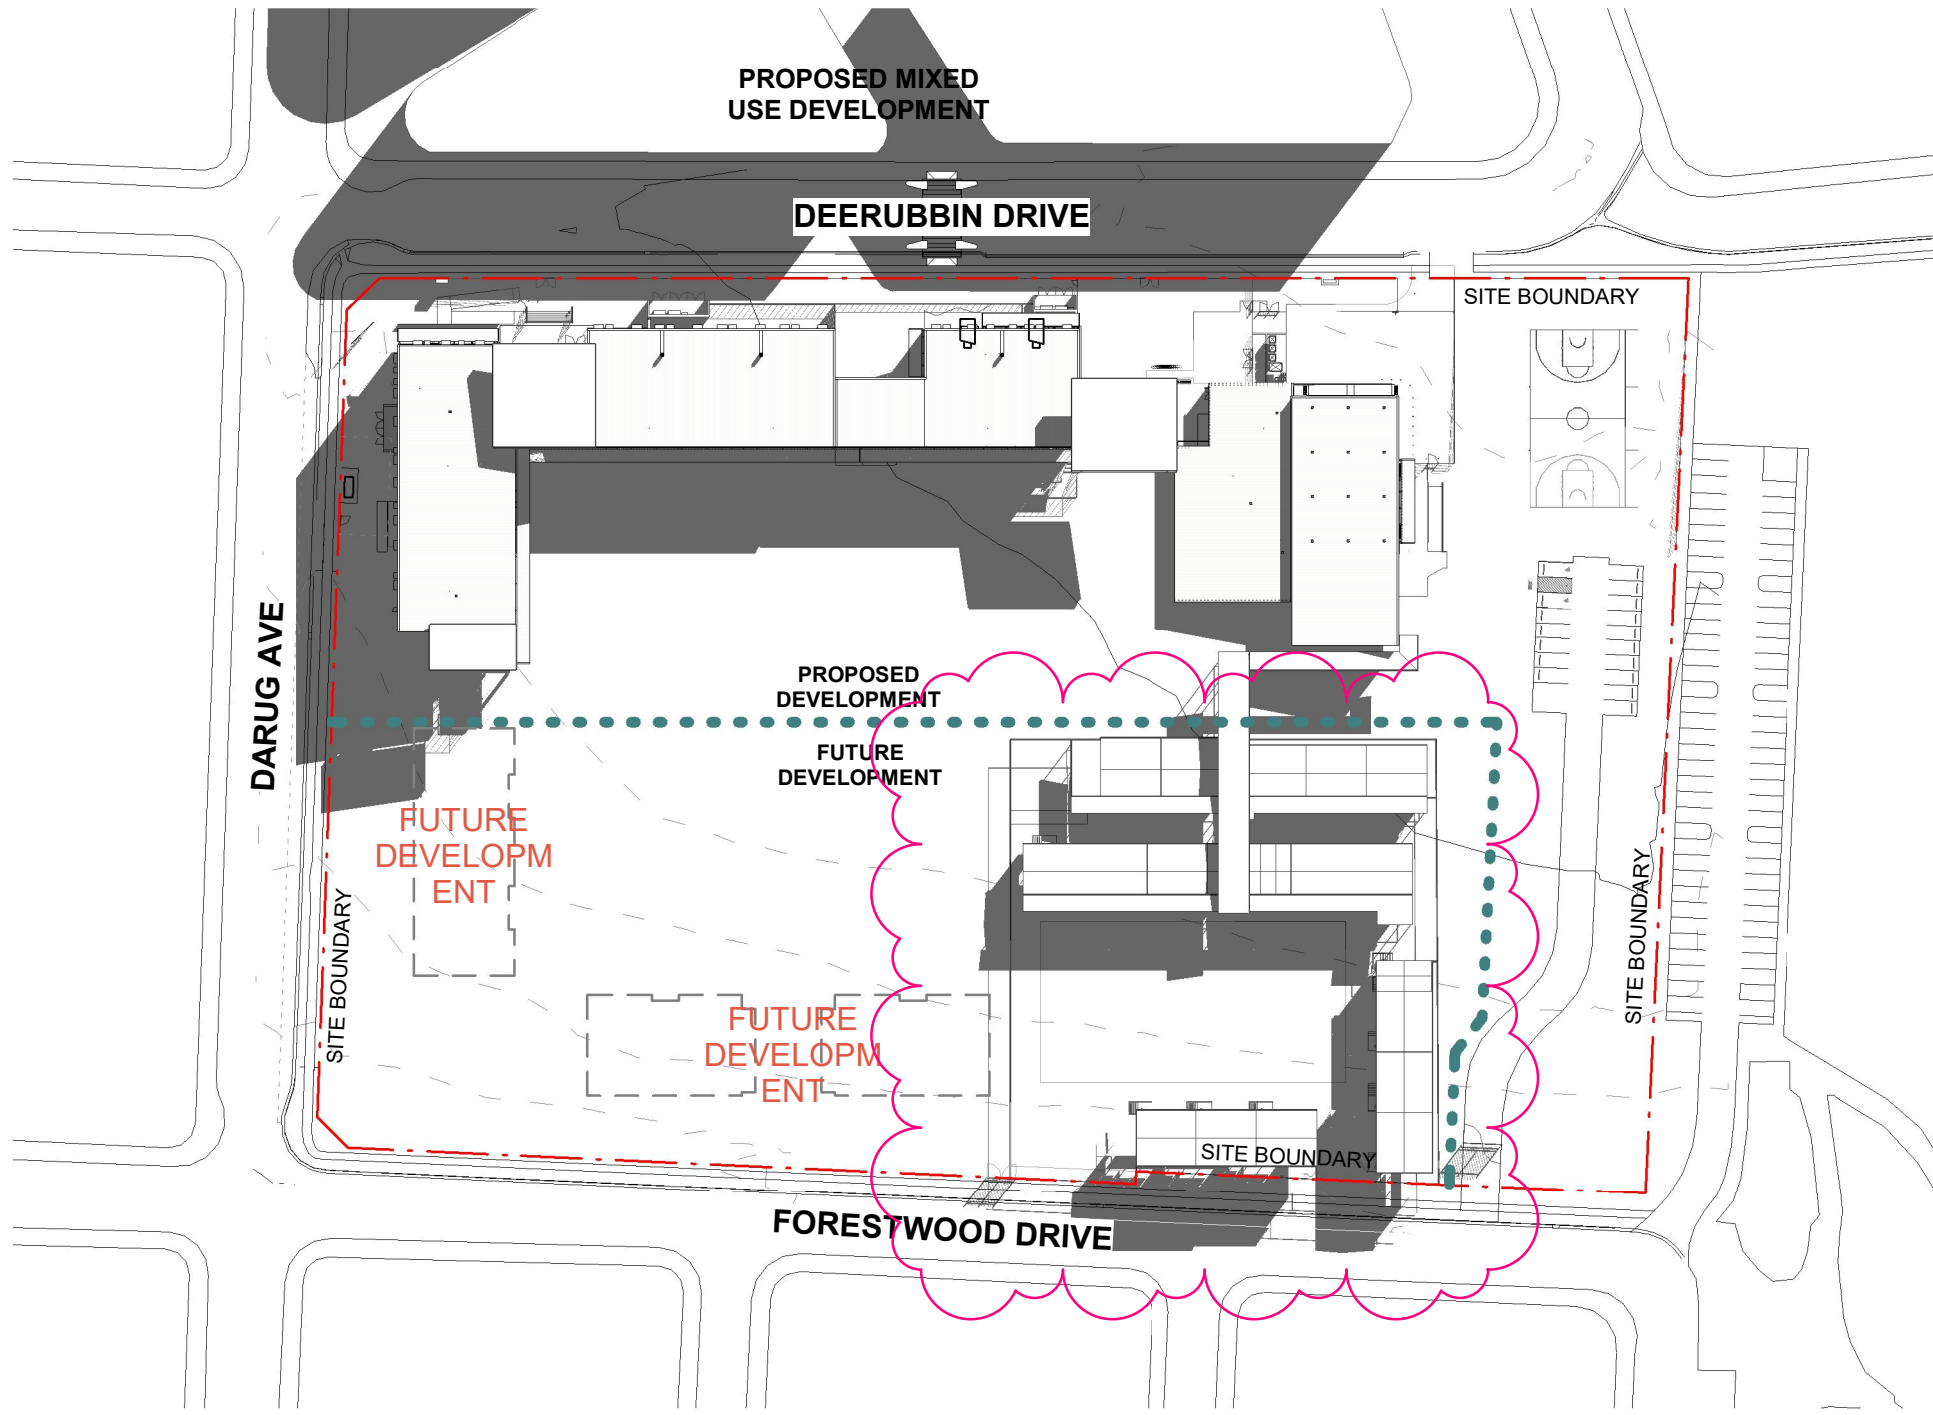


1 SHADOW DIAGRAM JUNE 21 9AM

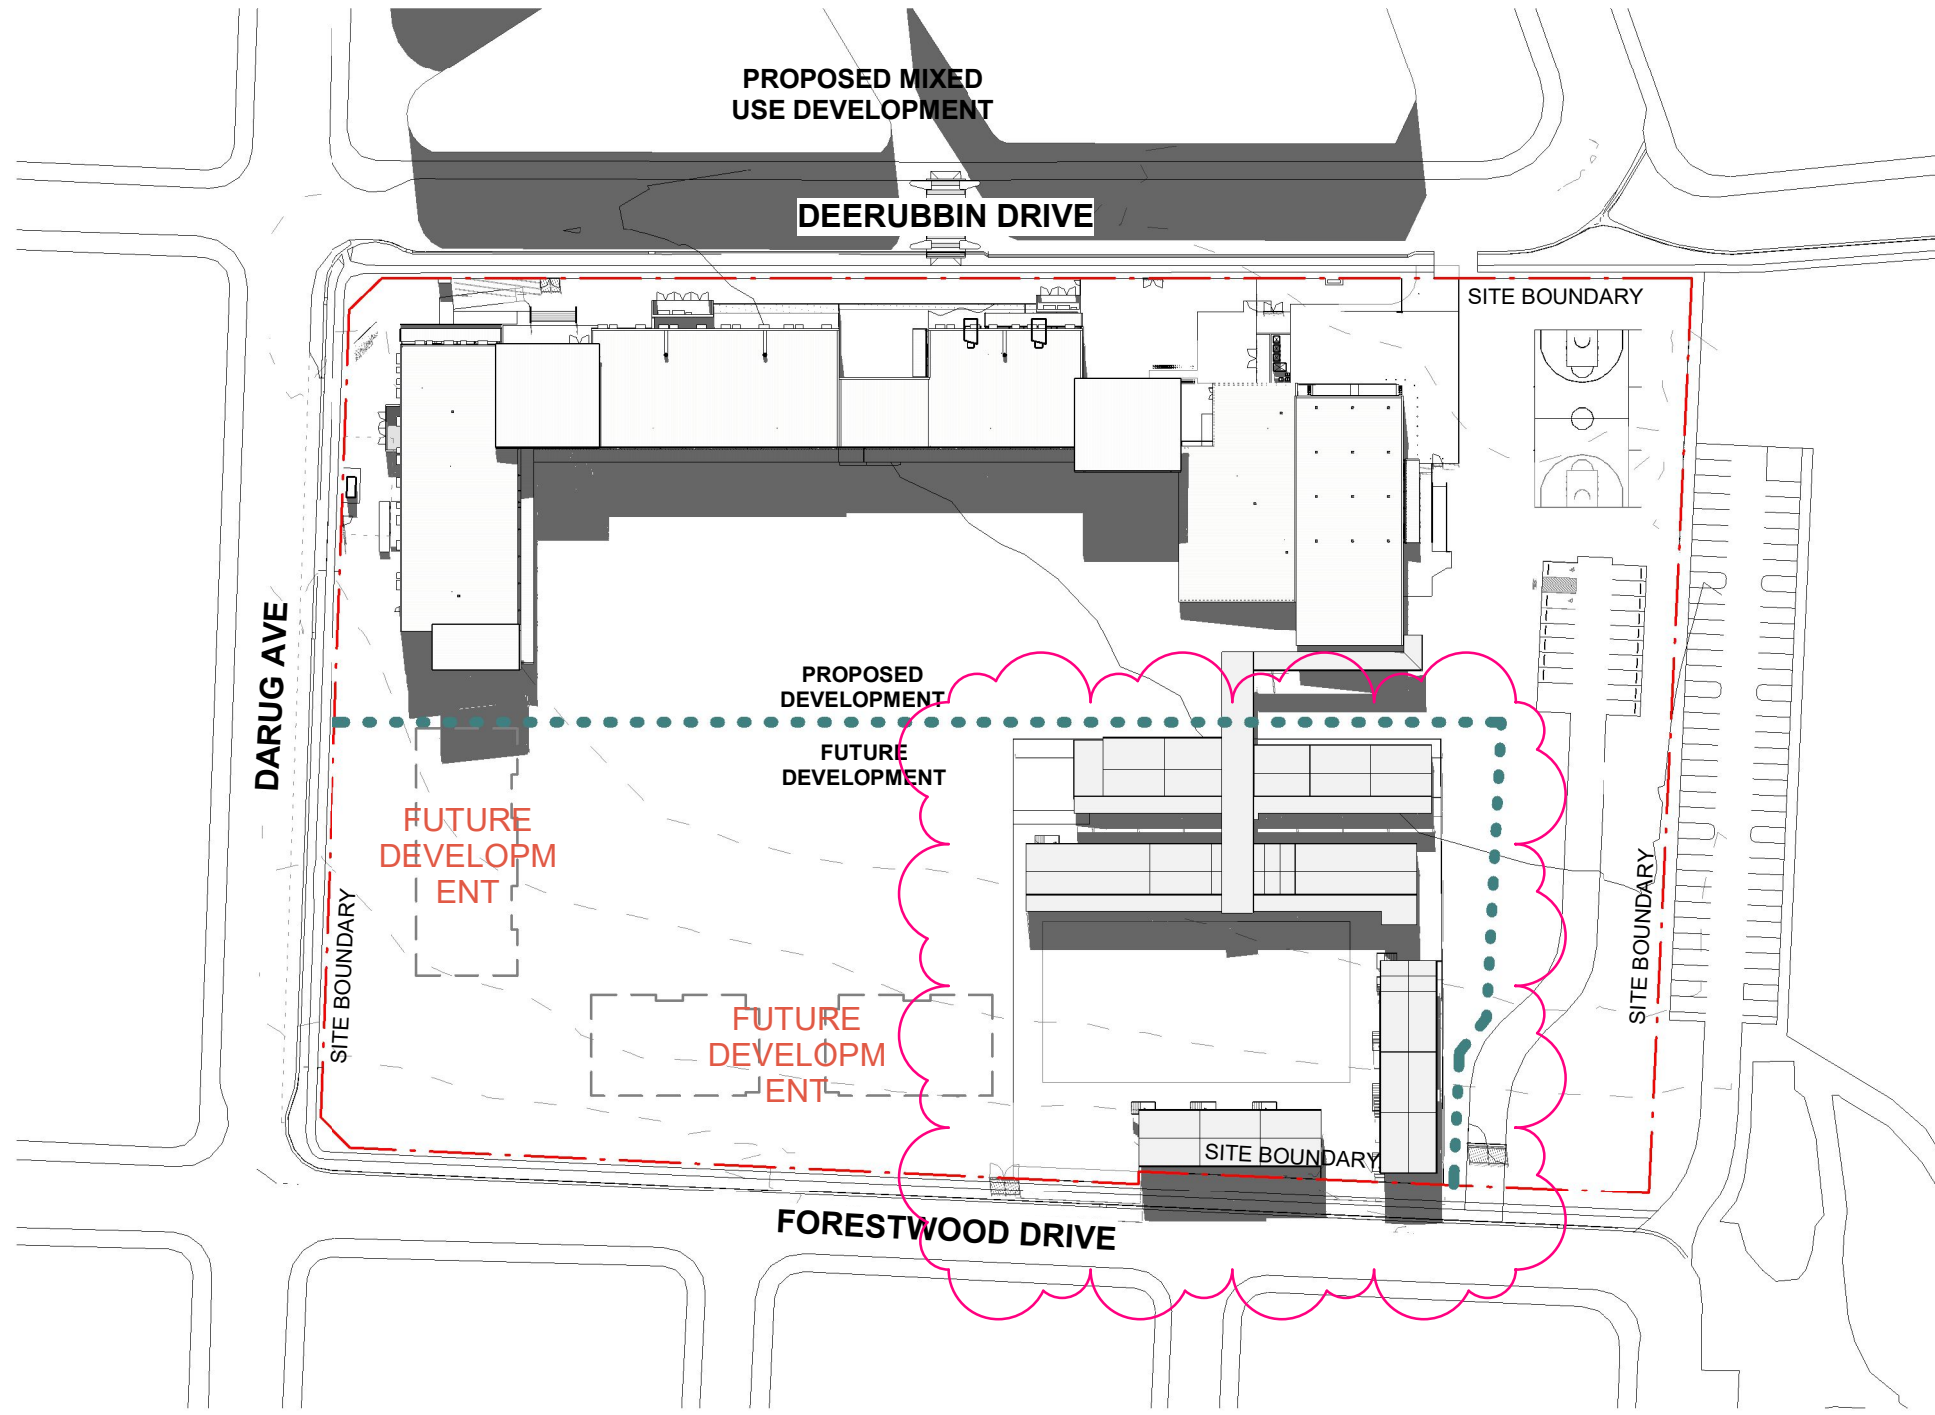


2 SHADOW DIAGRAM JUNE 21 12PM

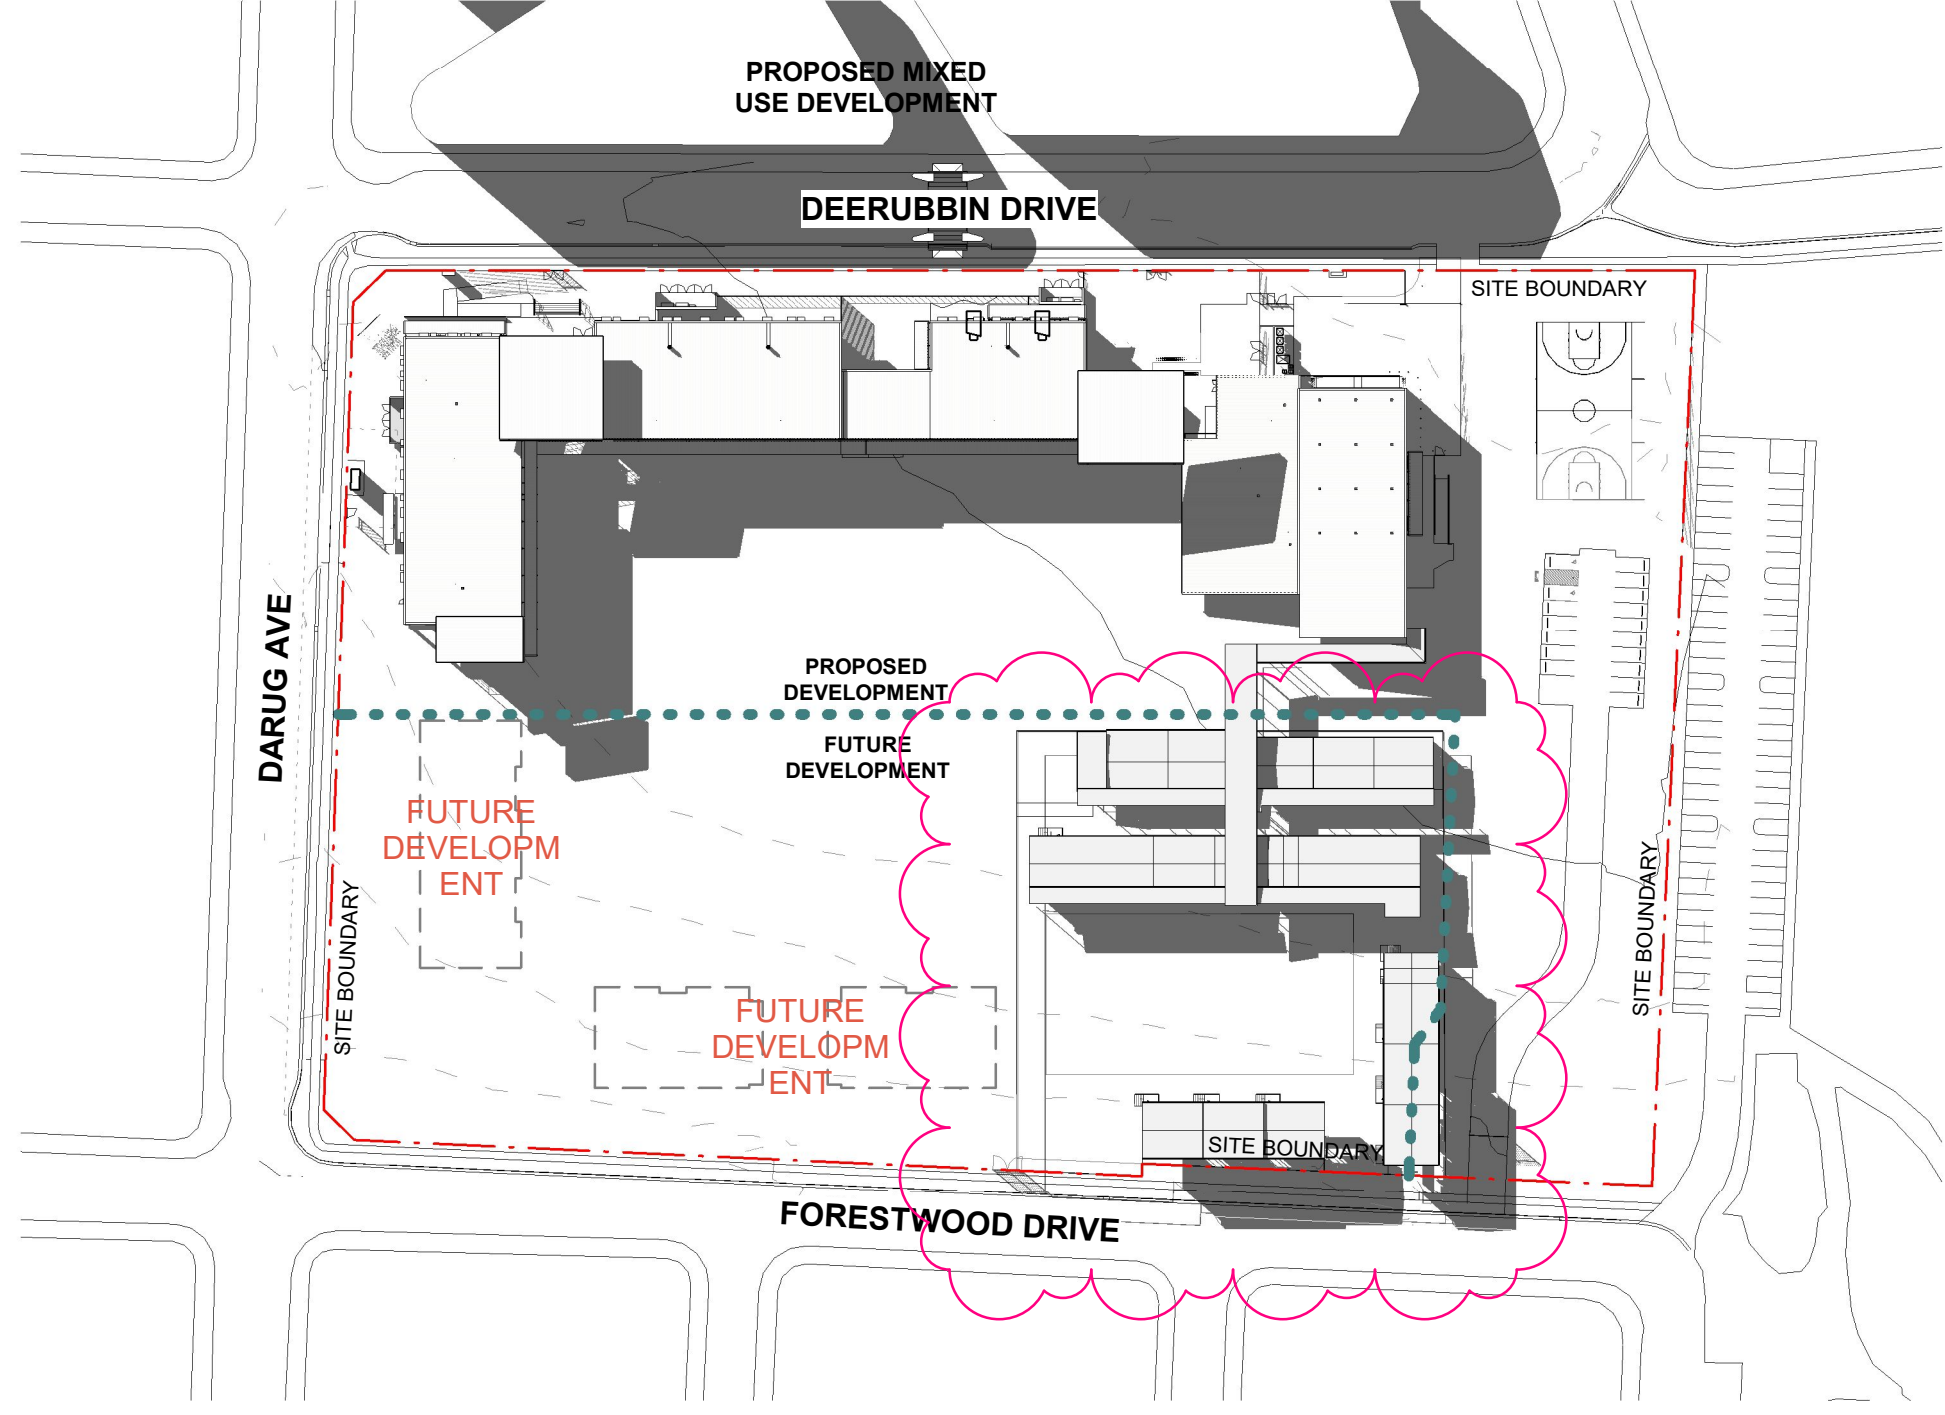


3 SHADOW DIAGRAM JUNE 21 3PM

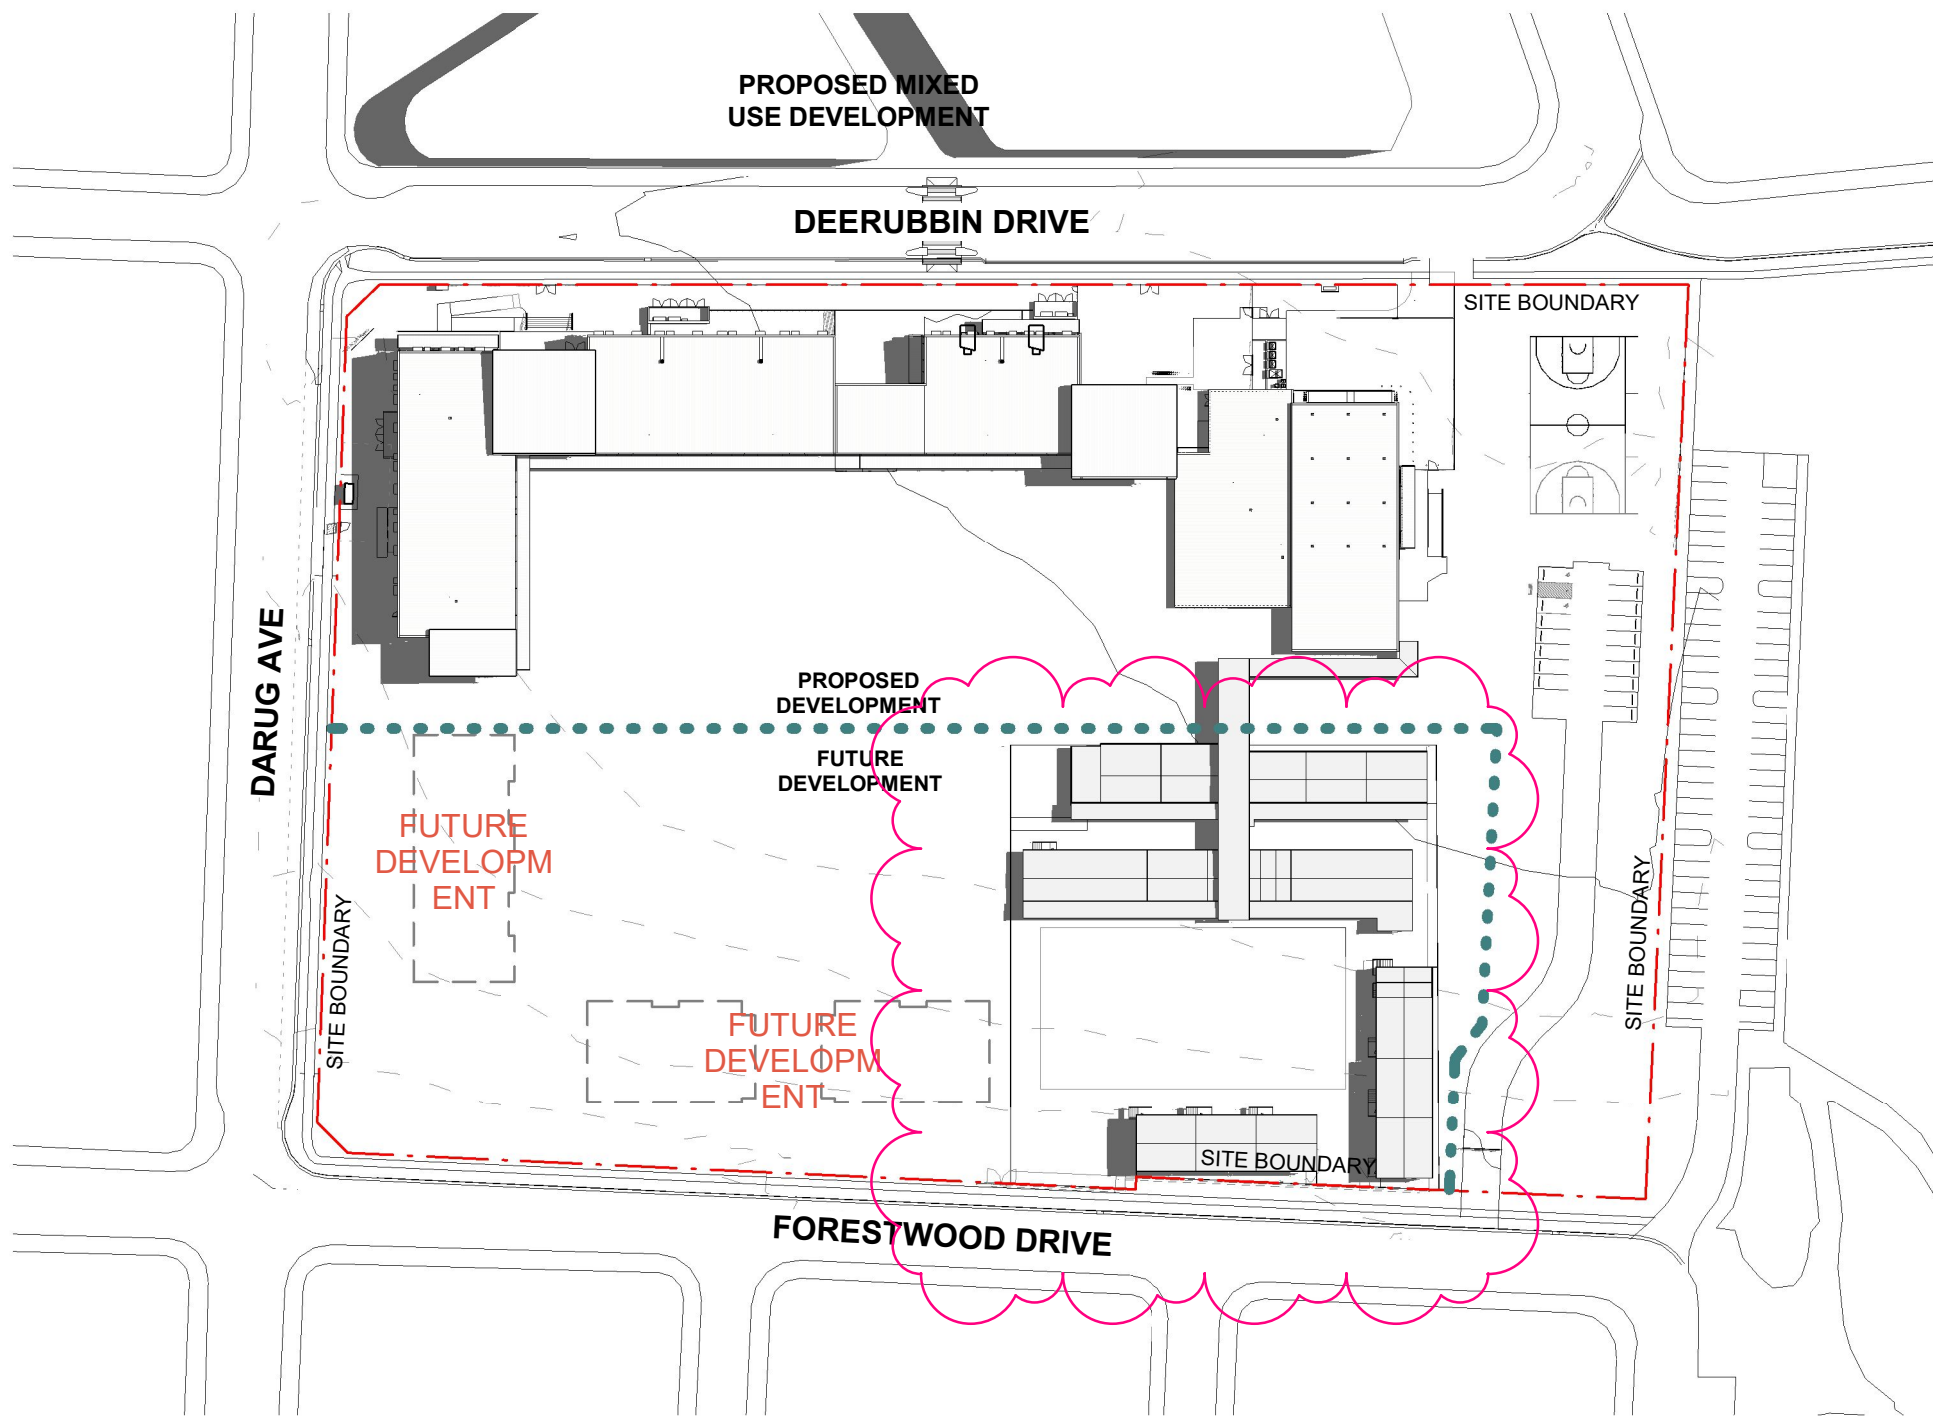

4 SHADOW DIAGRAM DEC 21 9AM

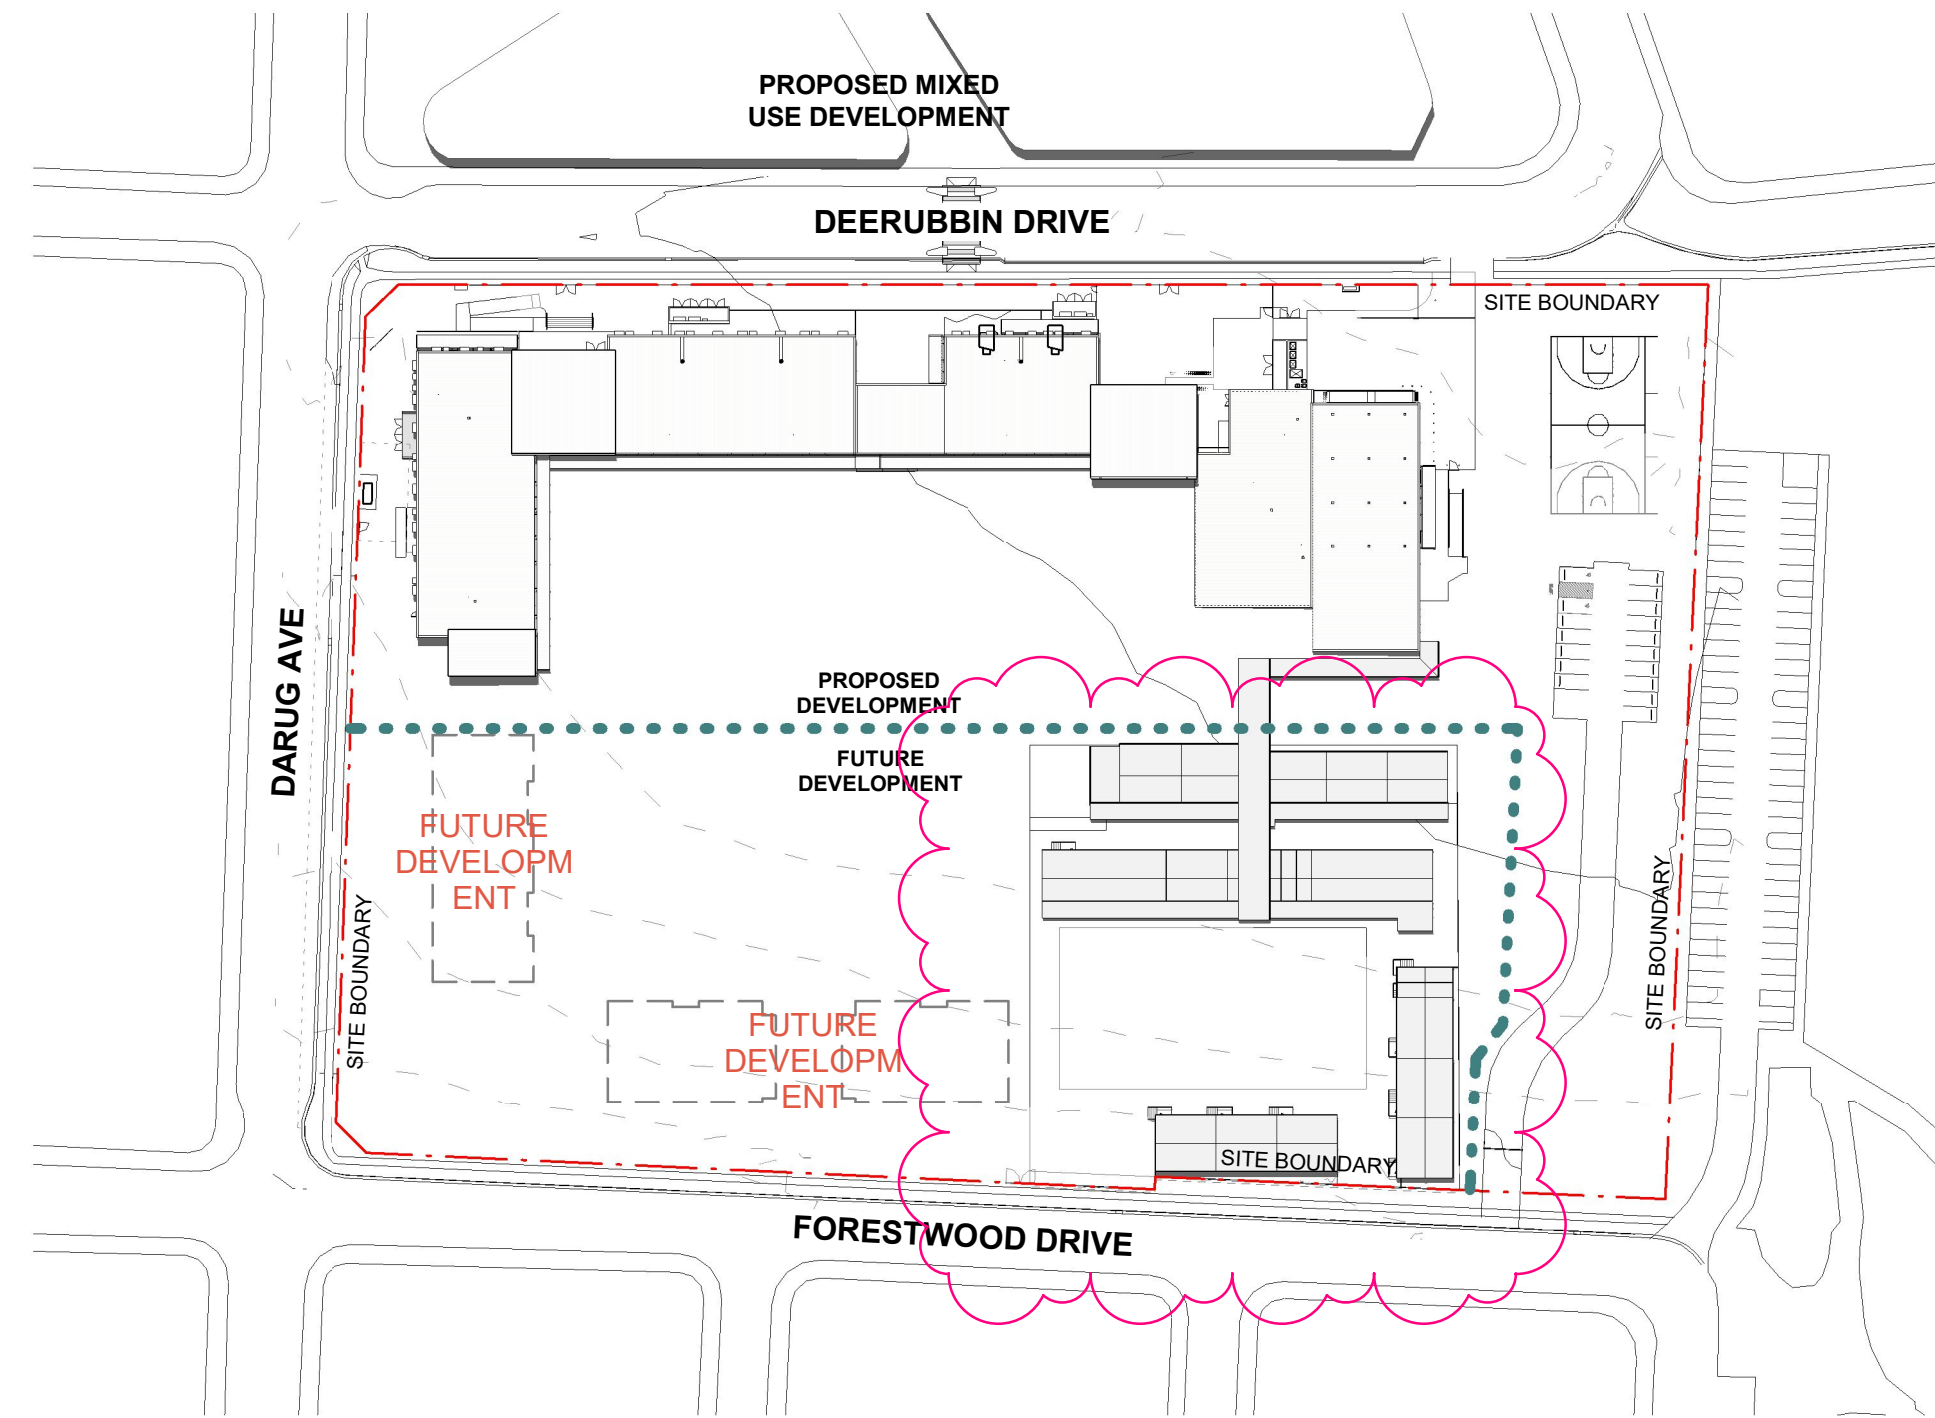

5 SHADOW DIAGRAM DEC 21 12PM

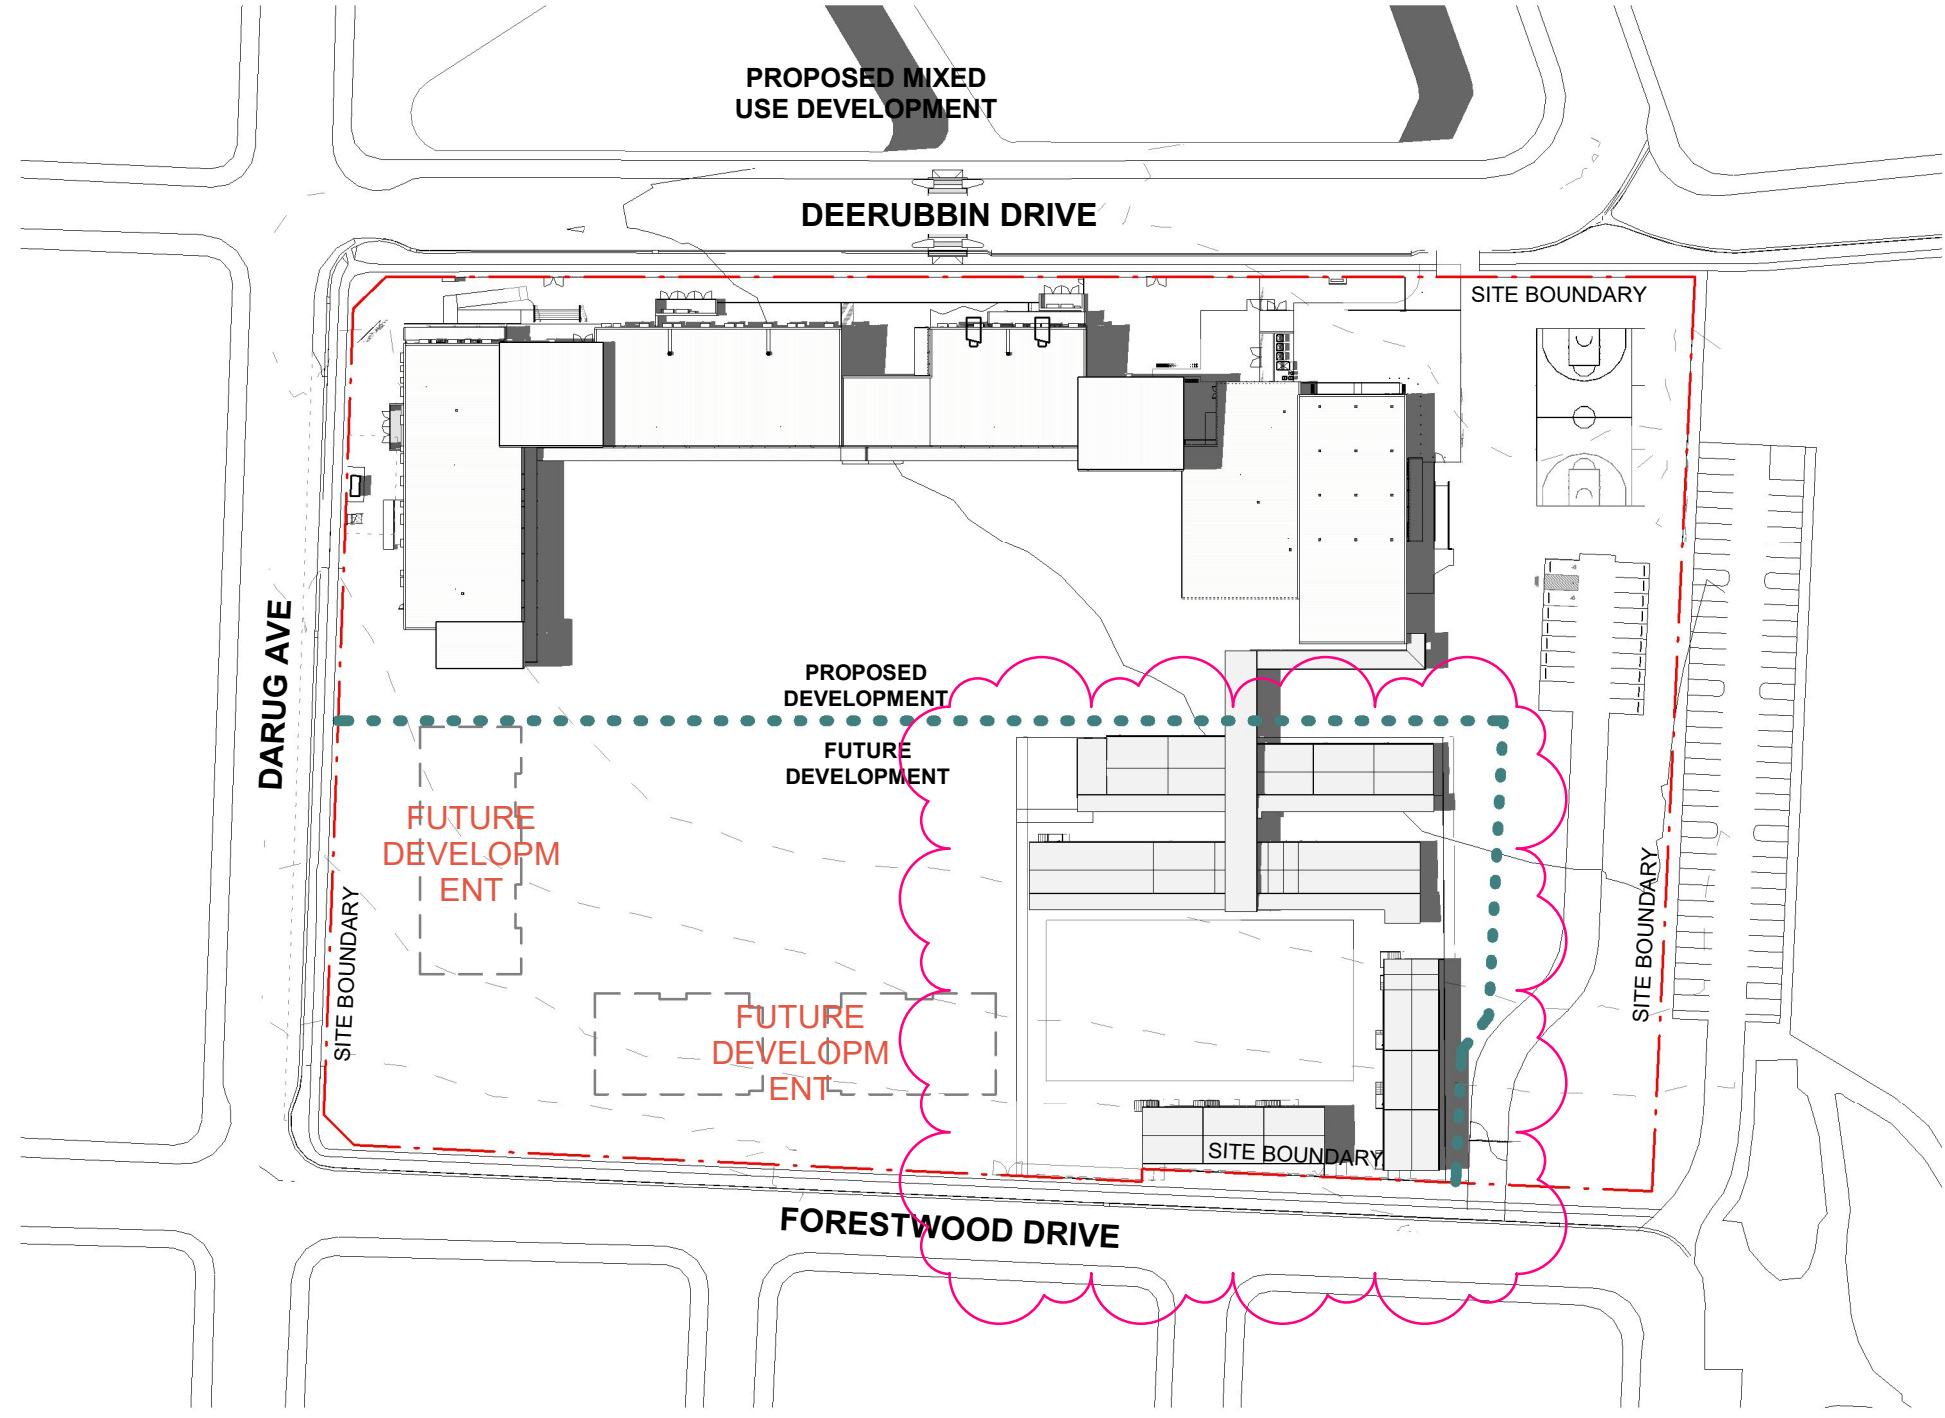

6 SHADOW DIAGRAM DEC 21 3PM

| Issue No. | Date       | Description            | Chkd |
|-----------|------------|------------------------|------|
| 01        | 12/04/2021 | ISSUE FOR COORDINATION |      |
| 02        | 23/04/2021 | ISSUE FOR COORDINATION |      |
| 03        | 04/05/2021 | SSDA ISSUE             |      |
| 04        | 06/08/2021 | SSDA ISSUE             | JL   |
| 05        | 11/11/2021 | SSDA RIS               | CHS  |
| 06        | 04/07/2022 | MOD SSDA               |      |

MOD SSDA

**RICHARD CROOKES**  
CONSTRUCTIONS

TRAFFIC ENGINEER  
PTC  
KASIA BALSAM  
0407 236 908  
kasia.balsam@ptccconsultants.com

TOWN PLANNER  
RPS  
ROB DWYER  
0425 285 778  
rob.dwyer@rpsgroup.com.au

MULTI SERVICES  
NDY  
RYAN HAHN  
0407 236 908  
r.hahn@ndy.com

CIVIL AND STRUCTURAL ENGINEERING  
WOOLACOTT'S  
JUSTIN CHIRILLO  
02 8203 1504  
jchirillo@woolacott's.com.au

QUANTITY SURVEYOR  
MBM  
AUTUMN LU  
02 9270 1062  
autumn.lu@mbmpl.com.au


PROJECT MANAGER  
COLLIERS  
ANTHONY MAUGHAN-WRIGHT  
0424 189 883  
anthony.maughan-wright@colliers.com

Drawing Title  
SHADOW DIAGRAMS

Project  
NEW PRIMARY SCHOOL IN MULGOA  
RISE  
at  
1-23 Forestwood Drive, Glenmore Park, NSW 2745, Australia  
for  
SINSW

Architect  
**NBR**SARCHITECTURE.  
Sydney  
61 2 9922 2344  
Any form of replication of this drawing in full or in part without the written permission of NBR'S+PARTNERS Pty Ltd constitutes an infringement of the copyright.  
Nominated Architect:  
Andrew Duffin NSW 5602  
NBR'S & Partners Pty Ltd VIC 51197  
nbrsarchitecture.com  
© 2021  
ABN 16 002 247 565

Date 07/07/2022 1:22:53 pm  
Scale NOT TO SCALE  
Drawing Reference  
20415-NBR'S-DW-AR-SSDA-0003  
Revision 06

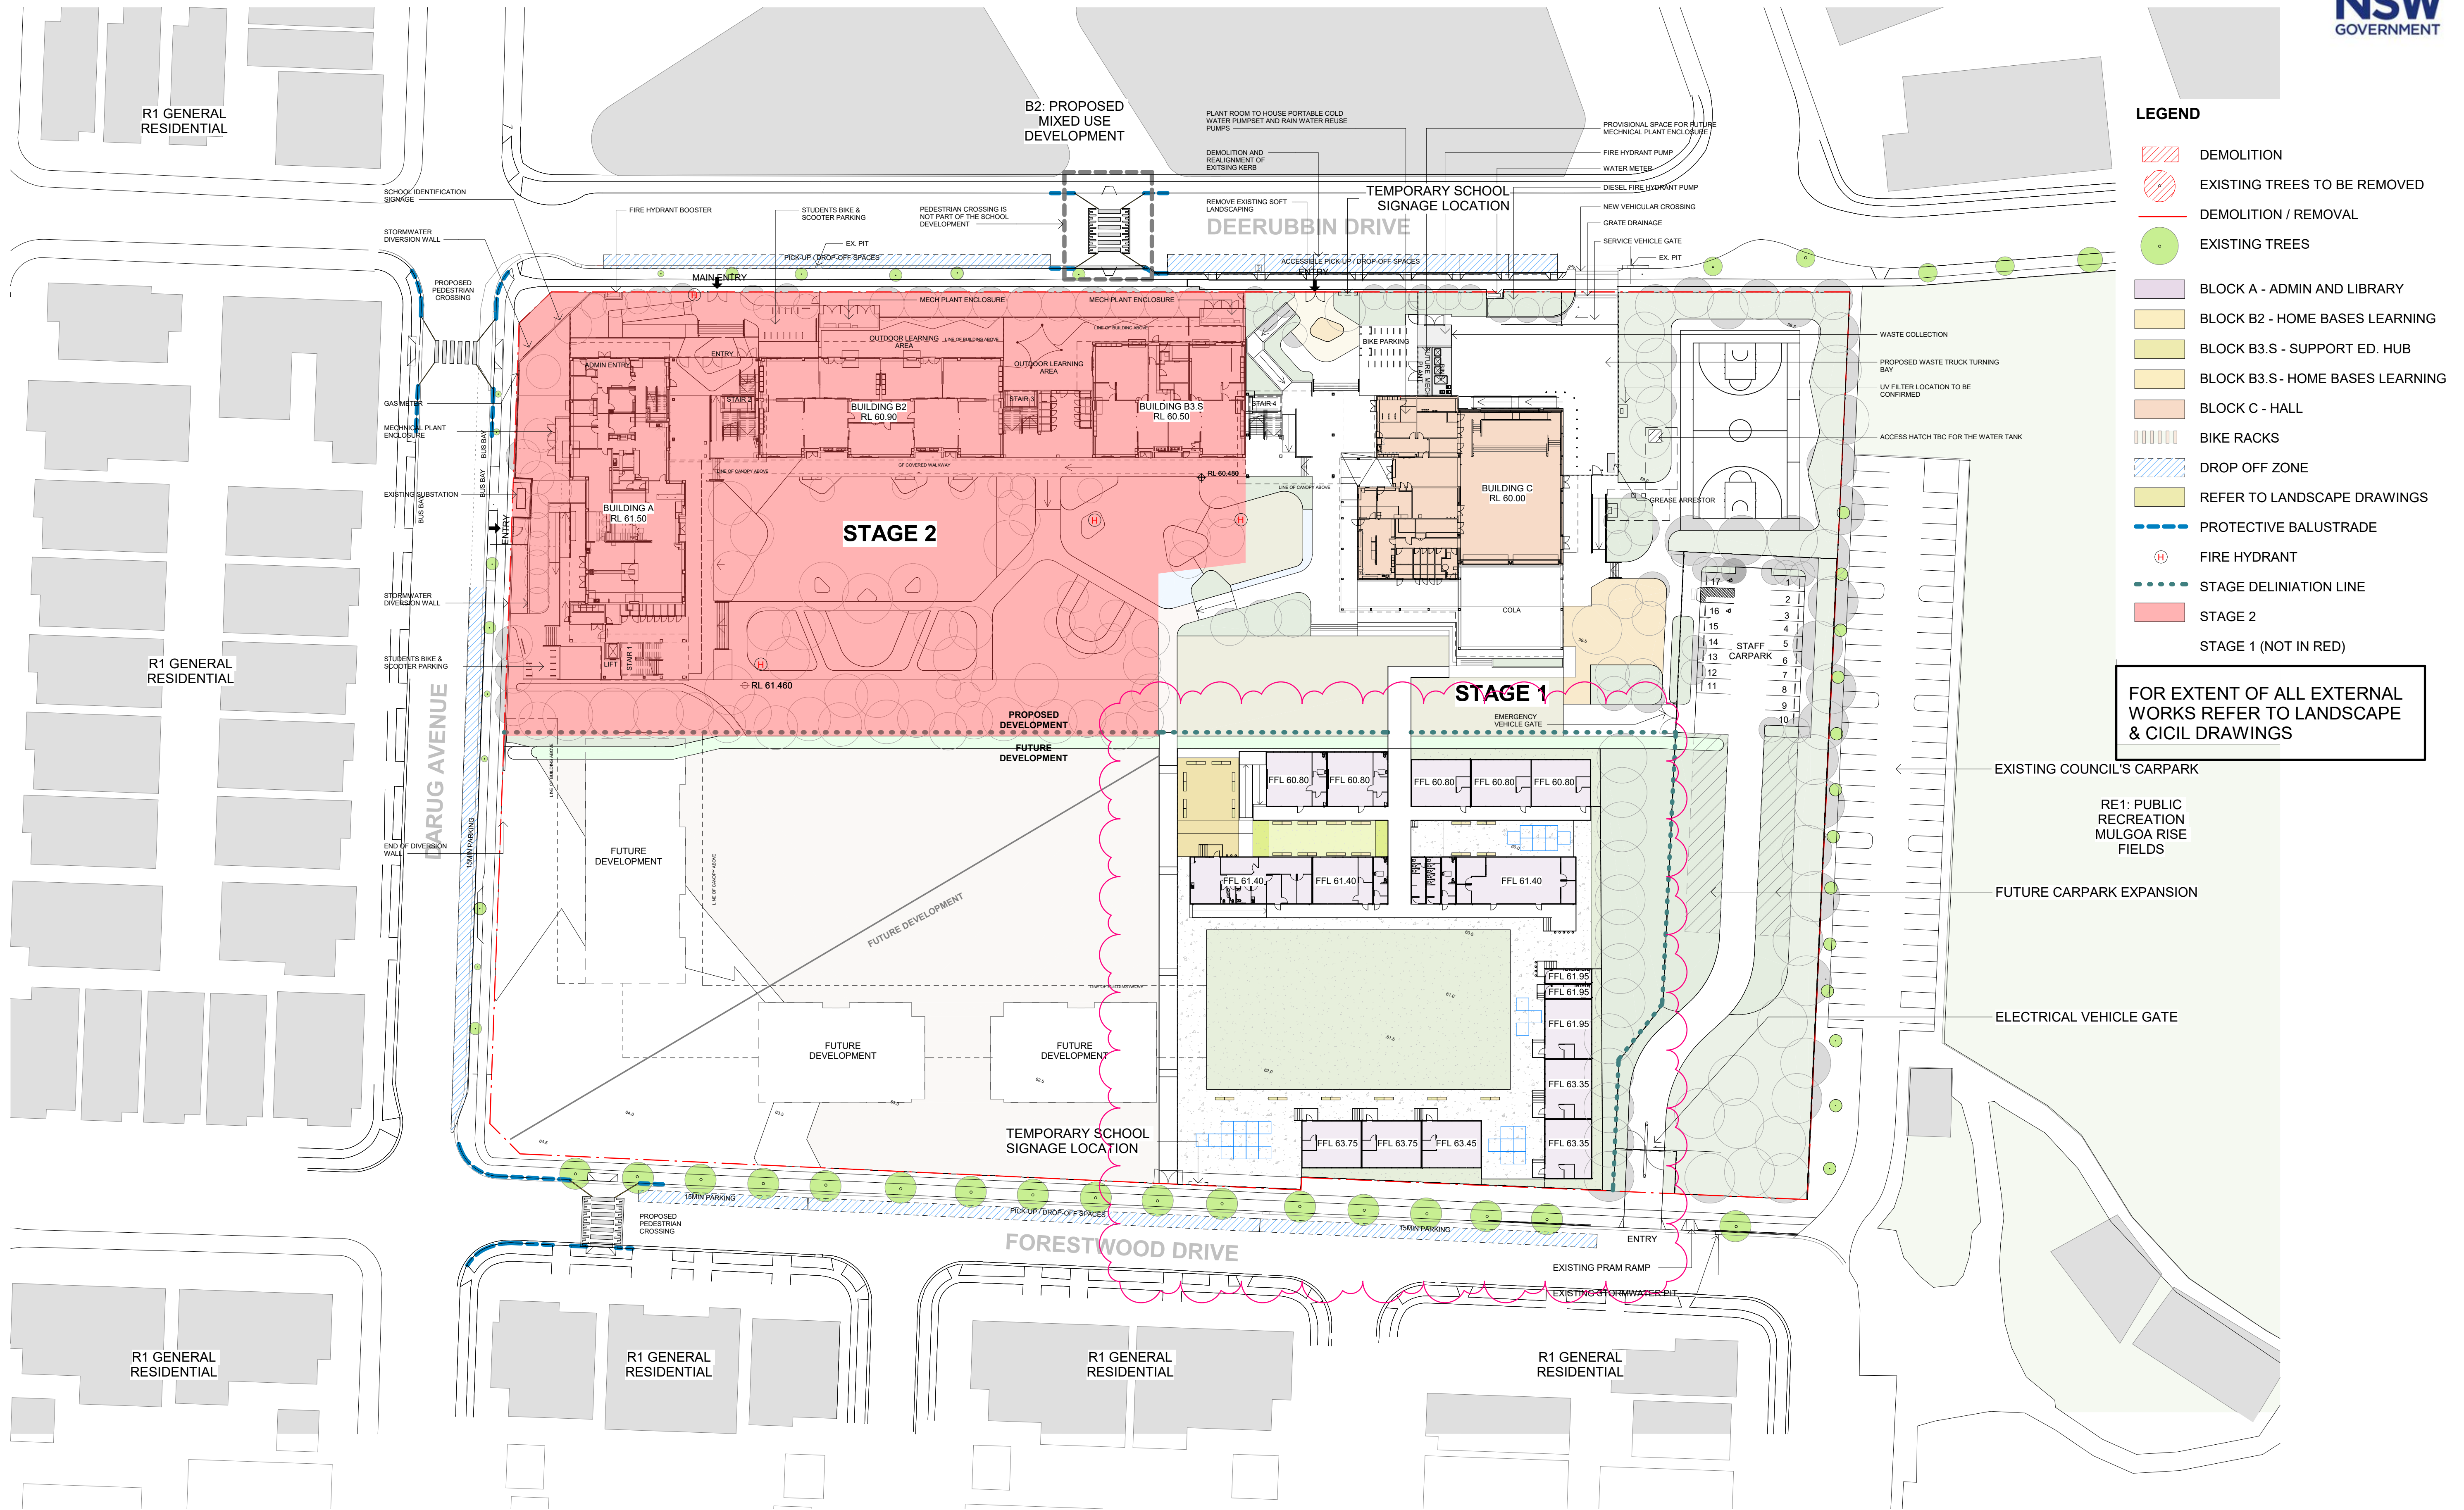

- LEGEND**
- DEMOLITION
  - EXISTING TREES TO BE REMOVED
  - DEMOLITION / REMOVAL
  - EXISTING TREES
  - BLOCK A - ADMIN AND LIBRARY
  - BLOCK B2 - HOME BASES LEARNING
  - BLOCK B3.S - SUPPORT ED. HUB
  - BLOCK B3.S - HOME BASES LEARNING
  - BLOCK C - HALL
  - BIKE RACKS
  - DROP OFF ZONE
  - REFER TO LANDSCAPE DRAWINGS
  - PROTECTIVE BALUSTRADE
  - FIRE HYDRANT
  - STAGE DELINATION LINE
  - STAGE 2
  - STAGE 1 (NOT IN RED)

FOR EXTENT OF ALL EXTERNAL WORKS REFER TO LANDSCAPE & CICAL DRAWINGS

EXISTING COUNCIL'S CARPARK  
 RE1: PUBLIC RECREATION MULGOA RISE FIELDS  
 FUTURE CARPARK EXPANSION  
 ELECTRICAL VEHICLE GATE

| Issue No. | Date       | Description                | Chkd |
|-----------|------------|----------------------------|------|
| 04        | 04/05/2021 | SSDA ISSUE FOR INFORMATION | JL   |
| 05        | 14/07/2021 | COORDINATION ISSUE         | JL   |
| 06        | 19/07/2021 | ISSUE FOR COORDINATION     | JL   |
| 07        | 28/07/2021 | SSDA ISSUE                 | JL   |
| 08        | 06/08/2021 | SSDA ISSUE                 | JL   |
| 09        | 11/08/2021 | SSDA RIS                   | CHS  |
| 10        | 11/11/2021 | SSDA RIS                   | CHS  |
| 11        | 12/11/2021 | MOD SSDA                   | CHS  |
| 12        | 04/07/2022 |                            |      |

**MOD SSDA**

**RICHARD CROOKES CONSTRUCTIONS**

**TRAFFIC ENGINEER**  
**PTC**  
 KASIA BALSAM  
 02 8920 0800  
 kasia.balsam@ptccconsultants.co

**TOWN PLANNER**  
**RPS**  
 ROB DWYER  
 0425 285 778  
 rob.dwyer@rpsgroup.com.au

**MULTI SERVICES**  
**NDY**  
 RYAN HAHN  
 0407 236 908  
 r.hahn@ndy.com

**CIVIL AND STRUCTURAL ENGINEERING**  
**WOOLACOTTS**  
 JUSTIN CHIRILLO  
 02 8203 1504  
 jchirillo@woolacotts.com.au

**QUANTITY SURVEYOR**  
**MBM**  
 AUTUMN LU  
 02 9270 1062  
 autumn.lu@mbmpl.com.au

**PROJECT MANAGER**  
**COLLIERS**  
 ANTHONY MAUGHAN-WRIGHT  
 0424 189 883  
 anthony.maughan-wright@colliers.com

Drawing Title  
**SITE PLAN**

Project  
**NEW PRIMARY SCHOOL IN MULGOA RISE**  
 at  
 1-23 Forestwood Drive, Glenmore Park, NSW 2745, Australia  
 for  
**SINW**

Architect  
**NBR ARCHITECTURE.**  
 Sydney  
 61 2 9922 2344  
 Any form of replication of this drawing in full or in part without the written permission of NBR ARCHITECTURE Pty Ltd constitutes an infringement of the copyright.  
 Nominated Architect:  
 Andrew Duffin NSW 5602  
 NBR & Partners Pty Ltd VIC 51197

nbrsarchitecture.com  
 ABN 16 002 247 565

Date 07/07/2022 1:23:52 pm  
 Scale 1:500 @ A1

Drawing Reference  
**20415-NBRS-DW-AR-SSDA-0110012**


Revision

© 2021  
 ABN 16 002 247 565


 Date 07/07/2022 1:24:02 pm  
 Scale 1:500 @ A1

Drawing Reference Revision  
 20415-NBRS-DW-AR-SSDA-0113 09

0 5m 10m 15m 20m 25m 30m 35m 40m 1:500

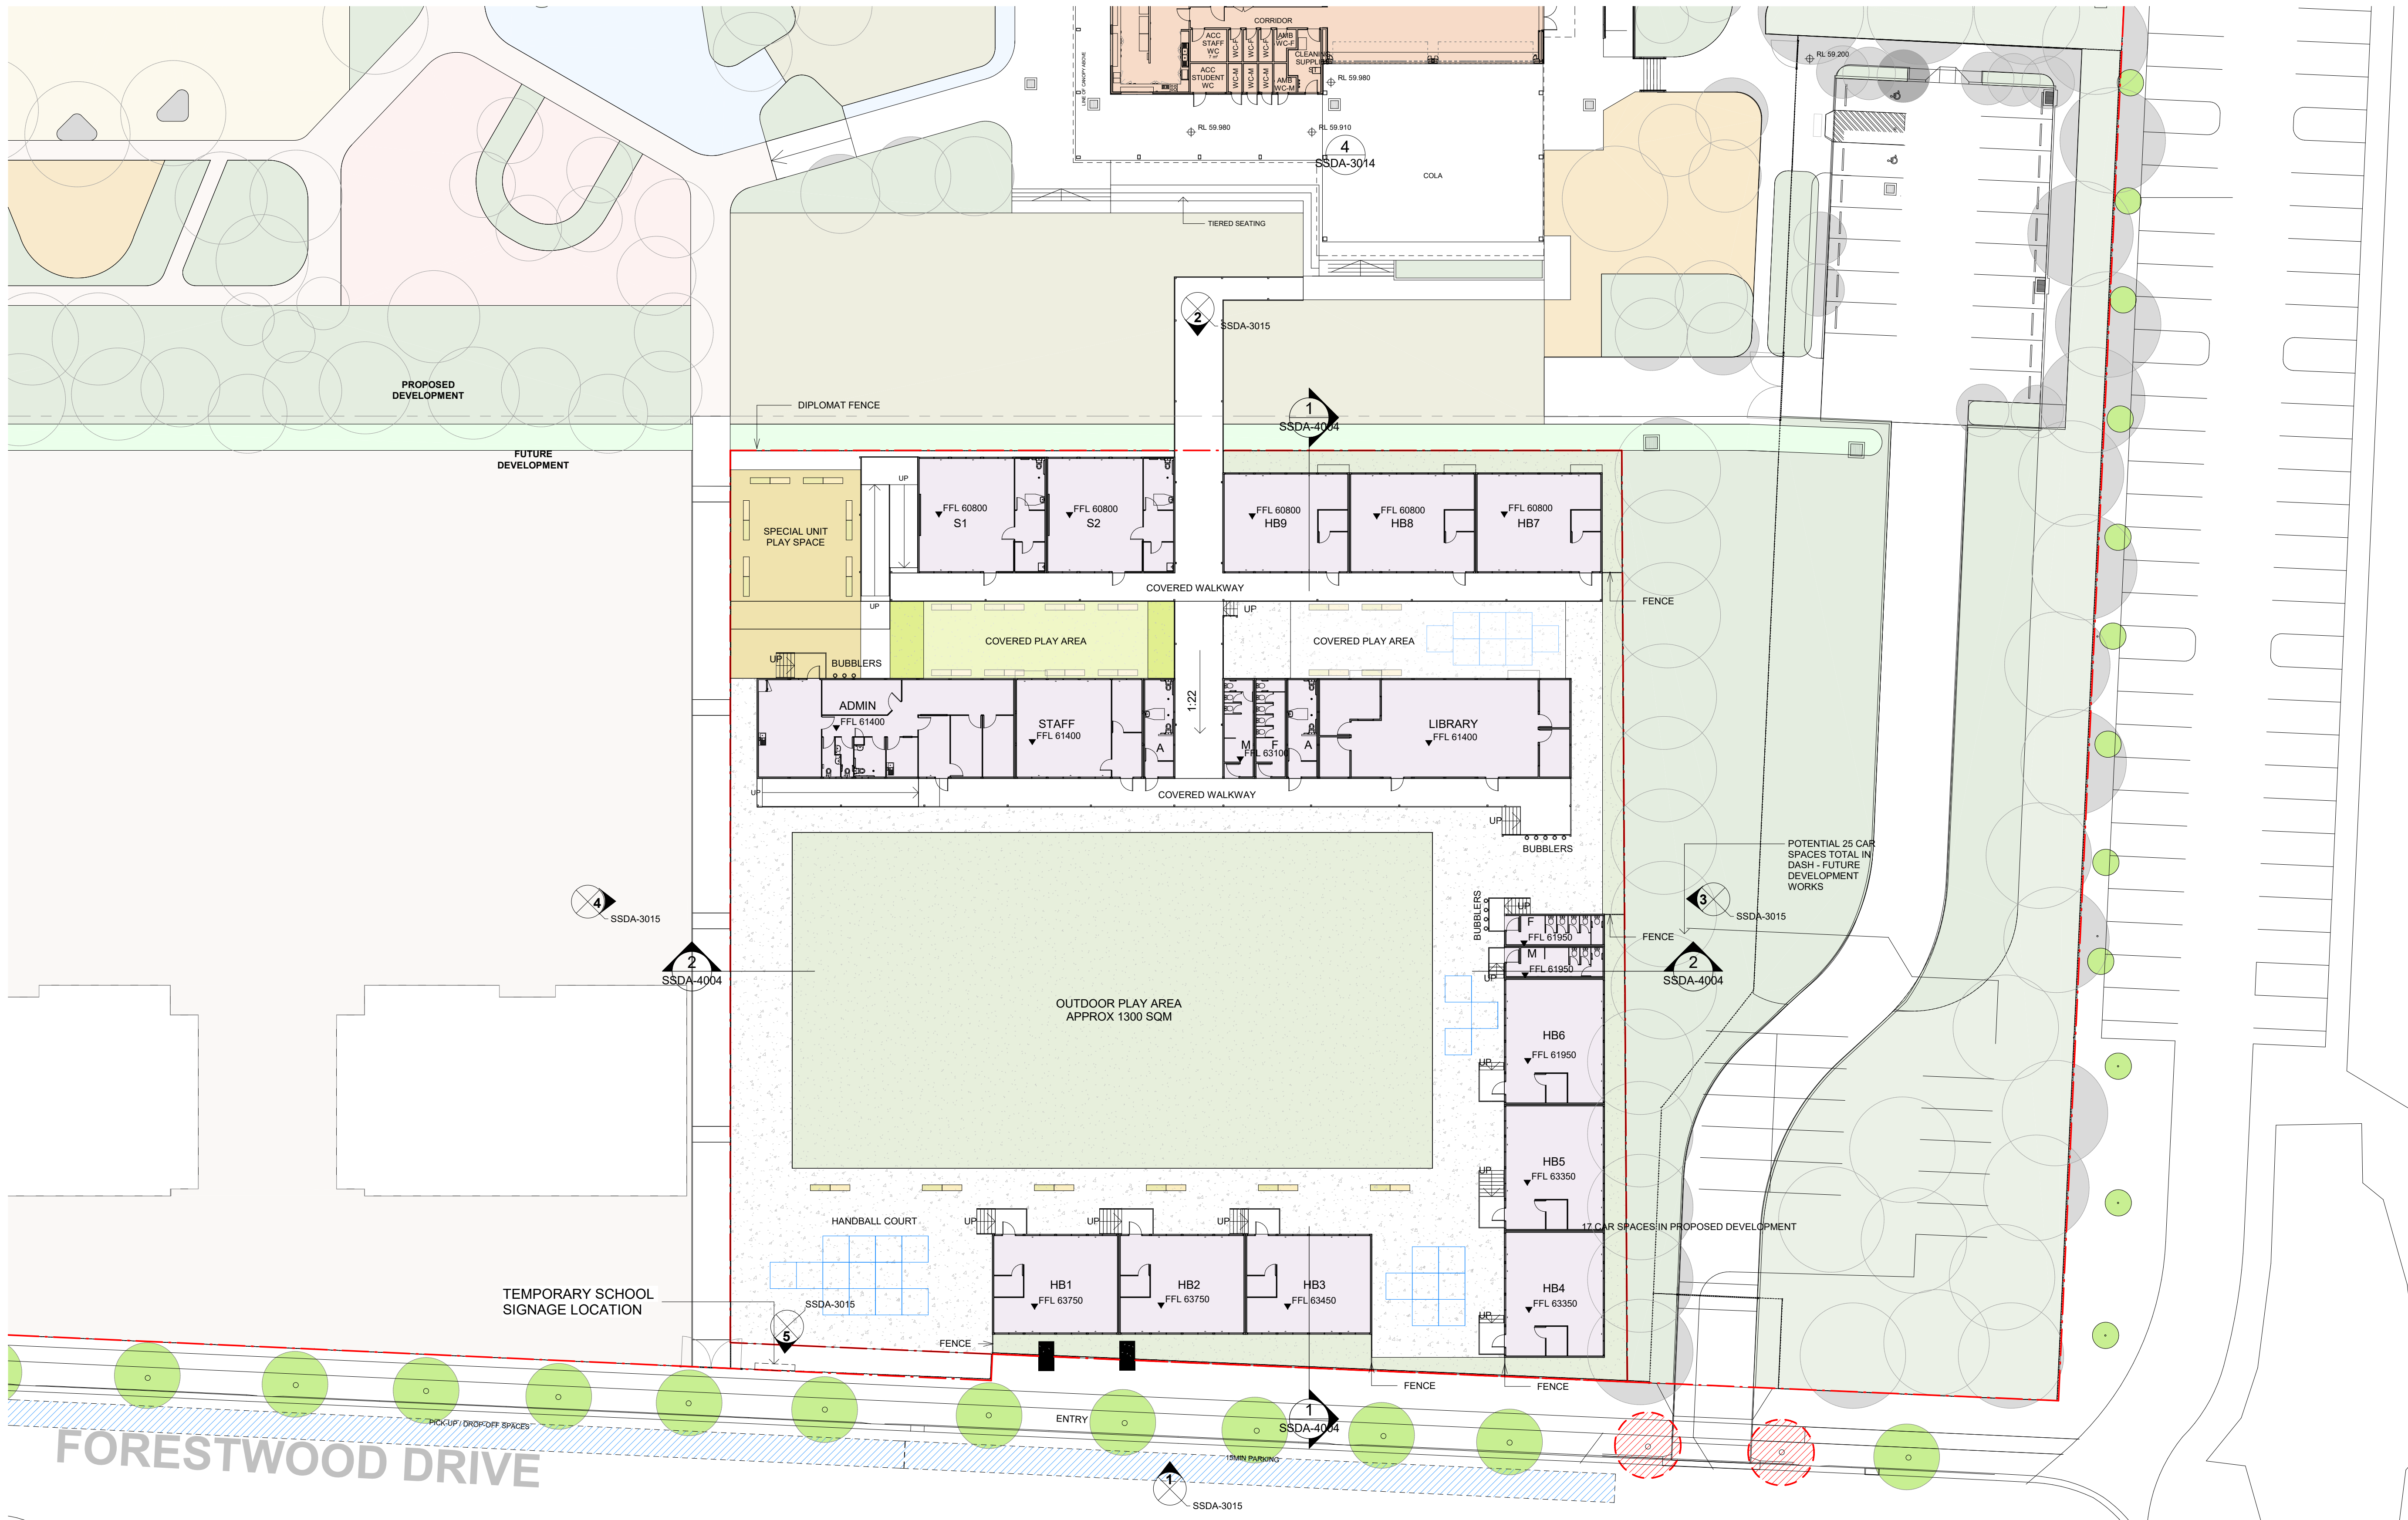

| Issue No. | Date       | Description | Chkd |
|-----------|------------|-------------|------|
| 01        | 04/07/2022 | MOD SSDA    |      |

MOD SSDA

**RICHARD CROOKES**  
CONSTRUCTIONS

**TRAFFIC ENGINEER**  
PTC  
KASIA BALSAM  
02 8920 0800  
kasia.balsam@ptccconsultants.com

**TOWN PLANNER**  
RPS  
ROB DWYER  
0425 285 778  
rob.dwyer@rpsgroup.com.au

**MULTI SERVICES**  
NDY  
RYAN HAHN  
0407 236 908  
r.hahn@ndy.com

**CIVIL AND STRUCTURAL ENGINEERING**  
WOOLACOTTS  
JUSTIN CHIRILLO  
02 8203 1504  
jchirillo@woolacotts.com.au

**QUANTITY SURVEYOR**  
MBM  
AUTUMN LU  
02 9270 1062  
autumn.lu@mbmpl.com.au

**PROJECT MANAGER**  
COLLIERS  
ANTHONY MAUGHAN-WRIGHT  
0424 189 883  
anthony.maughan-wright@colliers.com

Drawing Title  
GROUND FLOOR PLAN  
TEMPORARY SCHOOL MOD

Project  
NEW PRIMARY SCHOOL IN MULGOA  
RISE  
at  
1-23 Forestwood Drive, Glenmore Park, NSW 2745, Australia  
for  
SINSW


Architect  
**NBR**SARCHITECTURE.  
Sydney  
61 2 9922 2344  
Any form of replication of this drawing in full or in part without the written permission of NBR+PARTNERS Pty Ltd constitutes an infringement of the copyright.  
Nominated Architect:  
Andrew Duffin NSW 5602  
NBR & Partners Pty Ltd VIC 51197

nbrsarchitecture.com  
© 2021  
ABN 16 002 247 565

Date 07/07/2022 1:24:32 pm  
Scale 1: 250 @ A1

Drawing Reference  
20415-NBRS-DW-AR-SSDA-1003 01

Revision

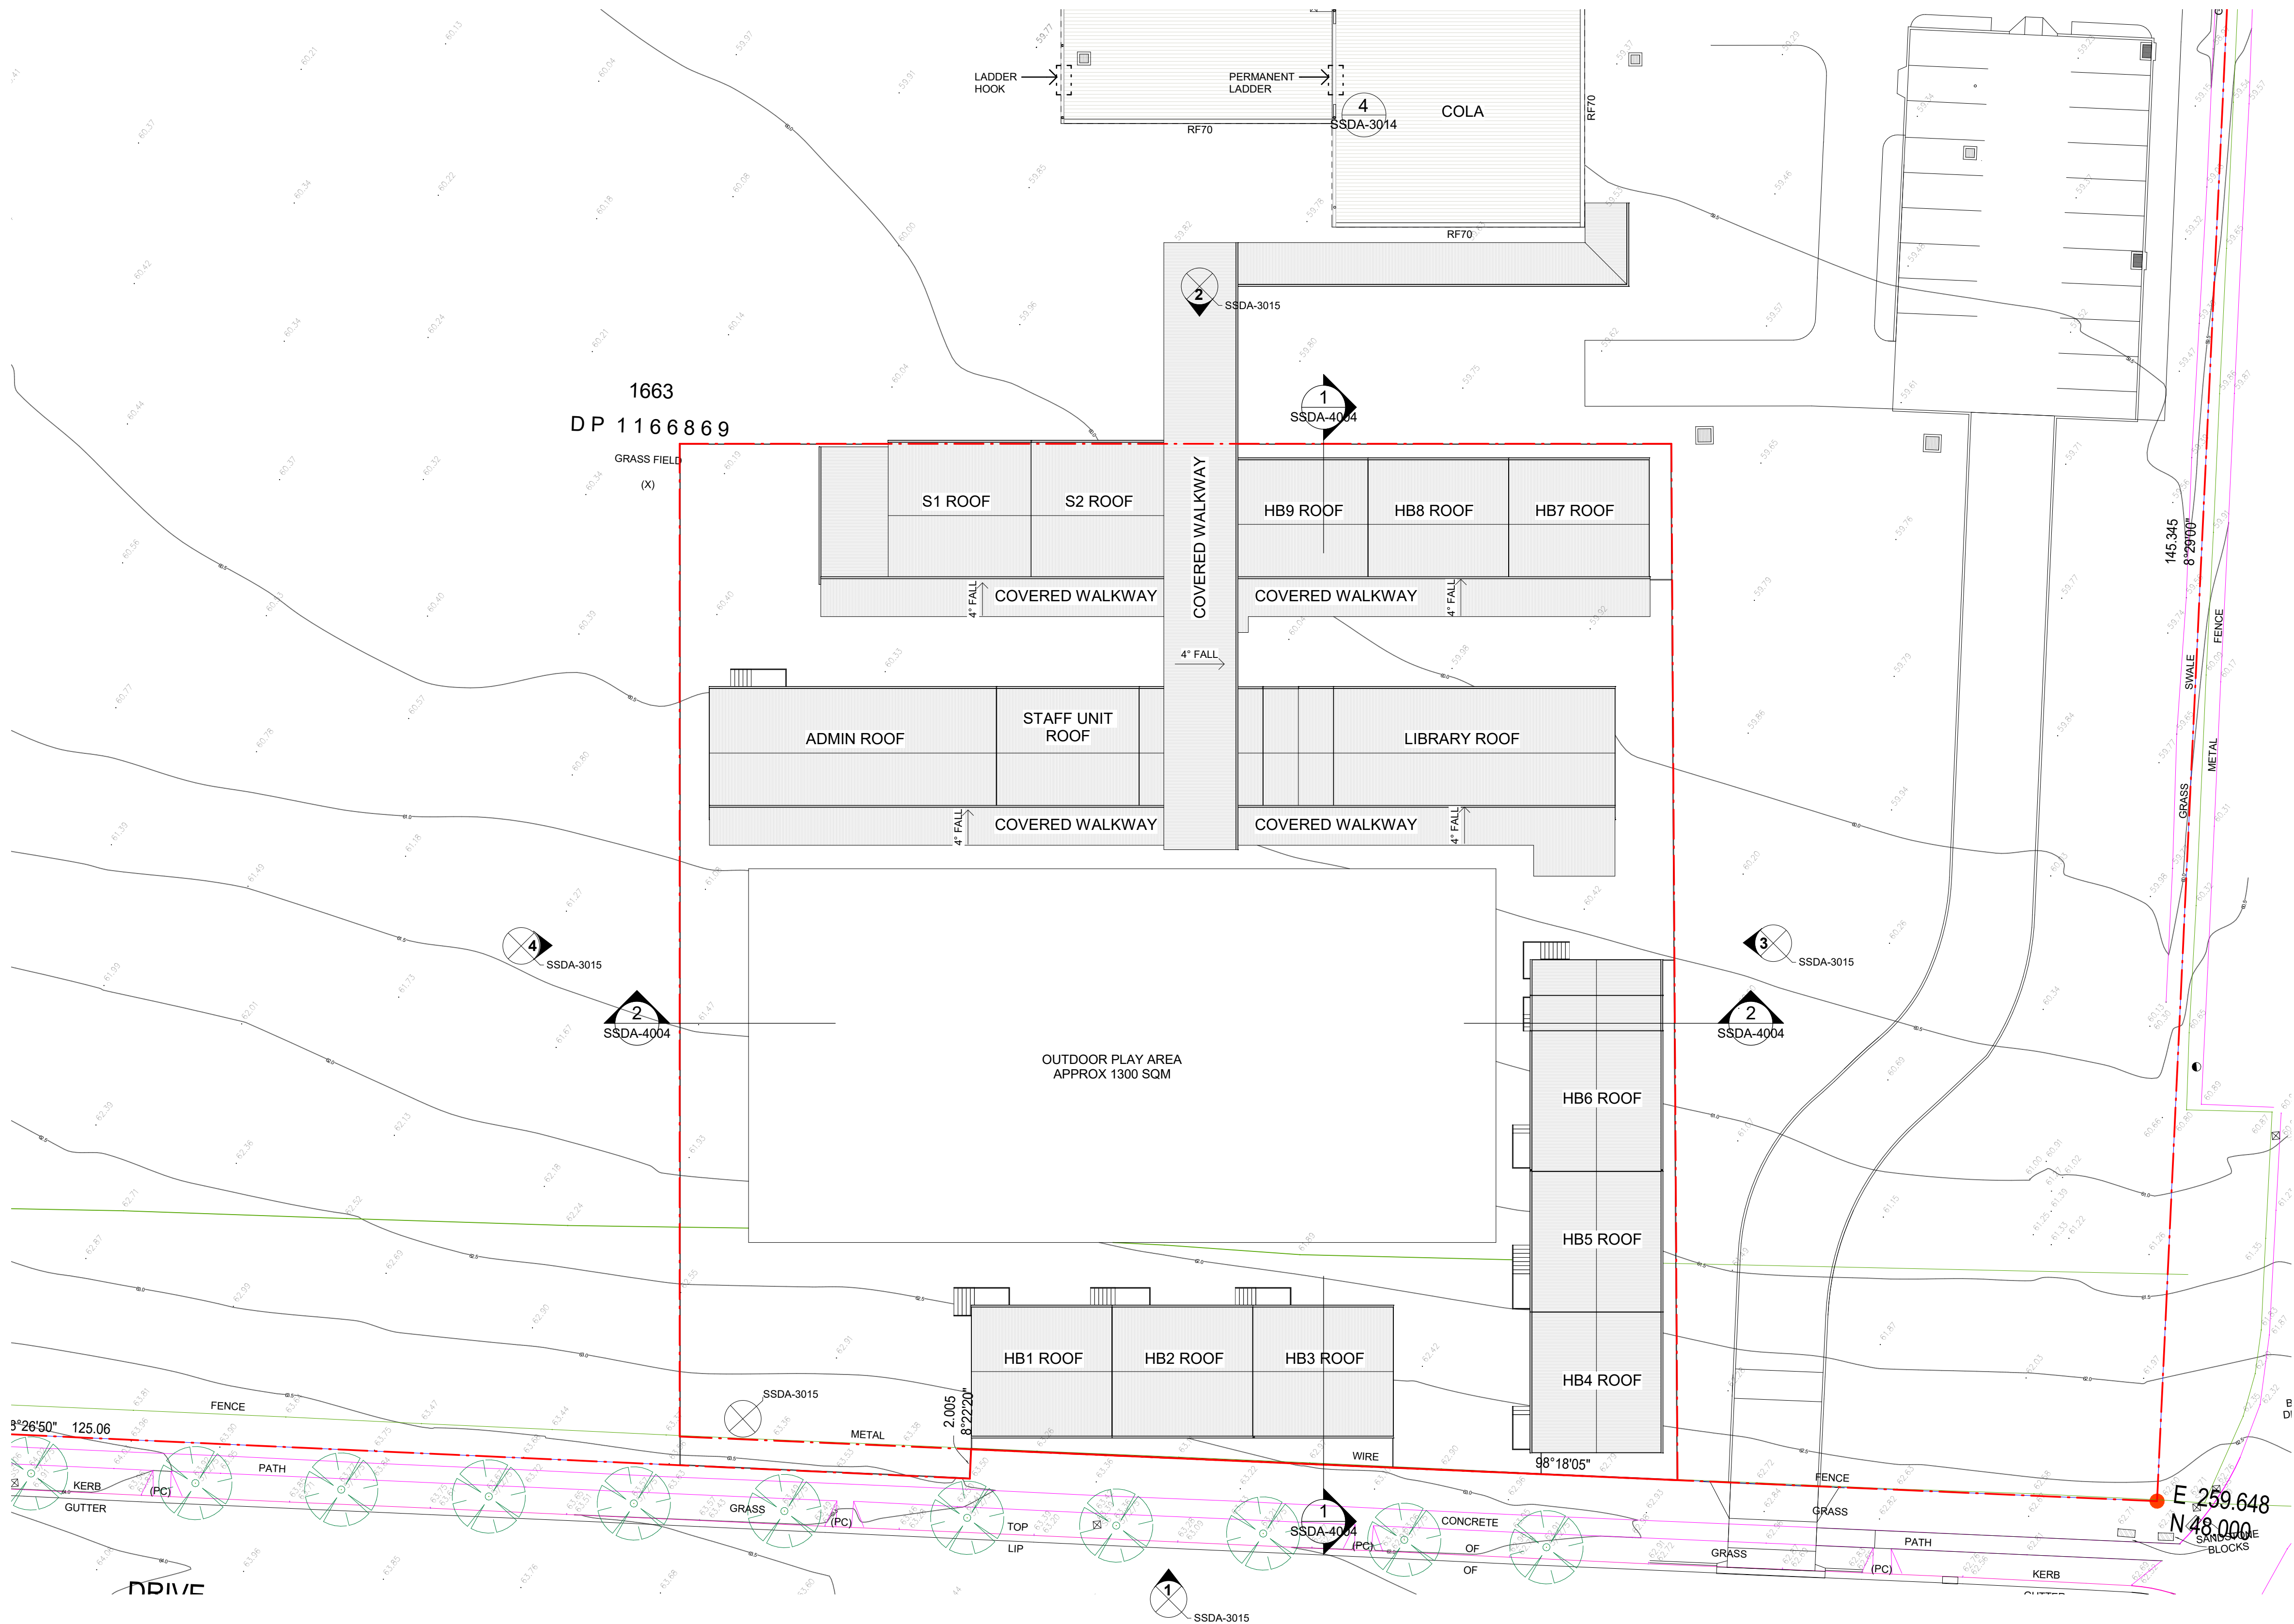

| Issue No. | Date       | Description | Chkd |
|-----------|------------|-------------|------|
| 01        | 04/07/2022 | MOD SSDA    |      |

MOD SSDA

**RICHARD CROOKES**  
CONSTRUCTIONS

**TRAFFIC ENGINEER**  
PTC  
KASIA BALSAM  
0407 236 908  
kasia.balsam@ptccconsultants.com

**TOWN PLANNER**  
RPS  
ROB DWYER  
0425 285 778  
rob.dwyer@rpsgroup.com.au

**MULTI SERVICES**  
NDY  
RYAN HAHN  
0407 236 908  
r.hahn@ndy.com

**CIVIL AND STRUCTURAL ENGINEERING**  
WOOLACOTTS  
JUSTIN CHIRILLO  
02 8203 1504  
jchirillo@woolacotts.com.au

**QUANTITY SURVEYOR**  
MBM  
AUTUMN LU  
02 9270 1062  
autumn.lu@mbmpl.com.au

**PROJECT MANAGER**  
COLLIERS  
ANTHONY MAUGHAN-WRIGHT  
0424 189 883  
anthony.maughan-wright@colliers.com

Drawing Title  
ROOF PLAN TEMPORARY SCHOOL  
MOD

Project  
NEW PRIMARY SCHOOL IN MULGOA  
RISE  
at  
1-23 Forestwood Drive, Glenmore Park, NSW 2745, Australia  
for  
SINW


Architect  
**NBR**SARCHITECTURE.  
Sydney  
61 2 9922 2344  
Any form of replication of this drawing in full or in part without the written permission of NBR-S+PARTNERS Pty Ltd constitutes an infringement of the copyright.  
Nominated Architect:  
Andrew Duffin NSW 5602  
NBR-S & Partners Pty Ltd VIC 51197

nbrsarchitecture.com  
© 2021  
ABN 16 002 247 565


Date 07/07/2022 1:24:38 pm  
Scale 1: 1200 @ A1

Drawing Reference  
20415-NBR-S-DW-AR-SSDA-1004


Revision  
01

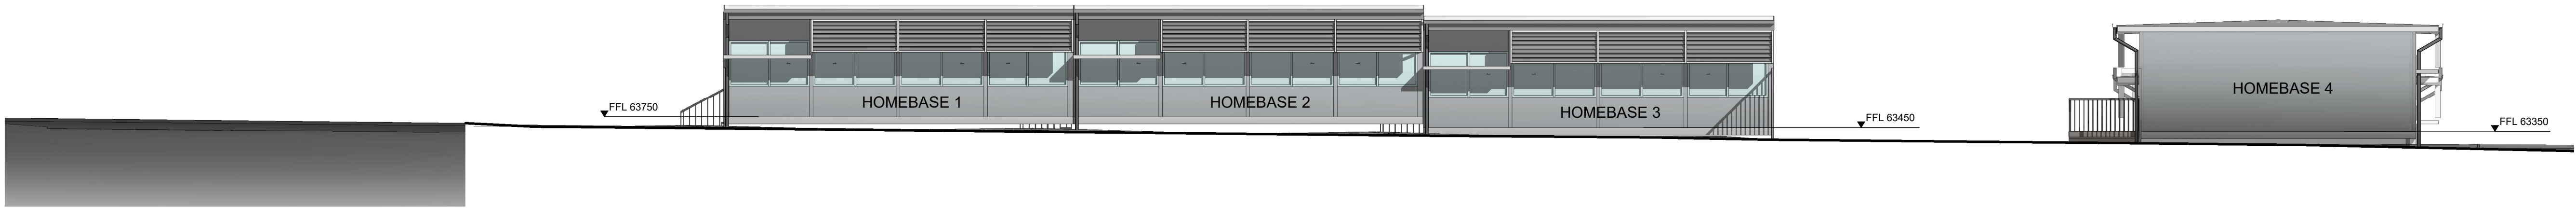


1 MOD SSDA\_SOUTH  
1 : 100

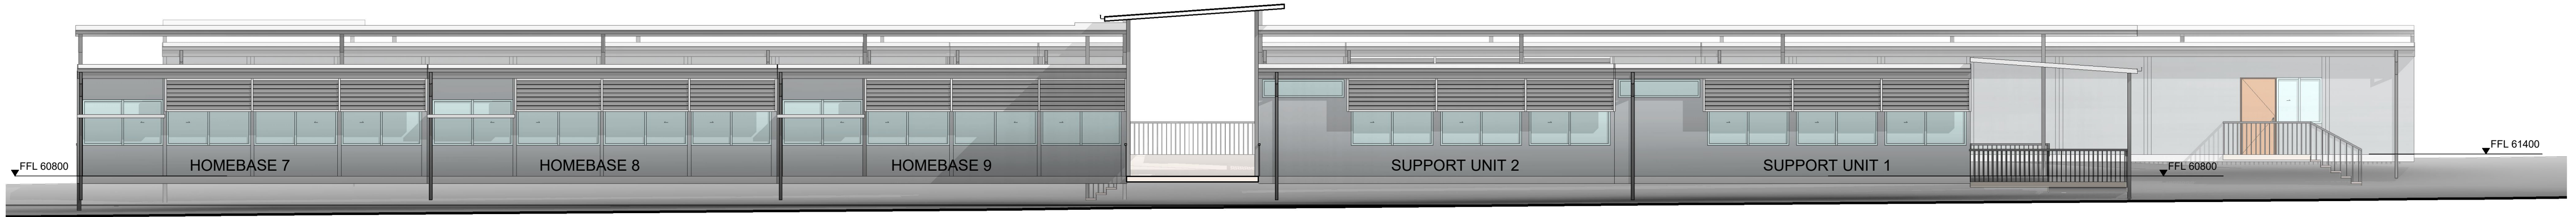


2 MOD SSDA\_NORTH  
1 : 100

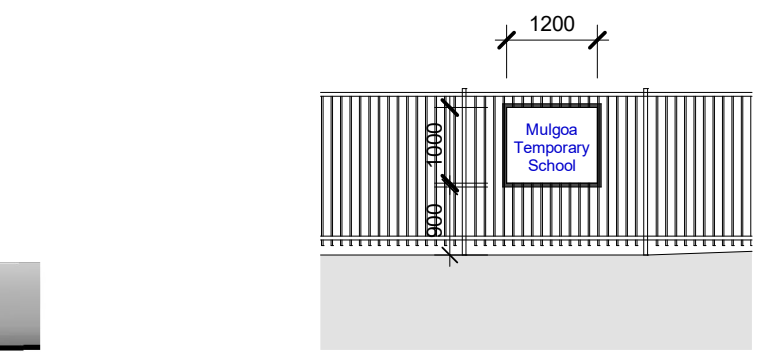

5 TYPICAL SIGNAGE ELEVATION  
1 : 100

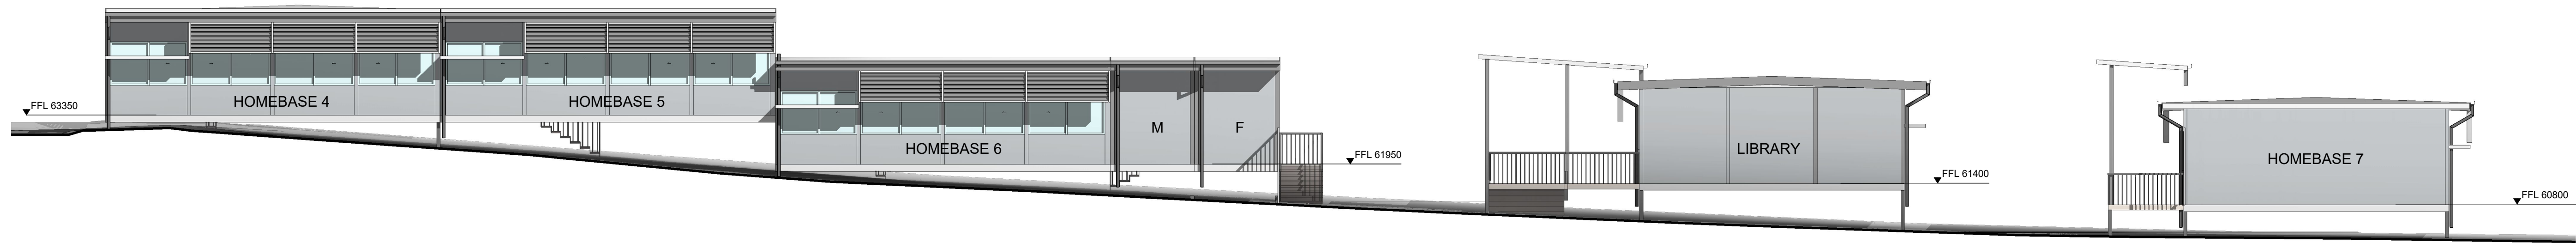

3 MOD SSDA\_RIGHT  
1 : 100

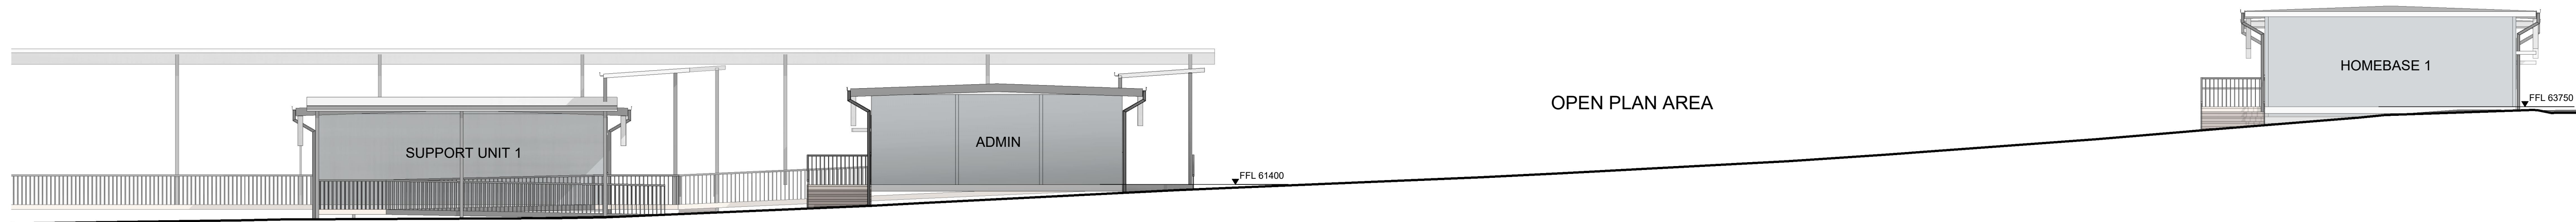

4 MOD SSDA\_LEFT  
1 : 100

| Issue No. | Date       | Description | Chkd |
|-----------|------------|-------------|------|
| 01        | 04/07/2022 | MOD SSDA    |      |

MOD SSDA

**RICHARD CROOKES**  
CONSTRUCTIONS

**TRAFFIC ENGINEER**  
**PTC**  
KASIA BALSAM  
02 8920 0800  
kasia.balsam@ptccconsultants.co

**TOWN PLANNER**  
**RPS**  
ROB DWYER  
0425 285 778  
rob.dwyer@rpsgroup.com.au

**MULTI SERVICES**  
**NDY**  
RYAN HAHN  
0407 236 908  
r.hahn@ndy.com

**CIVIL AND STRUCTURAL ENGINEERING**  
**WOOLACOTT'S**  
JUSTIN CHIRILLO  
02 8203 1504  
jchirillo@woolacott's.com.au

**QUANTITY SURVEYOR**  
**MBM**  
AUTUMN LU  
02 9270 1062  
autumn.lu@mbmpl.com.au

**PROJECT MANAGER**  
**COLLIERS**  
ANTHONY MAUGHAN-WRIGHT  
0424 189 883  
anthony.maughan-wright@colliers.com


Drawing Title  
ELEVATIONS TEMPORARY SCHOOL  
MOD

Project  
NEW PRIMARY SCHOOL IN MULGOA  
RISE  
at  
1-23 Forestwood Drive, Glenmore Park, NSW 2745, Australia  
for  
SINSW


Architect  
**NBR**SARCHITECTURE.  
Sydney  
61 2 9922 2344  
Any form of replication of this drawing in full or in part without the written permission of NBR S+PARTNERS Pty Ltd constitutes an infringement of the copyright.  
Nominated Architect:  
Andrew Duffin NSW 5602  
NBR S & Partners Pty Ltd VIC 51197  
nbrsarchitecture.com  
© 2021  
ABN 16 002 247 565

Date 07/07/2022 1:24:59 pm  
Scale 1 : 100 @ A1

Drawing Reference 20415-NBR S-DW-AR-SSDA-3015 01  
Revision

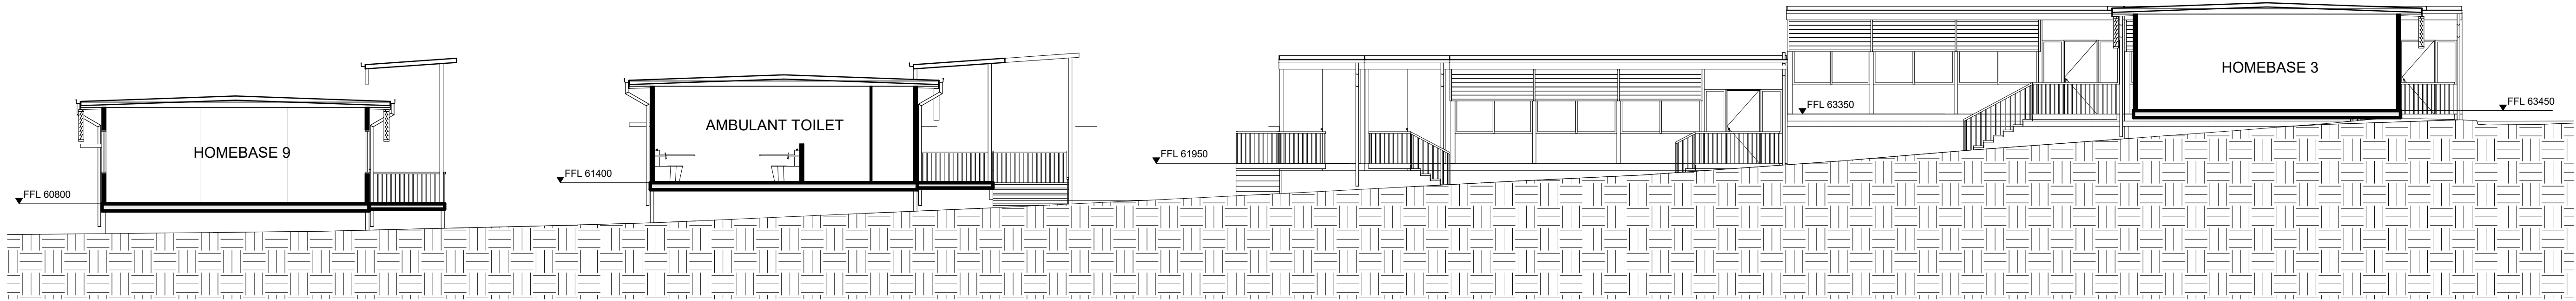

1 MOD SSDA\_SECTION 1  
1 : 100

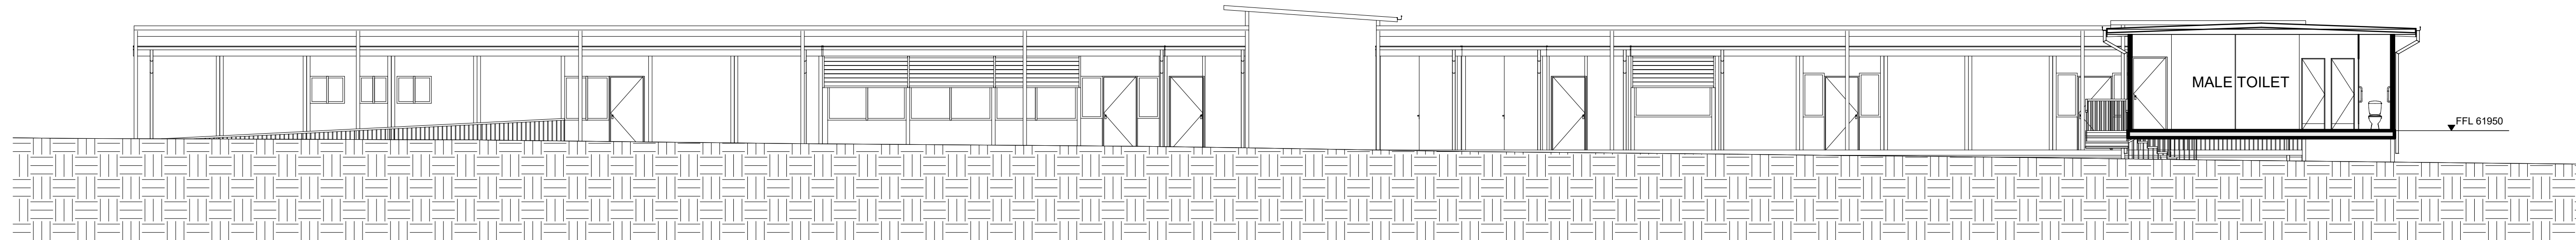

2 MOD SSDA\_SECTION 2  
1 : 100

| Issue No. | Date       | Description | Chkd |
|-----------|------------|-------------|------|
| 01        | 04/07/2022 | MOD SSDA    |      |

MOD SSDA

**RICHARD CROOKES**  
CONSTRUCTIONS

**TRAFFIC ENGINEER**  
**PTC**  
KASIA BALSAM  
02 8920 0800  
kasia.balsam@ptcconsultants.co

**TOWN PLANNER**  
**RPS**  
ROB DWYER  
0425 285 778  
rob.dwyer@rpsgroup.com.au

**MULTI SERVICES**  
**NDY**  
RYAN HAHN  
0407 236 908  
r.hahn@ndy.com

**CIVIL AND STRUCTURAL ENGINEERING**  
**WOOLACOTTS**  
JUSTIN CHIRILLO  
02 8203 1504  
jchirillo@woolacotts.com.au

**QUANTITY SURVEYOR**  
**MBM**  
AUTUMN LU  
02 9270 1062  
autumn.lu@mbmpl.com.au

**PROJECT MANAGER**  
**COLLIERS**  
ANTHONY MAUGHAN-WRIGHT  
0424 189 883  
anthony.maughan-wright@colliers.com

Drawing Title  
SECTIONS TEMPORARY SCHOOL  
MOD

Project  
NEW PRIMARY SCHOOL IN MULGOA  
RISE  
at  
1-23 Forestwood Drive, Glenmore Park, NSW 2745, Australia  
for  
SINSW

Architect  
**NBR**SARCHITECTURE.  
Sydney  
61 2 9922 2344  
Any form of replication of this drawing in full or in part without the written permission of NBR-S+PARTNERS Pty Ltd constitutes an infringement of the copyright.  
Nominated Architect:  
Andrew Duffin NSW 5602  
NBR-S & Partners Pty Ltd VIC 51197

nbrsarchitecture.com  
© 2021  
ABN 16 002 247 565

Date 07/07/2022 1:25:05 pm  
Scale 1 : 100 @ A1

Drawing Reference 20415-NBRS-DW-AR-SSDA-4004  
Revision 01

0 10 20 30 40 50 60 70 80 90 100



PERSPECTIVE FROM THE OUTDOOR PLAY AREA LOOKING TOWARD THE LIBRARY AND TOILET

| Issue No. | Date       | Description | Chkd |
|-----------|------------|-------------|------|
| 01        | 04/07/2022 | MOD SSDA    |      |

**FOR COORDINATION**

**RICHARD CROOKES**  
CONSTRUCTIONS

**TRAFFIC ENGINEER**  
**PTC**  
KASIA BALSAM  
02 8920 0800  
kasia.balsam@ptcconsultants.co

**TOWN PLANNER**  
**RPS**  
ROB DWYER  
0425 285 778  
rob.dwyer@rpsgroup.com.au

**MULTI SERVICES**  
**NDY**  
RYAN HAHN  
0407 236 908  
r.hahn@ndy.com

**CIVIL AND STRUCTURAL ENGINEERING**  
**WOOLACOTTS**  
JUSTIN CHIRILLO  
02 8203 1504  
jchirillo@woolacotts.com.au

**QUANTITY SURVEYOR**  
**MBM**  
AUTUMN LU  
02 9270 1062  
autumn.lu@mbmpl.com.au

**PROJECT MANAGER**  
**COLLIERS**  
ANTHONY MAUGHAN-WRIGHT  
0424 189 883  
anthony.maughan-wright@colliers.com

Drawing Title  
3D IMAGE 5 MOD

NBRS Internal Project No  
20415

Project  
NEW PRIMARY SCHOOL IN  
MULGOA RISE  
at  
1-23 Forestwood Drive, Glenmore Park, NSW 2745, Australia  
for  
SINSW

Architect  
**NBRS**ARCHITECTURE.  
Sydney  
61 2 9922 2344  
Any form of replication of this drawing in full or in part without the written permission of NBRS+PARTNERS Pty Ltd constitutes an infringement of the copyright.  
Nominated Architect:  
Andrew Duffin NSW 5602  
NBRS & Partners Pty Ltd VIC 51197  
nbsr.com.au  
© 2021  
ABN 16 002 247 565

Date 07/07/2022 1:25:09 pm  
Scale @ A1

Drawing Reference  
M-AR-DW-SSDA-7005

Revision  
01