


GENERAL NOTES

- ALL DIMENSIONS AND EXISTING CONDITIONS SHALL BE CHECKED AND VERIFIED BY THE CONTRACTOR BEFORE PROCEEDING WITH THE WORK.
- ALL LEVELS RELATIVE TO 'AUSTRALIAN HEIGHT DATUM'.
- DO NOT SCALE DRAWINGS.
- USE FIGURED DIMENSIONS ONLY.

legend

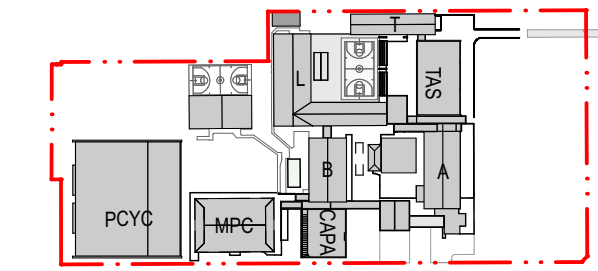

- LOW LEVEL BOLLARD MOUNTED LIGHT
- VERTICAL UP/DOWN LIGHT TO AWNING COLUMN
- VERTICAL UPLIGHT
- STRIP LIGHTING TO LANDSCAPED AREAS
- STRIP LIGHTS IN AWNING SOFFIT


| 04 | 14/4/21 | SSDA | MJ |
|-----|---------|---------------|----|
| 03 | 26/3/21 | SSDA | KT |
| 02 | 23/2/21 | Draft SSDA 02 | KT |
| 01 | 12/2/21 | Draft SSDA | MJ |
| rev | date | name | by |

first studio architecture interiors landscape urban community
sydney melbourne uk
Level 5, 70 King Street t +61 2 9251 7077 w firststudio.com

project
Hastings Schools Port Macquarie
Hastings Secondary College
Port Macquarie NSW 2444

title
External Lighting Plan
External Lighting Plan Link Ground TAS,
Level 1 Block L

| | | | |
|--------------|--------------------|--------------|---------|
| scale | 1:200 @ A1 | first issued | 12/2/21 |
| project code | sheet no. | revision | |
| HSPM | SSDA-610000 | 04 | |

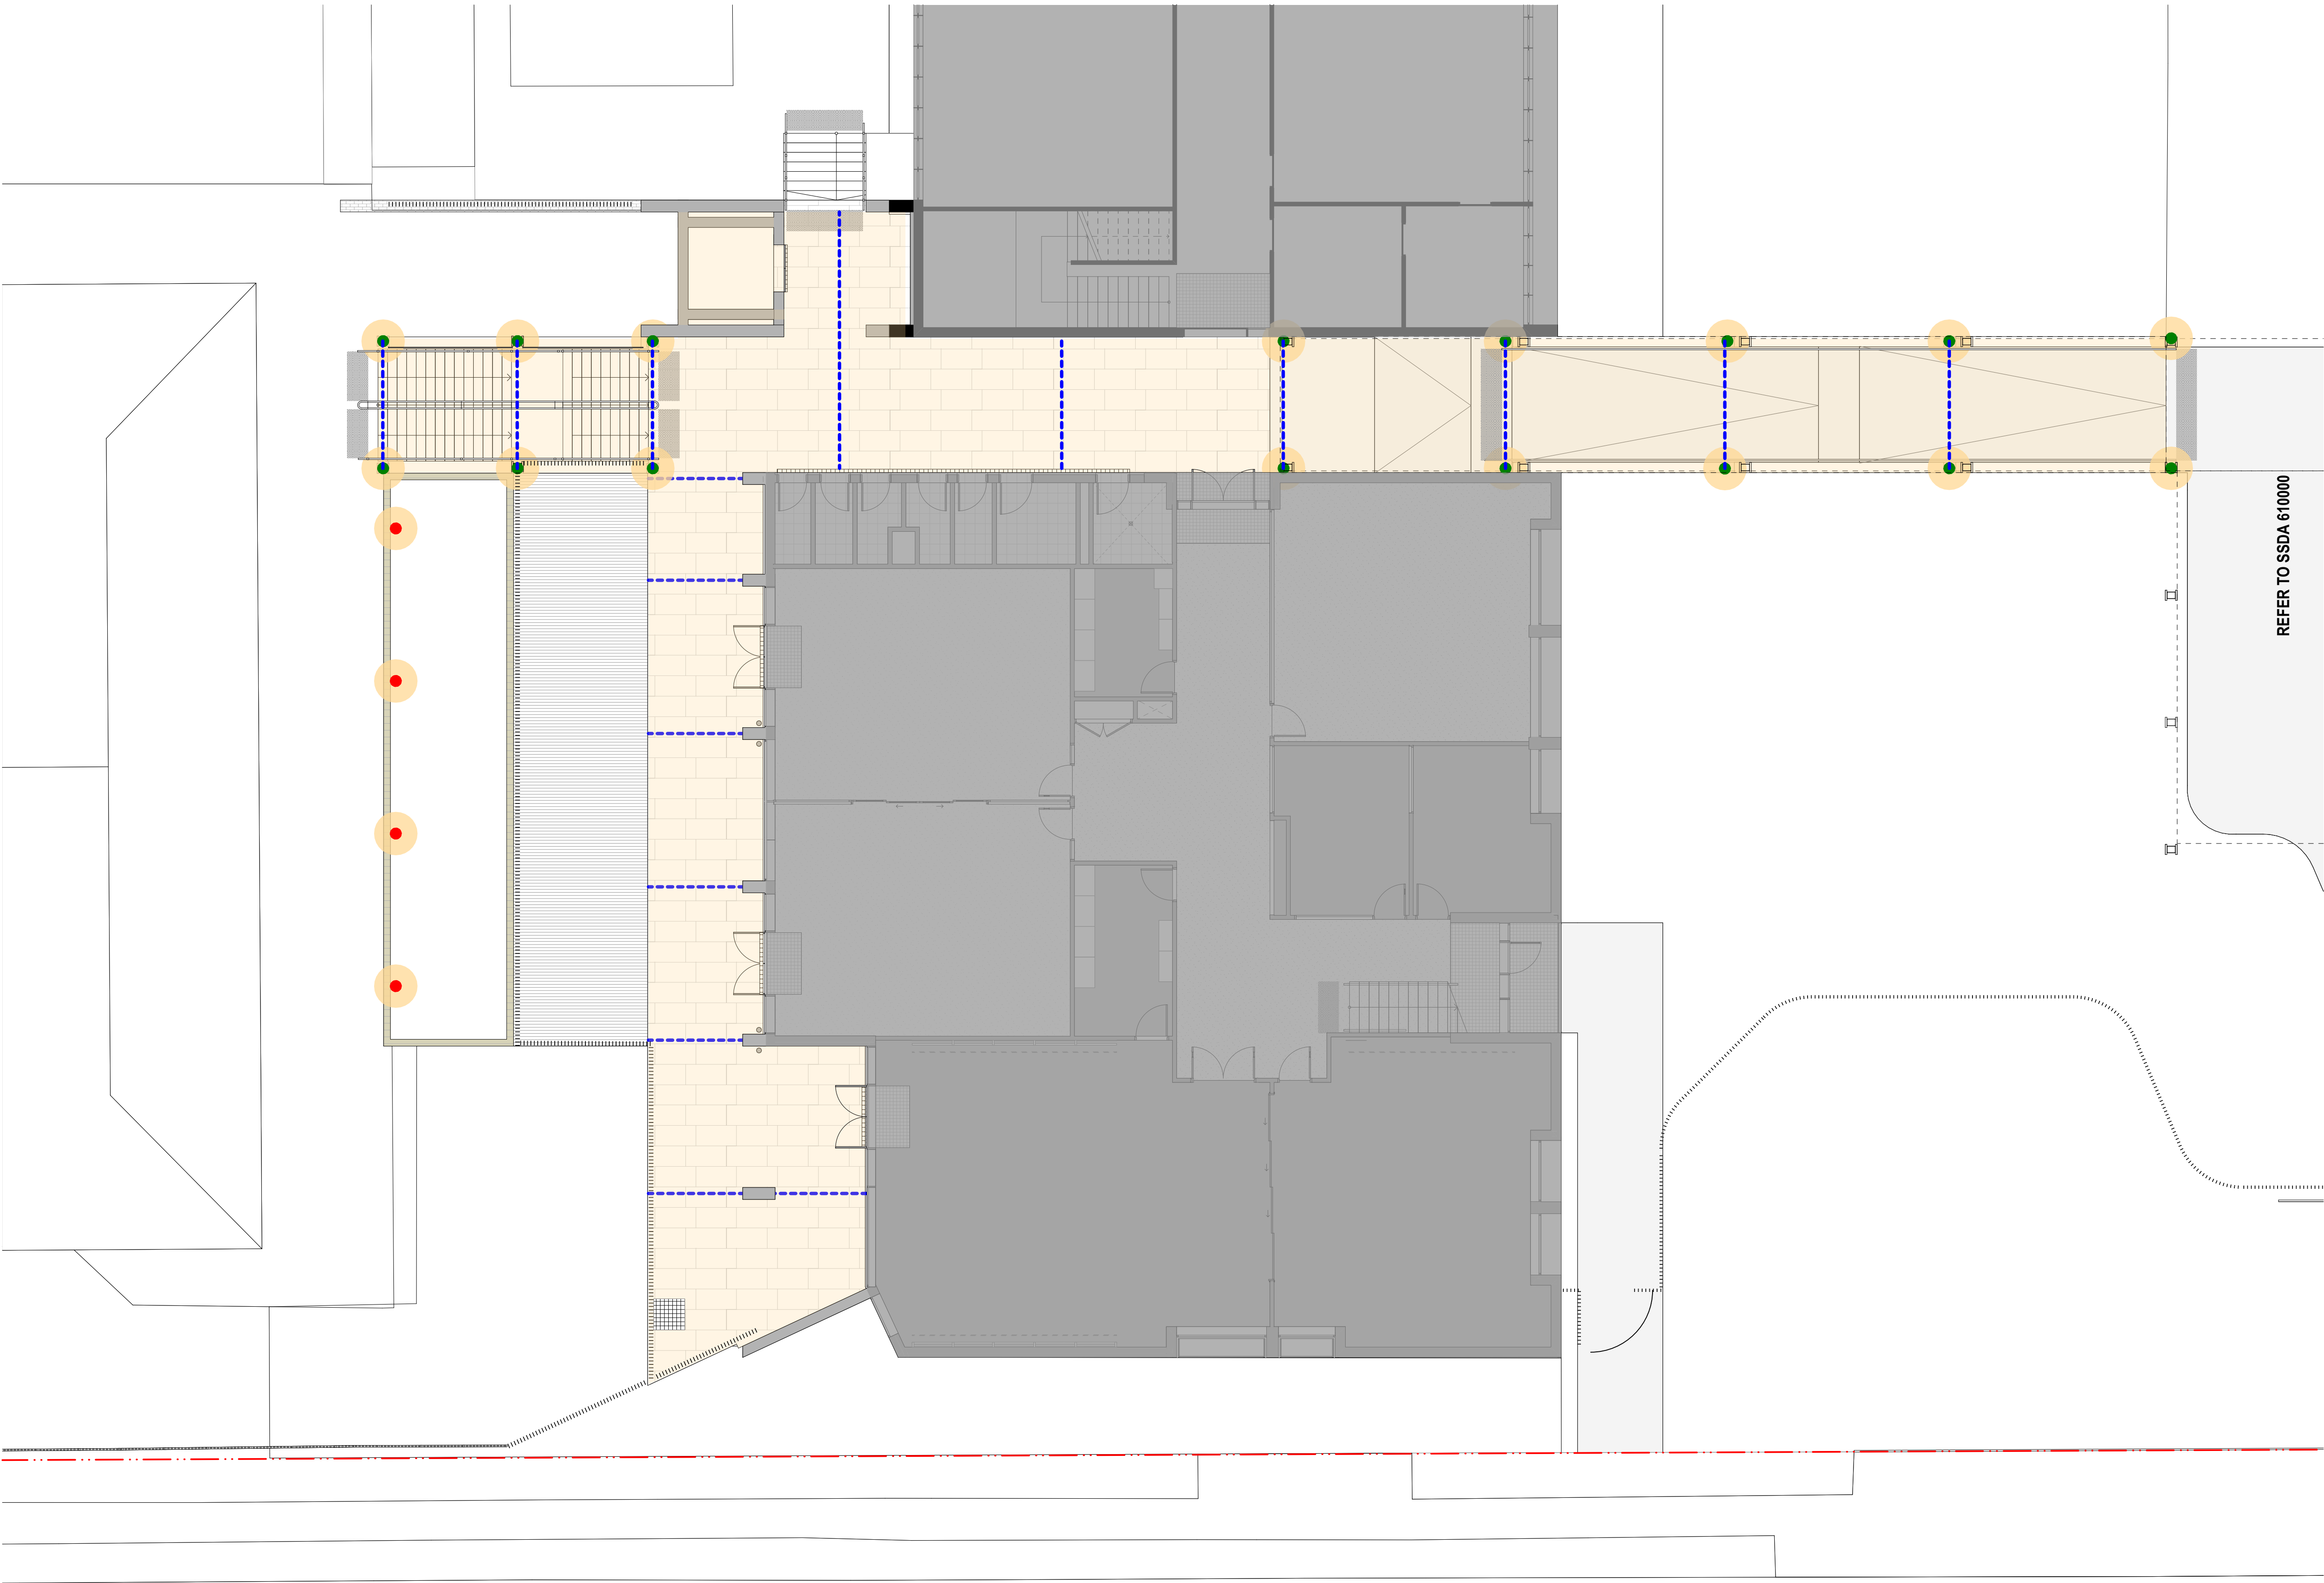

025

050

100

150

200

250

300

350

400

450

500

550

600

650

700

750

800

850

900

950

1000

GENERAL NOTES


ALL DIMENSIONS AND EXISTING CONDITIONS SHALL BE CHECKED AND VERIFIED BY THE CONTRACTOR BEFORE PROCEEDING WITH THE WORK.

ALL LEVELS RELATIVE TO AUSTRALIAN HEIGHT DATUM.

DO NOT SCALE DRAWINGS.

USE FIGURED DIMENSIONS ONLY.

legend

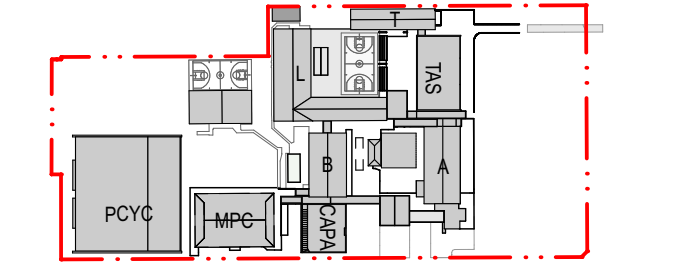

- LOW LEVEL BOLLARD MOUNTED LIGHT
- VERTICAL UP/DOWN LIGHT TO AWNING COLUMN
- VERTICAL UPLIGHT
- STRIP LIGHTING TO LANDSCAPED AREAS
- STRIP LIGHTS IN AWNING SOFFIT

REFER TO SSDA 610000

| | | | | |
|-----|---------|---------------|----|-----|
| 04 | 14/4/21 | SSDA | MJ | |
| 03 | 26/3/21 | SSDA | KT | |
| 02 | 23/2/21 | Draft SSDA 02 | KT | |
| 01 | 12/2/21 | Draft SSDA | MJ | |
| rev | date | name | by | chk |

first studio architecture interiors landscape urban community
sydney melbourne uk
Level 5, 70 King Street t +61 2 9251 7077 w firststudio.com



project
Hastings Schools Port Macquarie
Hastings Secondary College
Port Macquarie NSW 2444

title
External Lighting Plan
External Lighting Plan - CAPA Lower
Ground L and B

| | | | |
|--------------|--------------------|--------------|---------|
| scale | 1:200 @ A1 | first issued | 12/2/21 |
| project code | sheet no. | revision | |
| HSPM | SSDA-610001 | 04 | |

0

2

5

10m

GENERAL NOTES

ALL DIMENSIONS AND EXISTING CONDITIONS


◦ SHALL BE CHECKED AND VERIFIED BY THE CONTRACTOR BEFORE PROCEEDING WITH THE WORK.

◦ ALL LEVELS RELATIVE TO 'AUSTRALIAN HEIGHT DATUM'.

◦ DO NOT SCALE DRAWINGS.


◦ USE FIGURED DIMENSIONS ONLY.

legend

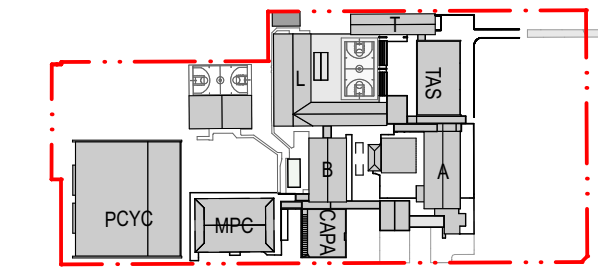

- LOW LEVEL BOLLARD MOUNTED LIGHT
- VERTICAL UP/DOWN LIGHT TO AWNING COLUMN
- VERTICAL UPLIGHT
- STRIP LIGHTING TO LANDSCAPED AREAS
- STRIP LIGHTS IN AWNING SOFFIT

1 PLAN External Lighting - Lower Ground L and B
1:100

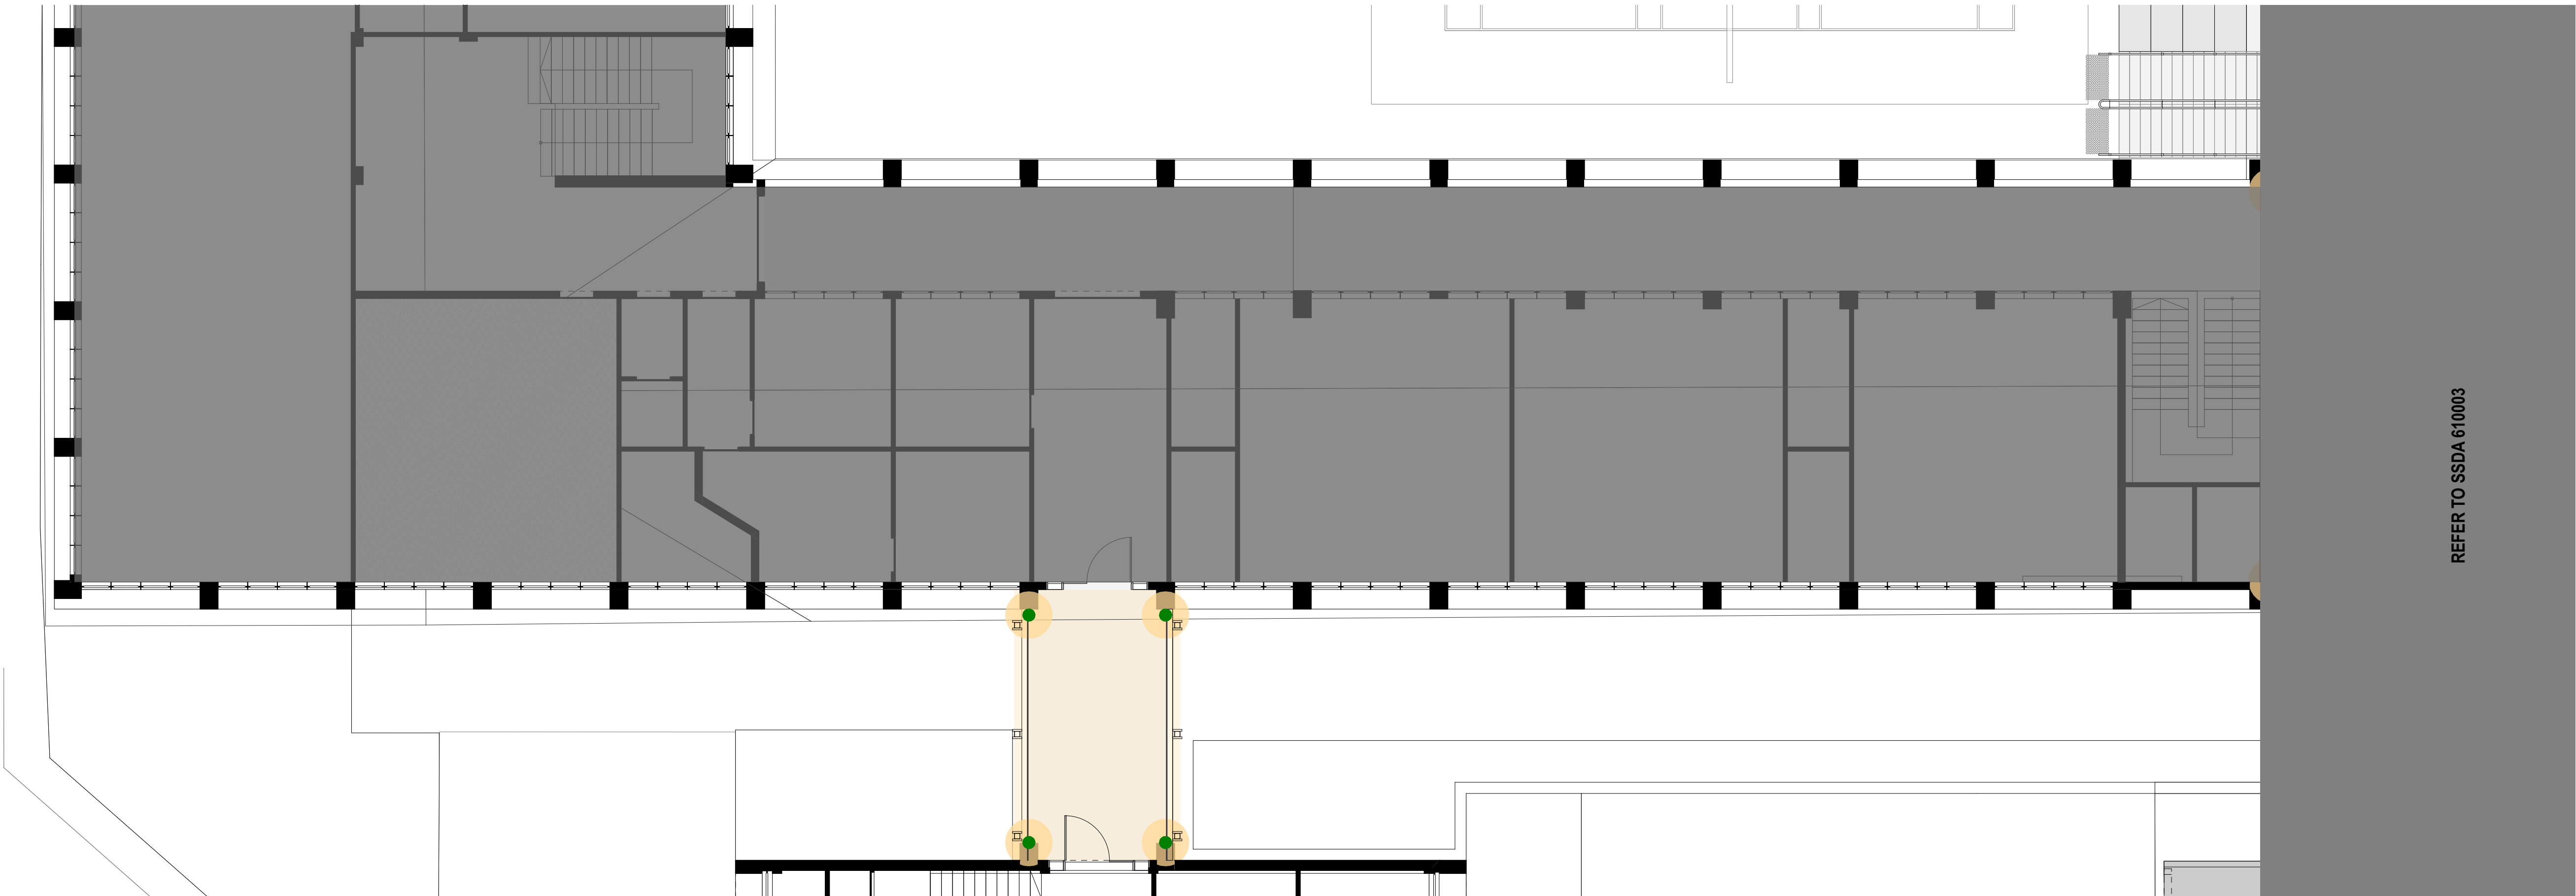

2 PLAN External Lighting - Ground TAS, Level 1 Block L
1:100

| | | | | |
|-----|---------|---------------|----|-----|
| 04 | 14/4/21 | SSDA | MJ | |
| 03 | 26/3/21 | SSDA | KT | |
| 02 | 23/2/21 | Draft SSDA 02 | KT | |
| 01 | 12/2/21 | Draft SSDA | MJ | |
| rev | date | name | by | chk |

fjmt studio architecture interiors landscape urban community

sydney melbourne uk

Level 5, 70 King Street t +61 2 9251 7077 w [fjmtstudio.com](#)

fjmt

project

Hastings Schools Port Macquarie

Hastings Secondary College

Port Macquarie NSW 2444

title

External Lighting Plan

External Lighting Plan - Link Bridge

scale

1:200 @ A1

first issued

12/2/21

project code

sheet no.

revision

HSPM

SSDA-610002

04

02510m

GENERAL NOTES


ALL DIMENSIONS AND EXISTING CONDITIONS SHALL BE CHECKED AND VERIFIED BY THE CONTRACTOR BEFORE PROCEEDING WITH THE WORK.

ALL LEVELS RELATIVE TO 'AUSTRALIAN HEIGHT DATUM'.

DO NOT SCALE DRAWINGS.

USE FIGURED DIMENSIONS ONLY.


legend

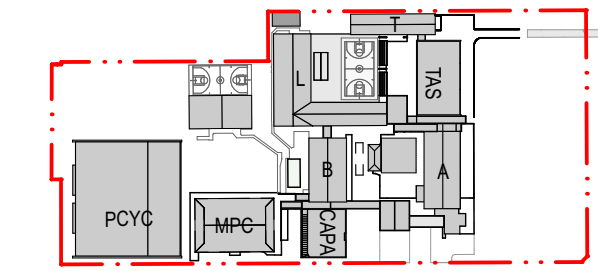

- LOW LEVEL BOLLARD MOUNTED LIGHT
- VERTICAL UP/DOWN LIGHT TO AWNING COLUMN
- VERTICAL UPLIGHT
- STRIP LIGHTING TO LANDSCAPED AREAS
- STRIP LIGHTS IN AWNING SOFFIT

REFER TO SSDA 610002

1 PLAN External Lighting - Lower Ground L and B
1:100

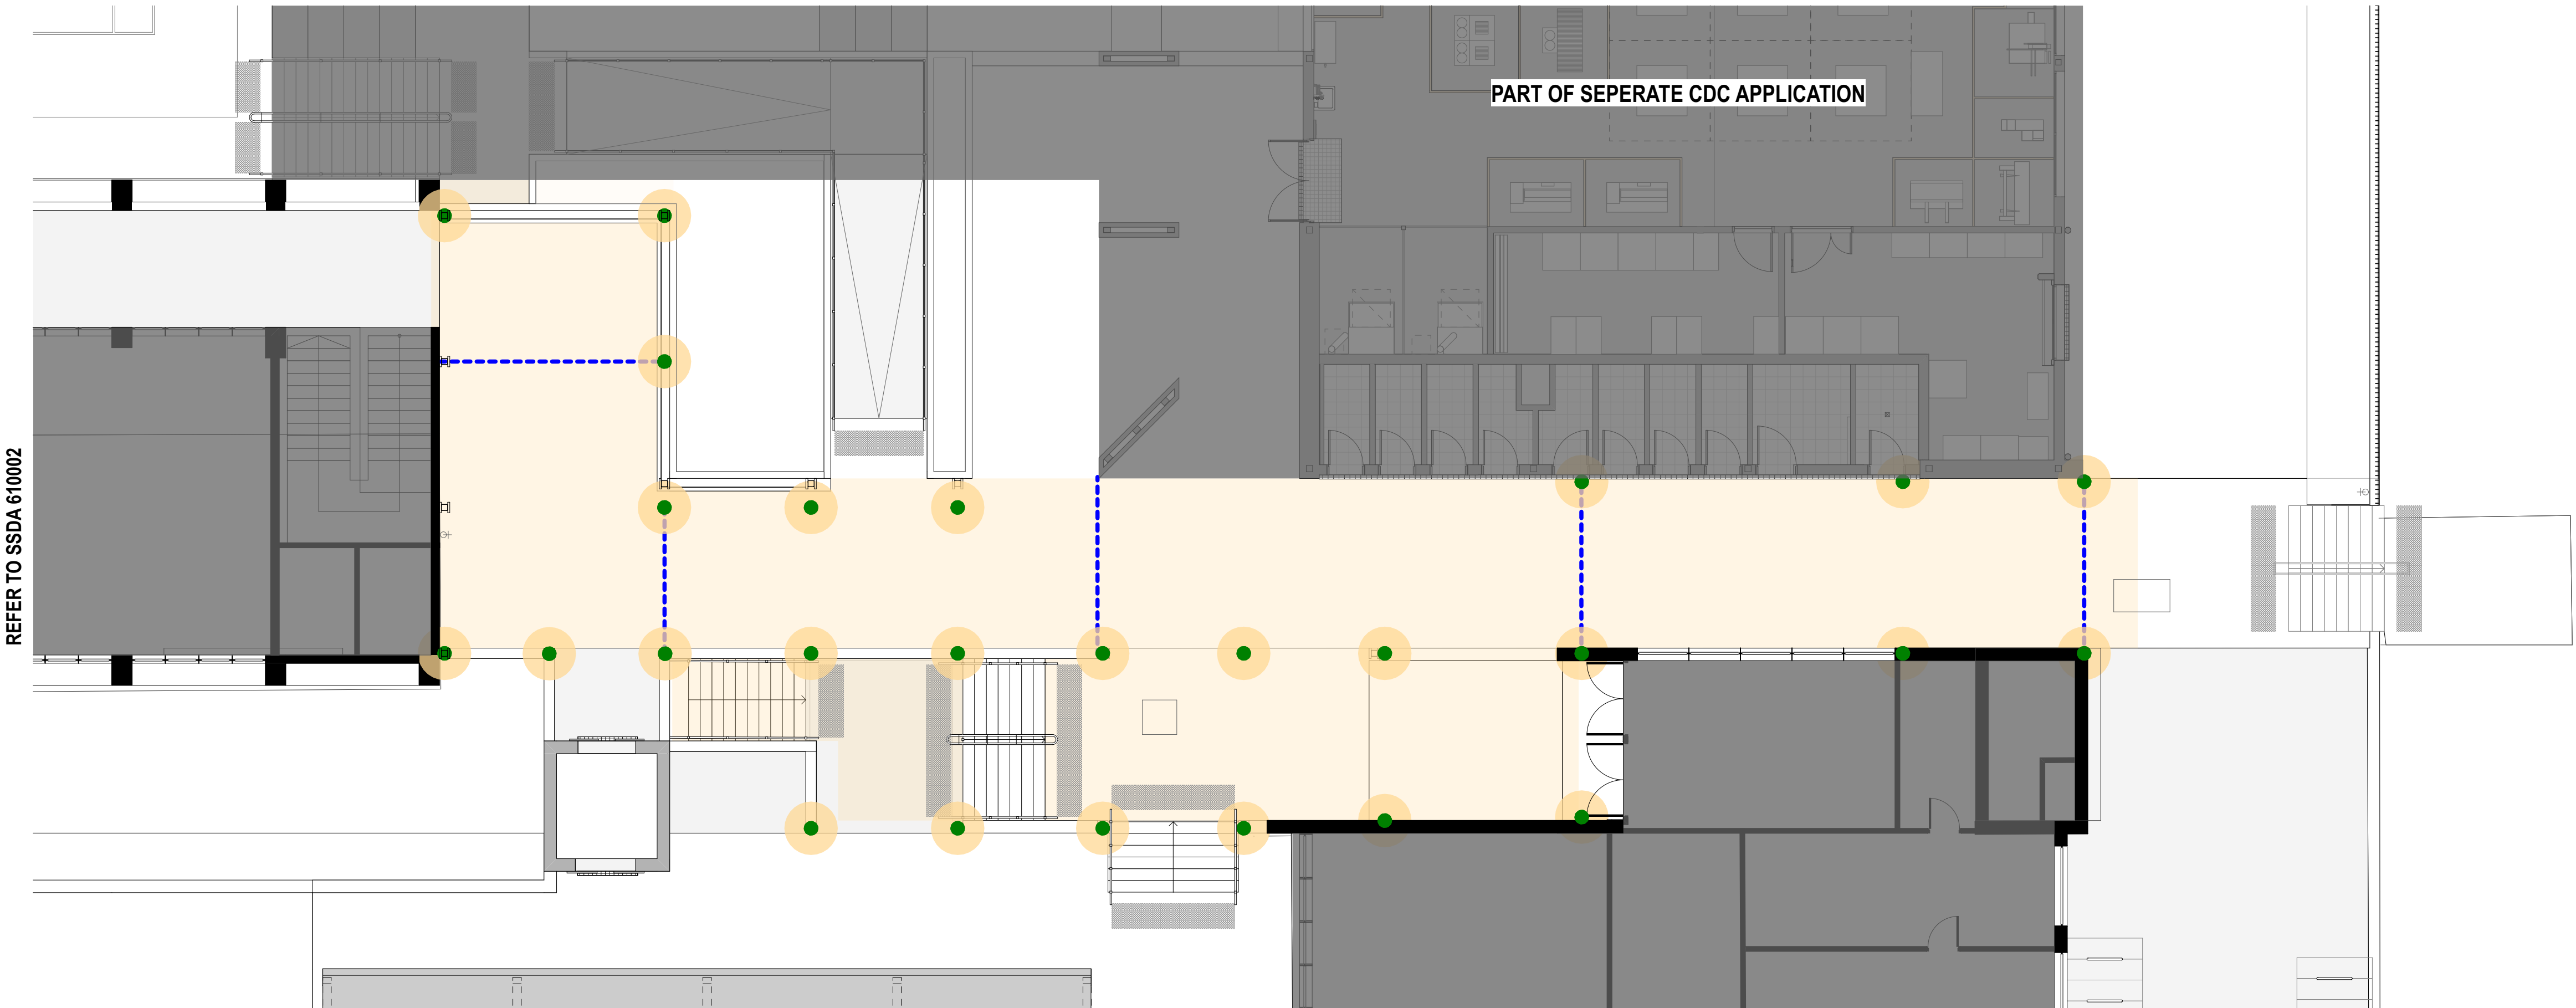

REFER TO SSDA 610002

2 PLAN External Lighting - Ground TAS, Level 1 Block L
1:100

| | | | |
|-----|---------|---------------|--------|
| 04 | 14/4/21 | SSDA | MJ |
| 03 | 26/3/21 | SSDA | KT |
| 02 | 23/2/21 | Draft SSDA 02 | KT |
| 01 | 12/2/21 | Draft SSDA | MJ |
| rev | date | name | by chk |

fjmt studio architecture interiors landscape urban community
sydney melbourne uk
Level 5, 70 King Street t +61 2 9251 7077 w fjmtstudio.com

fjmt

project

Hastings Schools Port Macquarie
Hastings Secondary College
Port Macquarie NSW 2444

| | | | |
|---|--|-------------|----------|
| title | | | |
| External Lighting Plan External Lighting Plan - North South Link | | | |
| scale 1:200 @ A1 first issued 12/2/21 | | | |
| project code | | sheet no. | revision |
| HSPM | | SSDA-610003 | 04 |



1 3D VIEW Streetscape - Top of hill- Looking Downhill



2 3D VIEW Streetscape - Entry - Looking Downhill



3 3D VIEW Streetscape - CAPA - Looking Downhill



4 3D VIEW Streetscape - PCYC - Downhill



5 3D VIEW Streetscape - Uphill



6 3D VIEW Streetscape - Entry - Uphill



7 3D VIEW Streetscape - CAPA - Uphill




8 3D VIEW Streetscape - PCYC - Uphill




9 3D VIEW Streetscape - TAS - Corner




10 3D VIEW Streetscape - TAS - Rear

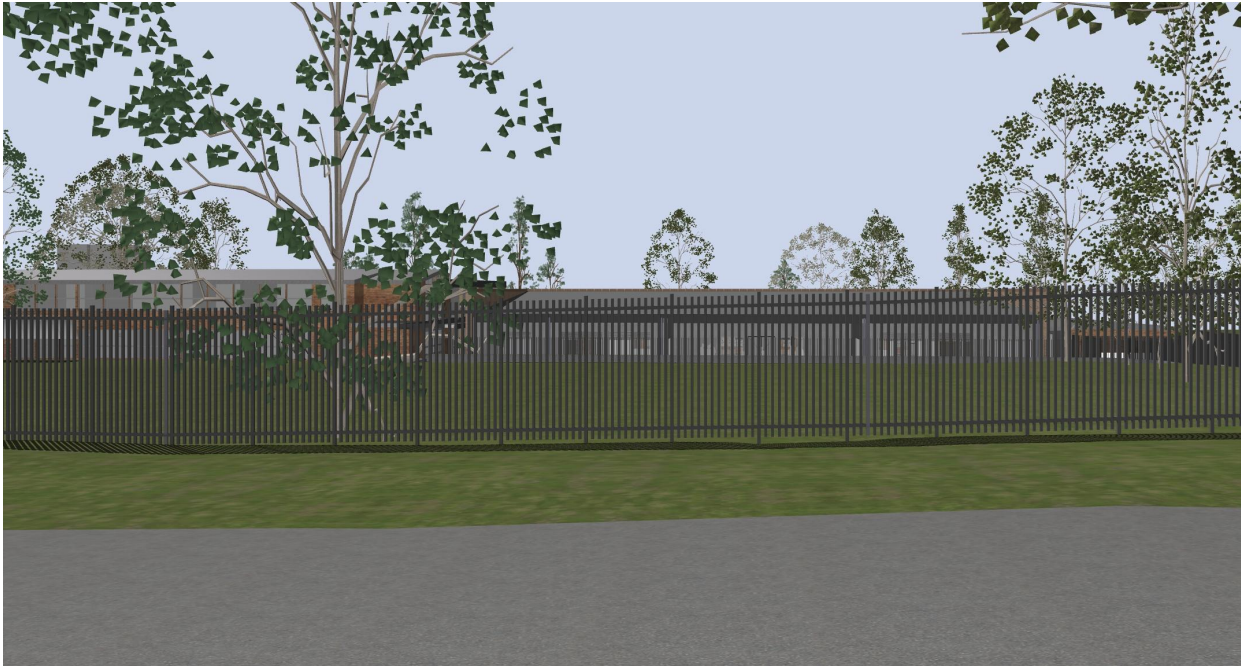

11 3D VIEW TAS REAR - MID

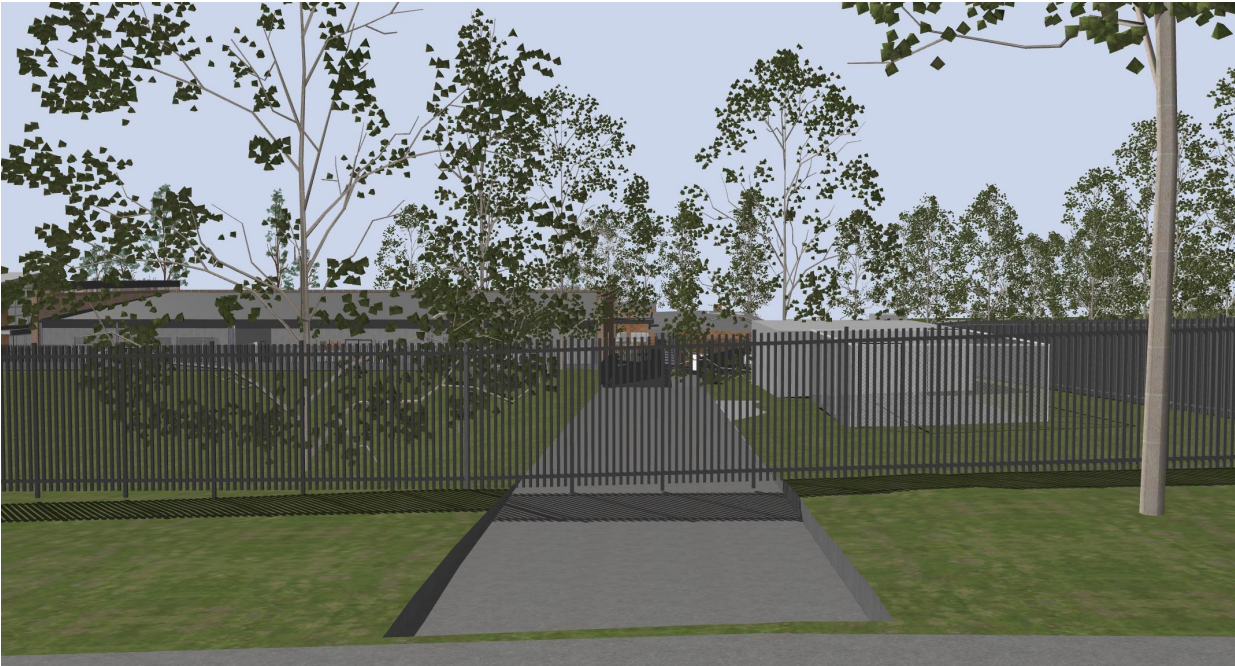

12 3D VIEW Streetscape - Tas Rear 2

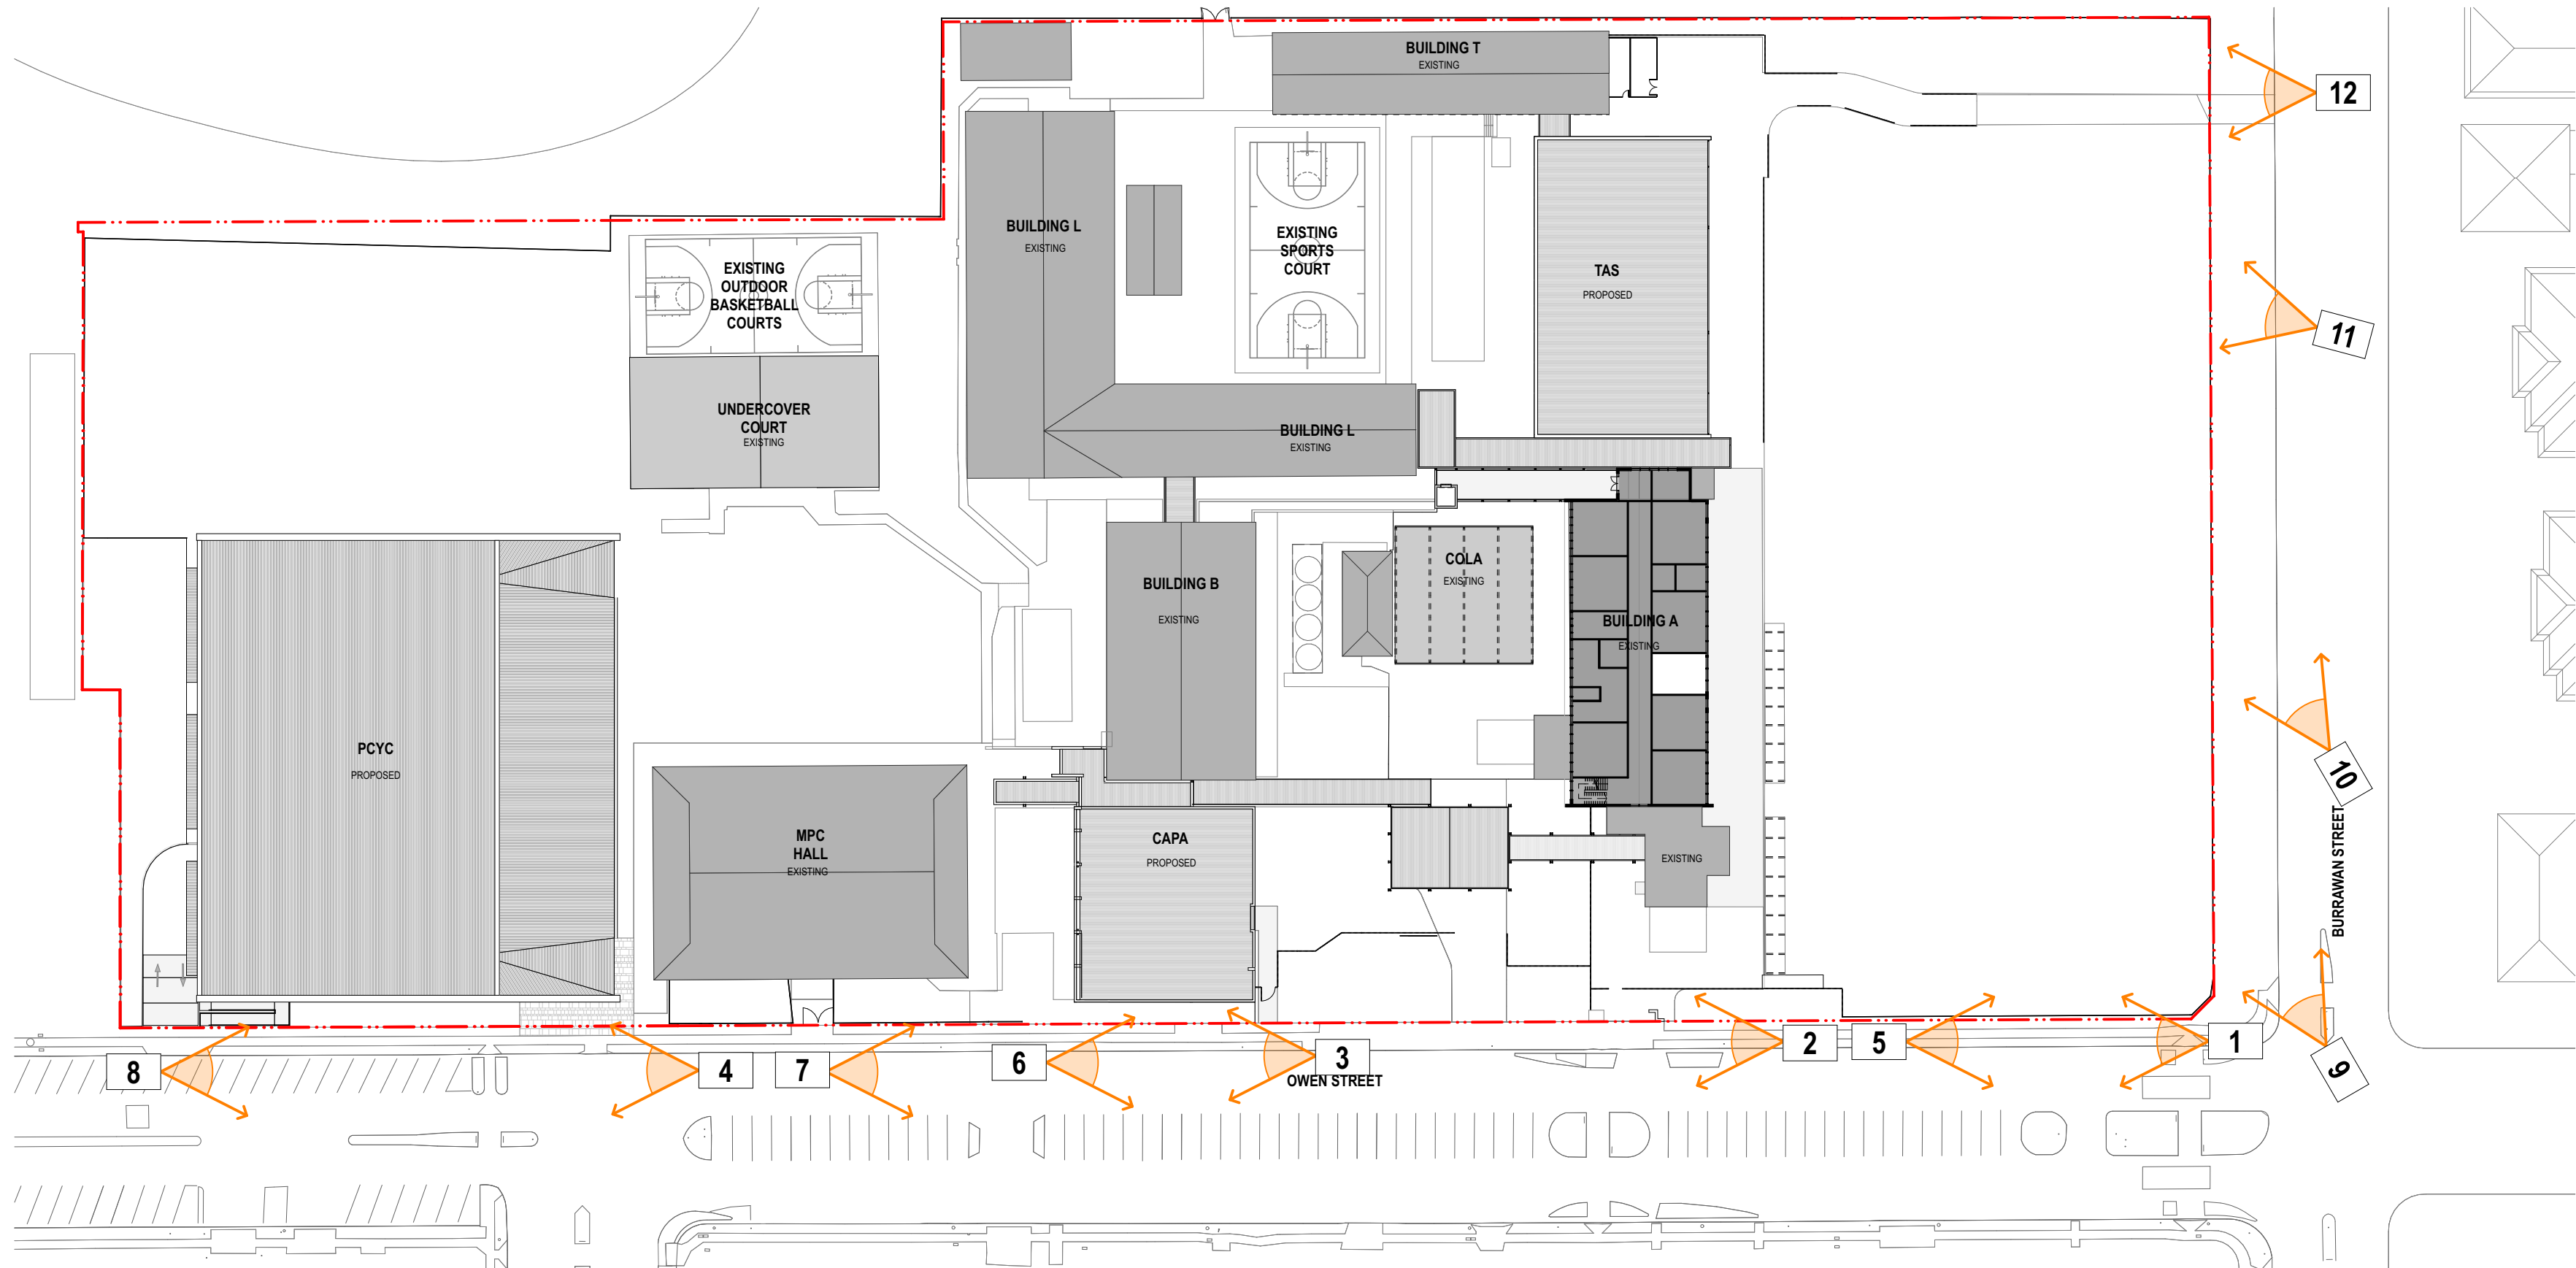

13 PLAN Views Keyplan


GENERAL NOTES

- ALL DIMENSIONS AND EXISTING CONDITIONS SHALL BE CHECKED AND VERIFIED BY THE CONTRACTOR BEFORE PROCEEDING WITH THE WORK.
- ALL LEVELS RELATIVE TO AUSTRALIAN HEIGHT DATUM.
- DO NOT SCALE DRAWINGS.
- USE FIGURED DIMENSIONS ONLY.


Legend

NOTE


EXISTING BUILDING LEVELS ARE APPROXIMATE.

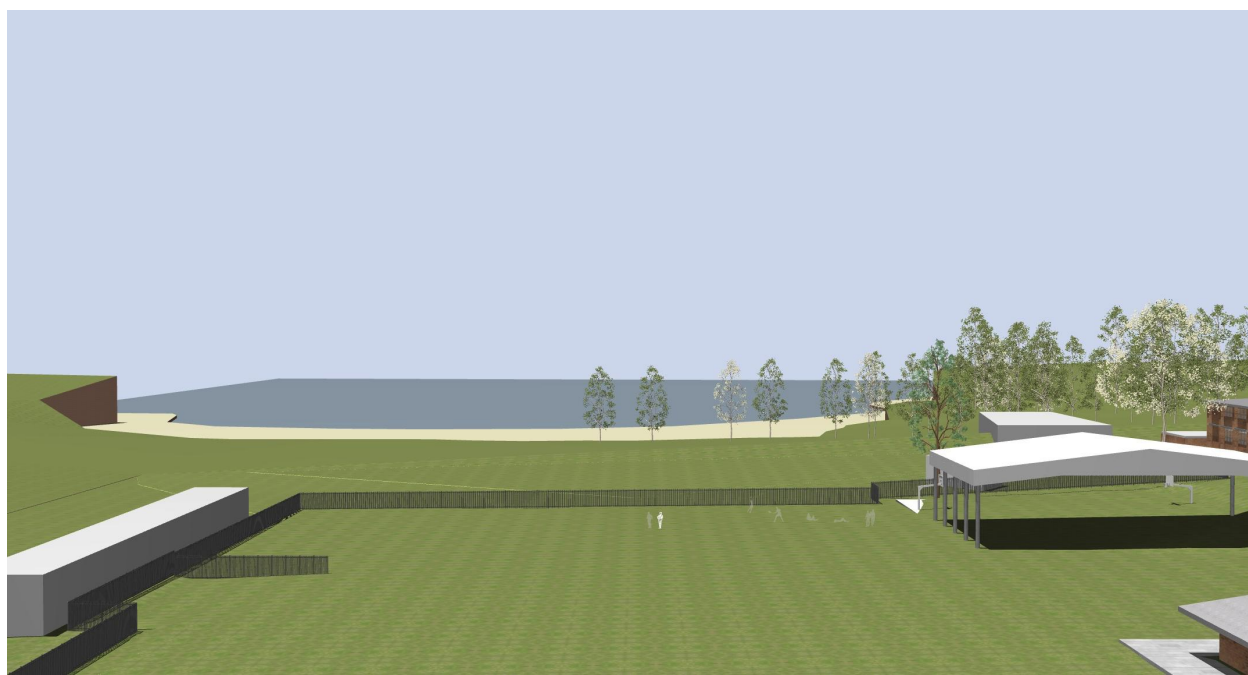

1 3D VIEW PCYC - RL +32900 / 22625 AFFL

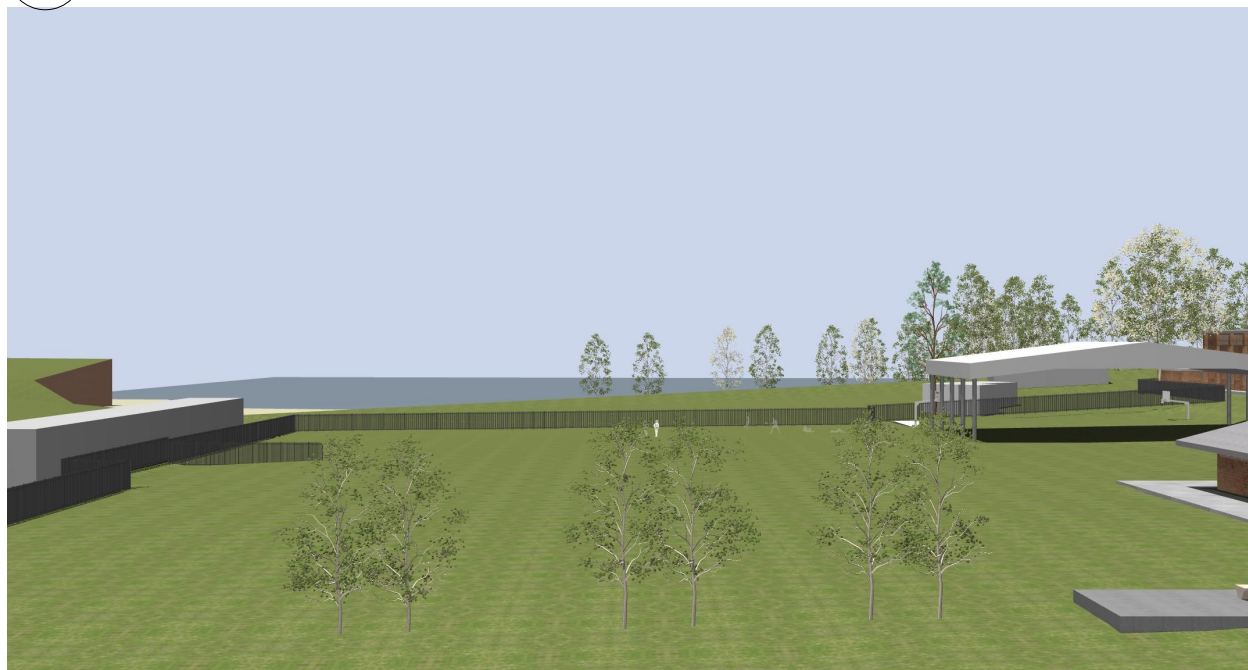


2 3D VIEW PCYC - RL +21245 / 11000 AFFL

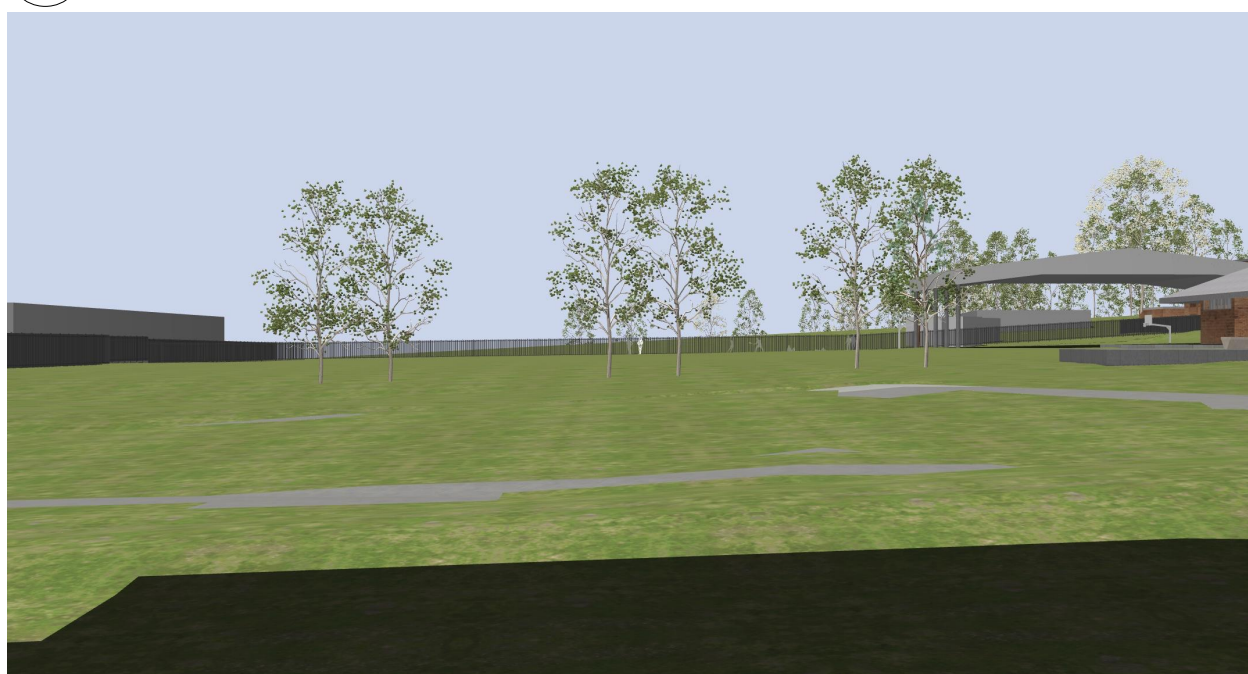

3 3D VIEW PCYC - RL +11940 / 1700 AFFL



4 3D VIEW PCYC - RL +32900 / 22625 AFFL

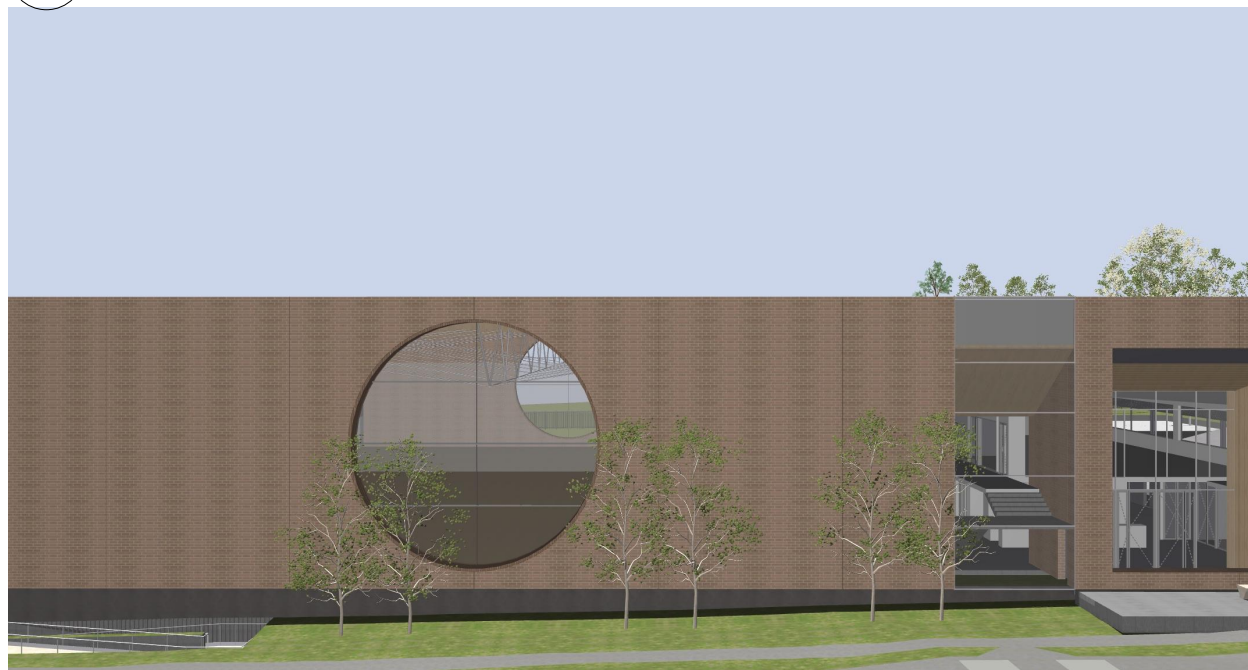

5 3D VIEW PCYC - RL +21245 / 11000 AFFL




6 3D VIEW PCYC - RL +11940 / 1700 AFFL



7 3D VIEW PCYC, Sports Field



8 3D VIEW CAPA From Owen St

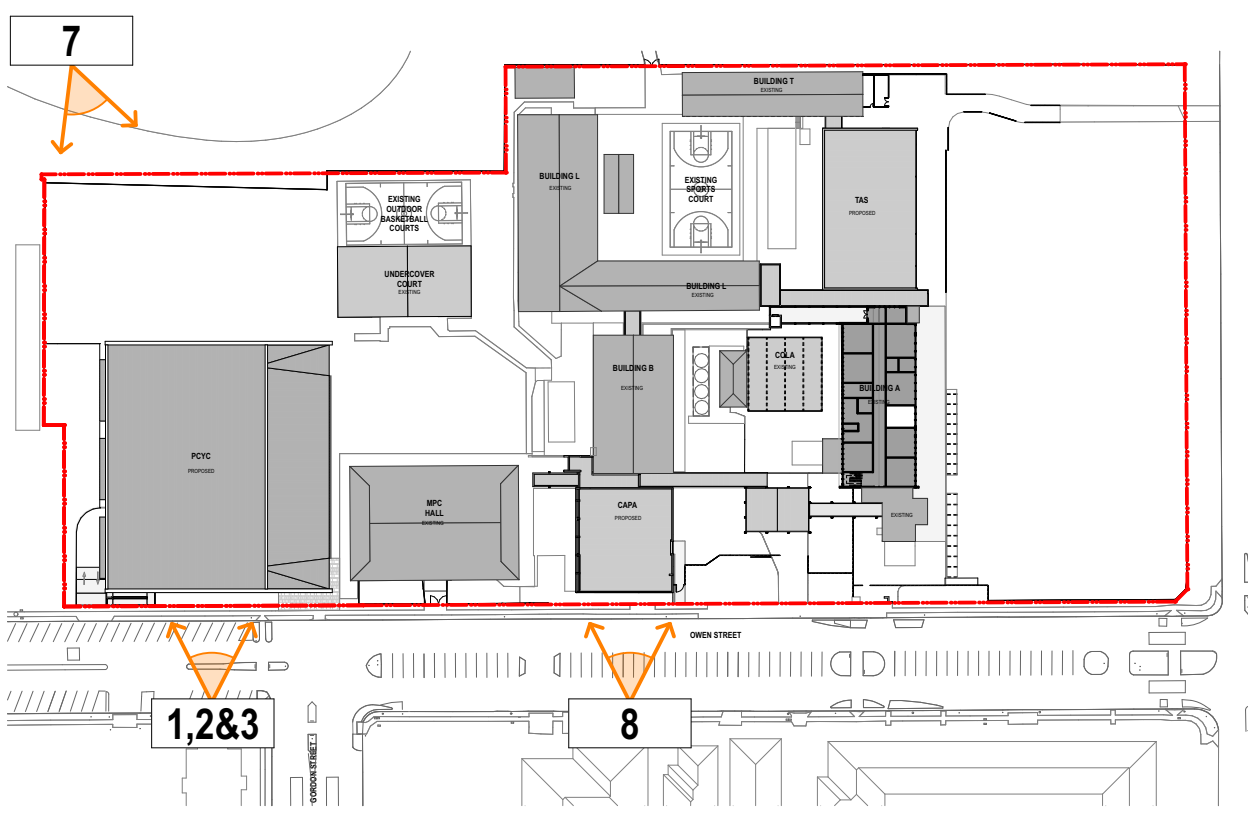


9 PLAN Views Keyplan




10 3D VIEW 14 Owen St Typical Plan



11 ELEVATION PCYC View Analysis

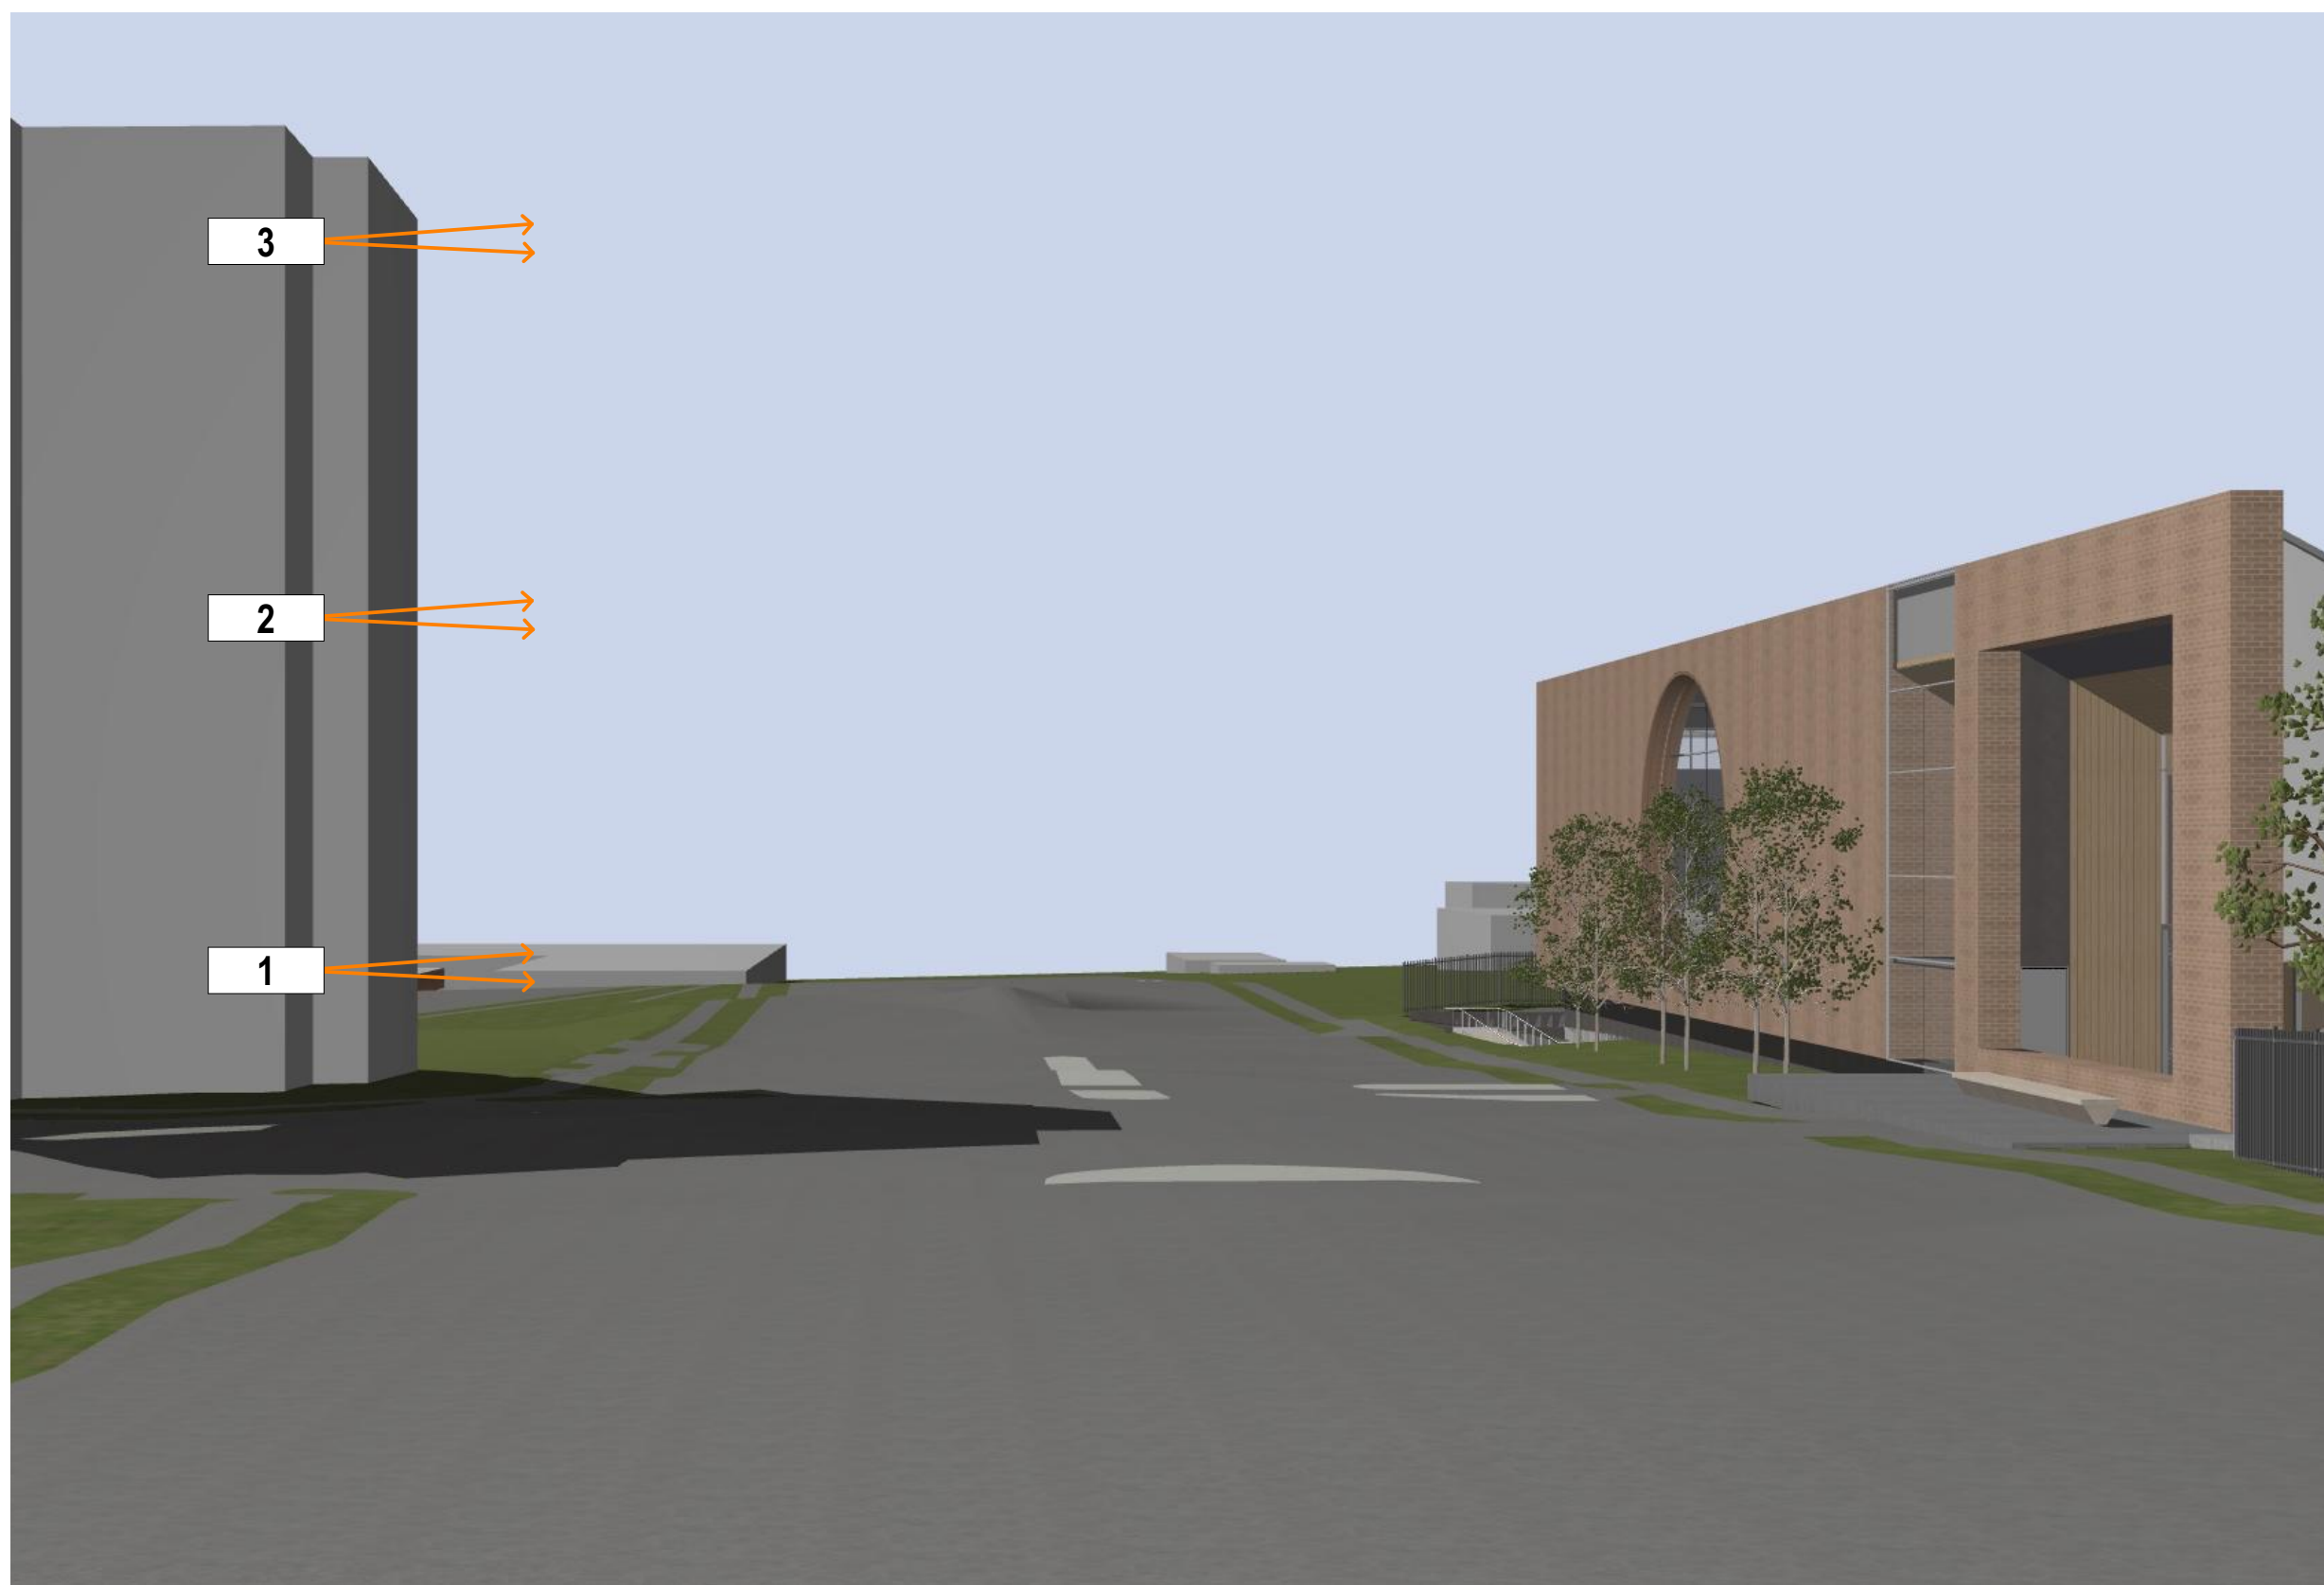

12 3D VIEW Owen Street North

 

GENERAL NOTES

- ALL DIMENSIONS AND EXISTING CONDITIONS SHALL BE CHECKED AND VERIFIED BY THE CONTRACTOR BEFORE PROCEEDING WITH THE WORK.
- ALL LEVELS RELATIVE TO AUSTRALIAN HEIGHT DATUM.
- DO NOT SCALE DRAWINGS.
- USE FIGURED DIMENSIONS ONLY.

Legend

NOTE
- EXISTING BUILDING LEVELS ARE APPROXIMATE.


fjmt studio architecture interiors landscape urban community
sydney melbourne uk
Level 5, 70 King Street t +61 2 9251 7077 w fjmtstudio.com




project
Hastings Schools Port Macquarie
Hastings Secondary College
Port Macquarie NSW 2444

title
View Analysis
View Analysis - PCYC & CAPA


| | | |
|--------------|--------------------|-----------|
| scale | first issued | 12/2/21 |
| project code | sheet no. | revision |
| HSPM | SSDA-620001 | 04 |

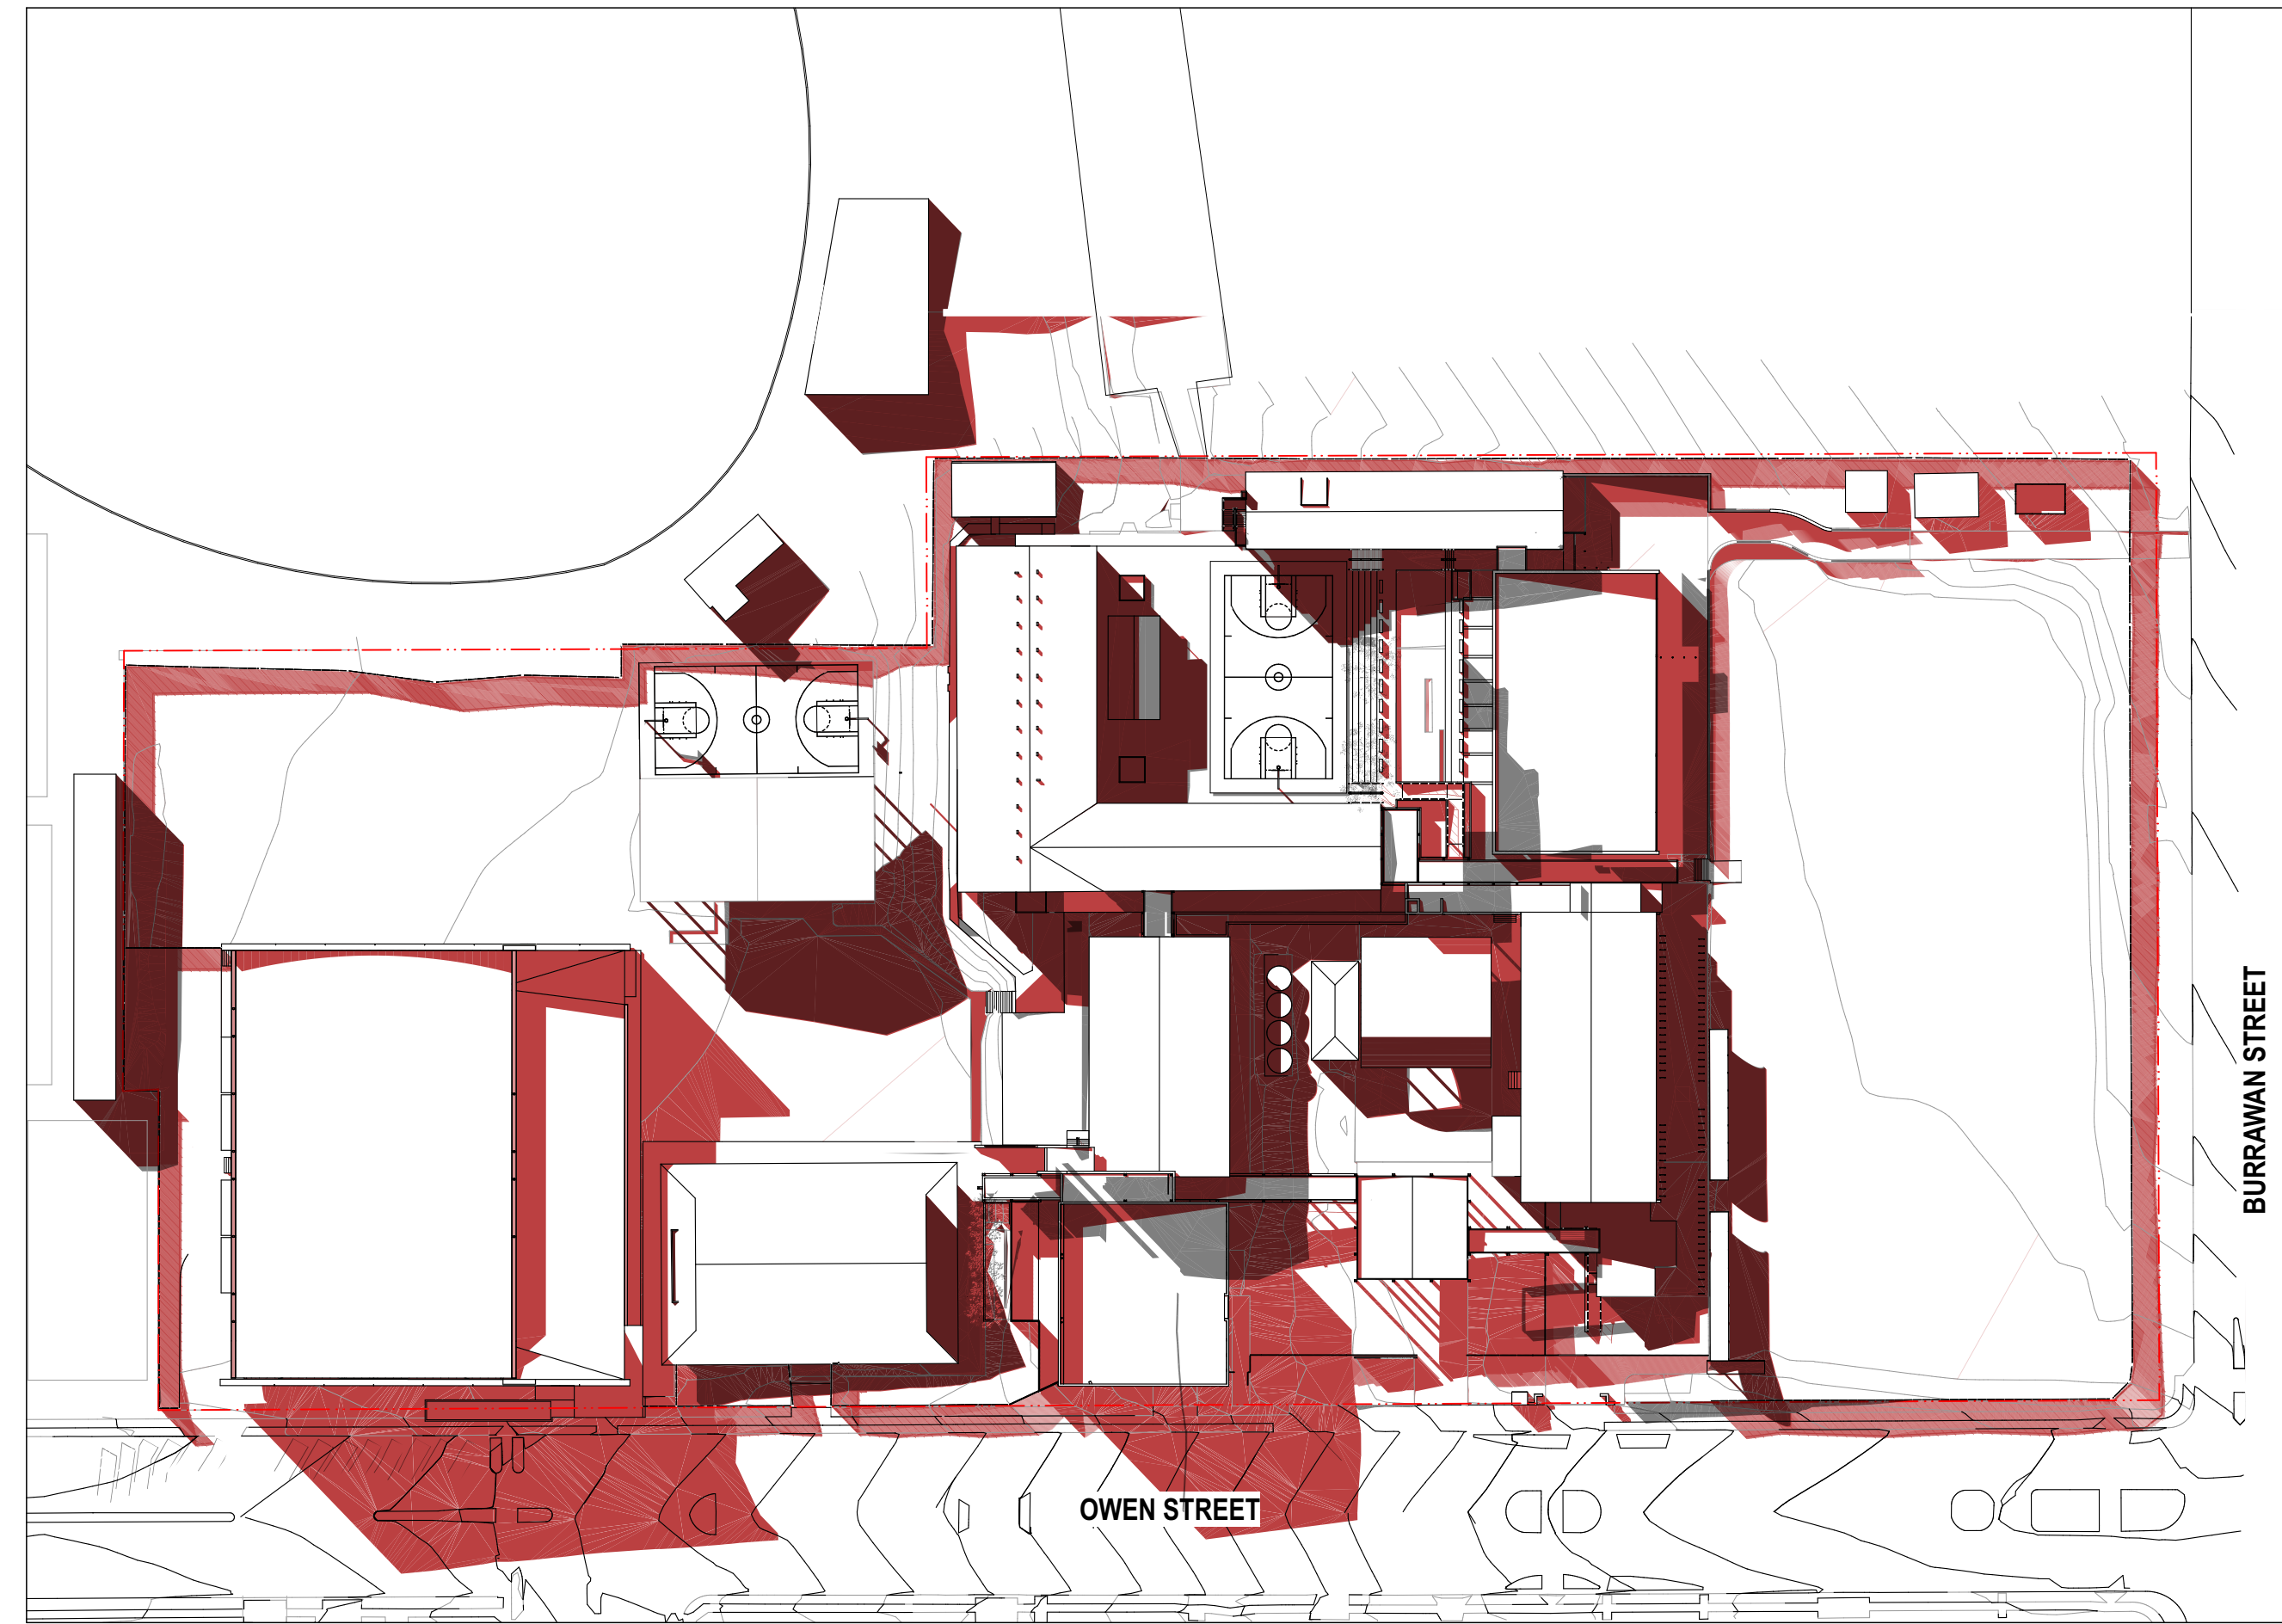

01 3D VIEW Shadow Diagram - June 21 9am
NTS

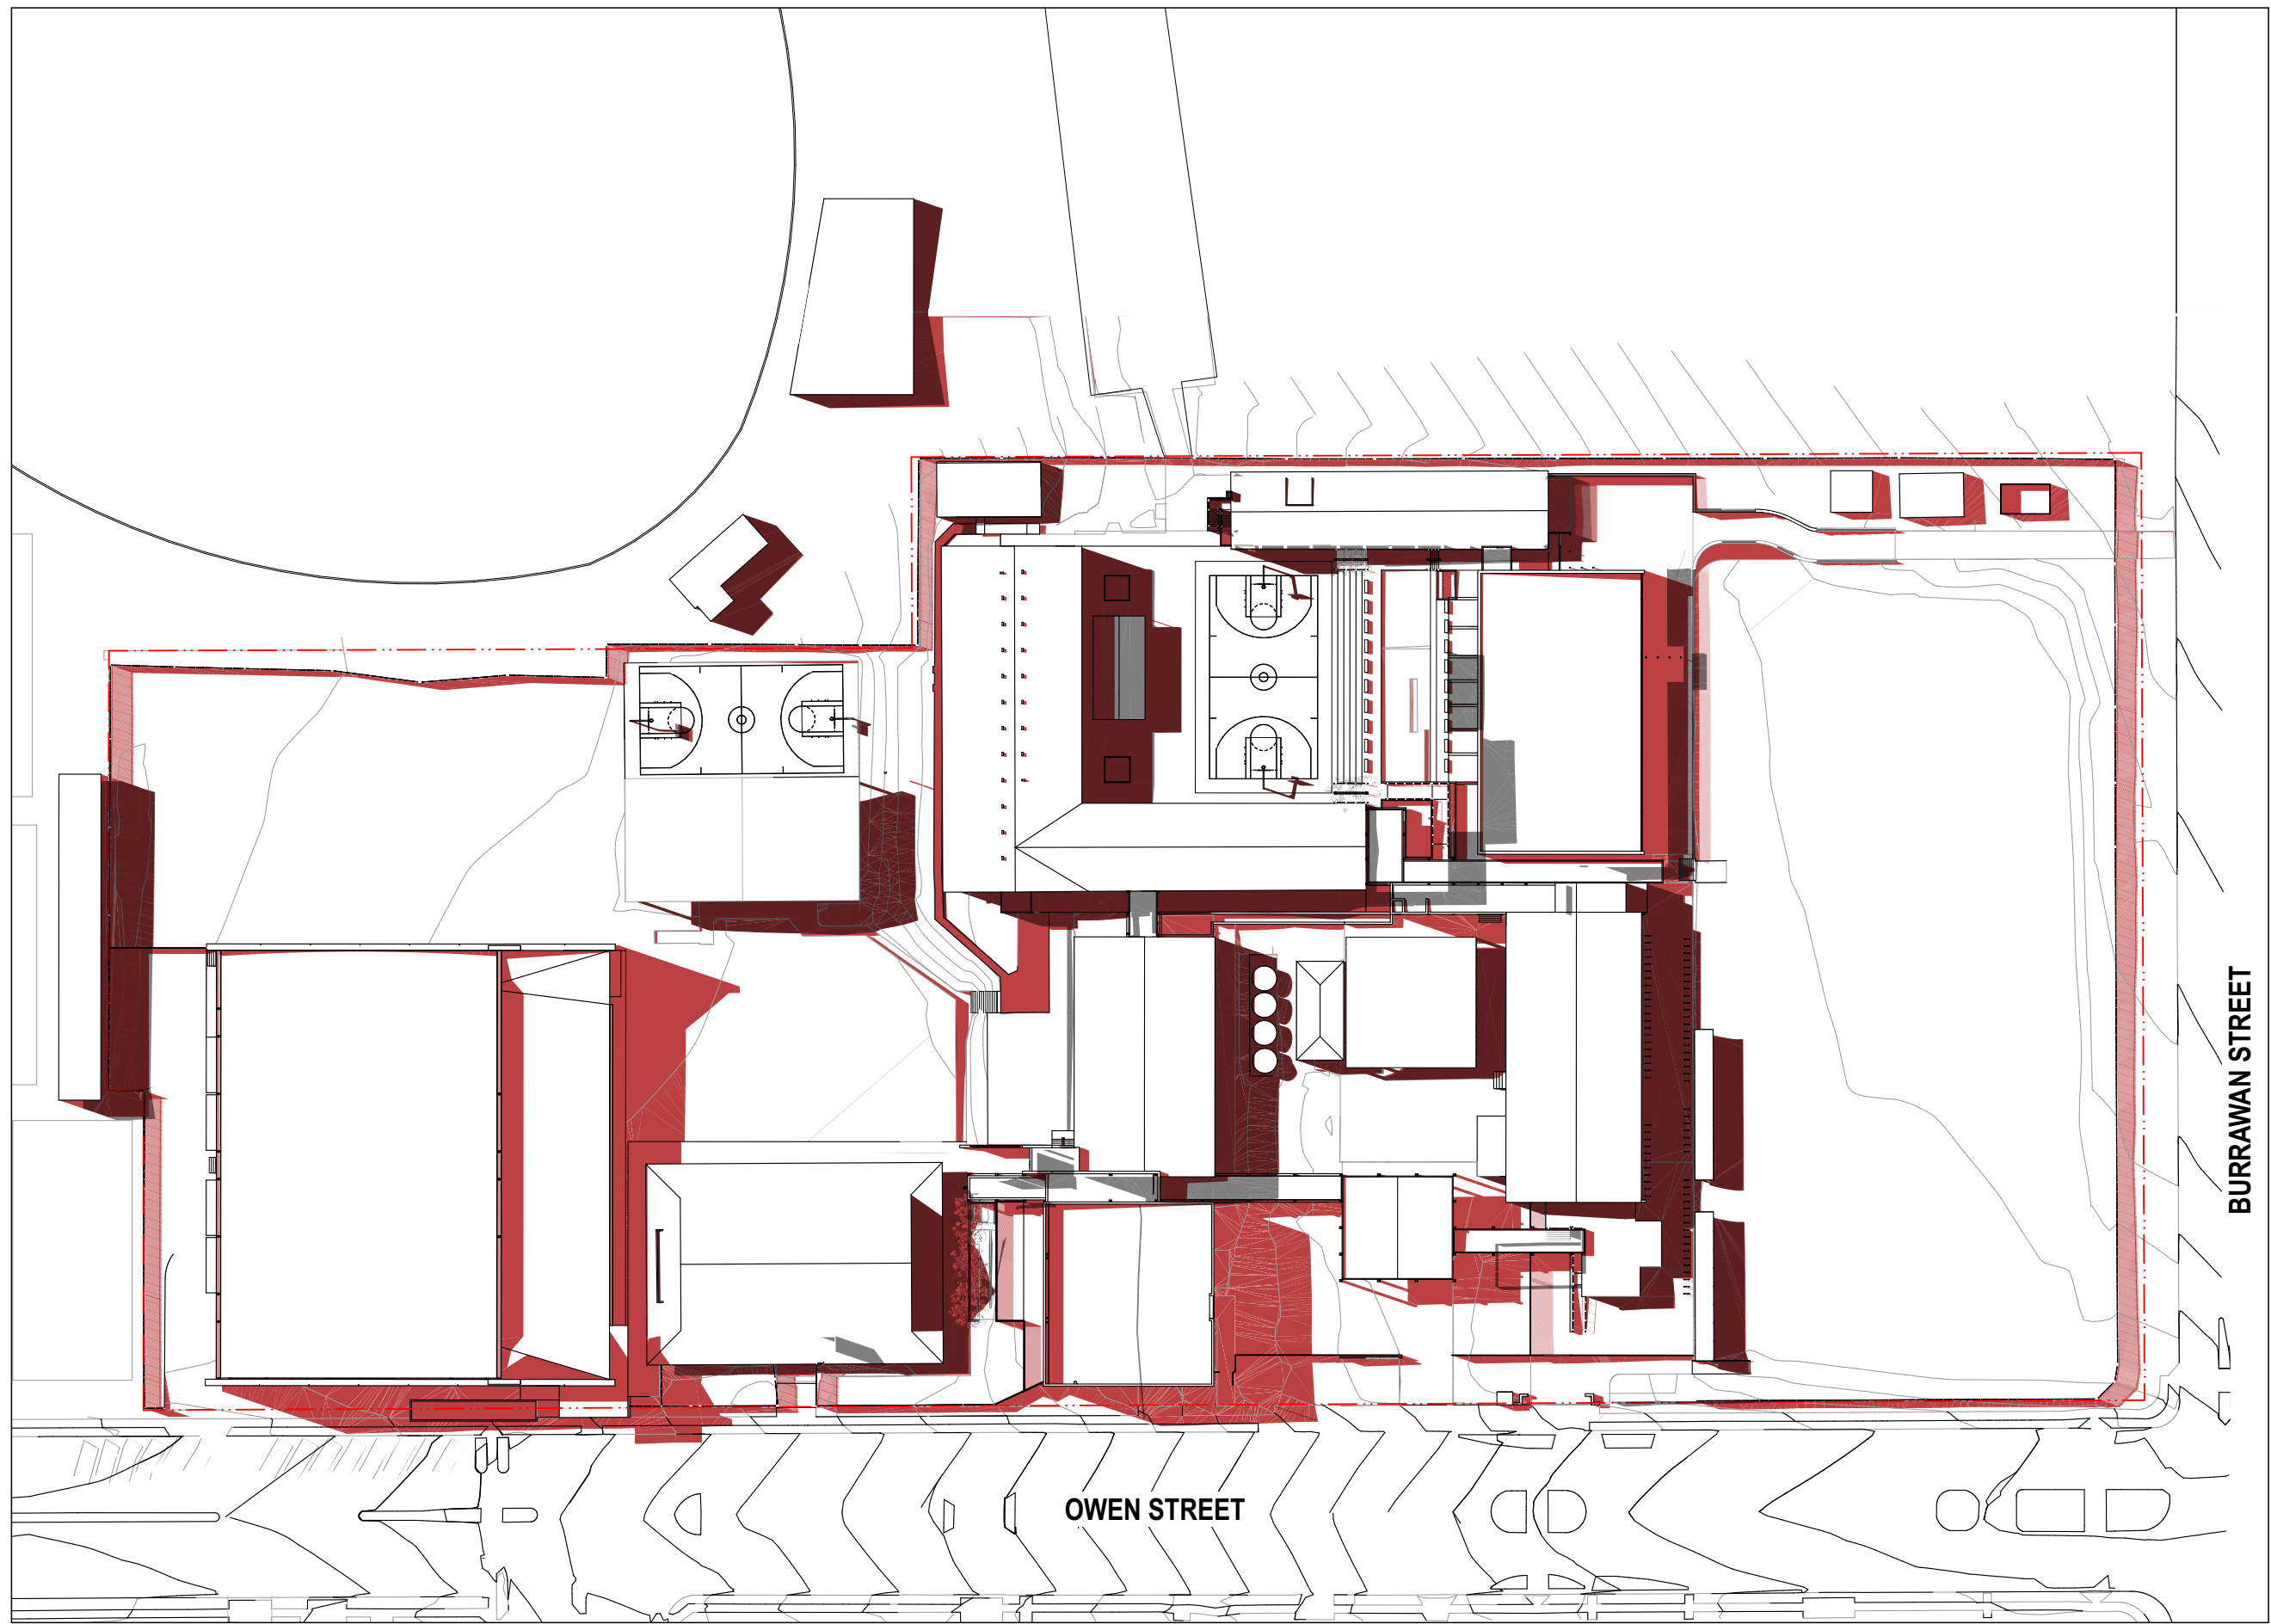

02 3D VIEW Shadow Diagram - June 21 11am
NTS

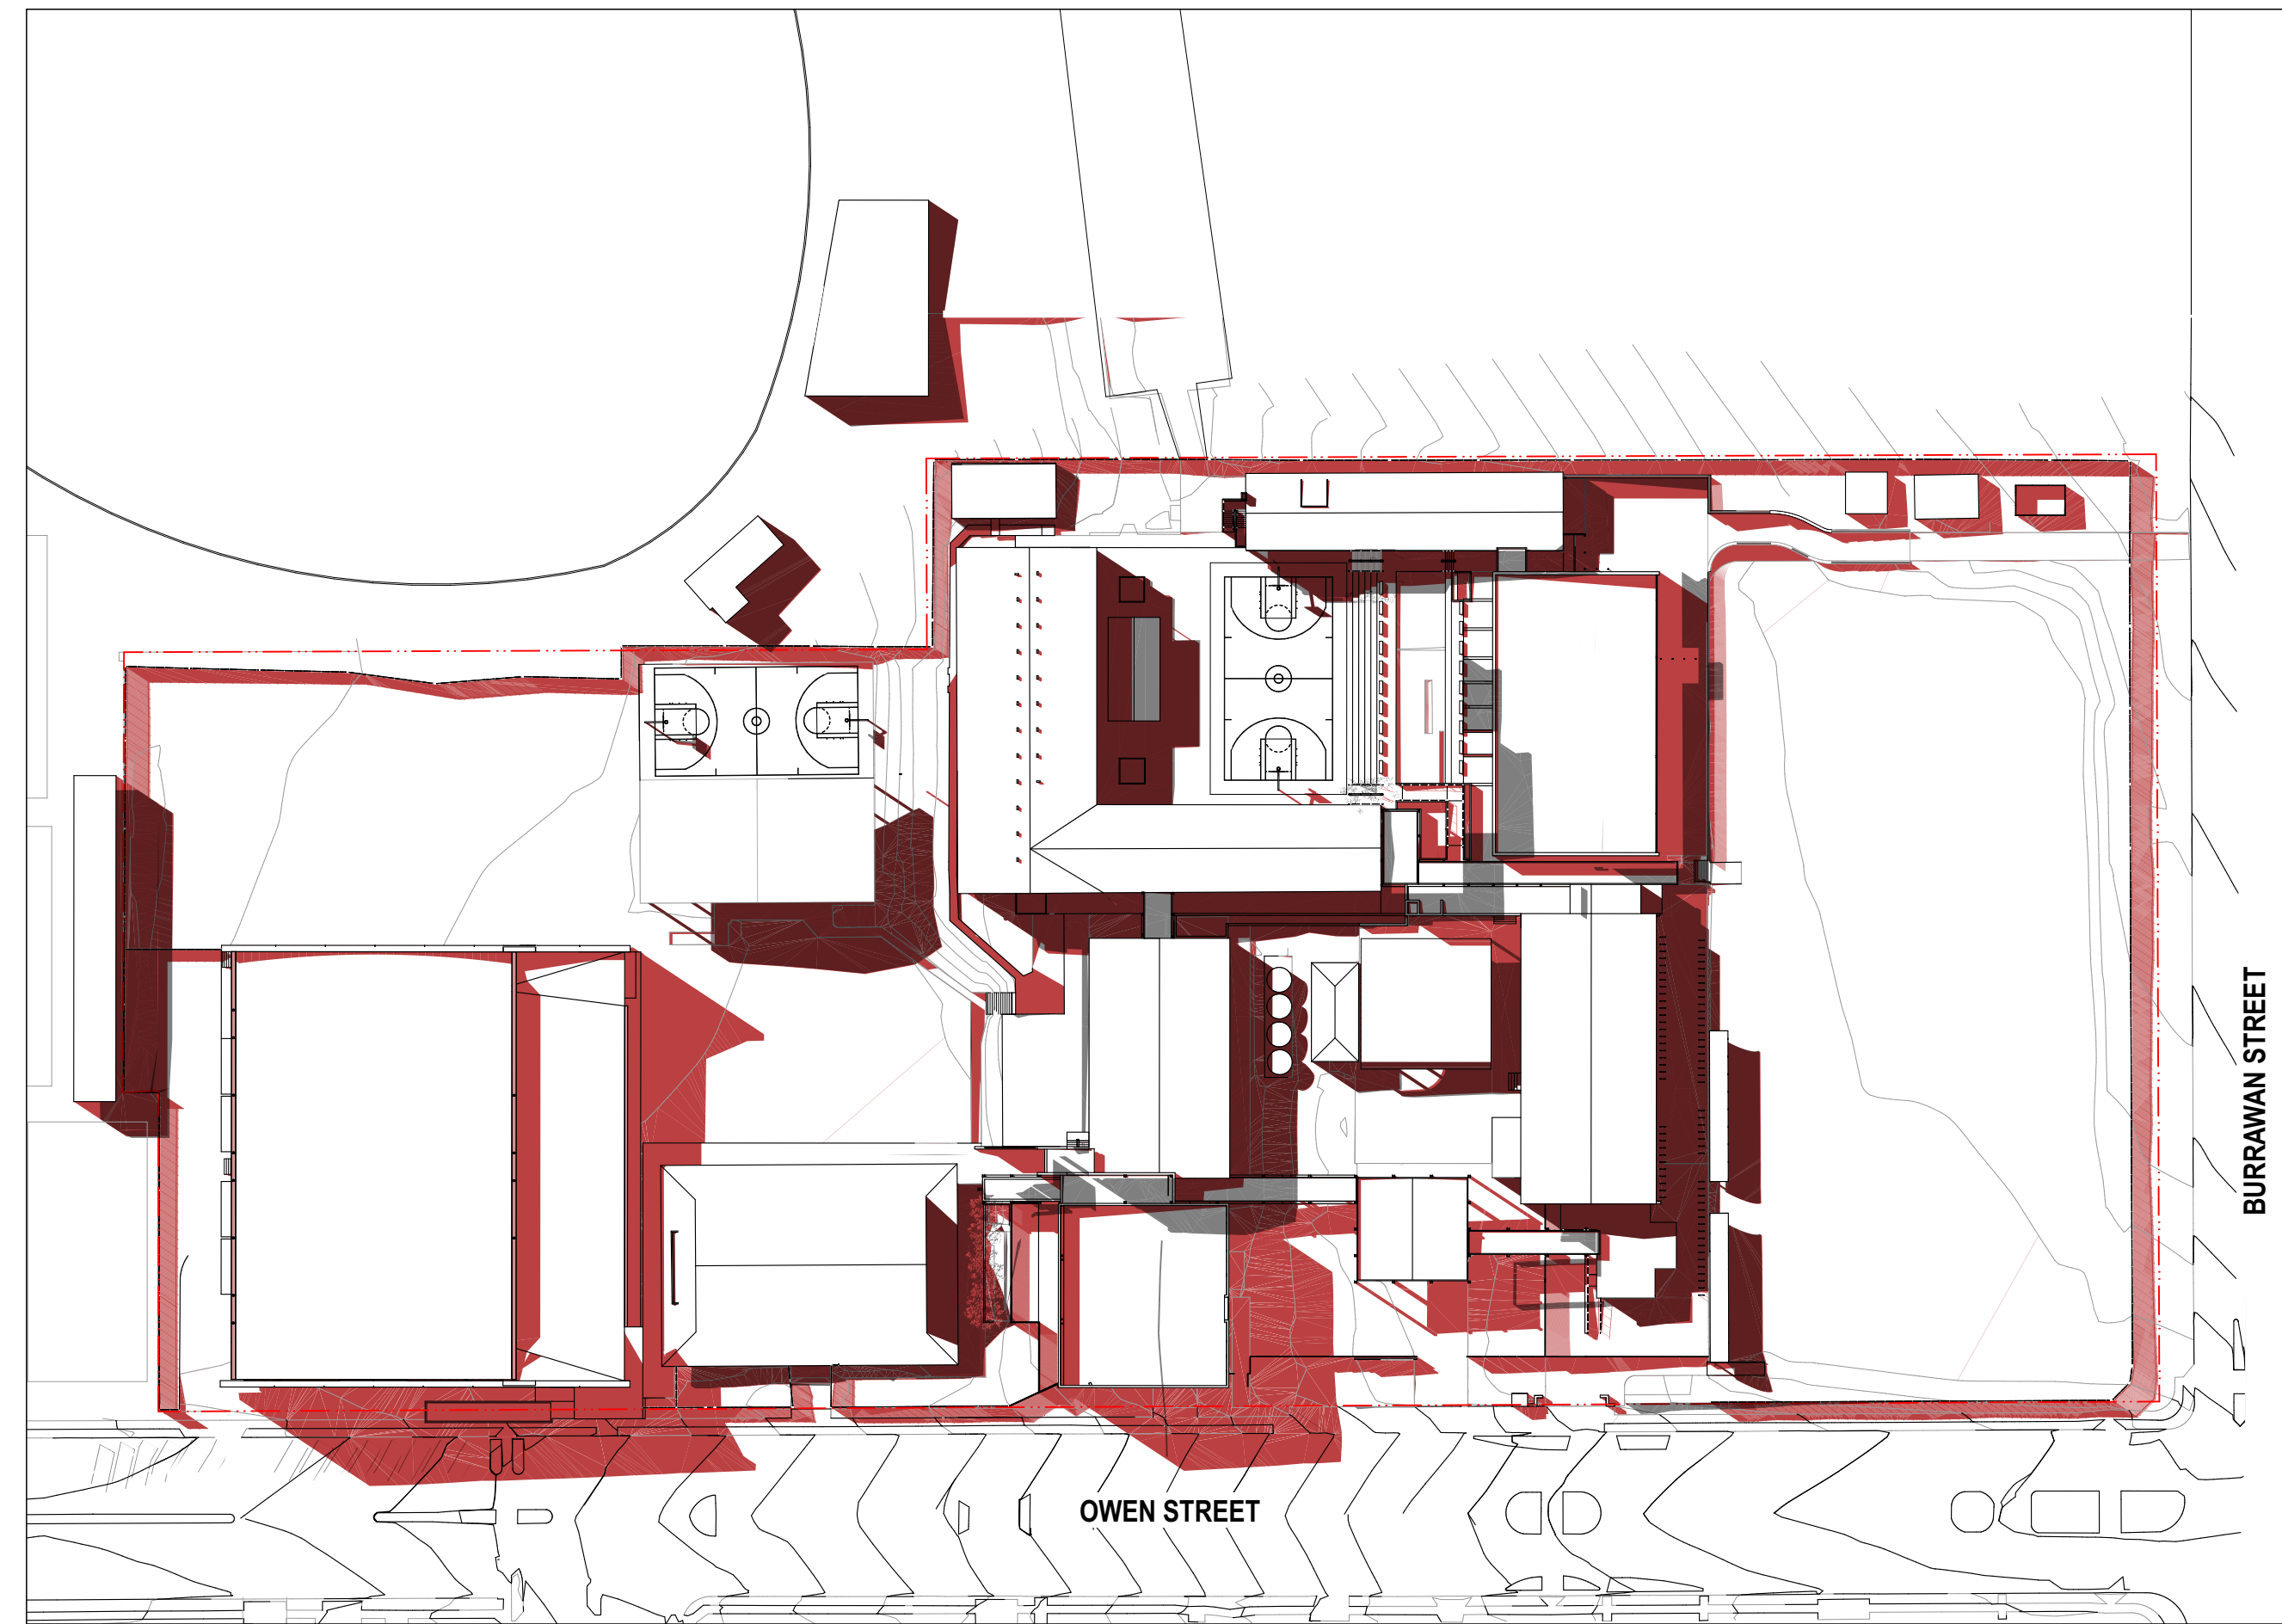

03 3D VIEW Shadow Diagram - June 21 10am
NTS



04 3D VIEW Shadow Diagram - June 21 12pm
NTS

GENERAL NOTES

- ALL DIMENSIONS AND EXISTING CONDITIONS SHALL BE CHECKED AND VERIFIED BY THE CONTRACTOR BEFORE PROCEEDING WITH THE WORK.
- ALL LEVELS RELATIVE TO AUSTRALIAN HEIGHT DATUM.
- DO NOT SCALE DRAWINGS.
- USE FIGURED DIMENSIONS ONLY.

legend

- SITE BOUNDARY
- EXISTING SHADOW EXTENT
- PROPOSED SHADOW EXTENT

| | | | | |
|-----|---------|---------------|----|-----|
| 04 | 14/4/21 | SSDA | MJ | |
| 03 | 26/3/21 | SSDA | KT | |
| 02 | 23/2/21 | Draft SSDA 02 | KT | |
| 01 | 12/2/21 | Draft SSDA | MJ | |
| rev | date | name | by | chk |

fjmt studio architecture interiors landscape urban community
sydney melbourne uk
Level 5, 70 King Street t +61 2 9251 7077 w fjmtstudio.com



project
Hastings Schools Port Macquarie
Hastings Secondary College
Port Macquarie NSW 2444

title
Shadow Diagrams
Sun Study Diagram June 21

| | | | |
|--------------|--------------------|--------------|---------|
| scale | 1:200 @ A1 | first issued | 12/2/21 |
| project code | sheet no. | revision | |
| HSPM | SSDA-630000 | 04 | |