


GF HVAC SCHEMATIC

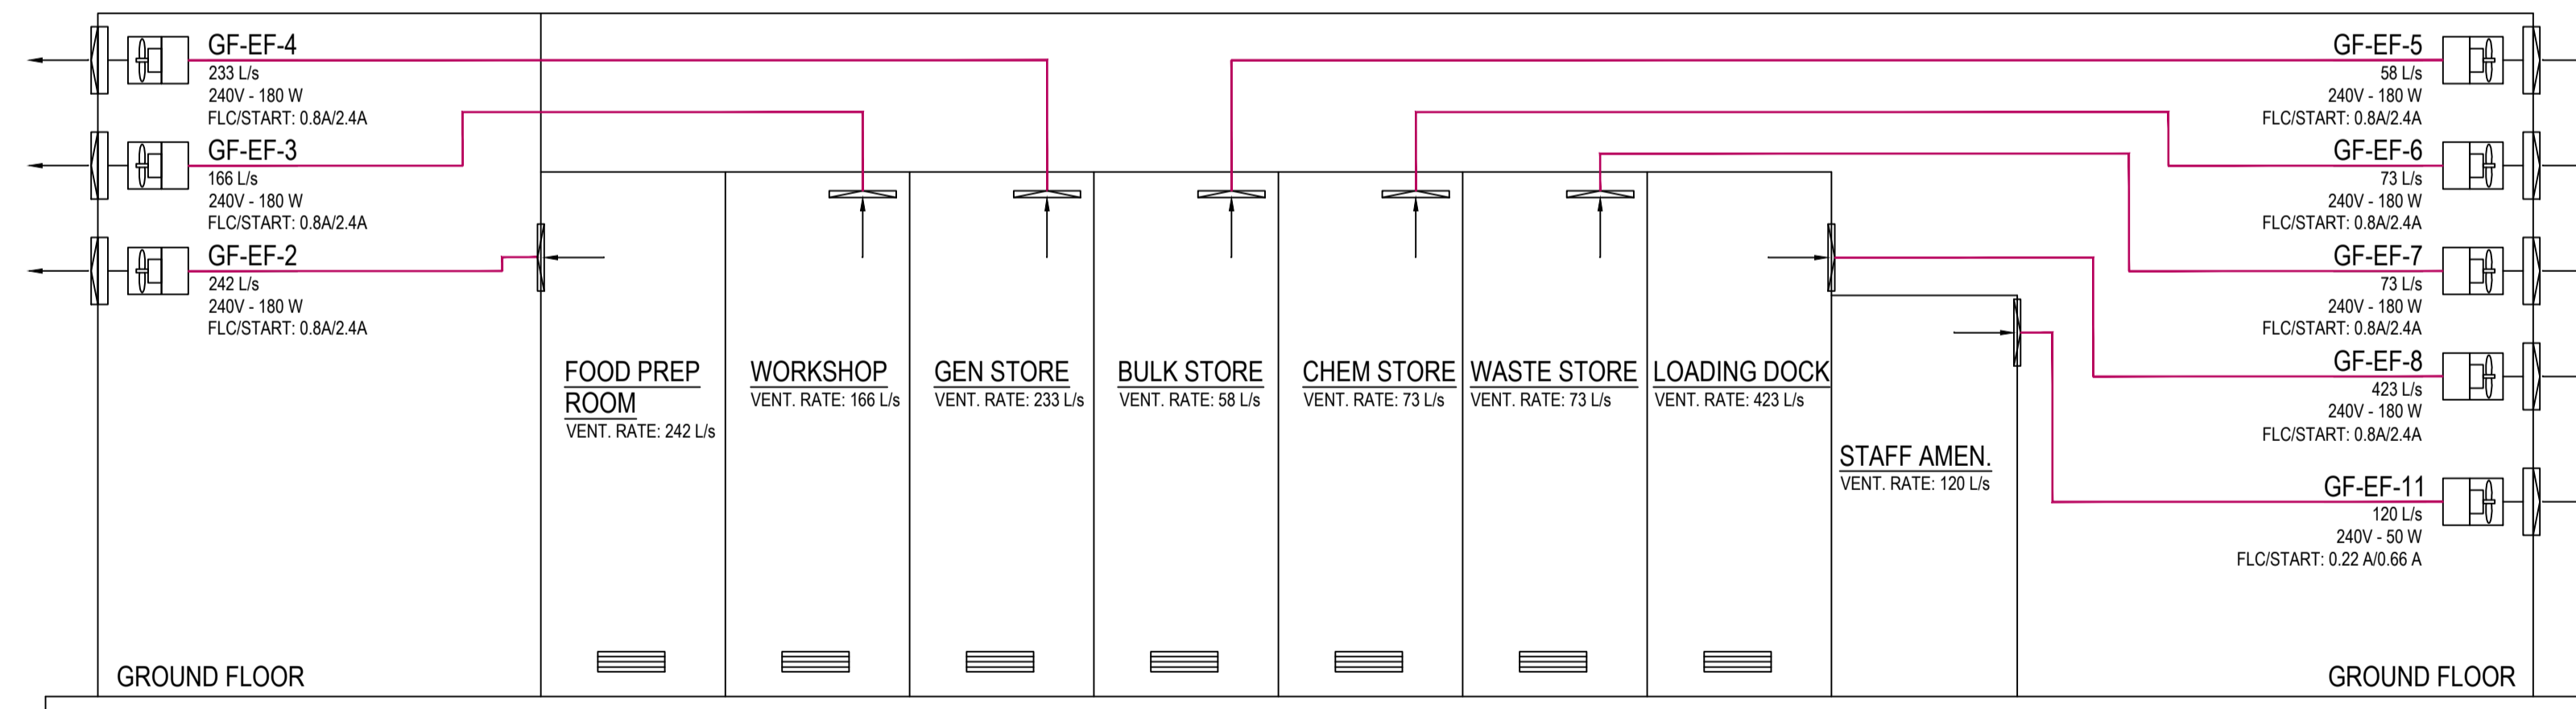

VENTILATION SCHEMATIC

PRELIMINARY


REV	ISSUED TO CLIENT	A.T.	A.T.	PLW	-	03.06.21	DWG No.	REFERENCE
1	2	3	4	5	6	7	8	9
A	ISSUED TO CLIENT	A.T.	A.T.	PLW	-	03.06.21		
REV	REVISION DETAILS	DSGN	DRWN	CHK	APP	DATE	DWG No.	REFERENCE




THIS DRAWING SHALL REMAIN THE PROPERTY OF CNF & ASSOCIATES. IT SHALL NOT BE REPRODUCED OR COPIED WITHOUT EXPRESS PERMISSION OF THE OWNERS

**CNF & Associates**  
 Lvl 2, 393 George Street Sydney N.S.W. 2000  
 Ph (02) 8296 6500  
 Email admin@cnfa.com.au  
 Web www.cnfa.com.au

DESIGN	DATE	PROJECT	Client
A. TRAN	02.06.2021	21-084	TCS
DRAWN	DATE	PLANT	Project
A. TRAN	02.06.2021	REPTILE CENTRE	TARONGA ZOO REPTILE CENTRE
CHECKED	DATE	ENG. SECTION	Title
P. WOODFORD	-		MECHANICAL SERVICES
APPROVED	DATE	SCALE	Original Size
		NTS	A1
			Drawing No.
			15
			Revision
			A

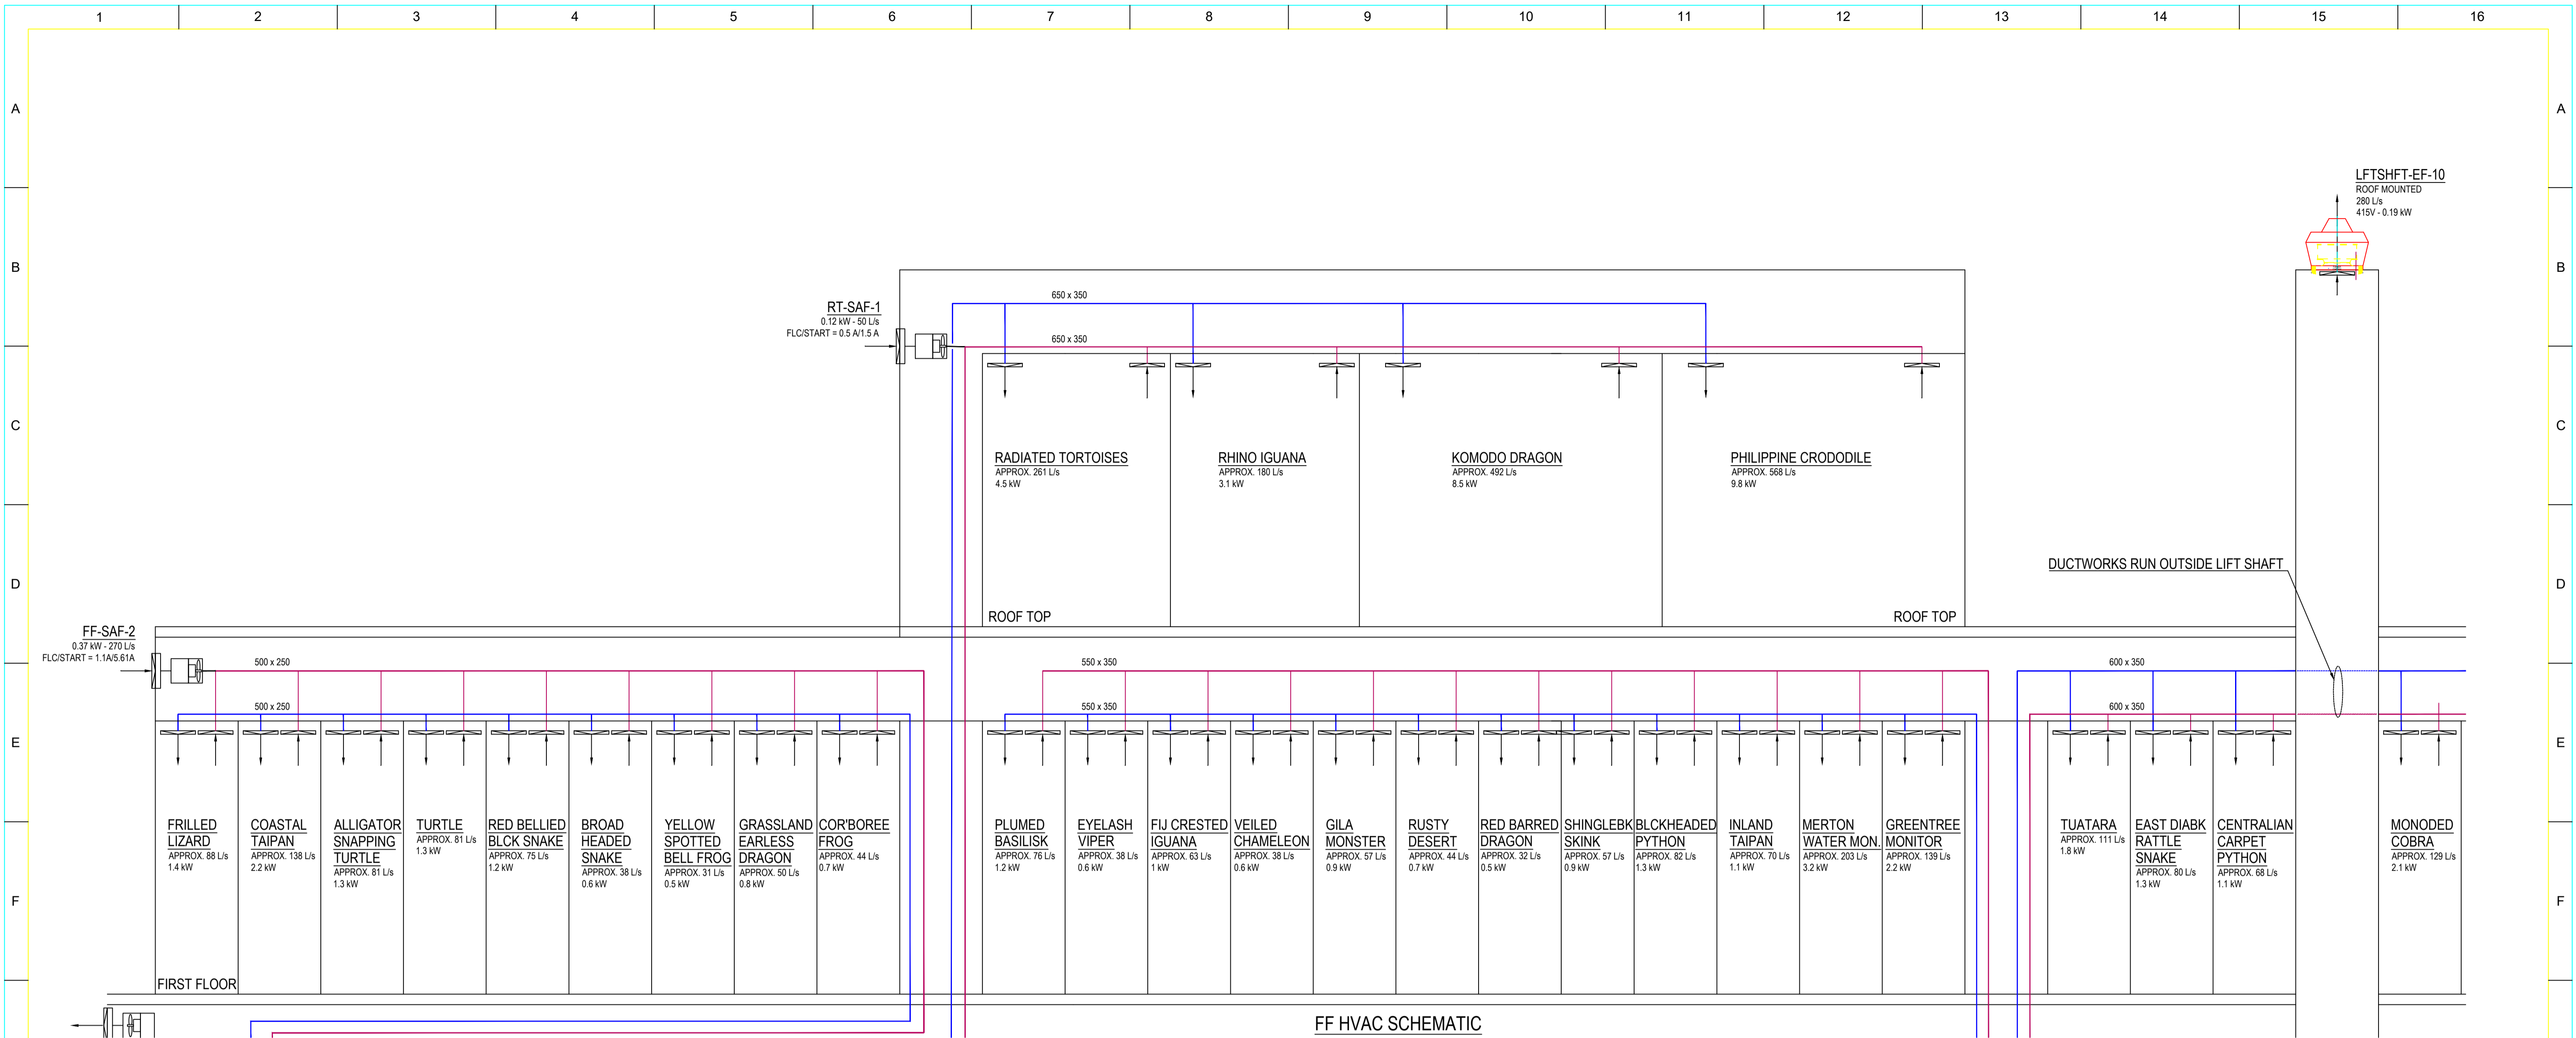

FF HVAC SCHEMATIC

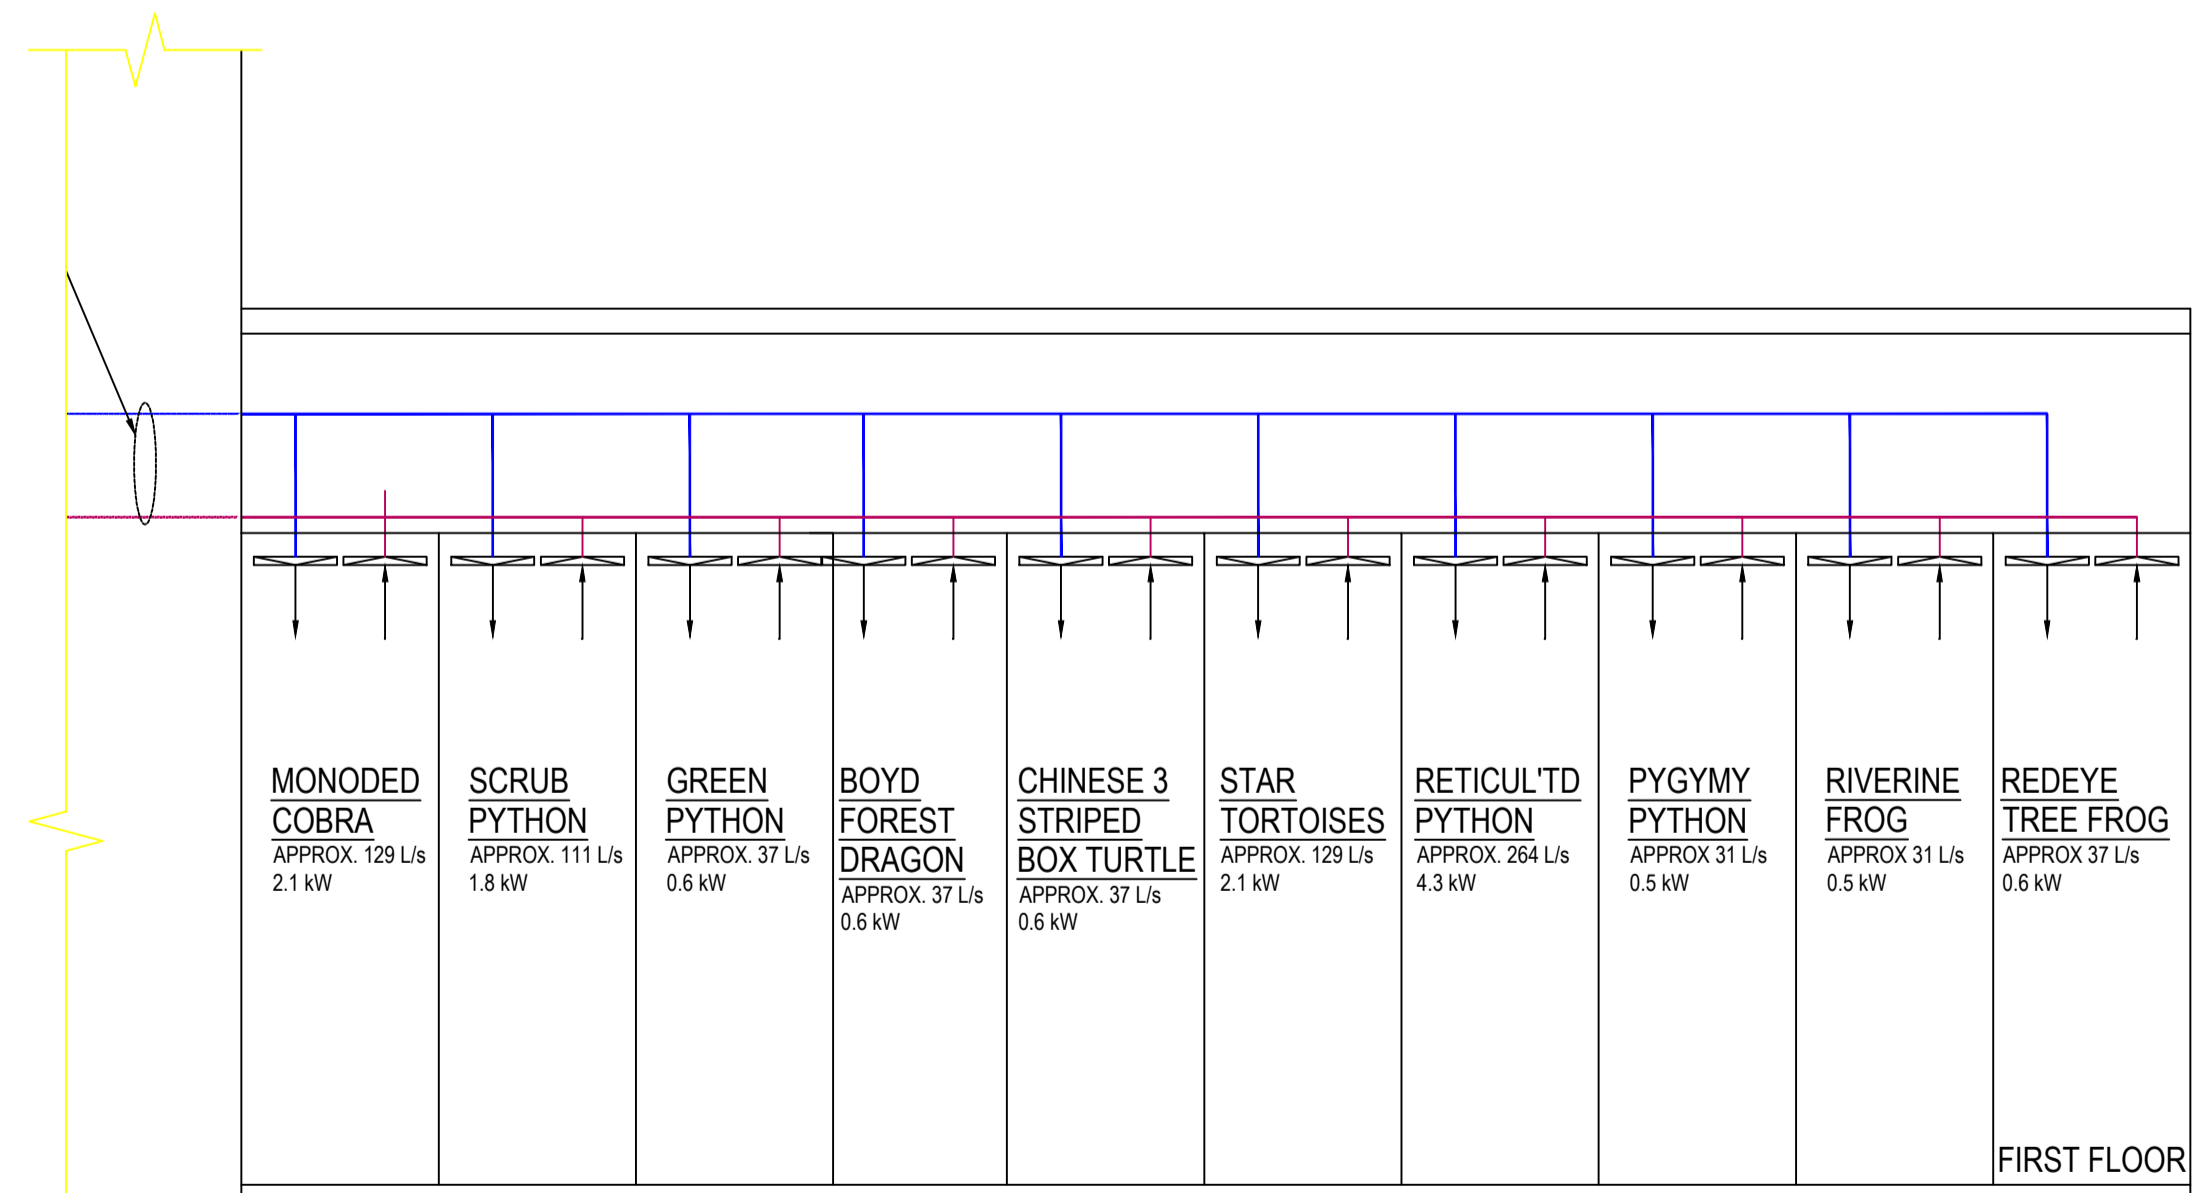

FF HVAC SCHEMATIC

PRELIMINARY


REV	ISSUED TO CLIENT	A.T.	A.T.	PLW	-	03.06.21	DWG No.	REFERENCE
1	2	3	4	5	6	7	8	9
A	ISSUED TO CLIENT	A.T.	A.T.	PLW	-	03.06.21		
REV	REVISION DETAILS	DSGN	DRWN	CHK	APP	DATE	DWG No.	REFERENCE



THIS DRAWING SHALL REMAIN THE PROPERTY OF CNF & ASSOCIATES. IT SHALL NOT BE REPRODUCED OR COPIED WITHOUT EXPRESS PERMISSION OF THE OWNERS

**CNF & Associates**  
 Lvl 2, 393 George Street Sydney N.S.W. 2000  
 Ph (02) 8296 6500  
 Email admin@cnfa.com.au Web www.cnfa.com.au

DESIGN	A. TRAN	DATE	02.06.2021	PROJECT	21-084	Client	TCS
DRAWN	A. TRAN	DATE	02.06.2021	PLANT	REPTILE CENTRE	Project	TARONGA ZOO REPTILE CENTRE
CHECKED	P. WOODFORD	DATE	-	ENG. SECTION		Title	MECHANICAL SERVICES
APPROVED		DATE		SCALE	NTS	Original Size	A1
						Drawing No:	15
						Revision	A

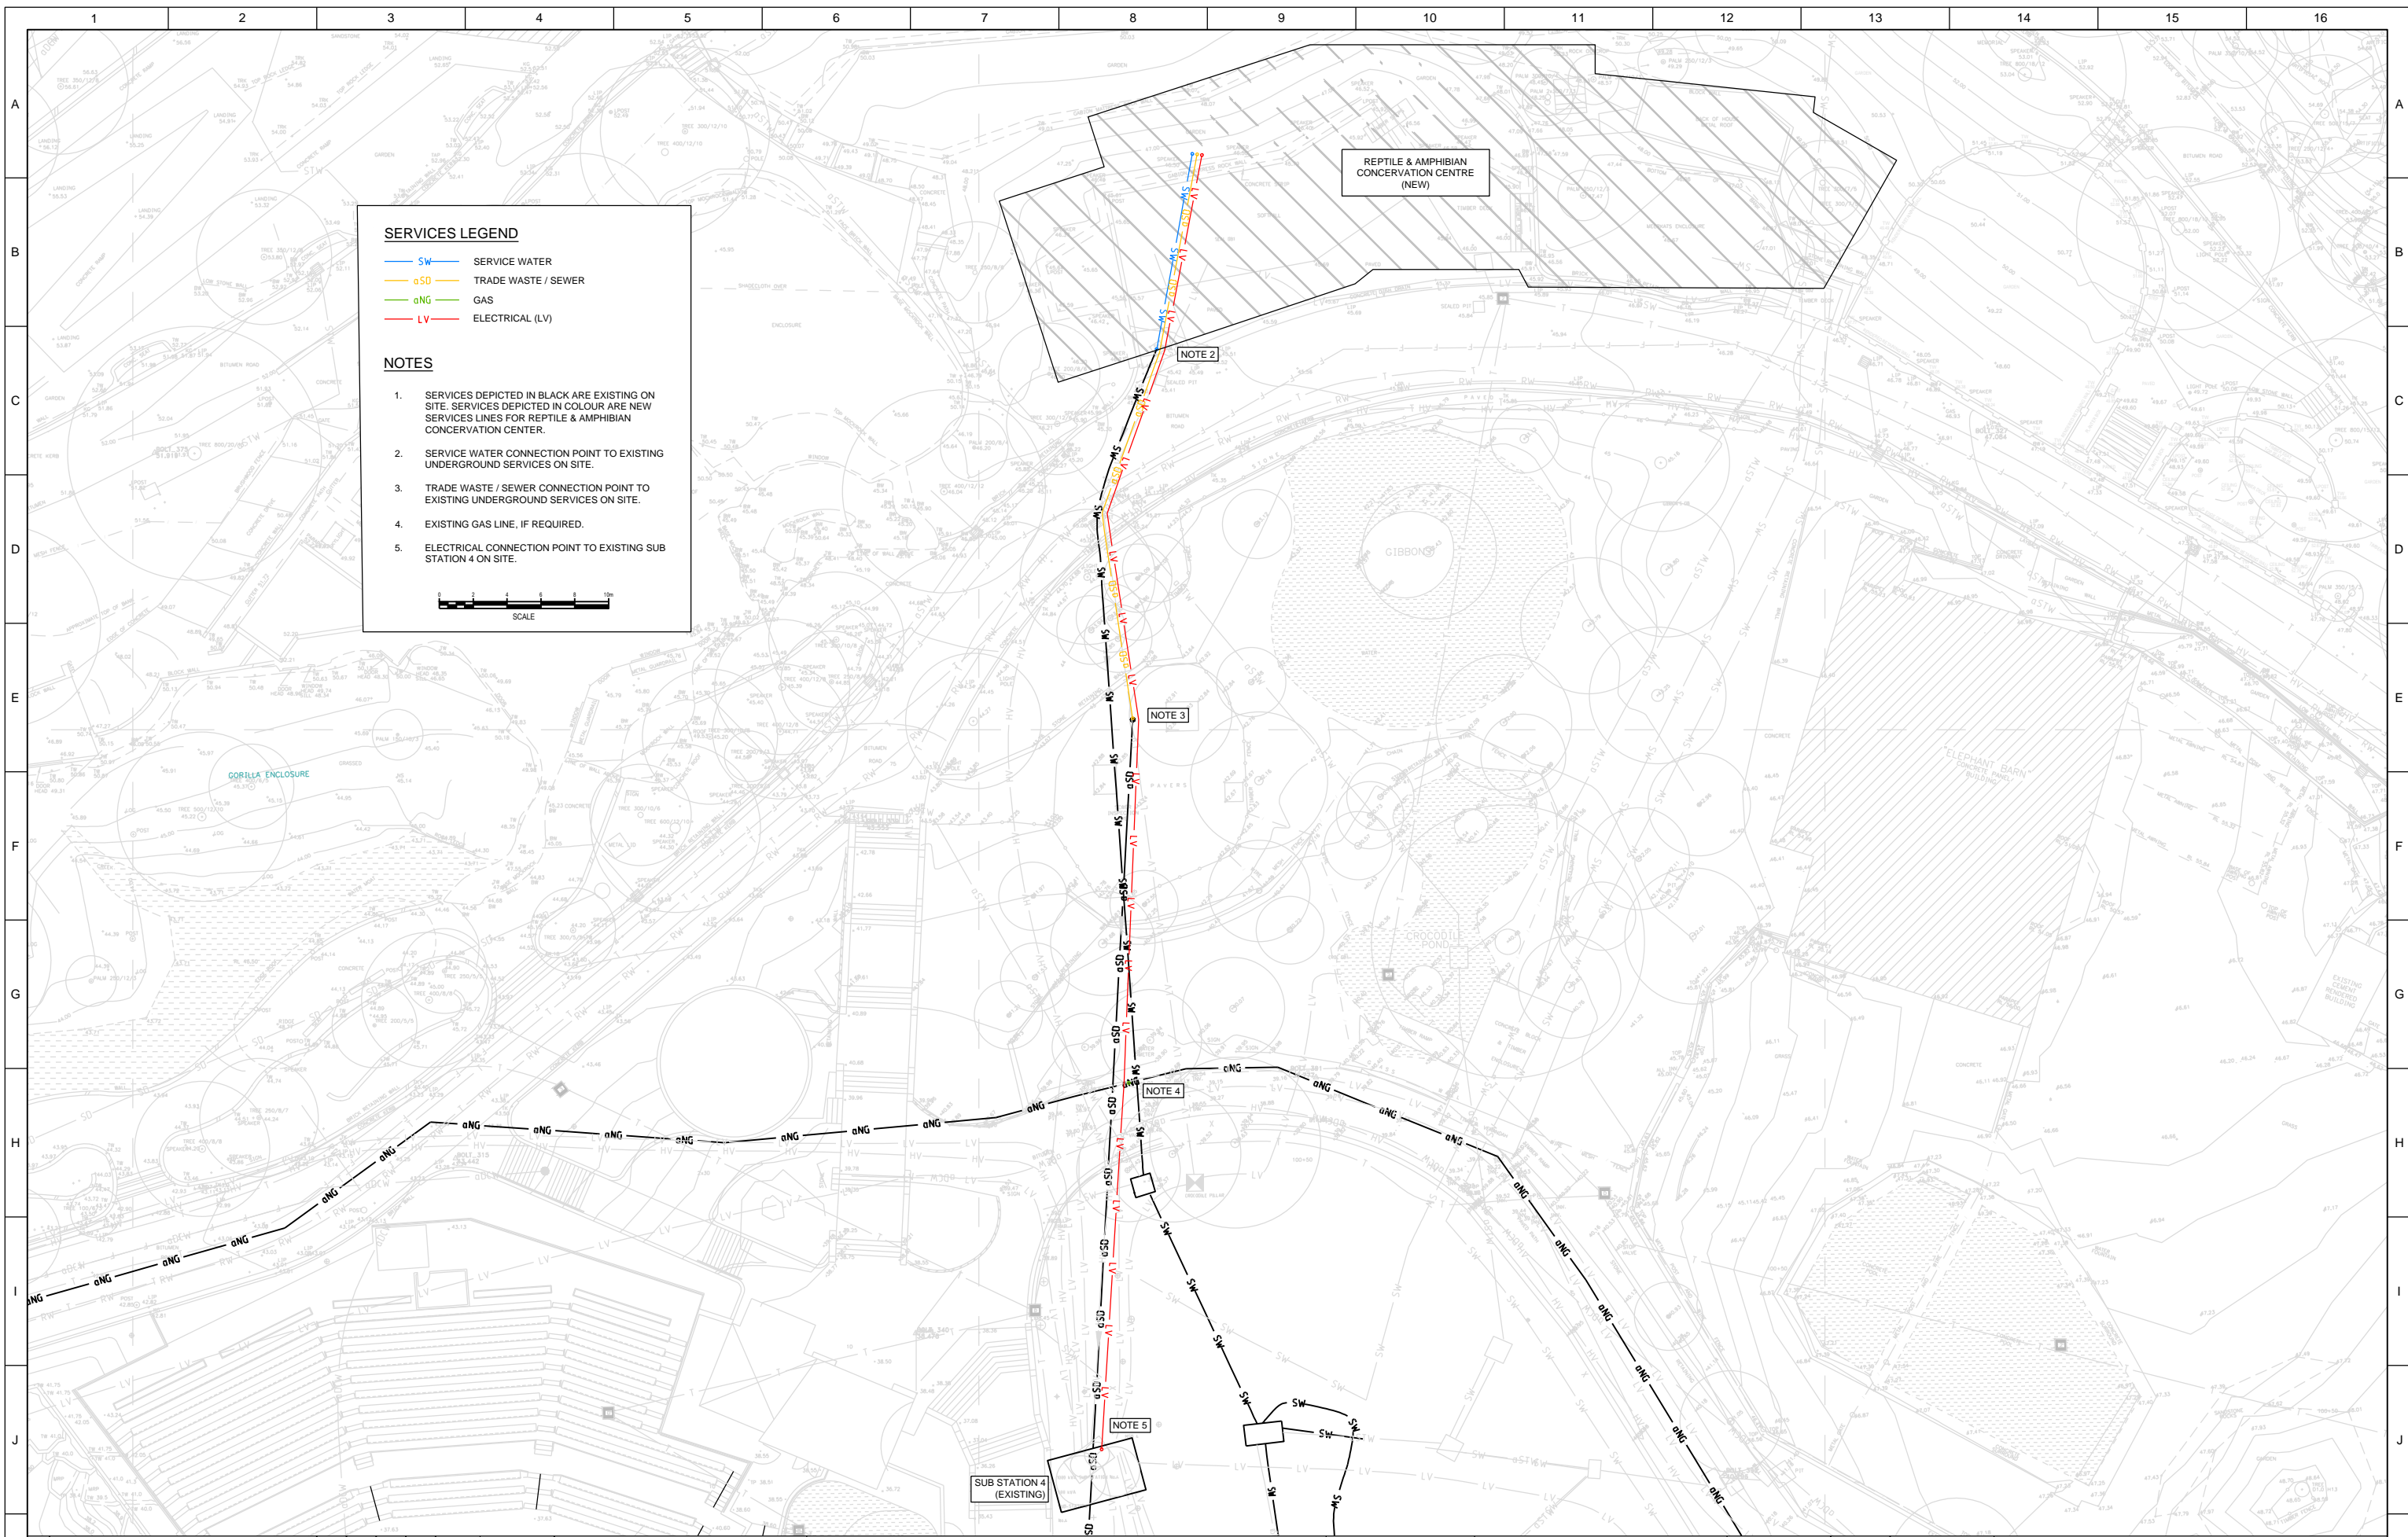

REV	DESCRIPTION	DES	DWN	CHK	APP	DATE	DWG No.	REFERENCE
B	PLANTROOM LAYOUT REVISED	S.I	S.I	LN	LN	24/06/21		
A	REPORT SUPPORTING DOCUMENTATION	S.I	S.I	LN	LN	02/06/21		



THIS DRAWING SHALL REMAIN THE PROPERTY OF CNF & ASSOCIATES. IT SHALL NOT BE REPRODUCED OR COPIED WITHOUT EXPRESS PERMISSION OF THE OWNERS


**CNF & Associates**

Ph (02) 6296 6500  
 Email admin@cnfa.com.au  
 Web www.cnfa.com.au

ABN 41 002 037 498  
 Lvl 2, 393 George Street  
 Sydney N.S.W. 2000

DESIGN	DATE	PROJECT
S. ISYCHOS	02/06/21	
DRAWN	DATE	PLANT
S. ISYCHOS	02/06/21	
CHECKED	DATE	ENG. SECTION
L. NADOR	02/06/21	
APPROVED	DATE	SCALE
L. NADOR	02/06/21	N/A

Client	Project	Title	Original Size	Drawing No.	Revision
TARONGA CONSERVATION SOCIETY	REPTILE & AMPHIBIAN CONSERVATION CENTRE	SITE SERVICES	A1	21-084-M-010	B

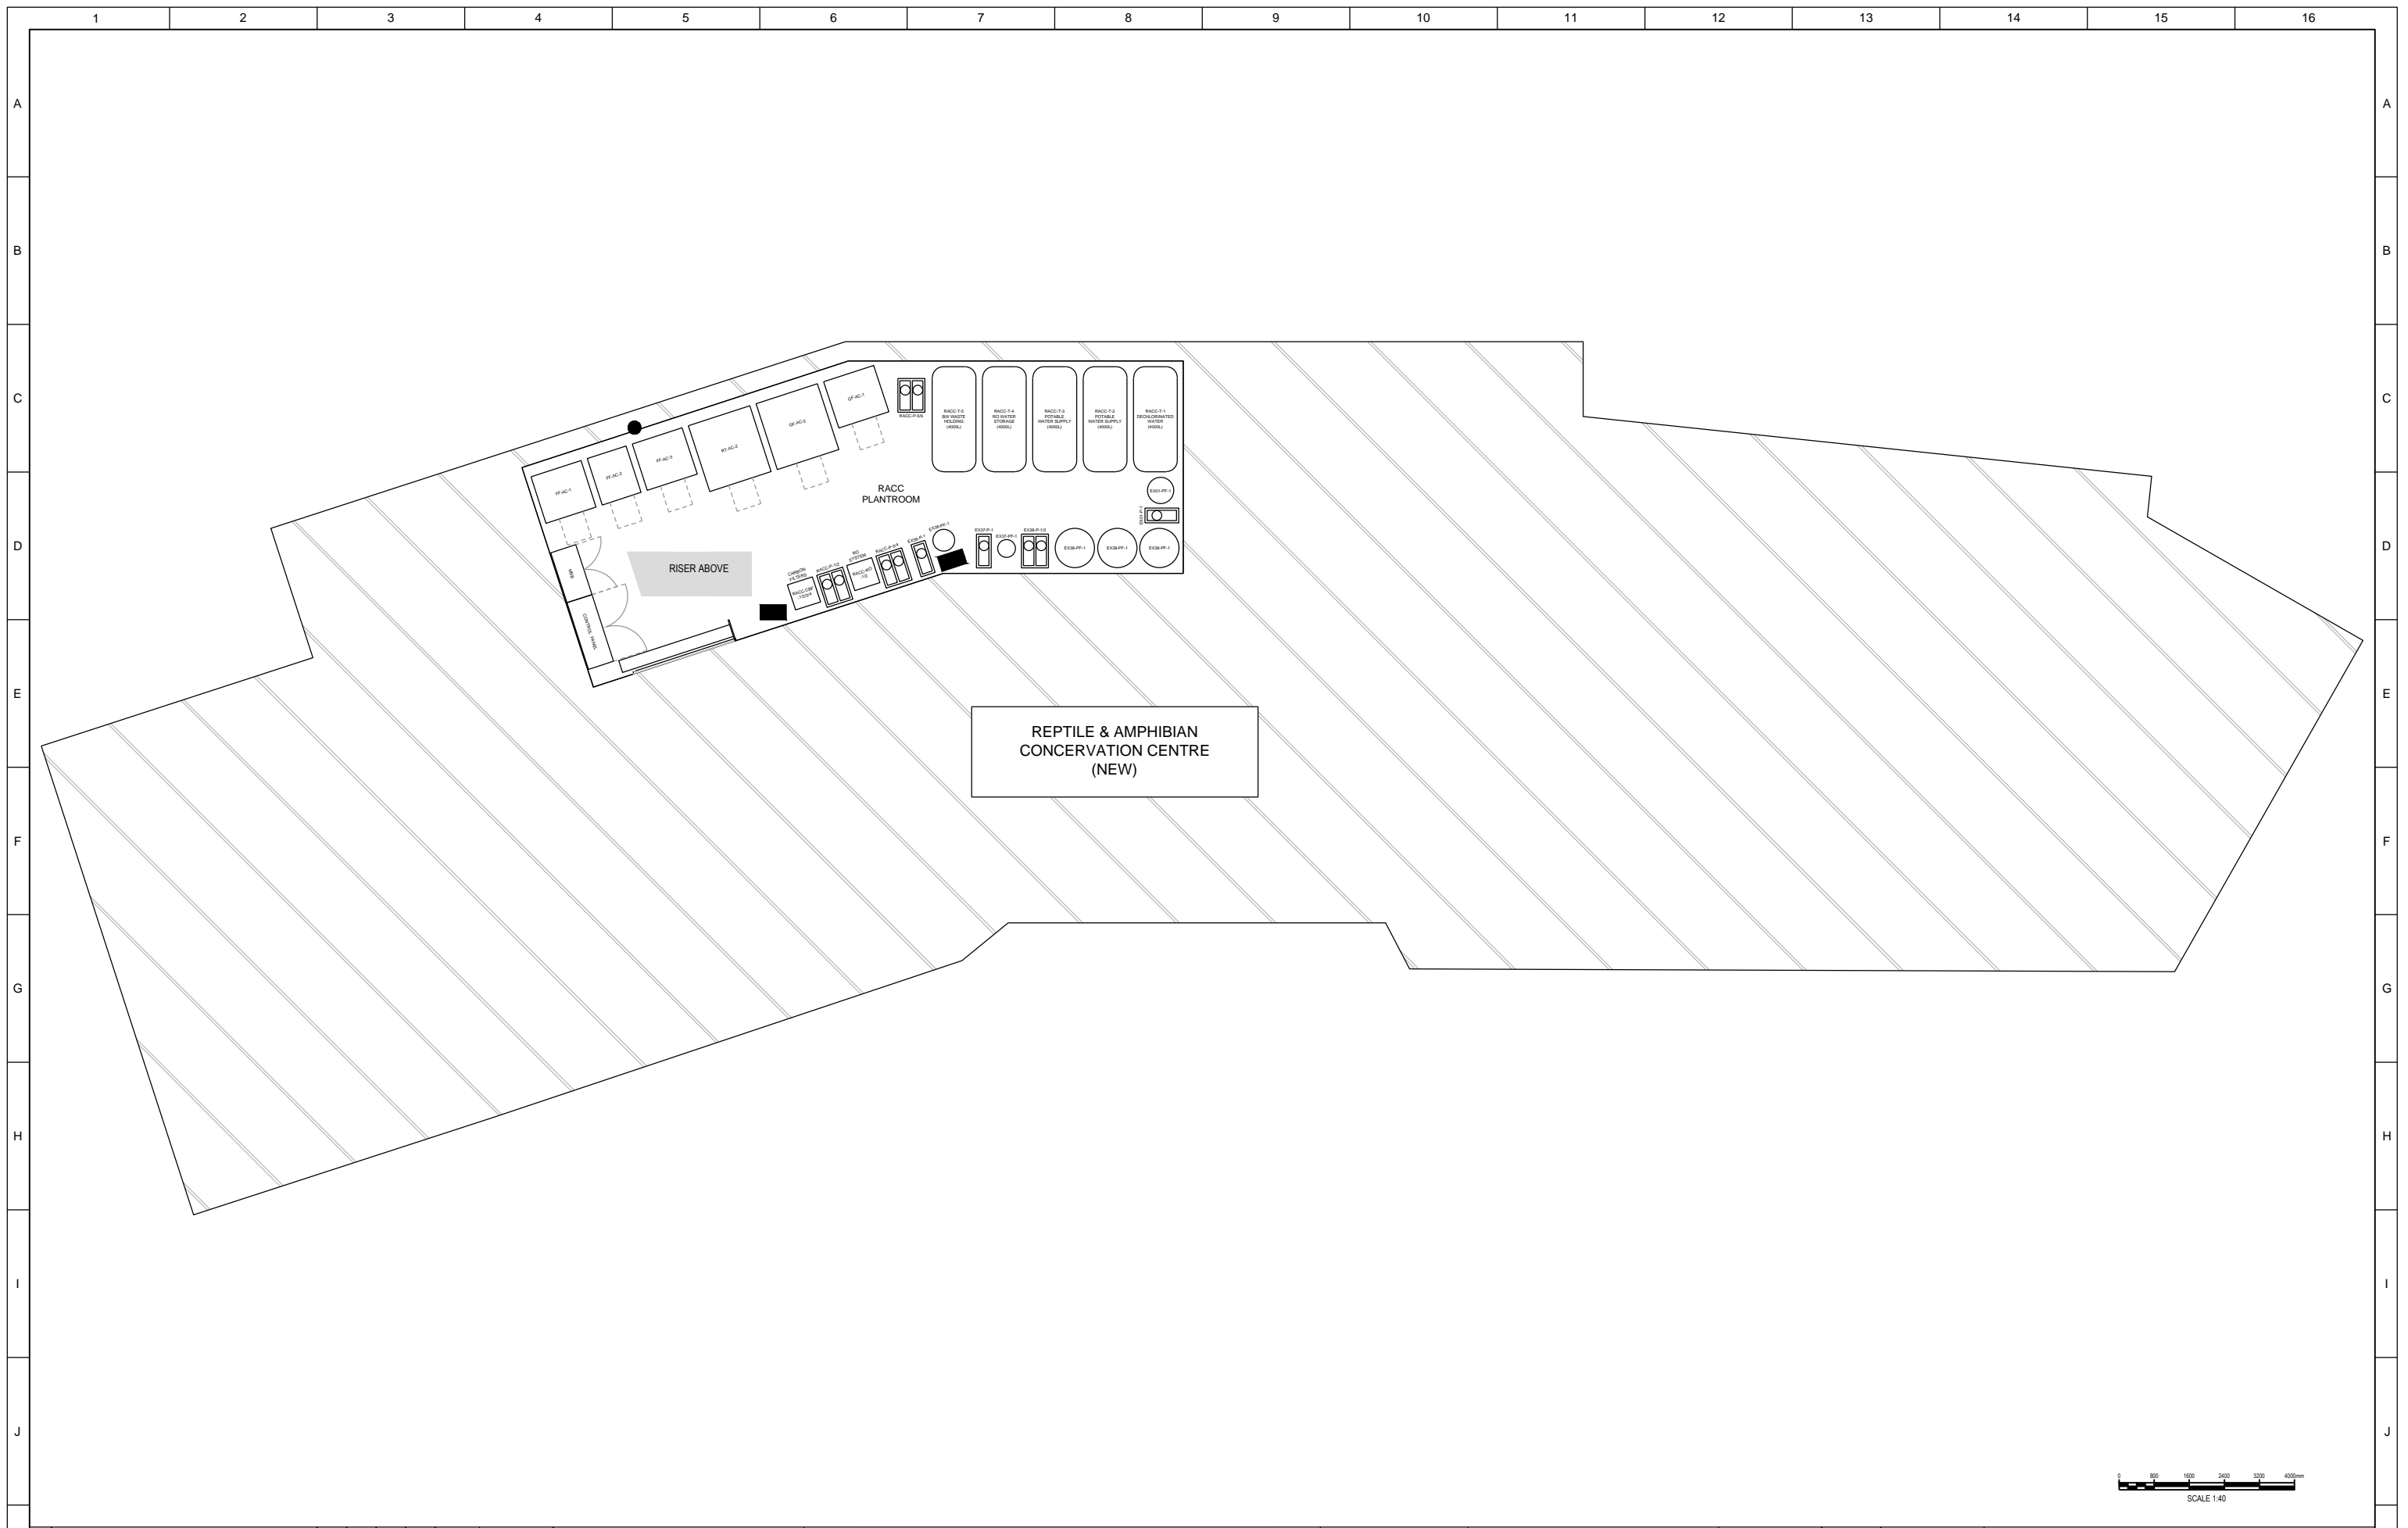

REPTILE & AMPHIBIAN  
CONSERVATION CENTRE  
(NEW)



REV	DESCRIPTION	DES	DWN	CHK	APP	DATE	DWG No.	REFERENCE
B	PLANTROOM LAYOUT REVISED	S.I	S.I	LN	LN	24/06/21		
A	REPORT SUPPORTING DOCUMENTATION	S.I	S.I	LN	LN	02/06/21		




THIS DRAWING SHALL  
REMAIN THE PROPERTY OF  
CNF & ASSOCIATES.  
IT SHALL NOT BE  
REPRODUCED OR COPIED  
WITHOUT EXPRESS  
PERMISSION OF THE  
OWNERS

**CNF** & Associates  
Ph (02) 6296 6500 ABN 41 002 037 498  
Email admin@cnfa.com.au Lvl 2, 393 George Street  
Web www.cnfa.com.au Sydney N.S.W. 2000

DESIGN	S. ISYCHOS	DATE	02/06/21	PROJECT	
DRAWN	S. ISYCHOS	DATE	02/06/21	PLANT	
CHECKED	L. NADOR	DATE	02/06/21	ENG. SECTION	
APPROVED	L. NADOR	DATE	02/06/21	SCALE	N/A

Client	TARONGA CONSERVATION SOCIETY
Project	REPTILE & AMPHIBIAN CONSERVATION CENTRE
Title	PLANTROOM
	GENERAL ARRANGEMENT
Original Size	A1
Drawing No:	21-084-M-011
Revision	B

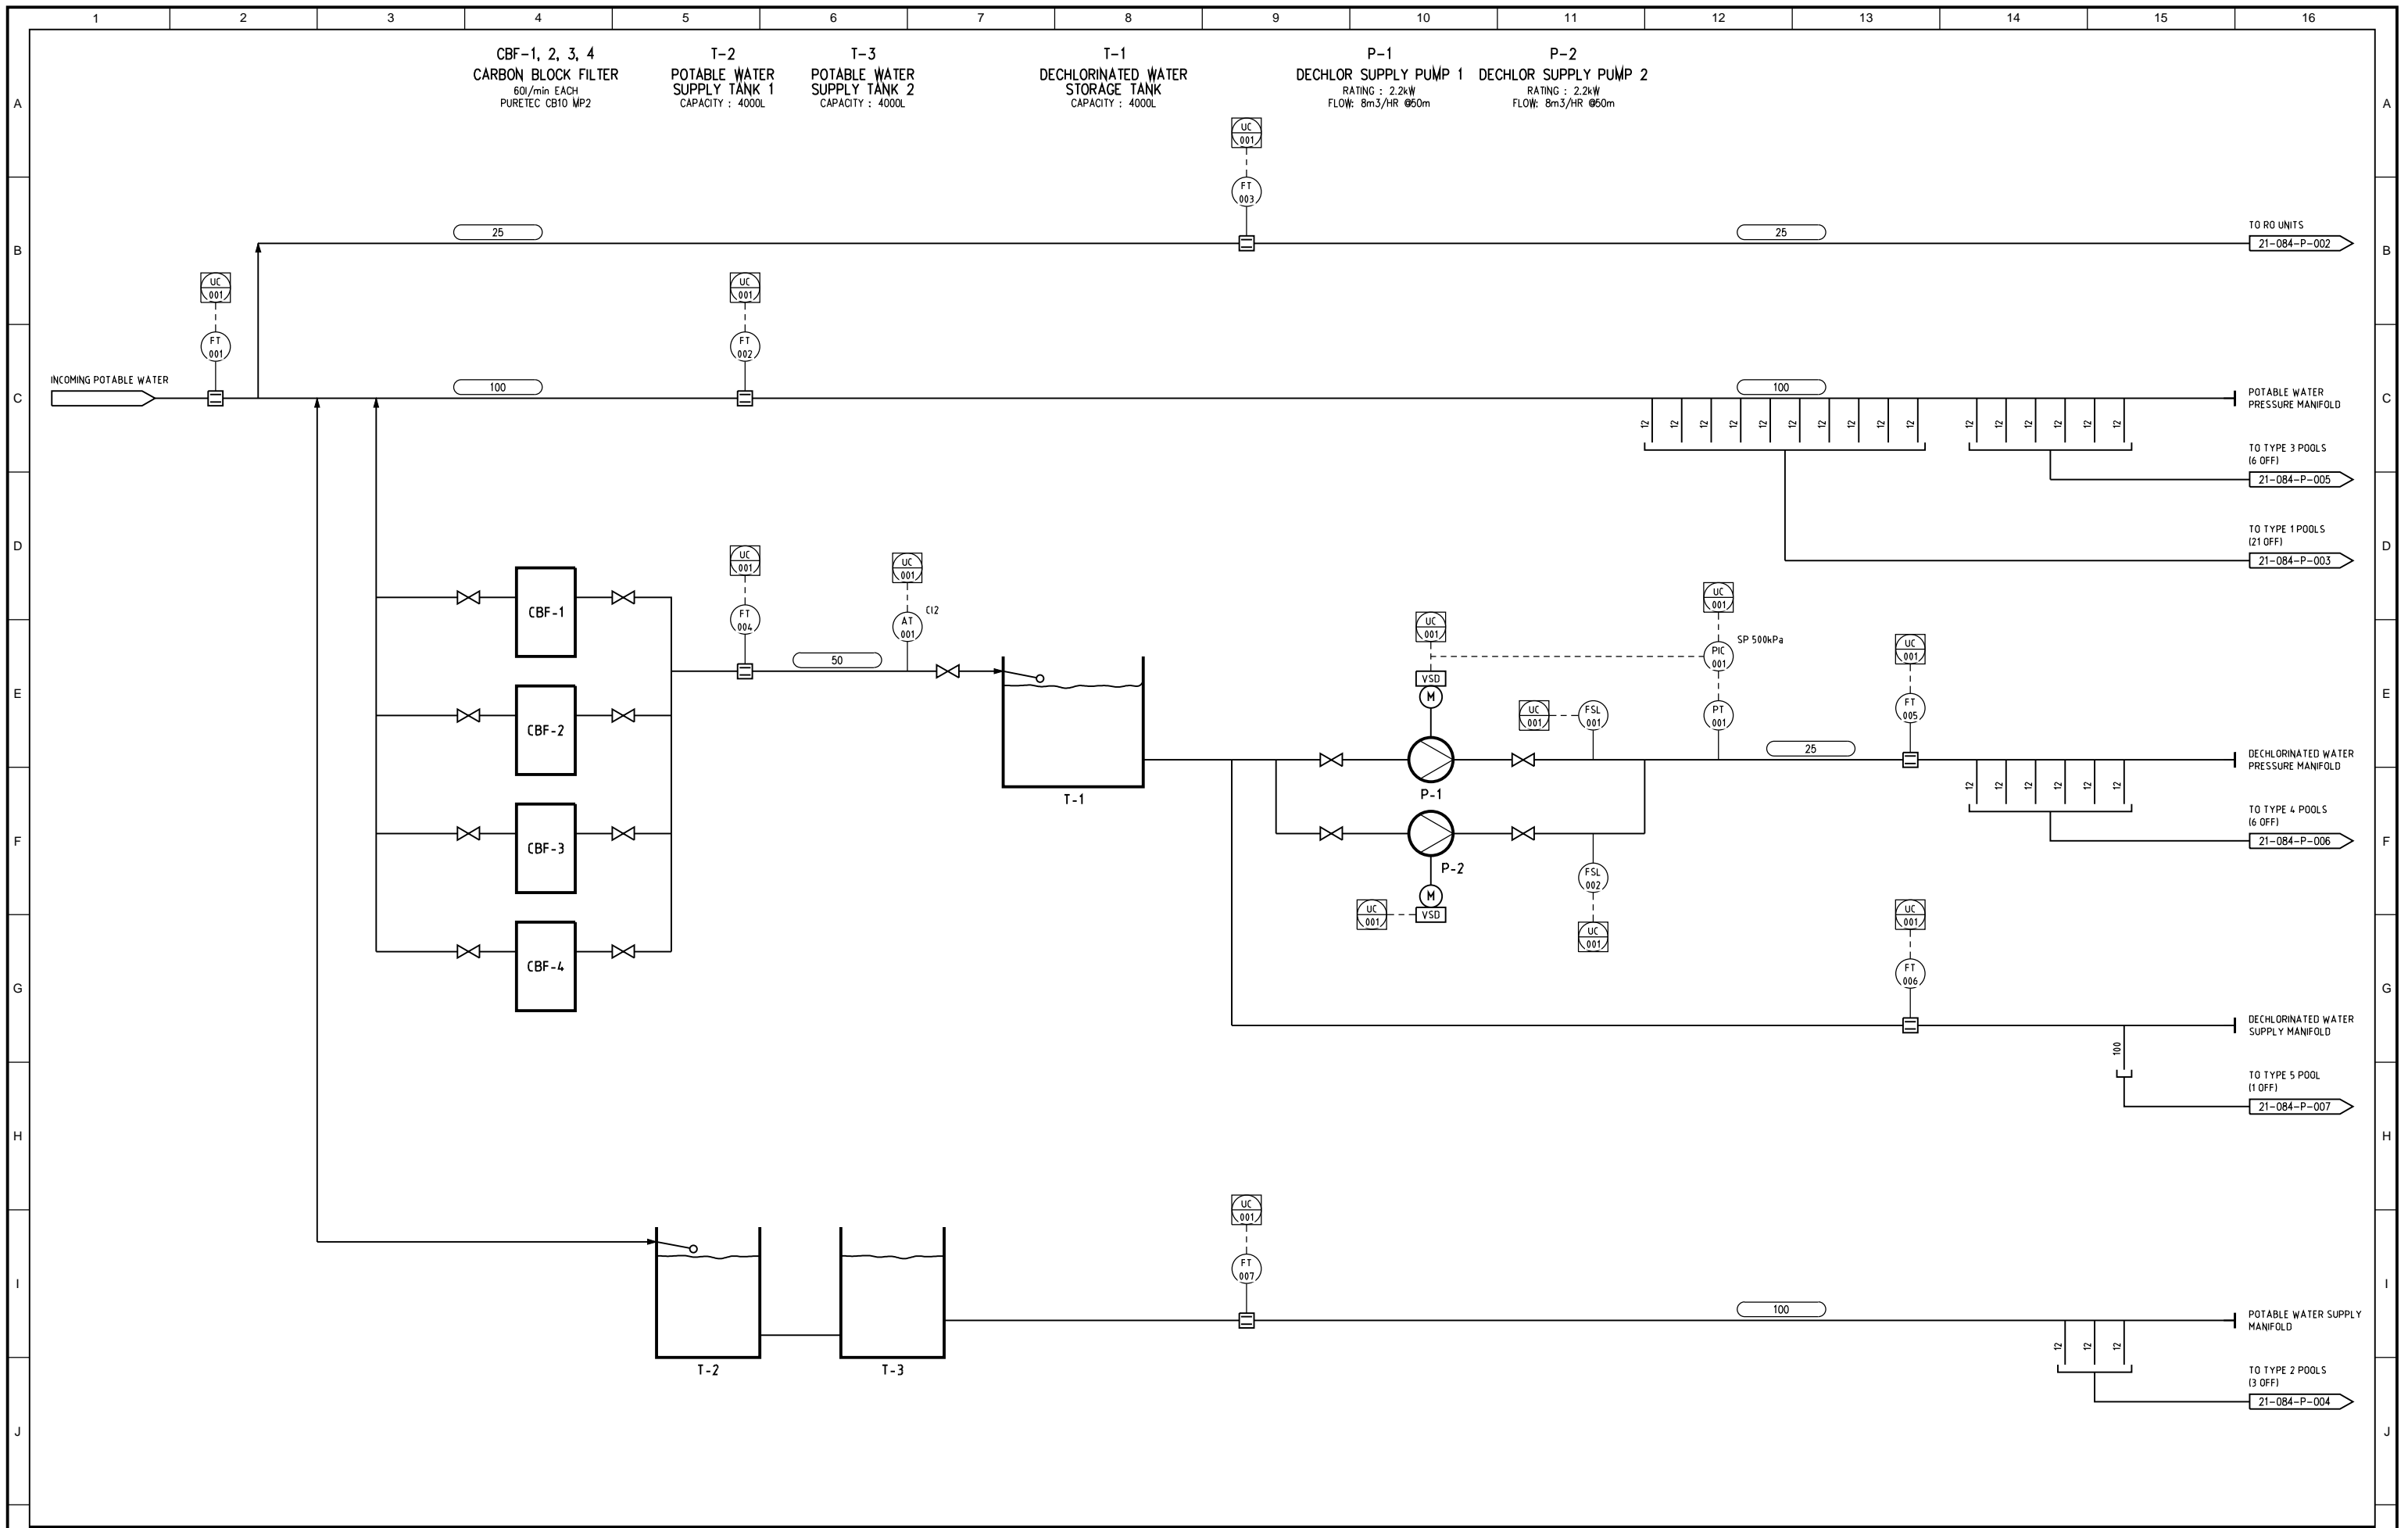

REV	DESCRIPTION	DES	DWN	CHK	APP	DATE	DWG No.	REFERENCE
A	ISSUED FOR REVIEW	L.N.	L.P.	S.I.	L.N.	03/06/21		
	REVISION DETAILS							




THIS DRAWING SHALL REMAIN THE PROPERTY OF CNF & ASSOCIATES. IT SHALL NOT BE REPRODUCED OR COPIED WITHOUT EXPRESS PERMISSION OF THE OWNERS

**CNF & Associates**  
 Ph (02) 6296 6500  
 Email admin@cnfa.com.au  
 Web www.cnfa.com.au  
 ABN 41 002 037 498  
 Lvl 2, 393 George Street  
 Sydney N.S.W. 2000

DESIGN	DATE	PROJECT
L. NADOR	03/06/21	21-084
DRAWN	DATE	PLANT
L. PERNICE	03/06/21	RACC
CHECKED	DATE	ENG. SECTION
S. ISYCHOS	03/06/21	ELECTRICAL
APPROVED	DATE	SCALE
L. NADOR	03/06/21	N/A

Client	Project	Title
TARONGA CONSERVATION SOCIETY	REPTILE & AMPHIBIAN CONSERVATION CENTRE	WATER SUPPLY P & ID
SHEET 1 OF 2		
Original Size	Drawing No.	Revision
A1	21-084-P-001	A

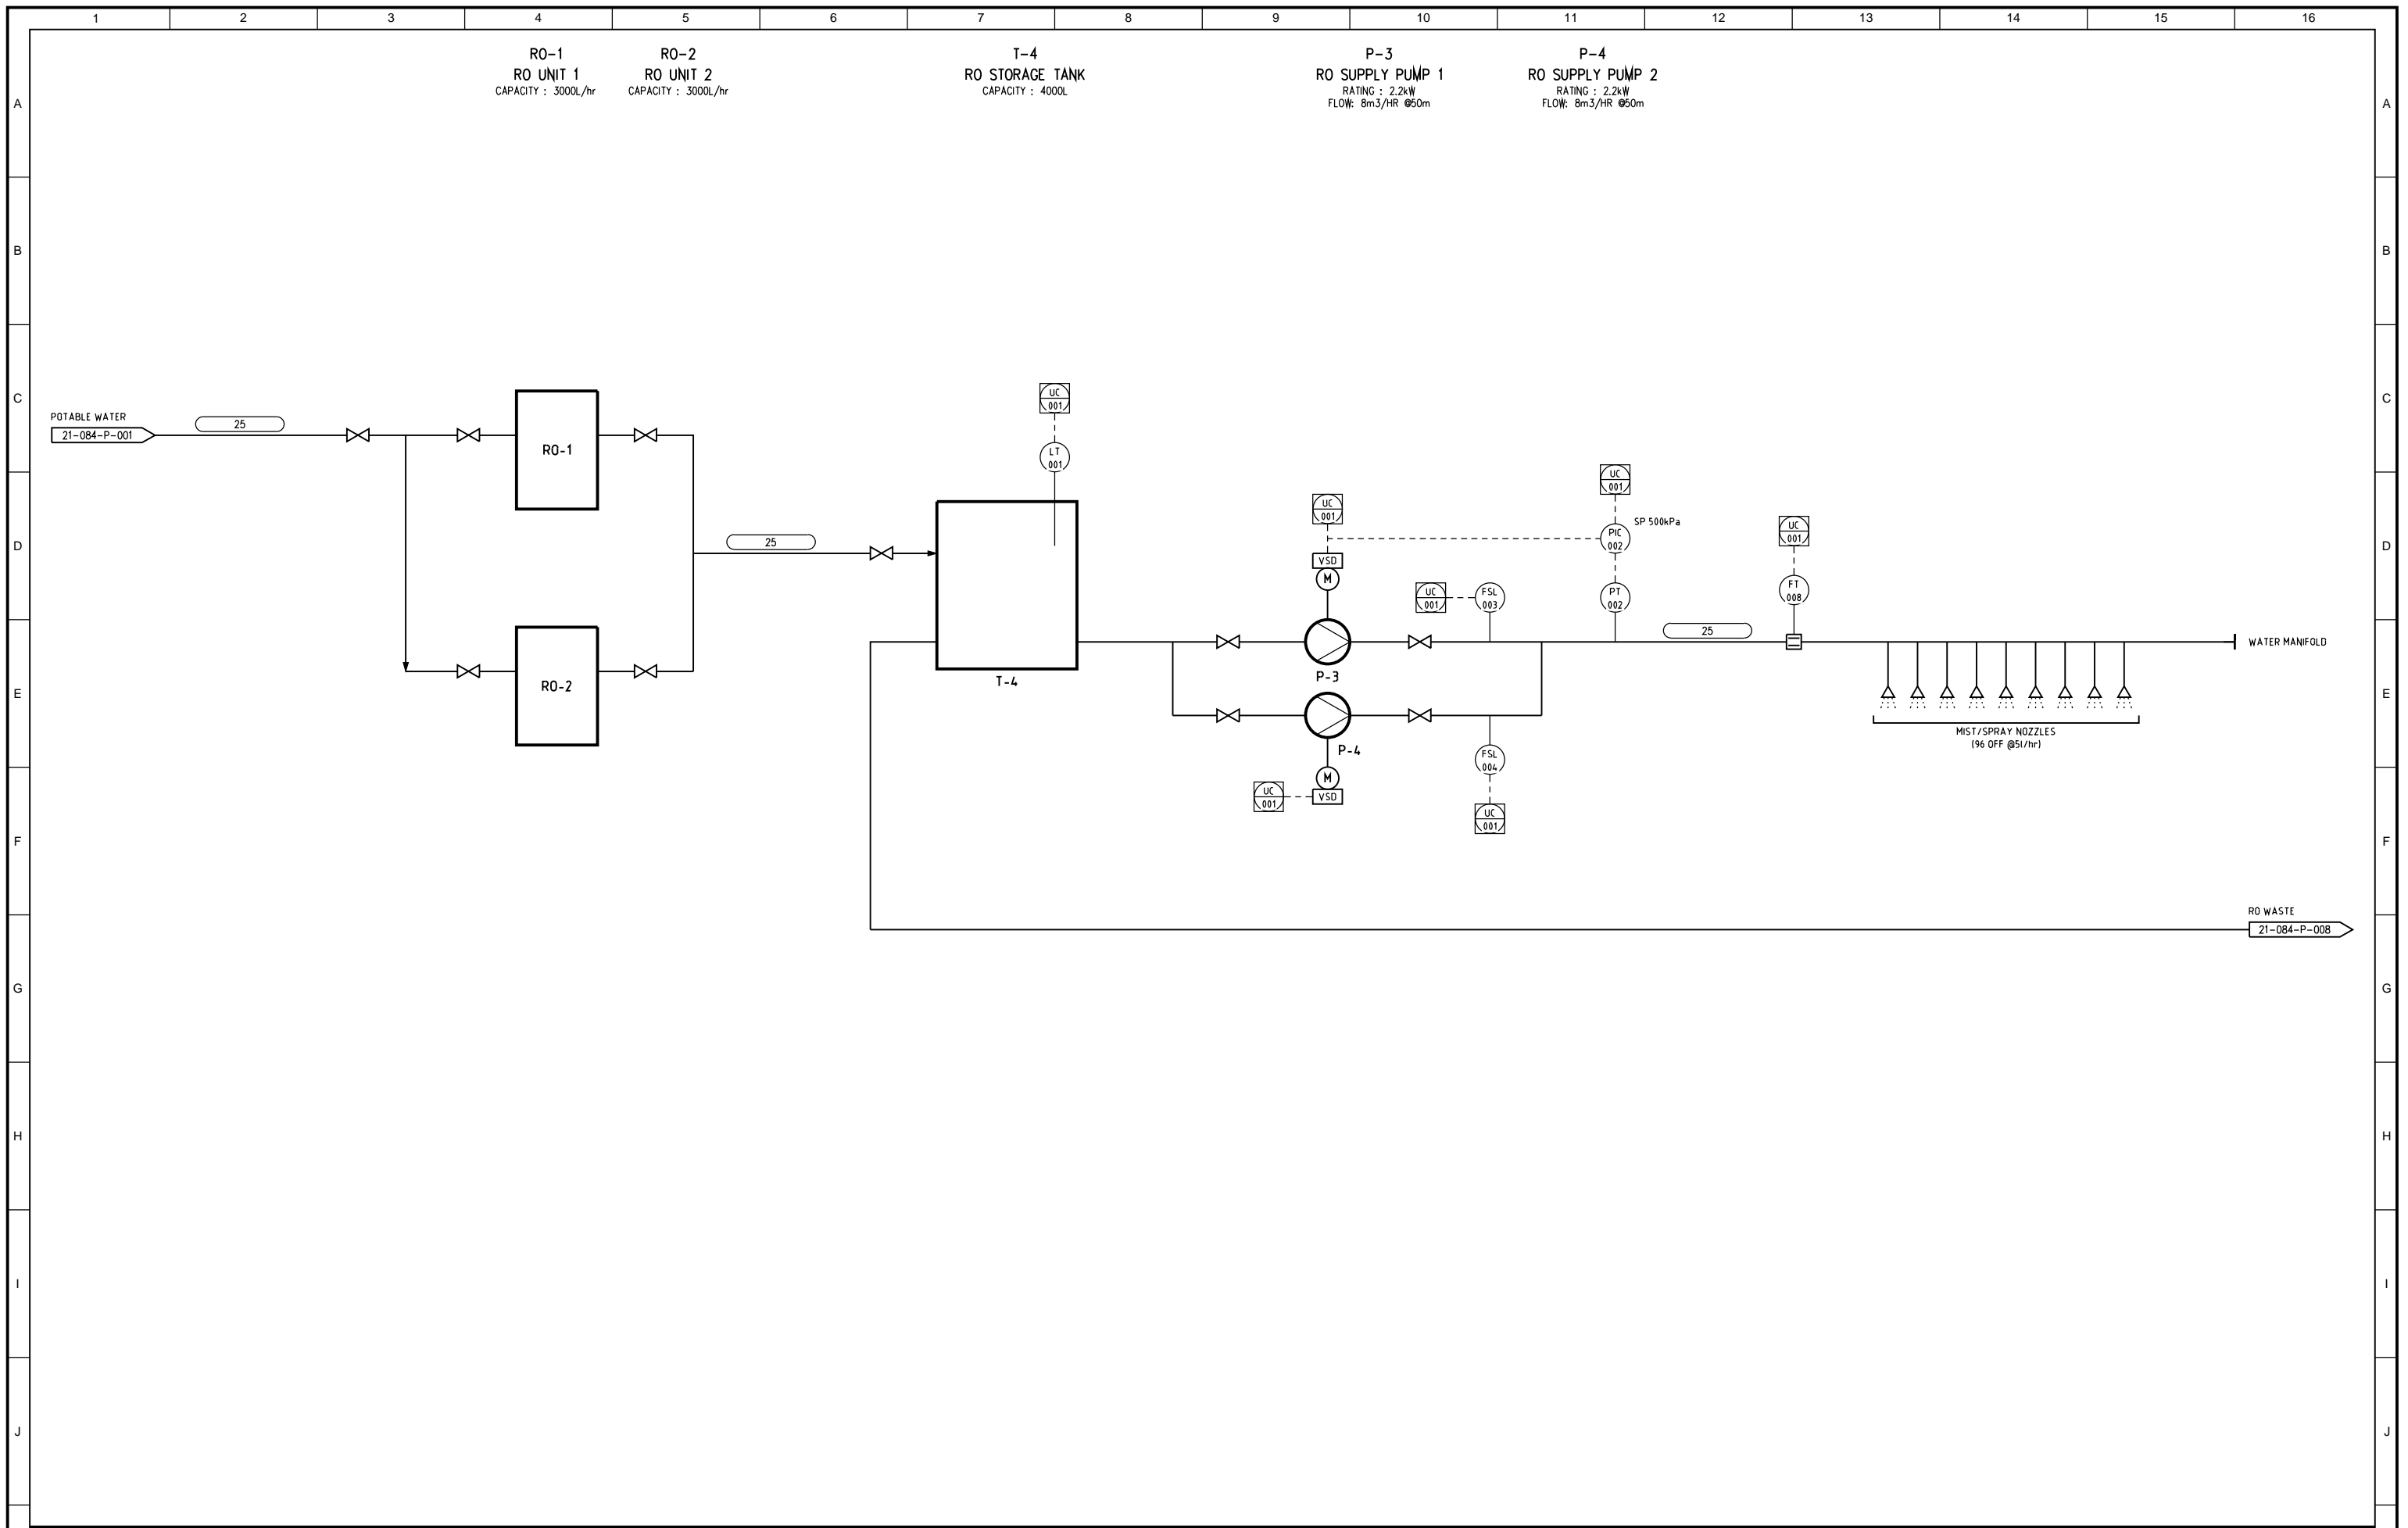

REV	ISSUED FOR REVIEW	DES	DWN	CHK	APP	DATE	DWG No.	REFERENCE
A	ISSUED FOR REVIEW	LN	LP	SI	LN	03/06/21		



THIS DRAWING SHALL REMAIN THE PROPERTY OF CNF & ASSOCIATES. IT SHALL NOT BE REPRODUCED OR COPIED WITHOUT EXPRESS PERMISSION OF THE OWNERS



DESIGN	L. NADOR	DATE	03/06/21	PROJECT	21-084
DRAWN	L. PERNICE	DATE	03/06/21	PLANT	RACC
CHECKED	S. ISYCHOS	DATE	03/06/21	ENG. SECTION	ELECTRICAL
APPROVED	L. NADOR	DATE	03/06/21	SCALE	N/A

Client	TARONGA CONSERVATION SOCIETY
Project	REPTILE & AMPHIBIAN CONSERVATION CENTRE
Title	WATER SUPPLY P & ID
	SHEET 2 OF 2
Original Size	A1
Drawing No:	21-084-P-002
Revision	A

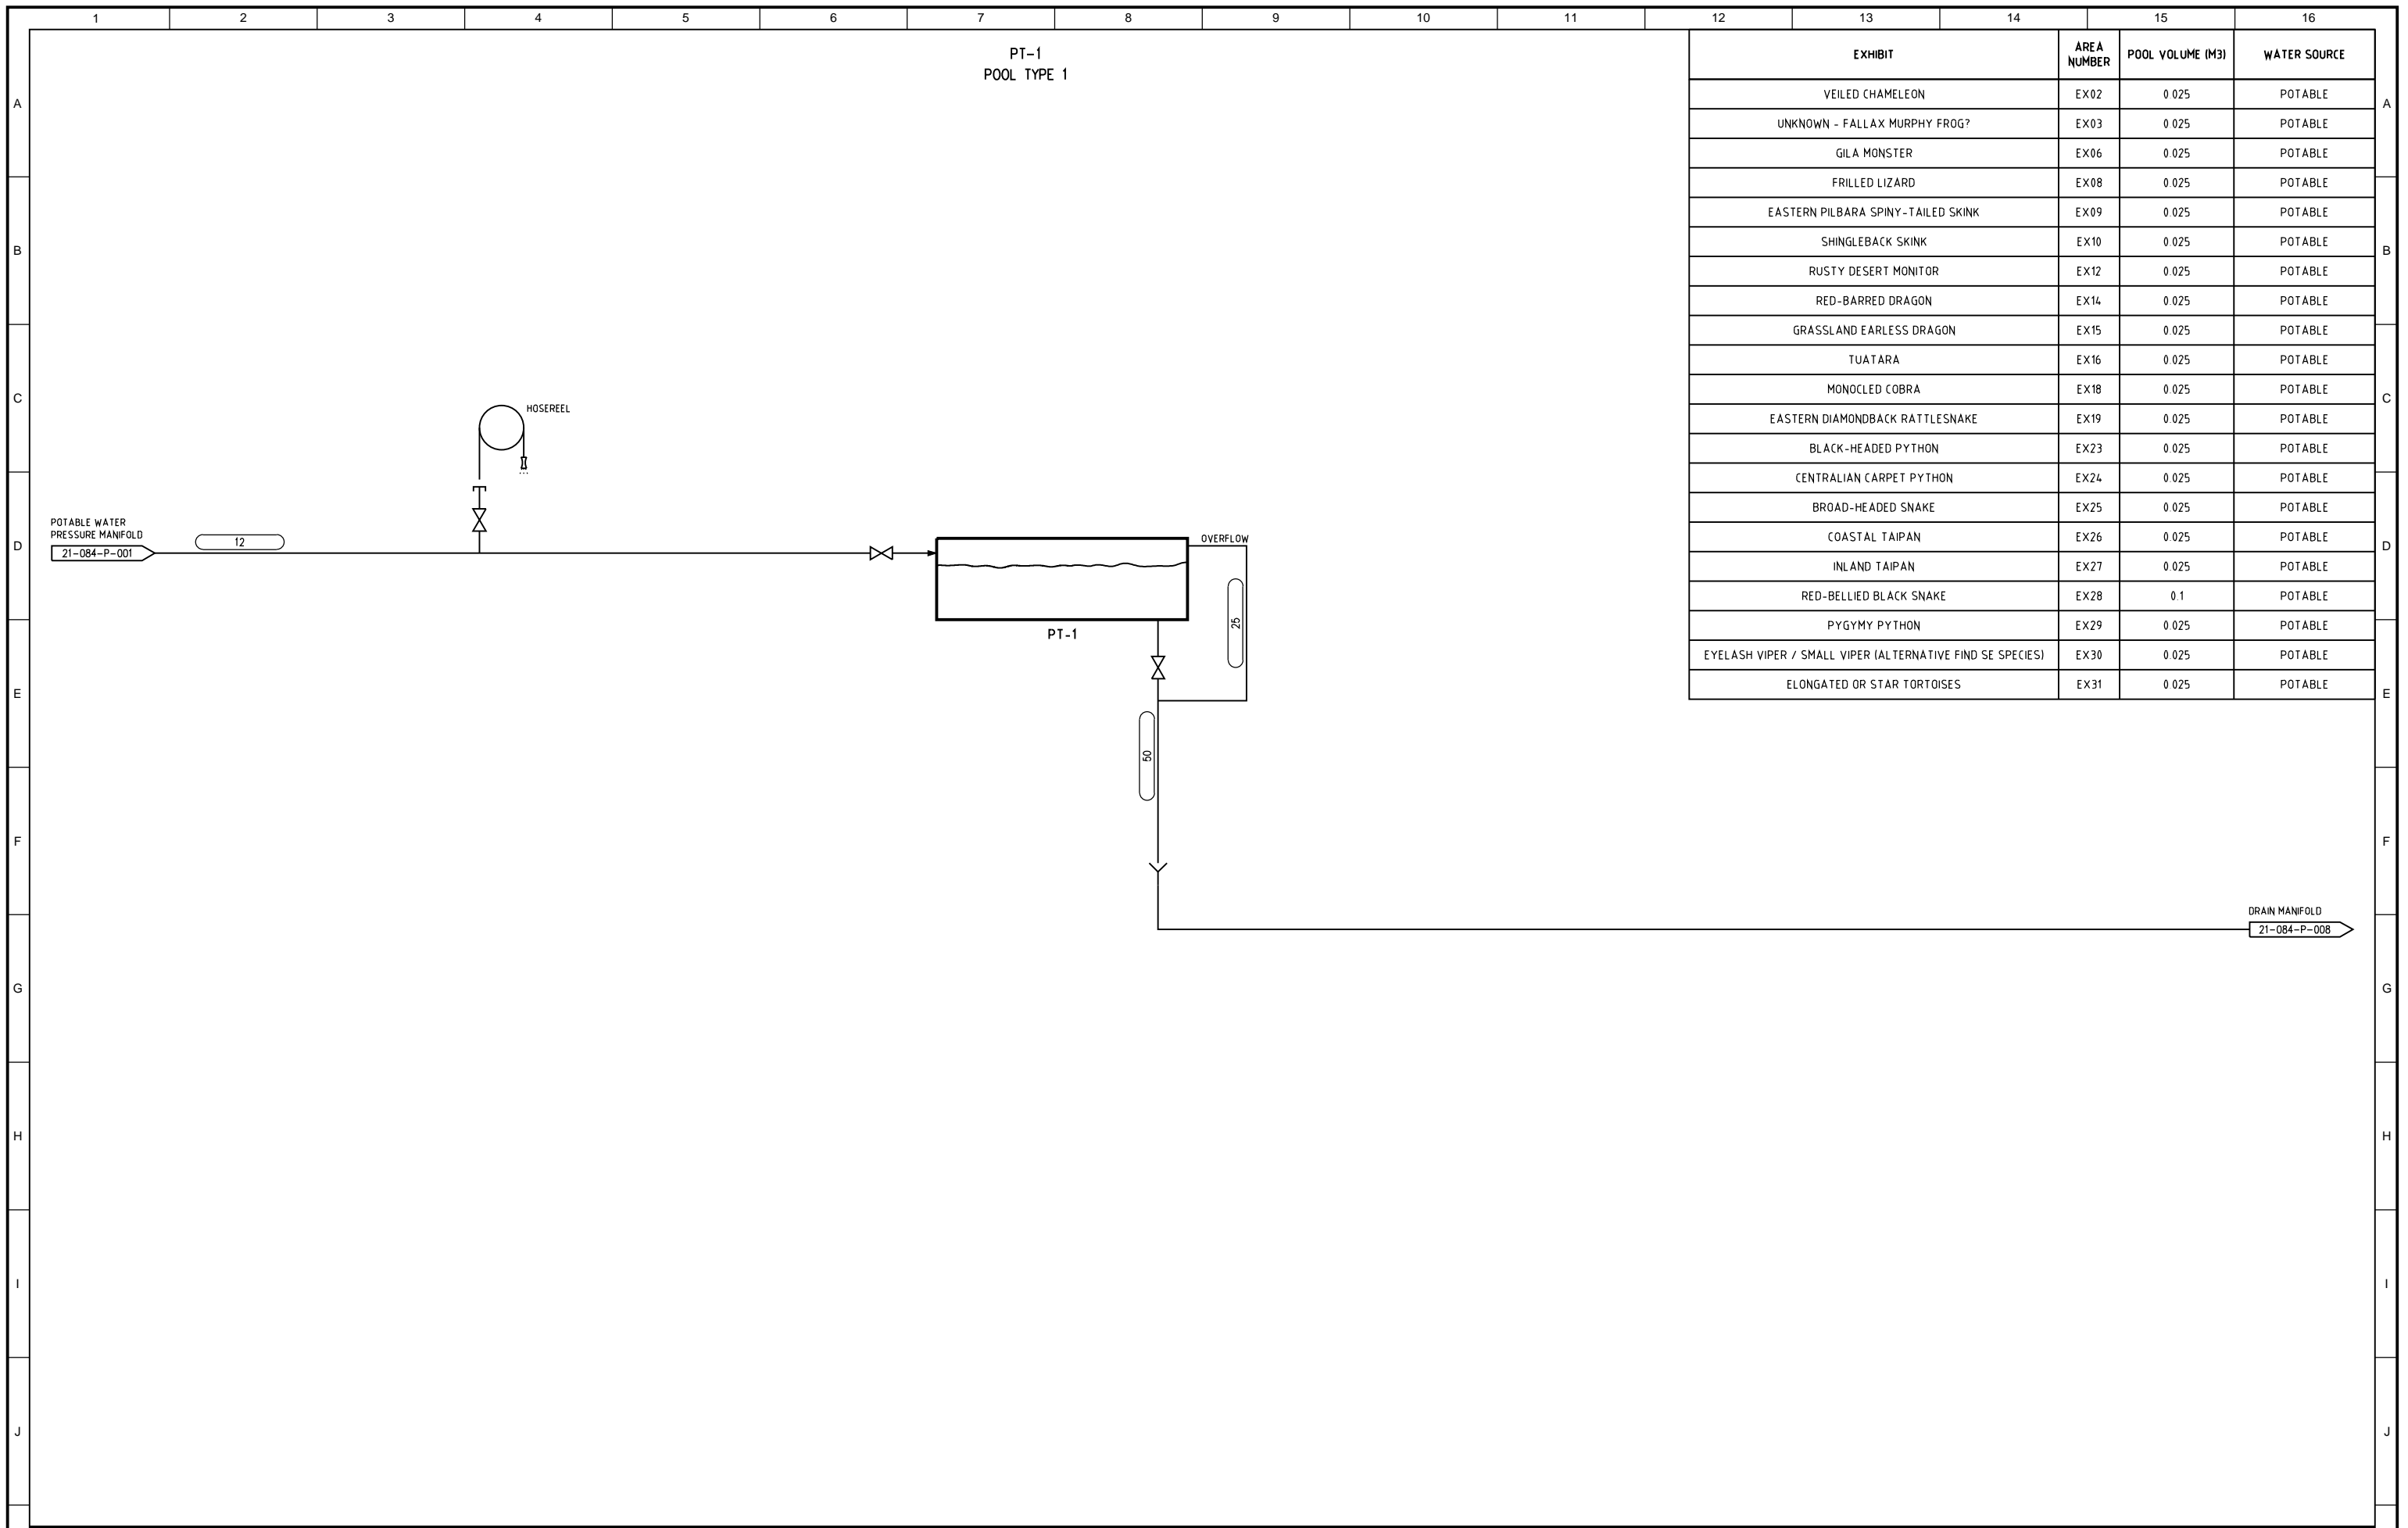


EXHIBIT	AREA NUMBER	POOL VOLUME (M3)	WATER SOURCE
VEILED CHAMELEON	EX02	0.025	POTABLE
UNKNOWN - FALLAX MURPHY FROG?	EX03	0.025	POTABLE
GILA MONSTER	EX06	0.025	POTABLE
FRILLED LIZARD	EX08	0.025	POTABLE
EASTERN PILBARA SPINY-TAILED SKINK	EX09	0.025	POTABLE
SHINGLEBACK SKINK	EX10	0.025	POTABLE
RUSTY DESERT MONITOR	EX12	0.025	POTABLE
RED-BARRED DRAGON	EX14	0.025	POTABLE
GRASSLAND EARLESS DRAGON	EX15	0.025	POTABLE
TUATARA	EX16	0.025	POTABLE
MONOCLED COBRA	EX18	0.025	POTABLE
EASTERN DIAMONDBACK RATTLESNAKE	EX19	0.025	POTABLE
BLACK-HEADED PYTHON	EX23	0.025	POTABLE
CENTRALIAN CARPET PYTHON	EX24	0.025	POTABLE
BROAD-HEADED SNAKE	EX25	0.025	POTABLE
COASTAL TAIPAN	EX26	0.025	POTABLE
INLAND TAIPAN	EX27	0.025	POTABLE
RED-BELLIED BLACK SNAKE	EX28	0.1	POTABLE
PYGYMY PYTHON	EX29	0.025	POTABLE
EYELASH VIPER / SMALL VIPER (ALTERNATIVE FIND SE SPECIES)	EX30	0.025	POTABLE
ELONGATED OR STAR TORTOISES	EX31	0.025	POTABLE

REV	ISSUED FOR REVIEW	LN	LP	SI	LN	DATE	DWG No.	REFERENCE
DES	DWN	CHK	APP	DATE	DWG No.	REFERENCE		
A	ISSUED FOR REVIEW				03/06/21			



THIS DRAWING SHALL REMAIN THE PROPERTY OF CNF & ASSOCIATES. IT SHALL NOT BE REPRODUCED OR COPIED WITHOUT EXPRESS PERMISSION OF THE OWNERS

**CNF & Associates**  
 Ph (02) 6296 6500 ABN 41 002 037 498  
 Email admin@cnfa.com.au Lvl 2, 393 George Street  
 Web www.cnfa.com.au Sydney N.S.W. 2000

DESIGN	L. NADOR	DATE	03/06/21	PROJECT	21-084	Client	TARONGA CONSERVATION SOCIETY
DRAWN	L. PERNICE	DATE	03/06/21	PLANT	RACC	Project	REPTILE & AMPHIBIAN CONSERVATION CENTRE
CHECKED	S. ISYCHOS	DATE	03/06/21	ENG. SECTION	ELECTRICAL	Title	POOL TYPE 1 P & ID
APPROVED	L. NADOR	DATE	03/06/21	SCALE	N/A	Original Size	A1
						Drawing No:	21-084-P-003
						Revision	A

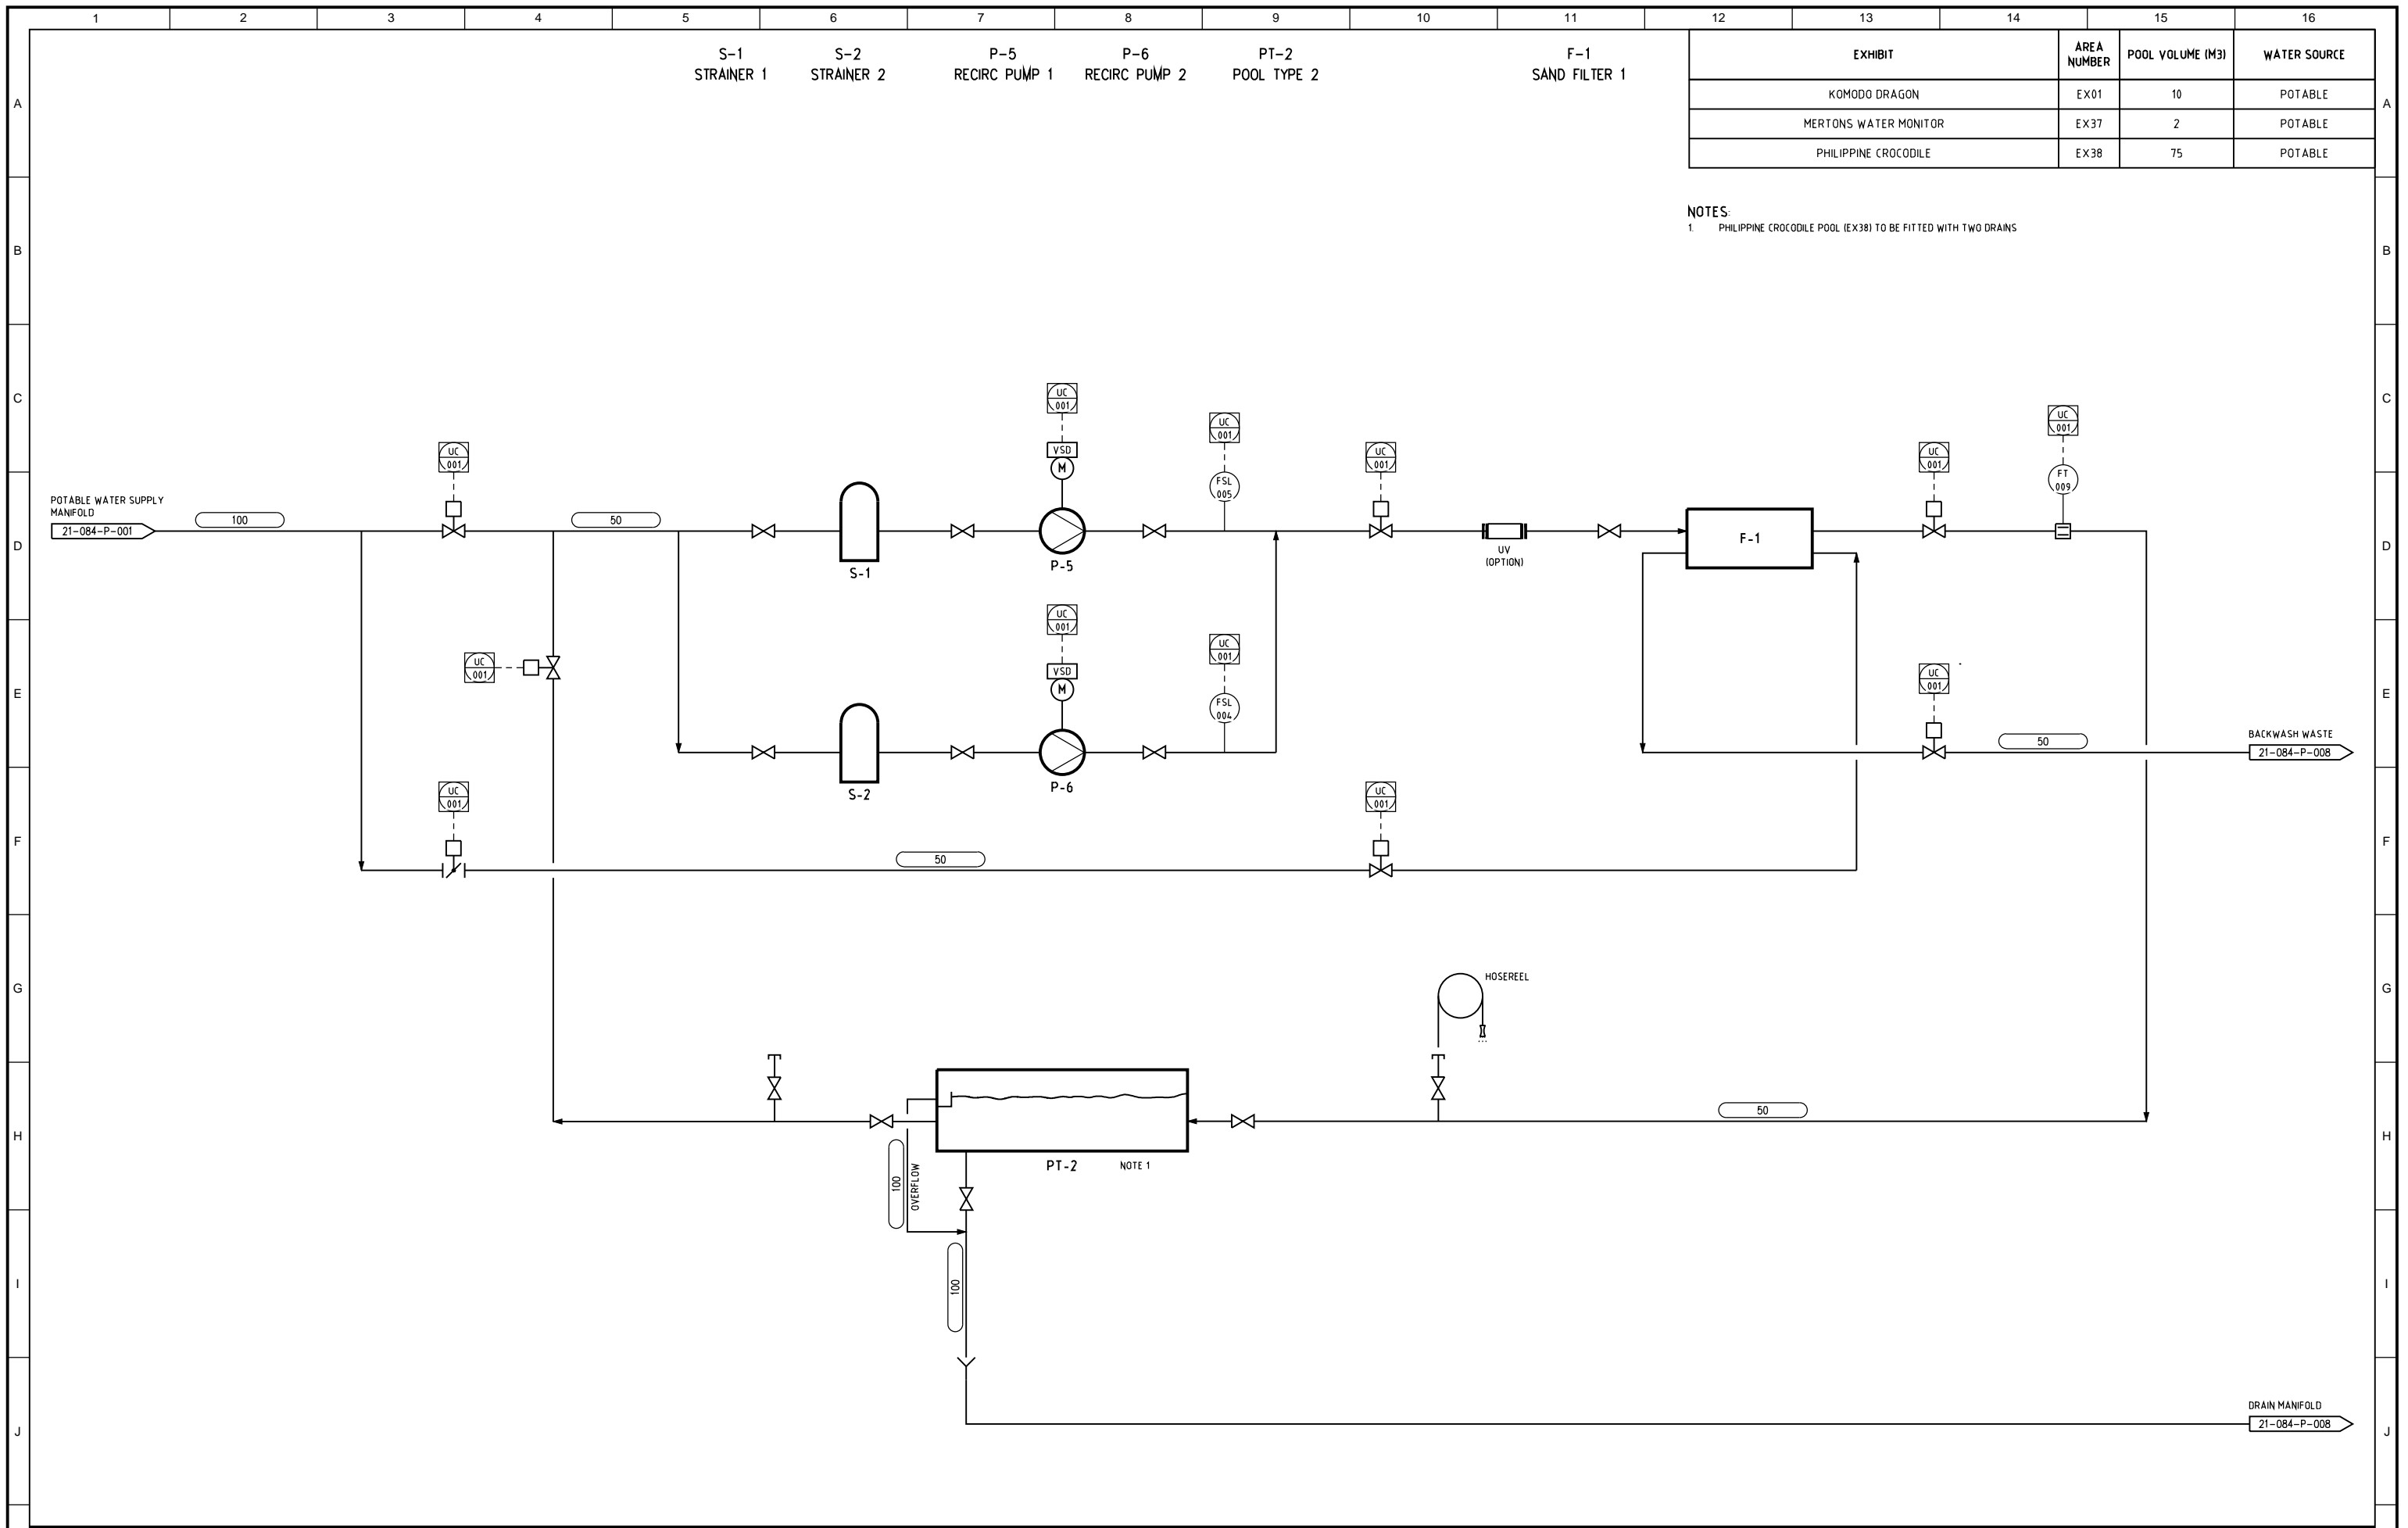


EXHIBIT	AREA NUMBER	POOL VOLUME (M3)	WATER SOURCE
KOMODO DRAGON	EX01	10	POTABLE
MERTONS WATER MONITOR	EX37	2	POTABLE
PHILIPPINE CROCODILE	EX38	75	POTABLE

NOTES:  
 1. PHILIPPINE CROCODILE POOL (EX38) TO BE FITTED WITH TWO DRAINS

REV	ISSUED FOR REVIEW	DES	DWN	CHK	APP	DATE	DWG No.	REFERENCE
A	ISSUED FOR REVIEW	L.N	L.P	S.I	L.N	03/06/21		



THIS DRAWING SHALL REMAIN THE PROPERTY OF CNF & ASSOCIATES. IT SHALL NOT BE REPRODUCED OR COPIED WITHOUT EXPRESS PERMISSION OF THE OWNERS



DESIGN	DATE	PROJECT
L. NADOR	03/06/21	21-084
DRAWN	DATE	PLANT
L. PERNICE	03/06/21	RACC
CHECKED	DATE	ENG. SECTION
S. ISYCHOS	03/06/21	ELECTRICAL
APPROVED	DATE	SCALE
L. NADOR	03/06/21	N/A

Client	Project	Title	Original Size	Drawing No:	Revision
TARONGA CONSERVATION SOCIETY	REPTILE & AMPHIBIAN CONSERVATION CENTRE	POOL TYPE 2 P & ID	A1	21-084-P-004	A

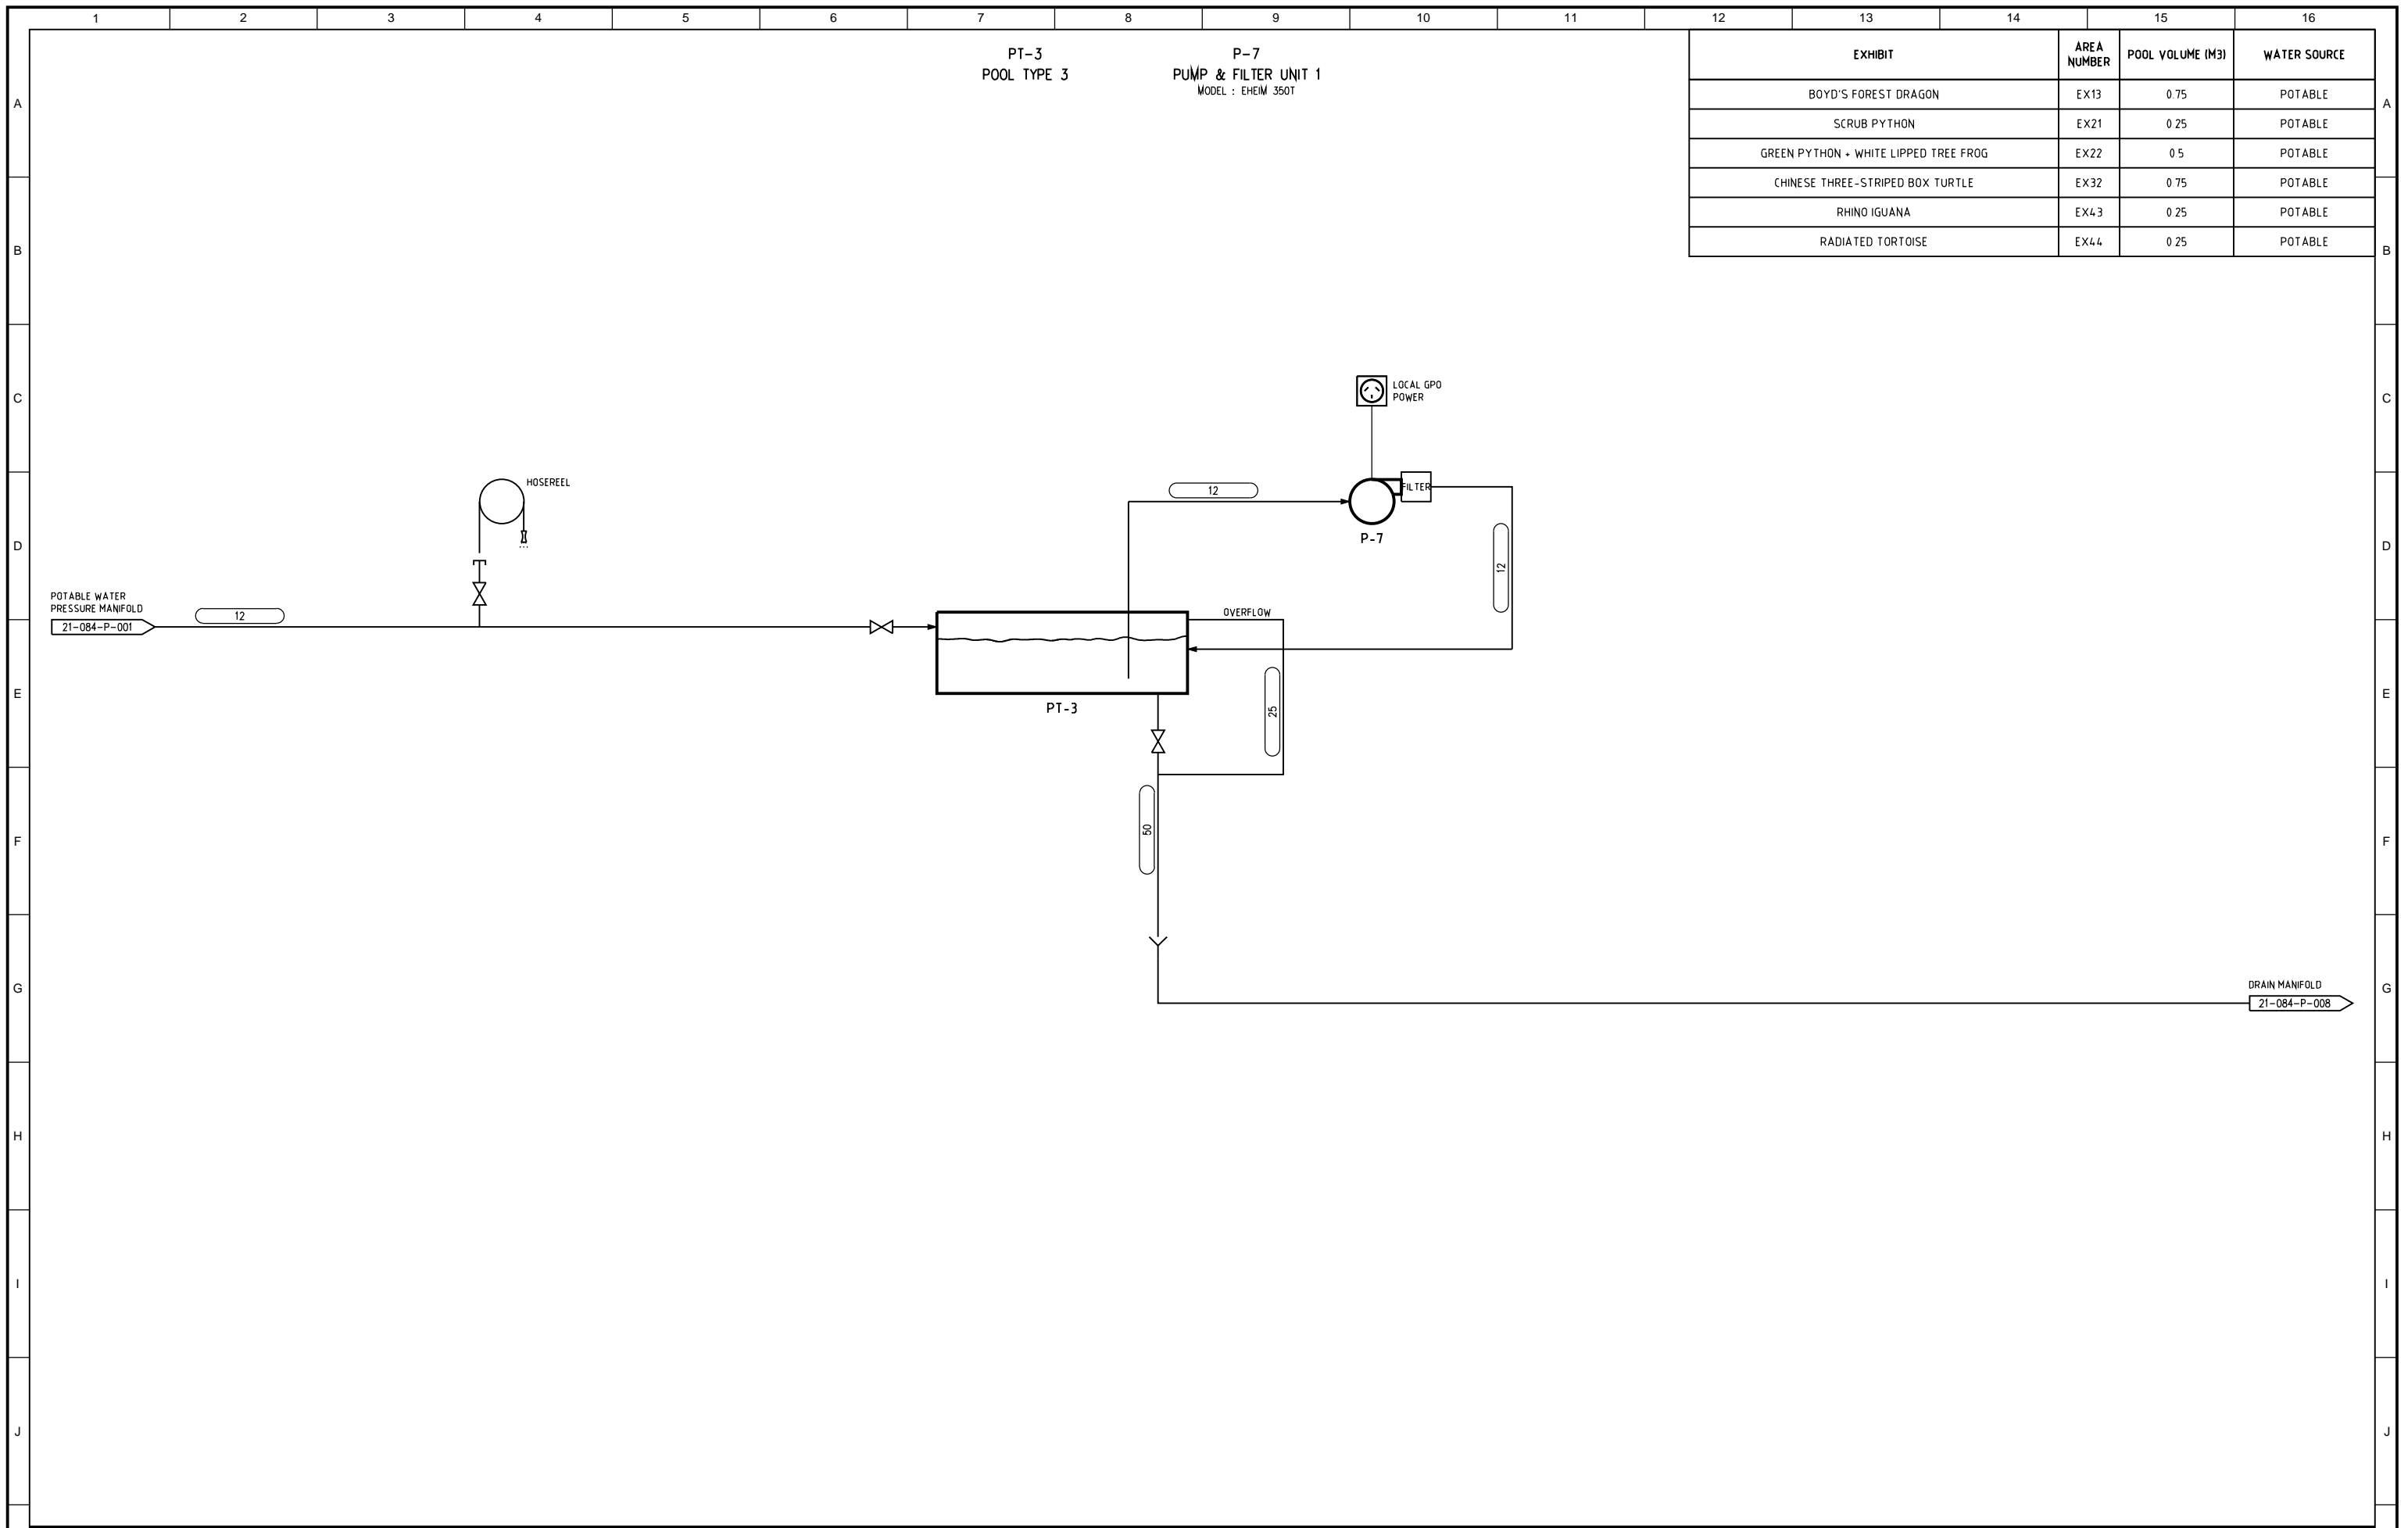


EXHIBIT	AREA NUMBER	POOL VOLUME (M3)	WATER SOURCE
BOYD'S FOREST DRAGON	EX13	0.75	POTABLE
SCRUB PYTHON	EX21	0.25	POTABLE
GREEN PYTHON - WHITE LIPPED TREE FROG	EX22	0.5	POTABLE
CHINESE THREE-STRIPED BOX TURTLE	EX32	0.75	POTABLE
RHINO IGUANA	EX43	0.25	POTABLE
RADIATED TORTOISE	EX44	0.25	POTABLE

REV	ISSUED FOR REVIEW	DES	DWN	CHK	APP	DATE	DWG No.	REFERENCE
A	ISSUED FOR REVIEW	L.N.	L.P.	S.I.	L.N.	03/06/21		



THIS DRAWING SHALL REMAIN THE PROPERTY OF CNF & ASSOCIATES. IT SHALL NOT BE REPRODUCED OR COPIED WITHOUT EXPRESS PERMISSION OF THE OWNERS

**CNF & Associates**  
 Ph (02) 8296 6500  
 Email admin@cnfa.com.au  
 Web www.cnfa.com.au  
 ABN 41 002 037 498  
 Lvl 2, 393 George Street  
 Sydney N.S.W. 2000

DESIGN	L. NADOR	DATE	03/06/21	PROJECT	21-084	Client	TARONGA CONSERVATION SOCIETY
DRAWN	L. PERNICE	DATE	03/06/21	PLANT	RACC	Project	REPTILE & AMPHIBIAN CONSERVATION CENTRE
CHECKED	S. ISYCHOS	DATE	03/06/21	ENG. SECTION	ELECTRICAL	Title	POOL TYPE 3 P & ID
APPROVED	L. NADOR	DATE	03/06/21	SCALE	N/A	Original Size	A1
						Drawing No:	21-084-P-005
						Revision	A

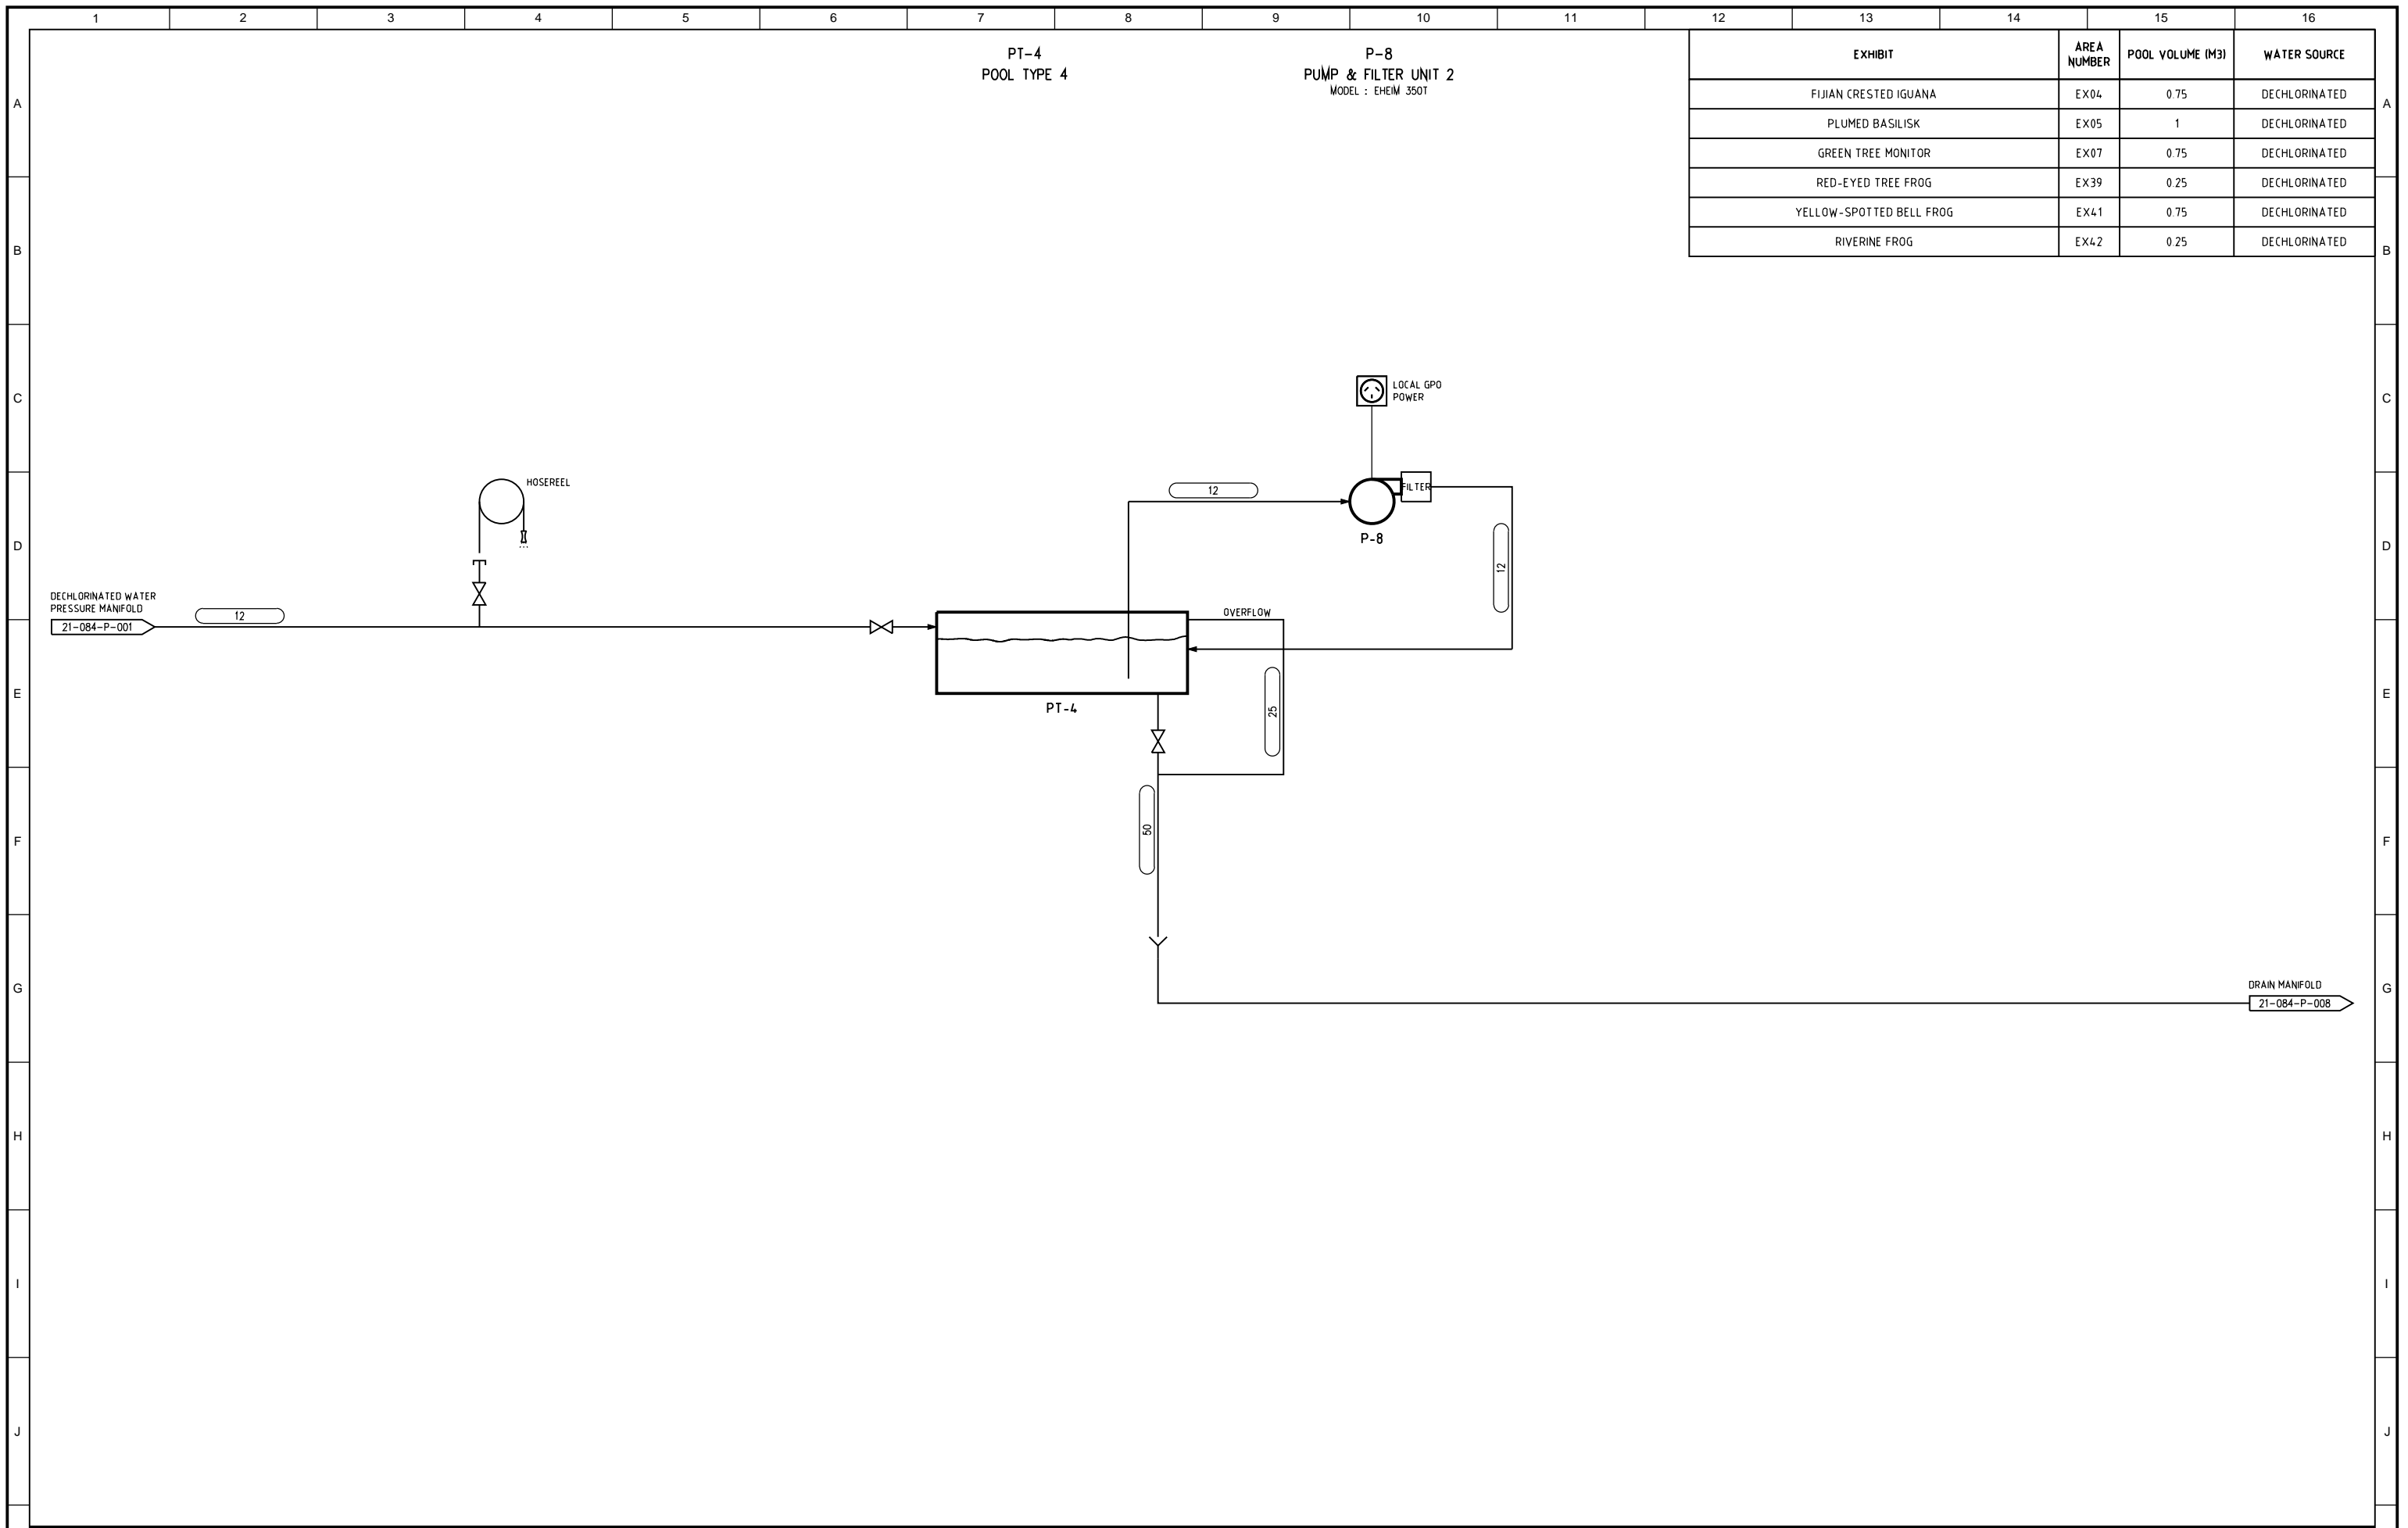


EXHIBIT	AREA NUMBER	POOL VOLUME (M3)	WATER SOURCE
FIJIAN CRESTED IGUANA	EX04	0.75	DECHLORINATED
PLUMED BASILISK	EX05	1	DECHLORINATED
GREEN TREE MONITOR	EX07	0.75	DECHLORINATED
RED-EYED TREE FROG	EX39	0.25	DECHLORINATED
YELLOW-SPOTTED BELL FROG	EX41	0.75	DECHLORINATED
RIVERINE FROG	EX42	0.25	DECHLORINATED

REV	ISSUED FOR REVIEW	LN	LP	SI	LN	03/06/21	DWG No.	REFERENCE
DES	DWN	CHK	APP	DATE	DWG No.	REFERENCE		



THIS DRAWING SHALL REMAIN THE PROPERTY OF CNF & ASSOCIATES. IT SHALL NOT BE REPRODUCED OR COPIED WITHOUT EXPRESS PERMISSION OF THE OWNERS



DESIGN	L. NADOR	DATE	03/06/21	PROJECT	21-084	Client	TARONGA CONSERVATION SOCIETY
DRAWN	L. PERNICE	DATE	03/06/21	PLANT	RACC	Project	REPTILE & AMPHIBIAN CONSERVATION CENTRE
CHECKED	S. ISYCHOS	DATE	03/06/21	ENG. SECTION	ELECTRICAL	Title	POOL TYPE 4 P & ID
APPROVED	L. NADOR	DATE	03/06/21	SCALE	N/A	Original Size	A1
						Drawing No:	21-084-P-006
						Revision	A

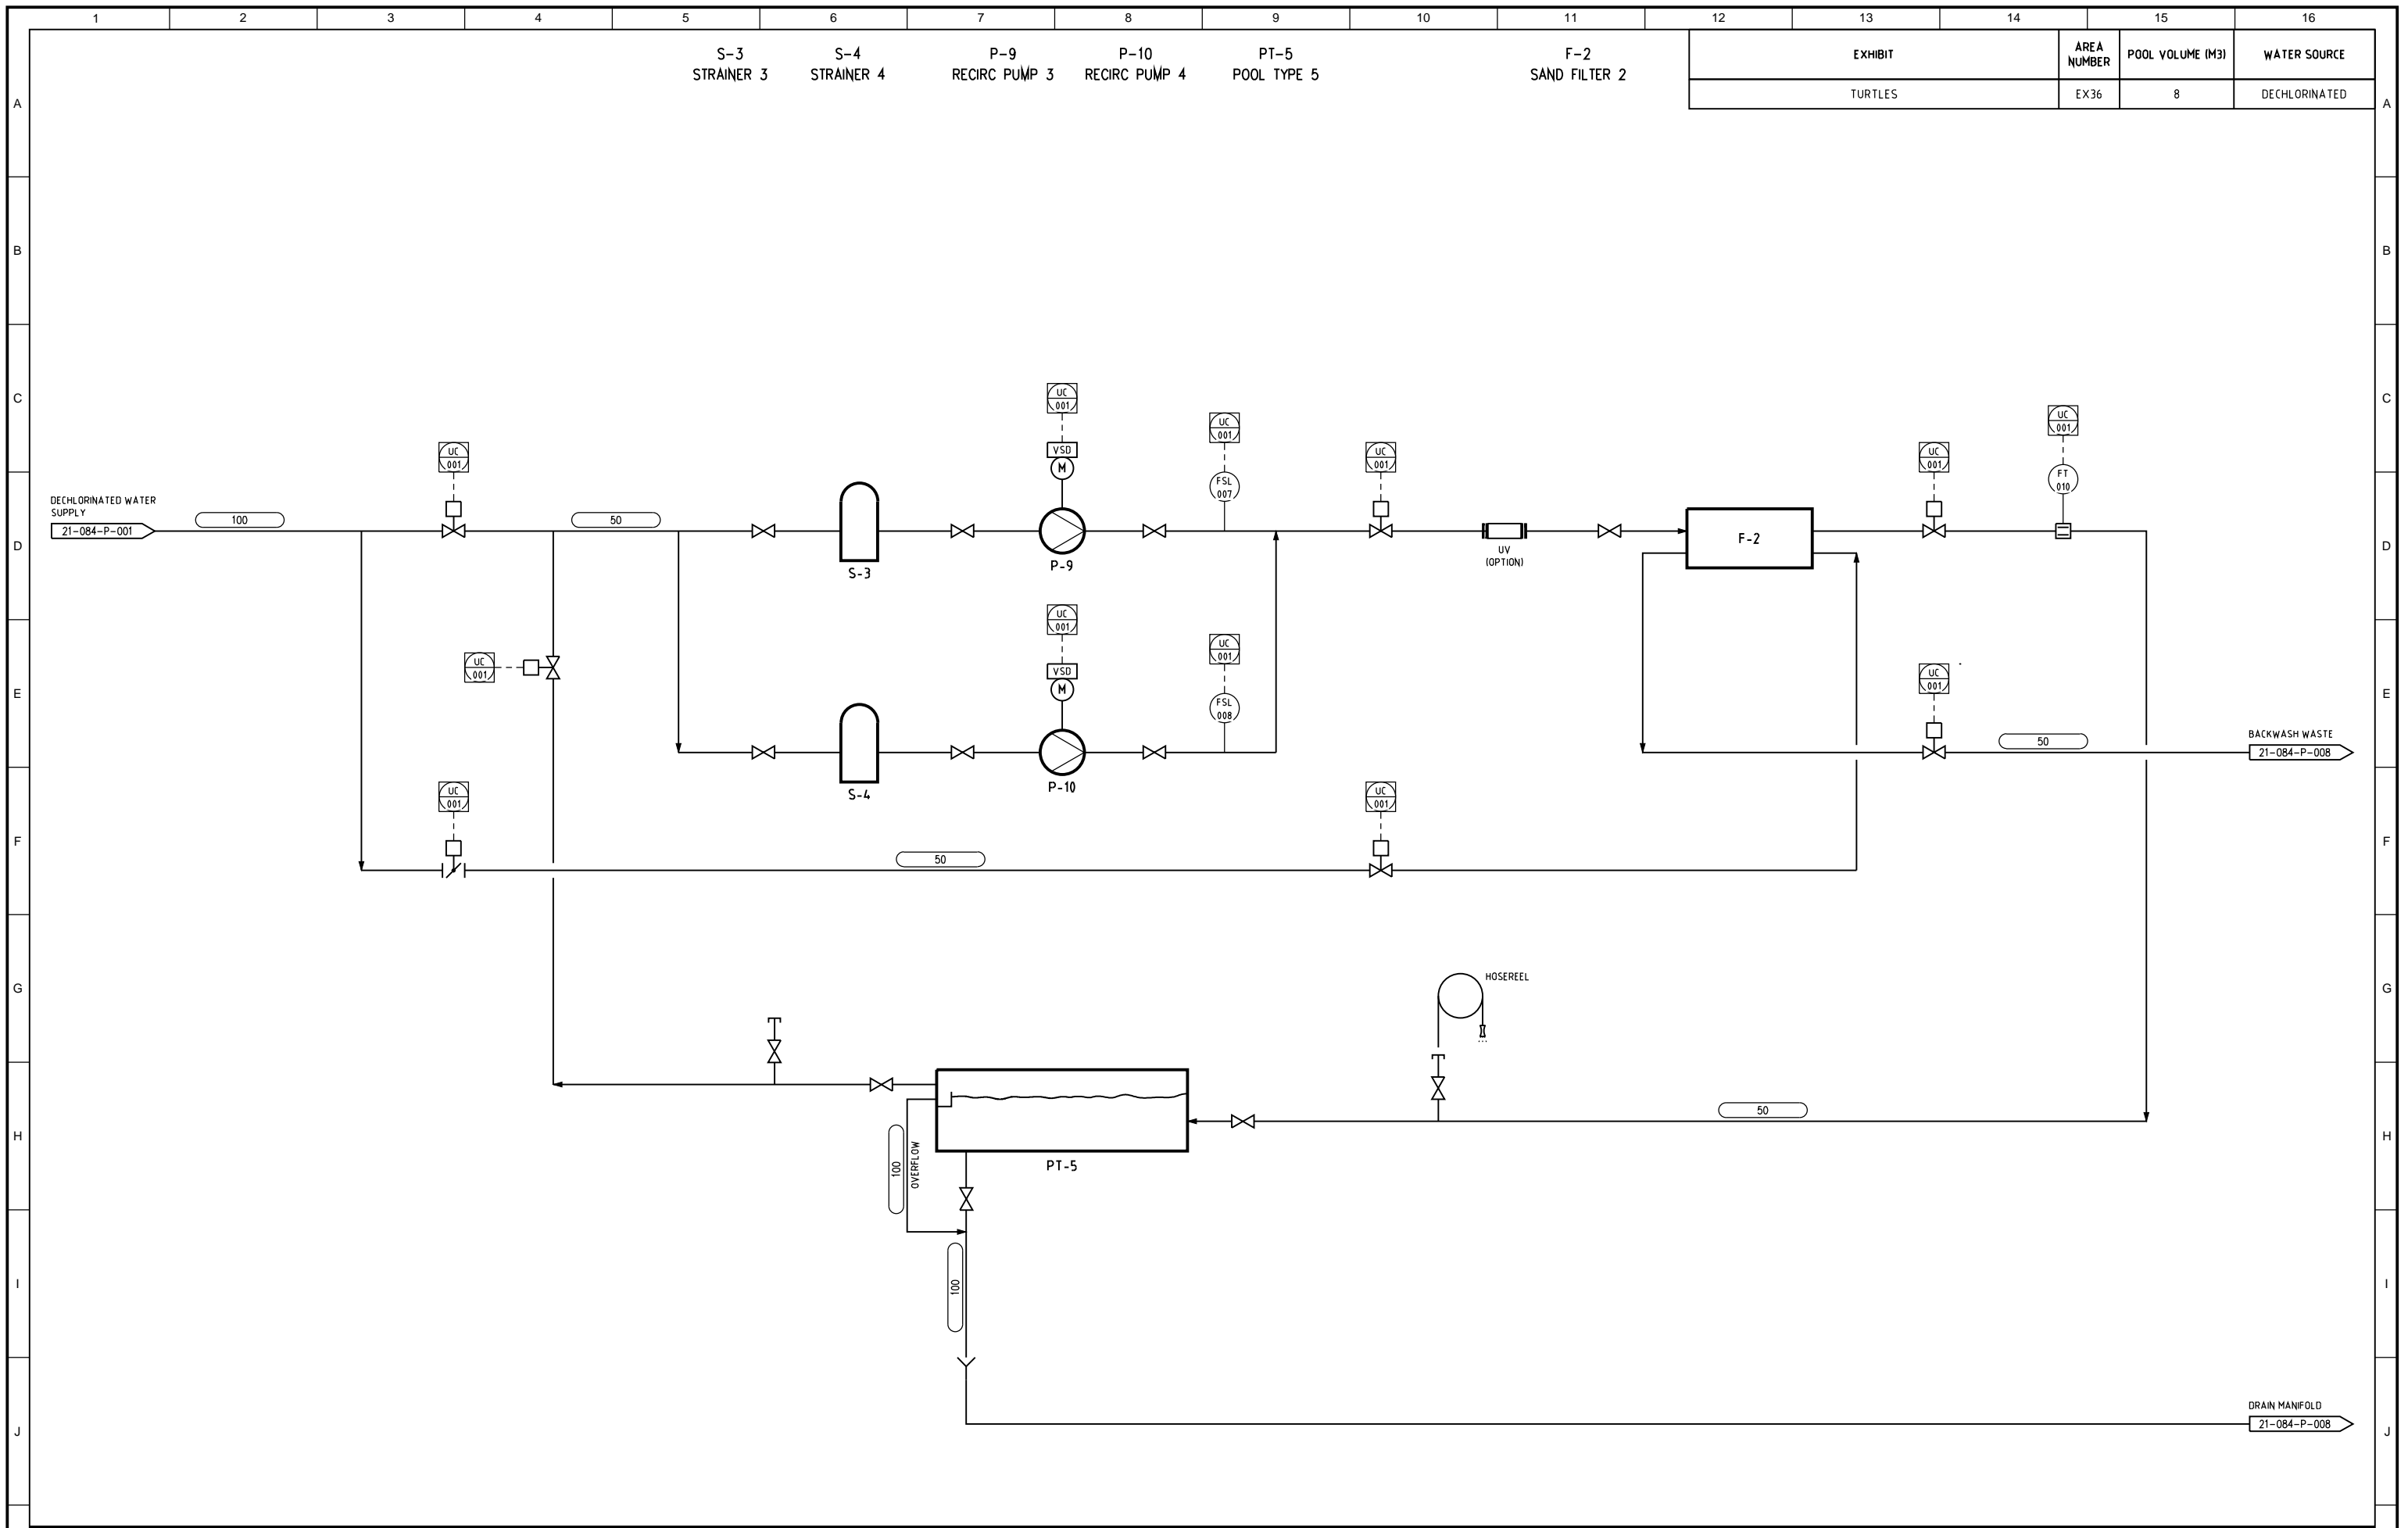


EXHIBIT	AREA NUMBER	POOL VOLUME (M3)	WATER SOURCE
TURTLES	EX36	8	DECHLORINATED

S-3 STRAINER 3    S-4 STRAINER 4    P-9 RECIRC PUMP 3    P-10 RECIRC PUMP 4    PT-5 POOL TYPE 5    F-2 SAND FILTER 2

REV	DESCRIPTION	DES	DWN	CHK	APP	DATE	DWG No.	REFERENCE
A	ISSUED FOR REVIEW	LN	LP	SI	LN	03/06/21		
	REVISION DETAILS							




THIS DRAWING SHALL REMAIN THE PROPERTY OF CNF & ASSOCIATES. IT SHALL NOT BE REPRODUCED OR COPIED WITHOUT EXPRESS PERMISSION OF THE OWNERS

**CNF & Associates**  
 Ph (02) 6296 6500    ABN 41 002 037 498  
 Email admin@cnfa.com.au    Lvl 2, 393 George Street  
 Web www.cnfa.com.au    Sydney N.S.W. 2000

DESIGN	DATE	PROJECT
L. NADOR	03/06/21	21-084
DRAWN	DATE	PLANT
L. PERNICE	03/06/21	RACC
CHECKED	DATE	ENG. SECTION
S. ISYCHOS	03/06/21	ELECTRICAL
APPROVED	DATE	SCALE
L. NADOR	03/06/21	N/A

Client	Project	Title
TARONGA CONSERVATION SOCIETY	REPTILE & AMPHIBIAN CONSERVATION CENTRE	POOL TYPE 5 P & ID
Original Size	Drawing No:	Revision
A1	21-084-P-007	A

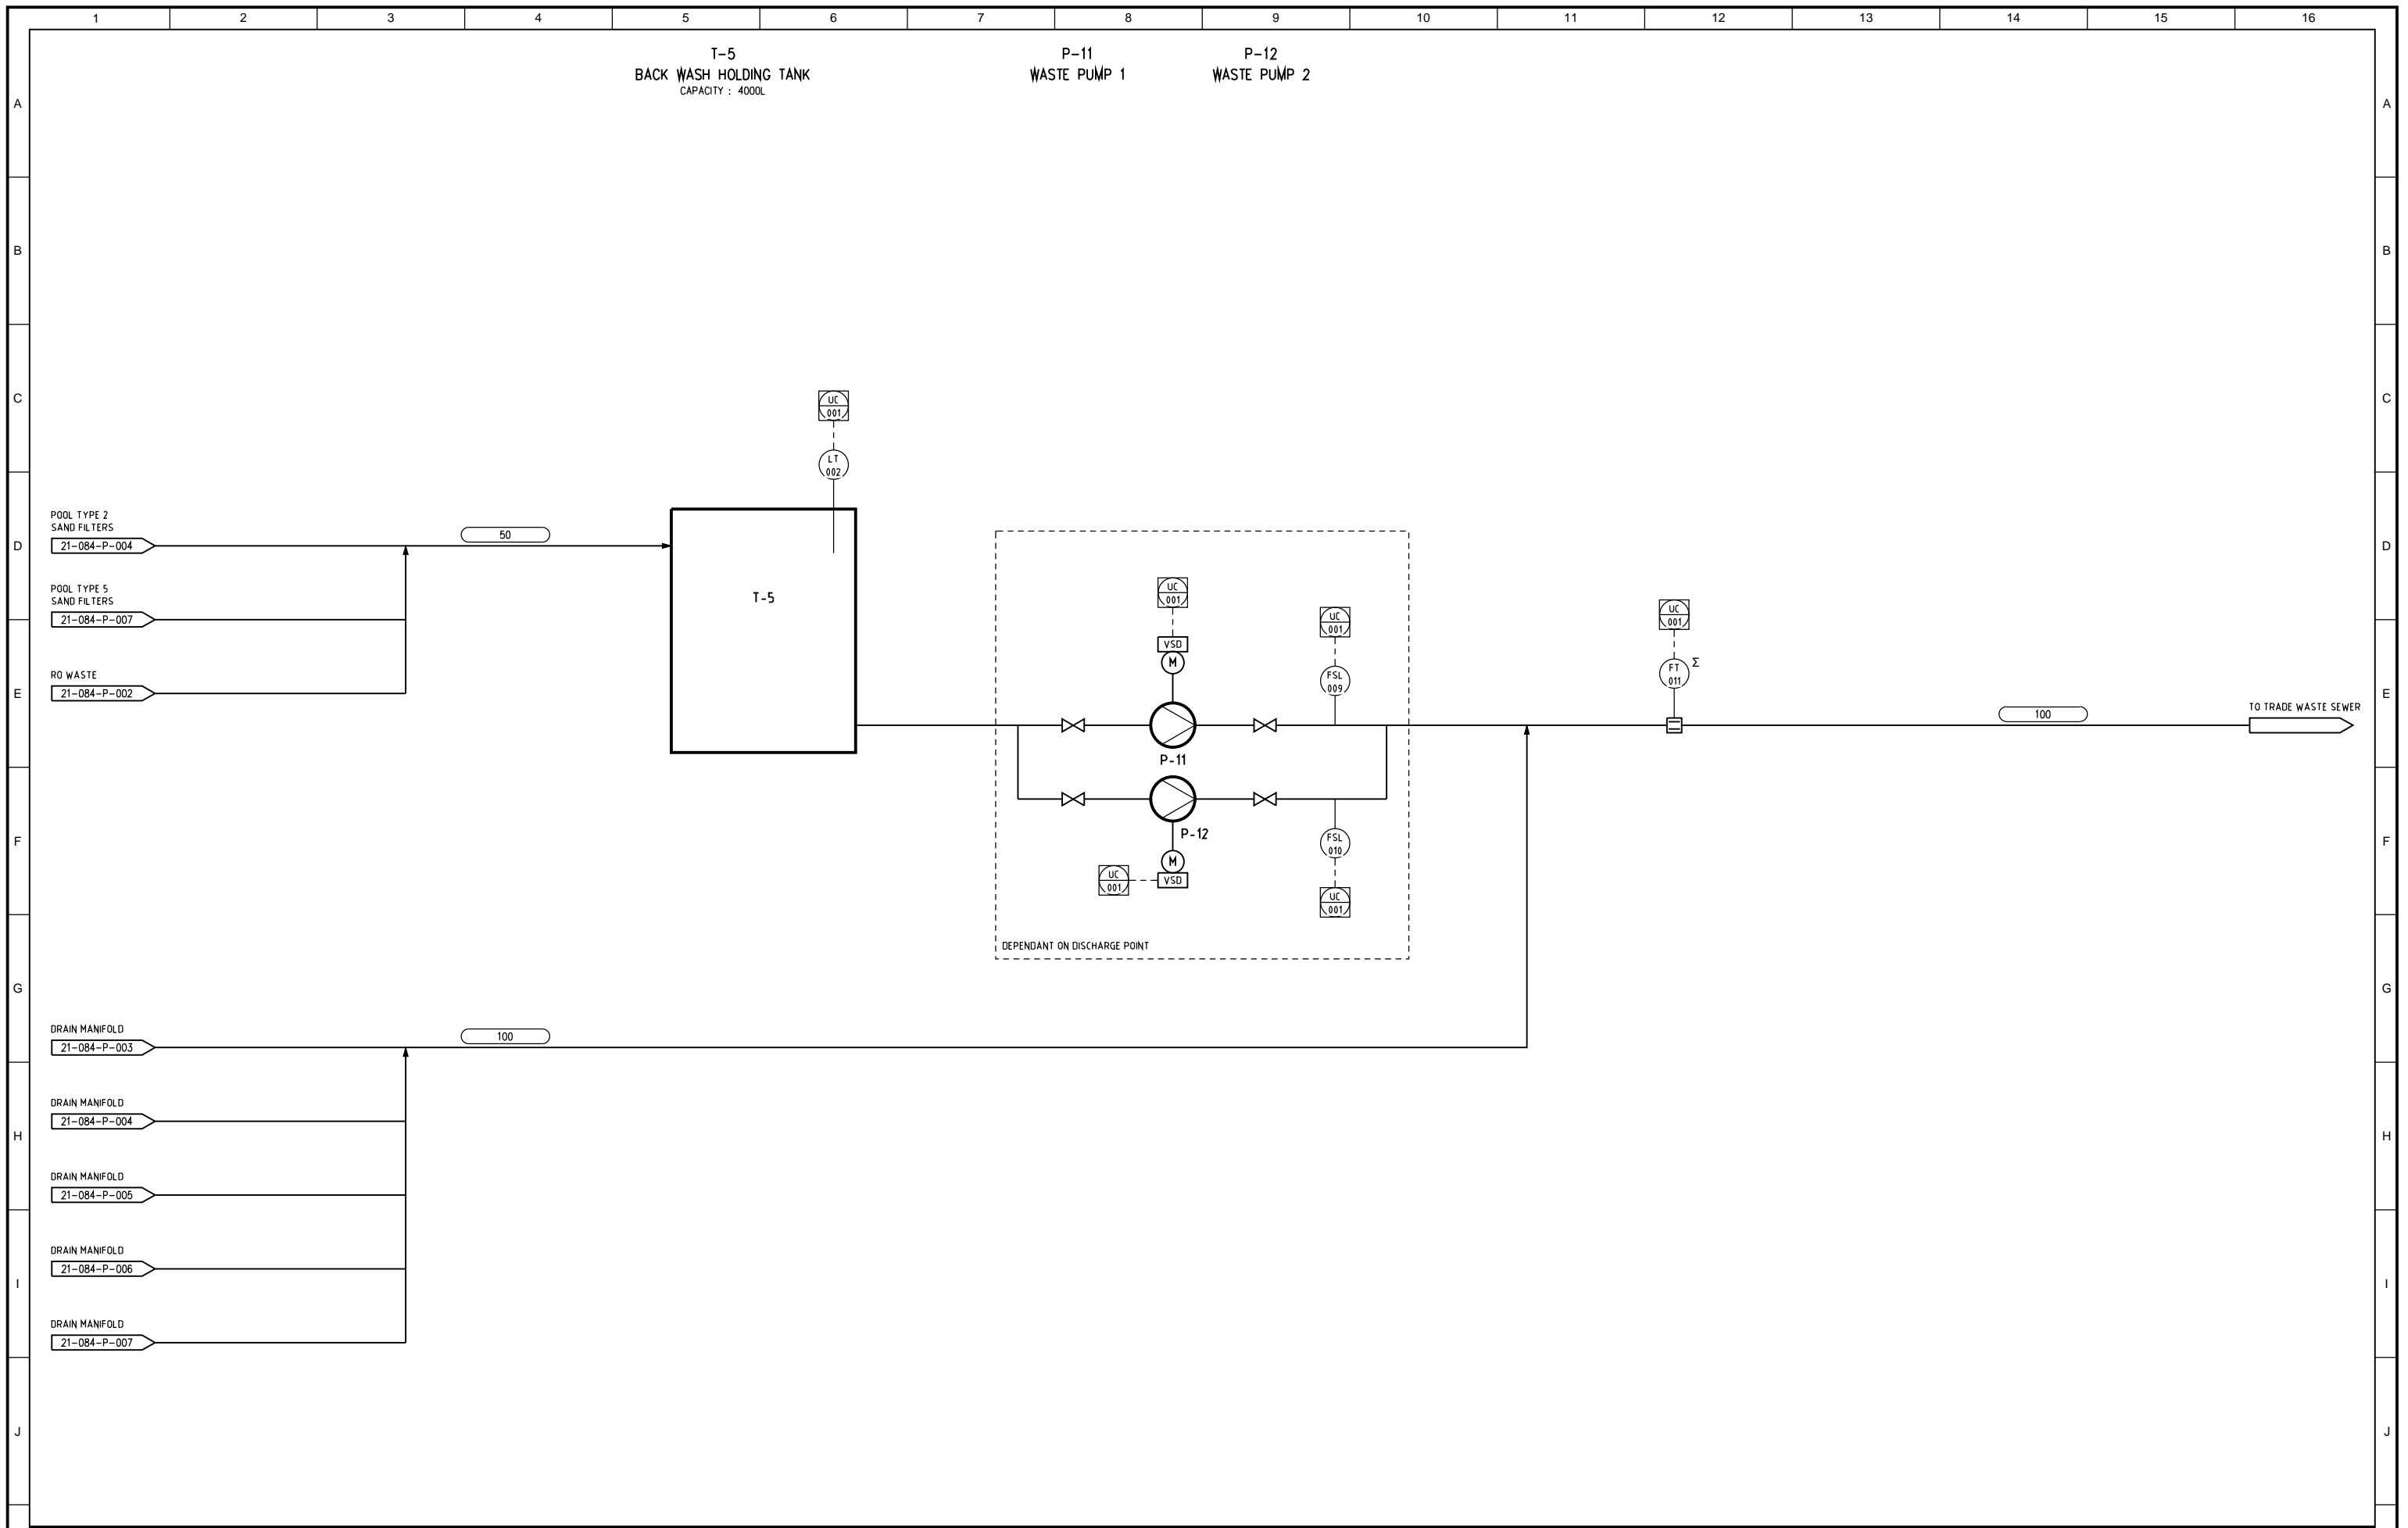

REV	DESCRIPTION	DES	DWN	CHK	APP	DATE	DWG No.	REFERENCE
A	ISSUED FOR REVIEW					03/06/21		
1								
2								
3								
4								
5								



THIS DRAWING SHALL REMAIN THE PROPERTY OF CNF & ASSOCIATES. IT SHALL NOT BE REPRODUCED OR COPIED WITHOUT EXPRESS PERMISSION OF THE OWNERS



DESIGN	L. NADOR	DATE	03/06/21	PROJECT	21-084
DRAWN	L. PERNICE	DATE	03/06/21	PLANT	RACC
CHECKED	S. ISYCHOS	DATE	03/06/21	ENG. SECTION	ELECTRICAL
APPROVED	L. NADOR	DATE	03/06/21	SCALE	N/A


Client	TARONGA CONSERVATION SOCIETY
Project	REPTILE & AMPHIBIAN CONSERVATION CENTRE
Title	BACKWASH P & ID
Original Size	A1
Drawing No.	21-084-P-008
Revision	A



**21-084-SCH-001\_A**  
**RACC EXHIBIT WATER REQUIREMENTS SUMMARY**

Description	Area Number	Datasheet Page	Pool Volume (m3)	Water Source	Pool Type	Turnover Time (hrs)	Recirc Pump Rate (m3/hr)	UV	Filter Area (m2)	Filter Media Volume (Litre)	Filter Backwash Volume (Litre)	Acceptable Filling Time (hrs)	Calculated Filling Flow Rate (m3/hr)	Pump Head (m)	Pump Size (kW)	Filter	Pump
<b>Species Exhibit Areas</b>																	
Komodo Dragon	EX01	48	10	Potable	Type 2	2	5	Yes	0.25	161	945	2	5	15	0.29	Waterco SD600	Silensor SLS 150
Veiled Chameleon	EX02	51	0.025	Potable	Type 1	-	-	No	-	-	-	-	-	-	-	-	-
Unknown - Fallax Murphy Frog?	EX03	54	0.025	Potable	Type 1	-	-	No	-	-	-	-	-	-	-	-	-
Fijian Crested Iguana	EX04	57	0.75	Dechlorinated	Type 4	2	0.375	No	0.02	-	-	-	-	-	-	Eheim 350T	Included in filter
Plumed Basilisk	EX05	59	1	Dechlorinated	Type 4	1	1	No	0.05	-	-	-	-	-	-	Eheim 350T	Included in filter
Gila Monster	EX06	62	0.025	Potable	Type 1	-	-	No	-	-	-	-	-	-	-	-	-
Green Tree Monitor	EX07	64	0.75	Dechlorinated	Type 4	1	0.75	No	0.04	-	-	-	-	-	-	Eheim 350T	Included in filter
Frilled lizard	EX08	66	0.025	Potable	Type 1	-	-	No	-	-	-	-	-	-	-	-	-
Eastern pilbara spiny-tailed skink	EX09	68	0.025	Potable	Type 1	-	-	No	-	-	-	-	-	-	-	-	-
Shingleback skink	EX10	70	0.025	Potable	Type 1	-	-	No	-	-	-	-	-	-	-	-	-
Slater's skink	EX11	72	-	-	-	-	-	-	-	-	-	-	-	-	-	-	-
Rusty desert monitor	EX12	74	0.025	Potable	Type 1	-	-	No	-	-	-	-	-	-	-	-	-
Boyd's Forest Dragon	EX13	76	0.75	Potable	Type 3	2	0.375	No	0.02	-	-	-	-	-	-	Eheim 350T	Included in filter
Red-barred dragon	EX14	78	0.025	Potable	Type 1	-	-	No	-	-	-	-	-	-	-	-	-
Grassland earless dragon	EX15	80	0.025	Potable	Type 1	-	-	No	-	-	-	-	-	-	-	-	-
Tuatara	EX16	82	0.025	Potable	Type 1	-	-	No	-	-	-	-	-	-	-	-	-
Reticulated Python	EX17	84	-	-	-	-	-	-	-	-	-	-	-	-	-	-	-
Monocled Cobra	EX18	86	0.025	Potable	Type 1	-	-	No	-	-	-	-	-	-	-	-	-
Eastern Diamondback Rattlesnake	EX19	88	0.025	Potable	Type 1	-	-	No	-	-	-	-	-	-	-	-	-
Scrub python	EX21	90	0.25	Potable	Type 3	2	0.125	No	0.006	-	-	-	-	-	-	Eheim 350T	Included in filter
Green Python + White Lipped Tree Frog	EX22	92	0.5	Potable	Type 3	2	0.25	No	0.013	-	-	-	-	-	-	Eheim 350T	Included in filter
Black-headed python	EX23	94	0.025	Potable	Type 1	-	-	No	-	-	-	-	-	-	-	-	-
Centralian Carpet Python	EX24	97	0.025	Potable	Type 1	-	-	No	-	-	-	-	-	-	-	-	-
Broad-headed Snake	EX25	100	0.025	Potable	Type 1	-	-	No	-	-	-	-	-	-	-	-	-
Coastal taipan	EX26	102	0.025	Potable	Type 1	-	-	No	-	-	-	-	-	-	-	-	-
Inland Taipan	EX27	104	0.025	Potable	Type 1	-	-	No	-	-	-	-	-	-	-	-	-
Red-bellied Black Snake	EX28	106	0.1	Potable	Type 1	-	-	No	-	-	-	-	-	-	-	-	-
Pygmy python	EX29	108	0.025	Potable	Type 1	-	-	No	-	-	-	-	-	-	-	-	-
Eyelash Viper / small viper (Alternative find SE species)	EX30	110	0.025	Potable	Type 1	-	-	No	-	-	-	-	-	-	-	-	-
Elongated or Star Tortoises	EX31	112	0.025	Potable	Type 1	-	-	No	-	-	-	-	-	-	-	-	-
Chinese Three-striped Box Turtle	EX32	116	0.75	Potable	Type 3	2	0.375	No	0.02	-	-	-	-	-	-	Eheim 350T	Included in filter
Aligator Snapping Turtle	EX33	-	-	-	-	-	-	-	-	-	-	-	-	-	-	-	-
Turtles	EX36	119	8	Dechlorinated	Type 5	2	4	No	0.2	105	655	2	4	15	0.23	Waterco SD500	Silensor SLS 150
Mertons Water Monitor	EX37	121	2	Potable	Type 2	2	1	No	0.05	68	420	2	1	15	0.06	Waterco SD400	Silensor SLS 100
Philippine Crocodile	EX38	123	75	Potable	Type 2	2	37.5	Yes	1.875	1131	6360	2	37.5	15	2.19	3 x Waterco SD900	2 x Silensor SLL 400
Red-eyed tree frog	EX39	125	0.25	Dechlorinated	Type 4	2	0.125	No	0.006	-	-	-	-	-	-	Eheim 350T	Included in filter
Corroboree Frog	EX40	127	0	-	-	-	-	-	-	-	-	-	-	-	-	-	-
Yellow-spotted Bell Frog	EX41	129	0.75	Dechlorinated	Type 4	2	0.375	No	0.019	-	-	-	-	-	-	Eheim 350T	Included in filter
Riverine Frog	EX42	130	0.25	Dechlorinated	Type 4	2	0.125	No	0.006	-	-	-	-	-	-	Eheim 350T	Included in filter
Rhino Iguana	EX43	131	0.25	Potable	Type 3	2	0.125	No	0.006	-	-	-	-	-	-	Eheim 350T	Included in filter
Radiated Tortoise	EX44	131	0.25	Potable	Type 3	2	0.125	No	0.006	-	-	-	-	-	-	Eheim 350T	Included in filter

Pool Types	Type	No. Off
Small Potable, no filtration	Type 1	21
Large Potable with Pressure Filter in plant room	Type 2	3
Small Potable with local filtration	Type 3	6
Small Dechlorinated, local filtration	Type 4	6
Large Dechlorinated with pressure filter in plant room	Type 5	1
<b>Total</b>		<b>37</b>

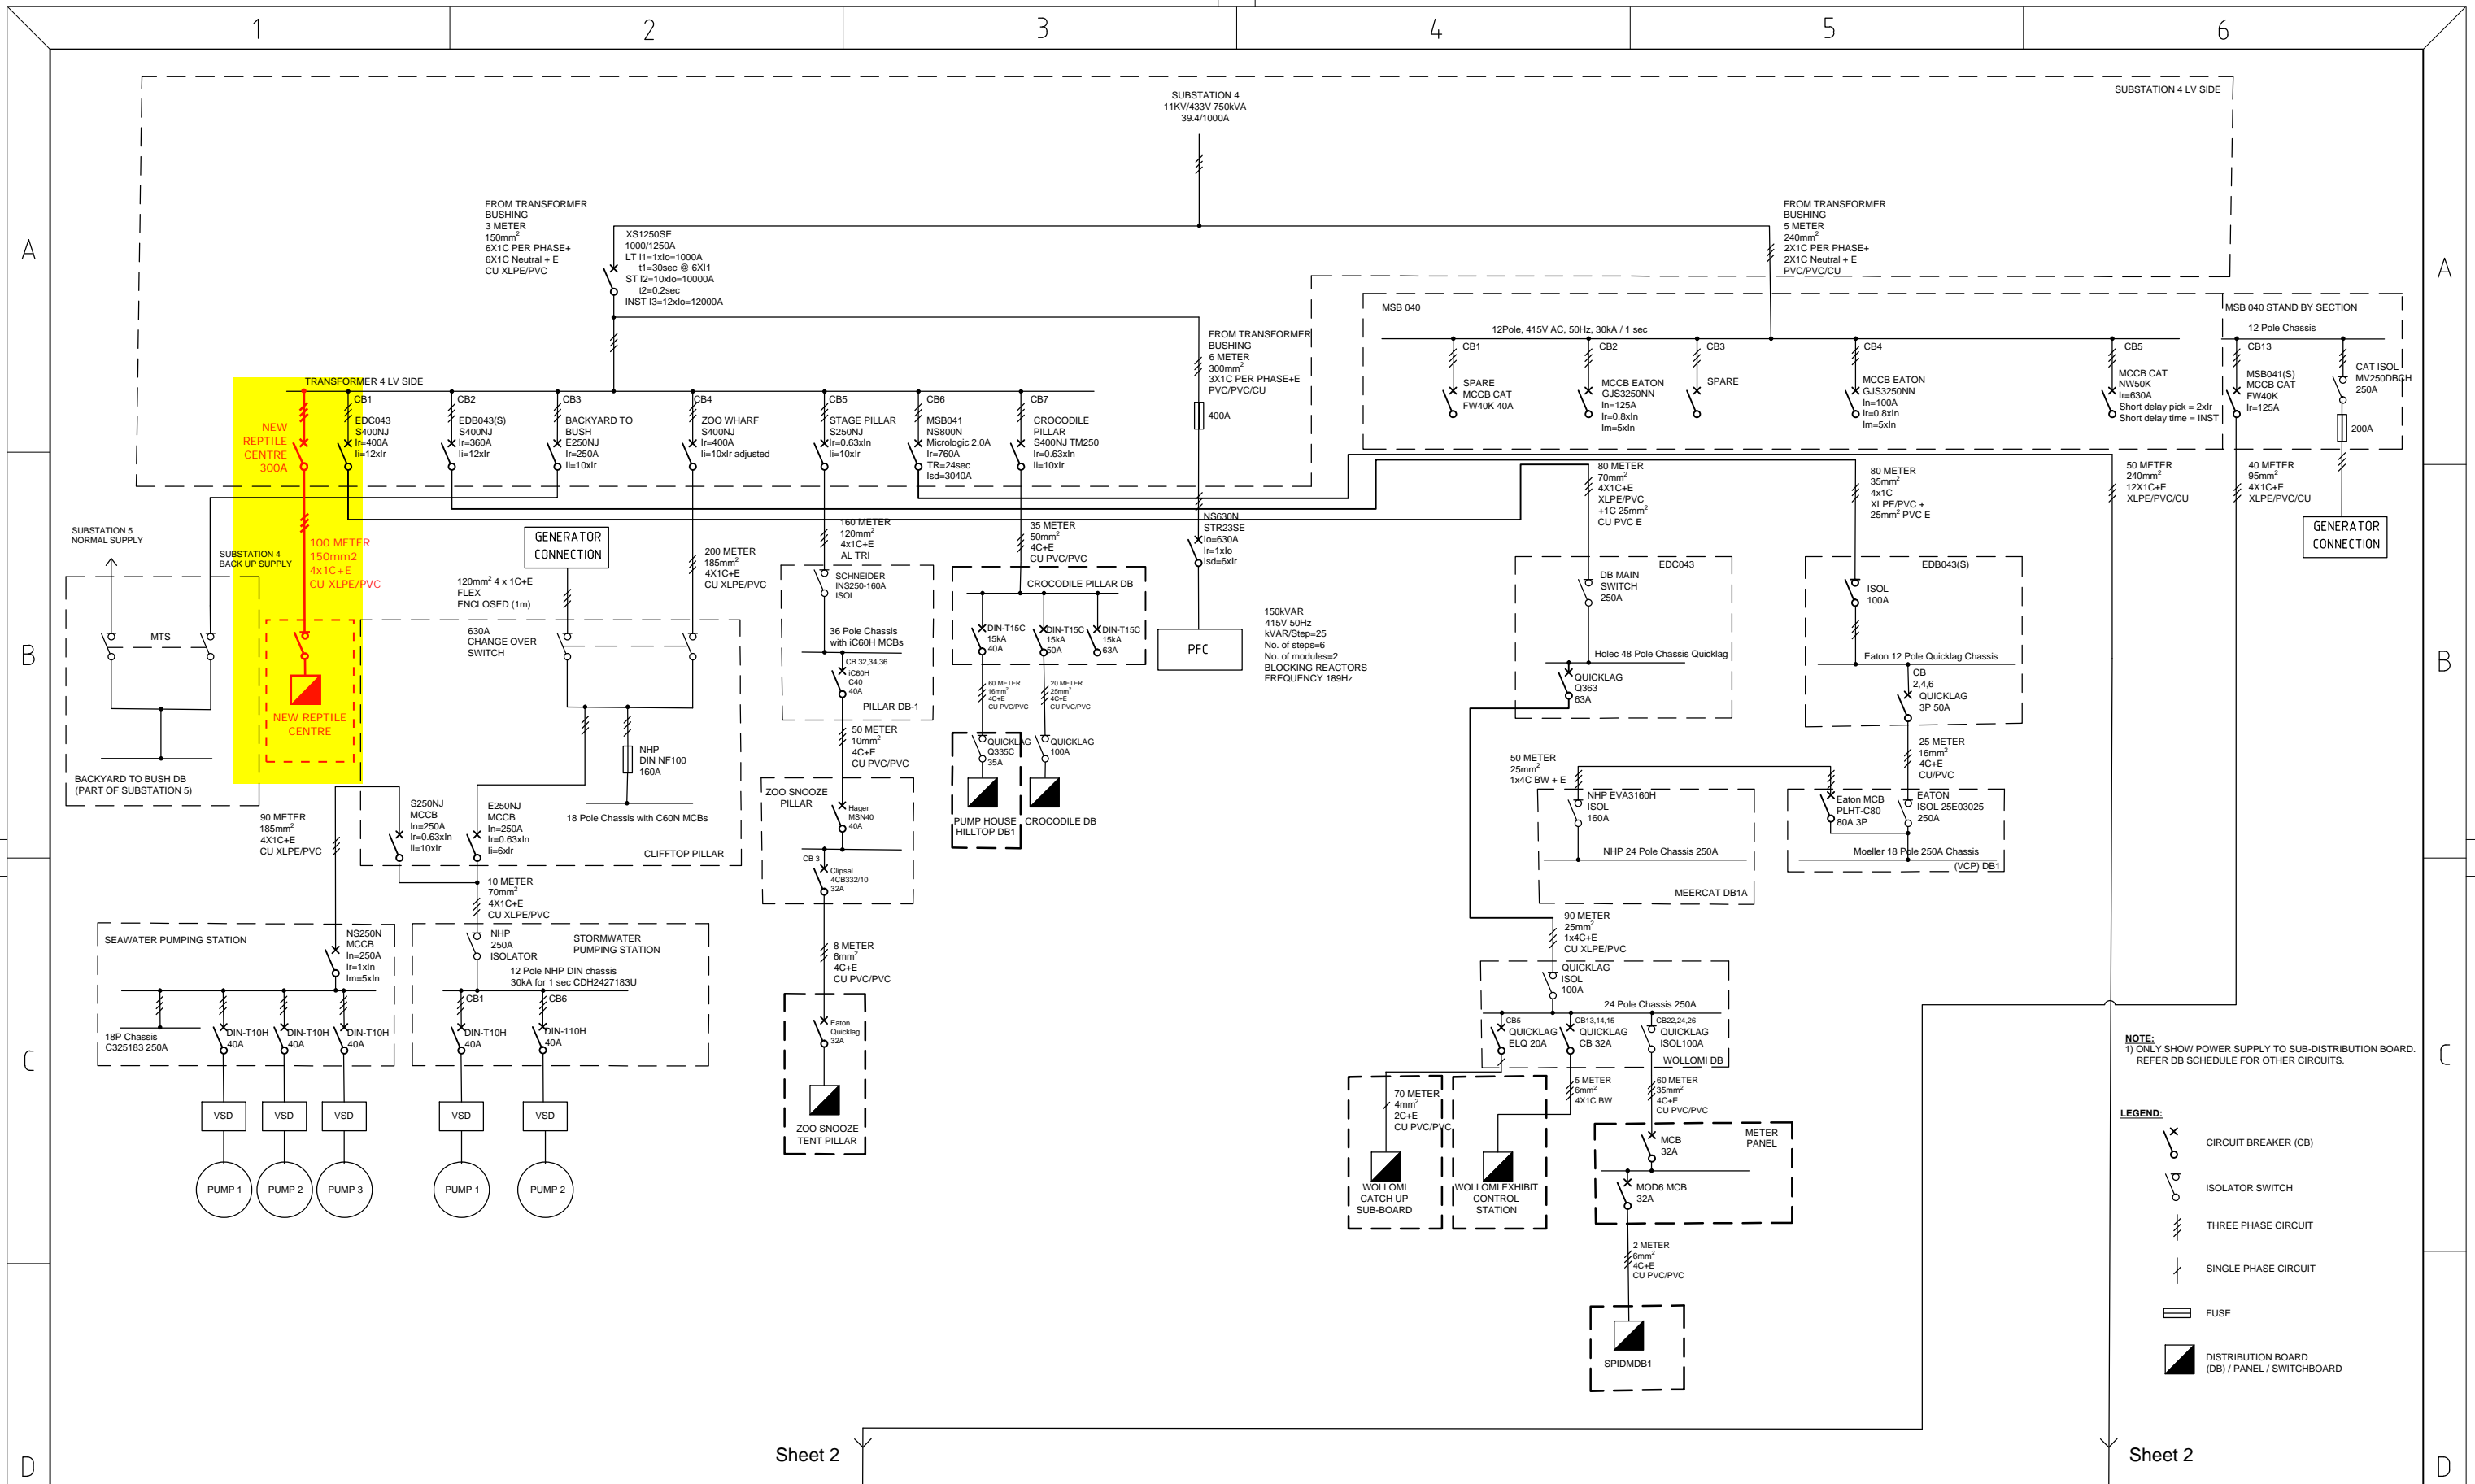

Sheet 2

Sheet 2

1	PROPOSED		19/11/19
LETTER	DETAILS OF AMENDMENT	APP'D	DATE




37 Baxter Road, Mascot  
New South Wales, 2020  
Phone (02) 8337 2200  
Fax (02) 8337 2224  
www.davidpower.com.au

ACN 003 921 373  
THIS DRAWING AND ALL TECHNICAL DATA CONTAINED HERE IN IS THE PROPERTY OF DAVID POWER PTY LTD AND MUST NOT BE DISCLOSED TO THIRD PARTIES OR COPIED OR REPRODUCED WHOLLY OR IN PART OR IN ANY FORM WITHOUT THE WRITTEN CONSENT OF THE OWNERS

DRAWN	BT	17.09.19	TITLE
DESIGNED			
APPROVED			

TARONGA ZOO SUBSTATION 4 SINGLE LINE DIAGRAM	
SCALE	DRAWING NO
N.T.S.	DP004-1
REV	A3
1	

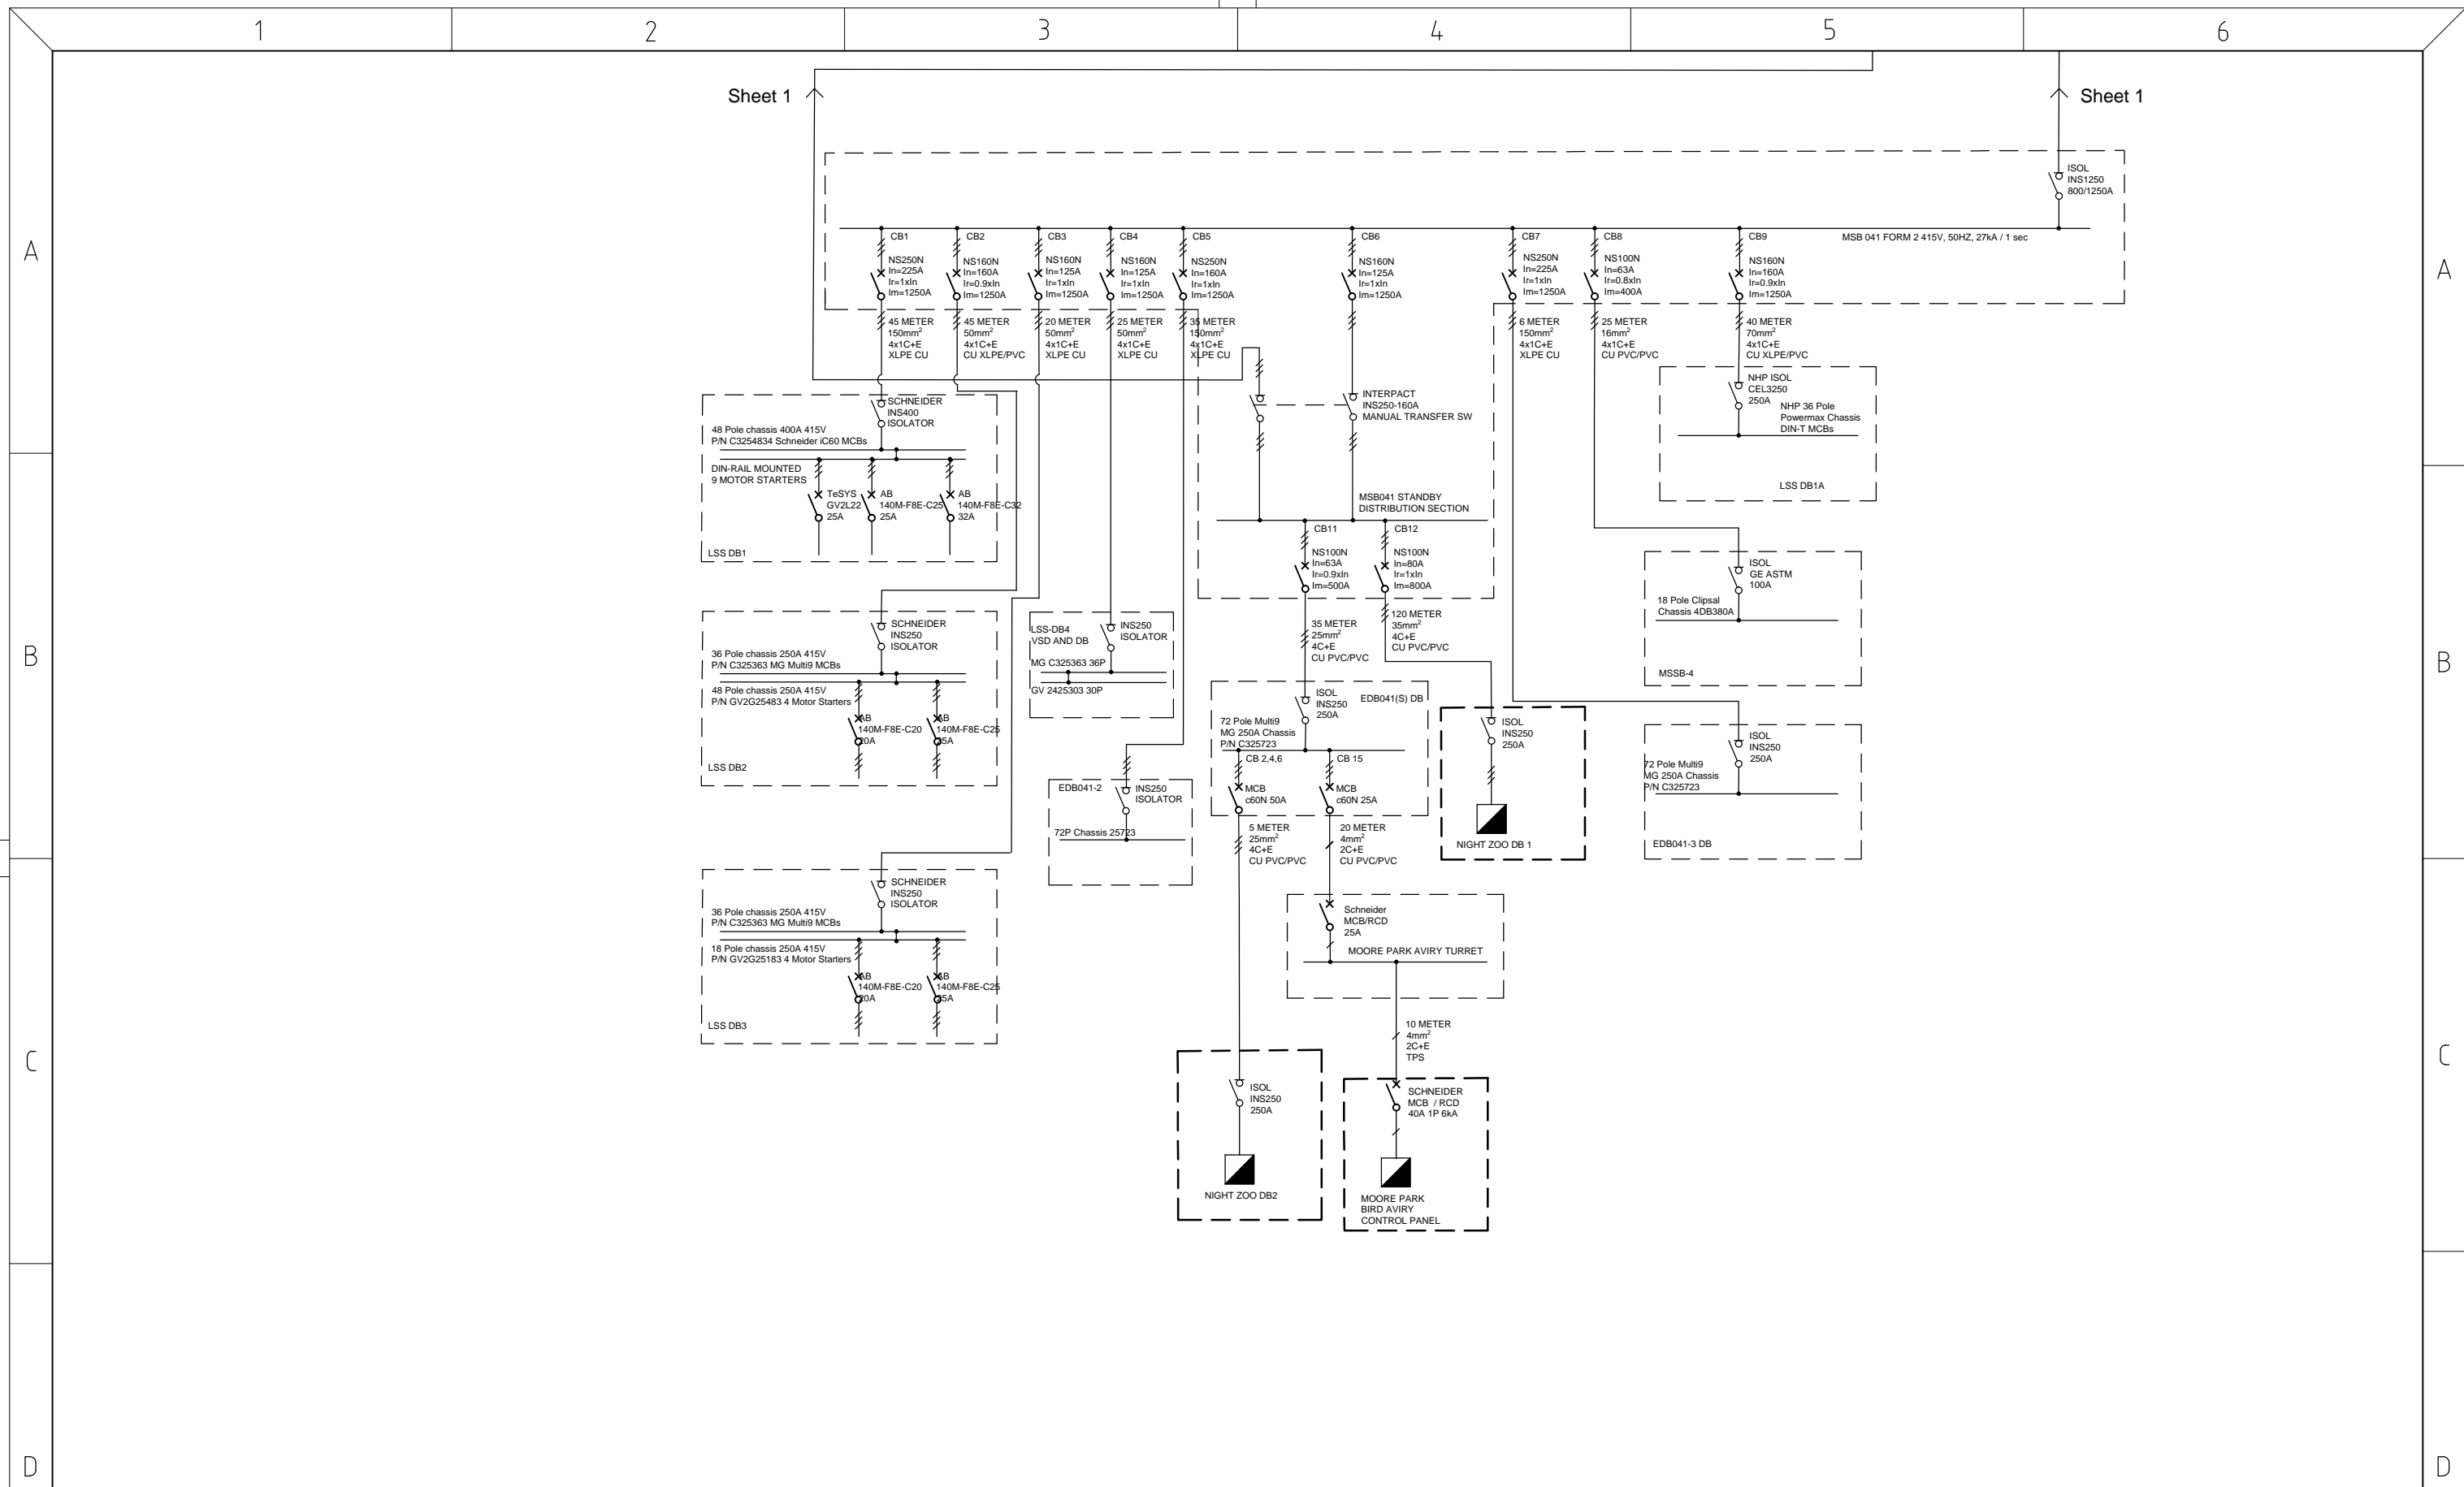

1	PROPOSED	19/11/19
LETTER	DETAILS OF AMENDMENT	APP'D DATE
1		
2		



37 Baxter Road, Mascot  
 New South Wales, 2020  
 Phone (02) 8337 2200  
 Fax (02) 8337 2224  
 www.davidpower.com.au

DRAWN BT 17.09.19  
 DESIGNED  
 APPROVED

TARONGA ZOO  
 SUBSTATION 4  
 SINGLE LINE DIAGRAM

SCALE N.T.S.  
 DRAWING NO DP004-2  
 REV 1  
 A3