



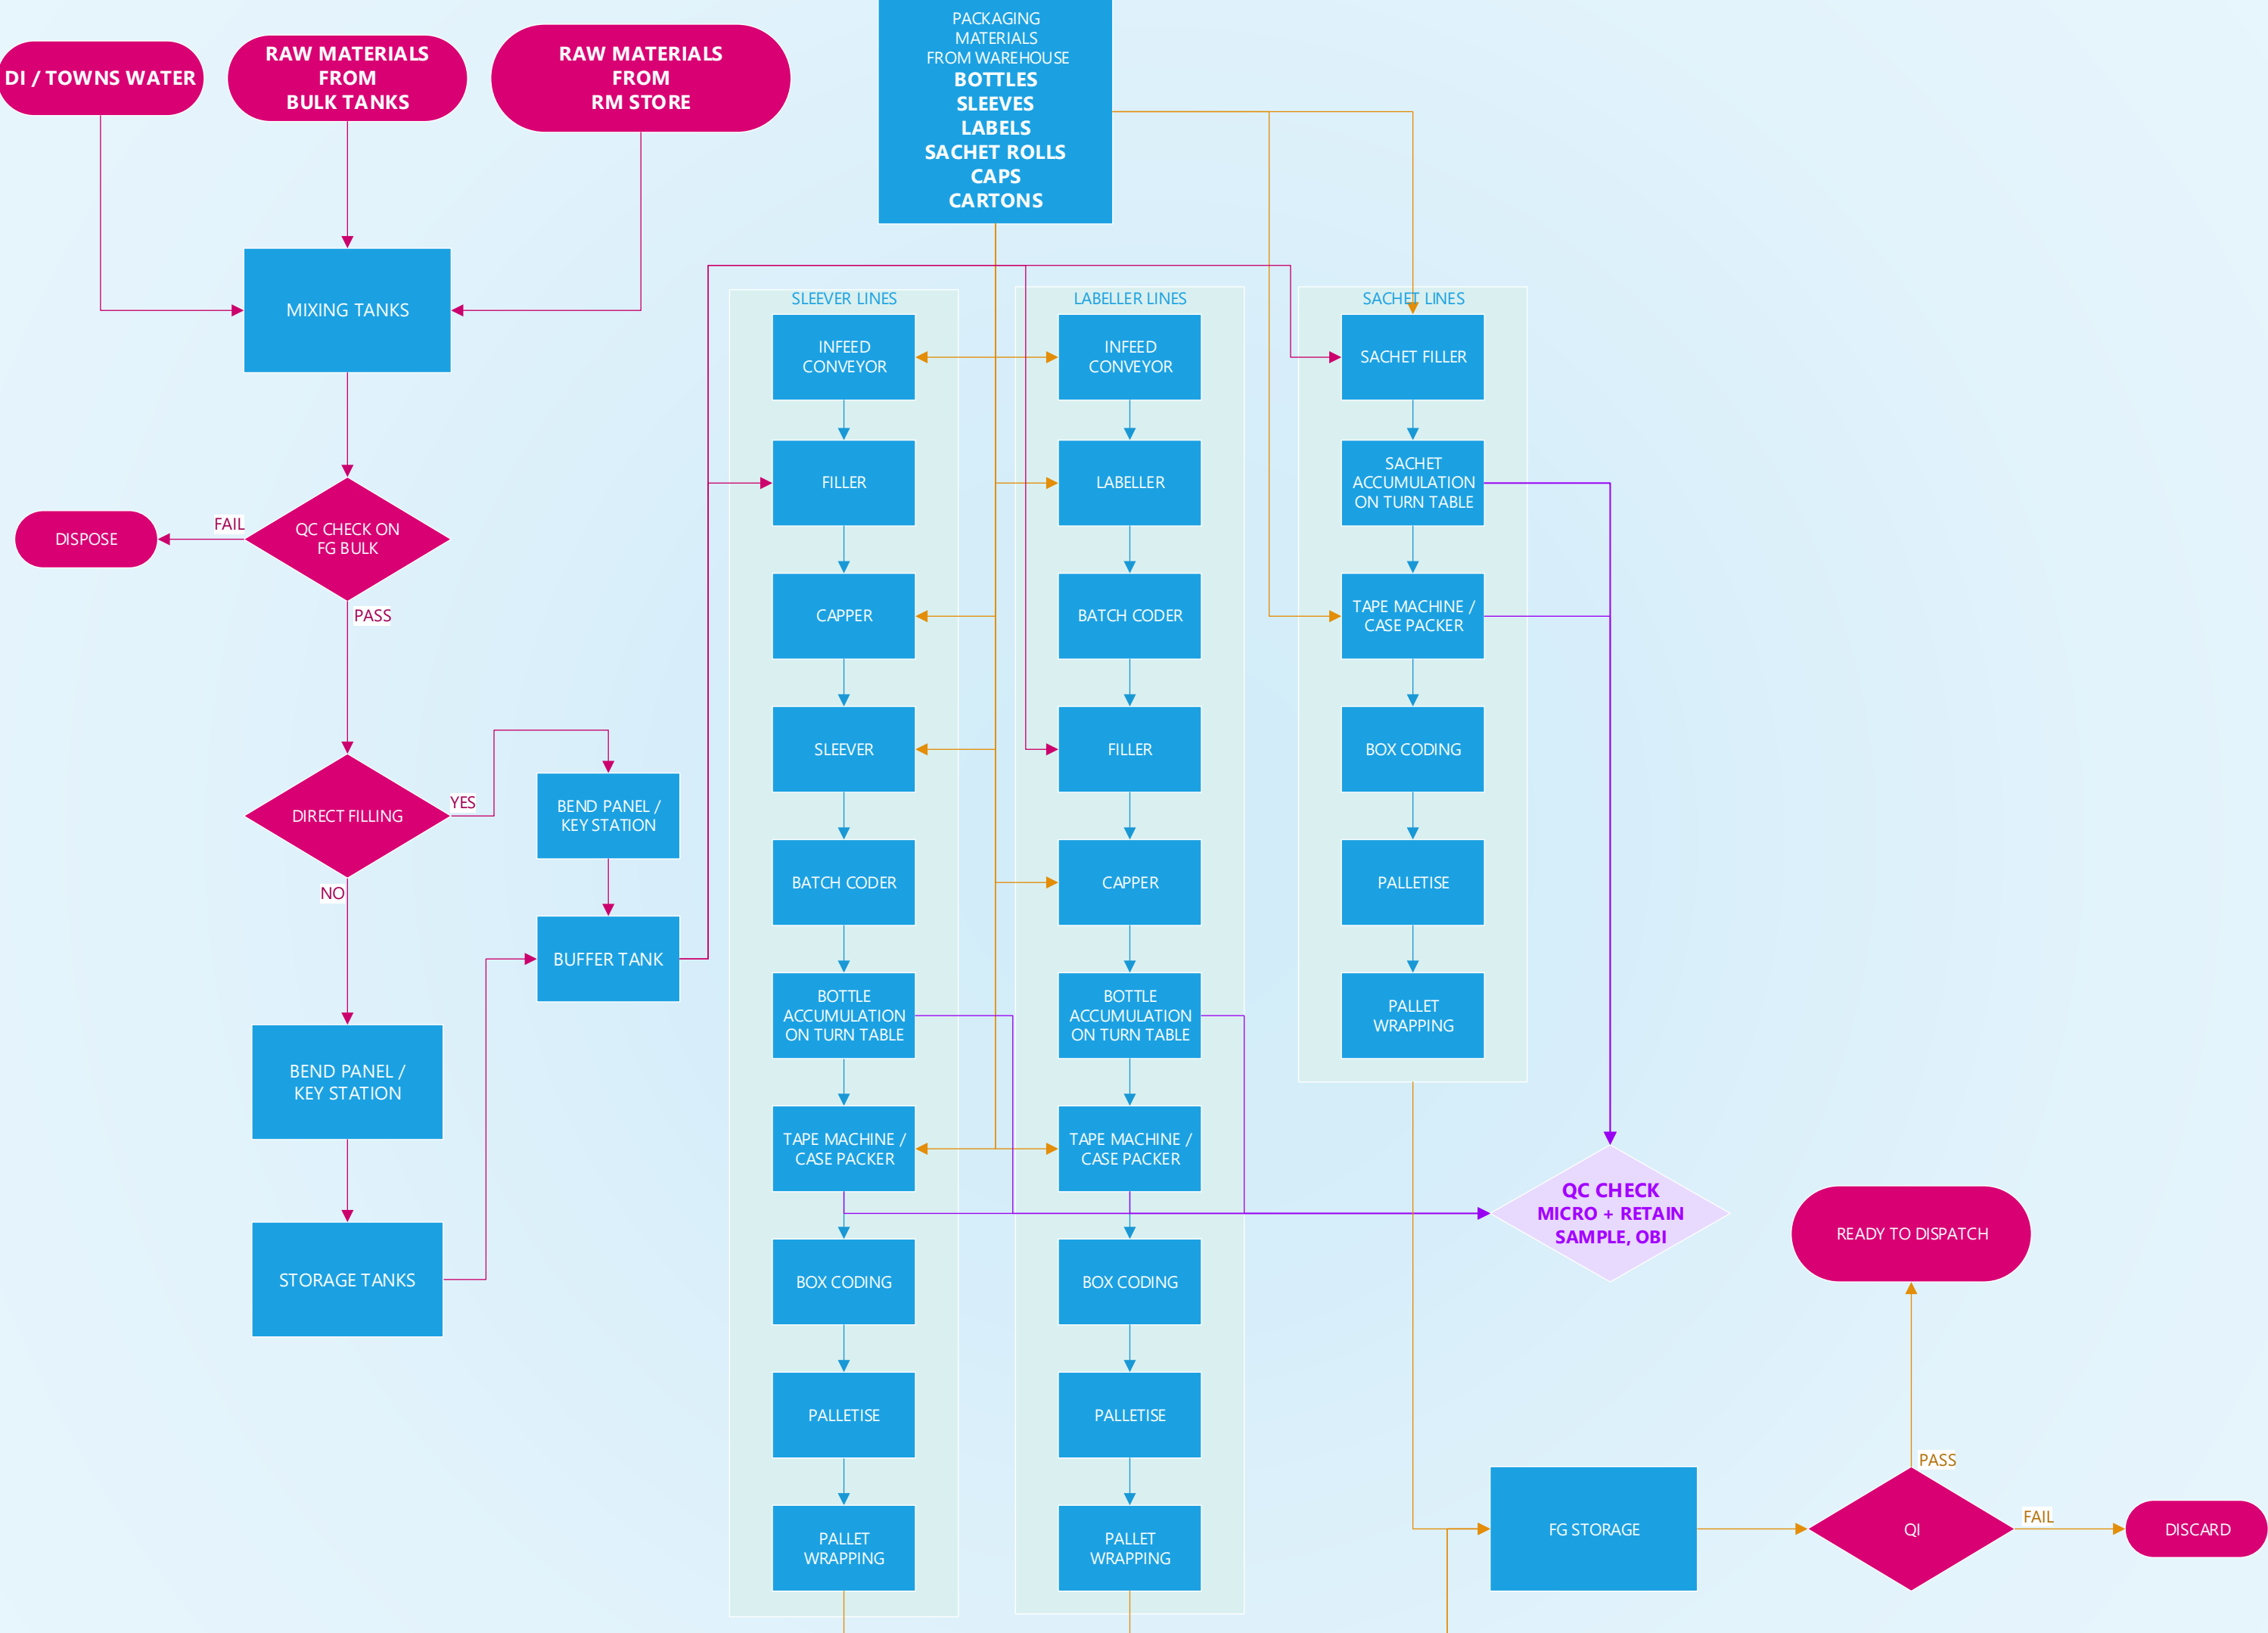

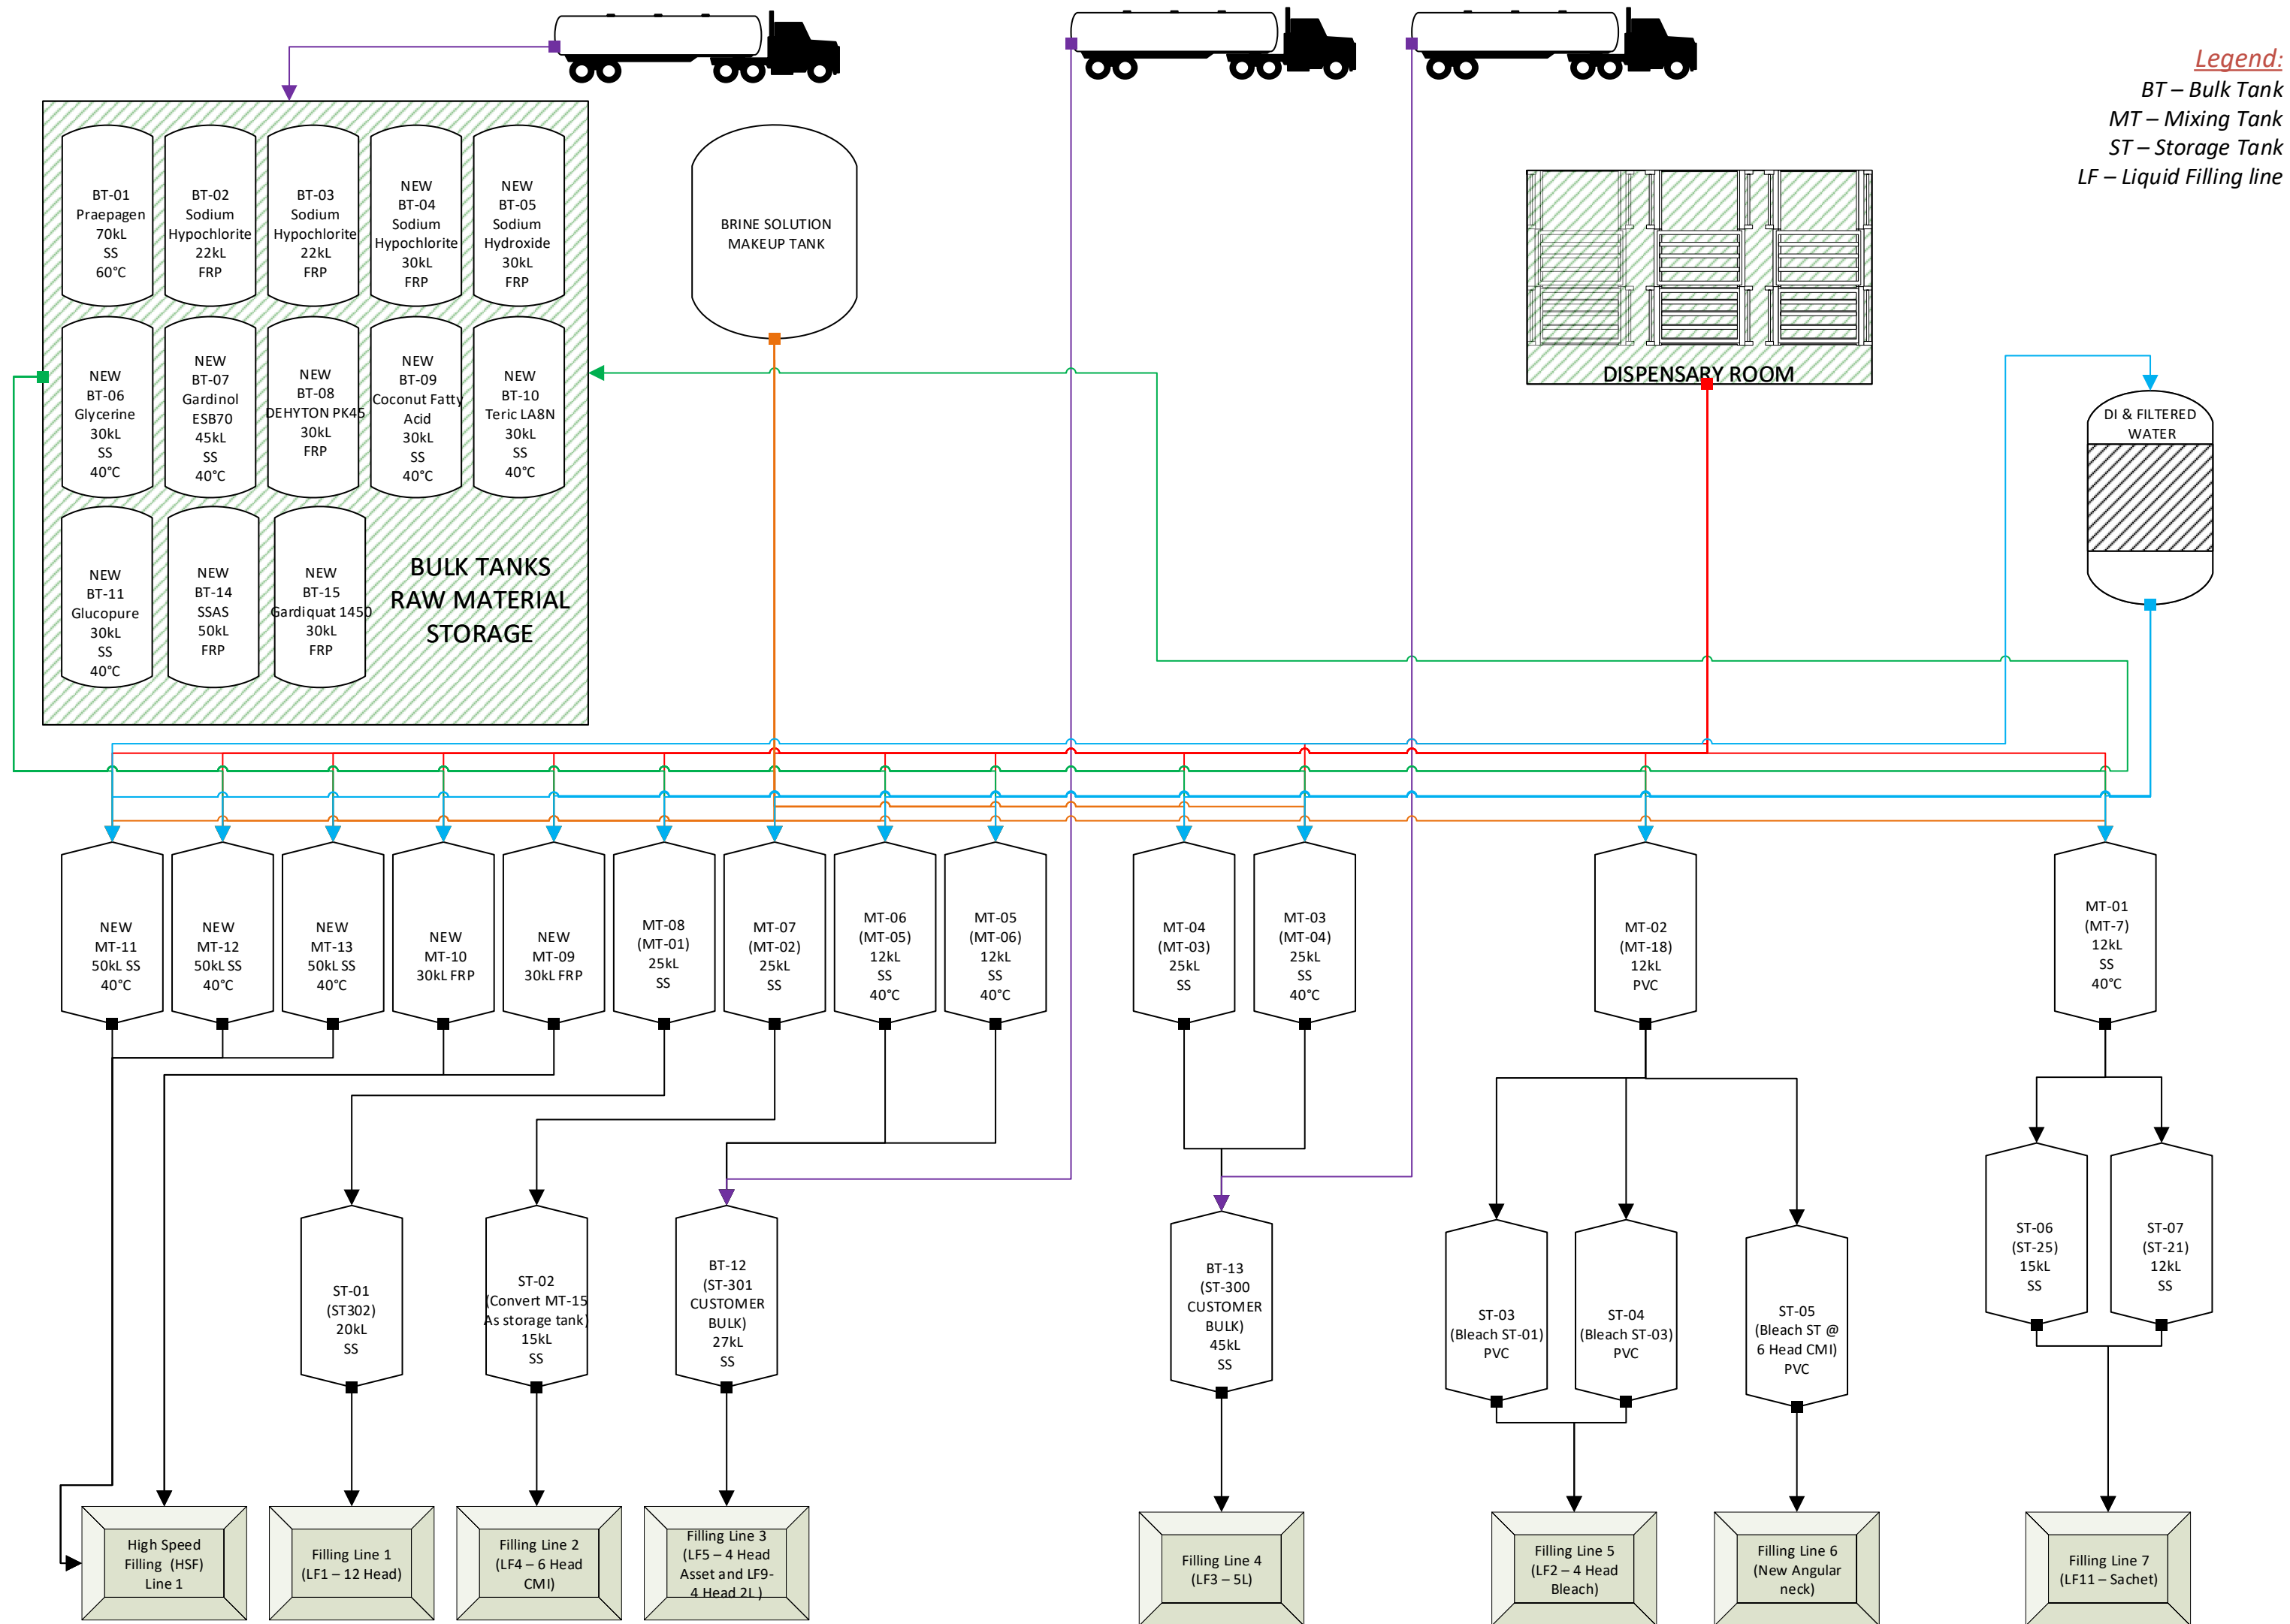



Process Flow Diagram and Representation of equipment list issued for relocation

Drawn By: Gopi Dhanekula