


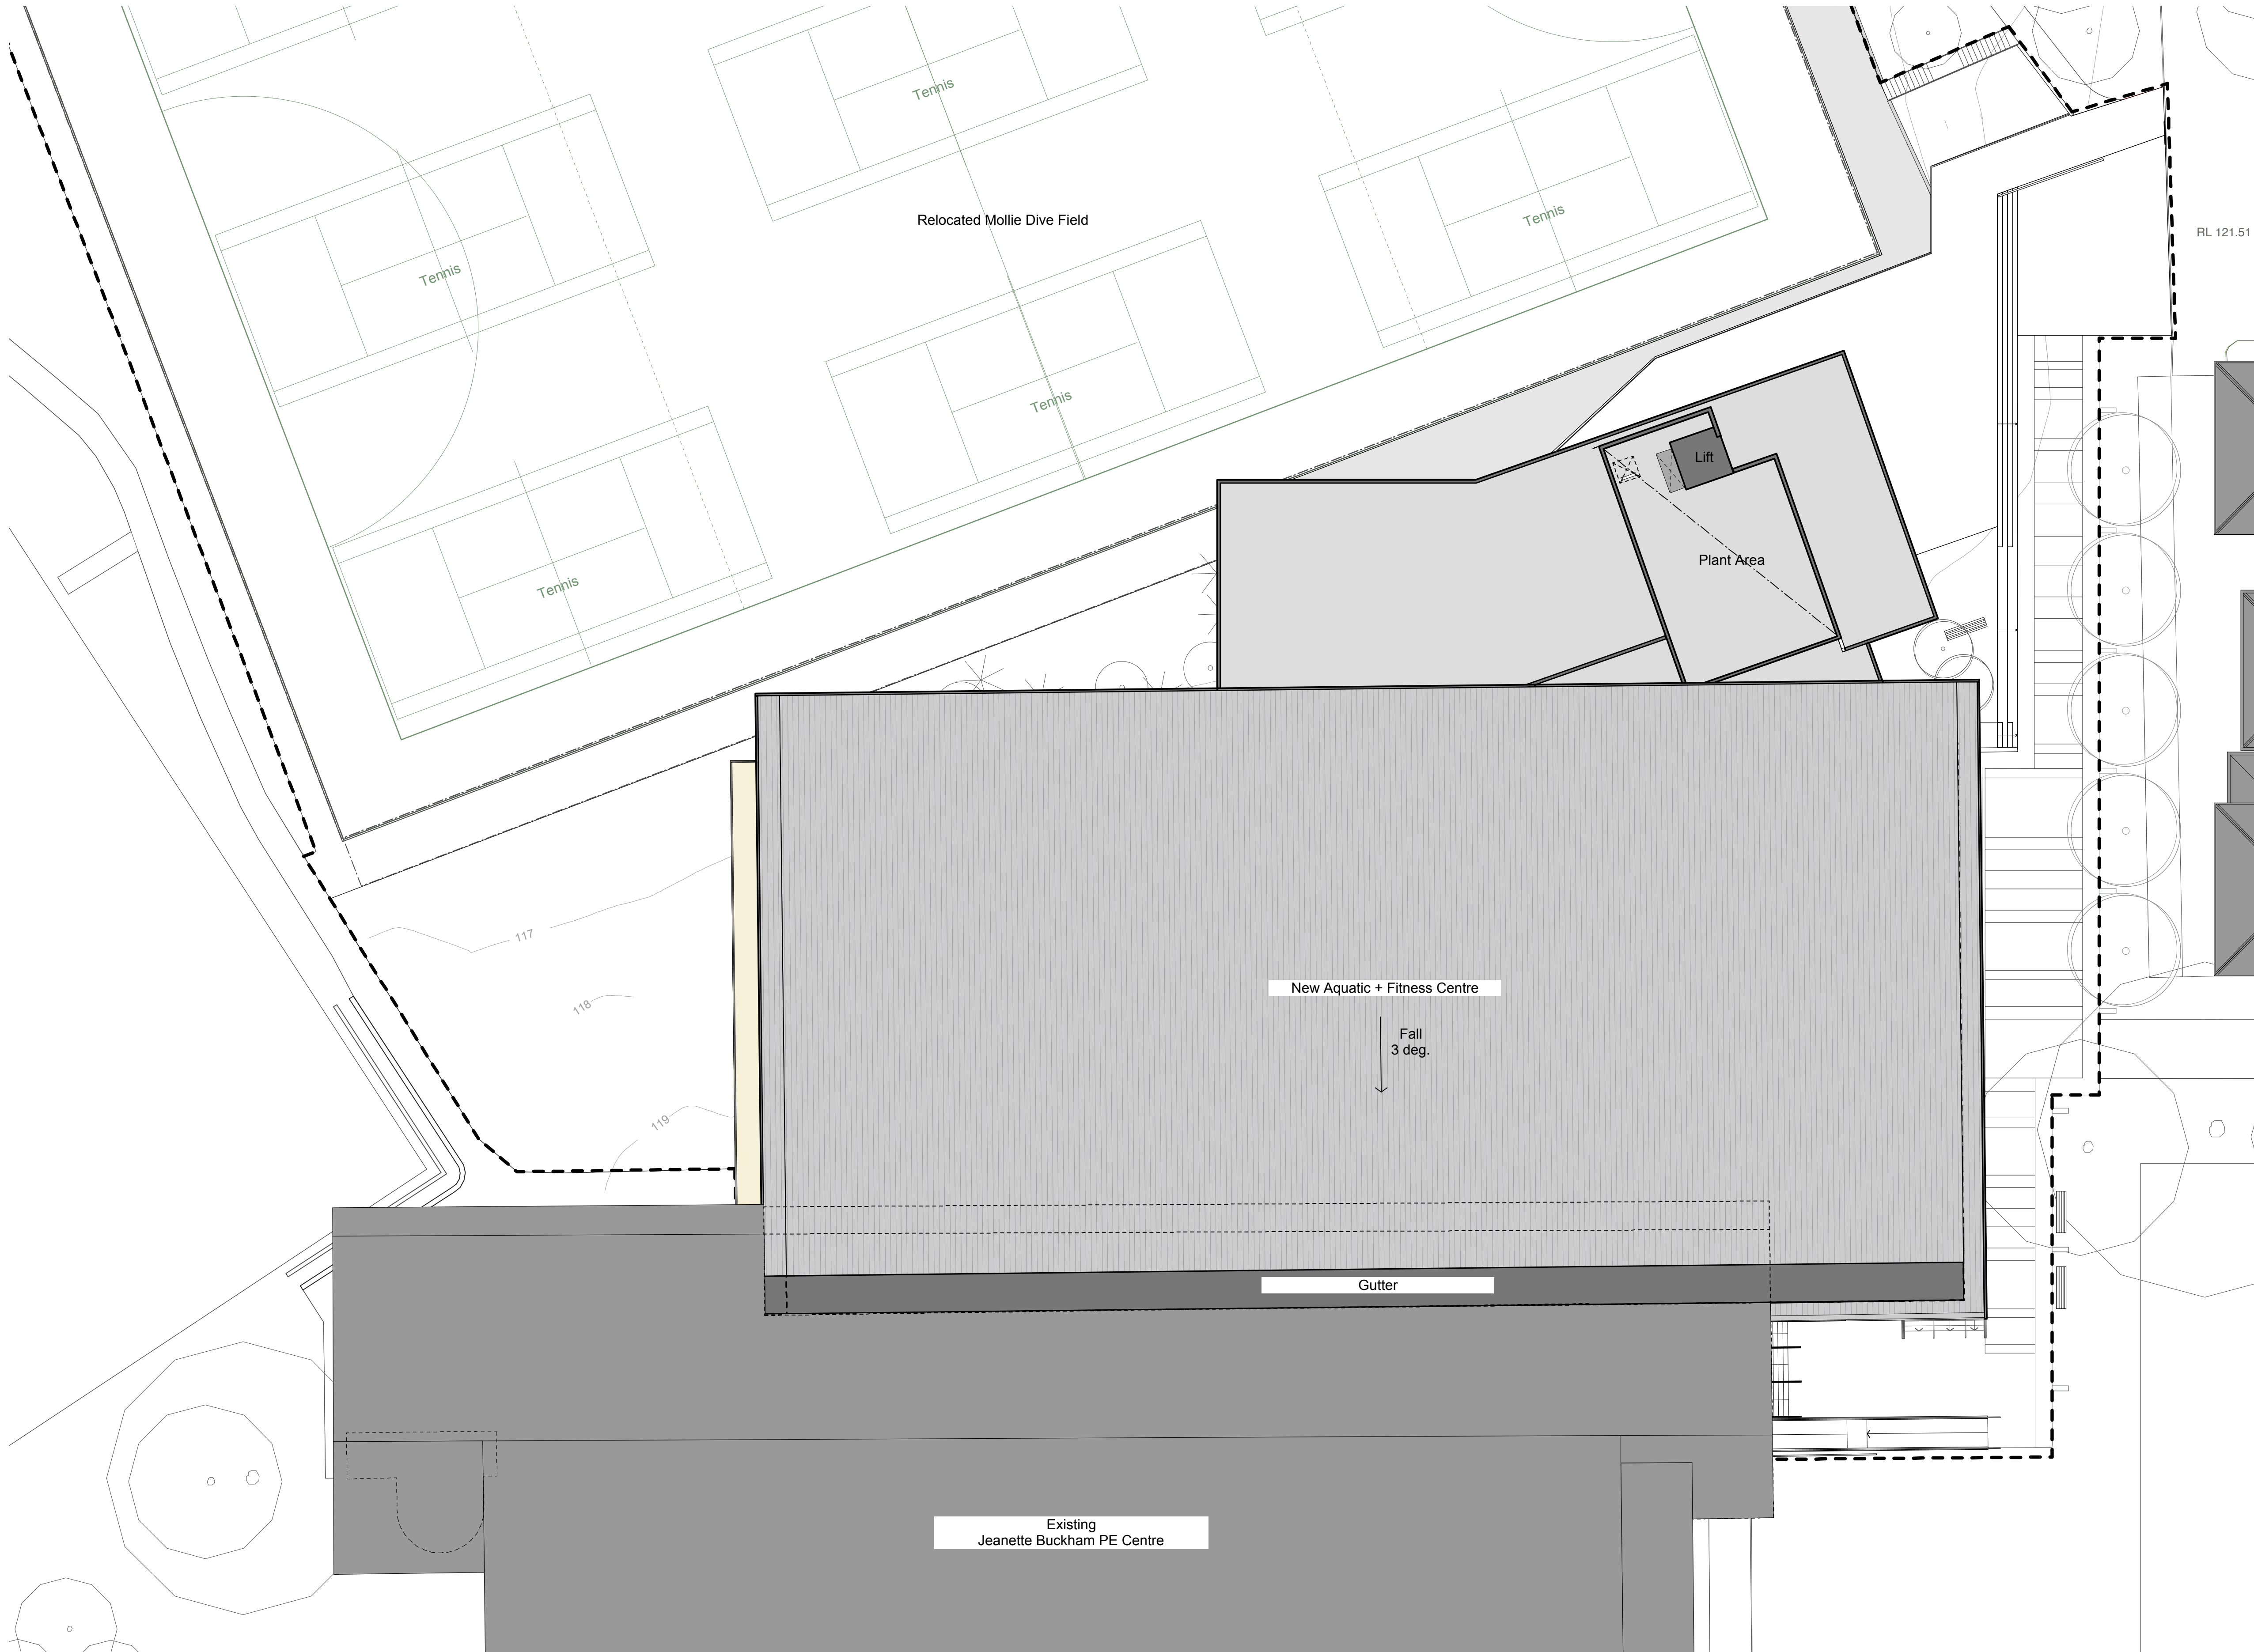

B	2/11/12	Amended issue for DA
A	28/8/12	Issue for DA
ISSUE	DATE	REVISION

0 mm 50 mm 100

DO NOT SCALE FROM DRAWING. USE FIGURED DIMENSIONS ONLY. CHECK ALL DIMENSIONS ON SITE BEFORE ANY MANUFACTURE OR CONSTRUCTION.



www.pmdl.com.au

PMDL Architecture + Design Pty Ltd
Andrew Pender 0317 David Morris 0605
Peter O'Connell 0154 Scott Lamb 0145
Sydney
Phone: +61 2 9458 5500
Melbourne
Phone: +61 3 9427 8885
Hong Kong
Phone: +852 2 3536 6962

PROJECT PLC Masterplan Phase 2					
CLIENT Pymble Ladies' College					
DRAWING Aquatic Centre Roof Plan					
CLIENT REF & CONTACT Avon Road, Pymble					
DATE Aug 2012	DRAWN aa	PROJECT#	DWG#	REVISION	
SCALE 1:200	CHKD ap	2126	DA104	B	