


PLAN
SCALE:1:250

NOTE:
AS PER CHAPTER 6-DCP47 CL6.8
DISCHARGE IS DIRECTLY TO
BUSHLAND & THEREFORE ON SITE
DETENTION IS NOT REQUIRED


LEGEND

	SUBSOIL DRAIN
	CATCH DRAIN
	STORMWATER PIPE
	STORMWATER PIT
	RETAINING WALL
	PROPOSED SPOT LEVEL

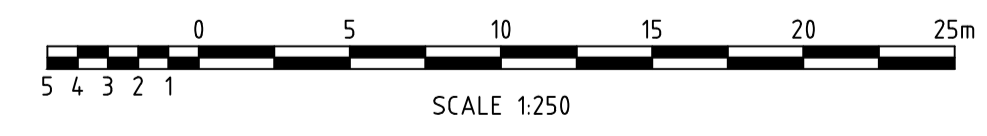

XREF's: X:GRP-A1-SHT; X:SYD-A1-LOGO; DADZ_precinct_plan; X:Contours; X:Utilities
 CAD FILE: H:\Structures\LOW & HOKE Projects\LH9500-9599\LH9500-2103(1).dwg

Rev	Date	Description	Drawn	Appr.
4	13/02/2015	HEADWALLS AT PLAYING FIELD DELETED	CRS	KAL
3	14/03/2013	FOR CLIENT REVIEW	LDB	DNA
2	8/03/2013	FOR CLIENT REVIEW	LDB	DNA
1	1/03/2013	FOR CLIENT REVIEW	LDB	DNA

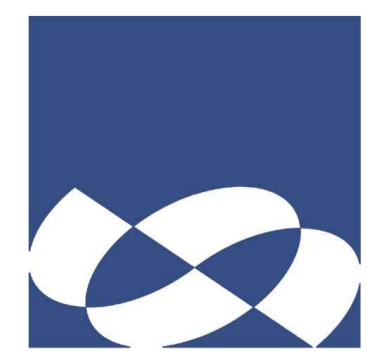

© Cardno Limited All Rights Reserved.
 This document is produced by Cardno Limited solely for the benefit of and use by the client in accordance with the terms of the retainer. Cardno Limited does not and shall not assume any responsibility or liability whatsoever to any third party arising out of any use or reliance by third party on the content of this document.

ABN: 95 001 145 035
 Level 9, The Forum, 203 Pacific Highway
 St Leonards NSW Australia 2065
 Phone (61) 2 94 96 7700 Fax (61) 2 94 99 5170
 Email: Sydney@cardno.com.au Web: www.cardno.com.au

Drawn	LDB	Date	1/03/2013
Checked	DNA	Date	1/03/2013
Designed	DNA	Date	1/03/2013
Verified	CEV	Date	1/03/2013
Approved	DNA	Date	1/03/2013

Client: **SDA, GREATER SYDNEY CONFERENCE**
 WAHROONGA ADVENTIST SCHOOL
 FOX VALLEY ROAD, WAHROONGA
 STORMWATER DESIGN
 STORMWATER DRAINAGE PLAN
 PLAYING FIELD & PE COURT

Status: NOT FOR CONSTRUCTION			
Date	Datum	Scale	Size
14/03/2013	AHD	AS SHOWN	A1
Drawing Number: LH9500-2103			Revision: 4