


SH66T.
1/5
15.4.2015

architectus™



Architectus Sydney
Level 3 341 George Street
Sydney NSW 2000
T (61 2) 8252 8400
F (61 2) 8252 8600
sydney@architectus.com.au

drawing ROADS LONG SECTIONS

 
28/03/2013 3:23:44 PM



 3. NOTE: Light Pole foundation depth to a Minimum of 1.4 M.

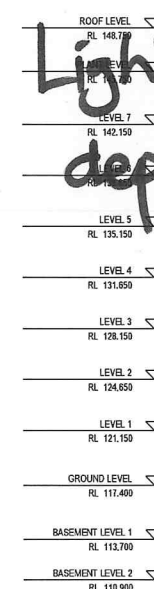

- LEGEND:
- TK - TOP OF KERB
 - RL - RELATIVE LEVEL
 - EX - EXISTING
 - STW - STORMWATER
 - ASWM - AUTHORITY STORMWATER MAIN

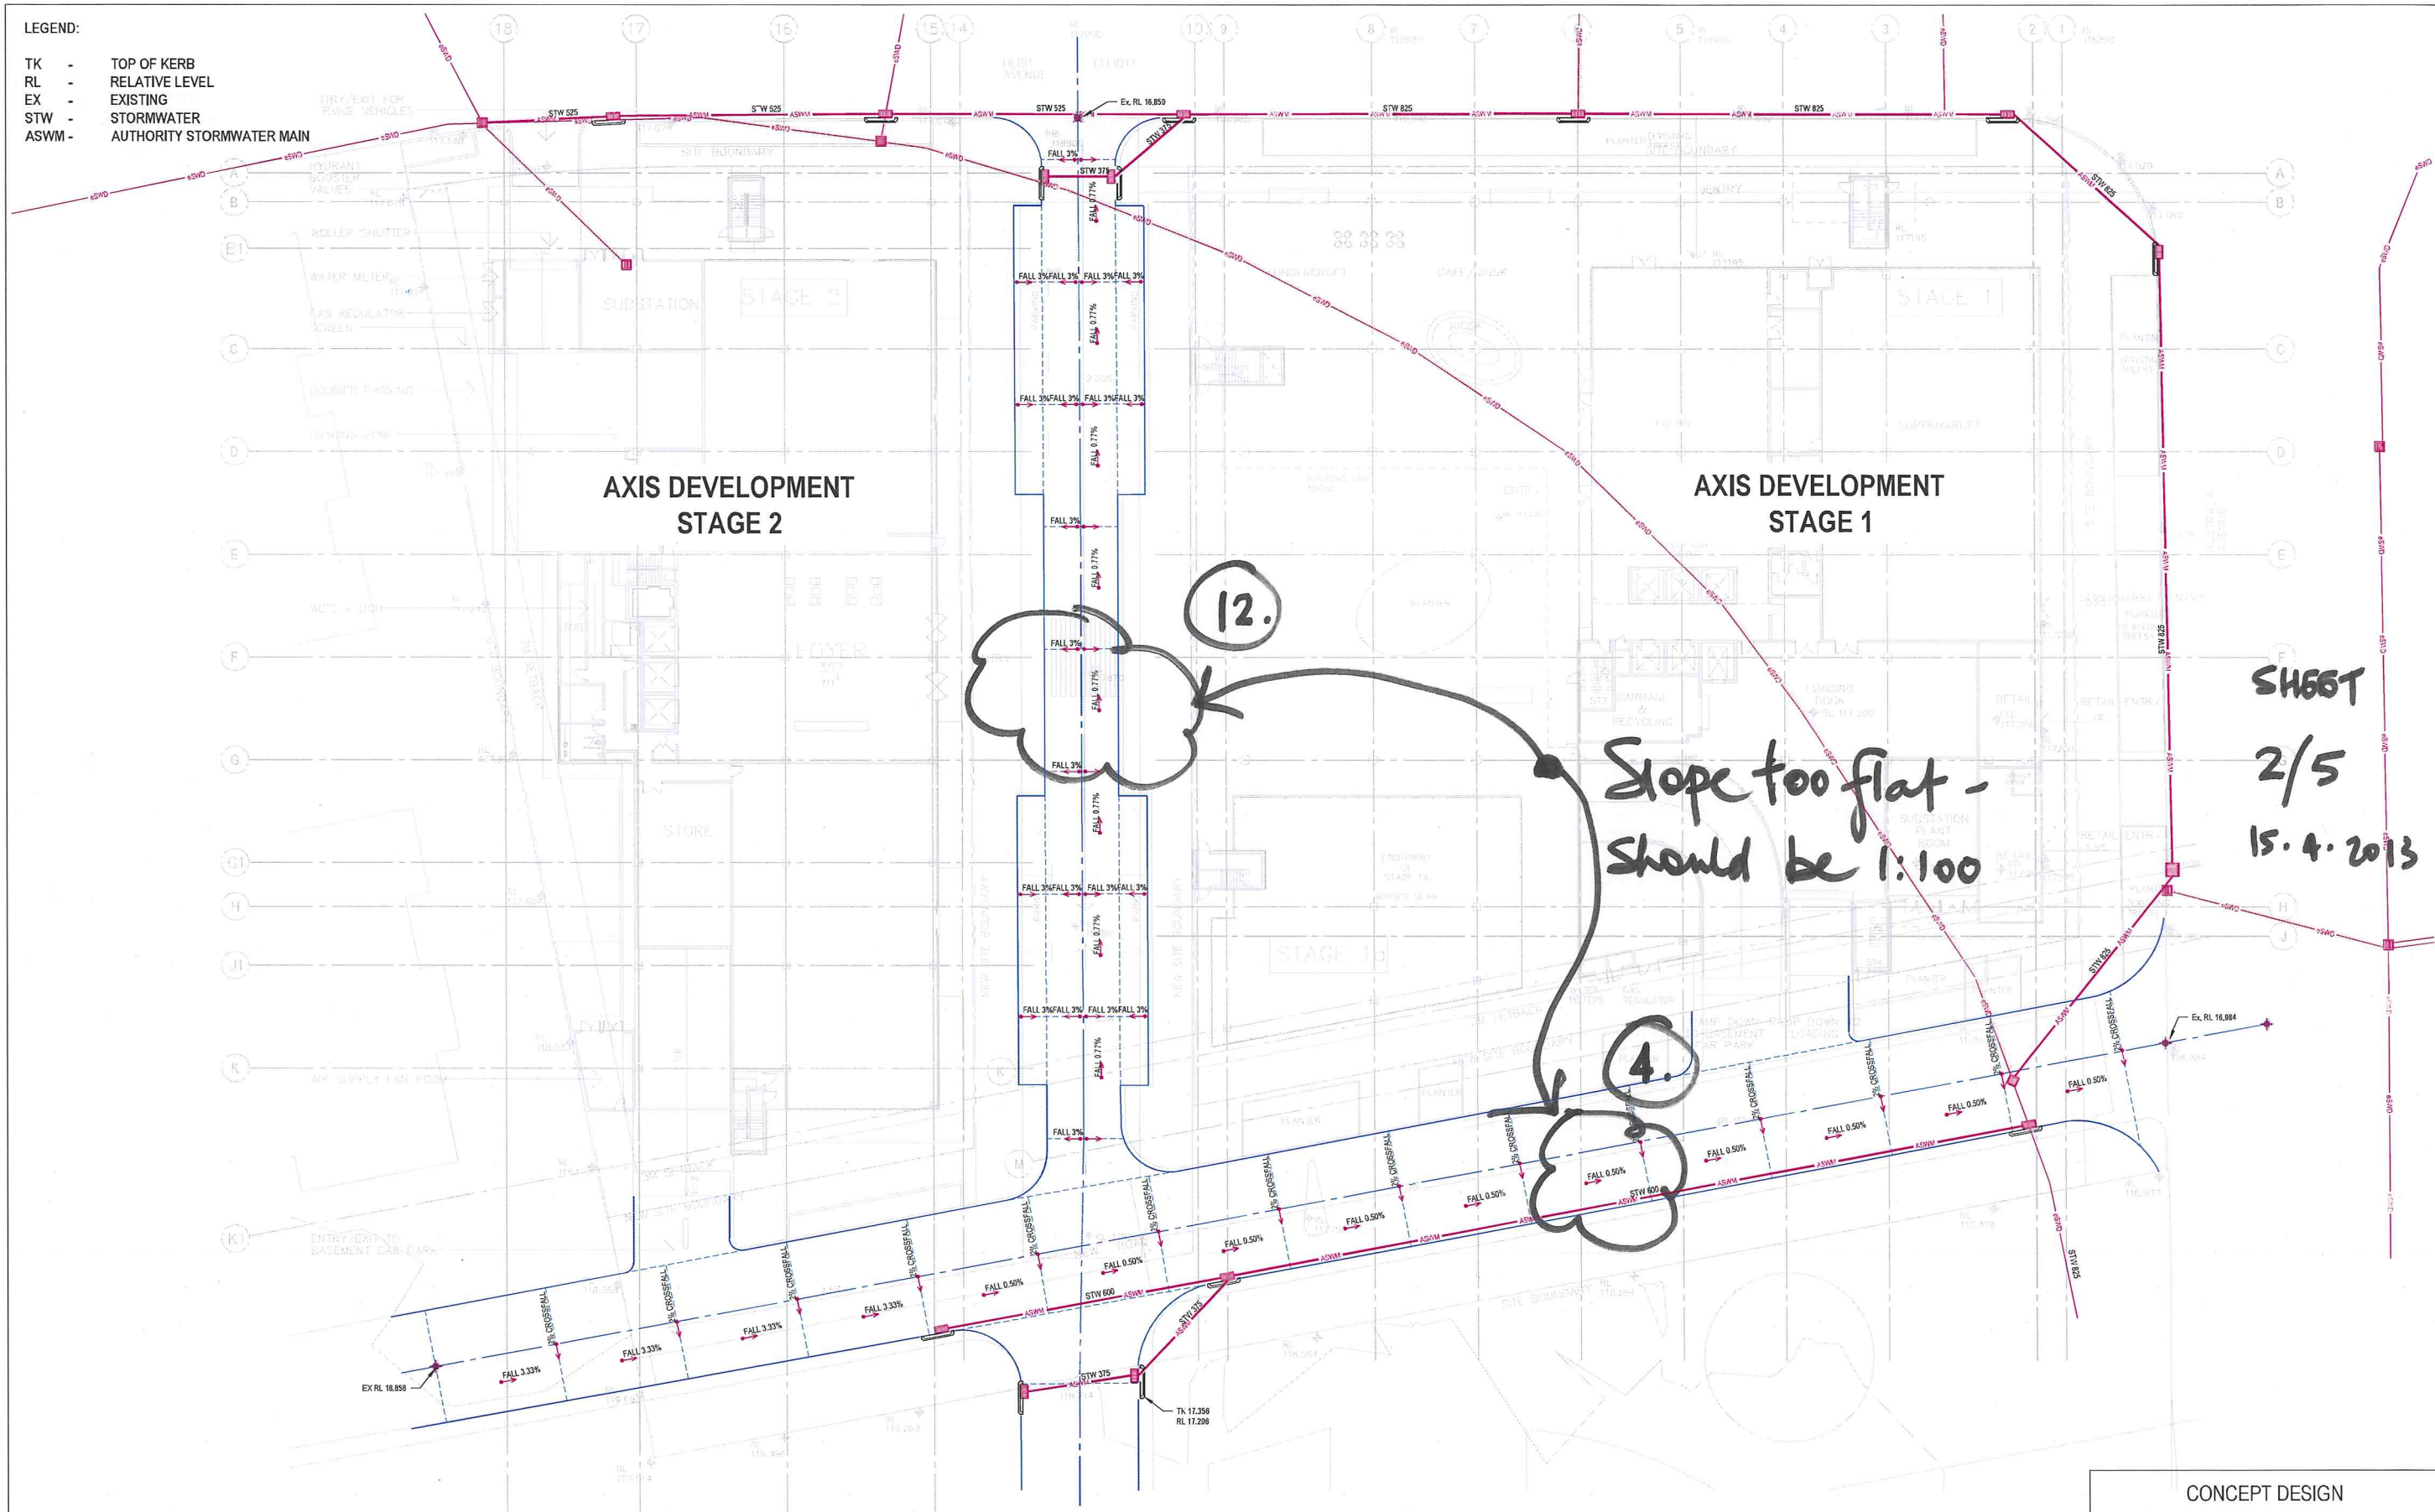


CONCEPT DESIGN

Hydraulic Consultant:
INSYNC SERVICES
Suite 8, Level 2
58 Church Avenue
MASCOT NSW 2020
Ph (02) 9699 4311
Fax (02) 9699 4322
A.C.N. 129 234 870
A.B.N. 24 917 388 129

Client:
Capital Corporation Pty Ltd
Suite 705 12 Century Circuit
Baulkham Hills NSW 2153
Ph (02) 8953 5099
Fax (02) 8953 5099


Architect:
Architectus
Level 3 341 George Street
Sydney NSW 2000
T (02) 8252 8400
Fax (02) 8252 8800

Issue	Date	Amendment	Int.	App.	COORDINATED REFERENCE DRAWINGS	ISSUE	DATE
A	28/03/13	PRELIMINARY ISSUE	BL	BL	SERVICE	DRAWING NUMBER	
B	02/04/13	FOR APPROVAL	BL	BL	ARCH	DA 1003	19 03 2013
					MECH		
					STRUCT		
					ELEC		
					CIVIL		
					THIS DRAWING IS THE PROPERTY OF INSYNC SERVICES AND IS NOT TO BE REPRODUCED OR COPIED IN ANY FORM WITHOUT THE EXPRESS WRITTEN AUTHORITY OF INSYNC SERVICES PTY LTD. THIS DRAWING CONTAINS PATENTS AND INTELLECTUAL PROPERTY OWNED BY INSYNC SERVICES PTY LTD.		

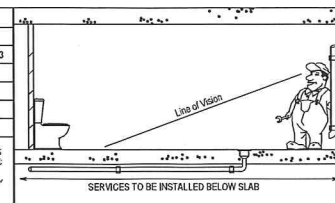

Project:
**SITE 43/44
SYDNEY OLYMPIC PARK
6 Australia Avenue
Sydney Olympic Park NSW 2140**

 Drawing Title:
**ROAD WORKS
GRADING PLAN**



Job No: **2012009**

Dwg No: **RW-002**

Scale: **(A1) 1:250**

Issue: **B**

NOTE: SYMBOLS ARE DRAWN IN THE CORRECT POSITION BUT ARE NOT SHOWN TO SCALE.

INSYNC SERVICES




SH561
3/5
15.4.2013 DA

Sydney
Melbourne
Auckland
Brisbane
Shanghai

Architectus Sydney
Level 3 341 George Street
Sydney NSW 2000
T (61 2) 8252 8400
F (61 2) 8252 8600
sydney@architectus.com.au

APRIL 11 008 480 448

scale	1 : 250	drawing no.	SK - 154
drawn	Author		
checked	Checker	issue	
project no	090086		03/27/13

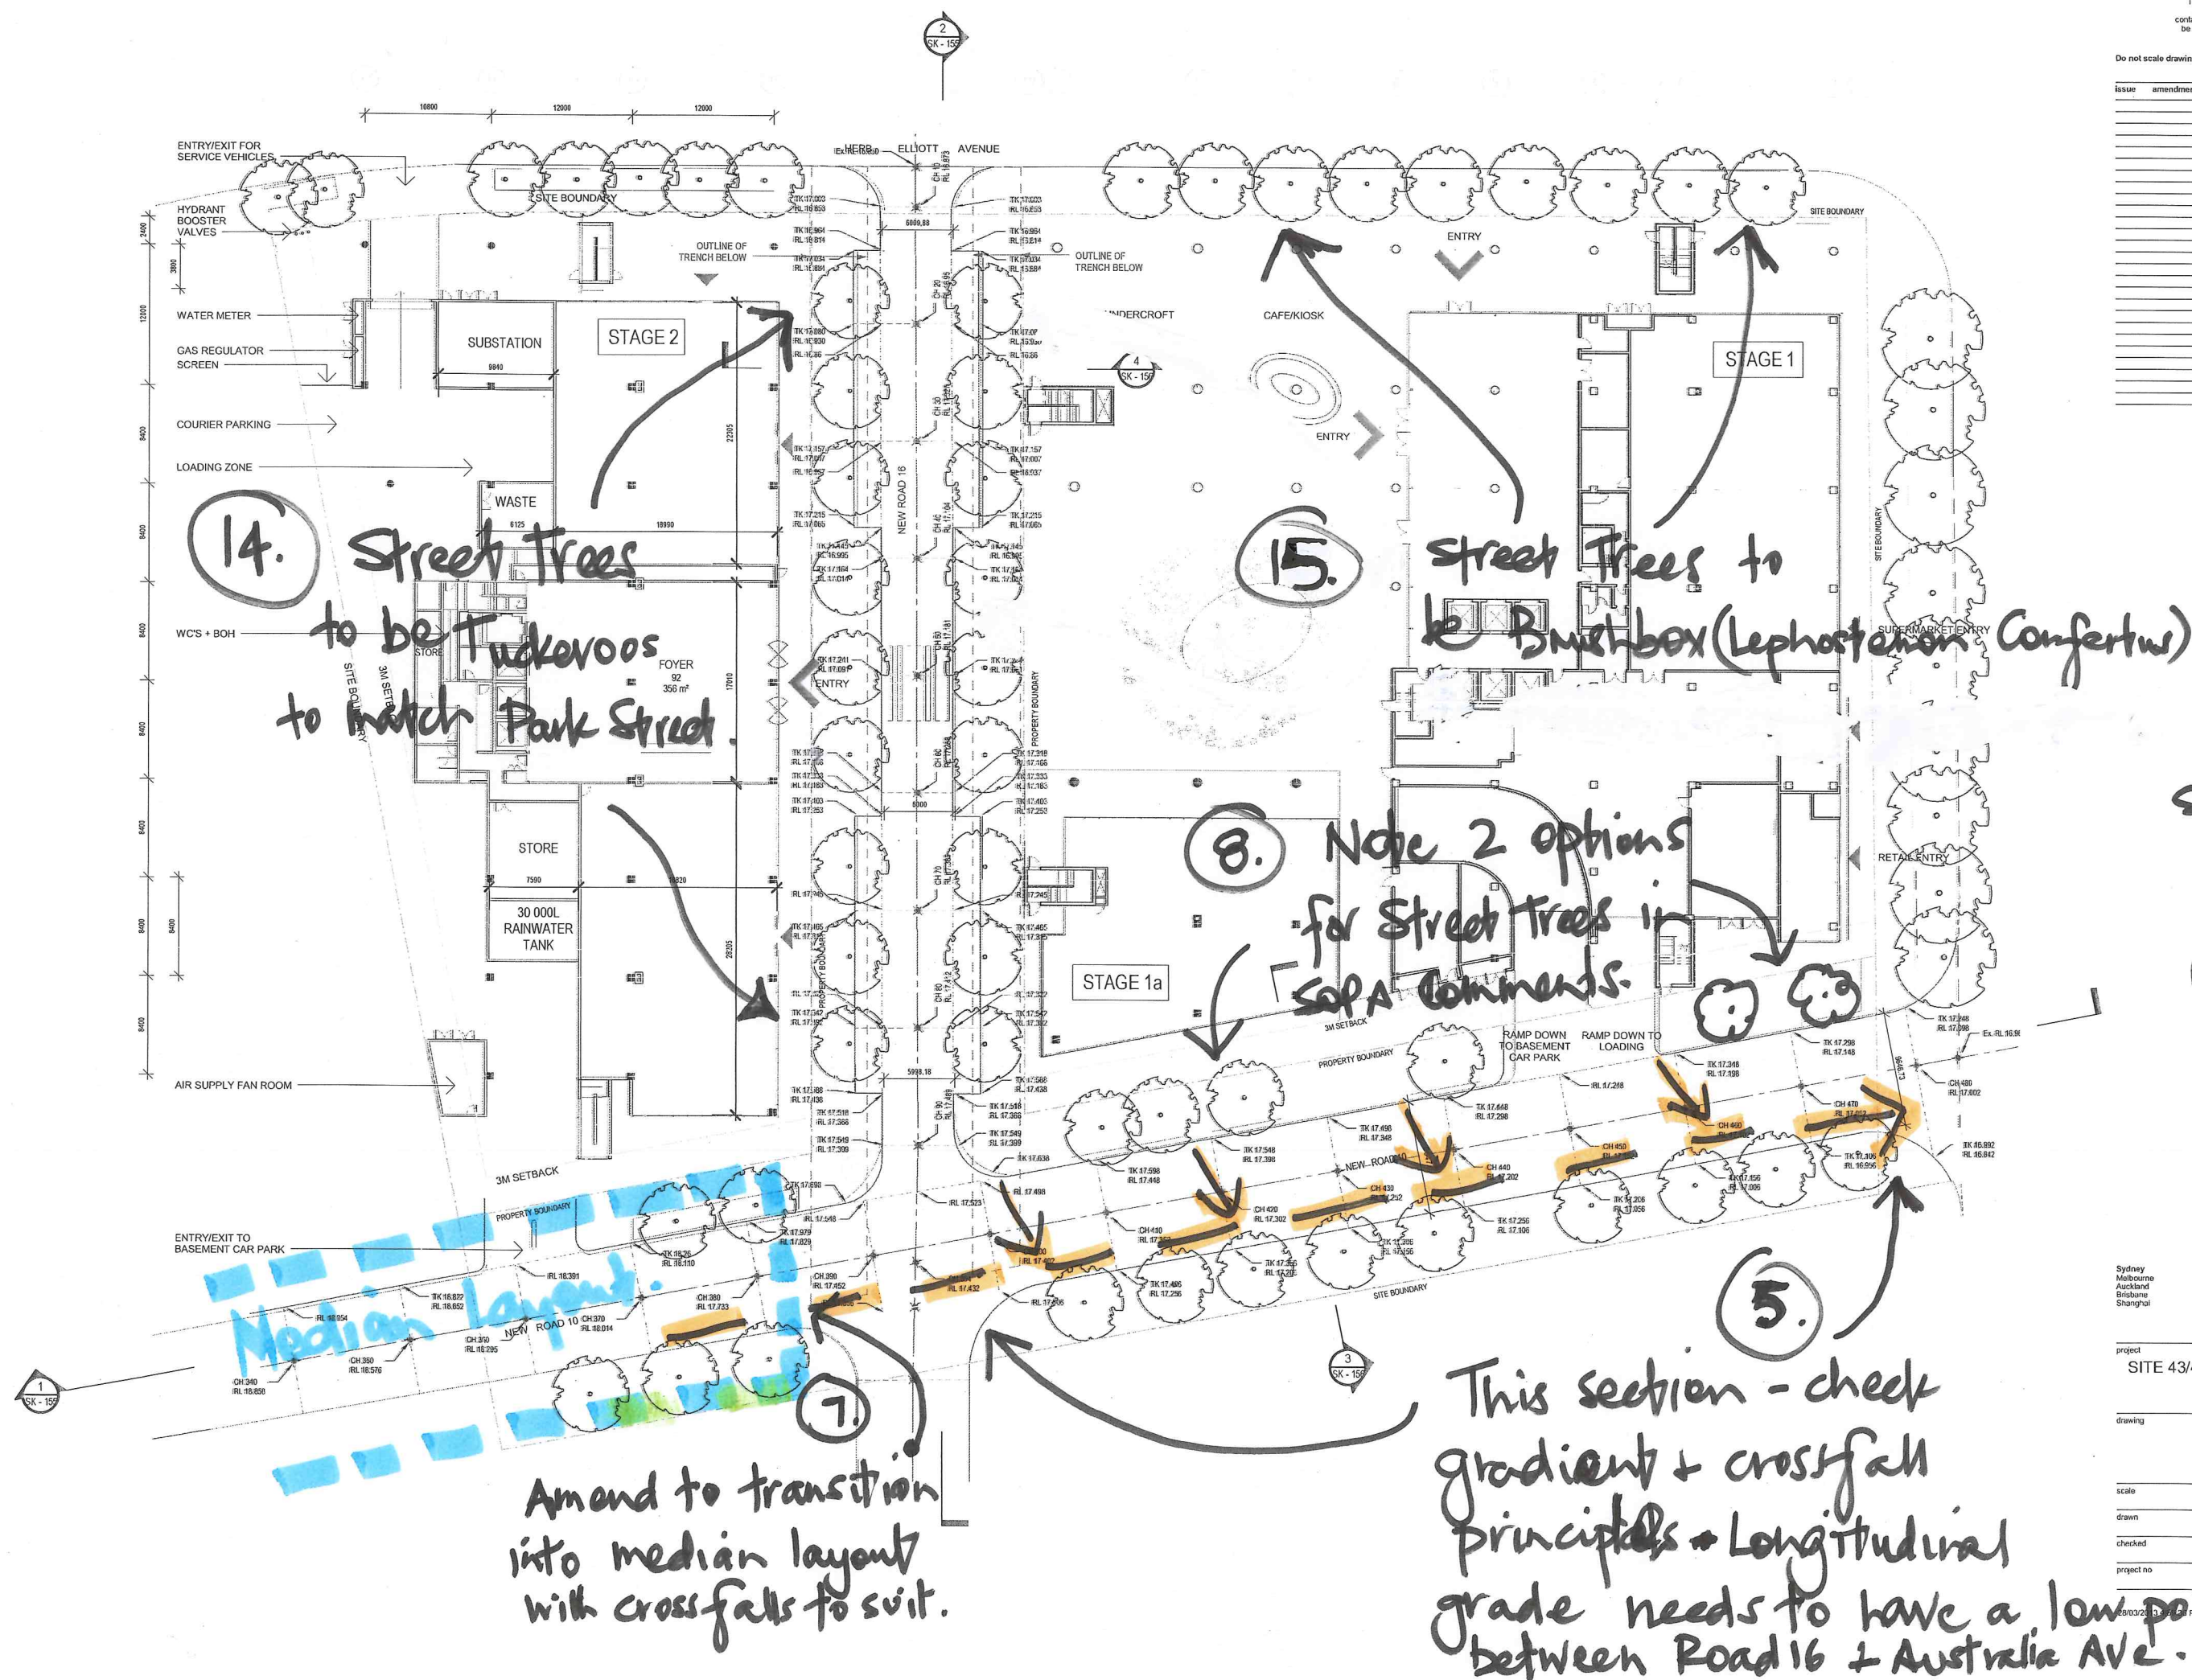

TK - TOP OF KERB
RL - RELATIVE LEVEL
EX - EXISTING

15.4.2013

Retaining Wall
Required. (temp?)
Max 1.28M at
tree - will combine &
increase westwards.


10.

9. Consider Street Trees if practical

CONCEPT DESIGN

 INSYNC CONSULTANTS Suite B, Level 2 55 Church Avenue MASCO NSW 2020 Ph (02) 9609 4311 Fax (02) 9609 4322 A.C.N.: 150 234 870 A.B.N.: 24 917 388 128	Client: Capital Corporation Pty Ltd Suite 118B, NSW 2153 Ph (02) 8853 5000 Fax (02) 8853 5099	Architect: Architectus Suite 705 12 Century Street Sydney NSW 2000 T (02) 8252 8400 Fax (02) 8252 8660	<table border="1"> <thead> <tr> <th>Issue</th> <th>Date</th> <th>Amendment</th> </tr> </thead> <tbody> <tr> <td>A</td> <td>28/03/13</td> <td>PRELIMINARY ISSUE</td> </tr> <tr> <td>B</td> <td>02/04/13</td> <td>FOR APPROVAL</td> </tr> </tbody> </table>	Issue	Date	Amendment	A	28/03/13	PRELIMINARY ISSUE	B	02/04/13	FOR APPROVAL	<table border="1"> <thead> <tr> <th>Int.</th> <th>App.</th> <th>COORDINATED REFERENCE DRAWINGS</th> <th>ISSUE</th> <th>DATE</th> </tr> </thead> <tbody> <tr> <td>BL</td> <td>BL</td> <td>SERVICE DRAWING NUMBER</td> <td></td> <td></td> </tr> <tr> <td>BL</td> <td>BL</td> <td>ARCH DA 1003</td> <td>A</td> <td>18 03 2013</td> </tr> <tr> <td></td> <td></td> <td>MECH</td> <td></td> <td></td> </tr> <tr> <td></td> <td></td> <td>STRUCT</td> <td></td> <td></td> </tr> <tr> <td></td> <td></td> <td>ELEC</td> <td></td> <td></td> </tr> <tr> <td></td> <td></td> <td>CIVIL</td> <td></td> <td></td> </tr> </tbody> </table>	Int.	App.	COORDINATED REFERENCE DRAWINGS	ISSUE	DATE	BL	BL	SERVICE DRAWING NUMBER			BL	BL	ARCH DA 1003	A	18 03 2013			MECH					STRUCT					ELEC					CIVIL			 Line of Vision SERVICES TO BE INSTALLED BELOW SLAB	Project: SITE 43/44 SYDNEY OLYMPIC PARK 6 Australia Avenue Sydney Olympic Park NSW 2140	Drawing Title: ROAD WORKS SPOT LEVELS North Point:  Job No: 2012009 Scale: (A1) 1:250 Drawn By: RW-001 Issue: B	NOTE: SYMBOLS ARE DRAWN IN THE CORRECT POSITION BUT ARE NOT SHOWN TO SCALE.
Issue	Date	Amendment																																																		
A	28/03/13	PRELIMINARY ISSUE																																																		
B	02/04/13	FOR APPROVAL																																																		
Int.	App.	COORDINATED REFERENCE DRAWINGS	ISSUE	DATE																																																
BL	BL	SERVICE DRAWING NUMBER																																																		
BL	BL	ARCH DA 1003	A	18 03 2013																																																
		MECH																																																		
		STRUCT																																																		
		ELEC																																																		
		CIVIL																																																		

- LEGEND:
- TK - TOP OF KERB
 - RL - RELATIVE LEVEL
 - EX - EXISTING
 - STW - STORMWATER
 - ASWM - AUTHORITY STORMWATER MAIN

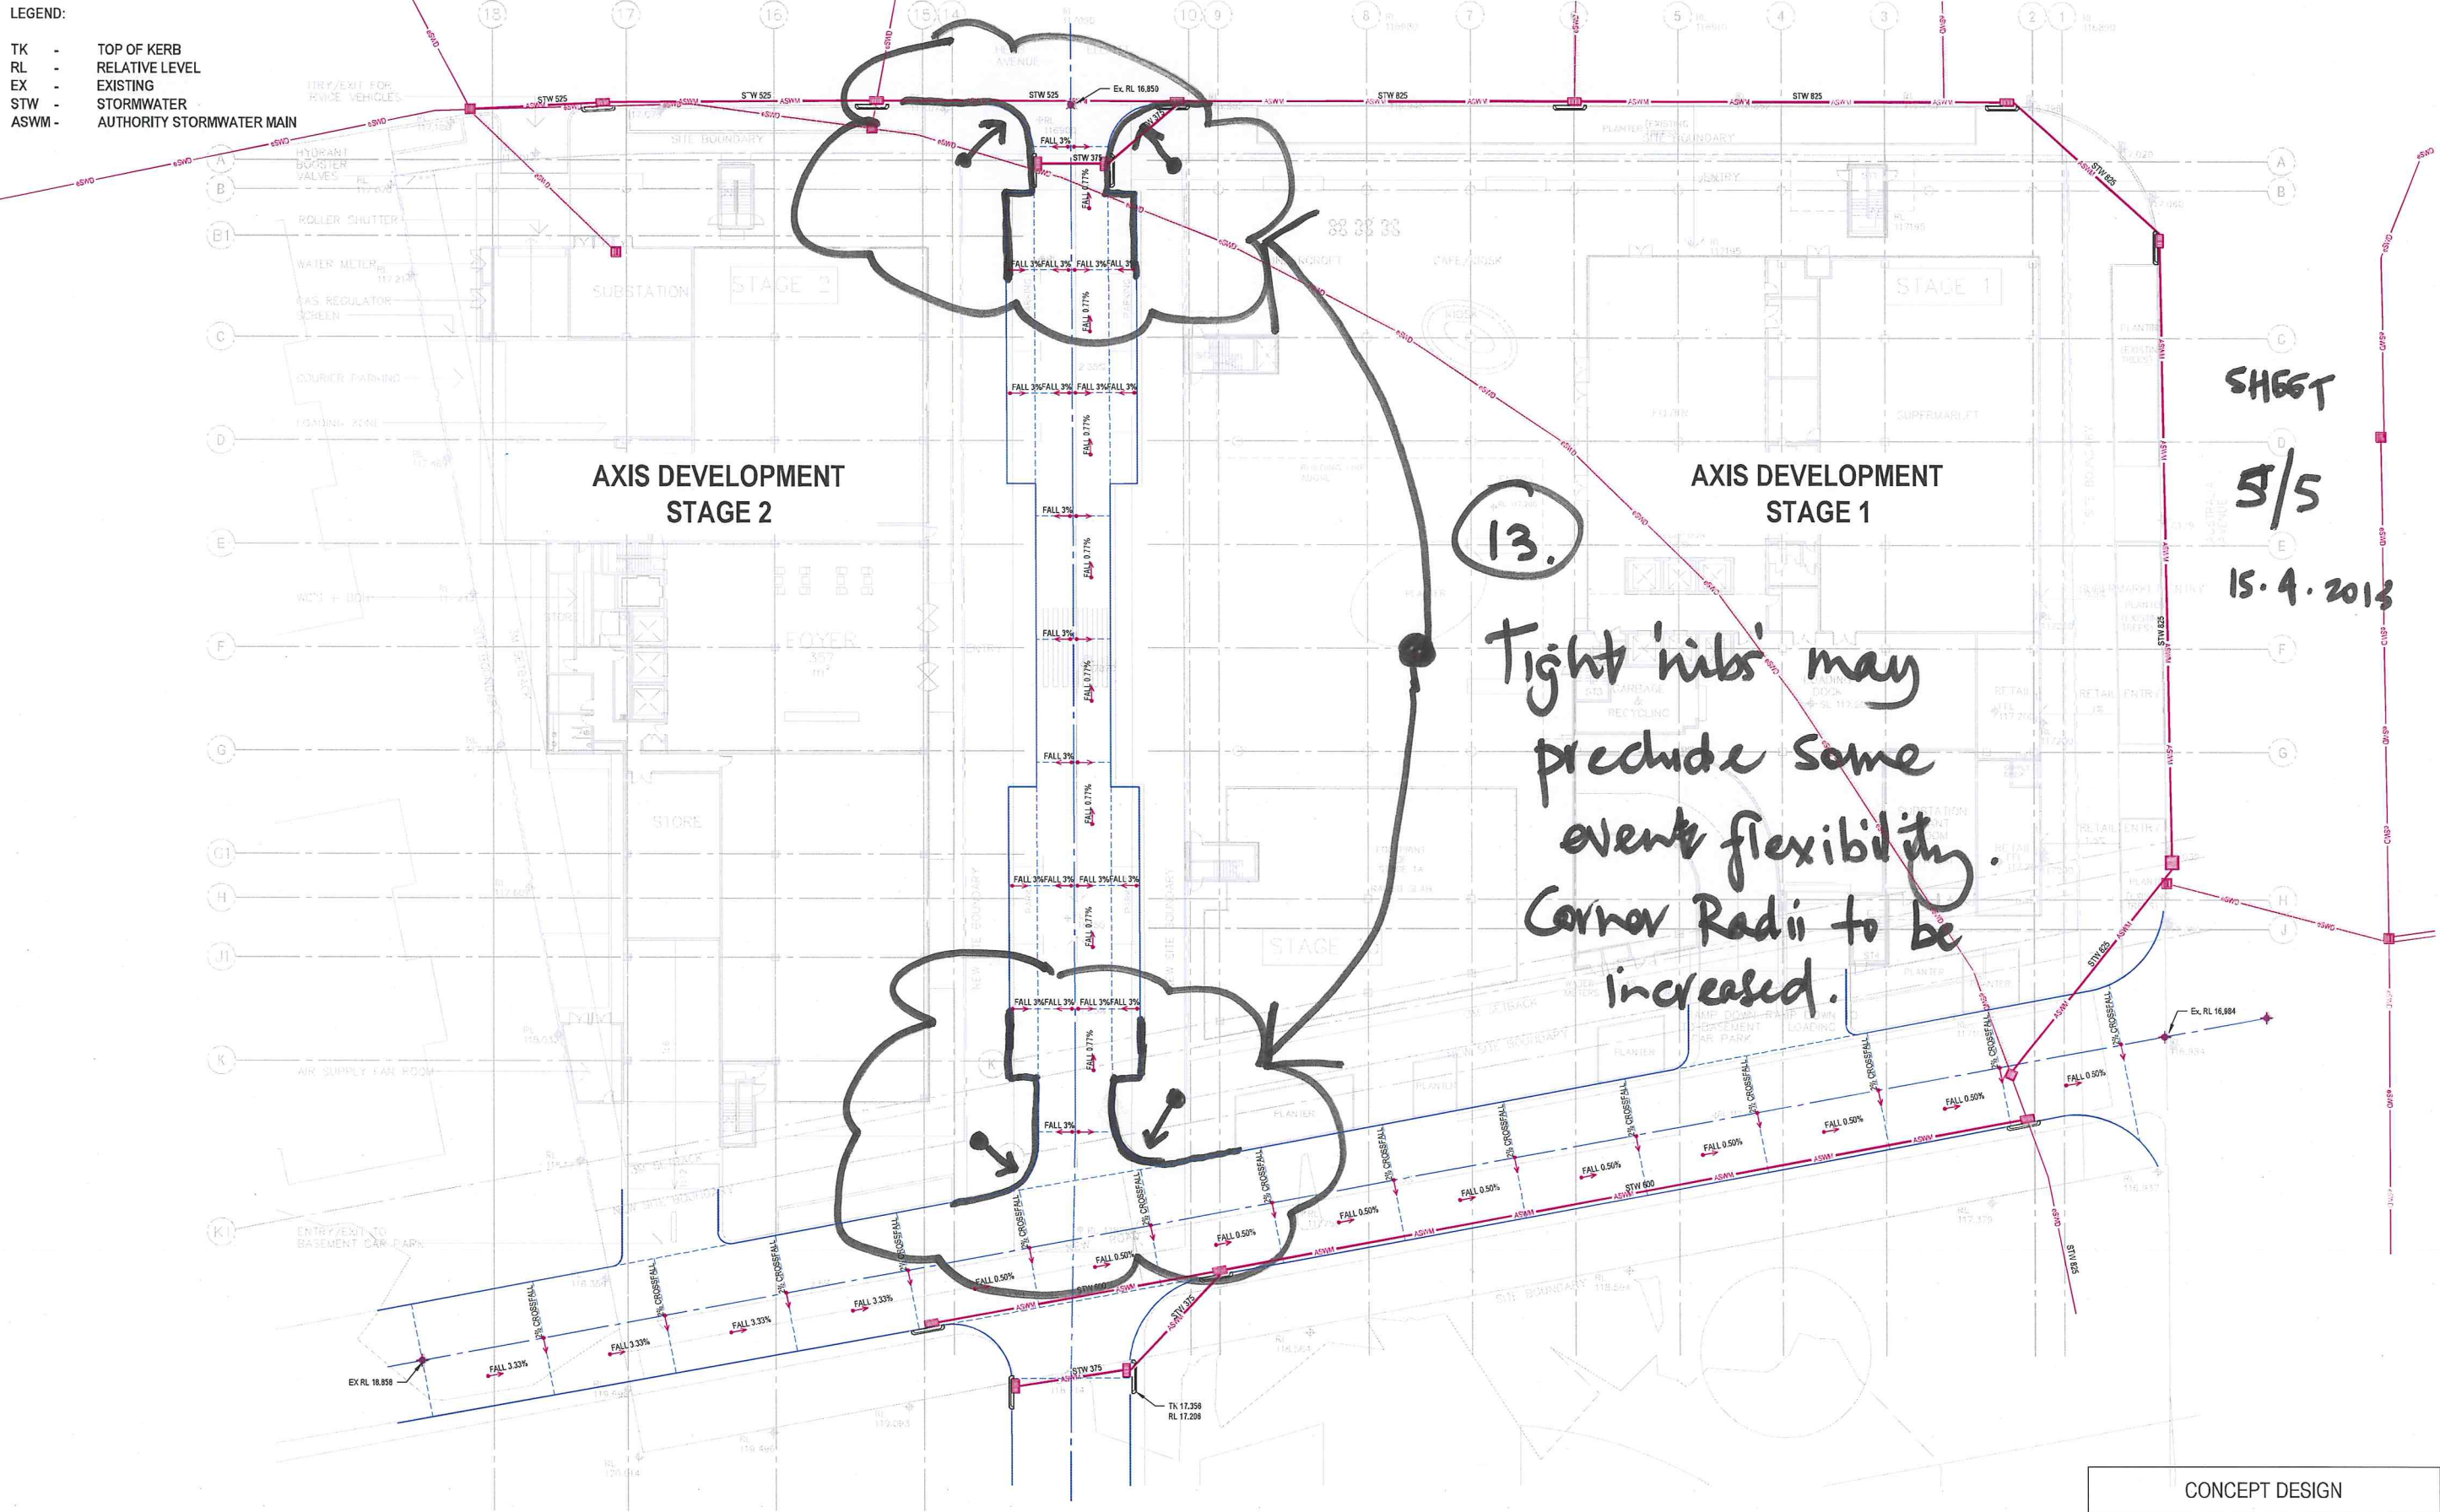

SHEET
5/5
15.4.2013

CONCEPT DESIGN

Hydraulic Consultant: INSYNC SERVICES Suite 8, Level 2 55 Church Avenue MASCOT NSW 2020 Ph (02) 9699 4311 Fax (02) 9699 4322 A.C.N. 159 224 870 A.B.N. 24 917 388 129	Client: Capital Corporation Pty Ltd Suite 705 12 Century Circuit Sydney NSW 2153 Ph (02) 8553 5000 Fax (02) 8553 5099	Architect: Architectus Level 3 341 George Street Sydney NSW 2000 T (02) 8252 8400 Fax (02) 8252 8600	<table border="1"><thead><tr><th>Issue</th><th>Date</th><th>Amendment</th></tr></thead><tbody><tr><td>A</td><td>28/03/13</td><td>PRELIMINARY ISSUE</td></tr><tr><td>B</td><td>02/04/13</td><td>FOR APPROVAL</td></tr></tbody></table>	Issue	Date	Amendment	A	28/03/13	PRELIMINARY ISSUE	B	02/04/13	FOR APPROVAL	<table border="1"><thead><tr><th>Int.</th><th>App.</th><th>COORDINATED REFERENCE DRAWINGS</th><th>ISSUE</th><th>DATE</th></tr></thead><tbody><tr><td>BL</td><td>BL</td><td>SERVICE DRAWING NUMBER</td><td>A</td><td>18/03/2013</td></tr><tr><td>BL</td><td>BL</td><td>ARCH DA 1003</td><td></td><td></td></tr><tr><td></td><td></td><td>MECH</td><td></td><td></td></tr><tr><td></td><td></td><td>STRUCT</td><td></td><td></td></tr><tr><td></td><td></td><td>ELEC</td><td></td><td></td></tr><tr><td></td><td></td><td>CIVIL</td><td></td><td></td></tr></tbody></table>	Int.	App.	COORDINATED REFERENCE DRAWINGS	ISSUE	DATE	BL	BL	SERVICE DRAWING NUMBER	A	18/03/2013	BL	BL	ARCH DA 1003					MECH					STRUCT					ELEC					CIVIL			Project: SITE 43/44 SYDNEY OLYMPIC PARK 6 Australia Avenue Sydney Olympic Park NSW 2140	Drawing Title: ROAD WORKS GRADING PLAN	North Point: 	Job No: 2012009 Dwg No: RW-002	Scale: (A1) 1:250 Issue: B
Issue	Date	Amendment																																																			
A	28/03/13	PRELIMINARY ISSUE																																																			
B	02/04/13	FOR APPROVAL																																																			
Int.	App.	COORDINATED REFERENCE DRAWINGS	ISSUE	DATE																																																	
BL	BL	SERVICE DRAWING NUMBER	A	18/03/2013																																																	
BL	BL	ARCH DA 1003																																																			
		MECH																																																			
		STRUCT																																																			
		ELEC																																																			
		CIVIL																																																			

INSYNC SERVICES



FILE NAME & PATH: I:\Working\Projects\2012\2012009 Axis Development - Sydney Olympic Park\Drawings\Hydraulic\RW-002.dwg PLOTTED BY: jenkinsy PLOT DATE & TIME: 02 Apr 2013 11:53:00am