

THE NEXT GENERATION

CIVIL INFRASTRUCTURE WORKS PACKAGE

EIS SUBMISSION

DRAWING LIST

- GENERAL**
- C000 COVER SHEET AND LOCALITY PLAN
 - C001 NOTES AND LEGENDS
 - C002 GENERAL ARRANGEMENT PLAN
- TYPICAL SECTIONS**
- C003 TYPICAL SECTIONS SHEET 1
 - C004 TYPICAL SECTIONS SHEET 2
 - C005 TYPICAL SECTIONS SHEET 3
 - C006 TYPICAL SECTIONS SHEET 4
 - C007 ESTATE ROAD TYPICAL SECTIONS AND DETAILS


- BULK EARTHWORKS**
- C009 BULK EARTHWORKS CUT AND FILL PLAN

- SITWORKS AND STORMWATER DRAINAGE PLAN**
- C010 SITWORKS AND STORMWATER DRAINAGE PLAN SHEET 1 OF 7
 - C011 SITWORKS AND STORMWATER DRAINAGE PLAN SHEET 2 OF 7
 - C012 SITWORKS AND STORMWATER DRAINAGE PLAN SHEET 3 OF 7
 - C013 SITWORKS AND STORMWATER DRAINAGE PLAN SHEET 4 OF 7
 - C014 SITWORKS AND STORMWATER DRAINAGE PLAN SHEET 5 OF 7
 - C015 SITWORKS AND STORMWATER DRAINAGE PLAN SHEET 6 OF 7
 - C016 SITWORKS AND STORMWATER DRAINAGE PLAN SHEET 7 OF 7

- ROAD LONGITUDINAL SECTIONS**
- C020 ESTATE ROAD LONGITUDINAL SECTIONS SHEET 1 OF 3
 - C021 ESTATE ROAD LONGITUDINAL SECTIONS SHEET 2 OF 3
 - C022 ESTATE ROAD LONGITUDINAL SECTIONS SHEET 3 OF 3


- PAVEMENT PLANS**
- C030 PAVEMENT PLAN

- EROSION AND SEDIMENTATION CONTROL**
- C040 EROSION AND SEDIMENTATION CONTROL PLAN
 - C041 EROSION AND SEDIMENTATION CONTROL DETAILS

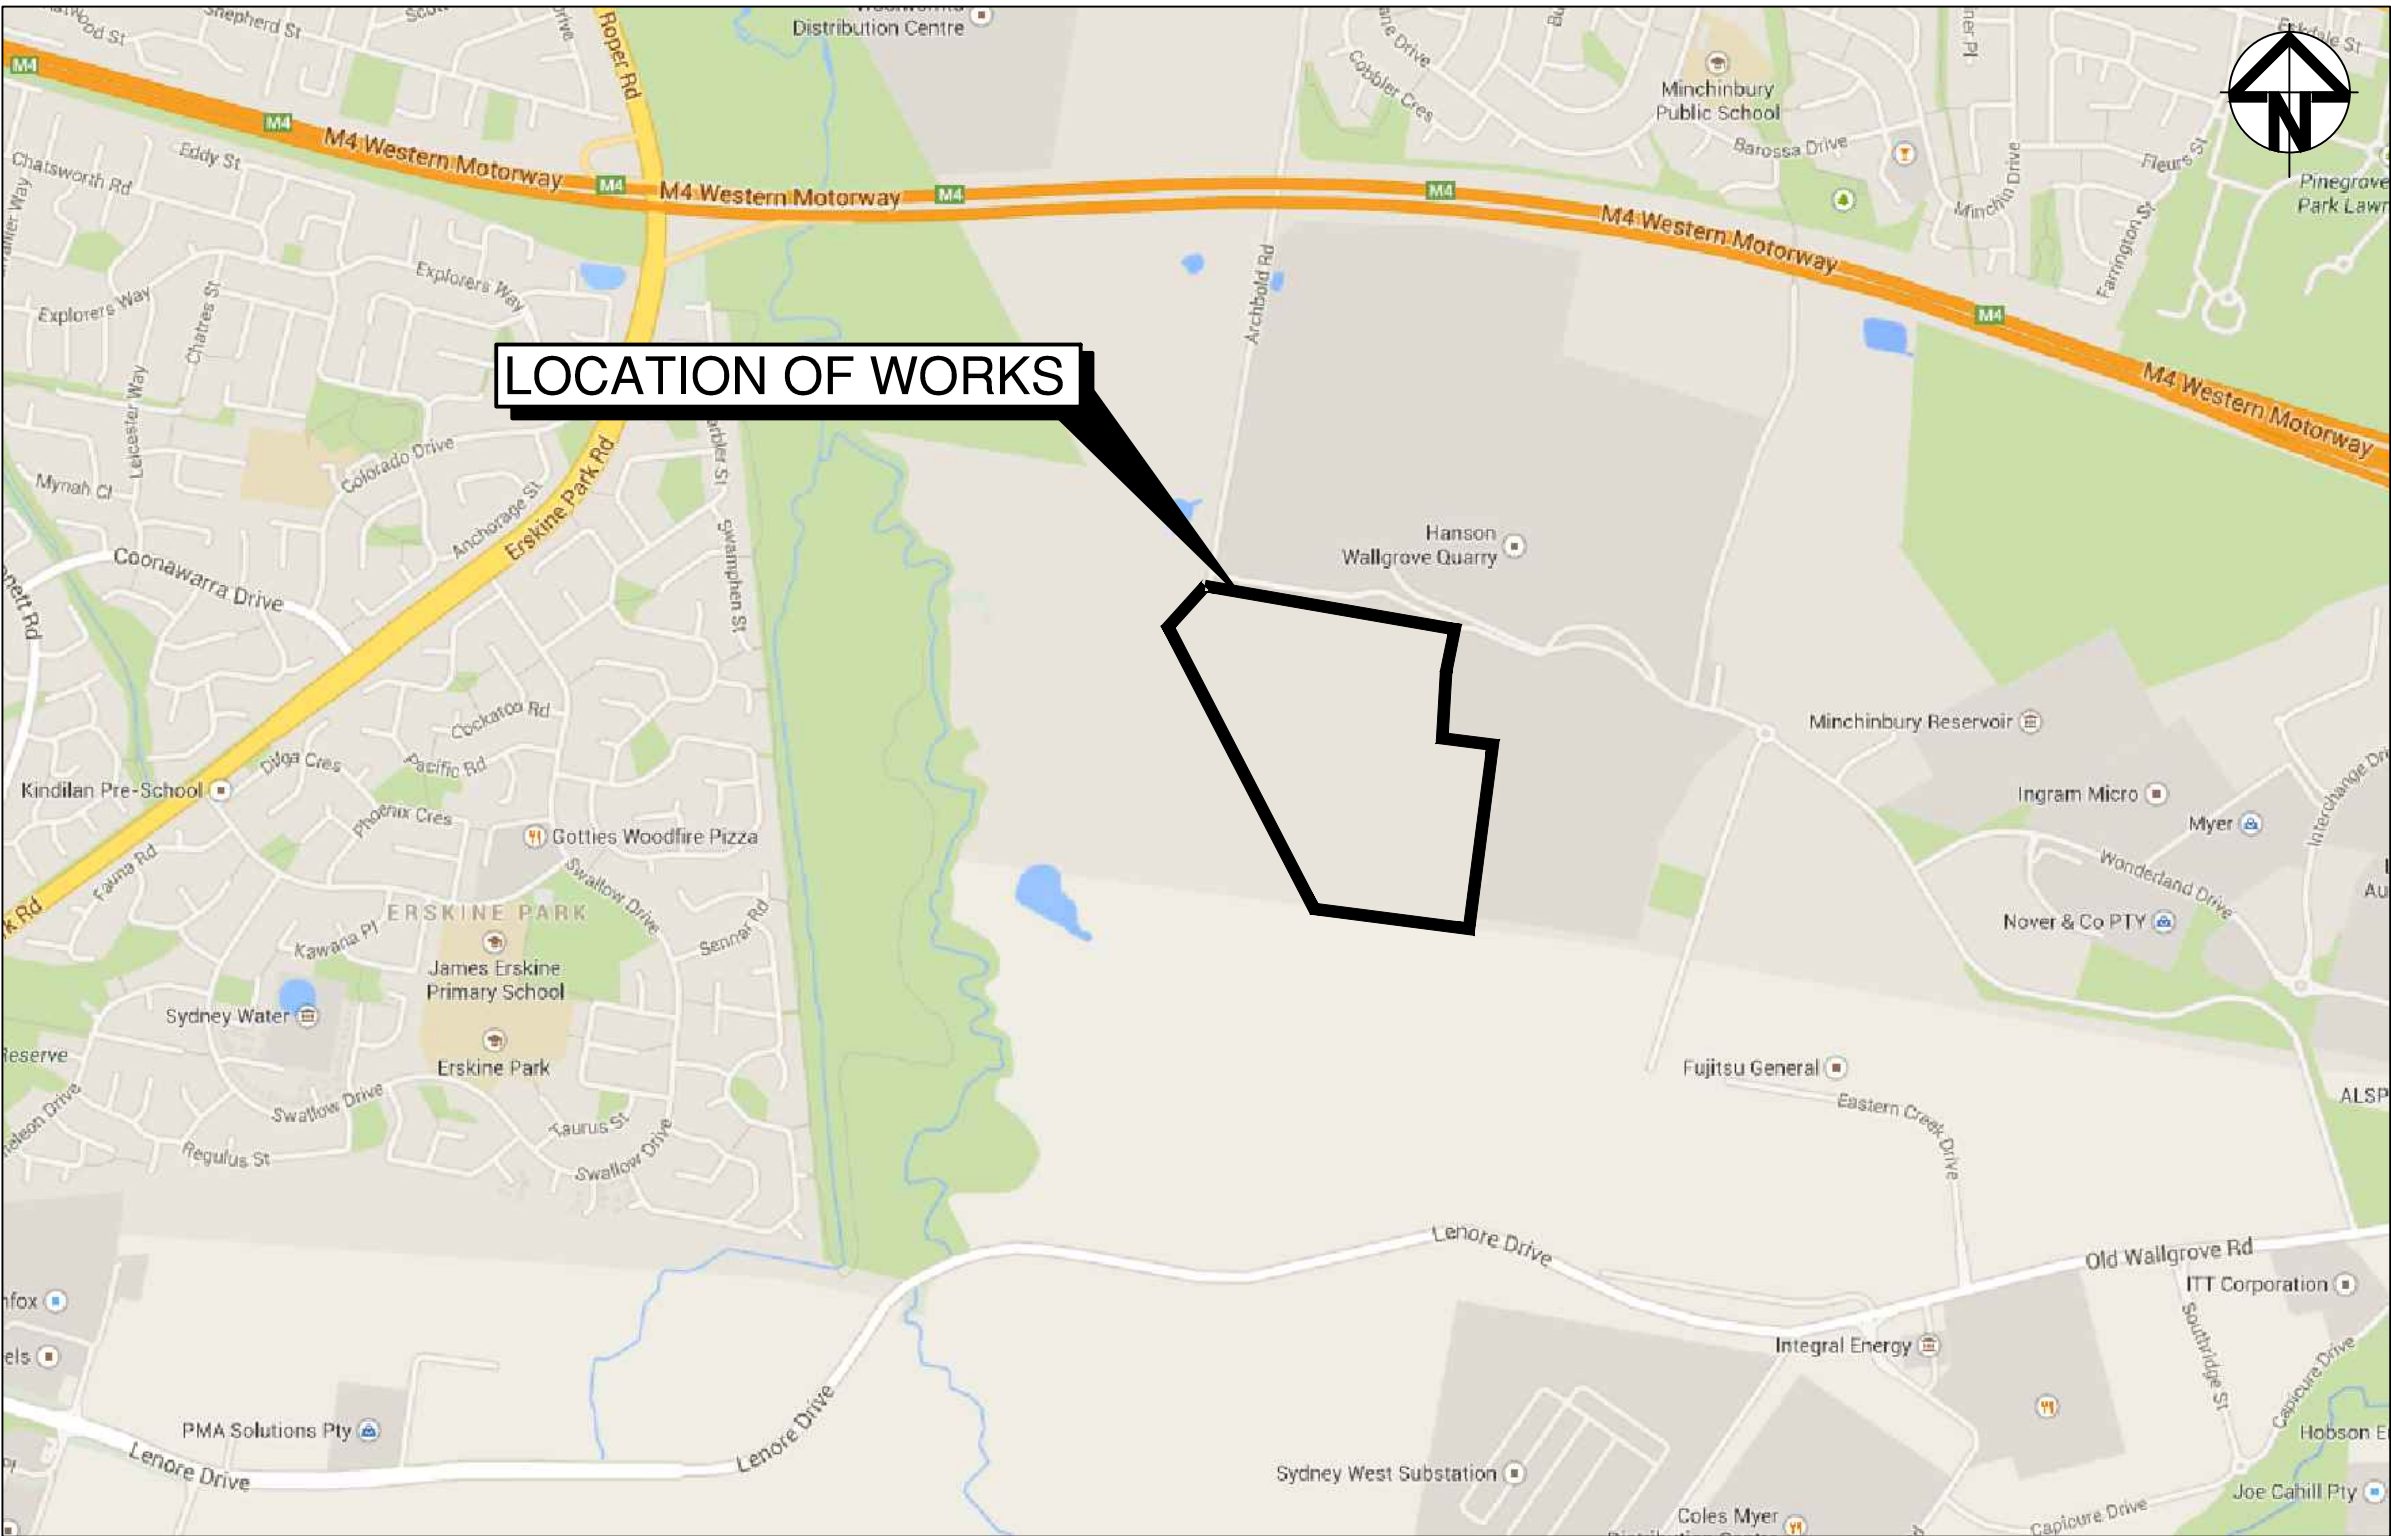

LOCALITY PLAN
N.T.S

			Bar Scales	THIS DRAWING CANNOT BE COPIED OR REPRODUCED IN ANY FORM OR USED FOR ANY OTHER PURPOSE OTHER THAN THAT ORIGINALLY INTENDED WITHOUT THE WRITTEN PERMISSION OF AT&L	Client 	Scales	Drawn	TS	Project ENERGY FROM WASTE ELECTRICITY GENERATION PLANT, EASTERN CREEK	Civil Engineers and Project Managers  Level 7, 153 Walker Street North Sydney NSW 2060 ABN 96 130 882 405 Tel: 02 9439 1777 Fax: 02 9923 1055 www.atl.net.au info@atl.net.au	
							Designed	TS			
							Grid	Checked			MM
							Height Datum	Approved			
D	RE-ISSUED FOR SSDA	13-07-17									
C	RE-ISSUED FOR SSDA	20-02-15									
B	ISSUED FOR SSDA	18-06-14	COVER SHEET AND LOCALITY PLAN		Title	Status FOR APPROVAL NOT TO BE USED FOR CONSTRUCTION	A1				
A	ISSUED FOR CLIENT REVIEW	14-05-14									
Issue	Description	Date						Drawing No. C000	Project No. 14-187	Issue D	

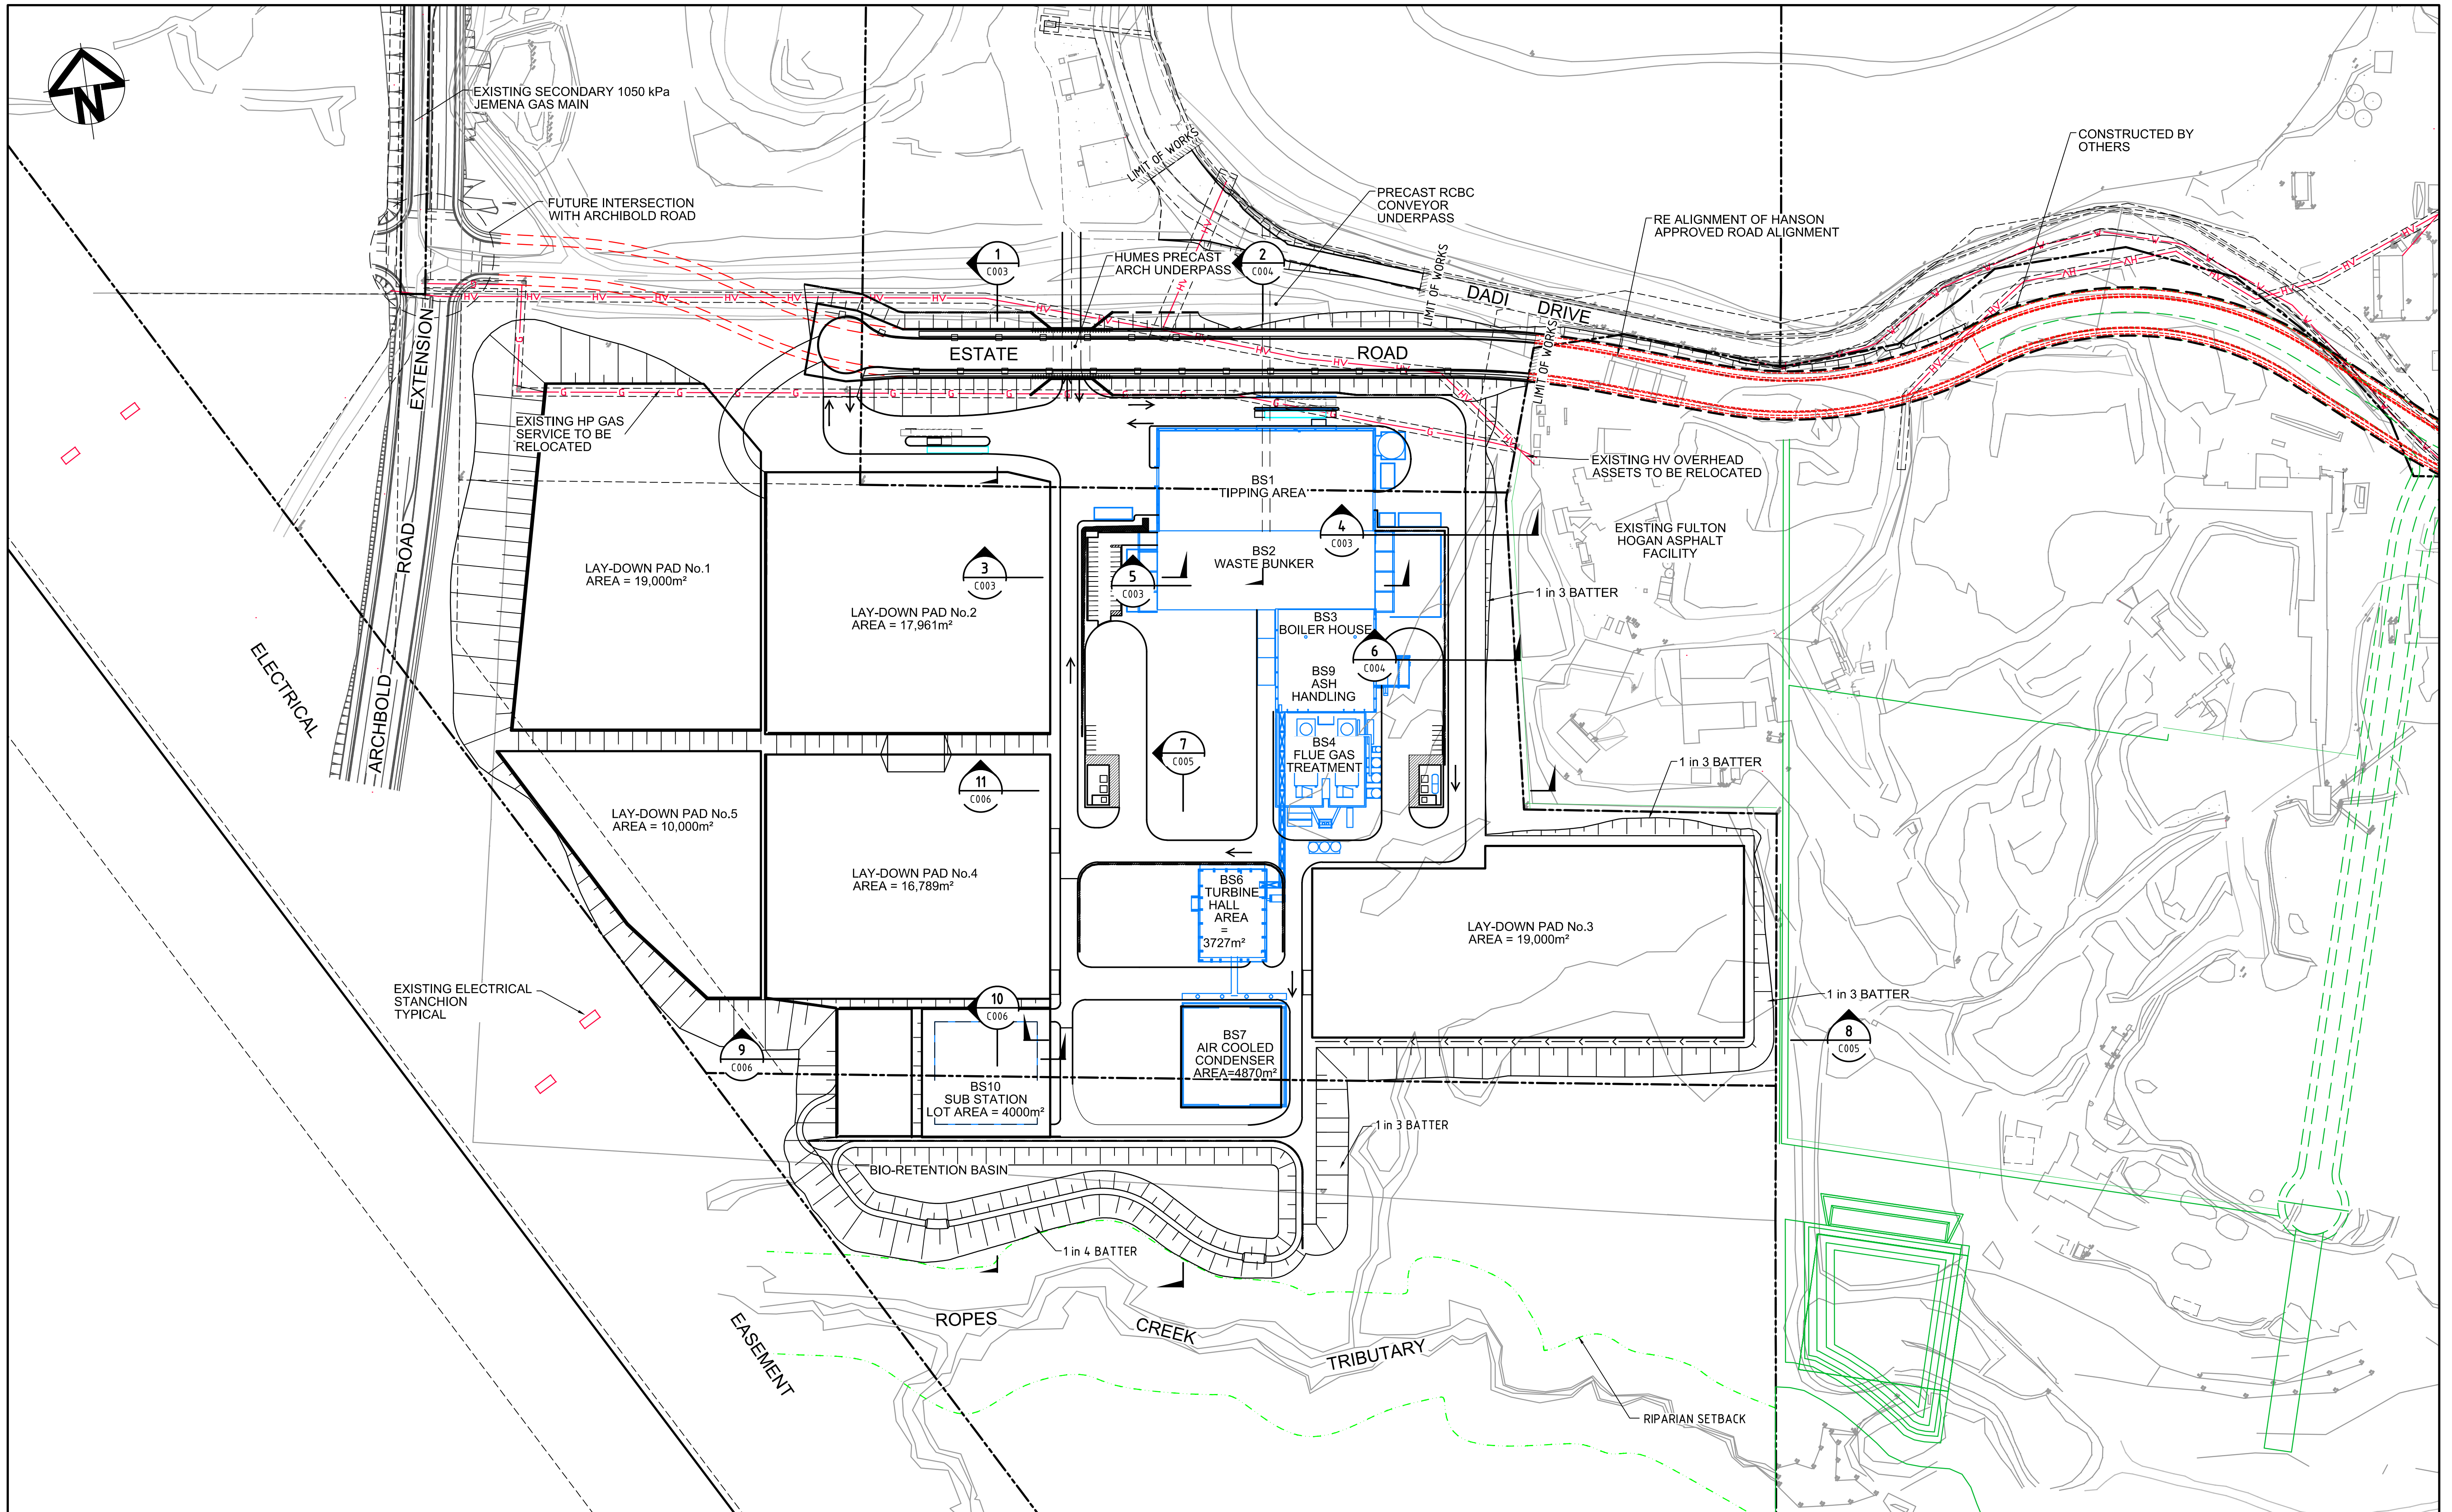

Issue	Description	Date
H	RE-ISSUED FOR SSDA	14-09-17
G	RE-ISSUED FOR SSDA	13-07-17
F	RE-ISSUED FOR SSDA	12-03-15
E	RE-ISSUED FOR SSDA	20-02-15
D	ISSUED FOR SSDA	18-06-14
C	ISSUED FOR INFORMATION	16-06-14
B	ISSUED FOR CLIENT REVIEW	14-05-14
A	ISSUED FOR COORDINATION	06-05-14

Bar Scales	
1 : 1500 @ A1 1 : 3000 @ A3	


THIS DRAWING CANNOT BE COPIED OR REPRODUCED IN ANY FORM OR USED FOR ANY OTHER PURPOSE OTHER THAN THAT ORIGINALLY INTENDED WITHOUT THE WRITTEN PERMISSION OF AT&L




Scales		Drawn	
1 : 1500 @ A1		Designed	TS
Grid MGA		Checked	MM
Height Datum AHD		Approved	

Project		Title	
ENERGY FROM WASTE ELECTRICITY GENERATION PLANT, EASTERN CREEK		GENERAL ARRANGEMENT PLAN	


Civil Engineers and Project Managers			
Level 7, 153 Walker Street North Sydney NSW 2060 ABN 66 130 882 405 Tel: 02 9439 1777 Fax: 02 9923 1055 www.atl.net.au info@atl.net.au			
Status NOT TO BE USED FOR CONSTRUCTION		FOR APPROVAL	
Drawing No. C002		Project No. 14-187	
		Issue H	

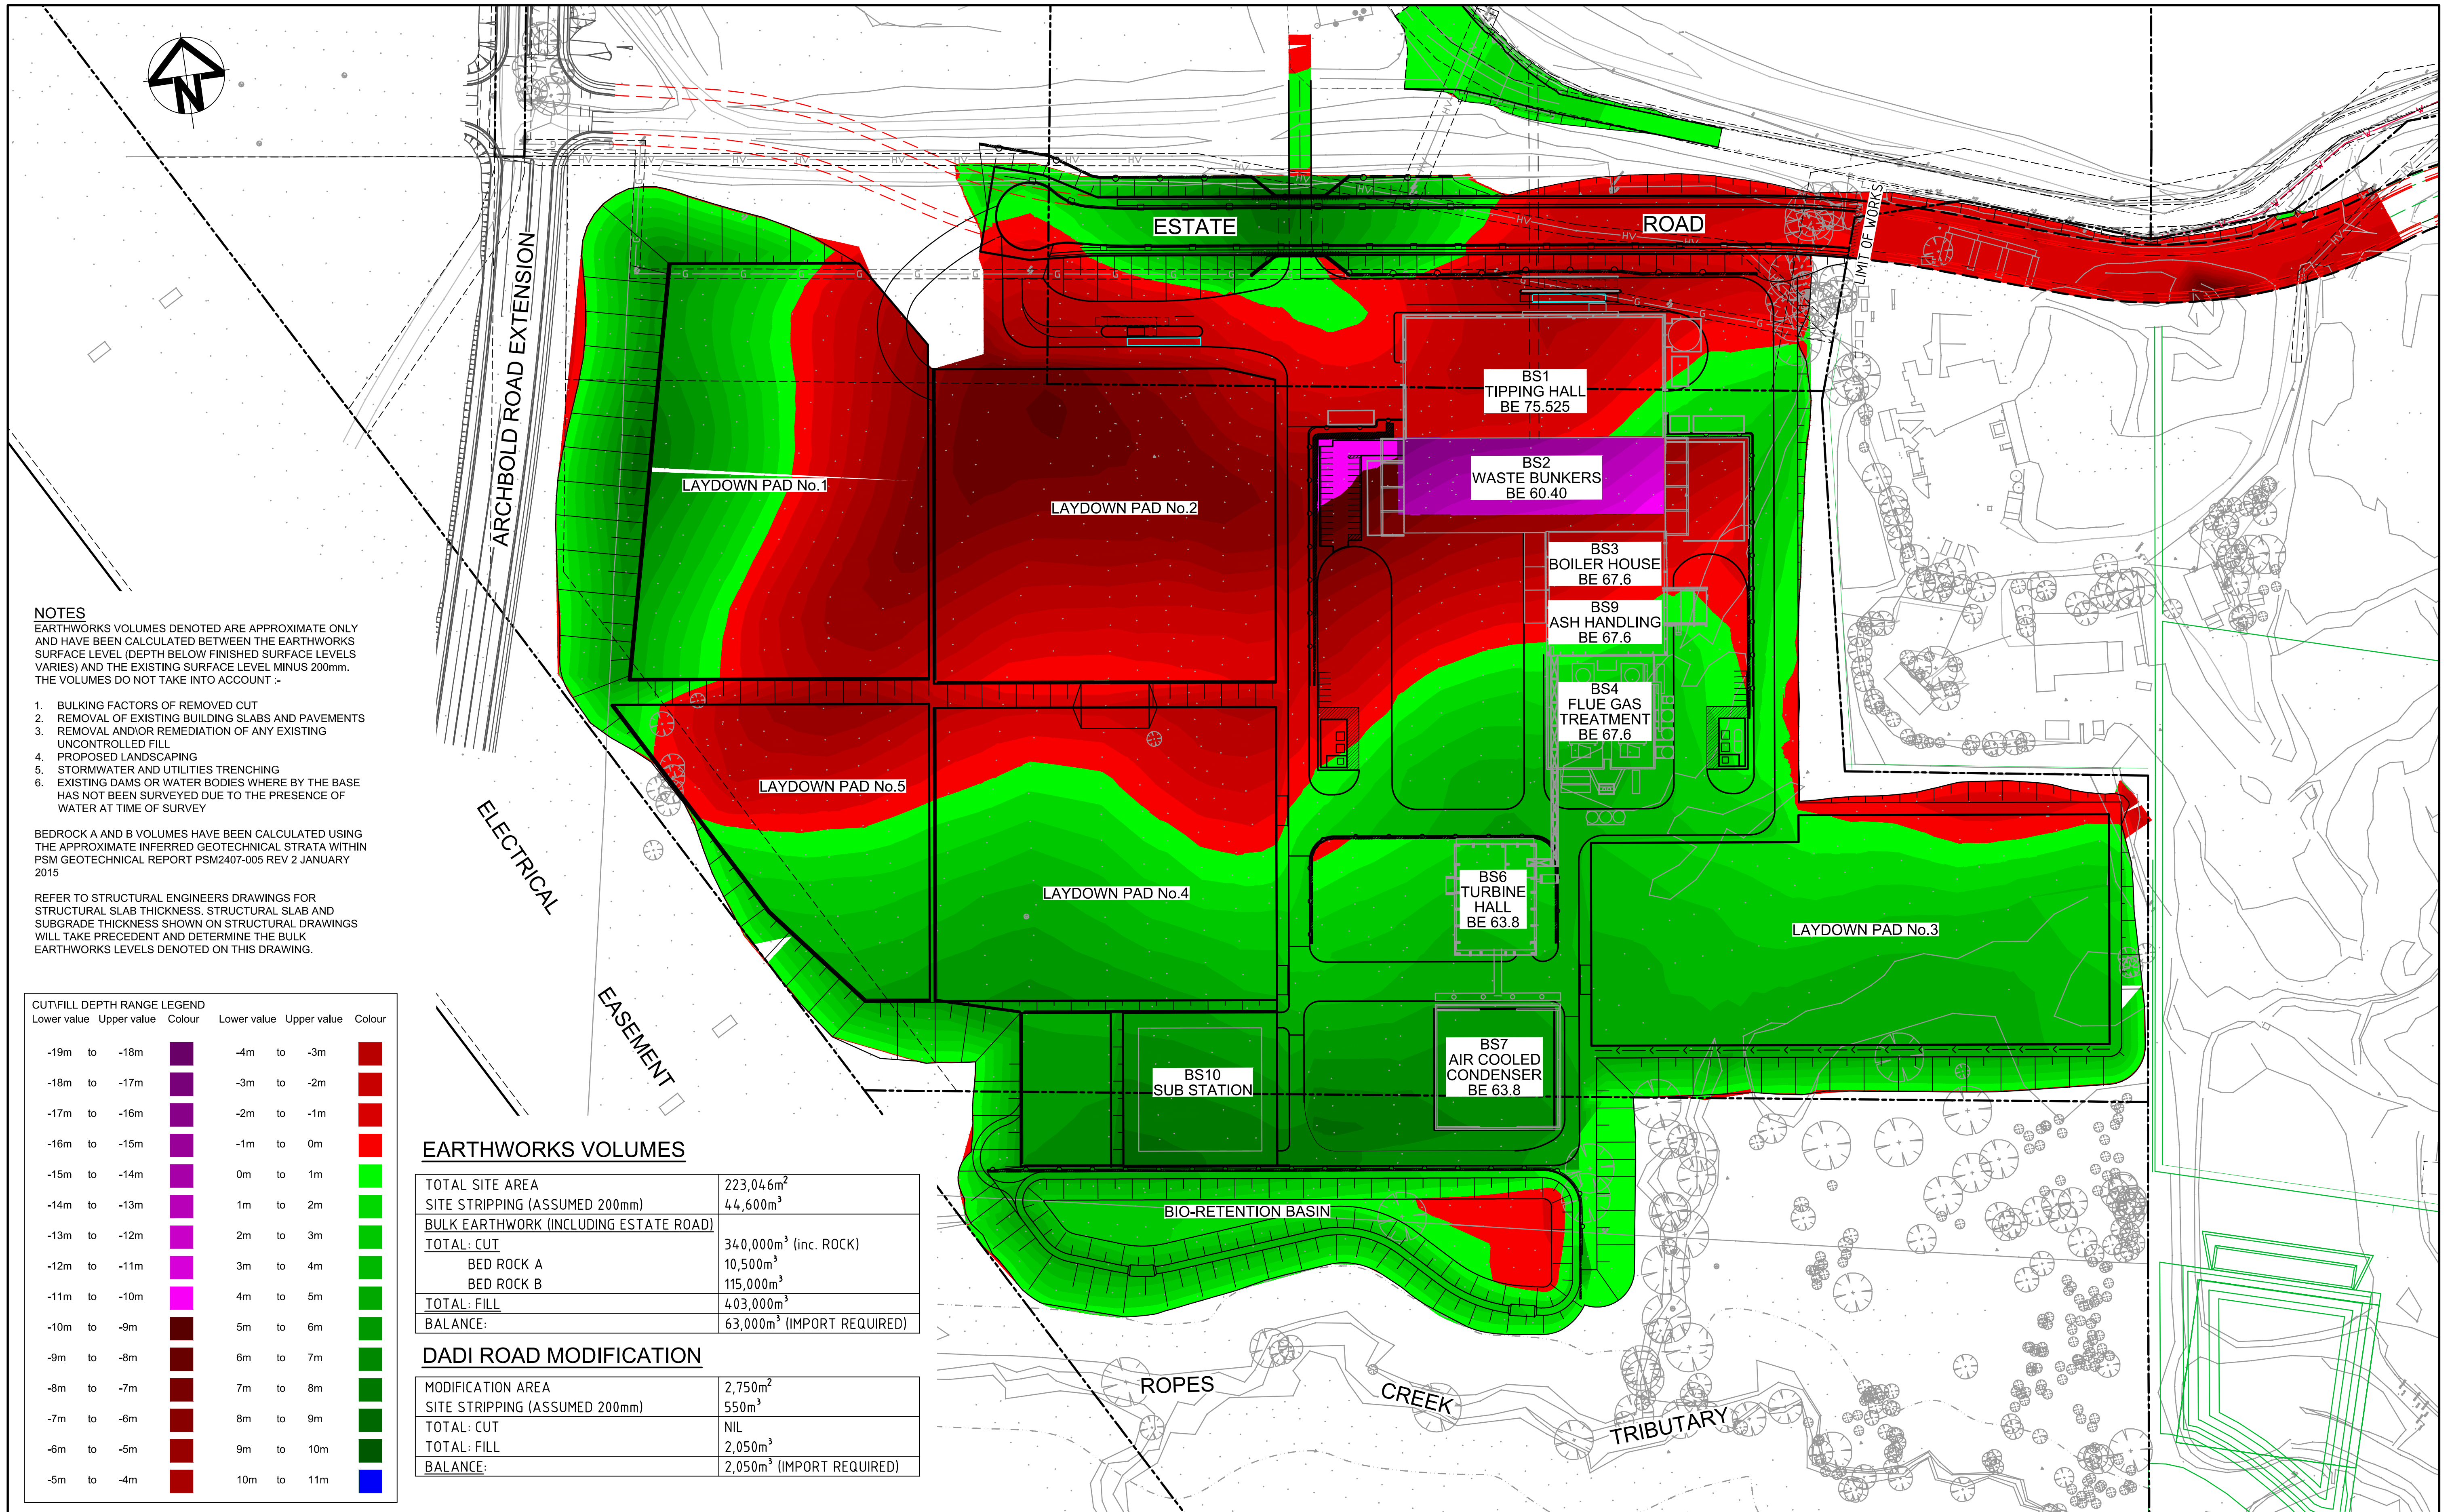

			Bar Scales	0255075100125m 1 : 1250 @ A1 1 : 2500 @ A3	THIS DRAWING CANNOT BE COPIED OR REPRODUCED IN ANY FORM OR USED FOR ANY OTHER PURPOSE OTHER THAN THAT ORIGINALLY INTENDED WITHOUT THE WRITTEN PERMISSION OF AT&L	Client The Next Generation (NSW) Pty Ltd Energyise Your Future	Scales 1 : 1250 @ A1	Drawn TS	Project ENERGY FROM WASTE ELECTRICITY GENERATION PLANT, EASTERN CREEK	Civil Engineers and Project Managers at&l Level 7, 153 Walker Street North Sydney NSW 2060 ABN 96 130 882 405 Tel: 02 9439 1777 Fax: 02 9923 1055 www.atl.net.au info@atl.net.au	
		Designed TS					Title BULK EARTHWORKS CUT AND FILL PLAN	Status FOR APPROVAL NOT TO BE USED FOR CONSTRUCTION			A1
		Checked MM									
		Approved					Drawing No. C009	Project No. 14-187	Issue F		
		Datum									
F	RE-ISSUED FOR SSDA	25-09-17									
E	RE-ISSUED FOR SSDA	14-09-17									
D	RE-ISSUED FOR SSDA	13-07-17									
C	RE-ISSUED FOR SSDA	20-02-15									
B	ISSUED FOR SSDA	18-06-14									
A	ISSUED FOR CLIENT REVIEW	14-05-14									
Issue	Description	Date									

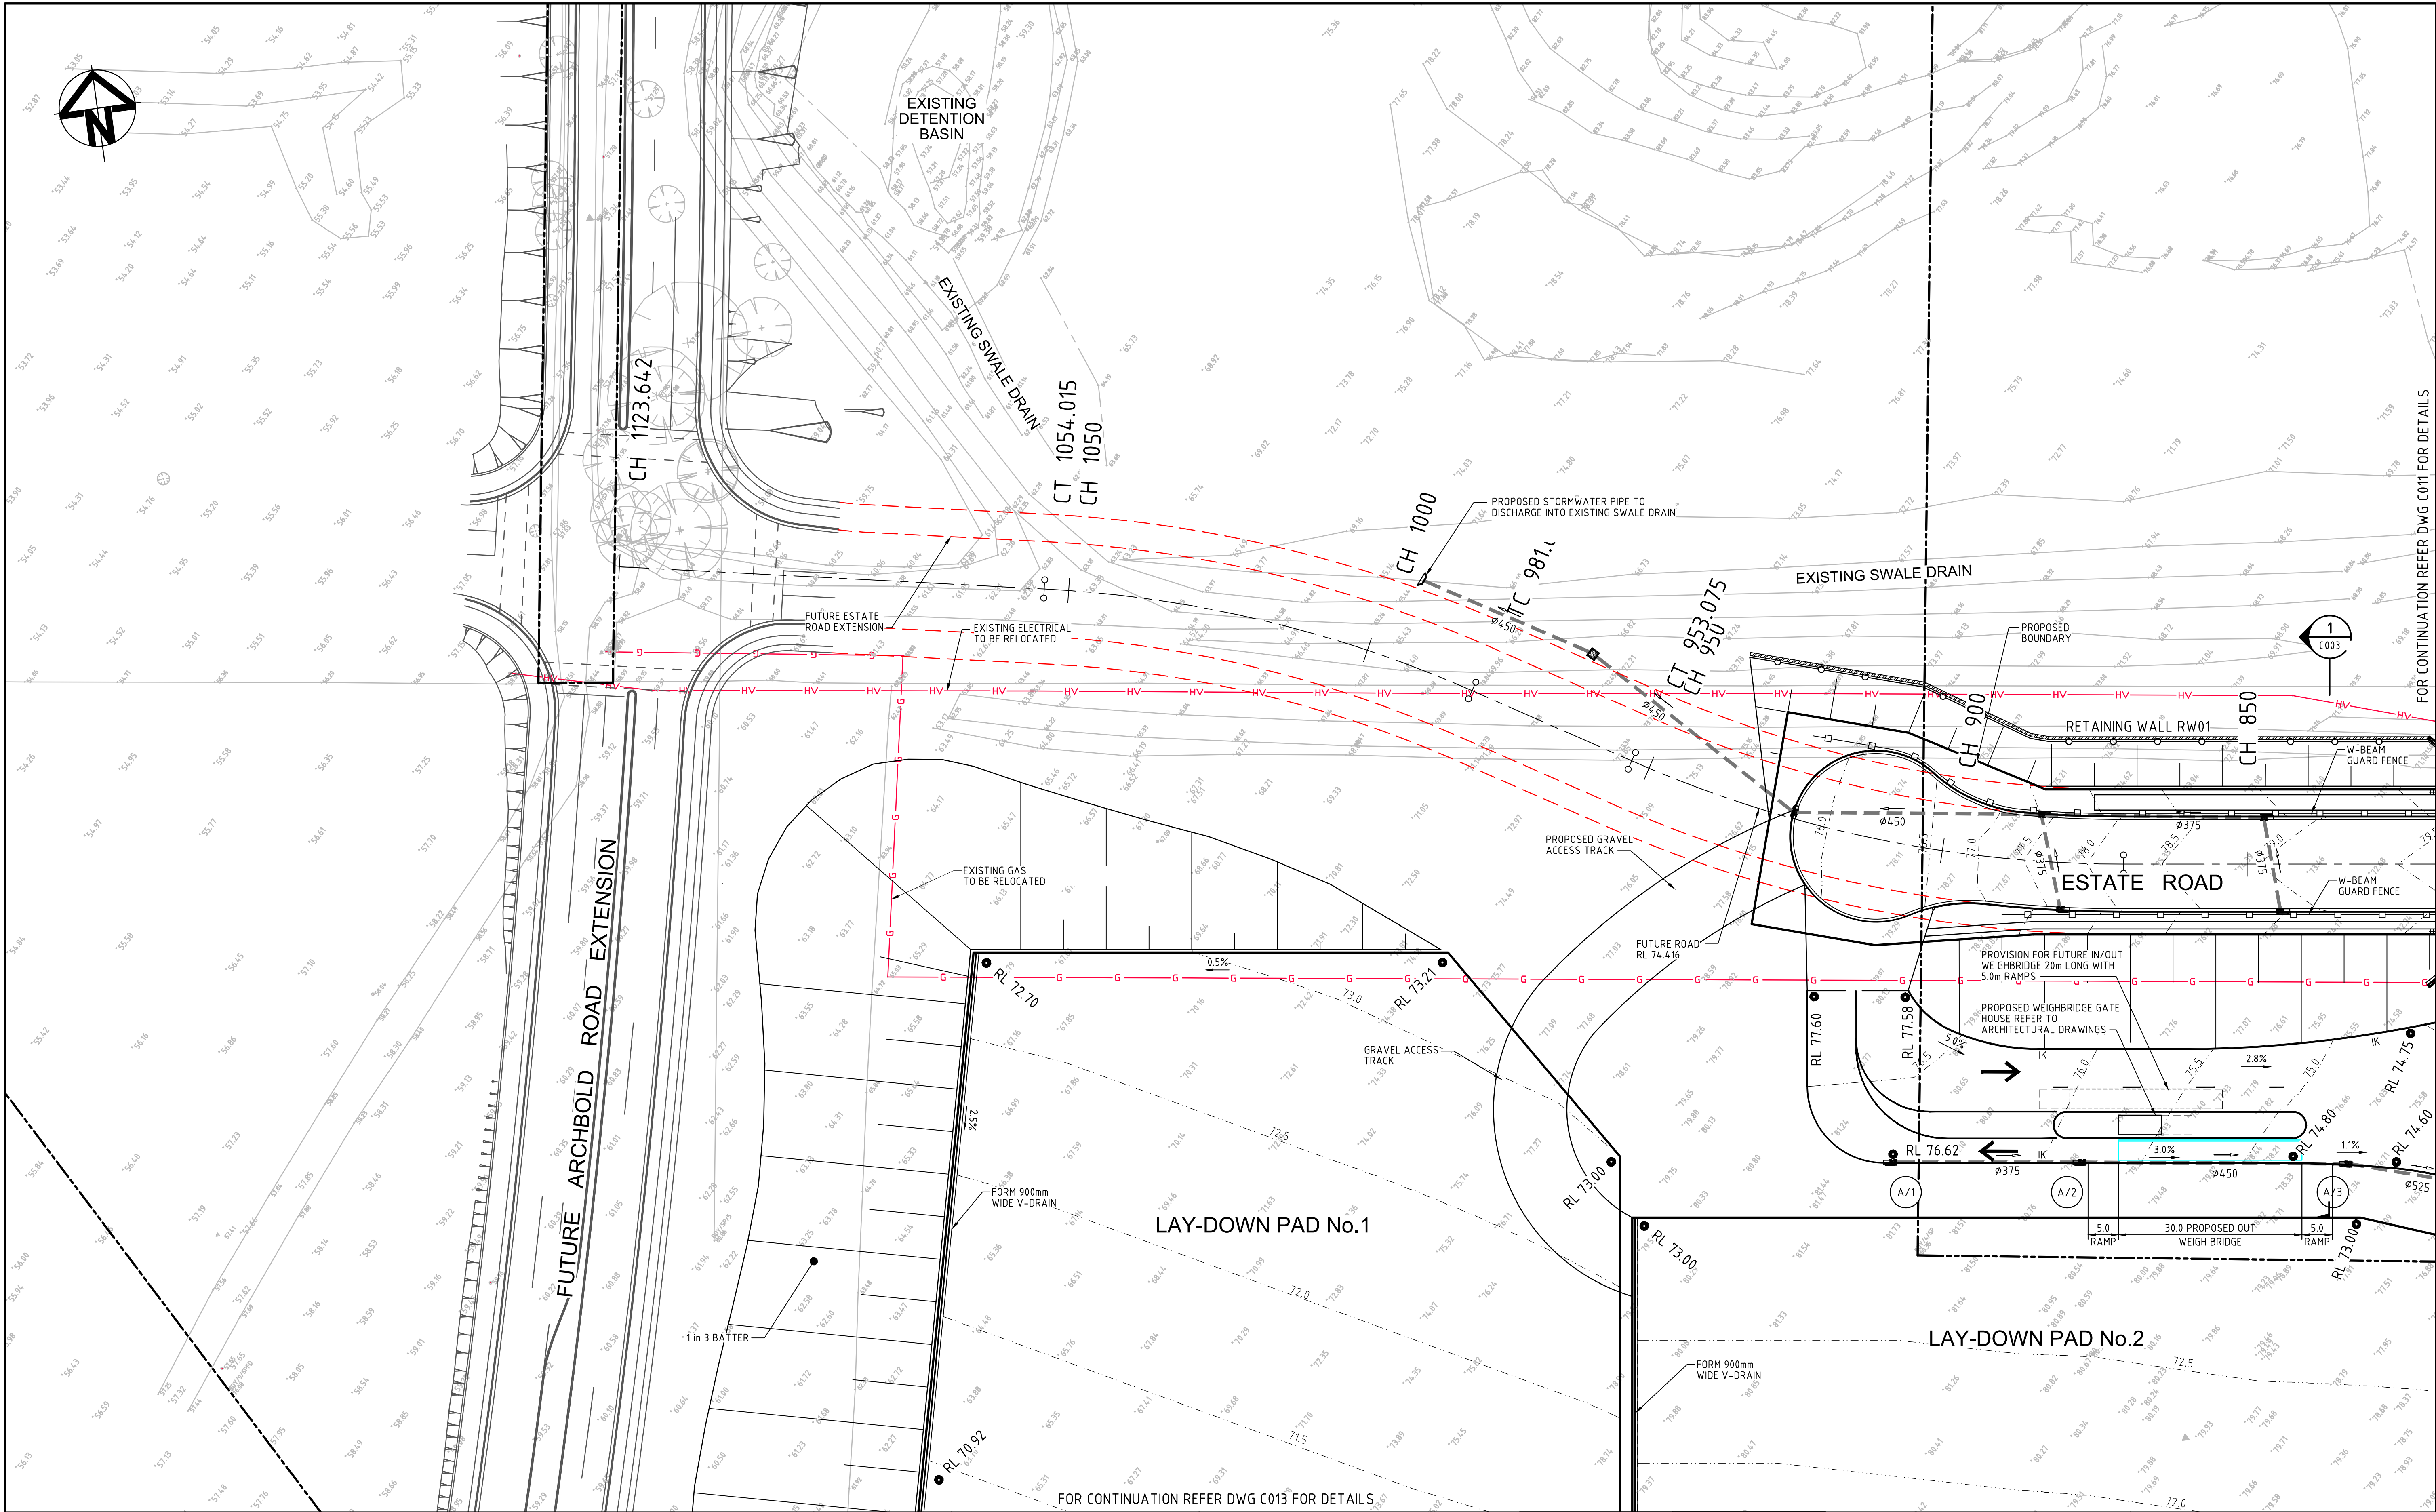

Issue	Description	Date
E	RE-ISSUED FOR SSDA	14-09-17
D	RE-ISSUED FOR SSDA	13-07-17
C	RE-ISSUED FOR SSDA	20-02-15
B	ISSUED FOR SSDA	18-06-14
A	ISSUED FOR CLIENT REVIEW	14-05-14

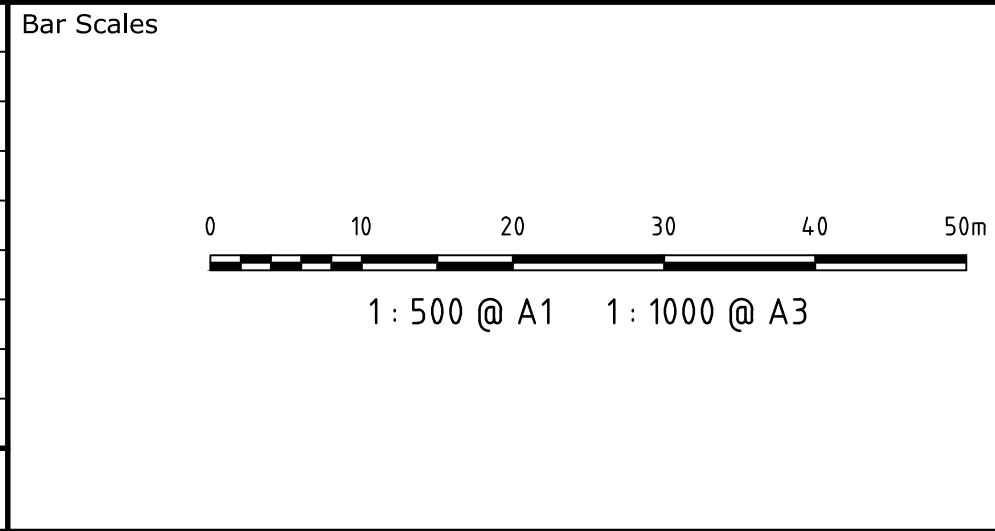


THIS DRAWING CANNOT BE COPIED OR REPRODUCED IN ANY FORM OR USED FOR ANY OTHER PURPOSE OTHER THAN THAT ORIGINALLY INTENDED WITHOUT THE WRITTEN PERMISSION OF AT&L



Scales	1 : 500 @ A1	Drawn	TS
		Designed	TS
Grid	MGA	Checked	MM
Height Datum	AHD	Approved	

Project	ENERGY FROM WASTE ELECTRICITY GENERATION PLANT, EASTERN CREEK
Title	SITWORKS AND STORMWATER DRAINAGE PLAN SHEET 1 OF 7


Civil Engineers and Project Managers		
at&l		
Level 7, 153 Walker Street North Sydney NSW 2060 ABN 96 130 882 405 Tel: 02 9439 1777 Fax: 02 9923 1055 www.atl.net.au info@atl.net.au		
Status	FOR APPROVAL NOT TO BE USED FOR CONSTRUCTION	A1
Drawing No.	Project No.	Issue
C010	14-187	E

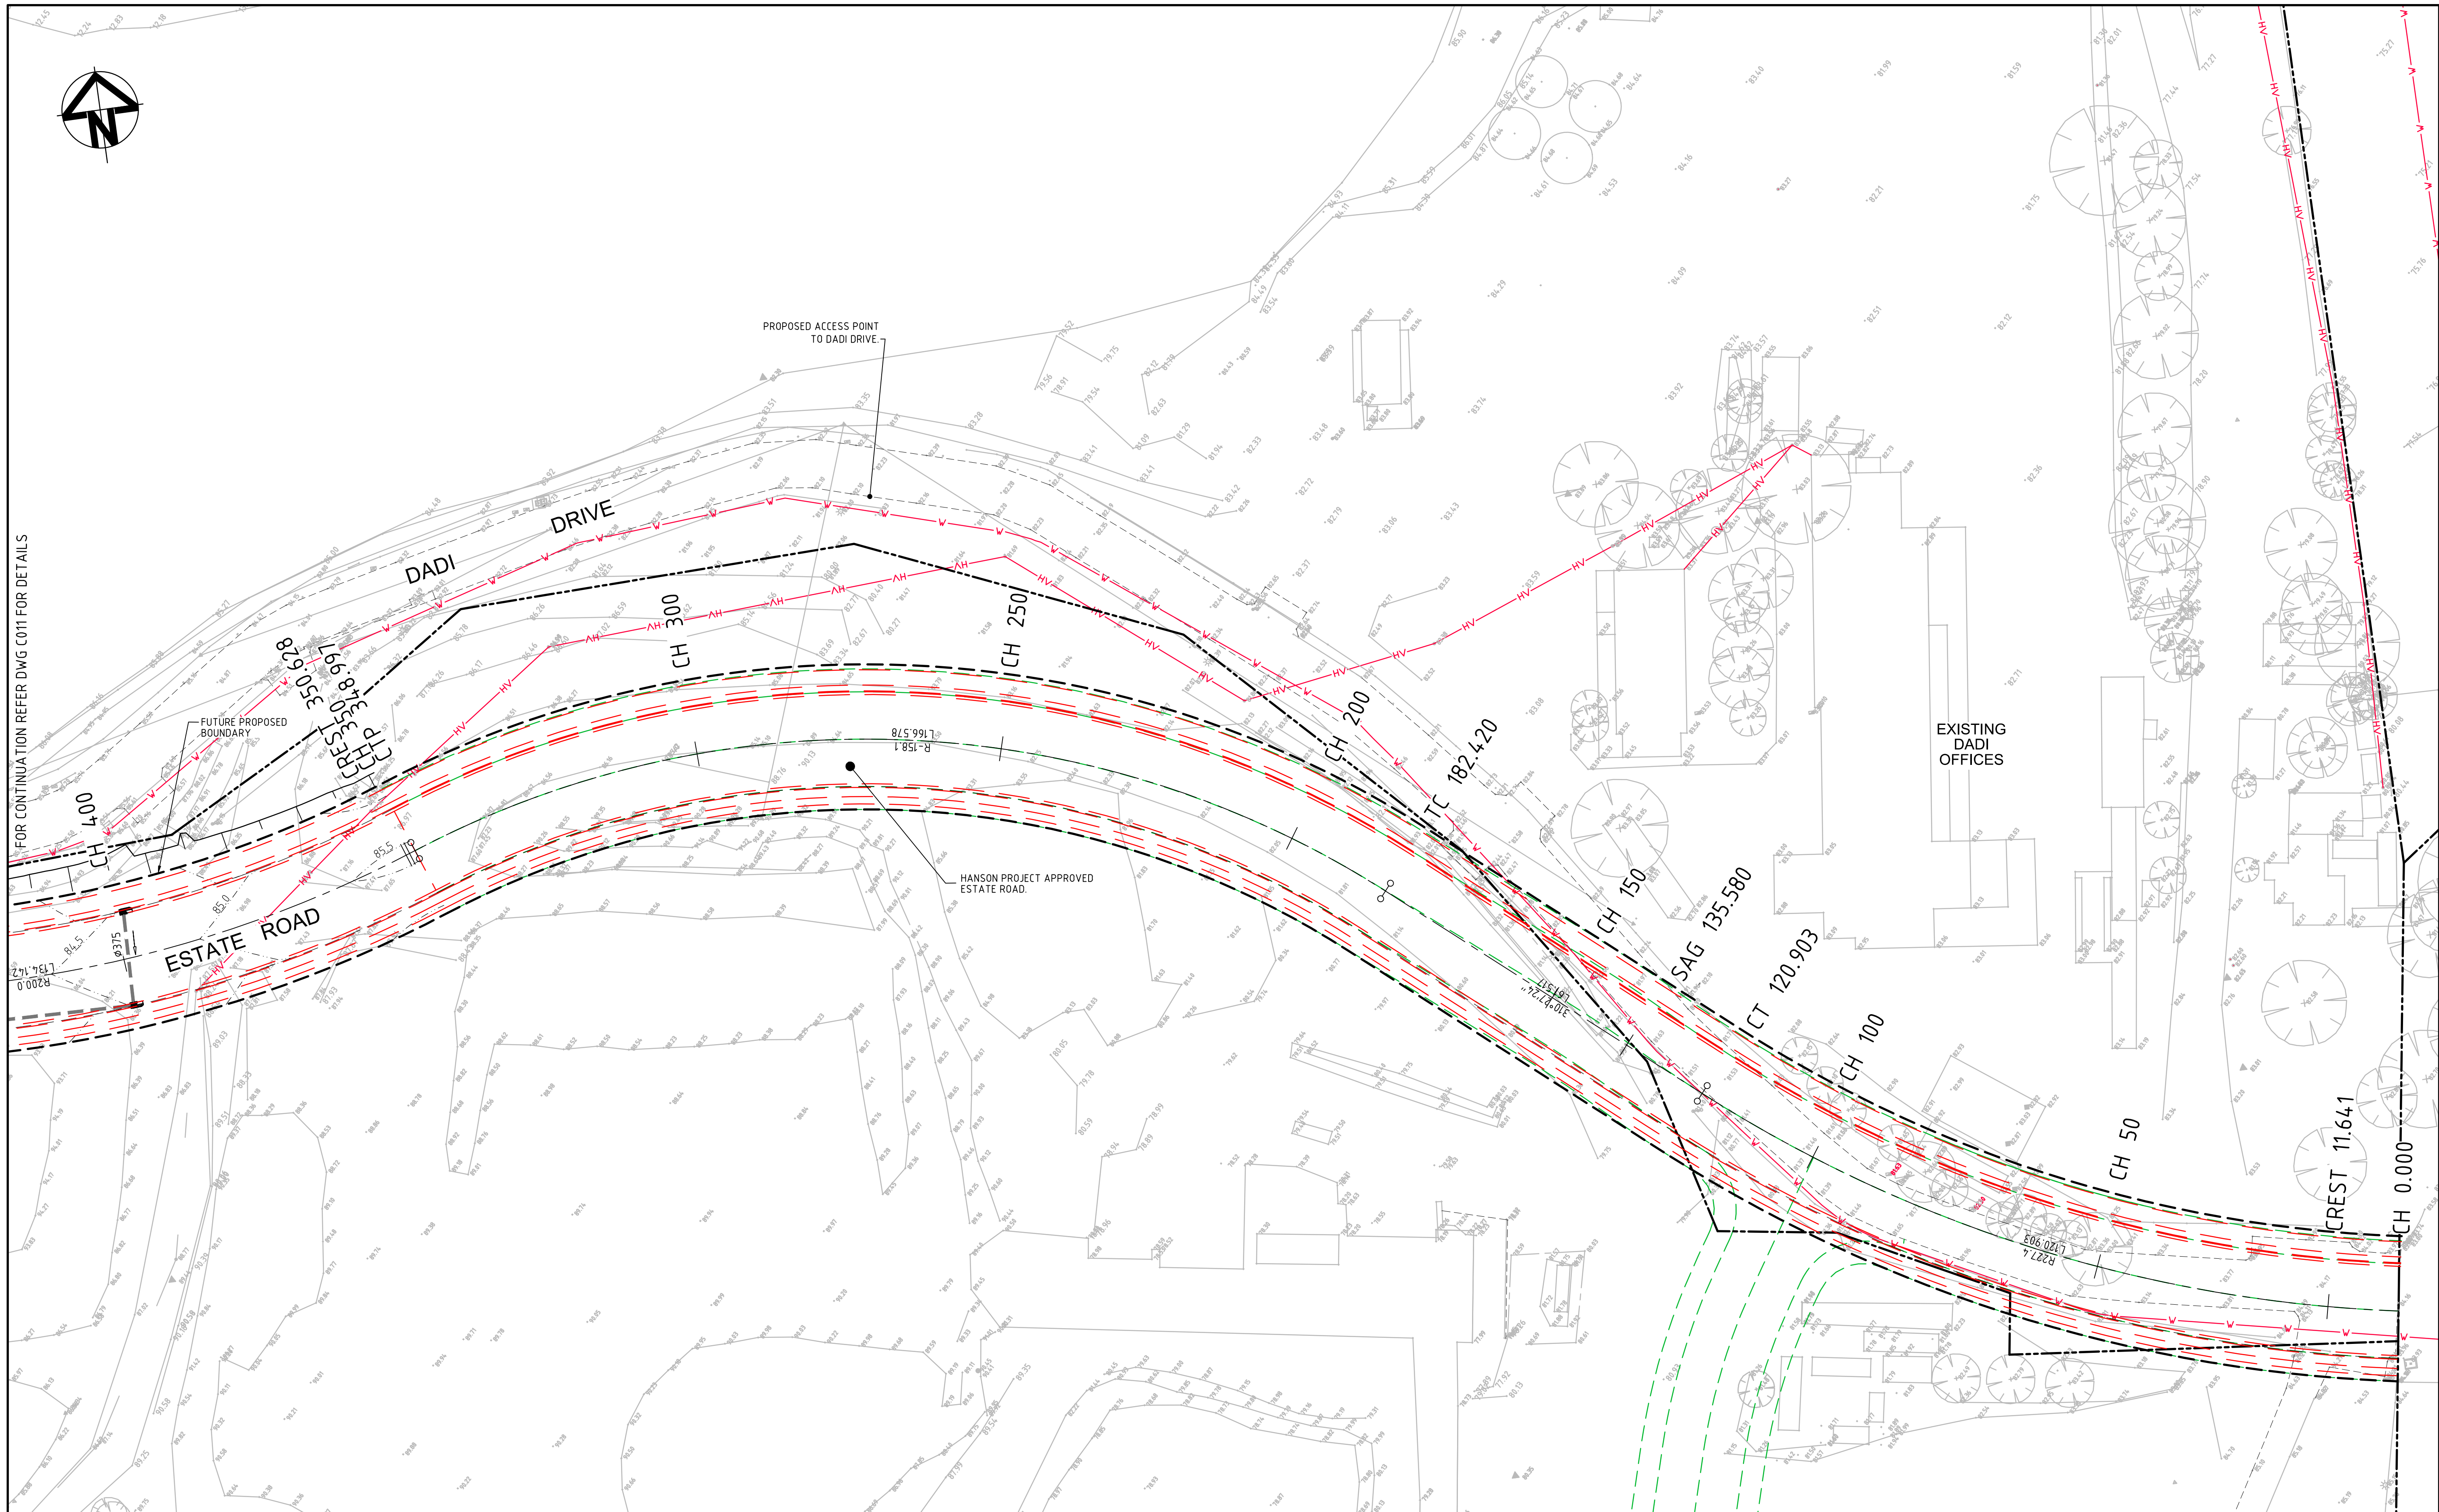

D	RE-ISSUED FOR SSDA	14-09-17
C	RE-ISSUED FOR SSDA	20-02-15
B	ISSUED FOR SSDA	18-06-14
A	ISSUED FOR CLIENT REVIEW	14-05-14
Issue	Description	Date

Bar Scales
0 10 20 30 40 50m
1 : 500 @ A1 1 : 1000 @ A3

THIS DRAWING CANNOT BE COPIED OR REPRODUCED IN ANY FORM OR USED FOR ANY OTHER PURPOSE OTHER THAN THAT ORIGINALLY INTENDED WITHOUT THE WRITTEN PERMISSION OF AT&L

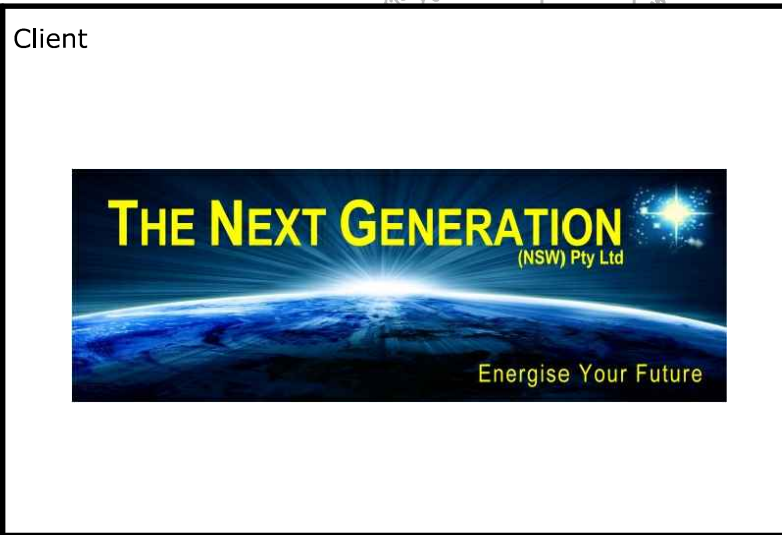


Scales	1 : 500 @ A1	Drawn	TS
		Designed	TS
Grid	MGA	Checked	MM
Height Datum	AHD	Approved	

Project	ENERGY FROM WASTE ELECTRICITY GENERATION PLANT, EASTERN CREEK
Title	SITWORKS AND STORMWATER DRAINAGE PLAN SHEET 3 OF 7

Civil Engineers and Project Managers		
at&l		
Level 7, 153 Walker Street North Sydney NSW 2060 ABN 96 130 882 405 Tel: 02 9439 1777 Fax: 02 9923 1055 www.atl.net.au info@atl.net.au		
Status	FOR APPROVAL	A1
NOT TO BE USED FOR CONSTRUCTION		
Drawing No.	Project No.	Issue
C012	14-187	D



E	RE-ISSUED FOR SSDA	14-09-17
D	RE-ISSUED FOR SSDA	13-07-17
C	RE-ISSUED FOR SSDA	20-02-15
B	ISSUED FOR SSDA	18-06-14
A	ISSUED FOR CLIENT REVIEW	14-05-14
Issue	Description	Date

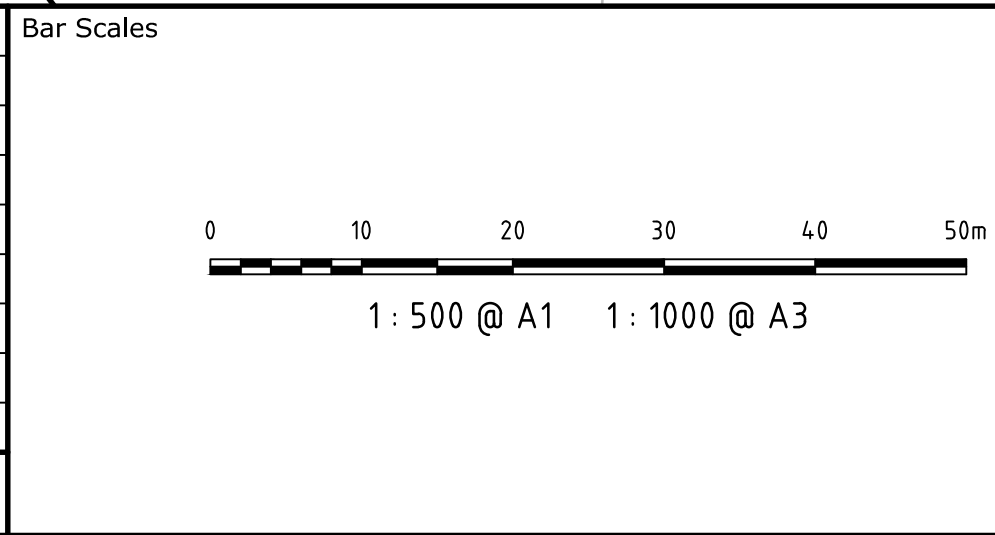

THIS DRAWING CANNOT BE COPIED OR REPRODUCED IN ANY FORM OR USED FOR ANY OTHER PURPOSE OTHER THAN THAT ORIGINALLY INTENDED WITHOUT THE WRITTEN PERMISSION OF AT&L



Scales	1 : 500 @ A1	Drawn	TS
Grid	MGA	Designed	TS
Height Datum	AHD	Checked	MM
		Approved	

Project	ENERGY FROM WASTE ELECTRICITY GENERATION PLANT, EASTERN CREEK
Title	SITWORKS AND STORMWATER DRAINAGE PLAN SHEET 4 OF 7

Civil Engineers and Project Managers		
at&l		
Level 7, 153 Walker Street North Sydney NSW 2060 ABN 96 130 882 405 Tel: 02 9439 1777 Fax: 02 9923 1055 www.atl.net.au info@atl.net.au		
Status	FOR APPROVAL	A1
Drawing No.	C013	Issue
Project No.	14-187	E