

Updated DA drawing overlay behind original DA for comparison of changes

5/16/2016 11:40:01 AM FOR INFORMATION REV DESCRIPTION OF CHANGE MS 13.09.2016 CHD DATE		CONSULTANT Access Consultant Cheung Access Code Compliance B M + G Pty Ltd Comm/Security Engineer JHA Consulting Engineers Electrical Engineer JHA Consulting Engineers		ESD Consultant JHA Consulting Engineers Facade Engineer Surface Design Consult. Pty Ltd Fire Engineer JHA Consulting Engineers Landscape Architects OCULUS Pty Ltd		Mechanical Engineer JHA Consulting Engineers Plumbing Engineer JHA Consulting Engineers Structural Engineer Northrop Engineers Pty Ltd		CLIENT <b>RICHARD CROOKES CONSTRUCTIONS</b> <b>THE UNIVERSITY OF SYDNEY</b>		ARCHITECTS <b>RICE DAUBNEY</b> Level 1, 110 Walker Street, North Sydney NSW 2060, Australia +61 2 9956 2666   hrd@ricedaubney.com   hdrinc.com		PROJECT <b>LEES 1 BUILDING (F07)</b> <b>THE UNIVERSITY OF SYDNEY</b> <b>CITY ROAD, CAMPERDOWN</b> PROJECT NUMBER 271821.15H		DRAWING TITLE <b>SECTION 1</b>		SCALE 1 : 100 @ A1 CONTRACT NUMBER <b>TBC</b>		CHECKED MS DRAWING NUMBER <b>HDR-AR-DWG-DA10</b>		DATE 13.09.2016 ISSUE <b>G</b>	
--	--	---	--	---	--	---	--	---	--	---	--	--	--	-----------------------------------	--	--	--	---	--	---	--


Minor dimensional refinements

Internal planning refinements

EXISTING CARSLAW BUILDING


PAINTED & RENDERED WALL TO REPLACE SUBSTATION WALL

BARFF ROAD

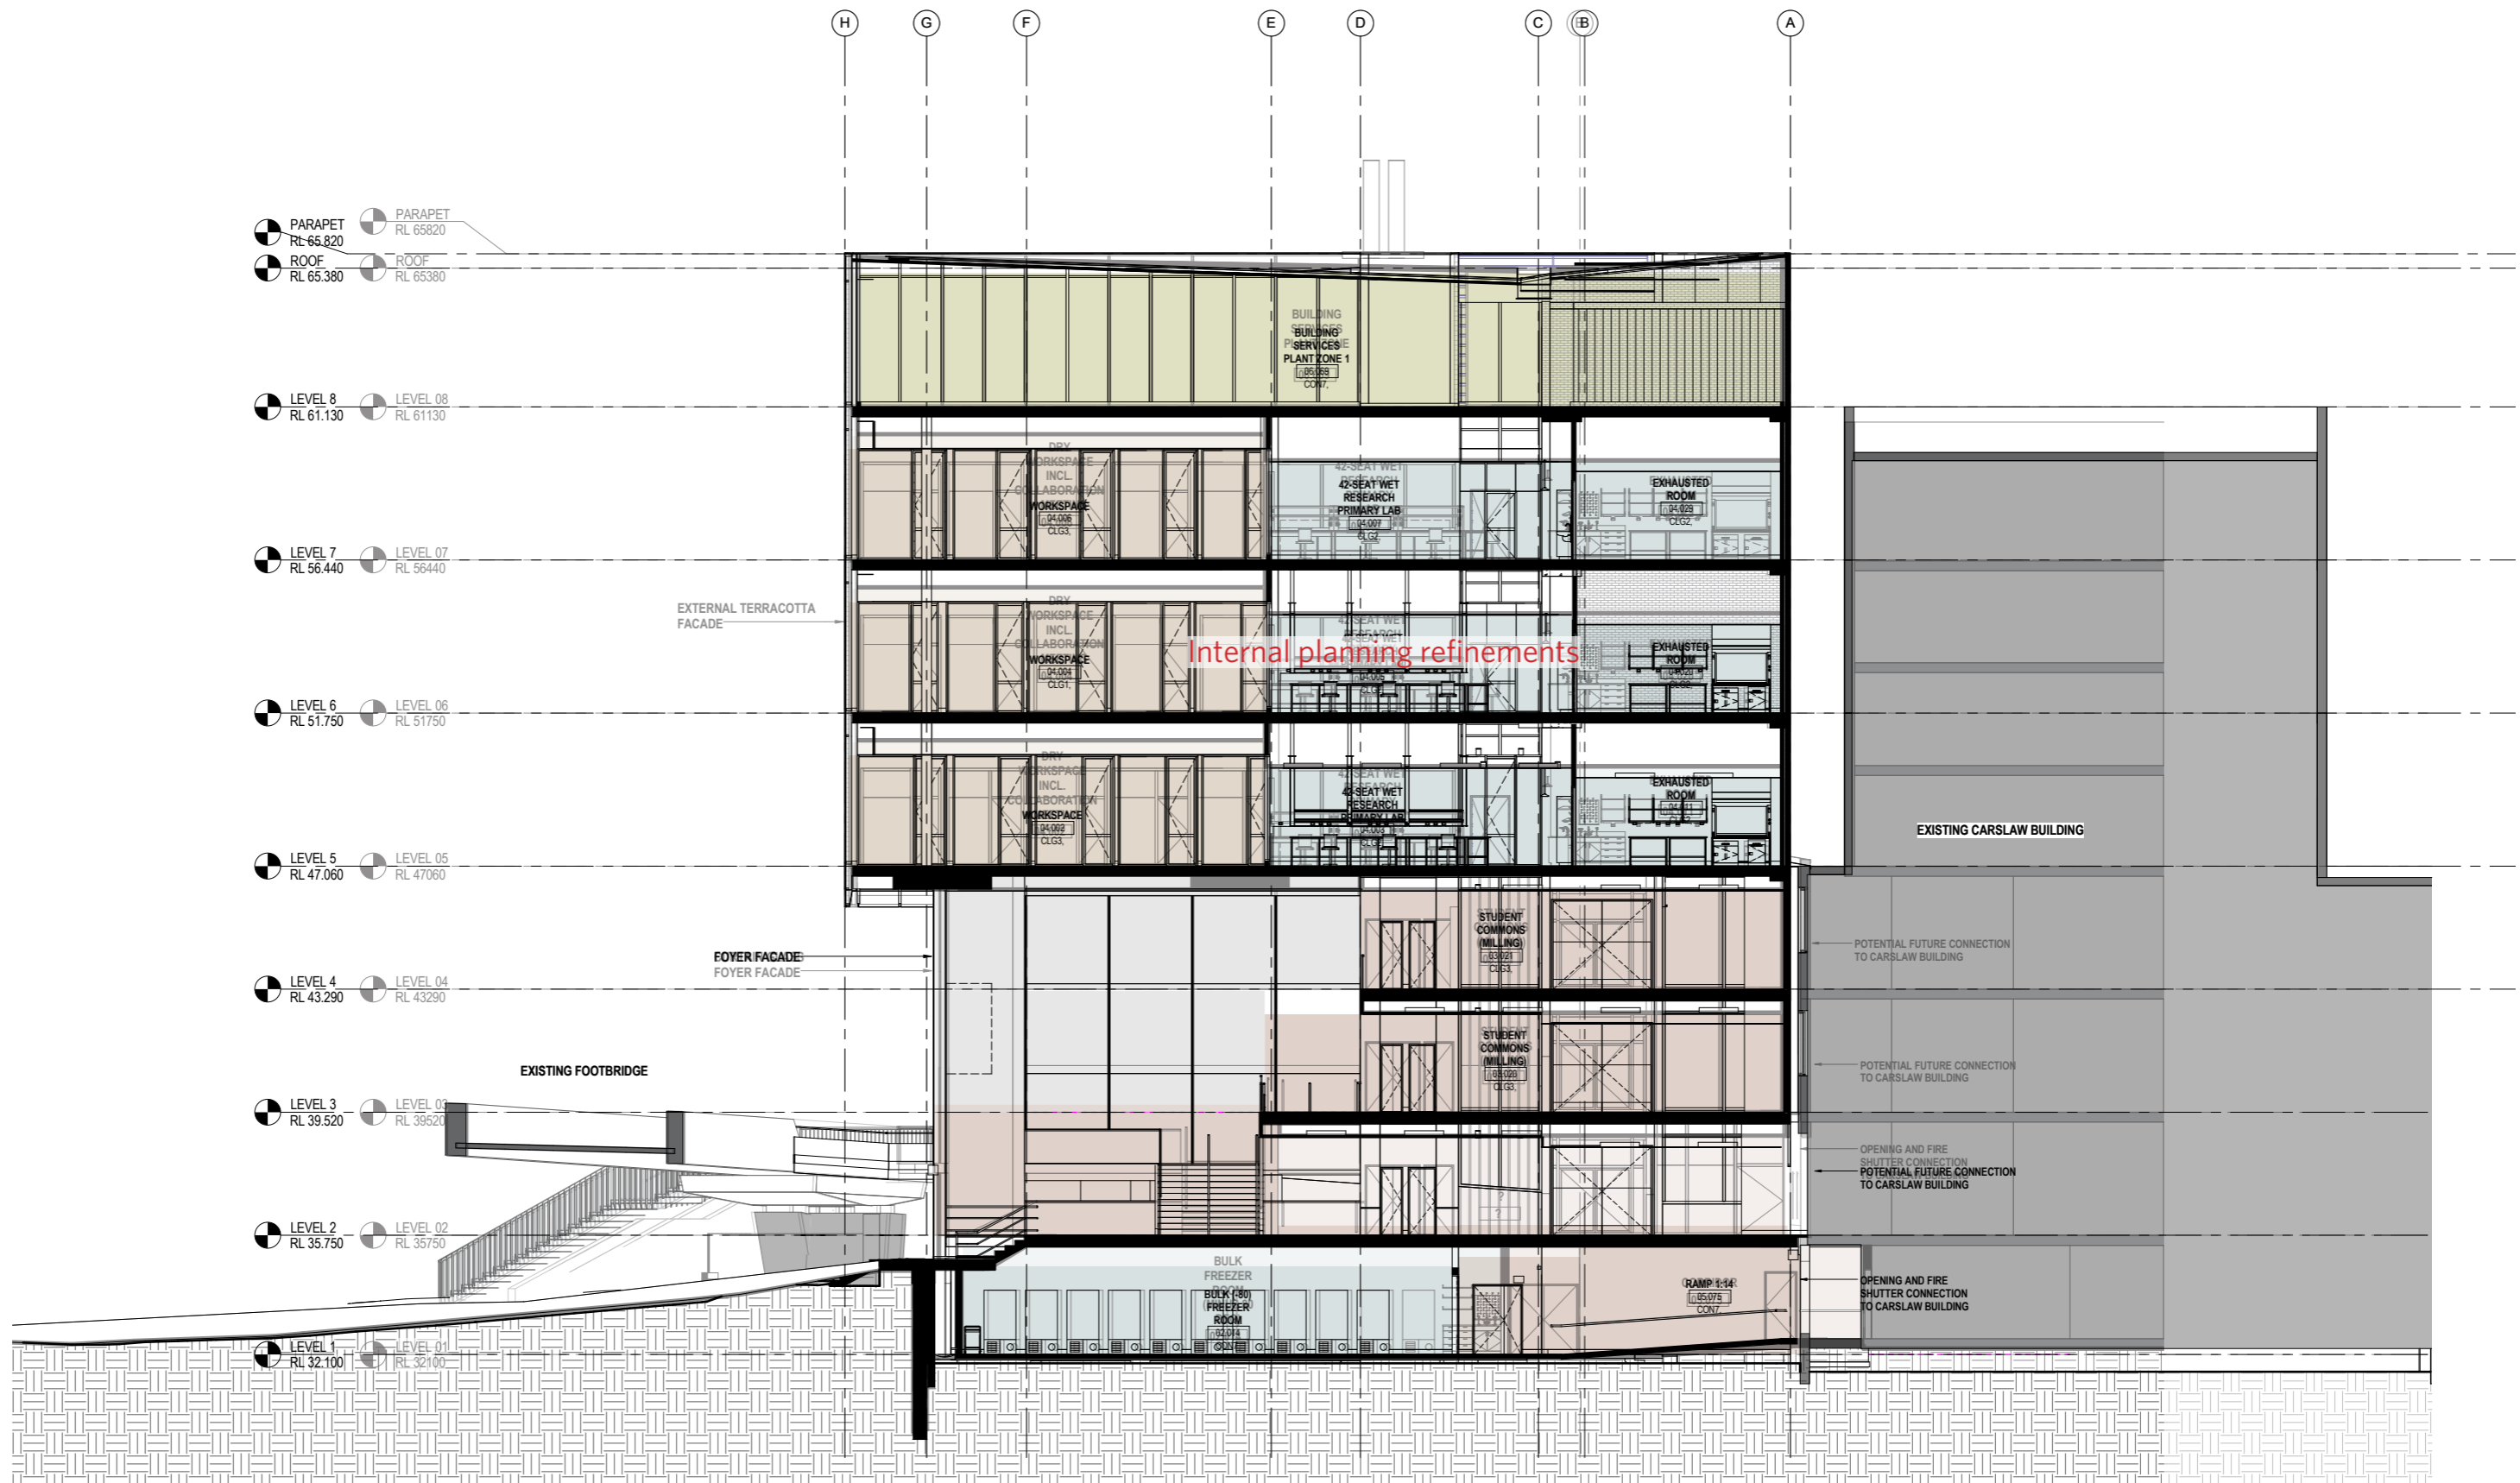


Updated DA drawing overlay behind original DA for comparison of changes

9/16/2016 11:40:06 AM FOR INFORMATION MS 13.09.2016 DATE 13.09.2016 0 1m 10m A1		CONSULTANT Access Consultant Cheung Access Code Compliance B M + G Pty Ltd Comms/Security Engineer JHA Consulting Engineers Electrical Engineer JHA Consulting Engineers	ESD Consultant JHA Consulting Engineers Facade Engineer Surface Design Consult. Pty Ltd Fire Engineer Defire Pty Limited Landscape Architects OCULUS Pty Ltd	Mechanical Engineer JHA Consulting Engineers Plumbing Engineer JHA Consulting Engineers Structural Engineer Northrop Engineers Pty Ltd	CLIENT RICHARD CROOKES CONSTRUCTIONS  THE UNIVERSITY OF SYDNEY	ARCHITECTS  RICE DAUBNEY Level 1, 110 Walker Street, North Sydney NSW 2060, Australia +61 2 9956 2666   hdr@ricedaubney.com   hdrinc.com	PROJECT LEES1 BUILDING (F07) THE UNIVERSITY OF SYDNEY CITY ROAD, CAMPERDOWN PROJECT NUMBER 271821_15H	DRAWING TITLE SECTION 2	SCALE 1:100 @ A1 CONTRACT NUMBER TBC	CHECKED MS DRAWING NUMBER HDR-AR-DWG-DA11	DATE 13.09.2016 ISSUE G
--	--	--	---	---	--	--	--	----------------------------	---	--	----------------------------------

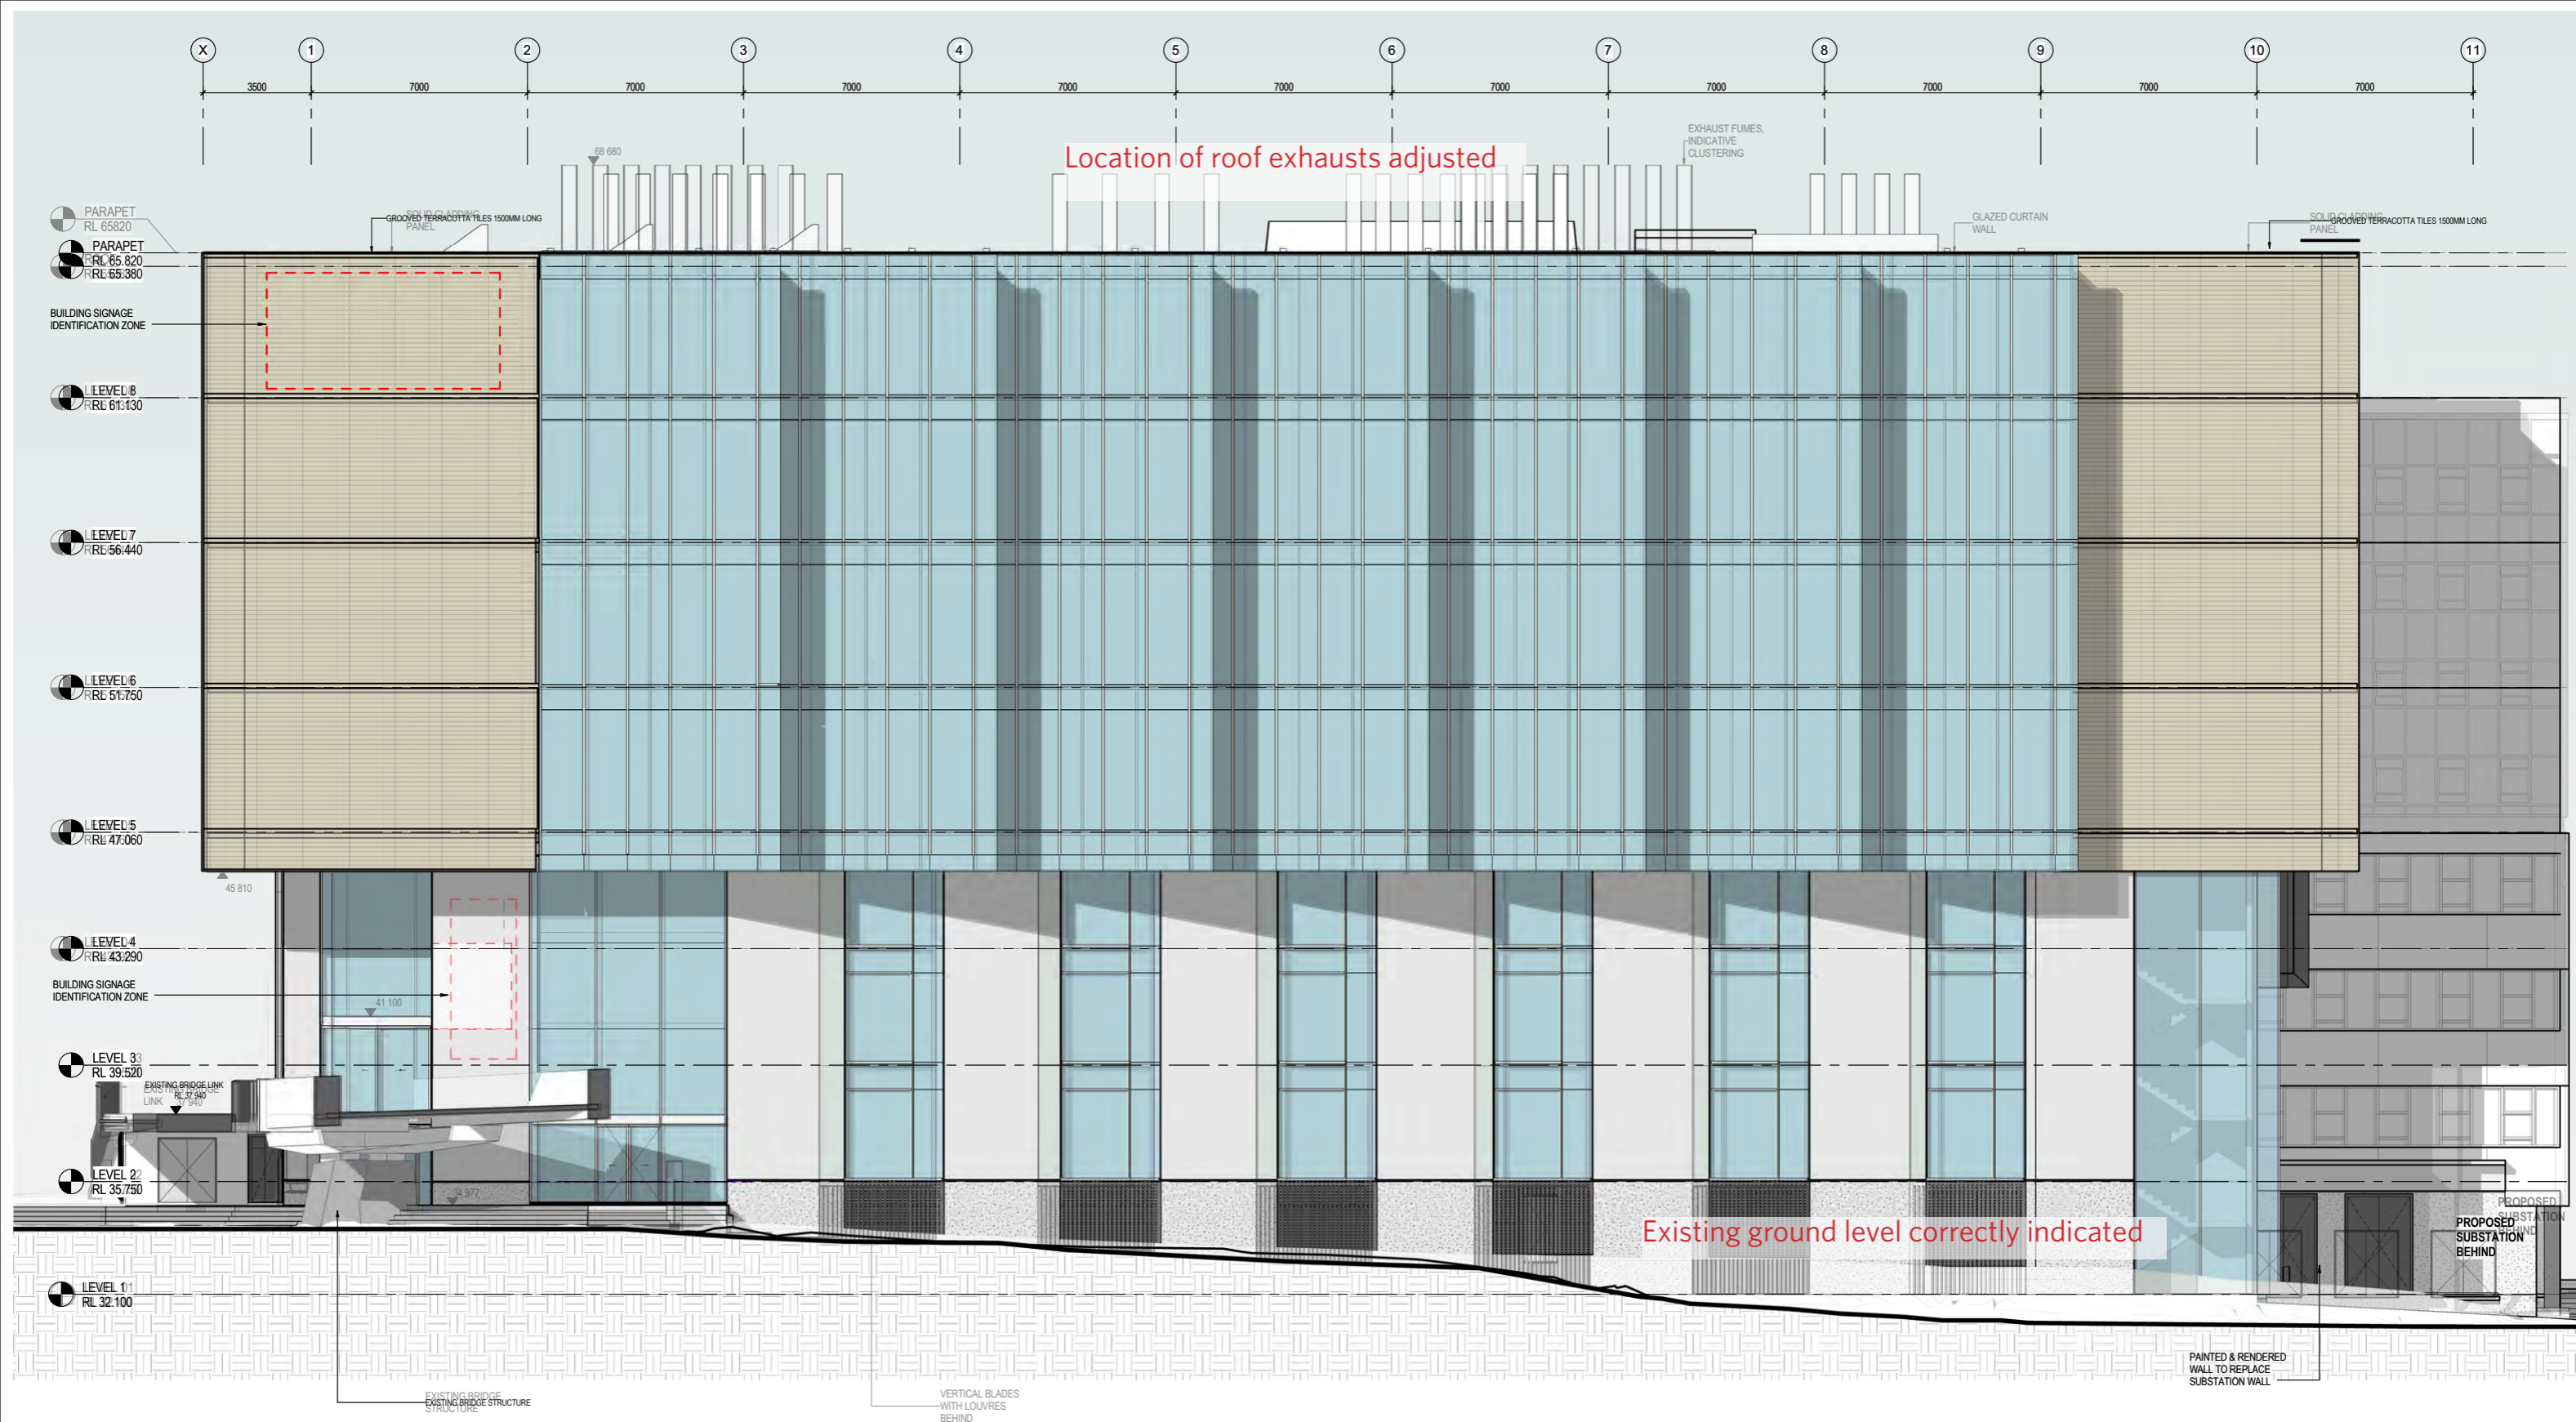


Updated DA drawing overlay behind original DA for comparison of changes

9/10/2016 11:41:54 AM G FOR INFORMATION REV DESCRIPTION OF CHANGE MS 13.09.2016 CHD DATE	0 1m 10m A1	CONSULTANT Access Consultant Cheung Access Code Compliance B M + G Pty Ltd Comms/Security Engineer JHA Consulting Engineers Electrical Engineer JHA Consulting Engineers	ESD Consultant JHA Consulting Engineers Facade Engineer Surface Design Consult. Pty Ltd Fire Engineer Defire Pty Limited Landscape Architects OCULUS Pty Ltd	Mechanical Engineer JHA Consulting Engineers Plumbing Engineer JHA Consulting Engineers Structural Engineer Northrop Engineers Pty Ltd	CLIENT RICHARD CROOKES CONSTRUCTIONS THE UNIVERSITY OF SYDNEY	ARCHITECTS HDR RICE DAUBNEY Level 1, 110 Walker Street, North Sydney NSW 2060, Australia +61 2 9956 2666   hdr@ricedaubney.com   hdrinc.com	PROJECT LEES1 BUILDING (F07) THE UNIVERSITY OF SYDNEY CITY ROAD, CAMPERDOWN PROJECT NUMBER 271821.15H	DRAWING TITLE SOUTH ELEVATION	SCALE 1:100 @ A1	CHECKED MS	DATE 13.09.2016
		CONTRACT NUMBER TBC	DRAWING NUMBER HDR-AR-DWG-DA12	ISSUE G	THIS DOCUMENT IS THE COPYRIGHT OF THE RICE DAUBNEY GROUP (NSW) PVT LTD. ALL INFORMATION ILLUSTRATED ON THIS DOCUMENT IS TO BE CHECKED AND VERIFIED ON SITE. IN THE EVENT OF DISCREPANCIES REFER TO ARCHITECT PRIOR TO COMMENCEMENT OF THE WORK. DO NOT SCALE DRAWINGS MANUALLY OR ELECTRONICALLY.						

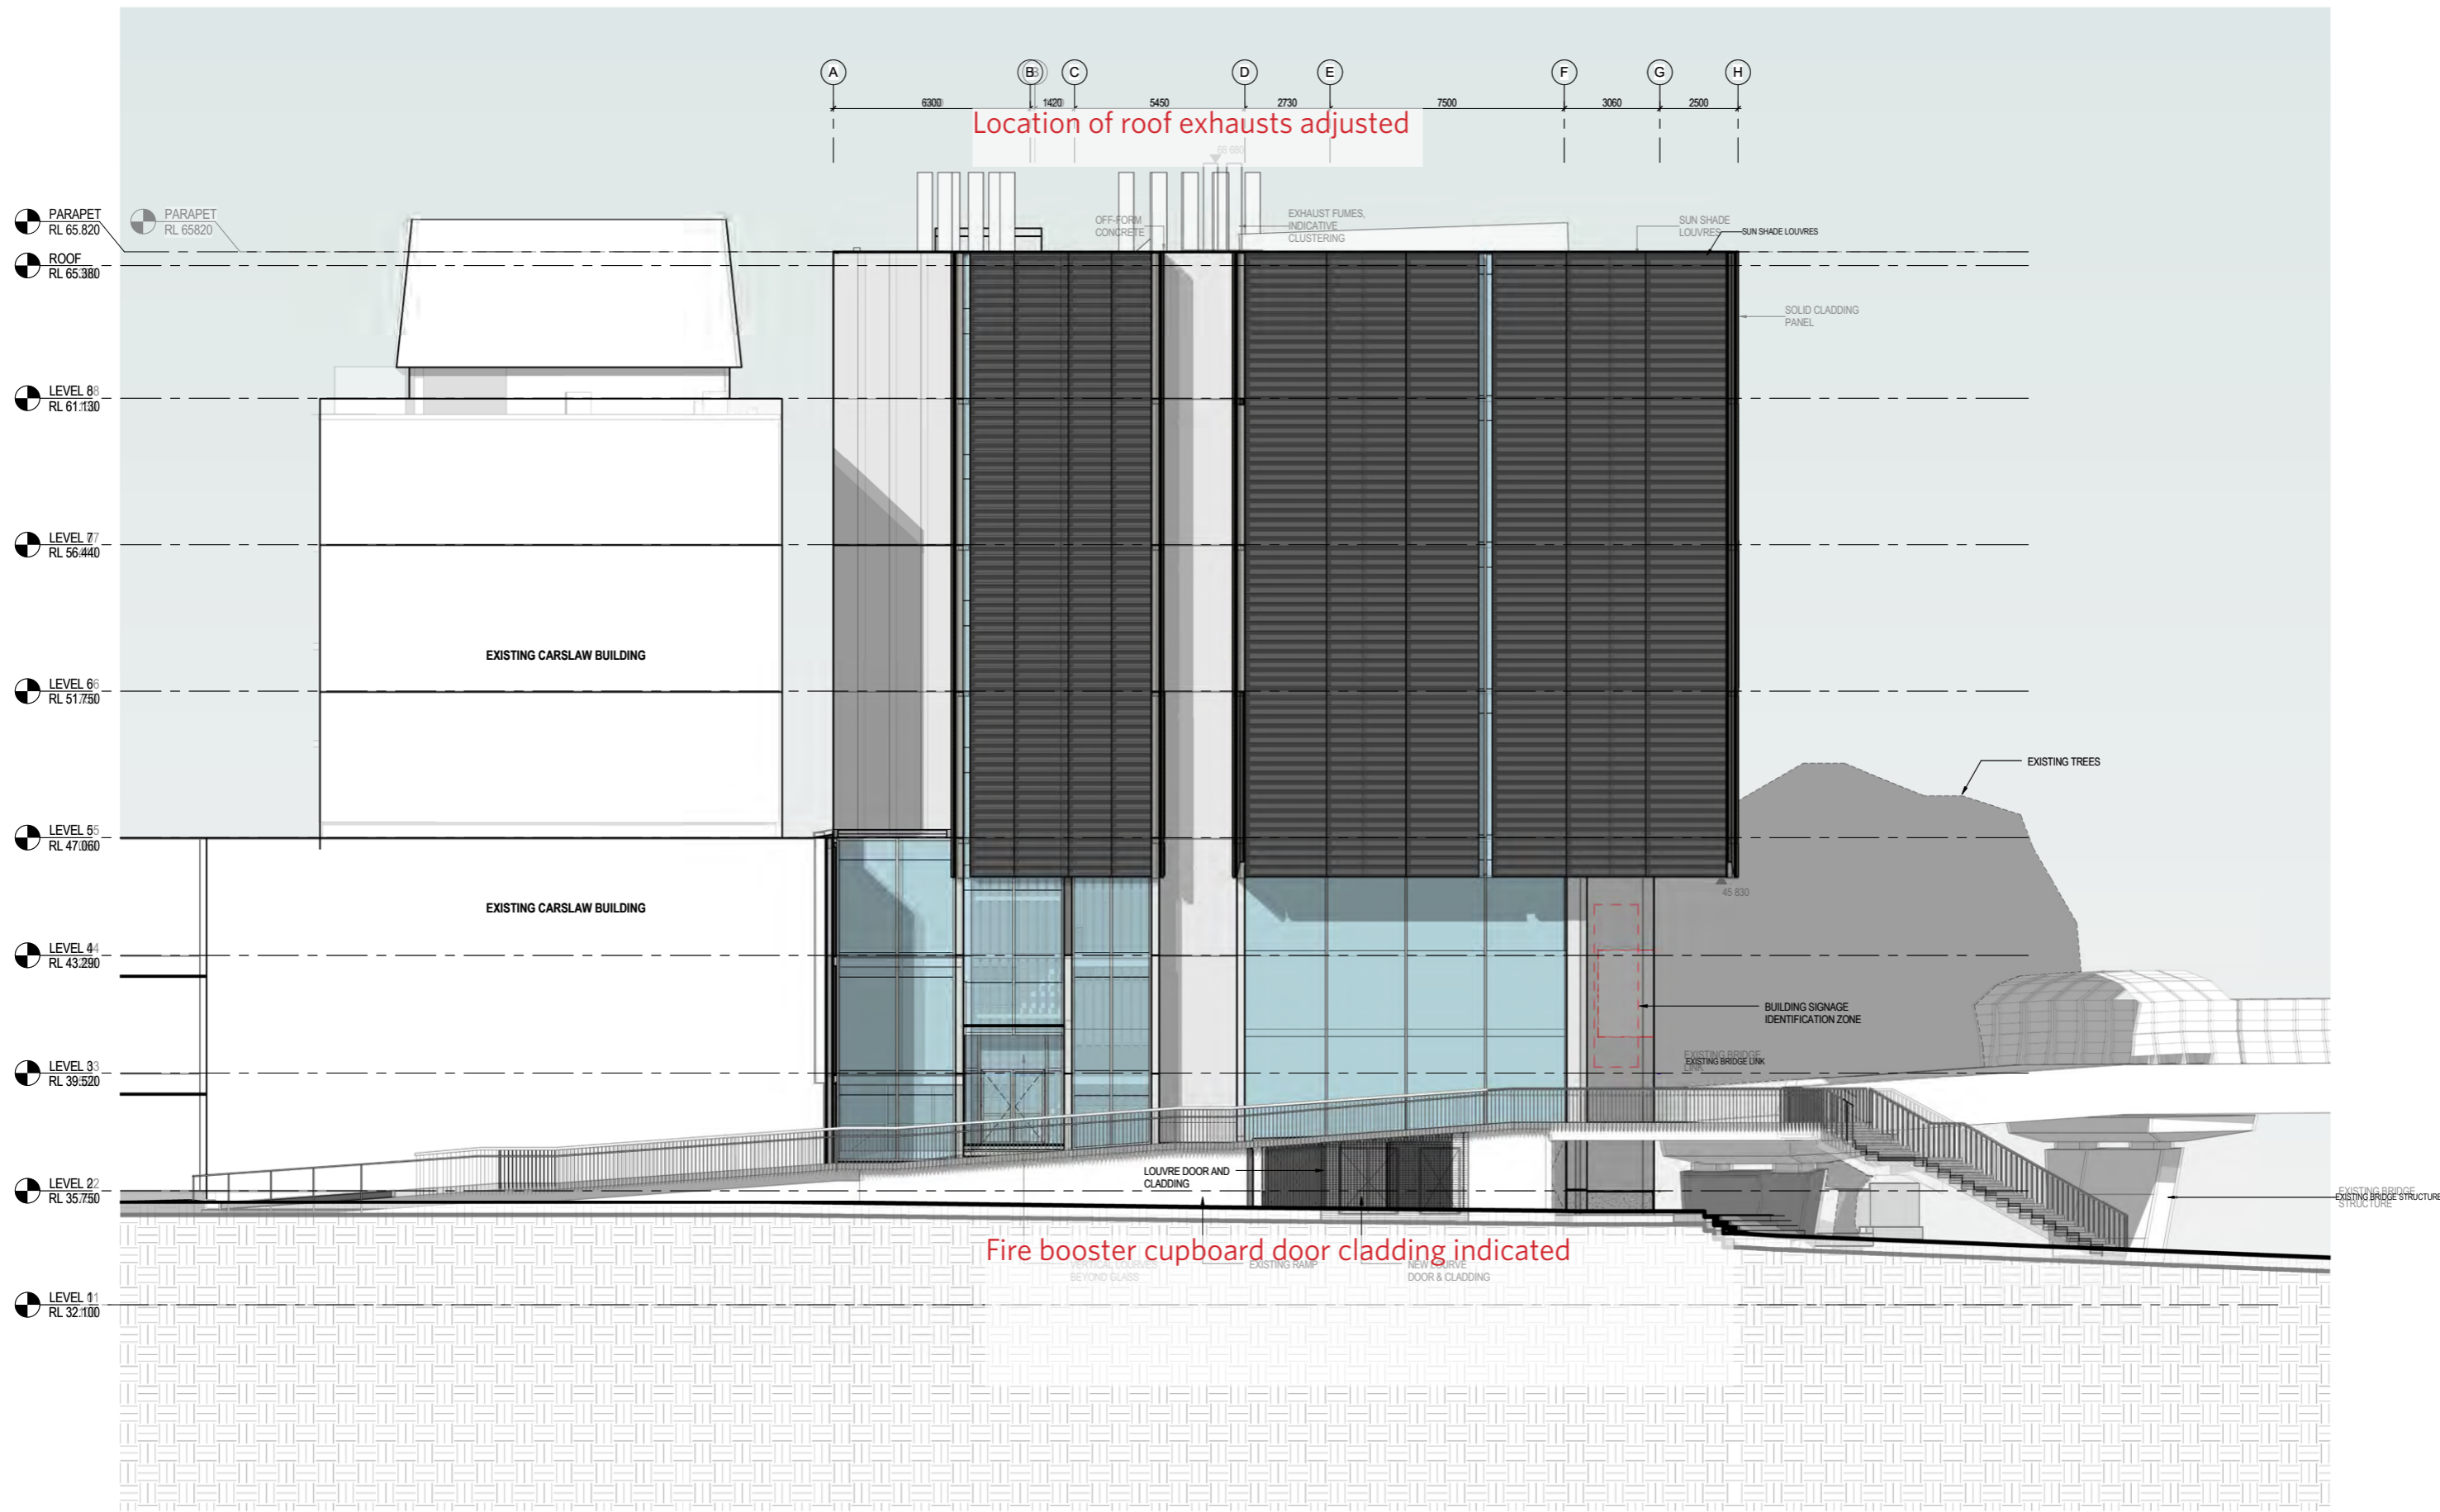


Updated DA drawing overlay behind original DA for comparison of changes

9/10/2016 11:43:40 AM FOR INFORMATION DESCRIPTION OF CHANGE MS CHD DATE 13.09.2016 0 1m 10m A1	CONSULTANT Access Consultant Cheung Access Code Compliance B M + G Pty Ltd Comms/Security Engineer JHA Consulting Engineers Electrical Engineer JHA Consulting Engineers	ESD Consultant JHA Consulting Engineers Facade Engineer Surface Design Consult. Pty Ltd Fire Engineer Defire Pty Limited Landscape Architects OCULUS Pty Ltd	Mechanical Engineer JHA Consulting Engineers Plumbing Engineer JHA Consulting Engineers Structural Engineer Northrop Engineers Pty Ltd	CLIENT RICHARD CROOKES CONSTRUCTIONS THE UNIVERSITY OF SYDNEY	ARCHITECTS HDR RICE DAUBNEY Level 1, 110 Walker Street, North Sydney NSW 2060, Australia +61 2 9956 2666   hdr@riceanddaubney.com   hdrinc.com	PROJECT LEES1 BUILDING (F07) THE UNIVERSITY OF SYDNEY CITY ROAD, CAMPERDOWN PROJECT NUMBER 271821.15H	DRAWING TITLE WEST ELEVATION	SCALE 1:100 @ A1 CONTRACT NUMBER TBC	CHECKED MS DRAWING NUMBER HDR-AR-DWG-DA13	DATE 13.09.2016 ISSUE G
	THIS DOCUMENT IS THE COPYRIGHT OF THE RICE DAUBNEY GROUP (NSW) PTY LTD. ALL INFORMATION ILLUSTRATED ON THIS DOCUMENT IS TO BE CHECKED AND VERIFIED ON SITE. IN THE EVENT OF DISCREPANCIES REFER TO ARCHITECT PRIOR TO COMMENCEMENT OF THE WORK. DO NOT SCALE DRAWINGS MANUALLY OR ELECTRONICALLY.									

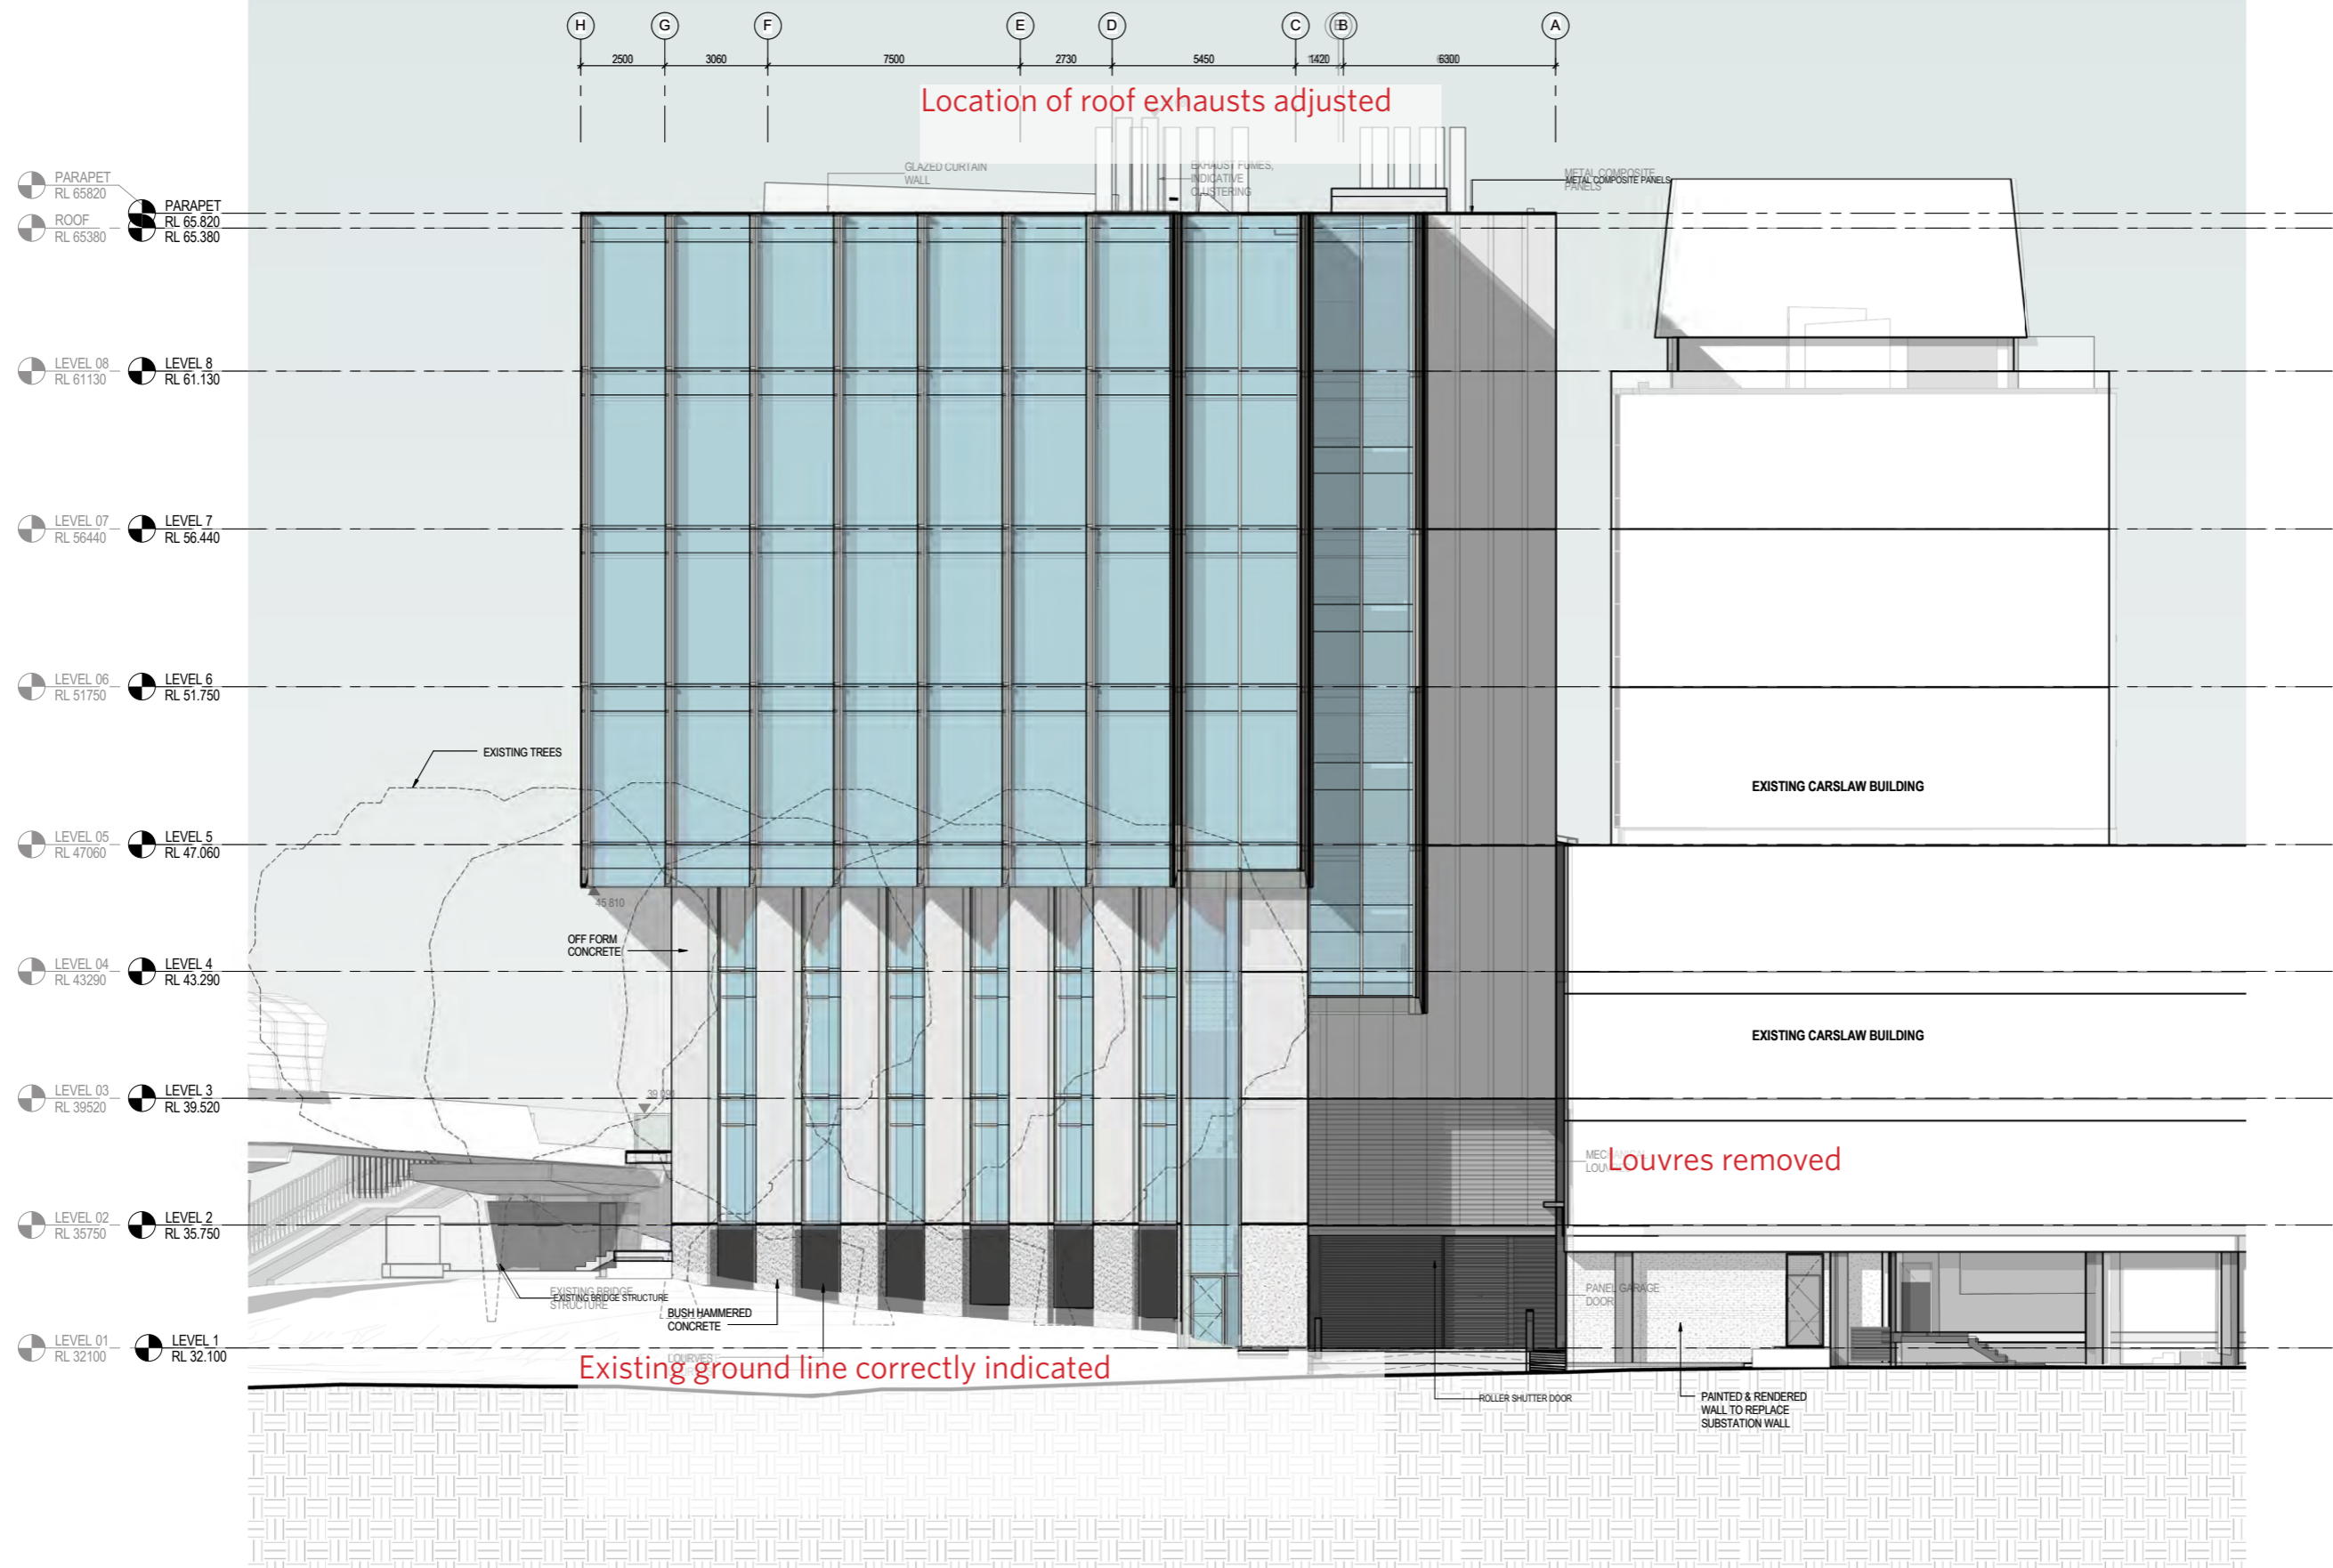

Updated DA drawing overlay behind original DA for comparison of changes

9/10/2016 11:45:18 AM FOR INFORMATION DESCRIPTION OF CHANGE		MS 13.09.2016 DATE	0 1m 10m A1	<b>CONSULTANT</b> Access Consultant Cheung Access Code Compliance B M + G Pty Ltd Comms/Security Engineer JHA Consulting Engineers Electrical Engineer JHA Consulting Engineers	ESD Consultant JHA Consulting Engineers Facade Engineer Surface Design Consult. Pty Ltd Fire Engineer JHA Consulting Engineers Landscape Architects OCULUS Pty Ltd	Mechanical Engineer JHA Consulting Engineers Plumbing Engineer JHA Consulting Engineers Structural Engineer Northrop Engineers Pty Ltd	<b>CLIENT</b> RICHARD CROOKES CONSTRUCTIONS THE UNIVERSITY OF SYDNEY	<b>ARCHITECTS</b> HDR RICE DAUBNEY Level 1, 110 Walker Street, North Sydney NSW 2060, Australia +61 2 9956 2666   hdr@riceanddaubney.com   hdrinc.com	<b>PROJECT</b> LEES1 BUILDING (F07) THE UNIVERSITY OF SYDNEY CITY ROAD, CAMPERDOWN PROJECT NUMBER 271821_15H	<b>DRAWING TITLE</b> EAST ELEVATION	SCALE 1:100 @ A1 CHECKED MS DATE 13.09.2016 CONTRACT NUMBER TBC DRAWING NUMBER HDR-AR-DWG-DA14 ISSUE G
---	--	--------------------------	-------------	---	---	---	--	--	---	--	---

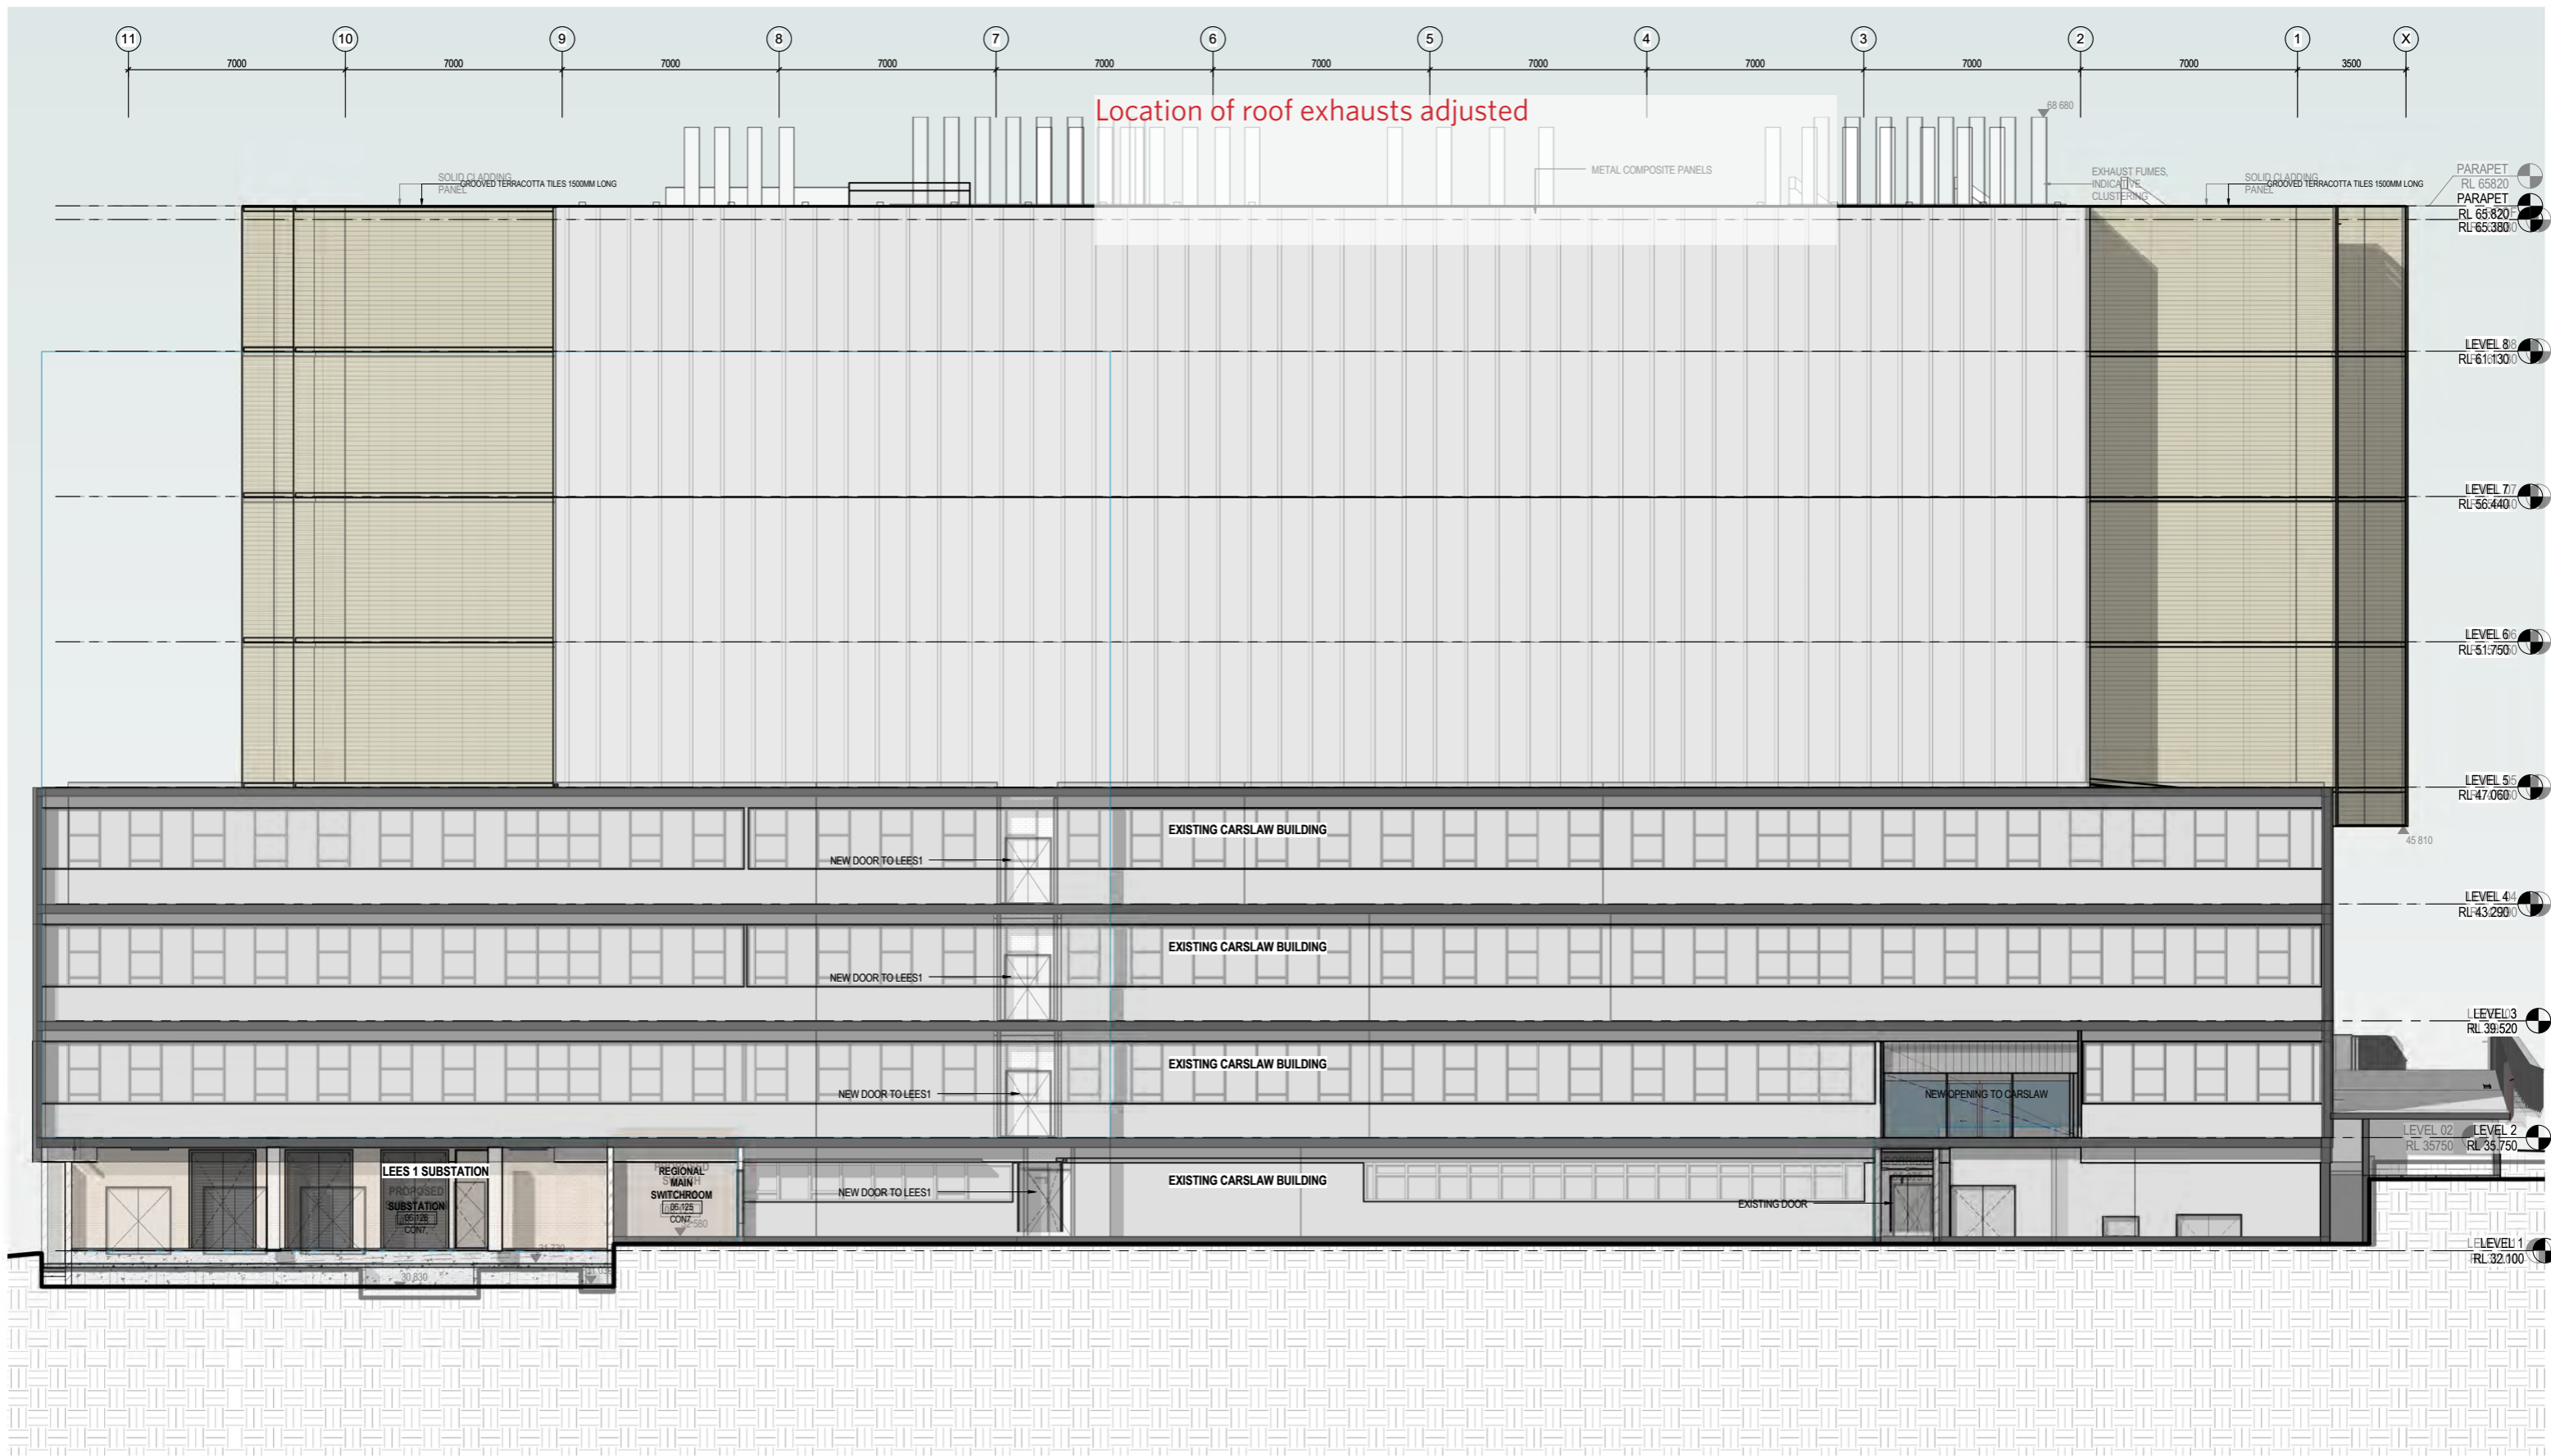

Updated DA drawing overlay behind original DA for comparison of changes

G FOR INFORMATION REV DESCRIPTION OF CHANGE MS 13.09.2016 CHD DATE	0 1m 10m A1	CONSULTANT Access Consultant Cheung Access Code Compliance B M + G Pty Ltd Comms/Security Engineer JHA Consulting Engineers Electrical Engineer JHA Consulting Engineers	ESD Consultant JHA Consulting Engineers Facade Engineer Surface Design Consult. Pty Ltd Fire Engineer Defire Pty Limited Landscape Architects OCULUS Pty Ltd	Mechanical Engineer JHA Consulting Engineers Plumbing Engineer JHA Consulting Engineers Structural Engineer Northrop Engineers Pty Ltd	CLIENT <b>RICHARD CROOKES CONSTRUCTIONS</b> THE UNIVERSITY OF SYDNEY Level 1, 110 Walker Street, North Sydney NSW 2060, Australia +61 2 9956 2666   hdr@riceanddaubney.com   hdrinc.com	ARCHITECTS <b>RICE DAUBNEY</b> Level 1, 110 Walker Street, North Sydney NSW 2060, Australia +61 2 9956 2666   hdr@riceanddaubney.com   hdrinc.com	PROJECT <b>LEES1 BUILDING (F07)</b> THE UNIVERSITY OF SYDNEY CITY ROAD, CAMPERDOWN PROJECT NUMBER 271821_15H	DRAWING TITLE <b>NORTH ELEVATION</b>	SCALE 1:100 @ A1	CHECKED MS	DATE 13.09.2016	CONTRACT NUMBER <b>TBC</b>	DRAWING NUMBER <b>HDR-AR-DWG-DA15</b>	ISSUE <b>G</b>	<small>THIS DOCUMENT IS THE COPYRIGHT OF THE RICE DAUBNEY GROUP (NSW) PTY LTD. ALL INFORMATION ILLUSTRATED ON THIS DOCUMENT IS TO BE CHECKED AND VERIFIED ON SITE. IN THE EVENT OF DISCREPANCIES REFER TO ARCHITECT PRIOR TO COMMENCEMENT OF THE WORK. DO NOT SCALE DRAWINGS MANUALLY OR ELECTRONICALLY.</small> <small>C:\w\2016\15H LEES 1_BASE BUILDING_samh.hoony@hdrinc.com.au</small>
		CONSULTANT Access Consultant Cheung Access Code Compliance B M + G Pty Ltd Comms/Security Engineer JHA Consulting Engineers Electrical Engineer JHA Consulting Engineers	ESD Consultant JHA Consulting Engineers Facade Engineer Surface Design Consult. Pty Ltd Fire Engineer Defire Pty Limited Landscape Architects OCULUS Pty Ltd	Mechanical Engineer JHA Consulting Engineers Plumbing Engineer JHA Consulting Engineers Structural Engineer Northrop Engineers Pty Ltd	CLIENT <b>RICHARD CROOKES CONSTRUCTIONS</b> THE UNIVERSITY OF SYDNEY Level 1, 110 Walker Street, North Sydney NSW 2060, Australia +61 2 9956 2666   hdr@riceanddaubney.com   hdrinc.com	ARCHITECTS <b>RICE DAUBNEY</b> Level 1, 110 Walker Street, North Sydney NSW 2060, Australia +61 2 9956 2666   hdr@riceanddaubney.com   hdrinc.com	PROJECT <b>LEES1 BUILDING (F07)</b> THE UNIVERSITY OF SYDNEY CITY ROAD, CAMPERDOWN PROJECT NUMBER 271821_15H	DRAWING TITLE <b>NORTH ELEVATION</b>	SCALE 1:100 @ A1	CHECKED MS	DATE 13.09.2016	CONTRACT NUMBER <b>TBC</b>	DRAWING NUMBER <b>HDR-AR-DWG-DA15</b>	ISSUE <b>G</b>	<small>THIS DOCUMENT IS THE COPYRIGHT OF THE RICE DAUBNEY GROUP (NSW) PTY LTD. ALL INFORMATION ILLUSTRATED ON THIS DOCUMENT IS TO BE CHECKED AND VERIFIED ON SITE. IN THE EVENT OF DISCREPANCIES REFER TO ARCHITECT PRIOR TO COMMENCEMENT OF THE WORK. DO NOT SCALE DRAWINGS MANUALLY OR ELECTRONICALLY.</small> <small>C:\w\2016\15H LEES 1_BASE BUILDING_samh.hoony@hdrinc.com.au</small>




Updated DA drawing overlay behind original DA for comparison of changes

DATE: 9/10/2016 11:47:02 AM FOR INFORMATION DESCRIPTION OF CHANGE		MS 13.09.2016 CHKD DATE		CONSULTANT Access Consultant: Cheung Access Code Compliance: B M + G Pty Ltd Comm/Security Engineer: JHA Consulting Engineers Electrical Engineer: JHA Consulting Engineers ESD Consultant: JHA Consulting Engineers Facade Engineer: JHA Consulting Engineers Surface Design Consult: Ply Ltd Fire Engineer: Defire Pty Limited Landscape Architects: OCULUS Pty Ltd		MECHANICAL ENGINEER: JHA Consulting Engineers PLUMBING ENGINEER: JHA Consulting Engineers STRUCTURAL ENGINEER: Northrop Engineers Pty Ltd		CLIENT <b>RICHARD CROOKES CONSTRUCTIONS</b> <b>THE UNIVERSITY OF SYDNEY</b>		ARCHITECTS <b>RICE DAUBNEY</b> Level 1, 110 Walker Street, North Sydney NSW 2060, Australia +61 2 9956 2666   hdr@ricedaubney.com   hdrinc.com		PROJECT <b>LEES1 BUILDING (F07)</b> <b>THE UNIVERSITY OF SYDNEY</b> <b>CITY ROAD, CAMPERDOWN</b>		DRAWING TITLE <b>SITE PLAN</b>		SCALE: 1:200 @ A1 CONTRACT NUMBER: TBC CHECKED: MS DRAWING NUMBER: HDR-AR-DWG-DA16 DATE: 13.09.2016 ISSUE: G	
---	--	----------------------------	--	--	--	---	--	---	--	---	--	---	--	-----------------------------------	--	---	--

THIS DOCUMENT IS THE COPYRIGHT OF THE RICE DAUBNEY GROUP (NSW) PTY LTD. ALL INFORMATION ILLUSTRATED ON THIS DOCUMENT IS TO BE CHECKED AND VERIFIED ON SITE. IN THE EVENT OF DISCREPANCIES REFER TO ARCHITECT PRIOR TO COMMENCEMENT OF THE WORK. DO NOT SCALE DRAWINGS MANUALLY OR ELECTRONICALLY.

C:\v\2016\15H LEES 1\_BASE BUILDING\_samh.hosny@hdrinc.com.au



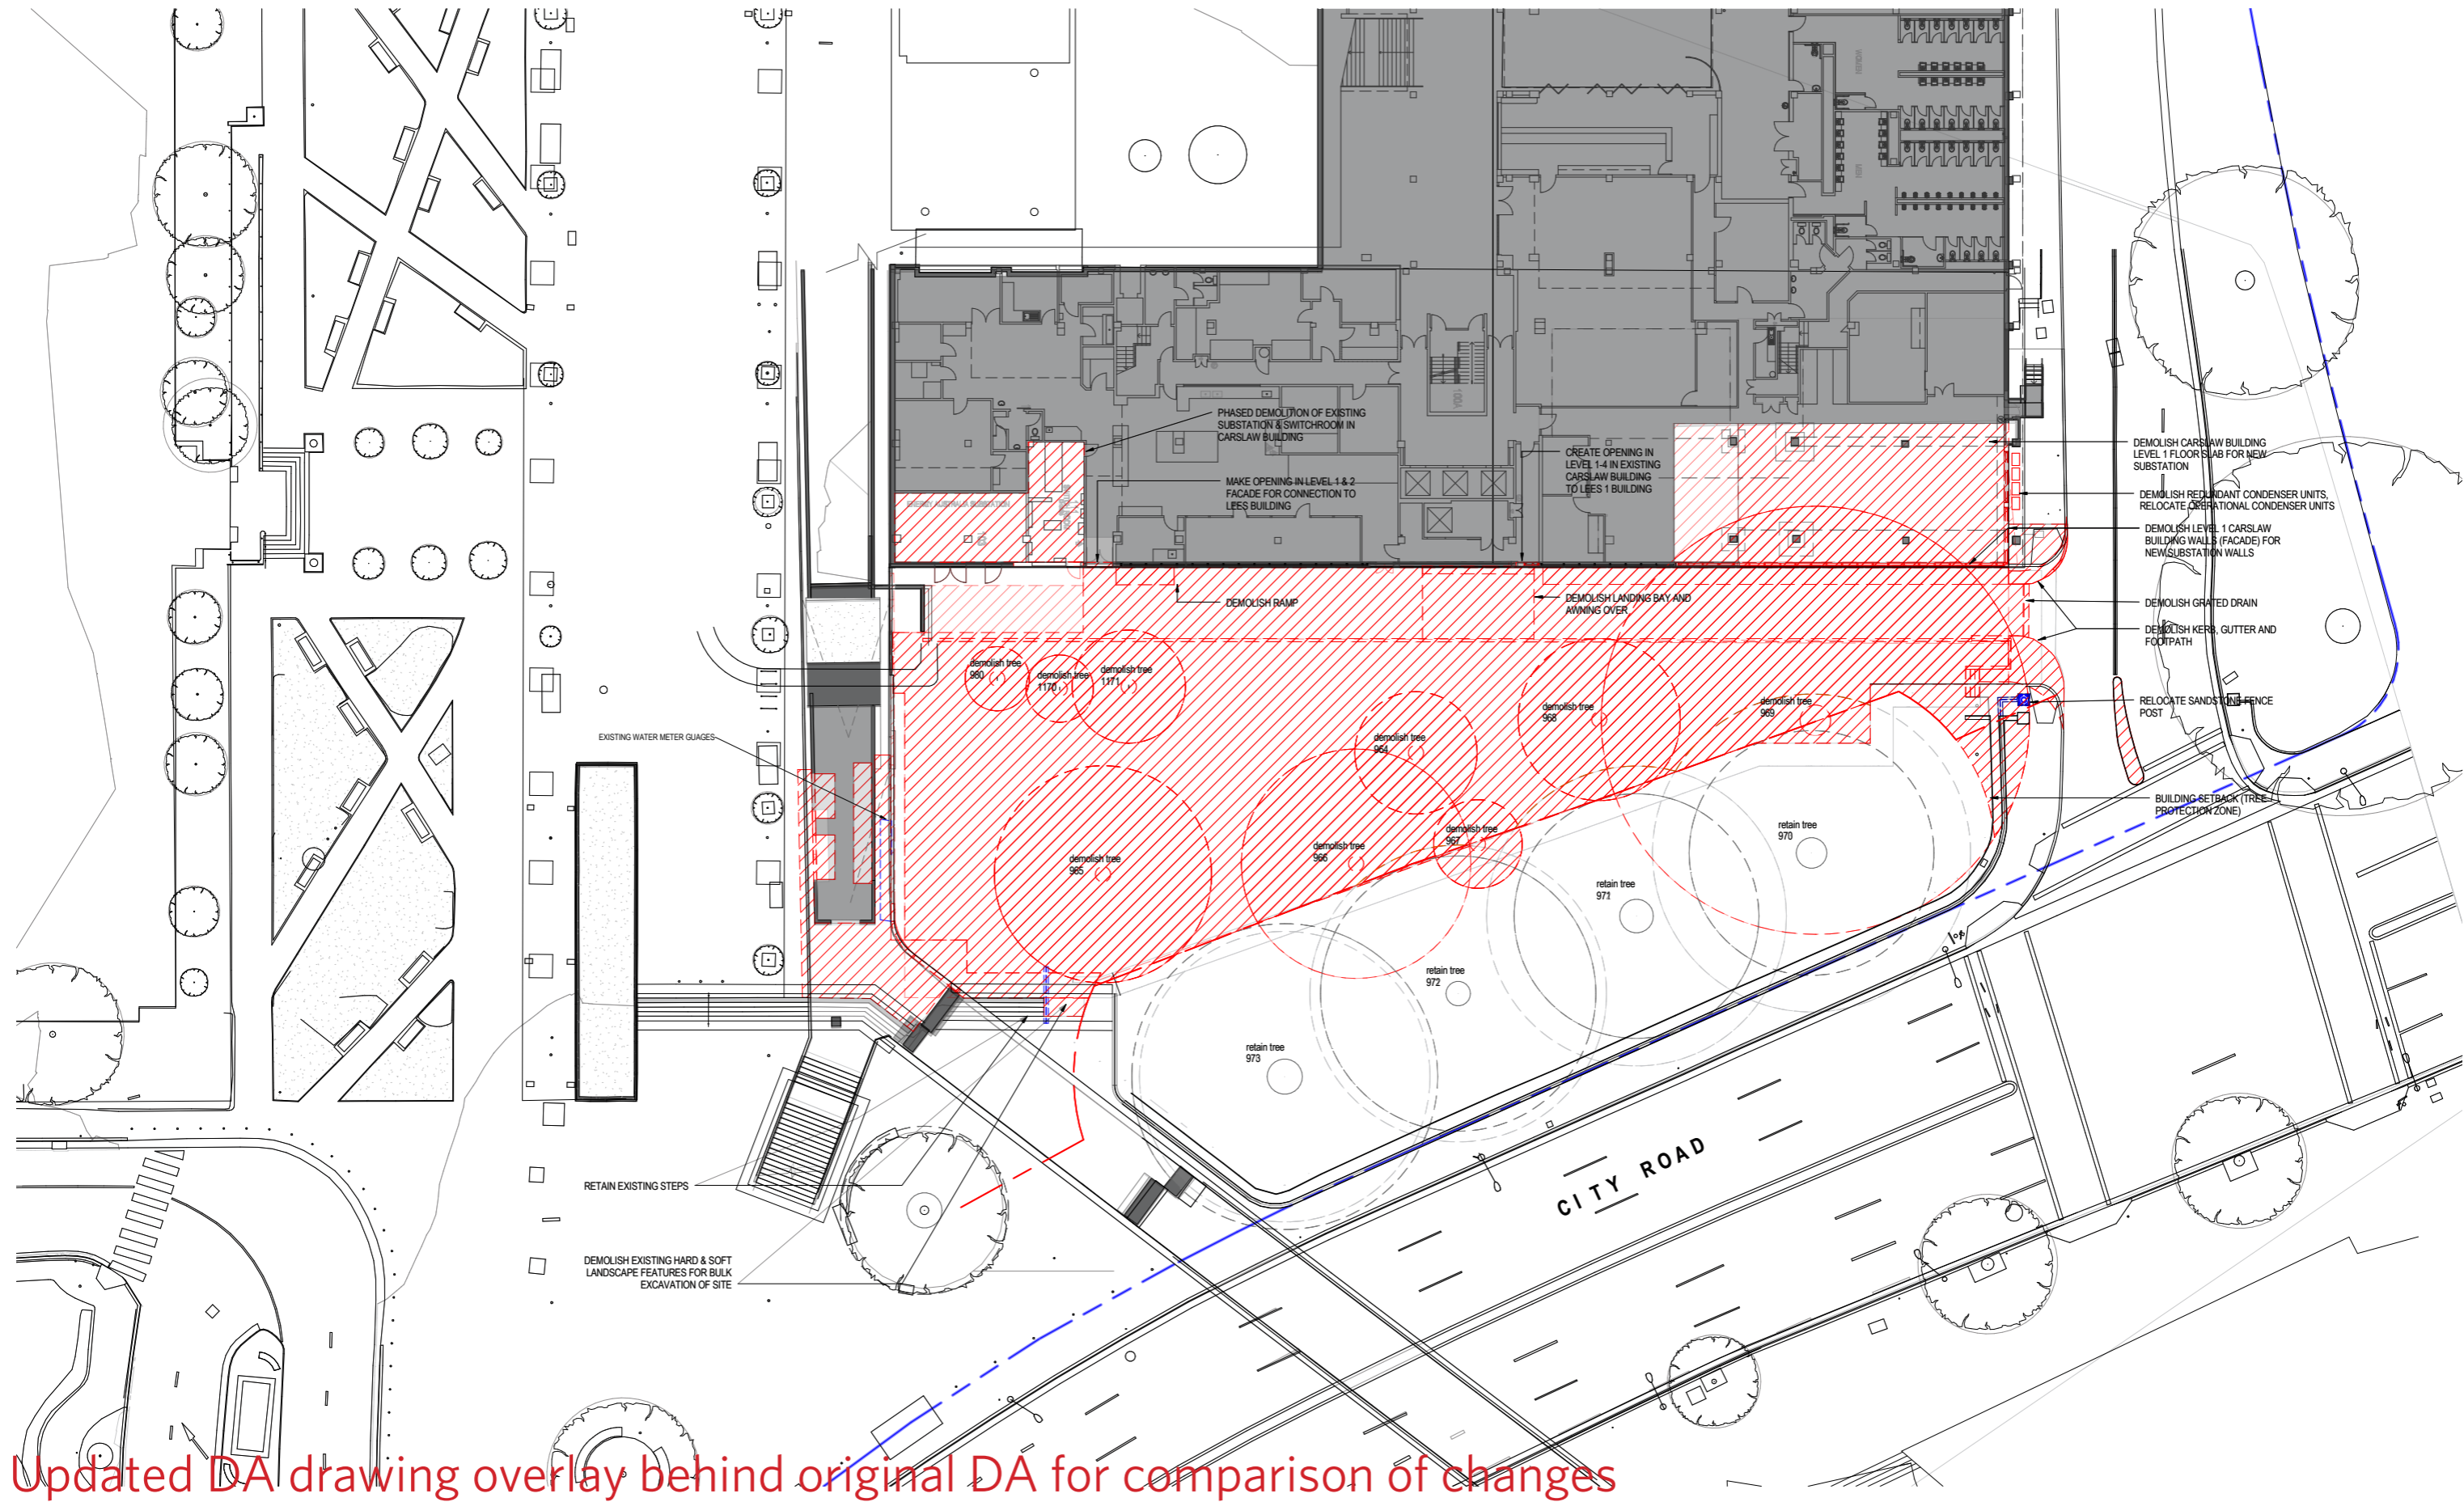

Updated DA drawing overlay behind original DA for comparison of changes

DATE: 13/09/2016 11:47:05 AM FOR INFORMATION DESCRIPTION OF CHANGE		MS 13.09.2016 CHKD DATE		0 1m 20m A1		<b>CONSULTANT</b> Access Consultant: Cheung Access Code Compliance: B M + G Pty Ltd Comms/Security Engineer: JHA Consulting Engineers Electrical Engineer: JHA Consulting Engineers ESD Consultant: JHA Consulting Engineers Facade Engineer: Surface Design Consult. Pty Ltd Fire Engineer: JHA Consulting Engineers Landscape Architects: OCELLUS Pty Ltd Mechanical Engineer: JHA Consulting Engineers Plumbing Engineer: JHA Consulting Engineers Structural Engineer: Northrop Engineers Pty Ltd		<b>CLIENT</b> RICHARD CROOKES CONSTRUCTIONS THE UNIVERSITY OF SYDNEY		<b>ARCHITECTS</b> HDR RICE DAUBNEY Level 1, 110 Walker Street, North Sydney NSW 2060, Australia +61 2 9956 2666   hdr@ricedaubney.com   hdrinc.com		<b>PROJECT</b> LEES1 BUILDING (F07) THE UNIVERSITY OF SYDNEY CITY ROAD, CAMPERDOWN PROJECT NUMBER: 271821.15H		<b>DRAWING TITLE</b> SITE PLAN - TREE RETENTION		SCALE: 1:200 @ A1 CONTRACT NUMBER: TBC CHECKED: MS DRAWING NUMBER: HDR-AR-DWG-DA18 DATE: 13.09.2016 ISSUE: D	
--	--	----------------------------	--	-------------	--	--	--	--	--	---	--	---	--	--	--	---	--

THIS DOCUMENT IS THE COPYRIGHT OF THE RICE DAUBNEY GROUP (NSW) PTY LTD. ALL INFORMATION ILLUSTRATED ON THIS DOCUMENT IS TO BE CHECKED AND VERIFIED ON SITE. IN THE EVENT OF DISCREPANCIES REFER TO ARCHITECT PRIOR TO COMMENCEMENT OF THE WORK. DO NOT SCALE DRAWINGS MANUALLY OR ELECTRONICALLY.

C:\v\2016\15H LEES 1\_BASE BUILDING\_samh.hosny@hdrinc.com.au