



NSW GOVERNMENT
Planning


Issued under the Environmental Planning and Assessment Act 1979

Approved Application No. SSD 7056

granted on the 19 April 2017

Signed [Signature]

Sheet No. 11 of 40

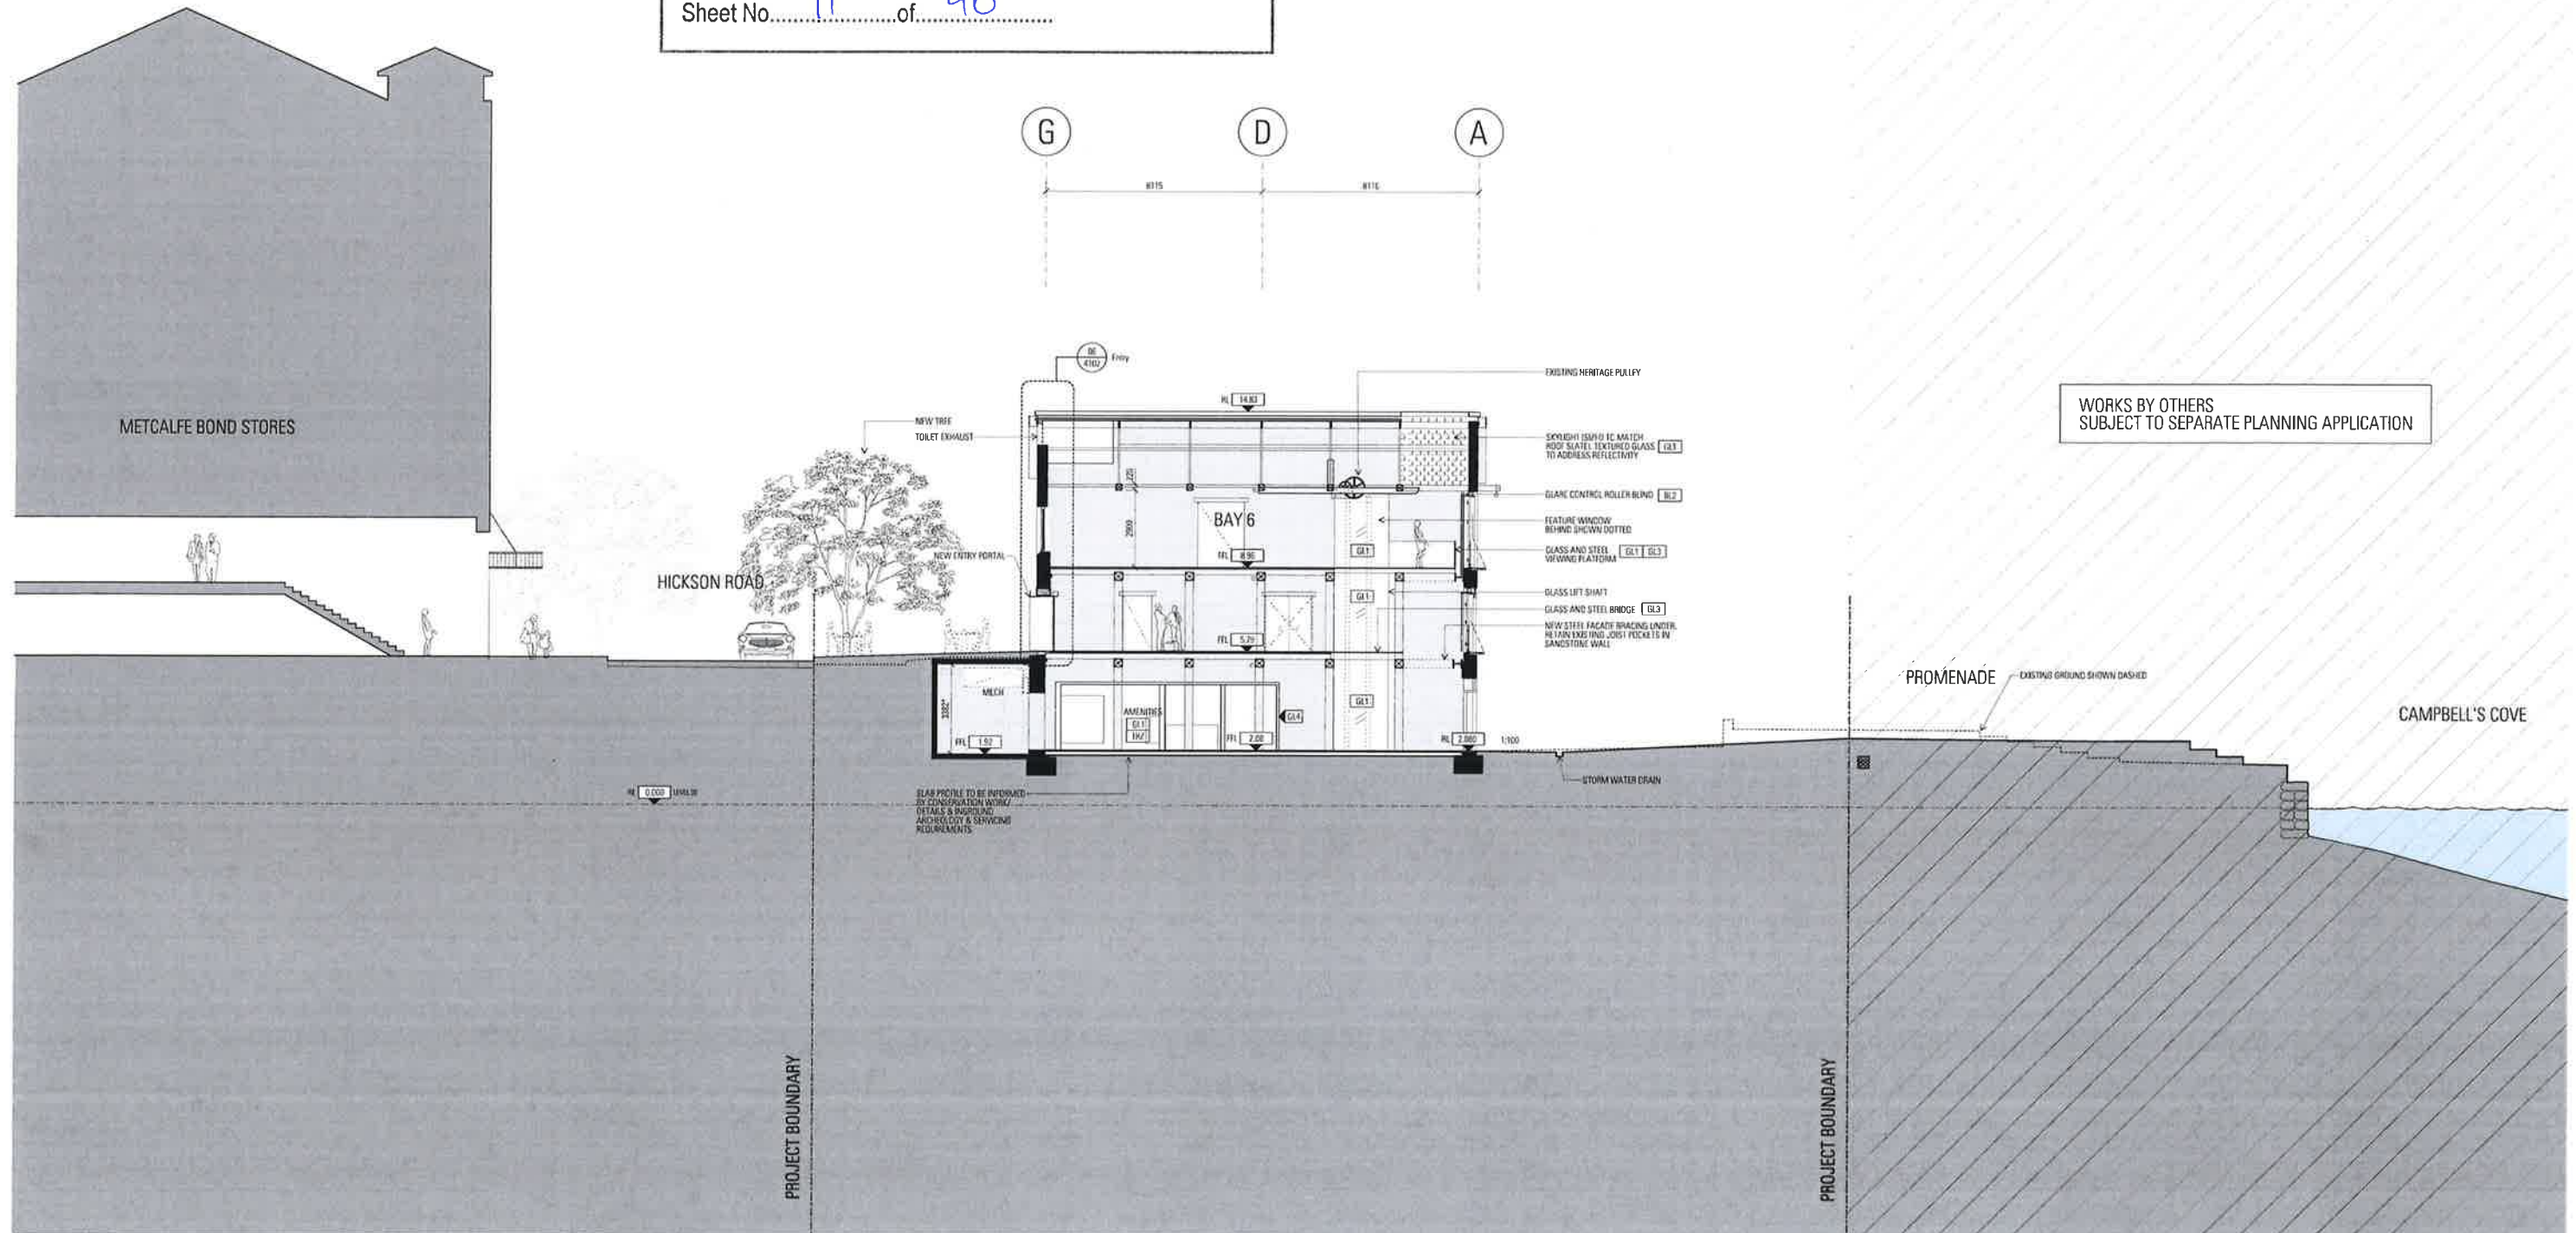

WORKS BY OTHERS
SUBJECT TO SEPARATE PLANNING APPLICATION

Author
JPM
JOHNSON PILTON WALKER

Drawn
Tallawanda Pty Ltd
Suite 201, 251 Pitt St, Sydney NSW 2000

Checked
Northrop Consulting Engineers Pty Ltd
Level 11, 245 George Street, Sydney NSW 2000

Marked by
Refer to Appendix 1 - Materials Board for Signs

SL
MS
GLT
PC

Shading Notes
Blue Shading
Indicates fill out design end point of the section of work

Project Title
CAMPBELL'S STORES
SYDNEY HARBOUR

Survey Notes
The survey was based on the 1:100 scale drawing and the survey was made by the client. The survey was made by the client. The survey was made by the client.

Rev. 01/18
App. 01/18
Rev. 01/18
App. 01/18

Scale 1:100 @ RL
1:250 @ A3

Key Plan
Do not scale from drawing. Use marked dimensions. To be read in conjunction with all other Campbell's drawings. The architect is to be immediately notified of any discrepancies. Copyright on this drawing retained by the Architect.

Drawing Title
SECTION - BAY 6
JPM Project Number
12006
Drawing Station
EA
Drawing Number
EA-A-3008
Revision
B





Approved Application No. SSD 7056

granted on the 19 April 2017

Signed.....

Sheet No. 12 of 40

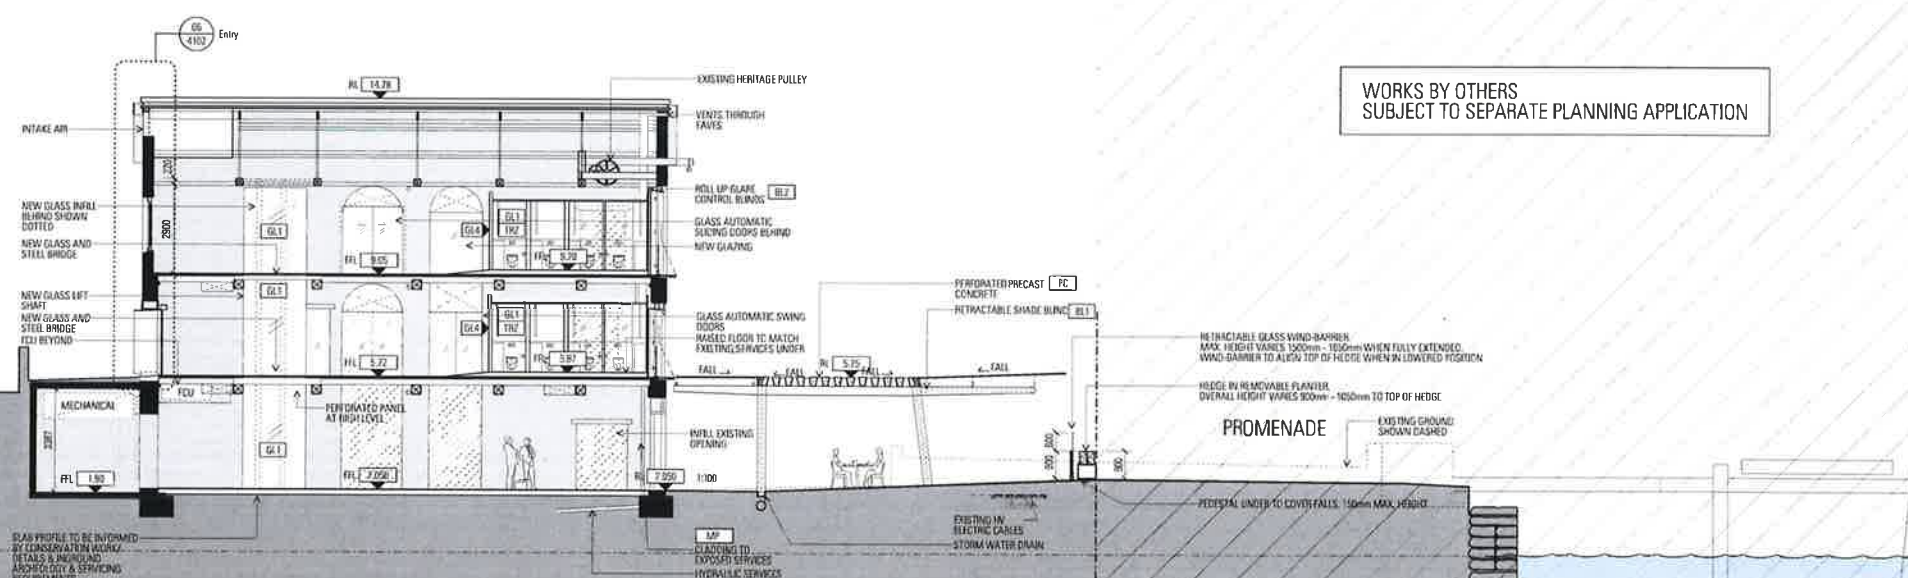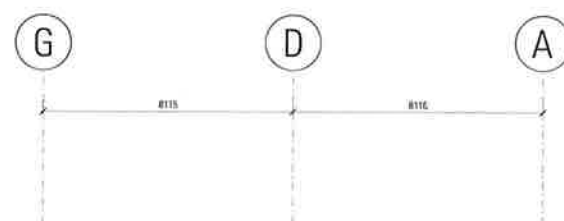

WORKS BY OTHERS
SUBJECT TO SEPARATE PLANNING APPLICATION

PROJECT BOUNDARY

0000 LEFT POSITION ADV





Approved Application No. SSD 7056

granted on the 19 April 2017

Signed.....



Sheet No. 13 of 40

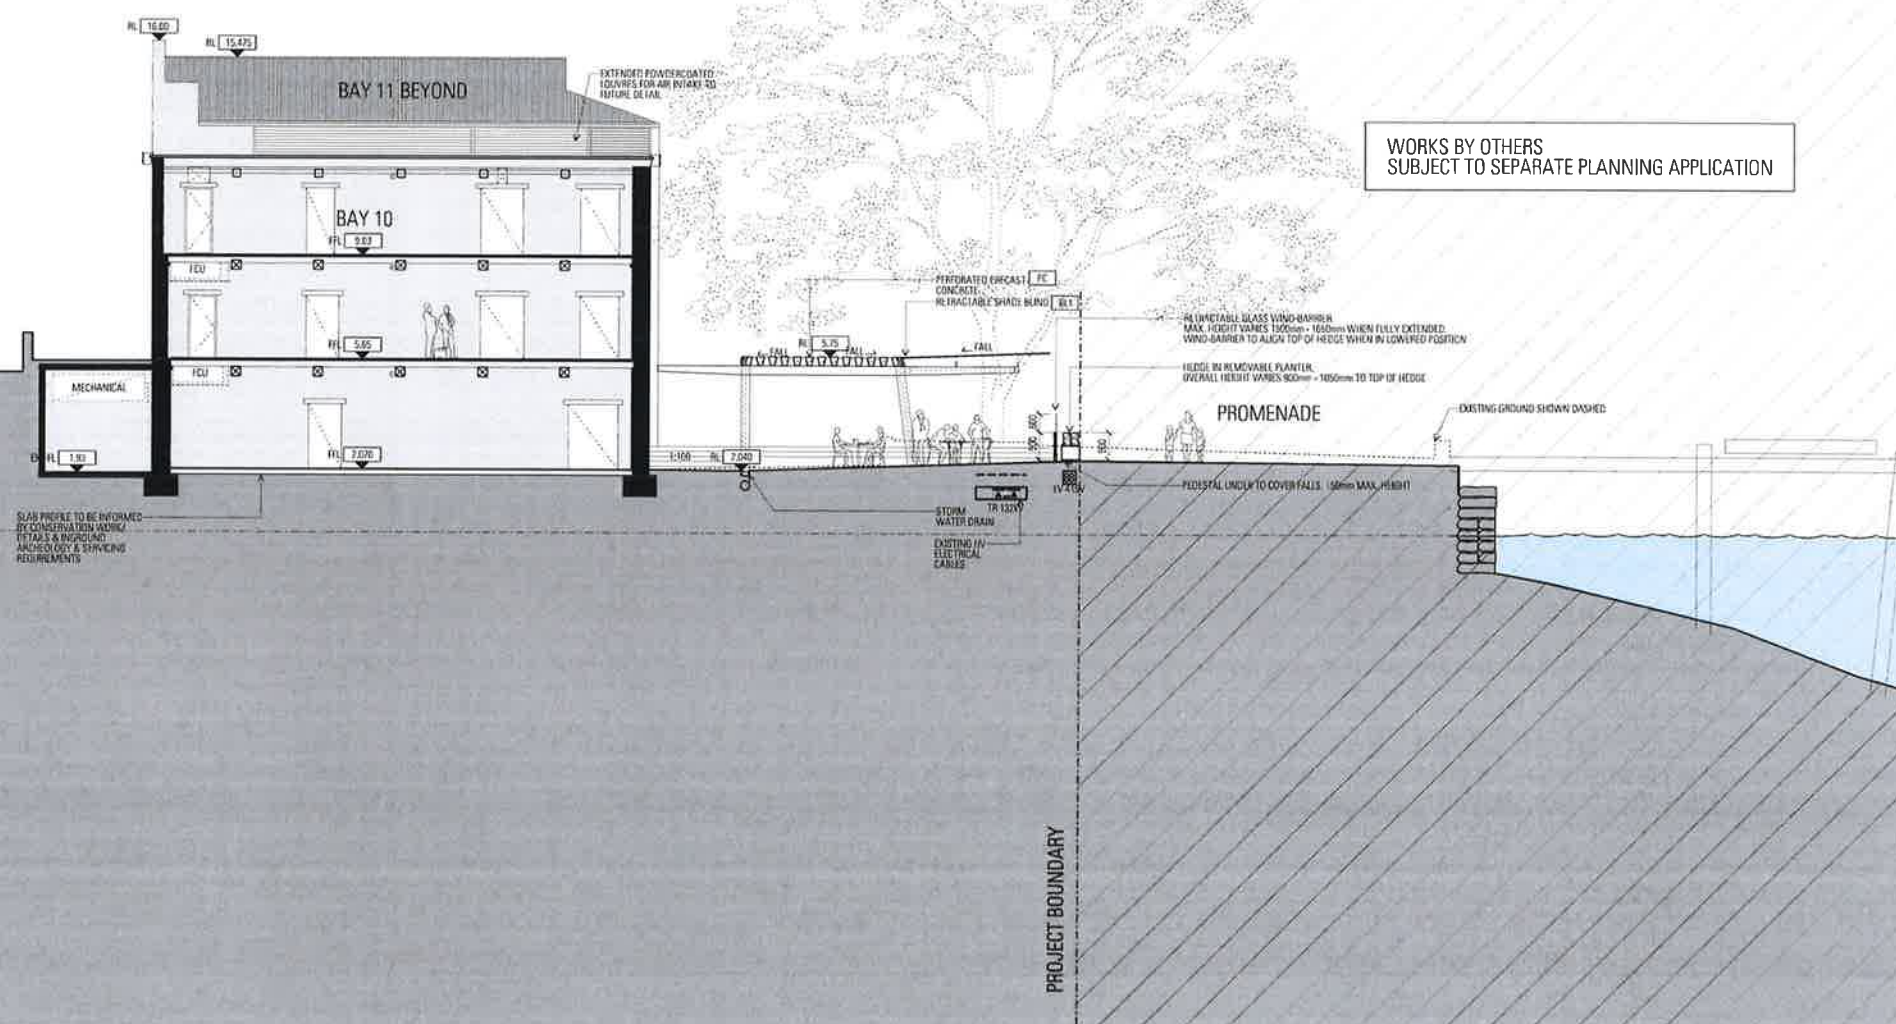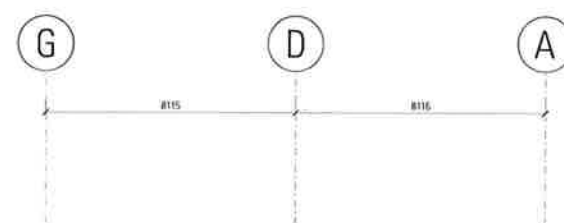

WORKS BY OTHERS
SUBJECT TO SEPARATE PLANNING APPLICATION



Sheet No. 14 of 40

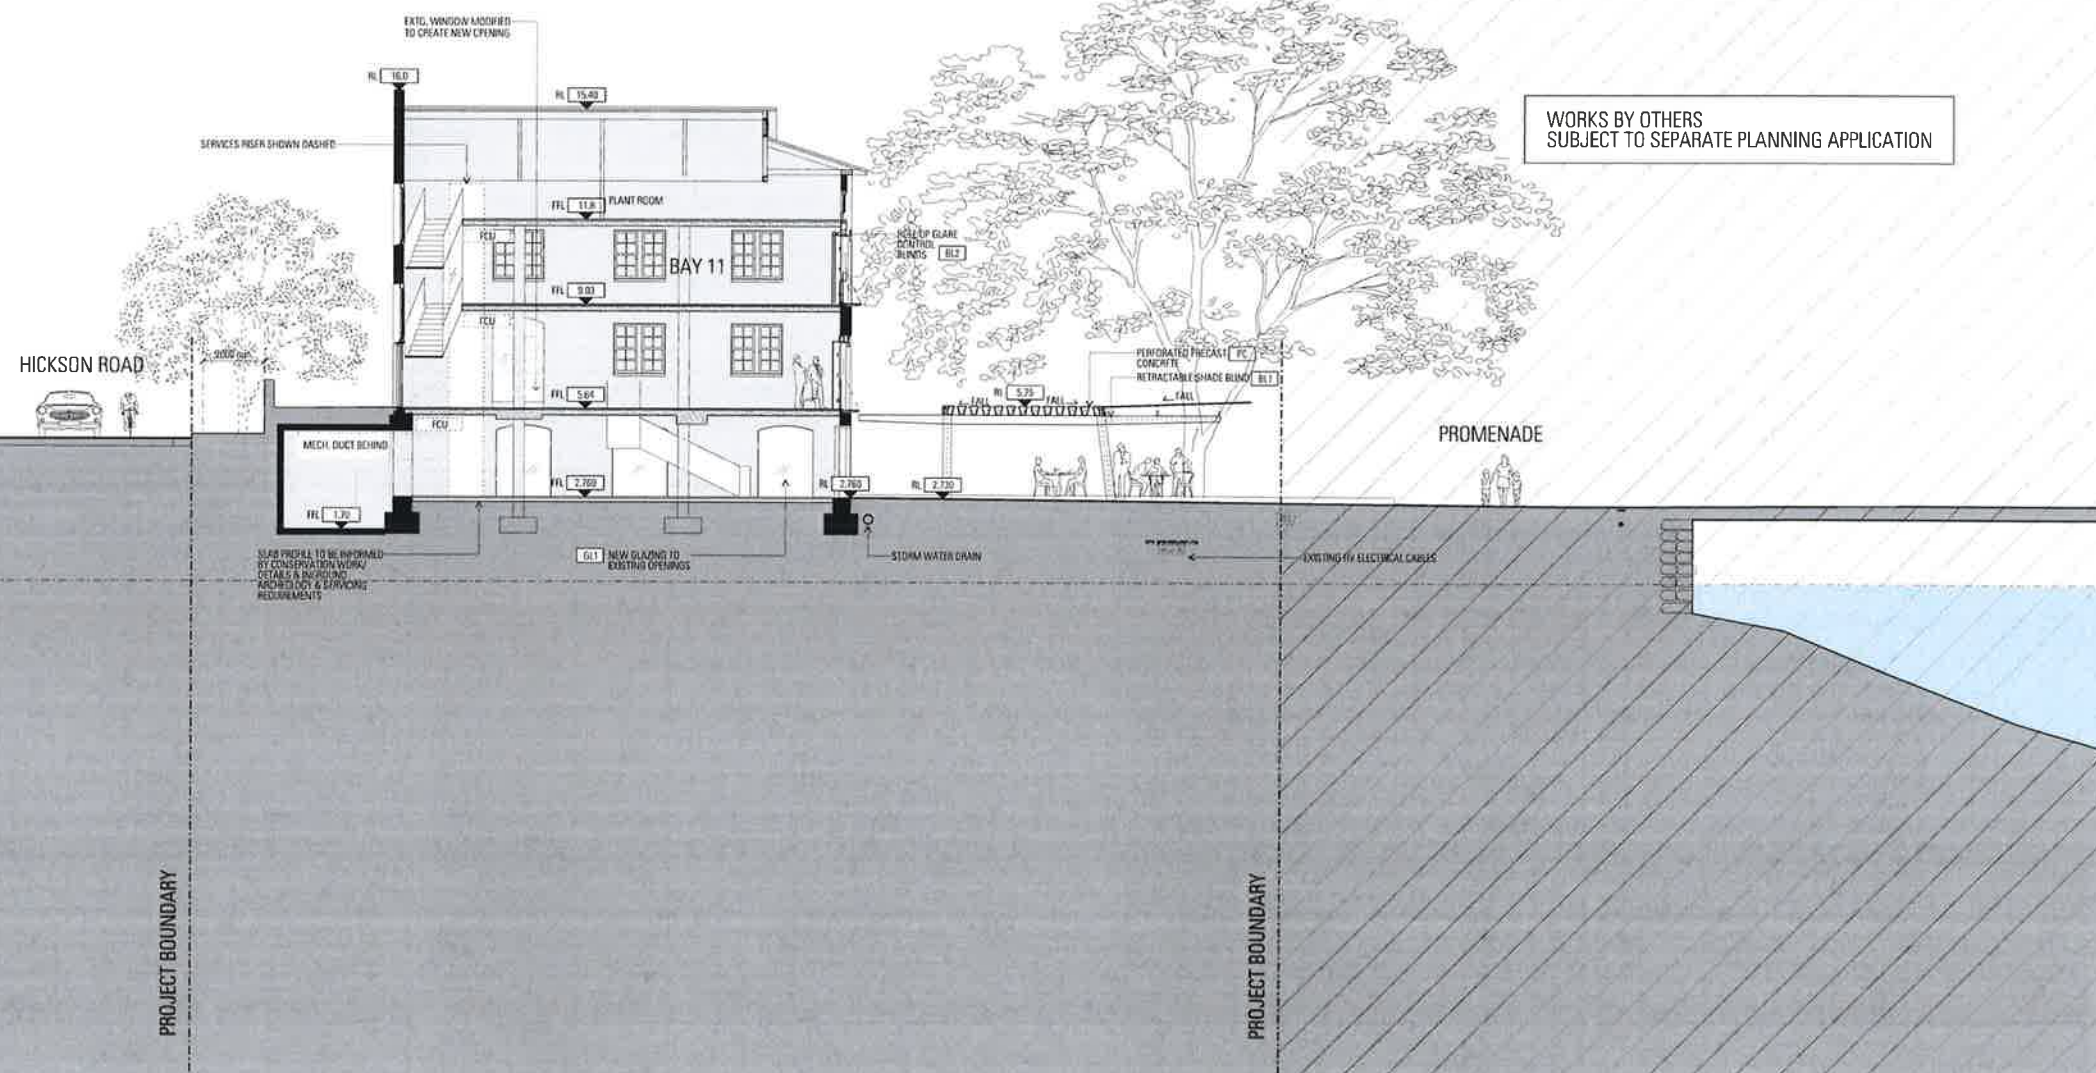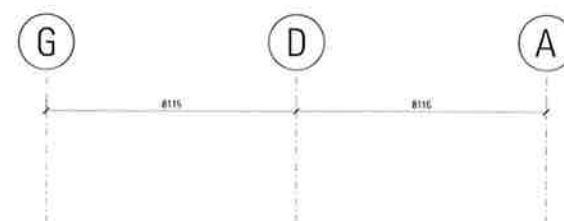

WORKS BY OTHERS
SUBJECT TO SEPARATE PLANNING APPLICATION

JPM Project Number:
12006
Drawing Status:
EA

Drawing Number
EA-A-3011
Revision
C



NSW GOVERNMENT
Planning

Issued under the Environmental Planning and Assessment Act 1979


Approved Application No. SSD 7056

granted on the 19 April 2017

Signed [Signature]

Sheet No. 15 of 40

WORKS BY OTHERS
SUBJECT TO SEPARATE PLANNING APPLICATION

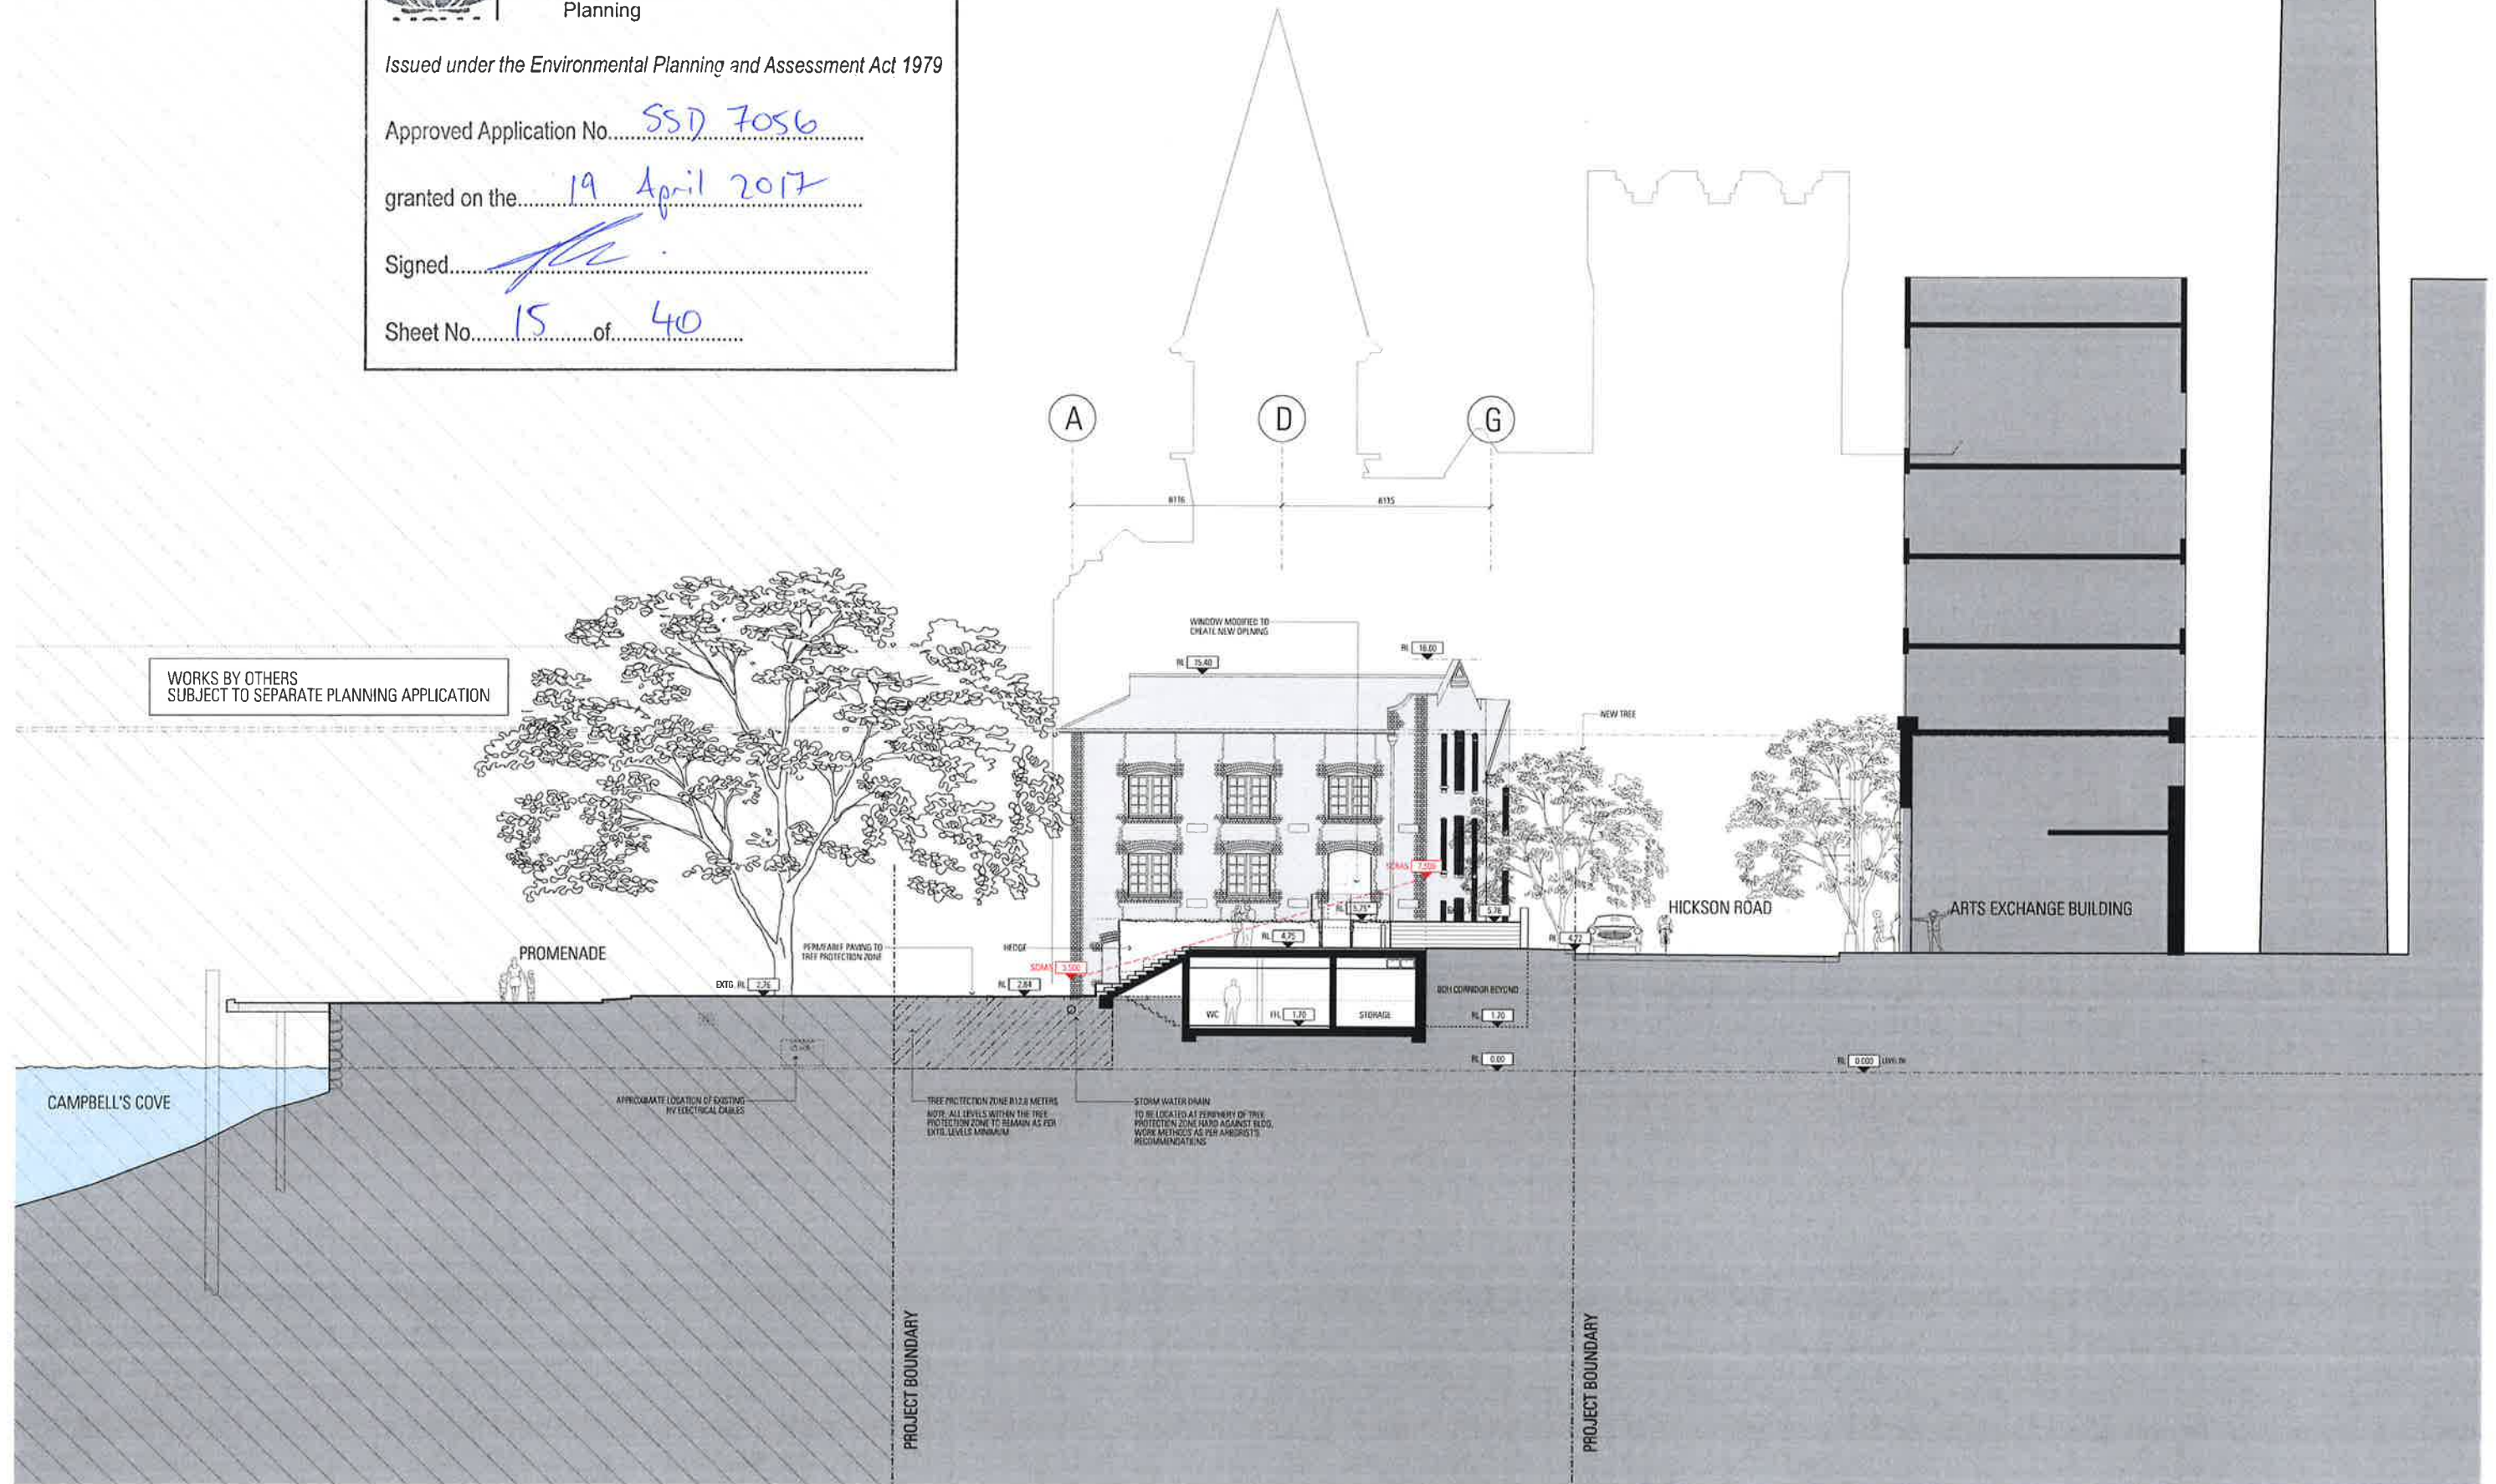

Author
JPW
JOHNSON PILTON WALKER

Client
Telstrastra Pty Ltd
Suite 201, 35 Lane St, Sydney NSW 2000

Project Manager & Designer
Alisa Page-Gilford
The Pilton Building, 1 Market Street, Sydney NSW 2000
Telephone: +61 2 9700 1231
www.alisapagegilford.com

Structural Engineer
Northrop Consulting Engineers Pty Ltd
Level 11, 36 George Street, Sydney NSW 2000
Telephone: +61 2 9361 8100
www.northropconsulting.com.au

Project Manager & Designer
Tender Thomas Consulting Engineers
Level 2, 40 Charles Street, Sydney NSW 2000
Telephone: +61 2 9600 1000
www.tenderthomas.com.au

Architect
Refer to Appendix 1: Materials Board for details

PAVE1	GB1	CONC1	MP1	SL
PAVE2	GB2	TRM1	MP2	MS
PAVE3	GL1	SS1	PT1	GL1
PAVE4	GL2	TRM2	PT2	PC
PAVE5	GL3	TRM3	PT3	
ASPH1	GL4	TRM4	BL1	
ST1	CONC1	SP1	TR2	

Legend
Existing Works
New Works
Works to existing opening
Indicates the location of the work to be done

CAMPBELL'S STORES
SYDNEY HARBOUR


Building Notes
The building is a listed building and is subject to the provisions of the Sydney Harbour National Park Management Plan and the Sydney Harbour National Park Act 1988.
The building is a listed building and is subject to the provisions of the Sydney Harbour National Park Management Plan and the Sydney Harbour National Park Act 1988.
The building is a listed building and is subject to the provisions of the Sydney Harbour National Park Management Plan and the Sydney Harbour National Park Act 1988.

Rev. Date
A 18/10/16
B 10/08/16

App. Cdr. Revision or reason for issue
BM EA Drawings
BM Response to Submissions

Scale / North Arrow
1:100 @ D1
1:250 @ A3

Do not scale from reading, use master dimensions to be read in conjunction with all other Consultant's drawings for accuracy to be immediately notified of any discrepancies. Copyright in this drawing retained by the Architect.

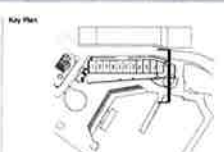

Section Title
SECTION - BAY 12 SOUTH

Project Number
12006
Drawing Number
EA-A-3012-2
Revision
B



NSW GOVERNMENT
Planning


Issued under the Environmental Planning and Assessment Act 1979

Approved Application No. SSD 7056

granted on the 19 April 2017

Signed [Signature]

Sheet No. 16 of 40

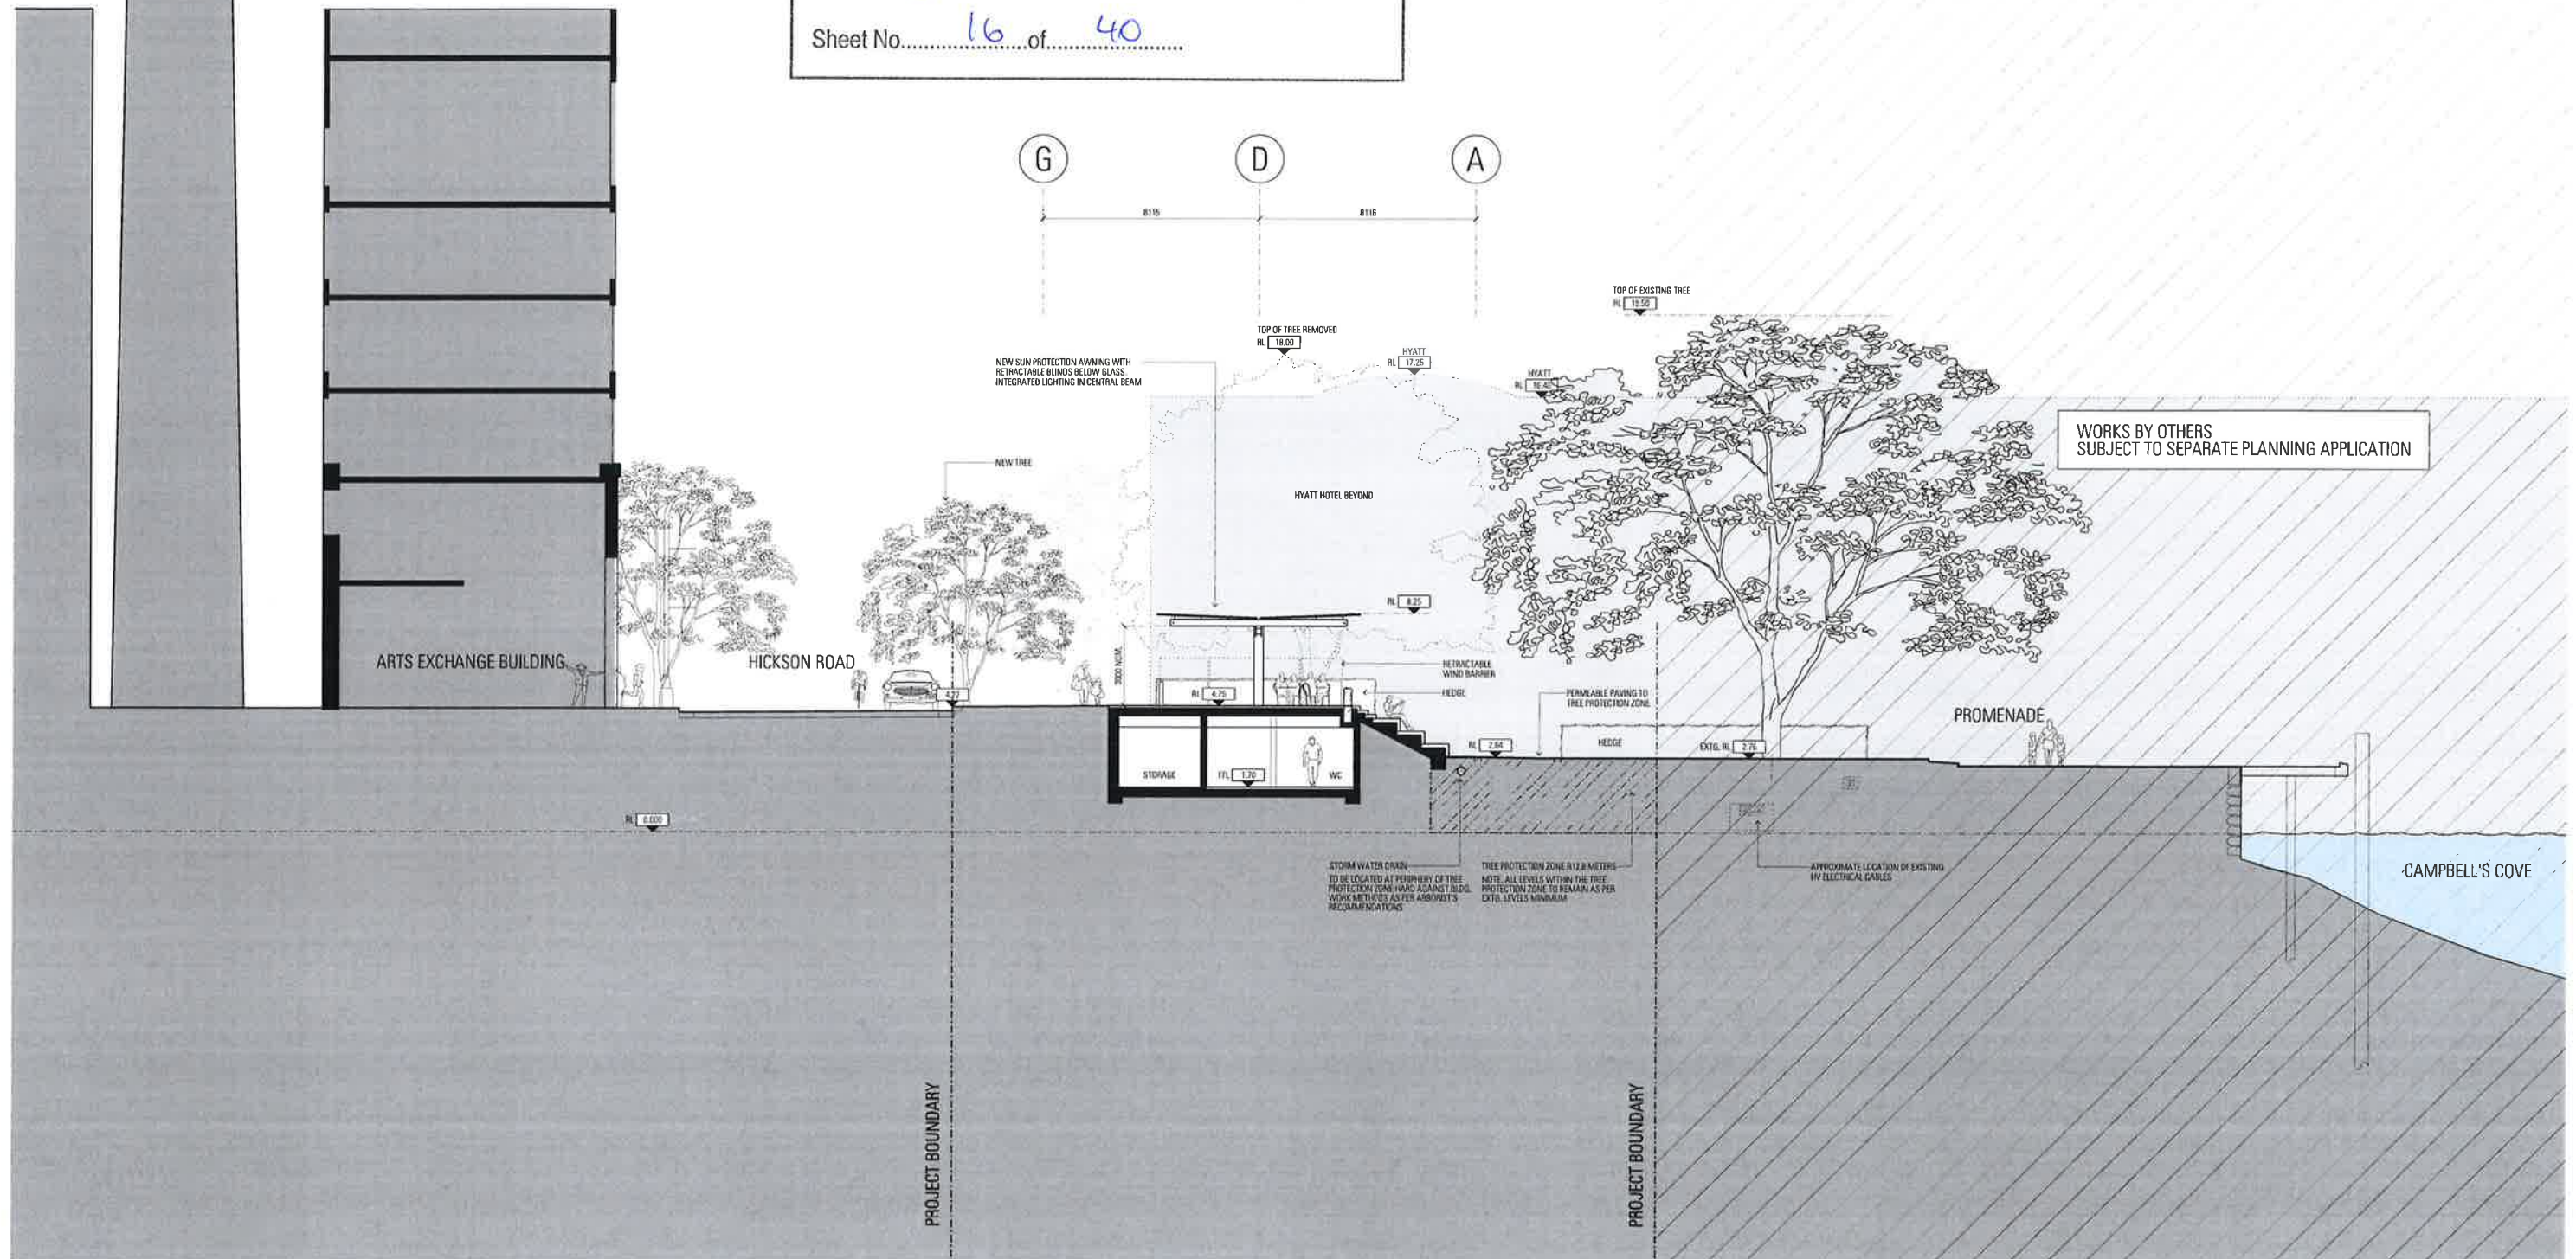

Author:
JPW
JOHNSON PILTON WALKER
Johnson Pilton Walker Pty Ltd ACN 095 776 686
Level 10 Plaza Building Australia Square
95 Pitt Street
Sydney NSW 2000 Australia
Telephone: +61 2 9259 5800
Facsimile: +61 2 9259 5888
www.jpw.com.au

Client:
Tikoweb Pty Ltd
Suite 201, 35 Little St, Sydney NSW 2000
Telephone: +61 2 8241 4186 Facsimile: +61 2 8241 4241
http://www.tikoweb.com.au

Project Manager & Quantity Surveyor:
Alisa Page Kirkland
The Future Building, 1 Market Street, Sydney NSW 2000
Telephone: +61 2 9252 1241
www.thefuture.com.au

Structural Engineer:
Tucker Thompson Consulting Engineers Pty Ltd
Level 11, 345 George Street, Sydney NSW 2000
Telephone: +61 2 8241 4186 Facsimile: +61 2 8241 4241
http://www.tuckerthompson.com.au

Structural & Civil Engineer:
Tucker Thompson Consulting Engineers
Level 11, 345 George Street, Sydney NSW 2000
Telephone: +61 2 8241 4186 Facsimile: +61 2 8241 4241
www.tuckerthompson.com.au

PAVE1	CB1	CONC2	MP1	SL
PAVE2	CB2	TIM1	MP2	MS
PAVE3	CB3	TIM2	SS1	GLT
PAVE4	CB4	TILE1	PT1	PC
PAVE5	CB5	TILE2	PT5	
ASPHLT	GL4	TILE3	BL1	
ST1	CONC1	SP1	TR2	

SL
MS
GLT
PC


Fin:
Existing Works
New Works
Indicate fit out only (not part of the scope of work)

CAMPBELL'S STORES
SYDNEY HARBOUR

Survey Notes:
Drawings are based on the 2014 design and survey information provided by SDA. The survey data is for the site levels of level 1 and 2 as well as the 1st underground level.
Survey data is referenced to MGA 94 in plan and APD Elevation.
Where data levels have been omitted reference to '1st Down' levels is 2.30 m AHD to assist in construction to the 1st Down level.

Rev	Date	App	Chg	Reason for revision
A	16/10/16	RM	EA	Drawings
B	16/09/16	RM	EA	Response to Submissions
C	20/08/16	RM	EA	Revision to Bay 12

Scale: North Point
1:100 @ B1, 0 1 2 3 5M
1:250 @ A3
Do not scale from drawings. Use marked dimensions.
To be used in conjunction with all other Consultant's drawings.
The Architect is to be immediately notified of any discrepancies.
Copyright in this drawing retained by the Architect.

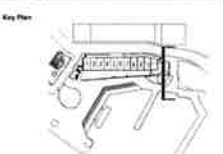

Drawing Title:
SECTION - BAY 12 NORTH

JPW Project Number:
12006
Drawing Number:
EA-A-3012
Revision:
C



NSW GOVERNMENT
Planning

Issued under the Environmental Planning and Assessment Act 1979

Approved Application No. SSD 7056


granted on the 19 April 2017

Signed [Signature]

Sheet No. 17 of 40



01 SOUTH - NORTH
SCALE 1:200

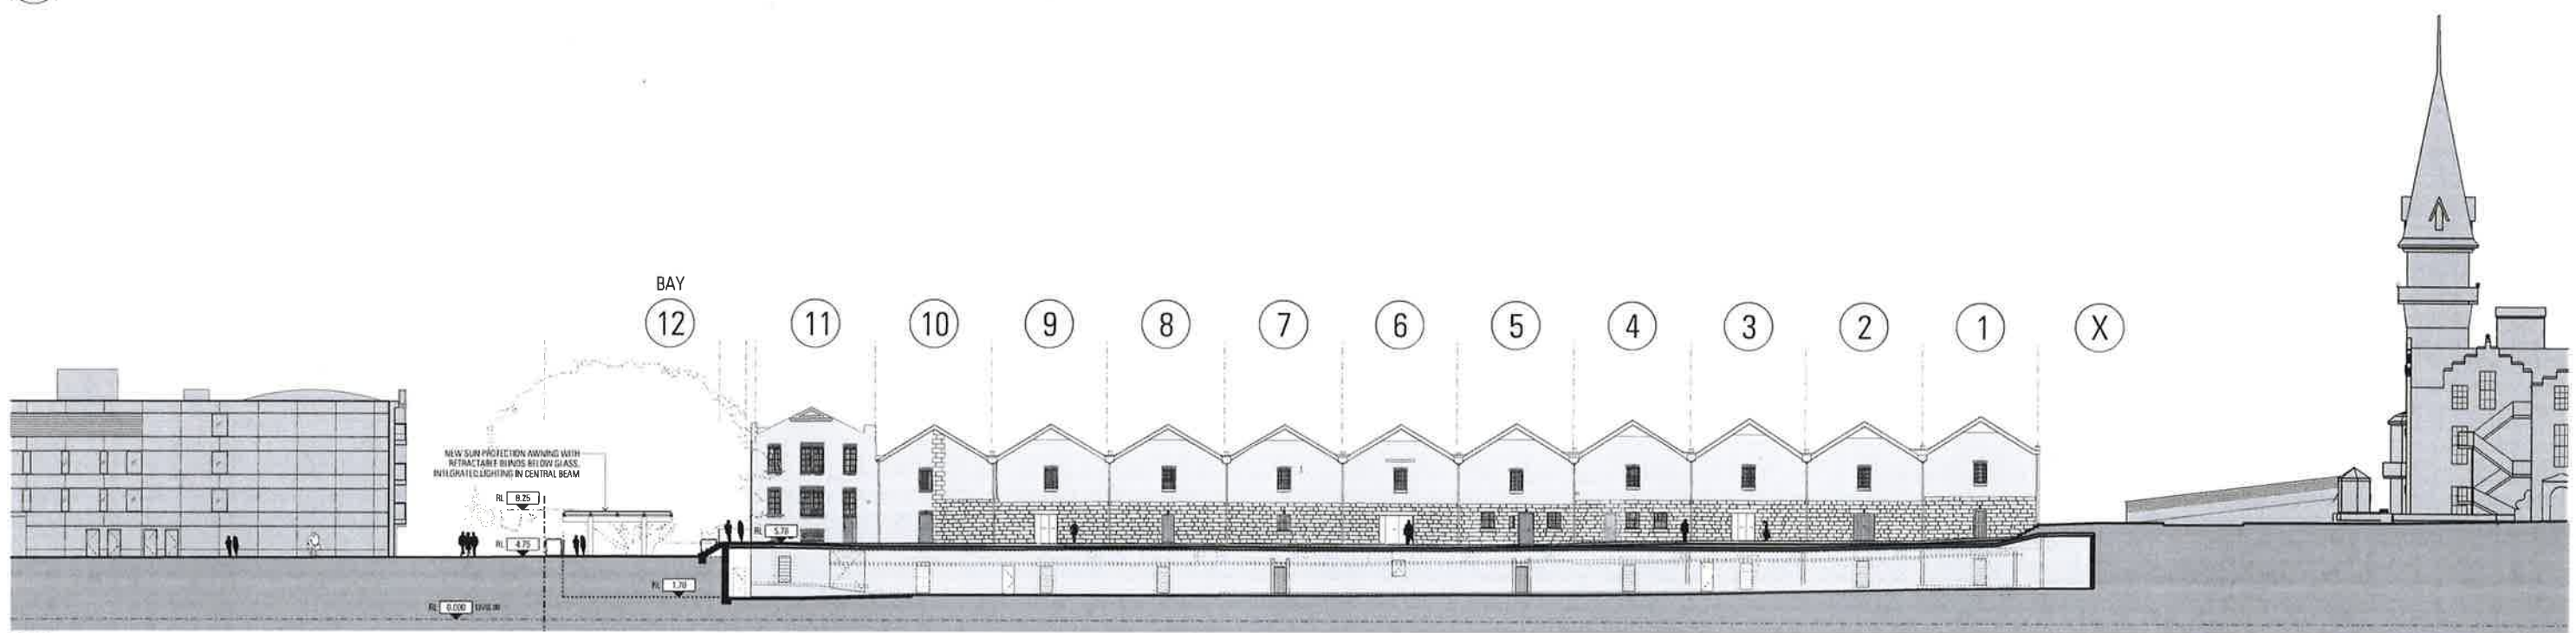

02 NORTH - SOUTH
SCALE 1:200

Architect
JPMW
JOHNSON PILTON WALKER
Level 10, Main Building, Australia Square
100 Pitt Street
Sydney NSW 2000 Australia
Telephone +61 2 9796 5400
Facsimile +61 2 9259 5599
www.jpw.com.au

Engineer
Taylor Thomas-Wilking Consulting Engineers Pty Ltd
Level 11, 245 George Street, Sydney NSW 2000
Telephone +61 2 9241 6100 Facsimile +61 2 9241 4324
http://www.ttw-engineers.com.au


Structural Engineer
Taylor Thomas-Wilking Consulting Engineers Pty Ltd
Level 11, 245 George Street, Sydney NSW 2000
Telephone +61 2 9241 6100 Facsimile +61 2 9241 4324
http://www.ttw-engineers.com.au

RAVEL	CONC2	MP1	SL
PAVES	TIM2	MP2	MS
PAVES	SSI	PT1	QLT
PAVES	PT1	PT2	PC
PAVES	PT2	PT3	
PAVES	PT3	PT4	
PAVES	PT4	PT5	
PAVES	PT99	PT100	

RAVEL	CONC2	MP1	SL
PAVES	TIM2	MP2	MS
PAVES	SSI	PT1	QLT
PAVES	PT1	PT2	PC
PAVES	PT2	PT3	
PAVES	PT3	PT4	
PAVES	PT4	PT5	
PAVES	PT99	PT100	

RAVEL	CONC2	MP1	SL
PAVES	TIM2	MP2	MS
PAVES	SSI	PT1	QLT
PAVES	PT1	PT2	PC
PAVES	PT2	PT3	
PAVES	PT3	PT4	
PAVES	PT4	PT5	
PAVES	PT99	PT100	

RAVEL	CONC2	MP1	SL
PAVES	TIM2	MP2	MS
PAVES	SSI	PT1	QLT
PAVES	PT1	PT2	PC
PAVES	PT2	PT3	
PAVES	PT3	PT4	
PAVES	PT4	PT5	
PAVES	PT58	PT59	
PAVES	PT59	PT60	</

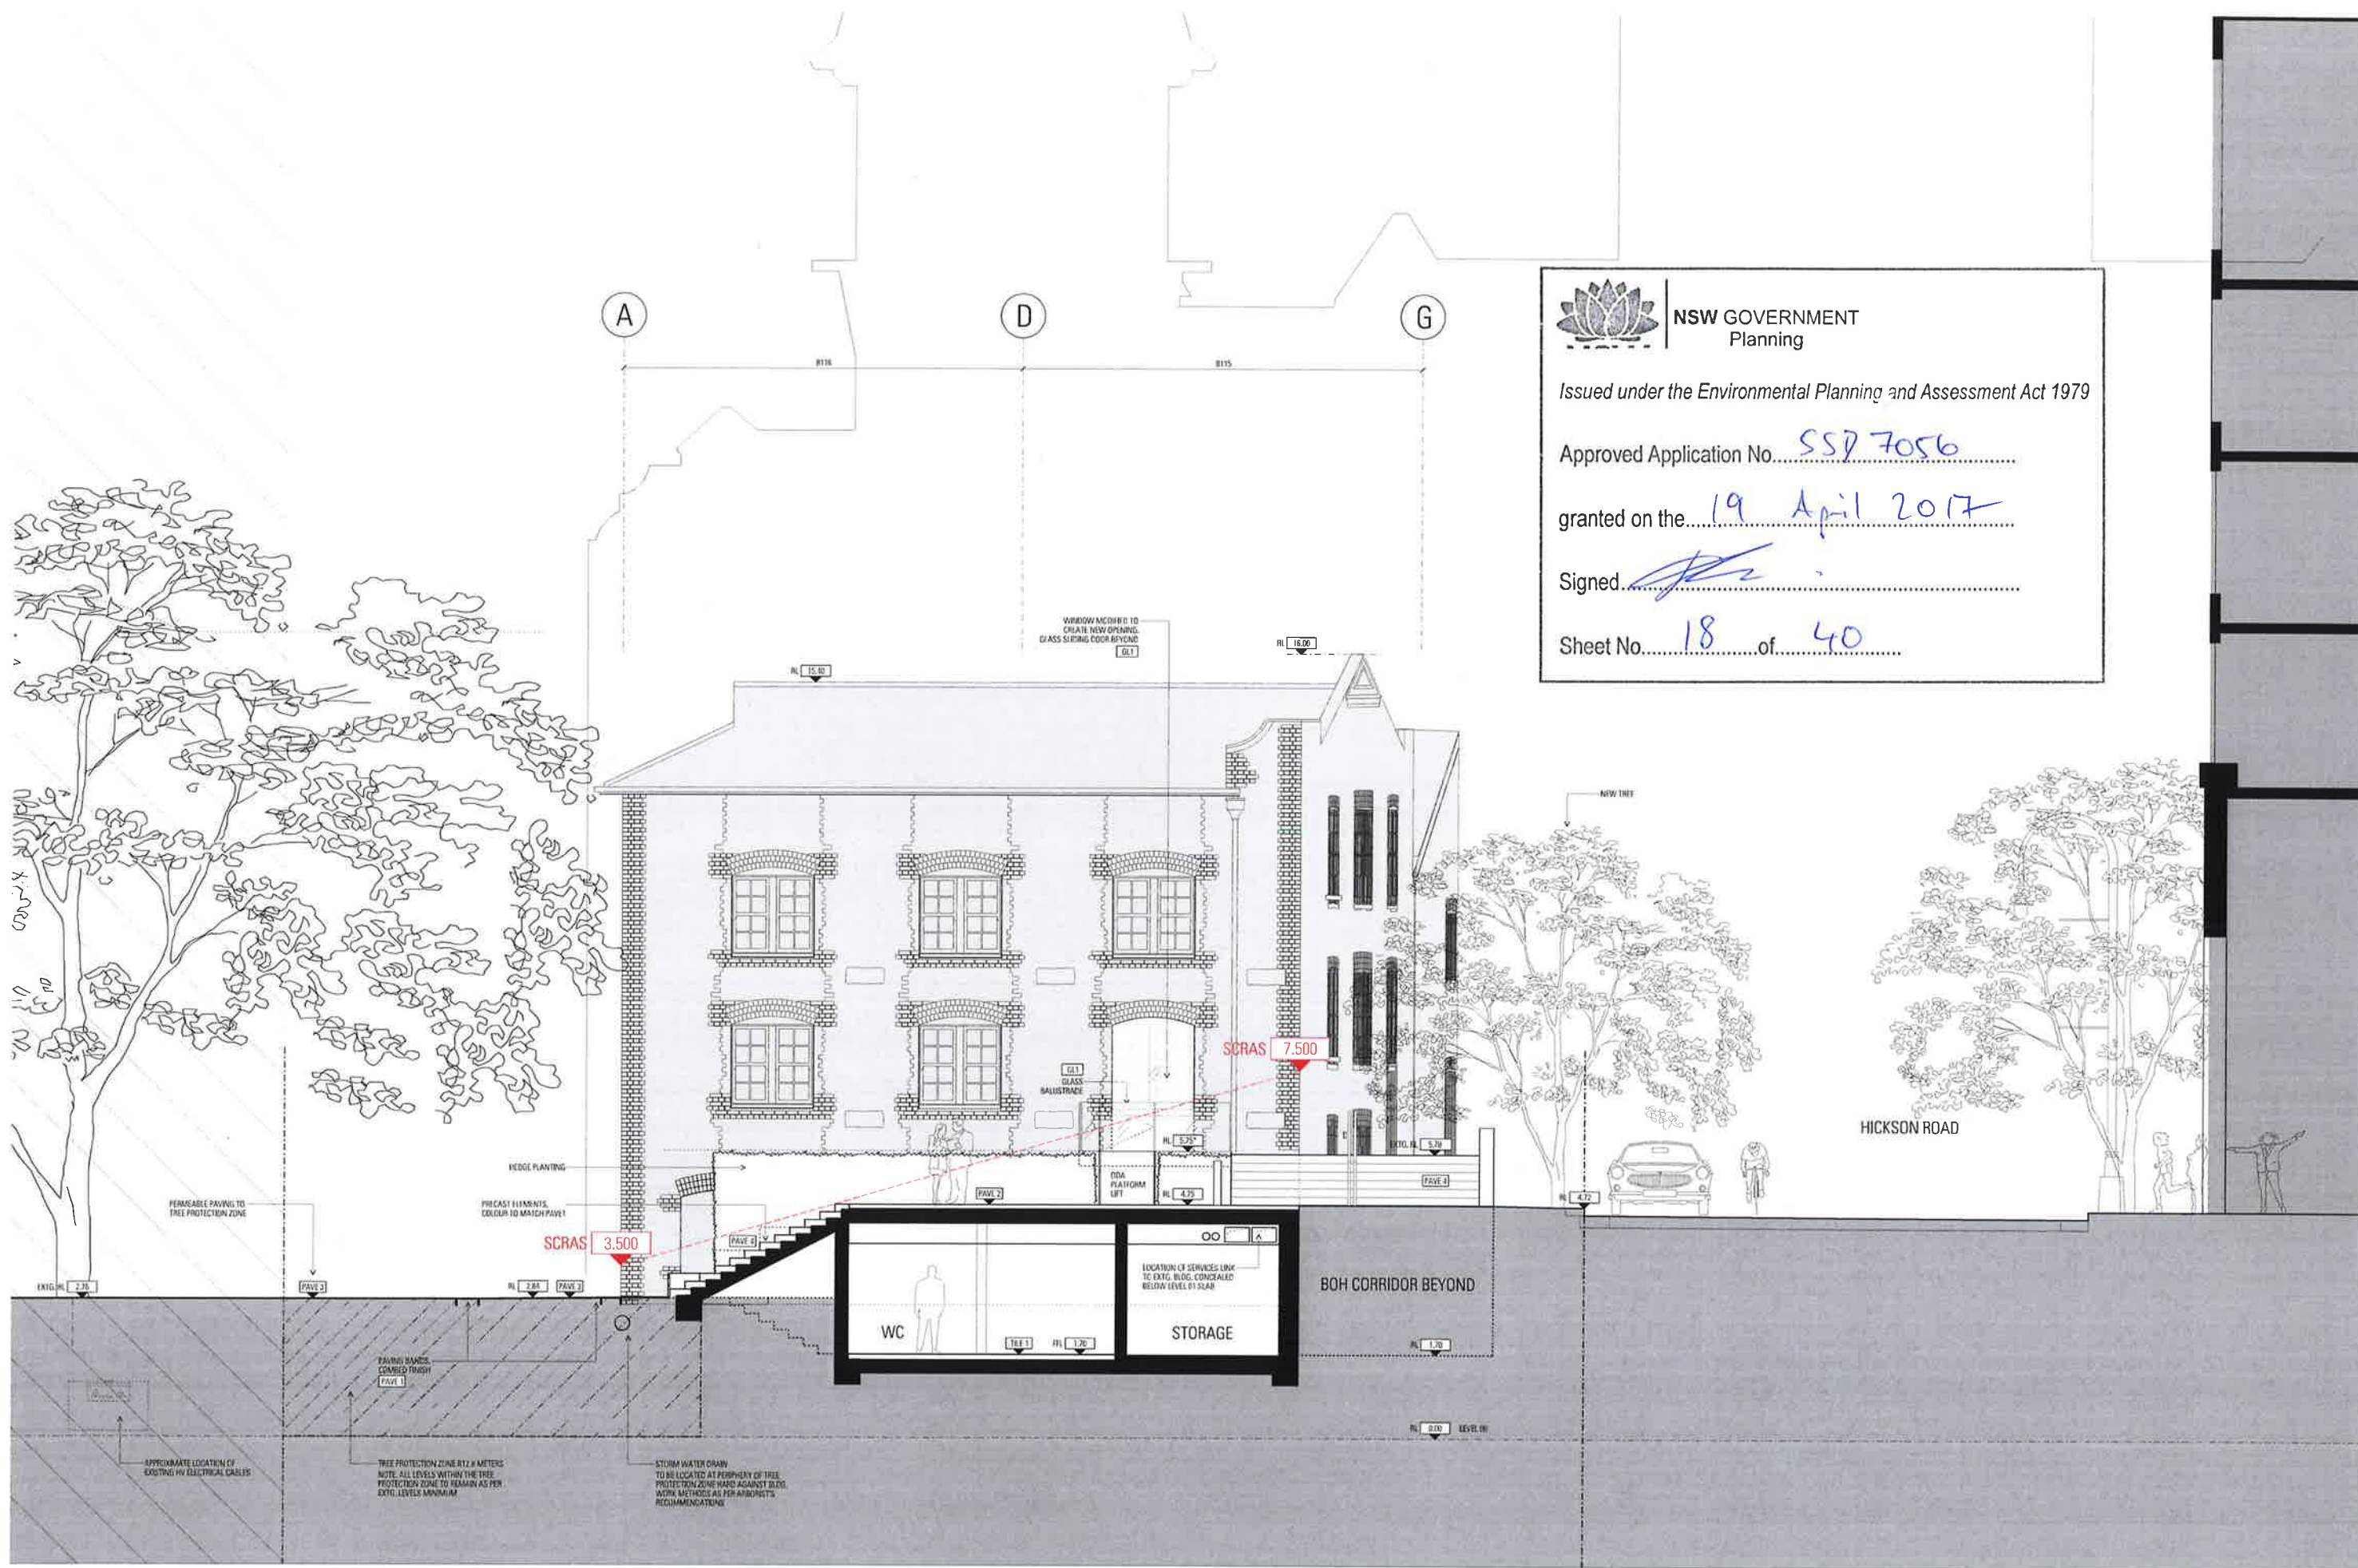

NSW GOVERNMENT
Planning

Issued under the Environmental Planning and Assessment Act 1979

Approved Application No. SSD 7056

granted on the 19 April 2017

Signed [Signature]

Sheet No. 18 of 40

Architect
JPMW
JOHNSON PILTON WALKER
Level 10, 110 Pitt Street, Sydney NSW 2000
Tel: (02) 9250 5000
Fax: (02) 9250 5001
www.jpwm.com.au

Client
Tallawanda Pty Ltd
Suite 201, 35 Lime St, Sydney NSW 2000
Project Manager & Tender Scheme
Alvin Page
110 Pitt Street, Sydney NSW 2000
Tel: (02) 9250 5000
Fax: (02) 9250 5001
www.tallawanda.com.au

Structural Engineer
Matthew Consulting Engineers Pty Ltd
Level 11, 345 George Street, Sydney NSW 2000
Tel: (02) 9250 5000
Fax: (02) 9250 5001
www.mce.com.au

Material Schedule

PAVE1	CONC2	MP1	SL
PAVE2	CONC1	MP2	MS
PAVE3	CONC1	SS1	QIT
PAVE4	CONC1	PT1	PC
PAVE5	CONC1	PT5	
PAVE6	CONC1	BL1	
ASPH1	CONC1	TR2	
ST1	CONC1		

Services

GB1	CONC2	MP1	SL
GB2	CONC1	MP2	MS
GB3	CONC1	SS1	QIT
GB4	CONC1	PT1	PC
GB5	CONC1	PT5	
GB6	CONC1	BL1	
GB7	CONC1	TR2	
GB8	CONC1		
GB9	CONC1		
GB10	CONC1		
GB100	CONC1		

Services


GB1	CONC2	MP1	SL
GB2	CONC1	MP2	MS
GB3	CONC1	SS1	QIT
GB4	CONC1	PT1	PC
GB5	CONC1	PT5	
GB6	CONC1	BL1	
GB7	CONC1	TR2	
GB8	CONC1		
GB9	CONC1		
GB10	CONC1		
GB100	CONC1		

Services

GB1	CONC2	MP1	SL
GB2	CONC1	MP2	MS
GB3	CONC1	SS1	QIT
GB4	CONC1	PT1	PC
GB5	CONC1	PT5	
GB6	CONC1	BL1	
GB7	CONC1	TR2	
GB8	CONC1		
GB9	CONC1		
GB10	CONC1		
GB100	CONC1		

Services

GB1	CONC2	MP1	SL
GB2	CONC1	MP2	MS
GB3	CONC1	SS1	QIT
GB4	CONC1	PT1	PC
GB5	CONC1	PT5	
GB6	CONC1	BL1	
GB7	CONC1	TR2	
GB8	CONC1		
GB9	CONC1		
GB10	CONC1		
GB91	CONC1		
GB9			

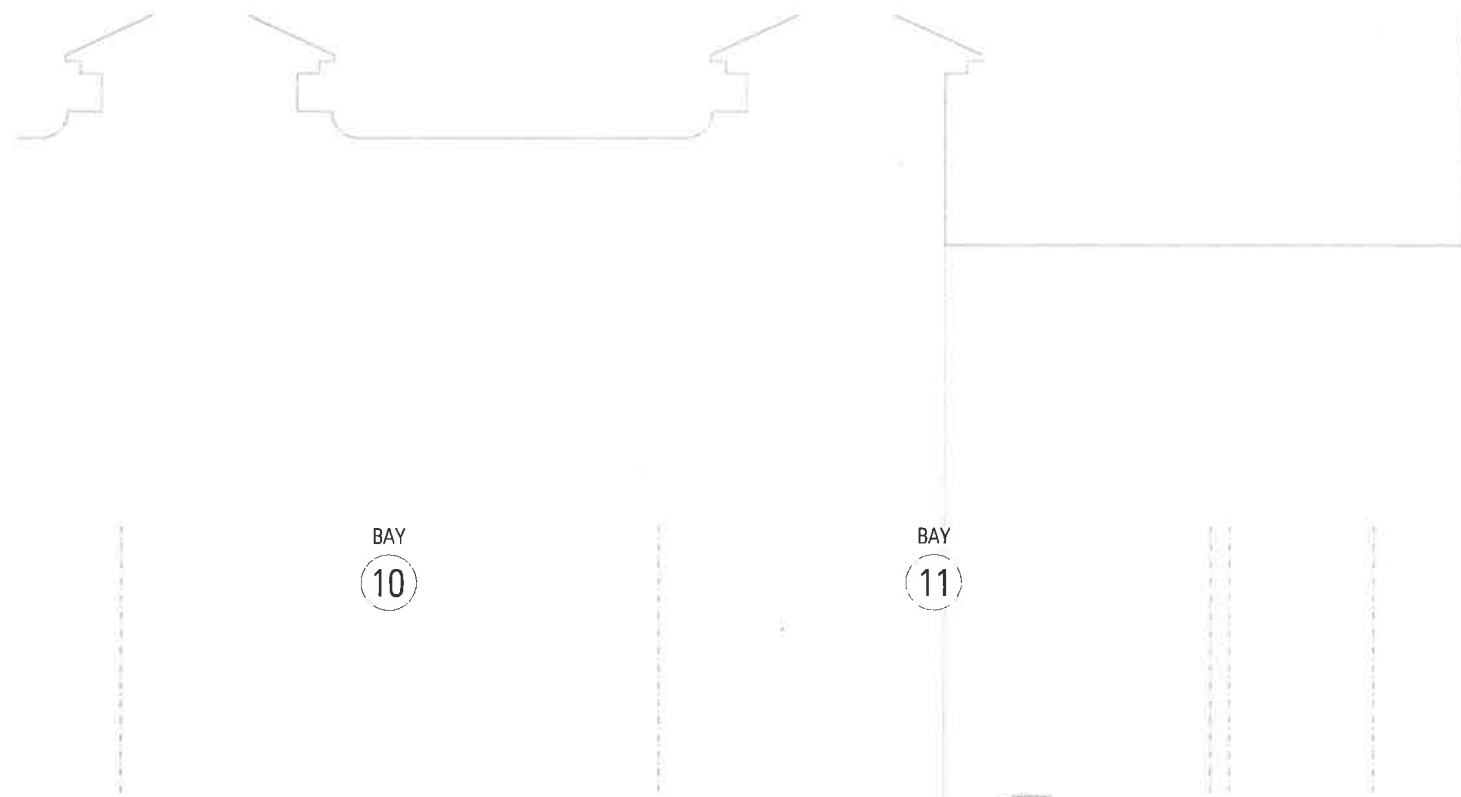



NSW GOVERNMENT
Planning


Issued under the Environmental Planning and Assessment Act 1979

Approved Application No. SSD 7056

granted on the 19 April 2017

Signed [Signature]

Sheet No. 19 of 40

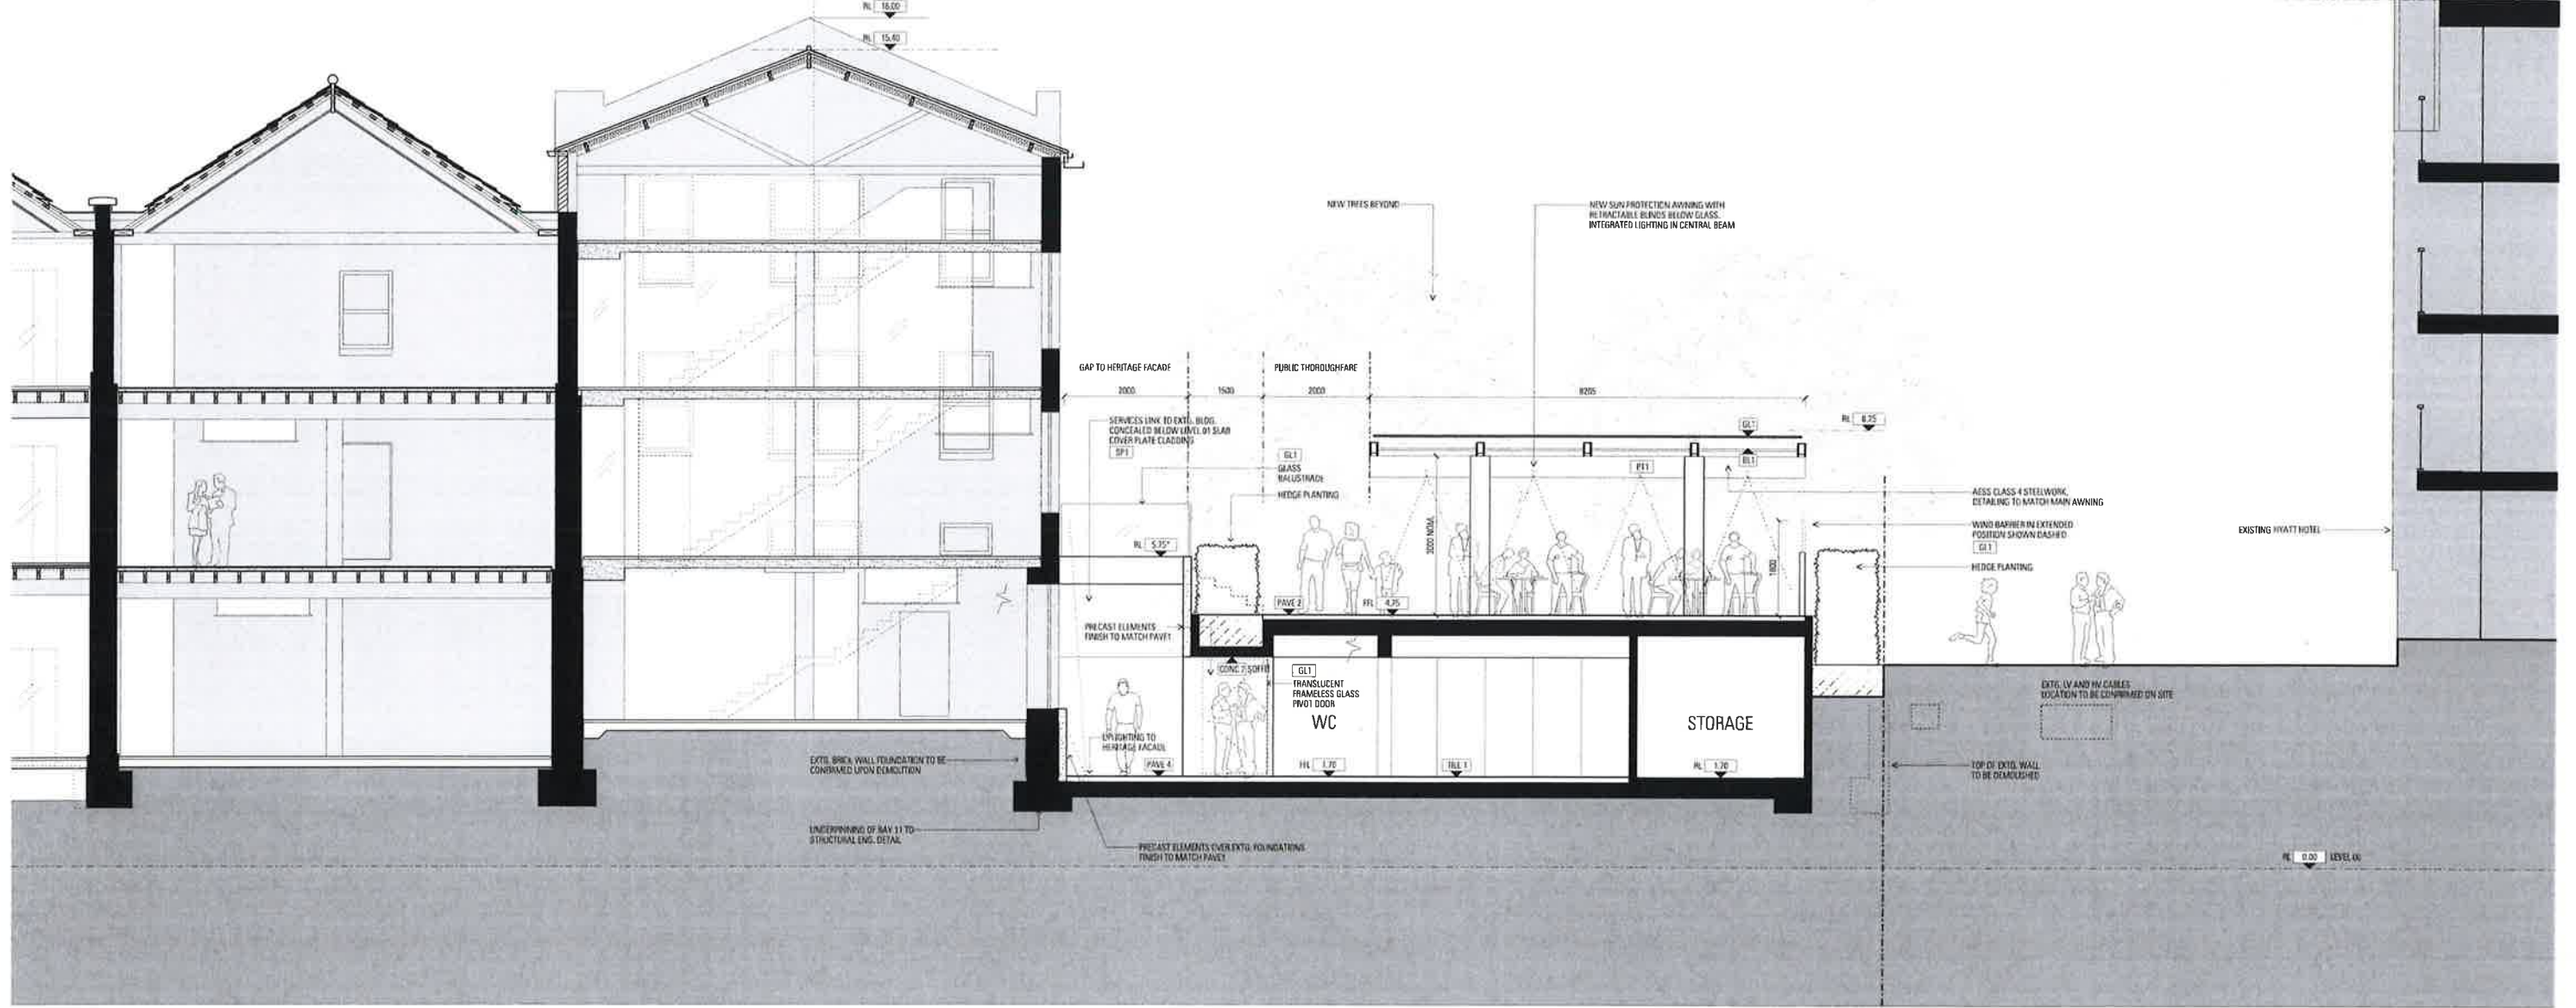

JPW
JOHNSON PILTON WALKER

Level 10, Flinders Building, Australia Square
100 Pitt Street
Sydney NSW 2000, Australia
Telephone: +61 2 9239 5888
Facsimile: +61 2 9239 5889
www.jpwa.com.au

Architect
Tobias Page Kirkland
The Pilton Building, 1 Market Street, Sydney NSW 2000
Telephone: +61 2 9239 2211
www.alugroup.com

Structural Engineer
Northwest Consulting Engineers Pty Ltd
Level 11, 345 George Street, Sydney NSW 2000
Telephone: +61 2 9261 4188 Facsimile: +61 2 9241 4204
www.nce.com.au

Structural Engineer
Tucker Thomson Whitling Consulting Engineers
Level 3, 40 Darling Street, Sydney NSW 2000
Telephone: +61 2 9429 7296 Facsimile: +61 2 9429 2146
www.ttw.com.au

Materials
Refer to Appendix 2 - Materials Based on Drawings

PAVE1	GB1	CONC2	HP1	SL
PAVE2	GB2	TIM1	HP2	MS
PAVE3	GB1	TIM2	ST1	GL
PAVE4	GB2	TIM1	PT1	PG
PAVE5	GB3	TIM2	PT2	
PAVE6	GB3	TIM2	PT3	
ASPHLT	GB4	TIM2	BL1	
ST1	CONC1	SP1	TIM2	

Client
Campbell's Stores
Sydney Harbour

Notes
1. Drawings are based on As Built Drawings and Survey Information provided by S&B. It is the responsibility of the Client to ensure that the information is accurate and up to date.
2. Survey is a limited to 10m top to point and 10m to 10m.
3. Where the building has been demolished, the Client is responsible for ensuring that the building is demolished to the required level.
4. The Client is responsible for ensuring that the building is demolished to the required level.
5. The Client is responsible for ensuring that the building is demolished to the required level.

Revisions

No.	Date	App. Chg.	Revised by	Reason for Issue
1	10/08/16	AW	Wagman	Wagman to Sydney
2	20/08/16	AW	Wagman	Wagman to Bay 12

Scale / North Point
1:500 B1, 0.5 1 1.5 2.5m
1:1000 AS

Do not scale from drawing. Use marked dimensions to be read in conjunction with all other Consultant's drawings. The Architect is not responsible for any discrepancies. Copyright on this drawing established by the Architect.

Key Plan



Drawing Title
DETAIL SECTION 02- BAY 12

JPW Project Number
12006

Drawing Status
EA

Drawing Number
EA-A-013

Revision
B

