


DHL Logistics Facility

Badgerys Creek

Landscape SSDA Stage 1

Drawing Schedule

Drawing Number	Drawing Title	Scale
S1-000	Landscape Coversheet	N/A
S1-001	Material and Plant Schedule	N/A
S1-100	Landscape Masterplan	1:1200
S1-101	Landscape Plan - Lot 4	1:150
S1-102	Landscape Plan - Lot 4	1:150
S1-103	Landscape Plan - Lot 3	1:150
S1-104	Landscape Plan - Lot 3	1:150
S1-501	Landscape Details	As Shown
S1-502	Landscape Details	As Shown
S1-601	Landscape Sections	1:50
S1-602	Landscape Sections	1:50
S1-801	Landscape Lighting Concept - Lot 4	1:150
S1-802	Landscape Lighting Concept - Lot 3	1:150
S1-901	Existing Tree	1:1200
S1-902	Deep Soil	1:1200
S1-903	Canopy Cover	1:1200

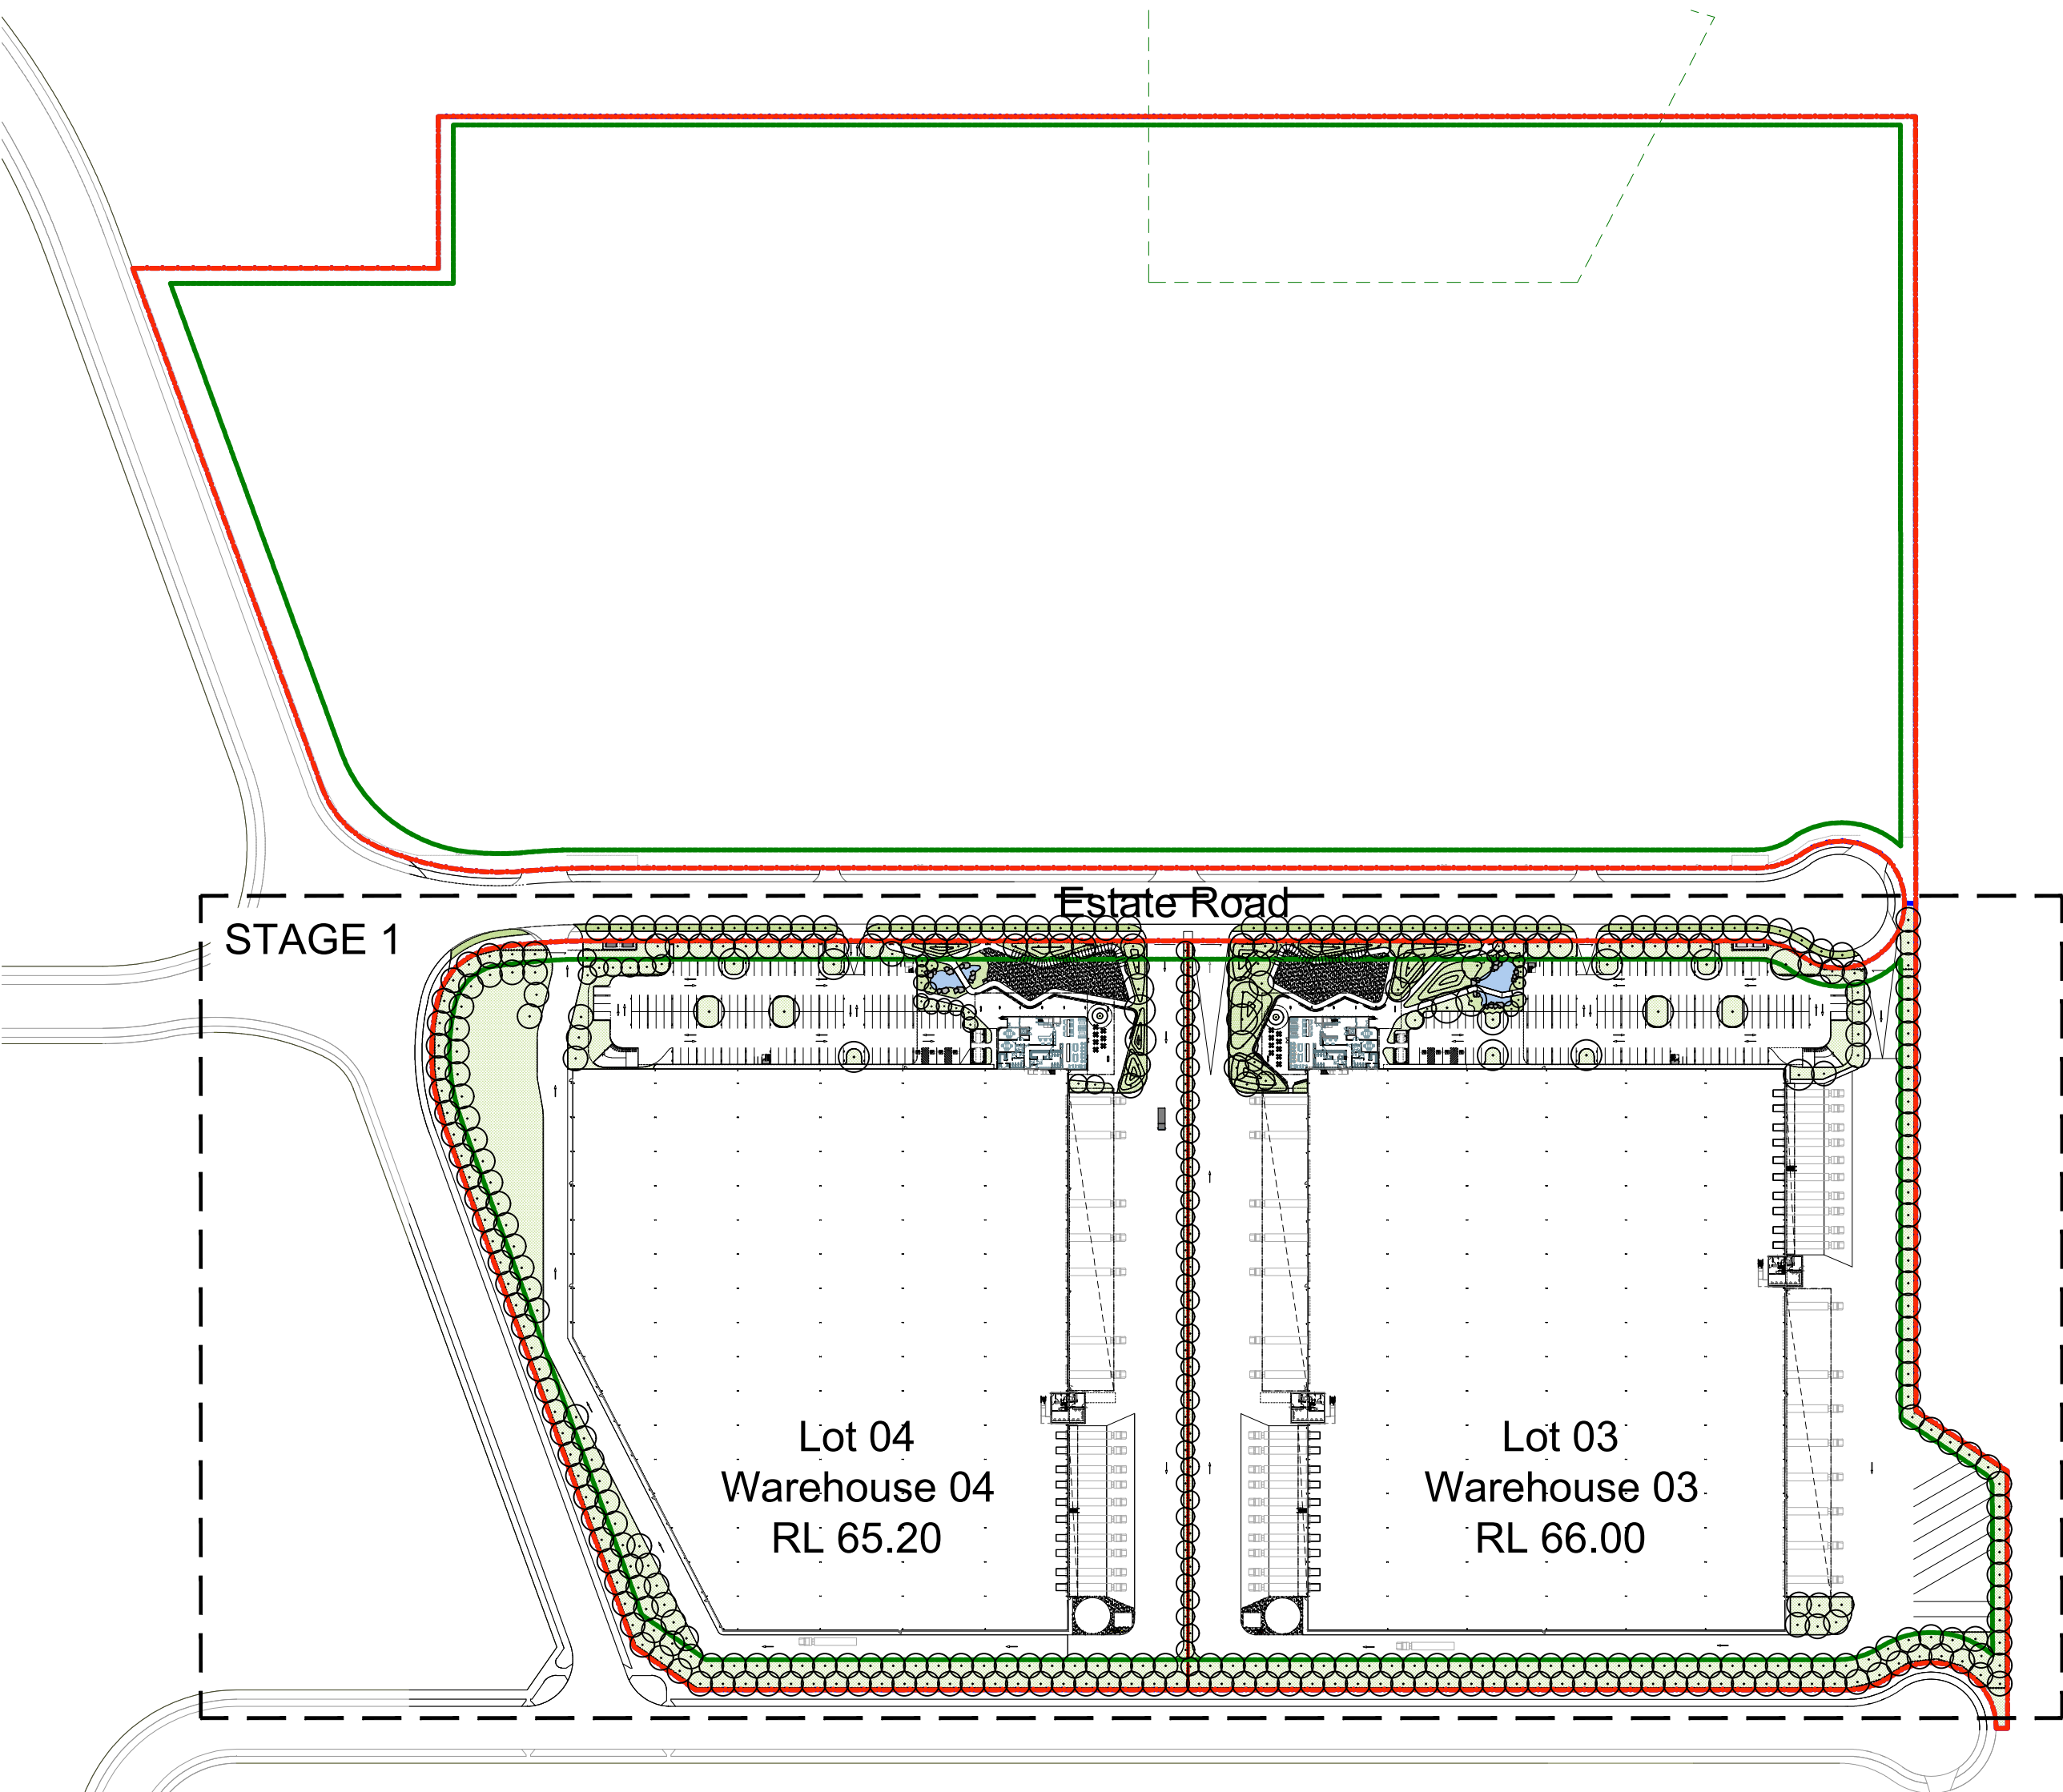


Site Plan | 1:2000

NOT FOR CONSTRUCTION

© 2021 Site Image (NSW) Pty Ltd. ABN 44 801 262 380 as agent for Site Image NSW Partnership. All rights reserved. This drawing is copyright and shall not be reproduced or copied in any form or by any means (graphic, electronic or mechanical including photocopy) without the written permission of Site Image (NSW) Pty Ltd. Any license, expressed or implied, to use this document for any purpose what so ever is restricted to the terms of the written agreement between Site Image (NSW) Pty Ltd and the instructing party.

The contractor shall check and verify all work on site (including work by others) before commencing the landscape installation. Any discrepancies are to be reported to the Project Manager or Landscape Architect prior to commencing work. Do not scale this drawing. Any required dimensions not shown shall be referred to the Landscape Architect for confirmation.

D	Architectural Coordination	RG	NM	03.10.2024
C	Architectural & Civil Coordination	RG	NM	23.09.2024
B	Architectural Coordination	RG	NM	16.05.2023
A	Architectural Coordination	RG	NM	01.03.2023
Issue	Revision Description	Drawn	Check	Date

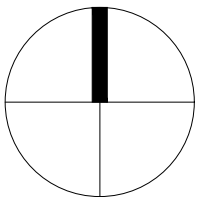

SITE IMAGE



Landscape Architects

Level 1, 3-5 Baptist Street
Radfern NSW 2016
Australia

Tel: (61 2) 8332 5600
Fax: (61 2) 9698 2877
www.siteimage.com.au

Client
DHL Supply Chain

Project
**DHL Logistics Facility
Badgerys Creek**

Drawing Name
Landscape Coversheet

Scale N/A
Job Number
SS22-4914

SSDA

Drawing Number
S1-000 Issue
D

General

	Property Boundary
	Stage Boundary
	Proposed Levels <i>To be read in conjunction with civil and architectural plans</i>
	Proposed Top of Wall Level <i>To be read in conjunction with civil and architectural plans</i>

Softworks

	Existing Tree to be Retained <i>Refer Arborist Report</i>
	Existing Tree to be removed <i>Refer Arborist Report</i>
	Proposed Street Trees <i>Refer Plant Schedule</i>
	Proposed Tree <i>Refer Plant Schedule</i>
	Proposed Shrub and Accent Planting <i>Refer Plant Schedule</i>
	Massed Grasses and Groundcovers
	Planting Mix Type 1 Mound Planting Matrix
	Planting Mix Type 2 WSUD Surround Planting Matrix
	Planting Mix Type 3 Street Verge Planting Matrix
	Planting Mix Type 4 General Planting Matrix
	Proposed Turf
	Deep Soil
	Canopy Cover

Materials & Furniture

	Edge Type 1 Flush Concrete Garden Edge
	Edge Type 2 Steel Edge
	Wall Type 1 In Situ Concrete
	Paving Type 1 Aggregate Concrete with Oxide
	Paving Type 2 Aggregate Concrete with Oxide
	Paving Type 3 Timber Decking TBC
	Furniture Type 1 Bench Seat with Back and Armrest Wall Mounted Mos Urban TBC
	Furniture Type 2 Cafe Dining Mos Urban TBC
	Furniture Type 5 Pergola TBC
	Fence Type 1 Security Palisade Fence 2100mm
	Handrail Type 1 TBC
	Boulders
	WSUD Water Feature

Lighting Types

	Bollard Light [3000K]
	Pole Top Light [3000K] TBC
	Recessed Wall Light [3000K]
	Garden Up Light on Stake [3000K]
	LED Strip Lighting [3000K]
	Down Light on Pergola [3000K]

Proposed Plant Schedule

	Botanic Name	Common Name	Mature Size		Pot Size	Density	Native \ Exotic
			Height	Spread			
STREET TREES							
TREES							
Ame	Acacia melanoxylon	Blackwood	15m	8m	100L	As Shown	N
Bac	Brachychiton acerifolius*	Illawarra Flame Tree	12m	6m	100L	As Shown	N
Bmy	Backhousia myrtifolia*	Cinnamon Myrtle	7m	4m	100L	As Shown	N
Bpo	Brachychiton populneus	Kurrajong	12m	5m	100L	As Shown	N
Cap	Ceratopetalum apetalum*	Coachwood	20m		200L	As Shown	N
Cau	Celtis australis	European nettle tree	14m	10m	200L	As Shown	E
Ctr	Cryptocarya triplinervis*	Three-veined Laurel	15m		200L	As Shown	N
Ere	Elaeocarpus reticulatus*	Blueberry Ash	9m	4m	100L	As Shown	N
Gbi	Ginkgo biloba	Ginkgo	11m	5m	100L	As Shown	E
Hfl	Hymenosporum flavum	Native frangipani	10m	5m	100L	As Shown	N
Hpe	Harpullia pendula*	Tulipwood	6m	4m	100L	As Shown	N
Psi	Pistacia sinensis	Chinese pistachio	8m	5m	100L	As Shown	E
San	Syzygium anisatum*	Aniseed myrtle	15m	8m	200L	As Shown	N
Ssi	Stenocarpus sinuatus	Firewheel tree	25m	8m	200L	As Shown	N

BOUNDARY PLANTING

TREES							
Aan	<i>Arbutus andrachnoides</i>	Grecian Strawberry tree	7m	7m	100L	As Shown	E
Ahi	<i>Angophora hispida</i> *	Dwarf Apple Gum	6m	4m	100L	As Shown	N
Bci	<i>Backhousia citriodora</i> *	Lemon Myrtle	8m	4m	100L	As Shown	N
Bmy	<i>Backhousia myrtifolia</i> *	Cinnamon Myrtle	7m	4m	100L	As Shown	N
Bpo	<i>Brachychiton populneus</i>	Kurrajong	12m	5m	100L	As Shown	N
Ere	<i>Elaeocarpus reticulatus</i> *	Blueberry Ash	9m	4m	100L	As Shown	N
Gtr	<i>Gleditsia triacanthos</i> 'Shademaster'	Honey locust	10m	8m	100L	As Shown	E
Ltu	<i>Liriodendron tulipifera</i>	Tulip tree	15m	7m	100L	As Shown	E
PeI	<i>Podocarpus elatus</i>	Plum pine	10m	6m	100L	As Shown	N

ON-LOT PLANTING

TREES							
Aex	Alphitonia excelsa*	Red ash	15m	8m	200L	As Shown	N
Aan	Arbutus andrachnoides	Grecian Strawberry tree	7m	7m	100L	As Shown	E
Bci	Backhousia citriodora*	Lemon Myrtle	8m	4m	200L	As Shown	N
Bpo	Brachychiton populneus	Kurrajong	12m	5m	200L	As Shown	N
Can	Cupaniopsis anacardioides*	Tuckeroo	8m	6m	100L	As Shown	N
Cca	Calodendrum capense	Cape chestnut	10m	10m	100L	As Shown	E
Eac	Ehretia acuminata*	Koda	10m	8m	100L	As Shown	N
Ere	Elaeocarpus reticulatus*	Blueberry Ash	9m	4m	100L	As Shown	N
Gbi	Ginkgo biloba	Ginkgo	11m	5m	100L	As Shown	E
Qil	Quercus ilex	Holm oak	20m	12m	200L	As Shown	E
Wfl	Waterhousea floribunda*	Weeping Lilly pilli	13m	10m	200L	As Shown	N
Zse	Zelkova serrata	Japanese Zelkova	11m	9m	100L	As Shown	E

ON-LOT CARPARK PLANTING

TREES							
Ahi	<i>Angophora hispida</i> *	Dwarf Apple Gum	6m	4m	100L	As Shown	N
Bpo	<i>Brachychiton populneus</i>	Kurrajong	12m	5m	100L	As Shown	N
Cca	<i>Calodendrum capense</i>	Cape chestnut	10m	10m	100L	As Shown	E
Gtr	<i>Gleditsia triacanthos</i> 'Shademaster'	Honey locust	10m	8m	100L	As Shown	E
Hpe	<i>Harpullia pendula</i>	Tulipwood	8m	6m	100L	As Shown	N
Hti	<i>Hibiscus tiliaceus</i> *	Native Hibiscus	5m	4m	100L	As Shown	N
Wfl	<i>Waterhouseia floribunda</i> *	Weeping Lilly pilli	13m	10m	100L	As Shown	N

SHRUBS & ACCENTS

Af	Acacia flexifolia	Bent-leaf Wattle	1.5	2	300mm	As Shown	
An	Atriplex nummularia	Old man saltbush	3	4	300mm	As Shown	N
Bs	Billardiera scandens	Common Apple Berry	1.5	3	300mm	As Shown	N
Cp	Callistemon pallidus	Lemon Bottlebrush	3	2	300mm	As Shown	
De	Doryanthes excelsa	Gymea Lily	3	0.3	300mm	As Shown	
LWR	Leucadendron salignum 'Winter Red'	Conebush	1.2	1.8	300mm	As Shown	
Mt	Melaleuca thymifolia	Honey Myrtle	1.2	2	300mm	As Shown	
OdR	Ozothamnus diosmifolius 'Radiance'	Rice Flower	2	1.2	300mm	As Shown	
WGB	Westringia fruticosa 'Grey Box'		0.5	0.5	300mm	As Shown	

GRASSES & GROUND COVERS

As	Acrotiche serrulata	Honey Pots	0.3	1	150mm	5/m2	N
ACC	Adenanthos cuneatus 'Coral Carpet'				150mm	5/m2	
ALS	Anigozanthos flavidus 'Landscape Scarlet'	Kangaroo Paw			150mm	5/m2	
Ah	Astroloma humifusum	Cranberry Heath	0.5	1.5	150mm	5/m2	N
Dc	Dianella caerulea				150mm	5/m2	
DLR	Dianella revoluta 'Little Rev'				150mm	5/m2	
Dr	Dichondra repens				150mm	5/m2	
Ju	Juncus usitatus				150mm	5/m2	
Lf	Lomandra fluviatilis 'ABU'				150mm	5/m2	
Lh	Lomandra hystrix				150mm	5/m2	
LT	Lomandra longifolia 'Tanika'				150mm	5/m2	
PE	Poa labillardieri 'Eskdale'				150mm	5/m2	
Rs	Rhagodia spinescens				150mm	5/m2	
WFF	Westringia fruticosa 'Flat 'n' Fruity'				150mm	5/m2	

Planting species adopted from Northern Gateway Public Domain and Landscape Strategy (Issue B)

Prepared by CLOUSTON Associates dated 30th November 2021

PCC Penrith City Council preferred species list

NOT FOR CONSTRUCTION

© 2021 Site Image (NSW) Pty Ltd. ABN 44 801 262 380 as agent for Site Image NSW Partnership. All rights reserved. This drawing is copyright and shall not be reproduced or copied in any form or by any means (graphic, electronic or mechanical including photocopy) without the written permission of Site Image (NSW) Pty Ltd Any license, expressed or implied, to use this document for any purpose what so ever is restricted to the terms of the written agreement between Site Image (NSW) Pty Ltd and the instructing party.

The contractor shall check and verify all work on site (including work by others) before commencing the landscape installation. Any discrepancies are to be reported to the Project Manager or Landscape Architect prior to commencing work. Do not scale this drawing. Any required dimensions not shown shall be referred to the Landscape Architect for confirmation.

C	Architectural & Civil Coordination
B	Architectural Coordination
A	Architectural Coordination
Issue	Revision Description

RG	NM	23.09.2024
RG	NM	16.05.2023
RG	NM	01.03.2023
Drawn	Check	Date

SITE IMAGE



Landscape Architects
Level 1, 3-5 Baptist Street
Redfern NSW 2016
Australia
Tel: (61 2) 8332 5600
Fax: (61 2) 9698 2877
www.siteimage.com.au


Client
DHL Supply Chain

Project
DHL Logistics Facility
Badgerys Creek

Drawing Name
Material and Plant Schedule

SSDA

Scale N/A
Job Number
Drawing Number
Issue
SS22-4914
S1-001 C

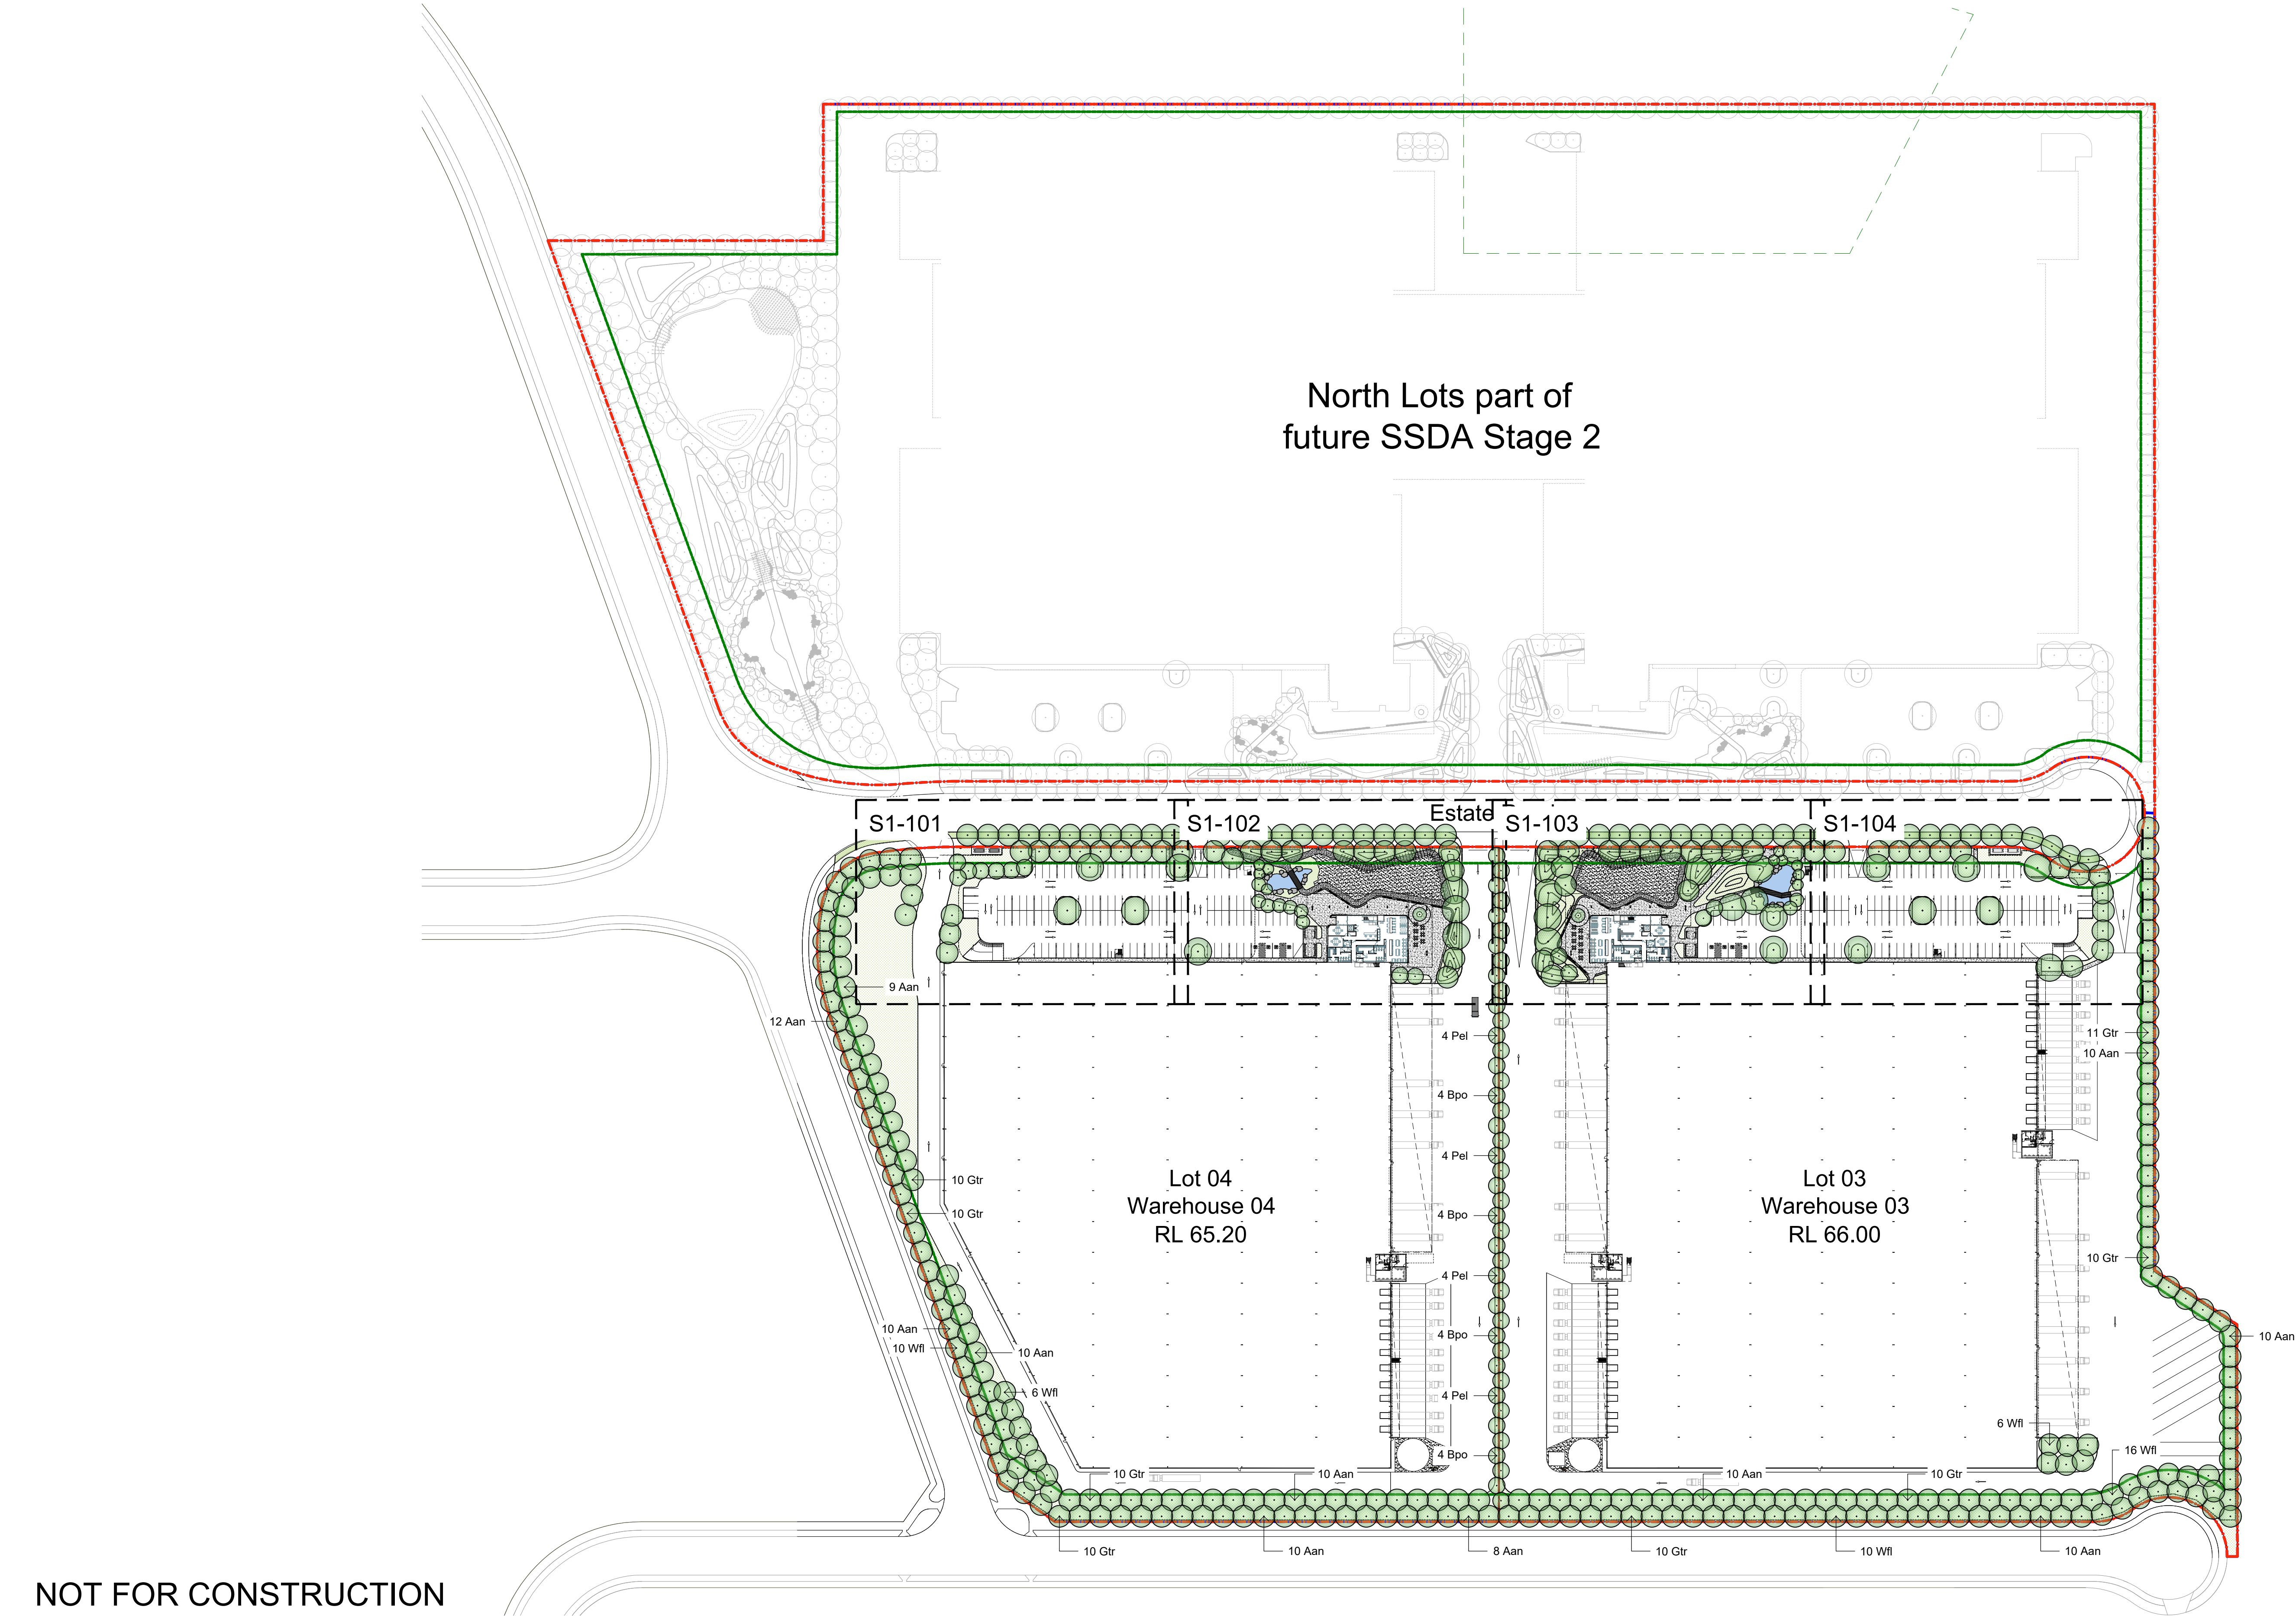

NOT FOR CONSTRUCTION

© 2021 Site Image (NSW) Pty Ltd. ABN 44 801 262 380 as agent for Site Image NSW Partnership. All rights reserved. This drawing is copyright and shall not be reproduced or copied in any form or by any means (graphic, electronic or mechanical including photocopy) without the written permission of Site Image (NSW) Pty Ltd. Any license, expressed or implied, to use this document for any purpose what so ever is restricted to the terms of the written agreement between Site Image (NSW) Pty Ltd and the instructing party.

The contractor shall check and verify all work on site (including work by others) before commencing the landscape installation. Any discrepancies are to be reported to the Project Manager or Landscape Architect prior to commencing work. Do not scale this drawing. Any required dimensions not shown shall be referred to the Landscape Architect for confirmation.

D	Architectural Coordination	RG	NM	03.10.2024
C	Architectural & Civil Coordination	RG	NM	23.09.2024
B	Architectural Coordination	RG	NM	16.05.2023
A	Architectural Coordination	RG	NM	01.03.2023
Issue	Revision Description	Drawn	Check	Date

Legend Refer Drawing S1-001

SITE IMAGE



Landscape Architects
Level 1, 3-5 Baptist Street
Redfern NSW 2016
Australia
Tel: (61 2) 8332 5600
Fax: (61 2) 9698 2877
www.siteimage.com.au


Client
DHL Supply Chain

Project
DHL Logistics Facility
Badgerys Creek

Drawing Name
Landscape Masterplan

SSDA
Scale 1:1200 @ A1
Job Number
SS22-4914

Drawing Number
S1-100
Issue
D

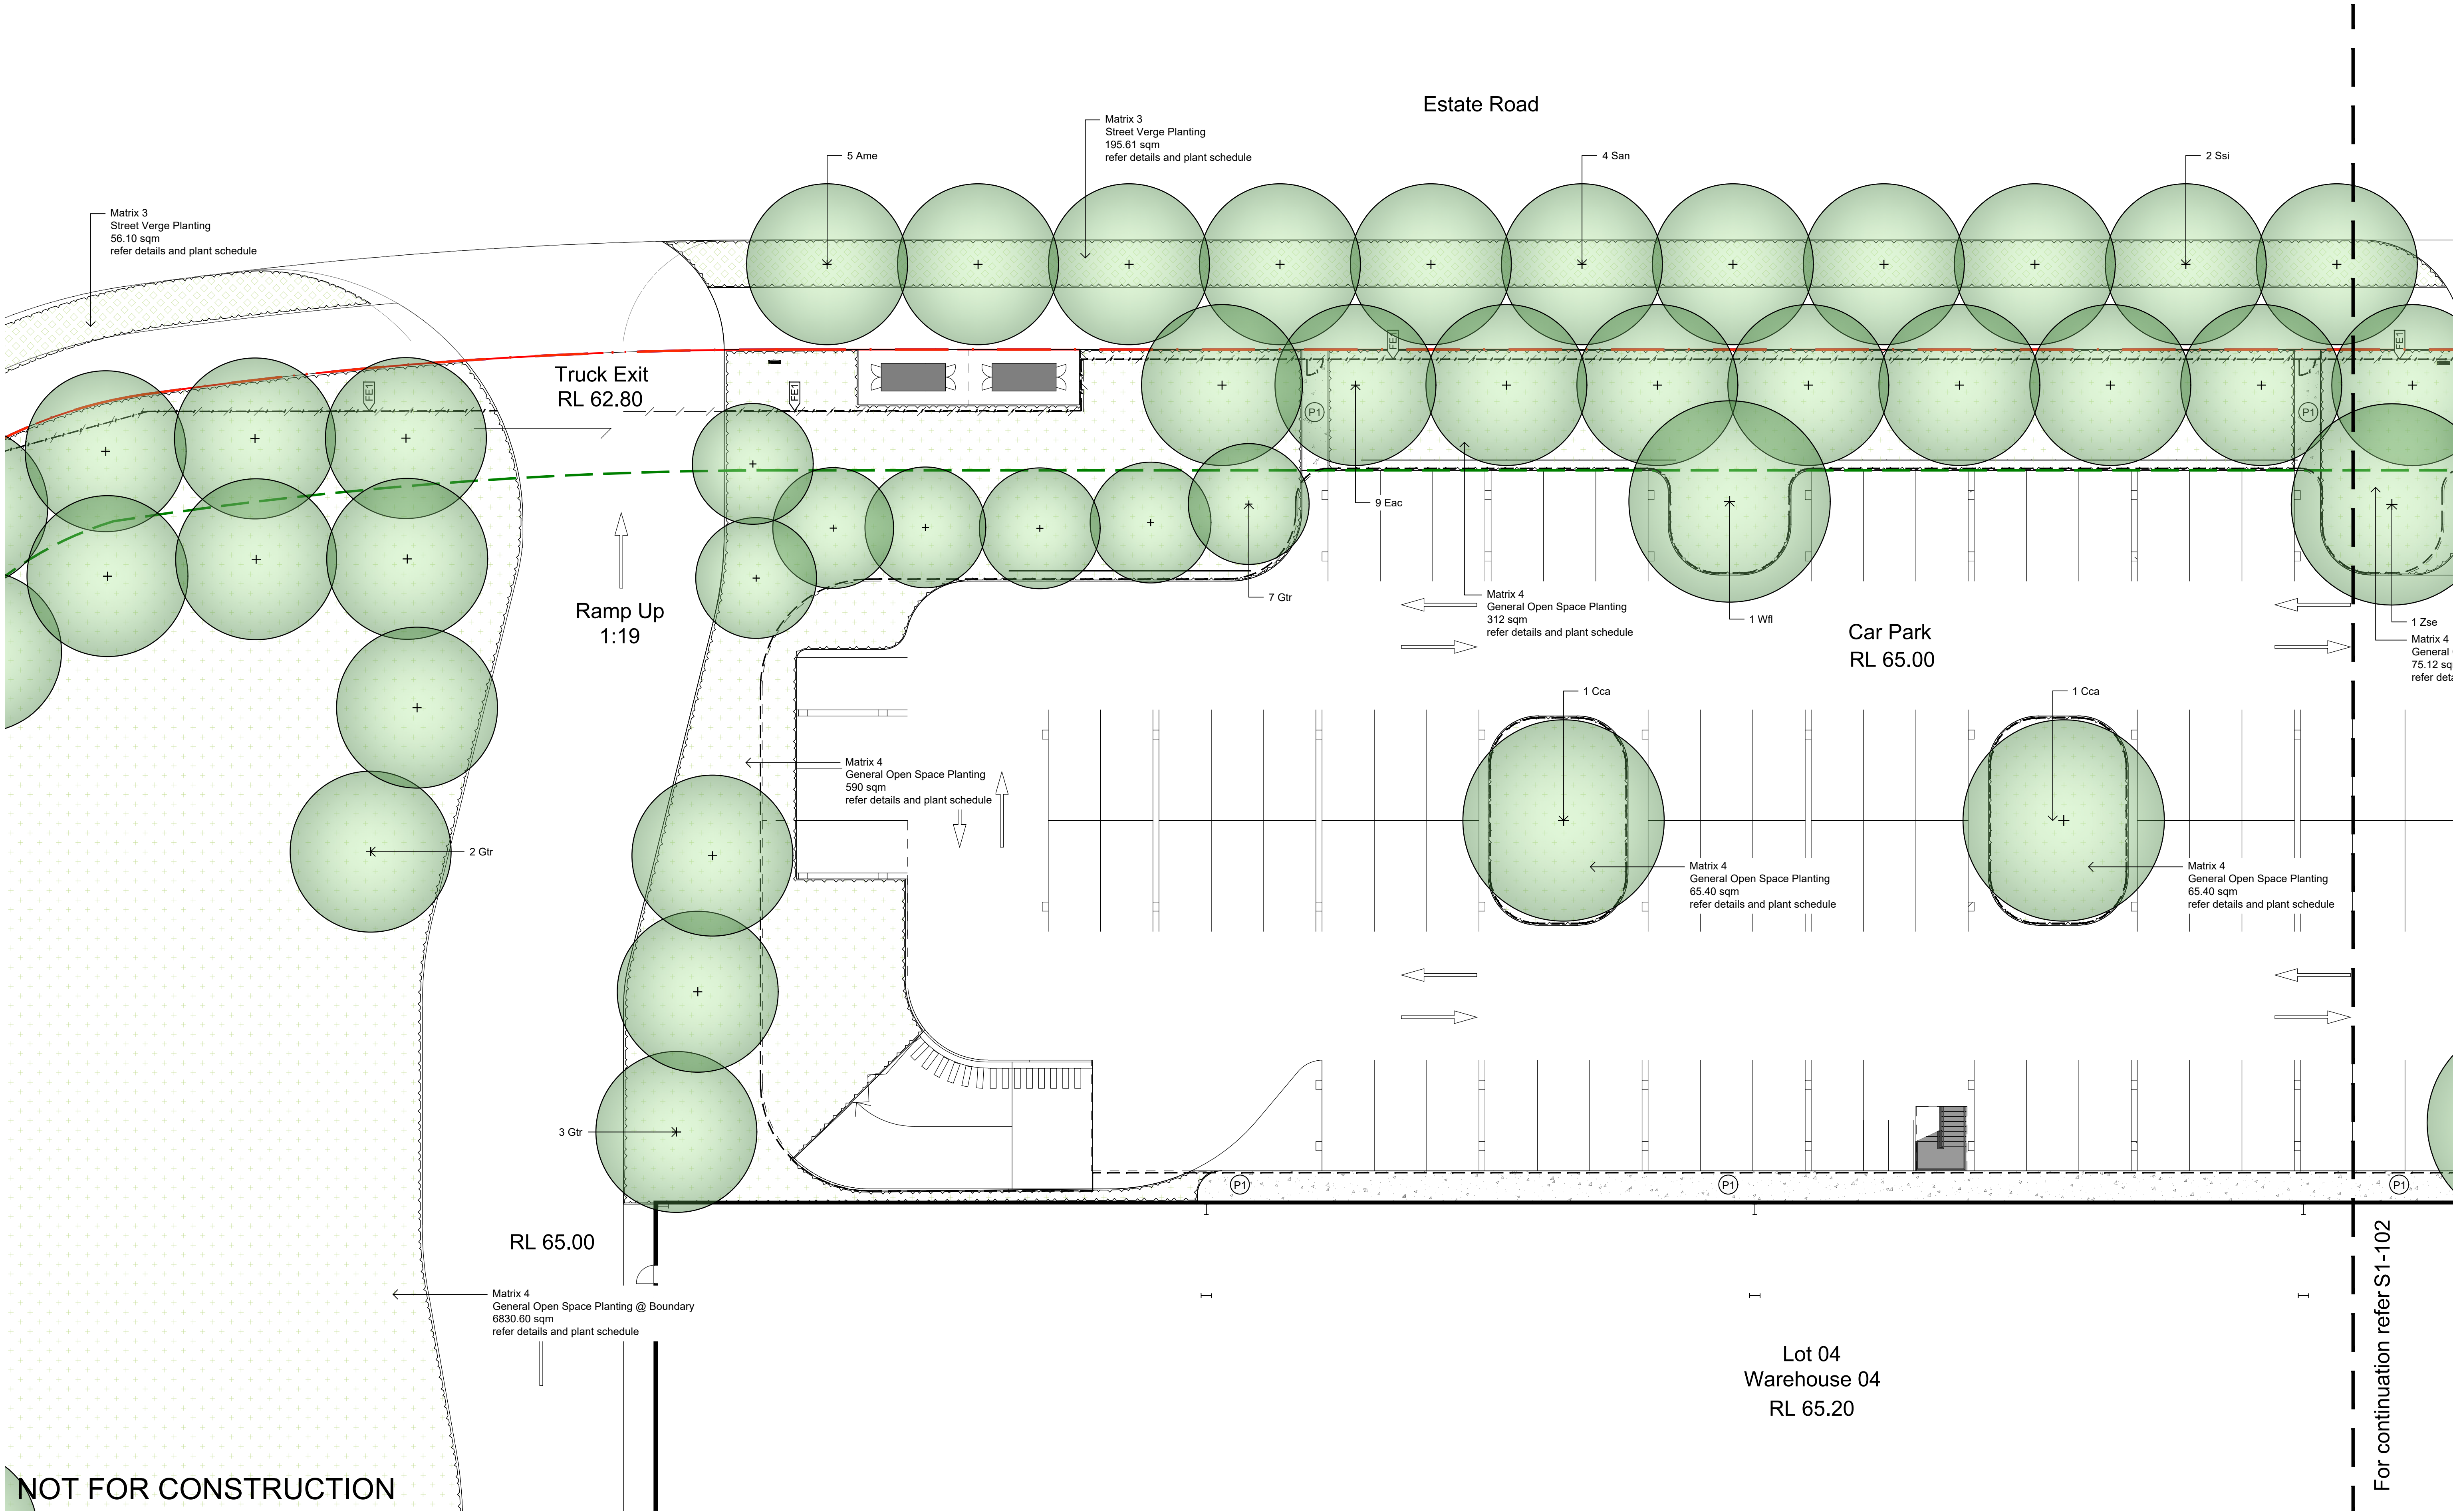

NOT FOR CONSTRUCTION

© 2021 Site Image (NSW) Pty Ltd. ABN 44 801 262 380 as agent for Site Image NSW Partnership. All rights reserved. This drawing is copyright and shall not be reproduced or copied in any form or by any means (graphic, electronic or mechanical including photocopy) without the written permission of Site Image (NSW) Pty Ltd. Any license, expressed or implied, to use this document for any purpose what so ever is restricted to the terms of the written agreement between Site Image (NSW) Pty Ltd and the instructing party.

The contractor shall check and verify all work on site (including work by others) before commencing the landscape installation. Any discrepancies are to be reported to the Project Manager or Landscape Architect prior to commencing work. Do not scale this drawing. Any required dimensions not shown shall be referred to the Landscape Architect for confirmation.

D	Architectural Coordination	RG	NM	03.10.2024
C	Architectural & Civil Coordination	RG	NM	23.09.2024
B	Architectural Coordination	RG	NM	16.05.2023
A	Architectural Coordination	RG	NM	01.03.2023
Issue	Revision Description	Drawn	Check	Date

Legend Refer Drawing S1-001

SITE IMAGE
Landscape Architects
Level 1, 3-5 Baptist Street
Redfern NSW 2016
Australia
Tel: (61 2) 8332 5600
Fax: (61 2) 9698 2877
www.siteimage.com.au

Client
DHL Supply Chain
Project
DHL Logistics Facility
Badgerys Creek

Drawing Name
Landscape Plan
Lot 4

Scale 1:150 @ A1
Job Number
SS22-4914

SSDA
0 1 2 3 4 5m
Drawing Number

S1-101 D



The contractor shall check and verify all work on site (including work by others) before commencing the landscape installation. Any discrepancies are to be reported to the Project Manager or Landscape Architect prior to commencing work. Do not scale this drawing. Any required dimensions not shown shall be referred to the Landscape Architect for confirmation.


C	Architectural & Civil Coordination	RG	NM	23.09.2024
B	Architectural Coordination	RG	NM	16.05.2023
A	Architectural Coordination	RG	NM	01.03.2023
Issue	Revision Description	Drawn	Check	Date

Tel: (61 2) 8332 5600
Fax: (61 2) 9698 2877
www.siteimage.com.au

Project
DHL Logistics Facility
Badgerys Creek

Job Number

S1-102 C

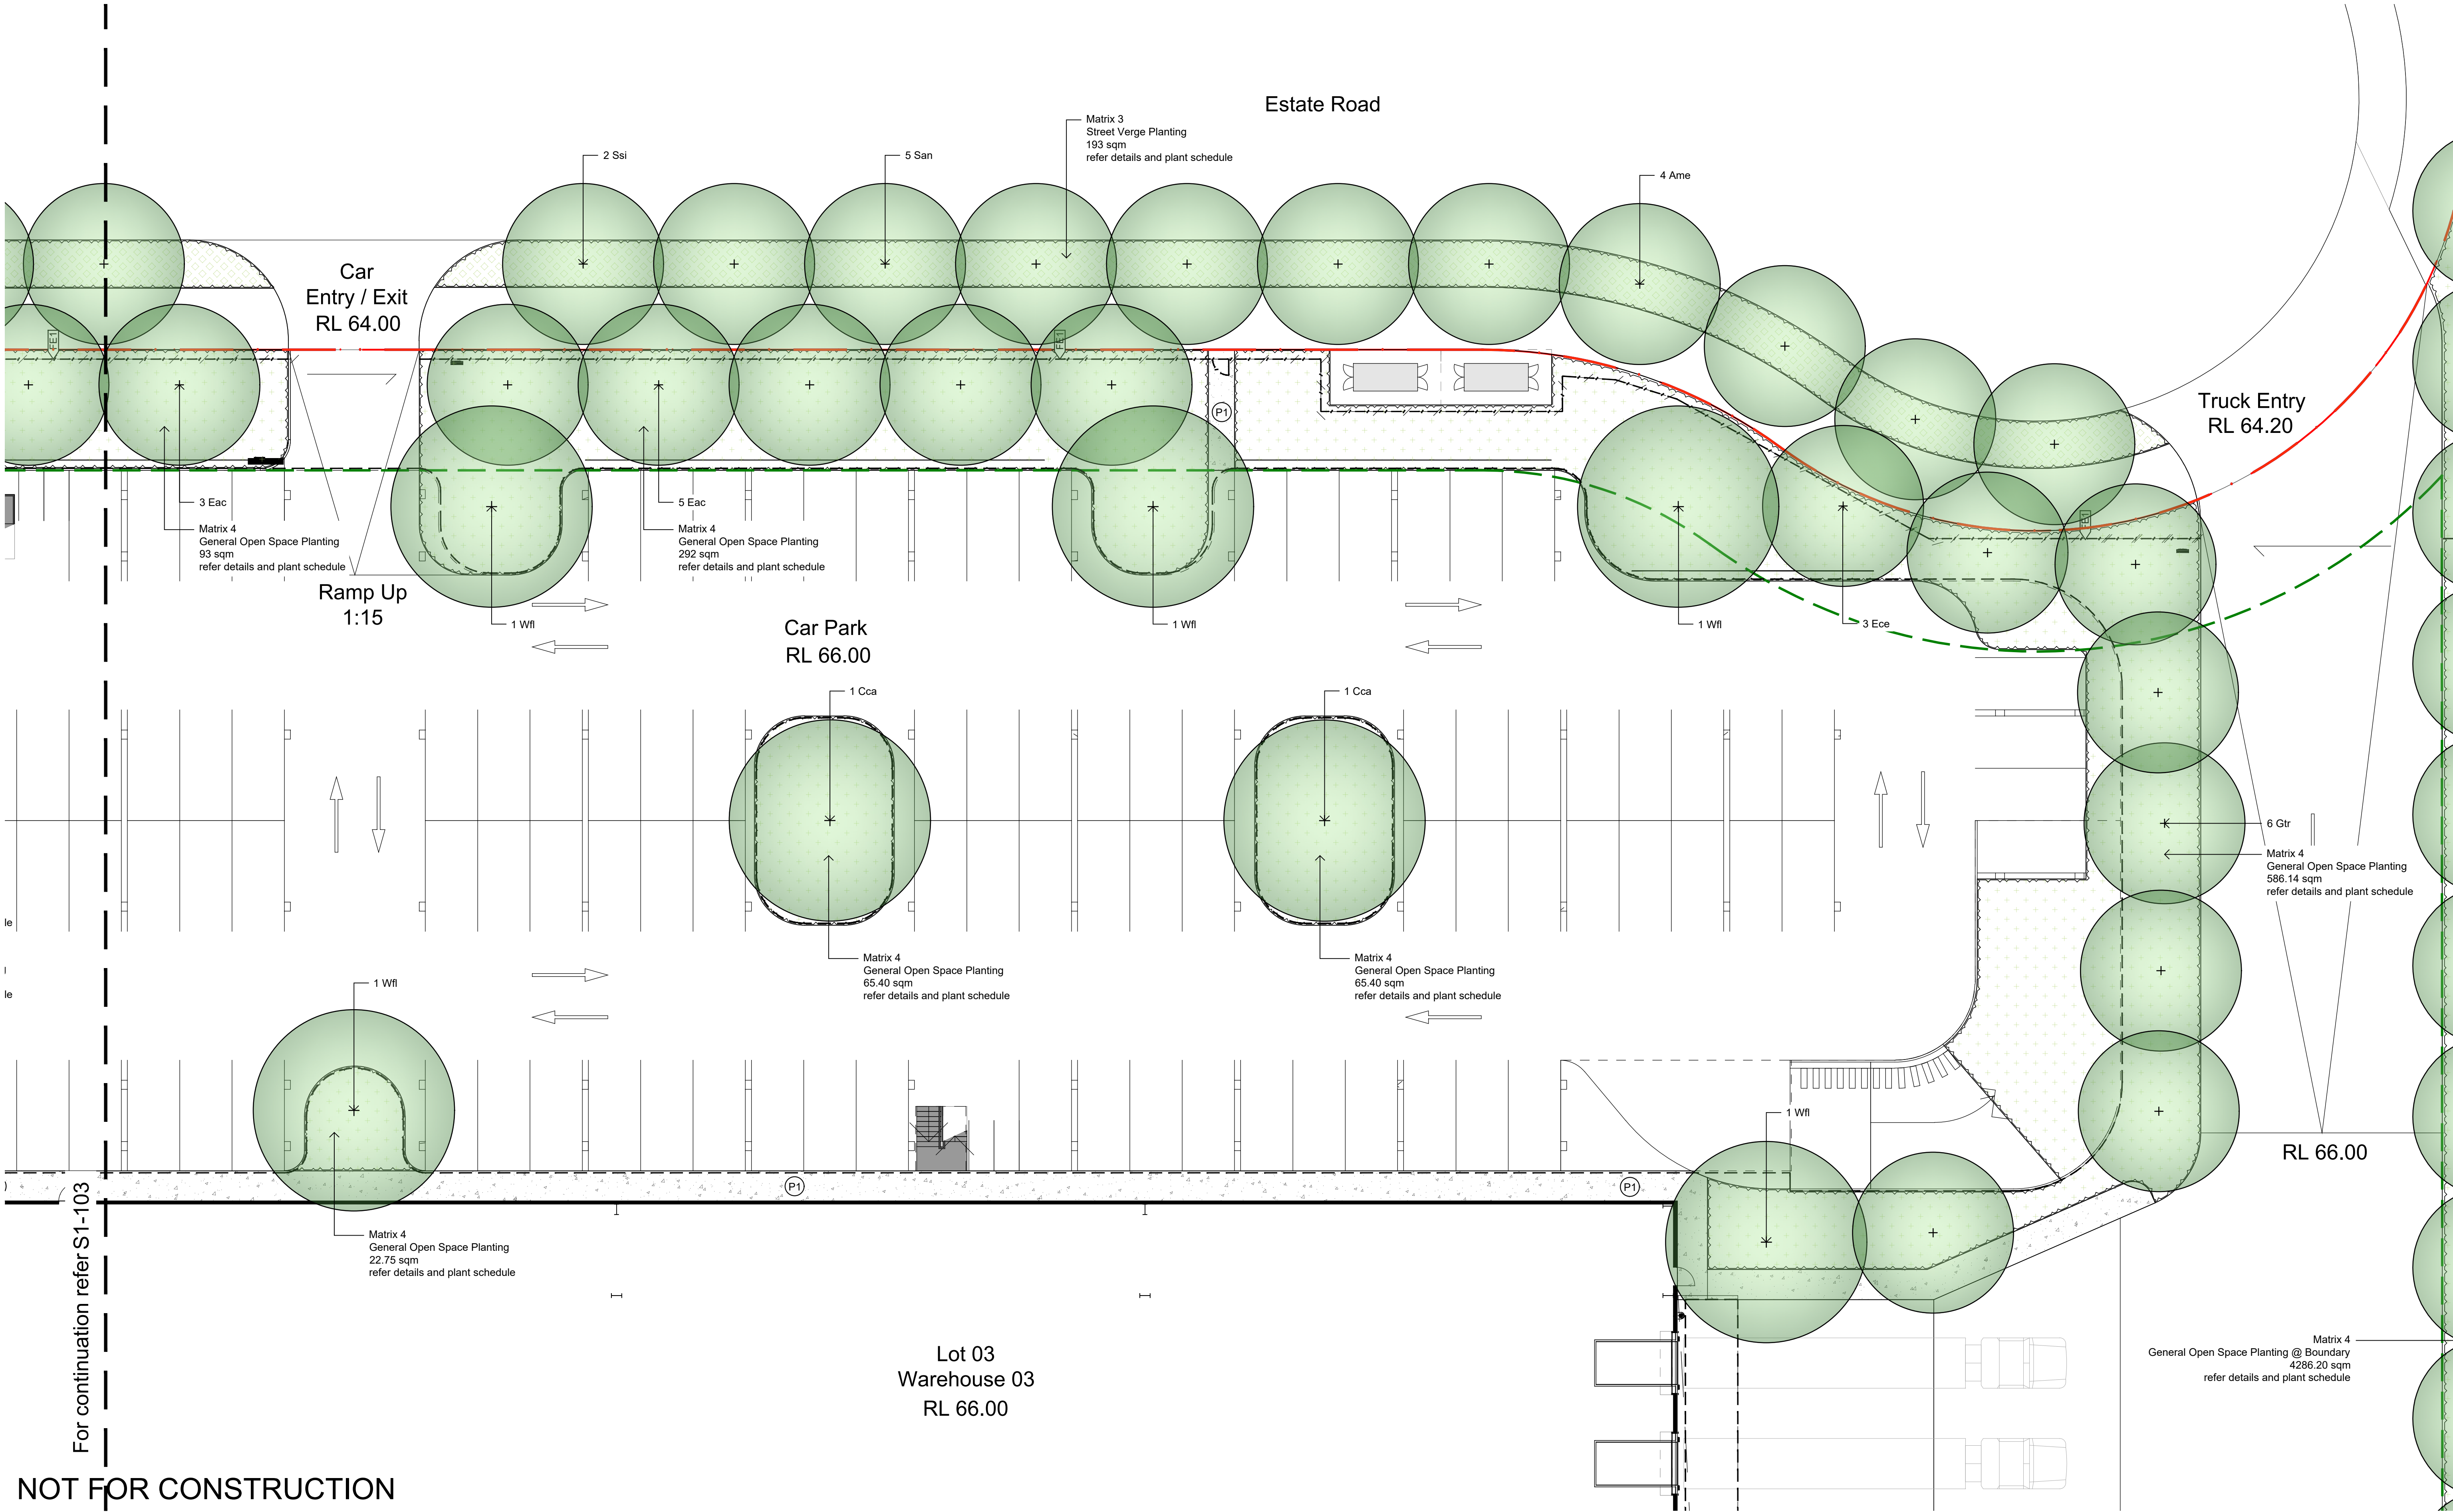


NOT FOR CONSTRUCTION

© 2021 Site Image (NSW) Pty Ltd. ABN 44 801 262 380 as agent for Site Image NSW Partnership. All rights reserved. This drawing is copyright and shall not be reproduced or copied in any form or by any means (graphic, electronic or mechanical including photocopying) without the written permission of Site Image (NSW) Pty Ltd. Any license, expressed or implied, to use this document for any purpose whatsoever is restricted to the terms of the written agreement between Site Image (NSW) Pty Ltd and the instructing party.

The contractor shall check and verify all work on site (including work by others) before commencing the landscape installation. Any discrepancies are to be reported to the Project Manager or Landscape Architect prior to commencing work. Do not scale this drawing. Any required dimensions not shown shall be referred to the Landscape Architect for confirmation.

D	Architectural Coordination	RG	NM	03.10.2024
C	Architectural & Civil Coordination	RG	NM	23.09.2024
B	Architectural Coordination	RG	NM	16.05.2023
A	Architectural Coordination	RG	NM	01.03.2023
Issue	Revision Description	Drawn	Check	Date

Legend Refer Drawing S1-001

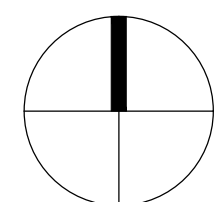

SITE IMAGE
Landscape Architects
Level 1, 3-5 Baptist Street
Redfern NSW 2016
Australia
Tel: (61 2) 8332 5600
Fax: (61 2) 9698 2877
www.siteimage.com.au

Client
DHL Supply Chain


Project
**DHL Logistics Facility
Badgerys Creek**

Drawing Name
**Landscape Plan
Lot 3**

Scale 1:150 @ A1
Job Number
SS22-4914


SSDA
0 1 2 3 4 5m
Drawing Number
S1-104

Issue
D

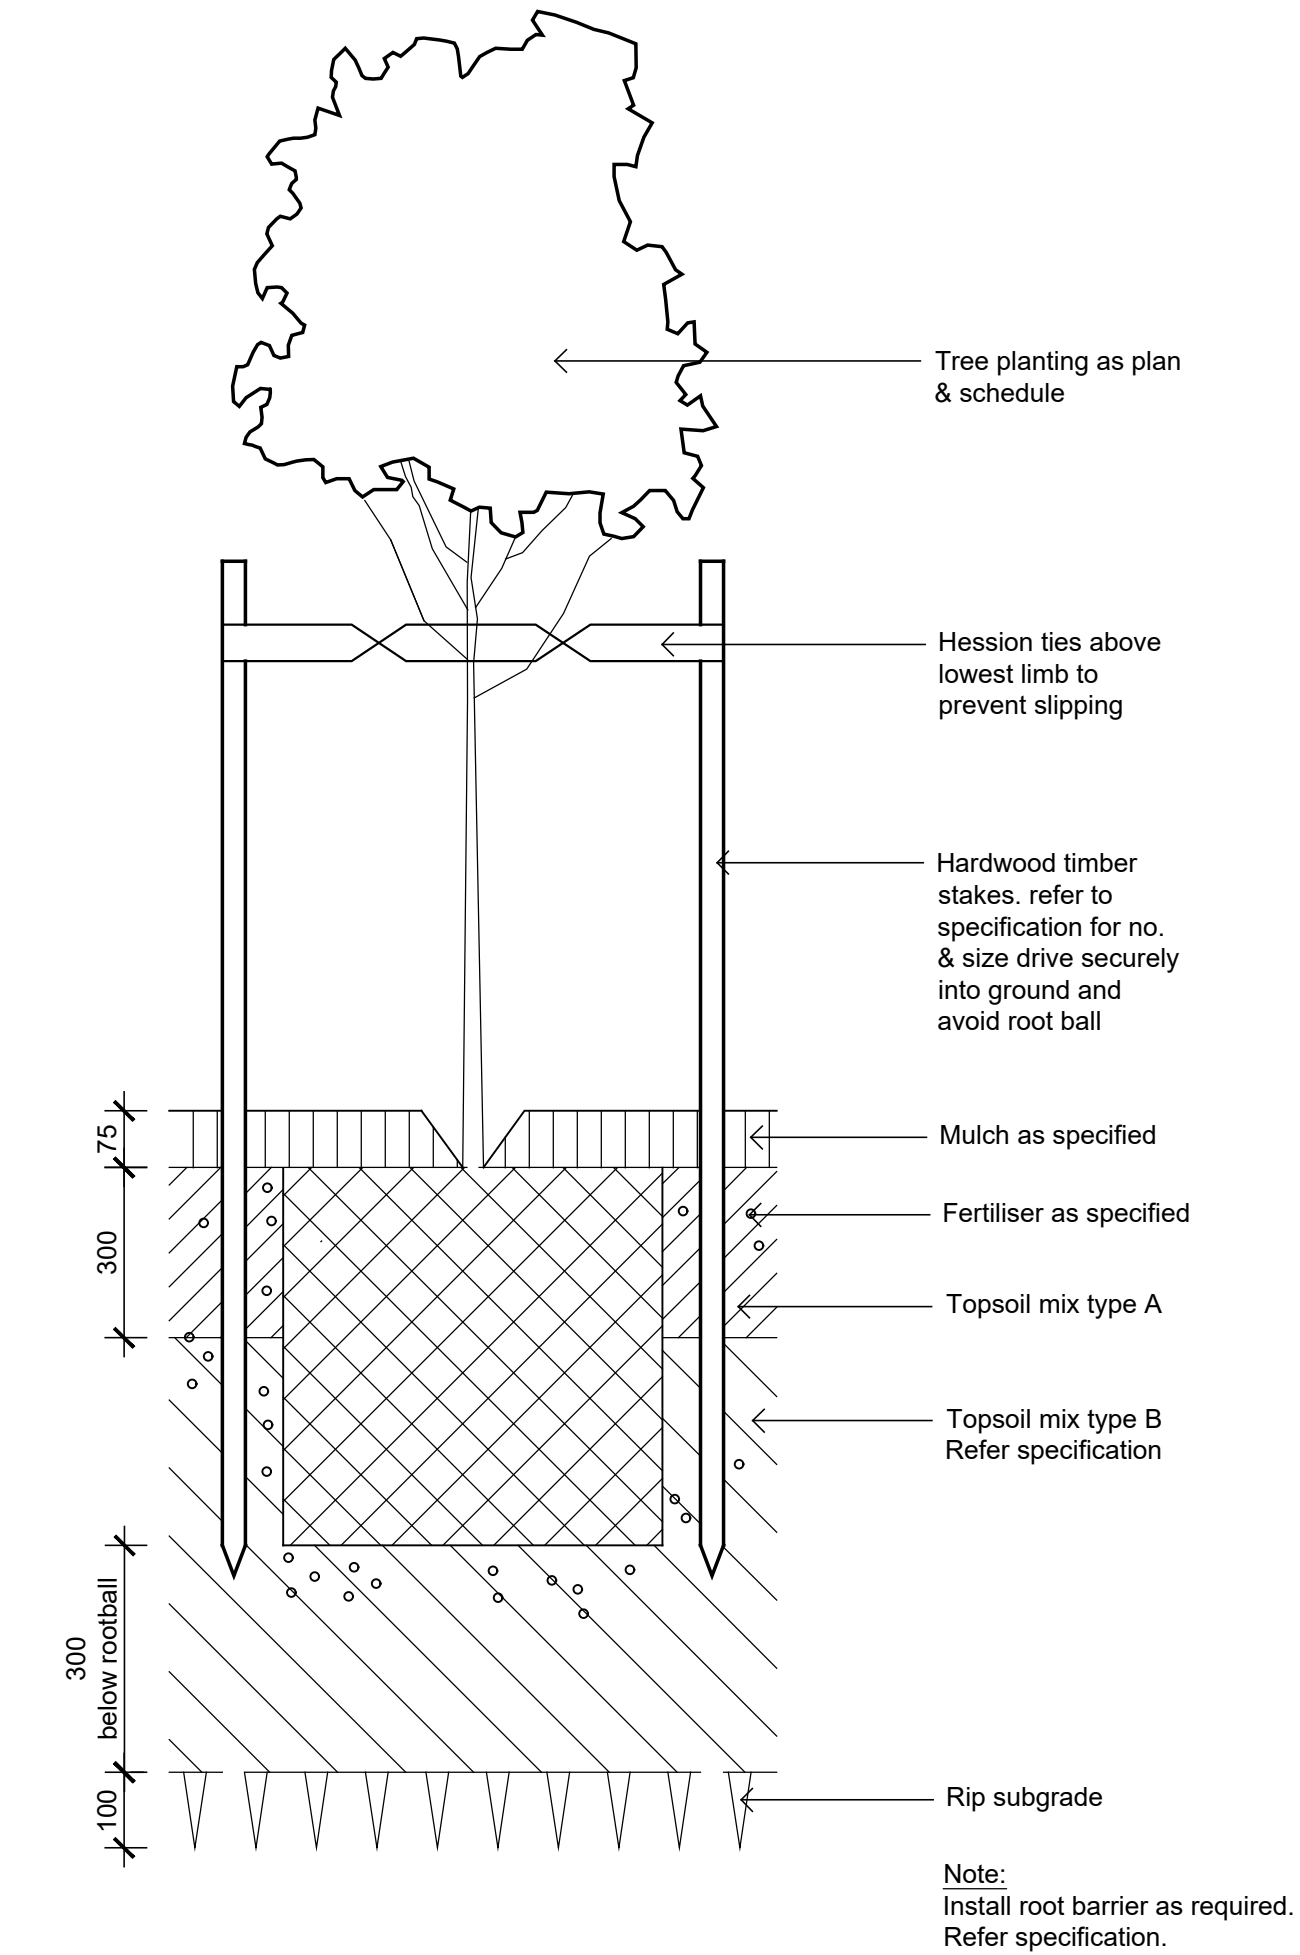


01 Detail 75-200L Tree Planting on Grade

1:10

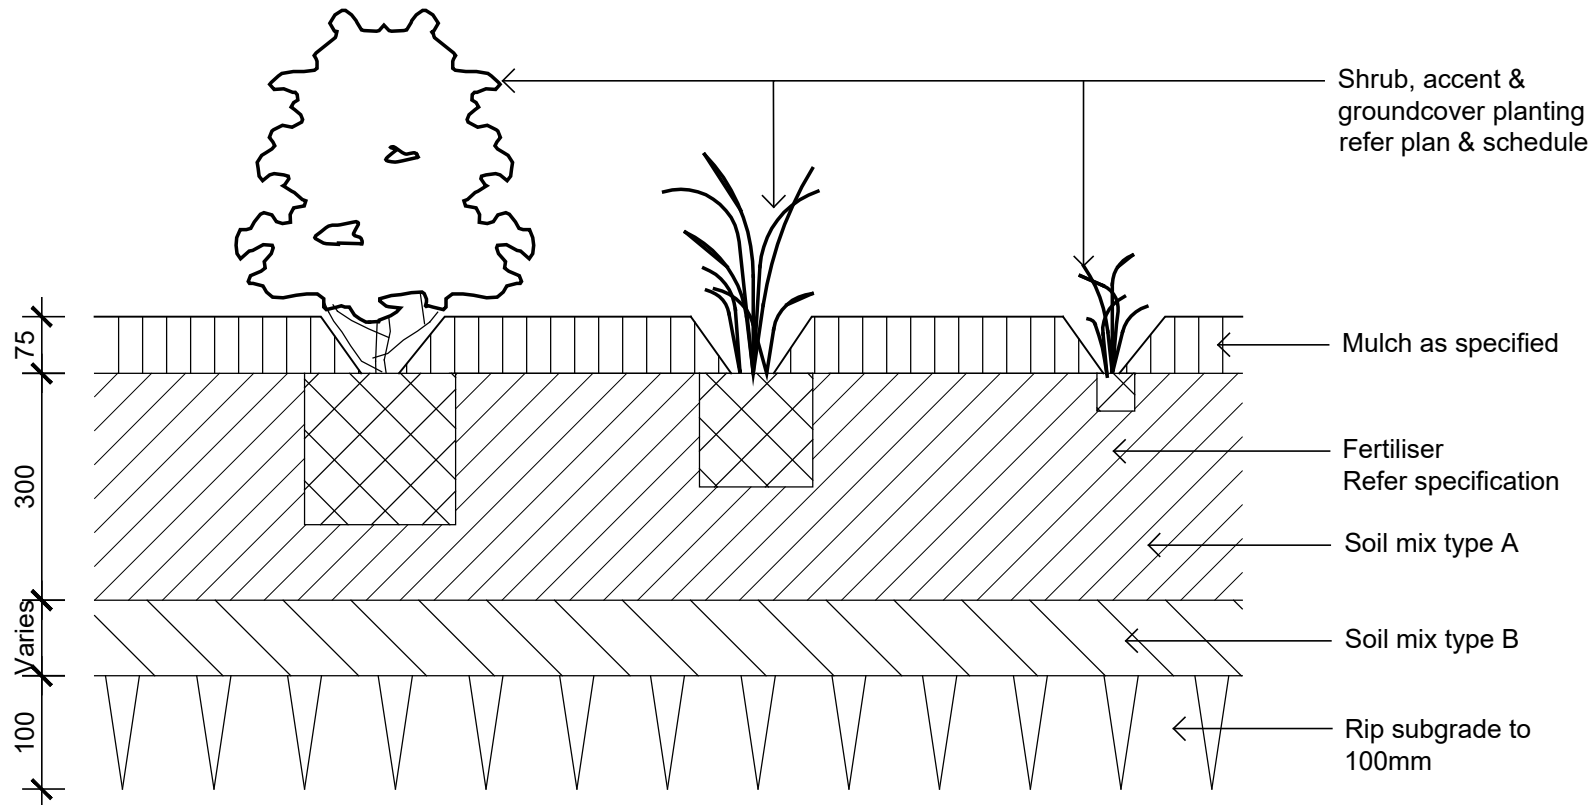


02 Detail Shrub Accent & Groundcover Planting on Grade

1:10

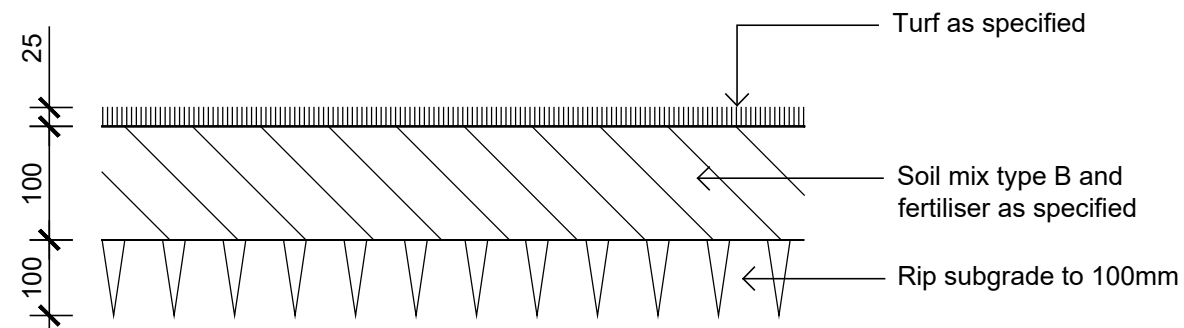


03 Detail Turf on Even Grade

1:10

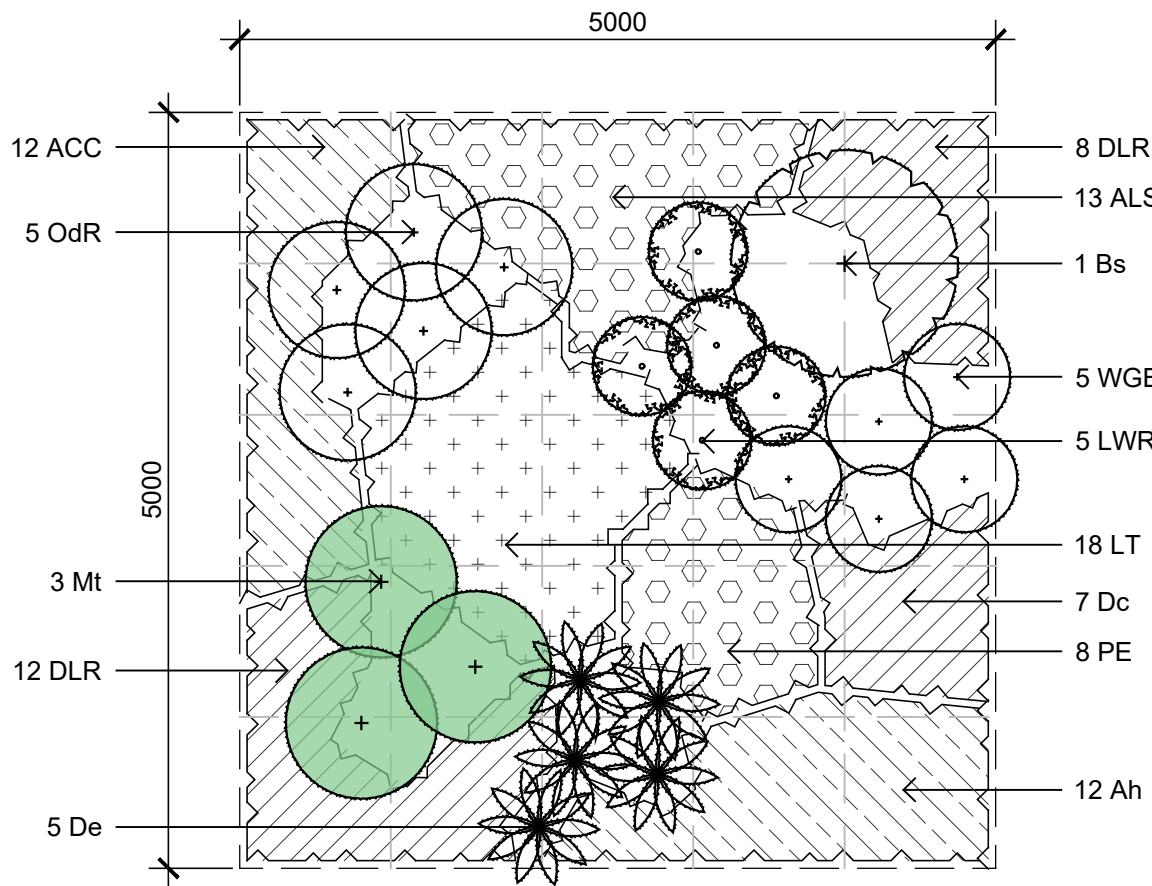


Planting Matrix 1 - Mound Planting

1:50

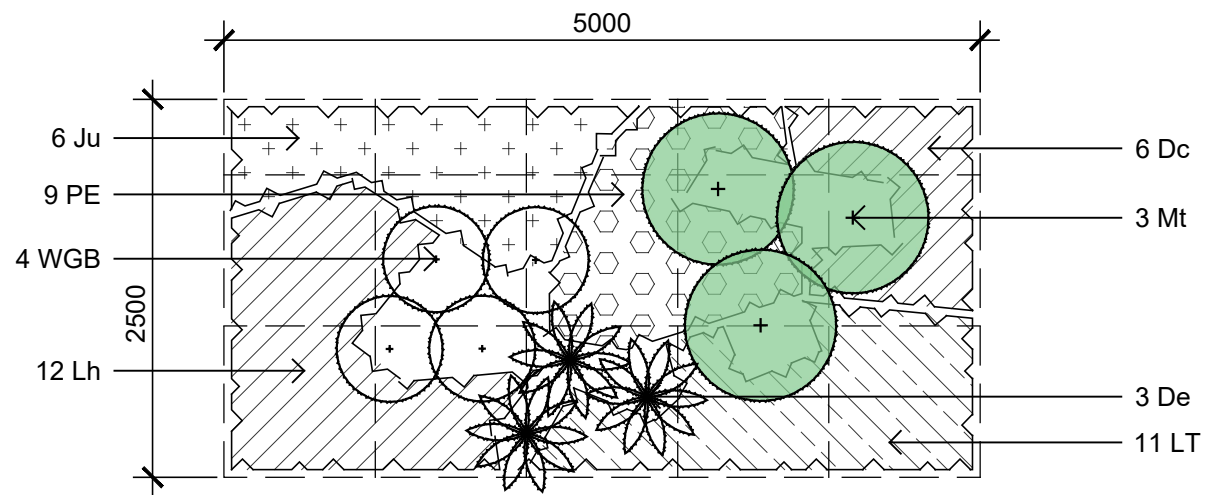


Planting Matrix 2 - WSUD Surrounds

1:50

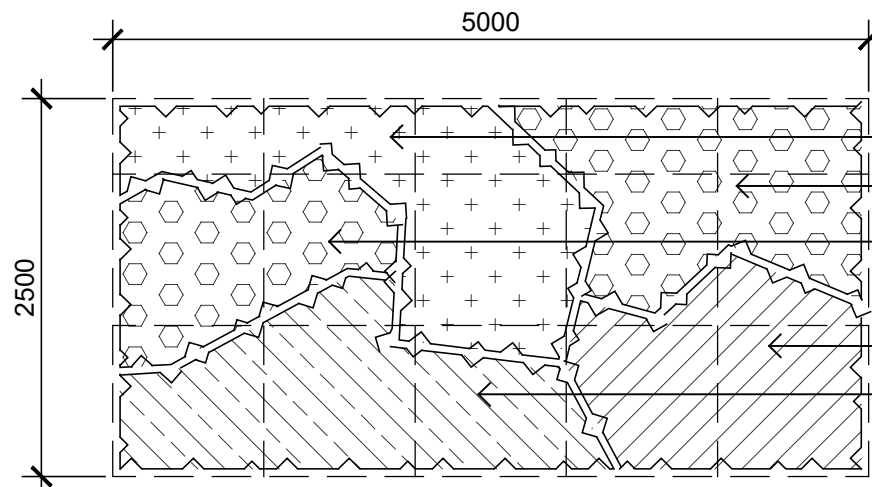

Planting Matrix 3 - Street Verge Planting

1:50

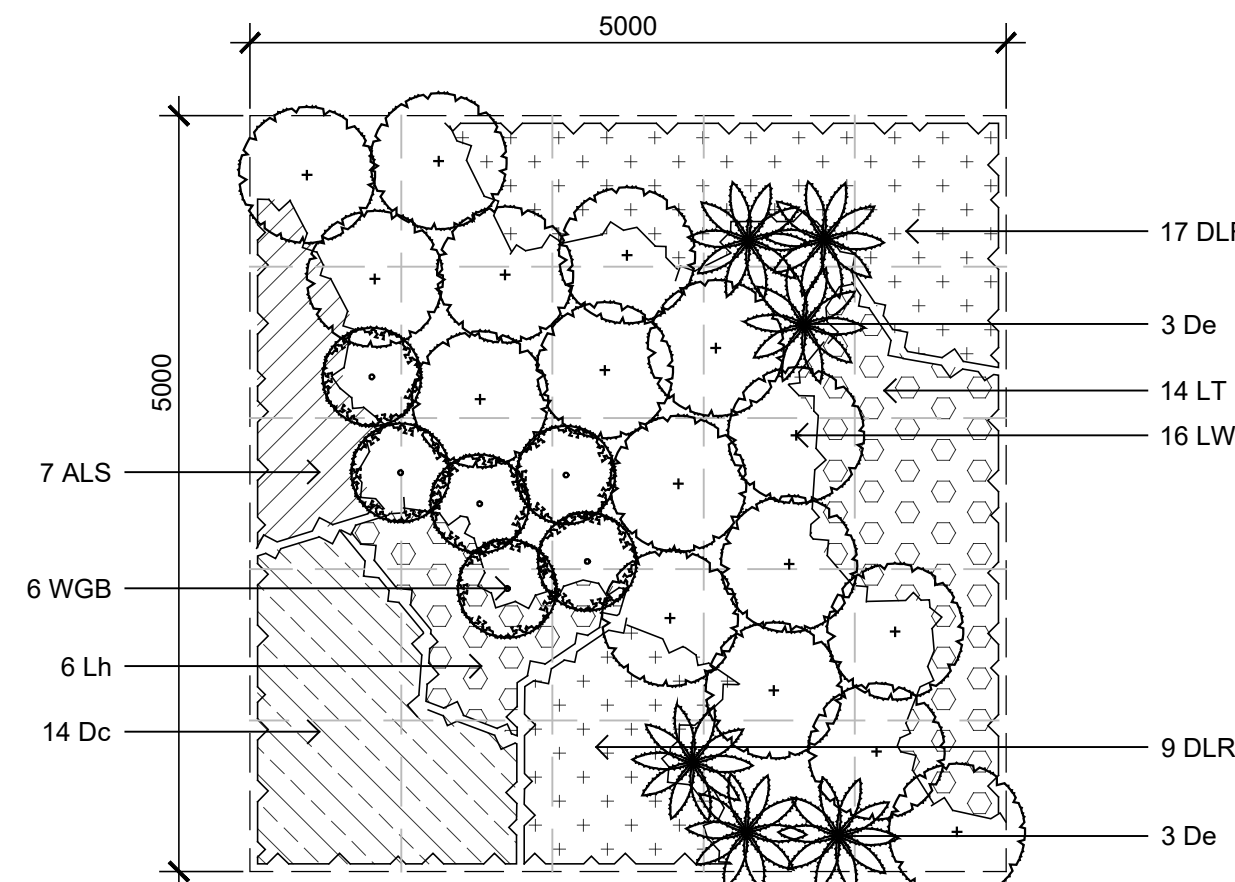

Planting Matrix 4 - General Open Space

1:50

NOT FOR CONSTRUCTION

© 2021 Site Image (NSW) Pty Ltd. ABN 44 801 262 380 as agent for Site Image NSW Partnership. All rights reserved. This drawing is copyright and shall not be reproduced or copied in any form or by any means (graphic, electronic or mechanical including photocopy) without the written permission of Site Image (NSW) Pty Ltd under license, expressed or implied, to use this document for any purpose what so ever is restricted to the terms of the written agreement between Site Image (NSW) Pty Ltd and the instructing party.

The contractor shall check and verify all work on site (including work by others) before commencing the landscape installation. Any discrepancies are to be reported to the Project Manager or Landscape Architect prior to commencing work. Do not scale this drawing. Any required dimensions not shown shall be referred to the Landscape Architect for confirmation.

B	Architectural & Civil Coordination	RG	NM	23.09.2024
A	Architectural Coordination	RG	NM	01.03.2023
Issue	Revision Description	Drawn	Check	Date



Client
DHL Supply Chain


Project
**DHL Logistics Facility
Badgerys Creek**

Drawing Name
Landscape Details


Scale **As Shown**
Job Number
SS22-4914

SSDA


Drawing Number
S1-501 Issue
B

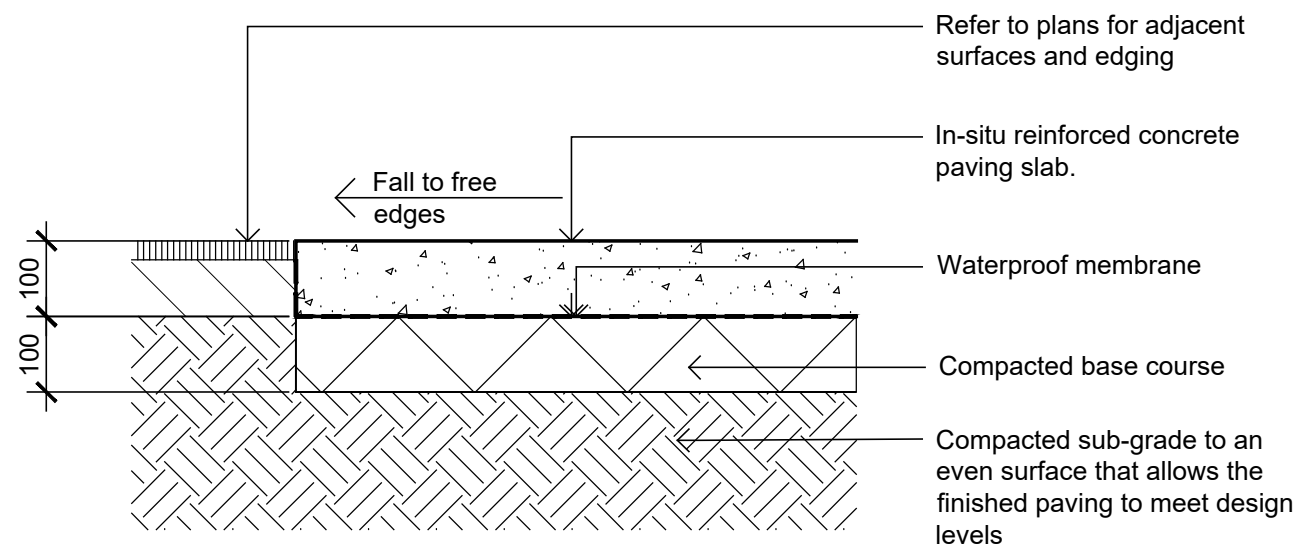


Insitu Concrete Paving - On grade
1:10

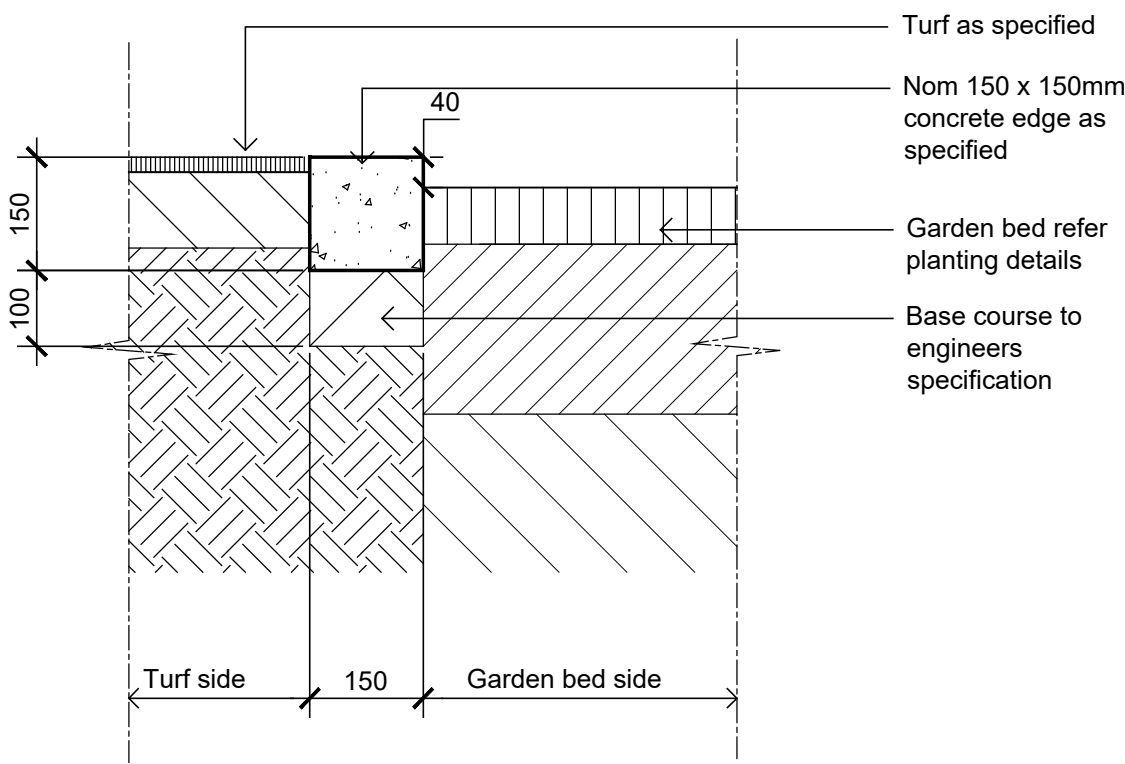


Typical Concrete Edge
1:10

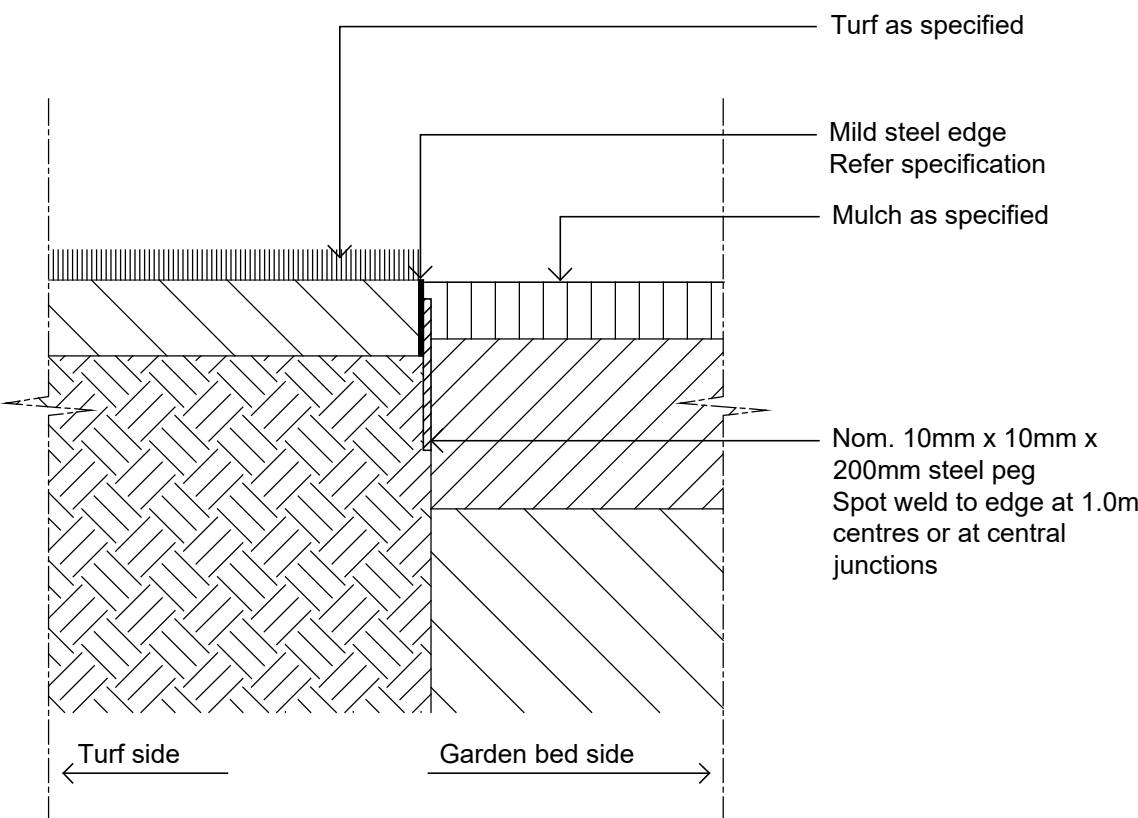


Typical Mild Steel Edge
1:10

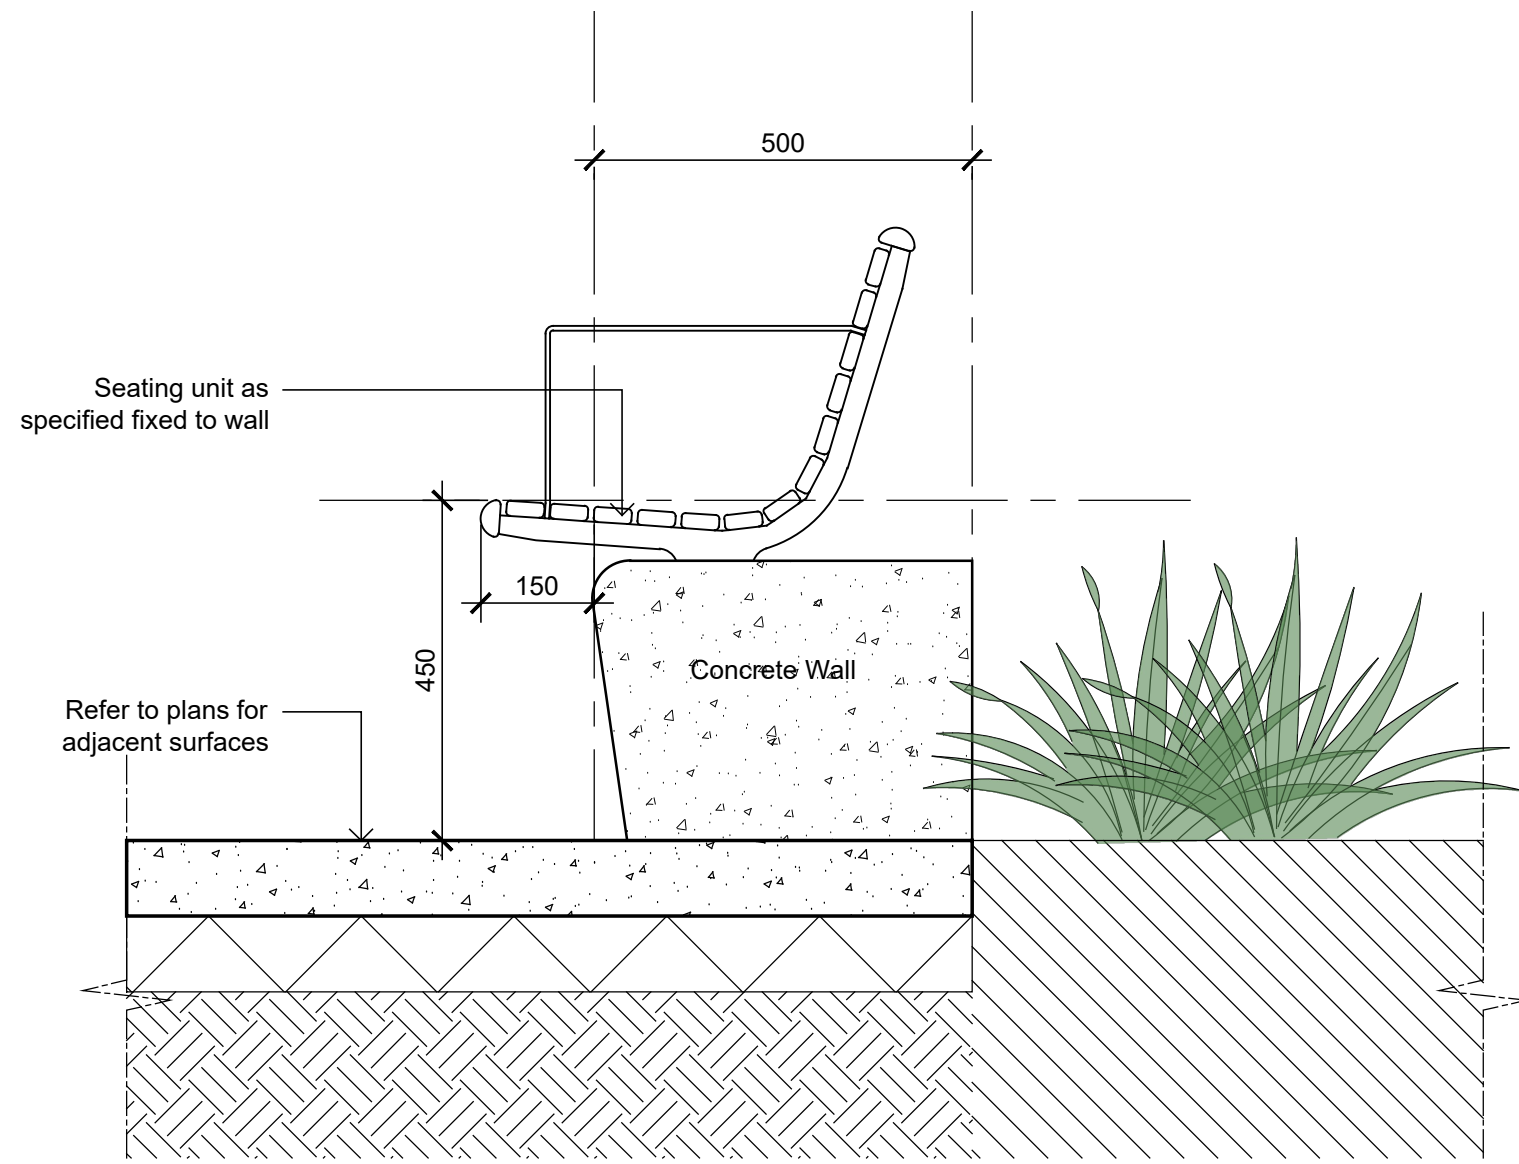

Wall Mounted Seat with Backrest and Armrest
1:10

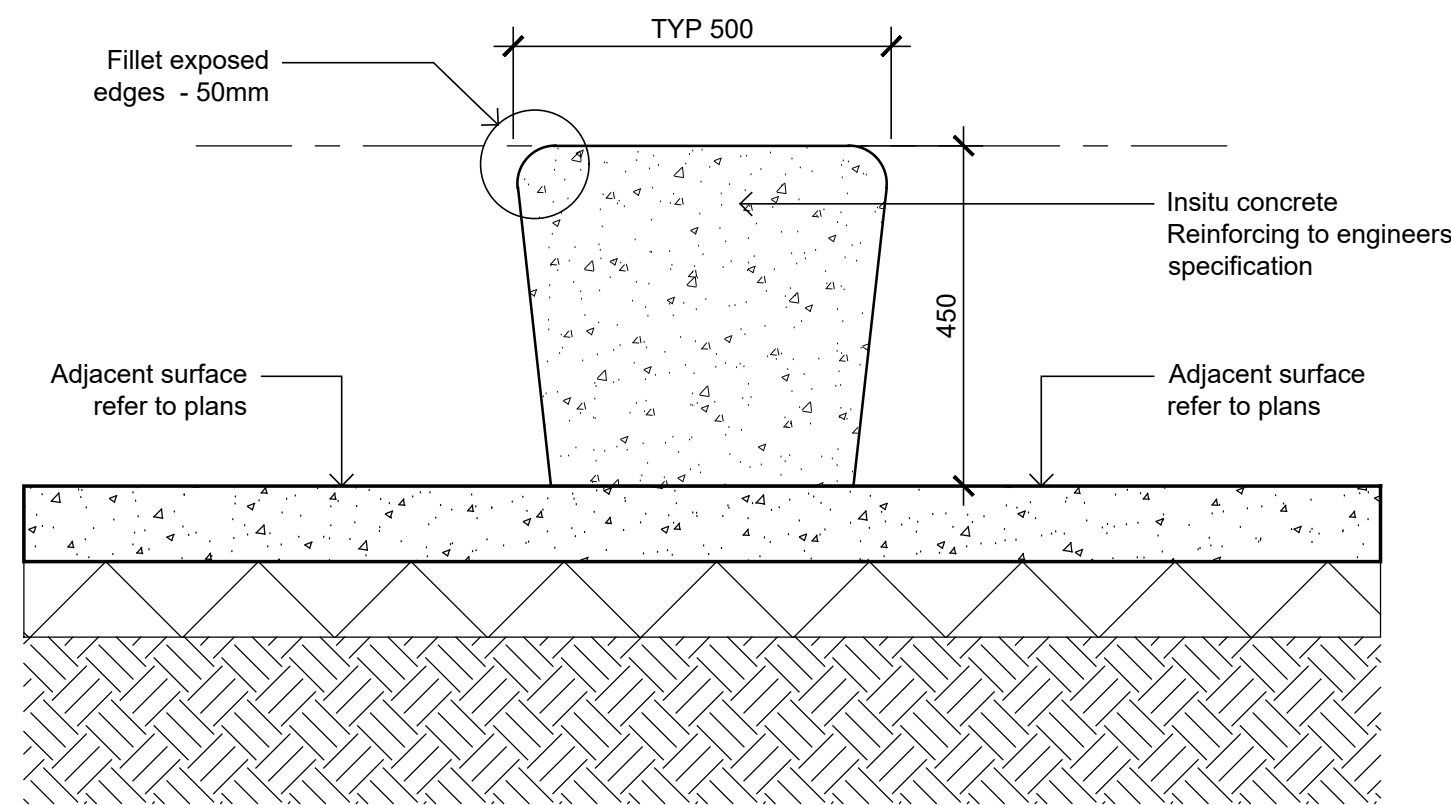

Typical In-site Concrete Wall - On Grade
1:10

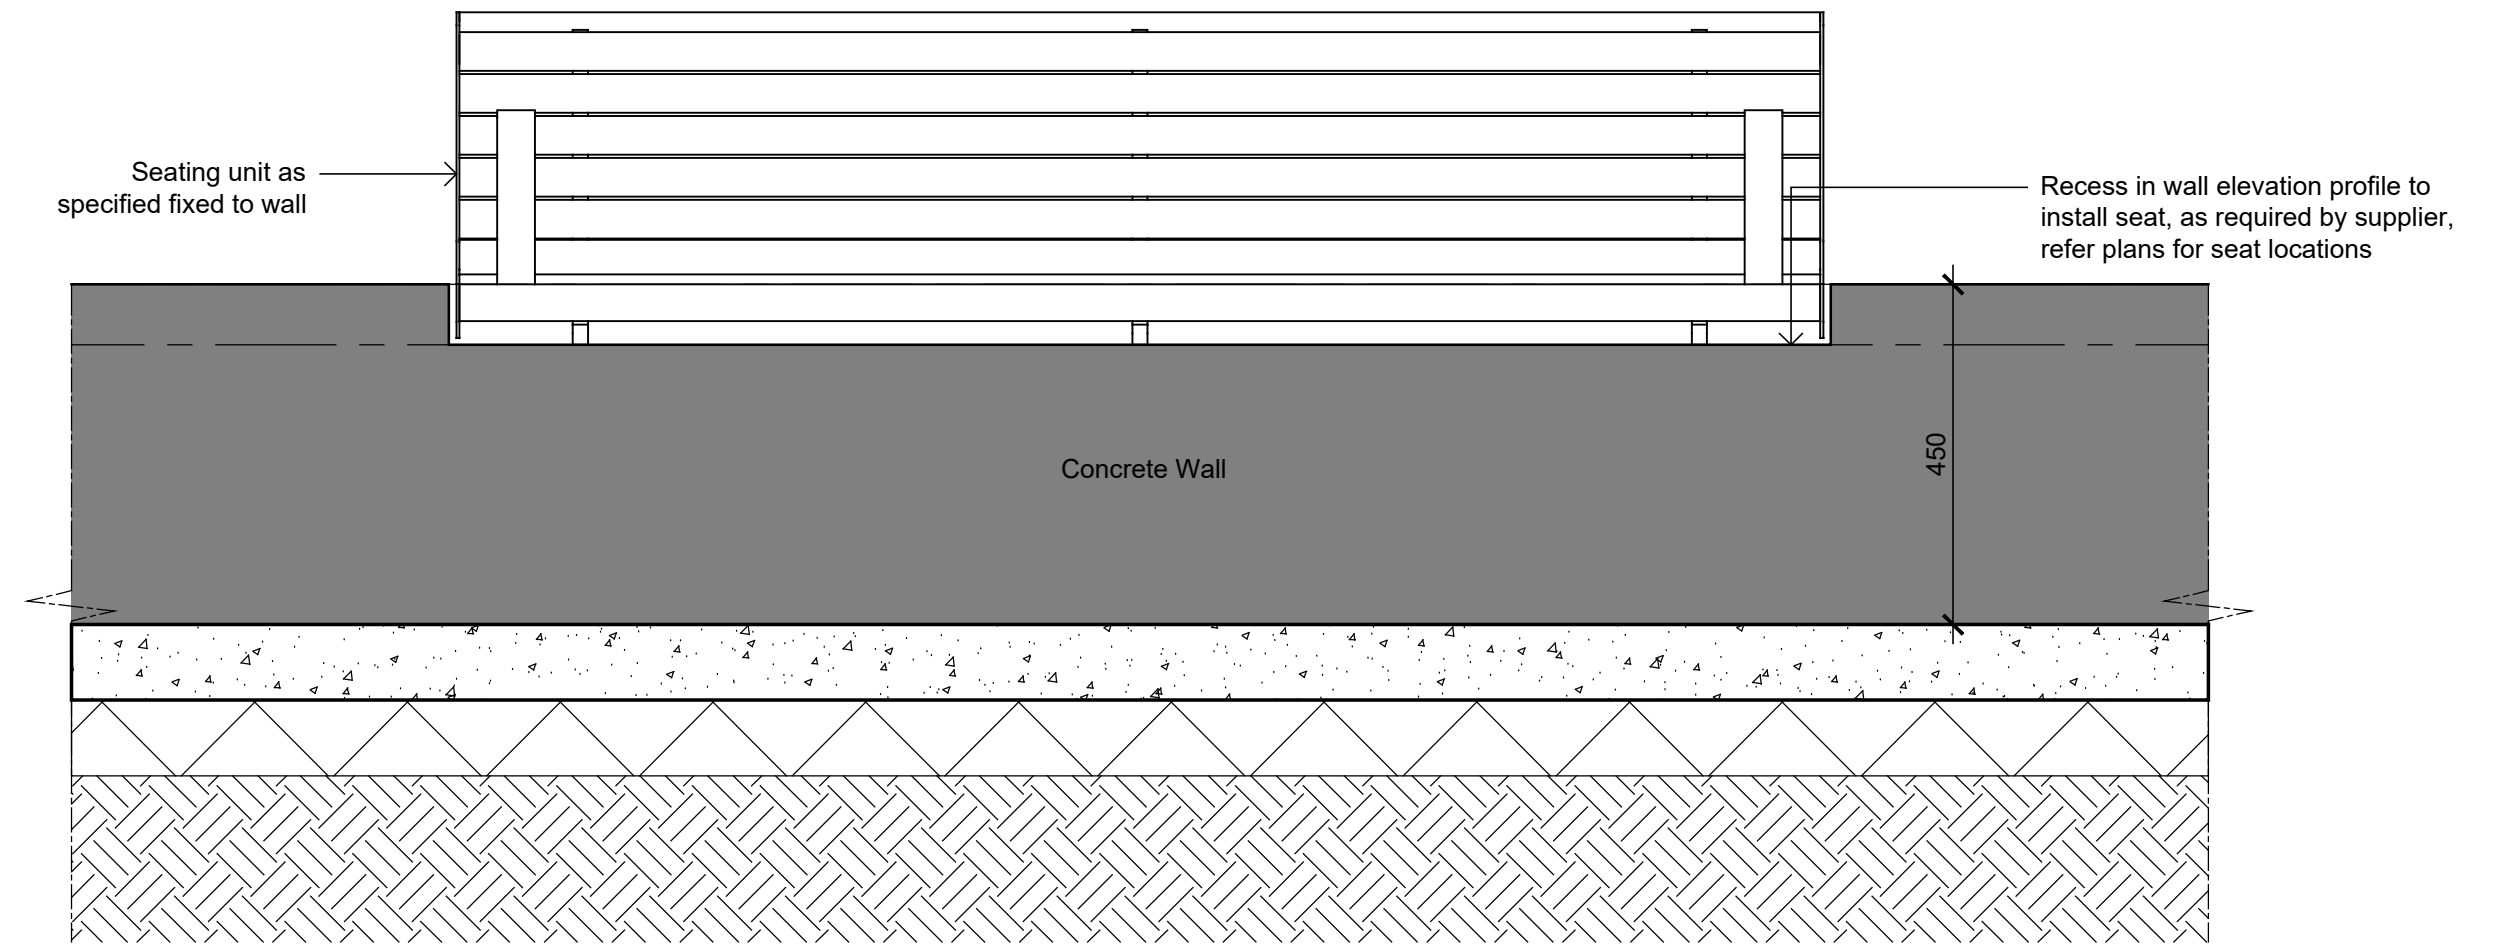

Typical Elevation - Wall Mounted Seat with Backrest and Armrest
1:10

NOT FOR CONSTRUCTION

© 2021 Site Image (NSW) Pty Ltd. ABN 44 801 262 380 as agent for Site Image NSW Partnership. All rights reserved. This drawing is copyright and shall not be reproduced or copied in any form or by any means (graphic, electronic or mechanical including photocopy) without the written permission of Site Image (NSW) Pty Ltd. Any license, expressed or implied, to use this document for any purpose what so ever is restricted to the terms of the written agreement between Site Image (NSW) Pty Ltd and the instructing party.

The contractor shall check and verify all work on site (including work by others) before commencing the landscape installation. Any discrepancies are to be reported to the Project Manager or Landscape Architect prior to commencing work. Do not scale this drawing. Any required dimensions not shown shall be referred to the Landscape Architect for confirmation.

C	Architectural & Civil Coordination	RG	NM	23.09.2024
B	Architectural Coordination	RG	NM	16.05.2023
A	Architectural Coordination	RG	NM	01.03.2023
Issue	Revision Description	Drawn	Check	Date

SITE IMAGE
Landscape Architects
Level 1, 3-5 Baptist Street
Redfern NSW 2016
Australia
Tel: (61 2) 8332 5600
Fax: (61 2) 9698 2877
www.siteimage.com.au

Client
DHL Supply Chain

Project
DHL Logistics Facility
Badgerys Creek

Drawing Name
Landscape Details

Scale **As Shown**
Job Number
SS22-4914

SSDA

Drawing Number
S1-502
Issue
C



01 Section - Streetscape
1:50

NOT FOR CONSTRUCTION

© 2021 Site Image (NSW) Pty Ltd. ABN 44 801 262 380 as agent for Site Image NSW Partnership. All rights reserved. This drawing is copyright and shall not be reproduced or copied in any form or by any means (graphic, electronic or mechanical including photocopy) without the written permission of Site Image (NSW) Pty Ltd. Any license, expressed or implied, to use this document for any purpose what so ever is restricted to the terms of the written agreement between Site Image (NSW) Pty Ltd and the instructing party.

The contractor shall check and verify all work on site (including work by others) before commencing the landscape installation. Any discrepancies are to be reported to the Project Manager or Landscape Architect prior to commencing work. Do not scale this drawing. Any required dimensions not shown shall be referred to the Landscape Architect for confirmation.

Legend Refer Drawing S1-001

B	Architectural & Civil Coordination	RG	NM	23.09.2024
A	Architectural Coordination	RG	NM	01.03.2023
Issue	Revision Description	Drawn	Check	Date




Client
DHL Supply Chain

Project
**DHL Logistics Facility
Badgerys Creek**

Drawing Name
Landscape Sections

Scale 1:50 @ A1
Job Number
SS22-4914

SSDA
0 0.5 1 1.5 2 2.5m
Drawing Number
S1-601 Issue
B

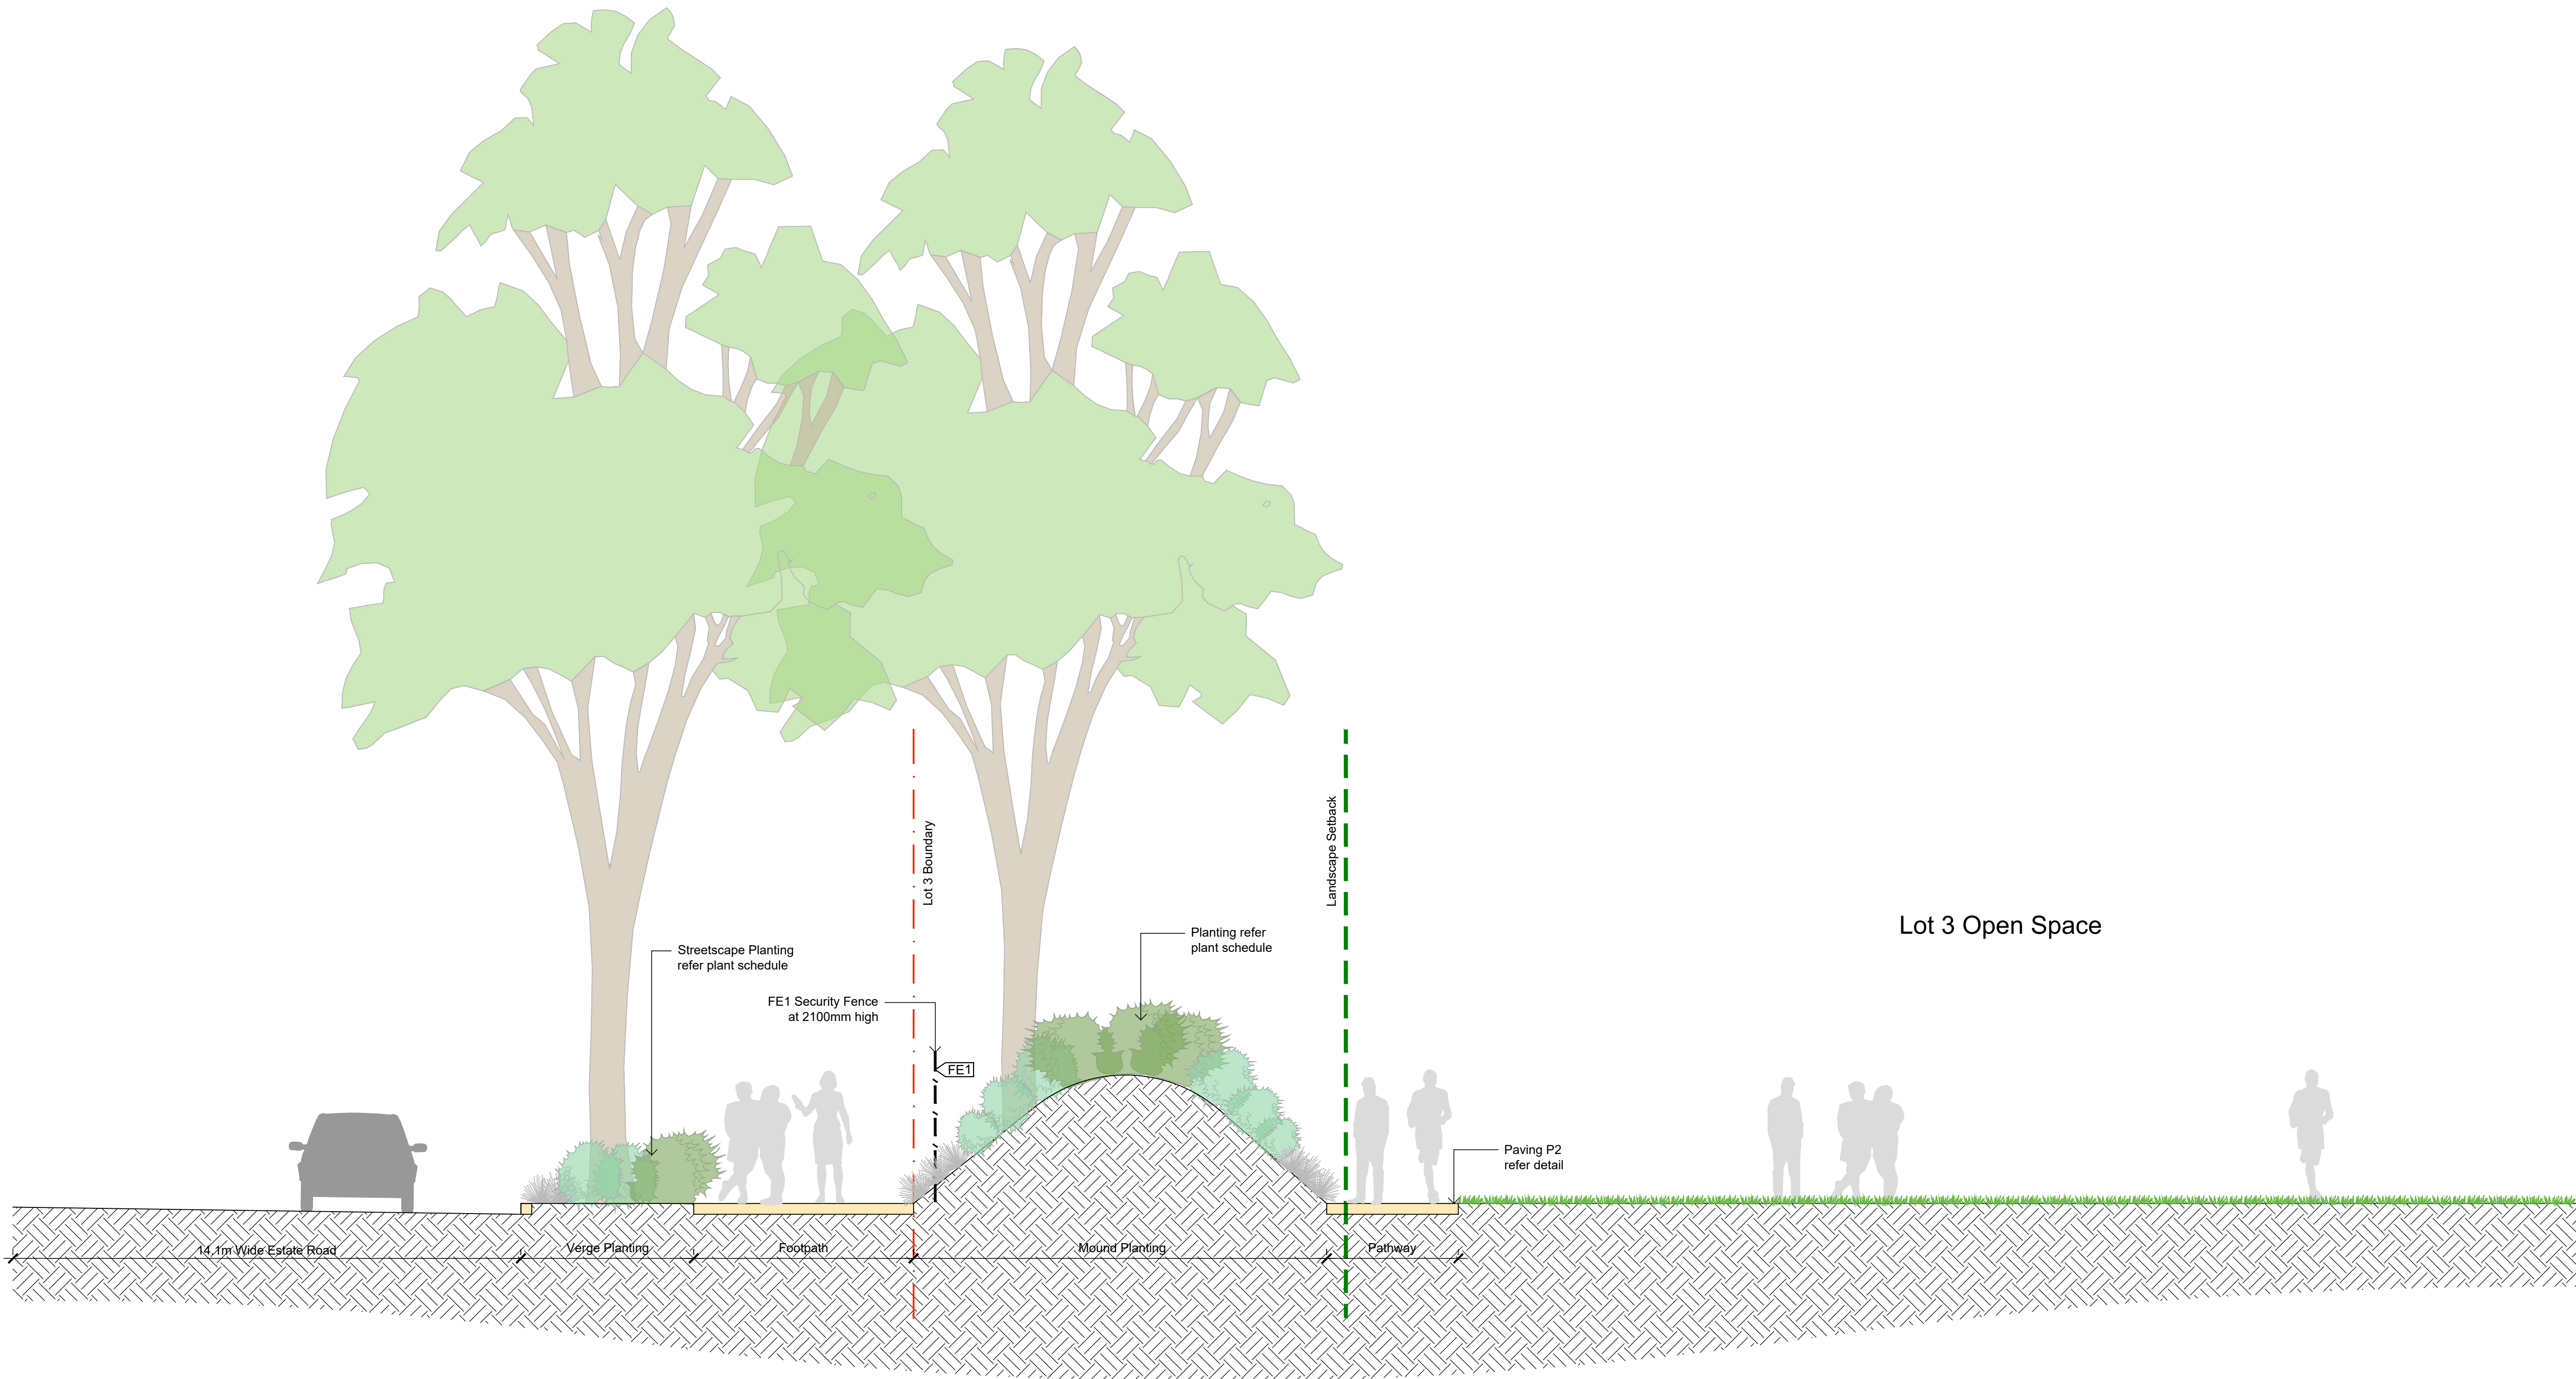

01 Section - Lot 3 Communal Open Space
1:50


NOT FOR CONSTRUCTION

Legend Refer Drawing S1-001

© 2021 Site Image (NSW) Pty Ltd. ABN 44 801 262 380 as agent for Site Image NSW Partnership. All rights reserved. This drawing is copyright and shall not be reproduced or copied in any form or by any means (graphic, electronic or mechanical including photocopy) without the written permission of Site Image (NSW) Pty Ltd. Any license, expressed or implied, to use this document for any purpose what so ever is restricted to the terms of the written agreement between Site Image (NSW) Pty Ltd and the instructing party.

The contractor shall check and verify all work on site (including work by others) before commencing the landscape installation. Any discrepancies are to be reported to the Project Manager or Landscape Architect prior to commencing work. Do not scale this drawing. Any required dimensions not shown shall be referred to the Landscape Architect for confirmation.

B	Architectural & Civil Coordination	RG	NM	23.09.2024
A	Architectural Coordination	RG	NM	01.03.2023
Issue	Revision Description	Drawn	Check	Date

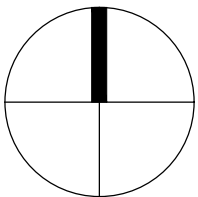

SITE IMAGE
Landscape Architects
Level 1, 3-5 Baptist Street
Redfern NSW 2016
Australia
Tel: (61 2) 8332 5600
Fax: (61 2) 9698 2877
www.siteimage.com.au


Client
DHL Supply Chain

Project
DHL Logistics Facility
Badgerys Creek

Drawing Name
Landscape Sections

Scale 1:50 @ A1
Job Number
SS22-4914

SSDA
0 0.5 1 1.5 2 2.5m
Drawing Number Issue
S1-602 B

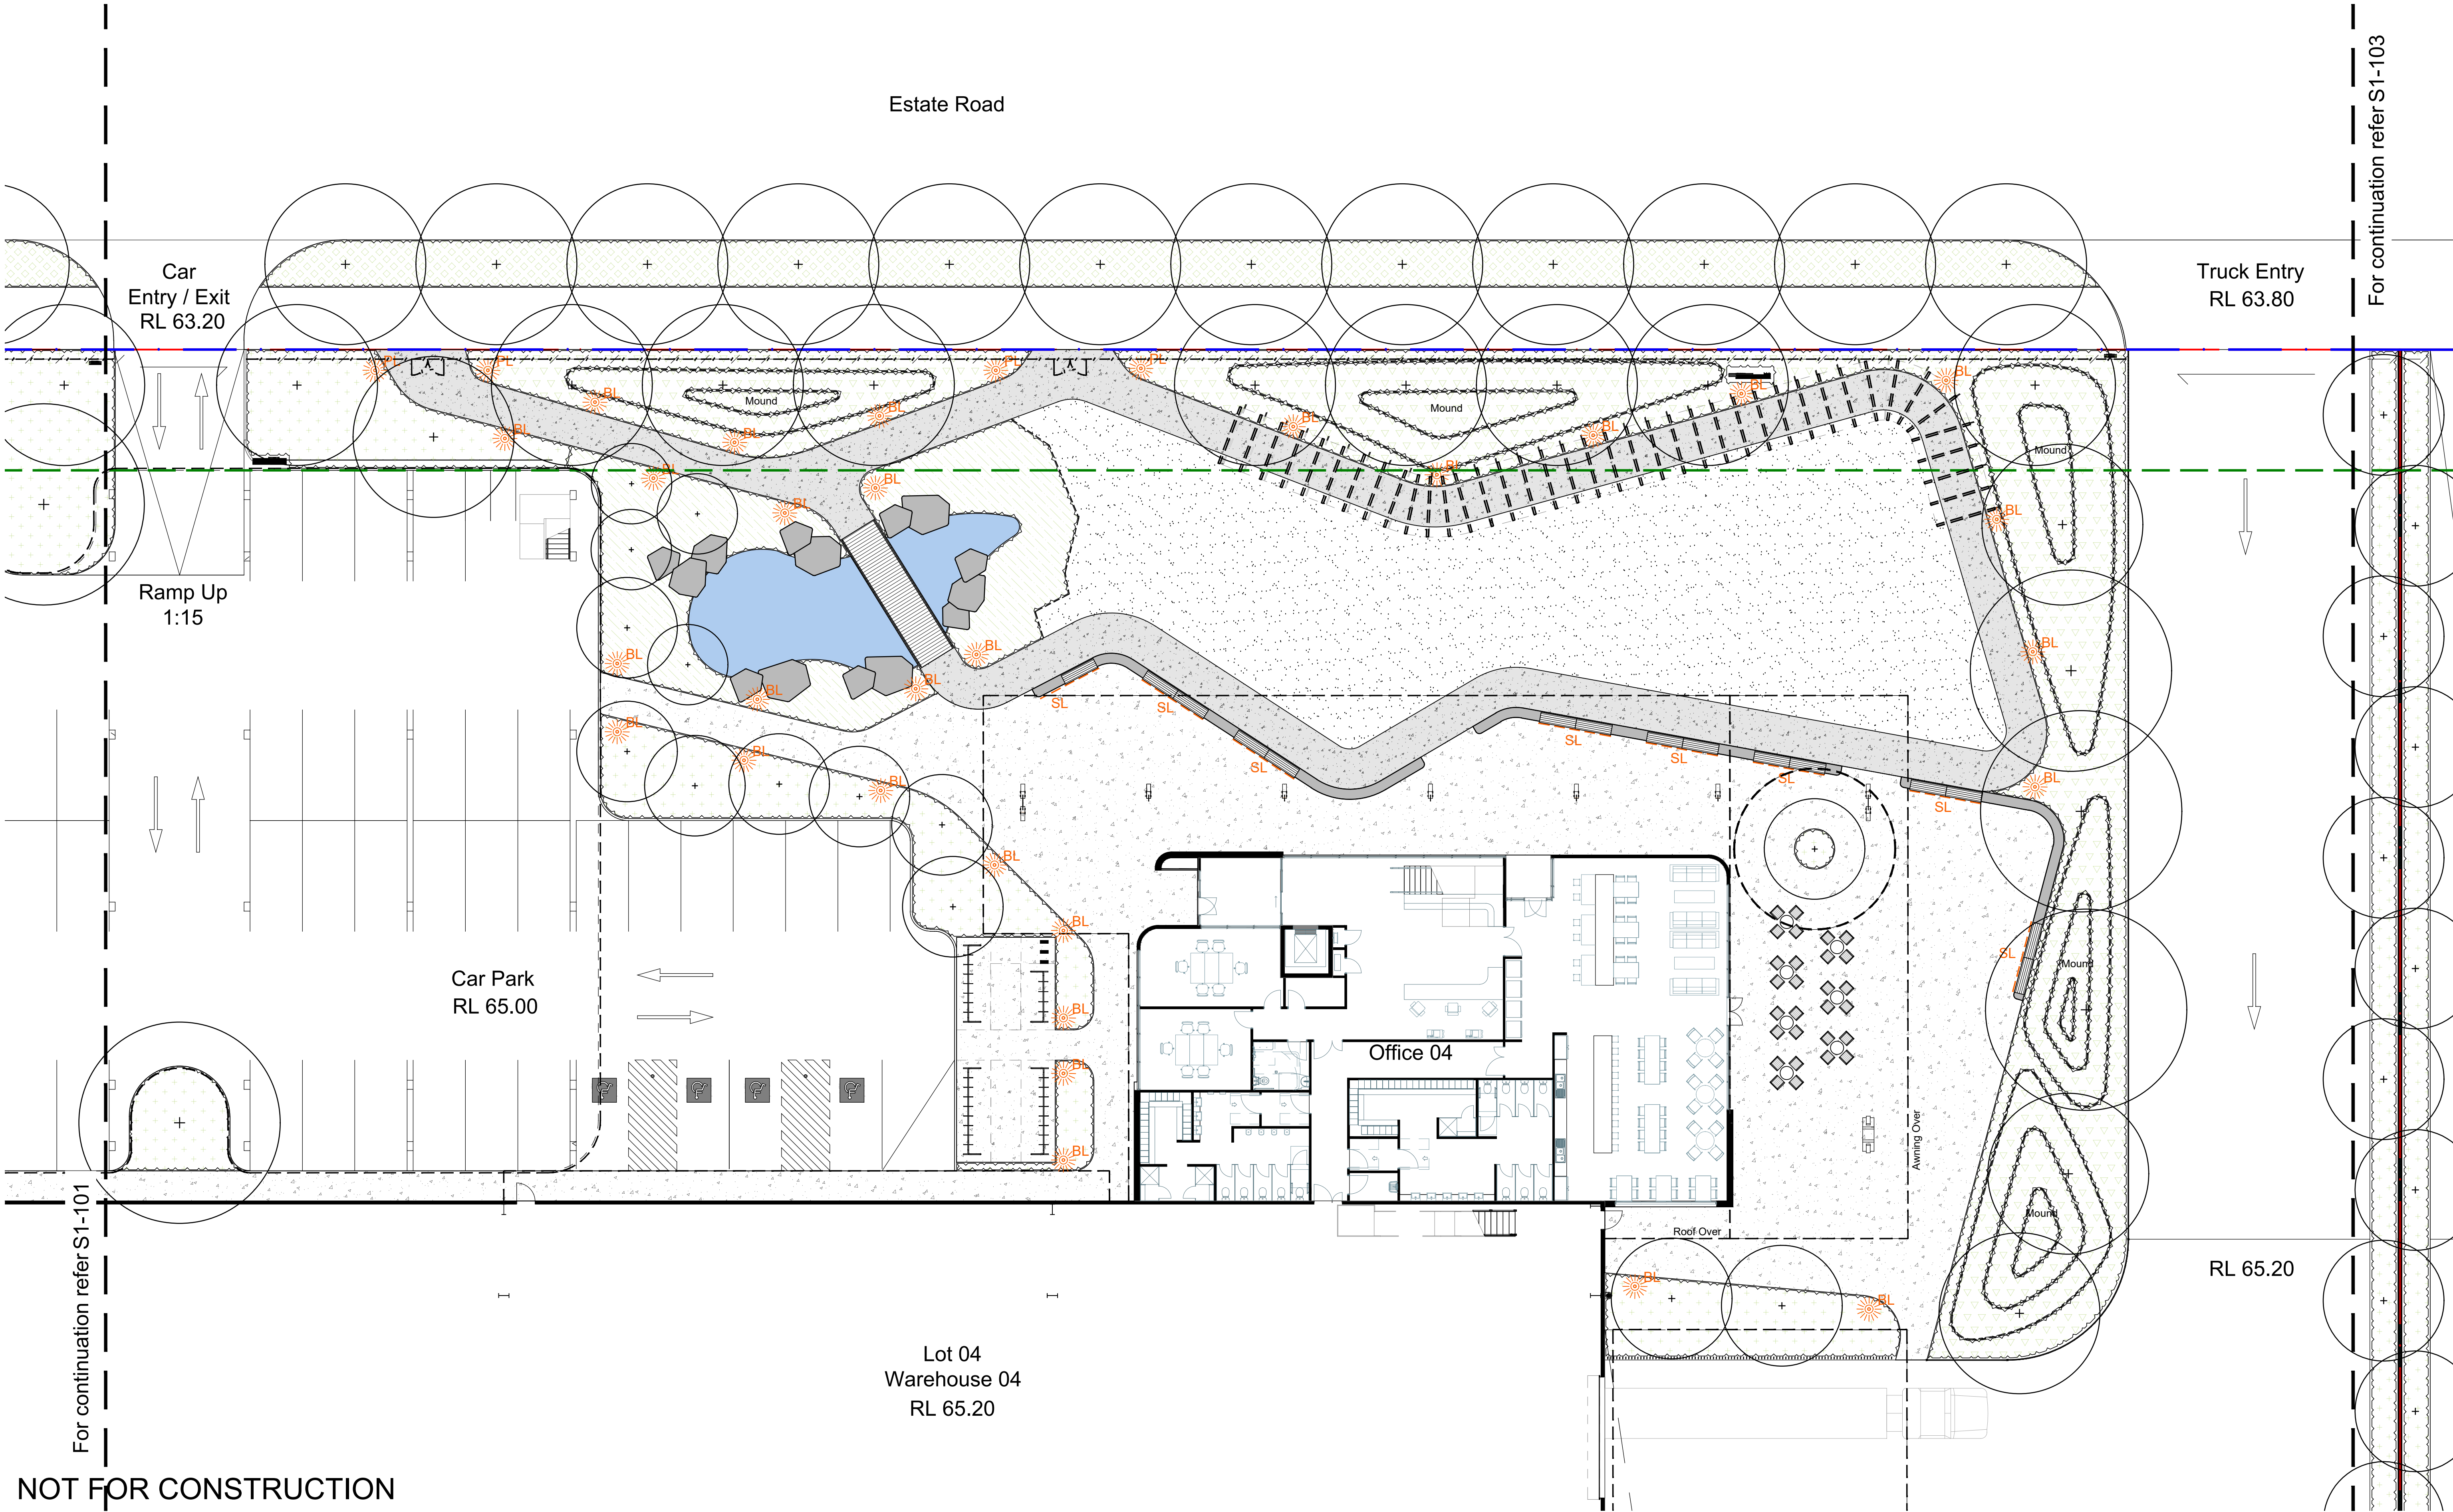

© 2021 Site Image (NSW) Pty Ltd. ABN 44 801 262 380 as agent for Site Image NSW Partnership. All rights reserved. This drawing is copyright and shall not be reproduced or copied in any form or by any means (graphic, electronic or mechanical including photocopy) without the written permission of Site Image (NSW) Pty Ltd. Any license, expressed or implied, to use this document for any purpose what so ever is restricted to the terms of the written agreement between Site Image (NSW) Pty Ltd and the instructing party.


The contractor shall check and verify all work on site (including work by others) before commencing the landscape installation. Any discrepancies are to be reported to the Project Manager or Landscape Architect prior to commencing work. Do not scale this drawing. Any required dimensions not shown shall be referred to the Landscape Architect for confirmation.

C	Architectural & Civil Coordination	RG	NM	23.09.2024
B	Architectural Coordination	RG	NM	16.05.2023
A	Architectural Coordination	RG	NM	01.03.2023
Issue	Revision Description	Drawn	Check	Date

Legend Refer Drawing S1-001

-  Bollard Light
TBC
-  Pole Top Light
TBC
-  Recessed Wall Light
TBC

-  Garden Up Light on Stake
TBC
-  LED Strip Lighting
TBC
-  Down Light on Pergola
TBC

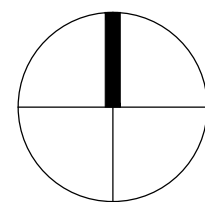

SITE IMAGE
Landscape Architects
Level 1, 3-5 Baptist Street
Redfern NSW 2016
Australia
Tel: (61 2) 8332 5600
Fax: (61 2) 9698 2877
www.siteimage.com.au

Client
DHL Supply Chain


Project
**DHL Logistics Facility
Badgers Creek**

Drawing Name
**Landscape Lighting Concept
Lot 4**

Scale 1:150 @ A1
Job Number
SS22-4914

SSDA
0 1 2 3 4 5m
Drawing Number

S1-801 C

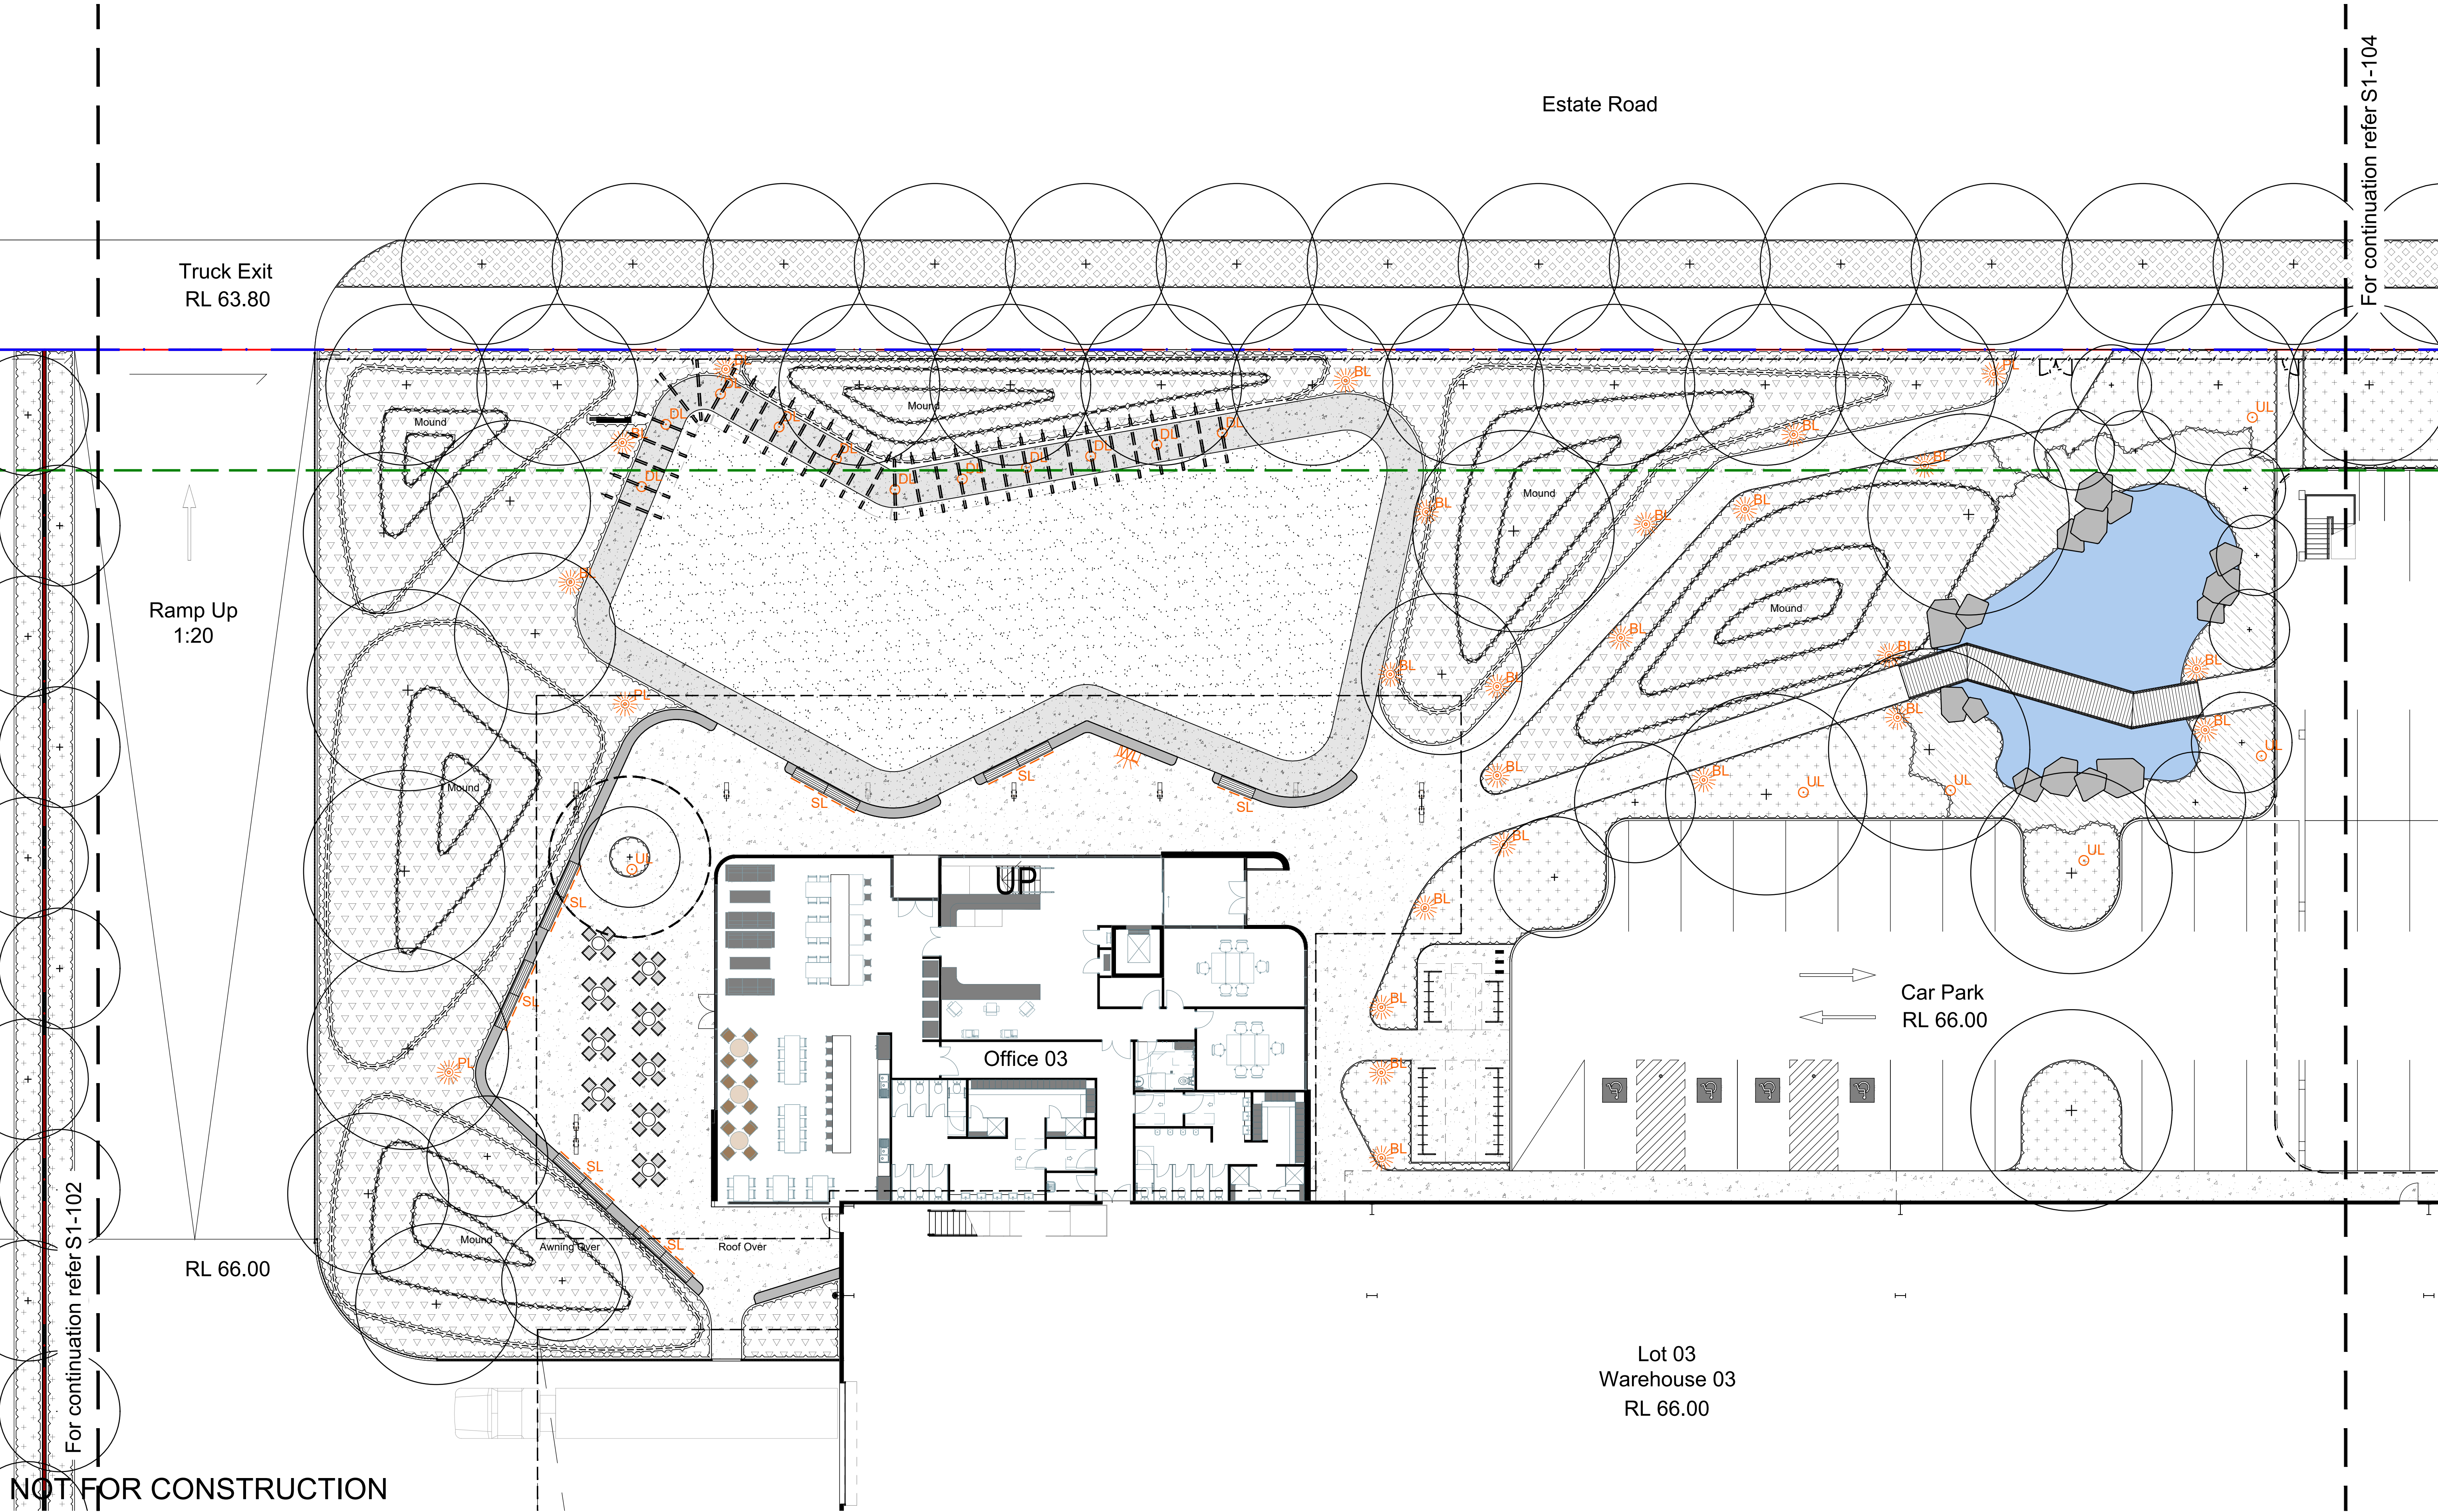

© 2021 Site Image (NSW) Pty Ltd. ABN 44 801 262 380 as agent for Site Image NSW Partnership. All rights reserved. This drawing is copyright and shall not be reproduced or copied in any form or by any means (graphic, electronic or mechanical including photocopy) without the written permission of Site Image (NSW) Pty Ltd. Any license, expressed or implied, to use this document for any purpose what so ever is restricted to the terms of the written agreement between Site Image (NSW) Pty Ltd and the instructing party.


The contractor shall check and verify all work on site (including work by others) before commencing the landscape installation. Any discrepancies are to be reported to the Project Manager or Landscape Architect prior to commencing work. Do not scale this drawing. Any required dimensions not shown shall be referred to the Landscape Architect for confirmation.

C	Architectural & Civil Coordination	RG	NM	23.09.2024
B	Architectural Coordination	RG	NM	16.05.2023
A	Architectural Coordination	RG	NM	01.03.2023
Issue	Revision Description	Drawn	Check	Date

Legend Refer Drawing S1-001

-  Bollard Light
TBC
-  Pole Top Light
TBC
-  Recessed Wall Light
TBC

-  Garden Up Light on Stake
TBC
-  LED Strip Lighting
TBC
-  Down Light on Pergola
TBC

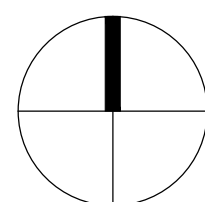


SITE IMAGE
Landscape Architects
Level 1, 3-5 Baptist Street
Redfern NSW 2016
Australia
Tel: (61 2) 8332 5600
Fax: (61 2) 9698 2877
www.siteimage.com.au


Client
DHL Supply Chain
Project
DHL Logistics Facility
Badgerys Creek

Drawing Name
Landscape Lighting Concept
Lot 3

SSDA
Scale 1:150 @ A1
Job Number
SS22-4914

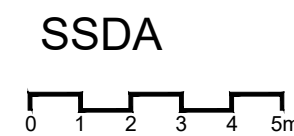

S1-802 C

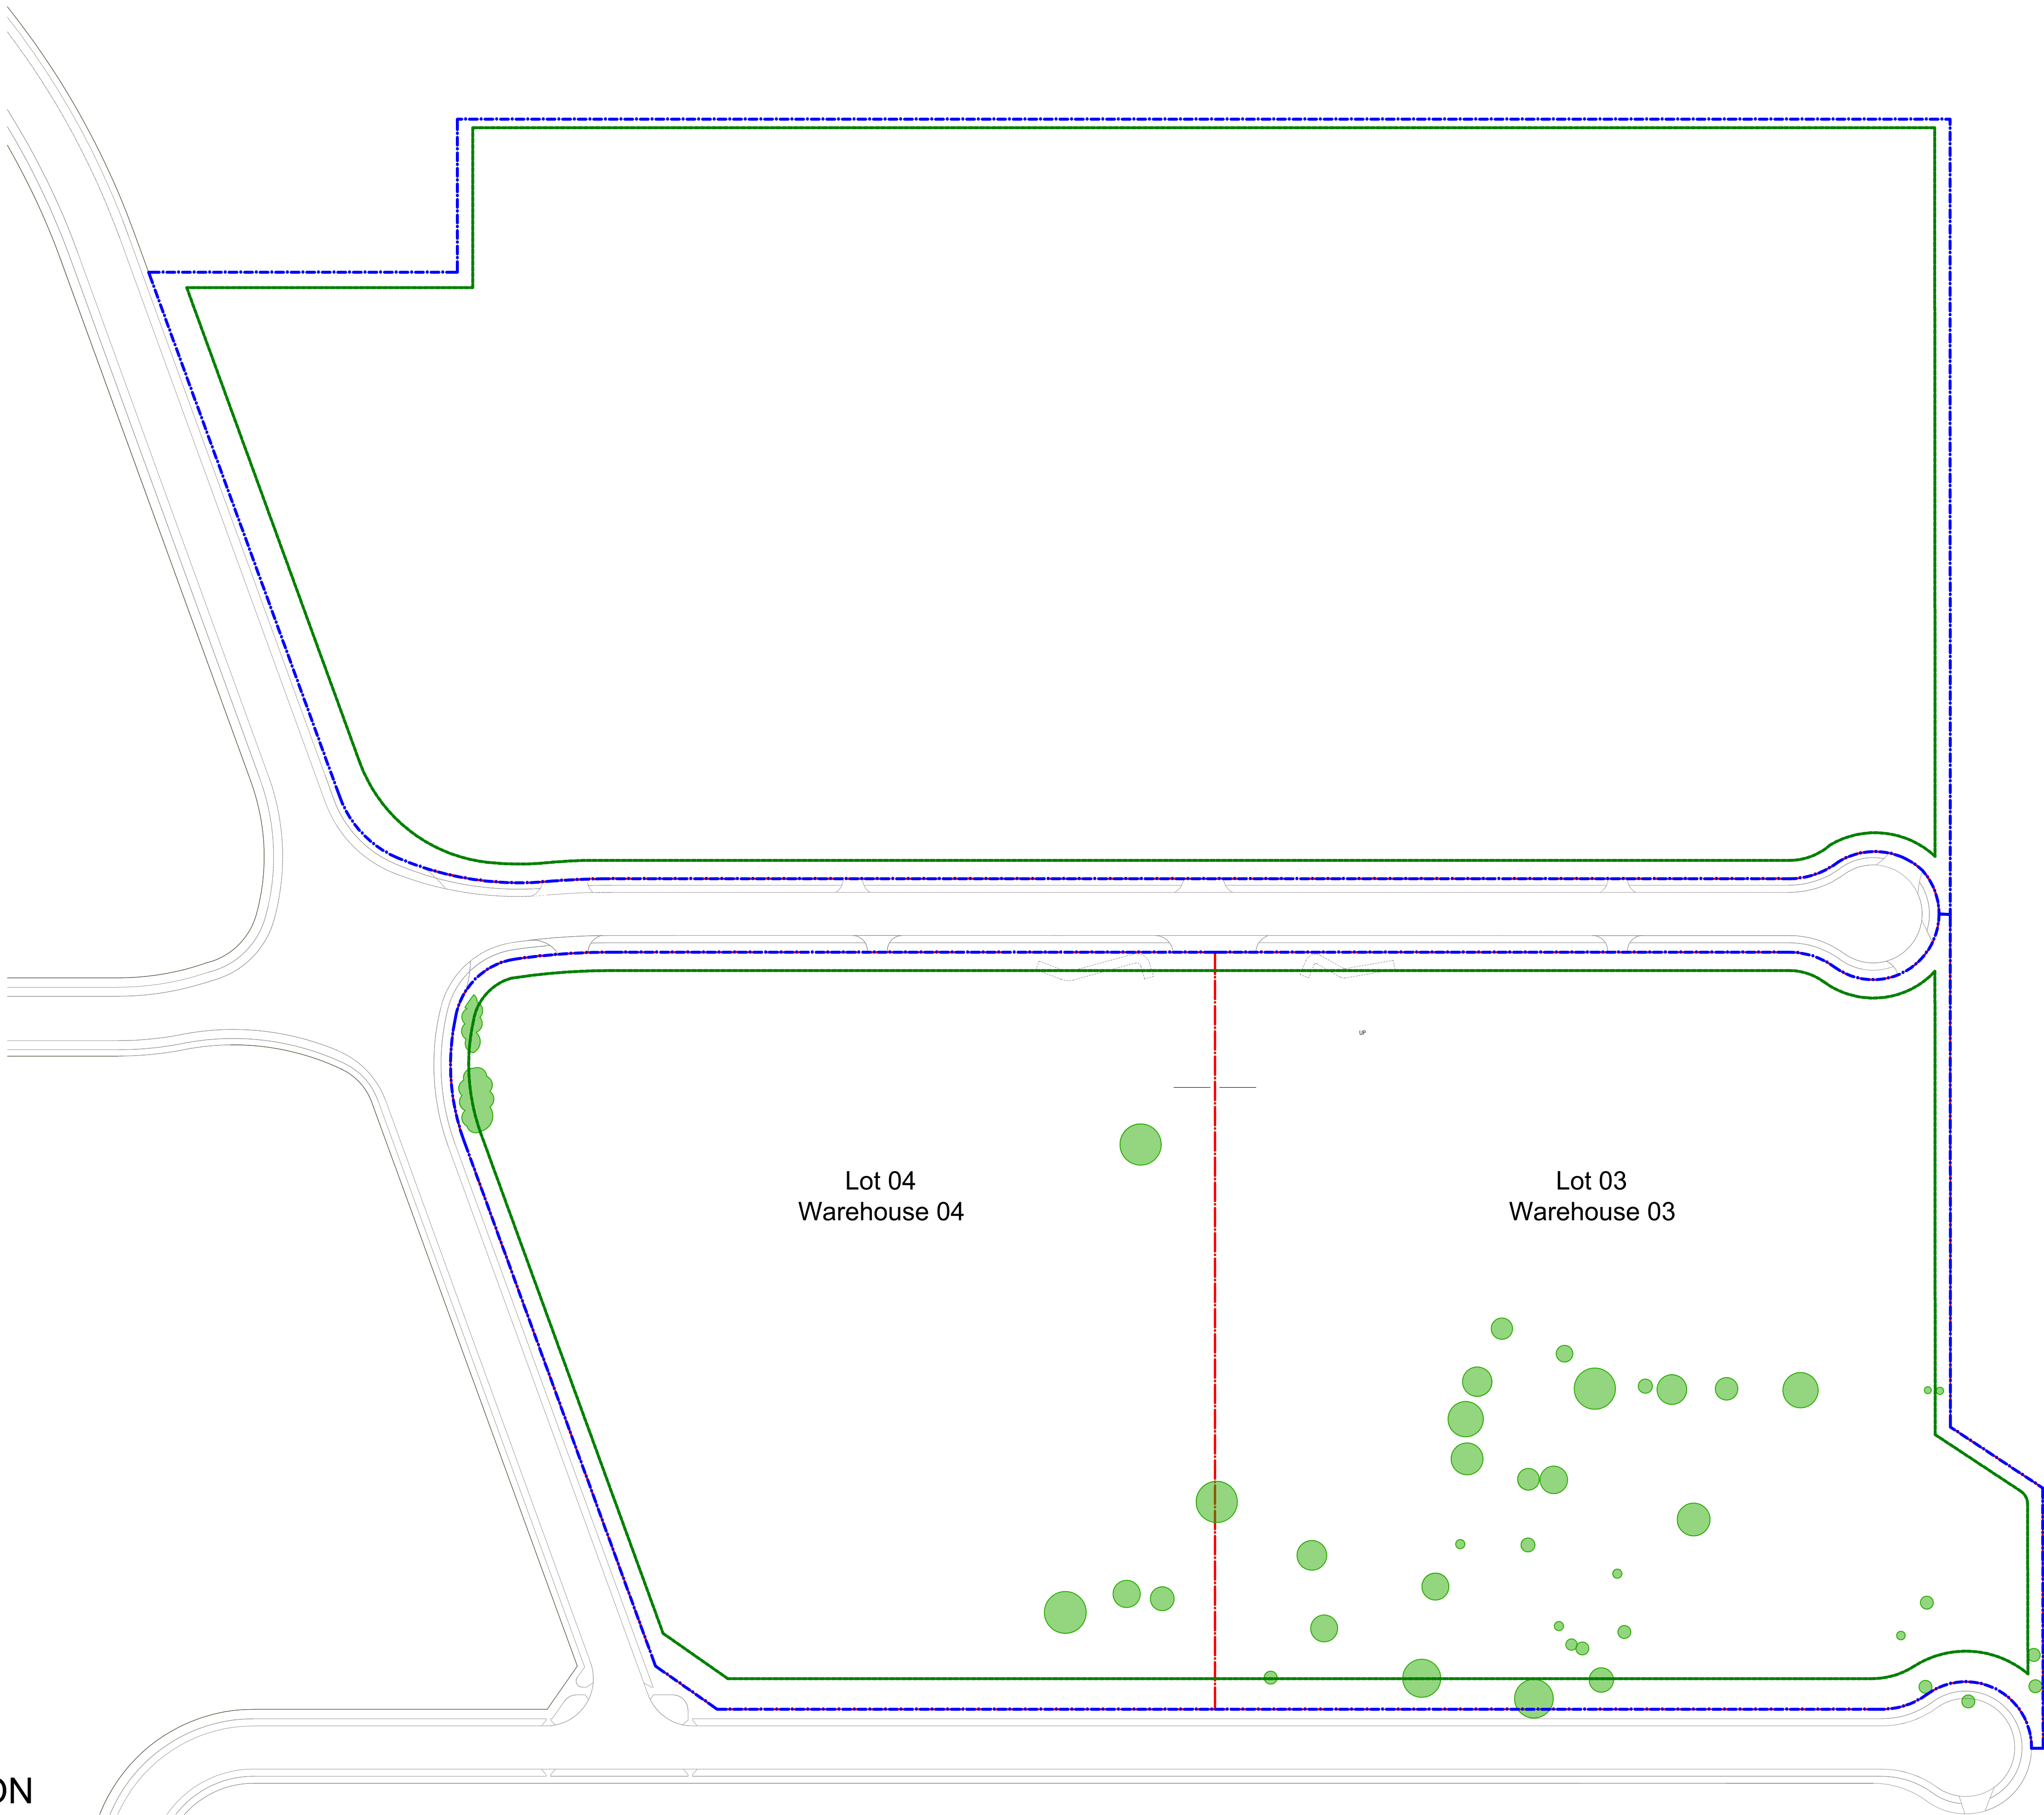


NOT FOR CONSTRUCTION

© 2021 Site Image (NSW) Pty Ltd. ABN 44 801 262 380 as agent for Site Image NSW Partnership. All rights reserved. This drawing is copyright and shall not be reproduced or copied in any form or by any means (graphic, electronic or mechanical including photocopy) without the written permission of Site Image (NSW) Pty Ltd. Any license, expressed or implied, to use this document for any purpose what so ever is restricted to the terms of the written agreement between Site Image (NSW) Pty Ltd and the instructing party.

The contractor shall check and verify all work on site (including work by others) before commencing the landscape installation. Any discrepancies are to be reported to the Project Manager or Landscape Architect prior to commencing work. Do not scale this drawing. Any required dimensions not shown shall be referred to the Landscape Architect for confirmation.

Legend Refer Drawing S1-001

B	Architectural & Civil Coordination	RG	NM	23.09.2024
A	Architectural Coordination	RG	NM	01.03.2023
Issue	Revision Description	Drawn	Check	Date

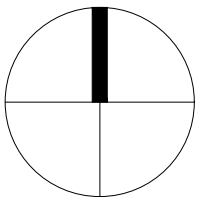

SITE IMAGE
Landscape Architects
Level 1, 3-5 Baptist Street
Rosedale NSW 2016
Australia
Tel: (61 2) 8332 5600
Fax: (61 2) 9698 2877
www.siteimage.com.au

Client
DHL Supply Chain


Project
DHL Logistics Facility
Badgerys Creek

Drawing Name
Existing Tree Plan

Scale 1:1200 @ A1
Job Number
SS22-4914

SSDA

Drawing Number
S1-901
Issue
B

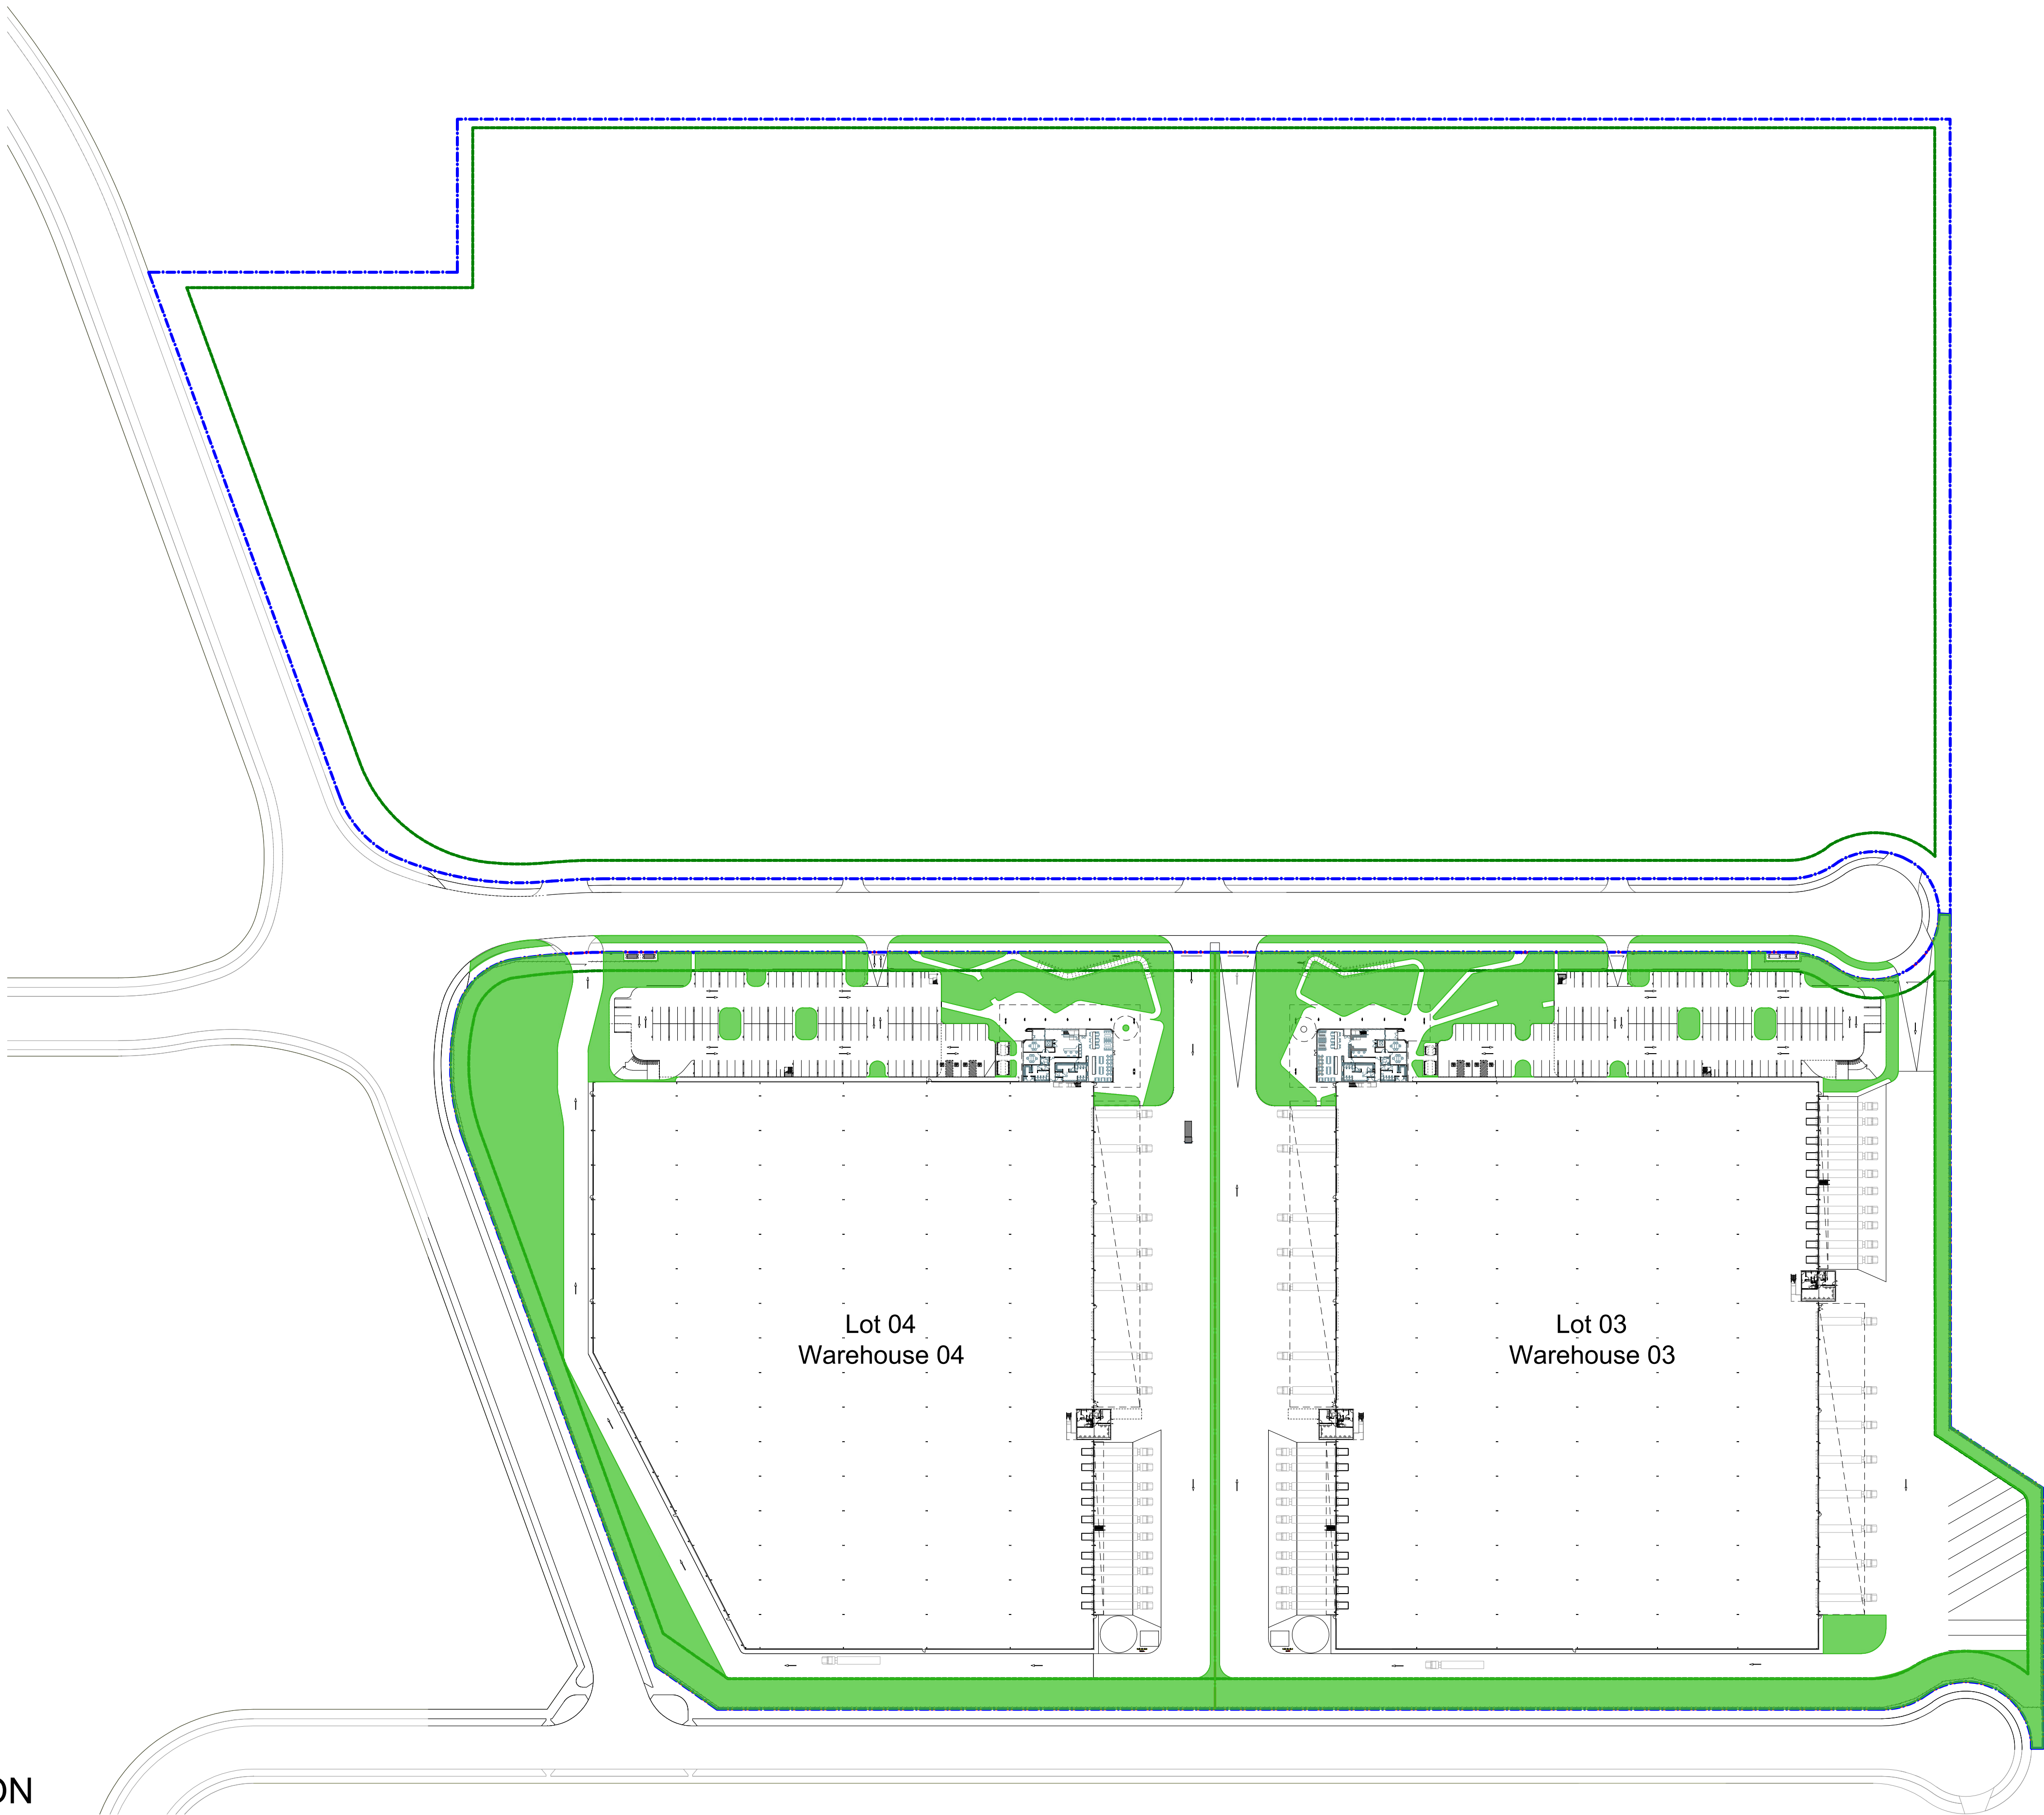


NOT FOR CONSTRUCTION

Legend Refer Drawing S1-001

© 2021 Site Image (NSW) Pty Ltd. ABN 44 801 262 380 as agent for Site Image NSW Partnership. All rights reserved. This drawing is copyright and shall not be reproduced or copied in any form or by any means (graphic, electronic or mechanical including photocopy) without the written permission of Site Image (NSW) Pty Ltd. Any license, expressed or implied, to use this document for any purpose what so ever is restricted to the terms of the written agreement between Site Image (NSW) Pty Ltd and the instructing party.

The contractor shall check and verify all work on site (including work by others) before commencing the landscape installation. Any discrepancies are to be reported to the Project Manager or Landscape Architect prior to commencing work. Do not scale this drawing. Any required dimensions not shown shall be referred to the Landscape Architect for confirmation.

D	Architectural Coordination	RG	NM	03.10.2024
C	Architectural & Civil Coordination	RG	NM	23.09.2024
B	Architectural Coordination	RG	NM	16.05.2023
A	Architectural Coordination	RG	NM	01.03.2023
Issue	Revision Description	Drawn	Check	Date

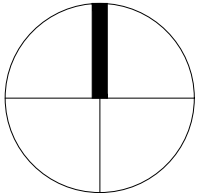

SITE IMAGE
Landscape Architects
Level 1, 3-5 Baptist Street
Redfern NSW 2016
Australia
Tel: (61 2) 8332 5600
Fax: (61 2) 9698 2877
www.siteimage.com.au

Client
DHL Supply Chain

Project
**DHL Logistics Facility
Badgerys Creek**

Drawing Name
Deep Soil Plan

Scale 1:1200 @ A1
Job Number
SS22-4914

SSDA

Drawing Number
S1-902
Issue
D


NOT FOR CONSTRUCTION

© 2021 Site Image (NSW) Pty Ltd. ABN 44 801 262 380 as agent for Site Image NSW Partnership. All rights reserved. This drawing is copyright and shall not be reproduced or copied in any form or by any means (graphic, electronic or mechanical including photocopy) without the written permission of Site Image (NSW) Pty Ltd. Any license, expressed or implied, to use this document for any purpose what so ever is restricted to the terms of the written agreement between Site Image (NSW) Pty Ltd and the instructing party.

The contractor shall check and verify all work on site (including work by others) before commencing the landscape installation. Any discrepancies are to be reported to the Project Manager or Landscape Architect prior to commencing work. Do not scale this drawing. Any required dimensions not shown shall be referred to the Landscape Architect for confirmation.

D	Architectural Coordination	RG	NM	03.10.2024
C	Architectural & Civil Coordination	RG	NM	23.09.2024
B	Architectural Coordination	RG	NM	16.05.2023
A	Architectural Coordination	RG	NM	01.03.2023
Issue	Revision Description	Drawn	Check	Date

Legend Refer Drawing S1-001

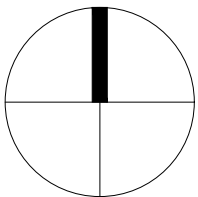

SITE IMAGE
Landscape Architects
Level 1, 3-5 Baptist Street
Radfern NSW 2016
Australia
Tel: (61 2) 8332 5600
Fax: (61 2) 9698 2877
www.siteimage.com.au

Client
DHL Supply Chain

Project
**DHL Logistics Facility
Badgerys Creek**

Drawing Name
Canopy Cover Plan

SSDA
Scale 1:1200 @ A1
Job Number
SS22-4914
Drawing Number
S1-903
Issue
D