



- LEGEND**
- AC AIR CONDITIONING
  - ACR ACRYLIC PANEL
  - B BOLLARD
  - BAL BALUSTRADE
  - BC BENCH CUPBOARD
  - BHO BULKHEAD OVER
  - BHP BOILING HOT PLATE
  - BL BLOCKWORK
  - BO BUILDING OVER
  - BOE BRICK ON EDGE - CUT SOLDIER COURSE
  - BR BACK REST
  - BS BUCKET SINK
  - BSN BASKIN
  - BTC CUPBOARD BENCH TOP
  - BTP PREPARATION BENCH TOP
  - BTS SERVERY BENCH TOP
  - BU BUILDING UNDER
  - CAT CEILING ACOUSTIC TILES
  - CC CONCRETE - STEEL TROWEL FINISH
  - CFG COMPRESSED FIBRE CEMENT
  - CFL CABINET FOR FLAMMABLE LIQUIDS
  - CH CONVECTION HEATER
  - CJ CONTROL JOINT
  - CMS CONCRETE MOWING STRIP
  - COL COLUMN
  - COLA COVERED OUTDOOR LEARNING AREA
  - CONC CONCRETE PAVING
  - CPT CARPET
  - CR CEMENT RENDER
  - CT CERAMIC TILE
  - CTN SHOWER CURTAIN AND TRACK
  - CWA COVERED WALKWAY
  - DAS DOOR AUTO SLIDER
  - DC DRAWER - CUTLERY
  - DF DRINKING FOUNTAIN
  - DG DOUBLE GLAZED
  - DGR GRATED DRAIN
  - DM DRAWER - MONEY
  - DML METAL LOUVER DOOR
  - DMM METAL MESH DOOR
  - DP RAINWATER DOWN PIPE
  - DPL PANEL LIFT DOOR
  - DPT PAPER TOWEL DISPENSER
  - DRS ROLLER SHUTTER DOOR
  - DSC SOLID CORE DOOR
  - DSG SLIDING GLAZED DOOR
  - DW DISH WASHER
  - EDB ELECTRICAL DISTRIBUTION BOARD
  - EG EAVES GUTTER
  - EJ EXPRESSED JOINT
  - EQ EQUAL
  - EX EXISTING
  - F FIXED GLAZING
  - FB FACE BRICK
  - FBL FIRE BLANKET
  - FC FIBRE CEMENT
  - FD FOLD DOWN SEAT
  - FE-B FINISHED CEILING LEVEL
  - FCL FIRE EXTINGUISHER TYPE B
  - FLL FINISHED FLOOR LEVEL
  - FGF FROSTED GLASS FILM
  - FHR FIRE HOSE REEL
  - FL FLASHING
  - FP FLAG POLE
  - FRE FREEZER
  - FR FIRE RATED
  - FRPB FIRE RATED PLASTERBOARD
  - FV FLOOR VENT
  - FW FLOOR WASTE
  - GAL GALVANISED STEEL FINISH
  - GH GAS HEATERS
  - GL GENERAL LEARNING SPACE
  - GLX EXISTING GROUND LINE
  - GR GRAB RAIL
  - GR-D DROP DOWN GRAB RAIL
  - GWB GLASS WHITE BOARD
  - H CLOTHES HOOK
  - HH HYDRONIC HEATERS
  - HR HANDRAIL
  - HWS HOT WATER SYSTEM
  - ISF INDUSTRIAL SHEET FLOORING
  - IWB INTERACTIVE WHITE BOARD
  - KG KERB GUTTER
  - KR KERB ROLLER
  - LAM LAMINATE
  - LB LIGHTING BAR
  - LGA ADJUSTABLE GLASS LOUVRES
  - LMA ADJUSTABLE METAL LOUVRES
  - LMF FIXED METAL LOUVRES
  - LT LAUNDRY TUB WITH CUPBOARD
  - MC MEDICINE CABINET
  - MCW METAL WALL CLADDING
  - M MIRROR
  - MS STAINLESS STEEL MIRROR
  - MS MAIN SWITCH BOARD
  - MSS MOBILE SHELVING SYSTEM / COMPACTUS
  - MV MECHANICAL VENT
  - MVE MECHANICAL VENT EXHAUST COWL
  - MW MICROWAVE OVEN
  - NOT TO SCALE
  - OFC OFF FORM CONCRETE
  - PB PLASTERBOARD
  - PCA POWDER COATED ALUMINIUM
  - PF PALLISADE FENCING
  - PIV PINBOARD
  - PLS POLYCARBONATE SHEETING
  - PLY PLYWOOD
  - PCM PERFORATED CORRUGATED METAL
  - PPL PERFORATED PLYWOOD
  - PBP PERFORATED PLASTERBOARD
  - PT PAINTED FINISH
  - PWR WATER RESISTANT PLASTERBOARD
  - R-BK RACK FOR BATS
  - R-LM RACK MODULE FOR METAL LENGTHS
  - R-LW RACK MODULE FOR WOOD LENGTHS
  - R-SM RACK, TIMBER STAGE
  - RAF ABUTMENT FLASHING
  - RBC BARGE CAPPING
  - REF REFRIGERATOR
  - RHS RECTANGULAR HOLLOW SECTION
  - RL RELATIVE LEVEL
  - RO ROOF OVER
  - RP PEG TYPE RACK
  - RRC ROOF CAPPING
  - RSL ROLLER SHUTTER
  - RSM METAL ROOF SHEETING
  - RSF METAL ROOF FLASHING
  - RST TRANSLUCENT ROOF SHEETING
  - RV ROOF VENTILATOR
  - RVP VALLEY FLASHING
  - RETAINING WALL
  - RWG RAINWATER GUTTER
  - RWS RAINWATER SUMP
  - SA ADJUSTABLE SHELVING
  - SB SEAT - BENCH
  - SBK STAINLESS STEEL SPLASHBACK
  - SCM CORRUGATED METAL SOFFIT
  - SC(C) STEEL COLUMN OVER
  - SD SOAP DISPENSER
  - SEAL FLOOR WASTE
  - SH SHELF
  - SHD SHOWER HEAD
  - SK SKIRTING
  - SKC SECURITY KEY CABINET
  - SMS SECURITY MESH SCREEN
  - SP SPRANDREL PANEL
  - SPL SPLASHBACK
  - SPR SPREADER
  - SSN SUN SCREEN
  - ST STAIR SCREEN
  - STN STAIR NOSING
  - SW SWALE
  - TCI TACTILE INDICATORS
  - TMB TIMBER LOOK ALUMINIUM CLADDING
  - TMV THERMOSTATIC MIXING VALVE
  - TOW TOP OF WALL
  - TP TIMBER FLOOR
  - TPH TOILET PAPER HOLDER
  - TR TERRAZZO PARTITION
  - TPS TOWEL RAIL
  - TZP TERRAZZO PARTITION
  - ISF INDUSTRIAL SHEET FLOORING
  - UCS UNDERSIDE OF CONCRETE SLAB
  - UR URINAL
  - VP VIEWING PANEL
  - VVP VENT PIPE
  - WC TOILET
  - WMP WELD MESH FENCE
  - WS WALL STIFFENER
  - WSP WHEEL STOP

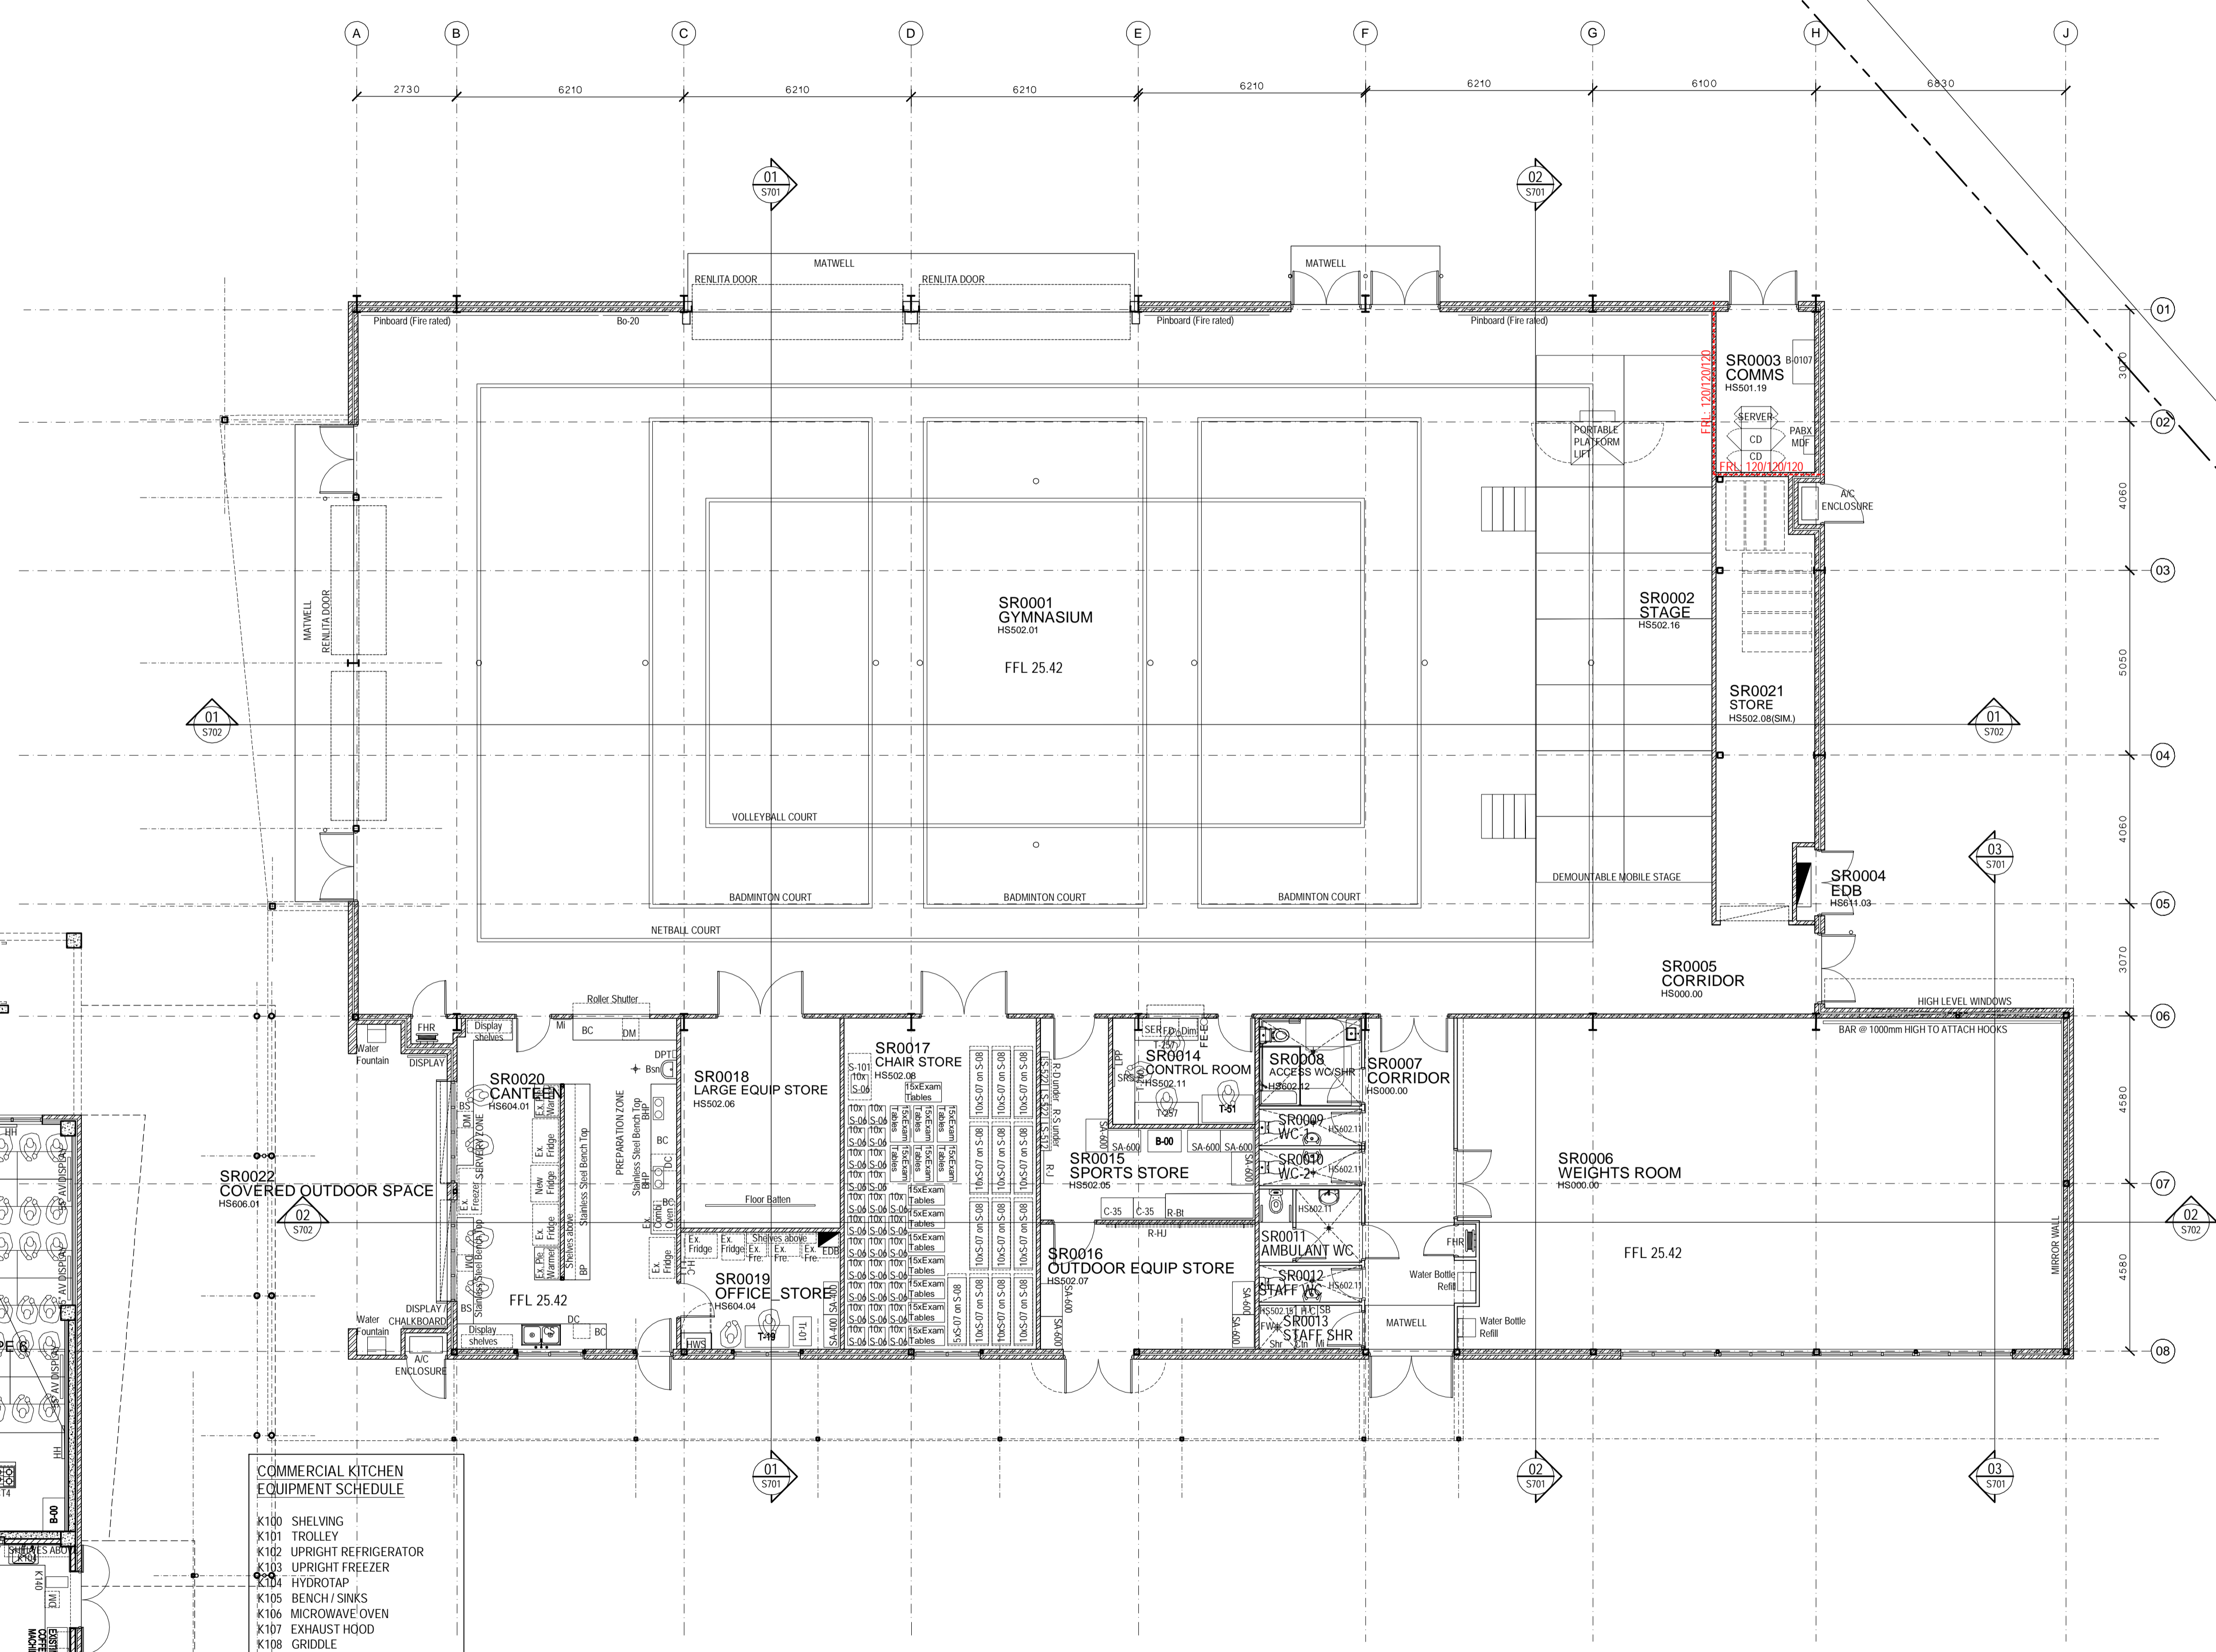

**EJE ARCHITECTURE**  
 ACN 002 912 843 | ABN 82 644 649 849  
 Nominated Architect - Bernard Collins  
 P +61 2 4929 2353 | F +61 2 4926 3069 | W www.eje.com.au  
 A 412 KING STREET, NEWCASTLE, NSW 2300

COMPLETION OF THE QUALITY ASSURANCE CHECKS IS VERIFICATION THAT THE DOCUMENT CONFORMS WITH THE REQUIREMENTS OF THE QUALITY PROJECT PLAN. WHERE QUALITY ASSURANCE CHECK IS INCOMPLETE THIS DOCUMENT IS PRELIMINARY FOR INFORMATION PURPOSES ONLY, OR SUCH PURPOSES AS STATED IN THE REVISION COLUMN.

THE IDEAS, INFORMATION AND CONCEPTS CONTAINED IN THIS DOCUMENT ARE THE PROPERTY OF EJE ARCHITECTURE. PHOTOCOPIING OR REPRODUCING THIS DOCUMENT AND PASSING IT ON TO OTHERS WITHOUT THE EXPRESS PERMISSION OF EJE ARCHITECTURE IS AN INFRINGEMENT OF COPYRIGHT. ©

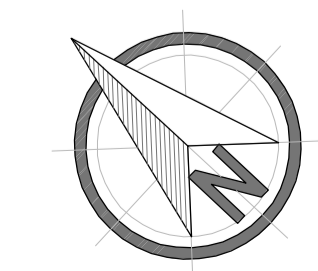

**NOT FOR CONSTRUCTION**



PROJECT: HUNTER SPORTS HIGH SCHOOL  
 MAJOR CAPITAL WORKS UPGRADE

CLIENT: NSW GOVERNMENT Public Works  
 NSW GOVERNMENT Education

SITE: PACIFIC HIGHWAY  
 GATESHEAD 2290


DRAWING: BLOCK S  
 FURNITURE FITOUT PLAN

WORK IN FIGURED DIMENSIONS IN PREFERENCE TO SCALE. CHECK DIMENSIONS AND LEVELS ON SITE PRIOR TO THE ORDERING OF MATERIALS OR THE COMPLETION OF WORKSHOP DRAWINGS. IF IN DOUBT ASK. REPORT ALL ERRORS AND OMISSIONS.


CONTRACT No: WS692136689  
 DRAWN: GG DATE: FEB 2016 SCALES: 1:100@A1  
 PROJECT No: 11029 PHASE: WD DRAWING No: A-S401 REV: 0



LEGEND	
AC	AIR CONDITIONING
ACR	ACRYLIC PANEL
B	BOLLARD
BAL	BALUSTRADE
BC	BENCH CUPBOARD
BHO	BULKHEAD OVER
BHP	BOILING HOT PLATE
BL	BLOCKWORK
BO	BUILDING OVER
BOE	BRICK ON EDGE - CUT SOLDIER COURSE
BR	BACK REST
BS	BUCKET SINK
BSN	BASIN
BTC	CUPBOARD BENCH TOP
BTP	PREPARATION BENCH TOP
BTS	SERVERY BENCH TOP
BU	BUILDING UNDER
CAT	CEILING ACOUSTIC TILES
CC	CONCRETE - STEEL TROWEL FINISH
CFC	COMPRESSED FIBRE CEMENT
CFL	CABINET FOR FLAMMABLE LIQUIDS
CH	CONVECTION HEATER
CJ	CONTROL JOINT
CMS	CONCRETE MOWING STRIP
COL	COLUMN
COLA	COVERED OUTDOOR LEARNING AREA
CONC	CONCRETE PAVING
CPT	CARPET
CR	CEMENT RENDER
CT	CERAMIC TILE
CTN	SHOWER CURTAIN AND TRACK
CWA	COVERED WALKWAY
DAS	DOOR AUTO SLIDER
DC	DRAWER - CUTLERY
DF	DRINKING FOUNTAIN
DG	DOUBLE GLAZED
DGR	GRATED DRAIN
DM	DRAWER - MONEY
DML	METAL LOUVRE DOOR
DMM	METAL MESH DOOR
DP	RAINWATER DOWN PIPE
DPL	PANEL LIFT DOOR
DPT	PAPER TOWEL DISPENSER
DRS	ROLLER SHUTTER DOOR
DSC	SOLID CORE DOOR
DSS	SLIDING GLAZED DOOR
DW	DISH WASHER
EDB	ELECTRICAL DISTRIBUTION BOARD
EG	EAVES GUTTER
EJ	EXPRESSED JOINT
EQ	EQUAL
EX	EXISTING
F	FIXED GLAZING
FB	FACE BRICK
FBK	FIBRE BRICK
FC	FIBRE CEMENT
FD	FOLD DOWN SEAT
FCL	FINISHED CEILING LEVEL
FE-B	FIRE EXTINGUISHER TYPE B
FFL	FINISHED FLOOR LEVEL
FGF	FROSTED GLASS FILM
FHR	FIRE HOSE REEL
FL	FLASHING
FP	FLAG POLE
FRE	FREEZER
FR	FIRE RATED
FRPB	FIRE RATED PLASTERBOARD
FV	FLOOR VENT
FW	FLOOR WASTE
GAL	GALVANISED STEEL FINISH
GH	GAS HEATERS
GL	GROUND LINE
GLS	GENERAL LEARNING SPACE
GLX	EXISTING GROUND LINE
GR	GRAB RAIL
GR-D	DROP DOWN GRAB RAIL
GWB	GLASS WHITE BOARD
H	CLOTHES HOOK
HH	HYDRONIC HEATERS
HR	HANDRAIL
HWS	HOT WATER SYSTEM
ISF	INDUSTRIAL SHEET FLOORING
IWB	INTERACTIVE WHITE BOARD
KG	KERB GUTTER
KR	KERB ROLLER
LAM	LAMINATE
LB	LIGHTING BAR
LGA	ADJUSTABLE GLASS LOUVRES
LMA	ADJUSTABLE METAL LOUVRES
LMF	FIXED METAL LOUVRES
LT	LAUNDRY TUB WITH CUPBOARD
MC	MEDICINE CABINET
MCW	METAL WALL CLADDING
MI	MIRROR
MI-S	STAINLESS STEEL MIRROR
MS	MOWING STRIP
MSB	MAIN SWITCH BOARD
MSS	MOBILE SHELVING SYSTEM / COMPACTUS
MV	MECHANICAL VENT
MVE	MECHANICAL VENT EXHAUST COUL
MW	MICROWAVE OVEN
NTS	NOT TO SCALE
OFC	OFF FORM CONCRETE
PB	PLASTERBOARD
PCA	POWDER COATED ALUMINIUM
PF	PALLISADE FENCING
PH	PINBOARD
PLS	POLYCARBONATE SHEETING
PLY	PLYWOOD
PCM	PERFORATED CORRUGATED METAL
PFL	PERFORATED PLYWOOD
PPB	PERFORATED PLASTERBOARD
PW	PAINTED FINISH
PTR	WATER RESISTANT PLASTERBOARD
R-B	RACK FOR BATS
R-LM	RACK MODULE FOR METAL LENGTHS
R-LW	RACK MODULE FOR WOOD LENGTHS
R-SM	RACK MODULE FOR TIMBER SHEETS
R-TS	RACK, TIMBER STACK
RAF	ABUTMENT FLASHING
RBC	BARGE CAPPING
REF	REFRIGERATOR
RHS	RECTANGULAR HOLLOW SECTION
RL	RELATIVE LEVEL
RO	ROOF OVER
RP	PEG TYPE RACK
RRC	ROOF CAPPING
RS	ROLLER SHUTTER
RSM	METAL ROOF SHEETING
RSF	METAL ROOF FLASHING
RST	TRANSLUCENT ROOF SHEETING
RV	ROOF VENTILATOR
RVF	VALLEY FLASHING
RW	RETAINING WALL
RWG	RAINWATER GUTTER
RWS	RAINWATER SUMP
SA	ADJUSTABLE SHELVING
SB	SEAT - BENCH
SBK	STAINLESS STEEL SPLASHBACK
SCM	CORRUGATED METAL SOFFIT
SCIO	STEEL COLUMN (OVER)
SD	SOAP DISPENSER
SE	SEALED FLOOR WASTE
SH	SHELF
SHD	SHOWER HEAD
SK	SKIRTING
SKC	SECURITY KEY CABINET
SMS	SECURITY MESH SCREEN
SP	SPRANDELL PANEL
SPL	SPLASHBACK
SPL	SPLASHER
SSN	SUN SCREEN
ST	STORE
STN	STAIR NOSING
SW	SWALE
TCI	TACTILE INDICATORS
TMB	TIMBER LOOK ALUMINIUM CLADDING
TMV	THERMOSTATIC MIXING VALVE
TOW	TOP OF WALL
TP	TIMBER FLOOR
TPH	TOILET PAPER HOLDER
TPS	TIMBER SPRUNG FLOOR
TR	TERRAZZO PARTITION
ISF	INDUSTRIAL SHEET FLOORING
UCS	UNDERSIDE OF CONCRETE SLAB
UR	URINAL
VP	VIEWING PANEL
VVP	VENT PIPE
WC	TOILET
WMP	WELD MESH FENCE
WS	WALL STIFFENER
WSP	WHEEL STOP
WT	WASH TROUGH

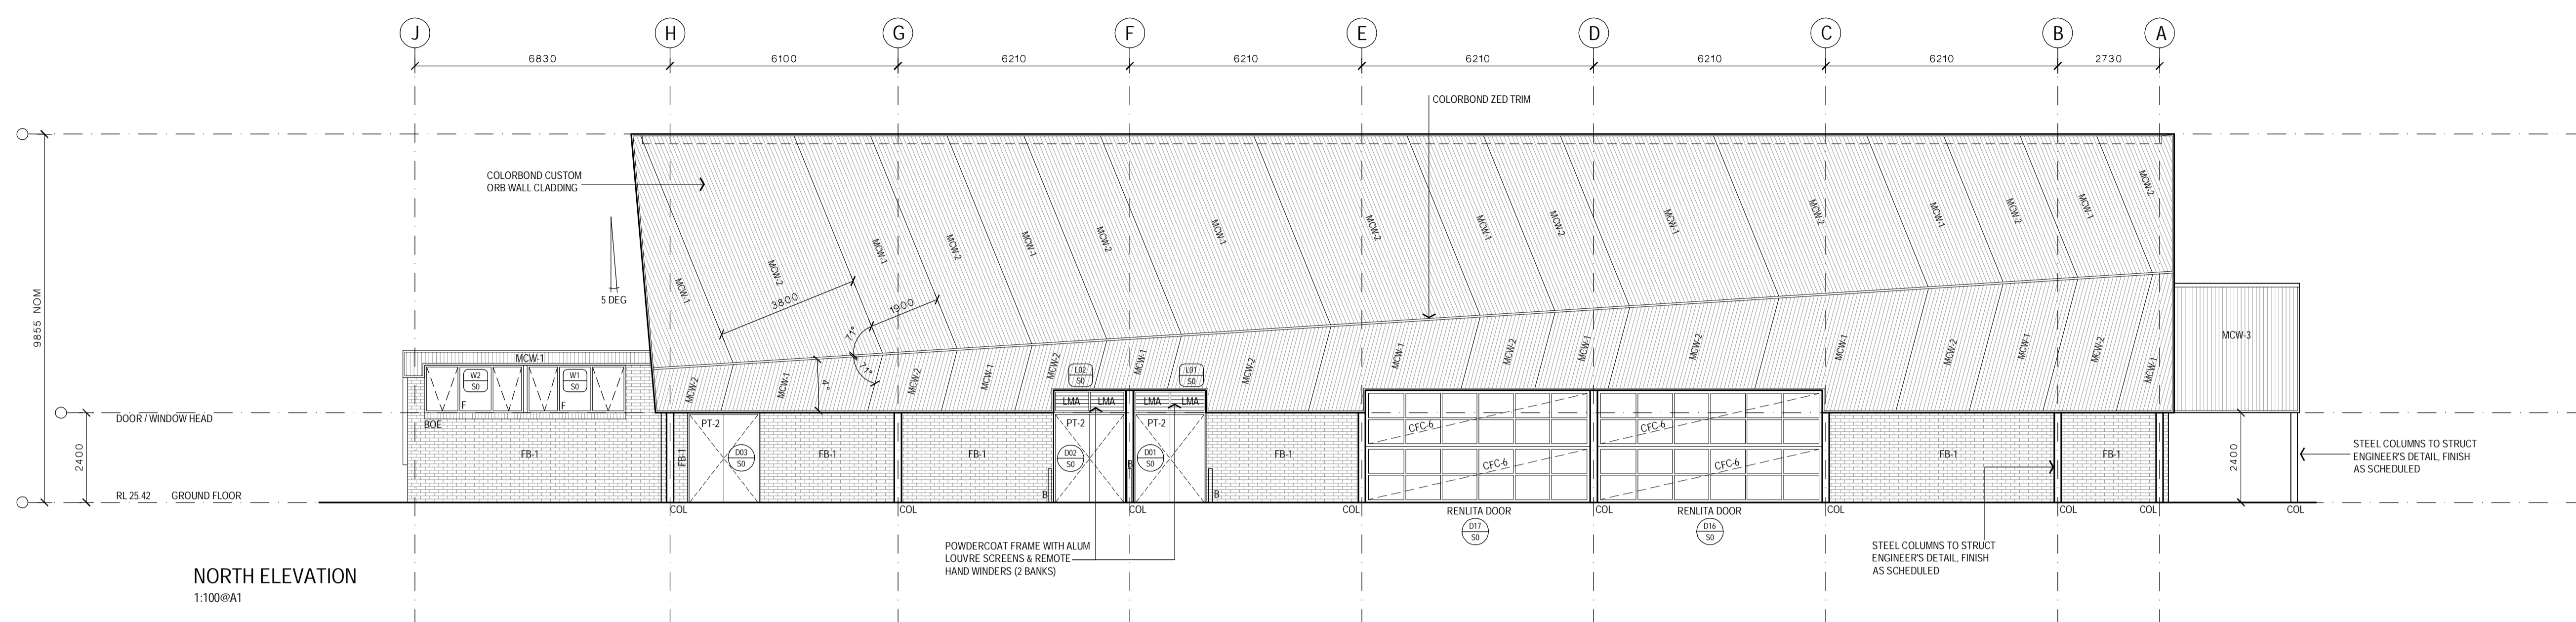

NORTH ELEVATION  
1:100@A1

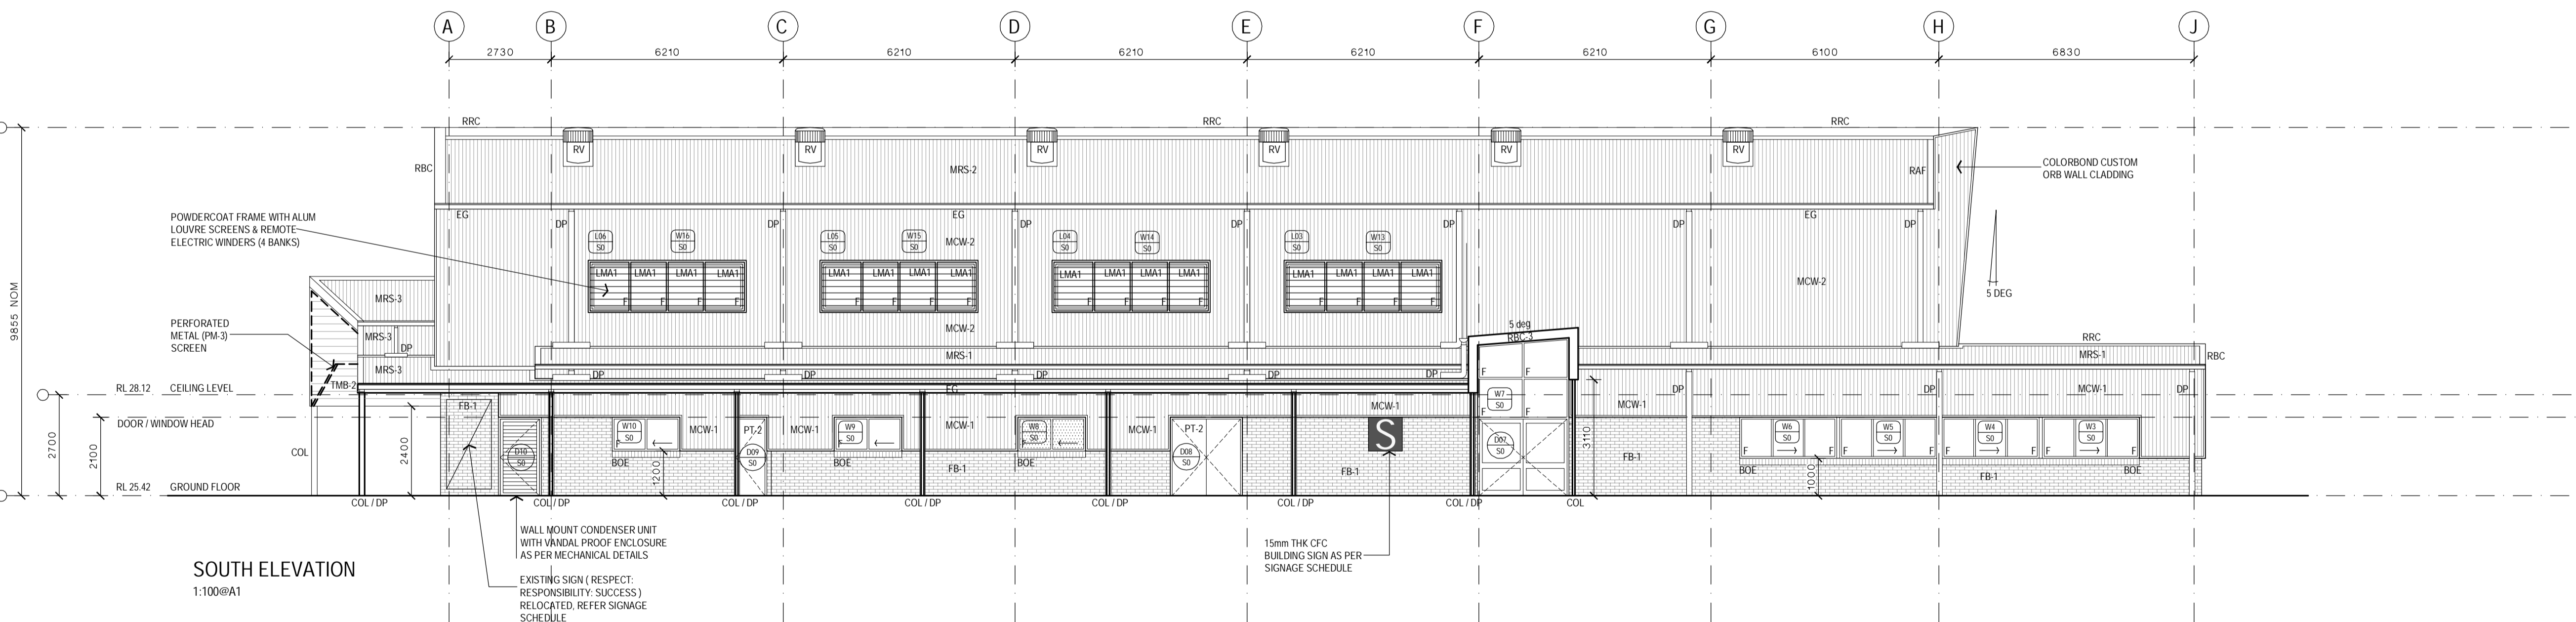

SOUTH ELEVATION  
1:100@A1

**EJE ARCHITECTURE**  
 ACN 002 912 843 | ABN 82 644 649 849  
 NSW Architects Registration No. 4338  
 Nominated Architects - Bernard Collins | NSW Architects Registration No. 4338  
 P +61 2 4529 2353 | F +61 2 4529 3069 | E mail@eje.com.au | W www.eje.com.au  
 A 412 KING STREET, NEWCASTLE, NSW 2300

**NOT FOR CONSTRUCTION**

REV	DATE	COMMENTS
0	25.05.2016	ISSUE FOR TENDER

DRN | CHKD | VRFD |  
 JM GS



PROJECT: HUNTER SPORTS HIGH SCHOOL  
 MAJOR CAPITAL WORKS UPGRADE



SITE: PACIFIC HIGHWAY  
 GATESHEAD 2290

DRAWING: BLOCK S  
 ELEVATIONS

WORK IN FIGURED DIMENSIONS IN PREFERENCE TO SCALE. CHECK DIMENSIONS AND LEVELS ON SITE PRIOR TO THE ORDERING OF MATERIALS OR THE COMPLETION OF WORKSHOP DRAWINGS. IF IN DOUBT ASK. REPORT ALL ERRORS AND OMISSIONS.

CONTRACT NO: WS692136689  
 DRAWN: DATE: SCALES:  
 FEB 2016 1:100@A1  
 PROJECT NO: 11029 PHASE: WD DRAWING NO: A-S601 REV: 0



COMPLETION OF THE QUALITY ASSURANCE CHECKS IS VERIFICATION THAT THE DOCUMENT CONFORMS WITH THE REQUIREMENTS OF THE QUALITY PROJECT PLAN. WHERE QUALITY ASSURANCE CHECK IS INCOMPLETE THIS DOCUMENT IS PRELIMINARY FOR INFORMATION PURPOSES ONLY, OR SUCH PURPOSES AS STATED IN THE REVISION COLUMN.  
 THE IDEAS, INFORMATION AND CONCEPTS CONTAINED IN THIS DOCUMENT ARE THE PROPERTY OF EJE ARCHITECTURE. PHOTOCOPYING OR REPRODUCING THIS DOCUMENT AND PASSING IT ON TO OTHERS WITHOUT THE EXPRESS PERMISSION OF EJE ARCHITECTURE IS AN INFRINGEMENT OF COPYRIGHT. ©

**NOT FOR CONSTRUCTION**

COMPLETION OF THE QUALITY ASSURANCE CHECKS IS VERIFICATION THAT THE DOCUMENT CONFORMS WITH THE REQUIREMENTS OF THE QUALITY PROJECT PLAN WHERE QUALITY ASSURANCE CHECK IS INCOMPLETE THIS DOCUMENT IS PRELIMINARY FOR INFORMATION PURPOSES ONLY, OR SUCH PURPOSES AS STATED IN THE REVISION COLUMN.  
 THE IDEAS, INFORMATION AND CONCEPTS CONTAINED IN THIS DOCUMENT ARE THE PROPERTY OF EJE ARCHITECTURE. PHOTOCOPIING OR REPRODUCING THIS DOCUMENT AND PASSING IT ONTO OTHERS WITHOUT THE EXPRESS PERMISSION OF EJE ARCHITECTURE IS AN INFRINGEMENT OF COPYRIGHT. ©

REV	DATE	COMMENTS
0	25.05.2016	ISSUE FOR TENDER

DRN	CHKD	VRFD
JIM	GS	LS



PROJECT: HUNTER SPORTS HIGH SCHOOL MAJOR CAPITAL WORKS UPGRADE



SITE: PACIFIC HIGHWAY GATESHEAD 2290

DRAWING: BLOCK S ELEVATIONS

WORK IN FIGURED DIMENSIONS IN PREFERENCE TO SCALE. CHECK DIMENSIONS AND LEVELS ON SITE PRIOR TO THE ORDERING OF MATERIALS OR THE COMPLETION OF WORKSHOP DRAWINGS. IF IN DOUBT ASK. REPORT ALL ERRORS AND OMISSIONS.

CONTRACT No: WS692136689



DRAWN: DATE: FEB 2016 SCALES: 1:100@A1

PROJECT No: 11029 PHASE: WD DRAWING No: A-S602 0 REV: 0






**LEGEND**

- AC AIR CONDITIONING
- ACR ACRYLIC PANEL
- B BOLLARD
- BAL BALUSTRADE
- BC BENCH CUPBOARD
- BHO BULKHEAD OVER
- BHP BOILING HOT PLATE
- BL BLOCKWORK
- BO BUILDING OVER
- BOE BRICK ON EDGE - CUT SOLDIER COURSE
- BR BACK REST
- BS BUCKET SINK
- BSN BASIN
- BTC CUPBOARD BENCH TOP
- BTP PREPARATION BENCH TOP
- BTS SERVING BENCH TOP
- BU BUILDING UNDER
- CAT CEILING ACOUSTIC TILES
- CC CONCRETE - STEEL TROWEL FINISH
- CFC COMPRESSED FIBRE CEMENT
- CFL CABINET FOR FLAMMABLE LIQUIDS
- CH CONVECTION HEATER
- CJ CONTROL JOINT
- CMS CONCRETE MOWING STRIP
- COL COL UMN
- COLA COVERED OUTDOOR LEARNING AREA
- CONC CONCRETE PAVING
- CPT CARPET
- CR CEMENT RENDER
- CT CERAMIC TILE
- CTN SHOWER CURTAIN AND TRACK
- CWA COVERED WALKWAY
- DAS DOOR AUTO SLIDER
- DC DRAWER - CUTLERY
- DF DRINKING FOUNTAIN
- DG DOUBLE GLAZED
- DGR GRATED DRAIN
- DM DRAWER - MONEY
- DML METAL LOUVER DOOR
- DMM METAL MESH DOOR
- DP RAINWATER DOWN PIPE
- DPL PANEL LIFT DOOR
- DPT PAPER TOWEL DISPENSER
- DRS ROLLER SHUTTER DOOR
- DSC SOLID CORE DOOR
- DSG SLIDING GLAZED DOOR
- DW DISH WASHER
- EDB ELECTRICAL DISTRIBUTION BOARD
- EG EAVES GUTTER
- EJ EXPRESSED JOINT
- EQ EQUAL
- EX EXISTING
- FB FIXED GLAZING
- FB FACE BRICK
- FBL FIRE BLANKET
- FC FIBRE CEMENT
- FD FOLD DOWN SEAT
- FCL FINISHED CEILING LEVEL
- FE-B FIRE EXTINGUISHER TYPE B
- FEL FINISHED FLOOR LEVEL
- FGF FROSTED GLASS FILM
- FHR FIRE HOSE REEL
- FL FLASHING
- FP FLAG POLE
- FRE FREEZER
- FR FIRE RATED
- FRPB FIRE RATED PLASTERBOARD
- FV FLOOR VENT
- FW FLOOR WASTE
- GAL GALVANISED STEEL FINISH
- GH GAS HEATERS
- GL GROUND LINE
- GLS GENERAL LEARNING SPACE
- GLX EXISTING GROUND LINE
- GR GRAB RAIL
- GR-D DROP DOWN GRAB RAIL
- GWB GLASS WHITE BOARD
- H-C CLOTHES HOOK
- HH HYDRONIC HEATERS
- HR HANDRAIL
- HWS HOT WATER SYSTEM
- ISF INDUSTRIAL SHEET FLOORING
- IBW INTERACTIVE WHITE BOARD
- KG KERB GUTTER
- KR KERB ROLLER
- LAM LAMINATE
- LB LIGHTING BAR
- LGA ADJUSTABLE GLASS LOUVRES
- LMA ADJUSTABLE METAL LOUVRES
- LMF FIXED METAL LOUVRES
- LT LAUNDRY TUB WITH CUPBOARD
- MC MEDICINE CABINET
- MCW METAL WALL CLADDING
- MI MIRROR
- MI-S STAINLESS STEEL MIRROR
- MS MOWING STRIP
- MSB MAIN SWITCH BOARD
- MSS MOBILE SHELVING SYSTEM / COMPACTUS
- MV MECHANICAL VENT
- MVE MECHANICAL VENT EXHAUST COWL
- MW MICROWAVE OVEN
- NTS NOT TO SCALE
- OFC OFF FORM CONCRETE
- PB PLASTERBOARD
- PCA POWDER COATED ALUMINIUM
- PF PALLIADIE FENCING
- PIN PINBOARD
- PLS POLYCARBONATE SHEETING
- PLY PLYWOOD
- PML PERFORATED CORRUGATED METAL
- PPM PERFORATED PLYWOOD
- PPB PERFORATED PLASTERBOARD
- PT PAINTED FINISH
- PWR WATER RESISTANT PLASTERBOARD
- R-B RACK FOR BATS
- R-LW RACK MODULE FOR WOOD LENGTHS
- R-SM RACK MODULE FOR TIMBER SHEETS
- R-TS RACK TIMBER STACK
- RAF ABUTMENT FLASHING
- RBC BARGE CAPPING
- REF REFRIGERATOR
- RHS RECTANGULAR HOLLOW SECTION
- RL RELATIVE LEVEL
- RO ROOF OVER
- RP PEG TYPE RACK
- RRC ROOF CAPPING
- RS ROLLER SHUTTER
- RSM METAL ROOF SHEETING
- RSF METAL ROOF FLASHING
- RST TRANSLUCENT ROOF SHEETING
- RV ROOF VENTILATOR
- RVF VALLEY FLASHING
- RW RETAINING WALL
- RWG RAINWATER GUTTER
- RWS RAINWATER SUMP
- SA SEAT - BENCH
- SB STAINLESS STEEL SPLASHBACK
- SCM CORRUGATED METAL SOFFIT
- SC(O) STEEL COLUMN (OVER)
- SD SOAP DISPENSER
- SFW SEALED FLOOR WASTE
- SH SHELF
- SHD SHOWER HEAD
- SK SKIRTING
- SKC SECURITY KEY CABINET
- SMS SECURITY MESH SCREEN
- SP SPRANDREL PANEL
- SPL SPLASHBACK
- SPR SPREADER
- SSN SUN SCREEN
- ST STORE
- STN STAIR NOSING
- SW SWALE
- TCL TACTILE INDICATORS
- TMB TIMBER LOOK ALUMINIUM CLADDING
- TMV THERMOSTATIC MIXING VALVE
- TOW TOP OF WALL
- TP TAP
- TPF TIMBER FLOOR
- TPH TOILET PAPER HOLDER
- TPS TIMBER SPRUNG FLOOR
- TR TOWEL RAIL
- ISF INDUSTRIAL SHEET FLOORING
- UCS UNDERSIDE OF CONCRETE SLAB
- UR URINAL
- VP VIEWING PANEL
- VVP VENT PIPE
- WC TOILET
- WMF WELD MESH FENCE
- WS WALL STIFFENER
- WSP WHEEL STOP
- WT WASH TROUGH

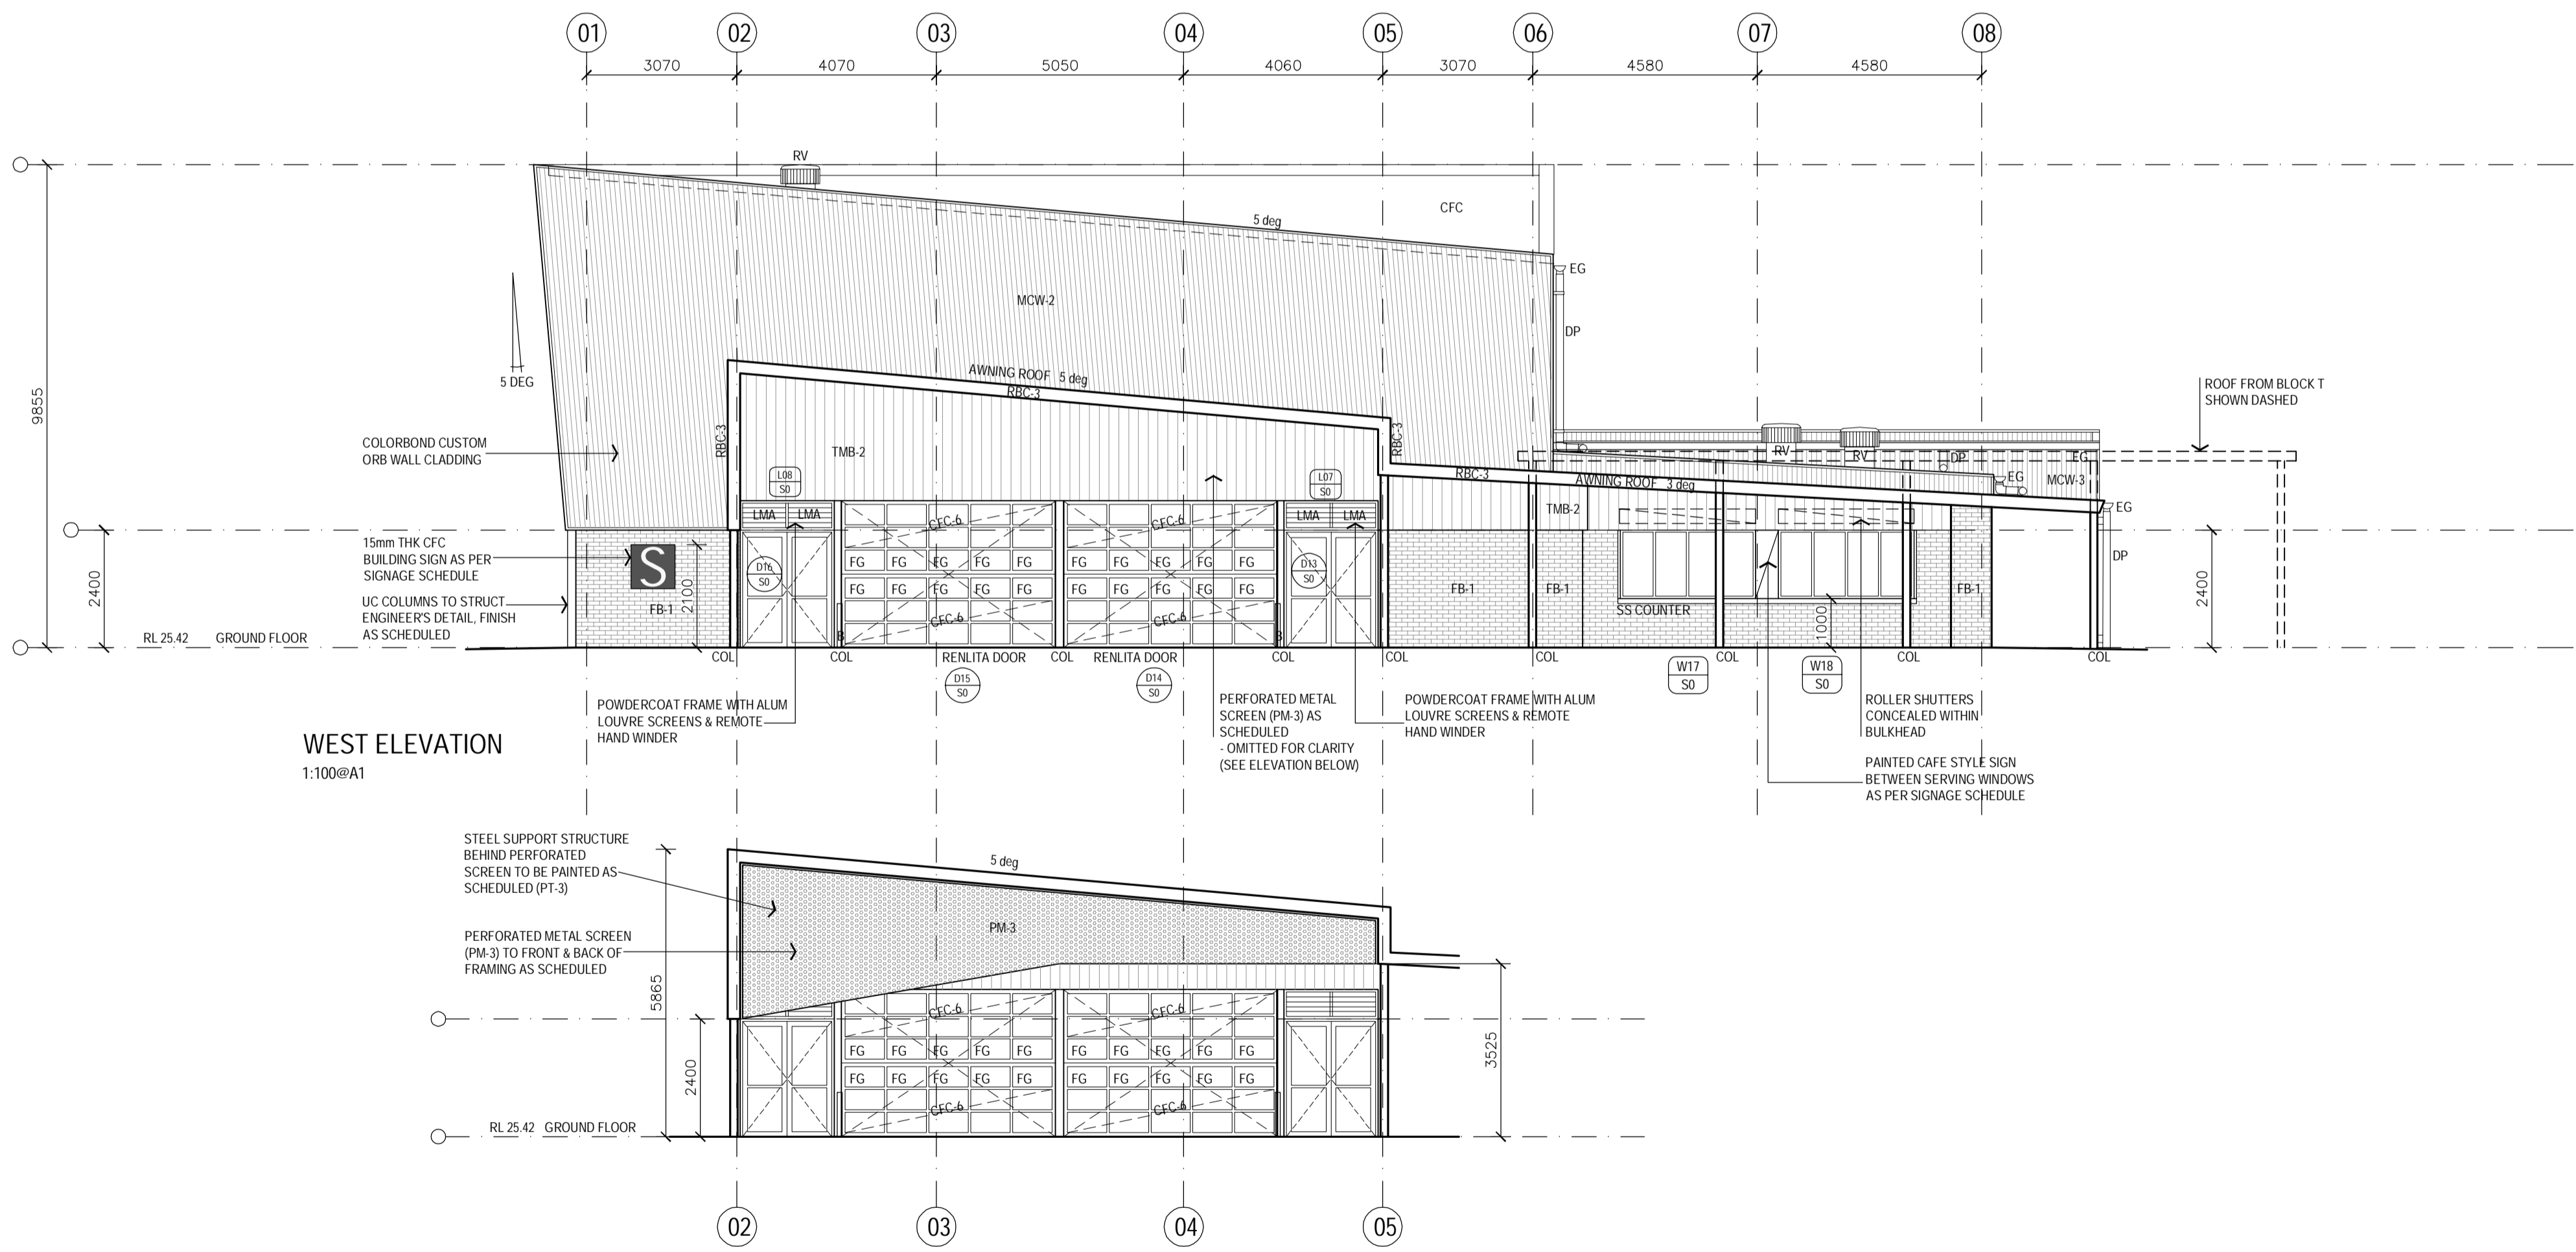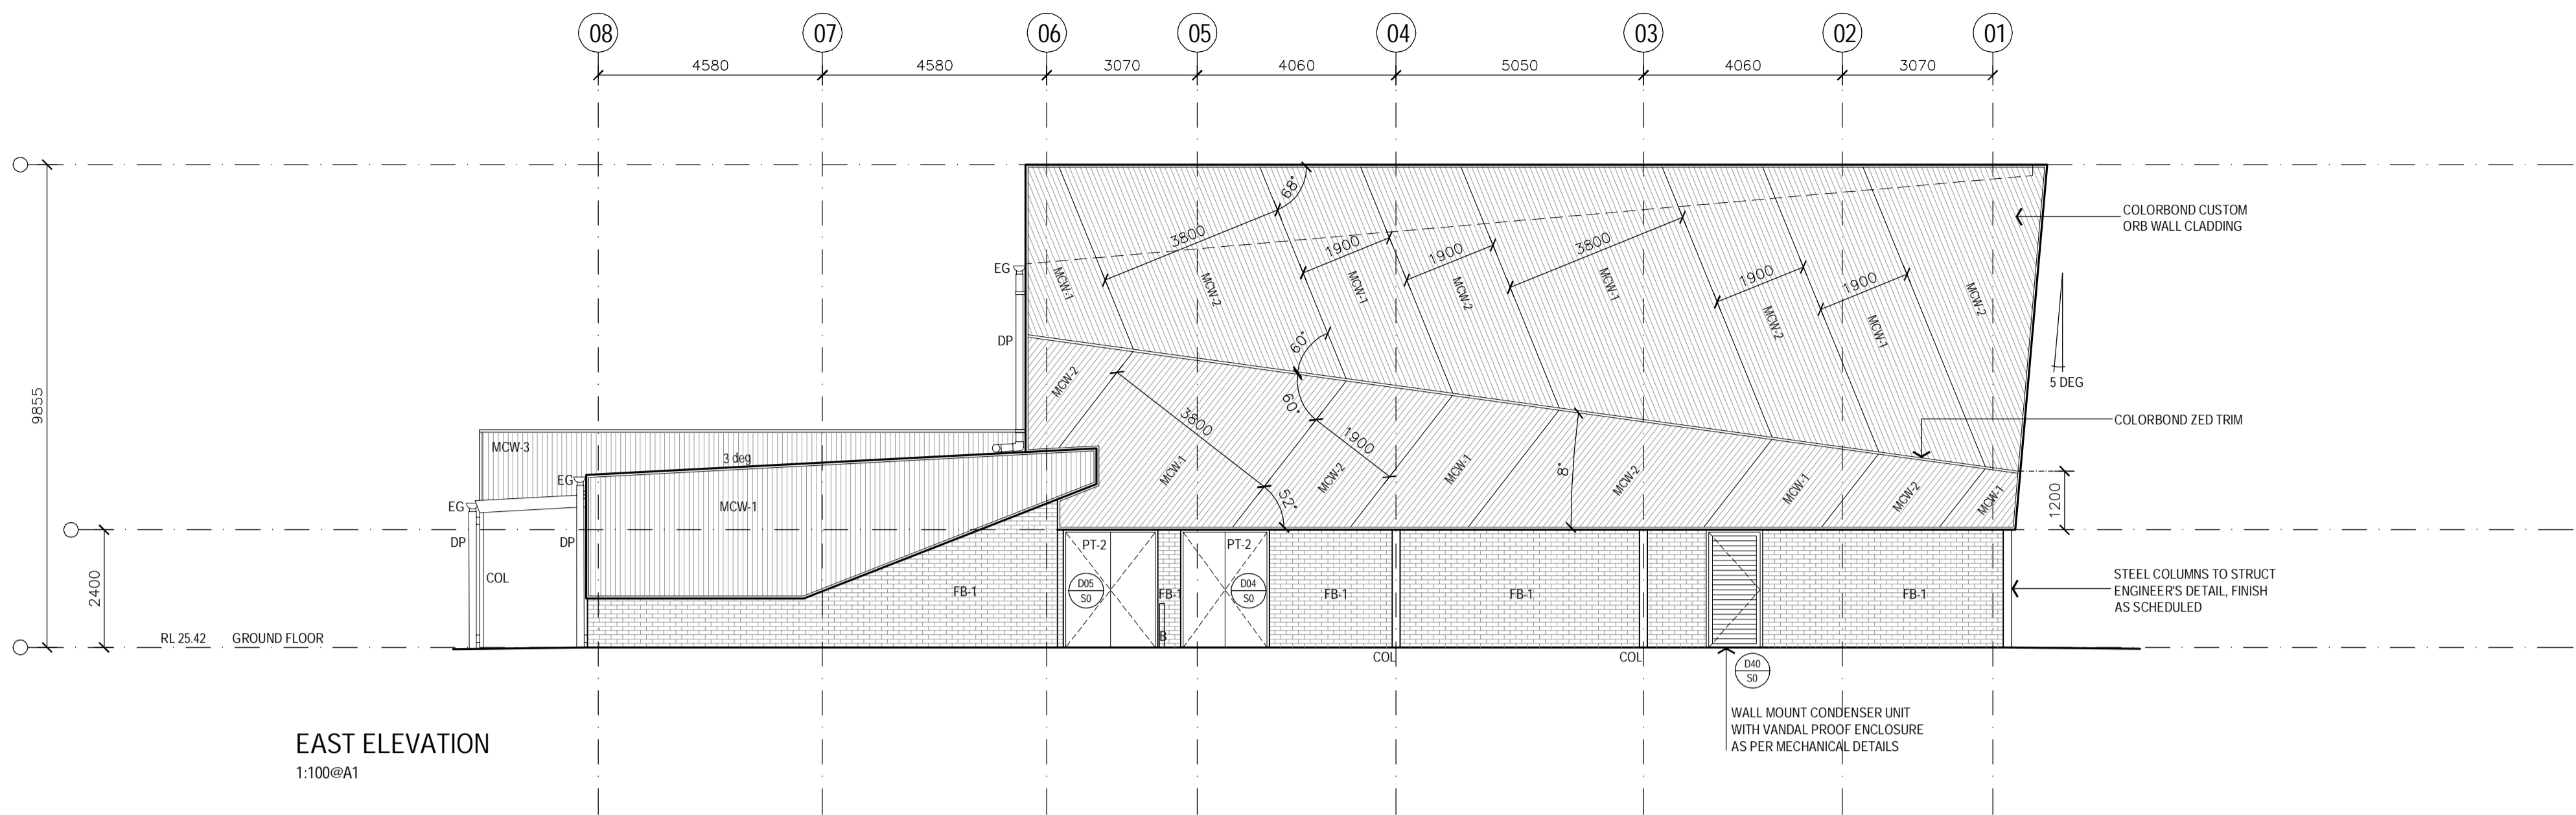

- LEGEND**
- ACR AIR CONDITIONING
  - ACR ACRYLIC PANEL
  - B BOLLARD
  - BAL BALUSTRADE
  - BC BENCH CUPBOARD
  - BHO BULKHEAD OVER
  - BHP BULKING HOT PLATE
  - BL BLOCKWORK
  - BO BUILDING OVER
  - BOE BRICK ON EDGE - CUT SOLDIER COURSE
  - BR BACK REST
  - BS BUCKET SINK
  - BSN BASIN
  - BTC CUPBOARD BENCH TOP
  - BTP PREPARATION BENCH TOP
  - BTS SERVERY BENCH TOP
  - BU BUILDING UNDER
  - CAT CEILING ACOUSTIC TILES
  - CC CONCRETE - STEEL TROUVEL FINISH
  - CFC COMPRESSED FIBRE CEMENT
  - CFL CABINET FOR FLAMMABLE LIQUIDS
  - CH CONVECTION HEATER
  - CJ CONTROL JOINT
  - CMS CONCRETE MOWING STRIP
  - COL COLUMN
  - COLA COVERED OUTDOOR LEARNING AREA
  - CONC CONCRETE PAVING
  - CPT CARPET
  - CR CEMENT RENDER
  - CT CERAMIC TILE
  - CTN SHOWER CURTAIN AND TRACK
  - CWA COVERED WALKWAY
  - DAS DOOR AUTO SLIDER
  - DC DRAWER - CUTLERY
  - DF DRINKING FOUNTAIN
  - DD DOUBLE GLAZED
  - DGR GRATED DRAIN
  - DM DRAWER - MONEY
  - DML METAL LOUVRE DOOR
  - DMM METAL MESH DOOR
  - DP RAINWATER DOWN PIPE
  - DPL PANEL LIFT DOOR
  - DPT PAPER TOWEL DISPENSER
  - DRS ROLLER SHUTTER DOOR
  - DSC SOLID CORE DOOR
  - DSG SLIDING GLAZED DOOR
  - DW DISH WASHER
  - EDB ELECTRICAL DISTRIBUTION BOARD
  - EG EAVES GUTTER
  - EJ EXPRESSED JOINT
  - EQ EQUAL
  - EX EXISTING
  - F FIXED GLAZING
  - FB FACE BRICK
  - FBL FIRE BLANKET
  - FC FIBRE CEMENT
  - FD FOLD DOWN SEAT
  - FCL FINISHED CEILING LEVEL
  - FE-B FIRE EXTINGUISHER TYPE B
  - FFL FINISHED FLOOR LEVEL
  - FGF FROSTED GLASS FILM
  - FHR FIRE HOSE REEL
  - FL FLASHING
  - FP FLAG POLE
  - FRE FREEZER
  - FR FIRE RATED
  - FRPB FIRE RATED PLASTERBOARD
  - FV FLOOR VENT
  - FW FLOOR WASTE
  - GAL GALVANISED STEEL FINISH
  - GH GAS HEATERS
  - GL GROUND LINE
  - GLS GENERAL LEARNING SPACE
  - GLX EXISTING GROUND LINE
  - GR GRAB RAIL
  - GR-D DROP DOWN GRAB RAIL
  - GWB GLASS WHITE BOARD
  - H-C CLOTHES HOOK
  - HH HYDRONIC HEATERS
  - HR HANDRAIL
  - HWS HOT WATER SYSTEM
  - ISF INDUSTRIAL SHEET FLOORING
  - WB INTERACTIVE WHITE BOARD
  - KG KERB GUTTER
  - KR KERB ROLLOVER
  - LAM LAMINATE
  - LB LIGHTING BAR
  - LGA ADJUSTABLE GLASS LOUVRES
  - LMA ADJUSTABLE METAL LOUVRES
  - LMF FIXED METAL LOUVRES
  - LT LAUNDRY TUB WITH CUPBOARD
  - MC METAL WALL CLADDING
  - MCW METAL WALL CLADDING
  - M MIRROR
  - MS STAINLESS STEEL MIRROR
  - MS MOWING STRIP
  - MSB MAIN SWITCH BOARD
  - MSS MOBILE SHELVING SYSTEM / COMPACTUS
  - MV MECHANICAL VENT
  - MVE MECHANICAL VENT EXHAUST COWL
  - MW MICROWAVE OVEN
  - NTS NOT TO SCALE
  - OPC OFF FORM CONCRETE
  - PB PLASTERBOARD
  - PCA POWDER COATED ALUMINIUM
  - PF PALLISADE FENCING
  - PIN PINEBOARD
  - PLS POLYCARBONATE SHEETING
  - PLY PLYWOOD
  - PCM PERFORATED CORRUGATED METAL
  - PPL PERFORATED PLYWOOD
  - PPB PERFORATED PLASTERBOARD
  - PT PAINTED FINISH
  - PWR WATER RESISTANT PLASTERBOARD
  - R-BI RACK FOR BATS
  - R-LM RACK MODULE FOR METAL LENGTHS
  - R-LW RACK MODULE FOR WOOD LENGTHS
  - R-SM RACK MODULE FOR TIMBER SHEETS
  - R-TS RACK, TIMBER STACK
  - RAF ABUTMENT FLASHING
  - RBC BARGE CAPPING
  - REF REFRIGERATOR
  - RHS RECTANGULAR HOLLOW SECTION
  - RL RELATIVE LEVEL
  - RO ROOF OVER
  - RR PEG TYPE RACK
  - RRC ROOF GAPPING
  - RS ROLLER SHUTTER
  - RSM METAL ROOF SHEETING
  - RSF METAL ROOF FLASHING
  - RST TRANSLUCENT ROOF SHEETING
  - RV ROOF VENTILATOR
  - RVF VALLEY FLASHING
  - RW RETAINING WALL
  - RWG RAINWATER GUTTER
  - RWS RAINWATER SLUMP
  - SA ADJUSTABLE SHELVING
  - SB SEAT - BENCH
  - SBK STAINLESS STEEL SPLASHBACK
  - SCM CORRUGATED METAL SOFFIT
  - SCIO STEEL COLUMN (OVER)
  - SD SOAP DISPENSER
  - SFW SEALED FLOOR WASTE
  - SH SHELF
  - SHD SHOWER HEAD
  - SK SKIRTING
  - SKC SECURITY KEY CABINET
  - SMS SECURITY MESH SCREEN
  - SP SPRANDREL PANEL
  - SPL SPLASHBACK
  - SPR SPREADER
  - SSN SUN SCREEN
  - ST STORE
  - STN STAIR NOSING
  - SW SWALE
  - TCI TACTILE INDICATORS
  - TMB TIMBER LOOK ALUMINIUM CLADDING
  - TMV THERMOSTATIC MIXING VALVE
  - TOW TOP OF WALKWAY
  - TP TIMBER FLOOR
  - TPH TOILET PAPER HOLDER
  - TPS TIMBER SPRUNG FLOOR
  - TR TOWEL RAIL
  - T2P TERRAZZO PARTITION
  - ISF INDUSTRIAL SHEET FLOORING
  - UCS UNDERSIDE OF CONCRETE SLAB
  - UR URNAL
  - VP VIEWING PANEL
  - VVP VENT PIPE
  - WC TOILET
  - WMF WELD MESH FENCE
  - WS WALL STIFFENER
  - WSP WASH STOP
  - WTT WASH TROUGH

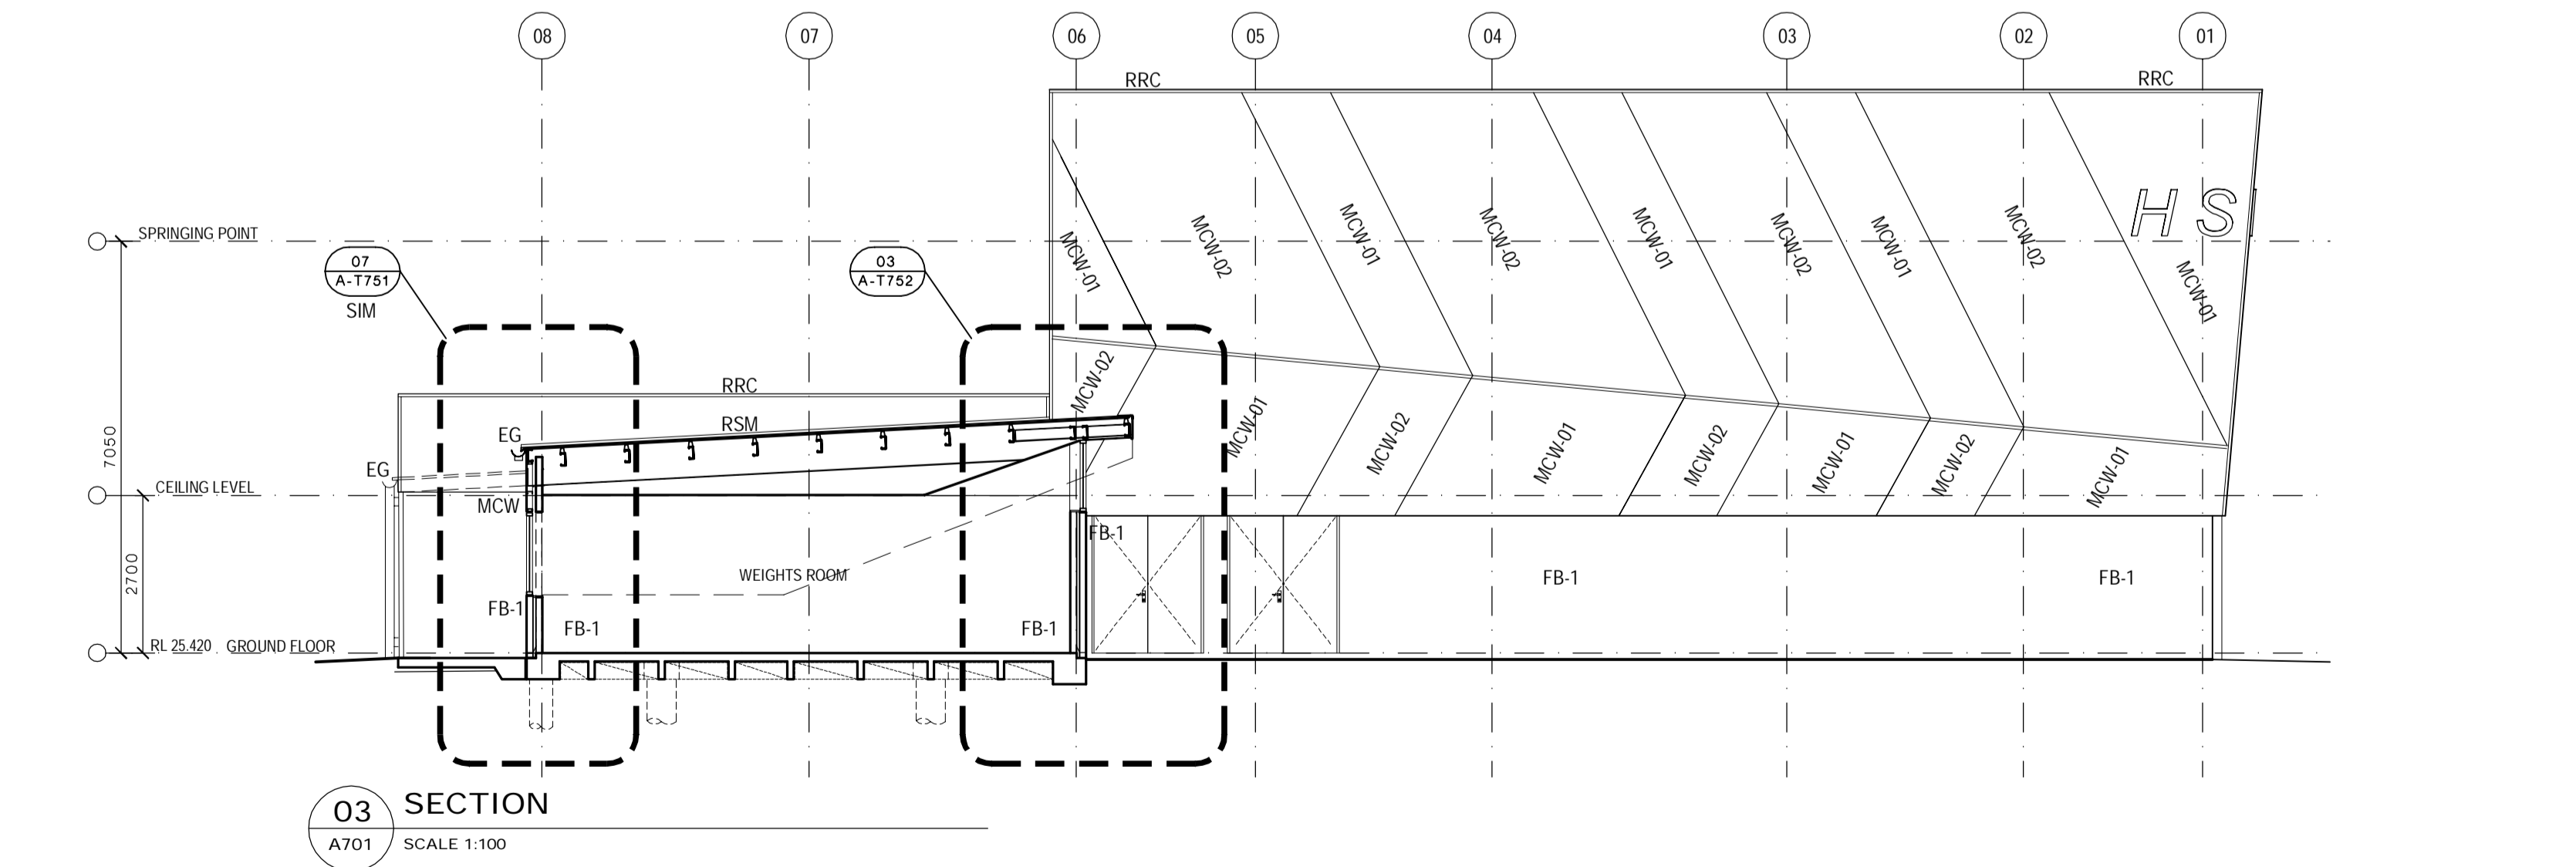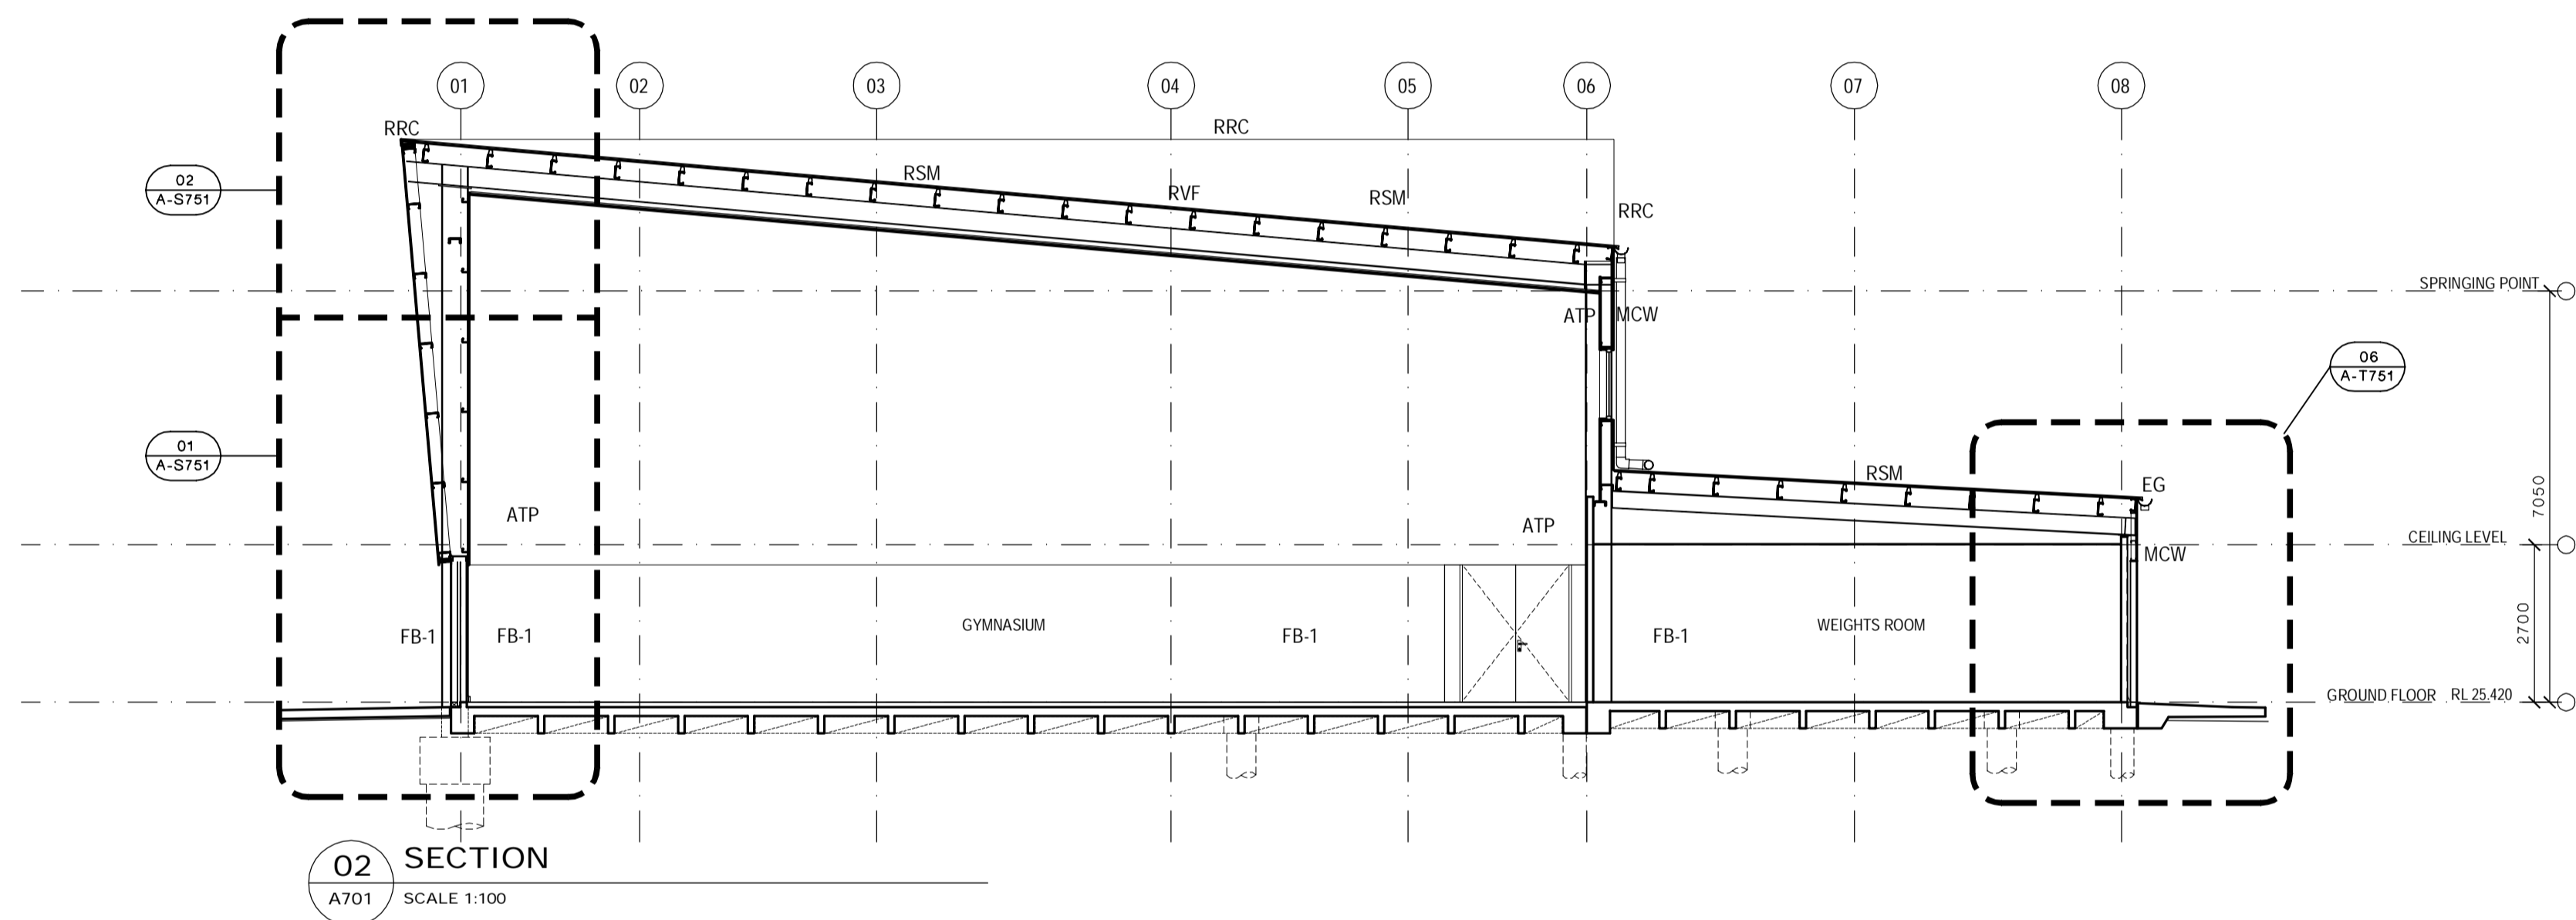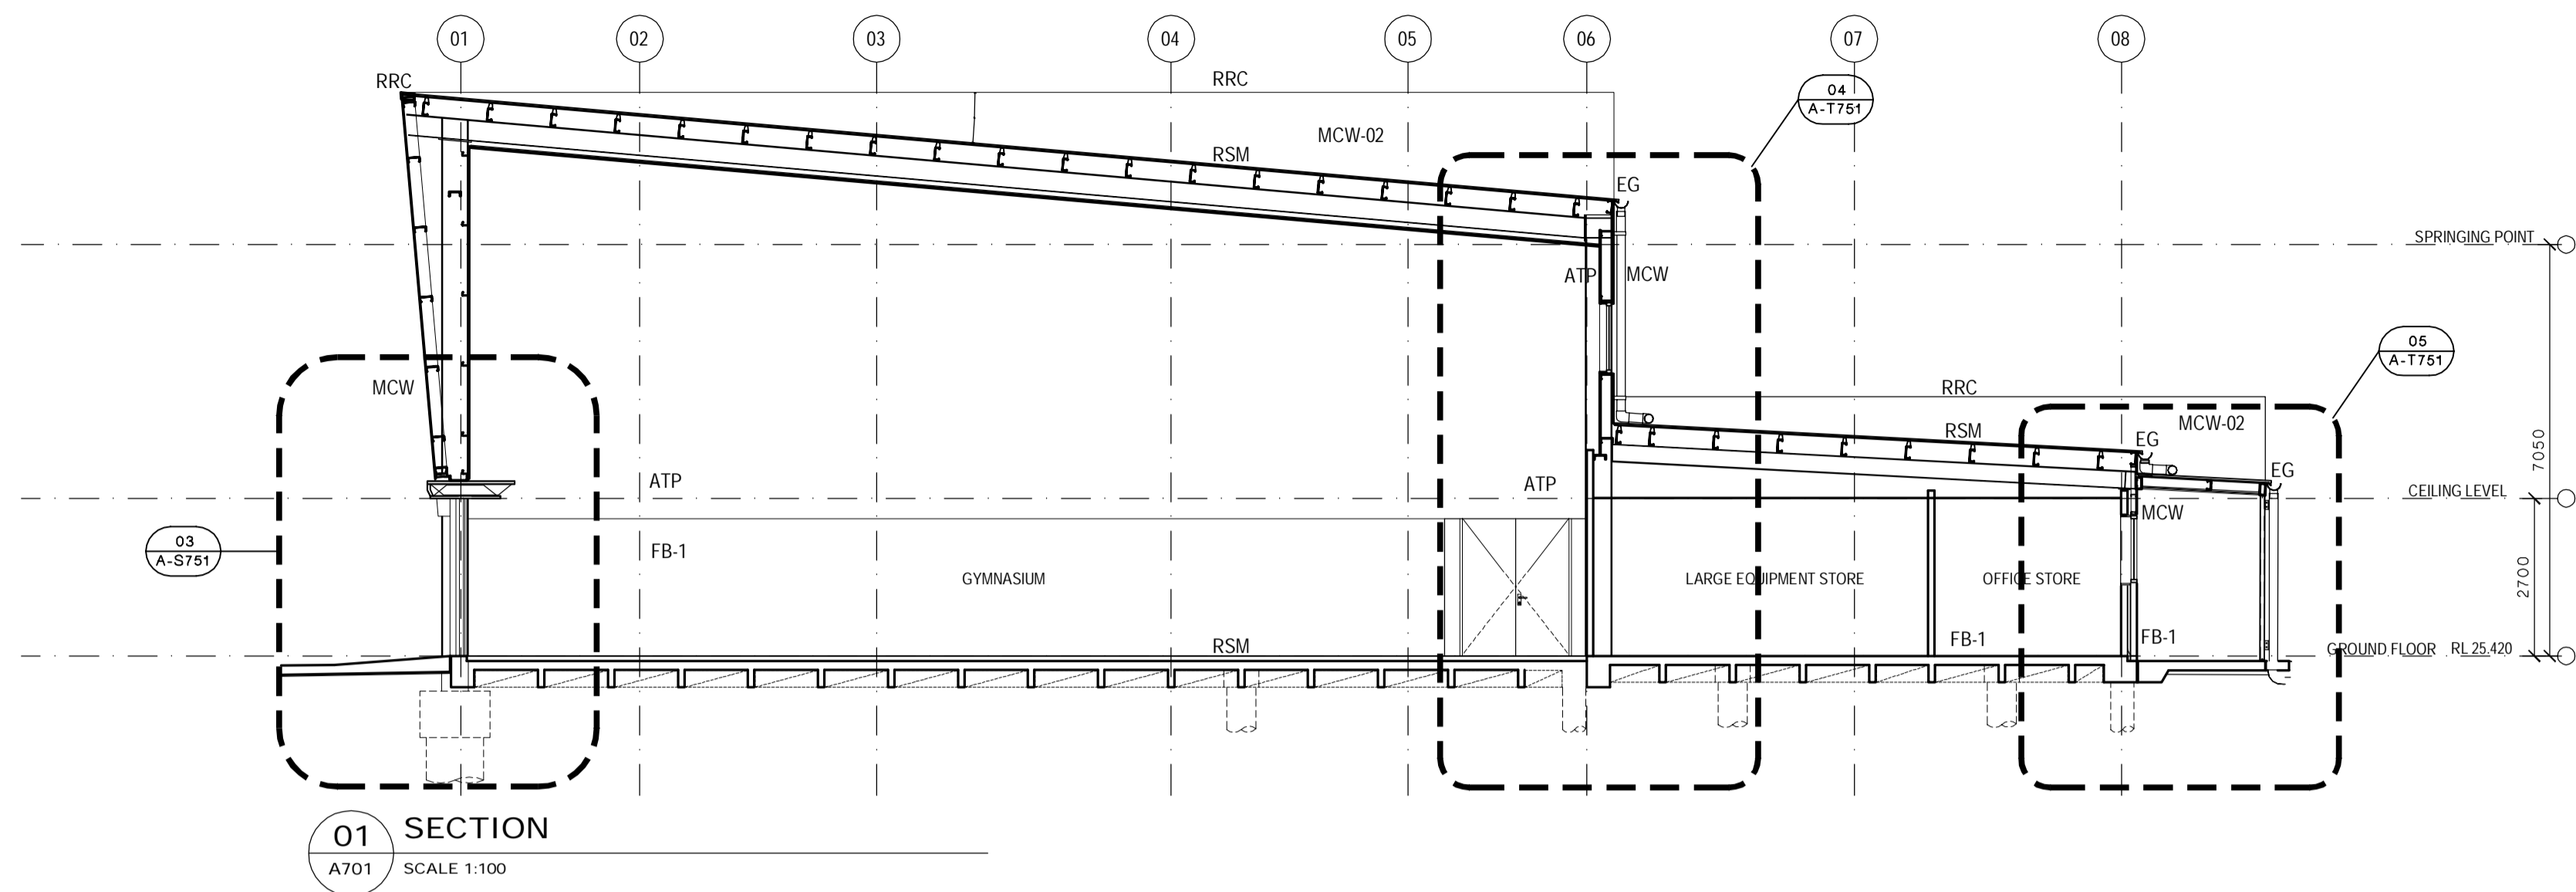

**EJE ARCHITECTURE**  
 ACN 002 912 843 | ABN 62 644 649 849  
 NSW Architects Registration No: 4438  
 P +61 2 4929 2353 | F +61 2 4926 3096 | E mail@eje.com.au | W www.eje.com.au  
 A 412 KING STREET, NEWCASTLE, NSW 2300

**NOT FOR CONSTRUCTION**

REV	DATE	COMMENTS
0	25.05.2016	ISSUE FOR TENDER

DRN | CHKD | VRFD |  
 GG | GS | *[Signature]*



PROJECT: HUNTER SPORTS HIGH SCHOOL  
 MAJOR CAPITAL WORKS UPGRADE




SITE: PACIFIC HIGHWAY  
 GATESHEAD 2290

DRAWING: BLOCK S  
 SECTIONS


WORK IN FIGURED DIMENSIONS IN PREFERENCE TO SCALE. CHECK DIMENSIONS AND LEVELS ON SITE PRIOR TO THE ORDERING OF MATERIALS OR THE COMPLETION OF WORKSHOP DRAWINGS. IF IN DOUBT ASK. REPORT ALL ERRORS AND OMISSIONS.

CONTRACT No: WS692136689  
 DRAWN: BLC DATE: FEB 2016 SCALES: 1:100@A1  
 PROJECT No: 11029 PHASE: WD DRAWING No: A-S701 REV: 0



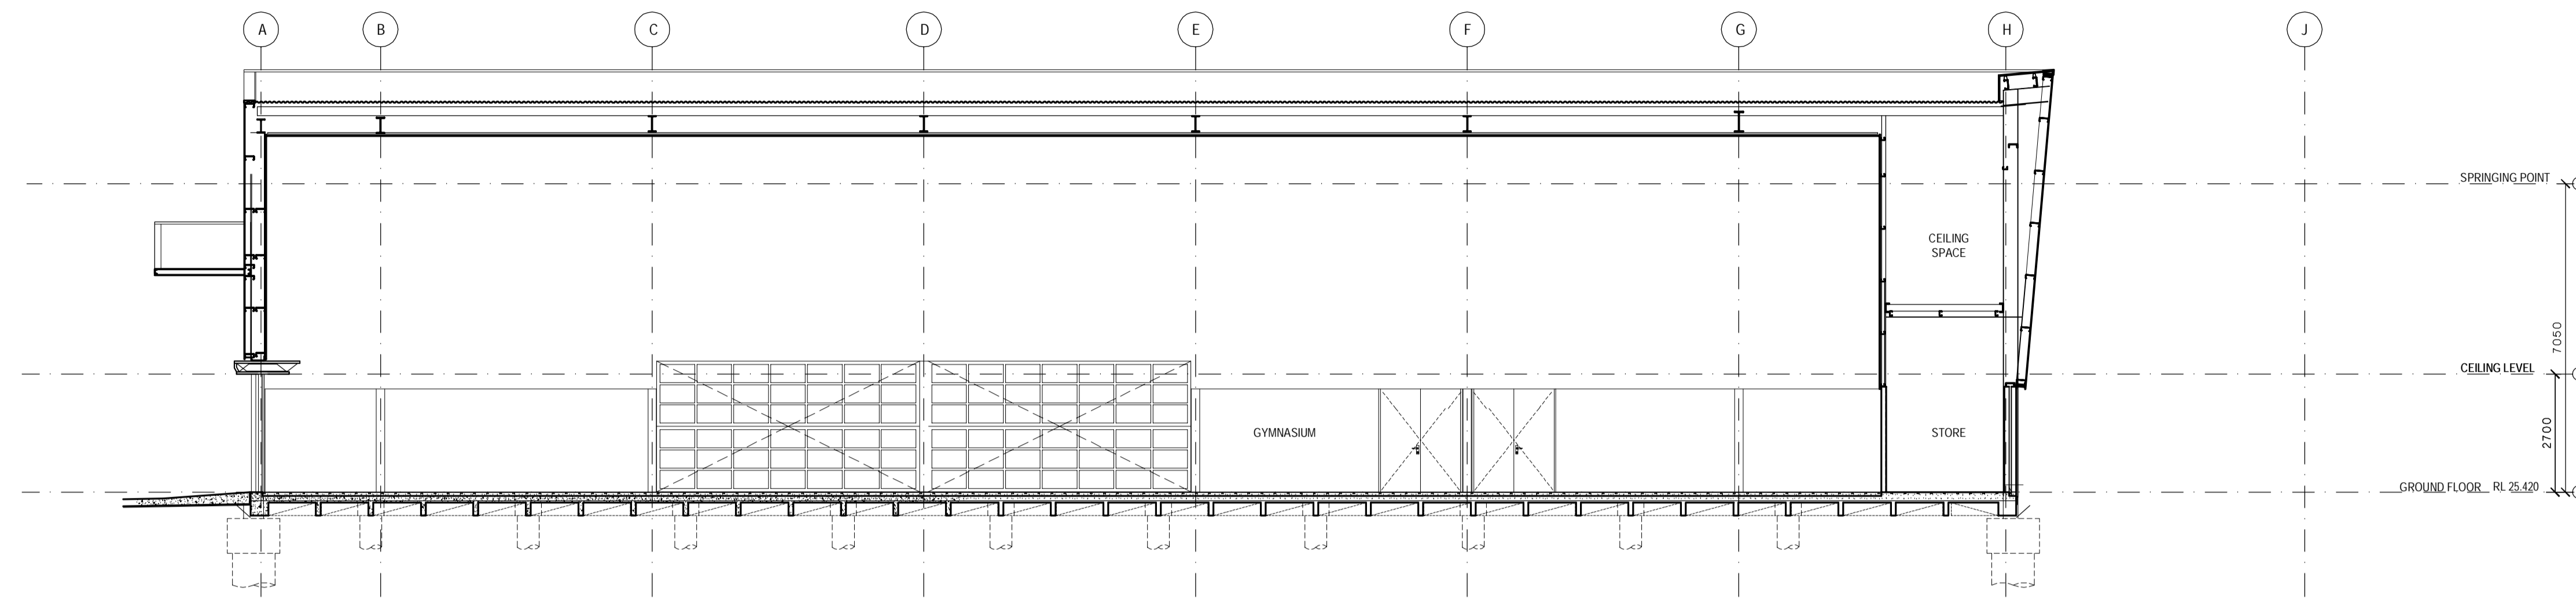

**01 SECTION**  
A701 SCALE 1:100

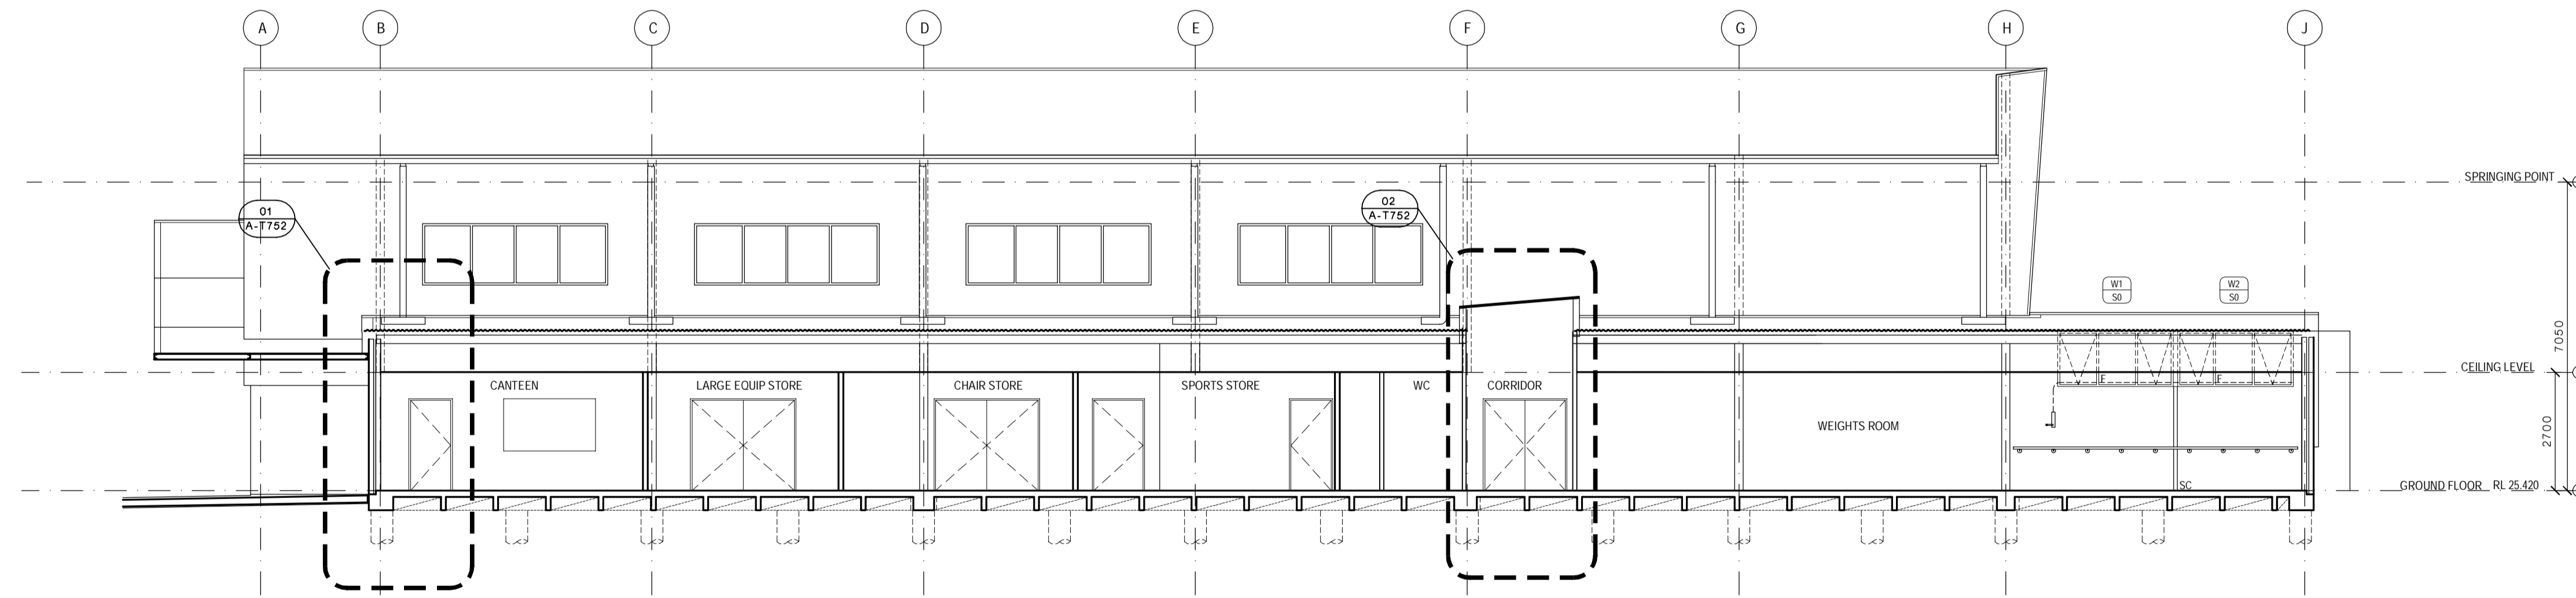

**02 SECTION**  
A701 SCALE 1:100

- LEGEND**
- ACR AIR CONDITIONING
  - ACR ACRYLIC PANEL
  - B BOLLARD
  - BAL BALUSTRADE
  - BC BENCH CUPBOARD
  - BHO BULKHEAD OVER
  - BHP BOLLING HOT PLATE
  - BL BLOCKWORK
  - BO BUILDING OVER
  - BOE BRICK ON EDGE - CUT SOLDIER COURSE
  - BR BACK REST
  - BS BUCKET SINK
  - BSN BASIN
  - BTC CUPBOARD BENCH TOP
  - BTP PREPARATION BENCH TOP
  - BTS SERVICE BENCH TOP
  - BU BUILDING UNDER
  - CAT CEILING ACOUSTIC TILES
  - CC CONCRETE - STEEL TROWEL FINISH
  - CFC COMPRESSED FIBRE CEMENT
  - CFL CABINET FOR FLAMMABLE LIQUIDS
  - CH CONVECTION HEATER
  - CJ CONTROL JOINT
  - CMS CONCRETE MOWING STRIP
  - COL COLUMN
  - COLA COVERED OUTDOOR LEARNING AREA
  - CONC CONCRETE PAVING
  - CPT CARPET
  - CR CEMENT RENDER
  - CT CERAMIC TILE
  - CTN SHOWER CURTAIN AND TRACK
  - CWA COVERED WALKWAY
  - DAS DOOR AUTO SLIDER
  - DC DRAWER - CUTLERY
  - DF DRINKING FOUNTAIN
  - DA DOUBLE GLAZED
  - DGR GRATED DRAIN
  - DM DRAWER - MONEY
  - DML METAL LOUVRE DOOR
  - DMM METAL MESH DOOR
  - DP RAINWATER DOWN PIPE
  - DPL PANEL LIFT DOOR
  - DPT PAPER TOWEL DISPENSER
  - DRS ROLLER SHUTTER DOOR
  - DSC SOLID CORE DOOR
  - DSG SLIDING GLAZED DOOR
  - DW DISH WASHER
  - EDB ELECTRICAL DISTRIBUTION BOARD
  - EG EAVES GUTTER
  - EJ EXPRESSED JOINT
  - EQ EQUAL
  - EX EXISTING
  - F FIXED GLAZING
  - FB FACE BRICK
  - FBL FIRE BLANKET
  - FC FIBRE CEMENT
  - FD FOLD DOWN SEAT
  - FCL FINISHED CEILING LEVEL
  - FEL-B FIRE EXTINGUISHER TYPE B
  - FFL FINISHED FLOOR LEVEL
  - FGF FROSTED GLASS FILM
  - FHR FIRE HOSE REEL
  - FL FLASHING
  - FP FLAG POLE
  - FR FREEZER
  - FR FIRE RATED
  - FRPB FIRE RATED PLASTERBOARD
  - FV FLOOR VENT
  - FW FLOOR WASTE
  - GAL GALVANISED STEEL FINISH
  - GH GAS HEATERS
  - GL GROUND LINE
  - GLS GENERAL LEARNING SPACE
  - GLX EXISTING GROUND LINE
  - GR GRAB RAIL
  - GR-D DROP DOWN GRAB RAIL
  - GWB GLASS WHITE BOARD
  - H-C CLOTHES HOOK
  - HH HYDRONIC HEATERS
  - HR HANDRAIL
  - HWS HOT WATER SYSTEM
  - ISF INDUSTRIAL SHEET FLOORING
  - WB INTERACTIVE WHITE BOARD
  - KG KERB GUTTER
  - KR KERB ROLLOVER
  - LAM LAMINATE
  - LB LIGHTING BAR
  - LGA ADJUSTABLE GLASS LOUVRES
  - LMA ADJUSTABLE METAL LOUVRES
  - LMF FIXED METAL LOUVRES
  - LT LAUNDRY TUB WITH CUPBOARD
  - MC MEDICINE CABINET
  - MCW METAL WALL CLADDING
  - M MIRROR
  - M-S STAINLESS STEEL MIRROR
  - MS MOWING STRIP
  - MSS MAIN SWITCH BOARD
  - MV MECHANICAL VENT
  - MVE MECHANICAL VENT EXHAUST COWL
  - NTS NOT TO SCALE
  - OPC OFF FORM CONCRETE
  - PCB PLASTERBOARD
  - PCA POWDER COATED ALUMINIUM
  - PF PALLISADE FENCING
  - PIN PINEBOARD
  - PLS POLYCARBONATE SHEETING
  - PLY PLYWOOD
  - PCM PERFORATED CORRUGATED METAL
  - PPL PERFORATED PLYWOOD
  - PRB PERFORATED PLASTERBOARD
  - PT PAINTED FINISH
  - PWR WATER RESISTANT PLASTERBOARD
  - R-BI RACK FOR BATS
  - R-LM RACK MODULE FOR METAL LENGTHS
  - R-LW RACK MODULE FOR WOOD LENGTHS
  - R-SM RACK, TIMBER SHEETS
  - R-TS RACK, TIMBER STACK
  - RAF ABUTMENT FLASHING
  - RBC BARGE CAPPING
  - REF REFRIGERATOR
  - RHS RECTANGULAR HOLLOW SECTION
  - RL RELATIVE LEVEL
  - RO ROOF OVER
  - RR PEG TYPE RACK
  - RRC ROOF CAPPING
  - RS ROLLER SHUTTER
  - RSM METAL ROOF SHEETING
  - RSF METAL ROOF FLASHING
  - RST TRANSLUCENT ROOF SHEETING
  - RV VALLEY FLASHING
  - RVF ROOF VENTILATOR
  - RW RETAINING WALL
  - RWG RAINWATER GUTTER
  - RWS RAINWATER SLUMP
  - SA ADJUSTABLE SHELVING
  - SB SEAT - BENCH
  - SBK STAINLESS STEEL SPLASHBACK
  - SCM CORRUGATED METAL SOFFIT
  - SCIO STEEL COLUMN (OVER)
  - SD SOAP DISPENSER
  - SFW SEALED FLOOR WASTE
  - SH SHELF
  - SHD SHOWER HEAD
  - SK SKIRTING
  - SNC SECURITY KEY CABINET
  - SMS SECURITY MESH SCREEN
  - SP SPRANDREL PANEL
  - SPL SPLASHBACK
  - SPR SPREADER
  - SSN SUN SCREEN
  - ST STORE
  - STN STAIR NOSING
  - SW SWALE
  - TCI TACTILE INDICATORS
  - TMB TIMBER LOOK ALUMINIUM CLADDING
  - TMV THERMOSTATIC MIXING VALVE
  - TOW TOP OF WALL
  - TP TIMBER FLOOR
  - TPH TOILET PAPER HOLDER
  - TPS TIMBER SPRUNG FLOOR
  - TR TOWEL RAIL
  - TZP TERRAZZO PARTITION
  - ISF INDUSTRIAL SHEET FLOORING
  - UCS UNDERSIDE OF CONCRETE SLAB
  - UR URNAL
  - VP VIEWING PANEL
  - VVP VENT PIPE
  - WC TOILET
  - WMF WELD MESH FENCE
  - WS WALL STIFFENER
  - WSP WASH STOP
  - WTT WASH TROUGH

**EJE ARCHITECTURE**  
 ACN 002 912 843 | ABN 62 644 649 849  
 Nominated Architect - Bernard Collins  
 P +61 2 4929 2353 | F +61 2 4926 3096 | E mail@eje.com.au | W www.eje.com.au  
 A 412 KING STREET, NEWCASTLE, NSW 2260

**NOT FOR CONSTRUCTION**

REV	DATE	COMMENTS
0	25.05.2016	ISSUE FOR TENDER

DRN | CHKD | VRFD |  
KJC JPC



PROJECT: HUNTER SPORTS HIGH SCHOOL  
MAJOR CAPITAL WORKS UPGRADE



SITE: PACIFIC HIGHWAY  
GATESHEAD 2290

DRAWING: BLOCK S  
SECTIONS

WORK IN FIGURED DIMENSIONS IN PREFERENCE TO SCALE. CHECK DIMENSIONS AND LEVELS ON SITE PRIOR TO THE ORDERING OF MATERIALS OR THE COMPLETION OF WORKSHOP DRAWINGS. IF IN DOUBT ASK. REPORT ALL ERRORS AND OMISSIONS.

CONTRACT No: WS692136689  
 DRAWN: BLC DATE: FEB 2016 SCALES: 1:100@A1  
 PROJECT No: 11029 PHASE: WD DRAWING No: A-S702 REV: 0





