





EXTERNAL ELEVATION
SCALE 1:200 @A1

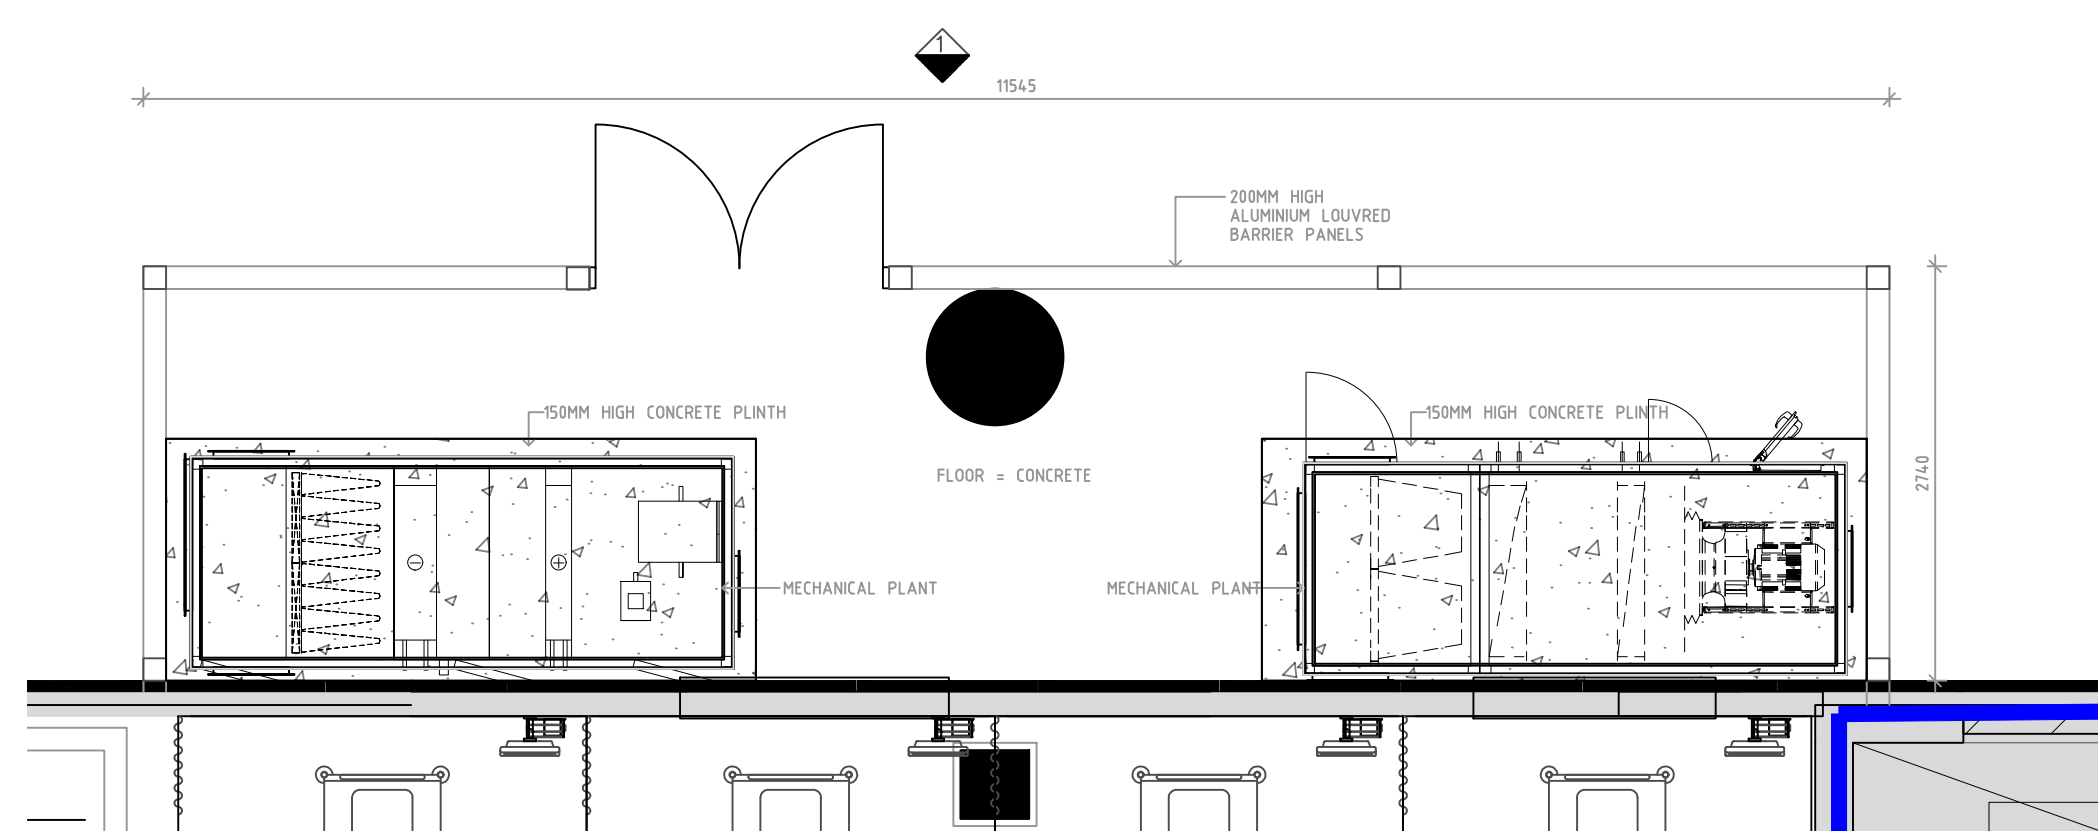

PLAN
SCALE 1:50 @A1

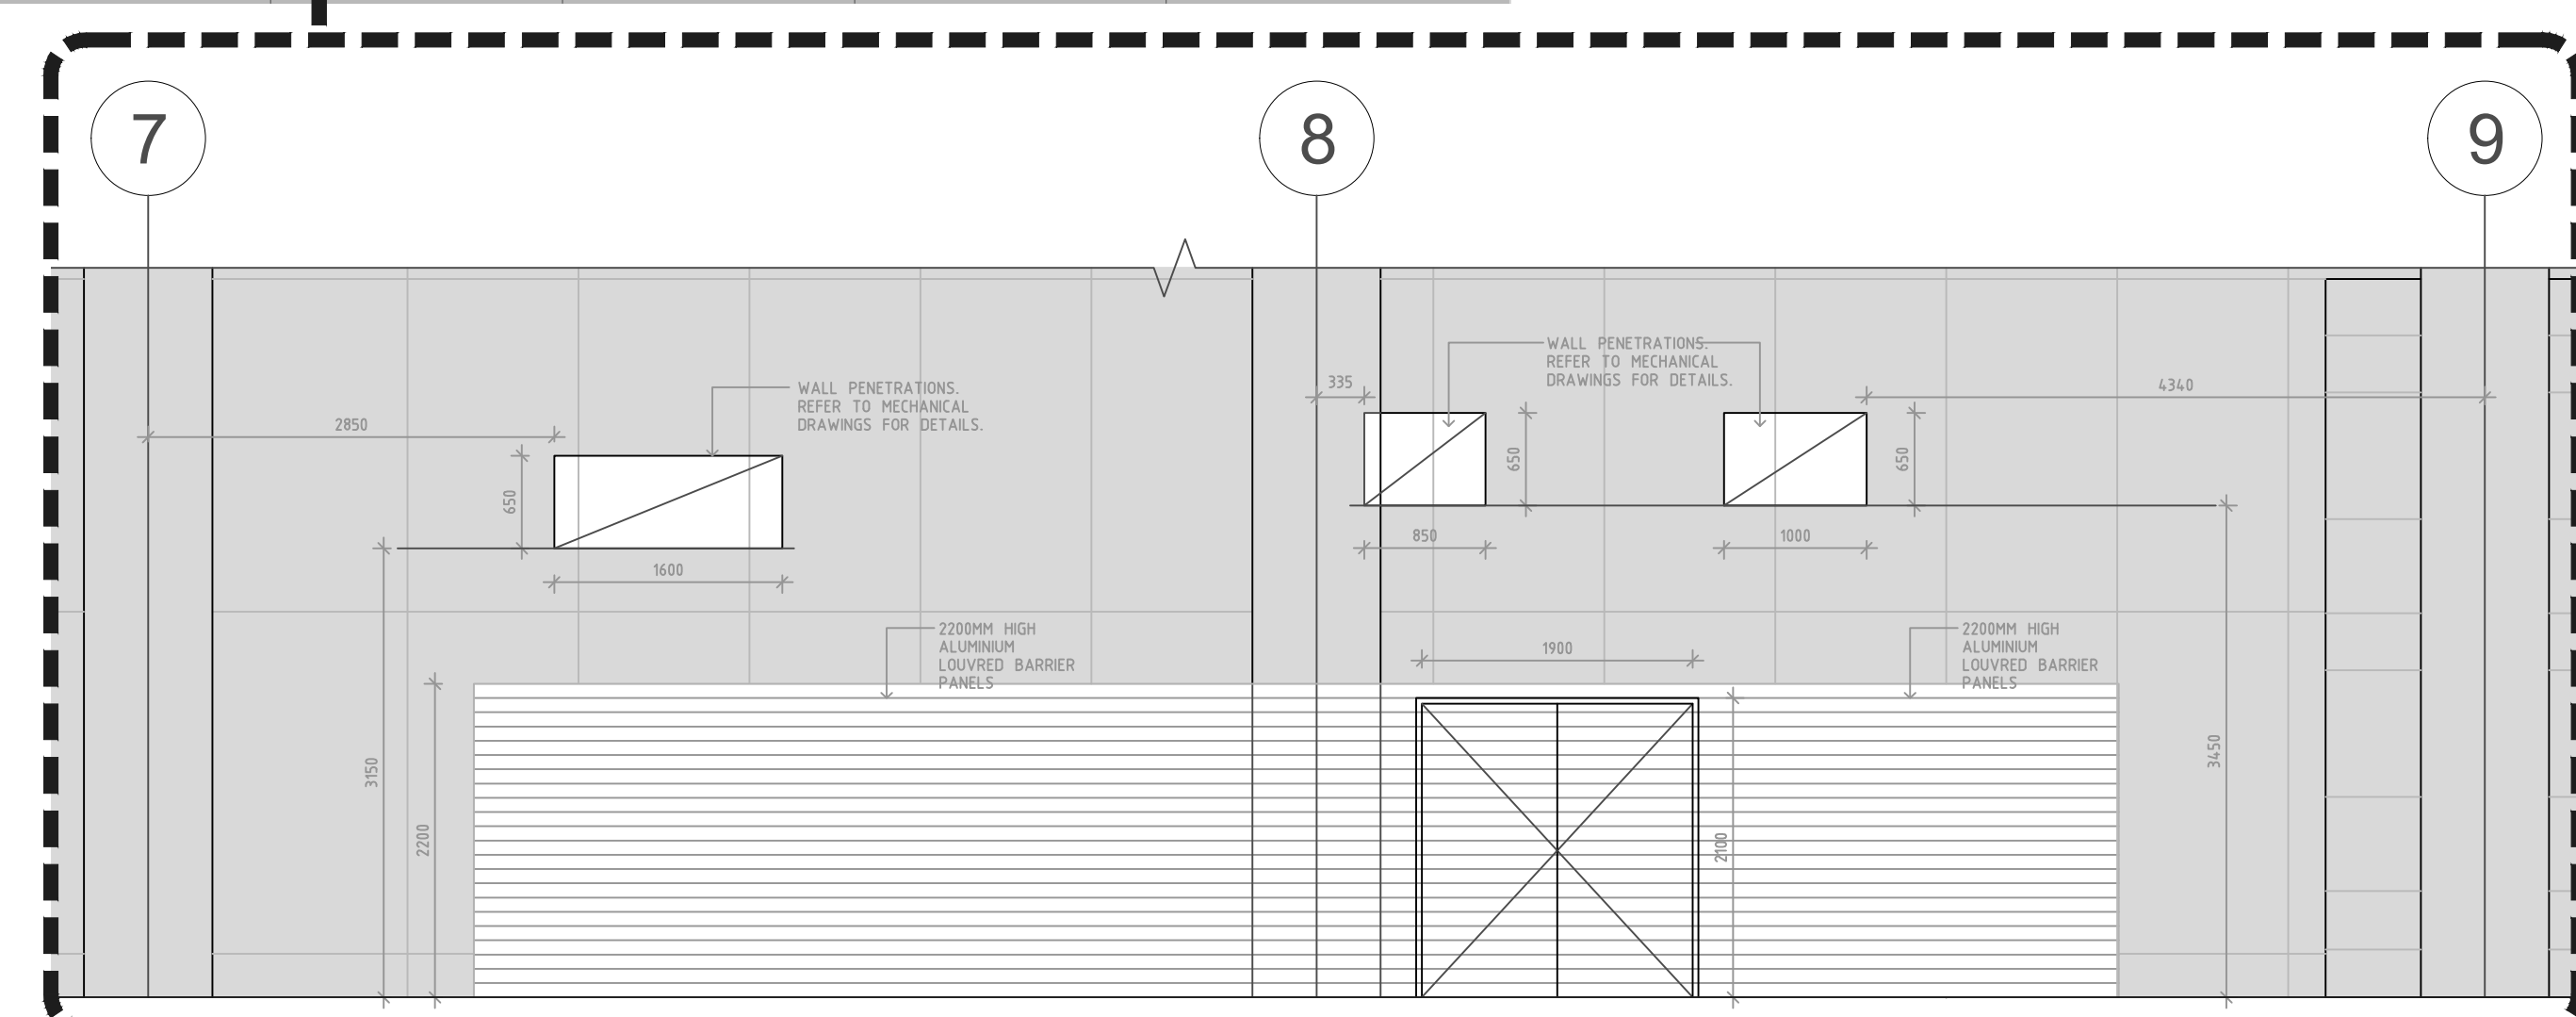

ELEVATION 1
SCALE 1:50 @A1

NOT FOR CONSTRUCTION

REV	DESCRIPTION	DATE
A	ISSUED FOR S4.55	23/09/19

Billard Leese Partnership Pty Ltd
Architects & Urban Planners
Level 6, 72-80 Cooper Street
Sunny Hills 2010
NSW Australia
T +61 2 8096 4066
E info@blp.com.au
www.blp.com.au

roberts pizzarotti
LEVEL 04, 1 PARKER PL
STONEY MEAD NSW 2058
T +61 2 9577 1100
info@robertspizzarotti.com

dexus
LEVEL 05, 104-110 DUNDEE ST
STONEY MEAD NSW 2058
T +61 2 9577 1100
info@dexus.com.au

savills
LEVEL 04, 1 PARKER PL
STONEY MEAD NSW 2058
T +61 2 9577 1100
info@savills.com.au

**NORTH SHORE
HEALTH HUB**

**EXTERNAL
MECHANICAL PLANT
ENCLOSURE**

Project No	17005
Scale	AS INDICATED
Date	23/09/2019
Drawn By	Author
Checked By	Checker
Drawing No	Revision
A-E-N1	A

SECTION 4.55 SUBMISSION