


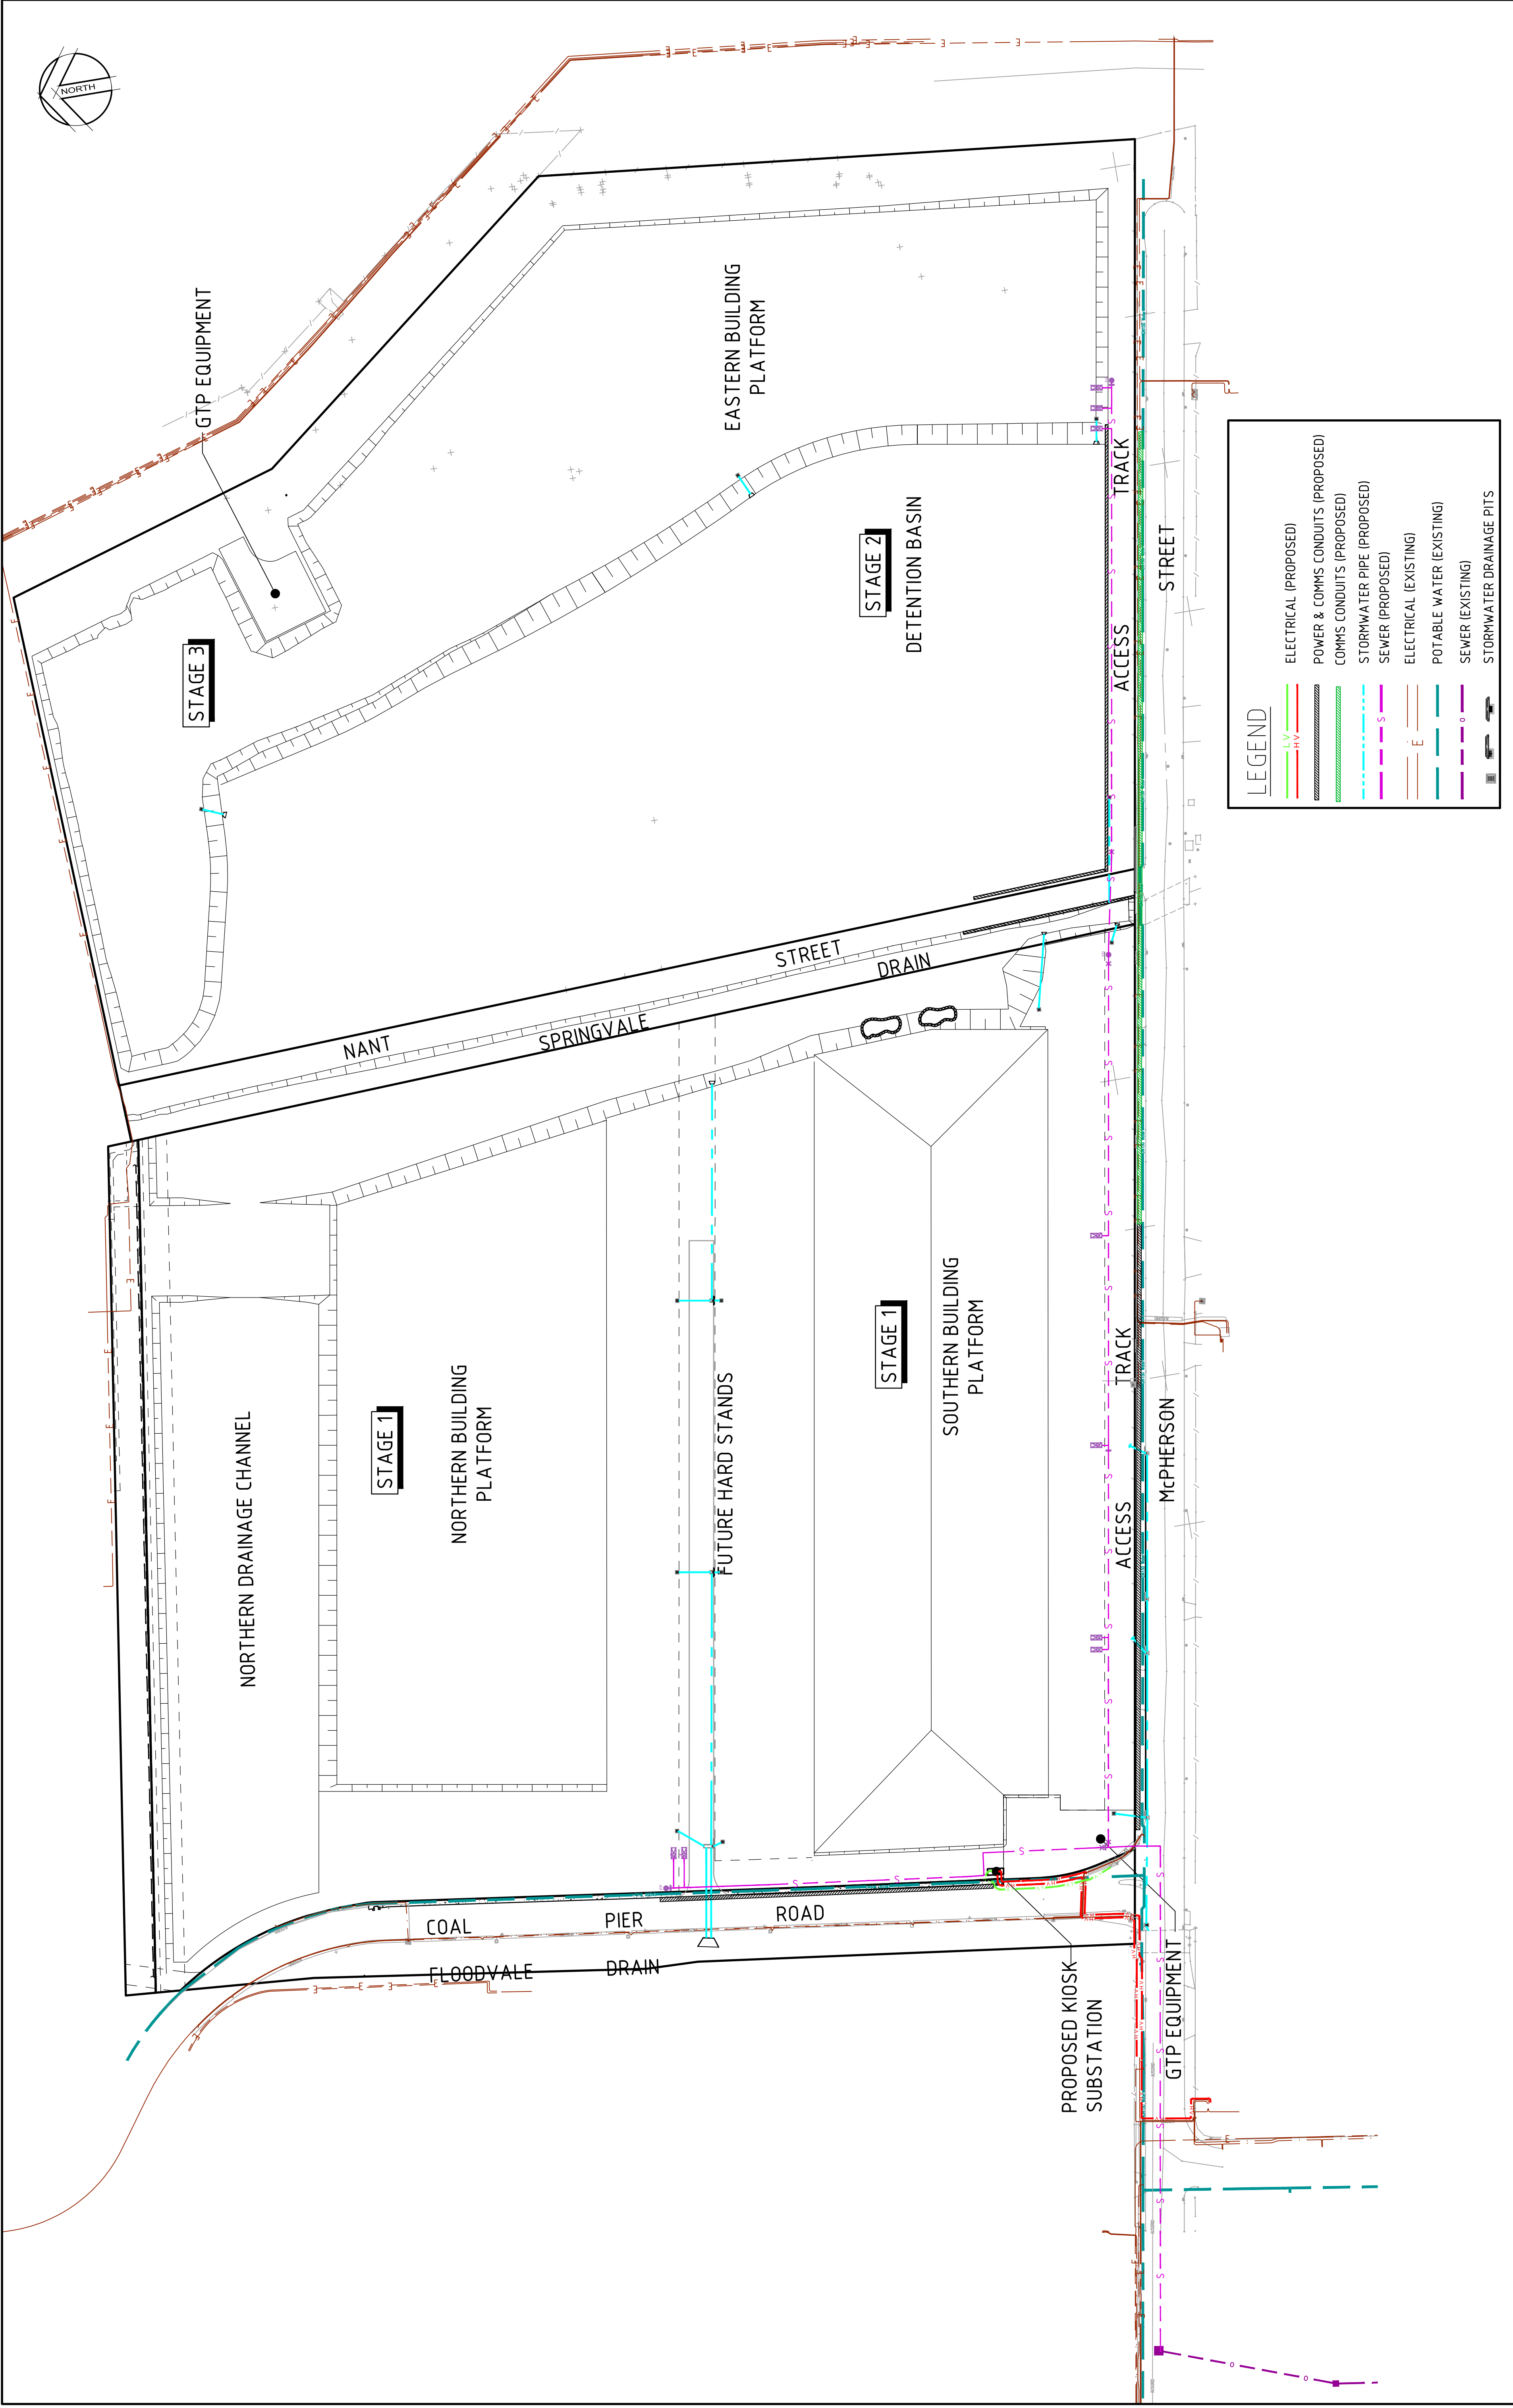

Rev		Date	Description	Drawn / Appr.	
C	10713		SEWER AND DRAINAGE LAYOUT AMENDED	NVH	RL
B	260613		GRADING AND LOT LAYOUT AMENDED	NVH	RL
A	130213		FOR INFORMATION	RT	RL

Client		ORICA		FOR INFORMATION	
Drawn	RT	Date	FEB'13	Status	
Checked	RL	Date	FEB'13		
Designed	RH	Date	FEB'13		
Verified	RH	Date	FEB'13		
Approved	RL	Date	FEB'13		
Quality		Quality		Drawing Number	
System		Engineer		210094-P1-001	
AS/NZS 1546		AS/NZS 1546		Revision	
Sydney		Sydney		C	

© Cardno Ltd 2011		Client	
All Rights Reserved.		Date	
This document is produced by Cardno Ltd solely for the		FEB'13	
benefit of and use by the Client in accordance with the terms		FEB'13	
of the contract. No liability is accepted by Cardno Ltd for		FEB'13	
any responsibility or liability whatsoever to any third party		FEB'13	
arising out of any use or reliance by third party on the content		FEB'13	
of this document.		FEB'13	

ABN 95 001 45 035		Scale	
Level 9, The Forum, 203 Pacific Highway, St Leonards, NSW		1:1000	
Phone: (441 2) 456 7788 Fax: (441 2) 949 3902		Datum	
Email: Sydney@cardno.com.au Web: www.cardno.com.au		AHD	

0 10 20 30 40 50 60 70 80 90 100 110 120 130 140 150mm		ON A1 ORIGINAL	
--	--	----------------	--