


- NOTES:
1. LOCATION OF HOT WATER PLANT TO BE SHOWN WHEN MECHANICAL PLANT ROOM IS LOCATED.
 2. LOCATION OF WATER METER & GAS METER TO BE COORDINATED WITH EXISTING TREES.

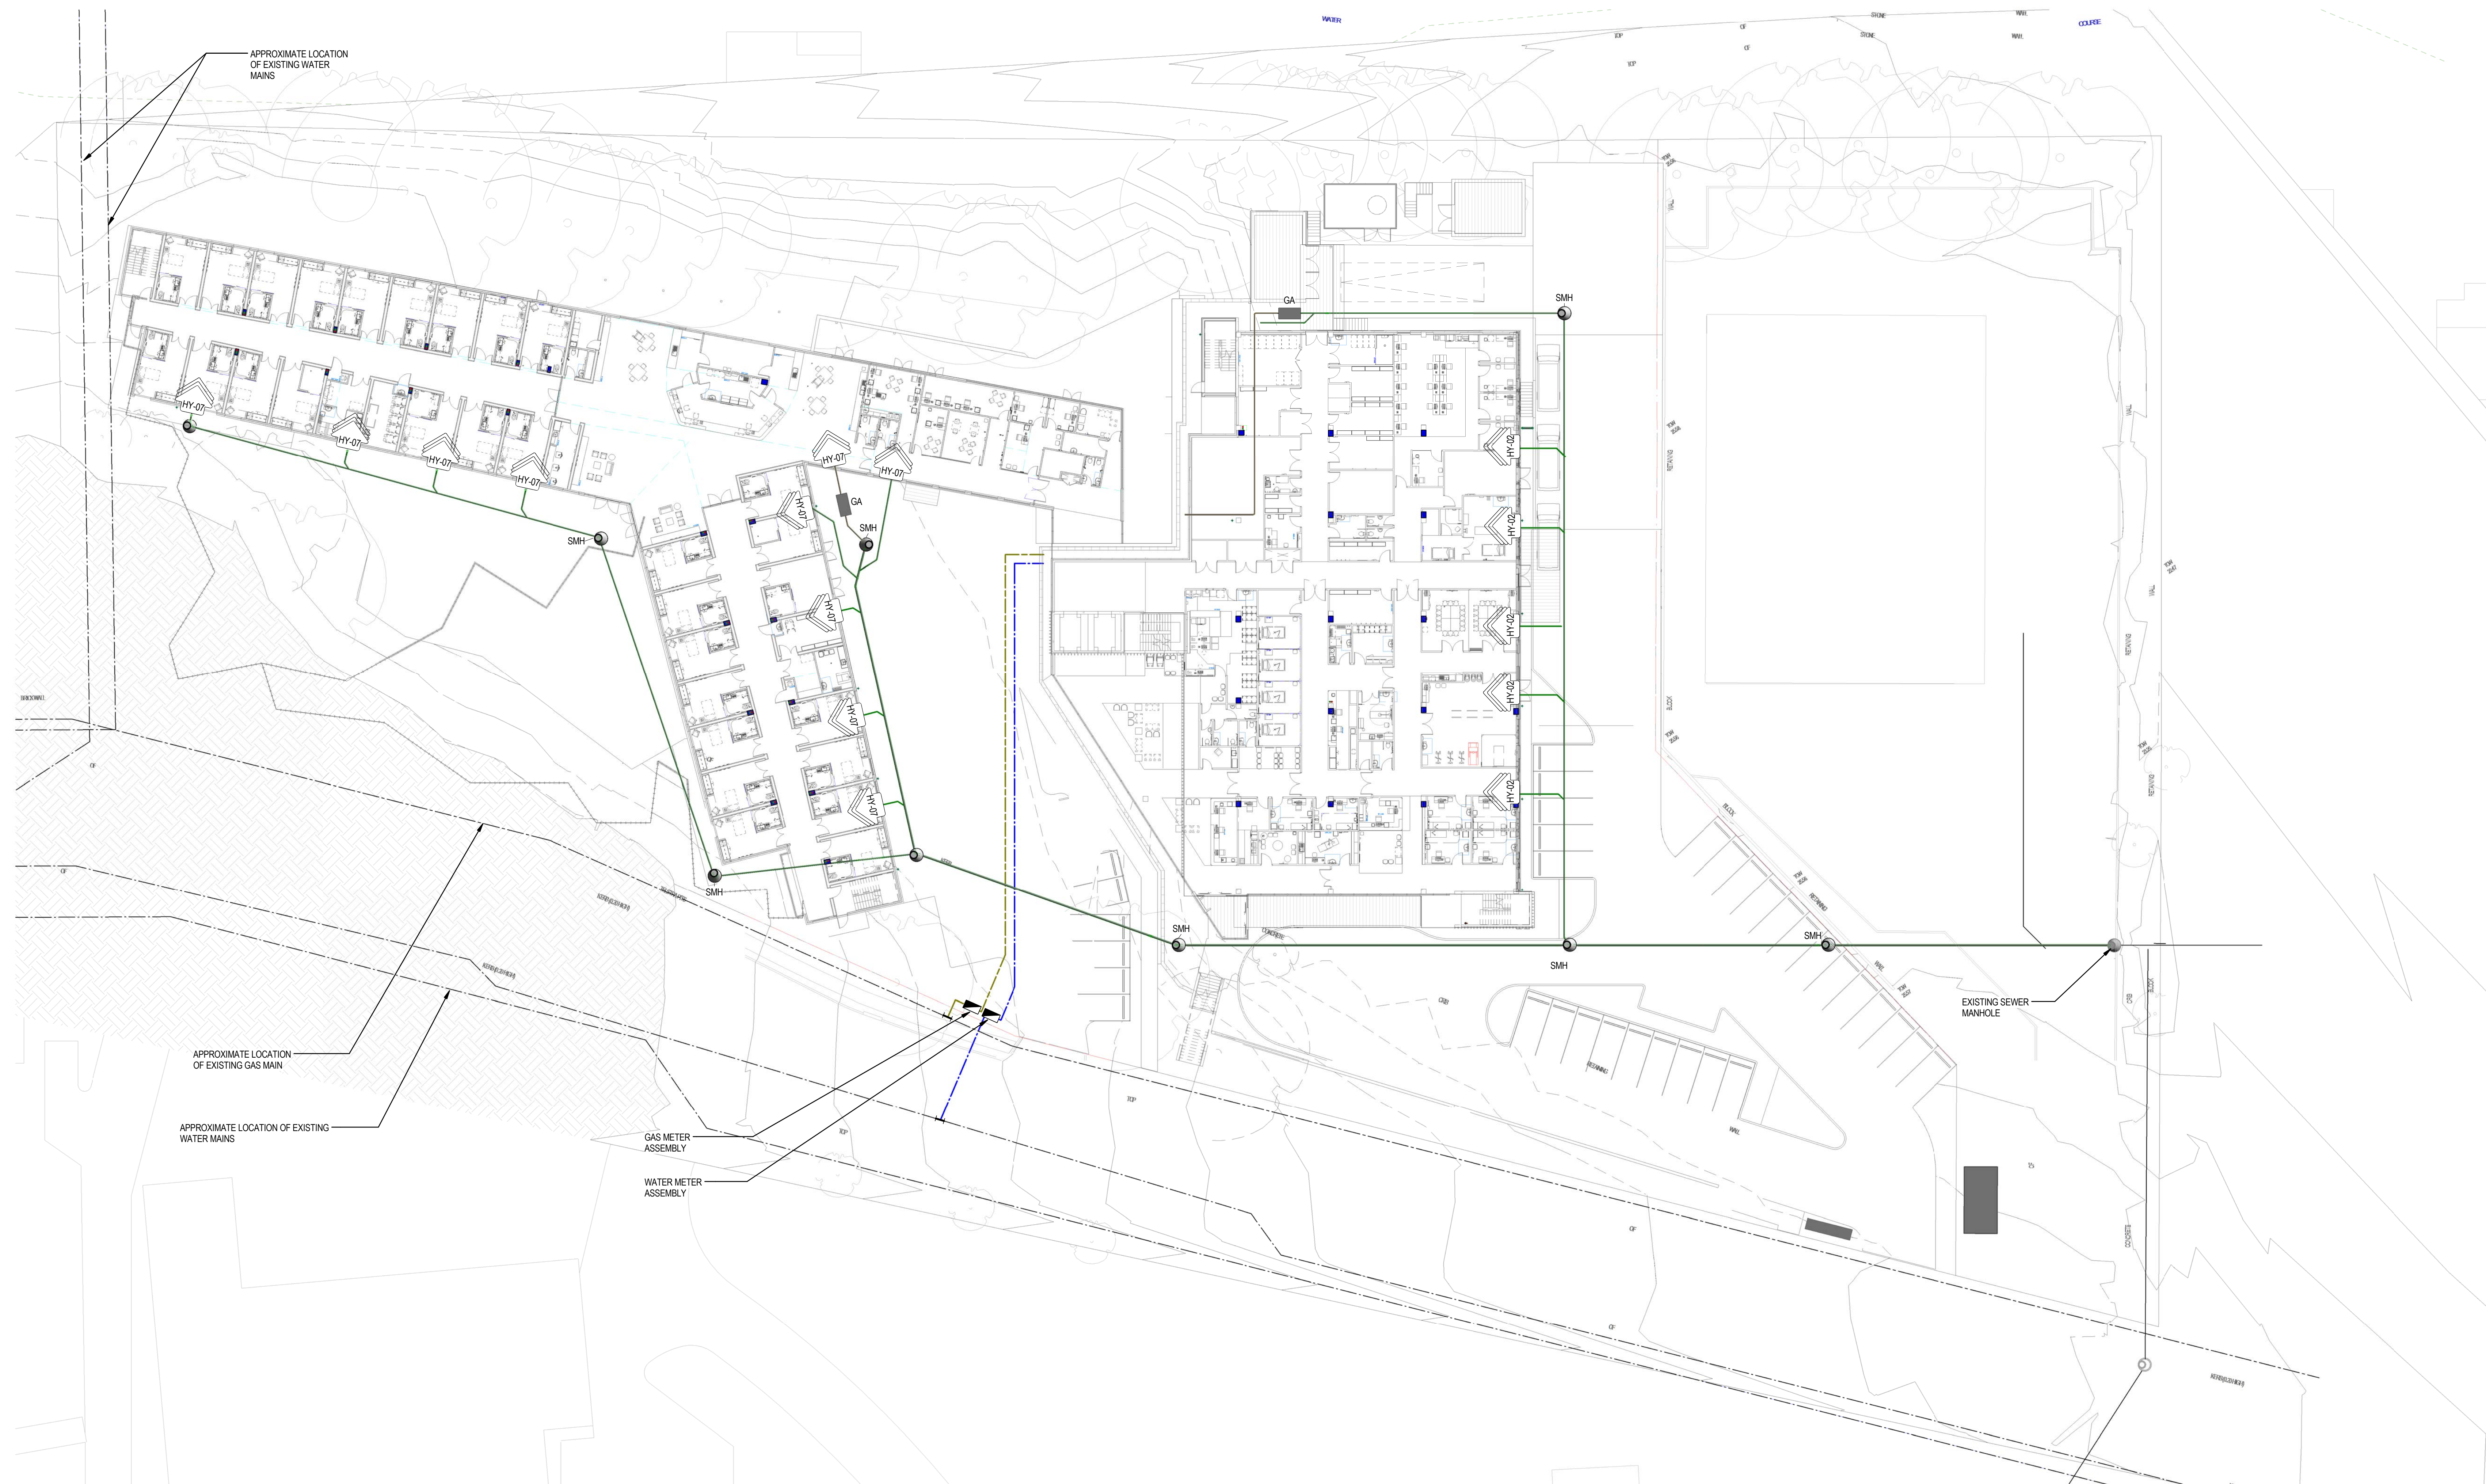

PRELIMINARY ISSUE

ISSUE	DATE	DESCRIPTION	AUTH
1	02/11/2016	40% DD ISSUE	SJ

Donnelley Simpson Cleary
Consulting Engineers

59 Hill Street
Rosedale NSW 2059
T: +612 9416 1177
F: +612 9416 8251
E: mail@dscc.com.au

MECHANICAL ELECTRICAL HYDRAULIC LIGHTING FIRE LIFTS

APPROVED This document is issued for the purpose of the latest revision.

UNCONTROLLED Content in this document may differ from that contained in the latest revision.

© Copyright of Donnelley Simpson Cleary Consulting Engineers Pty Ltd
ABN 19 002 611 437
All rights reserved. Figured dimensions shall be taken in preference to scaling. The Contractor shall check all dimensions on site before commencing work.

PROJECT
BULLI AGED CARE CENTRE OF EXCELLENCE
No. 22 HOSPITAL ROAD, BULLI NSW

DRAWING TITLE
HYDRAULIC SERVICES
SITE PLAN - HYDRAULIC SERVICES

SCALE: 1:250 AT B1 SIZE

DATE: 04/13/16

CHECKED: [Signature] APPROVED: [Signature]

DRAWN: [Signature] DESIGNED: [Signature]

AUTHOR: [Signature] DESIGNER: [Signature]

DWG PROJ NO: 7786

PHASE: DD REVISION: 1

DRAWING NO: 7786-DD-HY-01