


LEGEND

- EXISTING OUTDOOR SPACES
- TERRACE / COURTYARD SPACE
- ROOFTOP SPACE
- LIFTS
- TOILETS
- CLEANERS
- IT COMMS
- MECHANICAL PLANT
- FHR
- ACCESS STAIRS
- FIRE STAIRS
- AUDITORIUM / LECTURE HALLS
- SPECIALIST LEARNING SPACES
- FOUNDATION AREA / PLANT
- STORAGE
- DISTRIBUTION BOARD
- CARPARKING
- CIRCULATION
- ADMINISTRATION
- CAFETERIA
- CHILDCARE
- ART GALLERY
- HOME BASE 1
- HOME BASE 2
- HOME BASE 3
- HOME BASE 4
- HOME BASE 5
- HOME BASE 6
- EXTERNAL ENTRY PORTAL TO HOME BASE
- INTERNAL ENTRY PORTAL TO HOME BASE
- EXTERNAL ACCESS
- OUTDOOR PLAY

NOTES:

- PARTITION WALLS ARE SHOWN EXISTING, FINAL EXTENT TO BE CONFIRMED WITH FURTHER DESIGN DEVELOPMENT
- CALCULATED ROOM AREAS AND BOUNDARIES OF OUTDOOR PLAY AREAS ARE APPROXIMATE AND TO BE CONFIRMED

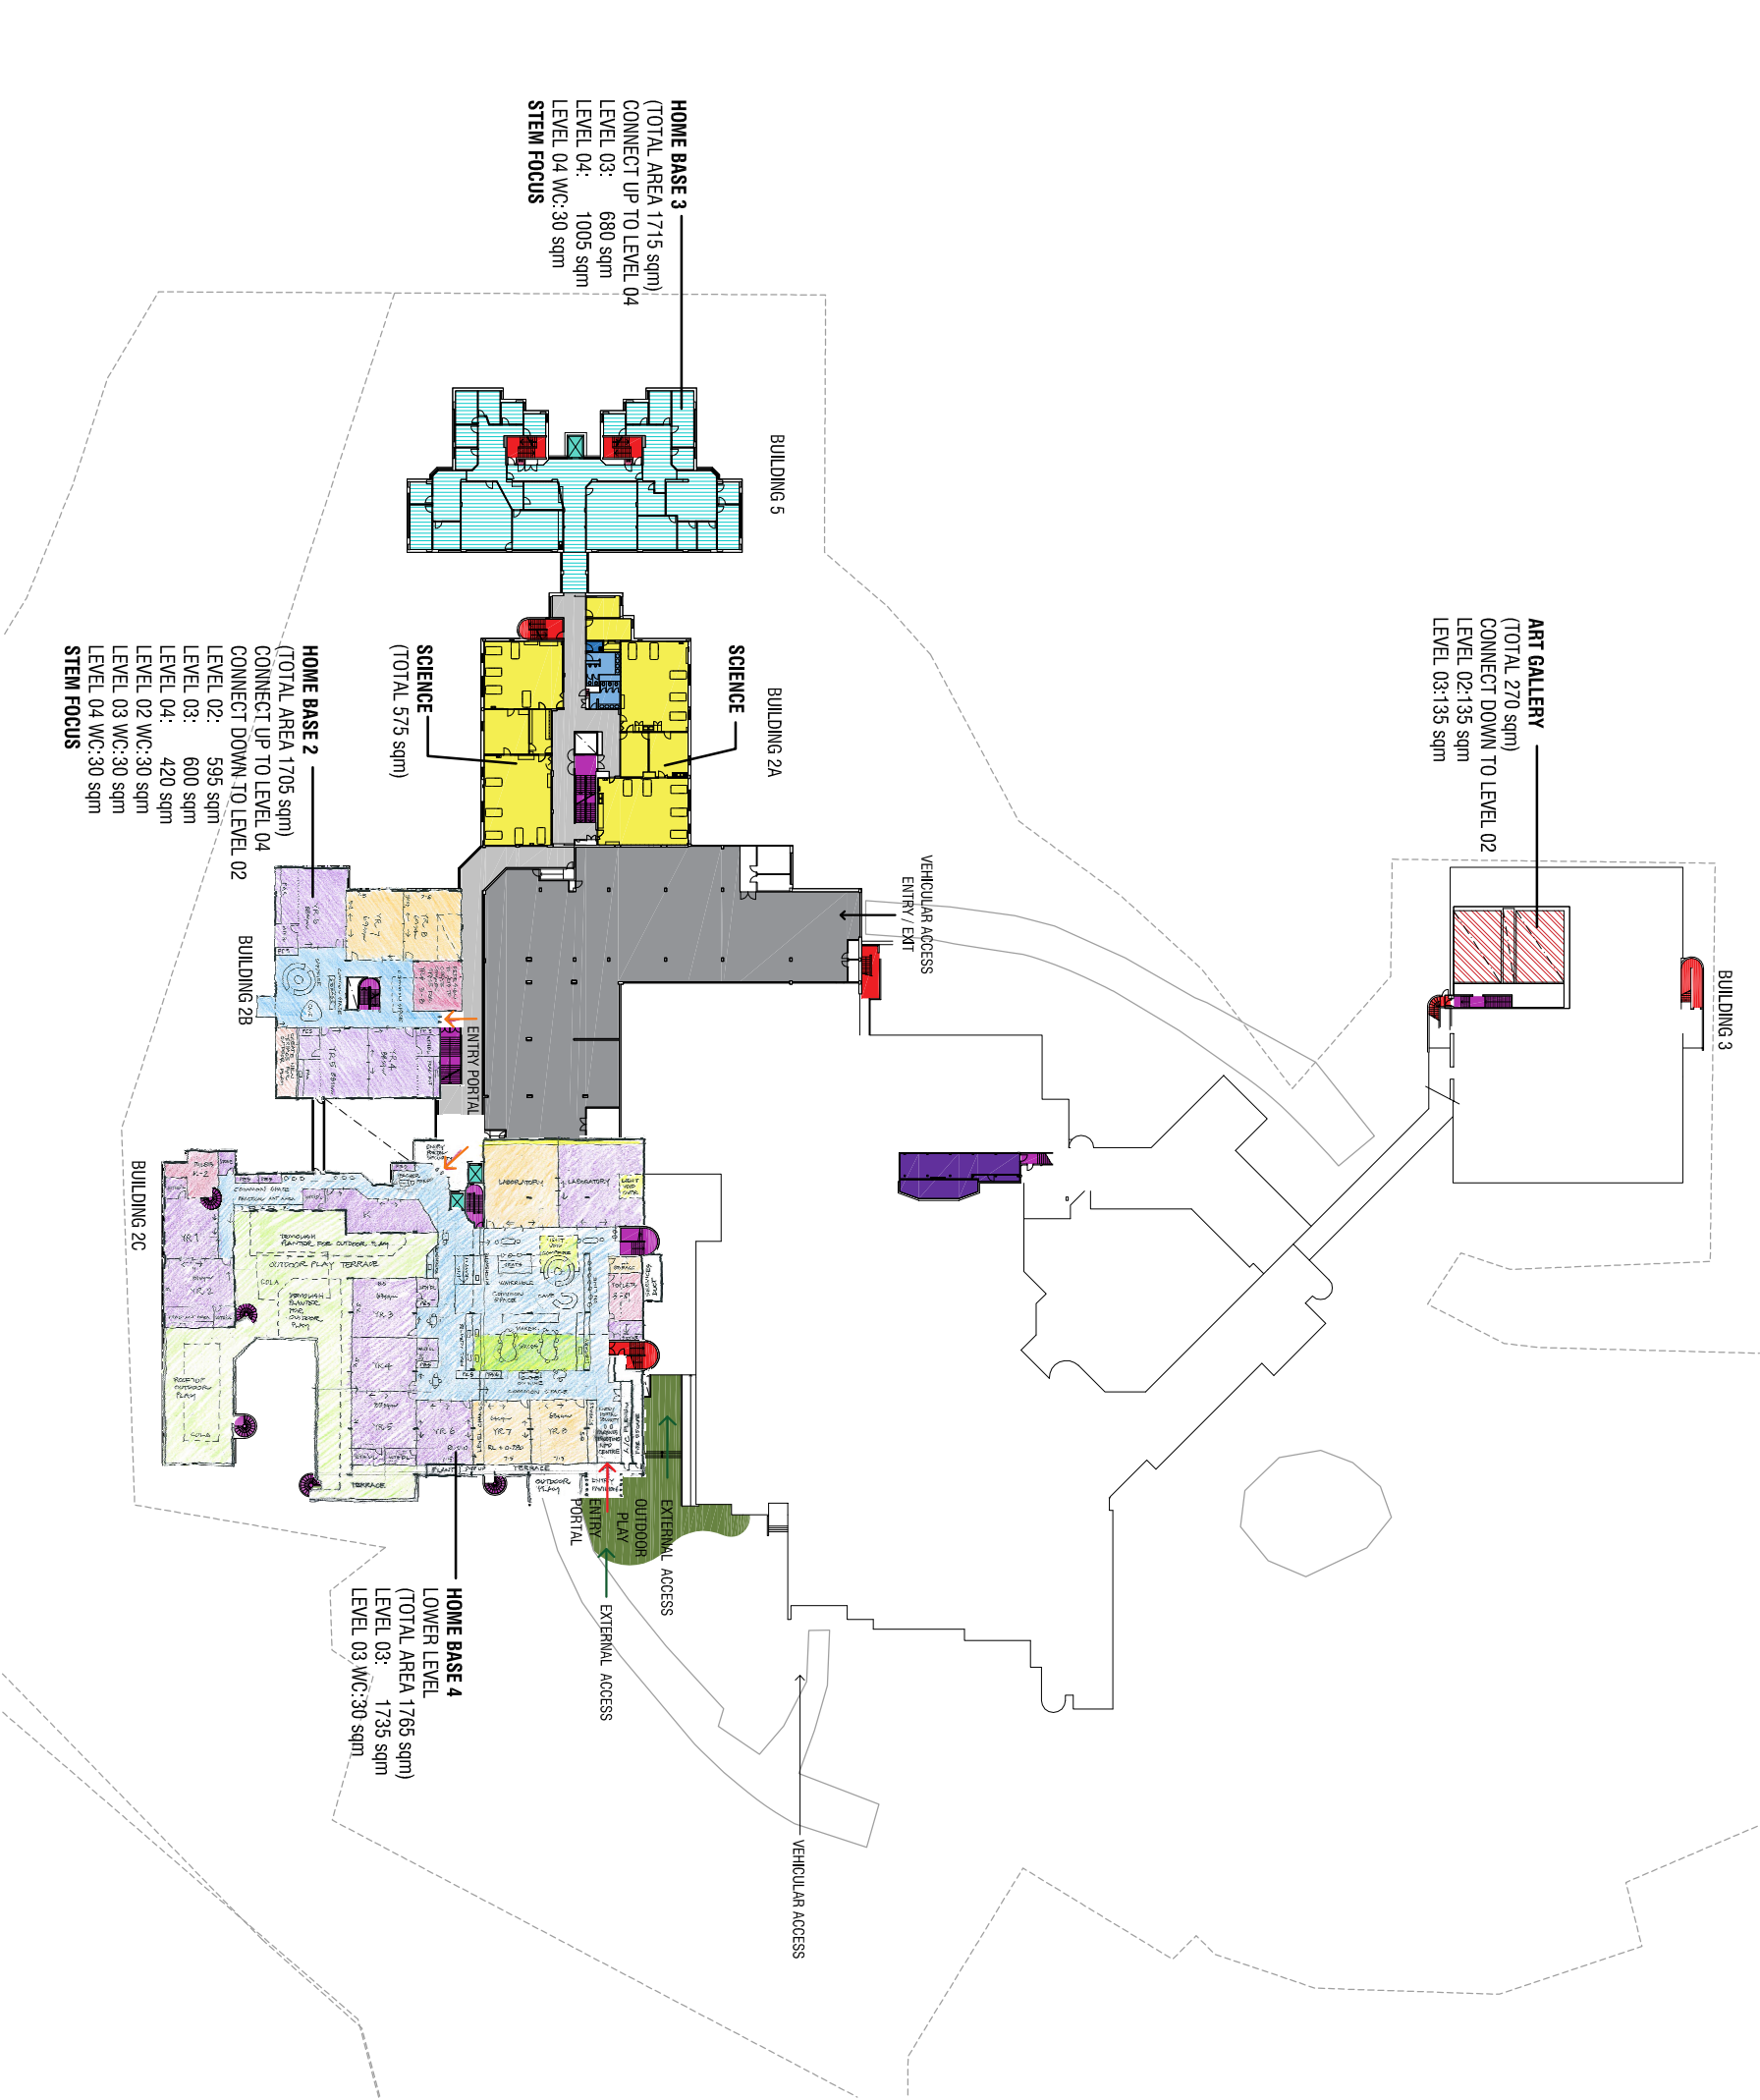

CLIENT

DEPARTMENT OF EDUCATION



Education

PROJECT

LINDFIELD LEARNING VILLAGE

CHECKED

DRAWN

RK

JOB NO.

S151441

SHEET SCALE

1:1000 @ A3

SHEET TITLE

DRAFT MASTERPLAN - LEVEL 03

NOMINATED ARCHITECTS:  
Grishin Cadden 4669 / Anthony Quan 3421 / Sandeep Amin 7337

DRAWING NO.

SK-LLV-23

DATE

06.09.16

REV

D

DesignInc | Lacoste + Stevenson | bmc2



architects in association


L12/77 PACIFIC HWY NORTH SYDNEY NSW 2060 AUSTRALIA  
PO BOX 631 NORTH SYDNEY NSW 2059 AUSTRALIA  
T +612 8853 7100 F +612 8853 7199  
E [info@designinc.com.au](mailto:info@designinc.com.au) [www.designinc.com.au](http://www.designinc.com.au)  
Architecture Urban Design Interiors

LEGEND


- EXISTING OUTDOOR SPACES
- TERRACE / COURTYARD SPACE
- ROOFTOP SPACE
- LIFTS
- TOILETS
- CLEANERS
- IT COMMS
- MECHANICAL PLANT
- FHR
- ACCESS STAIRS
- FIRE STAIRS
- AUDITORIUM / LECTURE HALLS
- SPECIALIST LEARNING SPACES
- FOUNDATION AREA / PLANT
- STORAGE
- DISTRIBUTION BOARD
- CARPARKING
- CIRCULATION
- ADMINISTRATION
- CAFETERIA
- CHILDCARE
- ART GALLERY
- HOME BASE 1
- HOME BASE 2
- HOME BASE 3
- HOME BASE 4
- HOME BASE 5
- HOME BASE 6
- EXTERNAL ENTRY PORTAL TO HOME BASE
- INTERNAL ENTRY PORTAL TO HOME BASE
- EXTERNAL ACCESS
- OUTDOOR PLAY

NOTES:  
- PARTITION WALLS ARE SHOWN EXISTING, FINAL EXTENT TO BE CONFIRMED WITH FURTHER DESIGN DEVELOPMENT  
- CALCULATED ROOM AREAS AND BOUNDARIES OF OUTDOOR PLAY AREAS ARE APPROXIMATE AND TO BE CONFIRMED

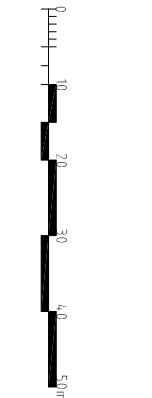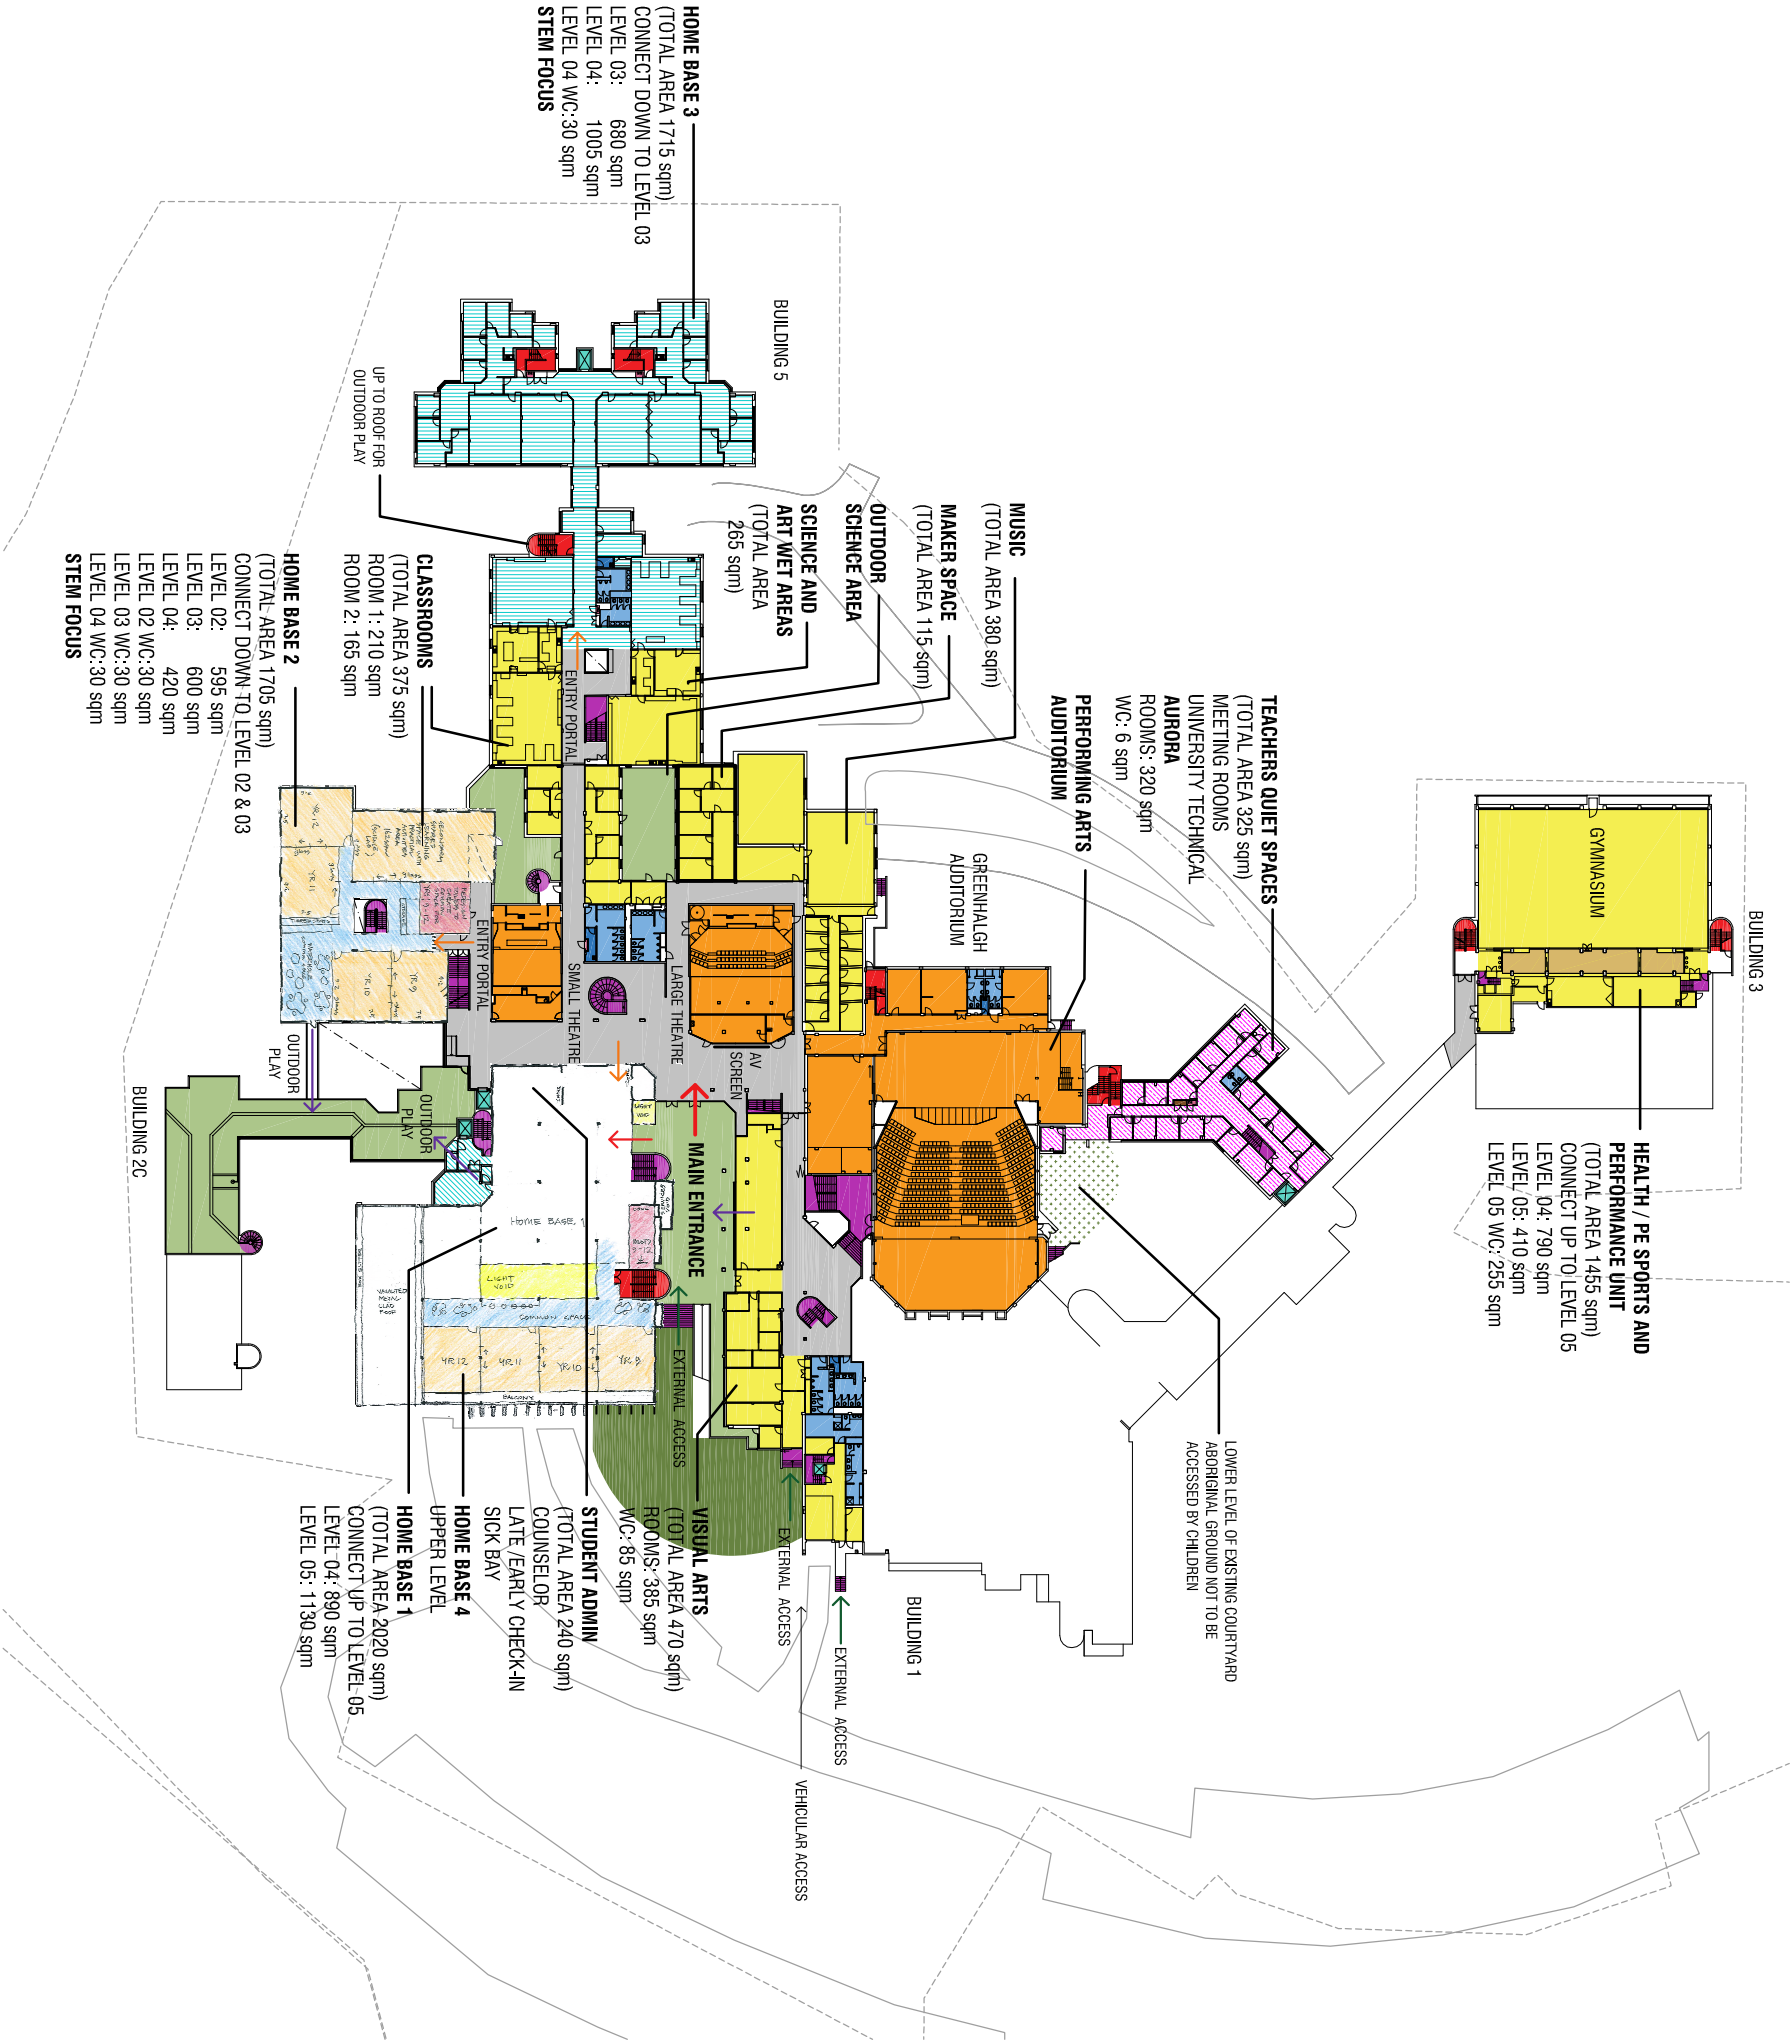

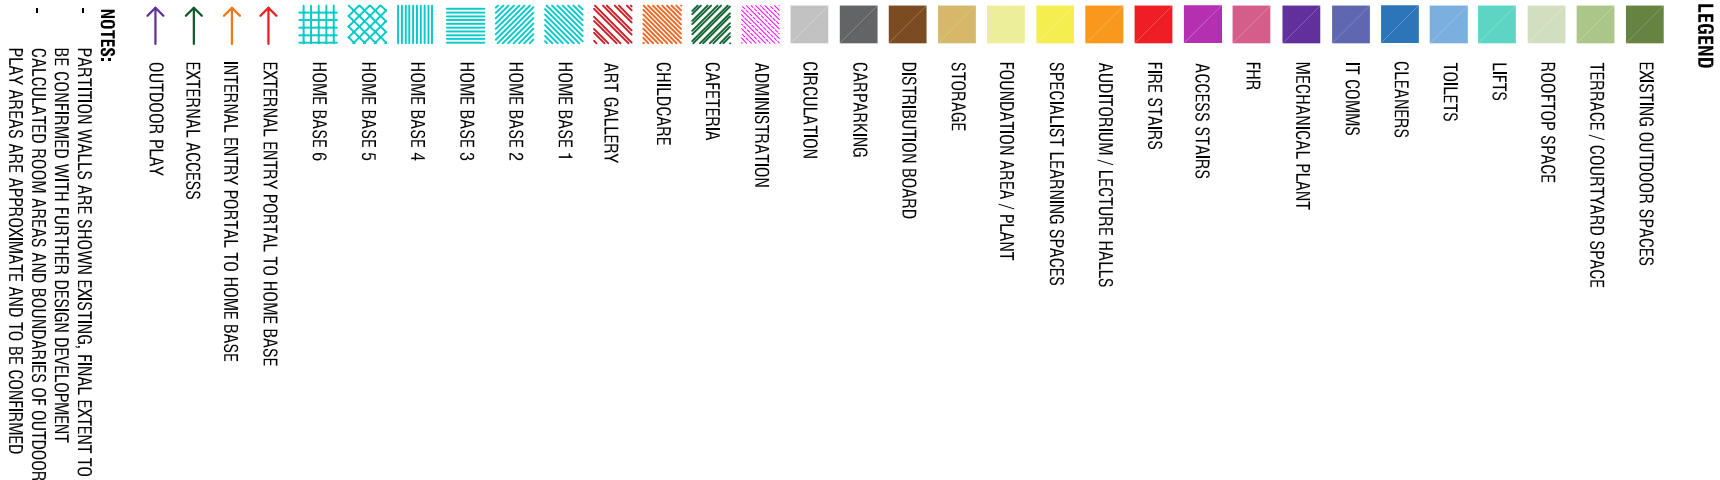



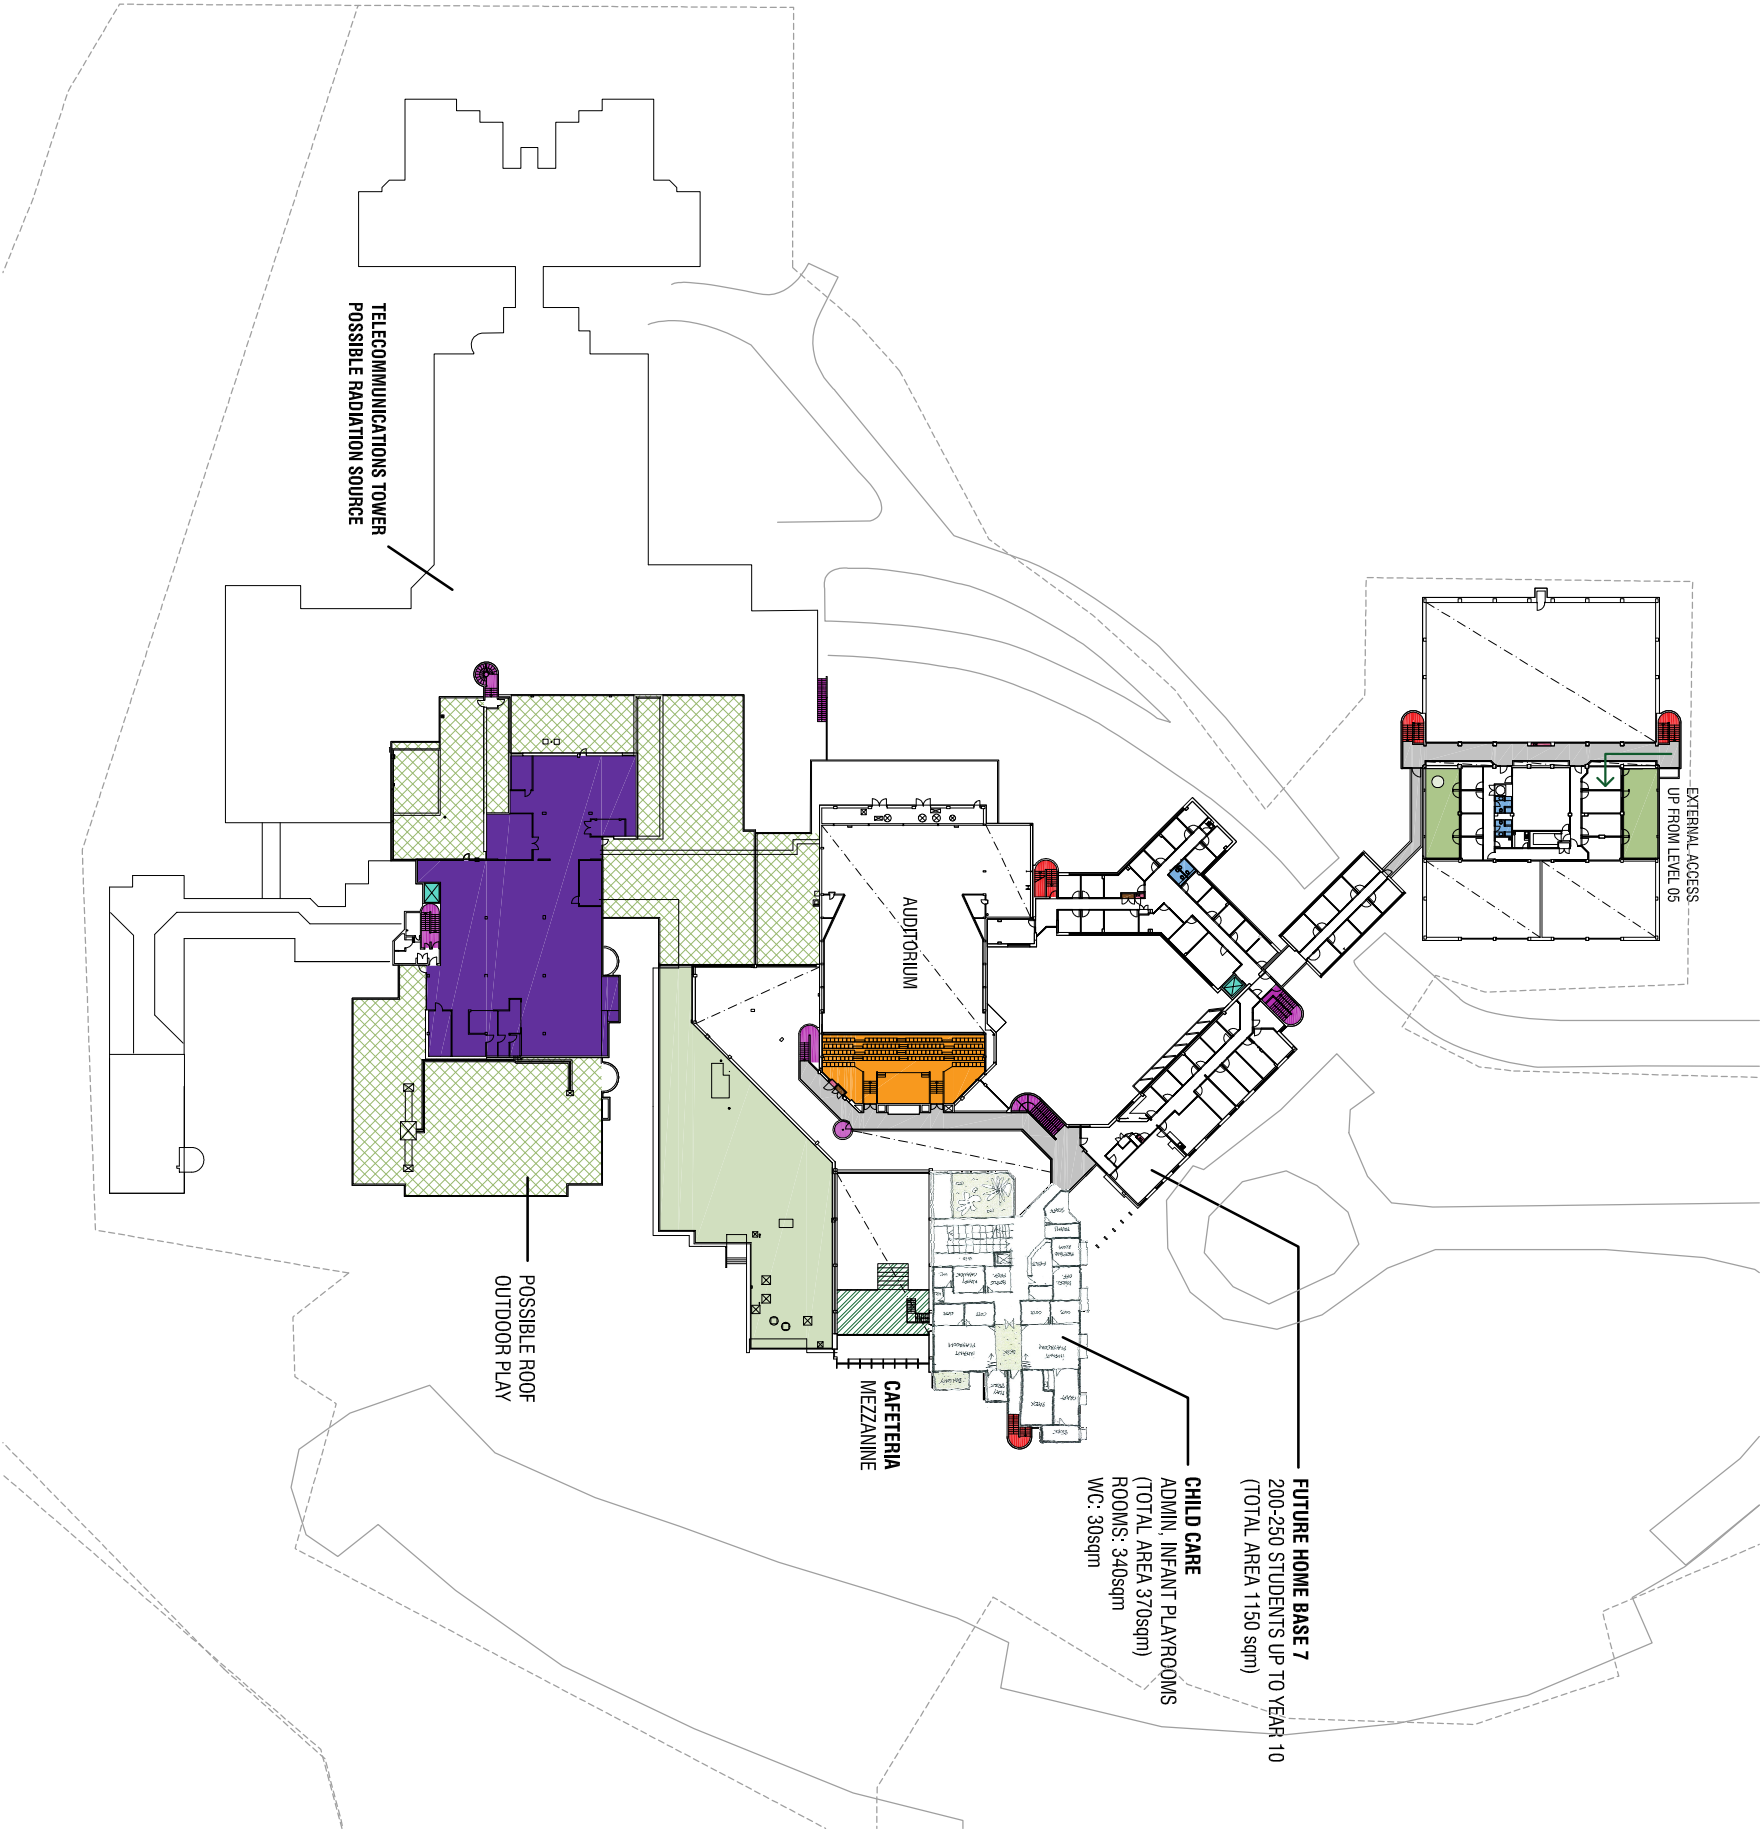

LEGEND

- EXISTING OUTDOOR SPACES
- TERRACE / COURTYARD SPACE
- ROOFTOP SPACE
- LIFTS
- TOILETS
- CLEANERS
- IT COMMS
- MECHANICAL PLANT
- FHR
- ACCESS STAIRS
- FIRE STAIRS
- AUDITORIUM / LECTURE HALLS
- SPECIALIST LEARNING SPACES
- FOUNDATION AREA / PLANT
- STORAGE
- DISTRIBUTION BOARD
- CARPARKING
- CIRCULATION
- ADMINISTRATION
- CAFETERIA
- CHILDCARE
- ART GALLERY
- HOME BASE 1
- HOME BASE 2
- HOME BASE 3
- HOME BASE 4
- HOME BASE 5
- HOME BASE 6
- EXTERNAL ENTRY PORTAL TO HOME BASE
- INTERNAL ENTRY PORTAL TO HOME BASE
- EXTERNAL ACCESS
- OUTDOOR PLAY

NOTES:

- PARTITION WALLS ARE SHOWN EXISTING, FINAL EXTENT TO BE CONFIRMED WITH FURTHER DESIGN DEVELOPMENT
- CALCULATED ROOM AREAS AND BOUNDARIES OF OUTDOOR PLAY AREAS ARE APPROXIMATE AND TO BE CONFIRMED

