


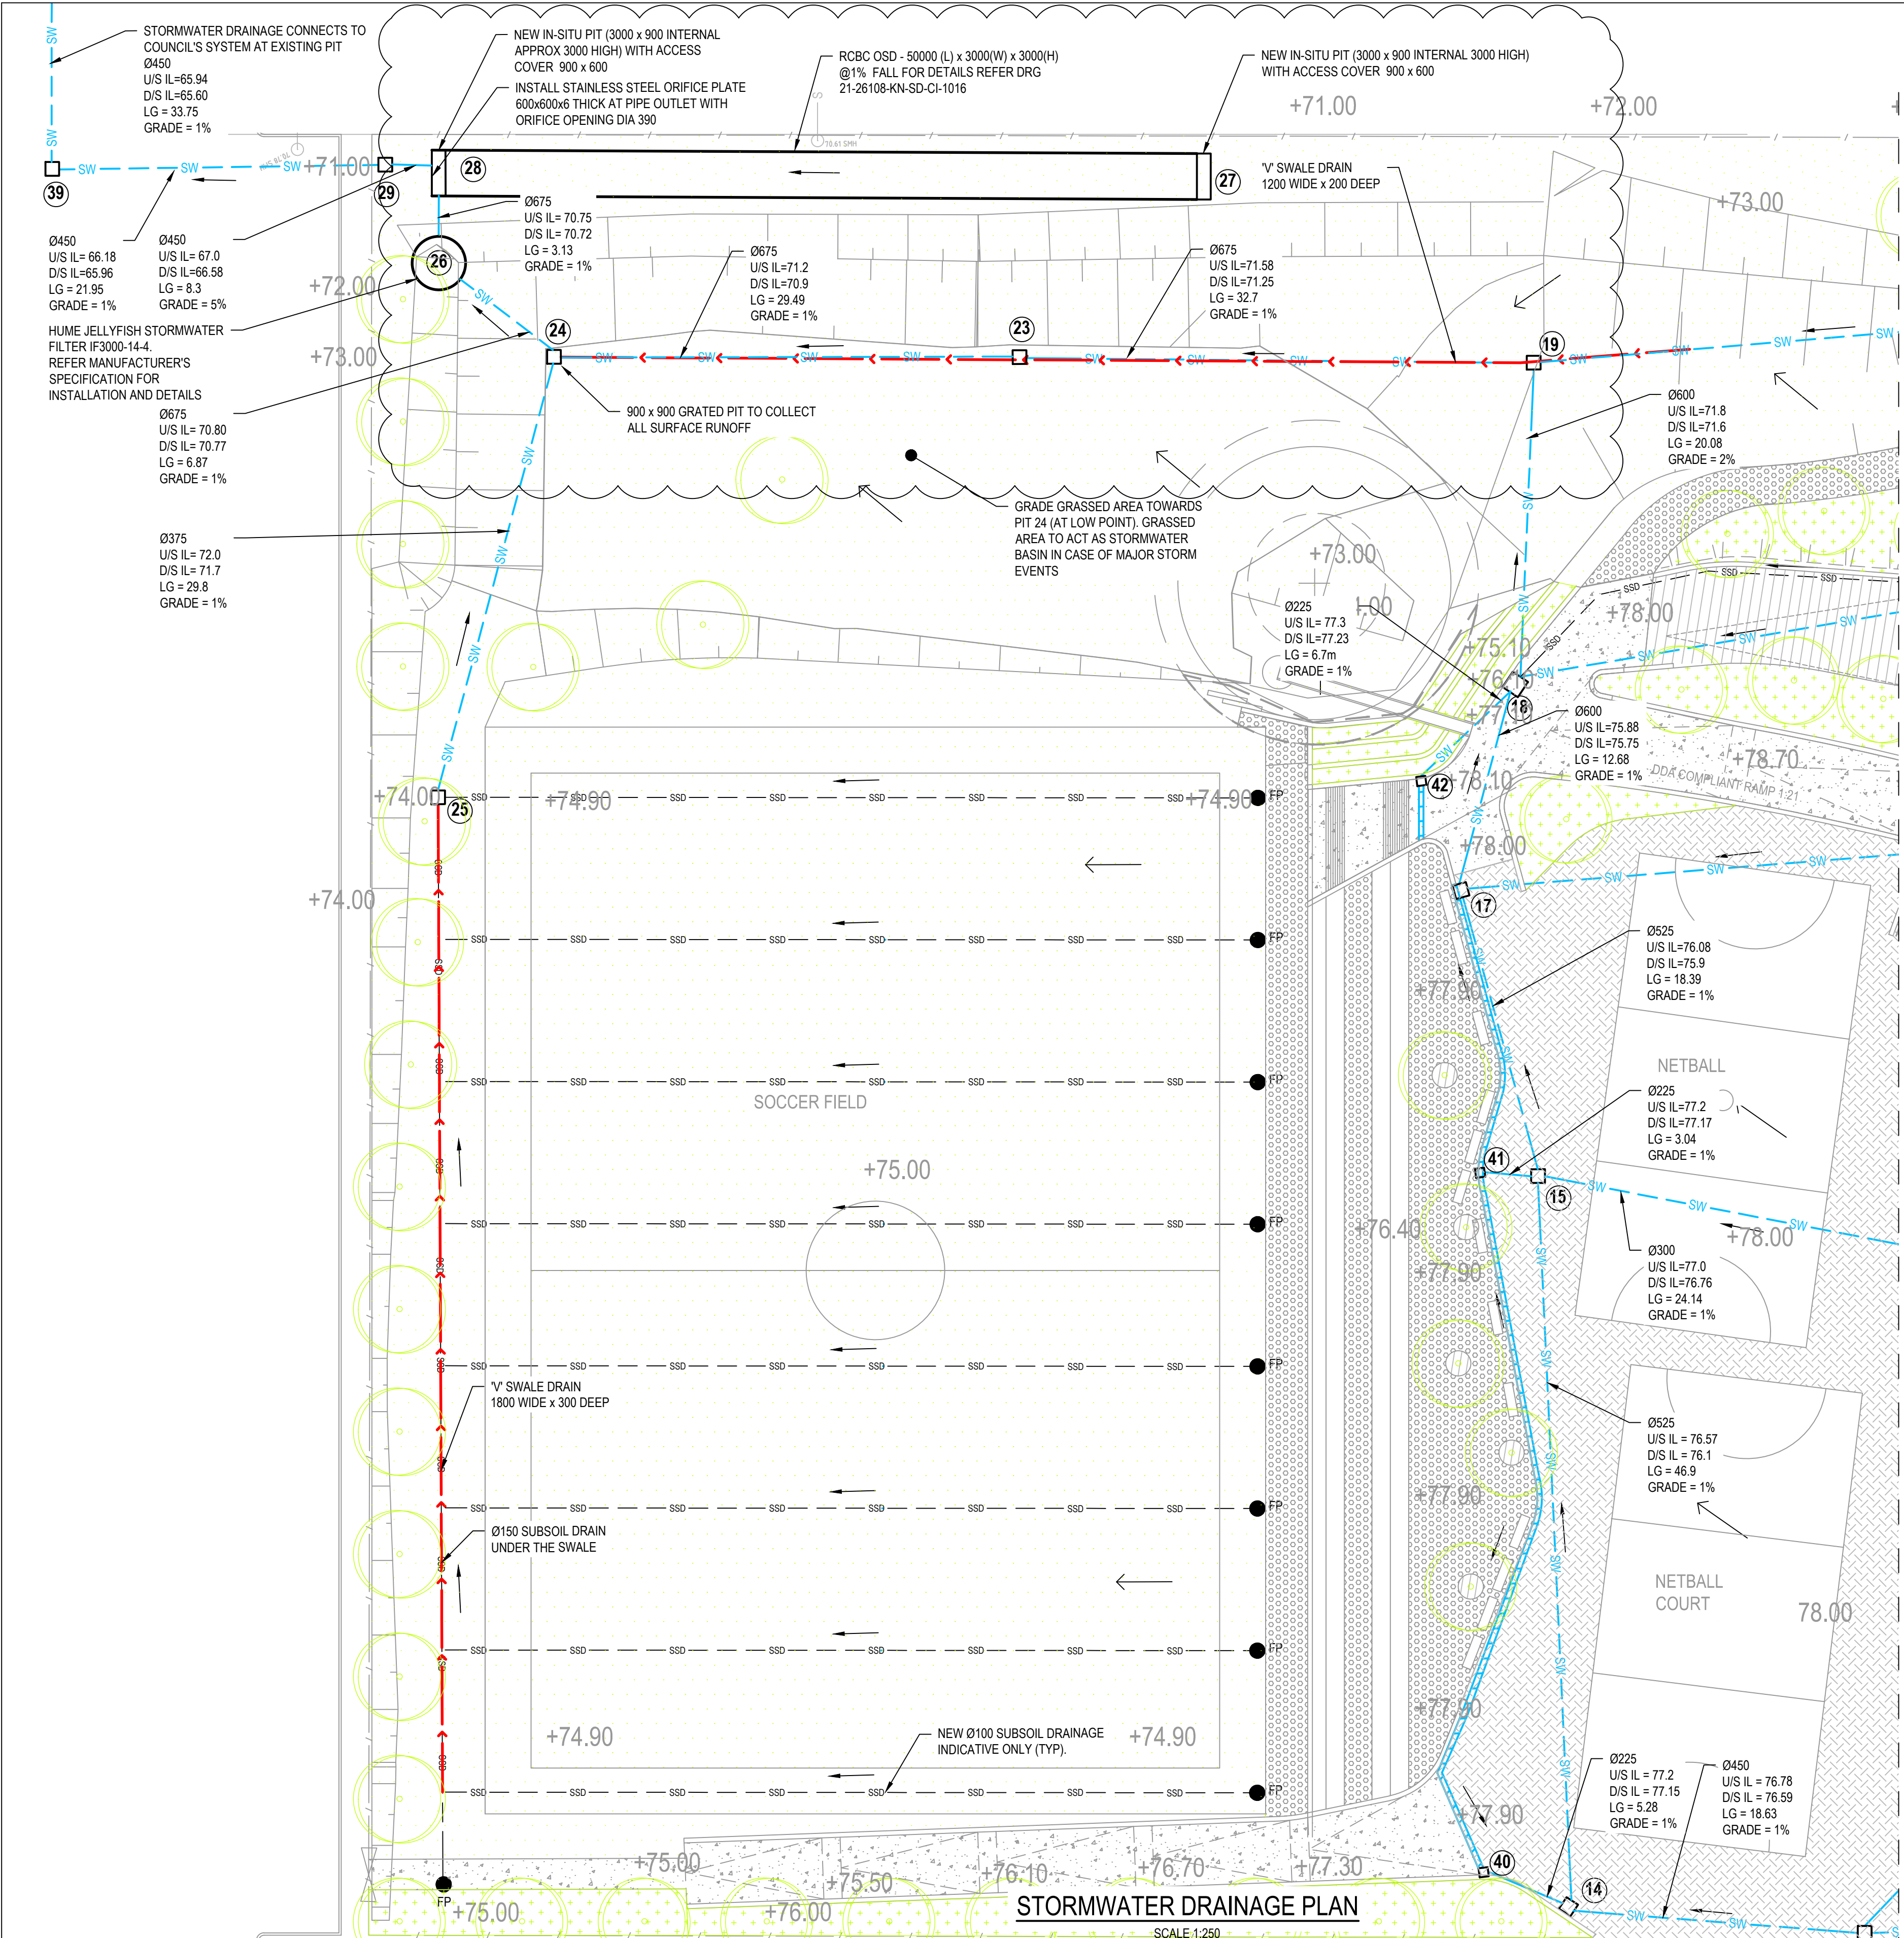

FOR CONTINUATION REFER DRG 21-26108-KN-CI-1012


PIT SCHEDULE	
PIT NUMBER	PIT DETAILS
1	600 x 600 GRATED INLET PIT
2	900 x 900 GRATED INLET PIT
3	900 x 900 GRATED INLET PIT
4	900 x 900 GRATED INLET PIT
5	900 x 900 GRATED INLET PIT
6	1200 x 1200 DEEP DROP PIT
7	900 x 900 GRATED INLET PIT
8	900 x 900 GRATED INLET PIT
9	900 x 900 GRATED INLET PIT
10	900 x 900 GRATED INLET PIT
11	900 x 900 GRATED INLET PIT
12	900 x 900 GRATED INLET PIT
13	900 x 900 GRATED INLET PIT
14	900 x 900 GRATED INLET PIT
15	600 x 600 GRATED INLET PIT
16	900 x 900 GRATED INLET PIT
17	600 x 600 GRATED INLET PIT
18	1200 x 1200 DEEP DROP PIT
19	900 x 900 GRATED INLET PIT
20	900 x 900 GRATED INLET PIT
21	900 x 900 GRATED INLET DROP PIT
22	900 x 900 GRATED INLET PIT
23	900 x 900 GRATED INLET PIT
24	900 x 900 GRATED INLET PIT
25	900 x 900 GRATED INLET PIT
26	GPT-HUMEGARD
27	3000 x 900 IN-SITU ACCESS PIT
28	3000 x 900 IN-SITU ACCESS PIT
29	1200 x 1200 DEEP DROP PIT
30	900 x 900 GRATED INLET PIT
31	900 x 900 GRATED INLET PIT
32	900 x 900 GRATED INLET PIT
33	900 x 900 GRATED INLET PIT
34	900 x 900 GRATED INLET PIT
35	900 x 900 GRATED INLET PIT
36	900 x 900 GRATED INLET PIT
37	900 x 900 GRATED INLET PIT
38	900 x 900 GRATED INLET PIT
39	900 x 900 GRATED INLET PIT
40	600 x 600 GRATED INLET PIT
41	600 x 600 GRATED INLET PIT
42	600 x 600 GRATED INLET PIT

LEGEND:

- NEW GRATED TRENCH DRAIN
- NEW STORMWATER PIPE
- NEW STORMWATER PIT
- PIPE FLOW DIRECTION
- NEW GRASSED DRAINAGE SWALE
- NEW SUBSOIL DRAINAGE
- NEW RAINWATER TANK
- NEW DOWNPIPE CONNECTION LINE Ø150 UPVC
- NEW FLUSH POINT
- OVERLAND FLOW DIRECTION

NOTES:

- REFER TO DRG 21-26108-KN-SD-CI-1010 FOR DRAINAGE NOTES.

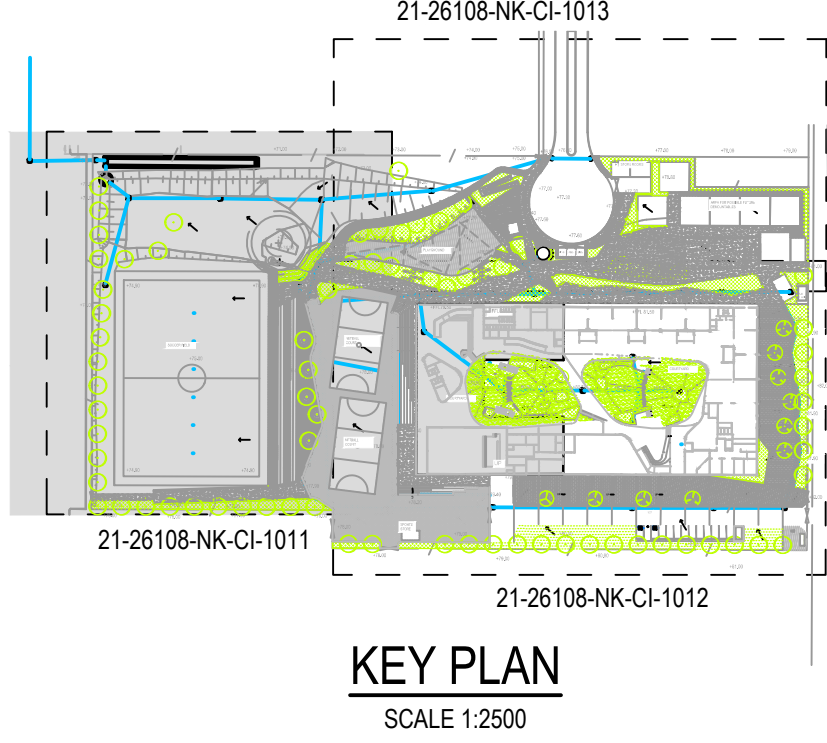

G ISSUED FOR SSD SUBMISSION		MR	PM*	MD*	02.02.18	
F ISSUED FOR SSD SUBMISSION		MR	PM*	MD*	24.11.17	
E SCHEME DESIGN FOR APPROVAL		MR	PM*	MD*	15.09.17	
D ISSUED FOR SD SUBMISSION		MR	PM*	MD*	05.09.17	
B ISSUED FOR SSD SUBMISSION		MR	CS*	SM*	09.08.17	
No	Revision	Note: * indicates signatures on original issue of drawing or last revision of drawing	Drawn	Job Manager	Project Director	Date

Plot Date: 2 February 2018 - 11:32 AM

Plotted by: Guillaume de Swardt

Cad File No: G:\21\26108\6. Kellyville North PS\00 Common\CADD\Drawings\21-26108-KN-SD-CI-1011.dwg

0 25 50 75 100 125m

SCALE 1:2500 AT ORIGINAL SIZE

0 2.5 5 7.5 10 12.5m

SCALE 1:250 AT ORIGINAL SIZE

NSW GOVERNMENT **Education**

TSA MANAGEMENT

GHD

Level 15, 133 Castlereagh Street, Sydney NSW 2000 Australia
T 61 2 9239 7100 F 61 2 9239 7199
E sydmail@ghd.com W www.ghd.com

DO NOT SCALE

Conditions of Use.
This document may only be used by GHD's client (and any other person who GHD has agreed can use this document) for the purpose for which it was prepared and must not be used by any other person or for any other purpose.

Drawn M.RANGWALA Designer G.DE SWARDT

Drafting Check A.MACLEAN* Design Check A.RAHMAN*

Approved (Project Director) Date

Scale 1:500

This Drawing must not be used for Construction unless signed as Approved

Client **NSW DEPARTMENT OF EDUCATION**

Project **NORTH KELLYVILLE PUBLIC SCHOOL**

Title **CIVIL STORMWATER DRAINAGE PLAN-SHEET 1 OF 3**

Original Size **A1** Drawing No: **21-26108-KN-SD-CI-1011** Rev: **F**