



NSW GOVERNMENT
Planning

Issued under the Environmental Planning and Assessment Act 1979

Approved Application No. **SSD 6351**

granted on the **22 March 2018**

Signed 

Sheet No. **1** of **12**

© COPYRIGHT GRIMSHAW ARCHITECTS PTY LIMITED. UNLESS OTHERWISE AGREED IN WRITING, ALL RIGHTS TO USE THIS DOCUMENT ARE SUBJECT TO PAYMENT IN FULL OF ALL GRIMSHAW CHARGES. THIS DOCUMENT MAY ONLY BE USED FOR THE EXPRESS PURPOSE AND PROJECT FOR WHICH IT HAS BEEN CREATED AND DELIVERED. AS NOTICED IN WRITING BY GRIMSHAW, AND THIS DOCUMENT MAY NOT BE OTHERWISE USED, OR COPIED, AND UNAUTHORISED USE OF THIS DOCUMENT IS AT THE USER'S SOLE RISK AND WITHOUT LIMITING GRIMSHAW'S RIGHTS TO THE USER RELEASES AND INDEMNITIES GRIMSHAW FROM AND AGAINST ALL LOSS AND DAMAGE.

REV.	DATE	FOR
01	MAY 2017	STAGE 1 SSDA

HEAD DESIGN CONSULTANT
GRIMSHAW

GRIMSHAW
LEVEL 3, 24 MCKENZIE ROAD, SYDNEY
NEW SOUTH WALES 2000 AUSTRALIA
TELEPHONE +61 2 9253 0088
WWW.GRIMSHAW.CO.UK

NORTH TOWER PRINCIPAL
**JPW
JOHNSON PILTON WALKER**

JOHNSON PILTON WALKER PTY LTD ACN 085 778 886
LEVEL 10 PLAZA BUILDING AUSTRALIA SQUARE
50 PITT STREET SYDNEY
NEW SOUTH WALES 2000 AUSTRALIA
TELEPHONE +61 2 9254 8888
FACSIMILE +61 2 9254 8889
EMAIL: JPW@JPW.COM.AU

HEAD ENGINEERING CONSULTANT
ARUP

ARUP
10001 KENT STREET, SYDNEY 2000
TEL: +61 2 820 8200
EMAIL: SYDNEY@ARUP.COM

PROJECT
**SYDNEY METRO MARTIN PLACE STATION
MACQUARIE'S UNSOLICITED PROPOSAL**

CLIENT
MACQUARIE GROUP LTD


NORTH

SCALE
1:1000 @ A1
DO NOT SCALE FROM DRAWING. USE MARKED DIMENSIONS TO BE READ IN CONJUNCTION WITH ALL OTHER CONSULTANT'S DRAWINGS.


STATUS
STAGE 1 SSDA

DRAWING
LOCATION PLAN
ENVELOPE DRAWINGS

DRAWN	CHECKED	AUTHORISED
KY	MC	AC

DRAWING NUMBER
MPS_COA_000_XX_DR_A_DA1007_01

REVISION

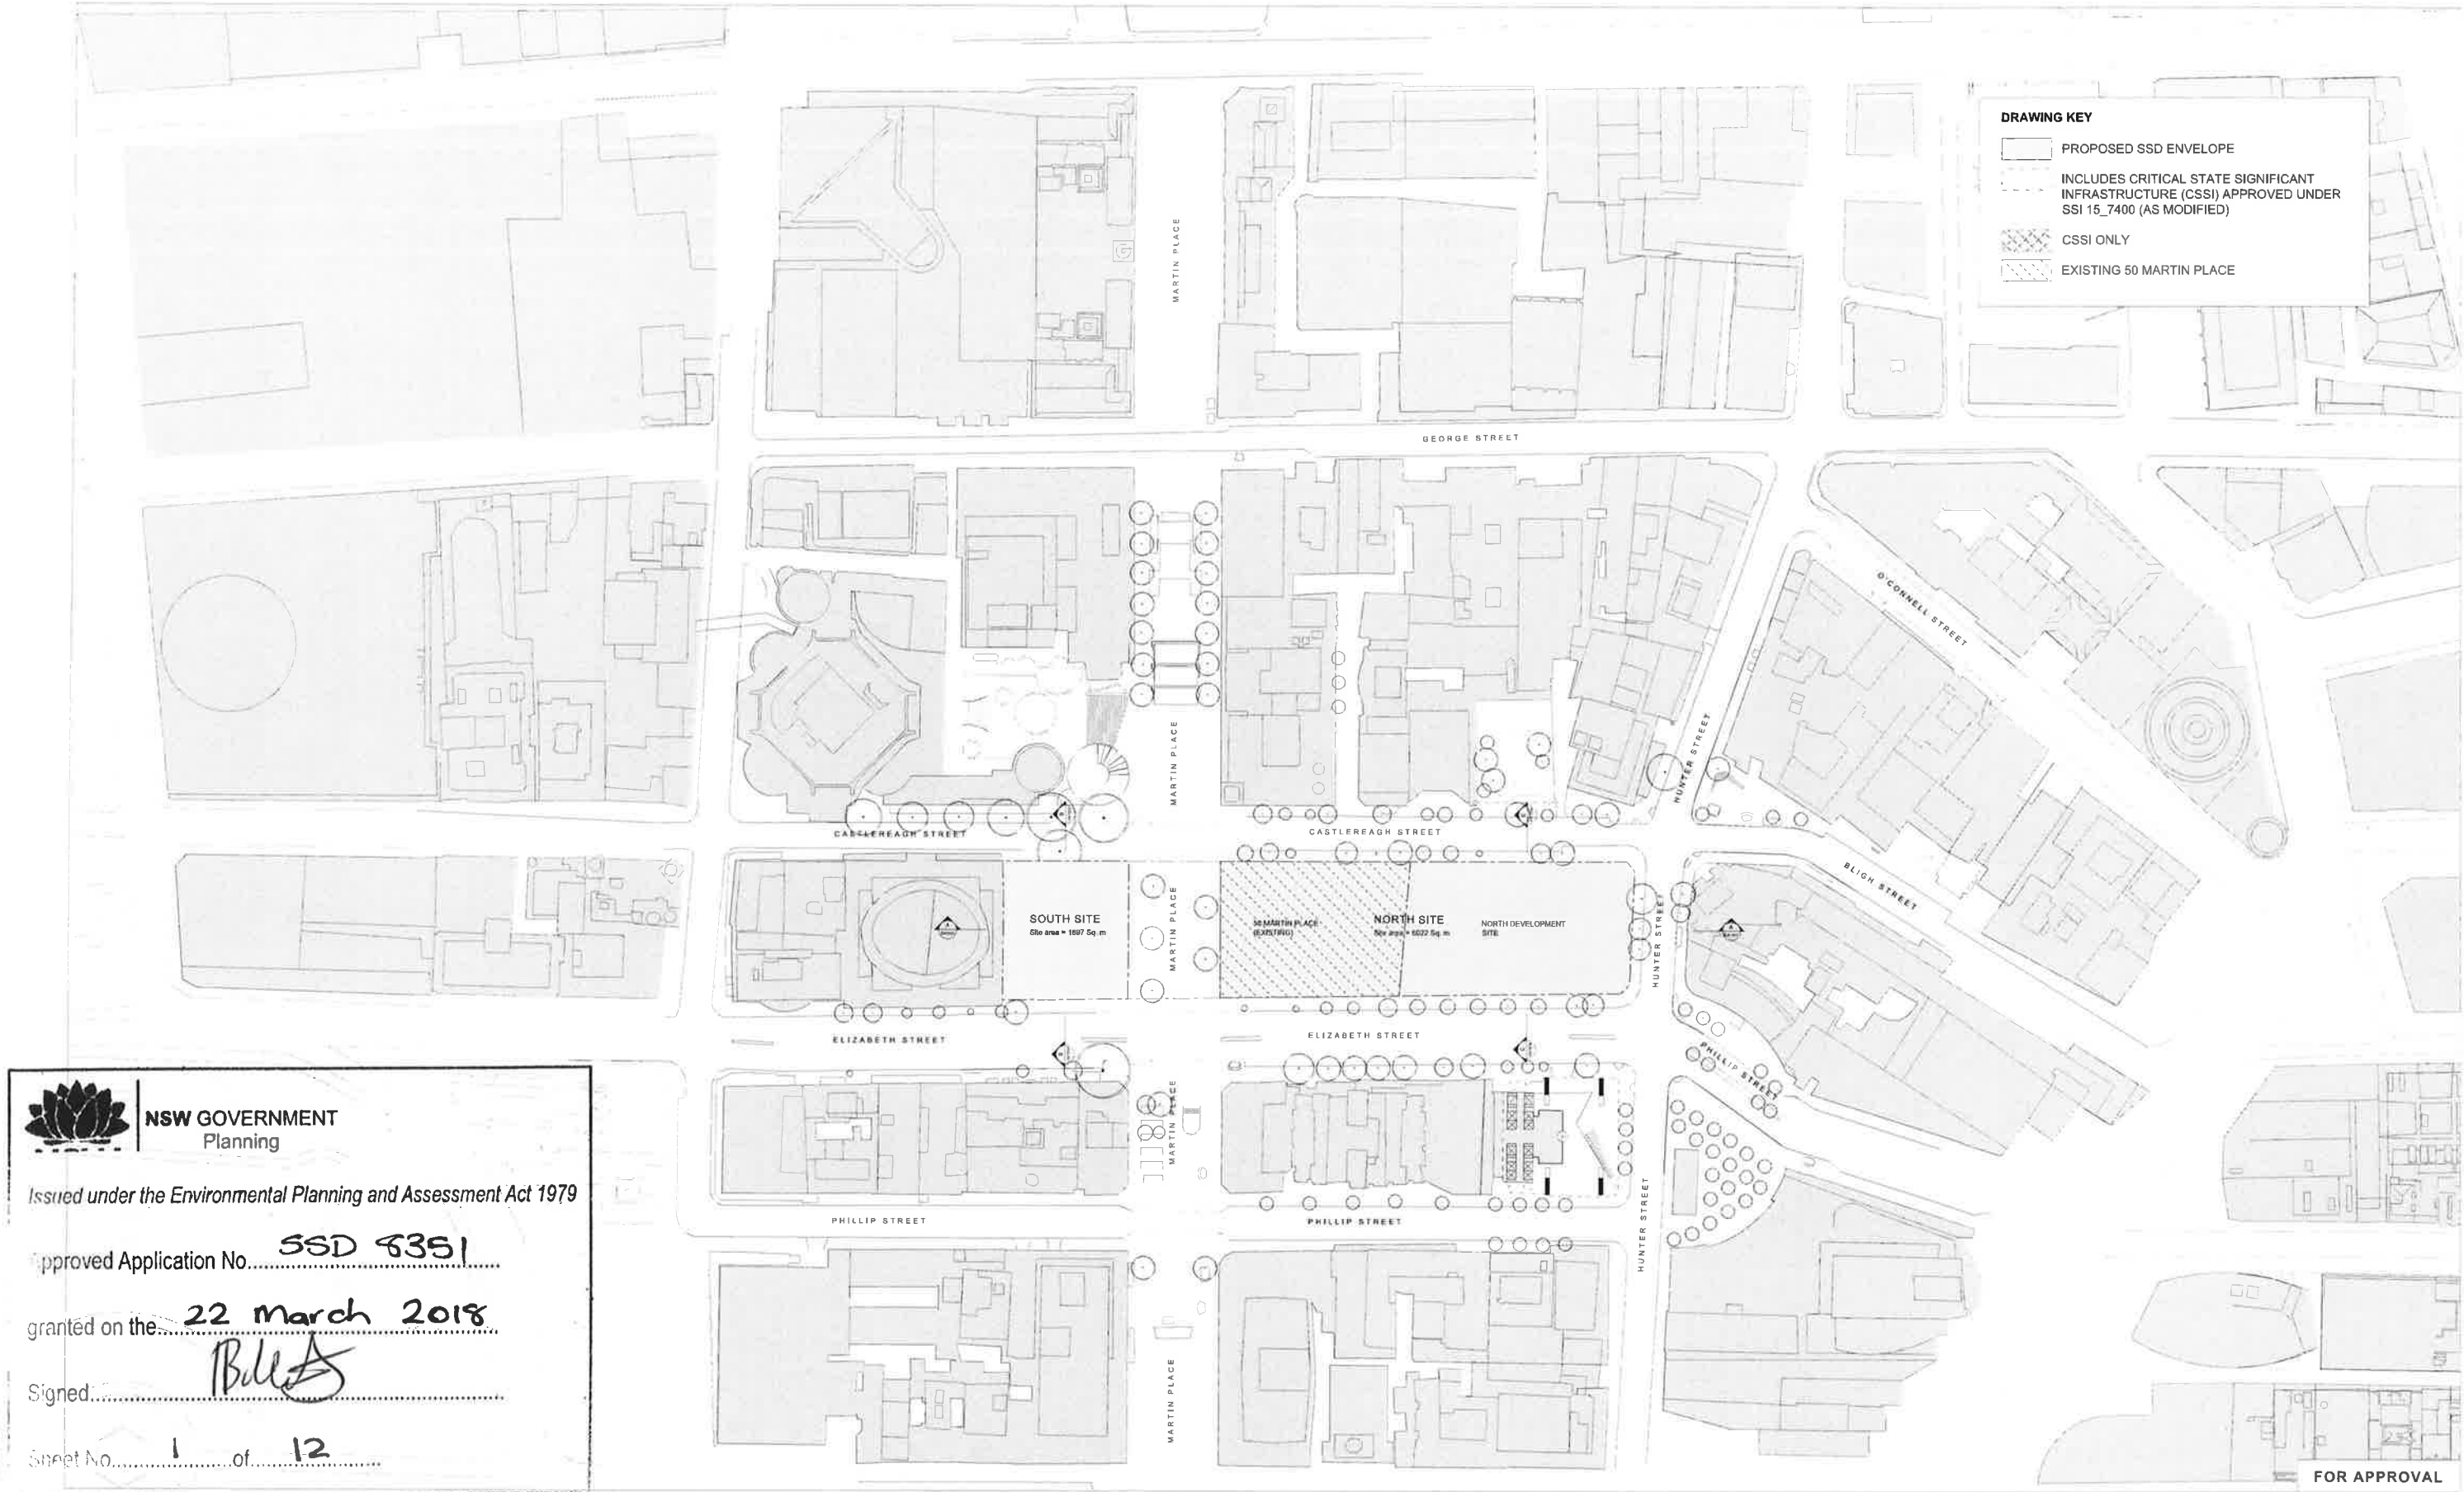



NSW GOVERNMENT
Planning

Issued under the Environmental Planning and Assessment Act 1979

Approved Application No. **SSD 8381**


granted on the **22 March 2018**

Signed *[Signature]*

Sheet No. **2** of **12**

DRAWING KEY

- PROPOSED SSD ENVELOPE
- INCLUDES CRITICAL STATE SIGNIFICANT INFRASTRUCTURE (CSSI) APPROVED UNDER SSI 15_7400 (AS MODIFIED)
- CSSI ONLY
- EXISTING 50 MARTIN PLACE

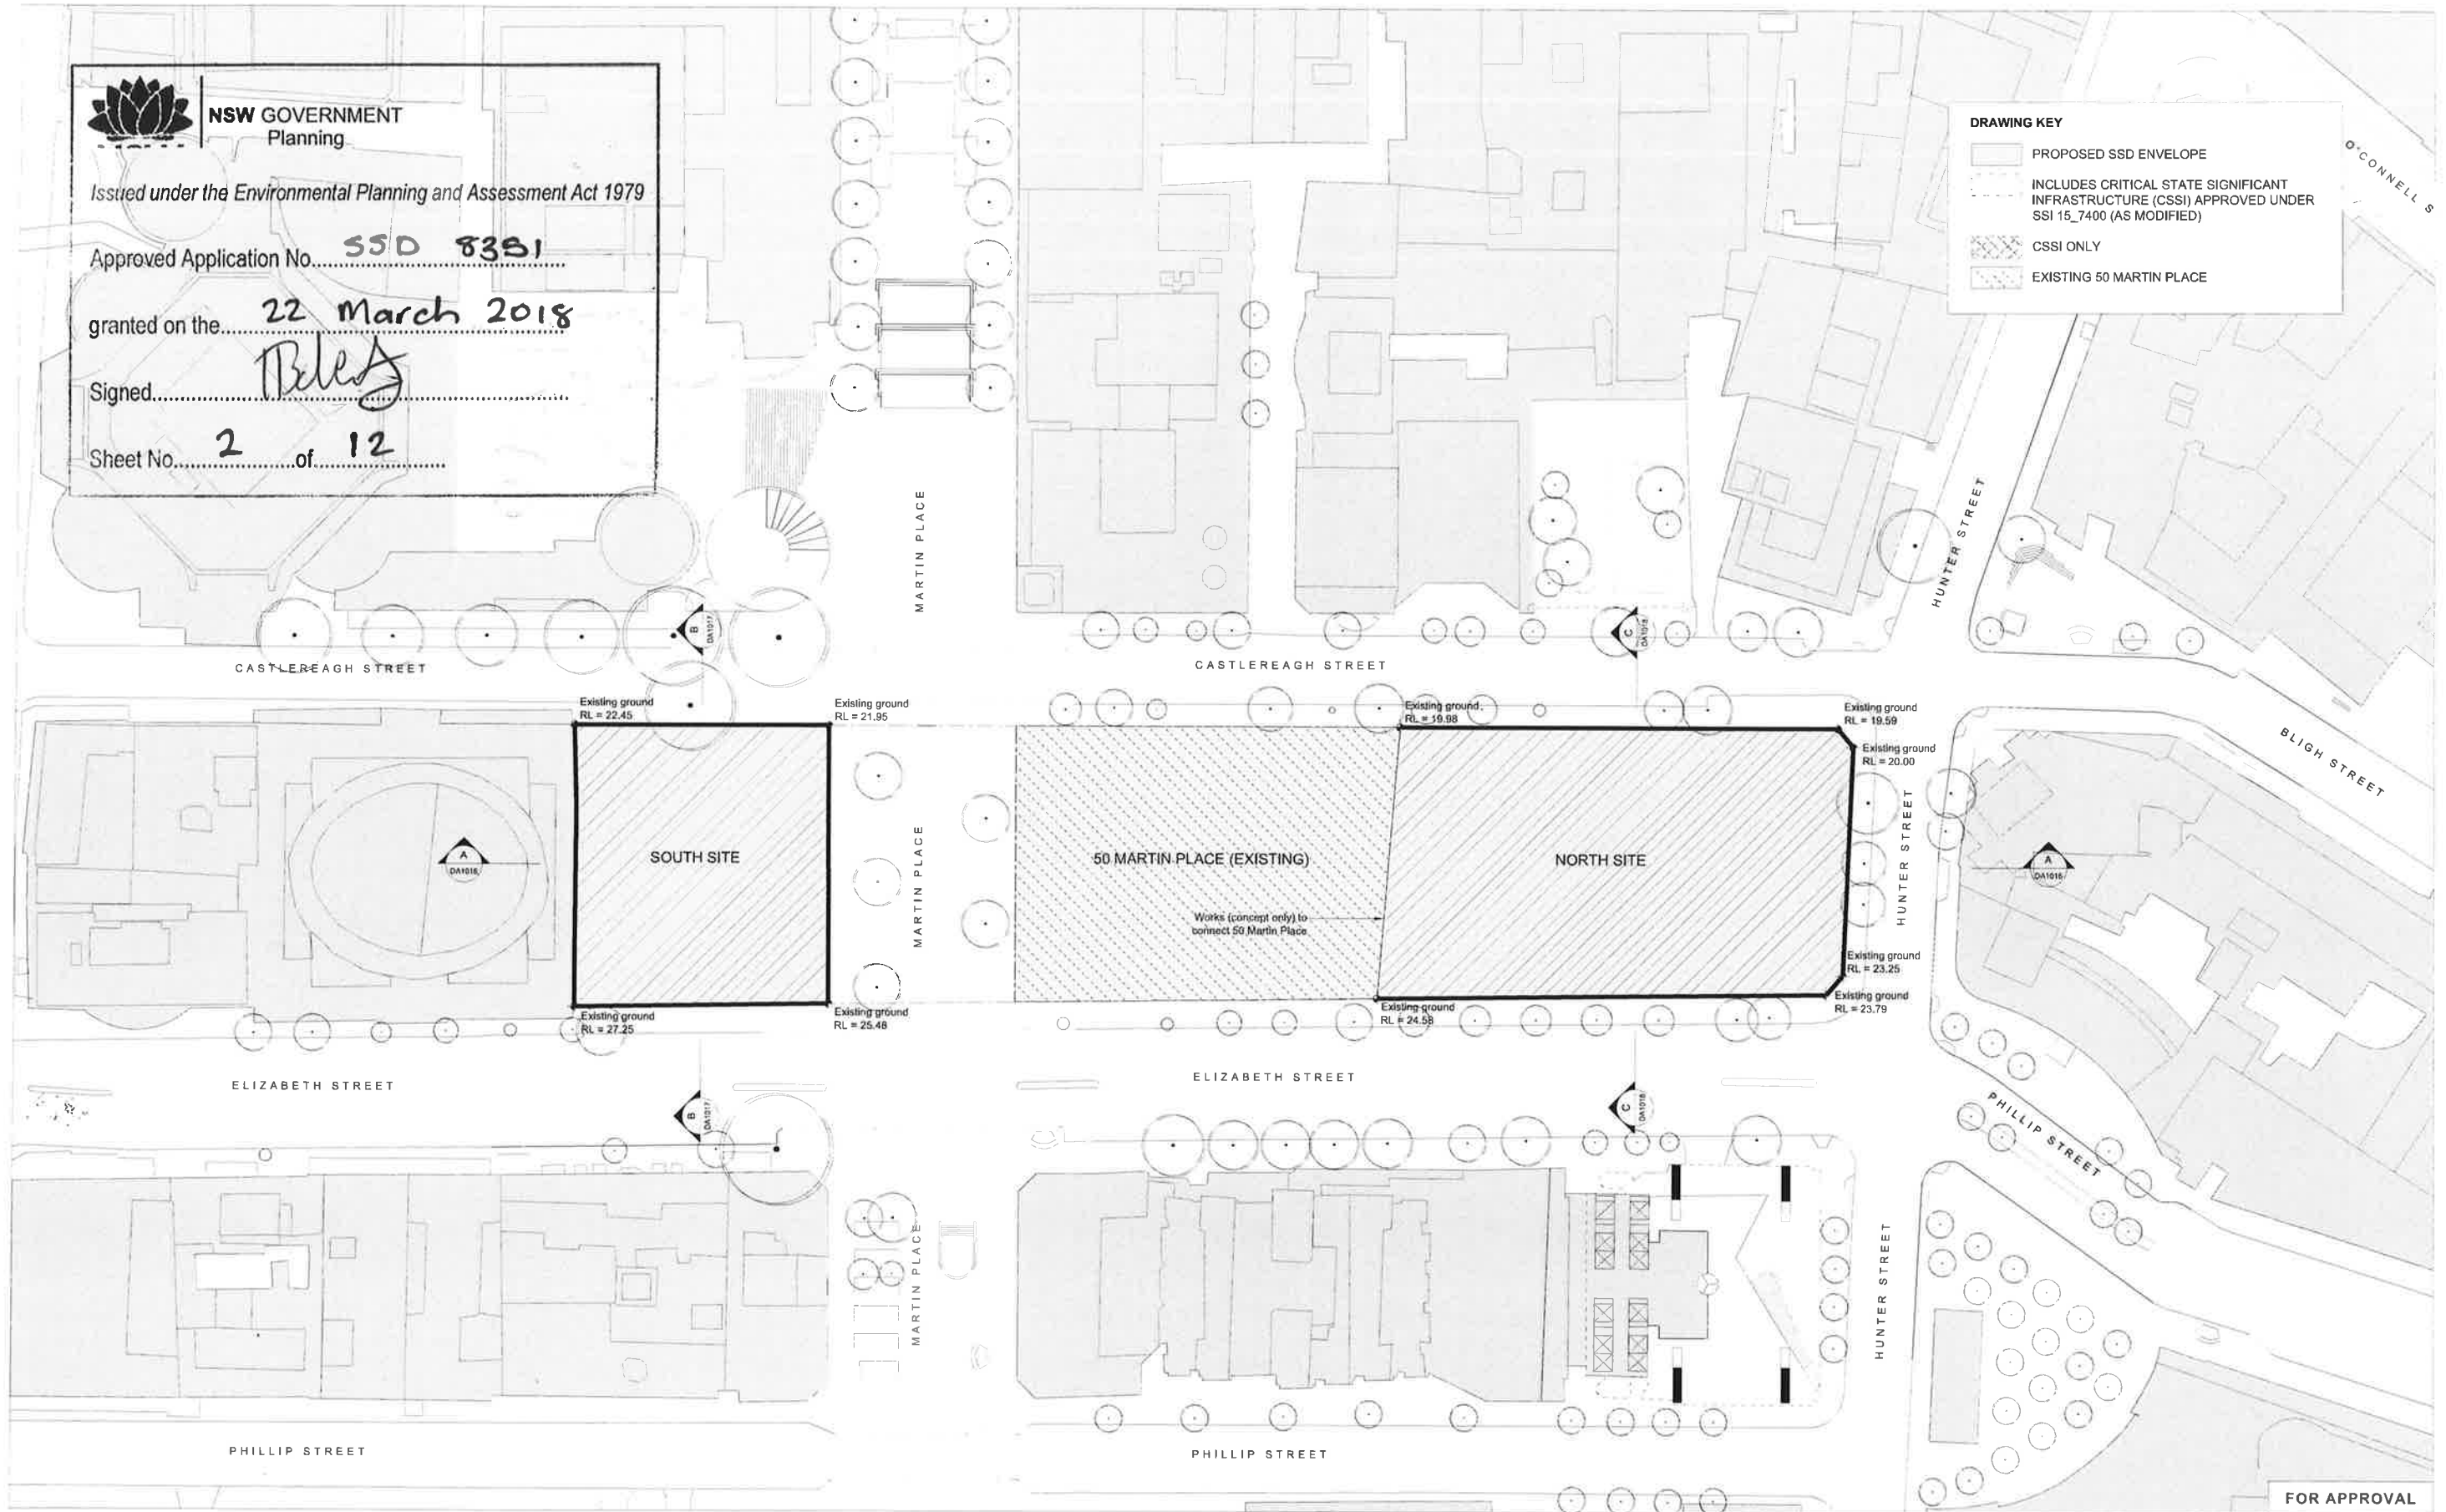

FOR APPROVAL

© COPYRIGHT GRIMSHAW ARCHITECTS PTY LIMITED. UNLESS OTHERWISE AGREED IN WRITING, ALL RIGHTS TO USE THIS DOCUMENT ARE SUBJECT TO PAYMENT IN FULL OF ALL GRIMSHAW CHARGES. THIS DOCUMENT MAY ONLY BE USED FOR THE EXPRESS PURPOSE AND PROJECT FOR WHICH IT HAS BEEN CREATED AND DELIVERED. AS NOTIFIED IN WRITING BY GRIMSHAW. AND THIS DOCUMENT MAY NOT BE OTHERWISE USED OR COMPILED OR UNAUTHORIZED USE OF THIS DOCUMENT IS AT THE USER'S SOLE RISK AND WITHOUT LIMITING GRIMSHAW'S RIGHTS TO THE USER RELEASED AND INDEMNIFIED GRIMSHAW FROM AND AGAINST ALL LOSSES AND DAMAGES.

REV.	DATE	FOR
01	MAY 2017	STAGE 1 SSDA



HEAD DESIGN CONSULTANT
GRIMSHAW

GRIMSHAW
LEVEL 8, 24 HICKSON ROAD, SYDNEY
NSW 1500
TELEPHONE +61 2 9233 0000
WWW.GRIMSHAW.COM.AU

NORTH TOWER PRINCIPAL
**JPW
JOHNSON PILTON WALKER**

JOHNSON PILTON WALKER PTY LTD ACN 581 778 818
LEVEL 15 PLAZA BUILDING AUSTRALIA SQUARE
SUITE 1000 1000 AUSTRALIA SQUARE
NEW SOUTH WALES 2000 AUSTRALIA
TELEPHONE +61 2 9233 8888
FACSIMILE +61 2 9233 8888
EMAIL JPW@JPW.COM.AU

HEAD ENGINEERING CONSULTANT
ARUP

ARUP
10001 KENT STREET SYDNEY 2000
TEL +61 2 9220 9300
EMAIL SYDNEY@ARUP.COM

PROJECT
**SYDNEY METRO MARTIN PLACE STATION
MACQUARIE'S UNSOLICITED PROPOSAL**

CLIENT
MACQUARIE GROUP LTD

NORTH

SCALE
1:500 @ A1
DO NOT SCALE FROM DRAWING. USE MARKED DIMENSIONS TO BE READ IN CONJUNCTION WITH ALL OTHER CORRELATING DOCUMENTS.

STATUS
STAGE 1 SSDA

DRAWING
GROUND FLOOR PLAN
ENVELOPE DRAWINGS

DRAWN	CHECKED	AUTHORISED
KY	MC	AC

DRAWING NUMBER
MPS_COA_000_XX_DR_A_DA1008_01

REVISION



NSW GOVERNMENT
Planning

Issued under the Environmental Planning and Assessment Act 1979

Approved Application No. SSD 8351


granted on the 22 March 2018

Signed [Signature]

Sheet No. 3 of 12

DRAWING KEY

- PROPOSED SSD ENVELOPE
- INCLUDES CRITICAL STATE SIGNIFICANT INFRASTRUCTURE (CSSI) APPROVED UNDER SSI 15_7400 (AS MODIFIED)
- CSSI ONLY
- EXISTING 50 MARTIN PLACE

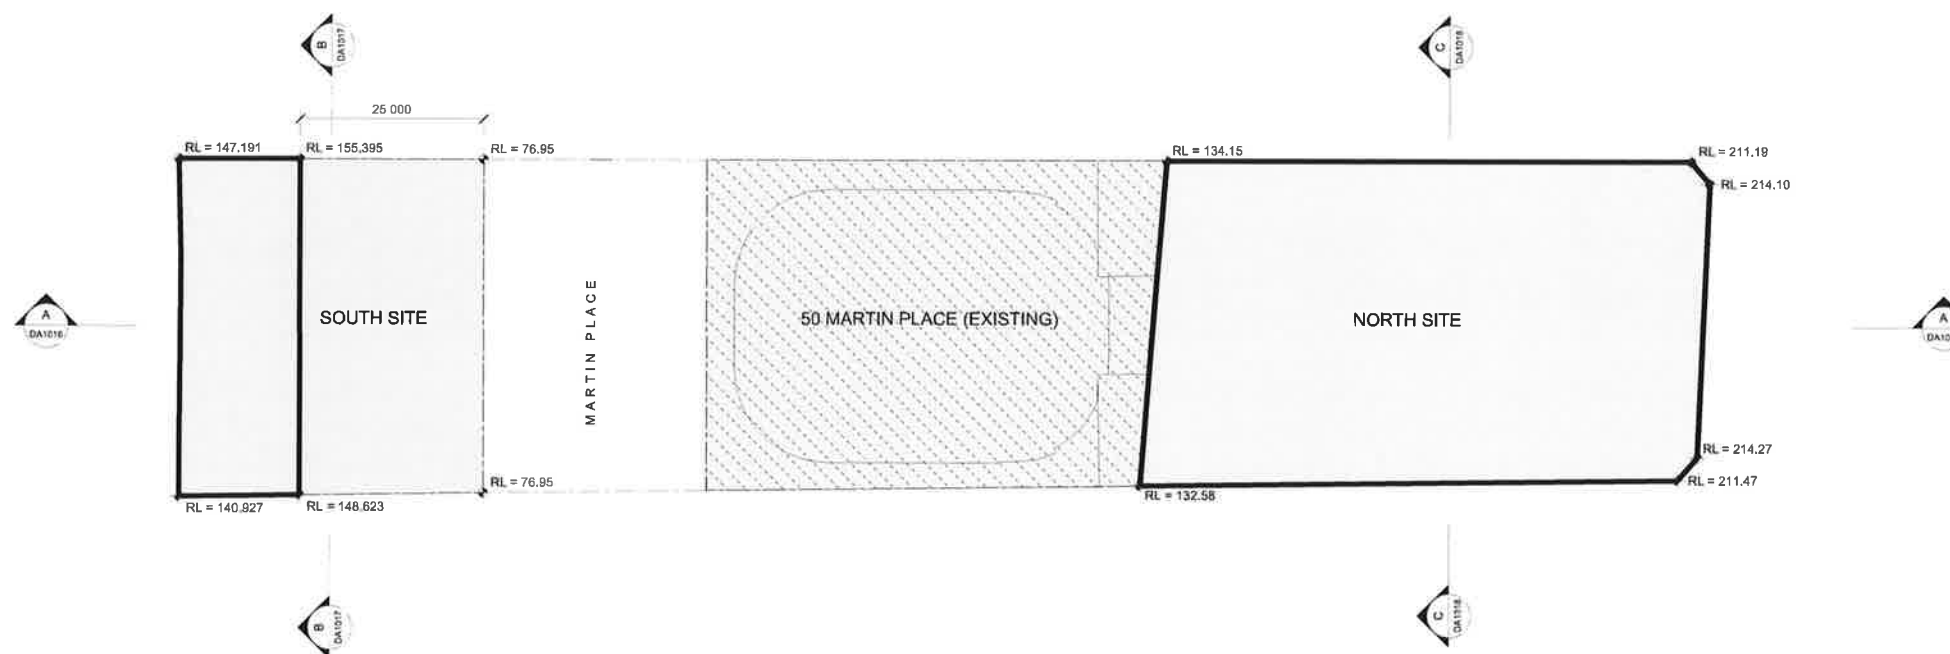

FOR APPROVAL

COPYRIGHT GRIMSHAW ARCHITECTS PTY LIMITED. UNLESS OTHERWISE AGREED IN WRITING, ALL RIGHTS TO USE THIS DOCUMENT ARE RESERVED. THIS DOCUMENT MAY ONLY BE USED FOR THE EXPRESS PURPOSE AND PROJECT FOR WHICH IT HAS BEEN CREATED AND DELIVERED. AS NOTIFIED IN WRITING BY GRIMSHAW, AND THIS DOCUMENT MAY NOT BE OTHERWISE USED, OR COPIED, OR REPRODUCED, OR USED IN ANY MANNER WITHOUT THE WRITING OF GRIMSHAW. THE USER RELEASES AND INDEMNIFIES GRIMSHAW FROM AND AGAINST ALL LOSS, SO, ARISING.

REV. DATE FOR
01 MAY 2017 STAGE 1 SSDA



HEAD DESIGN CONSULTANT
GRIMSHAW

GRIMSHAW
LEVEL 11, 111 HICKSON ROAD, SYDNEY
NEW SOUTH WALES 2000 AUSTRALIA
TEL: +61 2 9250 1000
WWW.GRIMSHAW.COM.AU

NORTH TOWER PRINCIPAL
**JPW
JOHNSON PILTON WALKER**

JOHNSON PILTON WALKER PTY LTD, ACN 881 176 888
LEVEL 10 PLAZA SUITE 100 AUSTRALIA SQUARE
85 PITT STREET SYDNEY
NEW SOUTH WALES 2000 AUSTRALIA
TEL: +61 2 9250 1000
FACSIMILE: +61 2 9250 1001
EMAIL: JPW@JPW.COM.AU

HEAD ENGINEERING CONSULTANT
ARUP

ARUP
10/101 KENT STREET, SYDNEY 2000
TEL: +61 2 8566 8000
EMAIL: SYDNEY@ARUP.COM

PROJECT
**SYDNEY METRO MARTIN PLACE STATION
MACQUARIE'S UNSOLICITED PROPOSAL**

CLIENT
MACQUARIE GROUP LTD

NORTH

SCALE
1:500 @ A1

DO NOT SCALE FROM DRAWING. USE MARKED DIMENSIONS TO BE READ IN CONJUNCTION WITH ALL OTHER CONSULTANT'S DRAWINGS.


STATUS
STAGE 1 SSDA

DRAWING
ROOF PLAN
ENVELOPE DRAWINGS

DRAWN CHECKED AUTHORISED
KY MC AC

DRAWING NUMBER
MPS_COA_000_XX_DR_A_DA1009_01

REVISION

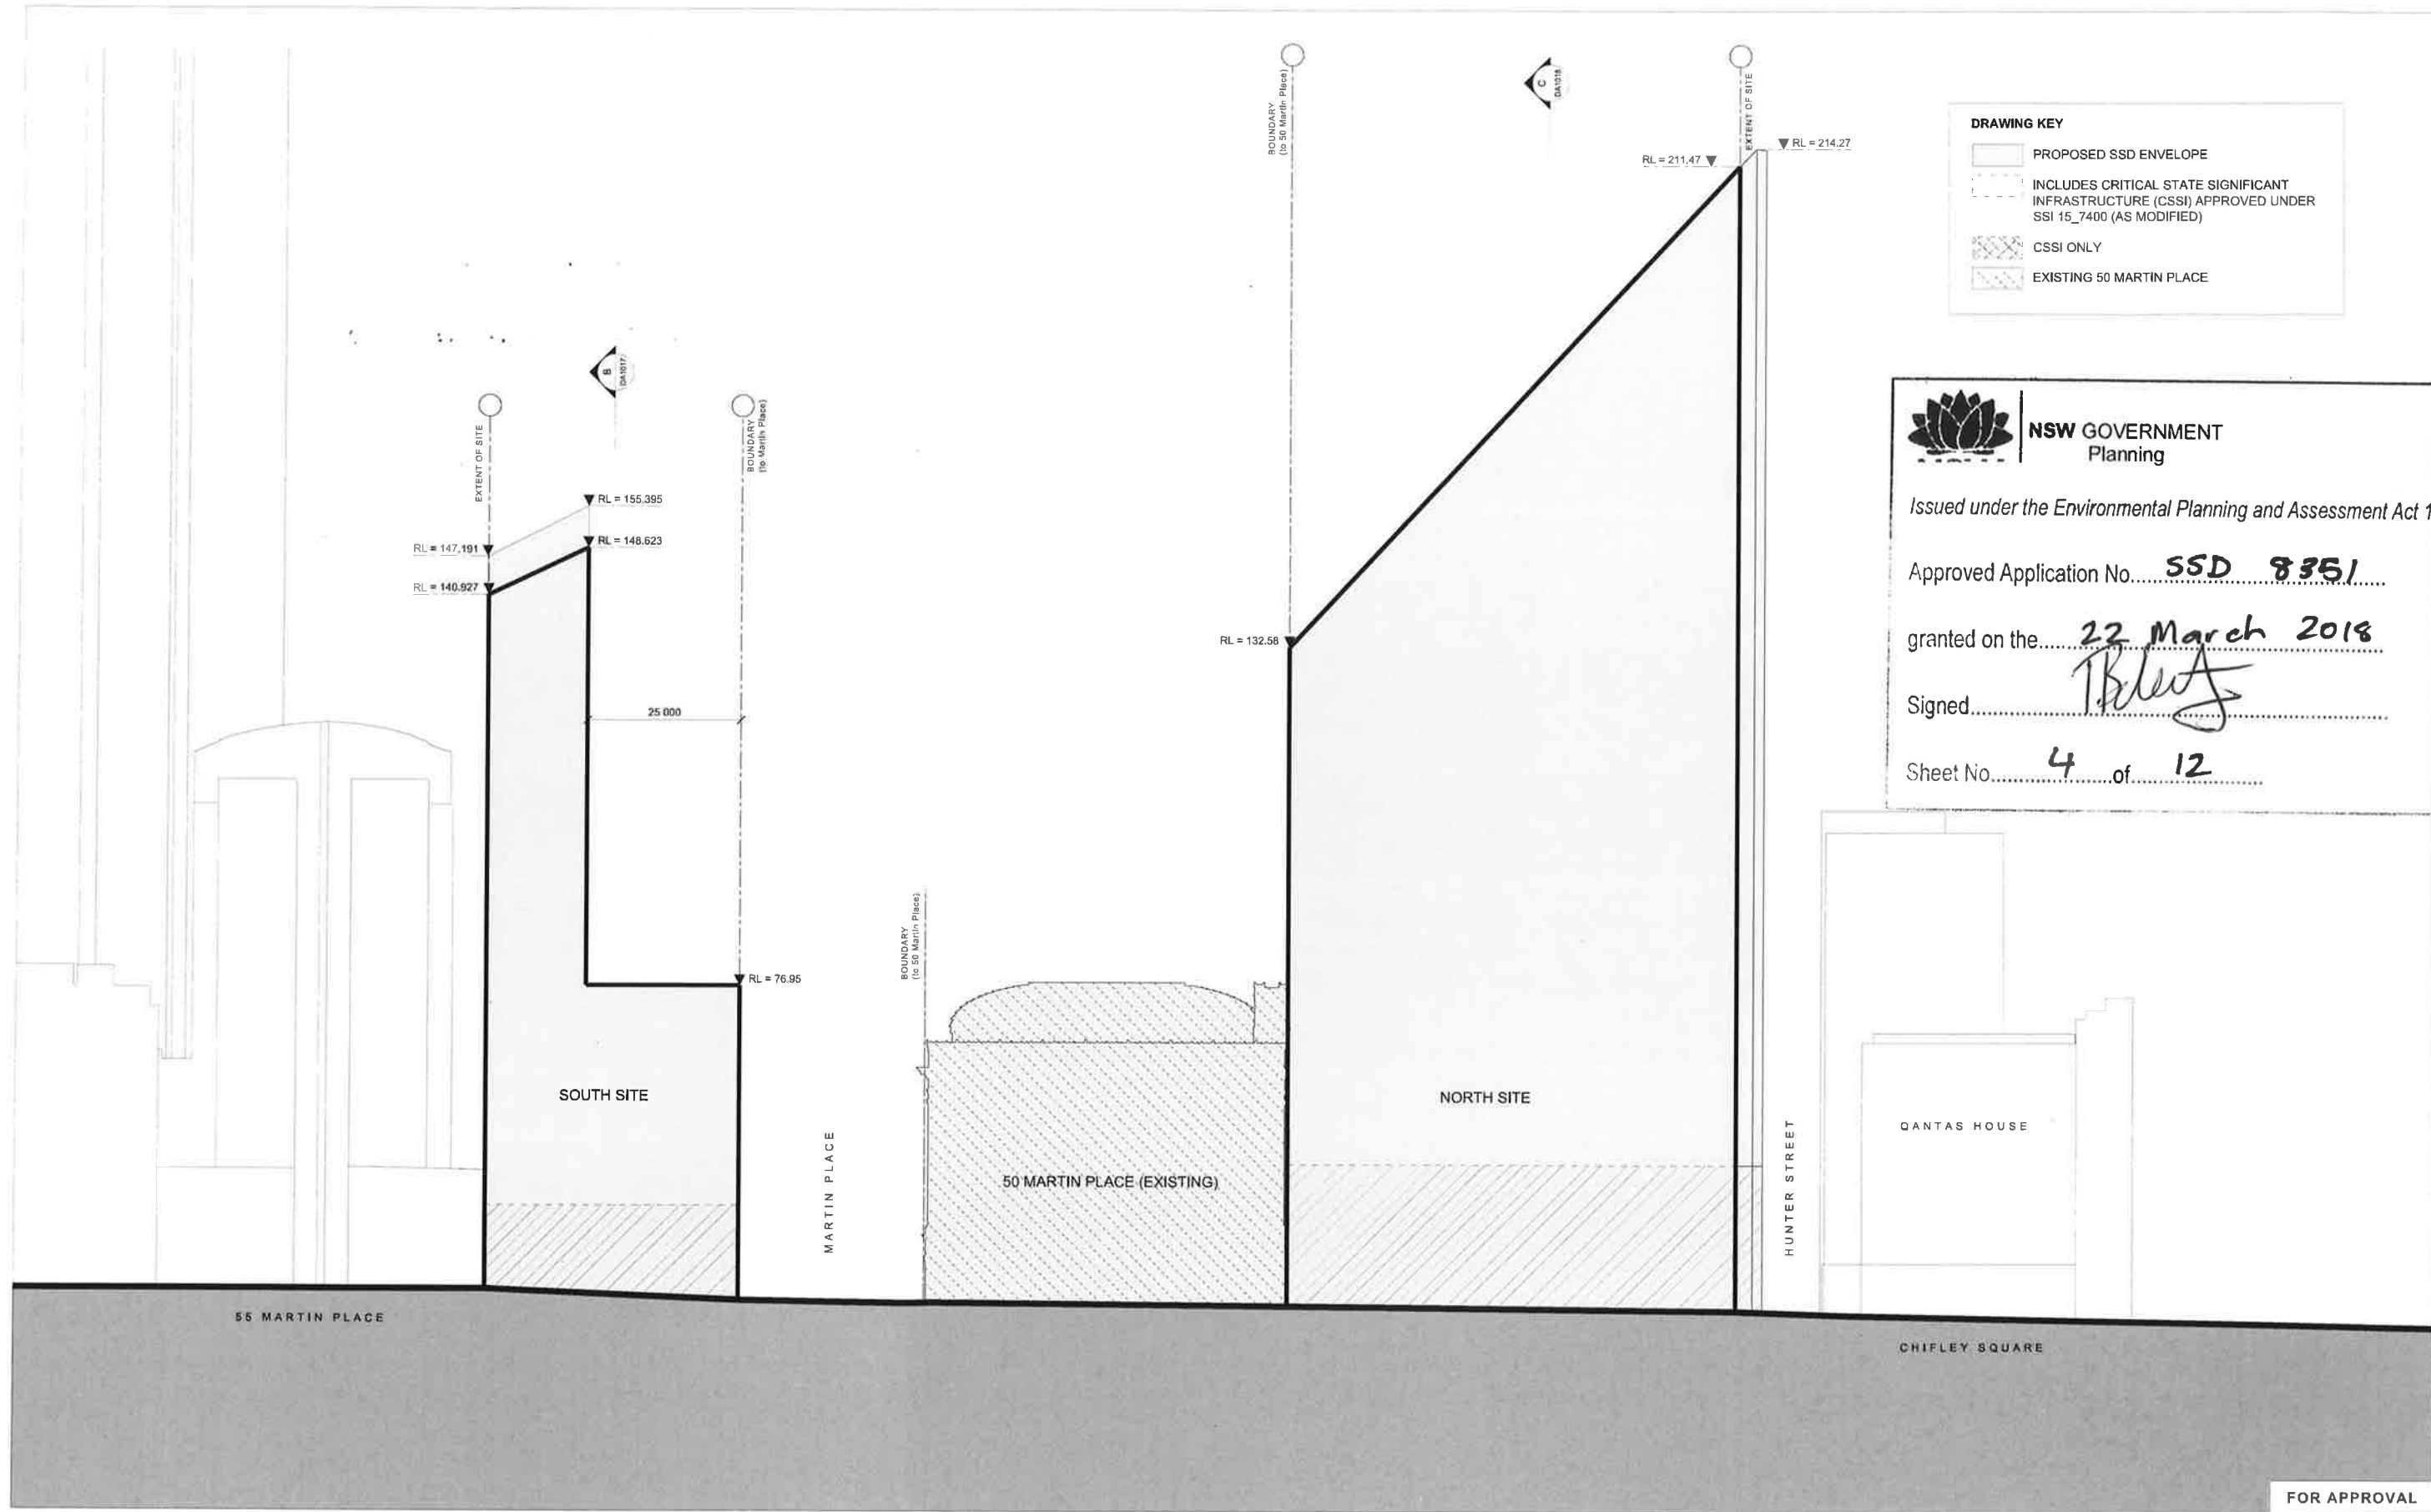

NSW GOVERNMENT
Planning


Issued under the Environmental Planning and Assessment Act 1979

Approved Application No. **SSD 8351**

granted on the **22 March 2018**

Signed *[Signature]*

Sheet No. **4** of **12**

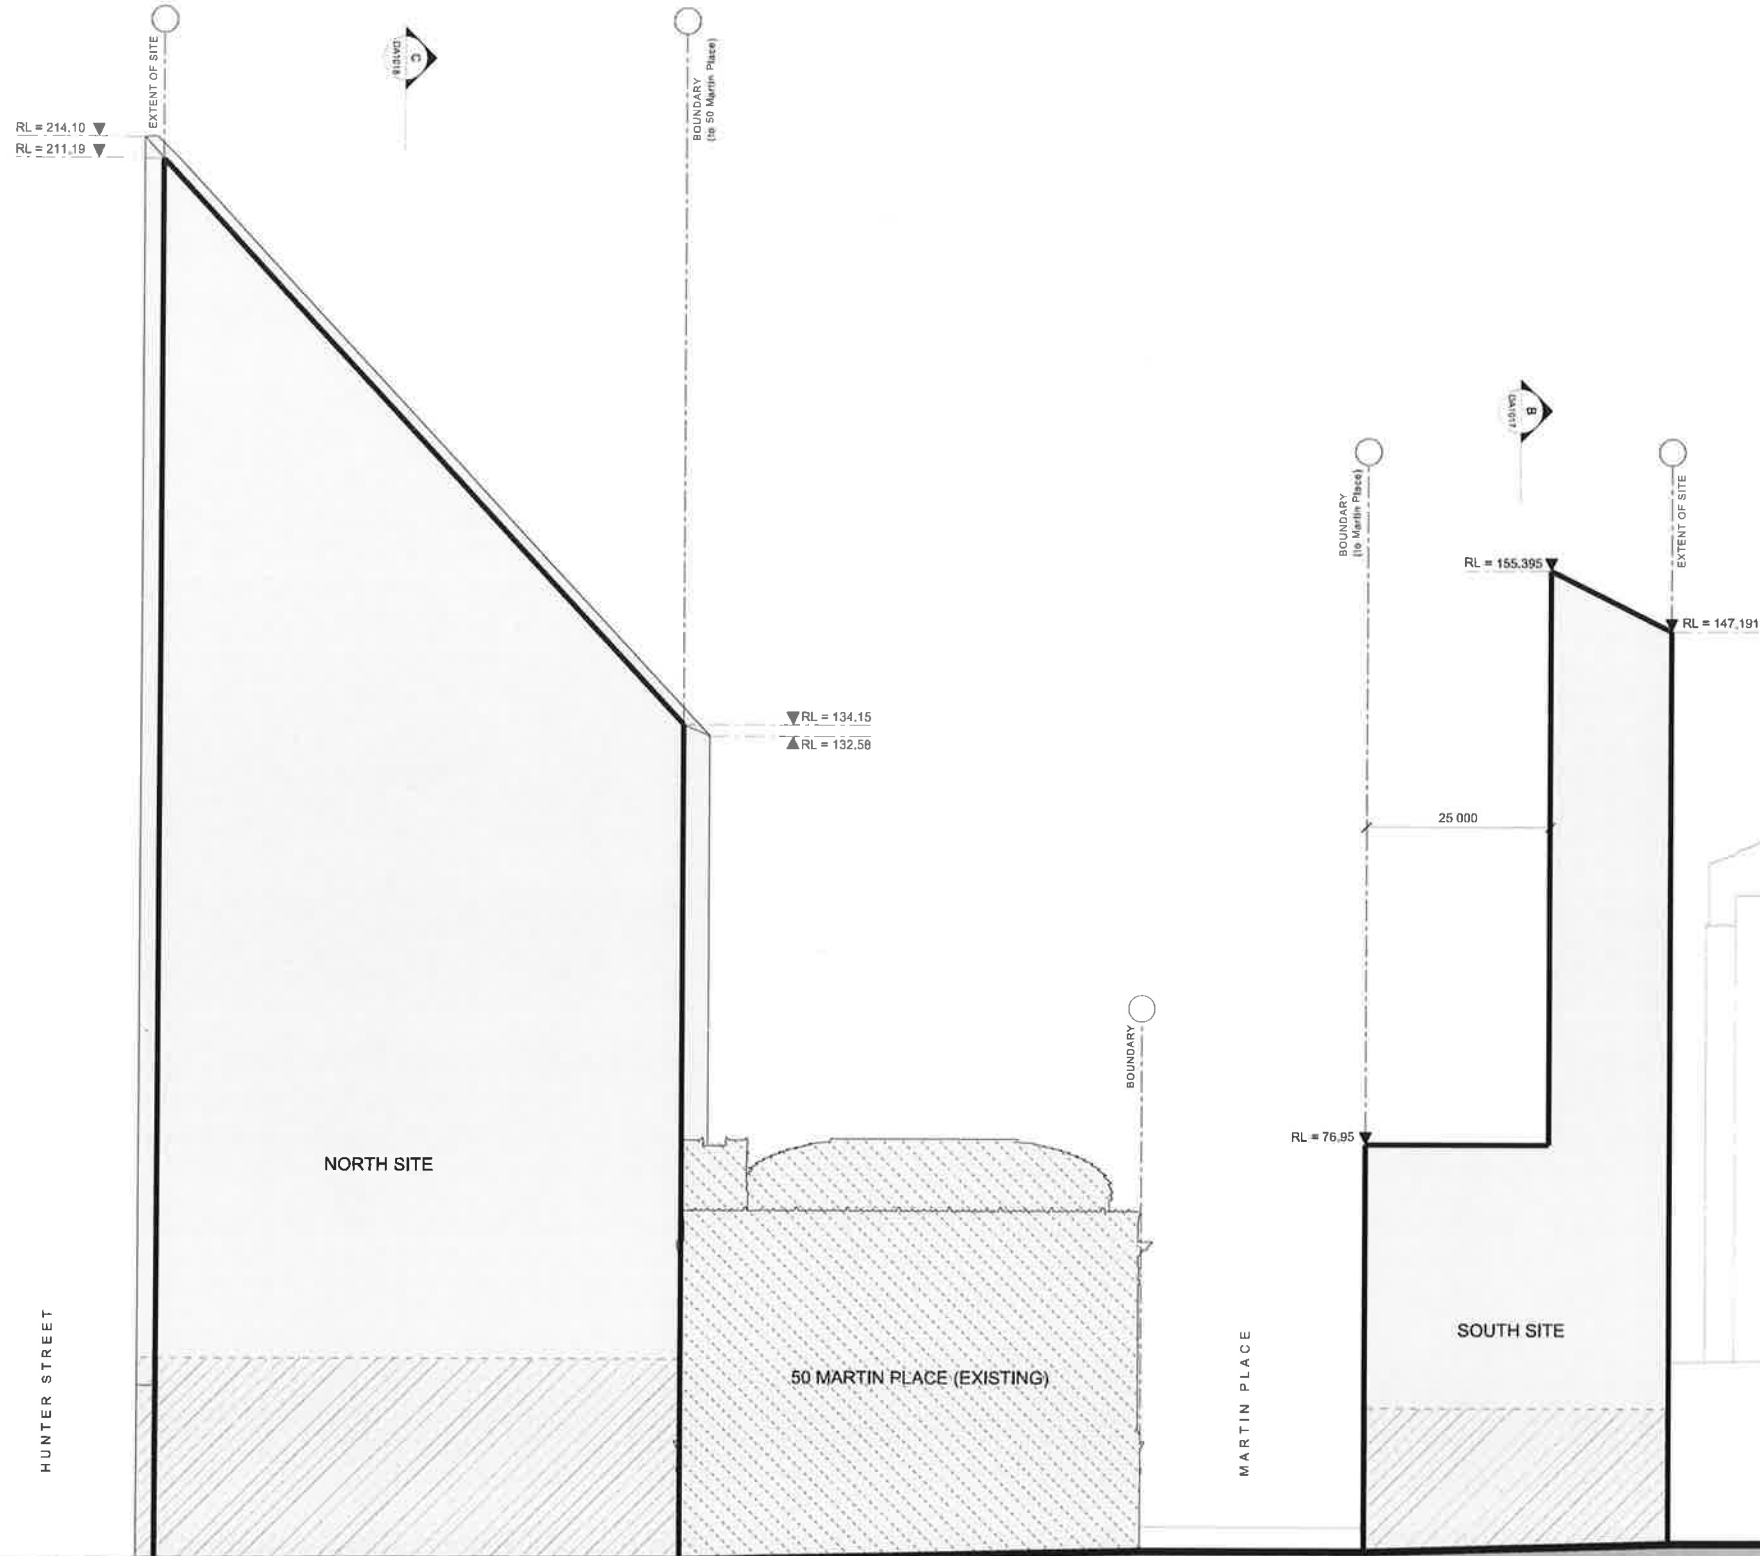

DRAWING KEY	
	PROPOSED SSD ENVELOPE
	INCLUDES CRITICAL STATE SIGNIFICANT INFRASTRUCTURE (CSSI) APPROVED UNDER SSI 15_7400 (AS MODIFIED)
	CSSI ONLY
	EXISTING 50 MARTIN PLACE

	NSW GOVERNMENT Planning
Issued under the Environmental Planning and Assessment Act 1979	
Approved Application No. SSD 8351	
granted on the 22 March 2018	
Signed	
Sheet No. 5 of 12	

© COPYRIGHT GRIMSHAW ARCHITECTS PTY LIMITED. UNLESS OTHERWISE AGREED IN WRITING, ALL RIGHTS TO USE THIS DOCUMENT ARE RESERVED TO GRIMSHAW ARCHITECTS PTY LIMITED. NO PART OF THIS DOCUMENT MAY BE REPRODUCED OR TRANSMITTED IN ANY FORM OR BY ANY MEANS, ELECTRONIC OR MECHANICAL, INCLUDING PHOTOCOPYING, RECORDING, OR BY ANY INFORMATION STORAGE AND RETRIEVAL SYSTEM, WITHOUT PERMISSION IN WRITING BY GRIMSHAW ARCHITECTS PTY LIMITED. THIS DOCUMENT IS THE PROPERTY OF GRIMSHAW ARCHITECTS PTY LIMITED AND IS LOANED TO YOU. IT IS TO BE USED ONLY FOR THE PROJECT AND SITE SPECIFICALLY IDENTIFIED IN THE TITLE BLOCK. IT IS NOT TO BE USED FOR ANY OTHER PROJECT OR SITE. IT IS NOT TO BE REPRODUCED OR TRANSMITTED IN ANY FORM OR BY ANY MEANS, ELECTRONIC OR MECHANICAL, INCLUDING PHOTOCOPYING, RECORDING, OR BY ANY INFORMATION STORAGE AND RETRIEVAL SYSTEM, WITHOUT PERMISSION IN WRITING BY GRIMSHAW ARCHITECTS PTY LIMITED.

REV.	DATE	FOR
01	MAY 2017	STAGE 1 SSDA



HEAD DESIGN CONSULTANT
GRIMSHAW

GRIMSHAW
LEVEL 3, 24 HICKSON ROAD, SYDNEY
NEW SOUTH WALES 2000 AUSTRALIA
TEL: 02 9550 1500
WWW.GRIMSHAW.COM.AU

NORTH TOWER PRINCIPAL
**JPIW
JOHNSON PILTON WALKER**

JOHNSON PILTON WALKER PTY LTD ACN 085 776 888
LEVEL 10 PLAZA BUILDING AUSTRALIA SQUARE
160 RIVER STREET SYDNEY
NSW 2000 AUSTRALIA
TELEPHONE: +61 2 9253 5800
FACSIMILE: +61 2 9253 5800
EMAIL: jpiw@jpiw.com.au

HEAD ENGINEERING CONSULTANT
ARUP

ARUP
10701 KENT STREET, SYDNEY 2000
TEL: +61 2 9230 5200
EMAIL: sydney@arup.com

PROJECT
**SYDNEY METRO MARTIN PLACE STATION
MACQUARIE'S UNSOLICITED PROPOSAL**

CLIENT
MACQUARIE GROUP LTD

NORTH

SCALE
1:500 @ A1
DO NOT SCALE FROM DRAWING. USE MARKED DIMENSIONS TO BE READ IN CONJUNCTION WITH ALL OTHER CONSULTANT'S DRAWINGS.

STATUS
STAGE 1 SSDA

DRAWING
**WEST ELEVATION
ENVELOPE DRAWINGS**

DRAWN	CHECKED	AUTHORISED
KY	MC	AC

DRAWING NUMBER	REVISION
MPS_COA_000_XX_DR_A_DA1011_01	

FOR APPROVAL

DRAWING KEY

- PROPOSED SSD ENVELOPE
- INCLUDES CRITICAL STATE SIGNIFICANT INFRASTRUCTURE (CSSI) APPROVED UNDER SSI 15_7400 (AS MODIFIED),
- CSSI ONLY
- EXISTING 50 MARTIN PLACE



NSW GOVERNMENT
Planning

Issued under the Environmental Planning and Assessment Act 1979

Approved Application No. **SSD 8351**

granted on the **22 March 2018**

Signed *[Signature]*

Sheet No. **6** of **12**



FOR APPROVAL

© COPYRIGHT GRIMSHAW ARCHITECTS PTY LIMITED. UNLESS OTHERWISE AGREED IN WRITING, ALL RIGHTS TO USE THIS DOCUMENT ARE SUBJECT TO PAYMENT IN FULL OF ALL GRIMSHAW CHARGES. THIS DOCUMENT MAY ONLY BE USED FOR THE EXPRESS PURPOSE AND PROJECT FOR WHICH IT HAS BEEN CREATED AND DELIVERED. AS NOTIFIED IN WRITING BY GRIMSHAW. AND THIS DOCUMENT MAY NOT BE OTHERWISE USED, OR COPIED, ANY UNAUTHORIZED USE OF THIS DOCUMENT IS AT THE USER'S SOLE RISK AND WITHOUT LIMITING GRIMSHAW RIGHTS THE USER RELEASES AND INDEMNIFIES GRIMSHAW FROM AND AGAINST ALL LOSS (SO ASBESTOS)

REV. DATE FOR
01 MAY 2017 STAGE 1 SSDA



HEAD DESIGN CONSULTANT
GRIMSHAW

GRIMSHAW
LEVEL 3, 24 RICKSON ROAD, SYDNEY
NEW SOUTH WALES 2000 AUSTRALIA
TELEPHONE +61 2 9438 1000
WWW.GRIMSHAW.CO.AU

NORTH TOWER PRINCIPAL

JPW
JOHNSON PILTON WALKER

JOHNSON PILTON WALKER PTY LTD ACN 005 776 885
LEVEL 10 PLAZA BUILDING AUSTRALIA SQUARE
10 RITT STREET SYDNEY
NEW SOUTH WALES 2000 AUSTRALIA
TELEPHONE +61 2 9358 3800
FACSIMILE +61 2 9358 3800
EMAIL JPW@JPW.COM.AU

HEAD ENGINEERING CONSULTANT

ARUP

ARUP
10/101 KENT STREET SYDNEY 2000
TEL +61 2 9530 9320
EMAIL SYDNEY@ARUP.COM

PROJECT

**SYDNEY METRO MARTIN PLACE STATION
MACQUARIE'S UNSOLICITED PROPOSAL**

CLIENT

MACQUARIE GROUP LTD

NORTH

SCALE
1:500 @ A1

DO NOT SCALE FROM DRAWING. USE MARKED DIMENSIONS TO BE READ IN CONJUNCTION WITH ALL OTHER CONSULTANT'S DRAWINGS.

STATUS
STAGE 1 SSDA


DRAWING

**NORTH ELEVATION (MARTIN PLACE)
ENVELOPE DRAWINGS**

DRAWN CHECKED AUTHORISED
KY MC AC

DRAWING NUMBER
MPS_COA_000_XX_DR_A_DA1012_01

REVISION

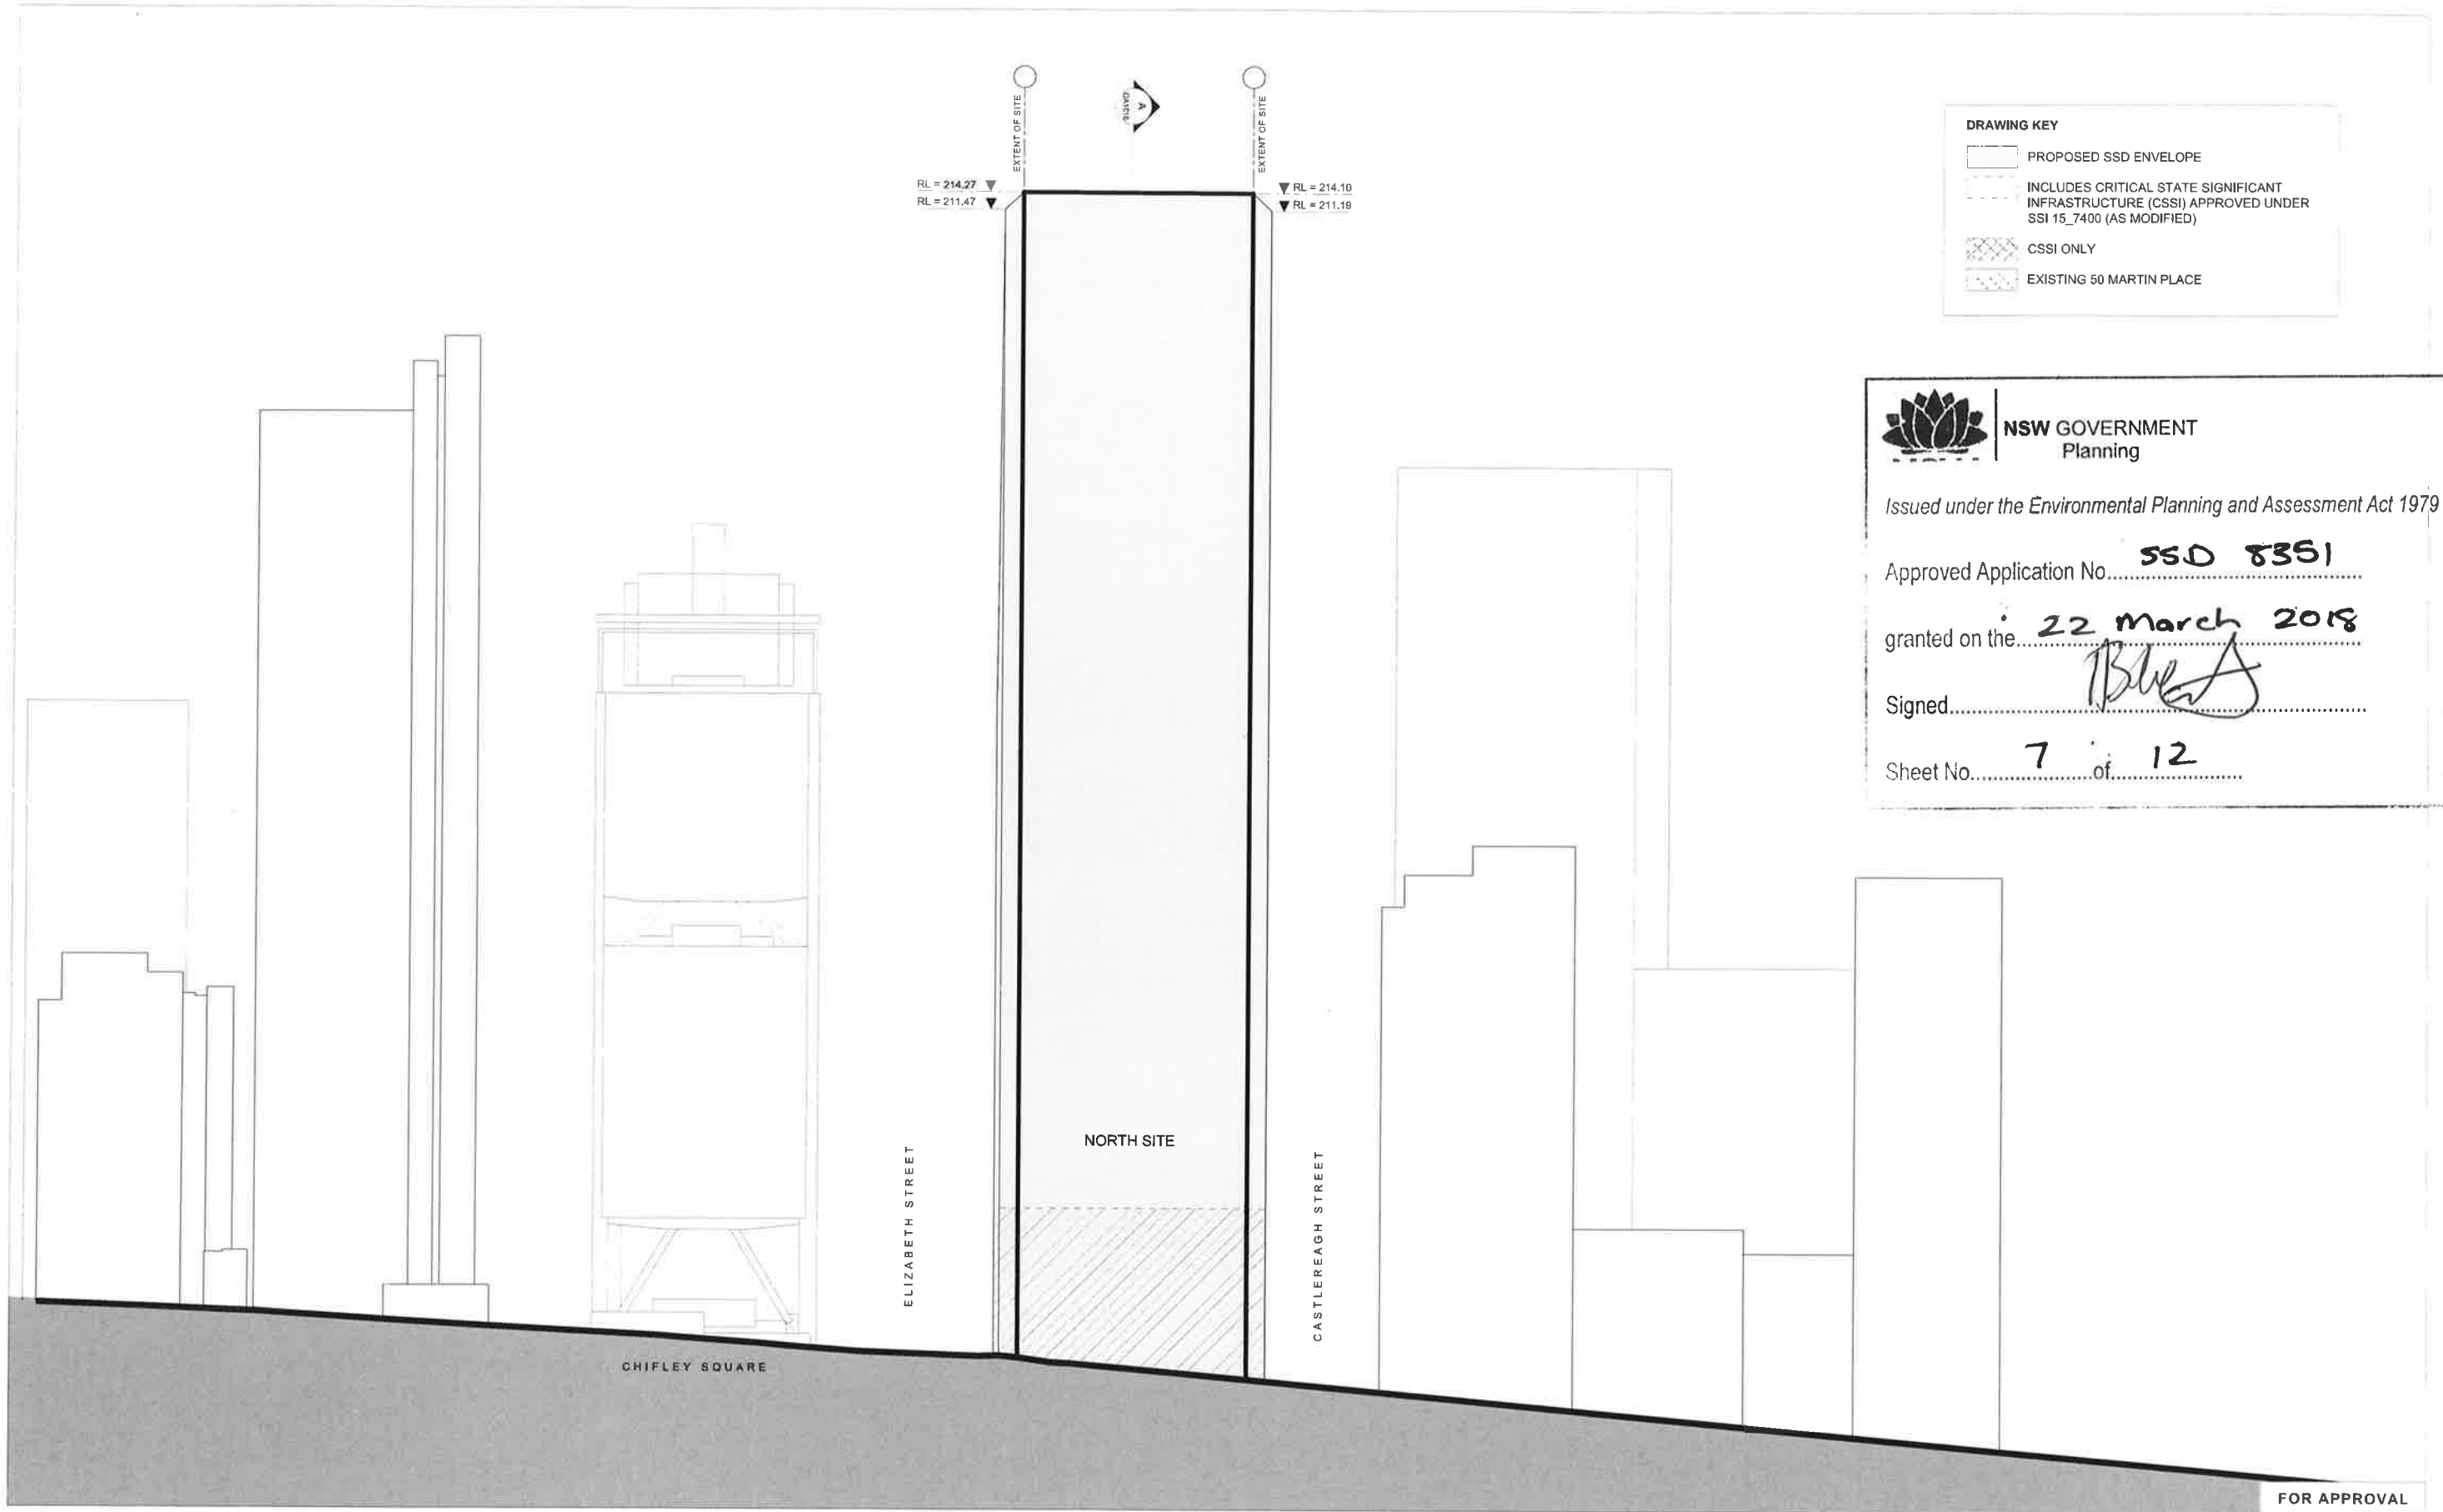

DRAWING KEY

- PROPOSED SSD ENVELOPE
- INCLUDES CRITICAL STATE SIGNIFICANT INFRASTRUCTURE (CSSI) APPROVED UNDER SSI 15_7400 (AS MODIFIED)
- CSSI ONLY
- EXISTING 50 MARTIN PLACE

NSW GOVERNMENT
Planning

Issued under the Environmental Planning and Assessment Act 1979

Approved Application No. **SSD 8351**

granted on the **22 March 2018**

Signed **Blue A**

Sheet No. **7** of **12**

FOR APPROVAL

REV. DATE FOR
01 MAY 2017 STAGE 1 SSDA

HEAD DESIGN CONSULTANT
GRIMSHAW

NORTH TOWER PRINCIPAL
JPW
JOHNSON PILTON WALKER

HEAD ENGINEERING CONSULTANT
ARUP

PROJECT
SYDNEY METRO MARTIN PLACE STATION
MACQUARIE'S UNSOLICITED PROPOSAL

CLIENT
MACQUARIE GROUP LTD

DRAWING
NORTH ELEVATION (HUNTER STREET)
ENVELOPE DRAWINGS

SCALE
1:500 @ A1

STATUS
STAGE 1 SSDA

DRAWN
KY

CHECKED
MC


AUTHORISED
AC

DRAWING NUMBER
MPS_COA_000_XX_DR_A_DA1013_01

REVISION

DRAWING KEY

- PROPOSED SSD ENVELOPE
- INCLUDES CRITICAL STATE SIGNIFICANT INFRASTRUCTURE (CSSI) APPROVED UNDER SSI 15_7400 (AS MODIFIED)
- CSSI ONLY
- EXISTING 50 MARTIN PLACE

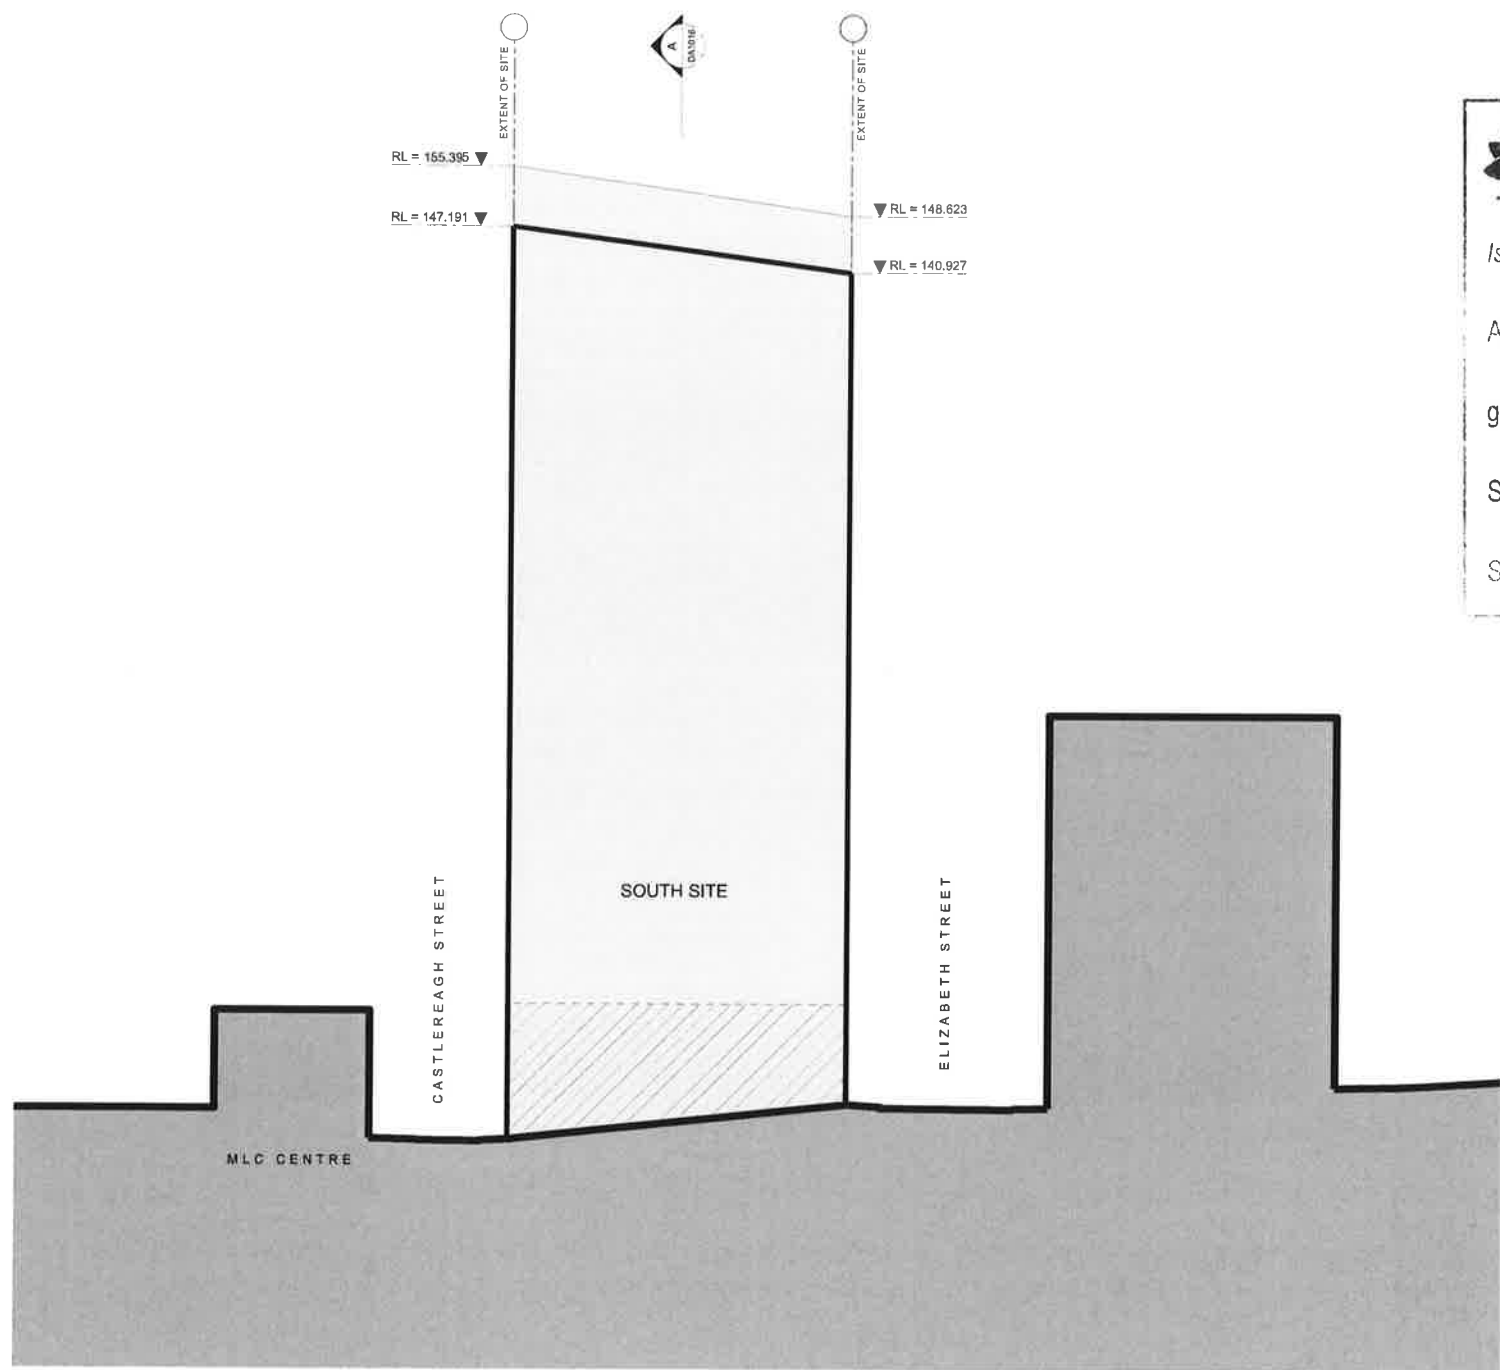

NSW GOVERNMENT Planning

Issued under the Environmental Planning and Assessment Act 1979

Approved Application No. **SSD 8351**

granted on the **22 March 2018**


Signed *[Signature]*

Sheet No. **8** of **12**

FOR APPROVAL

© COPYRIGHT GRIMSHAW ARCHITECTS PTY LIMITED. ALL RIGHTS RESERVED. THIS DOCUMENT IS SUBJECT TO PAYMENT IN FULL OF ALL GRIMSHAW CHARGES. THIS DOCUMENT MAY ONLY BE USED FOR THE EXPRESS PURPOSE AND PROJECT FOR WHICH IT HAS BEEN CREATED AND DELIVERED. ANY UNAUTHORIZED USE OF THIS DOCUMENT IS AT THE USER'S SOLE RISK AND WITHOUT LIMITING GRIMSHAW'S RIGHTS, THE USER RELEASES AND INDEMNIFIES GRIMSHAW FROM AND AGAINST ALL LOSS, SO, ANDING.

REV.	DATE	FOR
01	MAY 2017	STAGE 1 SSDA

 

HEAD DESIGN CONSULTANT
GRIMSHAW

GRIMSHAW
LEVEL 3, 24 HICKSON ROAD, SYDNEY
NEW SOUTH WALES 2000 AUSTRALIA
TELEPHONE +61 2 9433 6000
WWW.GRIMSHAW.COM.AU

NORTH TOWER PRINCIPAL
JPW JOHNSON PILTON WALKER

JOHNSON PILTON WALKER PTY LTD ACN 955 778 866
LEVEL 10 PLAZA BUILDING AUSTRALIA SQUARE
94 PITT STREET SYDNEY
NEW SOUTH WALES 2000 AUSTRALIA
TELEPHONE +61 2 9239 5900
FACSIMILE +61 2 9239 5900
EMAIL JPW@JPW.COM.AU

HEAD ENGINEERING CONSULTANT
ARUP

ARUP
801 HENRY STREET, SYDNEY 2000
TEL +61 2 9555 1300
EMAIL SYDNEY@ARUP.COM

PROJECT
**SYDNEY METRO MARTIN PLACE STATION
MACQUARIE'S UNSOLICITED PROPOSAL**

CLIENT
MACQUARIE GROUP LTD

NORTH

SCALE
1:500 @ A1

DO NOT SCALE FROM DRAWING. USE MARKED DIMENSIONS TO BE READ IN CONJUNCTION WITH ALL OTHER CONSULTANT'S DRAWINGS.

STATUS
STAGE 1 SSDA

DRAWING
**SOUTH ELEVATION (SOUTH SITE)
ENVELOPE DRAWINGS**

DRAWN CHECKED AUTHORISED
KY MC AC

DRAWING NUMBER
MPS_COA_000_XX_DR_A_DA1014_01

REVISION



NSW GOVERNMENT
Planning


Issued under the Environmental Planning and Assessment Act 1979

Approved Application No. **SSD 8361**

granted on the **22 March 2018**

Signed

Sheet No. **9** of **12**

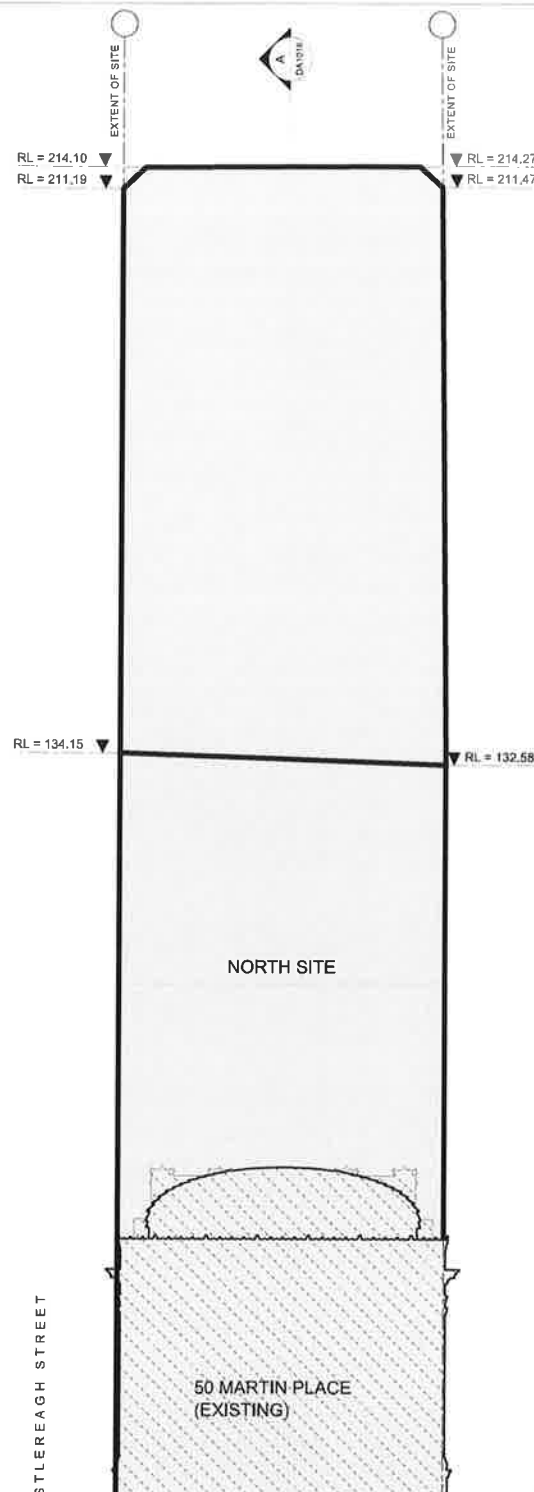


DRAWING KEY	
	PROPOSED SSD ENVELOPE
	INCLUDES CRITICAL STATE SIGNIFICANT INFRASTRUCTURE (CSSI) APPROVED UNDER SSI 15_7400 (AS MODIFIED)
	CSSI ONLY
	EXISTING 50 MARTIN PLACE

FOR APPROVAL

© COPYRIGHT GRIMSHAW ARCHITECTS PTY LIMITED. UNLESS OTHERWISE AGREED IN WRITING, ALL RIGHTS TO USE THIS DOCUMENT ARE SUBJECT TO PAYMENT IN FULL OF ALL GRIMSHAW CHARGES. THIS DOCUMENT MAY ONLY BE USED FOR THE EXPRESS PURPOSE AND PROJECT FOR WHICH IT HAS BEEN CREATED AND DELIVERED, AS NOTIFIED IN WRITING BY GRIMSHAW. AND THIS DOCUMENT MAY NOT BE OTHERWISE USED, OR COPIED, ANY UNAUTHORIZED USE OF THIS DOCUMENT IS AT THE USER'S SOLE RISK AND WITHOUT LIMITING GRIMSHAW'S RIGHTS TO THE USER RELEASES AND INDEMNIFIES GRIMSHAW FROM AND AGAINST ALL LOSS TO AVOID.

REV.	DATE	FOR
01	MAY 2017	STAGE 1 SSDA

 

HEAD DESIGN CONSULTANT
GRIMSHAW

GRIMSHAW
LEVEL 3/24 HICKSON ROAD, SYDNEY
NEW SOUTH WALES 2000 AUSTRALIA
TELEPHONE: +61 2 8233 8200
WWW.GRIMSHAW.CO.AU

NORTH TOWER PRINCIPAL
**JPW
JOHNSON PILTON WALKER**

JOHNSON PILTON WALKER PTY LTD ACN 085 778 866
LEVEL 10 PLAZA BUILDING AUSTRALIA SQUARE
88 PITT STREET SYDNEY
NEW SOUTH WALES 2000 AUSTRALIA
TELEPHONE: +61 2 9553 5800
FACSIMILE: +61 2 9553 5889
EMAIL: JPW@JPW.COM.AU

HEAD ENGINEERING CONSULTANT
ARUP

ARUP
10/100 WEST STREET, SYDNEY (NSW)
TEL: +61 2 8438 3000
EMAIL: SYDNEY@ARUP.COM

PROJECT
**SYDNEY METRO MARTIN PLACE STATION
MACQUARIE'S UNSOLICITED PROPOSAL**

CLIENT
MACQUARIE GROUP LTD

NORTH

SCALE
1:500 @ A1

DO NOT SCALE FROM DRAWING. USE MARKED DIMENSIONS TO BE READ IN CONJUNCTION WITH ALL OTHER CONSULTANT DRAWINGS.


STATUS
STAGE 1 SSDA

DRAWING
SOUTH ELEVATION (MARTIN PLACE)
ENVELOPE DRAWINGS

DRAWN	CHECKED	AUTHORIZED
KY	MC	AC

DRAWING NUMBER
MPS_COA_000_XX_DR_A_DA1015_01

REVISION

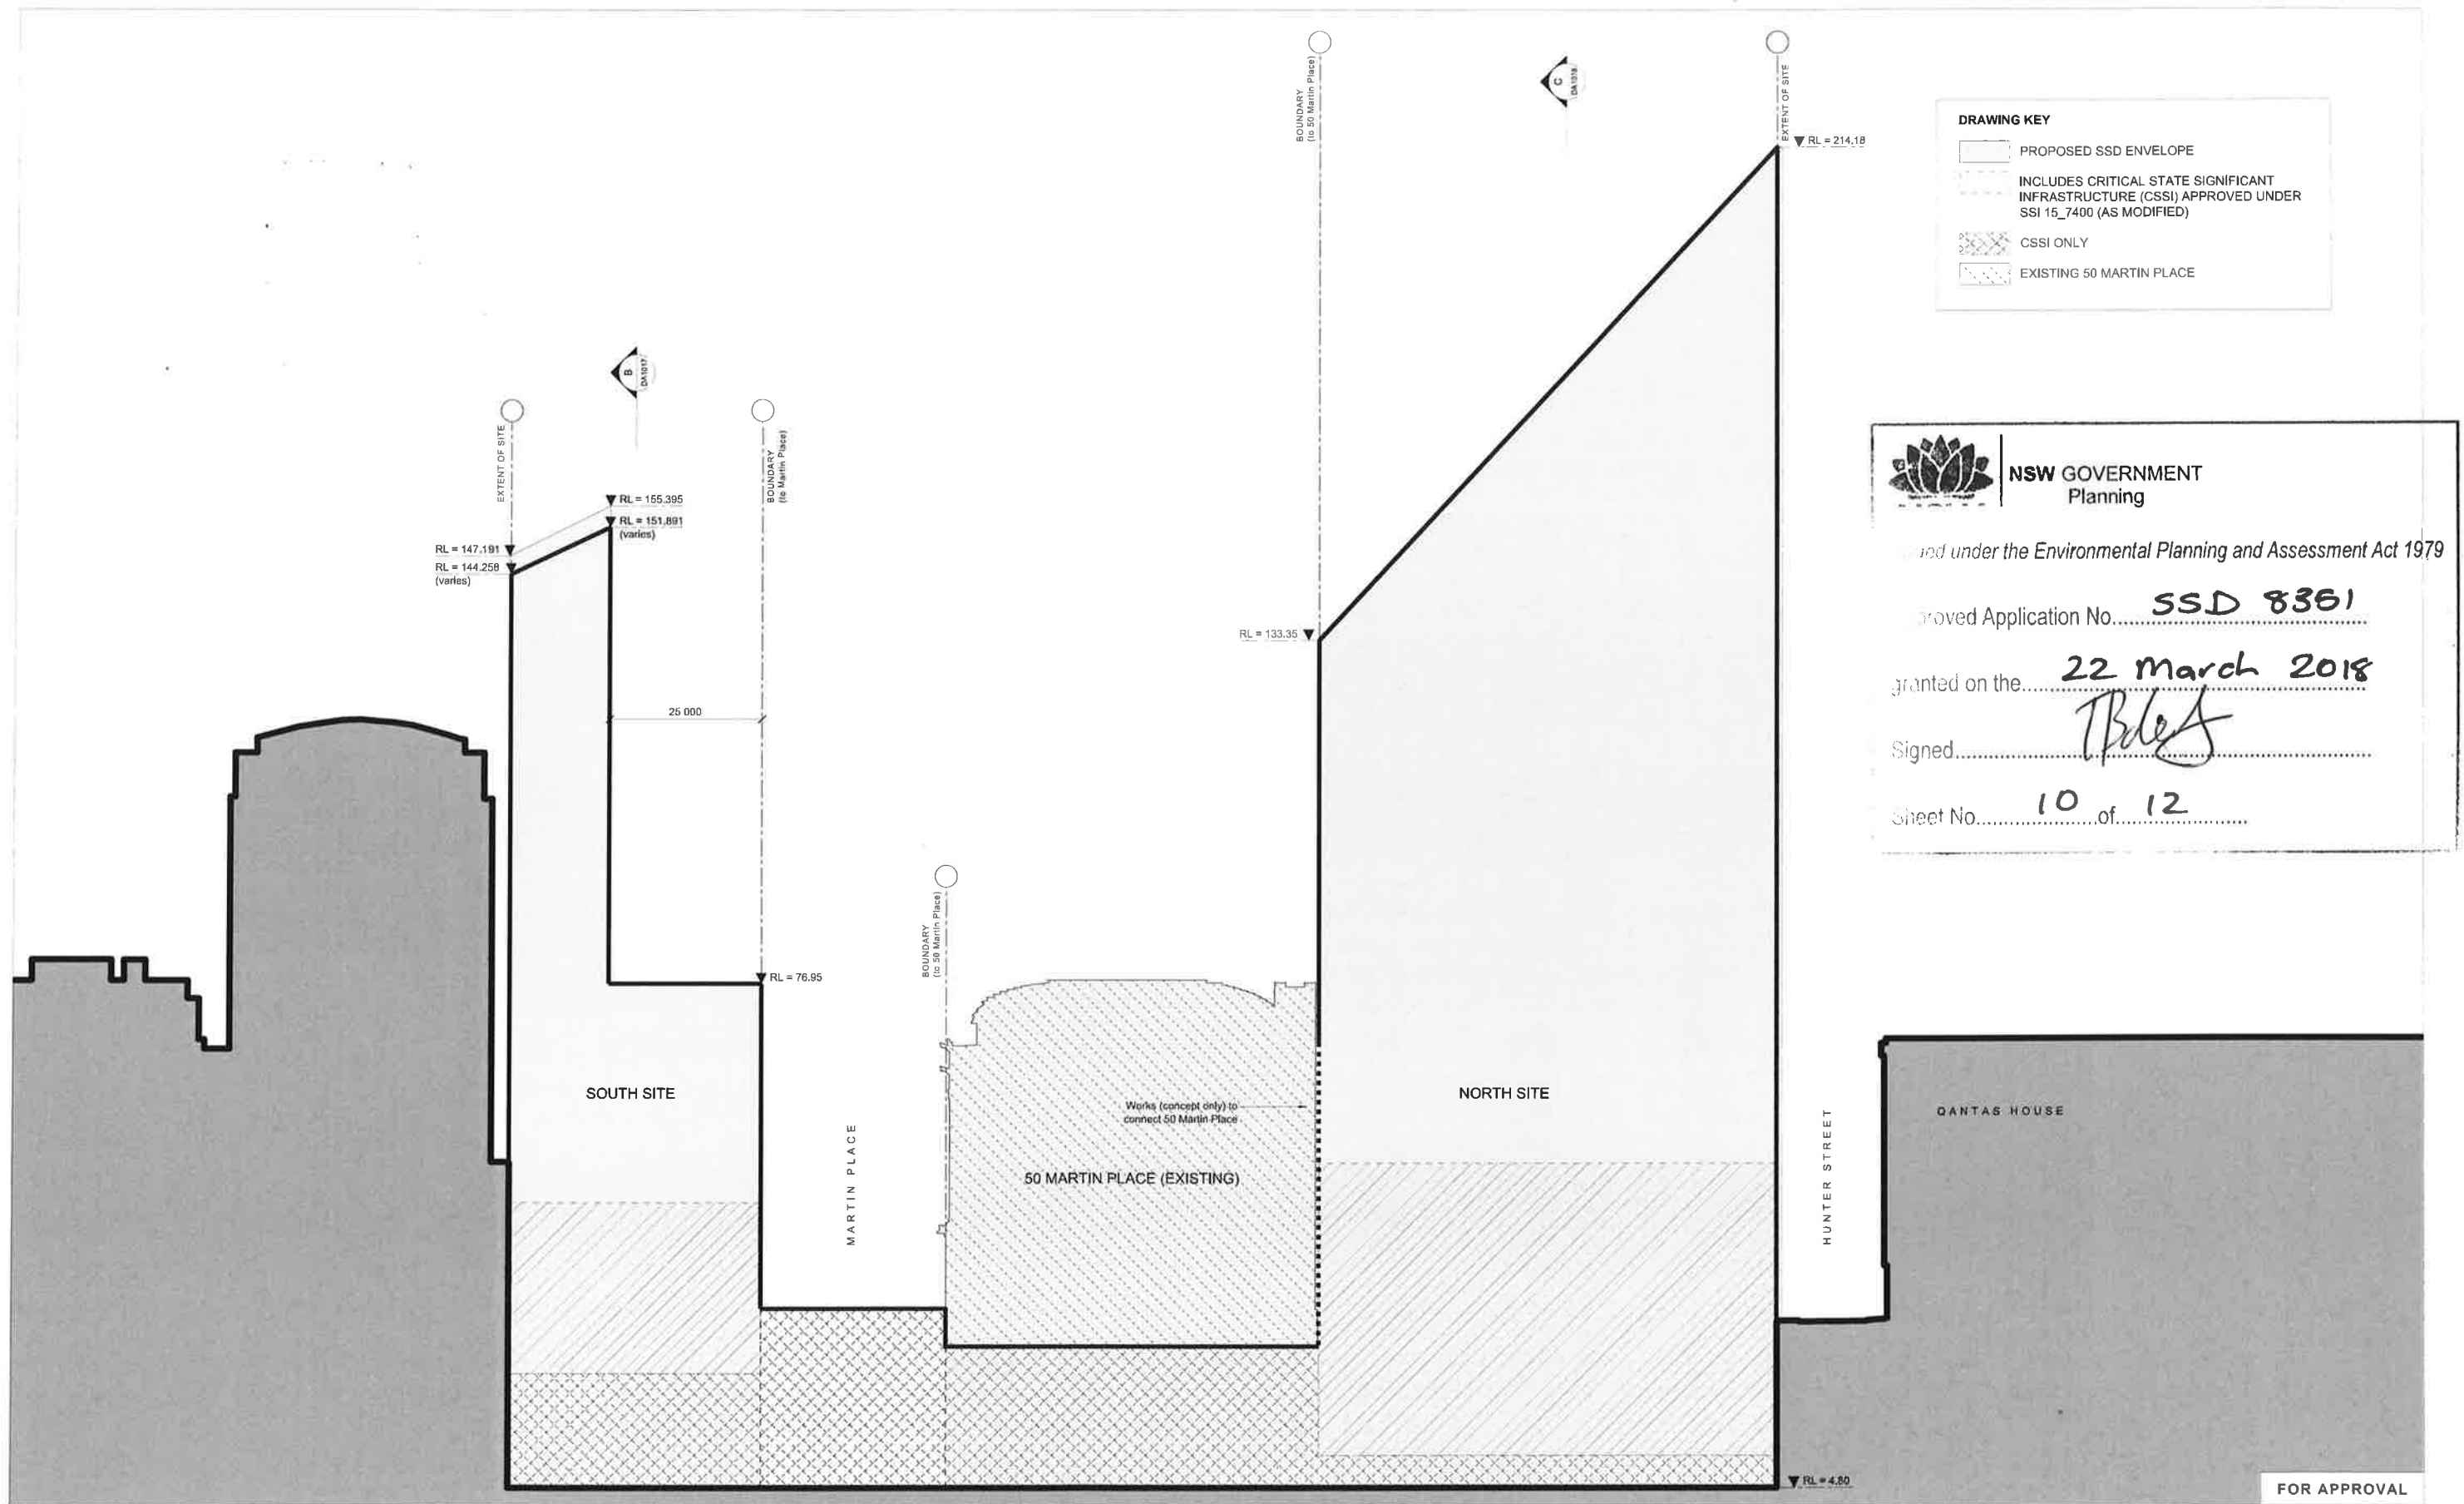

DRAWING KEY

- PROPOSED SSD ENVELOPE
- INCLUDES CRITICAL STATE SIGNIFICANT INFRASTRUCTURE (CSSI) APPROVED UNDER SSI 15_7400 (AS MODIFIED)
- CSSI ONLY
- EXISTING 50 MARTIN PLACE

NSW GOVERNMENT Planning

and under the Environmental Planning and Assessment Act 1979

Approved Application No. **SSD 8361**

granted on the **22 March 2018**

Signed **[Signature]**

Sheet No. **10** of **12**

©COPYRIGHT GRIMSHAW ARCHITECTS PTY LIMITED. UNLESS OTHERWISE AGREED IN WRITING, ALL RIGHTS TO USE THIS DOCUMENT ARE SUBJECT TO PAYMENT IN FULL OF ALL GRIMSHAW CHARGES. THIS DOCUMENT MAY ONLY BE USED FOR THE EXPRESS PURPOSE AND PROJECT FOR WHICH IT HAS BEEN CREATED AND DELIVERED. AS NOTIFIED IN WRITING BY GRIMSHAW. AND THIS DOCUMENT MAY NOT BE OTHERWISE USED, OR COPIED, OR REPRODUCED, OR ANY PART THEREOF, WITHOUT THE WRITTEN PERMISSION OF GRIMSHAW ARCHITECTS PTY LIMITED. GRIMSHAW ARCHITECTS PTY LIMITED ACCEPTS NO LIABILITY FOR ANY LOSS OR DAMAGE, INCLUDING BUT NOT LIMITED TO, LOSS OF PROFITS, ARISING FROM THE USE OF THIS DOCUMENT.	<table><tr><th>REV.</th><th>DATE</th><th>FOR</th></tr><tr><td>01</td><td>MAY 2017</td><td>STAGE 1 SSDA</td></tr></table>	REV.	DATE	FOR	01	MAY 2017	STAGE 1 SSDA	HEAD DESIGN CONSULTANT GRIMSHAW GRIMSHAW LEVEL 3-24 HICKSON ROAD, SYDNEY NEW SOUTH WALES 2000 AUSTRALIA TELEPHONE +61 2 8453 0000 WWW.GRIMSHAW.CO.UK	NORTH TOWER PRINCIPAL JPW JOHNSON PILTON WALKER JOHNSON PILTON WALKER PTY LTD ACN 06 778 886 LEVEL 10 PLAZA BUILDING AUSTRALIA SQUARE 50 PITT STREET SYDNEY NEW SOUTH WALES 2000 AUSTRALIA TELEPHONE +61 2 9221 8888 FACSIMILE +61 2 9221 8889 EMAIL JPW@JPW.COM.AU	HEAD ENGINEERING CONSULTANT ARUP ARUP ROBERT HUNT STREET SYDNEY NSW 2000 TEL: +61 2 9249 9249 EMAIL: SYDNEY@ARUP.COM	PROJECT SYDNEY METRO MARTIN PLACE STATION MACQUARIE'S UNSOLICITED PROPOSAL CLIENT MACQUARIE GROUP LTD	NORTH SCALE 1:500 @ A1 DO NOT SCALE FROM DRAWING. USE MARKED DIMENSIONS TO BE READ IN CONJUNCTION WITH ALL OTHER CONSULTANT'S DRAWINGS. STATUS STAGE 1 SSDA	DRAWING SECTION A-A (N-S) ENVELOPE DRAWINGS <table><tr><th>DRAWN</th><th>CHECKED</th><th>AUTHORISED</th></tr><tr><td>KY</td><td>MC</td><td>AC</td></tr></table> DRAWING NUMBER MPS_COA_000_XX_DR_A_DA1016_01 REVISION	DRAWN	CHECKED	AUTHORISED	KY	MC	AC
REV.	DATE	FOR																	
01	MAY 2017	STAGE 1 SSDA																	
DRAWN	CHECKED	AUTHORISED																	
KY	MC	AC																	



NSW GOVERNMENT
Planning

Issued under the Environmental Planning and Assessment Act 1979

Approved Application No. **SSD 8351**


granted on the **22 March 2018**

Signed *[Signature]*

Sheet No. **11** of **12**

DRAWING KEY


- PROPOSED SSD ENVELOPE
- INCLUDES CRITICAL STATE SIGNIFICANT INFRASTRUCTURE (CSSI) APPROVED UNDER SSI 15_7400 (AS MODIFIED)
- CSSI ONLY
- EXISTING 50 MARTIN PLACE

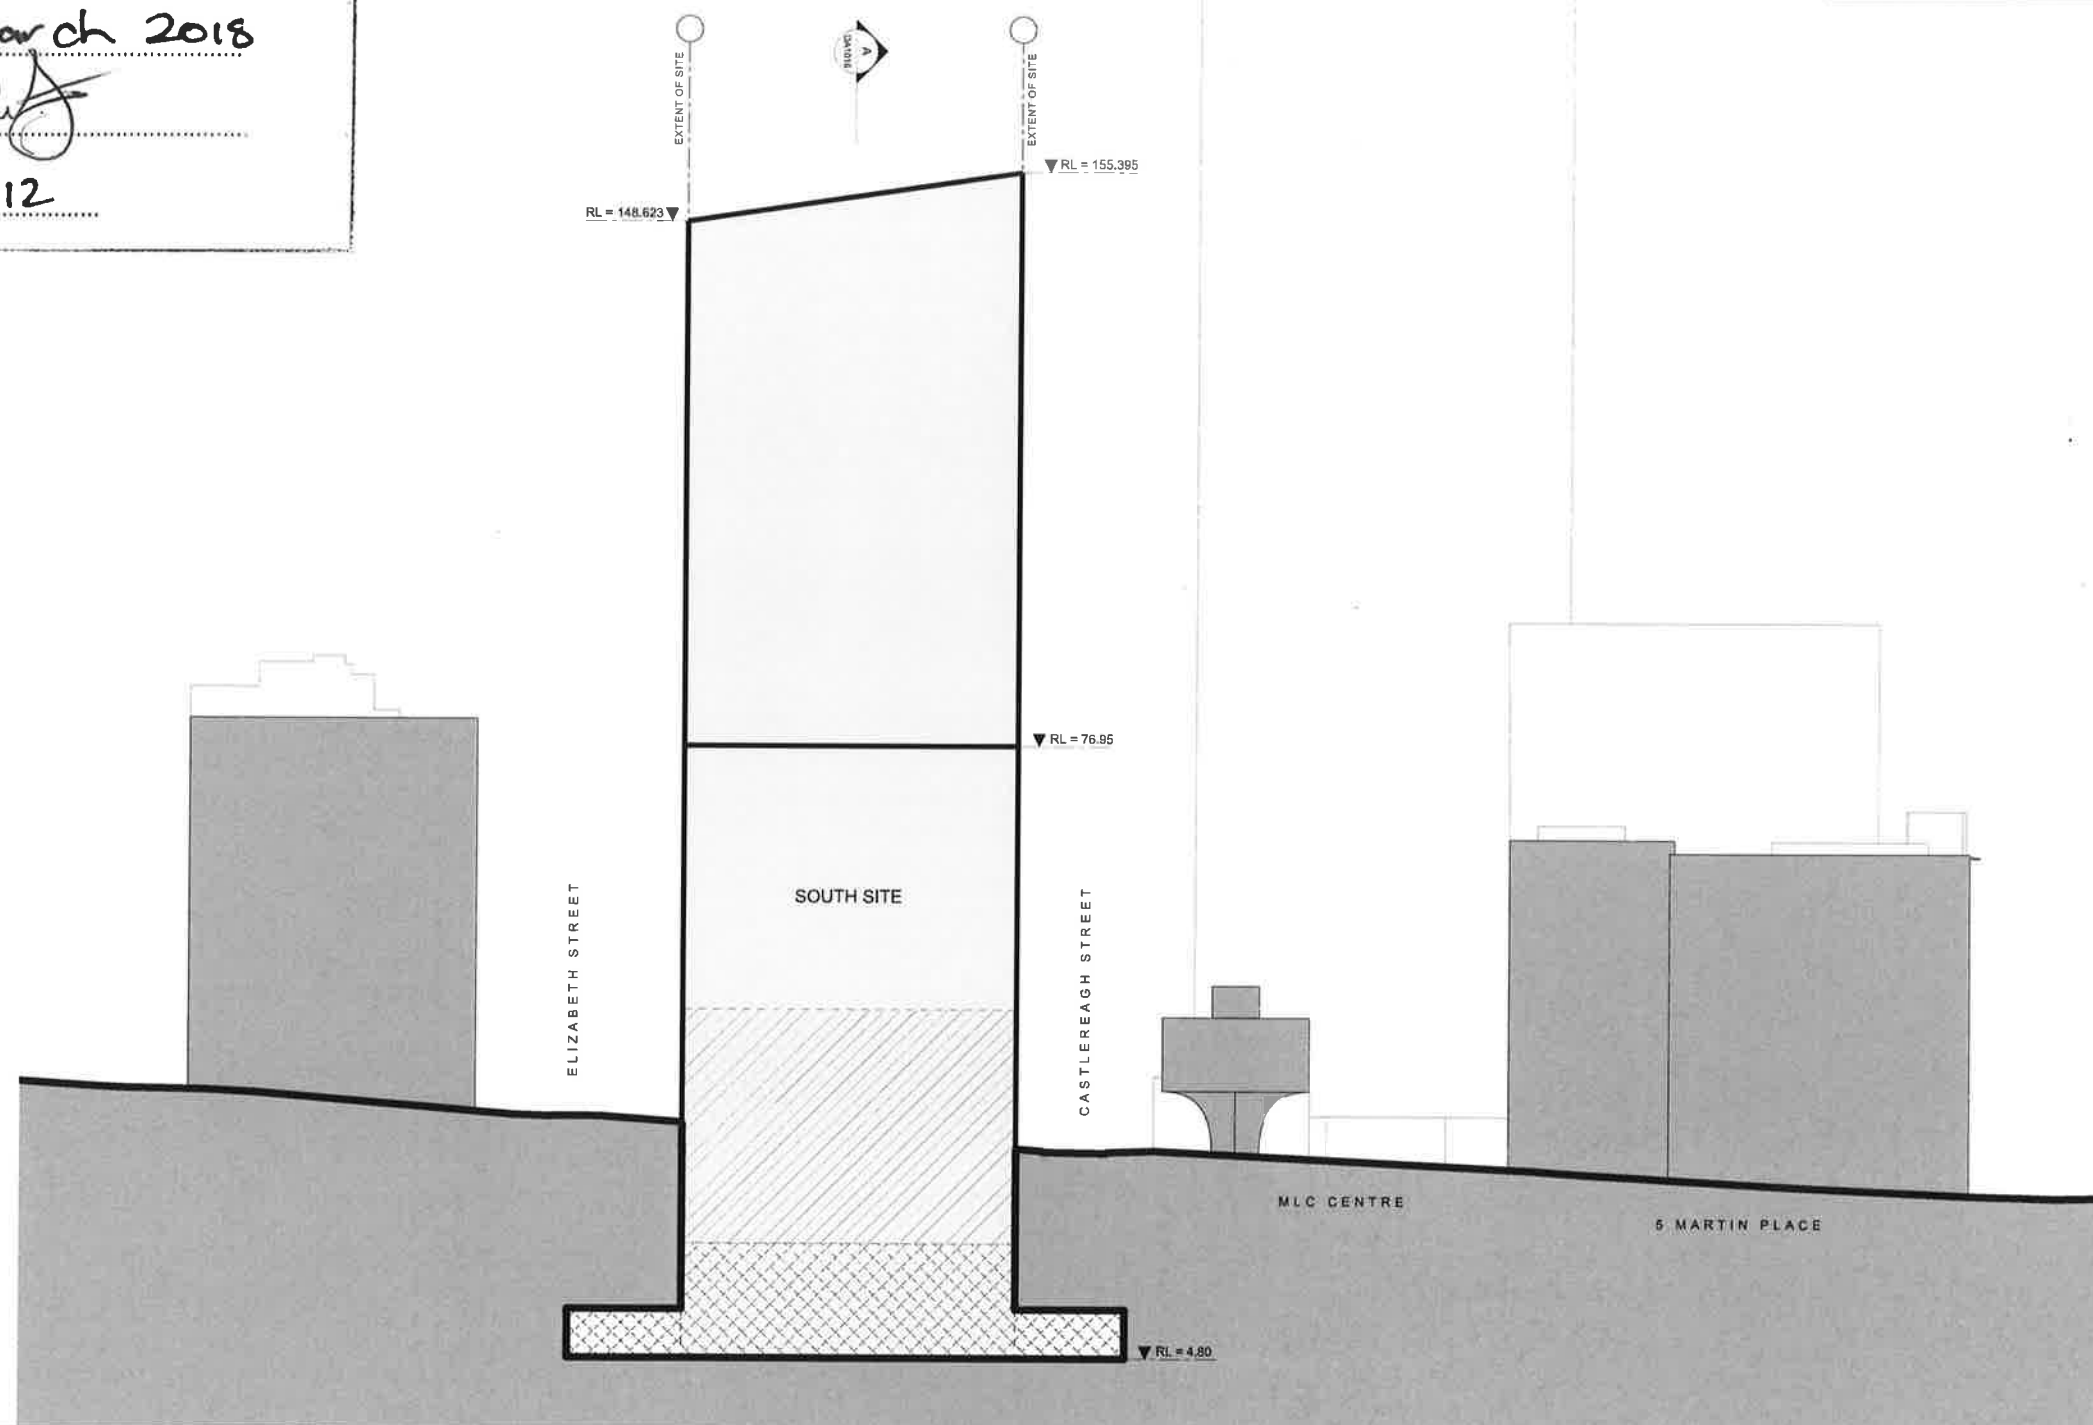

FOR APPROVAL

© COPYRIGHT GRIMSHAW ARCHITECTS PTY LIMITED. UNLESS OTHERWISE AGREED IN WRITING, ALL RIGHTS TO USE THIS DOCUMENT ARE SUBJECT TO PAYMENT IN FULL OF ALL GRIMSHAW CHARGES. THIS DOCUMENT MAY ONLY BE USED FOR THE EXPRESS PURPOSES AND PROJECT FOR WHICH IT HAS BEEN CREATED AND DELIVERED. AS NOTIFIED BY GRIMSHAW ARCHITECTS PTY LIMITED. THIS DOCUMENT MAY NOT BE REPRODUCED, COPIED, OR COMPILED, IN ANY MANNER, WITHOUT THE WRITTEN PERMISSION OF GRIMSHAW ARCHITECTS PTY LIMITED. GRIMSHAW ARCHITECTS PTY LIMITED ACCEPTS NO LIABILITY FOR ANY LOSS OR DAMAGE, INCLUDING BUT NOT LIMITED TO, LOSS OF PROFITS, DATA, OR OTHER INTANGIBLES, ARISING FROM THE USE OF THIS DOCUMENT.

REV.	DATE	FOR
01	MAY 2017	STAGE 1 SSDA

 

HEAD DESIGN CONSULTANT
GRIMSHAW

GRIMSHAW
LEVEL 3, 24 HICKSON ROAD, SYDNEY
NEW SOUTH WALES 2000 AUSTRALIA
TELEPHONE: +61 2 9253 0200
WWW.GRIMSHAW.COM.AU

NORTH TOWER PRINCIPAL
**JPW
JOHNSON PILTON WALKER**

JOHNSON PILTON WALKER PTY LTD ACN 085 776 885
LEVEL 19 PLAZA BUILDING AUSTRALIA SQUARE
80 PITT STREET SYDNEY
NEW SOUTH WALES 2000 AUSTRALIA
TELEPHONE: +61 2 9259 5506
FACSIMILE: +61 2 9259 5506
EMAIL: JPW@JPW.COM.AU

HEAD ENGINEERING CONSULTANT
ARUP

ARUP
10200 KENT STREET, SYDNEY 2000
TEL: +61 2 9595 6000
EMAIL: SYDNEY@ARUP.COM

PROJECT
**SYDNEY METRO MARTIN PLACE STATION
MACQUARIE'S UNSOLICITED PROPOSAL**

CLIENT
MACQUARIE GROUP LTD

NORTH

SCALE
1:500 @ A1

DO NOT SCALE FROM DRAWING. USE MARKED DIMENSIONS TO BE READ IN CONJUNCTION WITH ALL OTHER CONSULTANT'S DRAWINGS.

STATUS
STAGE 1 SSDA

DRAWING
**SECTION B-B (E-W, SOUTH SITE)
ENVELOPE DRAWINGS**

DRAWN	CHECKED	AUTHORISED
KY	MC	AC

DRAWING NUMBER
MPS_COA_000_XX_DR_A_DA1017_01

REVISION

EXTENT OF SITE
RL = 181.94
RL = 179.69
EXTENT OF SITE

 
- DRAWING KEY**
- PROPOSED SSD ENVELOPE
 - INCLUDES CRITICAL STATE SIGNIFICANT INFRASTRUCTURE (CSSI) APPROVED UNDER SSI 15_7400 (AS MODIFIED)
 - CSSI ONLY
 - EXISTING 50 MARTIN PLACE

 **NSW GOVERNMENT**
Planning


Issued under the *Environmental Planning and Assessment Act 1979*

Approved Application No. SSD 8351

granted on the 22 March 2018

Signed 

Sheet No. 12 of 12

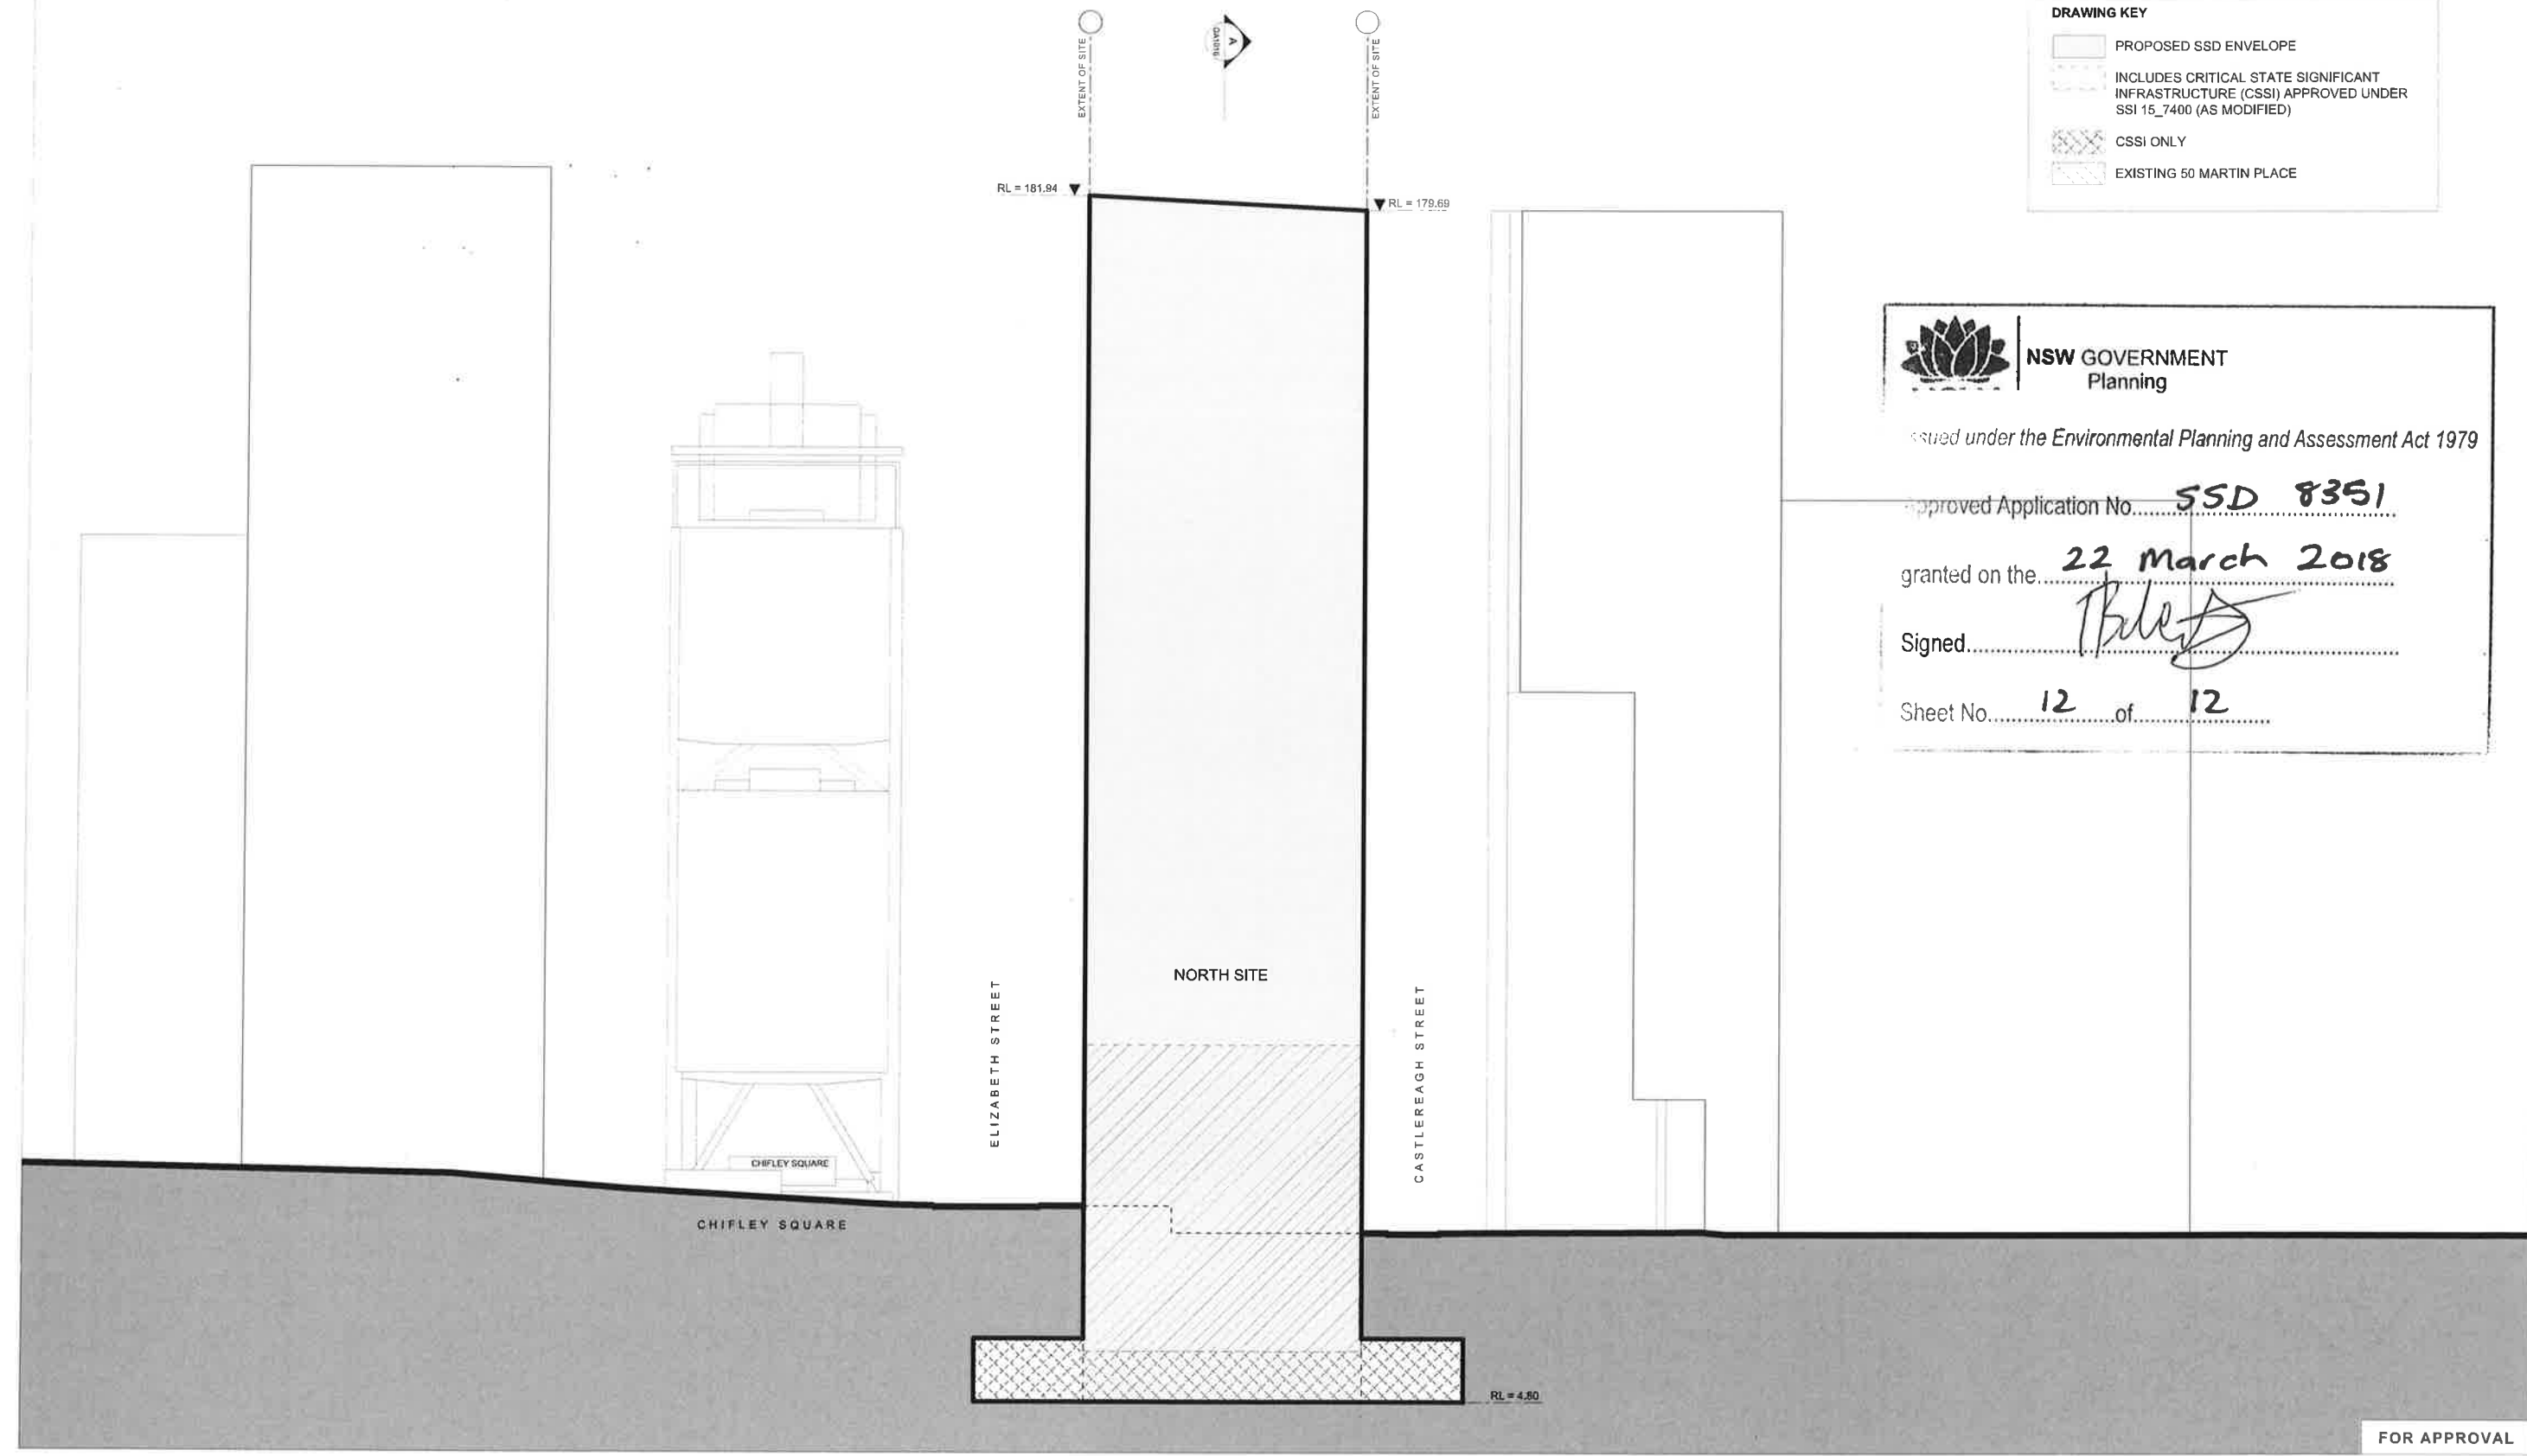

FOR APPROVAL