


NOTE: THE ENTIRE PLUMBING INSTALLATION IS TO COMPLY WITH THE FULL REQUIREMENTS OF THE LOCAL REGULATORY AUTHORITY, A.S.3500 AND THE PLUMBING AND THE BUILDING CODES OF AUSTRALIA.

LEGEND	
PIPELINES	
	EXISTING WATER SERVICE
	PROPOSED WATER SERVICE
	AUTHORITY WATER MAIN
	REDUNDANT PIPEWORK
SYMBOLS	
	WATER METER
	ISOLATION VALVE
	MAIN ISOLATION VALVE
	HOSE COCK

 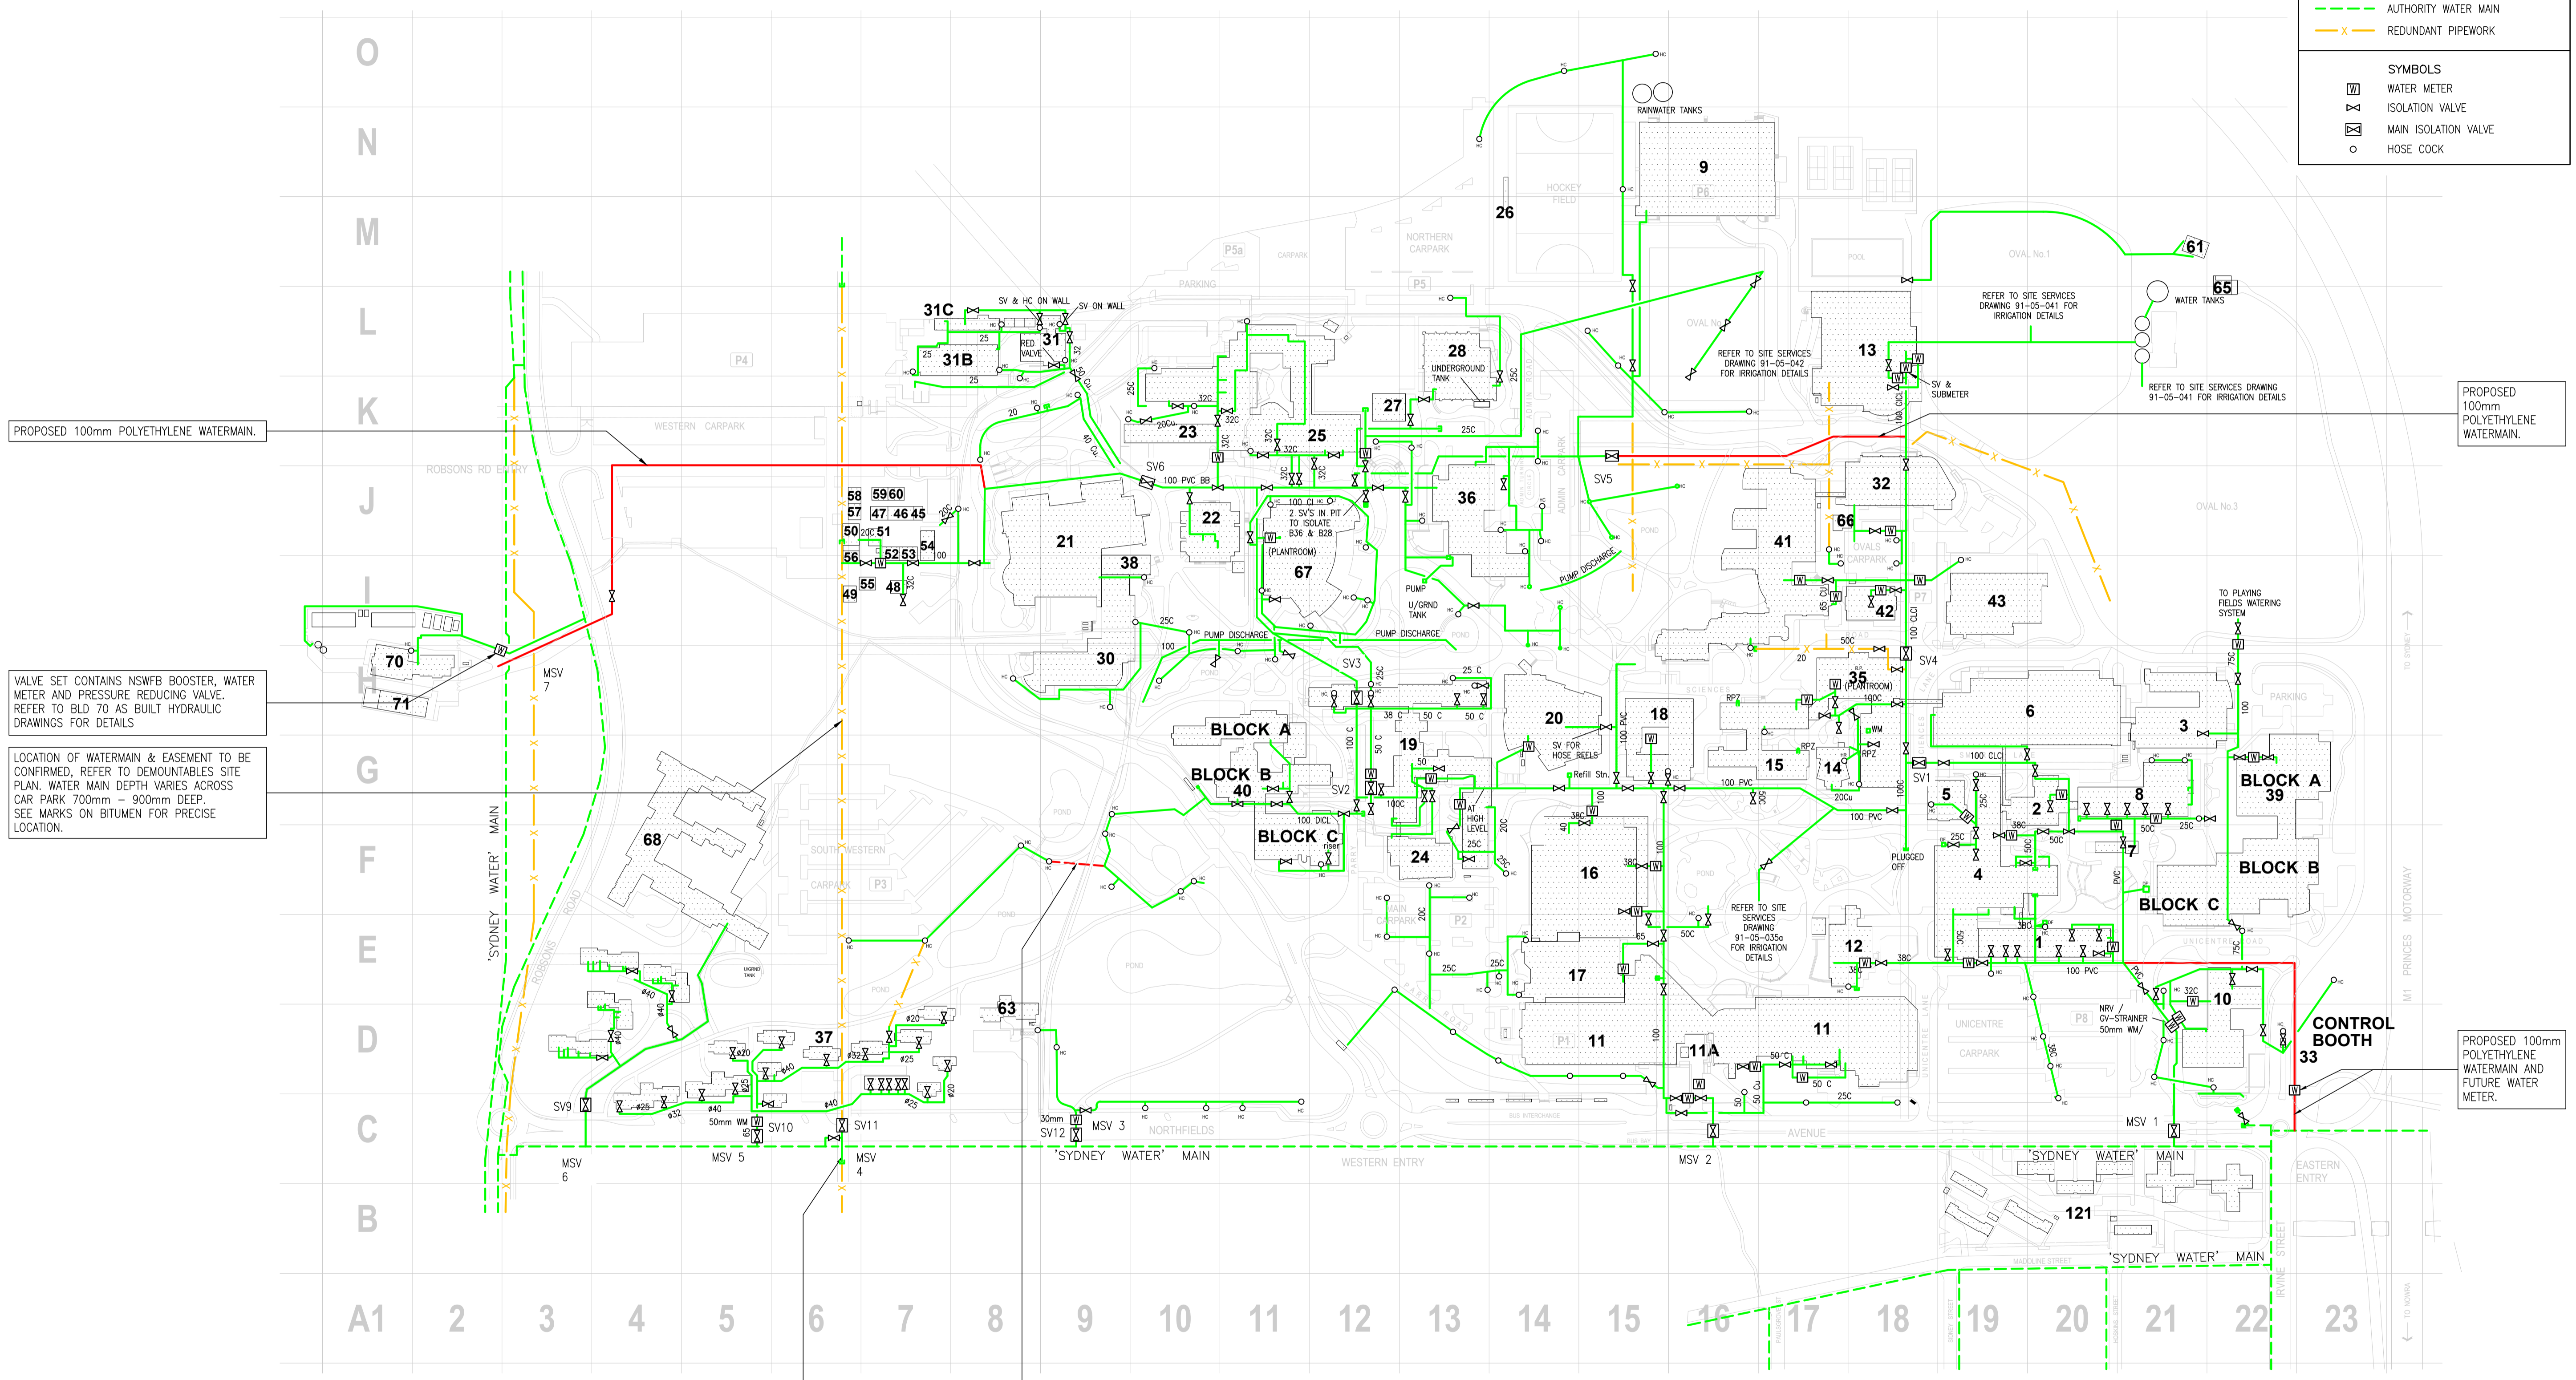


VALVE SET CONTAINS NSWFB BOOSTER, WATER METER AND PRESSURE REDUCING VALVE. REFER TO BLD 70 AS BUILT HYDRAULIC DRAWINGS FOR DETAILS

LOCATION OF WATERMAIN & EASEMENT TO BE CONFIRMED, REFER TO DEMOUNTABLES SITE PLAN. WATER MAIN DEPTH VARIES ACROSS CAR PARK 700mm - 900mm DEEP. SEE MARKS ON BITUMEN FOR PRECISE LOCATION.

PROPOSED 100mm POLYETHYLENE WATERMAIN.

PROPOSED 100mm POLYETHYLENE WATERMAIN AND FUTURE WATER METER.




GENERAL NOTES:

- THIS DRAWING IS FOR INFORMATION ONLY. DO NOT SCALE. USE PROVIDED DIMENSIONS ONLY. REFER TO ARCHITECTURAL DRAWINGS WHERE APPROPRIATE FOR EXACT LOCATION OF FIXTURES, FIXTURES AND THE LINE. THE DRAWING IS TO BE READ IN CONJUNCTION WITH ALL OTHER DOCUMENTS FORMING THE PROJECT DOCUMENTATION PACKAGE.
- CONFIRM ALL LEVELS AND DIMENSIONS AS ACCURATE ON SITE PRIOR TO INSTALLATION. REPORT ALL DISCREPANCIES TO THE SUPERINTENDENT IMMEDIATELY.
- THIS DRAWING HAS BEEN ISSUED IN CONFIDENCE AND REMAINS THE PROPERTY OF MCGILLUM PLUMBING & FIRE CONSULTANTS AUSTRALIA. DISTRIBUTION OR REPRODUCTION OF THE WHOLE OR PART OF THIS DRAWING WITHOUT THE EXPRESS PERMISSION OF MCGILLUM PLUMBING & FIRE CONSULTANTS AUSTRALIA IS A BREACH OF THE COMMONWEALTH COPYRIGHT ACT.

REV	DATE	PRELIMINARY	AMENDMENT
1	00/00/13	PRELIMINARY	

CEILING LEVEL ABOVE	FLOOR LEVEL NOTED IN TITLE	PIPEWORK LOCATION (U.N.G.)

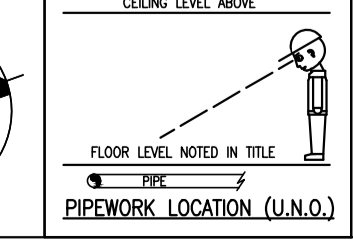

UNIVERSITY OF WOLLONGONG
BUILDINGS & GROUNDS DIVISION

MCGILLUM PFC
PLUMBING & FIRE CONSULTANTS AUSTRALIA
PO Box 96 Charlottes Pass NSW 2230
Email: mcgillum@pfc.com.au
5/35 Smith Street, Charlestown
408 088 124 422 408 088 124 422

ARCHITECT: UNIVERSITY OF WOLLONGONG
CLIENT: UNIVERSITY OF WOLLONGONG
PROJECT: PROPOSED MASTERPLAN UNIVERSITY OF WOLLONGONG, WOLLONGONG CAMPUS SITE PLAN - DOMESTIC WATER SERVICE

Drawn	Scale	Job No.	No. in Set
L.NOLAN	1:1250	2420-414D1-1	5
Design	Approved	DRG. No.	Revision
R.MCCALLUM	R.MCCALLUM	H-03	1

PRELIMINARY A3