
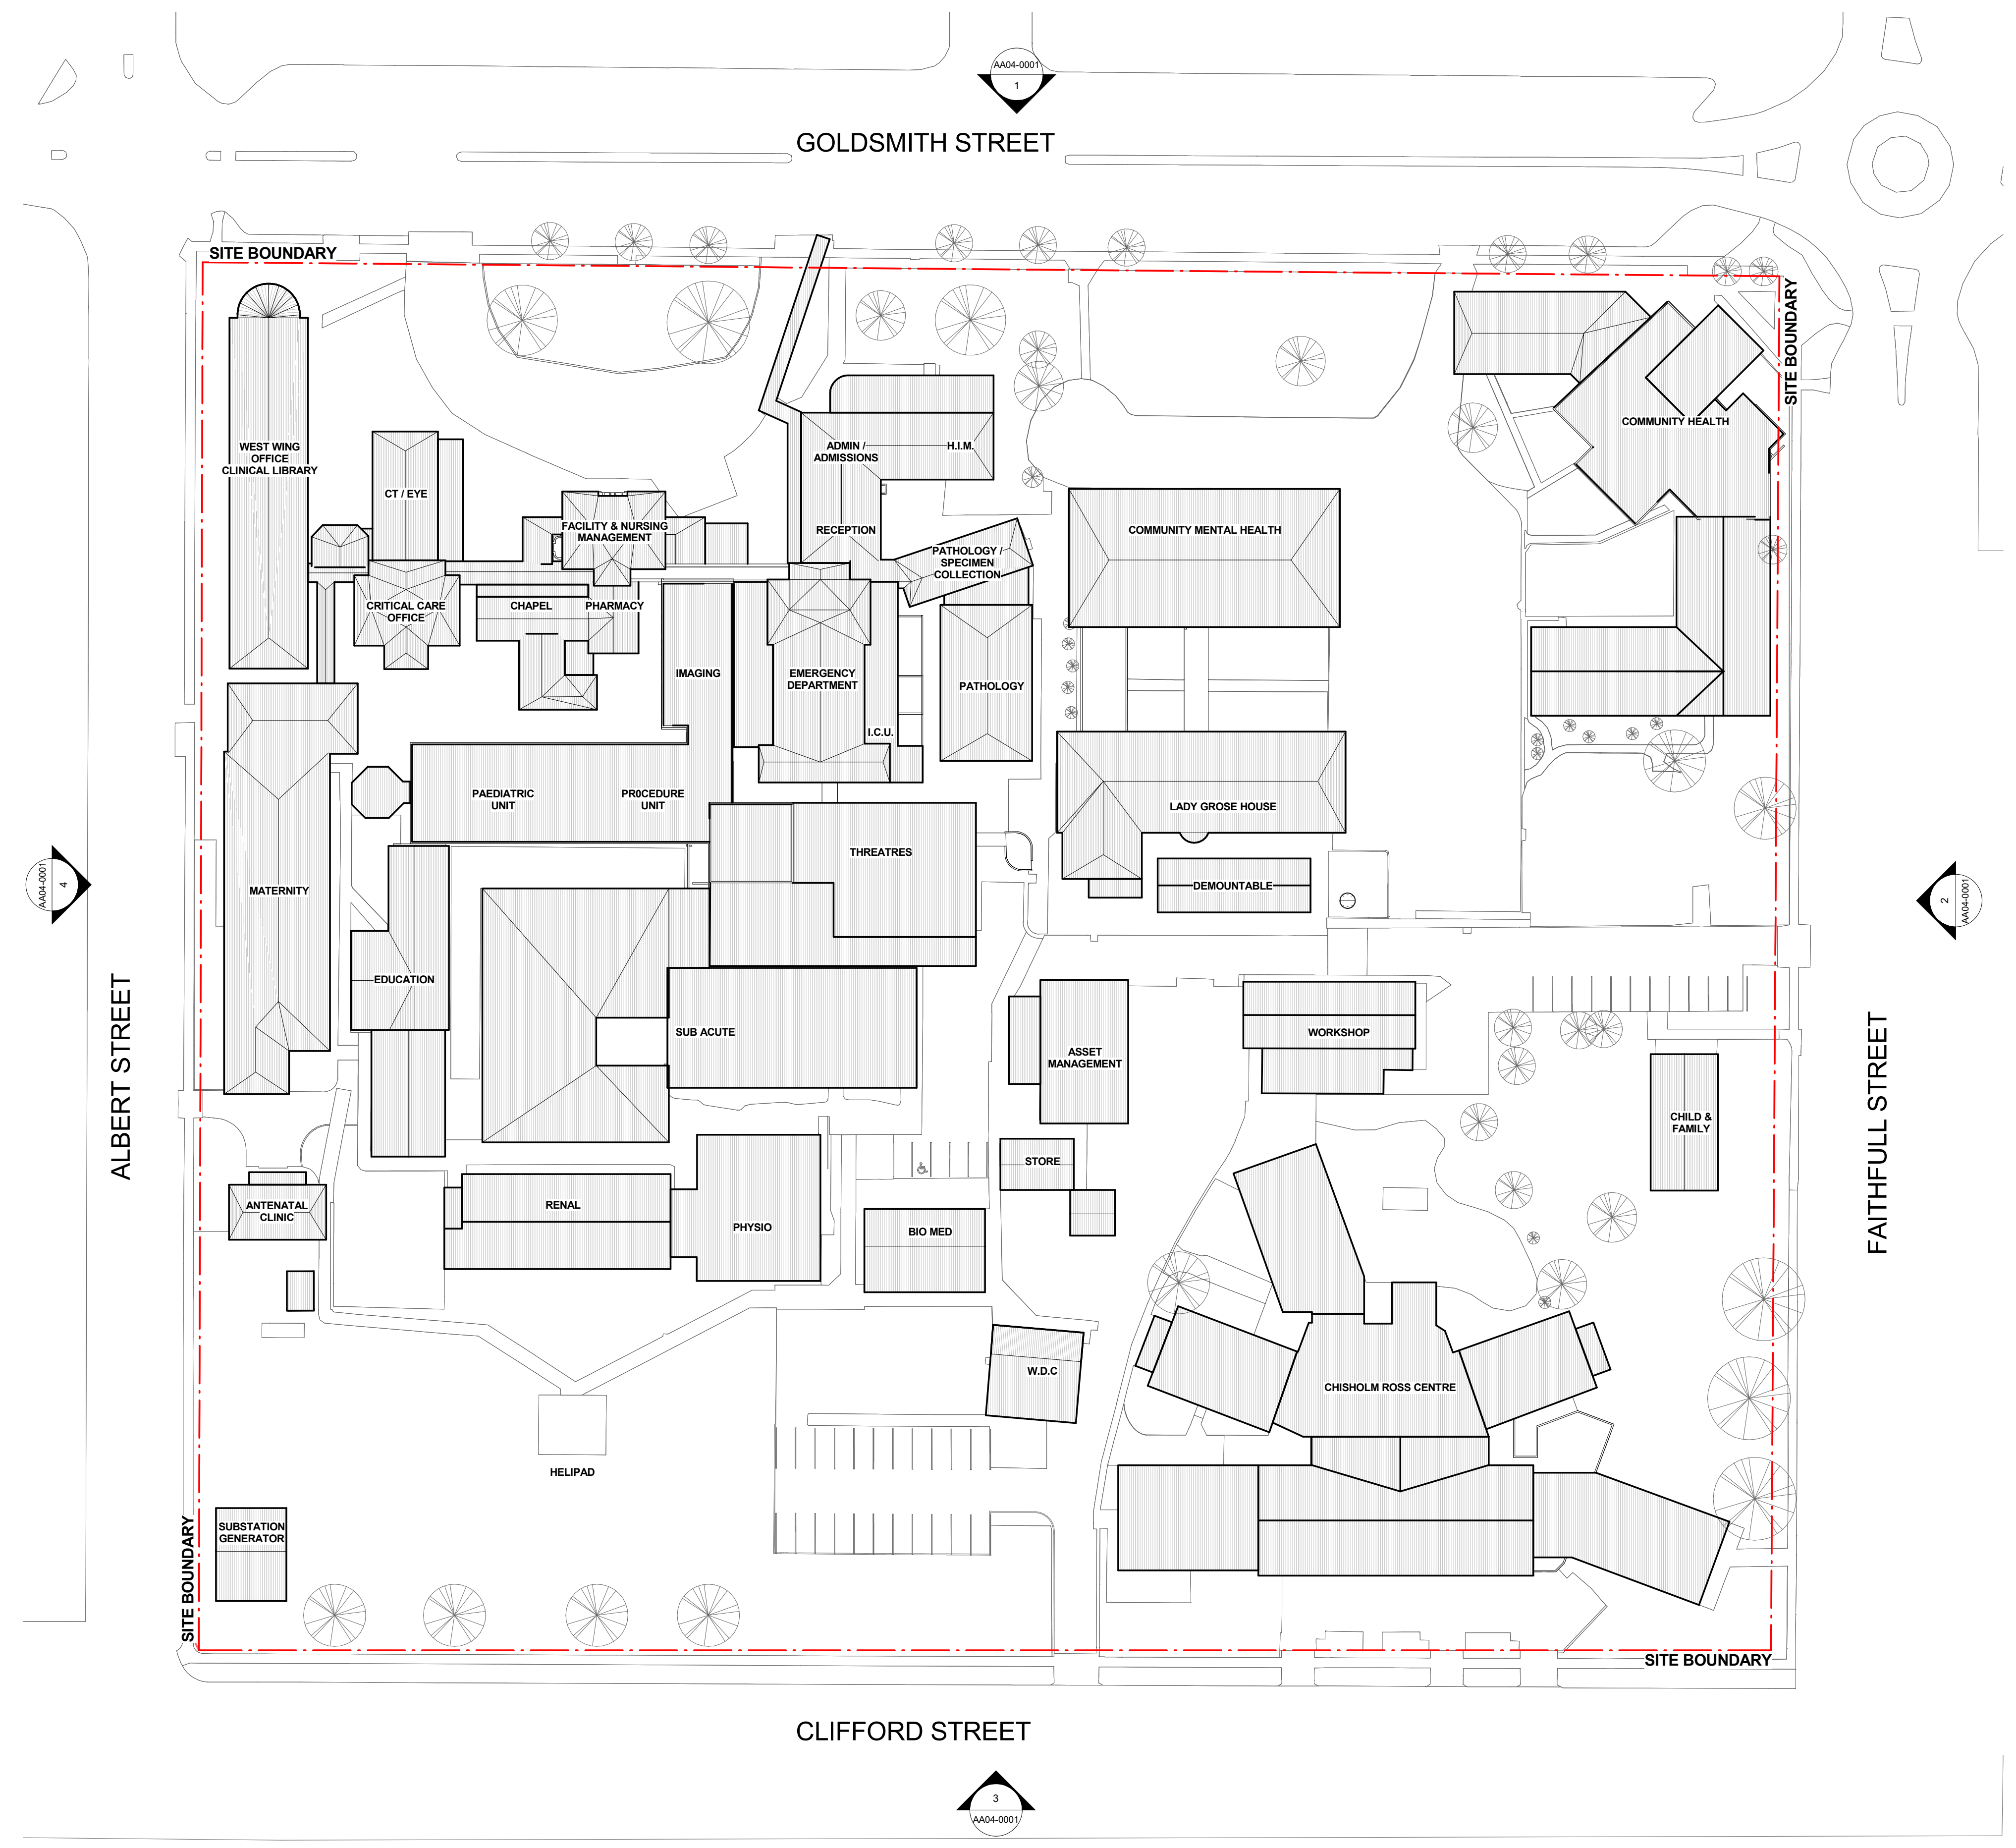


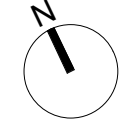


G	ISSUE FOR SSDA	25.09.17
F	ISSUE FOR REF	22.09.17
E	ISSUE FOR SEARS	28.07.17
D	FINAL SD ISSUE	21.07.17
C	FROZEN PLAN ISSUE	13.07.17
B	IC3	22.06.17
A	IC2	31.05.17
REV		
1	CLERK	

NSW Health Infrastructure
GOVERNMENT
14/77 Pacific Hwy,
North Sydney,
NSW 2060
T +61 2 9978 5402
www.himfra.health.nsw.gov.au/
PROJECT DIRECTOR
HEALTH INFRASTRUCTURE
PROJECT MANAGER
TSA MANAGEMENT
ARCHITECT
BILLARD LEECE PARTNERSHIP
STRUCTURAL ENGINEER
BONACCI GROUP
ELECTRICAL, ICT AND SECURITY SERVICES ENGINEER
WOOD AND GRIEVE ENGINEERS
HYDRAULICS & FIRE ENGINEERING
GHD
BUILDING SUPERVISOR
BM+G
MECHANICAL ENGINEER
TTW
CONSULTANT

BLP
Billard Leece Partnership Pty Ltd
Architects & Urban Planners
Studio 201, 50 Holt Street
Sunny Hills 2010
NSW Australia
T +61 2 8096 4066
E info@blp.com.au
www.blp.com.au

PROJECT
GOULBURN
HOSPITAL &
HOSPITAL SERVICES
REDEVELOPMENT
DESCRIPTION
SITE PLAN - EXISTING

Project No	15614
Scale	1:500@A1
Date	13/08/2017
Drawn By	LG
Checked By	LG
Drawing No	Revision
AA01-0001	G

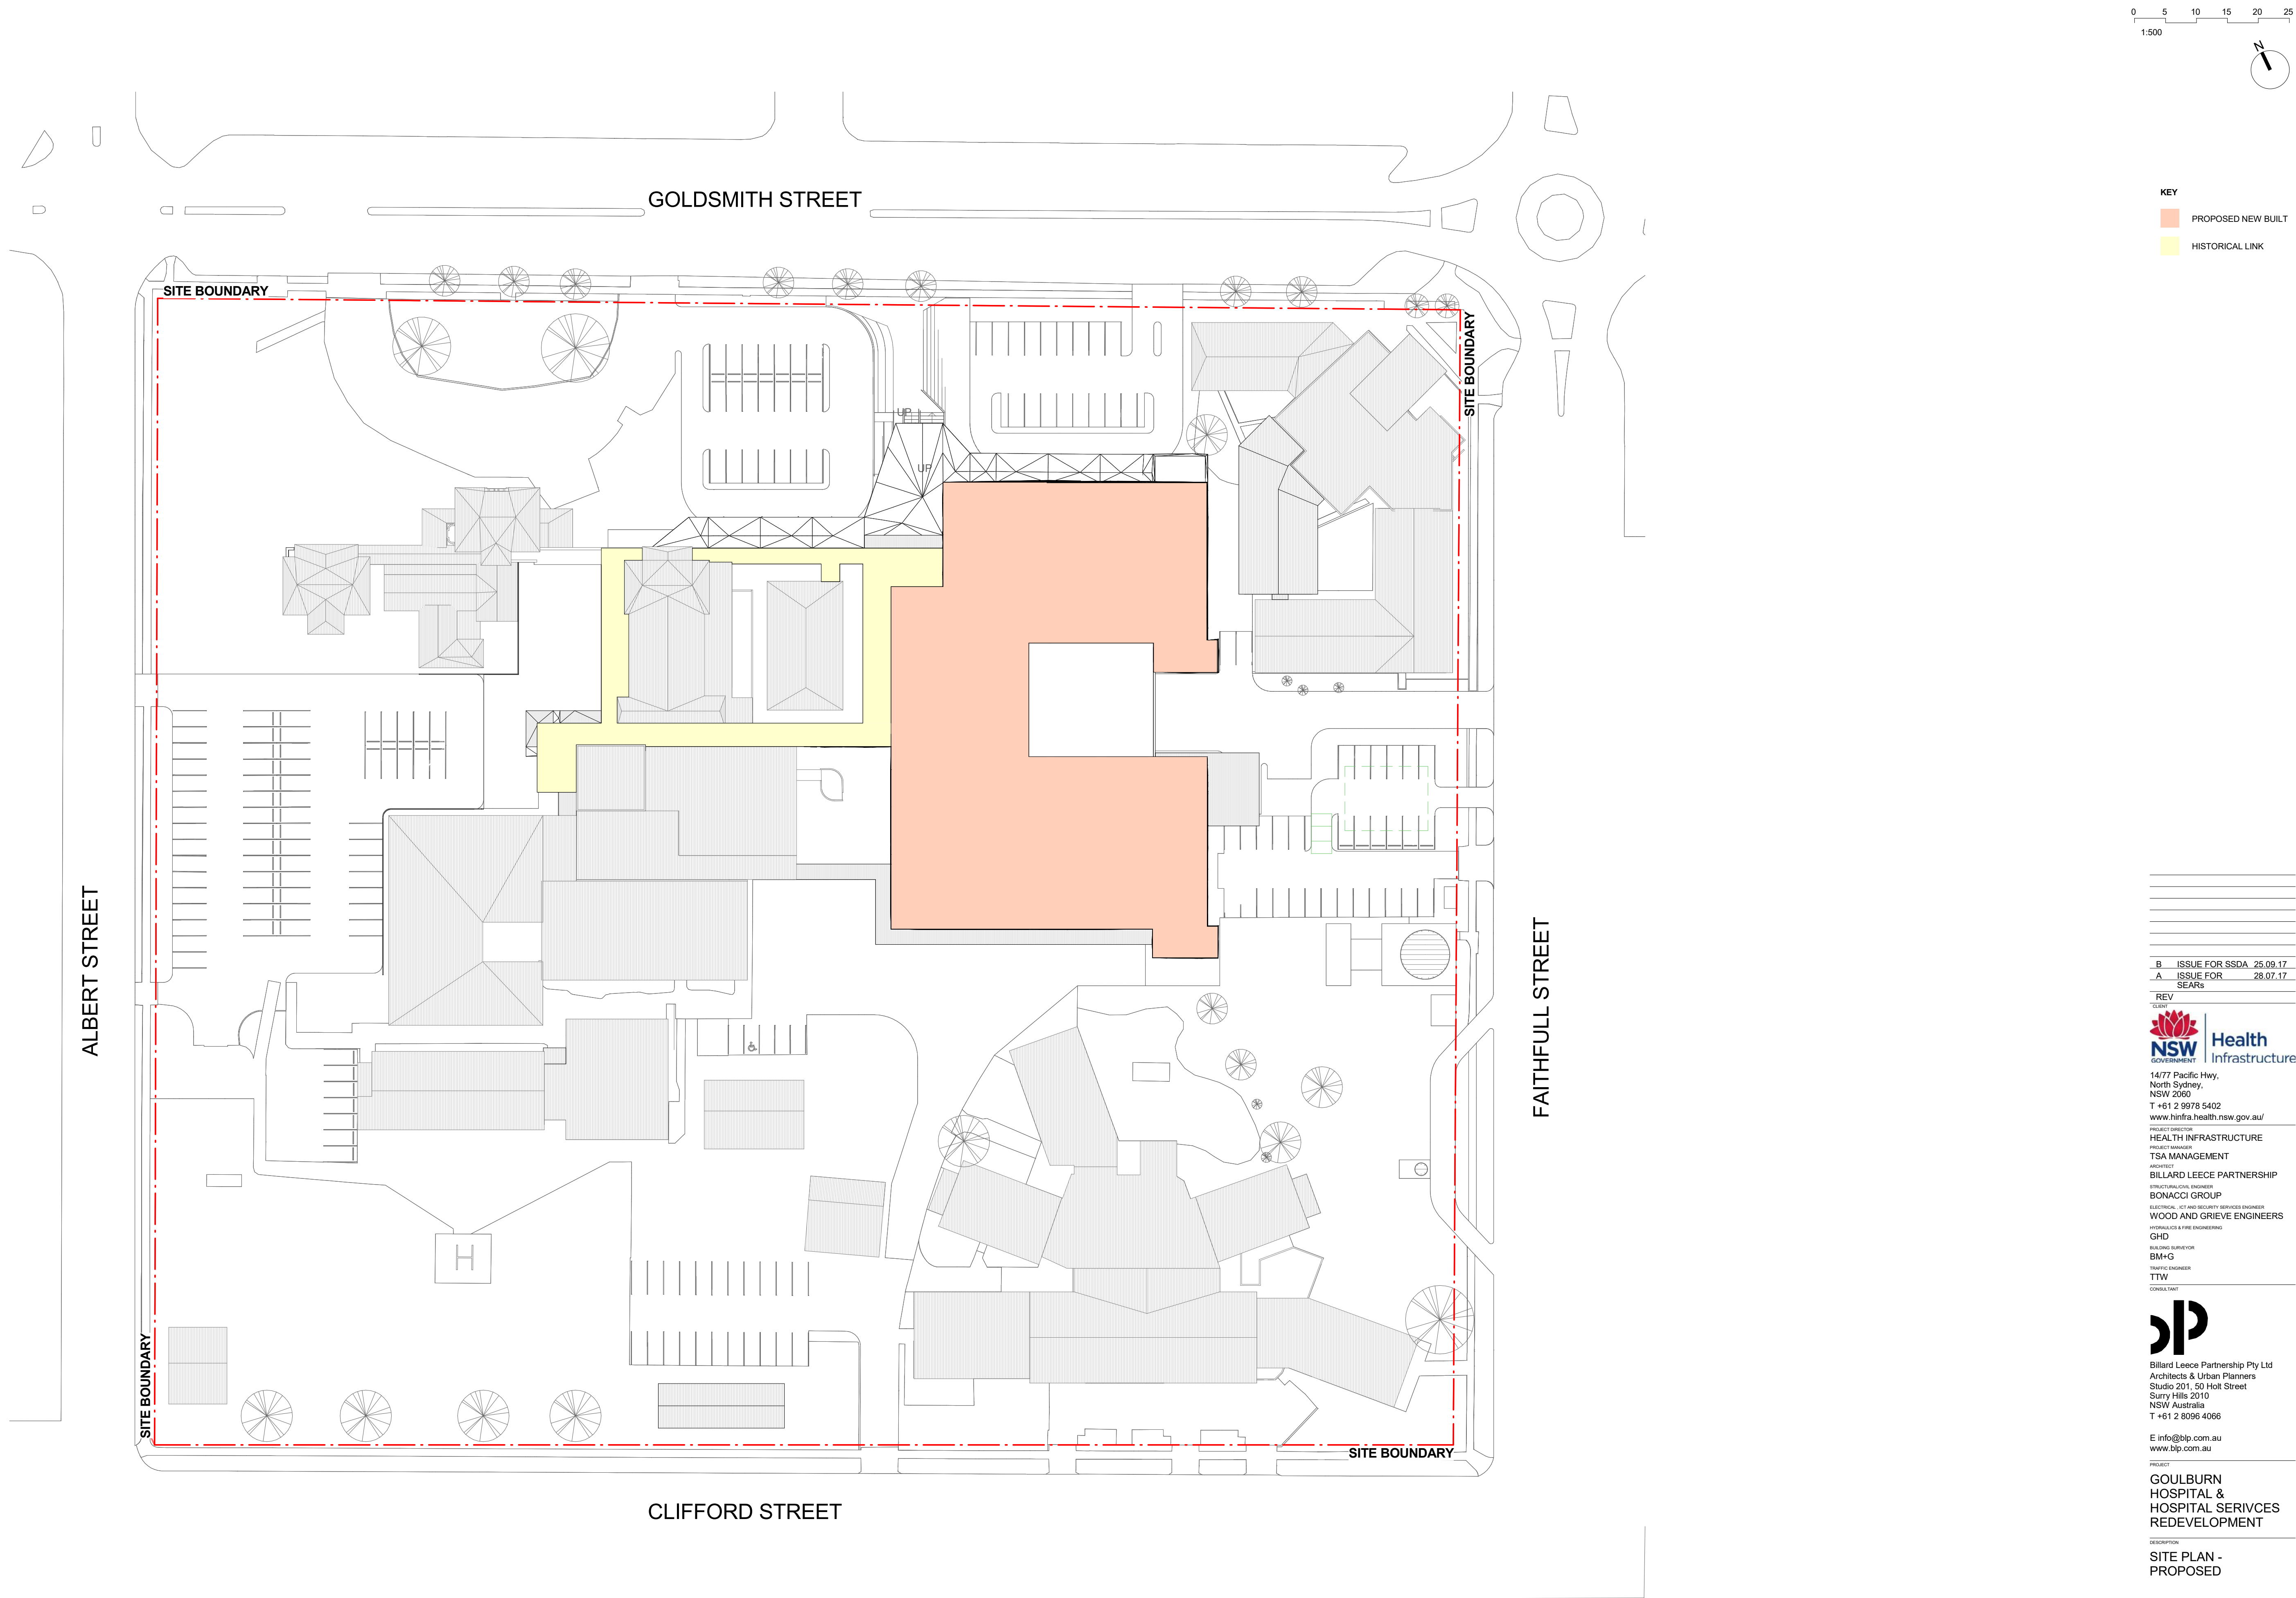

KEY

PROPOSED NEW BUILT

HISTORICAL LINK

B ISSUE FOR SSDA 25.09.17

A ISSUE FOR 28.07.17

REV

CLIENT

NSW GOVERNMENT

Health Infrastructure

14/77 Pacific Hwy,
North Sydney,
NSW 2060

T +61 2 9978 5402

www.himfra.health.nsw.gov.au/

PROJECT DIRECTOR

HEALTH INFRASTRUCTURE

PROJECT MANAGER

TSA MANAGEMENT

ARCHITECT

BILLARD LEECE PARTNERSHIP

INTERDISCIPLINARY PARTNER

BONACCI GROUP

ELECTRICAL, ICT AND SECURITY SERVICES ENGINEER

WOOD AND GRIEVE ENGINEERS

HYDRAULICS & FIRE ENGINEERING

GHD

BUILDING SURVEYOR

BM+G

MECHANICAL ENGINEER

TTW

CONSULTANT

CONSULTANT

Billard Leece Partnership Pty Ltd

Architects & Urban Planners

Studio 201, 50 Holt Street
Sunny Hills 2010
NSW Australia

T +61 2 8096 4066

E info@blp.com.au

www.blp.com.au

PROJECT

GOULBURN

HOSPITAL &

HOSPITAL SERVICES

REDEVELOPMENT

DESCRIPTION

SITE PLAN -

PROPOSED

Project No 15614

Scale As indicated@A1

Date 15/08/2017

Drawn By

Author

Drawing No

AA02-0202

Checked By


Checker

Revision


B

SSDA

25/09/2017 5:18:16 PM

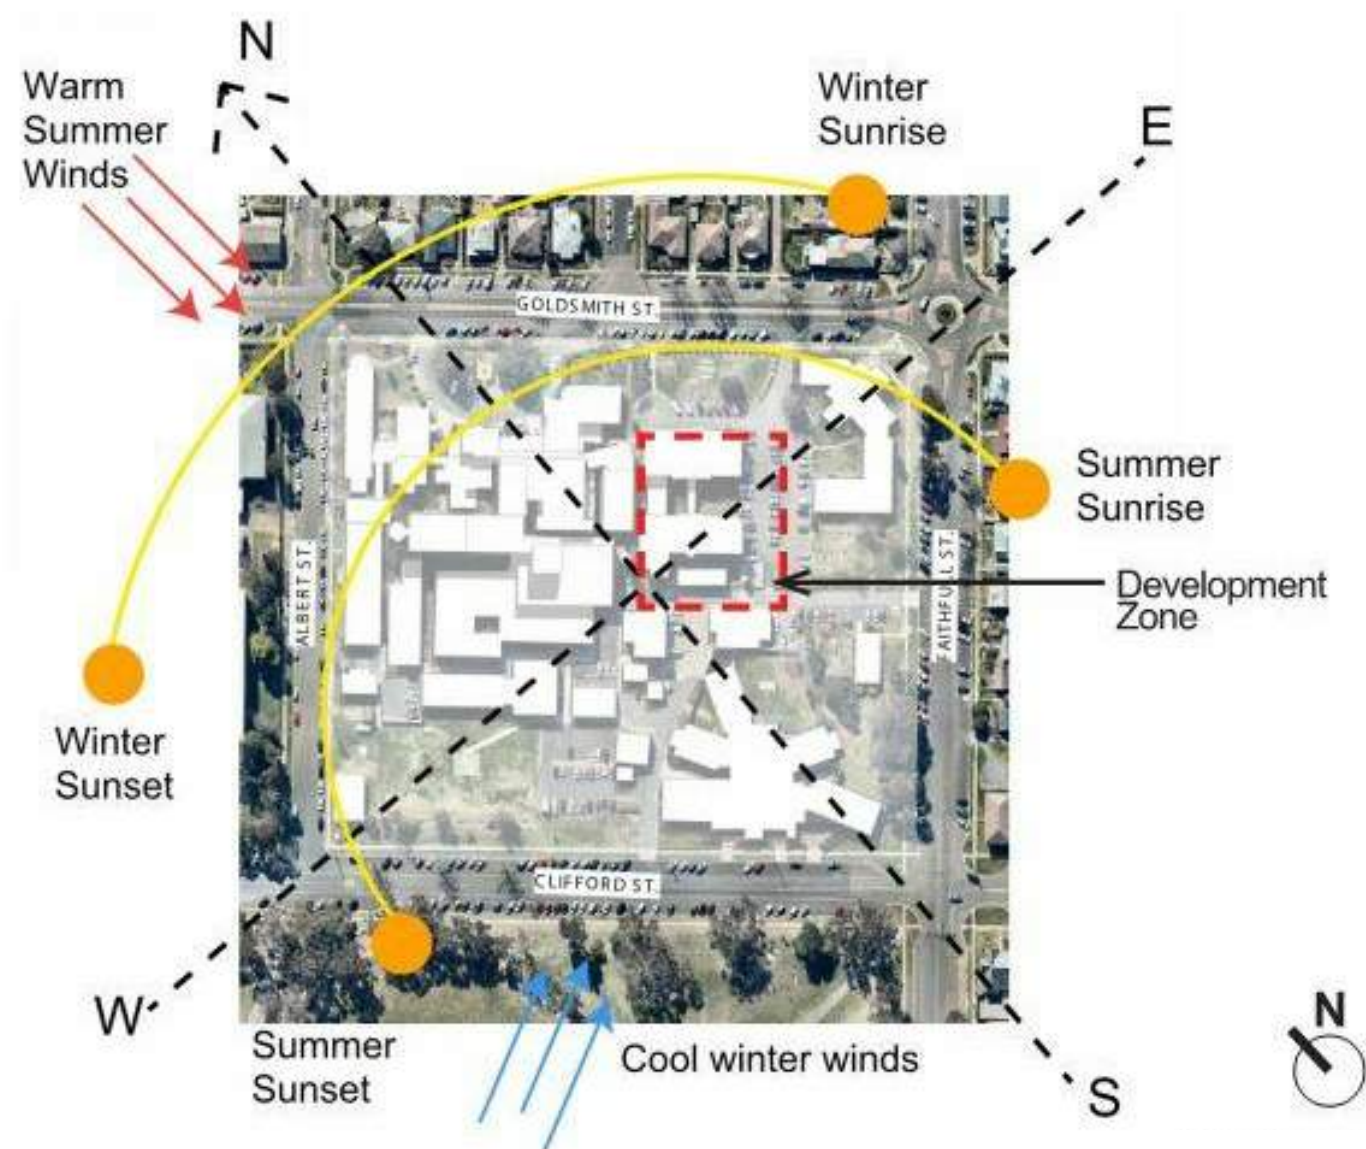

SUN AND WIND ANALYSIS

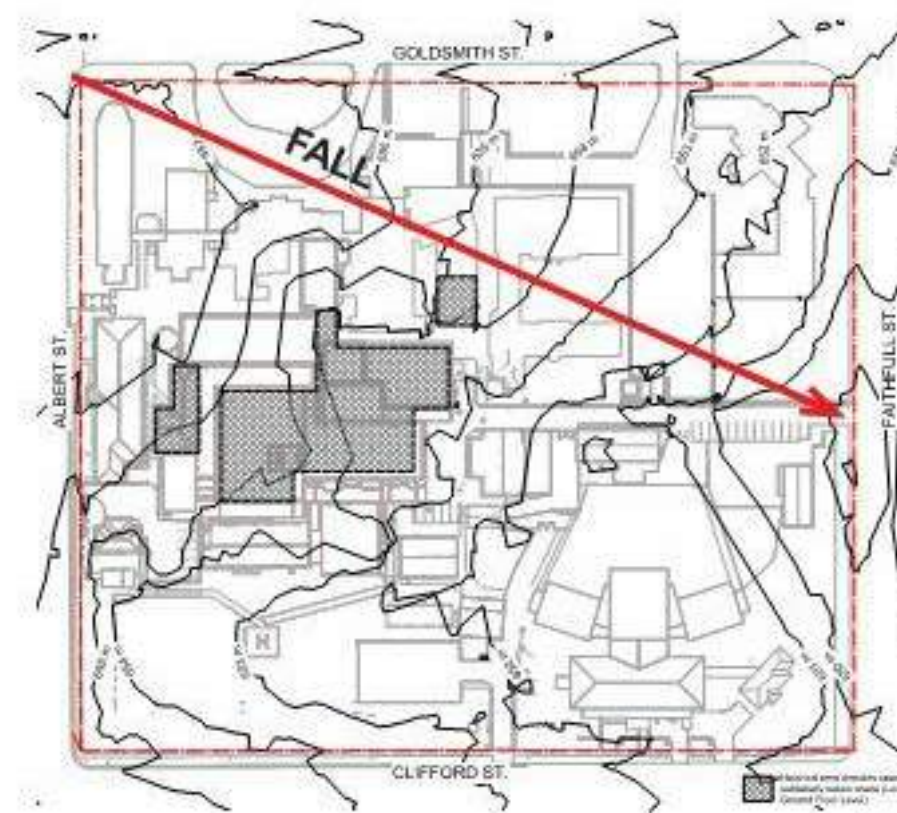

TOPOGRAPHY ANALYSIS DIAGRAM

A ISSUE FOR SSDA 25.09.17
REV



Billard Leece Partnership Pty Ltd
Architects & Urban Planners
Studio 201, 50 Holt Street
Surry Hills 2010
NSW Australia
T +61 2 8096 4066

E info@blp.com.au
www.blp.com.au

CLIENT



PROJECT
GOULBURN HOSPITAL &
HOSPITAL SERVICES
REDEVELOPMENT

SITE ANALYSIS MONTAGE


Project No 15614

Scale 1 : 500@A3 Date 15/08/2017

Drawn By PJ Checked By MC

Drawing No AA02-2301 Revision A

SSDA

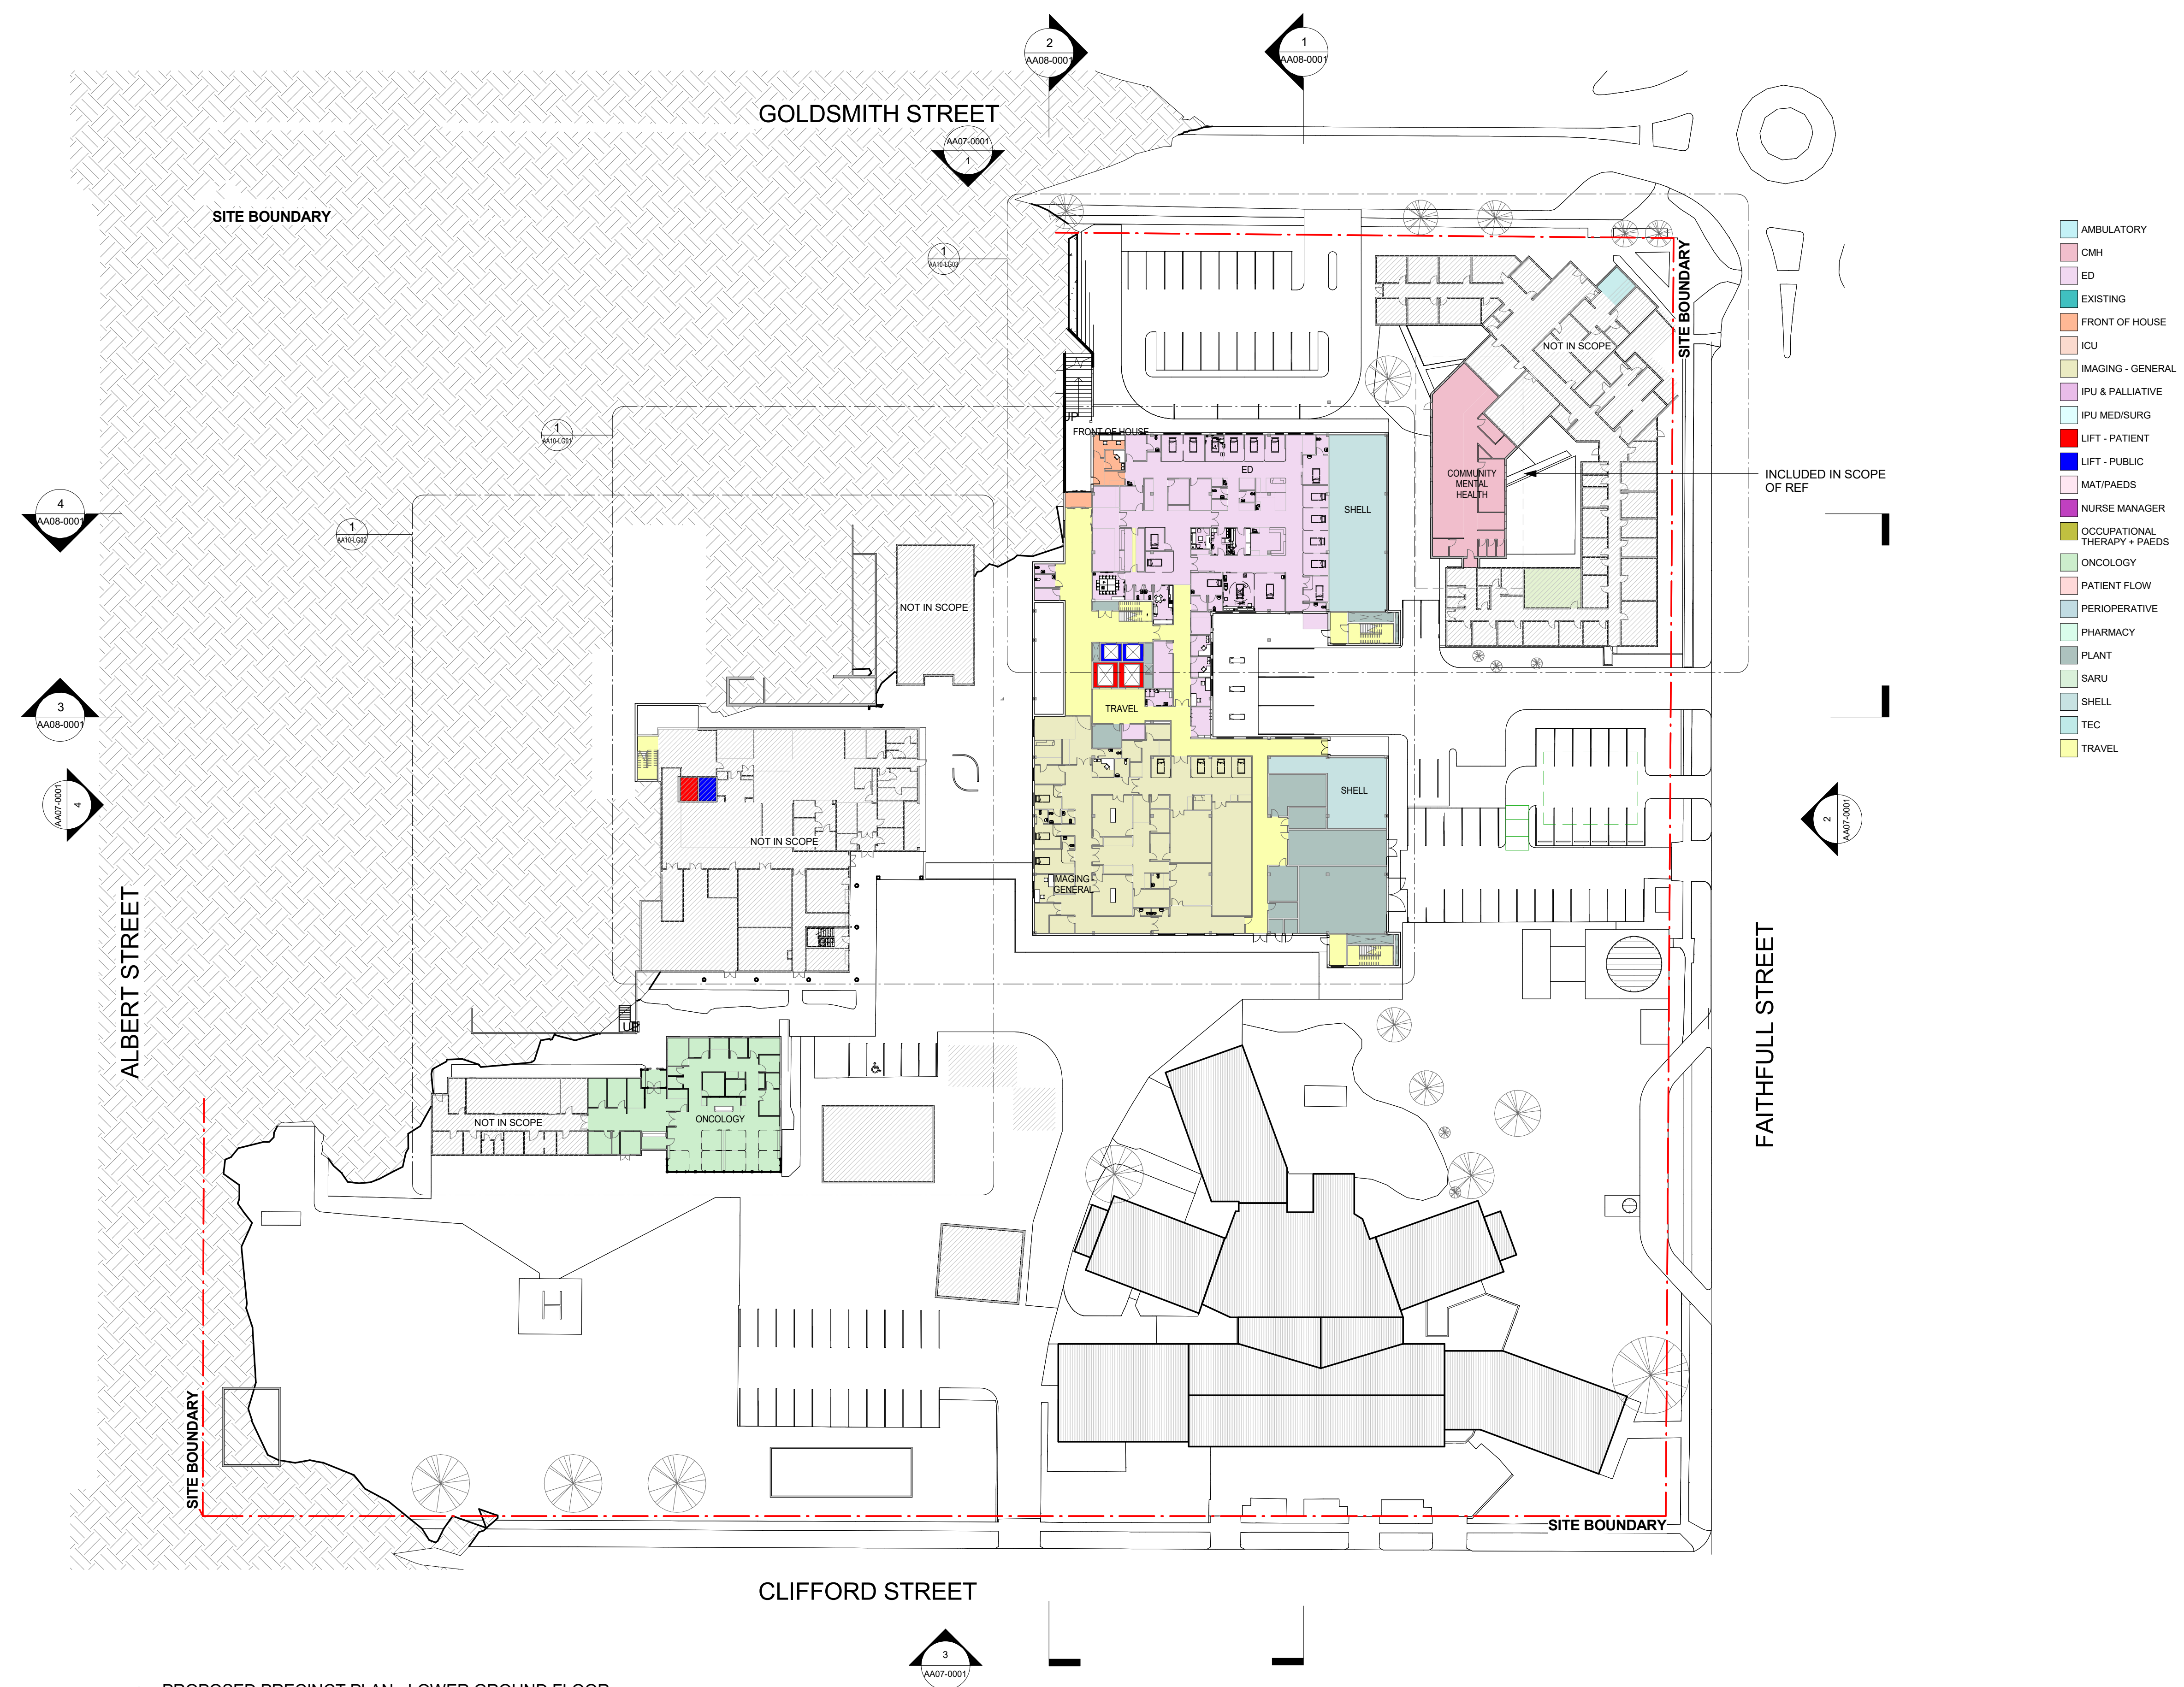

D	ISSUE FOR SSDA	25.09.17
C	FINAL SD ISSUE	21.07.17
B	FROZEN PLAN	13.07.17
A	IC3	22.06.17
REV	IC3	22.06.17


NSW GOVERNMENT
Health Infrastructure
14/77 Pacific Hwy,
North Sydney,
NSW 2060
T +61 2 9978 5402
www.himfra.health.nsw.gov.au/
PROJECT DIRECTOR
HEALTH INFRASTRUCTURE
PROJECT MANAGER
TSA MANAGEMENT
ARCHITECT
BILLARD LEECE PARTNERSHIP
ELECTRICAL ENGINEER
BONACCI GROUP
ELECTRICAL, ICT AND SECURITY SERVICES ENGINEER
WOOD AND GRIEVE ENGINEERS
HYDRAULICS & FIRE ENGINEERING
GHD
BUILDING SUPERVISOR
BM+G
MECHANICAL ENGINEER
TTW
CONSULTANT

Billard Leece Partnership Pty Ltd
Architects & Urban Planners
Studio 201, 50 Holt Street
Sunny Hills 2010
NSW Australia
T +61 2 8096 4066
E info@blp.com.au
www.blp.com.au

PROJECT
GOULBURN
HOSPITAL &
HOSPITAL SERVICES
REDEVELOPMENT

DESCRIPTION
PROPOSED PRECINCT
PLAN - LOWER
GROUND FLOOR

Project No	15614
Scale	1:500@A1
Date	13/08/2017
Drawn By	LG
Checked By	LG
Drawing No	Revision
AA06-LG01	D

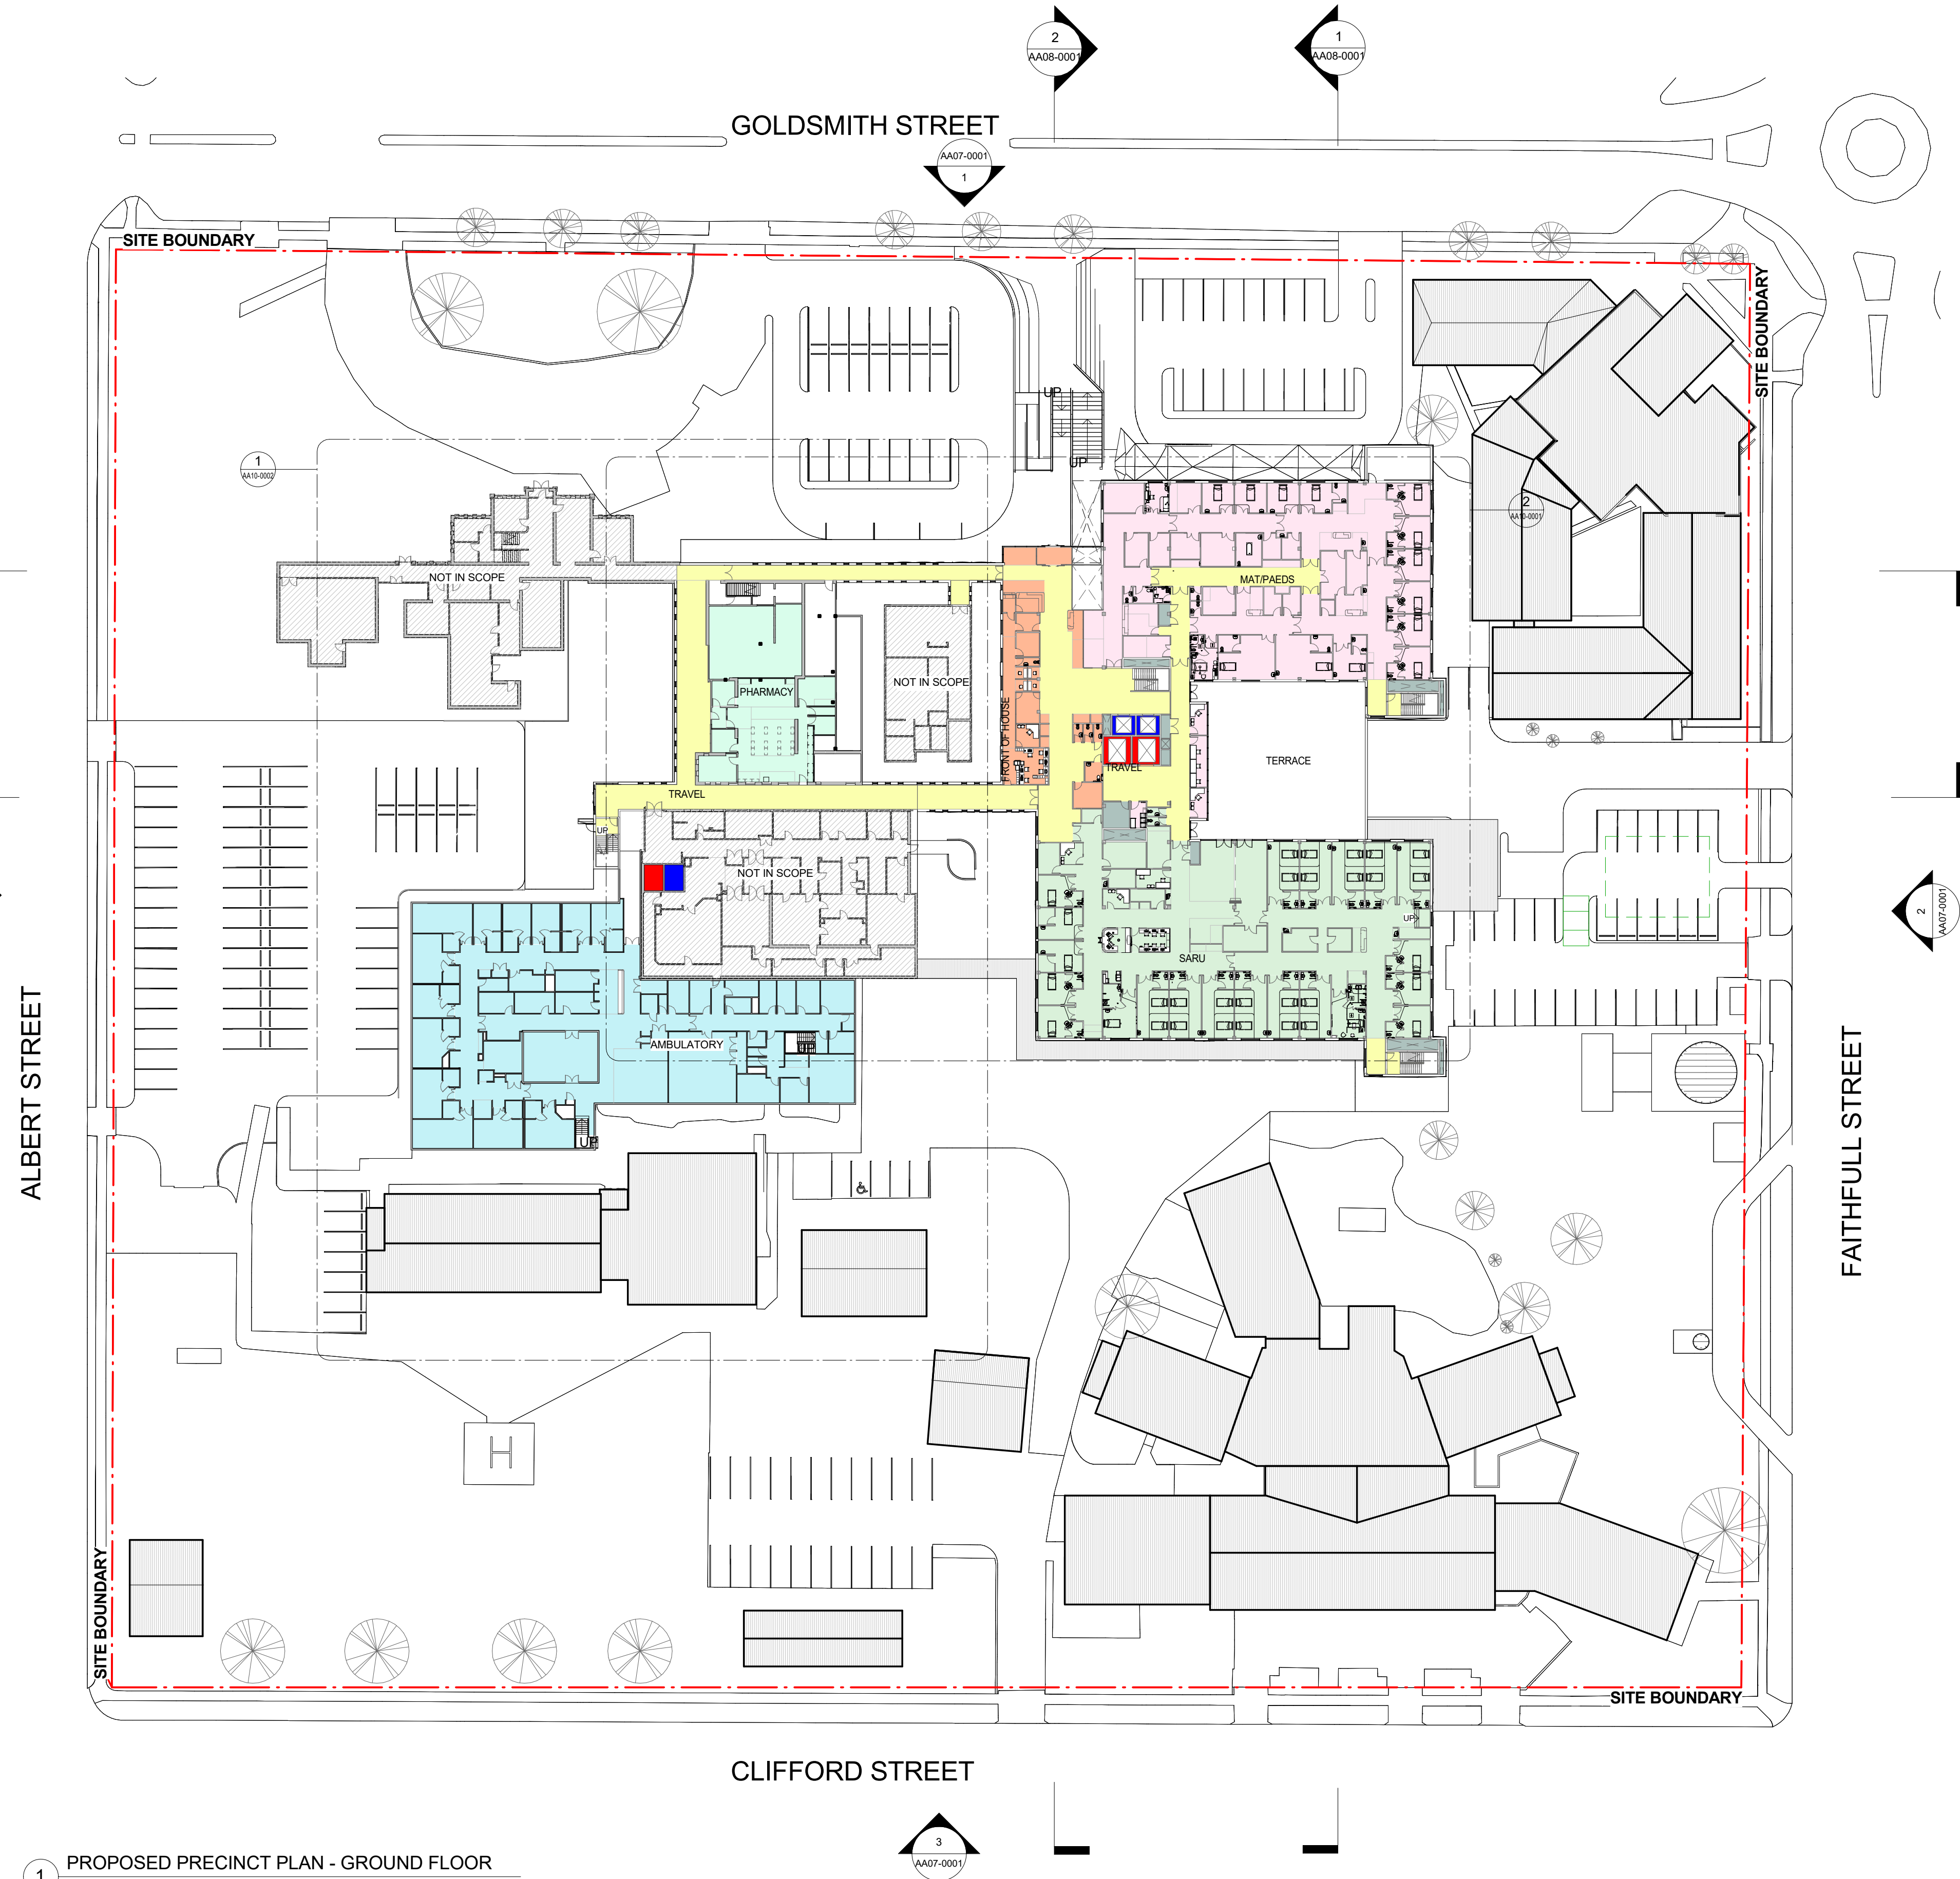

- AMBULATORY
- CMH
- ED
- EXISTING
- FRONT OF HOUSE
- ICU
- IMAGING - GENERAL
- IPU & PALLIATIVE
- IPU MED/SURG
- LIFT - PATIENT
- LIFT - PUBLIC
- MAT/PAEDS
- NURSE MANAGER
- OCCUPATIONAL THERAPY + PAEDS
- ONCOLOGY
- PATIENT FLOW
- PERIOPERATIVE
- PHARMACY
- PLANT
- SARU
- SHELL
- TEC
- TRAVEL

1 PROPOSED PRECINCT PLAN - GROUND FLOOR
1:500



D	ISSUE FOR SSDA	25.09.17
C	FINAL SD ISSUE	21.07.17
B	FROZEN PLAN	13.07.17
A	IC3	22.06.17
REV	IC3	22.06.17

NSW GOVERNMENT
Health Infrastructure
14/77 Pacific Hwy,
North Sydney,
NSW 2060
T +61 2 9978 5402
www.himfra.health.nsw.gov.au/
PROJECT DIRECTOR
HEALTH INFRASTRUCTURE
PROJECT MANAGER
TSA MANAGEMENT
ARCHITECT
BILLARD LEECE PARTNERSHIP
INTERDISCIPLINARY MANAGER
BONACCI GROUP
ELECTRICAL, ICT AND SECURITY SERVICES ENGINEER
WOOD AND GRIEVE ENGINEERS
HYDRAULICS & FIRE ENGINEERING
GHD
BUILDING SUPERVISOR
BM+G
MECHANICAL ENGINEER
TTW
CONSULTANT

Billard Leece Partnership Pty Ltd
Architects & Urban Planners
Studio 201, 50 Holt Street
Sunny Hills 2010
NSW Australia
T +61 2 8096 4066
E info@blp.com.au
www.blp.com.au

PROJECT
GOULBURN
HOSPITAL &
HOSPITAL SERVICES
REDEVELOPMENT
DESCRIPTION
PROPOSED PRECINCT
PLAN - GROUND
FLOOR

Project No	15614
Scale	1:500@A1
Date	13/08/2017
Drawn By	LG
Checked By	LG
Drawing No	Revision
AA06-0001	D

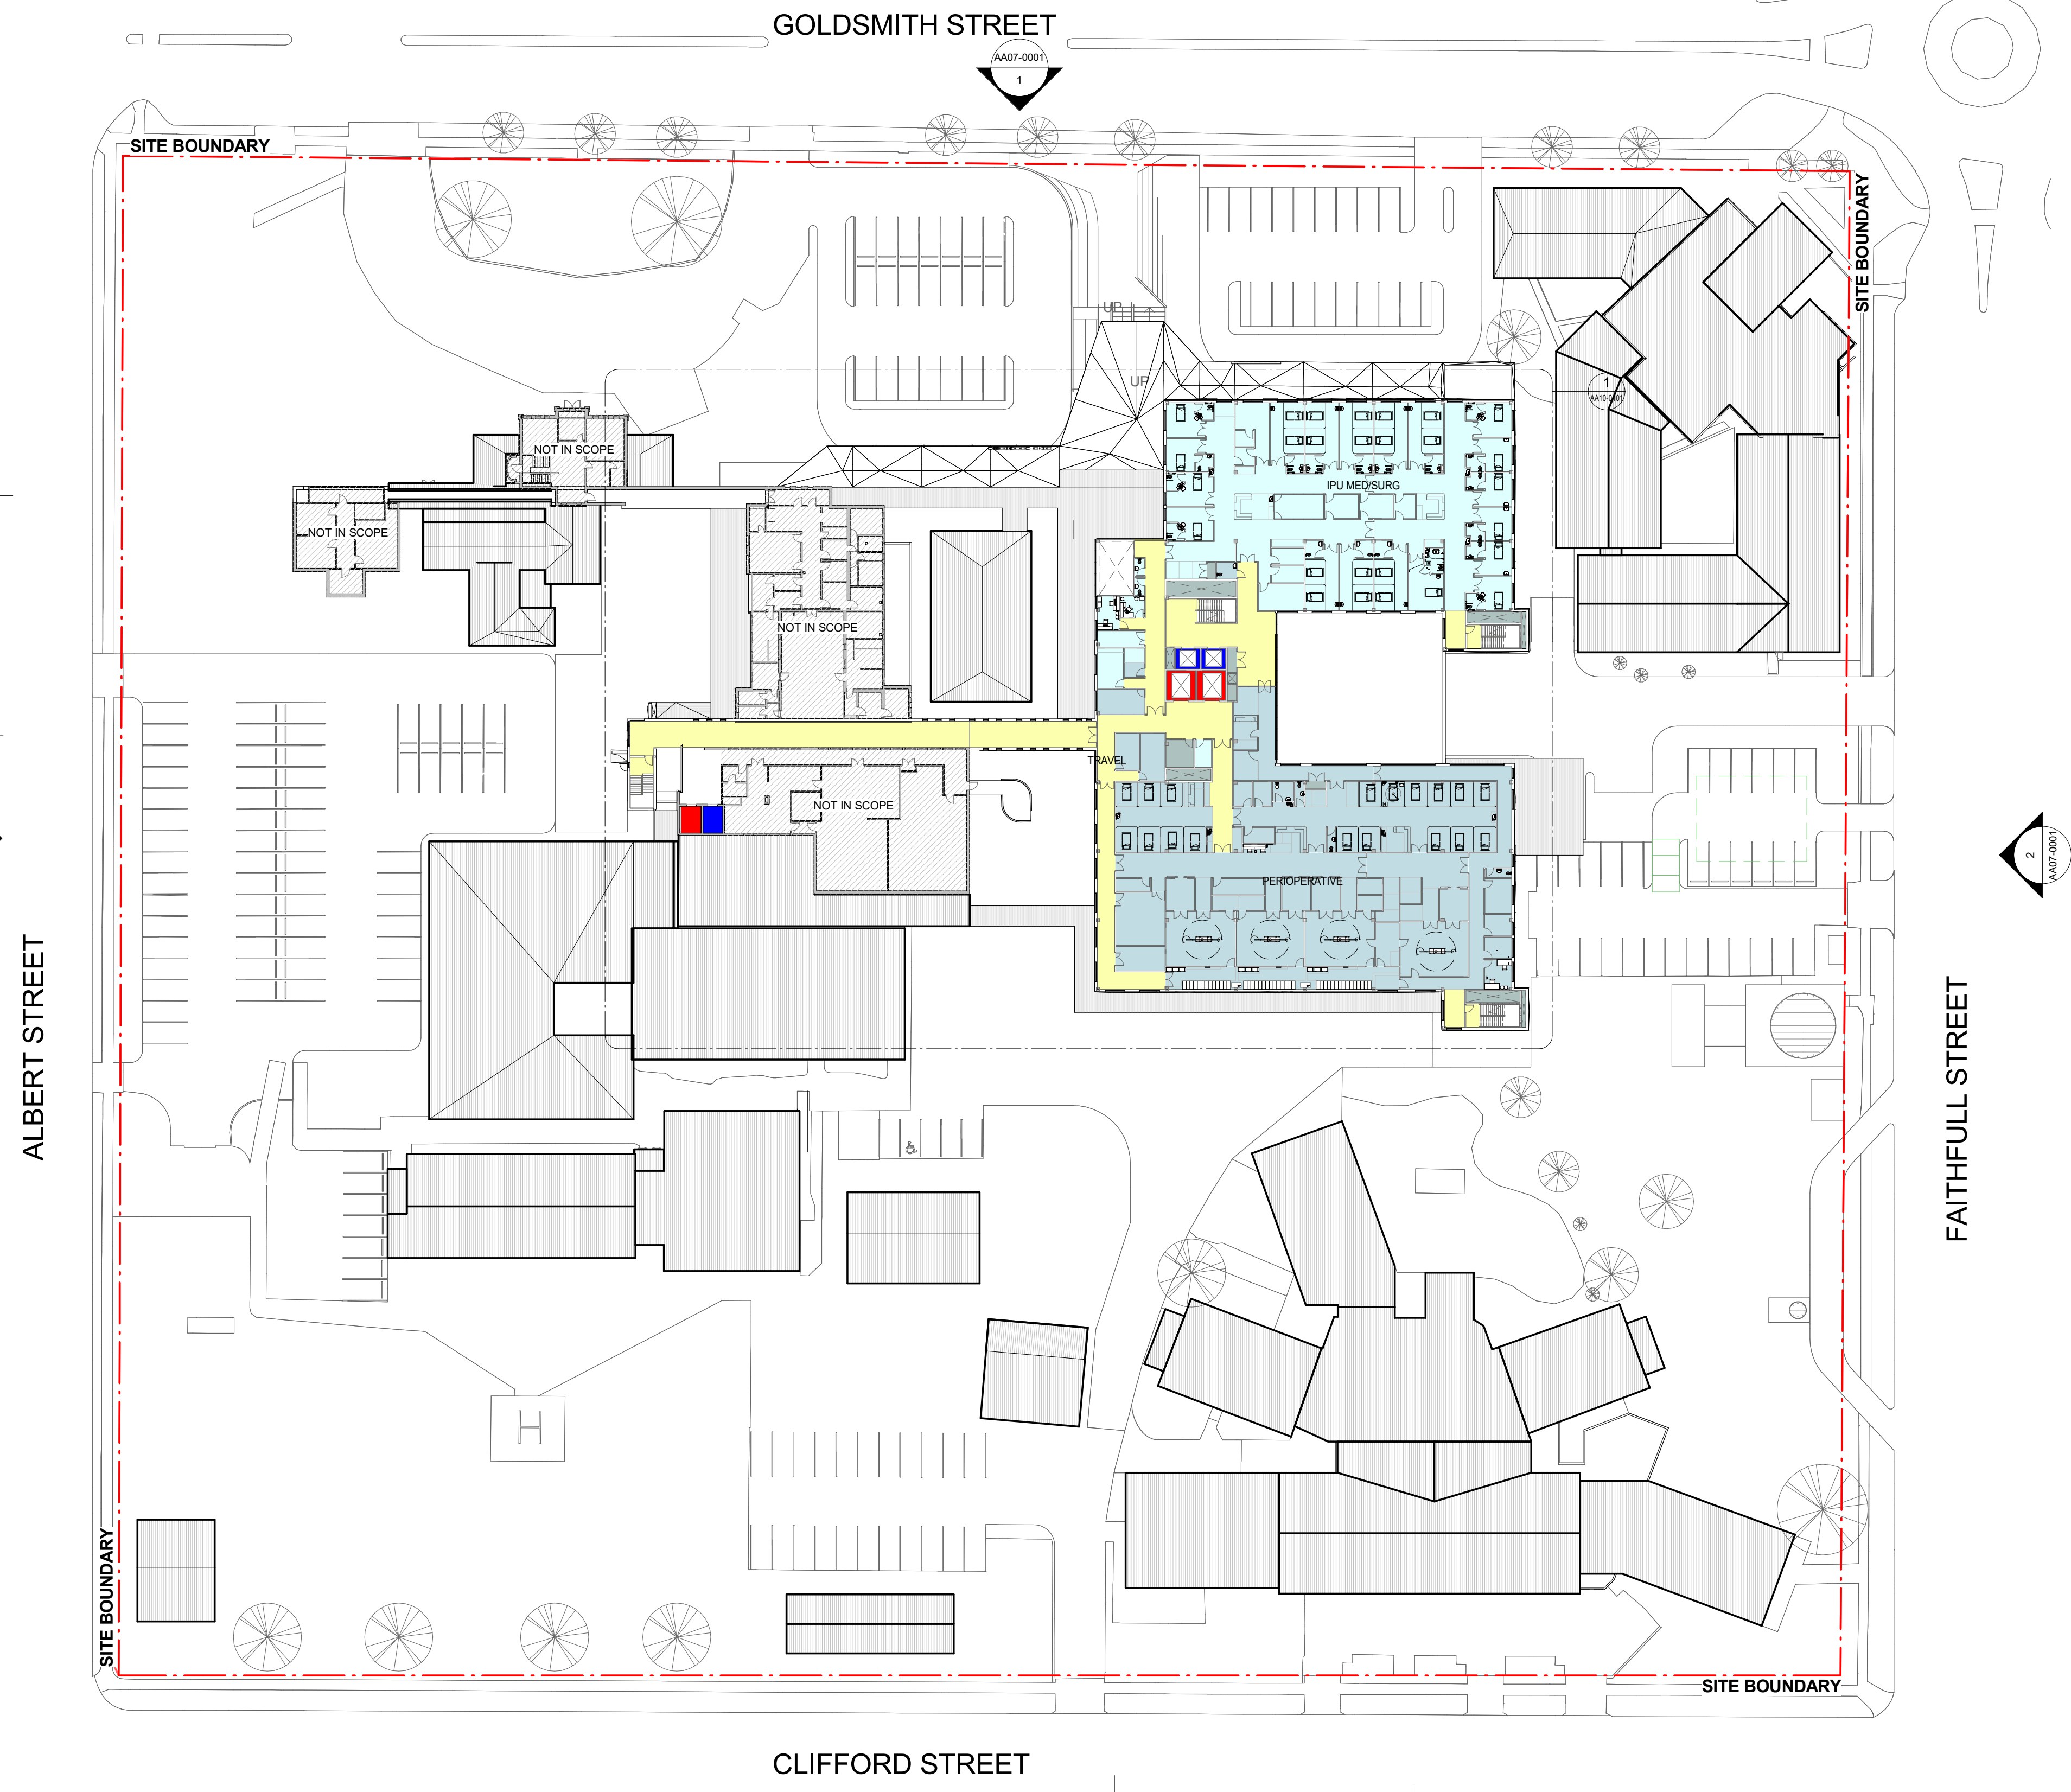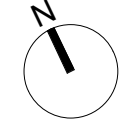

- AMBULATORY
- CMH
- ED
- EXISTING
- FRONT OF HOUSE
- ICU
- IMAGING - GENERAL
- IPU & PALLIATIVE
- IPU MED/SURG
- LIFT - PATIENT
- LIFT - PUBLIC
- MAT/PAEDS
- NURSE MANAGER
- OCCUPATIONAL THERAPY + PAEDS
- ONCOLOGY
- PATIENT FLOW
- PERIOPERATIVE
- PHARMACY
- PLANT
- SARU
- SHELL
- TEC
- TRAVEL

1 PROPOSED PRECINCT PLAN - FIRST FLOOR
1:500



D	ISSUE FOR SSDA	25.09.17
C	FINAL SD ISSUE	21.07.17
B	FROZEN PLAN	13.07.17
A	IC3	22.06.17
REV	CLIENT	

NSW Health
GOVERNMENT Infrastructure
14/77 Pacific Hwy,
North Sydney,
NSW 2060
T +61 2 9978 5402
www.himfra.health.nsw.gov.au/
PROJECT DIRECTOR
HEALTH INFRASTRUCTURE
PROJECT MANAGER
TSA MANAGEMENT
ARCHITECT
BILLARD LEECE PARTNERSHIP
INTERDISCIPLINARY PARTNER
BONACCI GROUP
ELECTRICAL, ICT AND SECURITY SERVICES ENGINEER
WOOD AND GRIEVE ENGINEERS
HYDRAULICS & FIRE ENGINEERING
GHD
BUILDING SUPERVISOR
BM+G
MECHANICAL ENGINEER
TTW
CONSULTANT

BLP
Billard Leece Partnership Pty Ltd
Architects & Urban Planners
Studio 201, 50 Holt Street
Sunny Hills 2010
NSW Australia
T +61 2 8096 4066
E info@blp.com.au
www.blp.com.au

PROJECT
GOULBURN
HOSPITAL &
HOSPITAL SERVICES
REDEVELOPMENT
DESCRIPTION
PROPOSED PRECINCT
PLAN - FIRST FLOOR

Project No	15614
Scale	1:500@A1
Date	13/08/2017
Drawn By	LG
Checked By	LG
Drawing No	Revision
AA06-0101	D

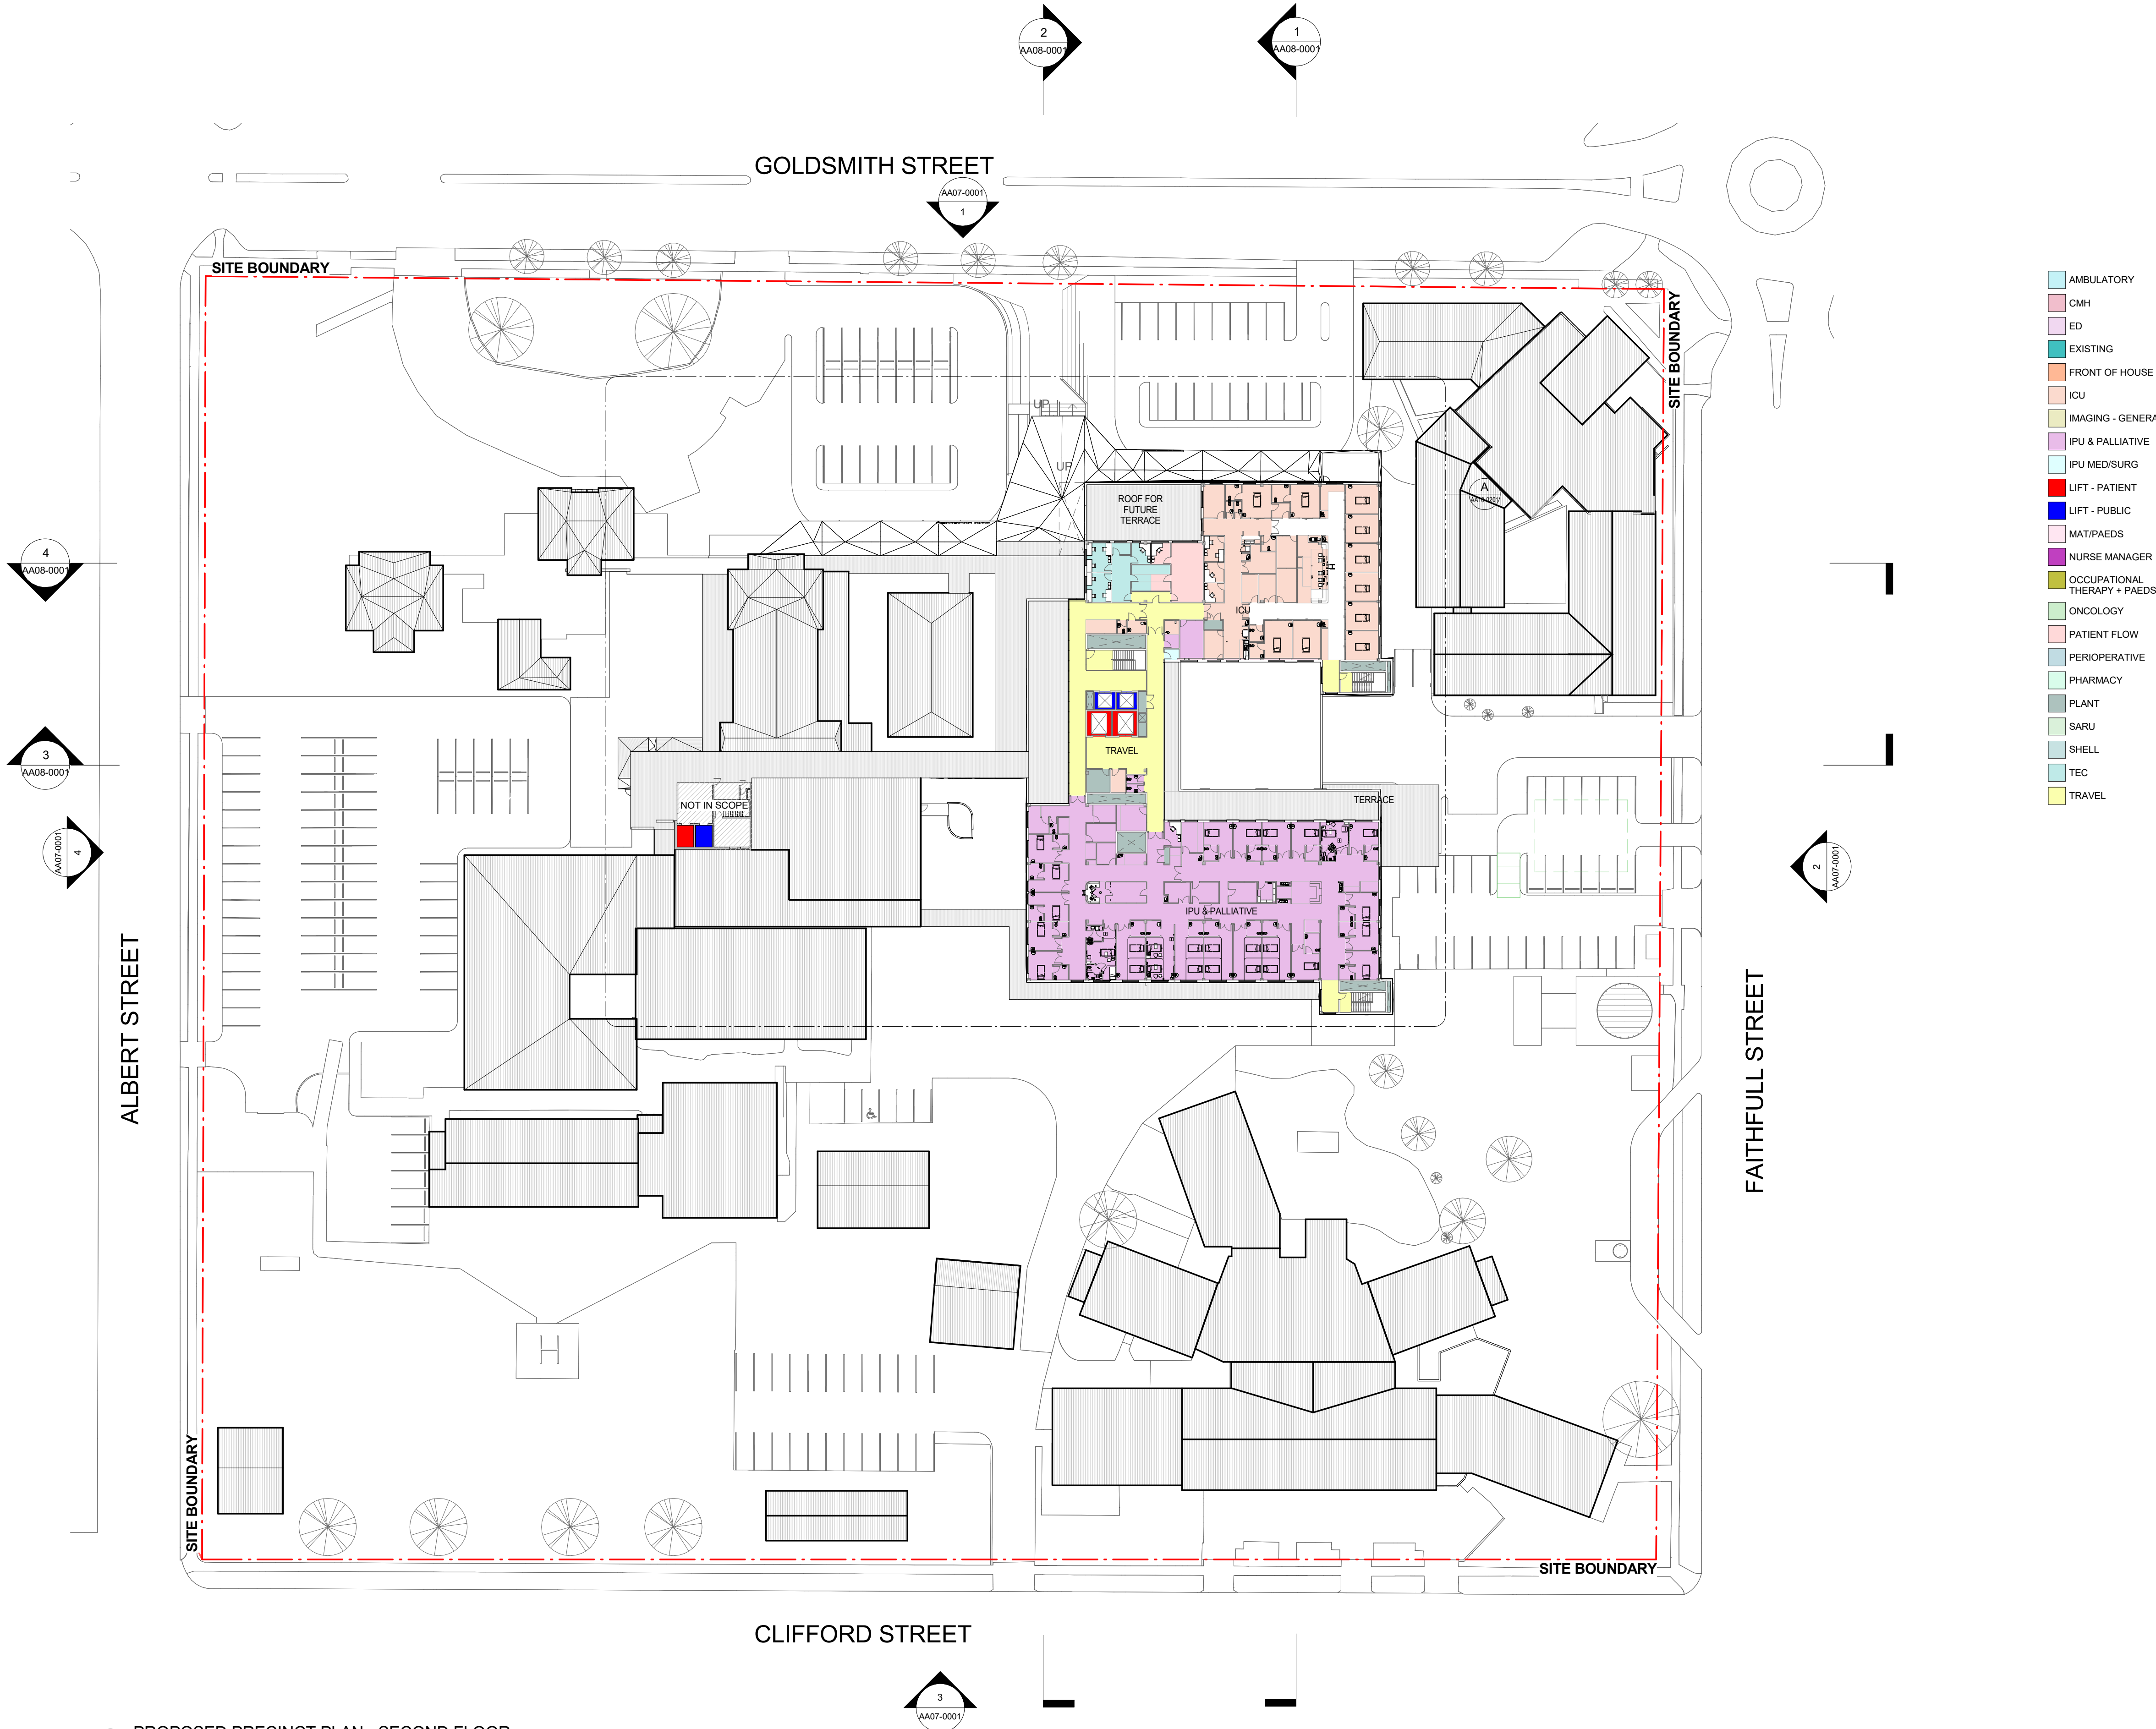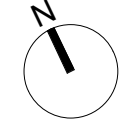

- AMBULATORY
- CMH
- ED
- EXISTING
- FRONT OF HOUSE
- ICU
- IMAGING - GENERAL
- IPU & PALLIATIVE
- IPU MED/SURG
- LIFT - PATIENT
- LIFT - PUBLIC
- MAT/PAEDS
- NURSE MANAGER
- OCCUPATIONAL THERAPY + PAEDS
- ONCOLOGY
- PATIENT FLOW
- PERIOPERATIVE
- PHARMACY
- PLANT
- SARU
- SHELL
- TEC
- TRAVEL

1 PROPOSED PRECINCT PLAN - SECOND FLOOR
1 : 500

D	ISSUE FOR SSDA	25.09.17
C	FINAL SD ISSUE	21.07.17
B	FROZEN PLAN	13.07.17
A	IC3	22.06.17
REV		
1	CLERK	


NSW Health
GOVERNMENT Infrastructure
14/77 Pacific Hwy,
North Sydney,
NSW 2060
T +61 2 9978 5402
www.himfra.health.nsw.gov.au/
PROJECT DIRECTOR
HEALTH INFRASTRUCTURE
PROJECT MANAGER
TSA MANAGEMENT
ARCHITECT
BILLARD LEECE PARTNERSHIP
ELECTROTECHNICAL MANAGER
BONACCI GROUP
ELECTRICAL, ICT AND SECURITY SERVICES ENGINEER
WOOD AND GRIEVE ENGINEERS
HYDRAULICS & FIRE ENGINEERING
GHD
BUILDING SUPERVISOR
BM+G
MECHANICAL ENGINEER
TTW
CONSULTANT

blp
Billard Leece Partnership Pty Ltd
Architects & Urban Planners
Studio 201, 50 Holt Street
Sunny Hills 2010
NSW Australia
T +61 2 8096 4066
E info@blp.com.au
www.blp.com.au

PROJECT
GOULBURN
HOSPITAL &
HOSPITAL SERVICES
REDEVELOPMENT

DESCRIPTION
PROPOSED PRECINCT
PLAN - SECOND
FLOOR

Project No	15614
Scale	1 : 500@A1
Date	13/08/2017
Drawn By	LG
Checked By	LG
Drawing No	Revision
AA06-0201	D

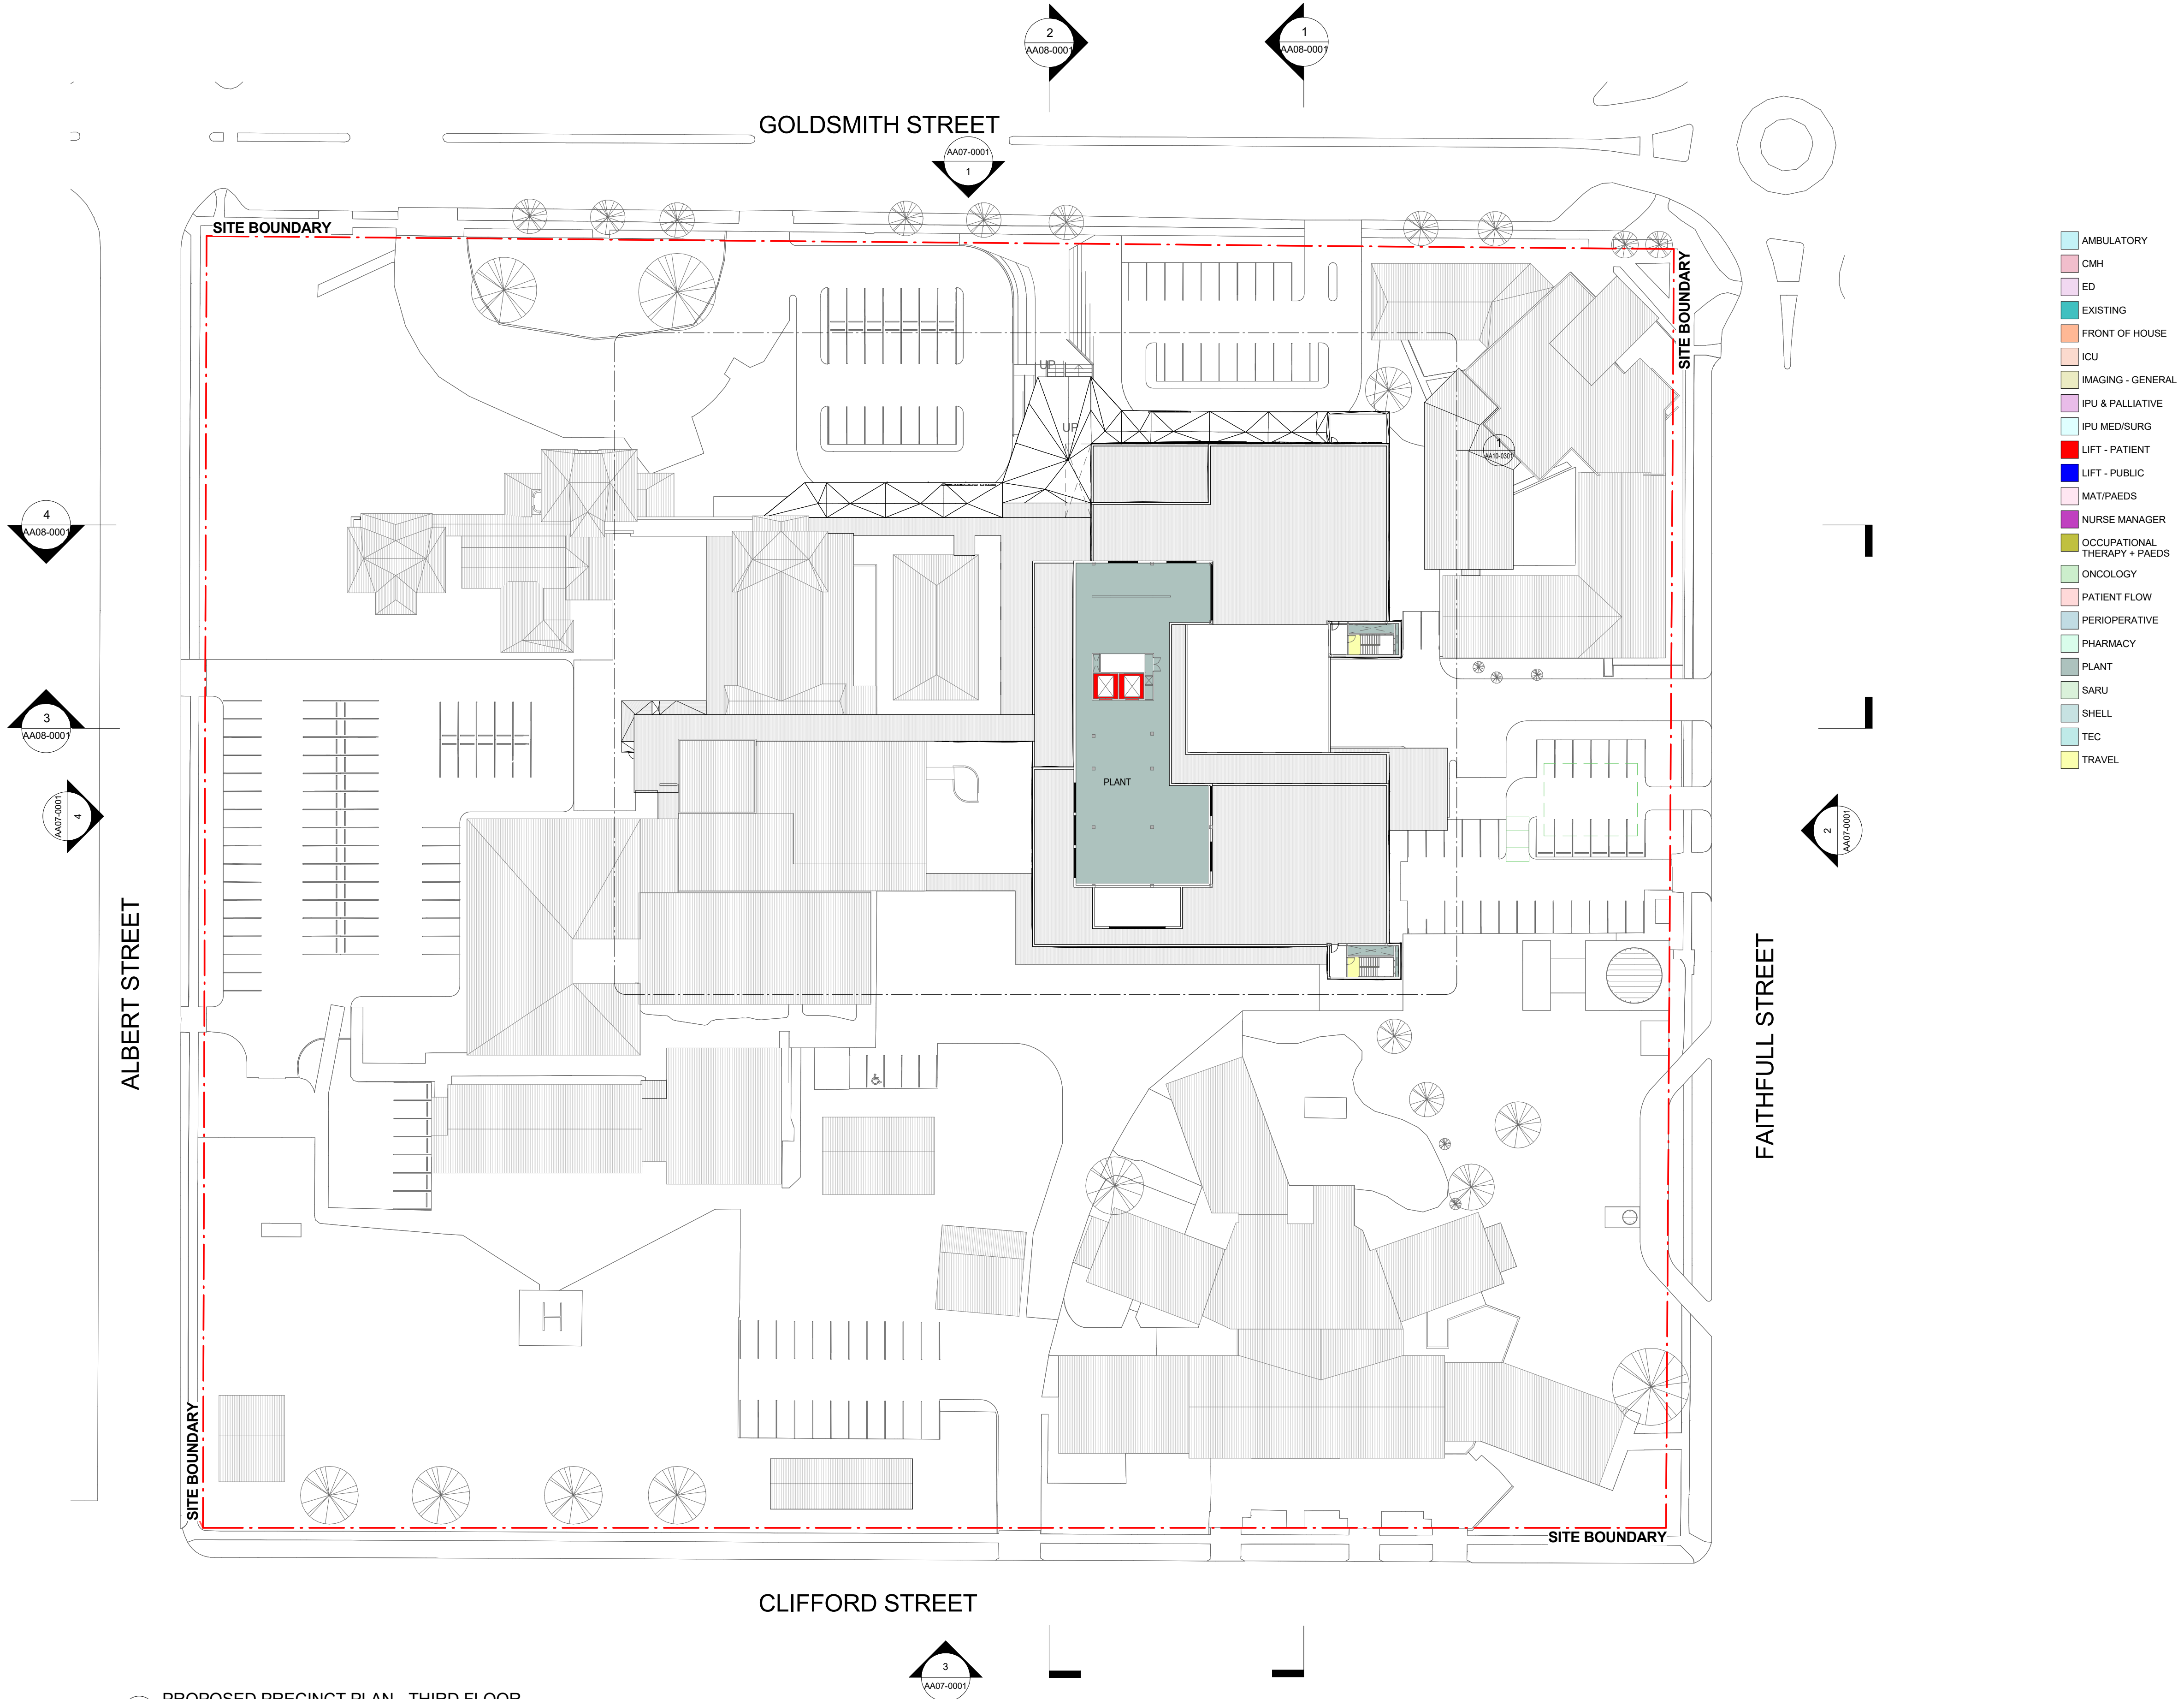

1 PROPOSED PRECINCT PLAN - THIRD FLOOR
1:500

- AMBULATORY
- CMH
- ED
- EXISTING
- FRONT OF HOUSE
- ICU
- IMAGING - GENERAL
- IPU & PALLIATIVE
- IPU MED/SURG
- LIFT - PATIENT
- LIFT - PUBLIC
- MAT/PAEDS
- NURSE MANAGER
- OCCUPATIONAL THERAPY + PAEDS
- ONCOLOGY
- PATIENT FLOW
- PERIOPERATIVE
- PHARMACY
- PLANT
- SARU
- SHELL
- TEC
- TRAVEL

D	ISSUE FOR SSDA	25.09.17
C	FINAL SD ISSUE	21.07.17
B	FROZEN PLAN	13.07.17
A	IC3	22.06.17


REV	1	22.06.17
CLIENT	NSW GOVERNMENT	
PROJECT MANAGER	TSR MANAGEMENT	
ARCHITECT	BILLARD LEECE PARTNERSHIP	
ELECTRICAL ENGINEER	BONACCI GROUP	
ELECTRICAL, ICT AND SECURITY SERVICES ENGINEER	WOOD AND GRIEVE ENGINEERS	
MECHANICAL & FIRE ENGINEERING	GHD	
BUILDING SURVEYOR	BM+G	
MECHANICAL ENGINEER	TTW	
CONSULTANT	CONSULTANT	

BLP
Billard Leece Partnership Pty Ltd
Architects & Urban Planners
Studio 201, 50 Holt Street
Sunny Hills 2010
NSW Australia
T +61 2 8096 4066
E info@blp.com.au
www.blp.com.au

PROJECT
GOULBURN
HOSPITAL &
HOSPITAL SERVICES
REDEVELOPMENT

DESCRIPTION
PROPOSED PRECINCT
PLAN - THIRD FLOOR

Project No	15614
Scale	1:500@A1
Date	13/06/2017
Drawn By	LG
Checked By	LG
Drawing No	Revision
AA06-0301	D

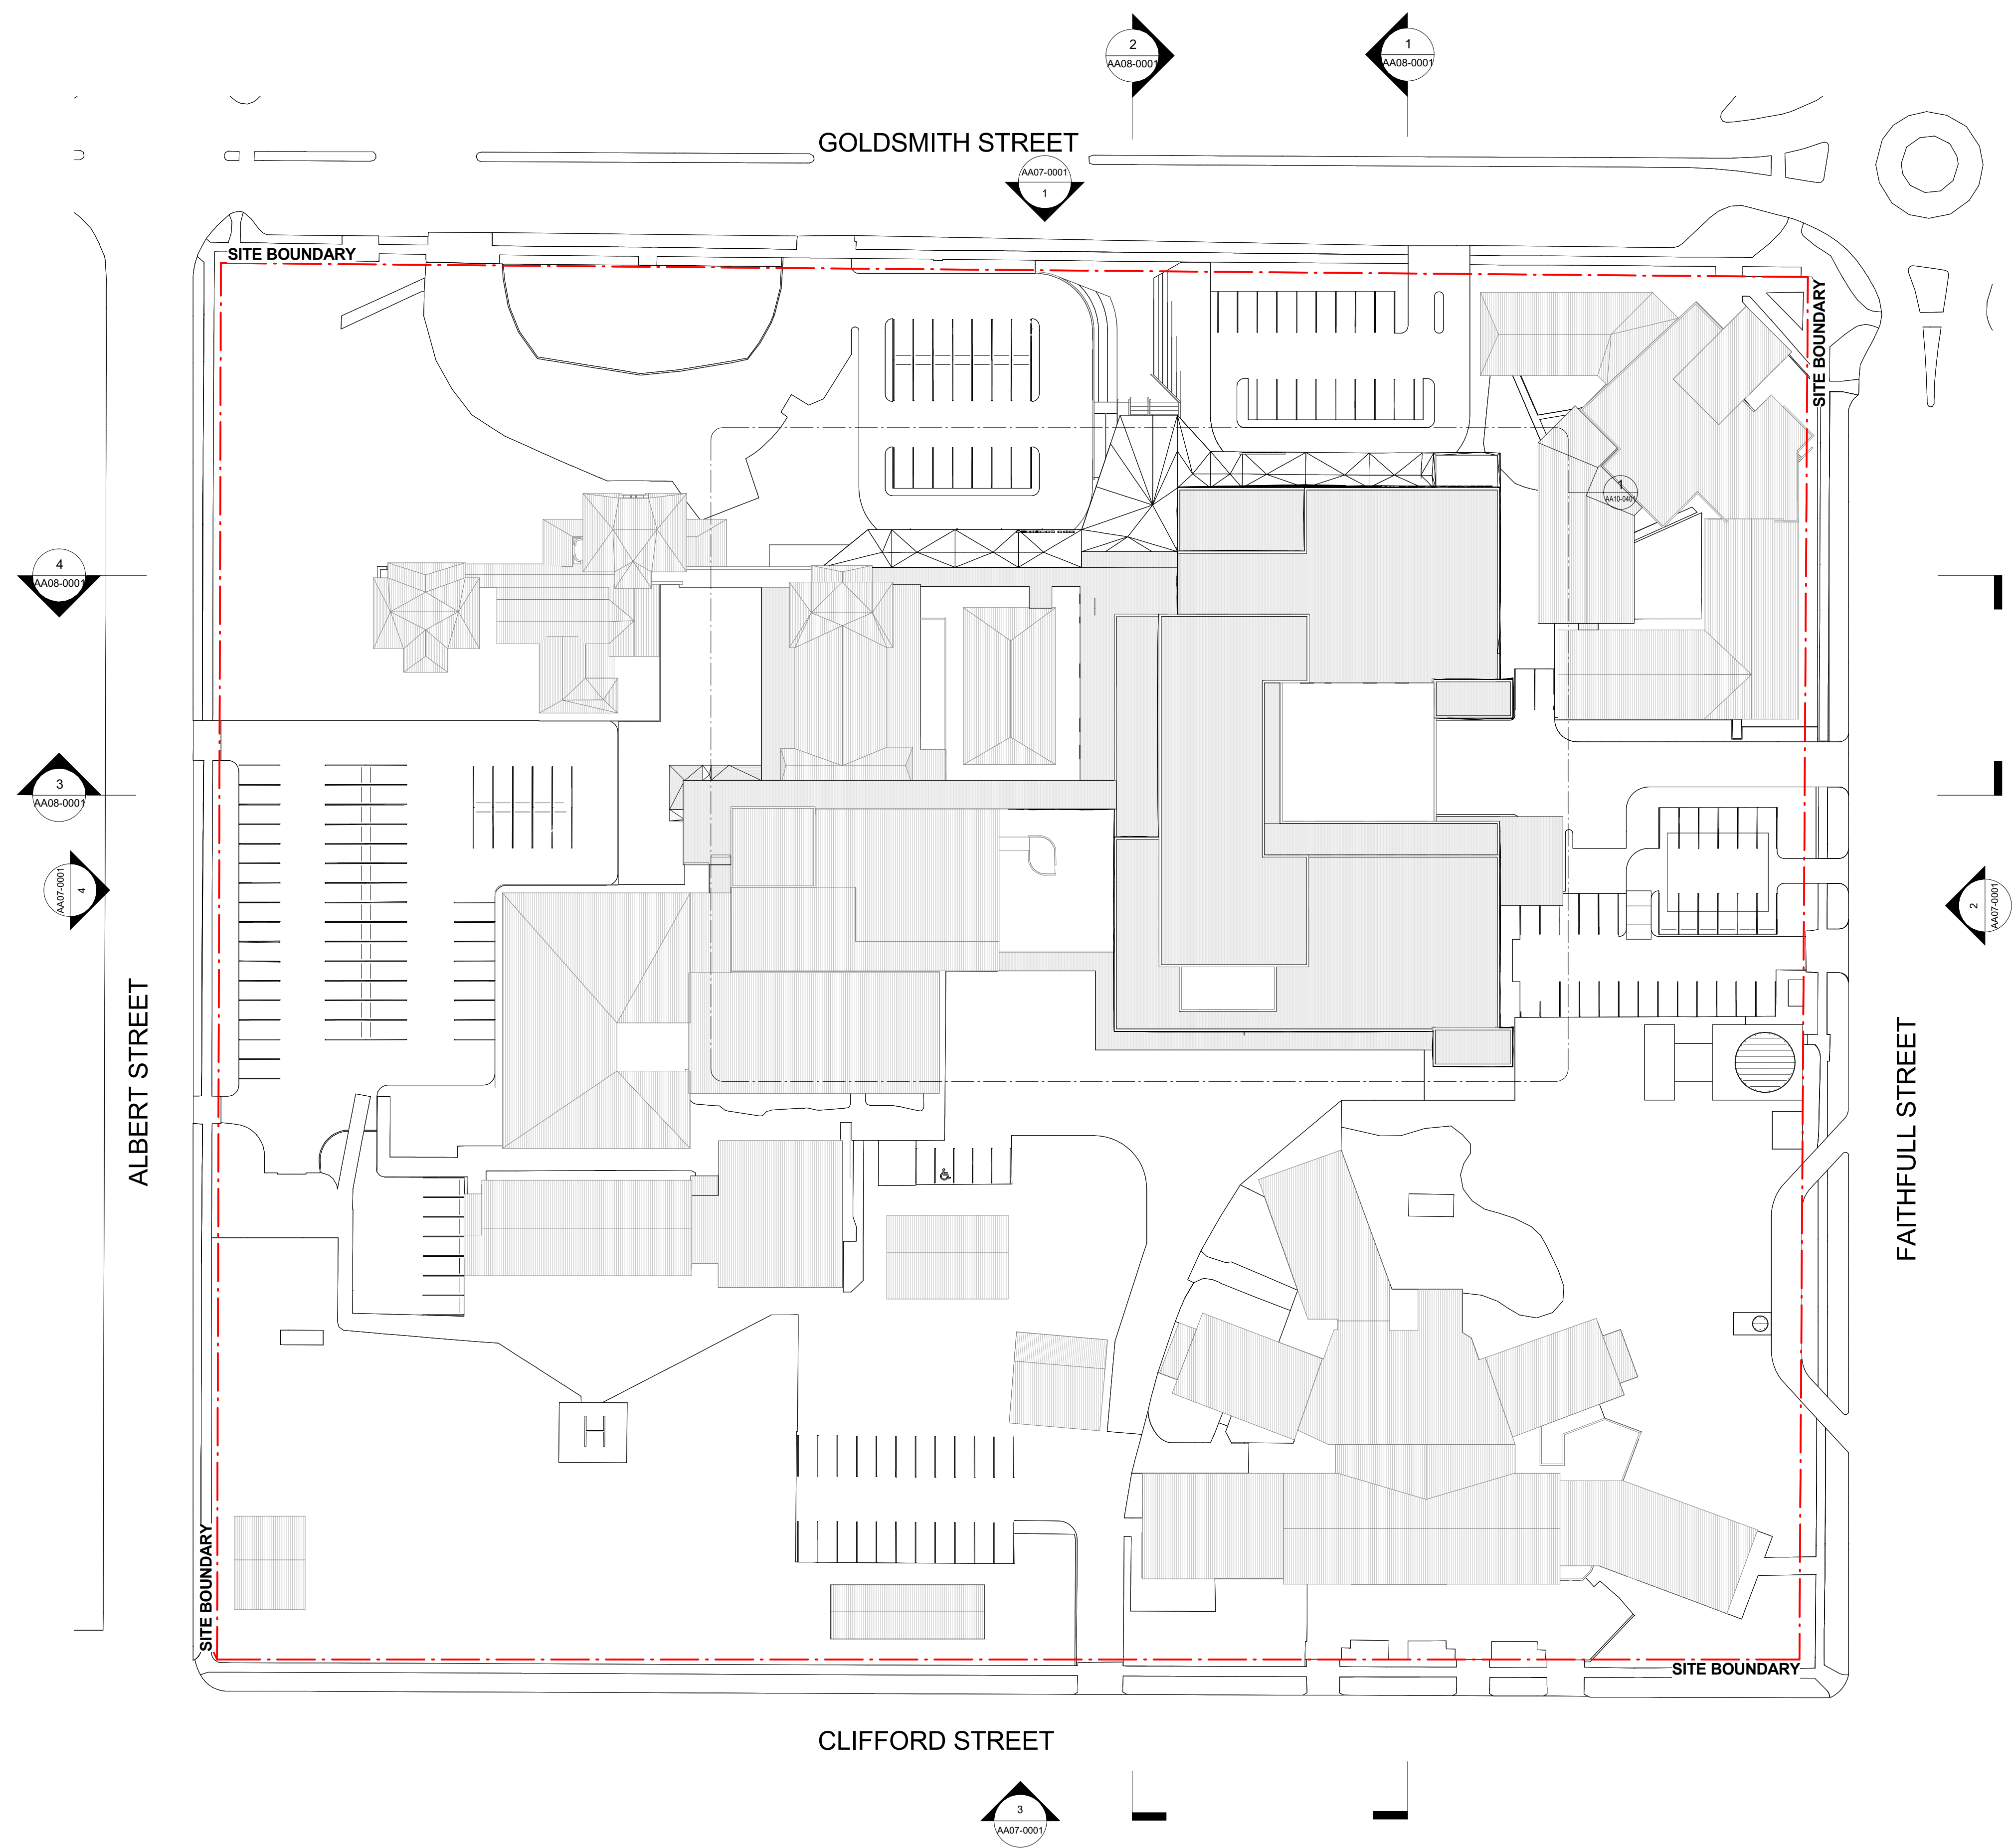

1 PROPOSED PRECINCT PLAN - ROOF
1:500

D	ISSUE FOR SSDA	25.09.17
C	FINAL SD ISSUE	21.07.17
B	FROZEN PLAN	13.07.17
A	IC3	22.06.17
REV		

NSW GOVERNMENT
Health Infrastructure
14/77 Pacific Hwy,
North Sydney,
NSW 2060
T +61 2 9978 5402
www.himfra.health.nsw.gov.au/
PROJECT DIRECTOR
HEALTH INFRASTRUCTURE
PROJECT MANAGER
TSA MANAGEMENT
ARCHITECT
BILLARD LEECE PARTNERSHIP
STRUCTURAL ENGINEER
BONACCI GROUP
ELECTRICAL, ICT AND SECURITY SERVICES ENGINEER
WOOD AND GRIEVE ENGINEERS
HYDRAULICS & FIRE ENGINEERING
GHD
BUILDING SUPERVISOR
BM+G
MECHANICAL ENGINEER
TTW
CONSULTANT

Billard Leece Partnership Pty Ltd
Architects & Urban Planners
Studio 201, 50 Holt Street
Sunny Hills 2010
NSW Australia
T +61 2 8096 4066
E info@blp.com.au
www.blp.com.au

PROJECT
GOULBURN
HOSPITAL &
HOSPITAL SERVICES
REDEVELOPMENT
DESCRIPTION
PROPOSED PRECINCT
PLAN - ROOF

Project No	15614
Scale	1:500@A1
Date	13/06/2017
Drawn By	LG
Checked By	LG
Drawing No	Revision
AA06-0401	D