


03/09/2020 5:45:57 PM

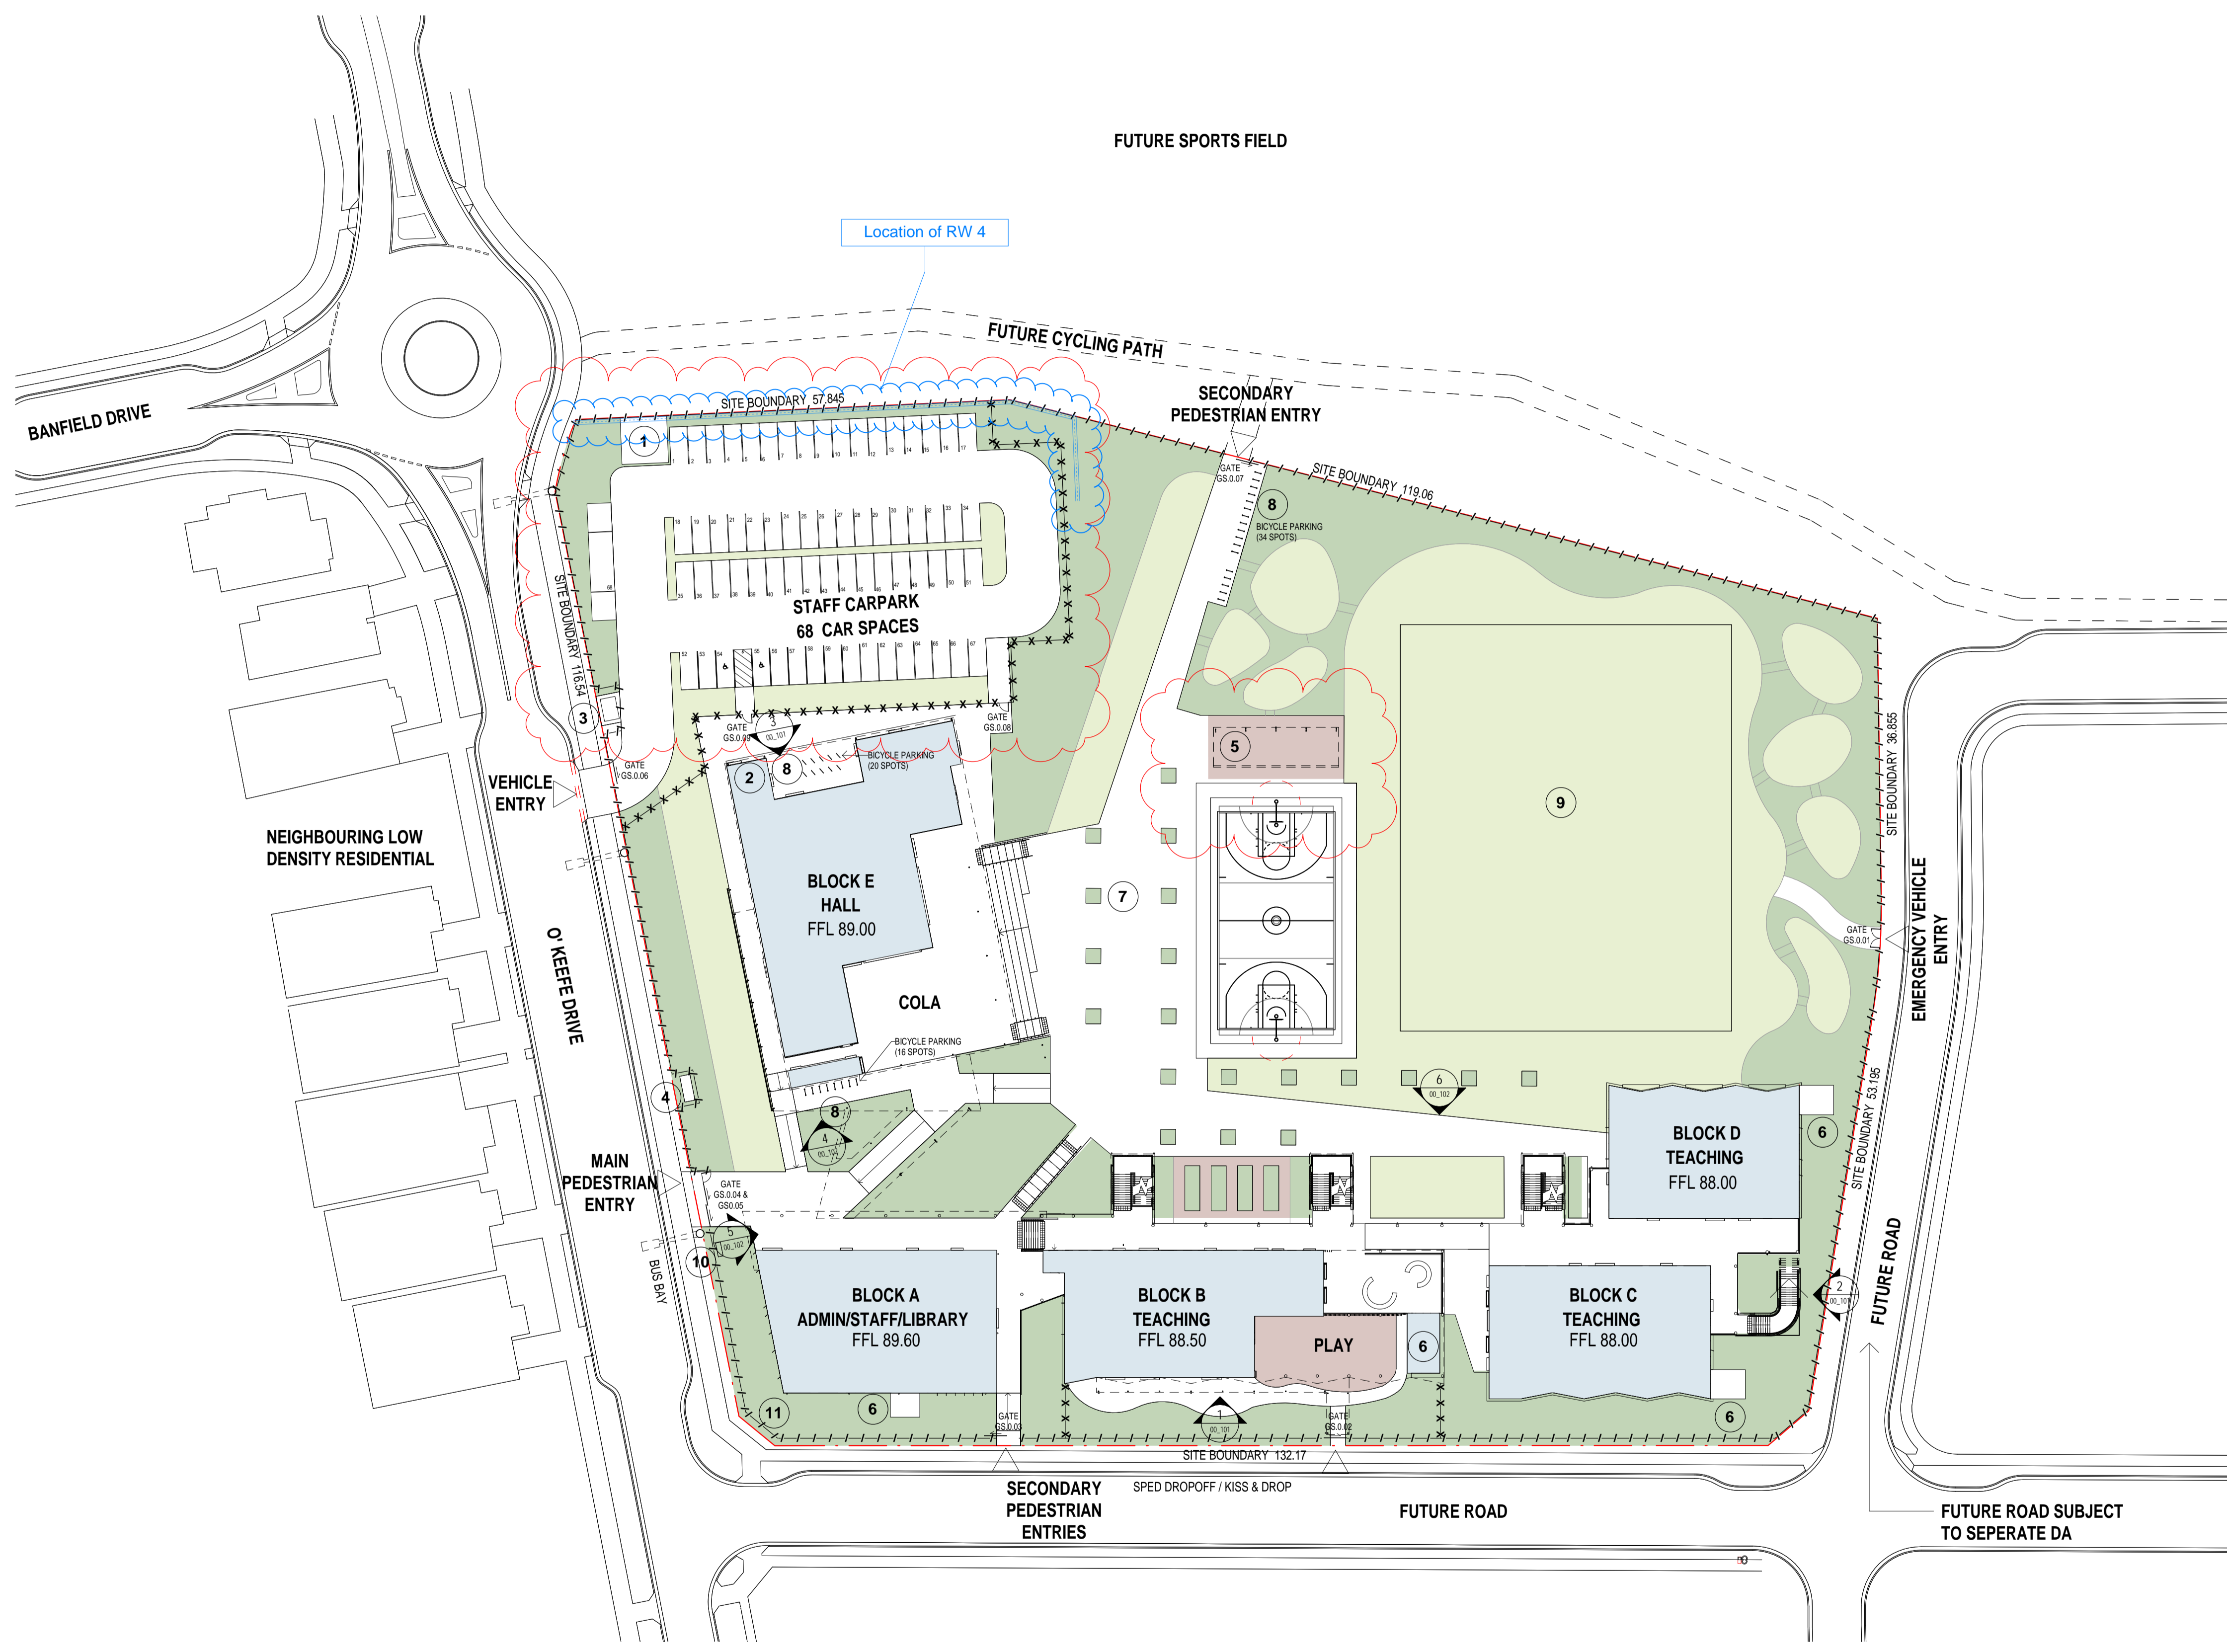

**SITE SERVICES**

NUMBER	DESCRIPTION
1	WASTE PAD
2	MAIN SWITCHBOARD ROOM
3	SUBSTATION
4	PUMPS
5	SHADE STRUCTURE
6	PLANT WITH SCREEN
7	ASSEMBLY
8	BICYCLE PARKING (TOTAL OF 60 SPOTS)
9	SPORTS FIELD
10	MAIN SCHOOL SIGN
11	FUTURE ELECTRIC SCHOOL SIGN

--- SITE BOUNDARY  
 - - - - - FENCE LINE - 2.1m HIGH DIPLOMAT PALISSADE FENCE TYPE.  
 \* \* \* \* \* FENCE LINE - 1.2m

**NOTE:**  
 REFER TO LANDSCAPE ARCHITECT DRAWINGS FOR MORE INFORMATION

**AMMENDMENTS**

REV	BY	DATE	DESCRIPTION
A	VL	13.08.19	PRELIMINARY ISSUE FOR REVIEW
B	RO	11.02.20	ISSUE FOR RTS - BICYCLE PARKING NOTE ADDED, LEGEND, AWNING & PLAYSPACE AMENDED & STAIR MOVED
C	HS	10.03.20	ISSUE FOR RTS - CAR & BIKE PARKING AMENDED
D	SJ	29.04.20	ISSUE FOR RTS - CAR PARKING NUMBERS ADDED, SHADE STRUCTURE AMENDED
E	PN	03.09.20	ISSUE FOR MOD 1 - REFERENCE ONLY

**LEGEND**

CON	CONCRETE	MR1a	METAL ROOFING, COLOUR A - UPPER LEVEL
CFC1	CLADDING CFC, NEUTRAL COLOUR	MR1b	METAL ROOFING, COLOUR B - LOWER LEVEL
CFC2a	CLADDING CFC, FEATURE COLOUR A	PC-b	POWDERCOAT, FEATURE COLOUR B
CFC2b	CLADDING CFC, FEATURE COLOUR B	PC-e	POWDERCOAT, FEATURE COLOUR E
CFC2c	CLADDING CFC, FEATURE COLOUR C	PC-f	POWDERCOAT, FEATURE COLOUR F
DP	DOWNPIPE	PMS	PERFORATED MESH SCREEN
LV1	ALUMINIUM LOUVRES - TYPE 1		
LV2	ALUMINIUM LOUVRES - TYPE 2		
	ISSUE FOR METAL WALL CLADDING, COLOUR B&D, SHADE STRUCTURE AMENDED/MC1b		

**HANSEN YUNCKEN**

NSW GOVERNMENT Education

STRUCTURAL CIVIL  
NORTHROP ENGINEERS  
(02) 9241 4188  
MECHANICAL ELECTRICAL  
STEINSEN WARMING  
(02) 9967 2200

HYDRAULIC  
WOOLACOTT'S  
(02) 8241 9900

FIRE  
MCD FIRE ENGINEERING  
(04) 2392 2245

PERUMAL PEDAVOLI ARCHITECTS

T: 02 9291 0000  
WEB: www.ppa.com.au

Nominated Architect:  
Vince Pedavoli NSW reg No.5045

LANDSCAPE ARCHITECT  
TAYLOR BRAMMER LANDS. ARCH.  
(02) 9387 8855

**PERUMAL PEDAVOLI ARCHITECTS**

CATHERINE FIELD PS  
O'KEEFE DRIVE, ORAN PARK, NSW, 2570  
NEW HIGH QUALITY CLASSROOMS PACKAGE 2

DRAWING NAME  
**SITE PLAN**

PROJECT NORTH

0 5000 10000 15000 20000 25000 30000  
SCALE 1:500 @ A1

DRAWN	CHECKED	VERIFIED	DATE
HS	KLC	SR	03 SEPT 2020

DRAWING NUMBER: NHQC2 - CF - AR - SSDA - 00\_002

REVISION: E

FOR COORDINATION ONLY - NOT FOR CONSTRUCTION