


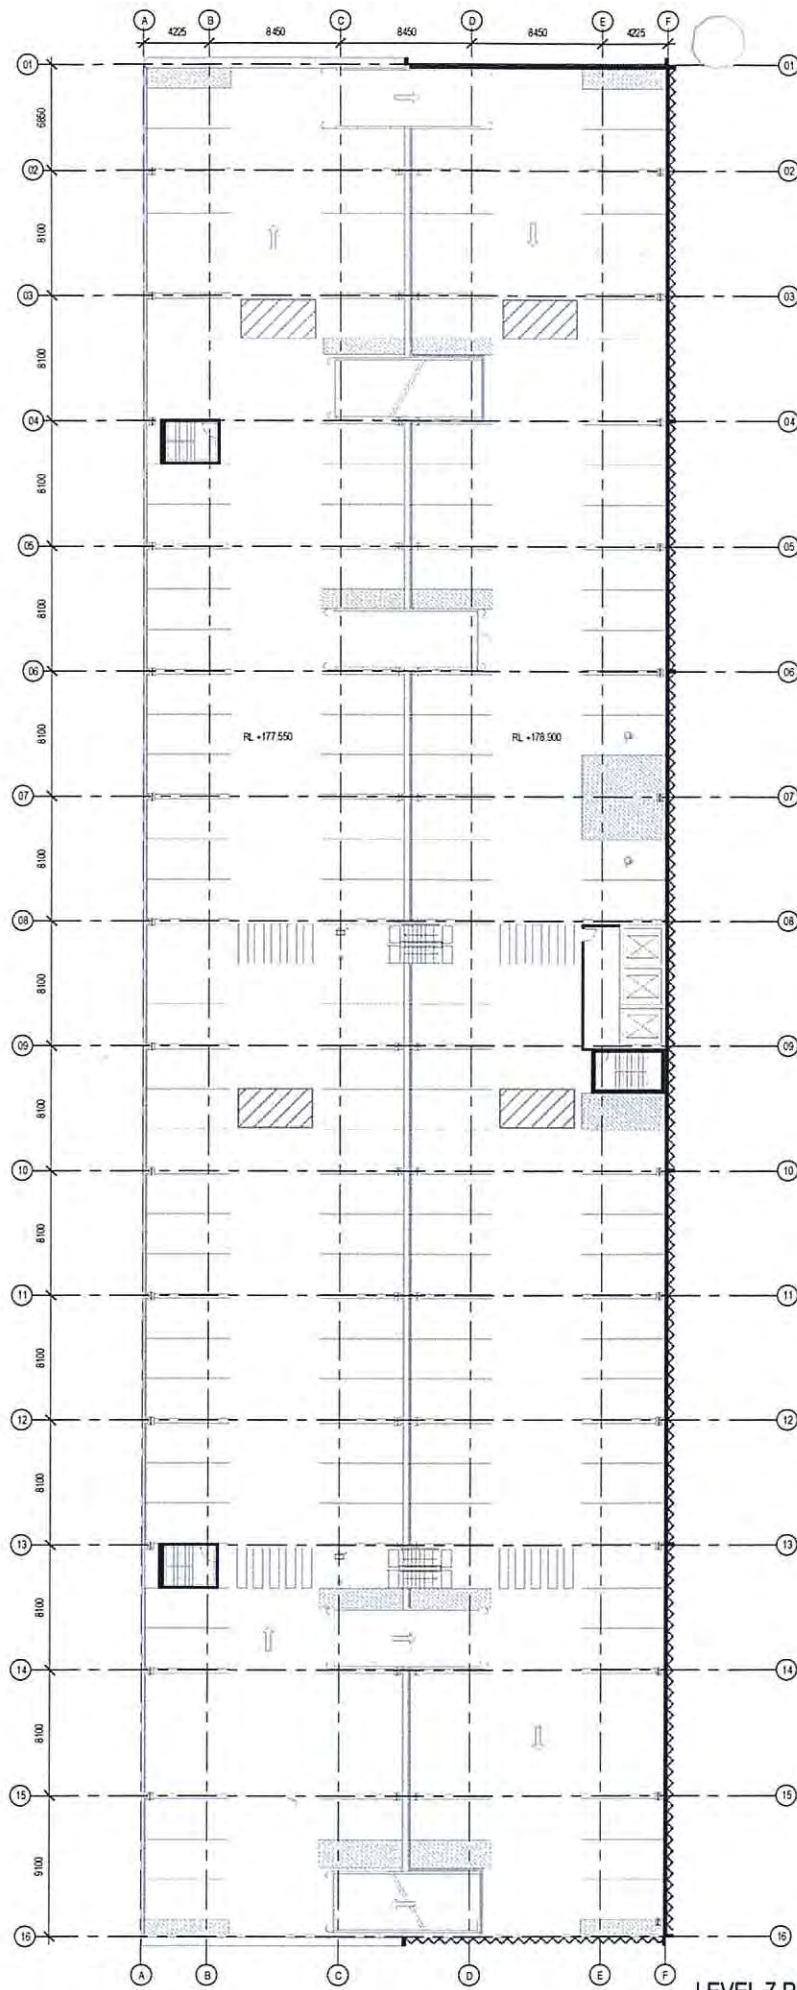

LEVEL 7 PUBLIC PARKING

NSW GOVERNMENT
Planning

Issued under the Environmental Planning and Assessment Act 1979

Approved Application No. **SSI 6792**

granted on the **29/06/15**

Signed **[Signature]**


Sheet No. **23** of **45**

Parking Numbers	
Type	Count
Accessible	2
Public	142
LEVEL 7	144
Accessible	2
Public	142
LEVEL 6	144
Accessible	2
Public	142
LEVEL 5	144
Accessible	2
Public	142
LEVEL 4	144
Accessible	2
Public	142
LEVEL 3	144
Accessible	2
Public	142
LEVEL 2	144
Accessible	2
Public	142
LEVEL 1	144
Accessible	2
Public	26
Staff	30
LEVEL G	58
Accessible	2
Staff	139
LEVEL B1	141
Accessible	2
Staff	12
LEVEL B2	141
Grand total	1346




MATERIALS LEGEND

- A LOCKER ATMOSPHERE FOLDED PERFORATED MESH OR EQUAL
- B LOCKER ATMOSPHERE PERFORATED MESH OR EQUAL
- C WHITE GLAZED BRICK
- D STAINLESS STEEL CABLE CLIMBERS
- E FLAT PLATE STEEL BARRIER
- F CYCLONE MESH FULL HEIGHT FENCING

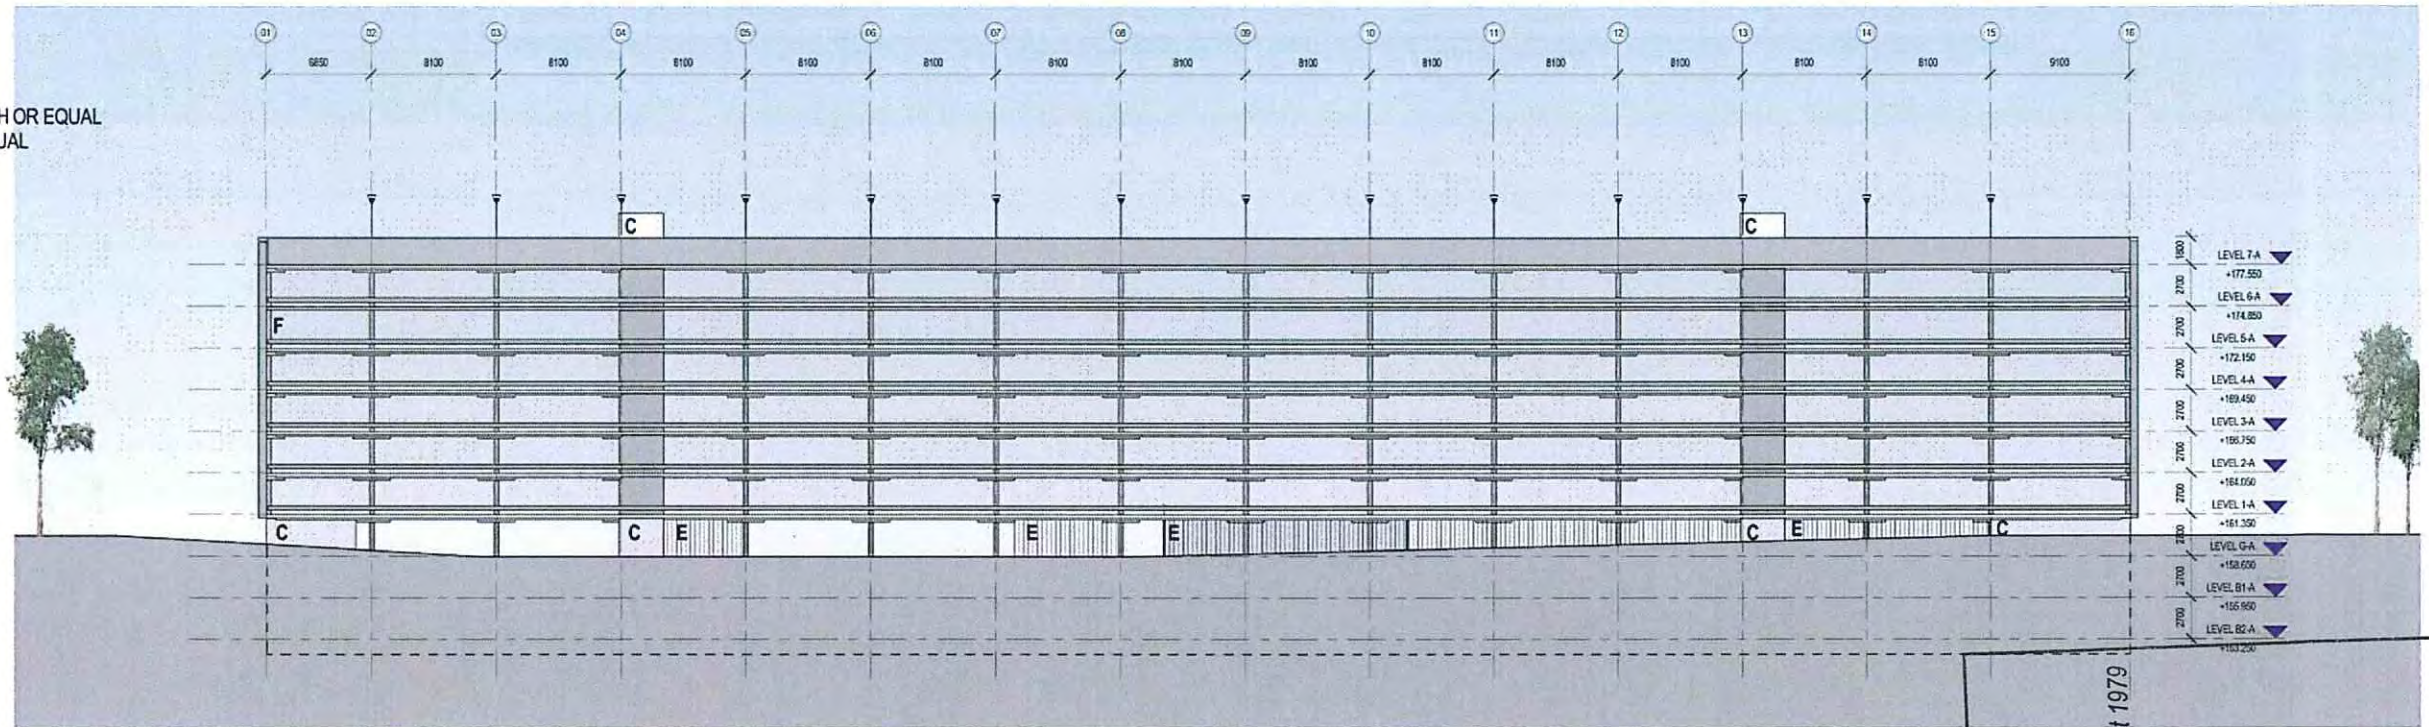

WEST ELEVATION

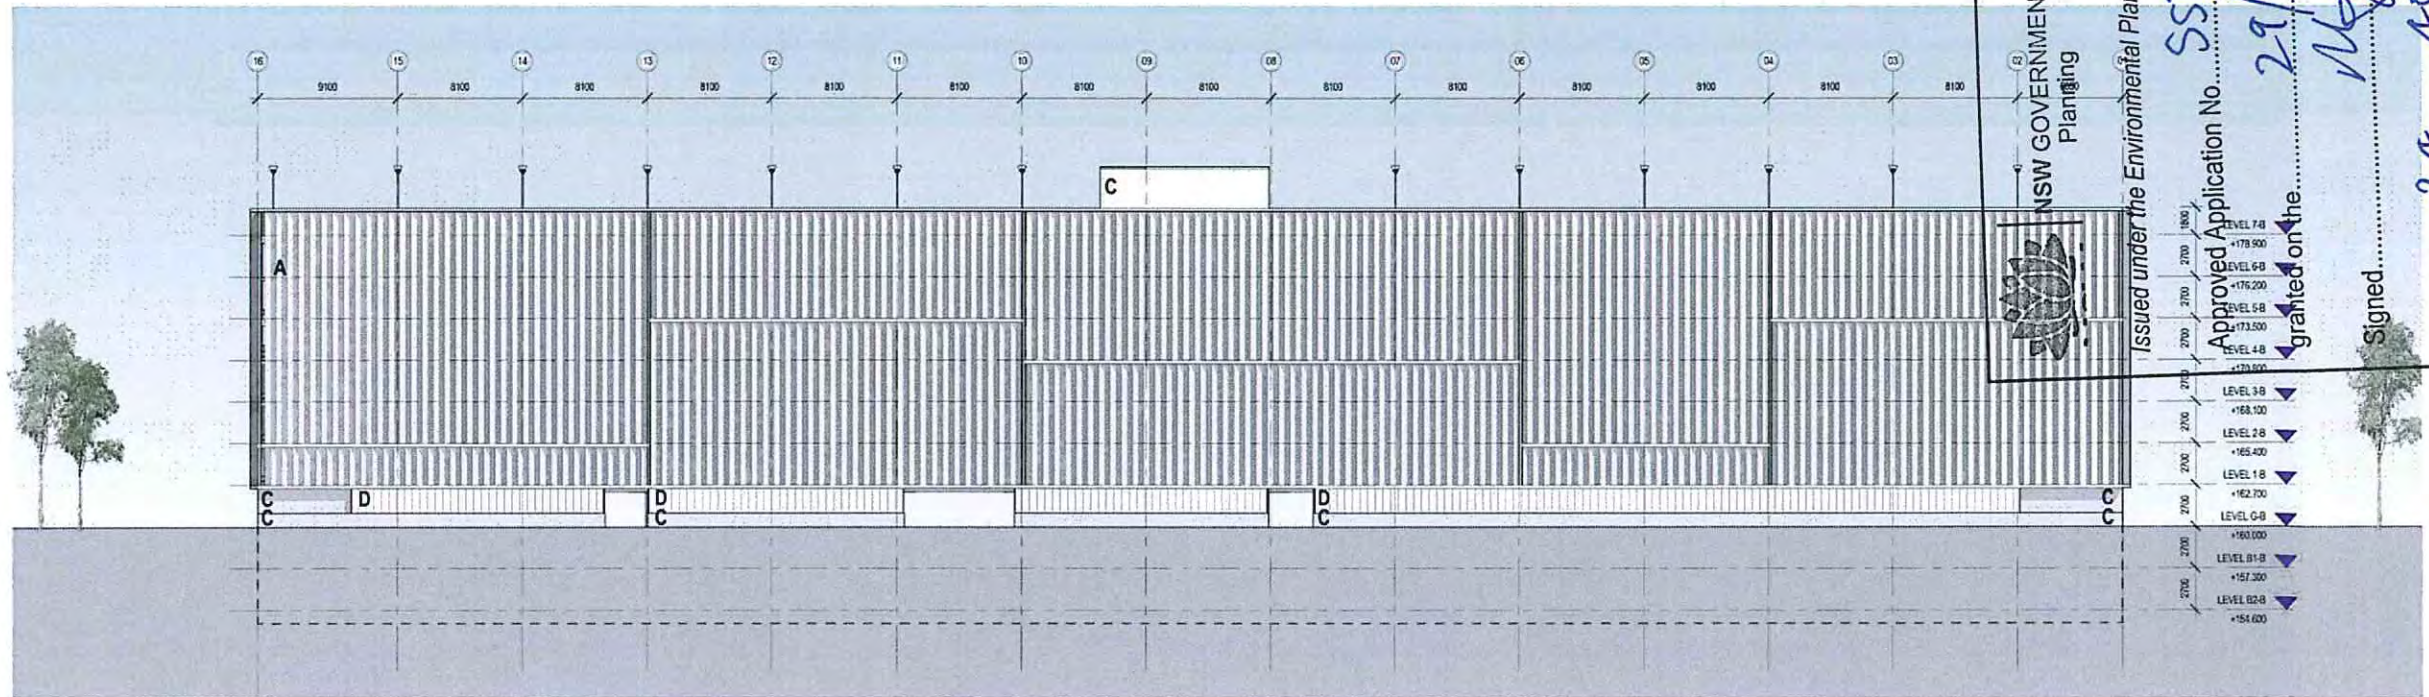

EAST ELEVATION

NSW GOVERNMENT
Planning



Issued under the Environmental Planning and Assessment Act 1979

Approved Application No. **SSI 6792**


granted on the **29/06/15**

Signed **[Signature]**


Sheet No. **24** of **45**

MATERIALS LEGEND

A LOCKER ATMOSPHERE FOLDED PERFORATED MESH OR EQUAL
 B LOCKER ATMOSPHERE PERFORATED MESH OR EQUAL
 C WHITE GLAZED BRICK
 D STAINLESS STEEL CABLE CLIMBERS
 E FLAT PLATE STEEL BARRIER
 F CYCLONE MESH FULL HEIGHT FENCING

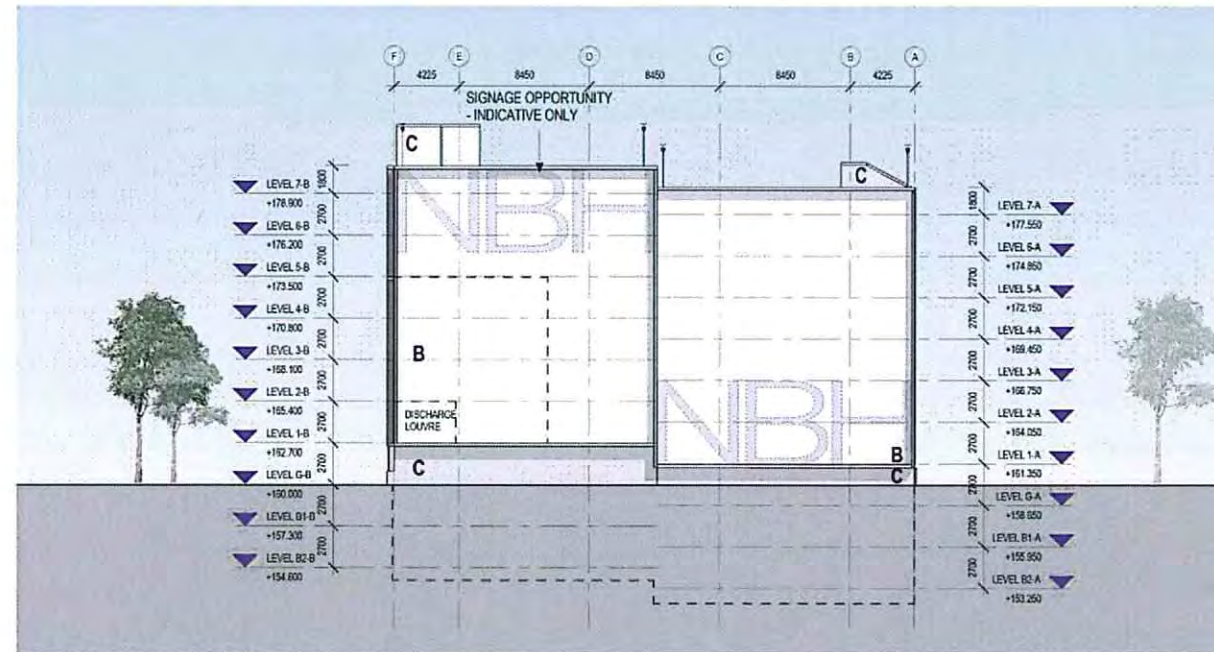

NORTH ELEVATION

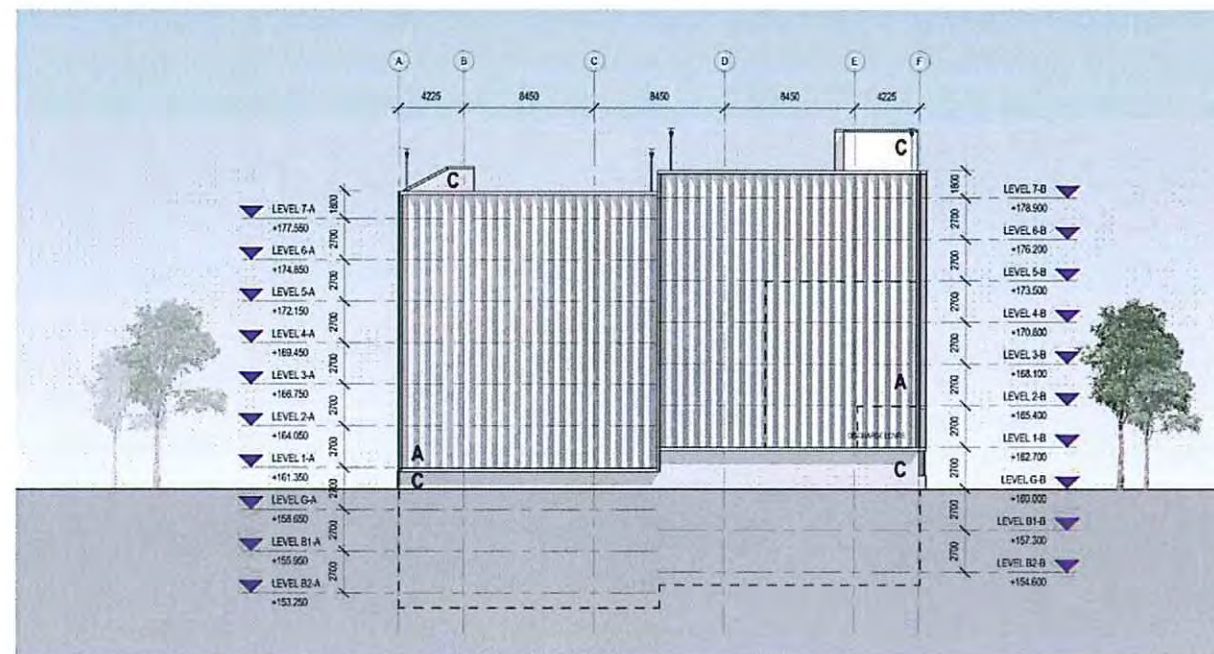

SOUTH ELEVATION

NSW GOVERNMENT
 Planning


Issued under the Environmental Planning and Assessment Act 1979

Approved Application No. SSI 6792

granted on the 29/06/15

Signed [Signature]

Sheet No. 25 of 45

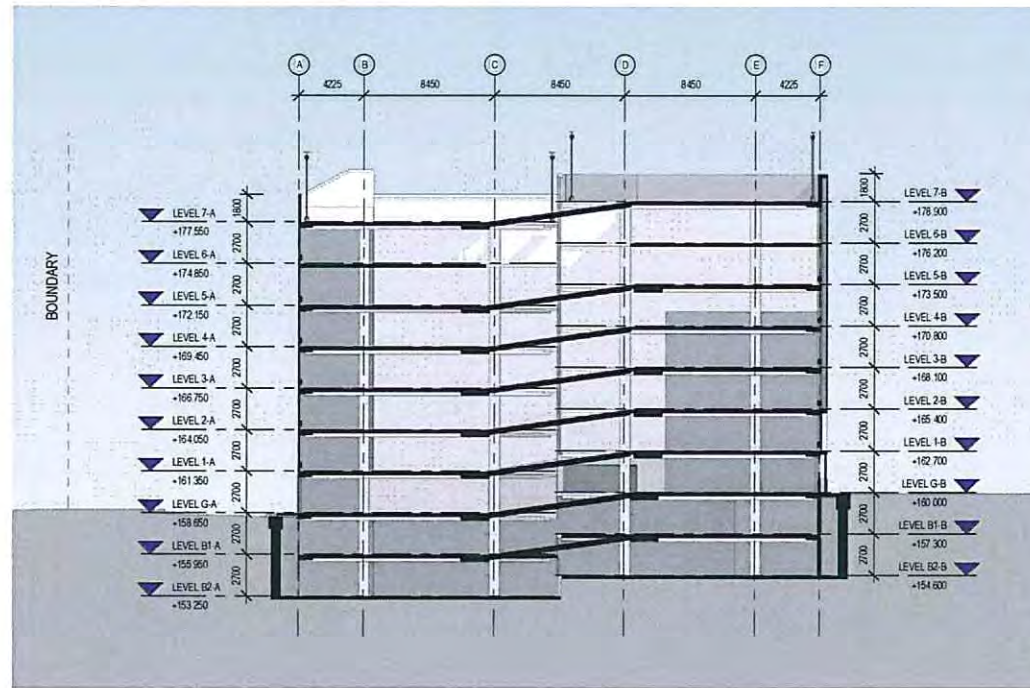

SECTION

NSW GOVERNMENT
Planning

Issued under the Environmental Planning and Assessment Act 1979

Approved Application No. SSI 6792

granted on the 29/06/15

Signed [Signature]

Sheet No. 26 of 45

PRECINCT/ CAMPUS WIDE


DRAWING SCHEDULE

APC.PCT.LAN.ALL.200	COVERSHEET
APC.PCT.LAN.EXT.201	MASTERPLAN
APC.PCT.LAN.EXT.202	PRECINCT PLAN
APC.PCT.LAN.EXT.203	PLANTING PLAN
APC.PCT.LAN.EXT.204	PLANTING PALETTE
APC.PCT.LAN.EXT.205	LANDSCAPE PLAN
APC.PCT.LAN.EXT.206	LANDSCAPE PLAN
APC.PCT.LAN.EXT.207	LANDSCAPE PLAN
APC.PCT.LAN.EXT.208	LANDSCAPE PLAN
APC.PCT.LAN.SEC.400	LANDSCAPE SECTIONS
APC.PCT.LAN.SEC.401	LANDSCAPE SECTIONS
APC.GEN.LAN.DET.600	TYPICAL DETAILS
APC.GEN.LAN.DET.601	TYPICAL DETAILS
APC.GEN.LAN.DET.602	TYPICAL DETAILS

LEGEND

SYMBOL	ITEM
	Site Boundary
	Paving Type 1 Concrete Unit paver - Pedestrian
	Paving Type 2 Concrete Unit paver - Trafficable
	Paving Type 3 Exposed aggregate concrete
	Ballast Type 1
	Ballast Type 2
	Wall Type 1 Stone Entrance Wall
	Wall Type 2 Insitu Concrete Wall 500mm H
	Bollard Type 1 900mm H Steel Bollard
	Seat Type 2 Timber Bench Seating
	Turf
	Native Grass Baiter Hydroseeded
	Garden Bed Type 1 On grade
	Garden Bed Type 3 Raised Planter
	Garden Bed Type 4 Carpark Planter
	Swale
	New Trees/Palms

NOTE:
REFER TO DRAWINGS DWG.GEN.LAN.AA.DET.00.001- 003
FOR TYPICAL DETAILS

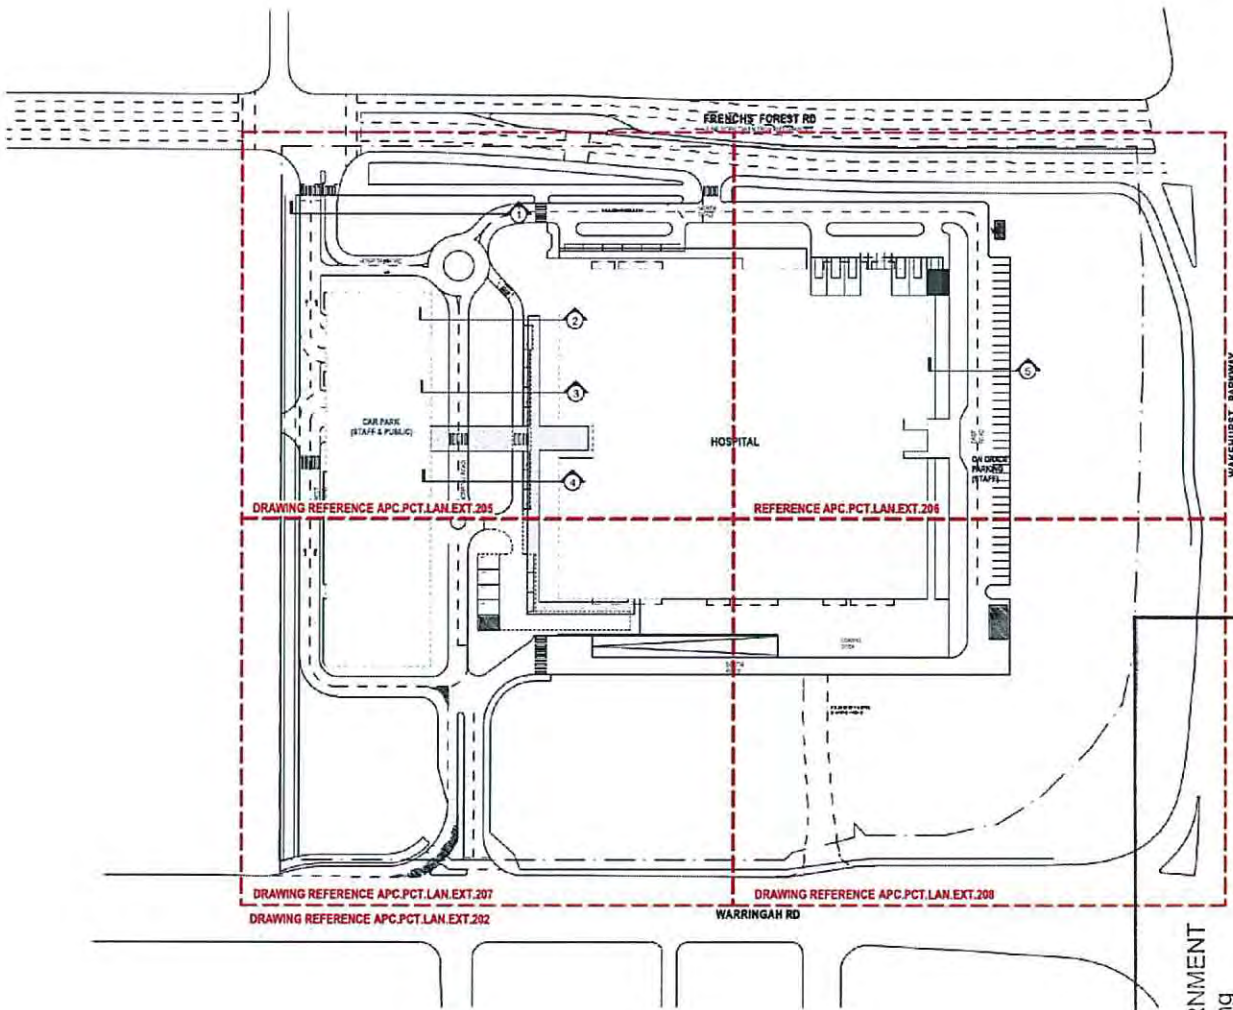

NSW GOVERNMENT
Planning


Issued under the Environmental Planning and Assessment Act 1979

Approved Application No. **SSI 6792**

granted on the **29/06/15**

Signed

Sheet No. **27** of **45**

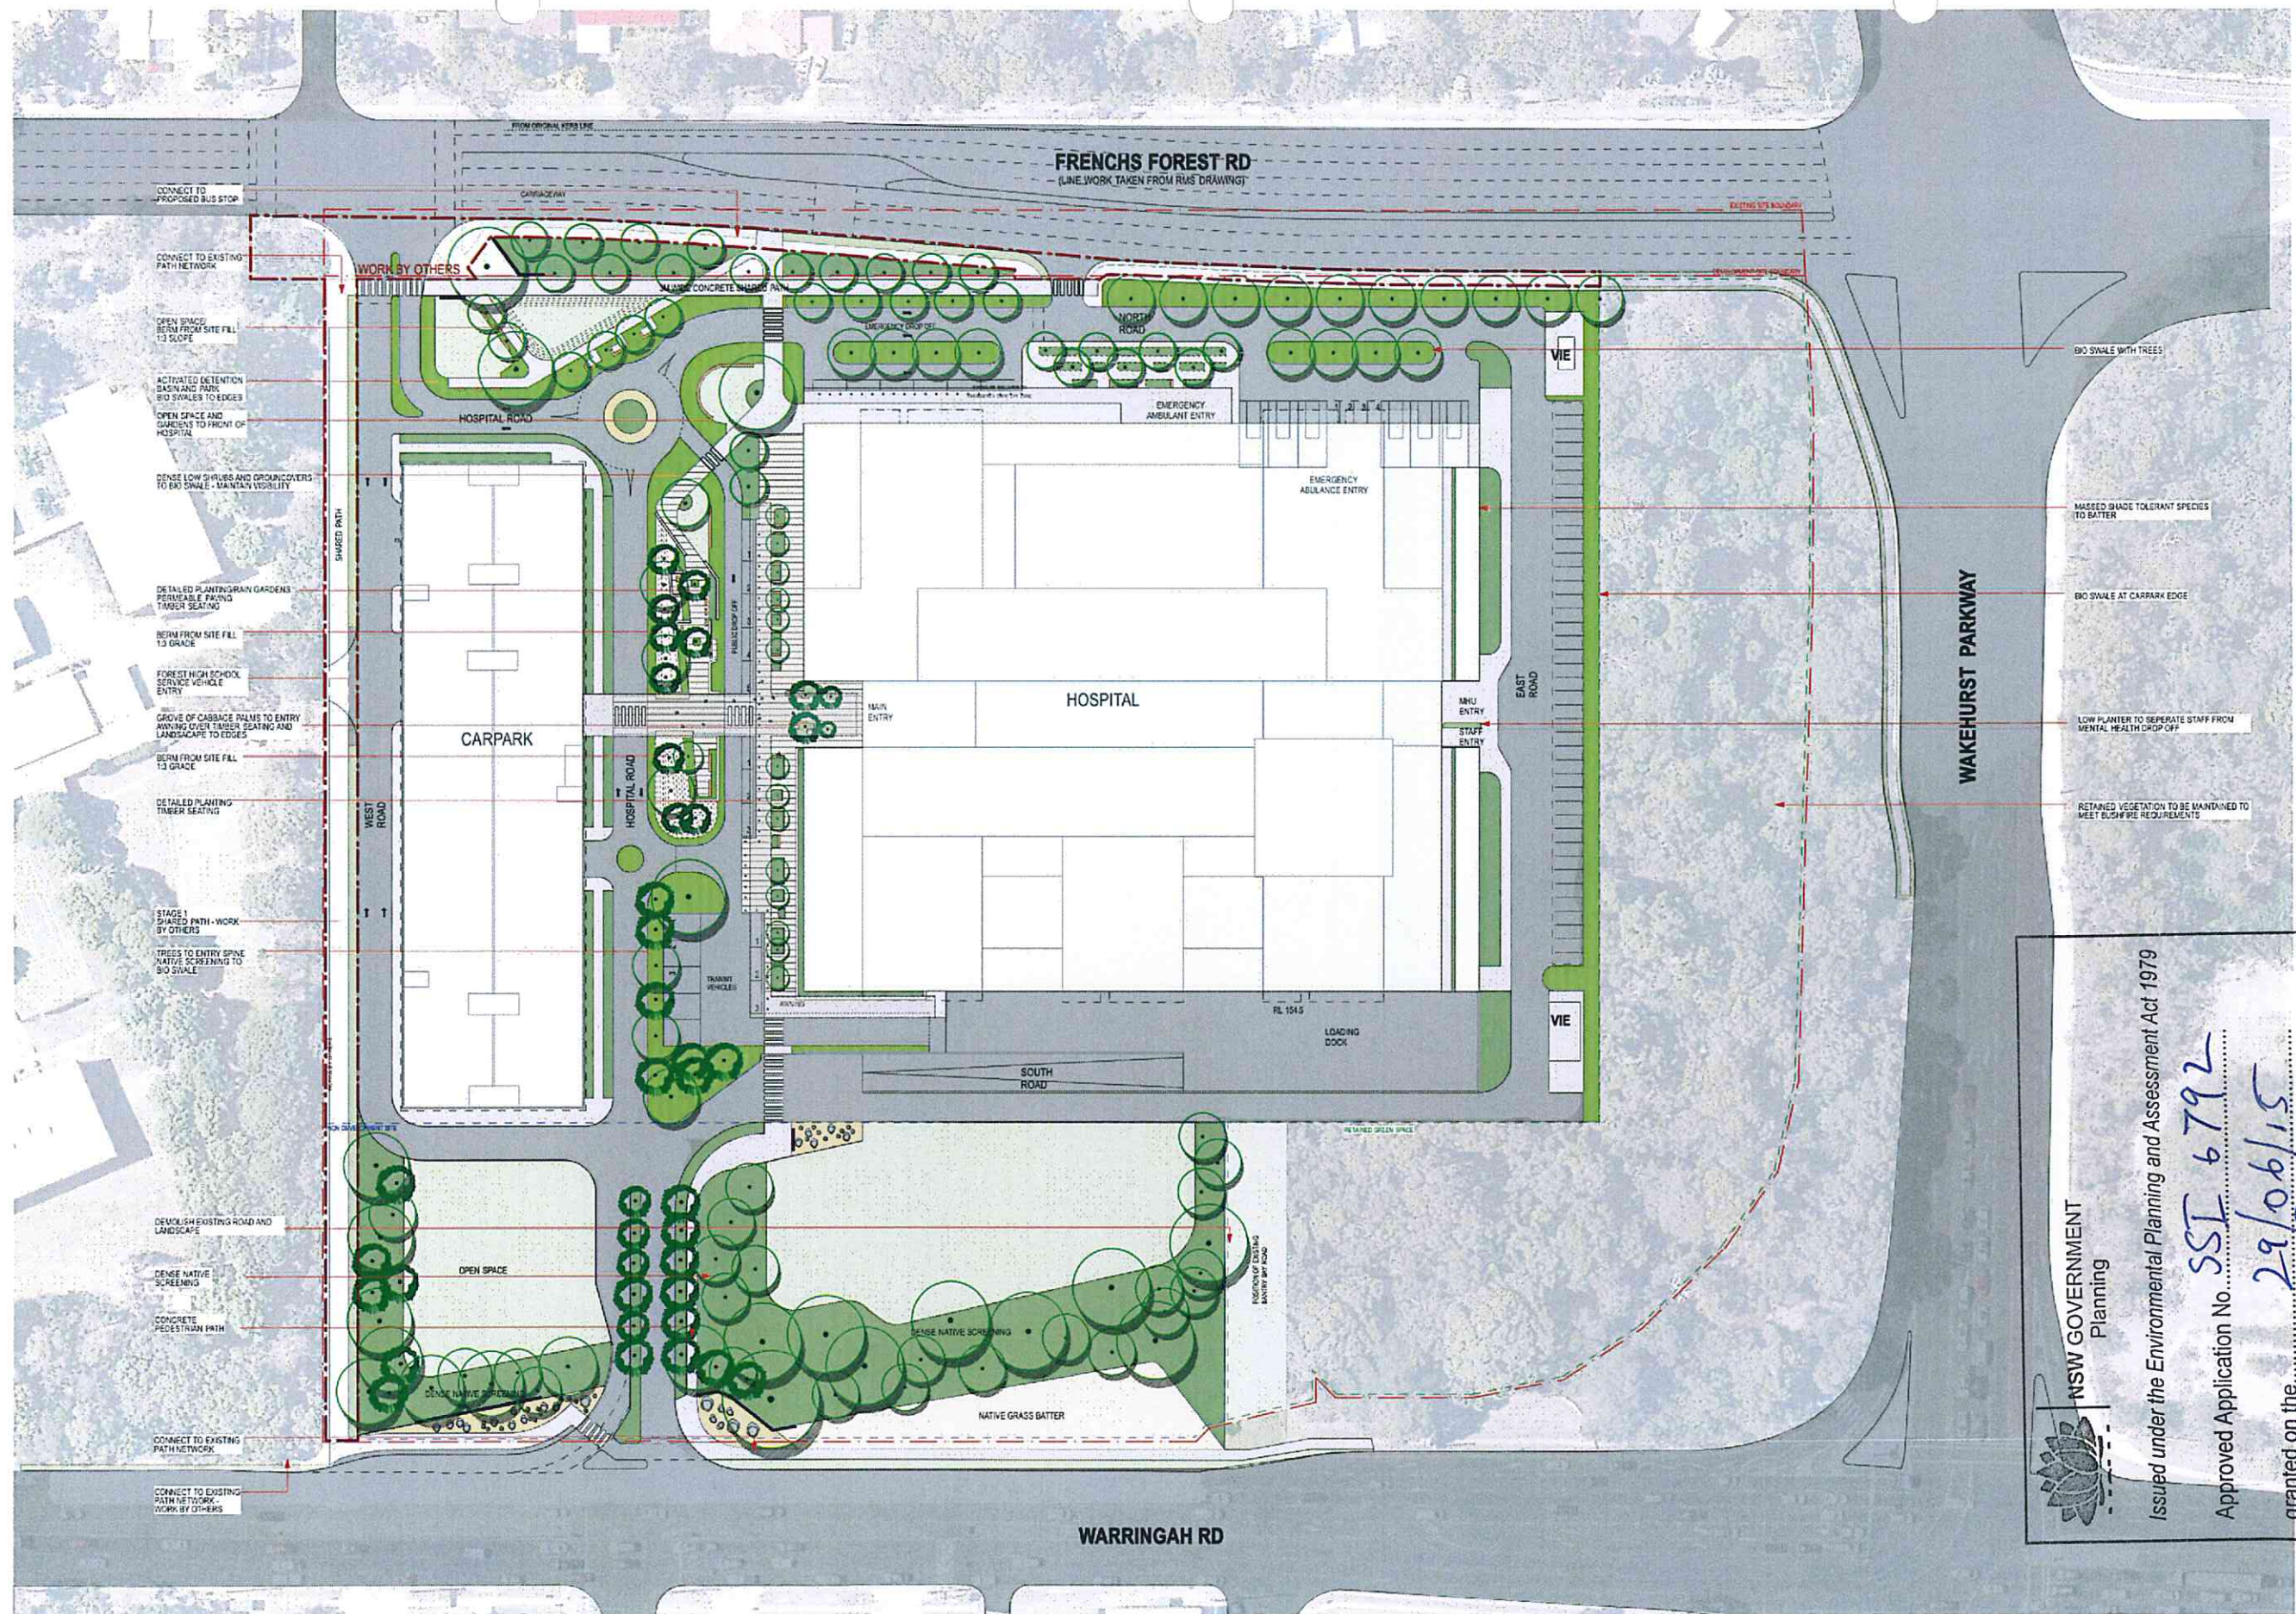

NSW GOVERNMENT
Planning


Issued under the Environmental Planning and Assessment Act 1979

Approved Application No. **SSL 6792**

granted on the **29/06/15**

Signed **[Signature]**

Sheet No. **28** of **45**

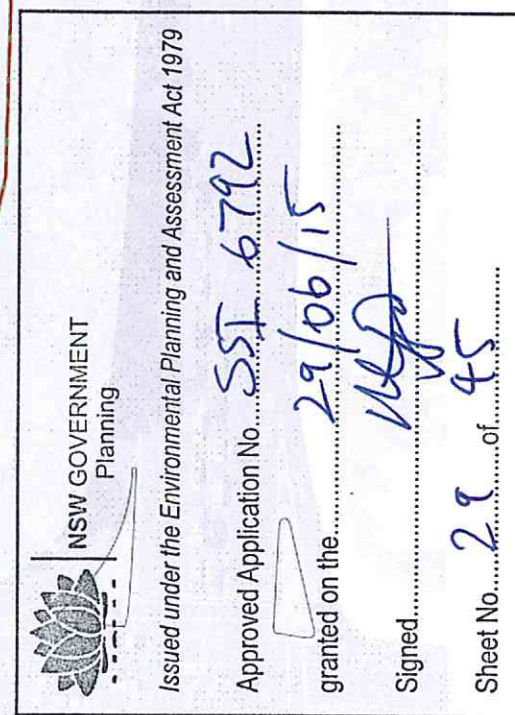

PURPOSE	DATE	DRAWING NO
EIS	13/11/14	APC.PCT.LAN. EXT.203


ZONE 1 - Native Low Growing Grass Meadow



ZONE 2 - Native Perimeter Planting



ZONE 3 - Planted Berms

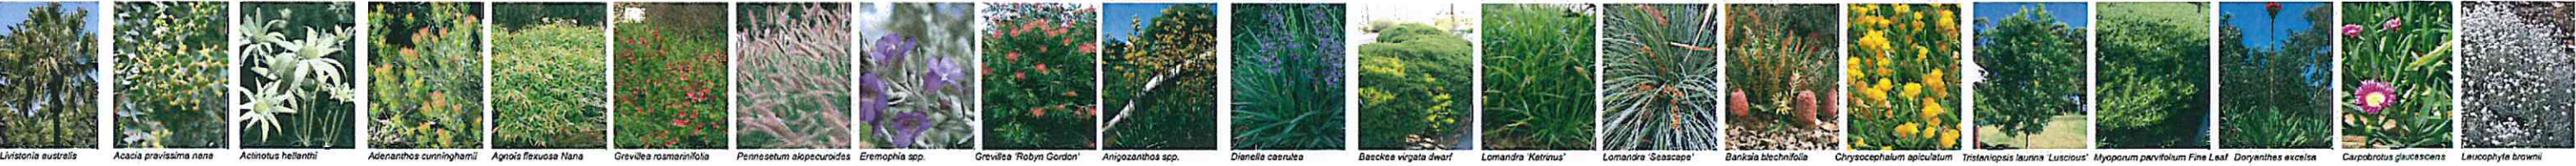

ZONE 4 - Garden Plaza with Rain Gardens




ZONE 5 - Detention Meadow




ZONE 6 - Lawn and Low Growing Grasses




ZONE 7 - Cabbage Palms

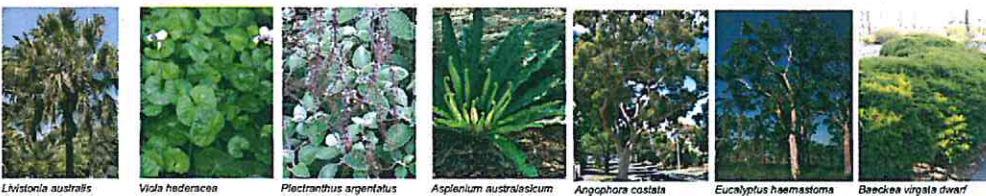

ZONE 8 - Front Entrance Border Planting

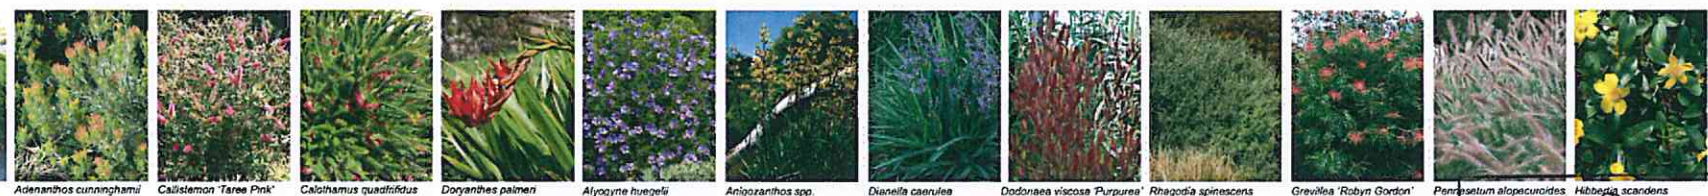

ZONE 9 - Swale Gardens

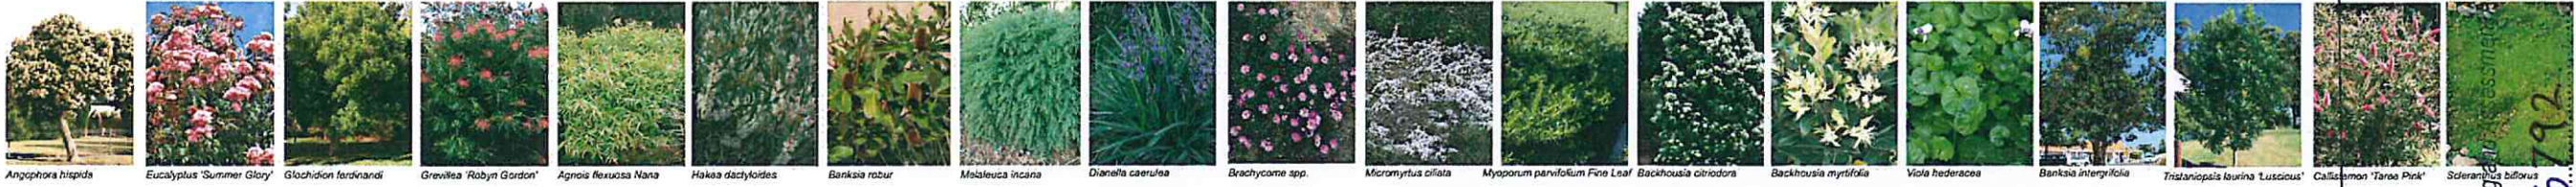

ZONE 10 - Green Zone



ZONE 11




NSW GOVERNMENT
Planning
Issued under the Environmental Planning and Assessment Act 1979

Approved Application No. 551-6-792

granted on the 29/06/15

Signed [Signature]

Sheet No. 30 of 45

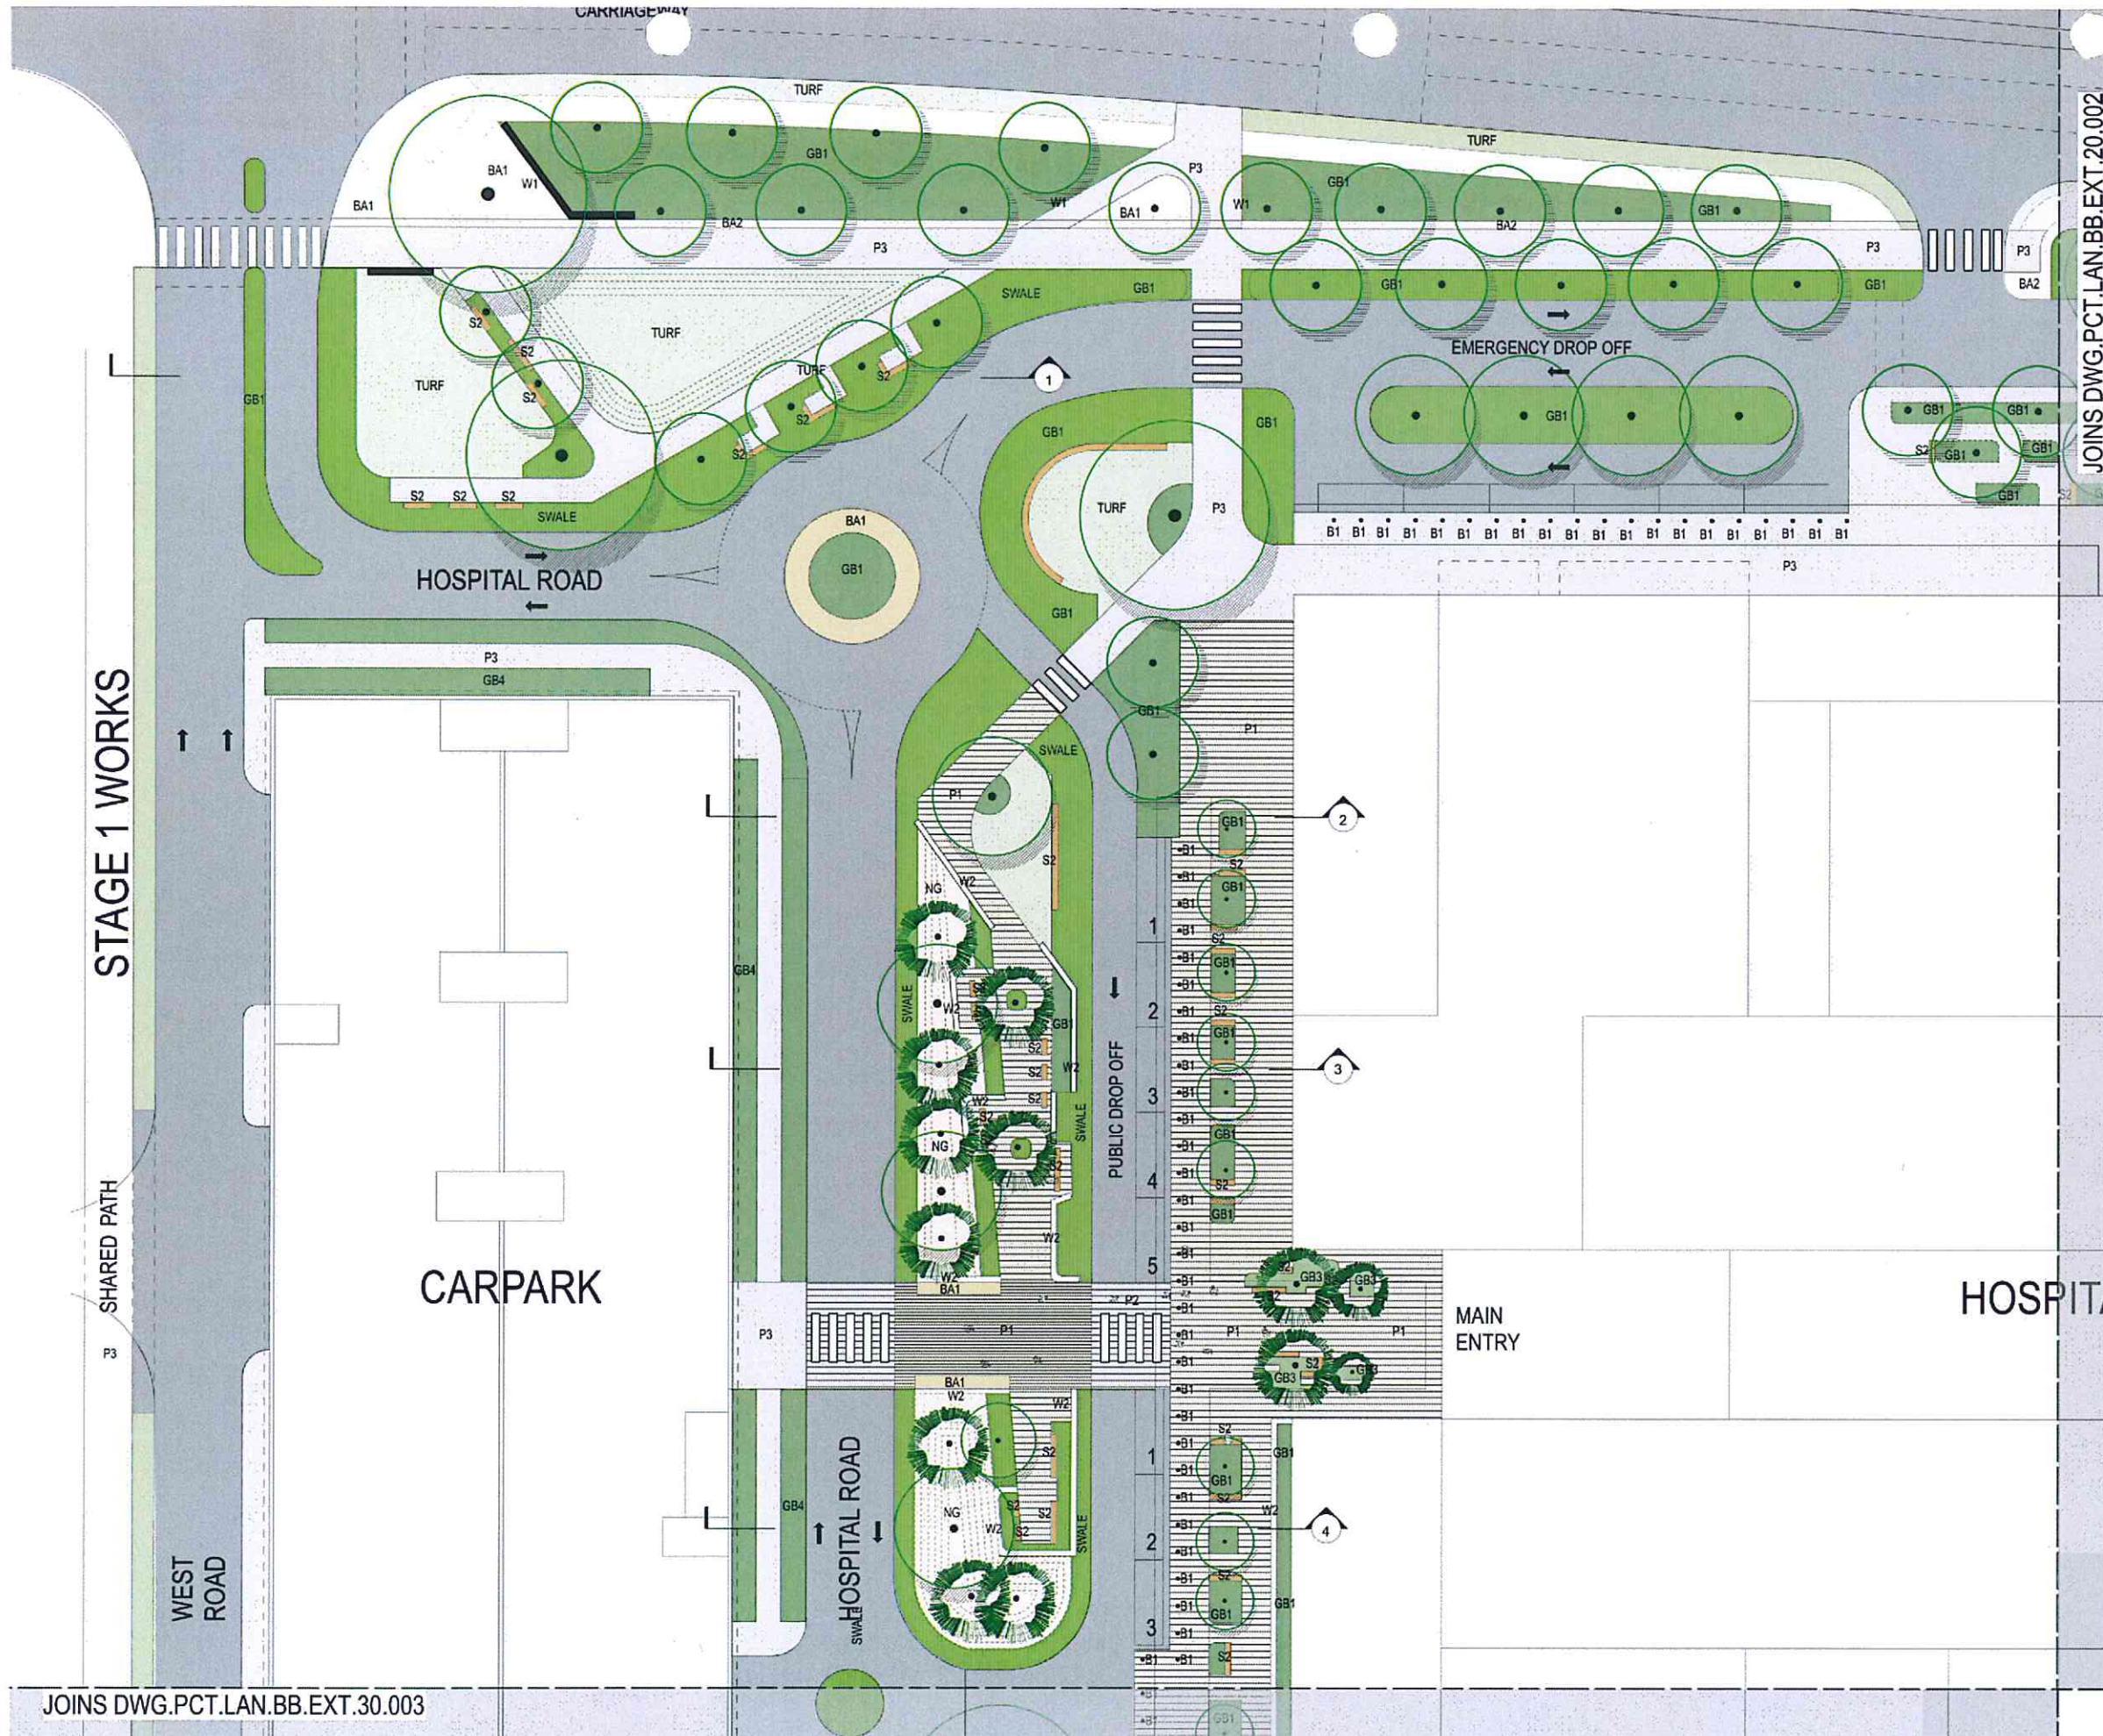

JOINS DWG.PCT.LAN.BB.EXT.20.002

NSW GOVERNMENT
Planning


Issued under the Environmental Planning and Assessment Act 1979

Approved Application No. SSI 6792

granted on the 29/06/15

Signed [Signature]

Sheet No. 31 of 45

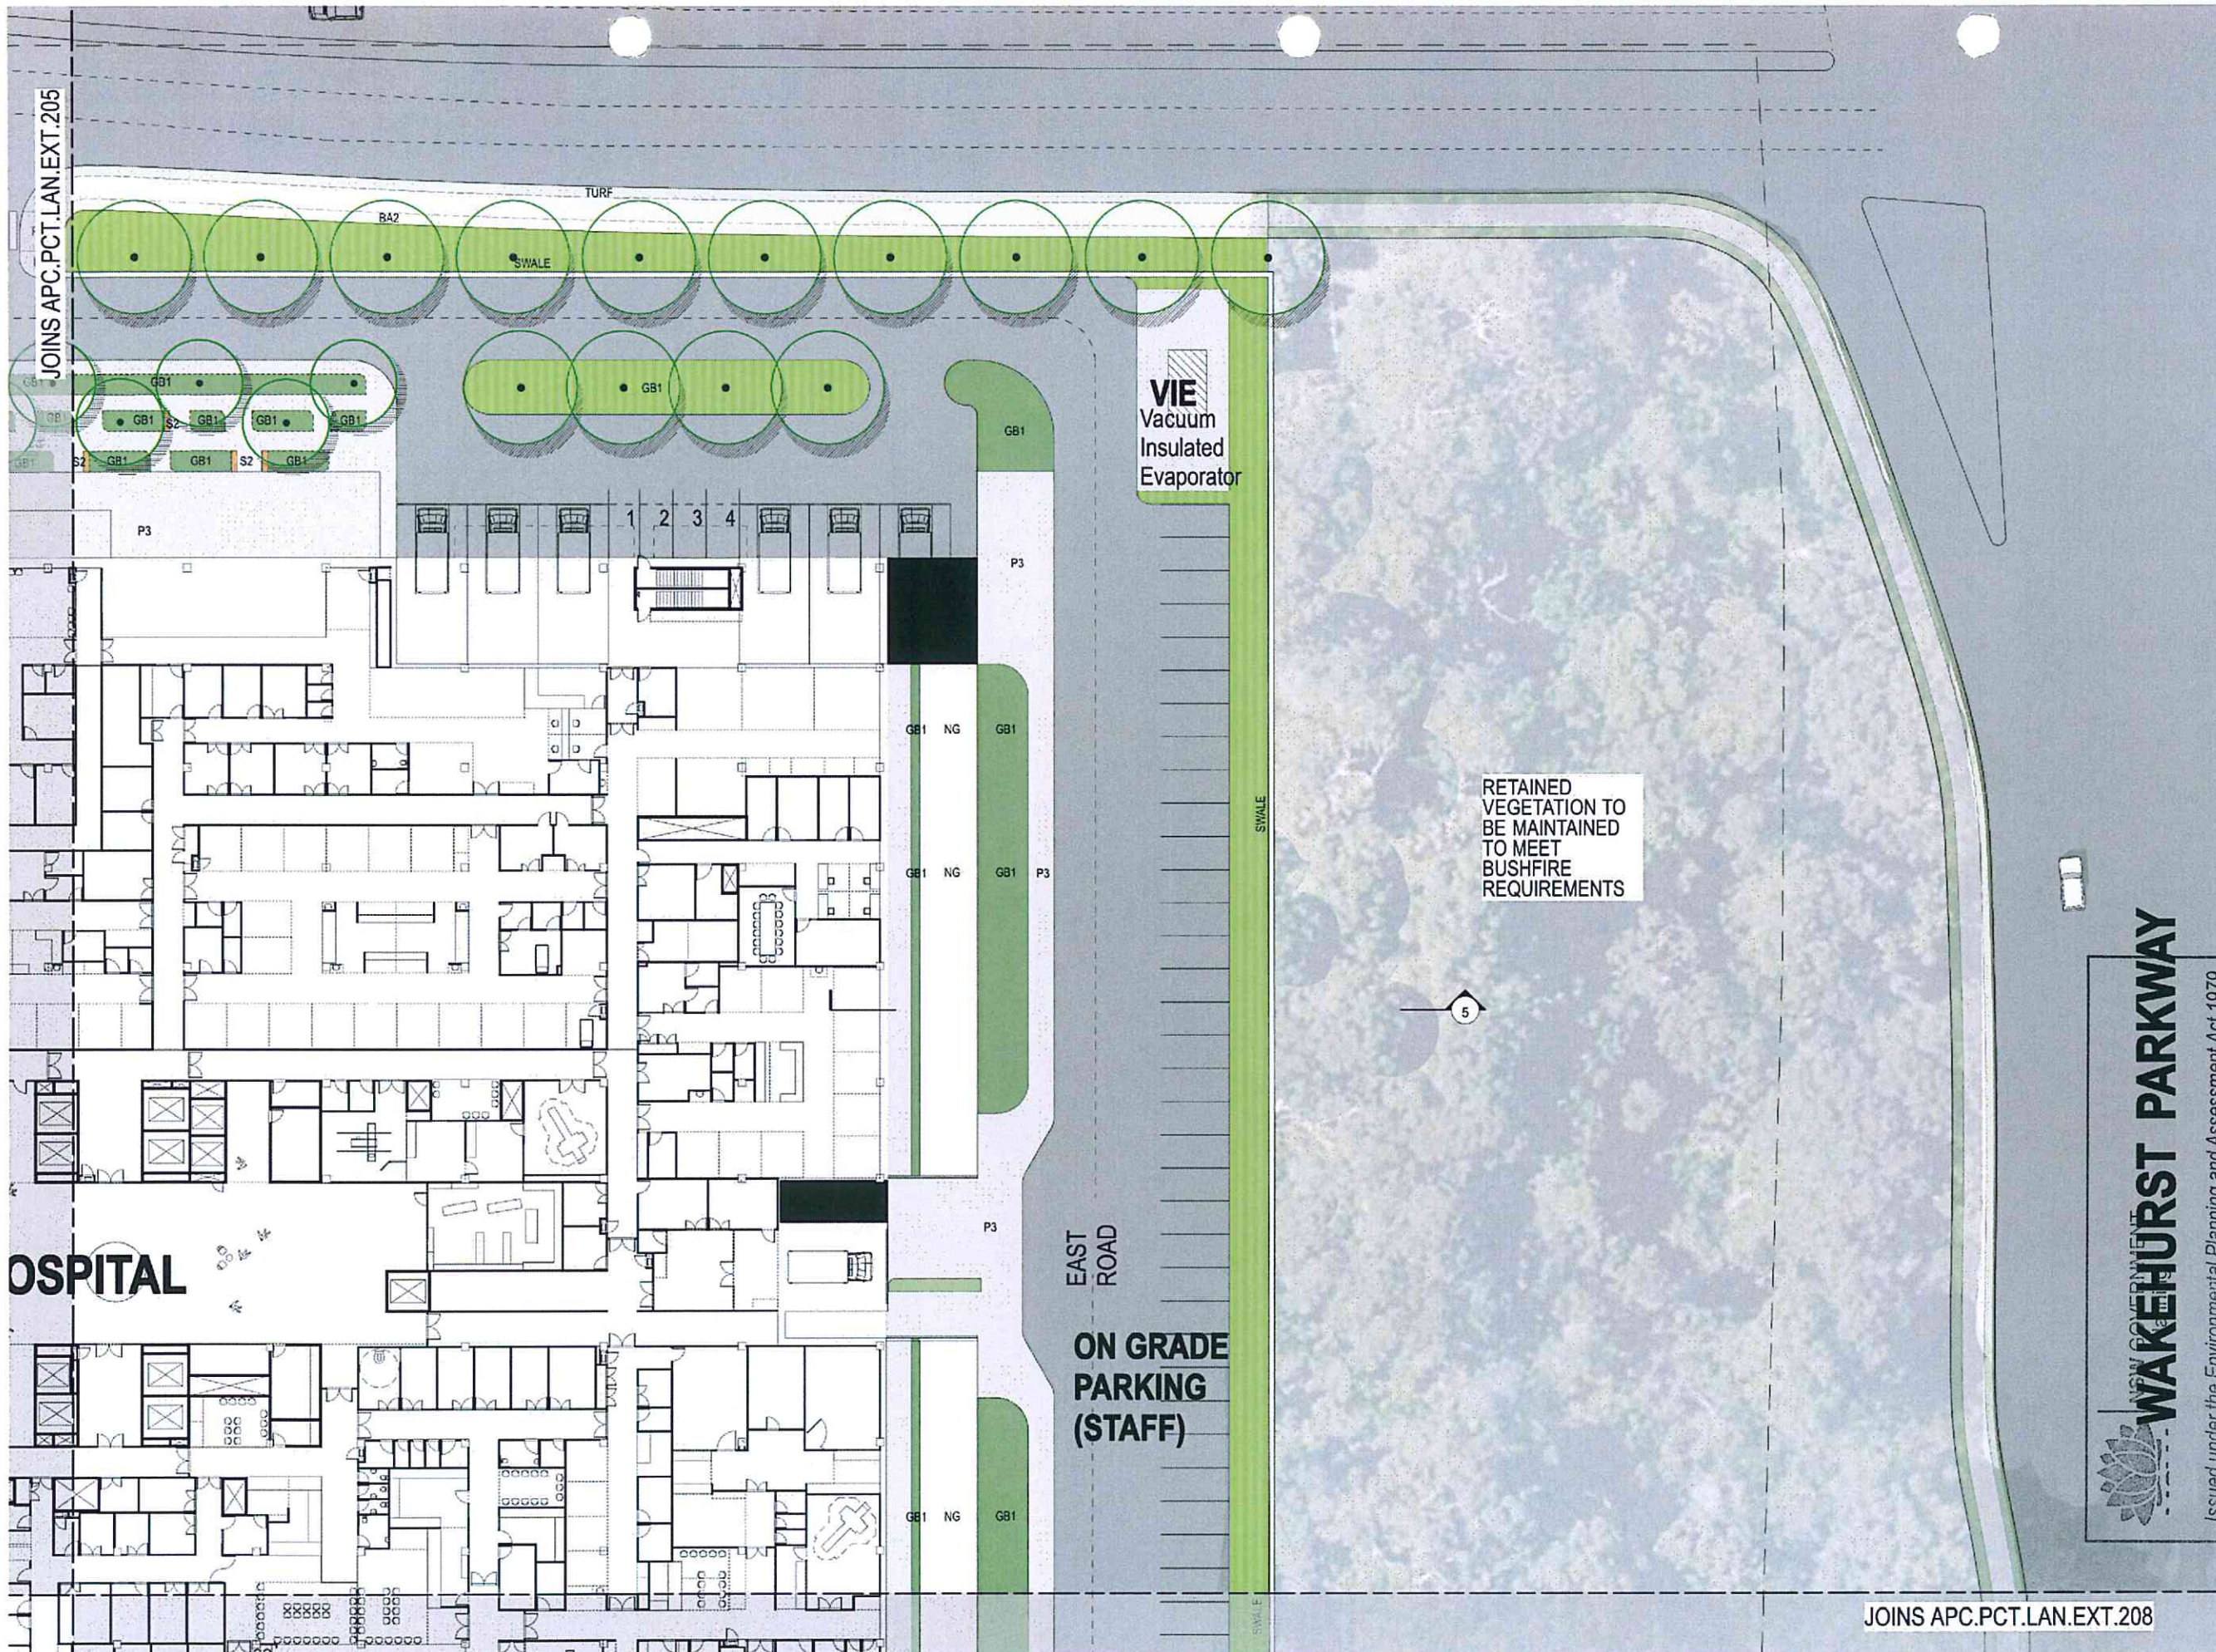

WAKEHURST PARKWAY

Issued under the Environmental Planning and Assessment Act 1979

Approved Application No. SS1 6792
 granted on the 29/06/15
 Signed [Signature]
 Sheet No. 32 of 45

BOUNDARY

STAGE 1 WORKS

SHARED PATH

NON DEVELOPMENT SITE

TRANSIT VEHICLES

SOUTH ROAD

JOINS DWG.PCT.LAN.BB.EXT.40.004



NSW GOVERNMENT
Planning


Issued under the Environmental Planning and Assessment Act 1979

Approved Application No. **SSI 6792**

granted on the **29/06/15**

Signed **[Signature]**

Sheet No. **33** of **45**

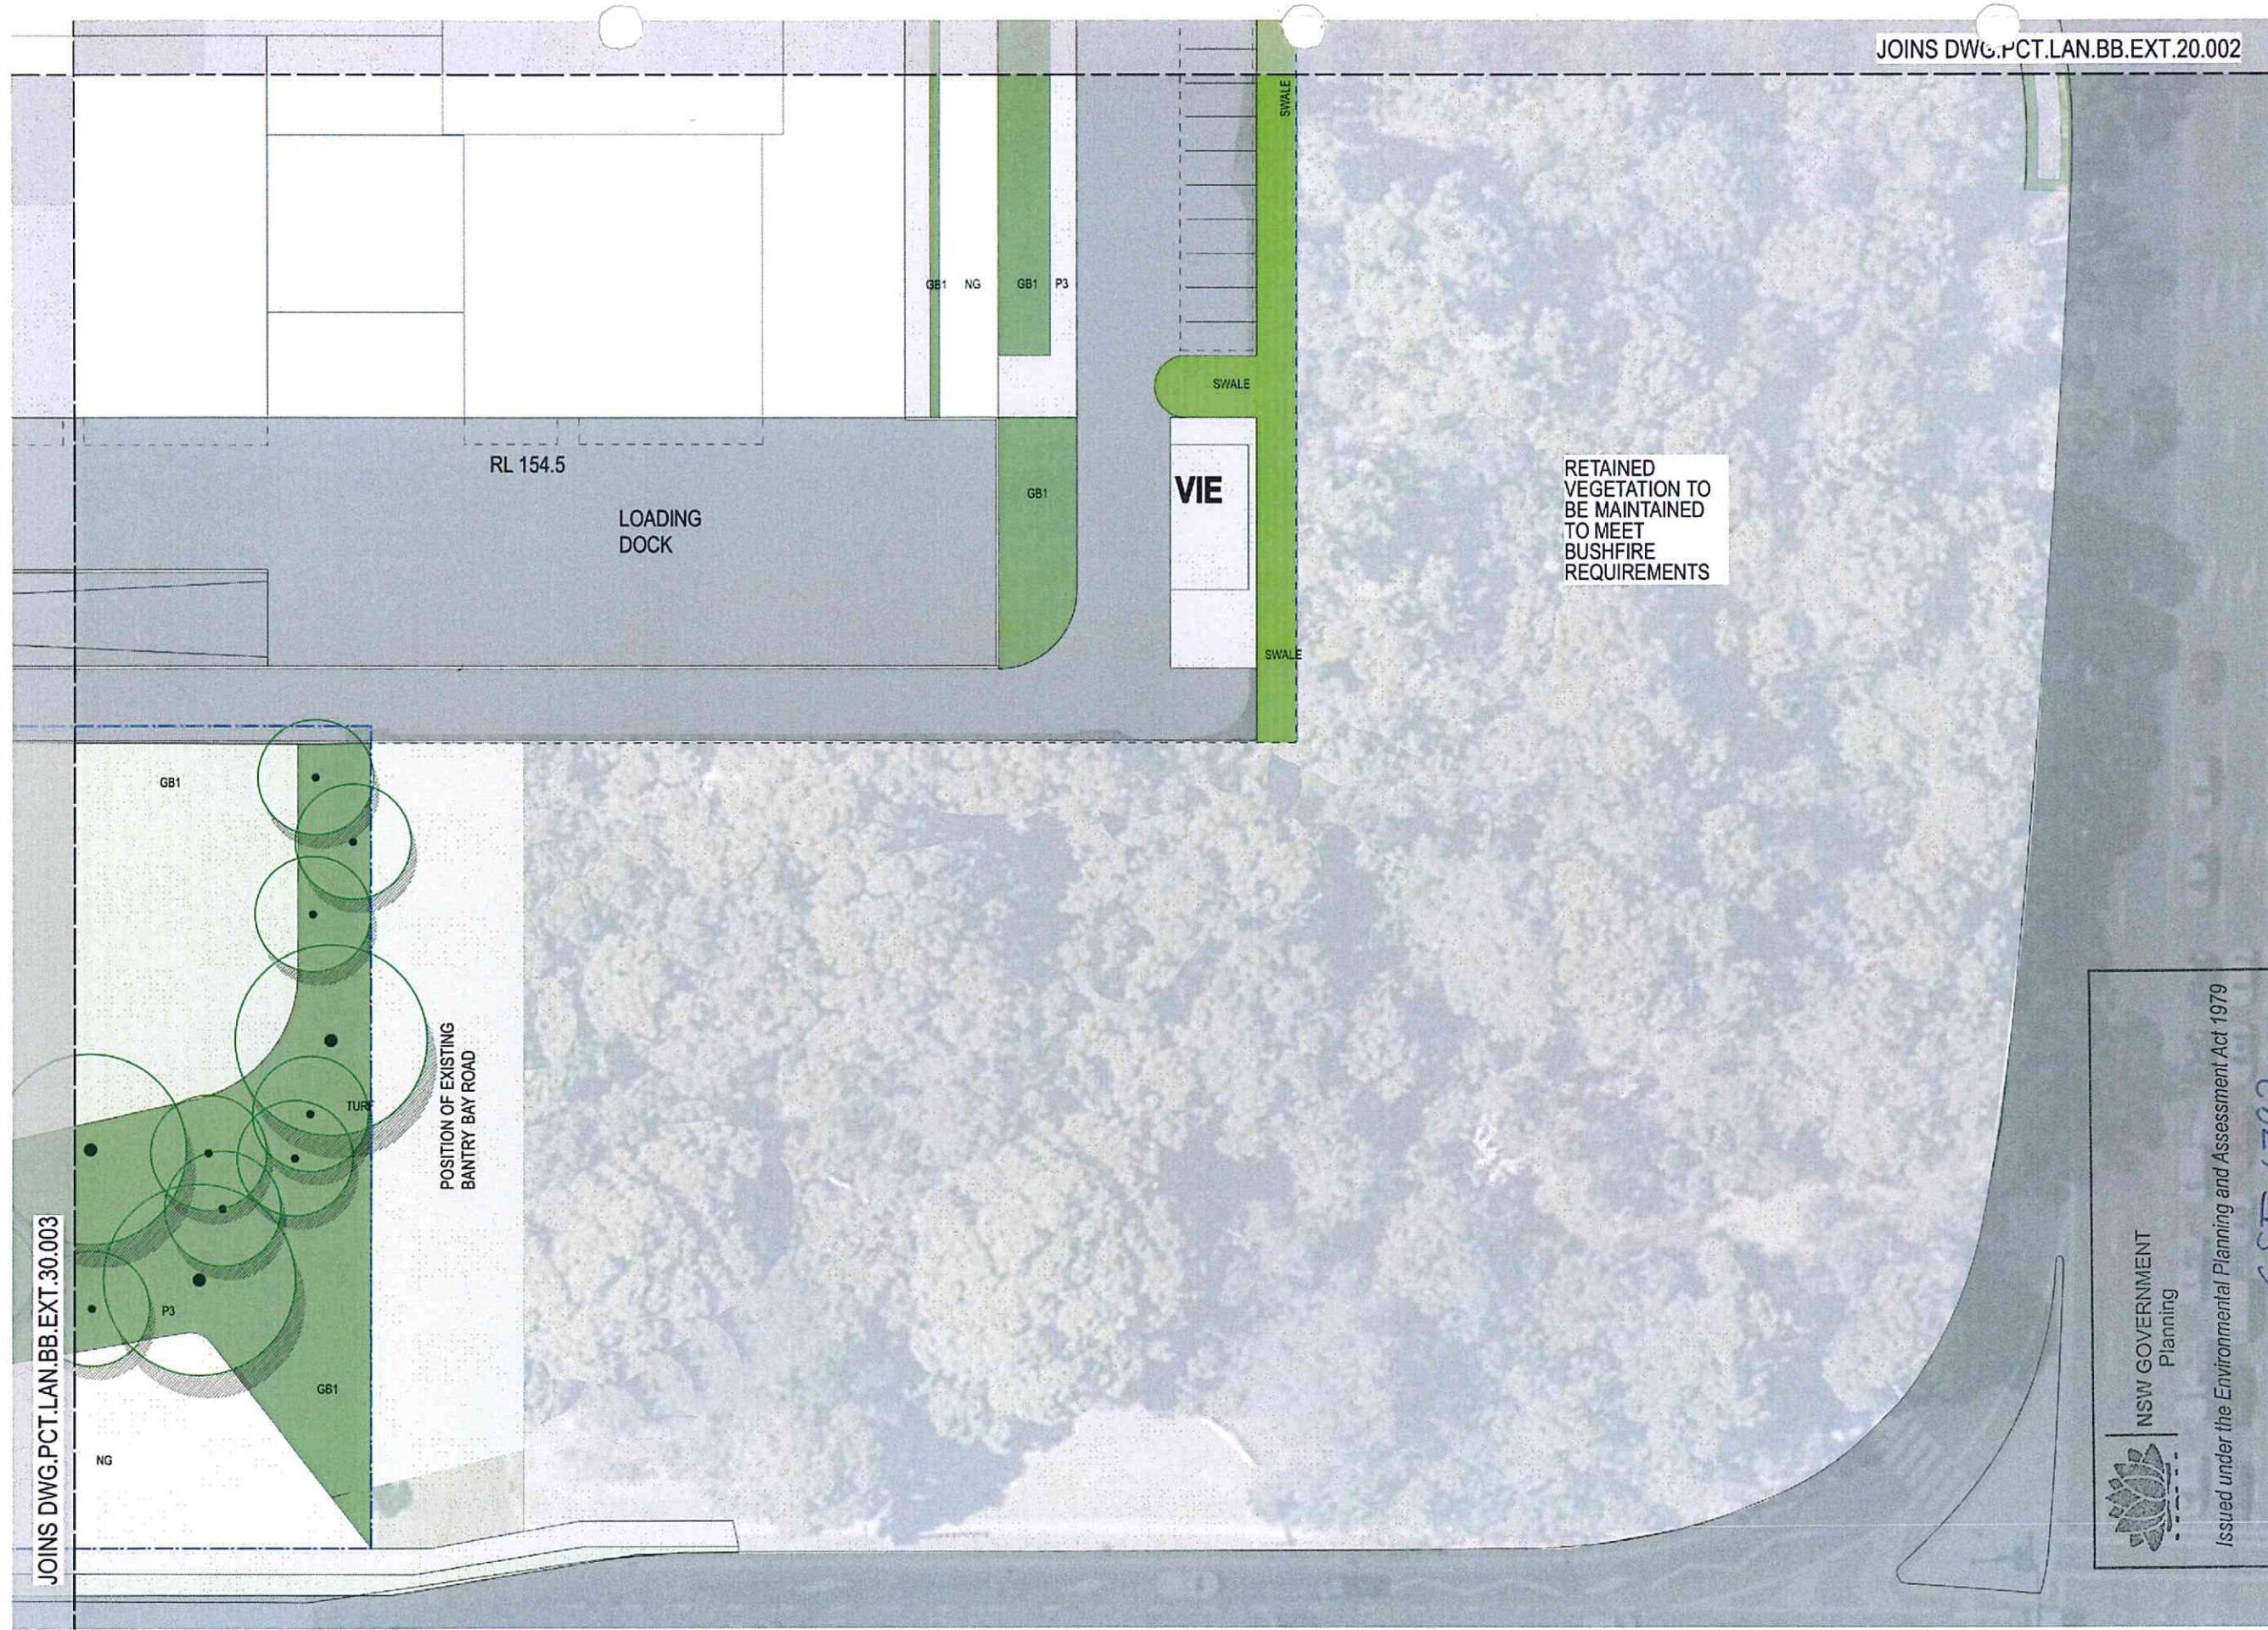

NSW GOVERNMENT
Planning

Issued under the Environmental Planning and Assessment Act 1979

Approved Application No. SSI 6792

granted on the 29/06/15

Signed [Signature]

Sheet No. 34 of 45



1 Section 1
1:100




2 Section 2
1:100


	NSW GOVERNMENT Planning	
	Issued under the Environmental Planning and Assessment Act 1979	
	Approved Application No. SSP 6792	
	granted on the 29/06/15	
	Signed [Signature]	
Sheet No. 35 of 45		



3 Section 3
1:100

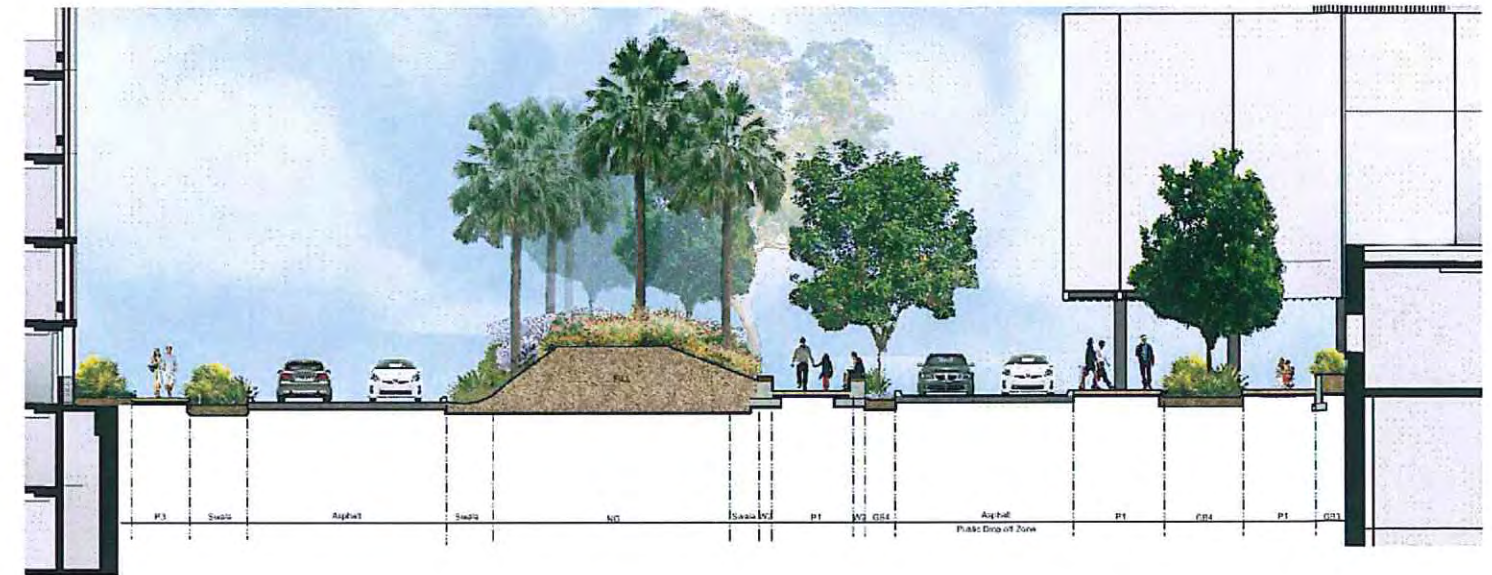

4 Section 4
1:100

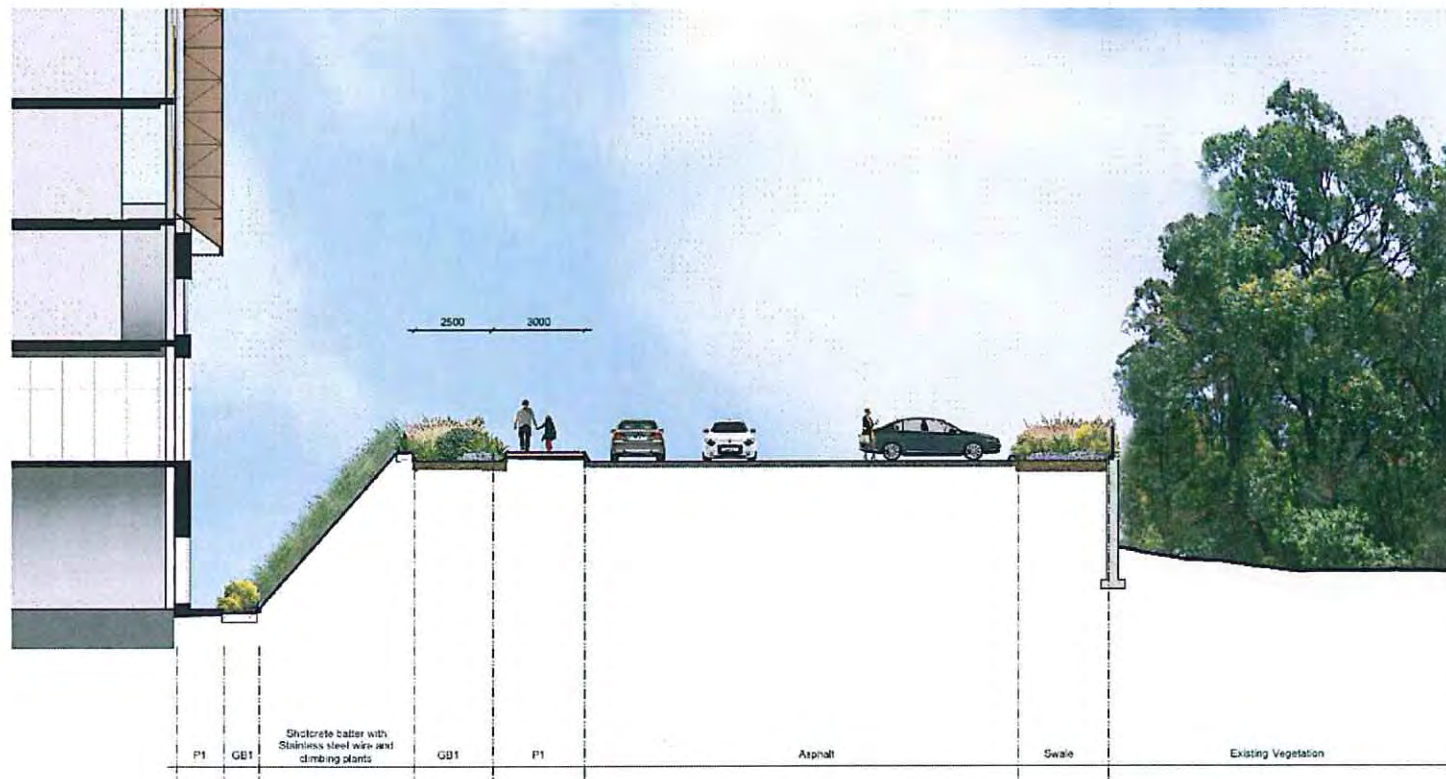

5 Section 5
1:100

 NSW GOVERNMENT Planning	Issued under the Environmental Planning and Assessment Act 1979			
	Approved Application No. <u>SSP 6792</u>			
	granted on the <u>29/06/15</u>			
	Signed <u>[Signature]</u>			
	Sheet No. <u>36</u> of <u>45</u>			

HOSPITAL

DRAWING SCHEDULE






- APC.HSP.LAN.ALL.200 COVERSHEET
- APC.HSP.LAN.L00.201 GROUND LEVEL COURTYARDS
- APC.HSP.LAN.L01.202 LEVEL 01 COURTYARD AND LANDSCAPED ROOF PLANS
- APC.HSP.LAN.L02.203 LEVEL 02 COURTYARD AND LANDSCAPED ROOF PLANS
- APC.HSP.LAN.L03.204 LEVEL 03 COURTYARD AND LANDSCAPED ROOF PLANS
- APC.HSP.LAN.L04.205 LEVEL 04 COURTYARD AND LANDSCAPED ROOF PLANS

- APC.GEN.LAN.DET.600 TYPICAL DETAILS
- APC.GEN.LAN.DET.601 TYPICAL DETAILS
- APC.GEN.LAN.DET.602 TYPICAL DETAILS

LEGEND


SYMBOL	ITEM				
	Extent of Landscape Works		Ballast Type 1		Garden Bed Type 2 Independent Planter
	Paving Type 1 Concrete Unit paver - Pedestrian		Ballast Type 2		Garden Bed Type 3 Raised Planter
	Paving Type 3 Exposed aggregate concrete		Edge Type 2		Waterproof Membrane Refer Architects Drawings
	Paving Type 4 Rubber Softfall Childrens Play Area		Seat Type 2 Timber Bench Seating		New Palms

NOTE:
REFER TO DRAWINGS APC.GEN.LAN.DET.600-601
FOR TYPICAL DETAILS

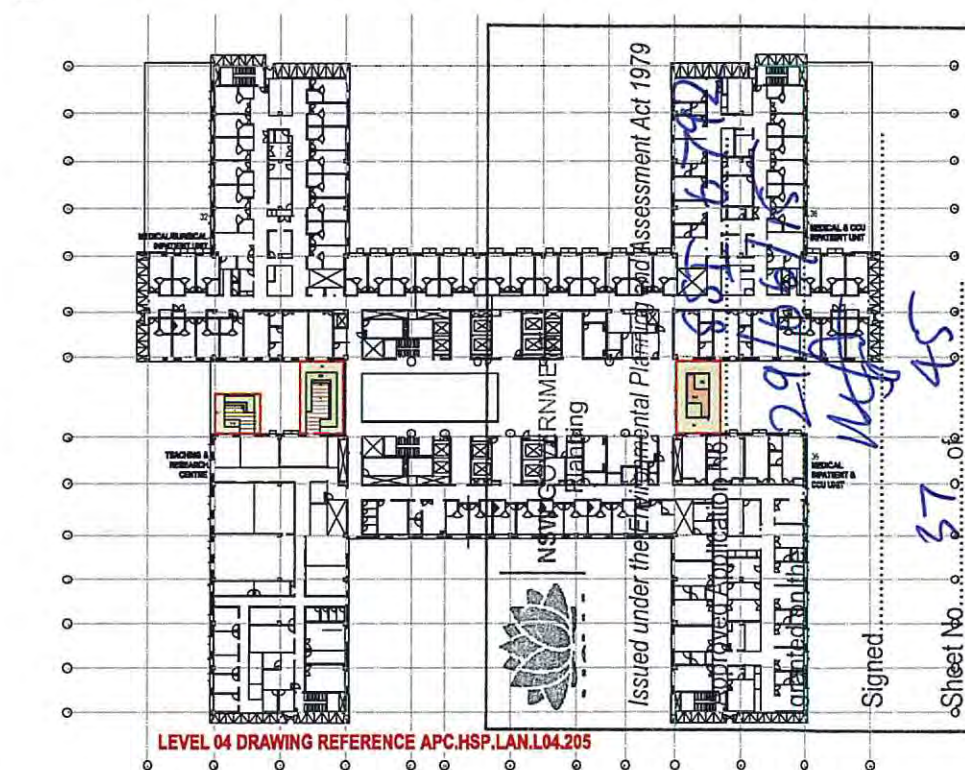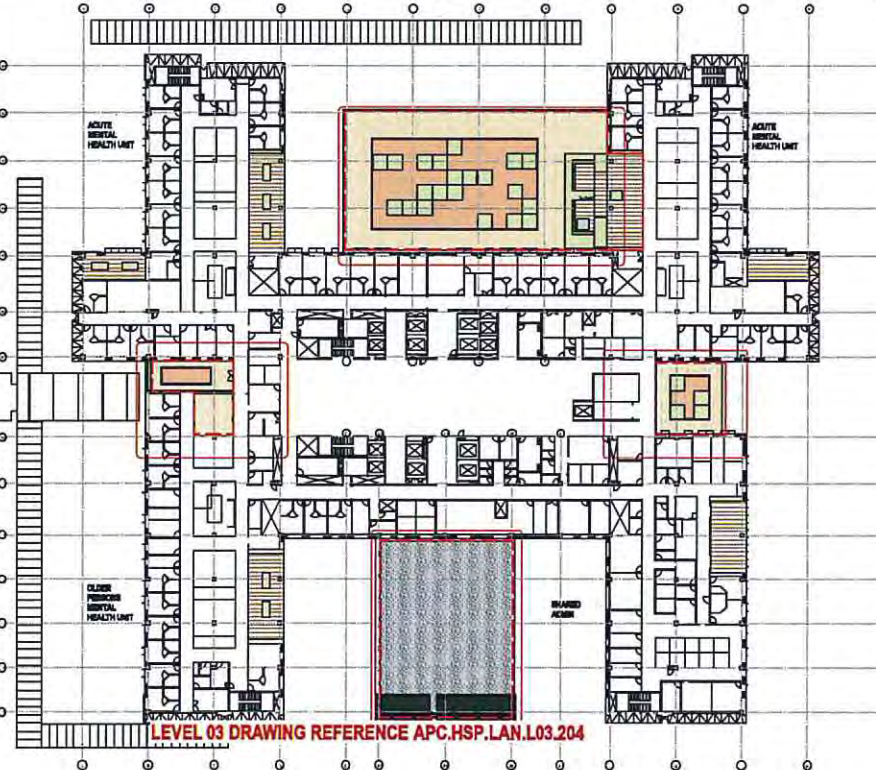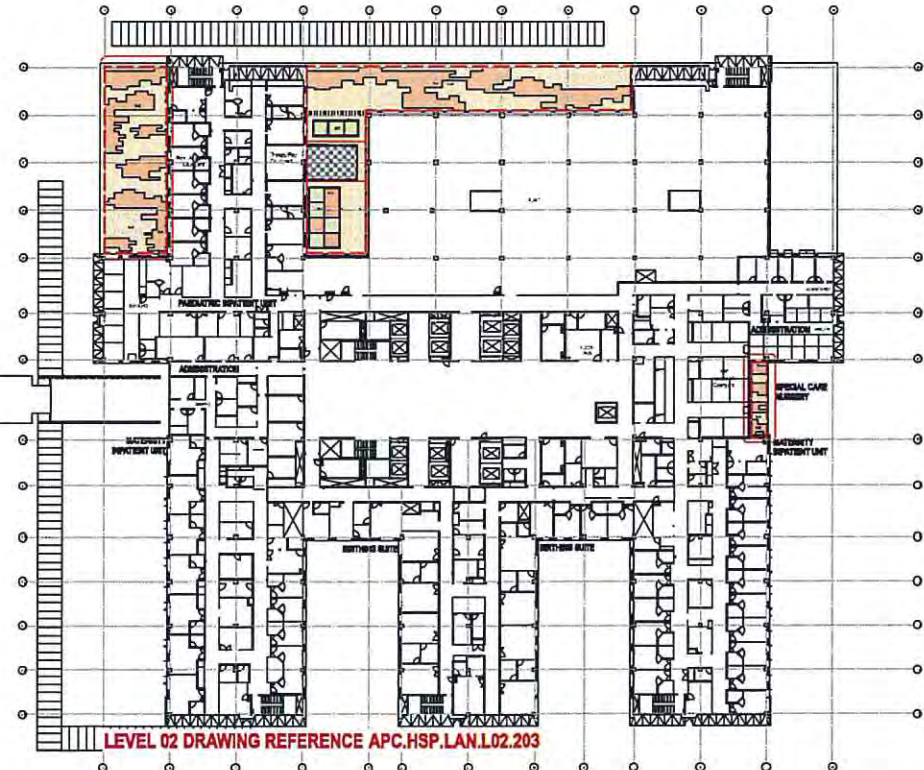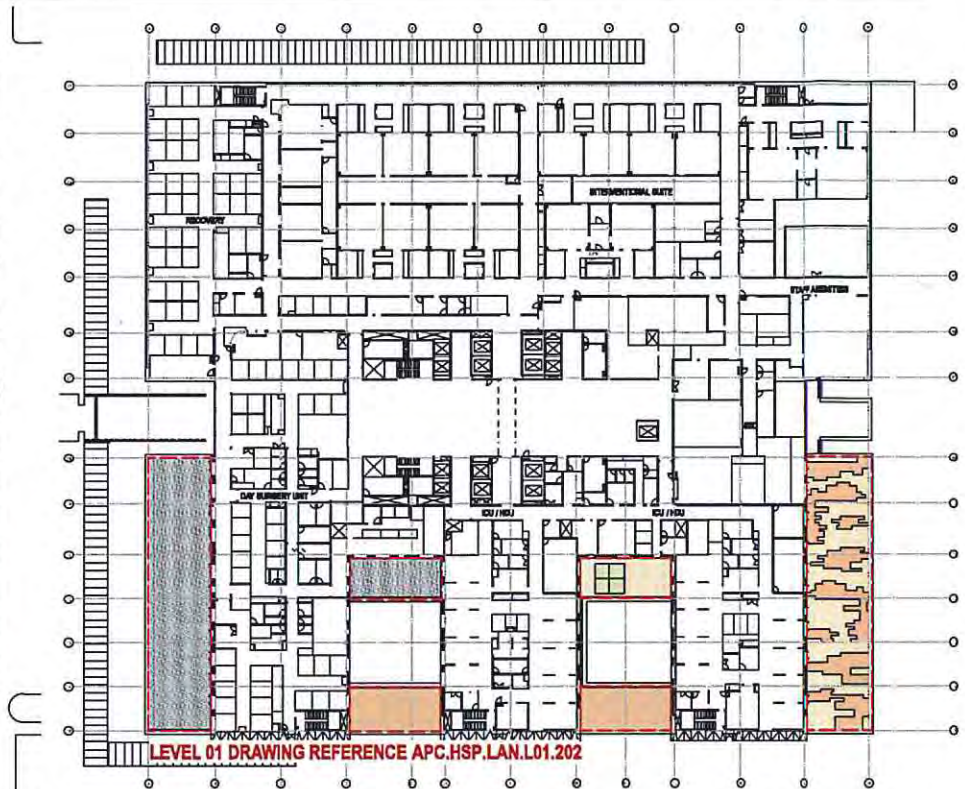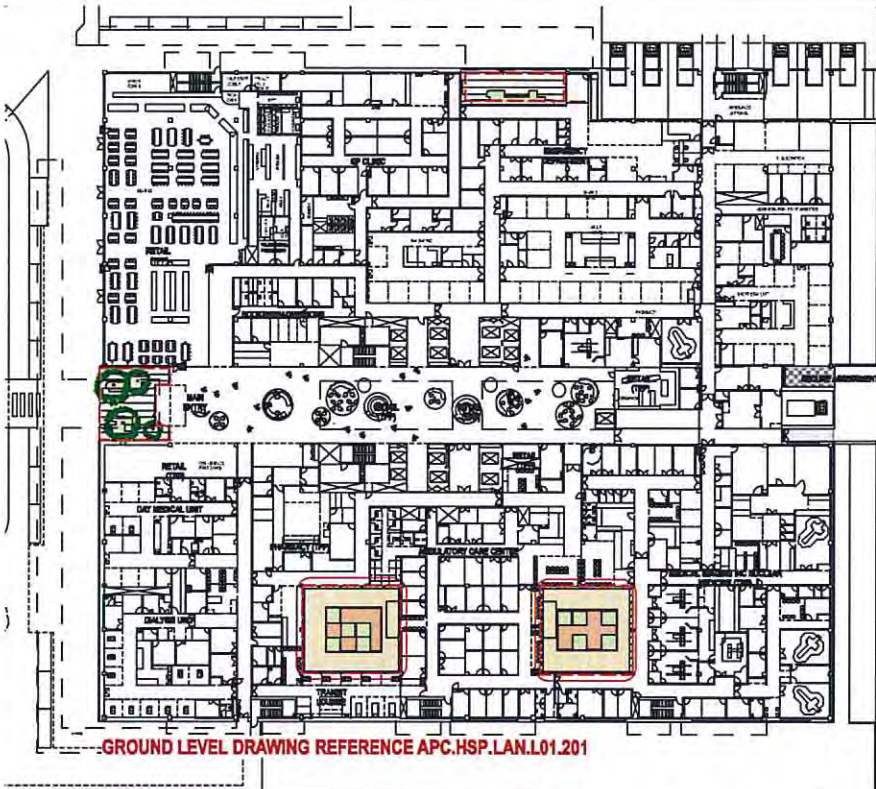

NOTE: INTERNAL LAYOUT IS INDICATIVE ONLY AND SUBJECT TO CHANGE

NSW Environmental Planning and Assessment Act 1979
Issued under the Environmental Planning and Assessment Act 1979
Approved for publication
29/11/14
Signed
Sheet No. 37 of 45

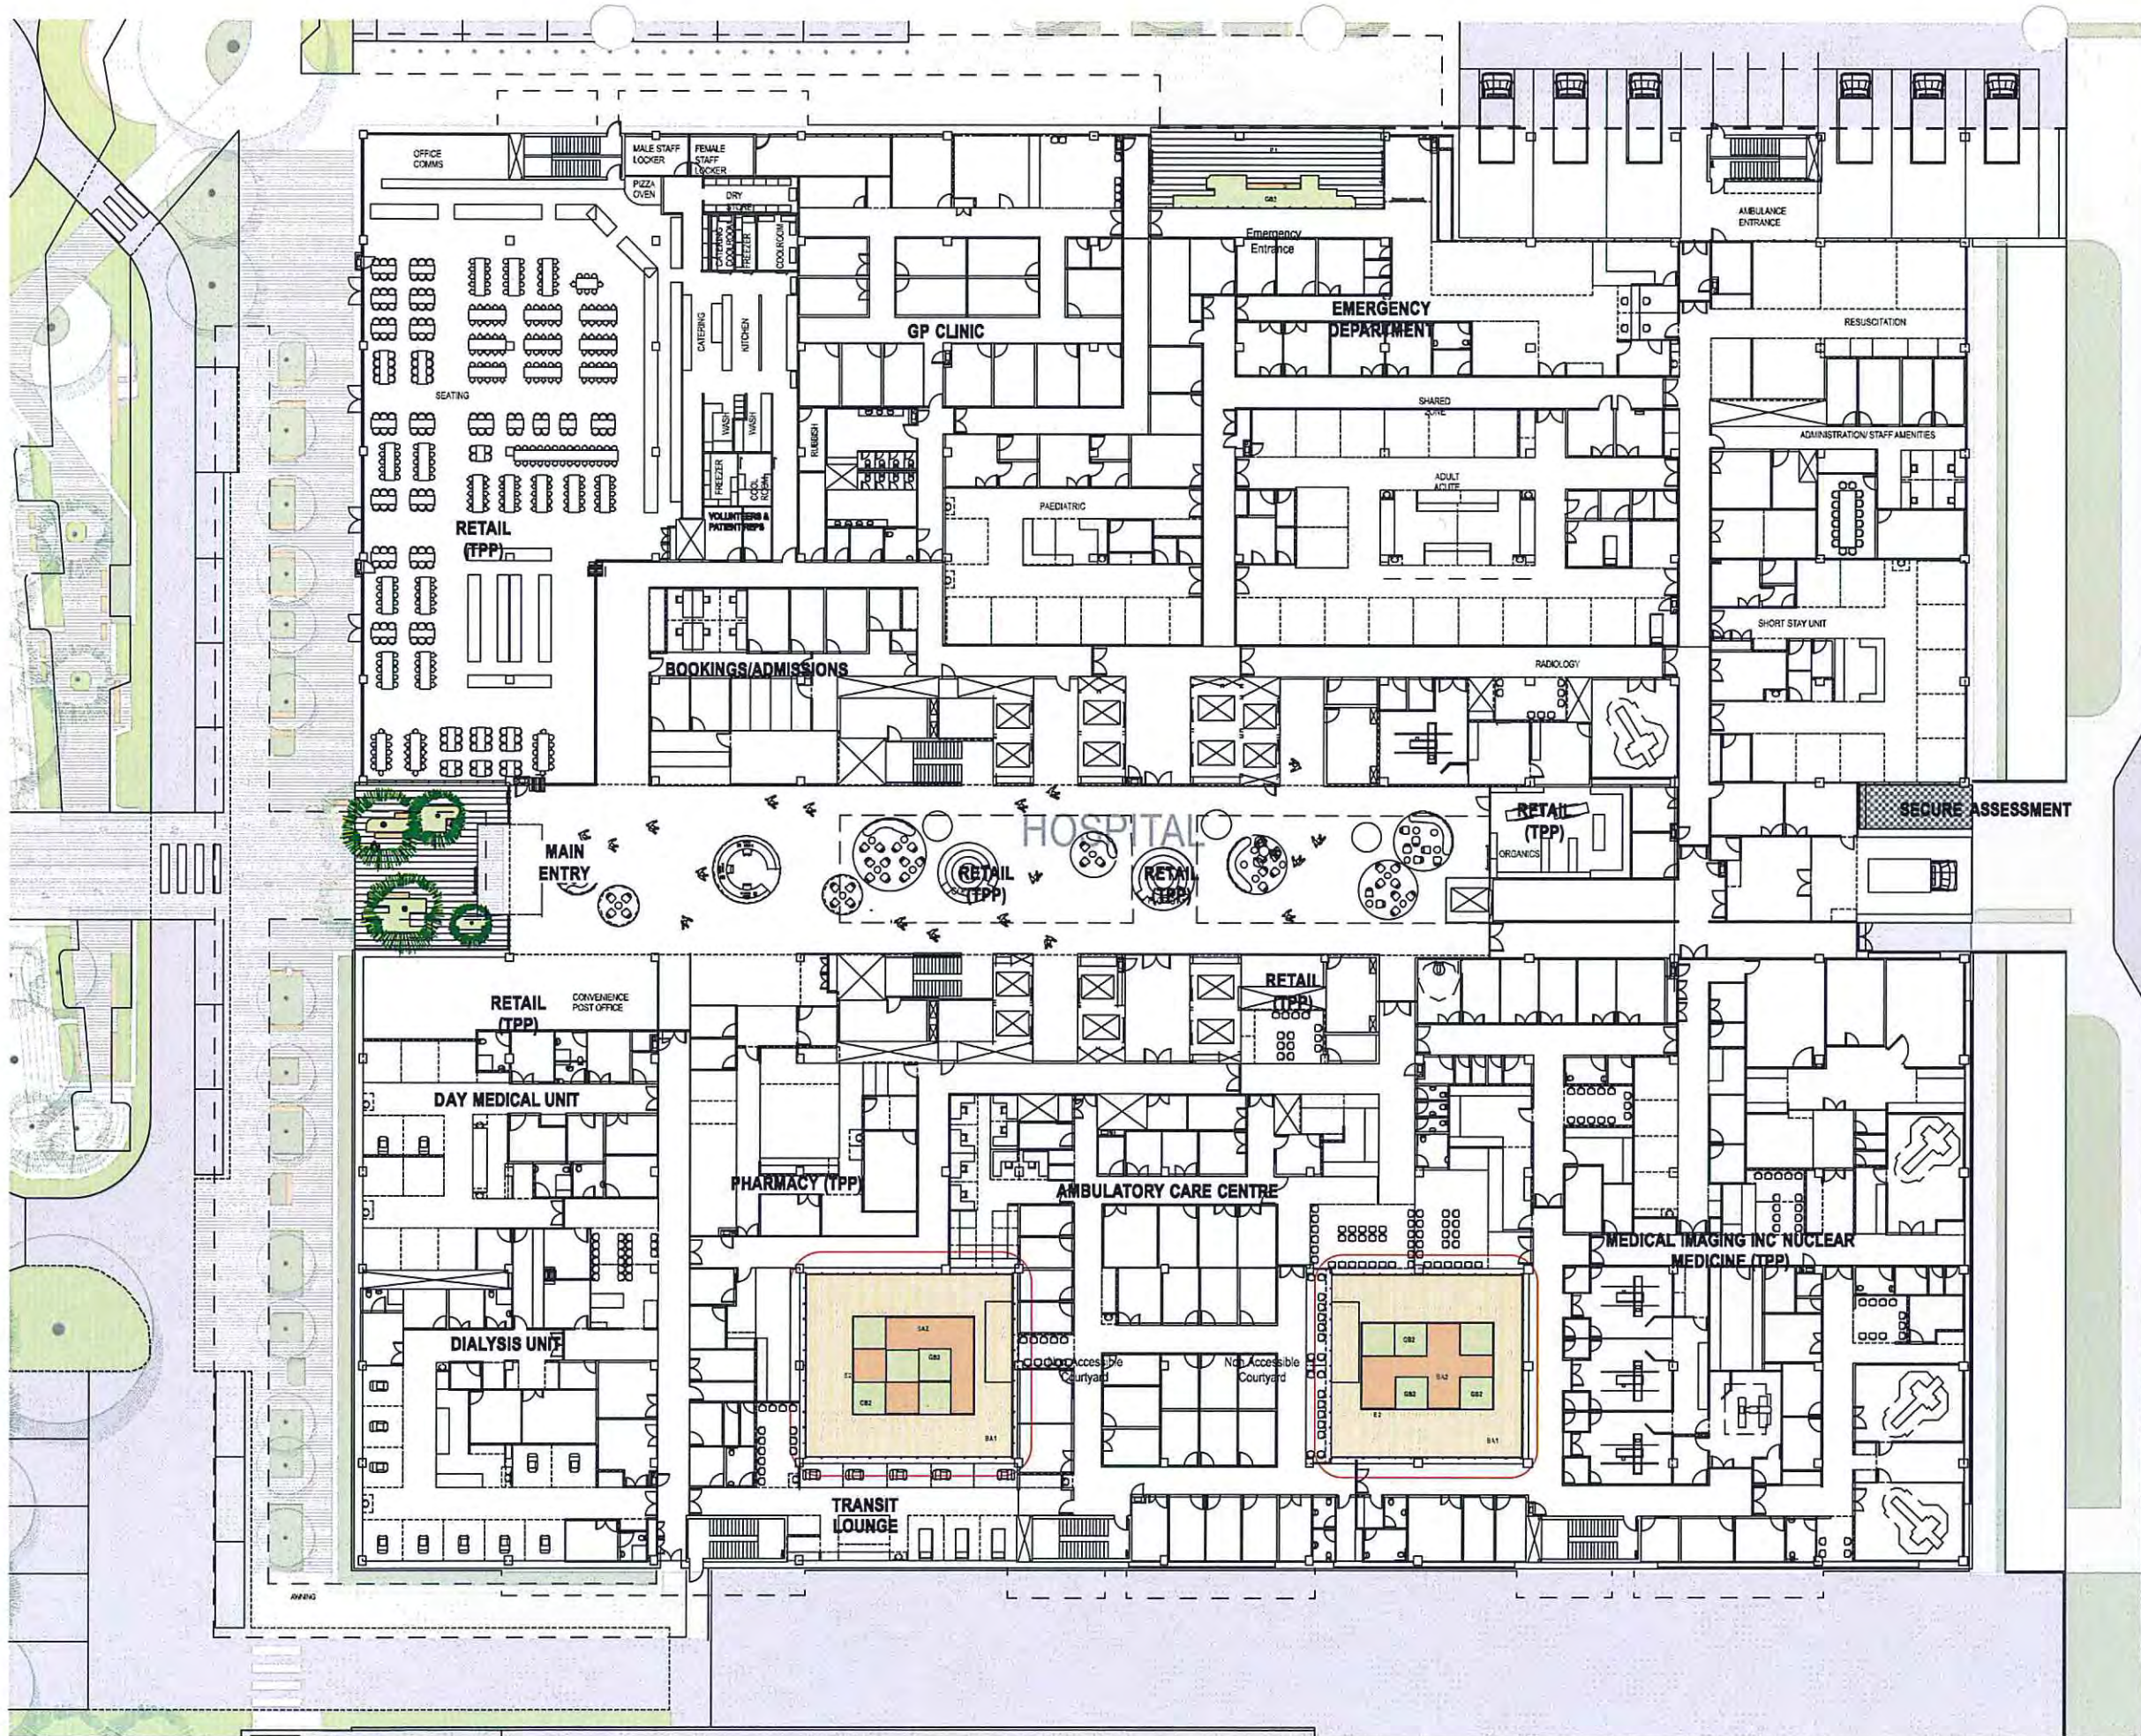

NSW GOVERNMENT
Planning

Issued under the Environmental Planning and Assessment Act 1979

 
Approved Application No. SS1 6792

granted on the 29/06/15

Signed [Signature]


Sheet No. 38 of 45

NOTE: INTERNAL LAYOUT IS INDICATIVE ONLY AND SUBJECT TO CHANGE



Design & Construction Contractor
THIESS

 Designer
360



Project
THE NORTHERN BEACHES HOSPITAL

GRAPHIC SCALE
0 1000 2000

SCALE
1 : 200


DRAWINGS
GROUND LEVEL COURTYARDS

PURPOSE
EIS

DATE
13/11/14

DRAWING NO
**APC.HSP.LAN.
L00.201**

REVISION
EX

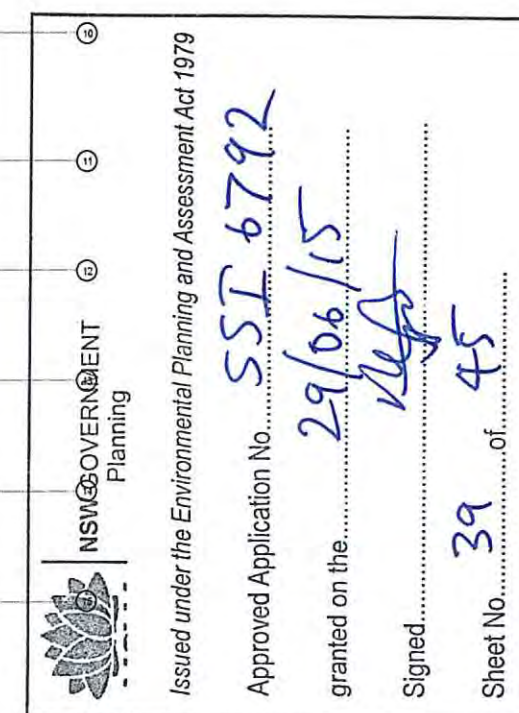



NSW GOVERNMENT
Planning

Issued under the Environmental Planning and Assessment Act 1979

Approved Application No. SSP 6792

granted on the 29/06/15

Signed [Signature]

 
Sheet No. 40 of 45

NOTE: INTERNAL LAYOUT IS INDICATIVE ONLY AND SUBJECT TO CHANGE



Design & Construction Contractor
THIESS

Designer
360



Project
THE NORTHERN BEACHES HOSPITAL

GRAPHIC SCALE
0 1000 2000 3000

SCALE
1 : 200


DRAWINGS
**LEVEL 02 COURTYARD and LANDSCAPED
ROOF Plans**

PURPOSE
EIS

DATE
13/11/14

DRAWING NO
**APC.HSP.LAN.
L02.203**

REVISION
EX

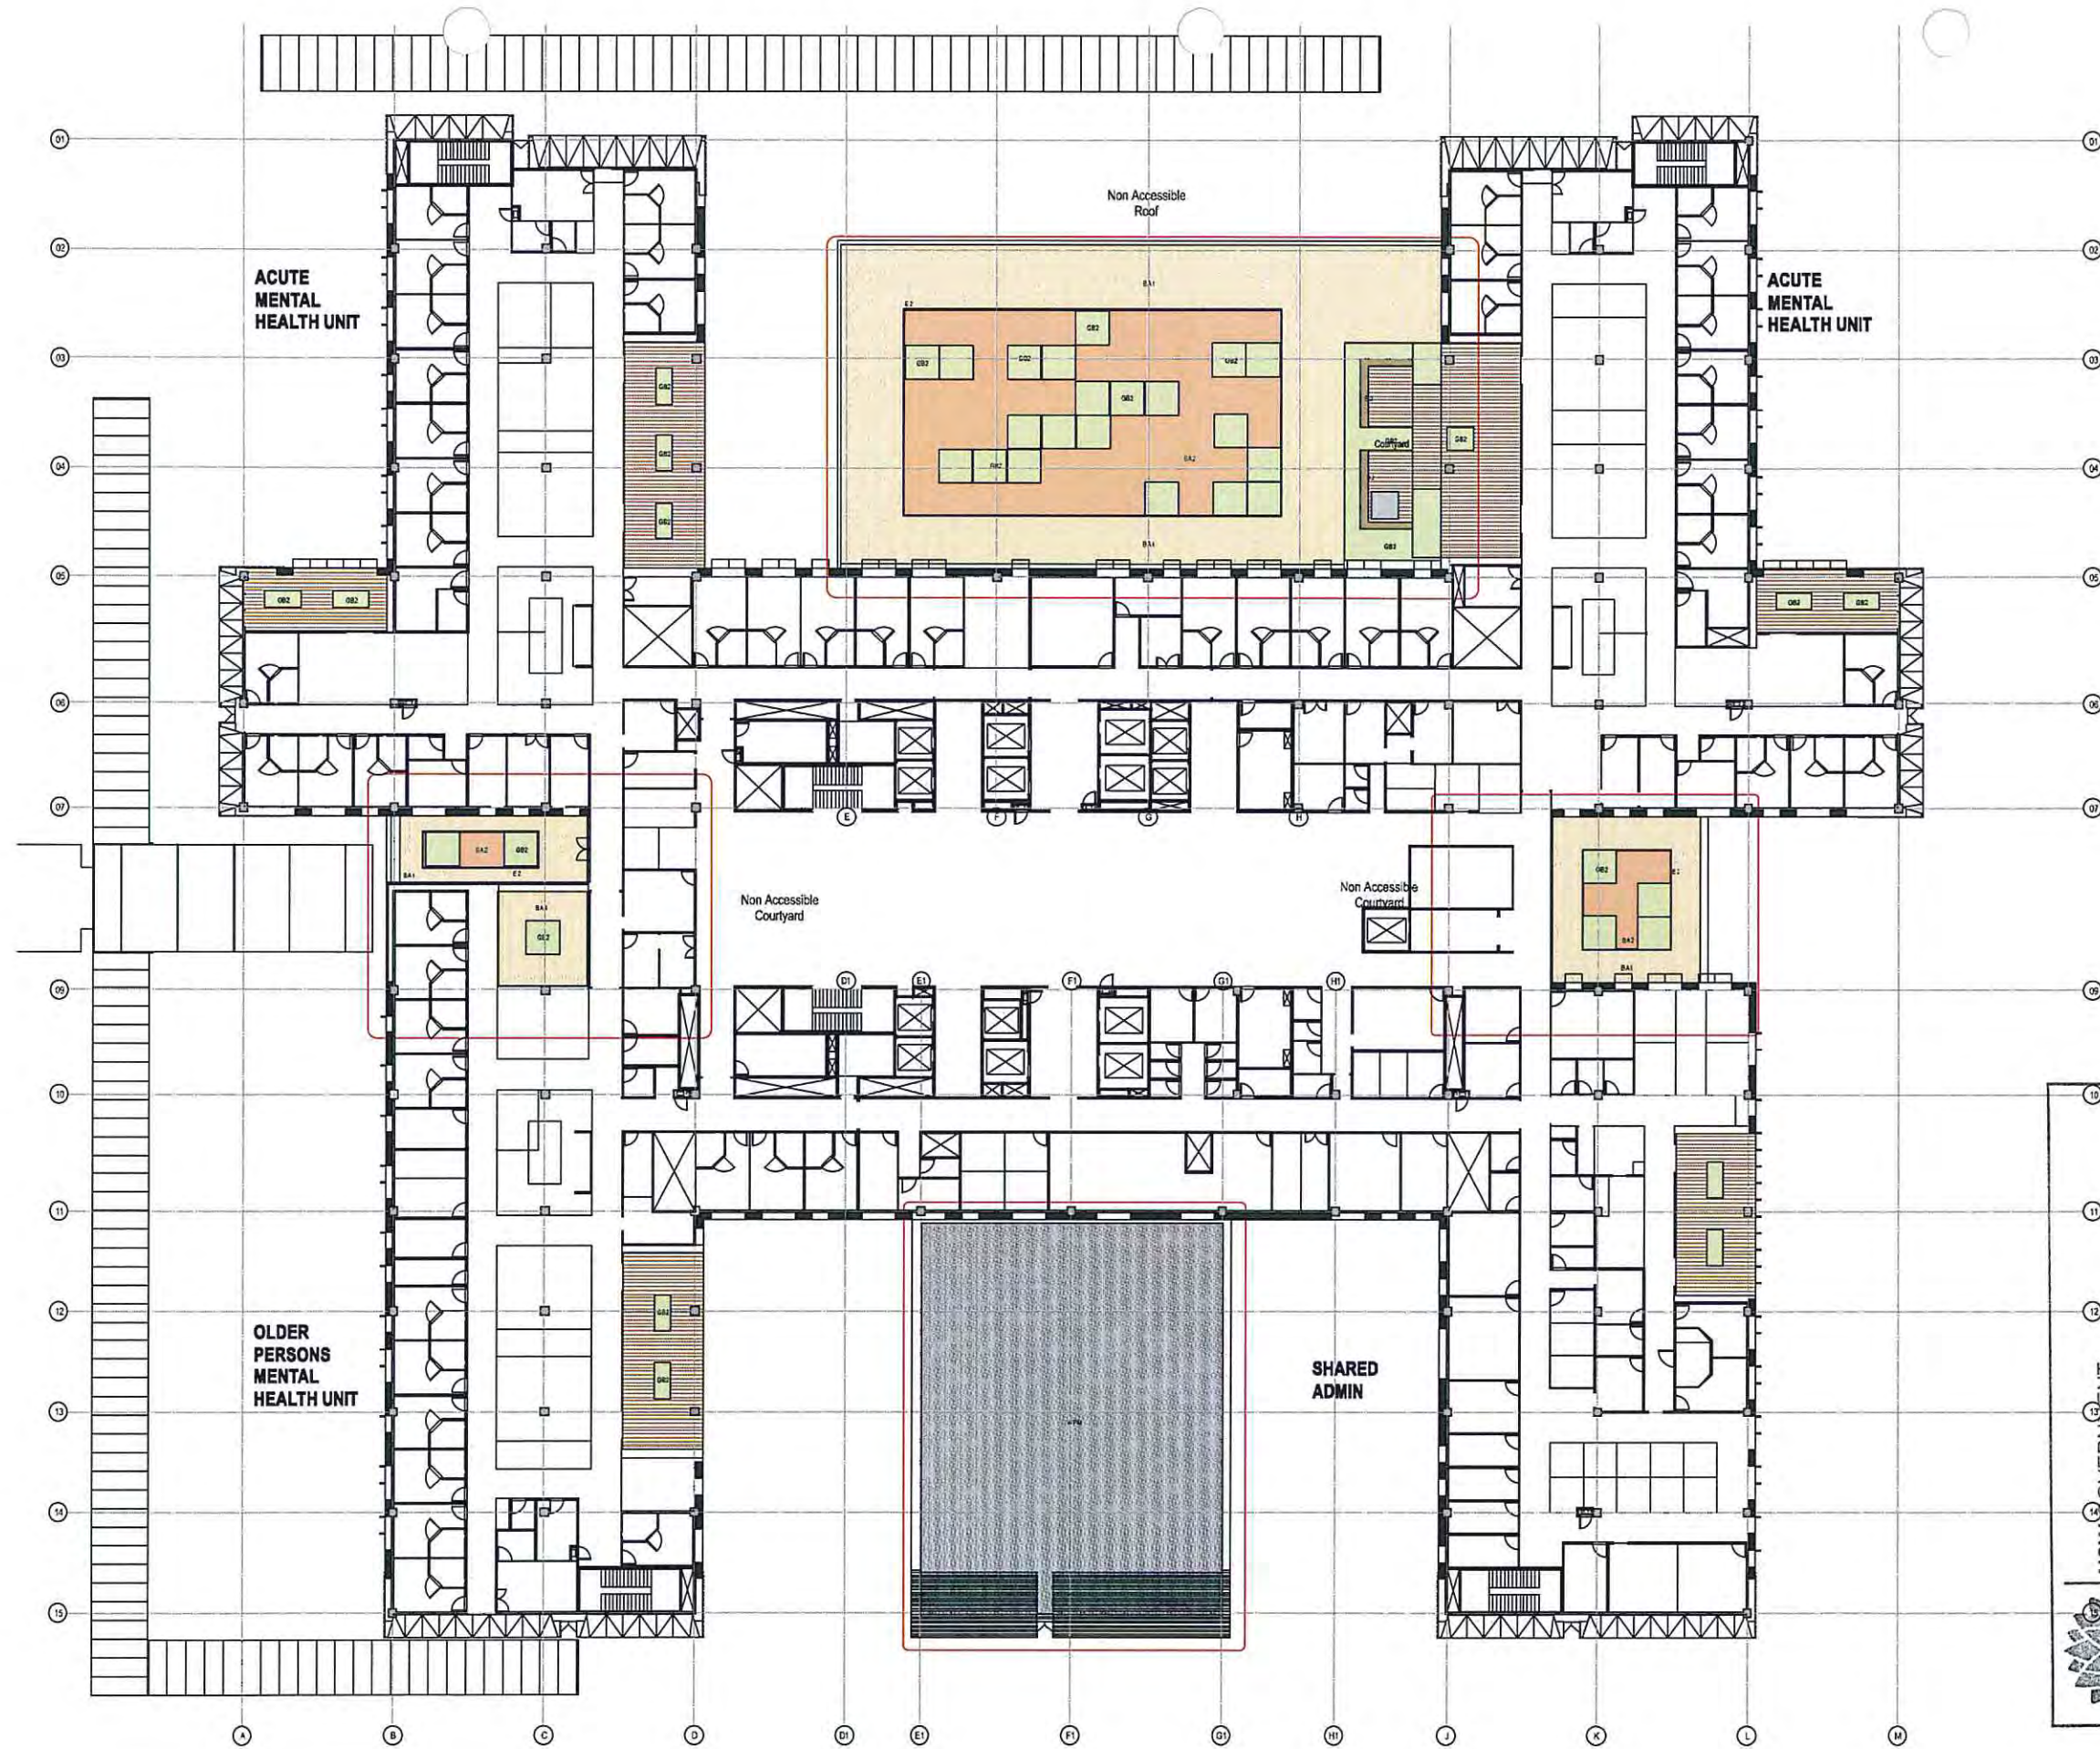

NSW GOVERNMENT
Planning

Issued under the Environmental Planning and Assessment Act 1979

Approved Application No. **SSI 6792**

granted on the **29/06/15**

Signed **[Signature]**

 
Sheet No. **41** of **45**

NOTE: INTERNAL LAYOUT IS INDICATIVE ONLY AND SUBJECT TO CHANGE



Design & Construction Contractor
THIESS

Designer
360



Project
THE NORTHERN BEACHES HOSPITAL

GRAPHIC SCALE
0 1000 2000 3000
SCALE
1 : 200


DRAWINGS
**LEVEL 03 COURTYARD and LANDSCAPED
ROOF Plans**

PURPOSE
EIS

DATE
13/11/14

DRAWING NO
**APC.HSP.LAN.
L03.204**

REVISION
EX

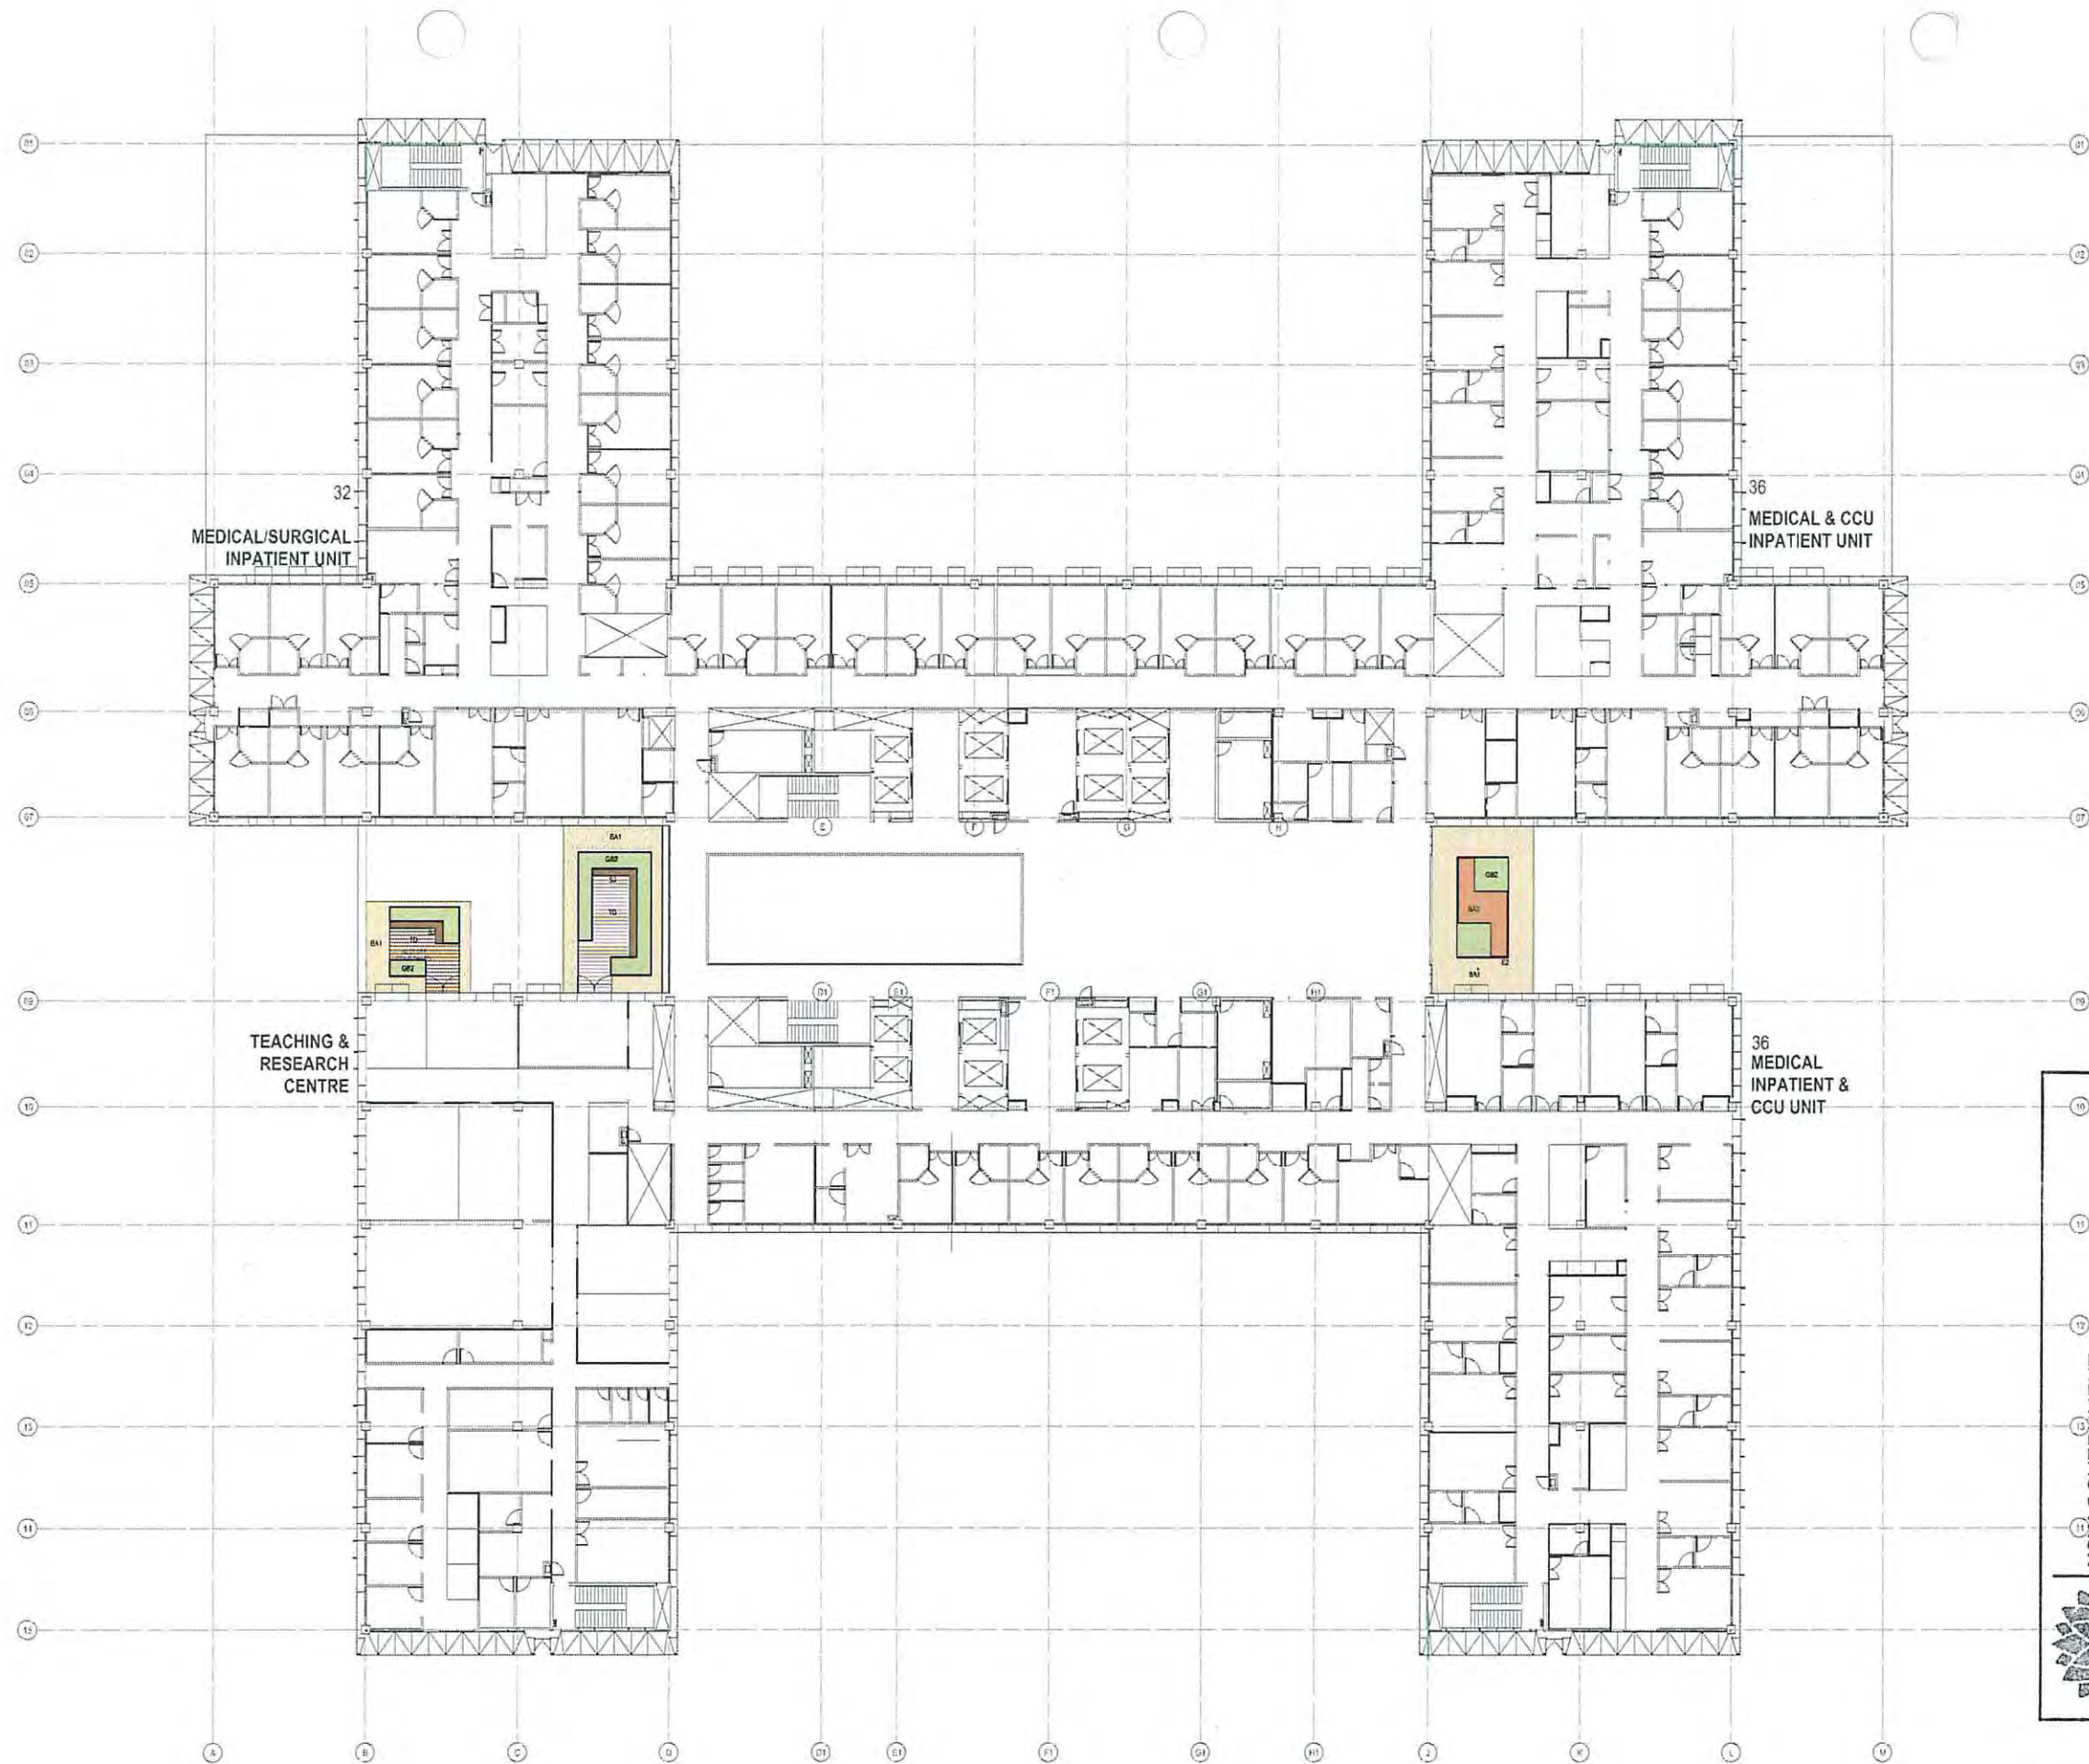

	Issued under the Environmental Planning and Assessment Act 1979	
	Approved Application No. SSI 6792	granted on the 29/06/15
	Signed <i>[Signature]</i>	Sheet No. A2 of 45
	Date 13/11/14	
	Drawing No. APC.HSP.LAN. L04.205	

NOTE: INTERNAL LAYOUT IS INDICATIVE ONLY AND SUBJECT TO CHANGE



Design & Construction Contractor
THIESS

Designer
360



Project
THE NORTHERN BEACHES HOSPITAL

GRAPHIC SCALE
0 1000 2000

SCALE
1 : 200




DRAWINGS
**LEVEL 04 COURTYARD and LANDSCAPED
ROOF Plans**


PURPOSE
EIS

DATE
13/11/14


DRAWING NO
**APC.HSP.LAN.
L04.205**

REVISION
EX

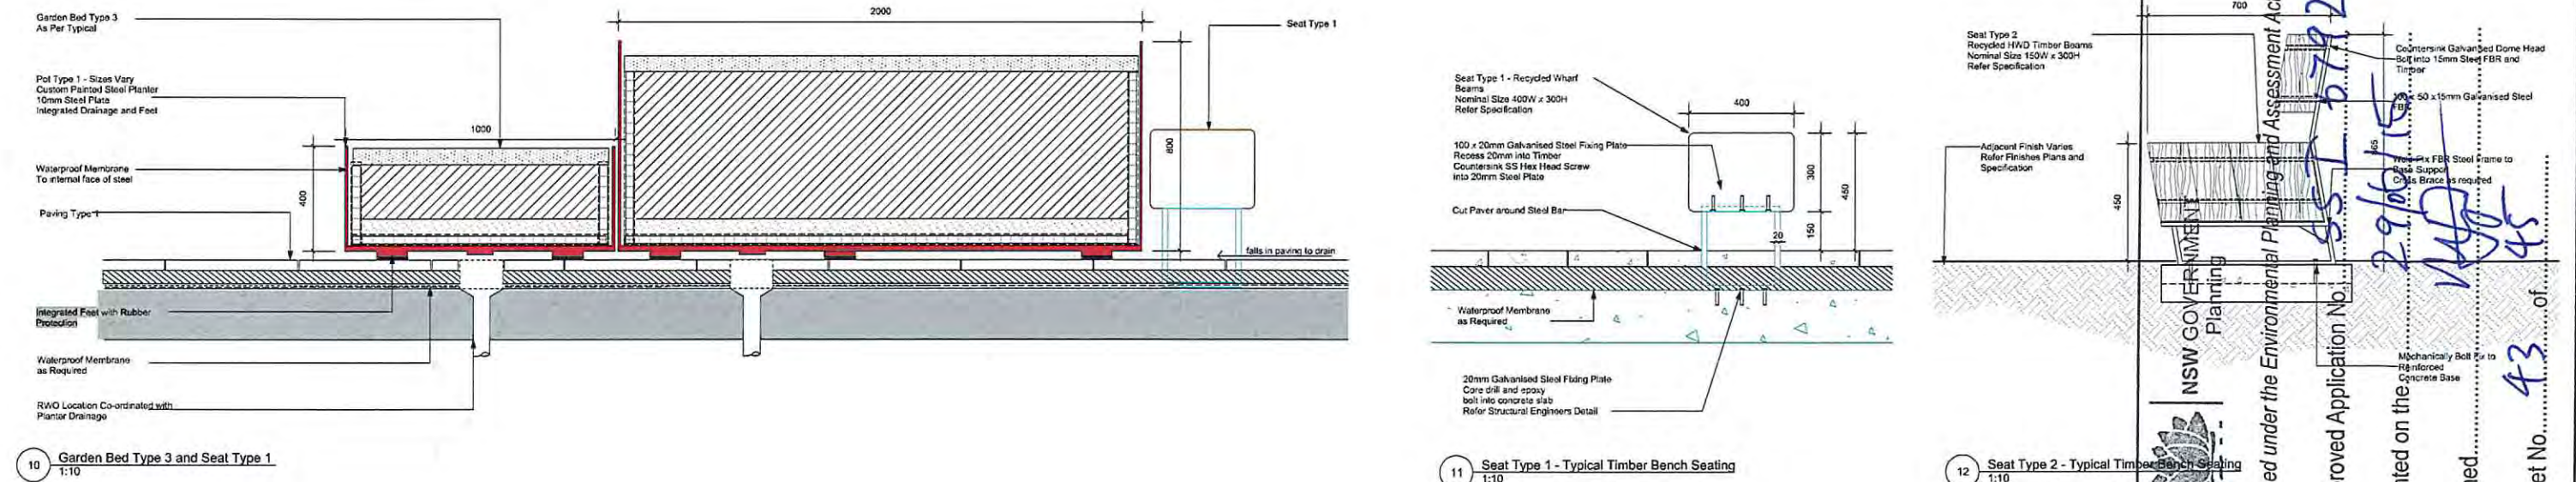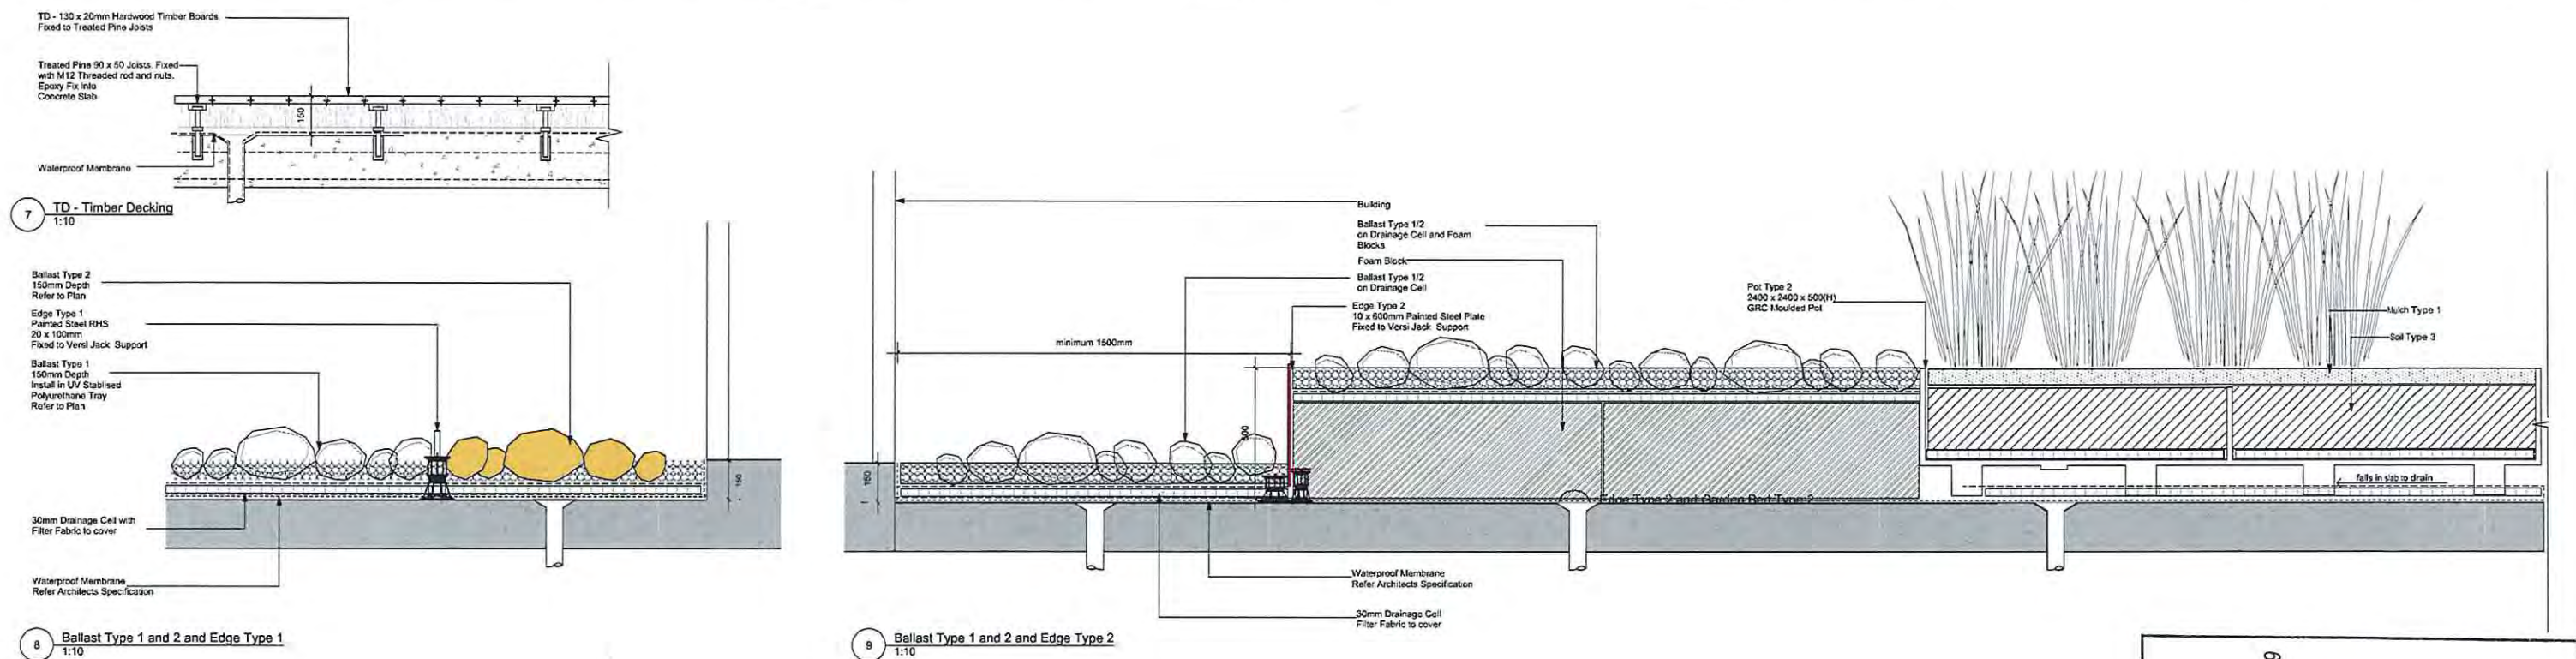
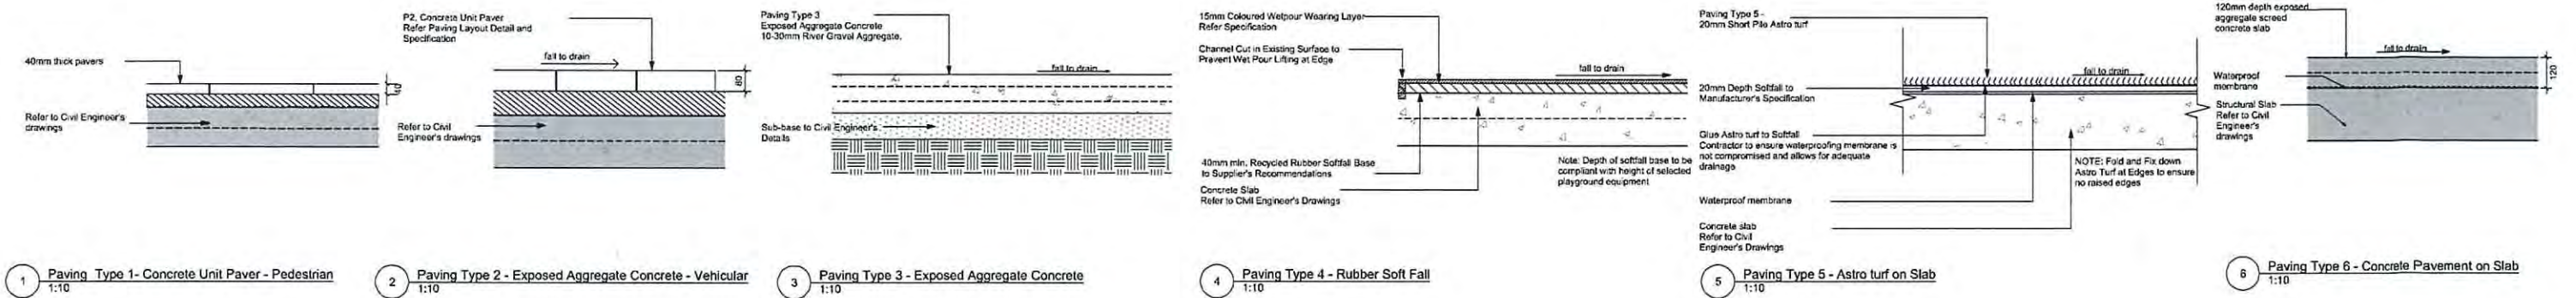


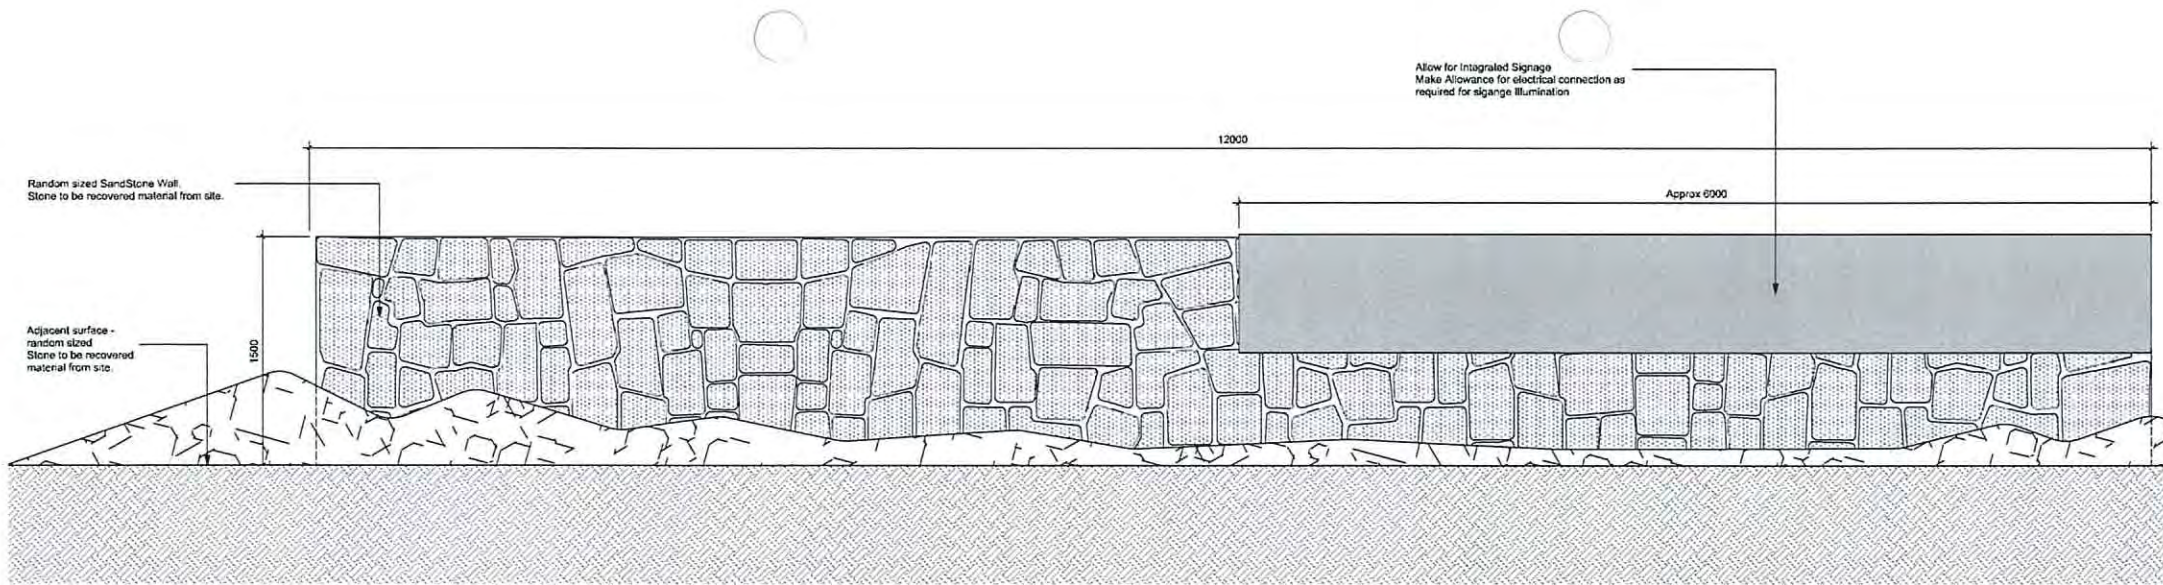

1 Wall Type 1 - Stone Entrance Wall (Indicative Only)
1:20

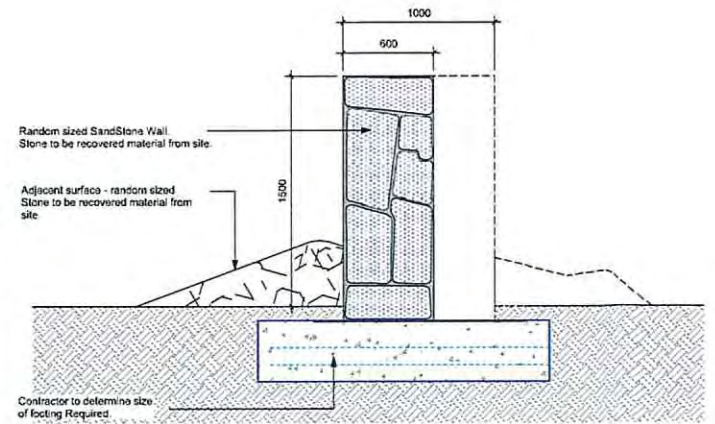


2 Wall Type 1 - Indicative Only
1:20

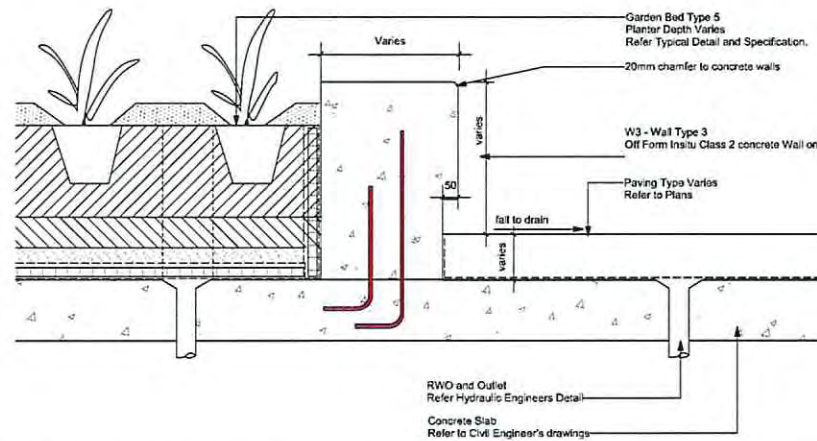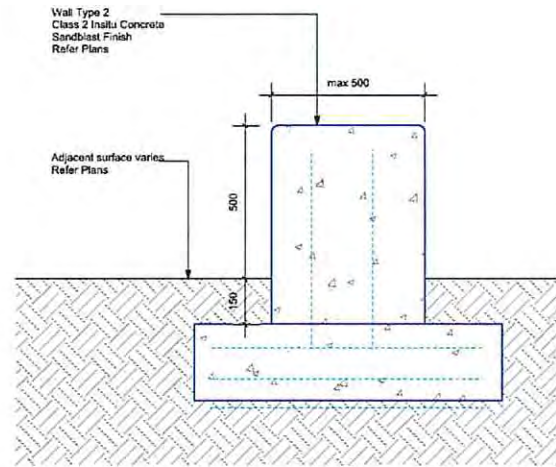


3 Wall Type 2 - Class 2 Insitu Concrete Wall on Grade
1:10

4 Wall Type 3 - Class 2 Insitu Concrete Wall on Slab
1:10

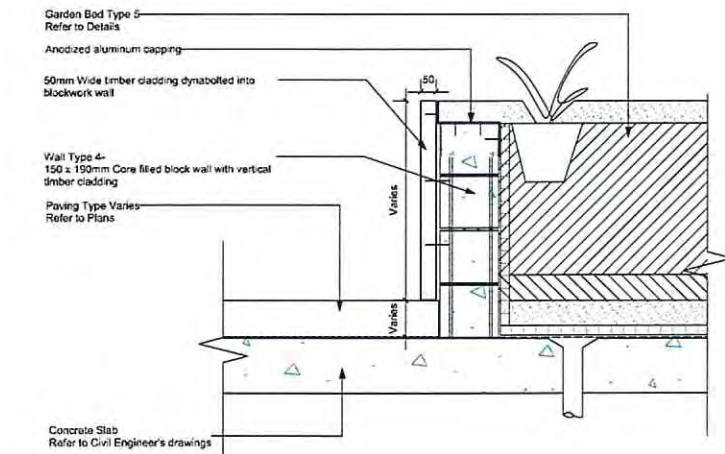


5 Wall Type 4 - Blockwork Wall with Timber Cladding
1:10

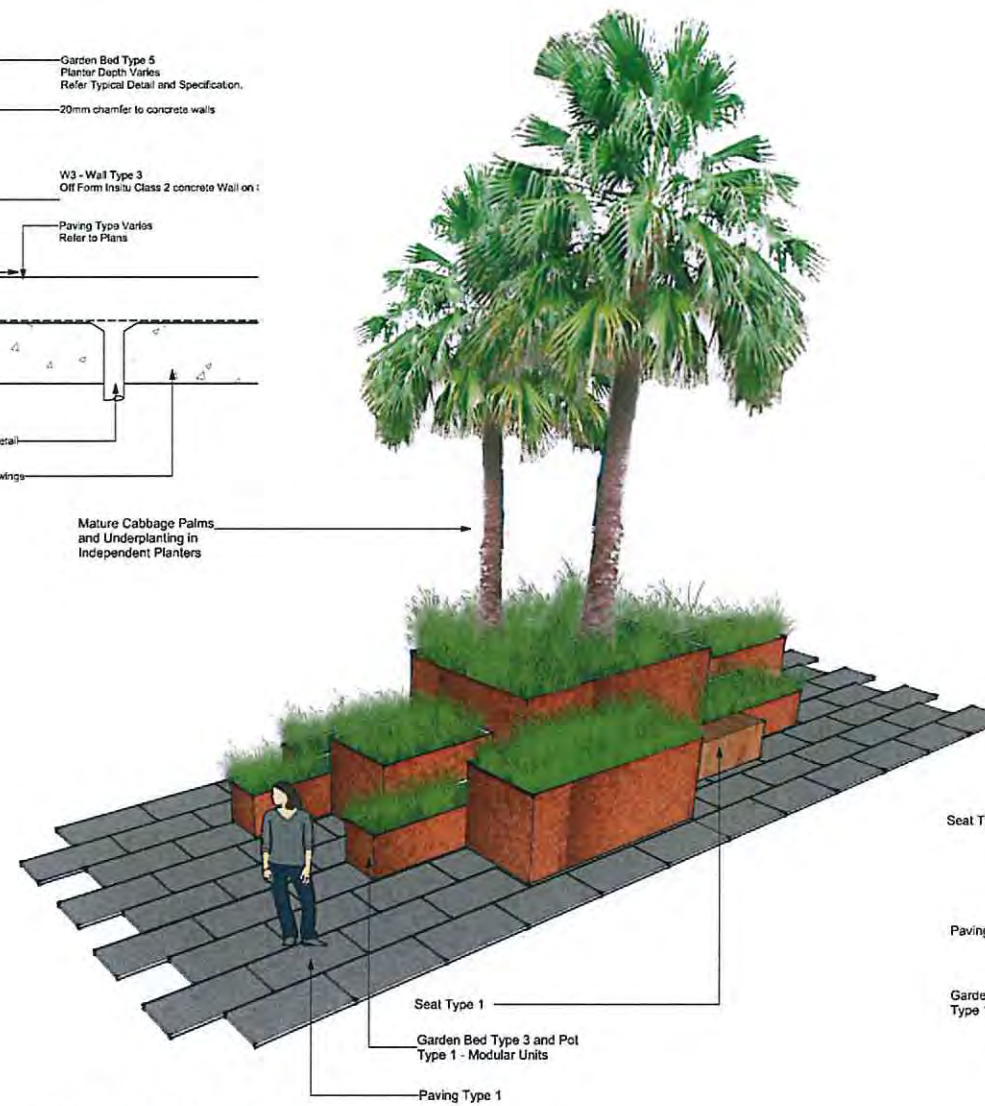


6 Garden Bed Type 3 - 3D Visual




NSW GOVERNMENT
Planning
Issued under the Environmental Planning and Assessment Act 1979
Approved Application No. 29/06/15
granted on the 29/06/15
Signed: [Signature]
Sheet No. 44 of 45

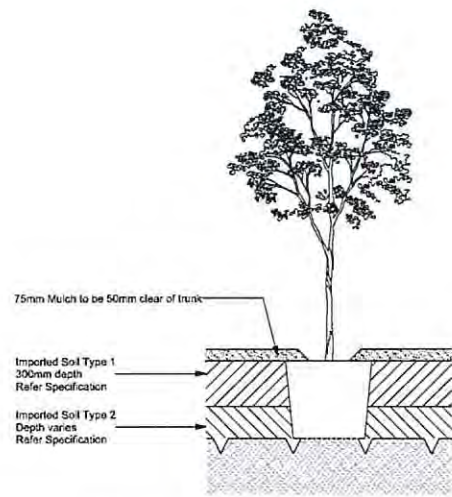


1 Typical Tree Planting
1:20

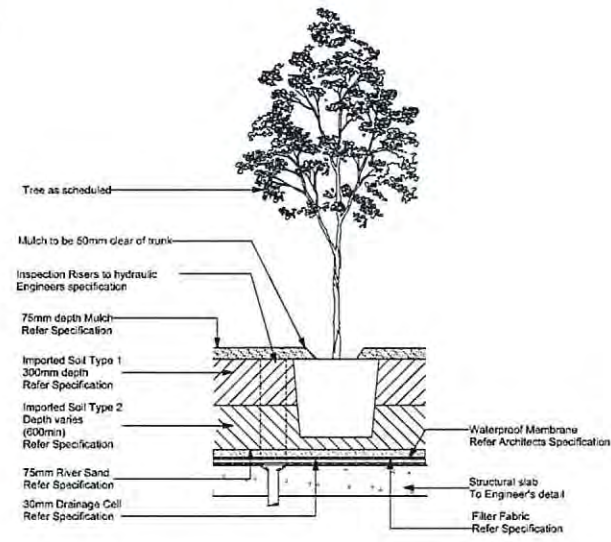


2 Advanced Tree on Slab
1:20

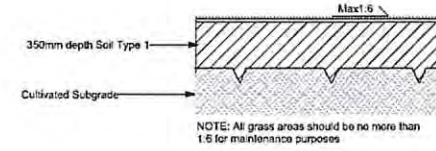


3 Turf
1:10

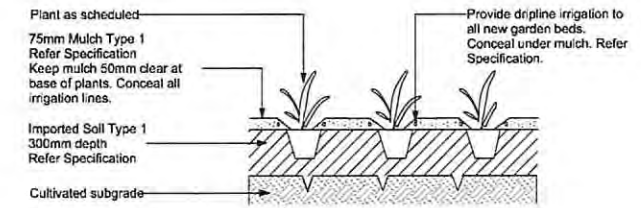


4 GB1- Garden Bed on Grade
1:20

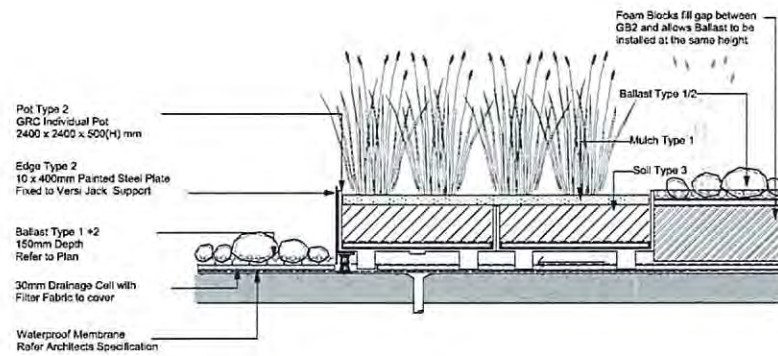


5 GB2 - Independent Planter over Slab - Internal Only
1:20

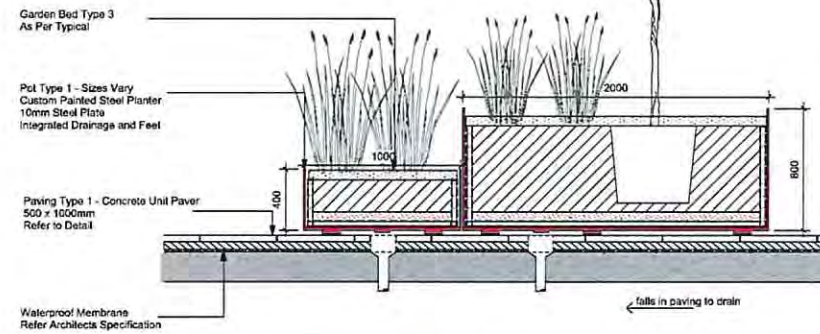


6 GB3- Independent Steel Planter - Entry Courtyards
1:20

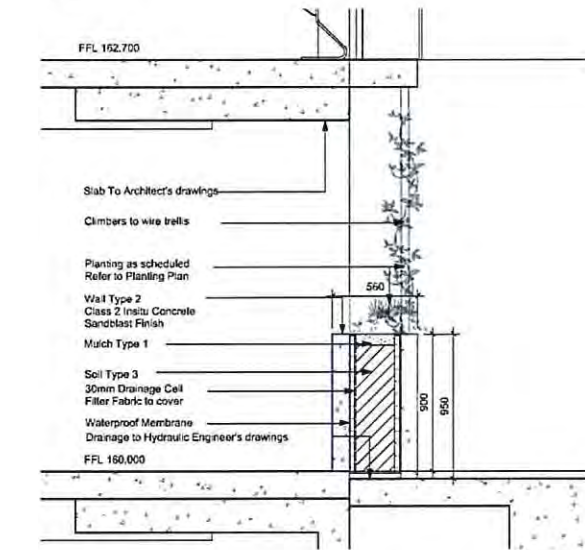

7 GB4 - Car Park Planter
1:20

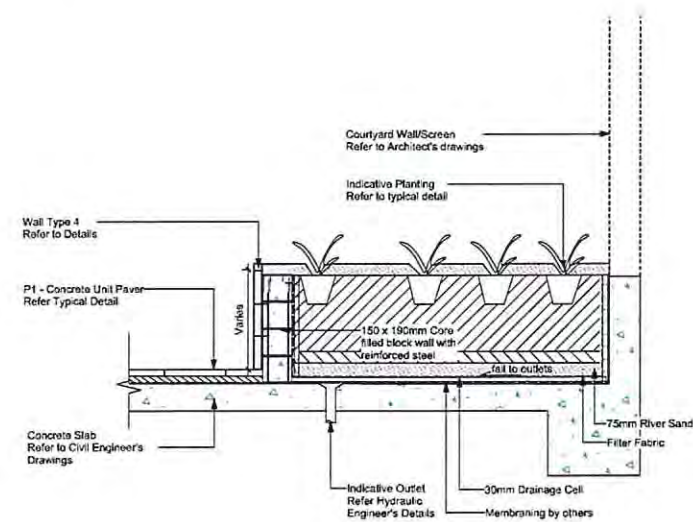

8 GB5 - Garden Bed on Slab - Mental Health Building
1:20

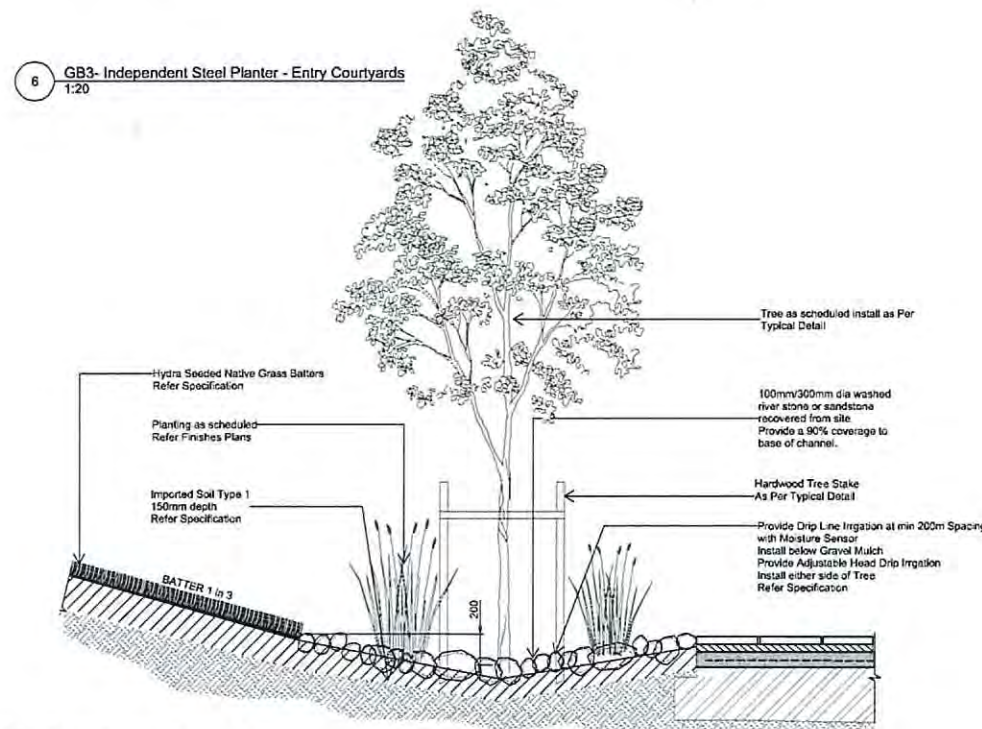

9 Typical Swale and Seeded Batter
1:20

NSW GOVERNMENT
Planning

Issued under the Environmental Planning and Assessment Act 1979

Approved Application No. **SSI 6792**

granted on the **29/06/15**

Signed **[Signature]**

Sheet No. **45** of **45**