



© Copyright 2009
p. + 61 (0)2 8274 8200 w. www.fitzpatrickpartners.com
a. LEVEL 6 156 CLARENCE ST. SYDNEY 2000, AUSTRALIA

THE DRAWING IS ISSUED UPON THE CONDITION IT IS NOT COPIED, REPRODUCED, RETAINED OR DECLARED TO ANY UNAUTHORIZED PERSON EITHER WHOLLY OR IN PART WITHOUT PRIOR CONSENT IN WRITING OF THE COMPANY.

DRAWINGS SHOW DESIGN INTENT ONLY. SHOP DRAWINGS ARE TO BE PROVIDED FOR APPROVAL PRIOR TO CONSTRUCTION OF MANUFACTURE. DO NOT SCALE DRAWINGS. CHECK DIMENSIONS BEFORE COMMENCING.

NUMBERS FOLLOWING AN ABBREVIATION DENOTE A PARTICULAR TYPE OF
ITEM. FOR EXPLANATION OF ITEM TYPES REFER TO SPECIFICATION AND
INDEXES SCHEDULE.



SCALE @ A3
1:2000

PRINT DATE
6/06/2018

DRAWING CONCEPT PLAN

STAGE 1 EIS SUBMISSION
MAITLAND HOSPITAL
DRAWING NO. DA07
ISSUE 10

ISSUE
10



- 1 RETAINED UNDISTURBED FOREST
- 2 LANDSCAPE ZONE
- 3 FUTURE REGENERATED BUSH LAND

NOTES

1. DRAWING IS BASED ON THE EXISTING 8.8 M² COPIES
 2. DRAWING IS BASED ON THE EXISTING 8.8 M² COPIES
 3. DRAWING IS BASED ON THE EXISTING 8.8 M² COPIES
 4. DRAWING IS BASED ON THE EXISTING 8.8 M² COPIES
 5. DRAWING IS BASED ON THE EXISTING 8.8 M² COPIES
 6. DRAWING IS BASED ON THE EXISTING 8.8 M² COPIES
 7. DRAWING IS BASED ON THE EXISTING 8.8 M² COPIES
 8. DRAWING IS BASED ON THE EXISTING 8.8 M² COPIES
 9. DRAWING IS BASED ON THE EXISTING 8.8 M² COPIES
 10. DRAWING IS BASED ON THE EXISTING 8.8 M² COPIES

1. DRAWING IS BASED ON THE EXISTING 8.8 M² COPIES
 2. DRAWING IS BASED ON THE EXISTING 8.8 M² COPIES
 3. DRAWING IS BASED ON THE EXISTING 8.8 M² COPIES
 4. DRAWING IS BASED ON THE EXISTING 8.8 M² COPIES
 5. DRAWING IS BASED ON THE EXISTING 8.8 M² COPIES
 6. DRAWING IS BASED ON THE EXISTING 8.8 M² COPIES
 7. DRAWING IS BASED ON THE EXISTING 8.8 M² COPIES
 8. DRAWING IS BASED ON THE EXISTING 8.8 M² COPIES
 9. DRAWING IS BASED ON THE EXISTING 8.8 M² COPIES
 10. DRAWING IS BASED ON THE EXISTING 8.8 M² COPIES



PROJECT NO.
21701
PROJECT NORTH

SCALE @ A3
1:2000

PRINT DATE
6/06/2018

DRAWING
CONCEPT PLAN - LANDSCAPE ZONAL PLAN

STAGE 1 EIS SUBMISSION
MAITLAND HOSPITAL
 DRAWING NO.
DA08
 ISSUE
10

Planning & Environment

Issued under the *Environmental Planning and Assessment Act 1979*

Approved Application No. 551 9022

granted on the 07 NOV 2018

Signed [Signature]

Sheet No. 2 of 12

fitzpatrick | partners

12 Cowling Street
 P.O. Box 1000
 Sydney 2000 Australia



- WORKS APPROVED UNDER PART 5 OF EPA ACT
- ROAD FOOTPRINT
- BUILDING FOOTPRINT

NSW Planning & Environment
 Issued under the Environmental Planning and Assessment Act 1979
 Approved Application No. SS1 9022
 Granted on the 07 NOV 2018
 Signed
 Sheet No. 12

fitzpatrick+partners

© Copyright 2018
 P.O. Box 222, 2022
 Level 6, 135 Clarence St, Sydney 2000, Australia

NOTES

1. THE DRAWING IS A SUMMARY OF THE INFORMATION PROVIDED IN THE PROJECT DESCRIPTION AND THE PROJECT DESCRIPTION IS THE ONLY SOURCE OF INFORMATION FOR THE PROJECT.
 2. THE DRAWING IS A SUMMARY OF THE INFORMATION PROVIDED IN THE PROJECT DESCRIPTION AND THE PROJECT DESCRIPTION IS THE ONLY SOURCE OF INFORMATION FOR THE PROJECT.
 3. THE DRAWING IS A SUMMARY OF THE INFORMATION PROVIDED IN THE PROJECT DESCRIPTION AND THE PROJECT DESCRIPTION IS THE ONLY SOURCE OF INFORMATION FOR THE PROJECT.

4. THE DRAWING IS A SUMMARY OF THE INFORMATION PROVIDED IN THE PROJECT DESCRIPTION AND THE PROJECT DESCRIPTION IS THE ONLY SOURCE OF INFORMATION FOR THE PROJECT.
 5. THE DRAWING IS A SUMMARY OF THE INFORMATION PROVIDED IN THE PROJECT DESCRIPTION AND THE PROJECT DESCRIPTION IS THE ONLY SOURCE OF INFORMATION FOR THE PROJECT.



PROJECT NO.
21701



SCALE @ A3
1:2000

PRINT DATE
6/06/2018

DRAWING
AREA OF INFLUENCE - BUILDING FOOTPRINT

STAGE 1 EIS SUBMISSION
MAITLAND HOSPITAL
 DRAWING NO. DA10
 ISSUE 10



NOTES

1. THIS DRAWING IS ISSUED UNDER THE ENVIRONMENTAL PLANNING AND ASSESSMENT ACT 1979. IT IS A CONDITION OF ANY DEVELOPMENT APPROVED UNDER THIS ACT THAT THE DEVELOPER SHALL COMPLY WITH THE REQUIREMENTS OF THIS ACT AND THE REGULATIONS MADE THEREUNDER.
2. THIS DRAWING IS A PRELIMINARY DESIGN AND SHOULD NOT BE USED FOR ANY OTHER PURPOSE WITHOUT THE WRITTEN CONSENT OF FITZPATRICK + PARTNERS.
3. THIS DRAWING IS A PRELIMINARY DESIGN AND SHOULD NOT BE USED FOR ANY OTHER PURPOSE WITHOUT THE WRITTEN CONSENT OF FITZPATRICK + PARTNERS.

4. THIS DRAWING IS A PRELIMINARY DESIGN AND SHOULD NOT BE USED FOR ANY OTHER PURPOSE WITHOUT THE WRITTEN CONSENT OF FITZPATRICK + PARTNERS.

CLIENT



PROJECT NO.
21701



PROJECT NORTH

SCALE @ A3
1:2000

PRINT DATE
6/06/2018


DRAWING
AREA OF INFLUENCE - AERIAL OVERLAY


STAGE 1 EIS SUBMISSION

MAITLAND HOSPITAL

DRAWING NO.
DA11

ISSUE
10

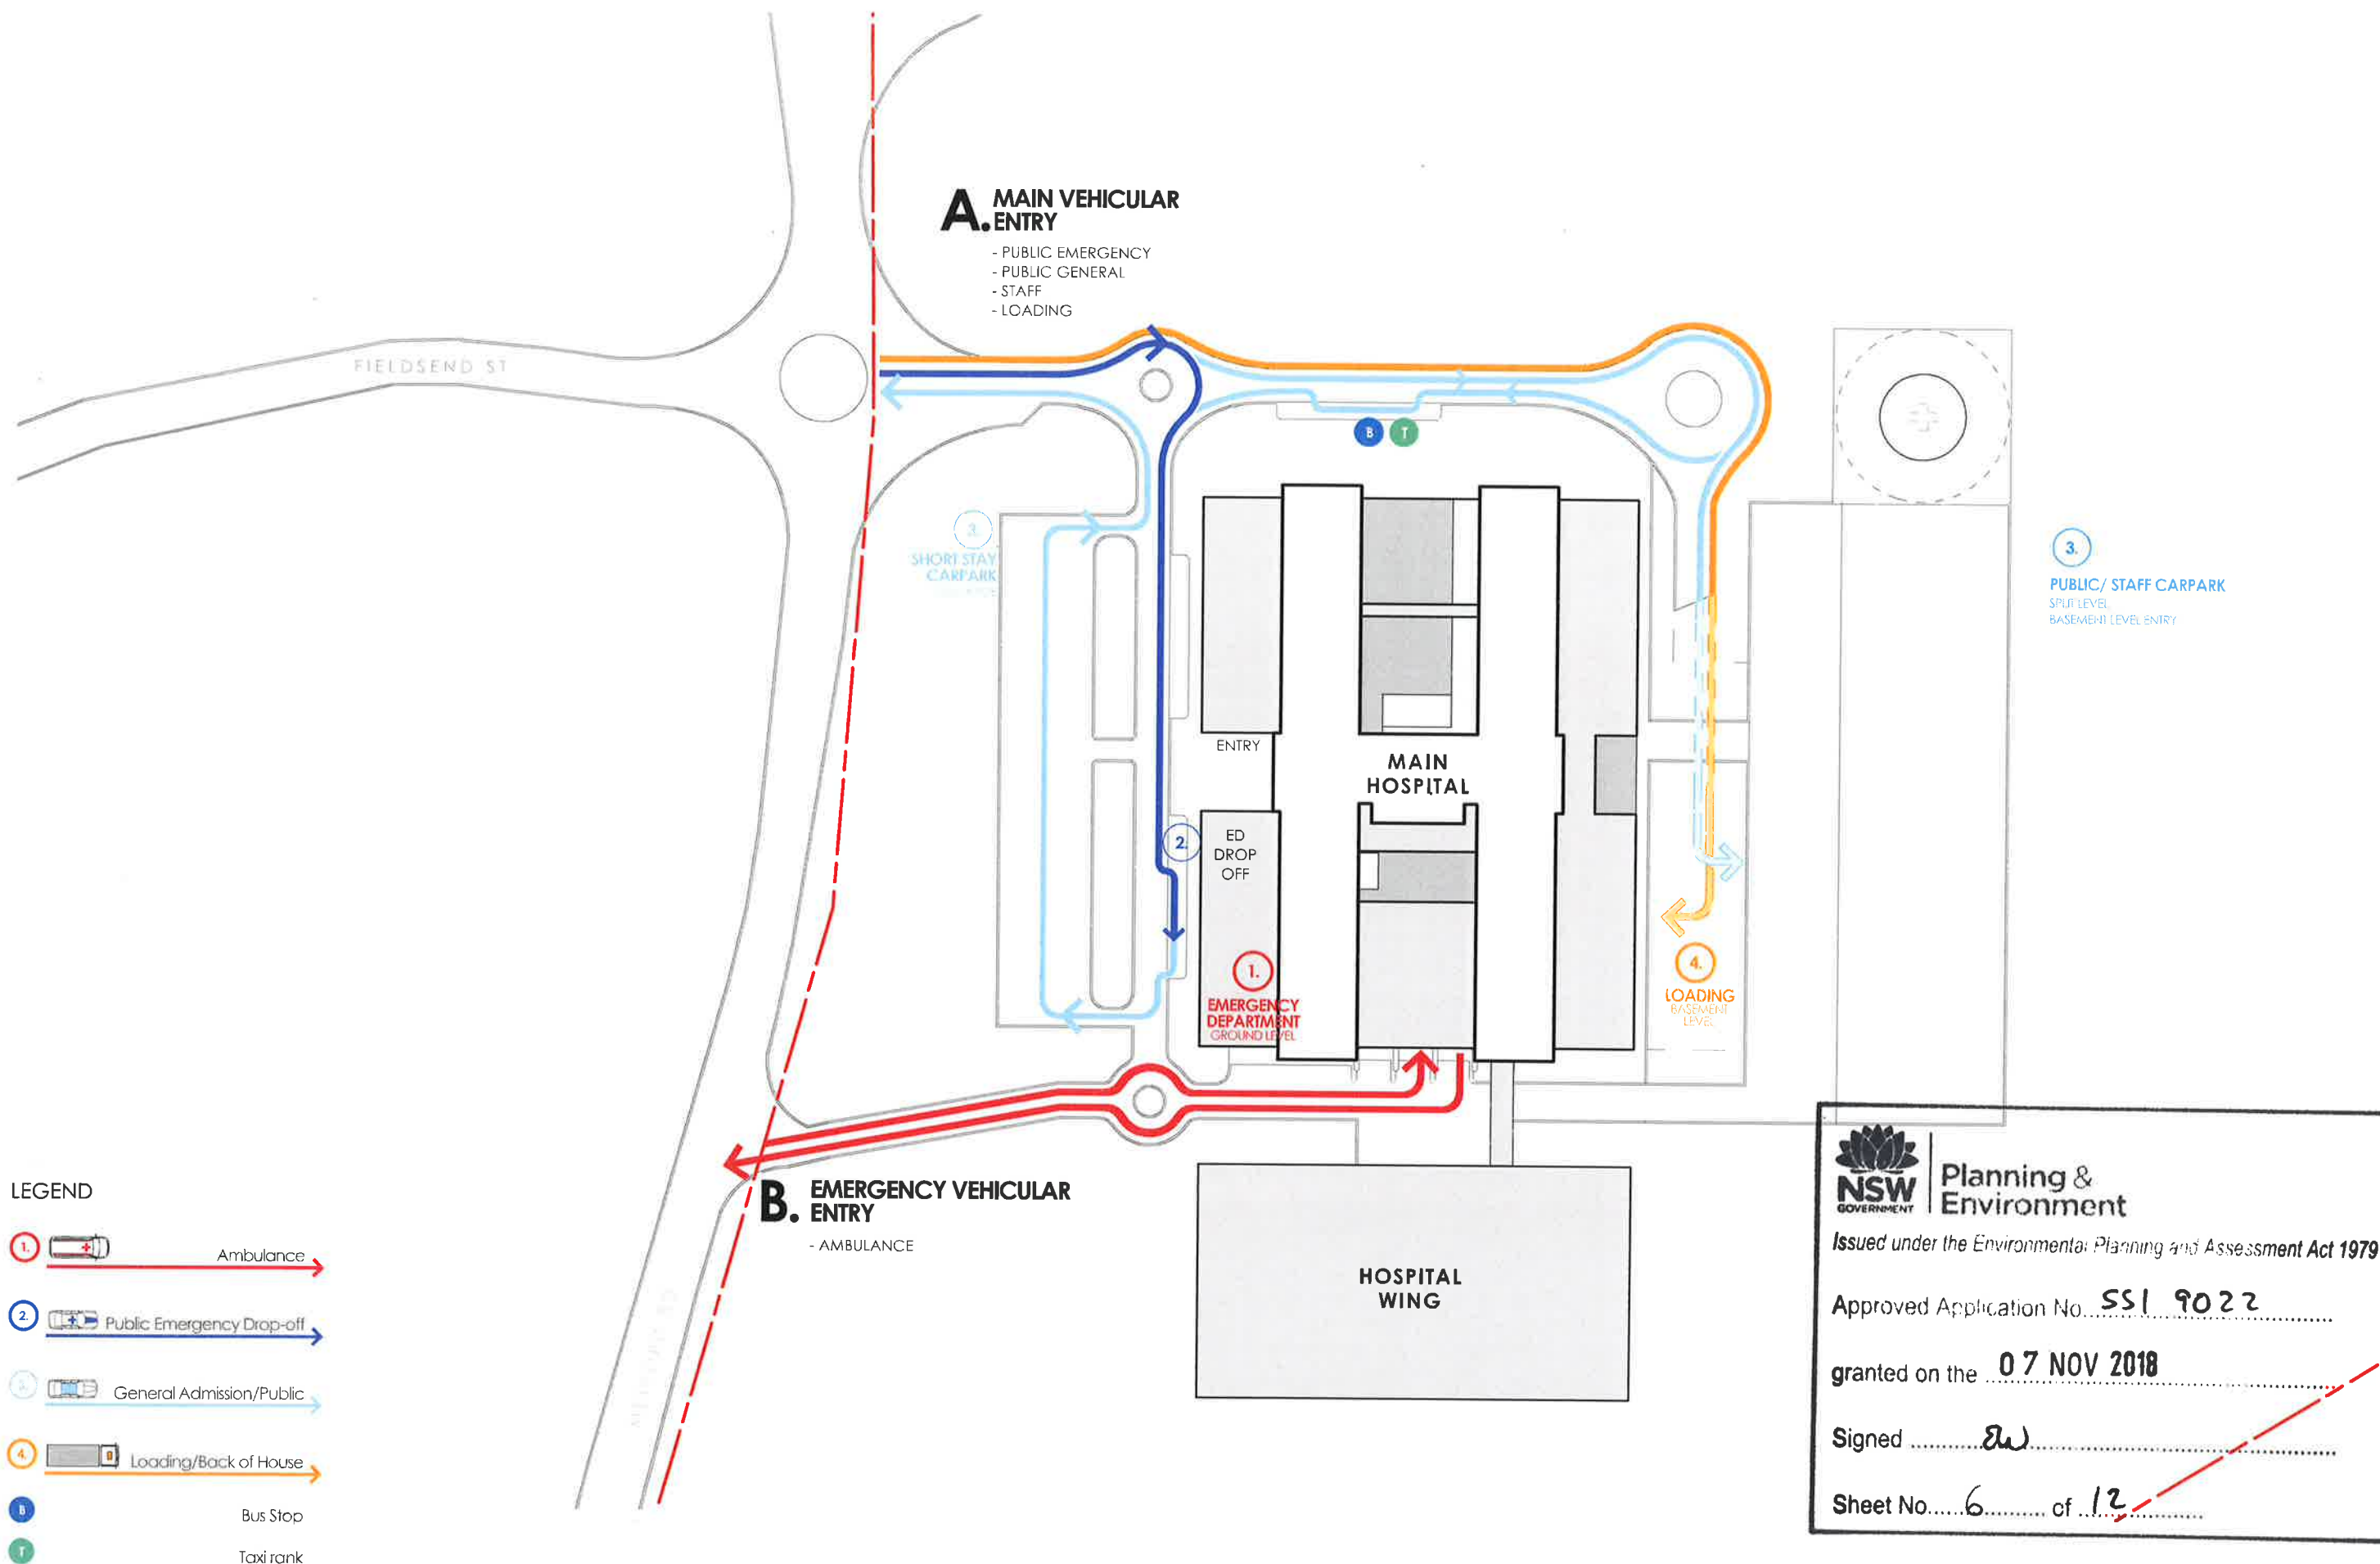

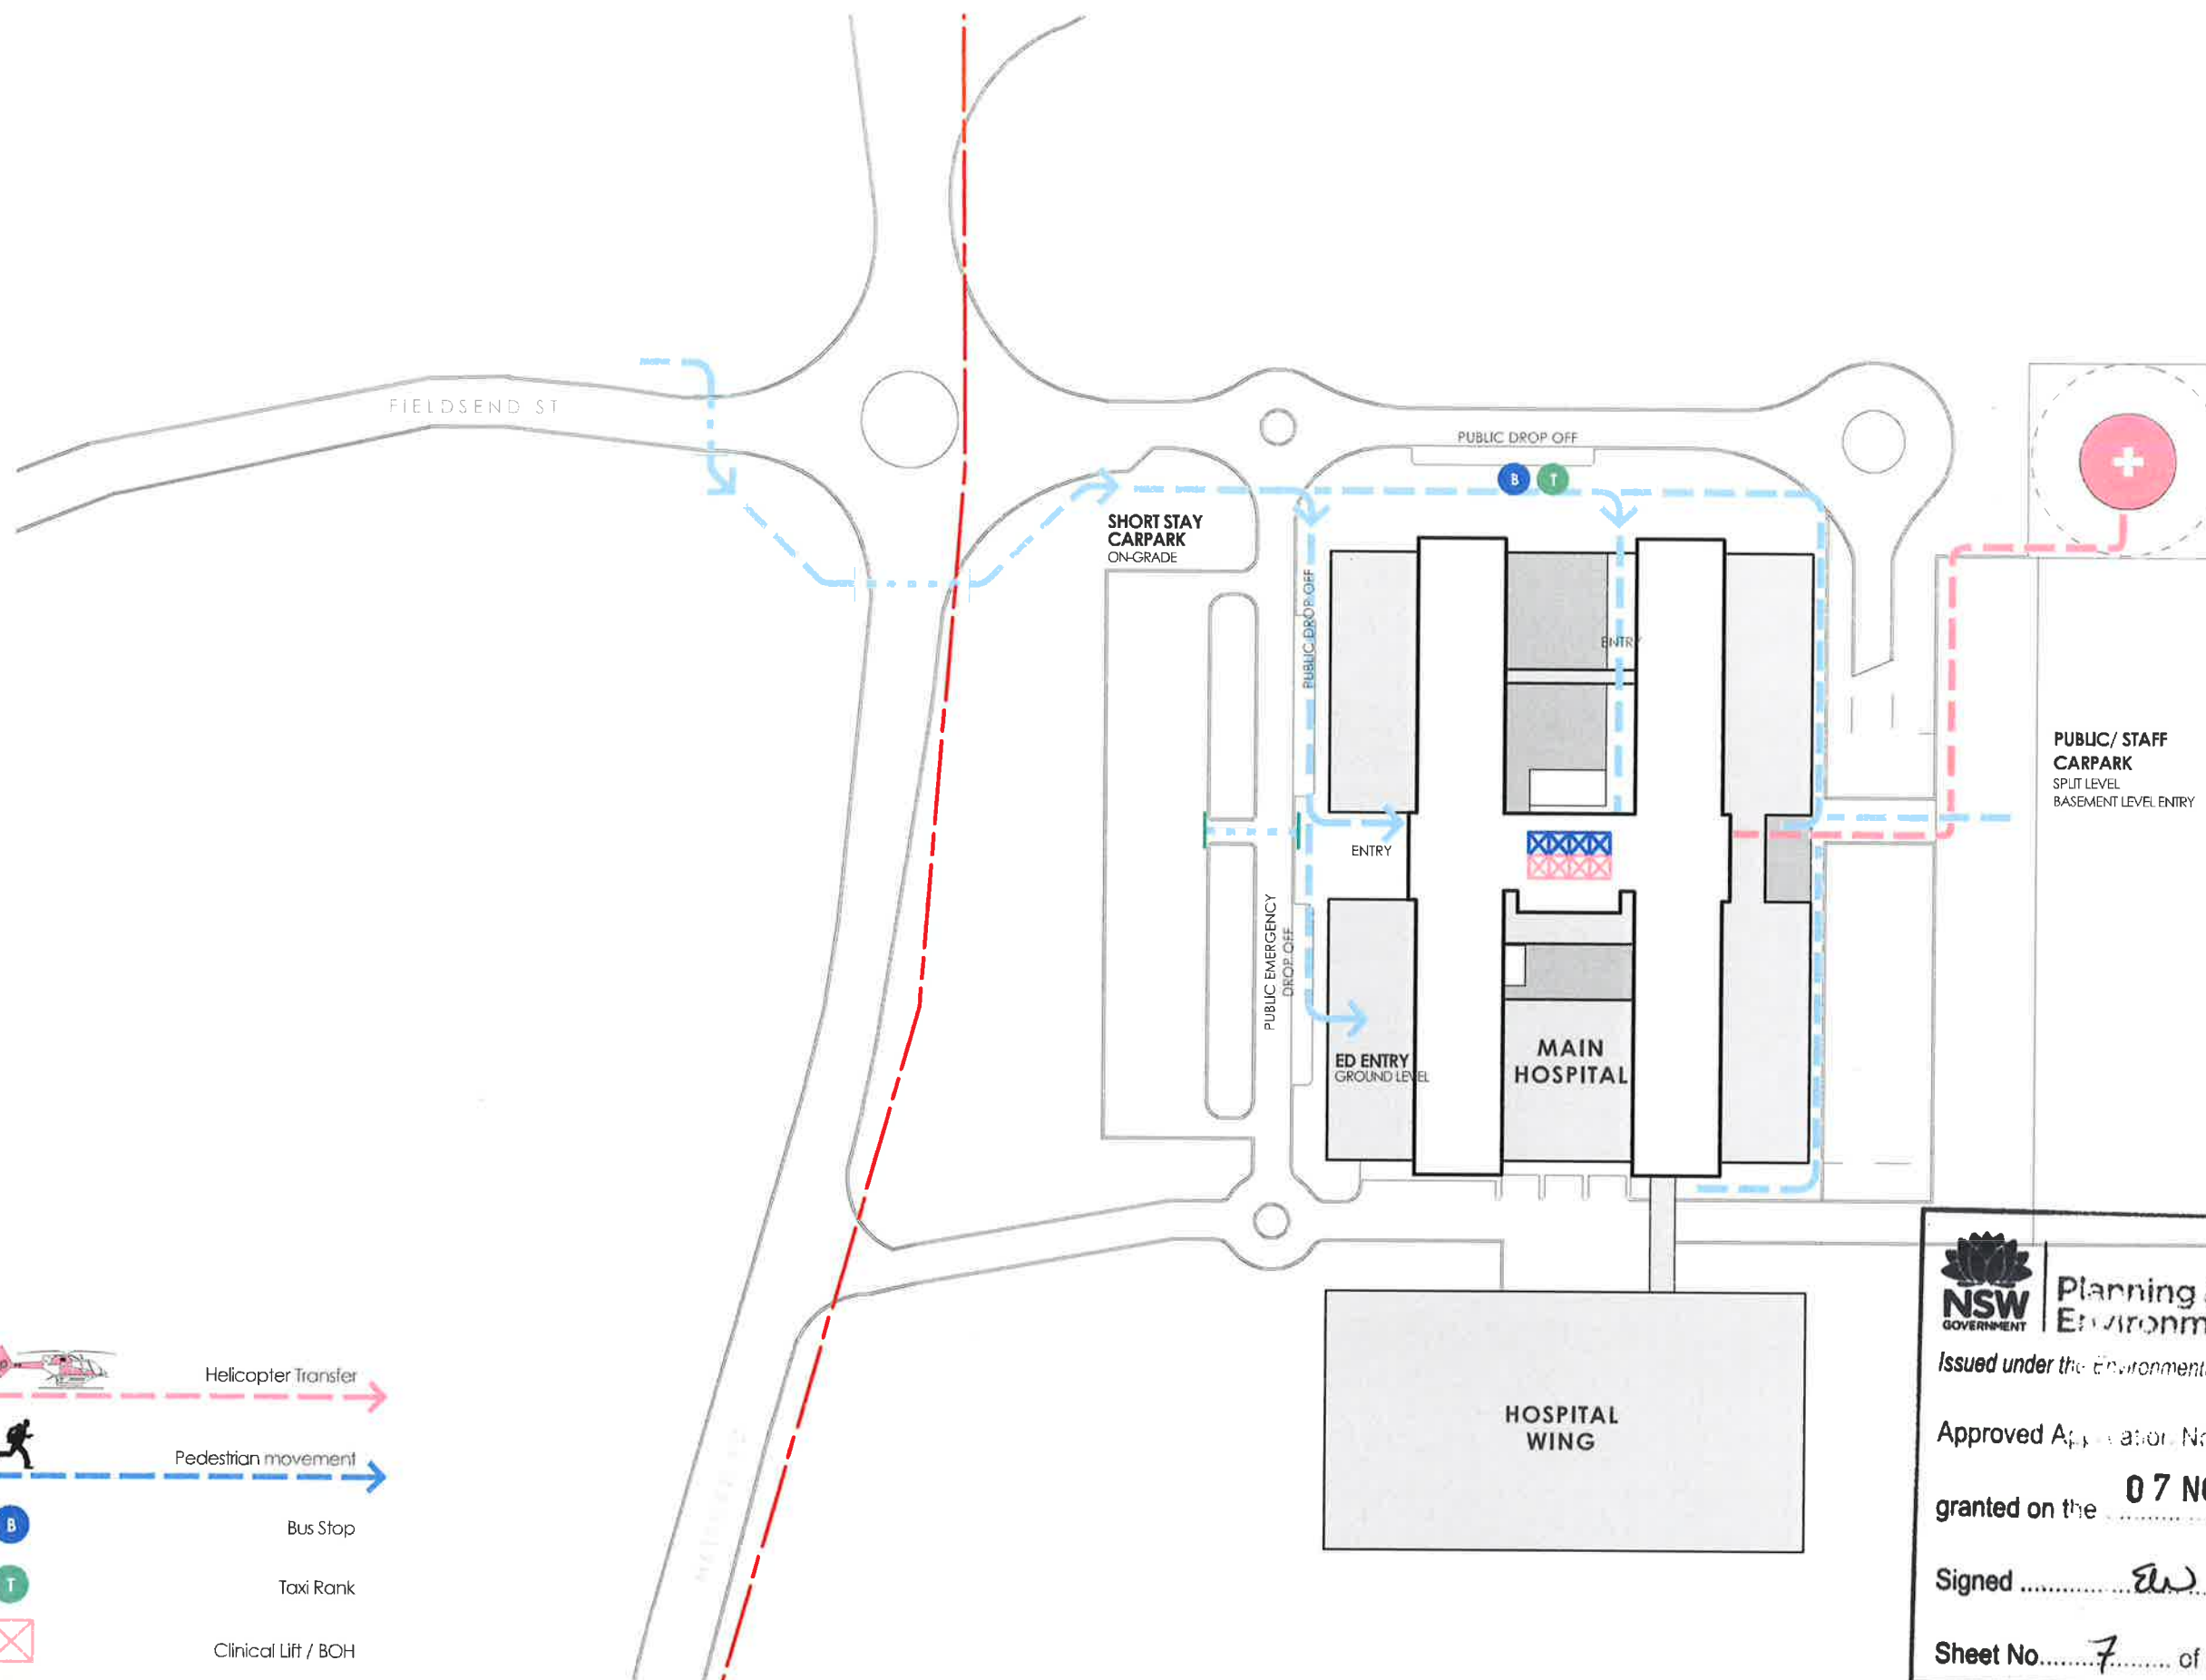

NSW GOVERNMENT Planning & Environment


Issued under the Environmental Planning and Assessment Act 1979

Approved Application No. **551 9022**


granted on the **07 NOV 2018**

Signed *EW*


Sheet No. **7** of **12**

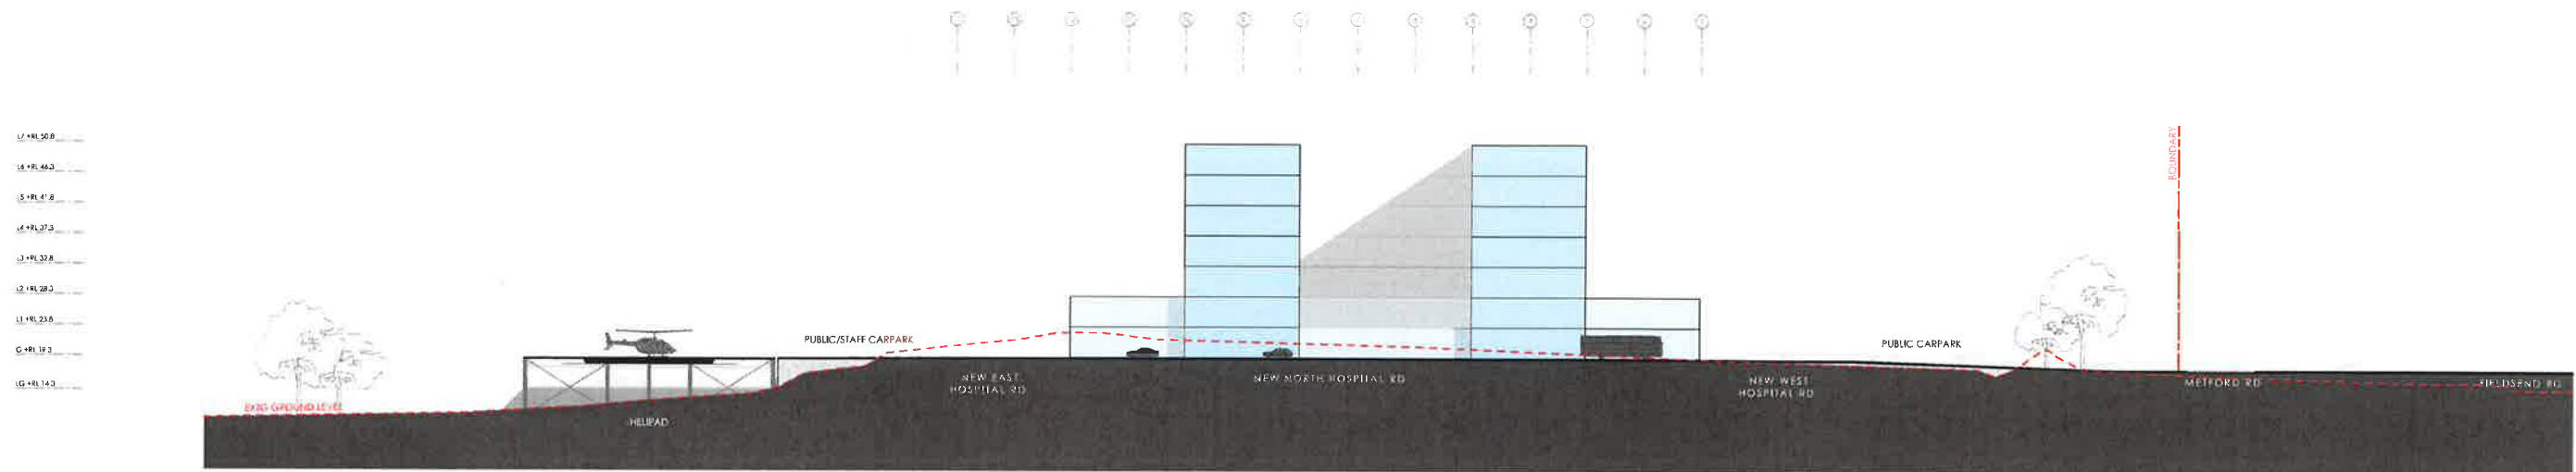


1 - NORTH ELEVATION

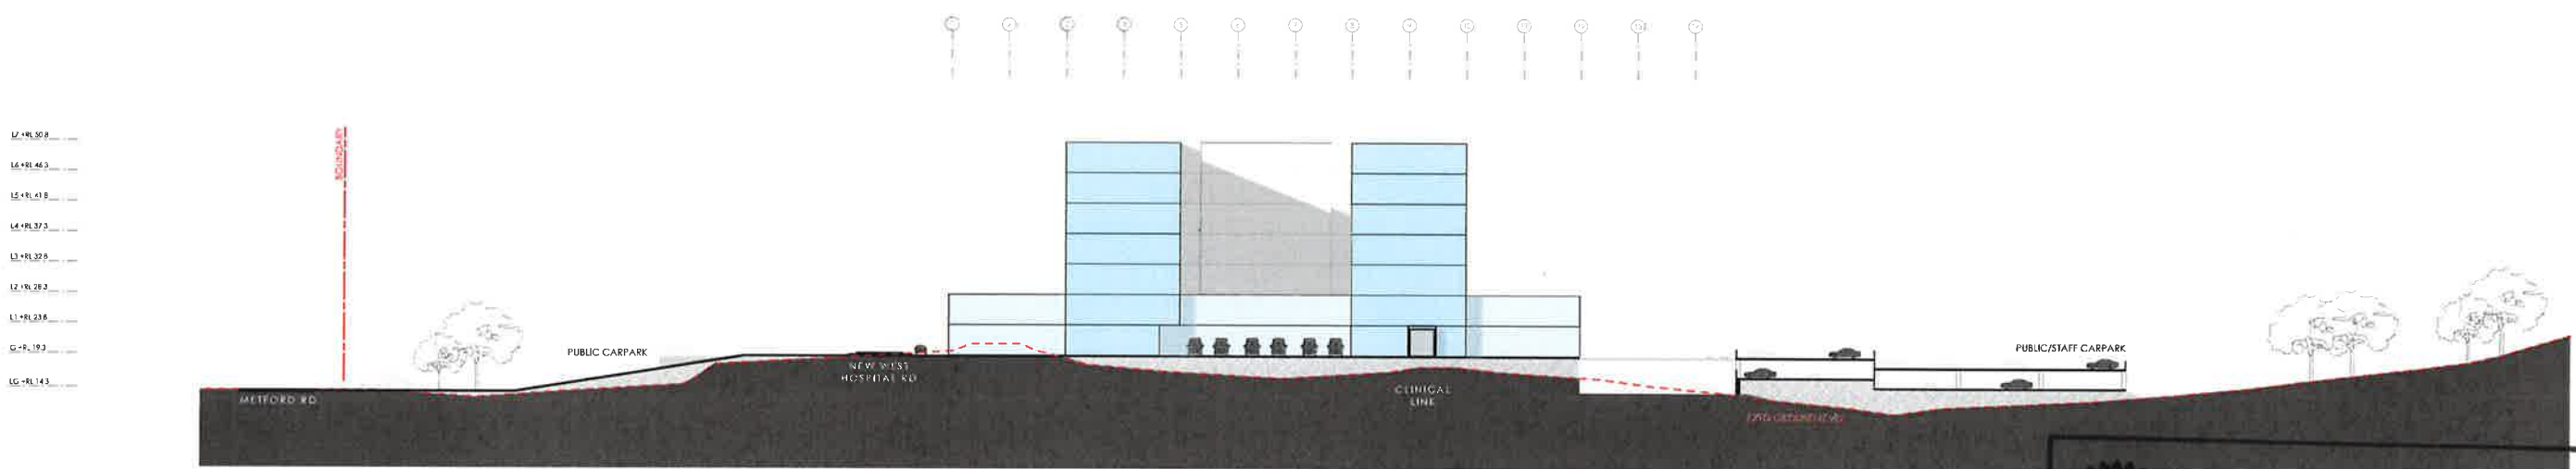

2 - SOUTH ELEVATION

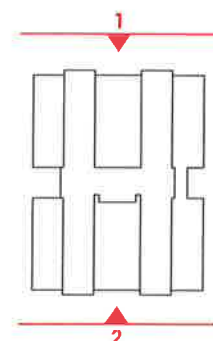

NSW GOVERNMENT | **Planning & Environment**
 Issued under the *Environmental Planning and Assessment Act 1979*
 Approved Application No. **551 9022**
 granted on the **07 NOV 2018**
 Signed **[Signature]**
 Sheet No. **8** of **12**

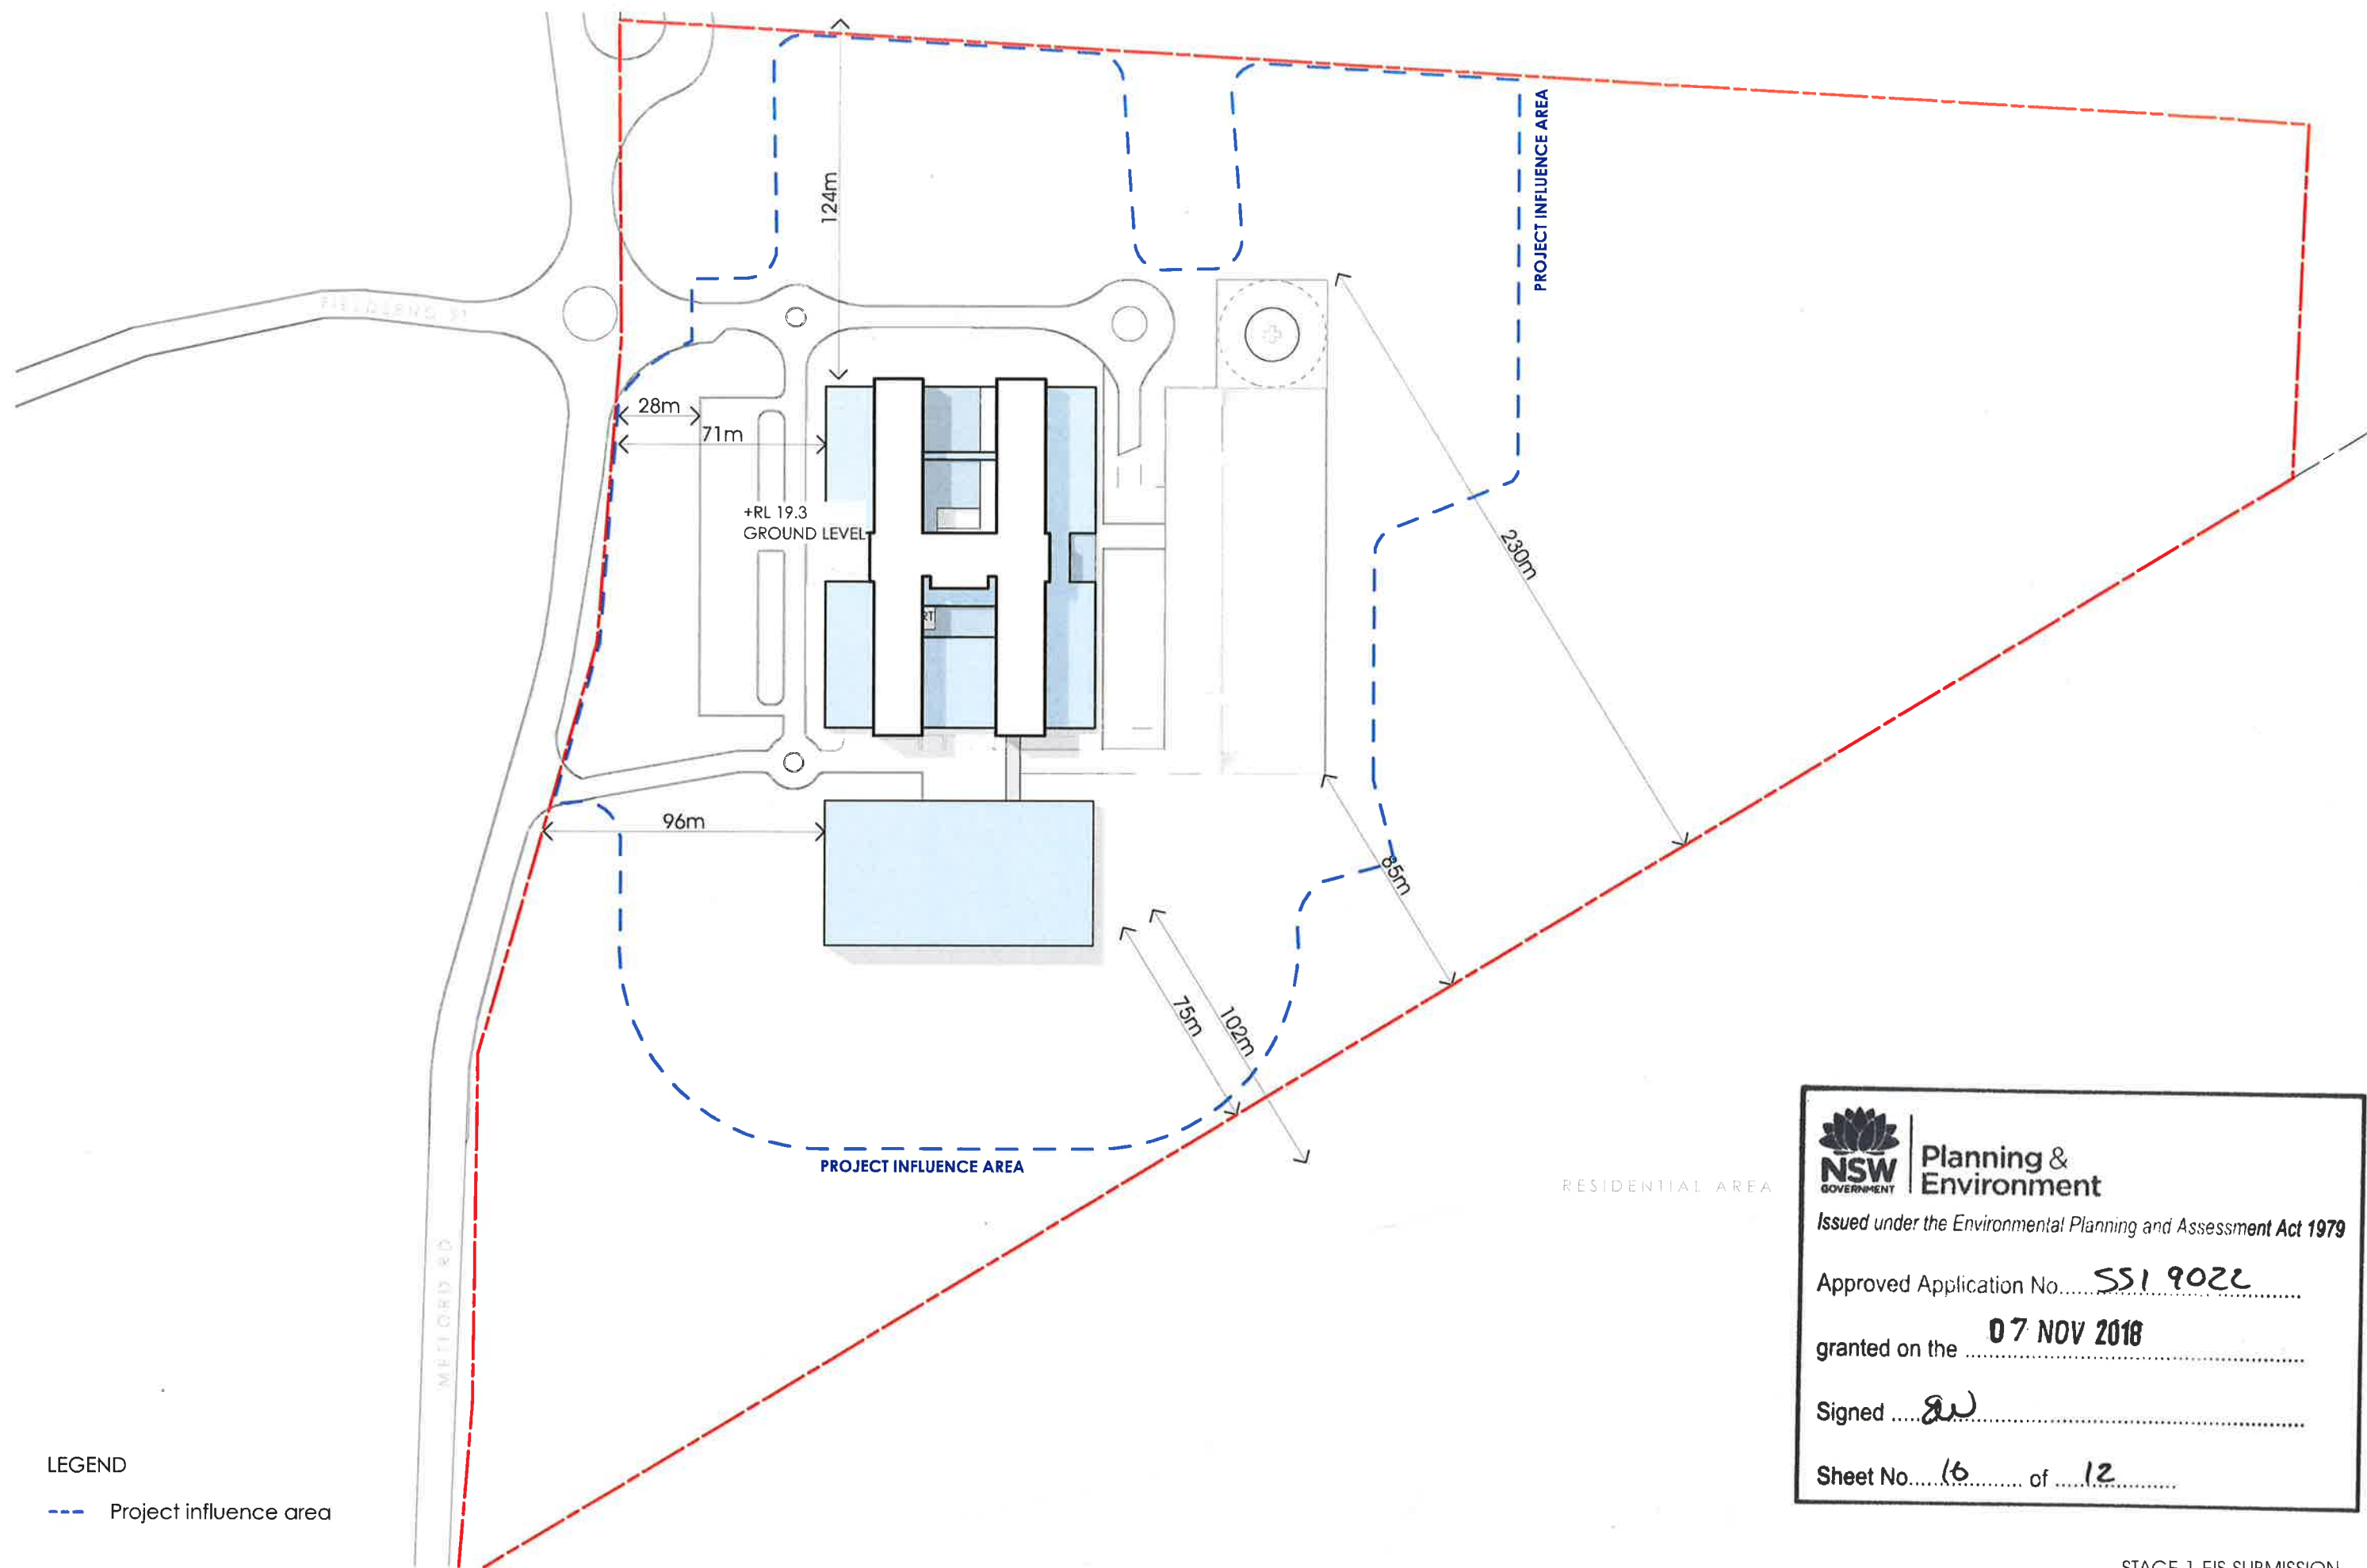

LEGEND
 --- Project influence area

NSW GOVERNMENT | **Planning & Environment**
 Issued under the Environmental Planning and Assessment Act 1979
 Approved Application No. **SSI 9022**
 granted on the **07 NOV 2018**
 Signed **[Signature]**
 Sheet No. **6** of **12**

fitzpatrick + partners

© Copyright 2018
 p + a | t + p | 8374 8022 | w www.fitzpatrickpartners.com
 a LEVEL 6 | 136 CLARENCE ST | SYDNEY 2000 | AUSTRALIA

NOTES

1. DRAWING IS BASED UPON THE CONCEPT PLAN AND SETBACKS REPORT.
 2. PROPOSED SETBACKS ARE BASED ON THE CONCEPT PLAN AND SETBACKS REPORT.
 3. DRAWING IS FOR INFORMATION ONLY. DRAWING IS NOT TO BE USED FOR CONSTRUCTION.
 4. ANY CHANGES TO THE CONCEPT PLAN AND SETBACKS REPORT MUST BE APPROVED BY THE CLIENT.

5. THE DRAWING IS FOR INFORMATION ONLY. DRAWING IS NOT TO BE USED FOR CONSTRUCTION.
 6. ANY CHANGES TO THE CONCEPT PLAN AND SETBACKS REPORT MUST BE APPROVED BY THE CLIENT.

CLIENT
NSW GOVERNMENT | **Health Infrastructure**

PROJECT NO.
 21701


PROJECT NORTH

SCALE @ A3
 1:2000

PRINT DATE
 6/06/2018

DRAWING
 CONCEPT PLAN - SETBACKS

STAGE 1 EIS SUBMISSION
MAITLAND HOSPITAL
 DRAWING NO.
 DA22
 ISSUE
 10

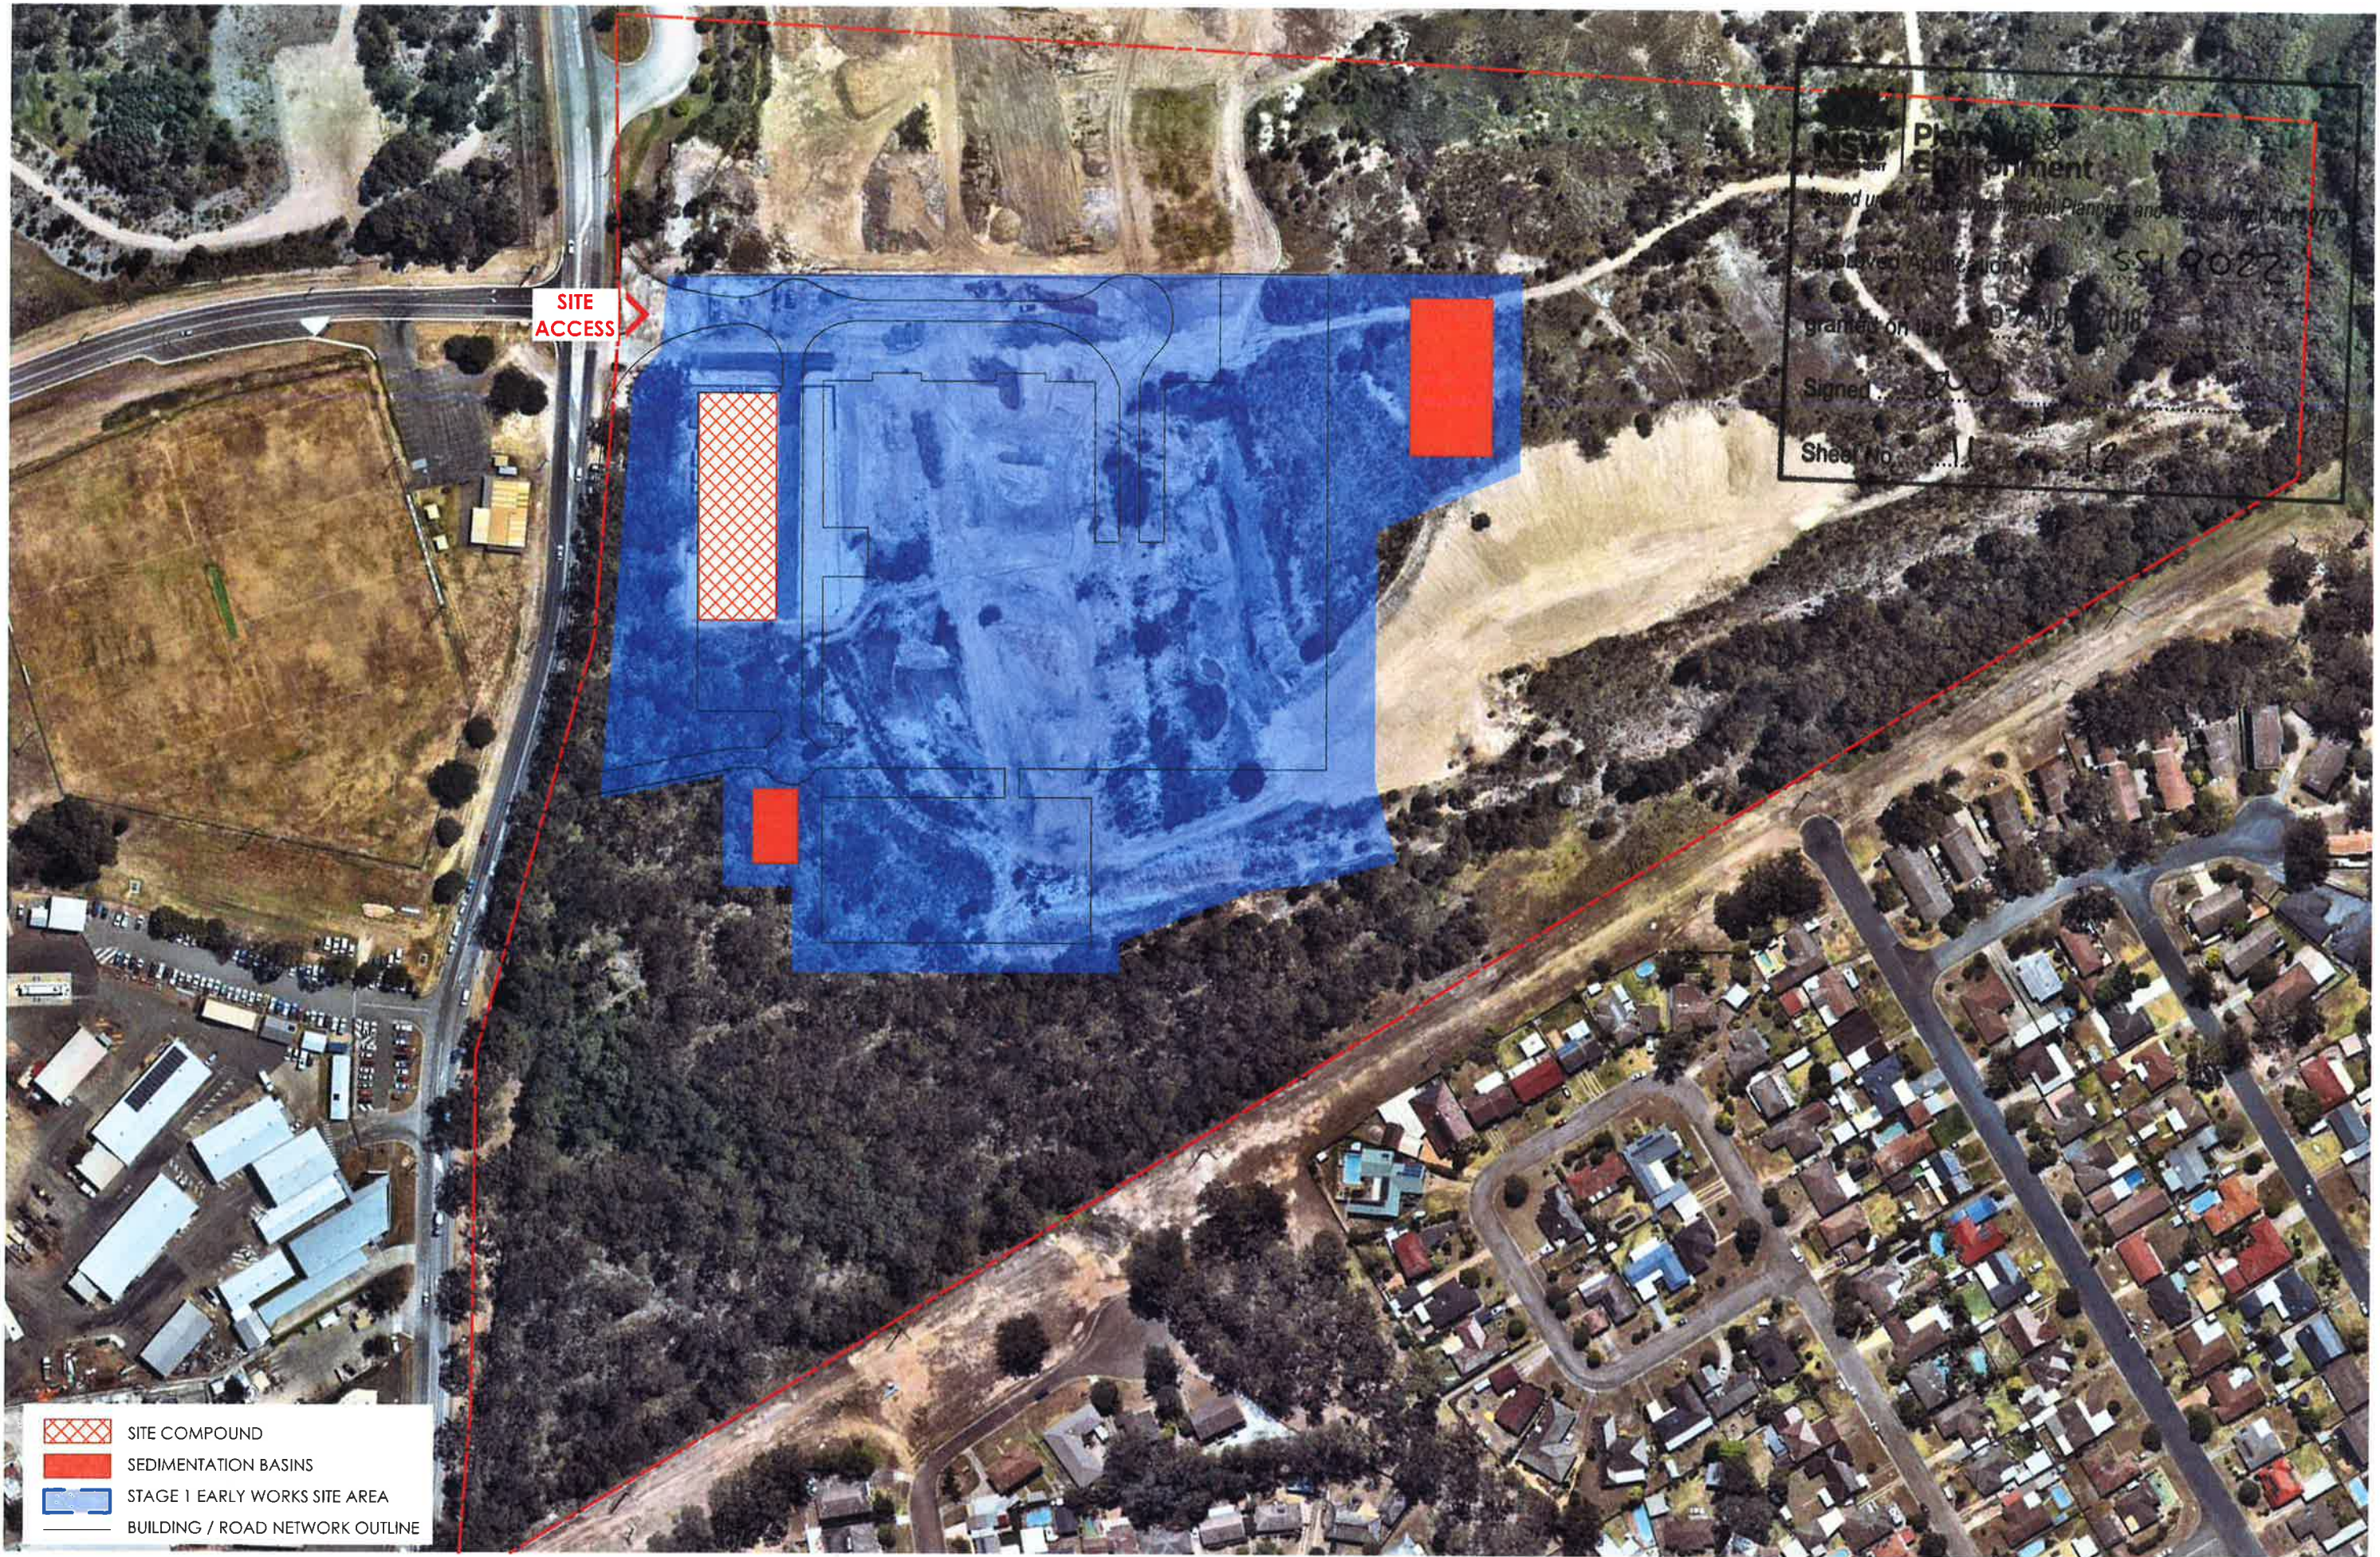

NOTES

1. ALL WORKS TO BE COMPLETED BY 31/03/2019
2. ALL WORKS TO BE COMPLETED BY 31/03/2019
3. ALL WORKS TO BE COMPLETED BY 31/03/2019
4. ALL WORKS TO BE COMPLETED BY 31/03/2019
5. ALL WORKS TO BE COMPLETED BY 31/03/2019
6. ALL WORKS TO BE COMPLETED BY 31/03/2019
7. ALL WORKS TO BE COMPLETED BY 31/03/2019
8. ALL WORKS TO BE COMPLETED BY 31/03/2019
9. ALL WORKS TO BE COMPLETED BY 31/03/2019
10. ALL WORKS TO BE COMPLETED BY 31/03/2019

