


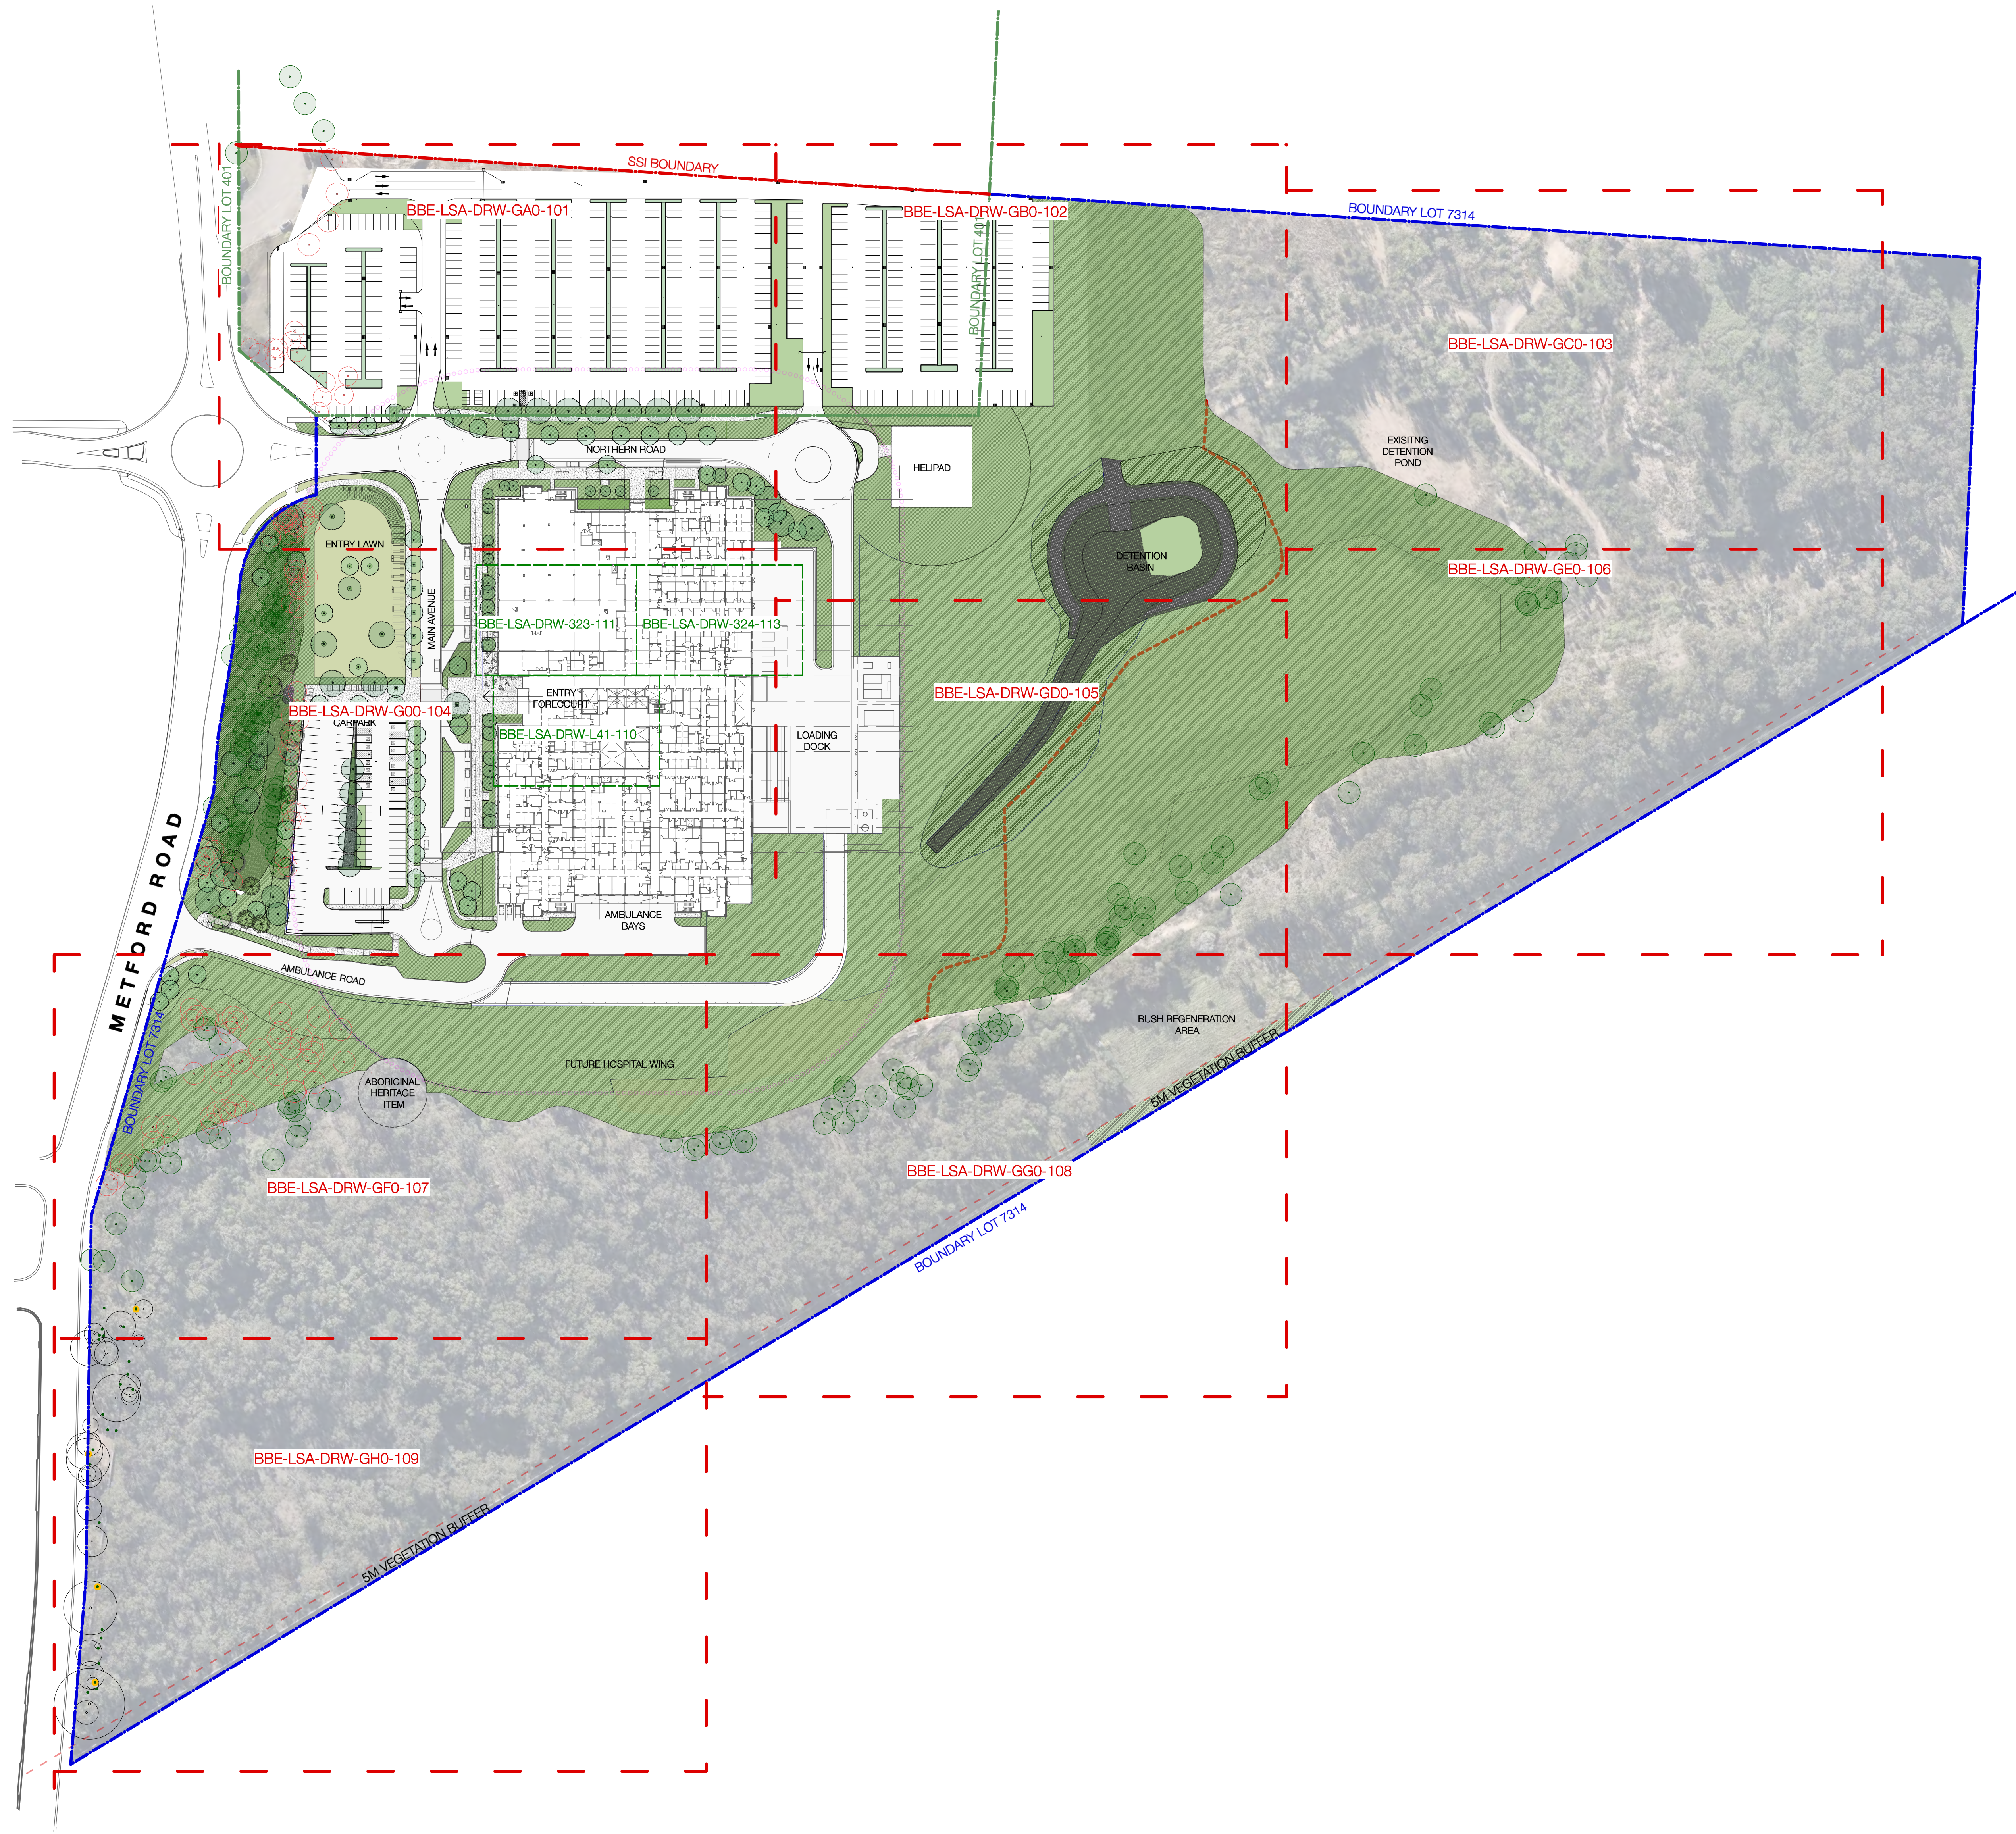

LEGEND

BOUNDARY LINE

PLANT MIX 01 - GRASSES AND GROUNDCOVERS

PLANT MIX 02 - SHRUBS AND GROUNDCOVERS

PLANT MIX 03 - WISUD GRASSES AND GROUND COVERS

PLANT MIX 04 - WISUD GRASSES AND GROUND COVERS

PLANT MIX 06 - STORMWATER SWALE

PLANT MIX 07 - SCREEN PLANTING

PLANT MIX 08 - HYDRICMULCH

PLANT MIX 09 - BUSH REGENERATION

PLANT MIX 12 - DETENTION BASIN

TURF PROFILE 01 - TURF ON GRADE

PAVEMENT TYPE 01 - CONCRETE FOOTPATH
SOFT COVE FINISH (NO TOOLED MARGINS)

PAVEMENT TYPE 02 - CONCRETE FOOTPATH EXPOSED
AGGREGATE FINISH (NO TOOLED MARGINS)

PAVEMENT TYPE 03 - ASPHALT REFER TO ENGINEERS
DOCUMENTATION (TTW)

PAVEMENT TYPE 04 - GRAVEL

PAVEMENT TYPE 05 - TILE

PAVEMENT TYPE 06 - SYNTHETIC TURF

PAVEMENT TYPE 07 - DECKING

PAVEMENT TYPE 08 - GRAVEL REFER TO ENGINEERS
DOCUMENTATION (TTW)

TREE PITS

BENCH SEAT

STORMWATER LINE. REFER TO ENGINEERS
DOCUMENTATION (TTW)

INLET PIT / STORMWATER PIT. REFER TO
ENGINEERS DOCUMENTATION (TTW)

EXISTING TREE TO BE REMOVED. REFER
TO ARBORISTS REPORT

EXISTING TREE TO BE RETAINED AND
PROTECTED. REFER TO ARBORISTS
REPORT

14	SSI Submission	18.06.19
13	For Coordination	13.05.19
12	SSI Submission	09.04.19
11	SSI Submission	03.04.19
10	SSI Submission	02.04.19
09	SSI Submission	28.03.19
08	SSI Submission	14.03.19
07	SSI Submission	18.02.19
06	SSI Submission	17.02.19
05	SSI Submission	14.02.19
04	Schematic Design	11.02.19
03	Schematic Design	17.01.19
02	Preliminary Schematic Design	10.12.18
01	Draft for Review	30.11.18

Rev	Description	Date
-----	-------------	------

MANAGING CONTRACTOR

MULTIPLEX

CONSULTANTS

PROJECT MANAGEMENT

CBRE

ARCHITECTURE

BVN

STRUCTURES & CIVIL

TTW Taylor Thomson Whitting

612 MARR 1000 | 401 Dundas Street S | Melbourne VIC 3006

HYDRAULIC & FIRE

MECHANICAL

ELECTRICAL

CLIENT



PROJECT

NEW MAITLAND HOSPITAL
Metford Road, Metford

DRAWING TITLE

COVER SHEET & KEY PLAN

STATUS	SSI	JOB NO.	1229
SCALE AT A0	1:1000	DRAWN	GB
		CO-ORDINATED	GB/IK
		CHECKED	IK
		APPROVED	GB/IK
DWG NO.	BBE-LSA-DRW-GXO-100	ISSUE	14

Original Sheet Size A0 - 1188 x 841mm

FOR INFORMATION