


STAGING & BUILDING LEGEND

- NEW & REFURBISHED BUILDINGS
- NEW PAVEMENT
- EXISTING BUILDING
- EXISTING PAVEMENT
- TEMPORARY HARD STAND
- 01

EXISTING BUILDING
- 30

NEW BUILDING
- 2.4m WIDE OVERHEAD ELECTRICITY ZONE
- PP

EXISTING POWER POLE
- EXISTING BOUNDARY LINE
- EXISTING FENCE LINE
- CONSTRUCTION SITE TEMPORARY FENCE

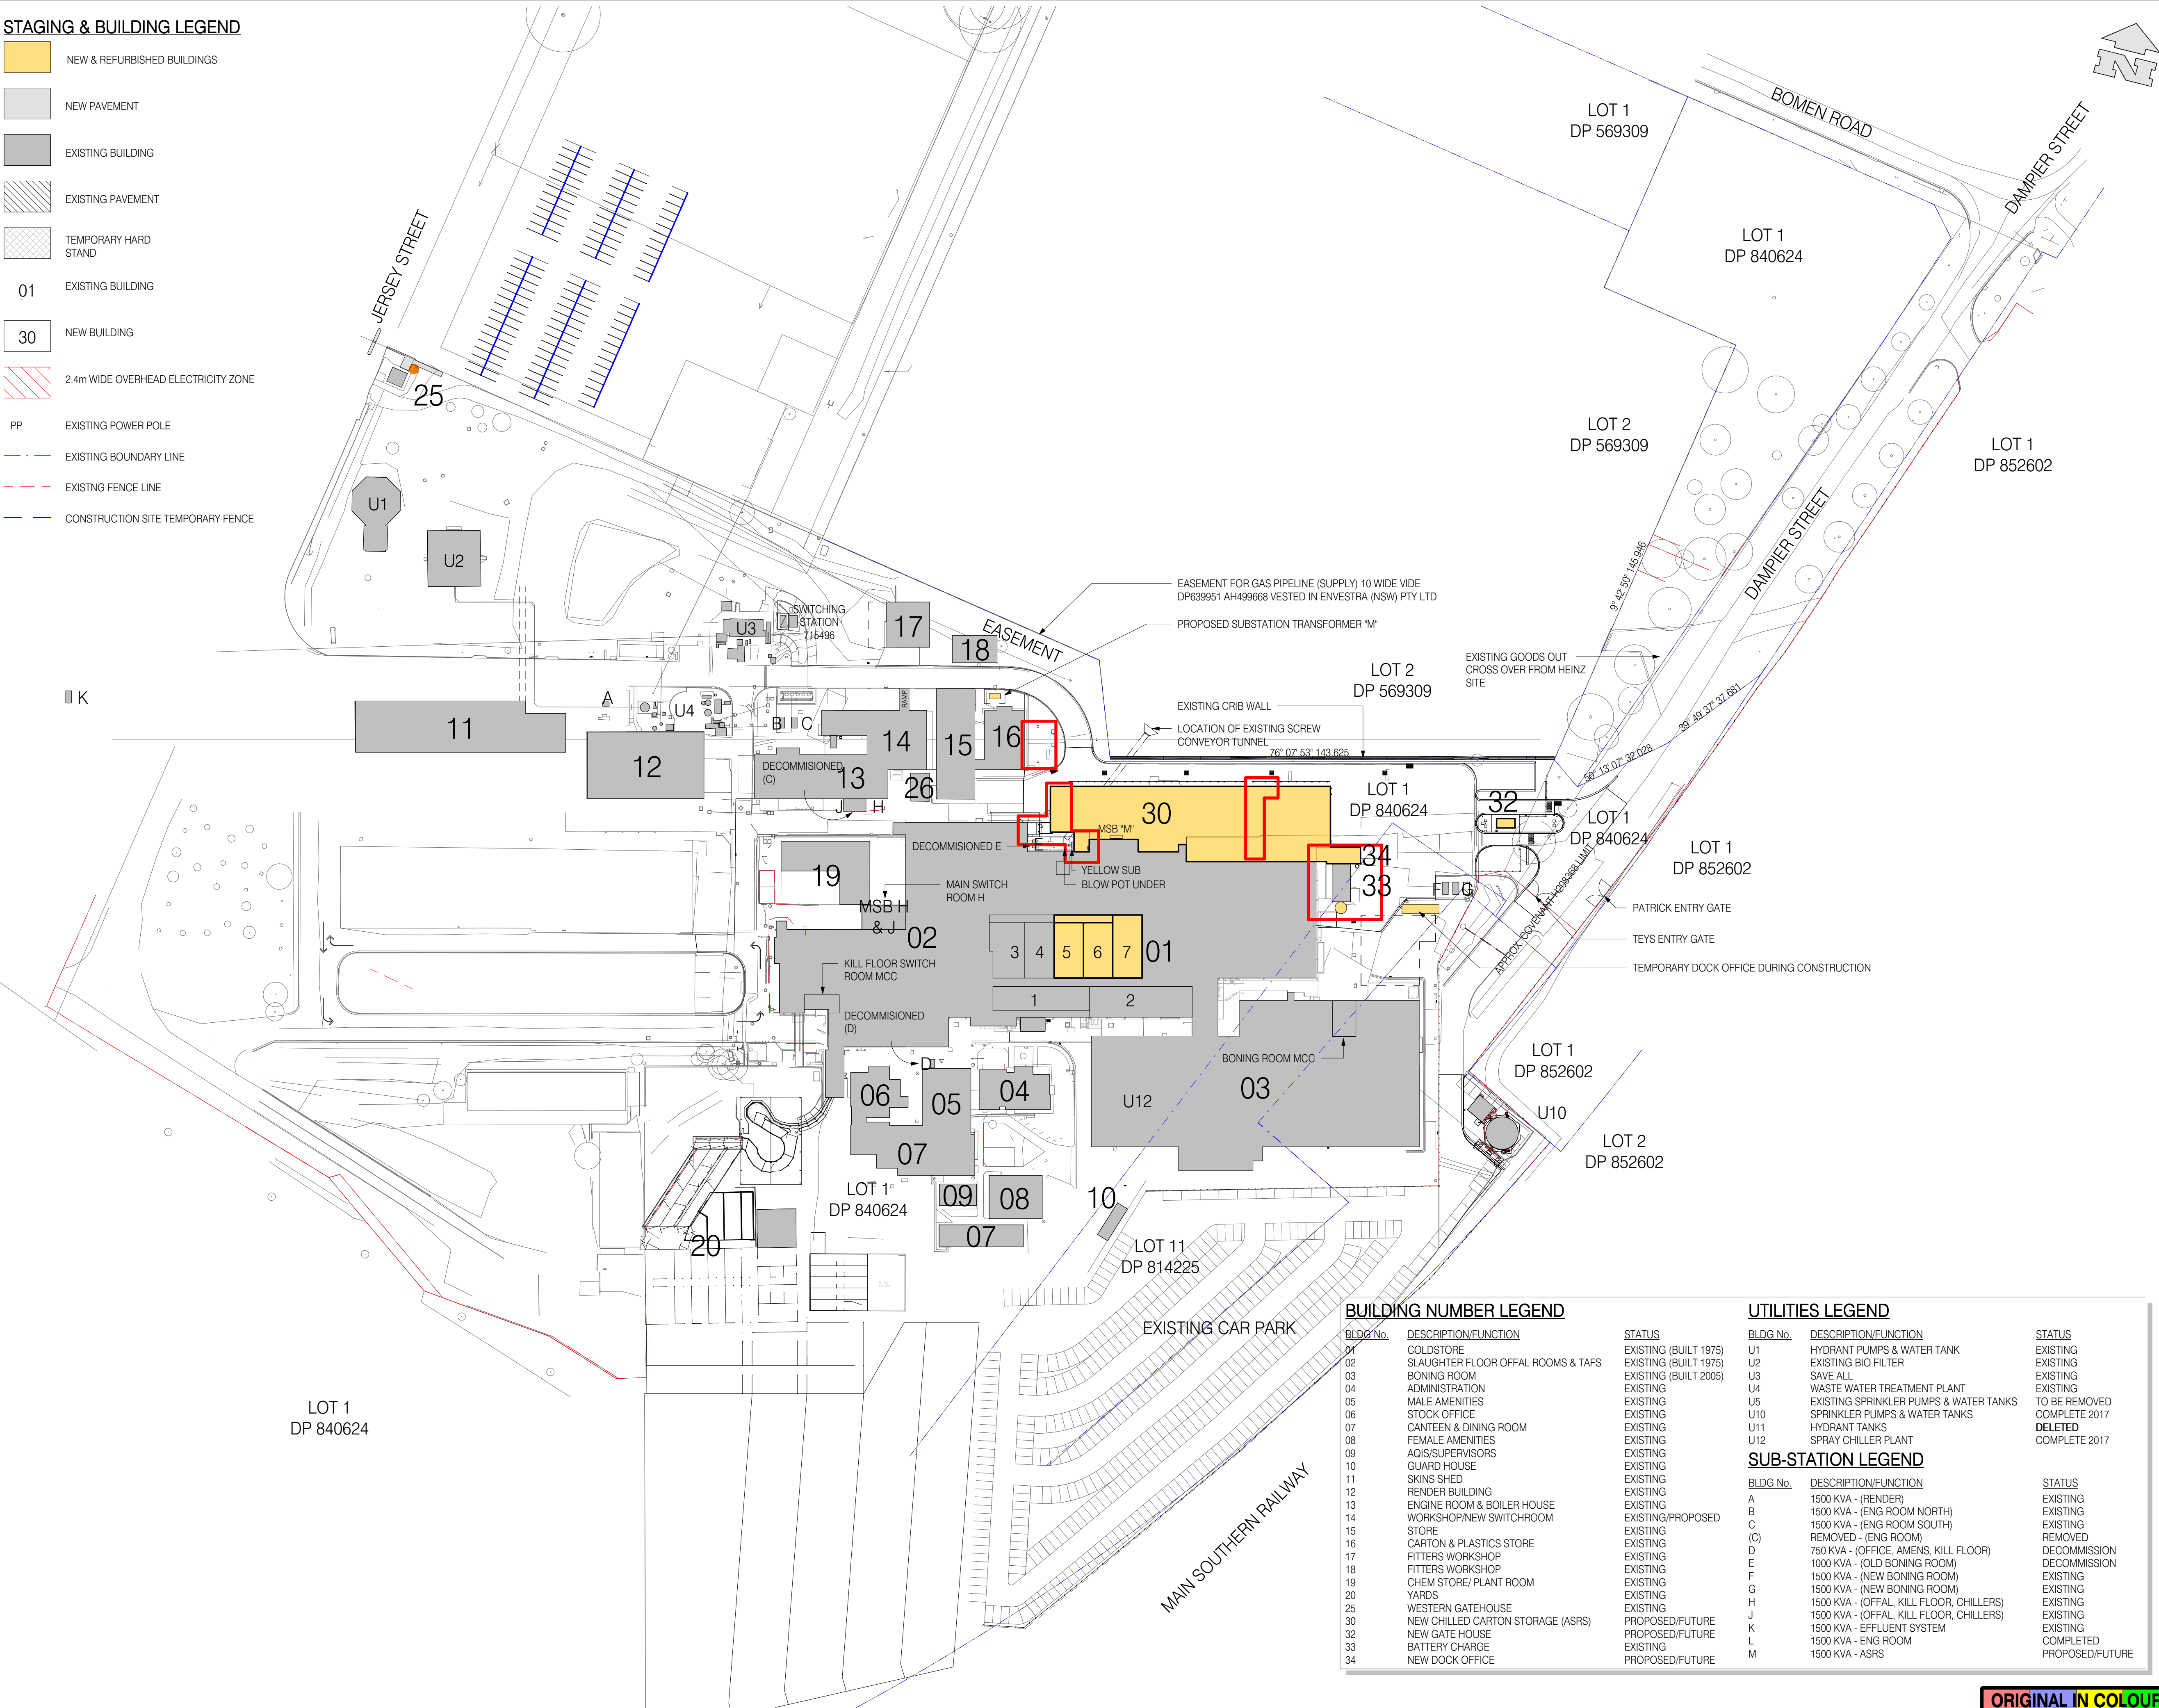

BUILDING NUMBER LEGEND

BLDG No.	DESCRIPTION/FUNCTION	STATUS
01	COLDSTORE	EXISTING (BUILT 1975)
02	SLAUGHTER FLOOR OFFAL ROOMS & TAPS	EXISTING (BUILT 1975)
03	BONING ROOM	EXISTING (BUILT 2005)
04	ADMINISTRATION	EXISTING
05	MALE AMENITIES	EXISTING
06	STOCK OFFICE	EXISTING
07	CANTEEN & DINING ROOM	EXISTING
08	FEMALE AMENITIES	EXISTING
09	AQIS/SUPERVISORS	EXISTING
10	GUARD HOUSE	EXISTING
11	SKINS SHED	EXISTING
12	RENDER BUILDING	EXISTING
13	ENGINE ROOM & BOILER HOUSE	EXISTING
14	WORKSHOP/NEW SWITCHROOM	EXISTING/PROPOSED
15	STORE	EXISTING
16	CARTON & PLASTICS STORE	EXISTING
17	FITTERS WORKSHOP	EXISTING
18	FITTERS WORKSHOP	EXISTING
19	CHEM STORE/ PLANT ROOM	EXISTING
20	YARDS	EXISTING
25	WESTERN GATEHOUSE	EXISTING
30	NEW CHILLED CARTON STORAGE (ASRS)	PROPOSED/FUTURE
32	NEW GATE HOUSE	PROPOSED/FUTURE
33	BATTERY CHARGE	EXISTING
34	NEW DOCK OFFICE	PROPOSED/FUTURE


UTILITIES LEGEND

BLDG No.	DESCRIPTION/FUNCTION	STATUS
U1	HYDRANT PUMPS & WATER TANK	EXISTING
U2	EXISTING BIO FILTER	EXISTING
U3	SAVE ALL	EXISTING
U4	WASTE WATER TREATMENT PLANT	EXISTING
U5	EXISTING SPRINKLER PUMPS & WATER TANKS	TO BE REMOVED COMPLETE 2017
U10	SPRINKLER PUMPS & WATER TANKS	DELETED
U11	HYDRANT TANKS	COMPLETE 2017
U12	SPRAY CHILLER PLANT	

SUB-STATION LEGEND

BLDG No.	DESCRIPTION/FUNCTION	STATUS
A	1500 KVA - (RENDER)	EXISTING
B	1500 KVA - (ENG ROOM NORTH)	EXISTING
C	1500 KVA - (ENG ROOM SOUTH)	EXISTING
(C)	REMOVED - (ENG ROOM)	REMOVED
D	750 KVA - (OFFICE, AMENS, KILL FLOOR)	DECOMMISSION
E	1000 KVA - (OLD BONING ROOM)	DECOMMISSION
F	1500 KVA - (NEW BONING ROOM)	EXISTING
G	1500 KVA - (NEW BONING ROOM)	EXISTING
H	1500 KVA - (OFFAL, KILL FLOOR, CHILLERS)	EXISTING
J	1500 KVA - (OFFAL, KILL FLOOR, CHILLERS)	EXISTING
K	1500 KVA - EFFLUENT SYSTEM	EXISTING
L	1500 KVA - ENG ROOM	COMPLETED
M	1500 KVA - ASRS	PROPOSED/FUTURE

© WILEY & CO PTY LTD  
ABN 40 010 604 869  
This document is the property of Wiley & Co Pty Ltd and is copyright. The subject matter of it is confidential. Do not use, reproduce, copy or disclose except with and only to the extent of the prior written consent of Wiley & Co Pty Ltd. Persons receiving this document are responsible for restricting disclosure as stated above.

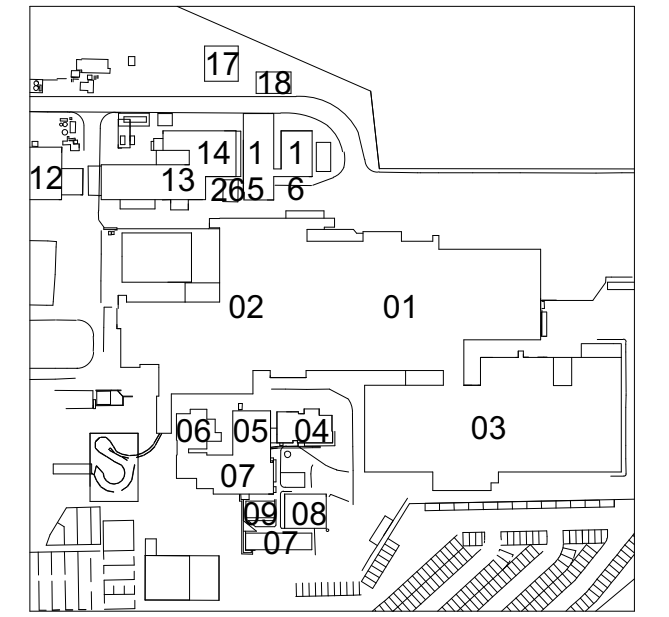

General Notes:  
AREA OF DA MODIFICATION

30/07/18	2	FOR REVISION (BLD LENGTHEN)	DT
30/07/18	1	INITIAL ISSUE	DT
Date	Issue	Amendment	Init

BRISBANE KUALA LUMPUR MELBOURNE SYDNEY TOOWOOMBA  
www.wiley.com.au  
connect@wiley.com.au  
1300 385 988

WILEY



TEYS AUSTRALIA - STAGE 2  
COLD MEAT PROJECT  
WAGGA WAGGA, NSW  
Drawing Title  
OVERALL  
PROPOSED SITE PLAN

Scale A1 = 1:1000 (A3 = 1:2000) 0 10 20

Drawn DT Date JUN 2018

Project No. W21206 Bldg No. 00

Drawing No. Issue

00A002 - 2  
PRELIMINARY

Plot Date : 3/09/2018 3:08:31 PM