

NEW PRIMARY SCHOOL IN MULGOA RISE

1-23 Forestwood Drive, Glenmore Park, NSW 2745



NBRS DRAWING LIST SSDA

DRAWING NUMBER	SHEET NAME
20415-NBRS-DR-A-SSDA-0001	COVER
20415-NBRS-DR-A-SSDA-0003	SHADOW DIAGRAMS
20415-NBRS-DR-A-SSDA-0101	SITE SURVEY
20415-NBRS-DR-A-SSDA-0102	SITE ANALYSIS
20415-NBRS-DR-A-SSDA-0110	SITE PLAN
20415-NBRS-DR-A-SSDA-0113	SITE ACCESS AND SECURITY PLAN
20415-NBRS-DR-A-SSDA-0115	SITE SECTIONS
20415-NBRS-DR-A-SSDA-0120	PUBLIC DOMAIN SCOPE OF WORKS
20415-NBRS-DR-A-SSDA-0999	CAR PARK PLAN
20415-NBRS-DR-A-SSDA-1000	OVERALL GROUND FLOOR PLAN
20415-NBRS-DR-A-SSDA-1001	OVERALL L1 PLAN
20415-NBRS-DR-A-SSDA-1002	OVERALL ROOF PLAN
20415-NBRS-DR-A-SSDA-1011	BLOCK A - GF PLAN
20415-NBRS-DR-A-SSDA-1012	BLOCK B3 - GF PLAN
20415-NBRS-DR-A-SSDA-1013	BLOCK B2 - GF PLAN
20415-NBRS-DR-A-SSDA-1014	BLOCK C - GF PLAN
20415-NBRS-DR-A-SSDA-1021	BLOCK A - LEVEL 1 PLAN
20415-NBRS-DR-A-SSDA-1022	BLOCK B3 - LEVEL 1 PLAN
20415-NBRS-DR-A-SSDA-1023	BLOCK B2 - LEVEL 1 PLAN
20415-NBRS-DR-A-SSDA-3010	SITE ELEVATIONS
20415-NBRS-DR-A-SSDA-3011	BUILDING A - ELEVATIONS
20415-NBRS-DR-A-SSDA-3012	BUILDING B3 - ELEVATIONS
20415-NBRS-DR-A-SSDA-3013	BUILDING B2 - ELEVATIONS
20415-NBRS-DR-A-SSDA-3014	BUILDING C - ELEVATIONS
20415-NBRS-DR-A-SSDA-4001	BUILDING A - SECTIONS
20415-NBRS-DR-A-SSDA-4002	BUILDING - SECTIONS
20415-NBRS-DR-A-SSDA-4003	BUILDING - DETAIL SECTIONS
20415-NBRS-DR-A-SSDA-7001	3D IMAGE 1
20415-NBRS-DR-A-SSDA-7002	3D IMAGE 2
20415-NBRS-DR-A-SSDA-7003	3D IMAGE 3
20415-NBRS-DR-A-SSDA-7004	3D IMAGE 4
20415-NBRS-DR-A-SSDA-8001	SIGNAGE
20415-NBRS-DR-A-SSDA-8001	EXTERNAL FINISHES

No.	Date	Description
01	23/04/2021	ISSUE FOR COORDINATION
02	04/05/2021	SSDA ISSUE
03	06/09/2021	SSDA ISSUE
04	11/11/2021	SSDA RIS

CHS	JL
-----	----

RICHARD CROOKES
CONSTRUCTIONS

SSDA RIS

TRAFFIC ENGINEER
PTC
KASIA BALSAM
02 9920 0800
kasia.balsam@ptcconsultants.co
RIS
ROB DWYER
0425 285 778
rob.dwyer@rpsgroup.com.au

MULTI SERVICES
NDY
RYAN HAHN
0407 236 908
r.hahn@rny.com
WOLACOTTS
02 8203 1504
0424 189 883
justin.chillilo@woolacotts.com.au

QUANTITY SURVEYOR
MBM
AUTUMN LU
02 9270 1062
autumn.lu@mbmpl.com.au
COLLIERS
ANTHONY MULLIGHAN-WRIGHT
0424 189 883
anthony.mullighan-wright@colliers.com

Drawing Title
COVER

Project
NEW PRIMARY SCHOOL IN MULGOA RISE
at
1-23 Forestwood Drive, Glenmore Park, NSW 2745, Australia
for
SINSW

Architect
NBRSARCHITECTURE.
Sydney
61 2 9922 2344
Any form of replication of this drawing in full or in part without the written permission of NBRS+PARTNERS Pty Ltd constitutes an infringement of the copyright.
NBRS & Partners Pty Ltd VIC 51197
Andrew Duffin NSW 5602
ABN 16 002 247 565
© 2021

Drawing Reference
20415-NBRS-DW-AR-SSDA-0001 04

Date 11/11/2021 7:06:07 PM
Scale NOT TO SCALE

Revision

Issue	No.	Date	Description
01	12/04/2021	ISSUE FOR COORDINATION	
02	23/04/2021	ISSUE FOR COORDINATION	
03	04/05/2021	SSDA ISSUE	
04	06/09/2021	SSDA ISSUE	
05	11/11/2021	SSDA RIS	
			CHS

RICHARD CROOKES
CONSTRUCTIONS

TRAFFIC ENGINEER
PTC
KASIA BALSAM
0425 285 778
rob.dwyer@rpsgroup.com.au

MULTI SERVICES
NDY
RAYAN HAHN
0407 236 908
r.hahn@rny.com

QUANTITY SURVEYOR
MBM
AUTUMN LU
02 9270 1062
autumn.lu@mbmpl.com.au


SHADOW DIAGRAMS
Drawing Title

Project
NEW PRIMARY SCHOOL IN MULGOA
Rise
at
1-23 Forestwood Drive, Glenmore Park, NSW 2745, Australia
for
SINSW


Architect
NBRS+PARTNERS
61 2 9922 2344
Any form of replication of this drawing in full or in part without the written permission of NBRS+PARTNERS Pty Ltd constitutes an infringement of the copyright.
NBRS & Partners Pty Ltd VIC 51197
ABN 16 002 247 565
© 2021

20415-NBRS-DW-AR-SSDA-0003 05
Revision
Date 11/11/2021 7:08:37 PM
Scale NOT TO SCALE
Drawing Reference


4 SHADOW DIAGRAM DEC 21 9AM

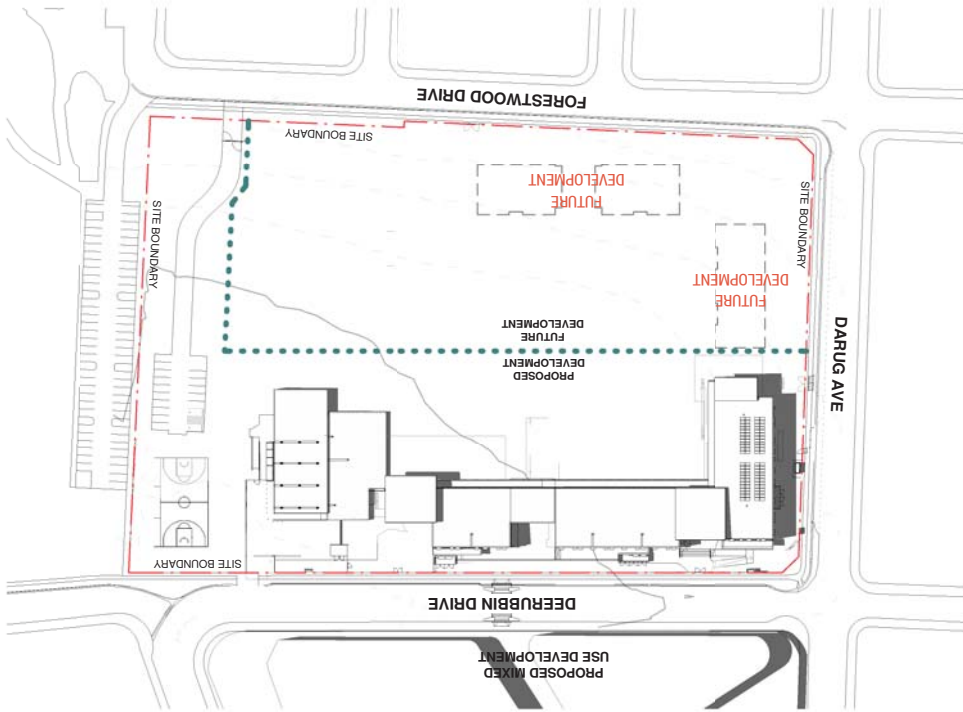


5 SHADOW DIAGRAM DEC 21 12PM

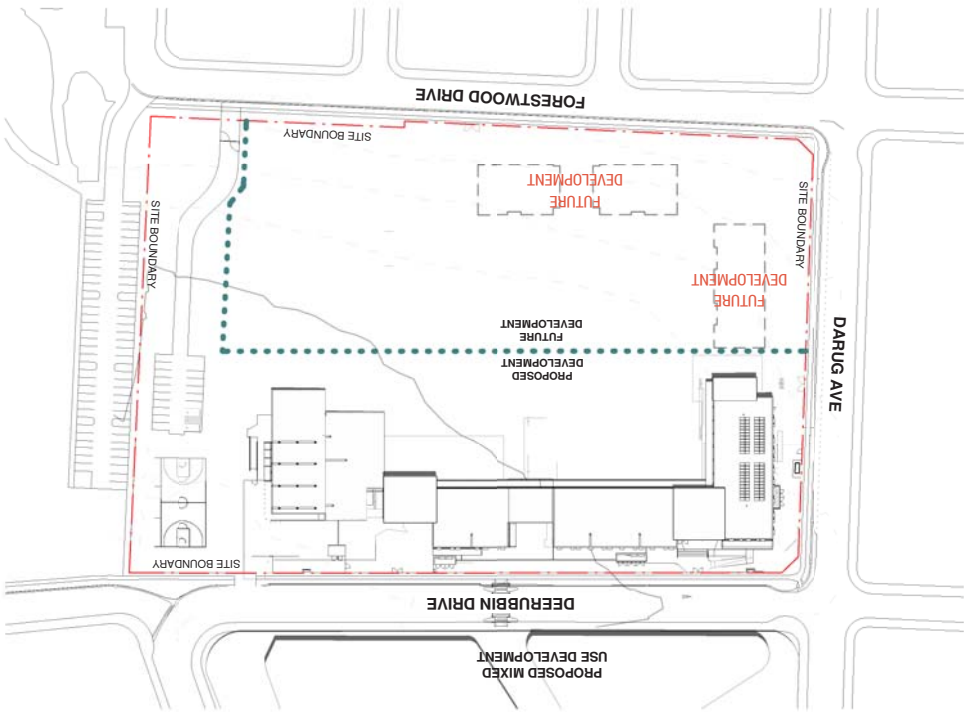


6 SHADOW DIAGRAM DEC 21 3PM

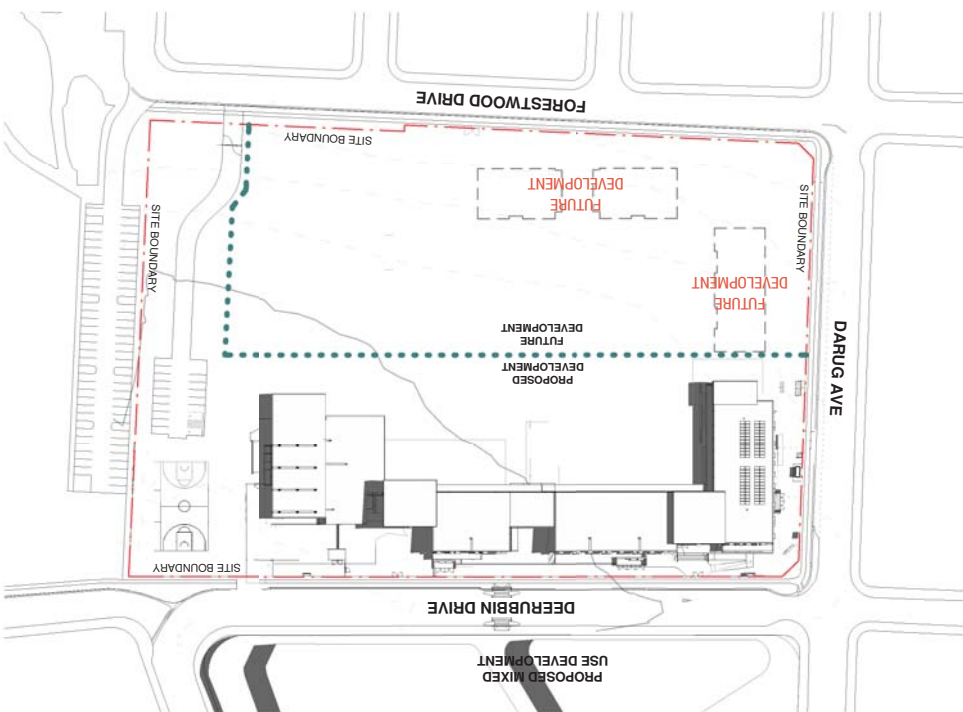


1 SHADOW DIAGRAM JUNE 21 9AM

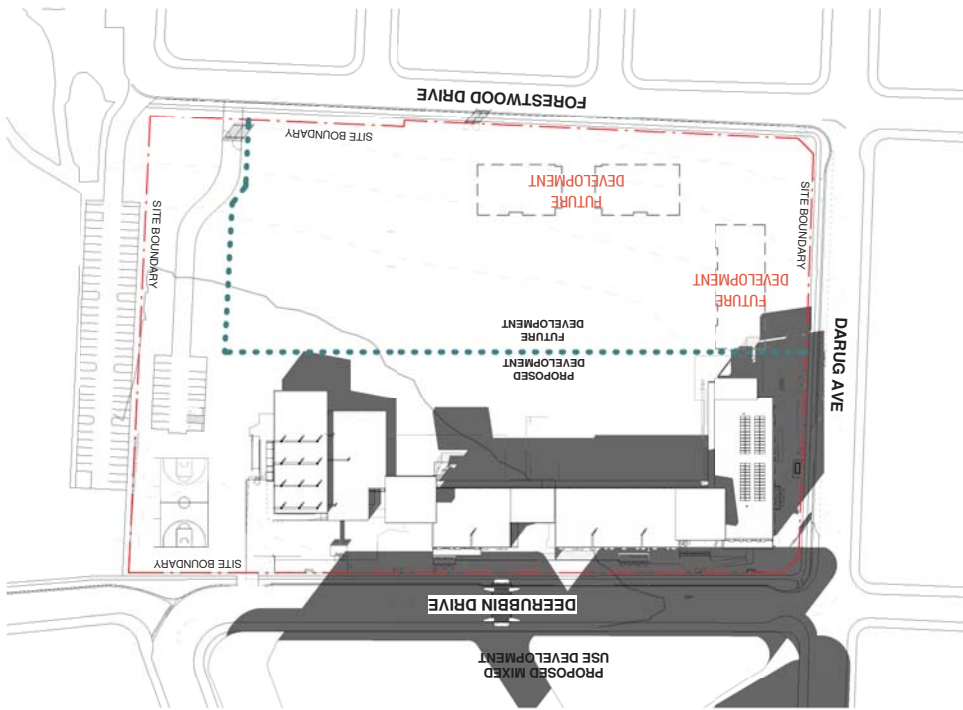

2 SHADOW DIAGRAM JUNE 21 12PM

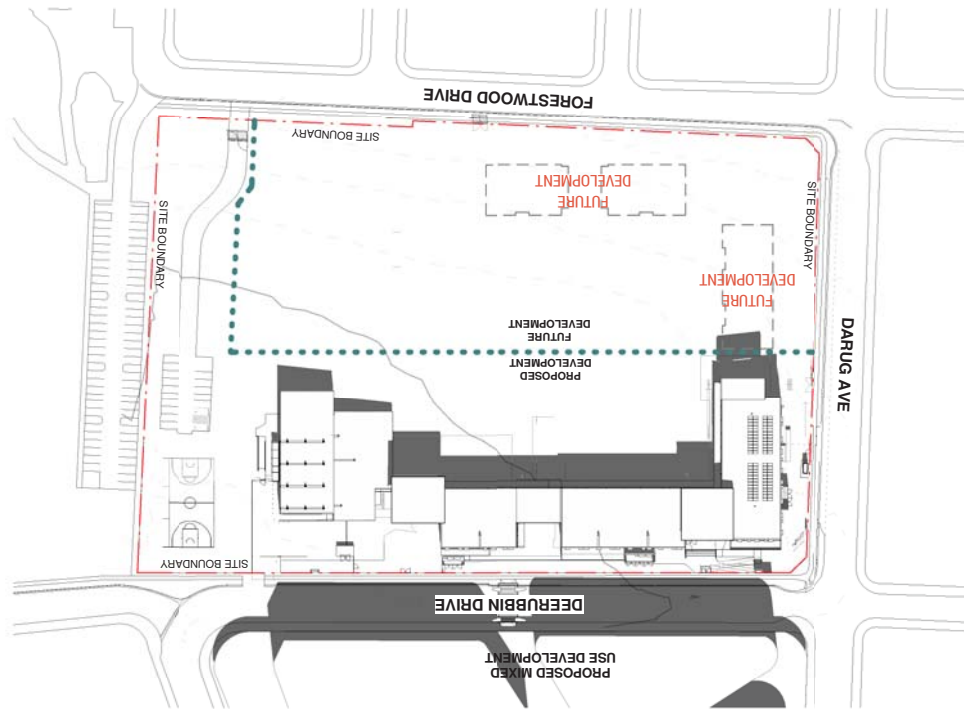

3 SHADOW DIAGRAM JUNE 21 3PM

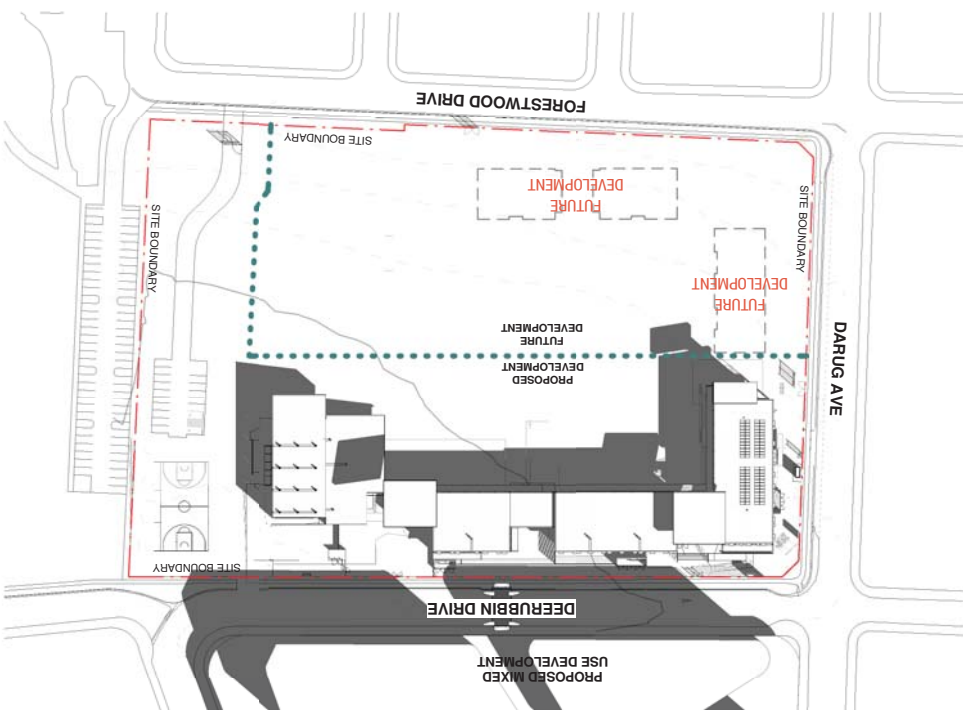

No.	Date	Description
01	12/11/2021	SSDA RIS
02	11/09/2021	SSDA ISSUE
03	06/08/2021	SSDA ISSUE
04	28/07/2021	COORDINATION ISSUE
05	19/07/2021	ISSUE FOR COORDINATION
06	14/07/2021	FOR INFORMATION
07	04/05/2021	SSDA ISSUE
08	23/04/2021	ISSUE FOR COORDINATION
09		
10		
11		

RICHARD CROOKES
CONSTRUCTIONS

TRAFFIC ENGINEER
PTC
KASIA BALSAM
02 8920 0800
kasia.balsam@pccconsultants.co

TOWN PLANNER
RPS
ROB DWYER
0425 285 778
rob.dwyer@rpsgroup.com.au

MULTI SERVICES
NDY
RYAN HAHN
0407 236 908
r.hahn@ndy.com

CIVIL AND STRUCTURAL ENGINEERING
WOOLACOTTS
JUSTIN CHILLID
02 8203 1504
jchillid@woolacotts.com.au


QUANTITY SURVEYOR
MBM
ALUMIN LU
02 9270 1062
alumin.lu@mbm.com.au

COLLIERS
ANTHONY MULLIGAN-WRIGHT
0424 189 883
anthony.mulligan-wright@colliers.com

Project
NEW PRIMARY SCHOOL IN MULGOA RISE
at
1-23 Forestwood Drive, Glenmore Park, NSW 2745, Australia
for
NSW

Architect
NBRS ARCHITECTURE
Sydney
61 2 9922 2344
Any form of replication of this drawing in full or in part without the written permission of NBRS+PARTNERS Pty Ltd constitutes an infringement of the copyright.
Northern Architect:
Andrew Duffin NSW 5602
NBRS & Partners Pty Ltd VIC 51197
ABN 16 002 247 565
© 2021

Drawing Reference
20415-NBRS-DW-AR-SSDA-0110011
Revision
Date 12/11/2021 3:04:11 PM
Scale 1:500 @ A1

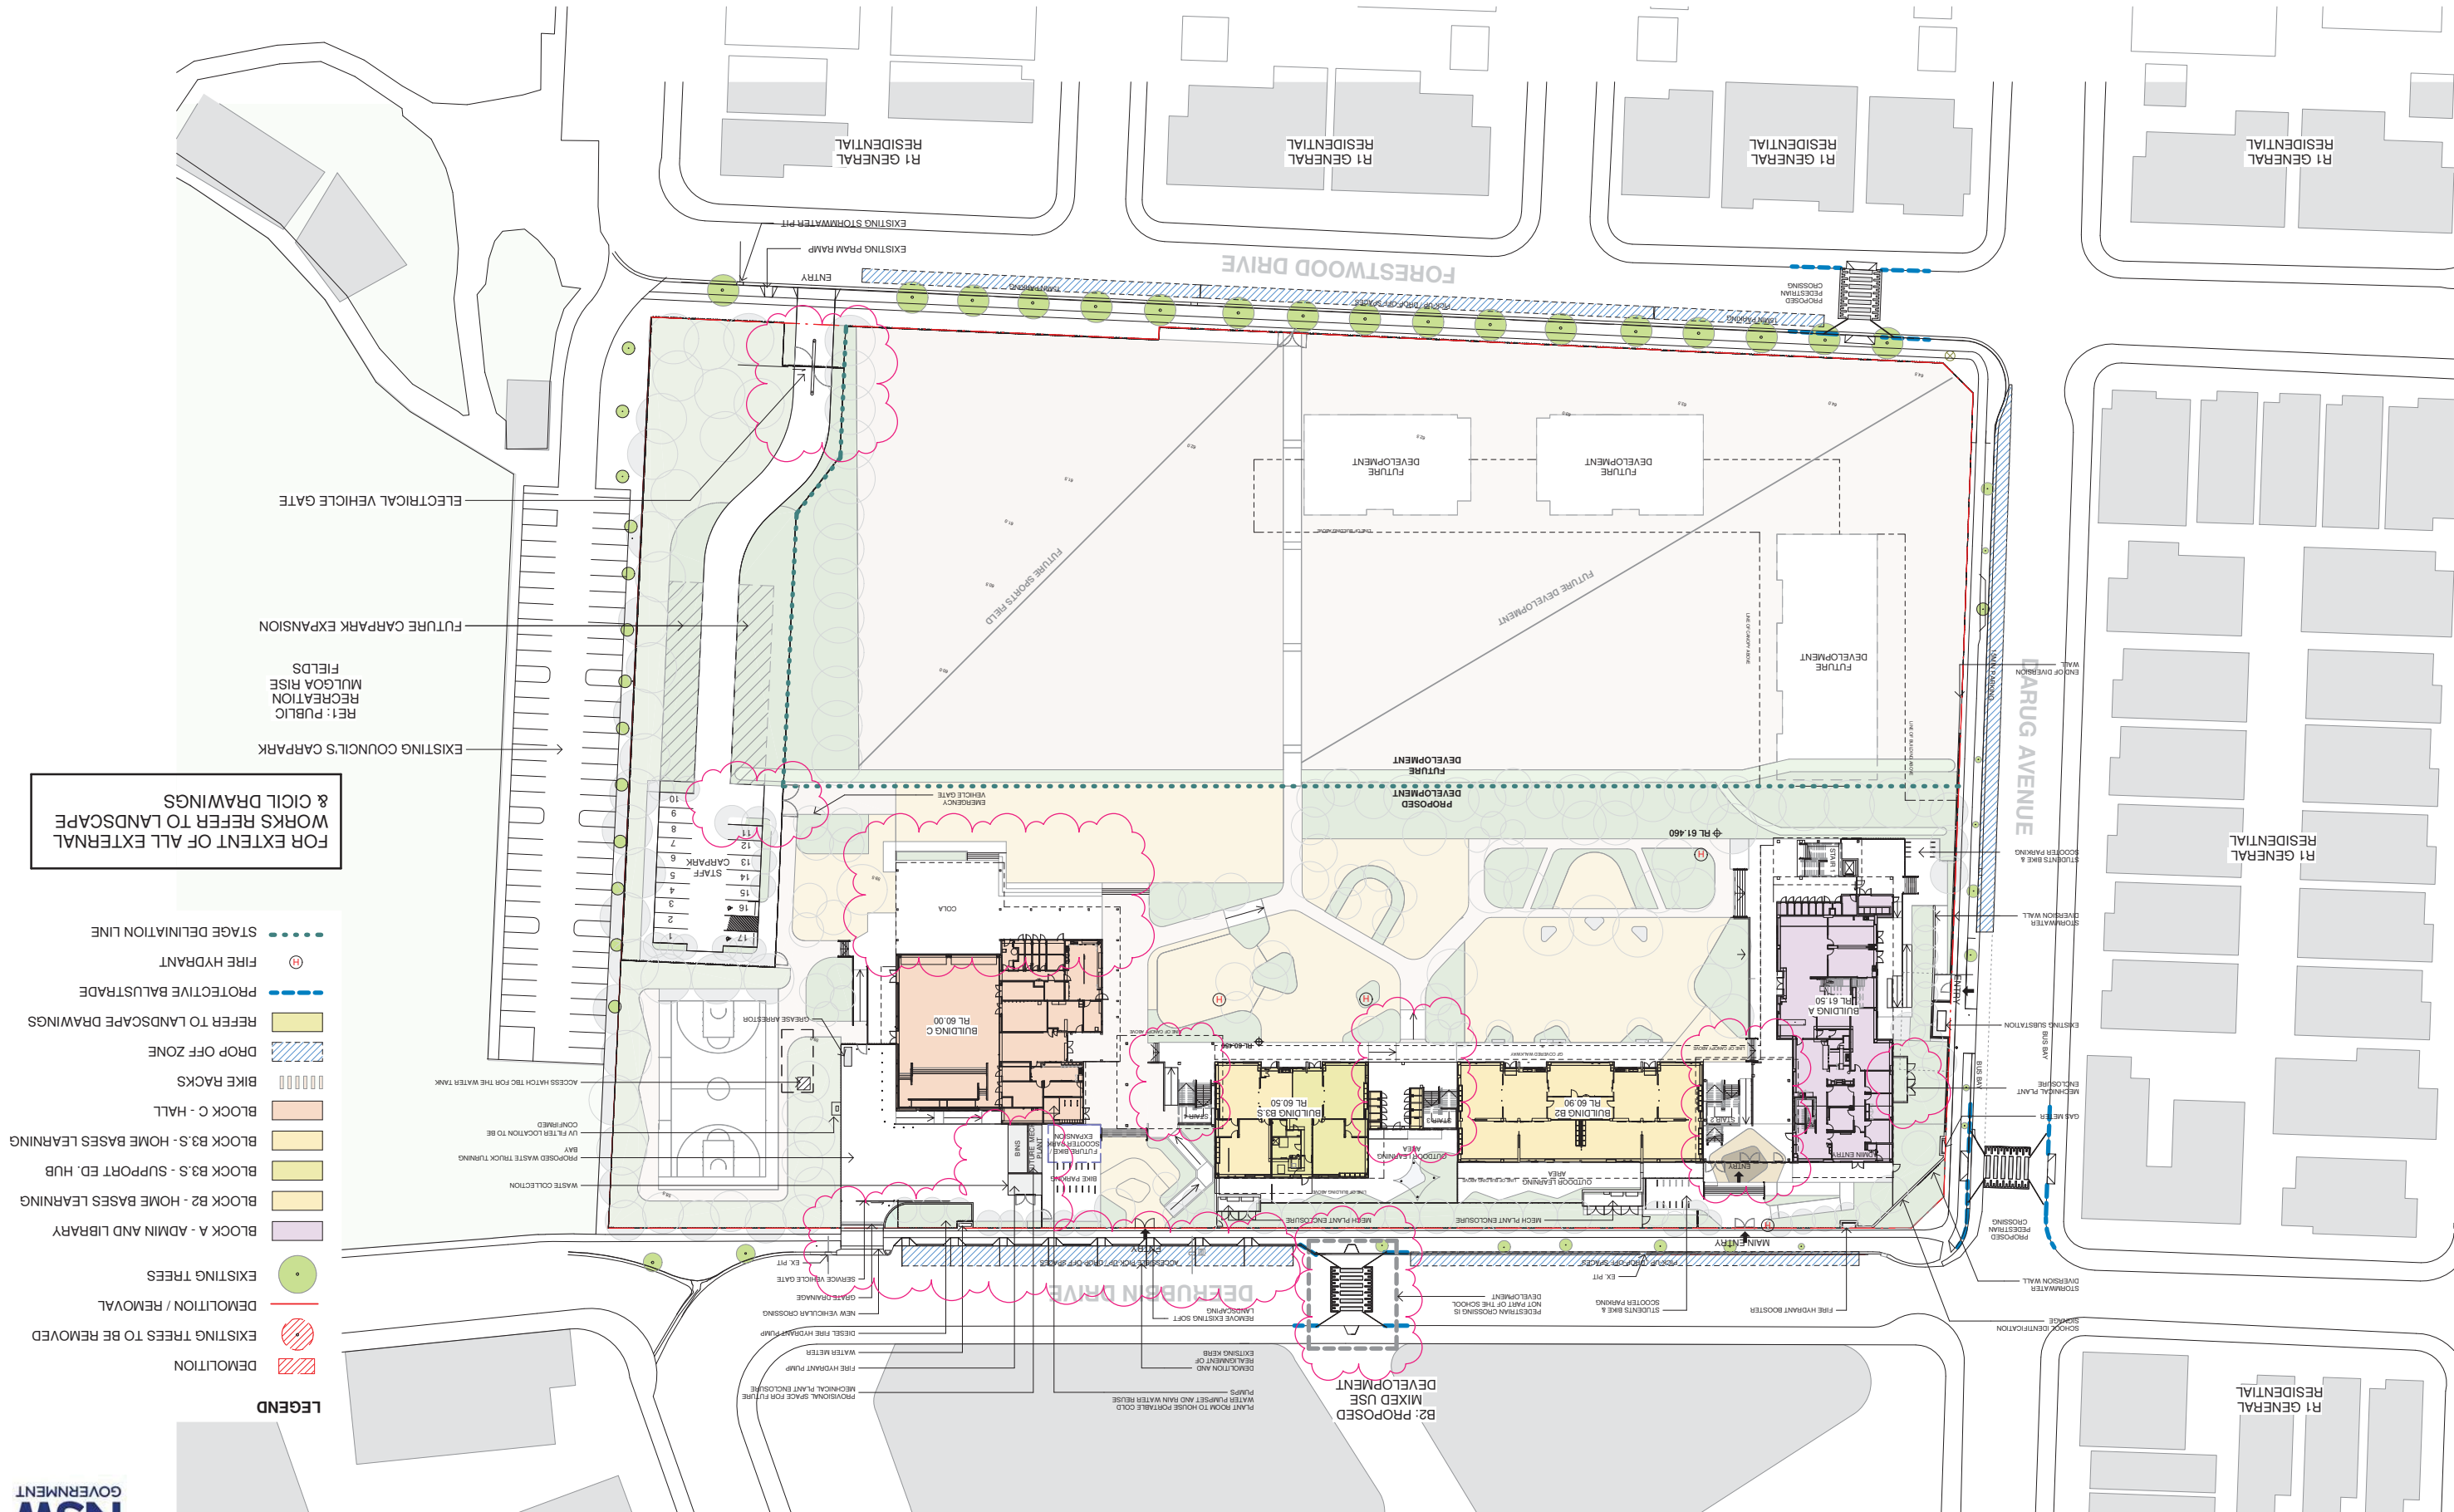

Issue	No.	Date	Description
01	12/04/2021		ISSUE FOR COORDINATION
02	16/04/2021		ISSUE
03	23/04/2021		ISSUE FOR COORDINATION
04	04/05/2021		SSDA ISSUE
05	06/05/2021		SSDA ISSUE
06	11/06/2021		SSDA ISSUE
07	12/11/2021		SSDA R1S
08	12/11/2021		SSDA R1S



TRAFFIC ENGINEER
RPS
KASIM BALSAM
02 8920 0800
kasim.balsam@rpsgroup.com.au

TOWN PLANNER
RPS
ROB DWYER
0425 285 778
rob.dwyer@rpsgroup.com.au

MULTI SERVICES
NDY
RYAN HAHN
0407 236 908
r.hahn@ndy.com

CIVIL AND STRUCTURAL ENGINEERING
WOOLACOTTS
JUSTIN CHILLID
02 8203 1504
johnlillio@woolacotts.com.au

QUANTITY SURVEYOR
MBM
ALUMIN LU
02 9270 1062
alumin.lu@mbm.com.au


COLLIERS
ANTHONY MULLIGHAN-WRIGHT
0424 189 8878
anthony.mullighan-wright@colliers.com

Project
NEW PRIMARY SCHOOL IN MULGOA
RISE
at
1-23 Forestwood Drive, Glenmore Park, NSW 2745, Australia
for
SINSW

Architect
NBRS ARCHITECTURE
61 2 9922 2344
Any form of replication of this drawing in full or in part without the written permission of NBRS+PARTNERS Pty Ltd constitutes an infringement of the copyright.
Northern Architekt
Andrew Duffin NSW 5602
NBRS & Partners Pty Ltd VIC 51197
ABN 16 002 247 565
© 2021

Drawing Reference
20415-NBRS-DW-AR-SSDA-0113 08
Revision

Scale
1:500 @ A1
Date 12/11/2021 3:58:29 PM

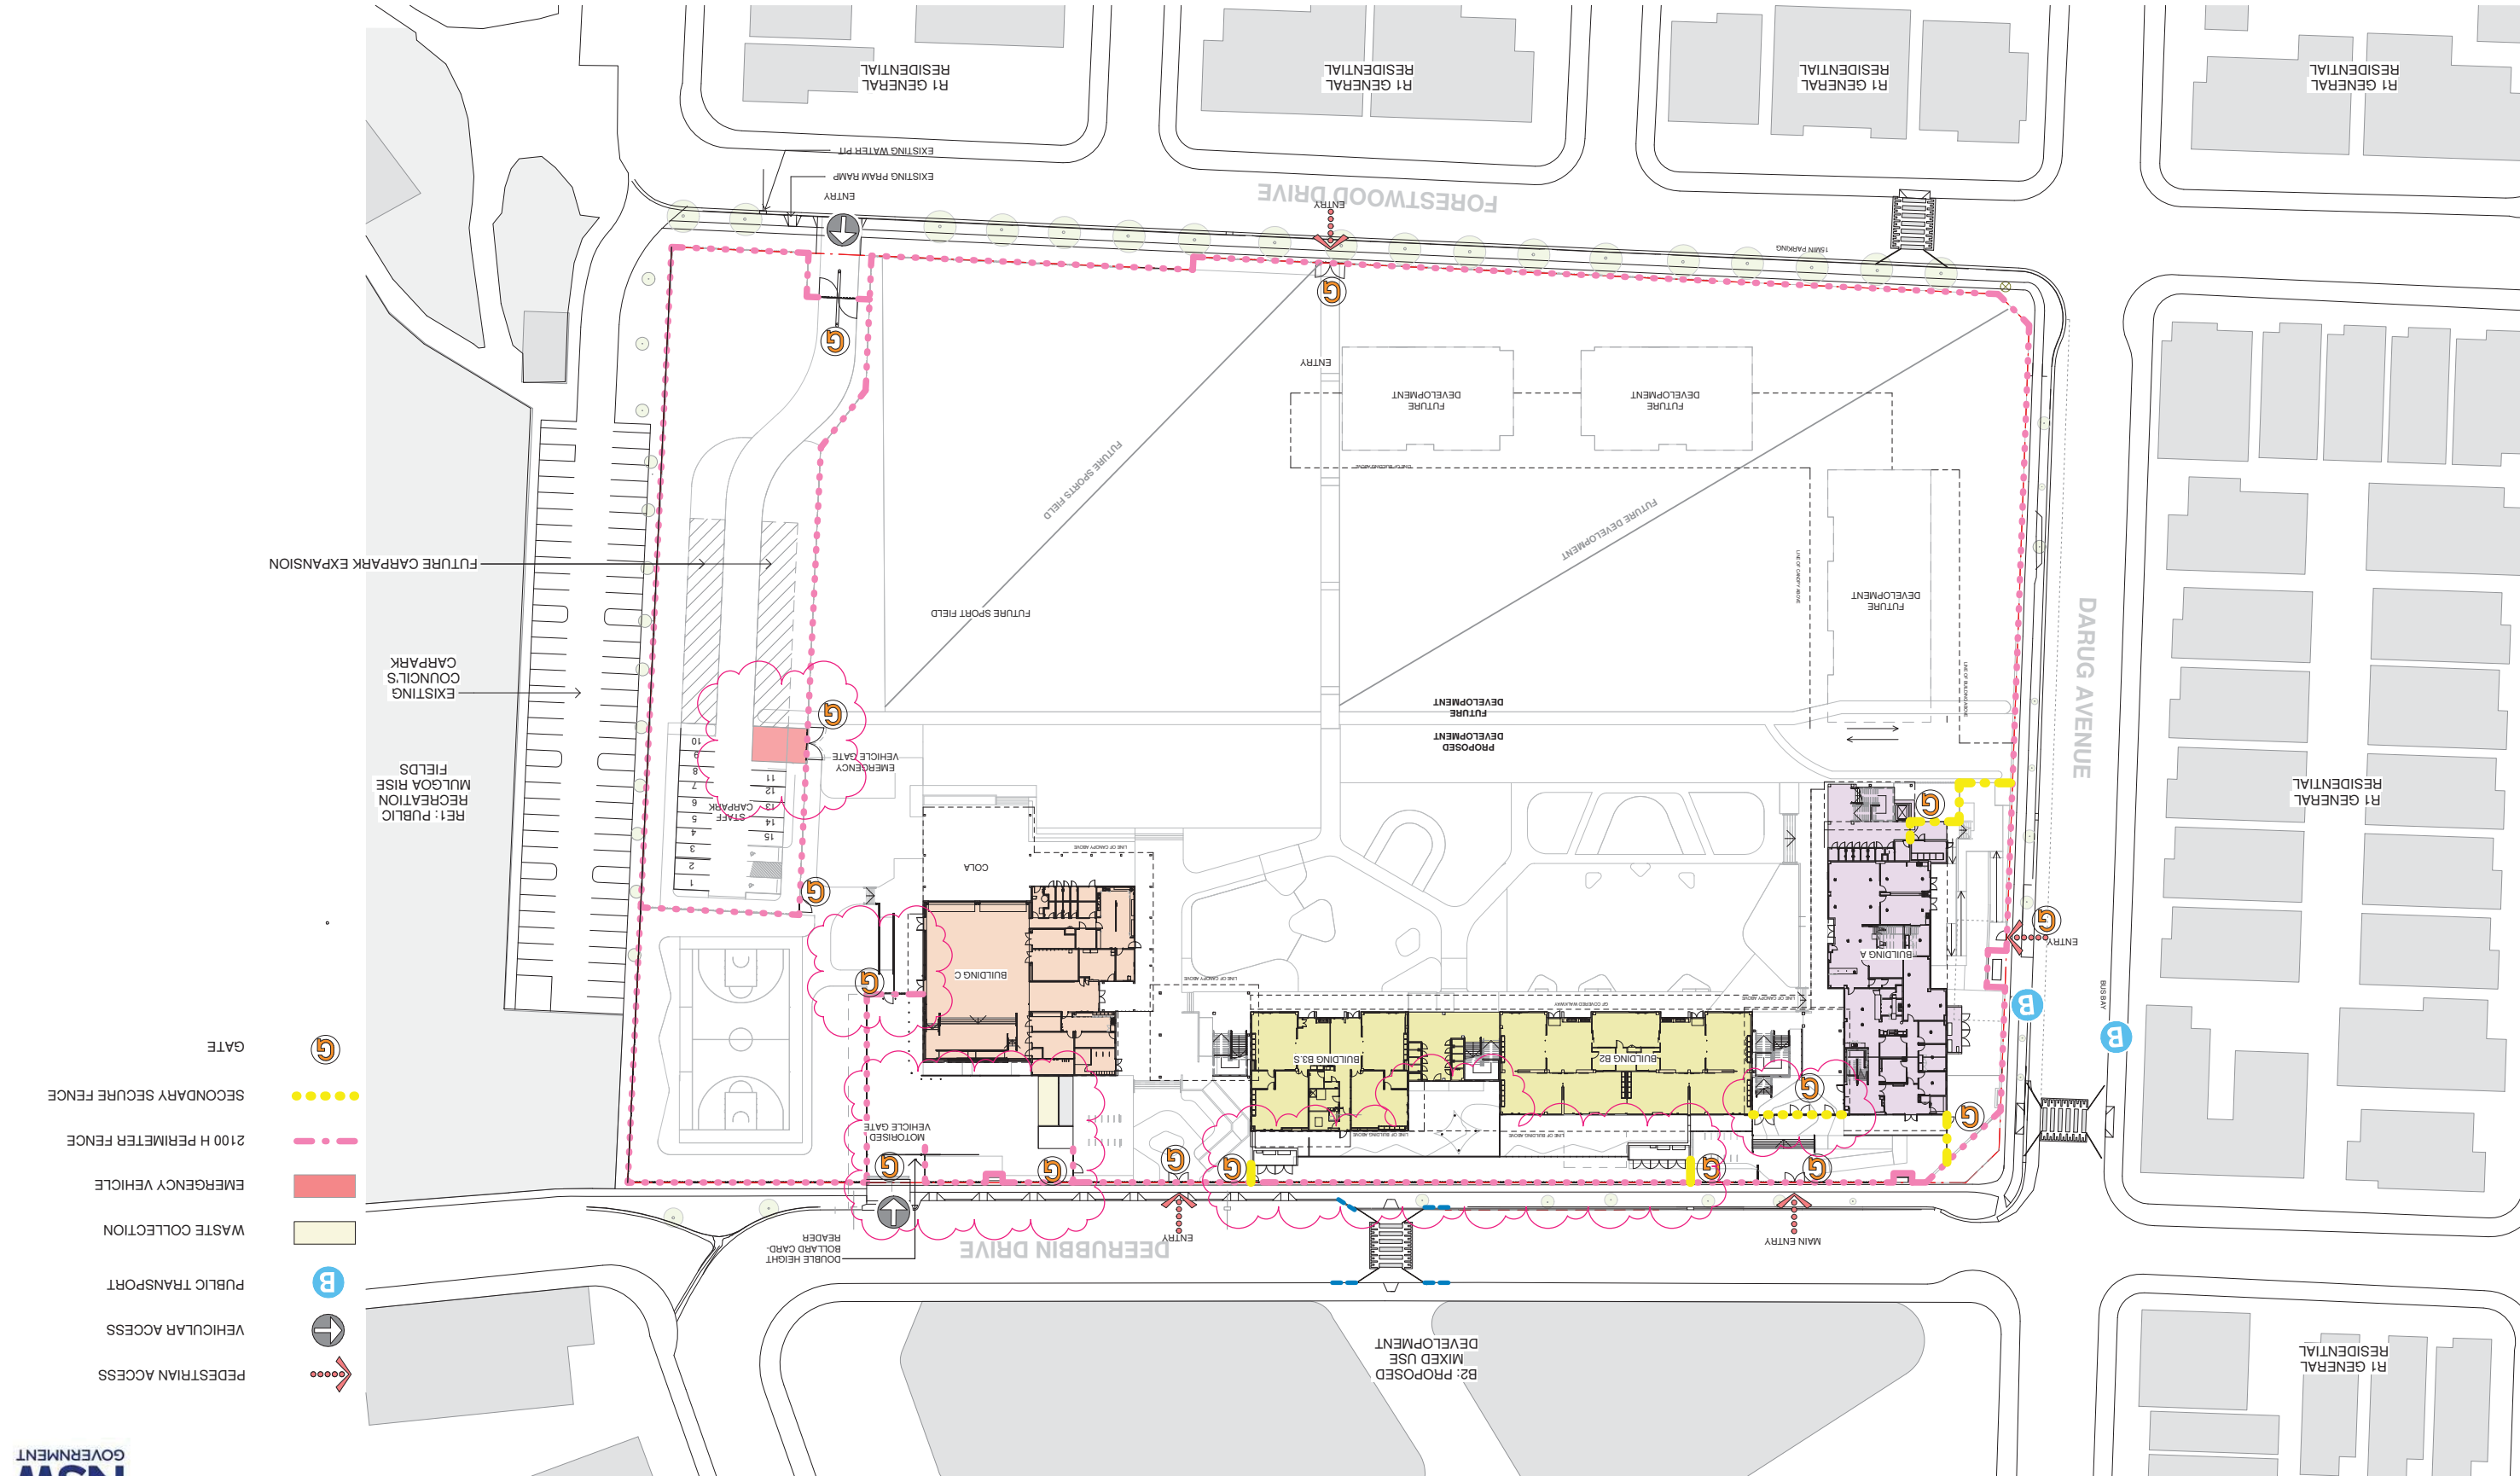

No.	Date	Description
01	12/04/2021	ISSUE FOR COORDINATION
02	23/04/2021	ISSUE FOR COORDINATION
03	04/05/2021	SSDA ISSUE
04	06/08/2021	SSDA ISSUE
05	11/11/2021	SSDA RIS
JL		CHS

RICHARD CROOKES
CONSTRUCTIONS

TRAFFIC ENGINEER
PTC
KASIA BALSAM
02 8920 0800
kasia.balsam@ptcconsultants.co

TOWN PLANNER
RPS
ROB DWYER
0425 285 778
rob.dwyer@rpsgroup.com.au

MULTI SERVICES
NDY
RYAN HAHN
0407 236 908
r.hahn@ndy.com

CIVIL AND STRUCTURAL ENGINEERING
WOOLACOTTS
JUSTIN CHILLILO
02 8203 1504
jchillilo@woolacotts.com.au

QUANTITY SURVEYOR
MBM
ALUMIN LU
02 9270 1062
alumin.lu@mbmpl.com.au

COLLIERS
PROJECT MANAGER
ANTHONY MULLIGHAN-WRIGHT
0424 189 883
anthony.mullighan-wright@colliers.com

Drawing Title
SITE SECTIONS


Project
NEW PRIMARY SCHOOL IN MULGOA
RISE
at
1-23 Forestwood Drive, Glenmore Park, NSW 2745, Australia
for
SINSW

Architect
NBSARCHITECTURE
Sydney
61 2 9922 2344
Any form of replication of this drawing in full or in part without the written permission of NBS+PARTNERS Pty Ltd constitutes an infringement of the copyright.
Northernland Architect:
Andrew Duffin NSW 5602
NBS+PARTNERS Pty Ltd VIC 51197
ABN 16 002 247 565
© 2021


Drawing Reference
20415-NBRS-DW-AR-SSDA-0115 05
Revision

Date 11/11/2021 5:13:44 PM
Scale 1:250 @ A1

3 SITE SECTION 02
1 : 250

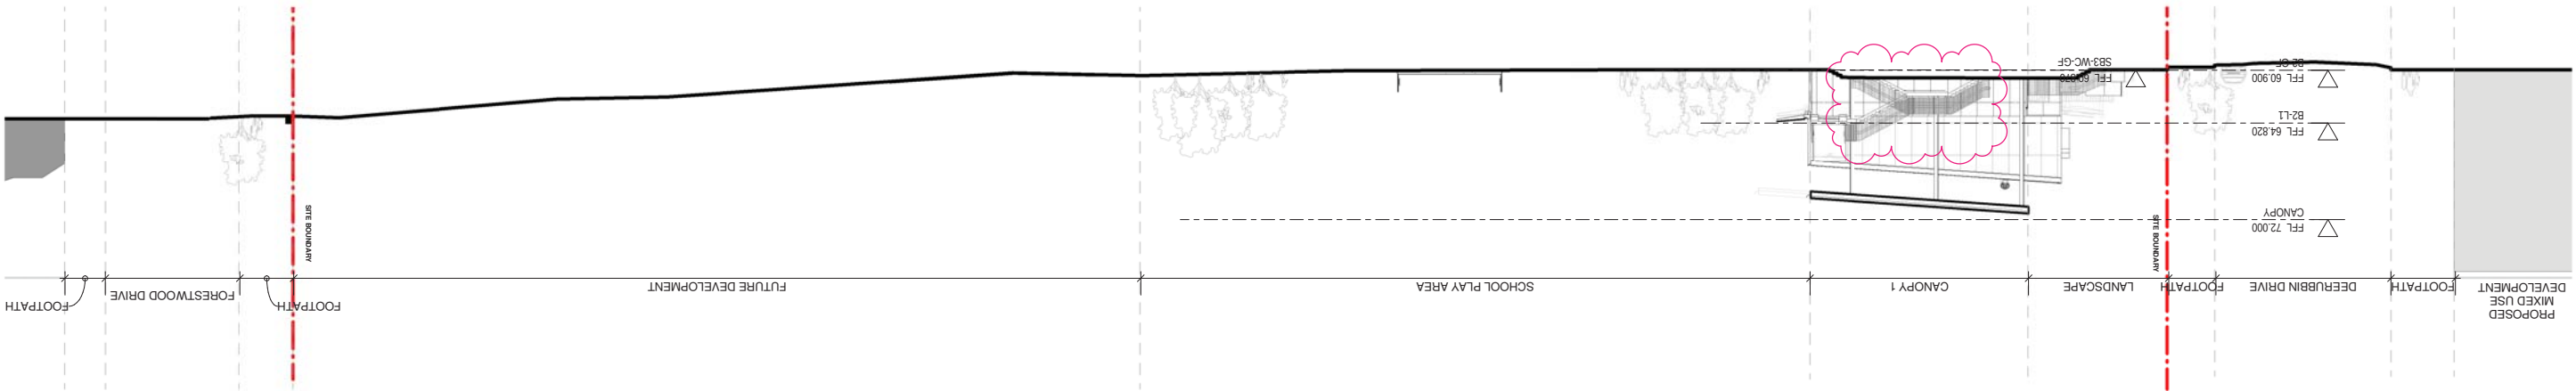

2 SITE SECTION 01 PART 2
1 : 250

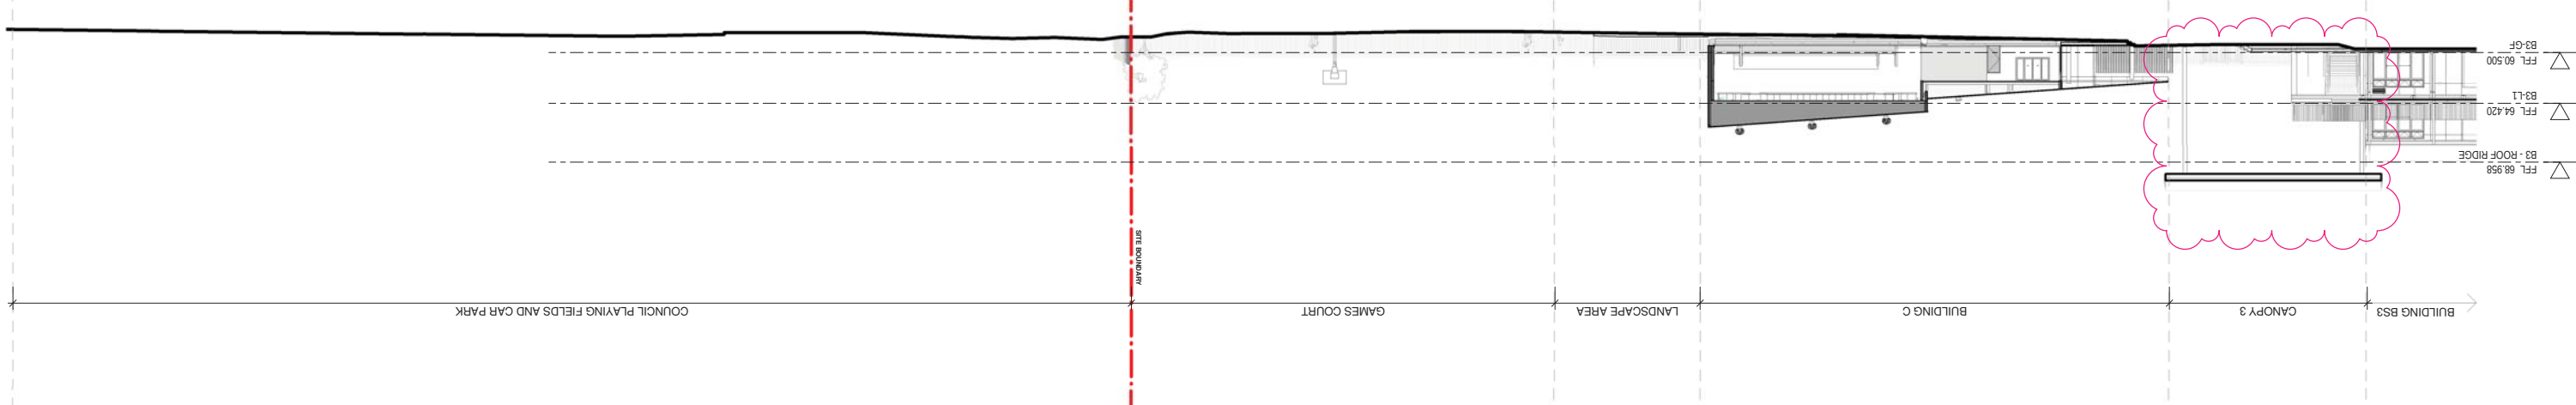

1 SITE SECTION 01 PART 1
1 : 250



Issue	No.	Date	Description
02	12/11/2021	SSDA RIS	
01	11/11/2021	SSDA RIS	
CHS			
CHS			
CHS			

RICHARD CROOKES
CONSTRUCTIONS

TRAFFIC ENGINEER
PTC
KASIA BALSAM
02 9290 0800
kasia.balsam@pccconsultants.co

TOWN PLANNER
RPS
ROB DWYER
0425 285 778
rob.dwyer@rpsgroup.com.au

MULTI SERVICES
NDY
RYAN HAHN
0407 236 908
r.hahn@ndy.com

CIVIL AND STRUCTURAL ENGINEERING
WOLACOTTS
JUSTIN CHILLID
02 8203 1504
jchillid@wolacotts.com.au


QUANTITY SURVEYOR
MBM
ANTHONY LU
02 9270 1062
anthony.lu@mbm.com.au

COLLIERS
ANTHONY MULLIGHAN-WRIGHT
0424 189 883
anthony.mullighan-wright@colliers.com

Drawing Title
PUBLIC DOMAIN SCOPE OF WORKS
NEW PRIMARY SCHOOL IN MULGOA
Rise
at
1-23 Forestwood Drive, Glenmore Park, NSW 2745, Australia
for
SINSW

Architect
NBRSARCHITECTURE
61 2 9922 2344
Any form of replication of this drawing in full or in part without the written permission of NBRS+PARTNERS Pty Ltd constitutes an infringement of the copyright.
NBRS+PARTNERS Pty Ltd VIC 51197
Andrew Duffin NSW 5602
ABN 16 002 247 565
© 2021

Drawing Reference
20415-NBRS-DW-AR-SSDA-0120 02
Revision
Date 12/11/2021 3:56:20 PM
Scale 1 : 500 @ A1

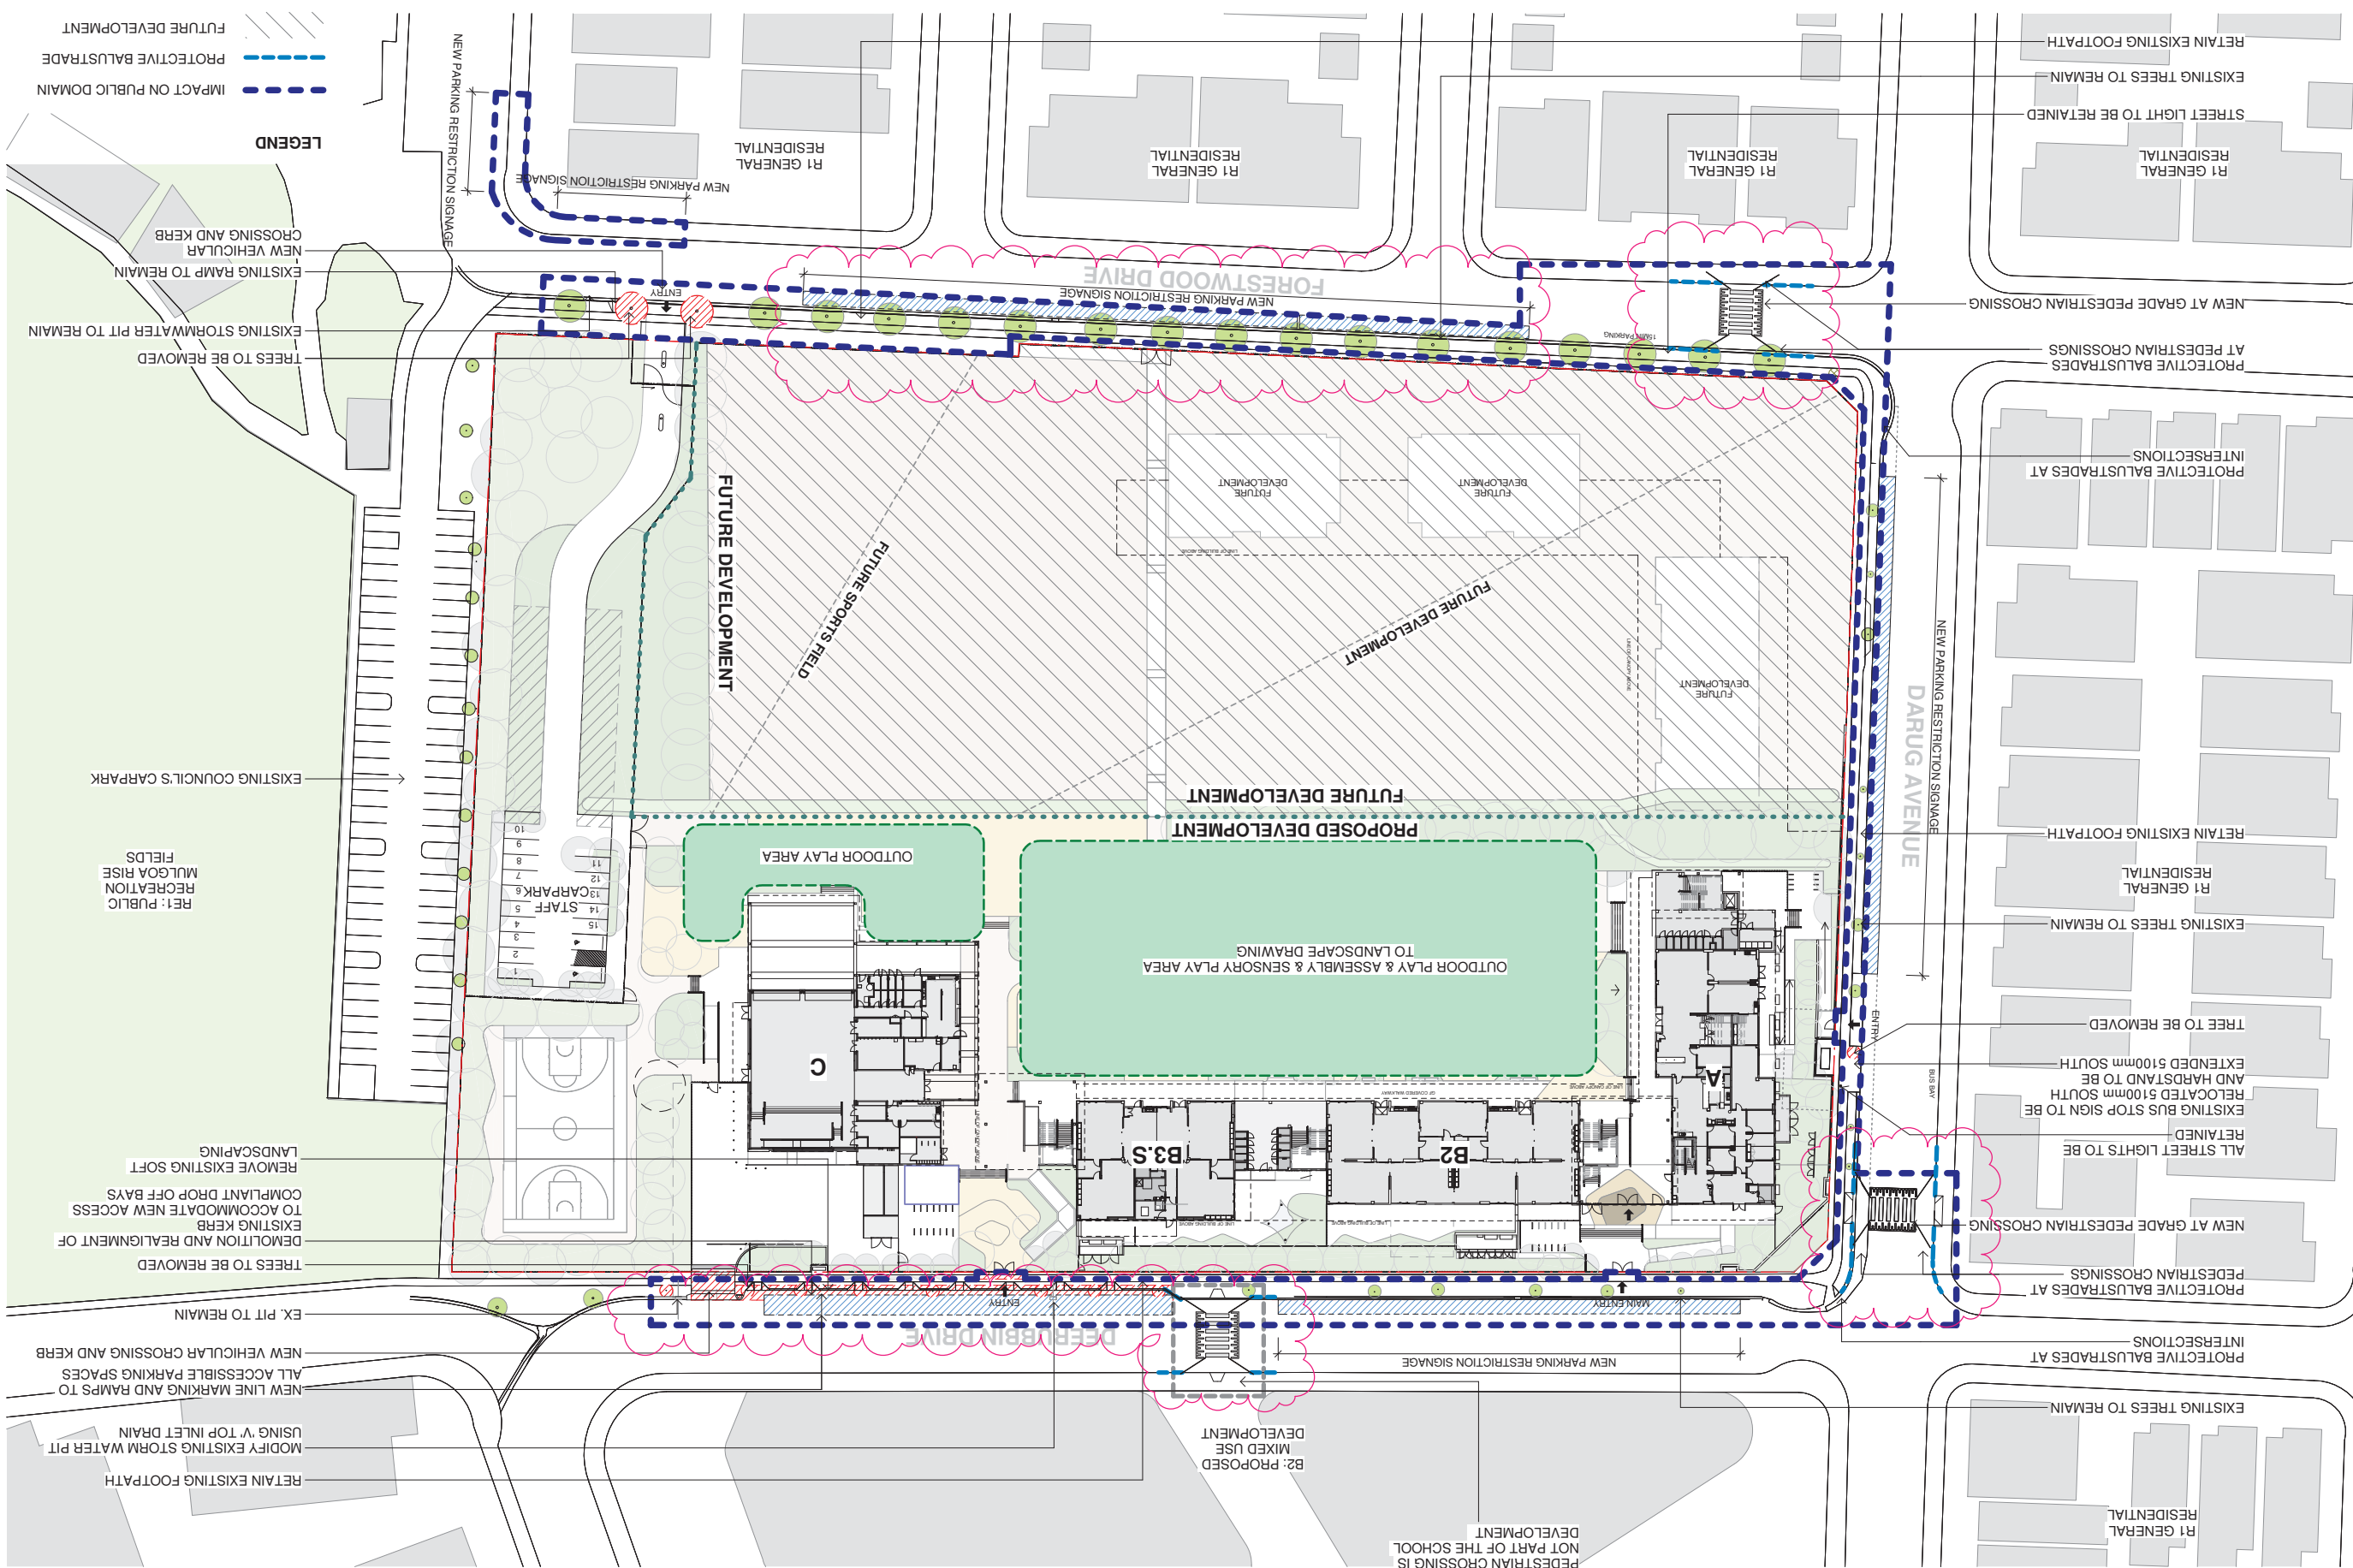

Issue	Date	Description	Chkd
02	16/04/2021	SD ISSUE	
03	22/04/2021	ISSUE FOR COORDINATION	
04	04/05/2021	SSDA ISSUE	
05	29/07/2021	COORDINATION ISSUE	
06	18/07/2021	ISSUE FOR COORDINATION	
07	06/08/2021	SSDA ISSUE	
08	11/08/2021	SSDA ISSUE	
09	11/11/2021	SSDA HIS	
10	12/11/2021	SSDA HIS	
			CHS
			CHS

RICHARD CROOKES
CONSTRUCTIONS

TRAFFIC ENGINEER
PTC
KASIA BALSAM
02 8920 0800
kasia.balsam@ptcconsultants.co
TOWN PLANNER
RPS
ROB DWYER
0425 285 778
rob.dwyer@rpsgroup.com.au



MULTI SERVICES
NDY
RYAN HAHN
0407 236 908
r.hahn@ndy.com

CIVIL AND STRUCT
WOOLACOTTS
JUSTIN CHIRILLO
02 8203 1504
jchirillo@woolacotts.com.au

QUANTITY SURVEYOR
MBM
AUTUMN LU
02 9270 1062
autumn.lu@mbmpl.com.au

Drawing Title
OVERALL GROUND FLOOR PLAN


Project
NEW PRIMARY SCHOOL IN MULGOA
Architect
NBRBS ARCHITECTURE.
Sydney
61 2 9922 2344
Any form of reproduction of this drawing in full or in part without the written permission of NBRBS+PARTNERS Pty Ltd constitutes an infringement of the copyright.
Nominated Architect:
Andrew Durrin NSW 6602
NBRBS & Partners Pty Ltd VIC 5117
© 2021
ABN 16 002 247 561

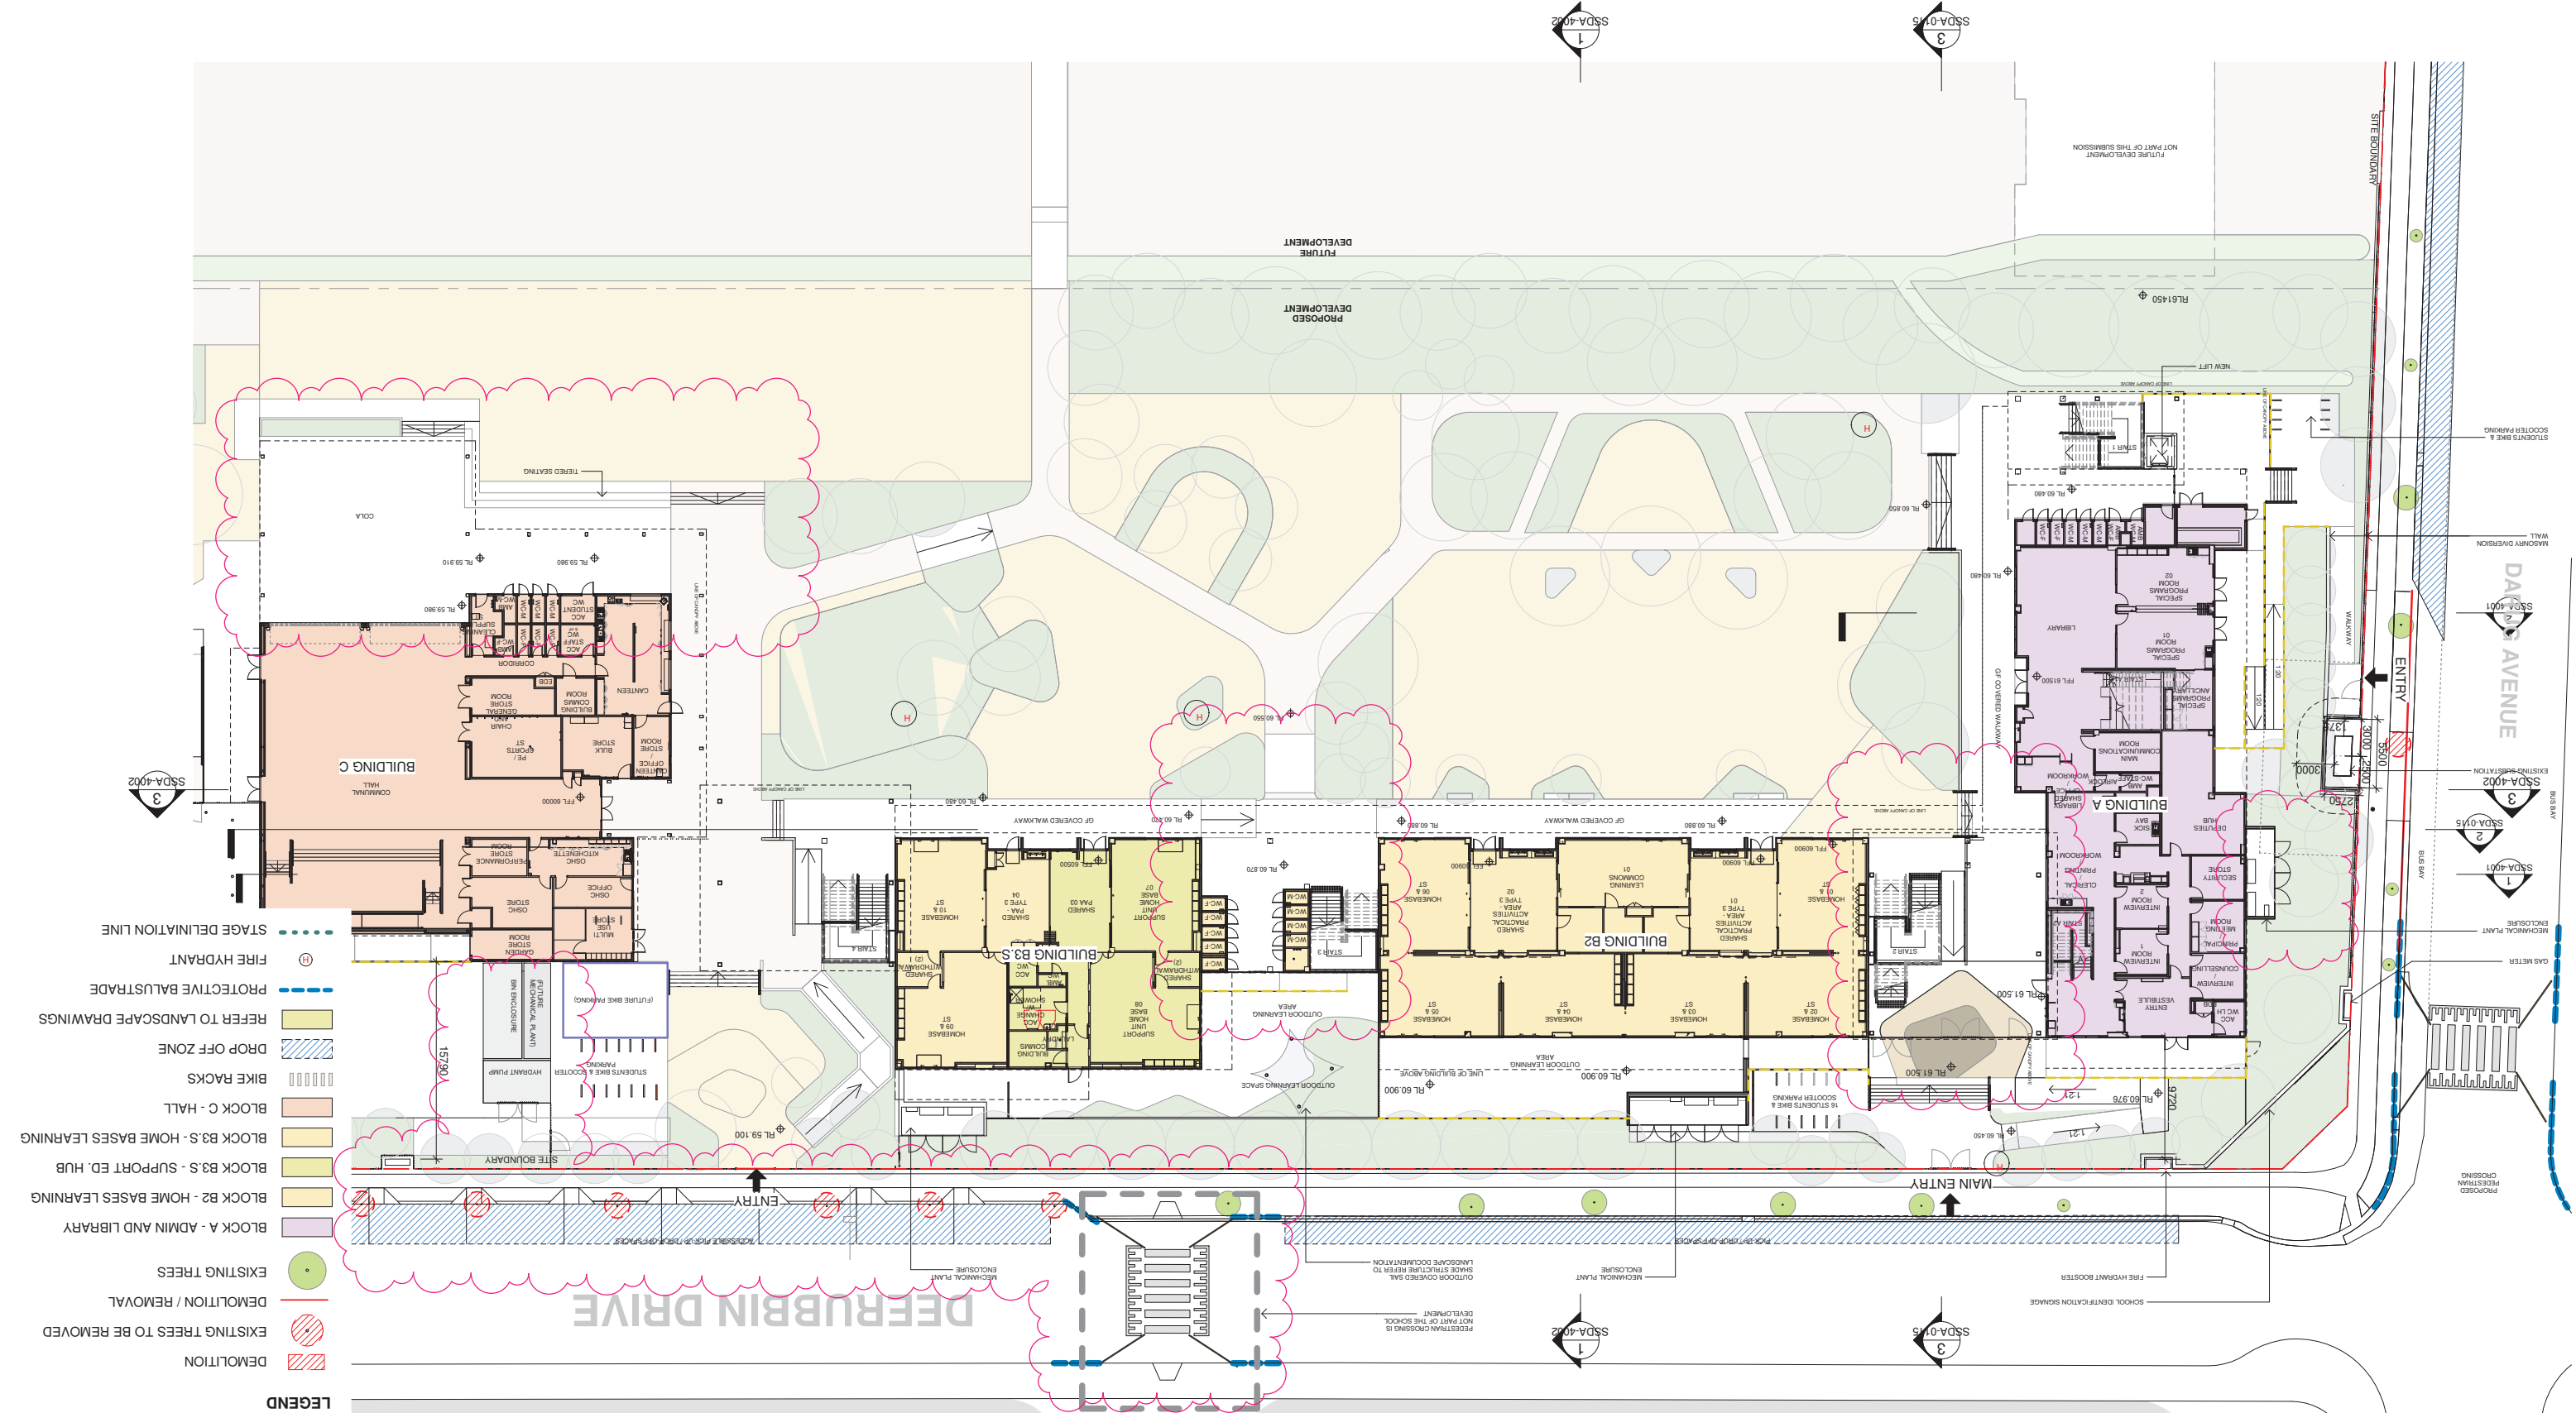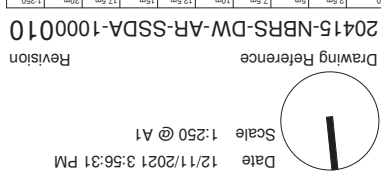

- | | |
|----------------------------------|---|
| DEMOLITION |  |
| EXISTING TREES TO BE REMOVED |  |
| DEMOLITION / REMOVAL |  |
| EXISTING TREES |  |
| BLOCK A - ADMIN AND LIBRARY |  |
| BLOCK B2 - HOME BASES LEARNING |  |
| BLOCK B3.S - SUPPORT ED. HUB |  |
| BLOCK B3.S - HOME BASES LEARNING |  |
| BLOCK C - HALL |  |
| BIKE RACKS |  |
| DROP OFF ZONE |  |
| REFER TO LANDSCAPE DRAWINGS |  |
| PROTECTIVE BALUSTRADE |  |
| FIRE HYDRANT |  |
| STAGE DEFINITION LINE |  |

LEGEND

- BLOCK A - ADMIN AND LIBRARY
- BLOCK B2 - HOME BASES LEARNING
- BLOCK B3.S - SPECIALIST LEAR. AREA
- BLOCK B3.S - HOME BASES LEARNING
- BLOCK C - HALL
- EXTERNAL BALUSTRADE

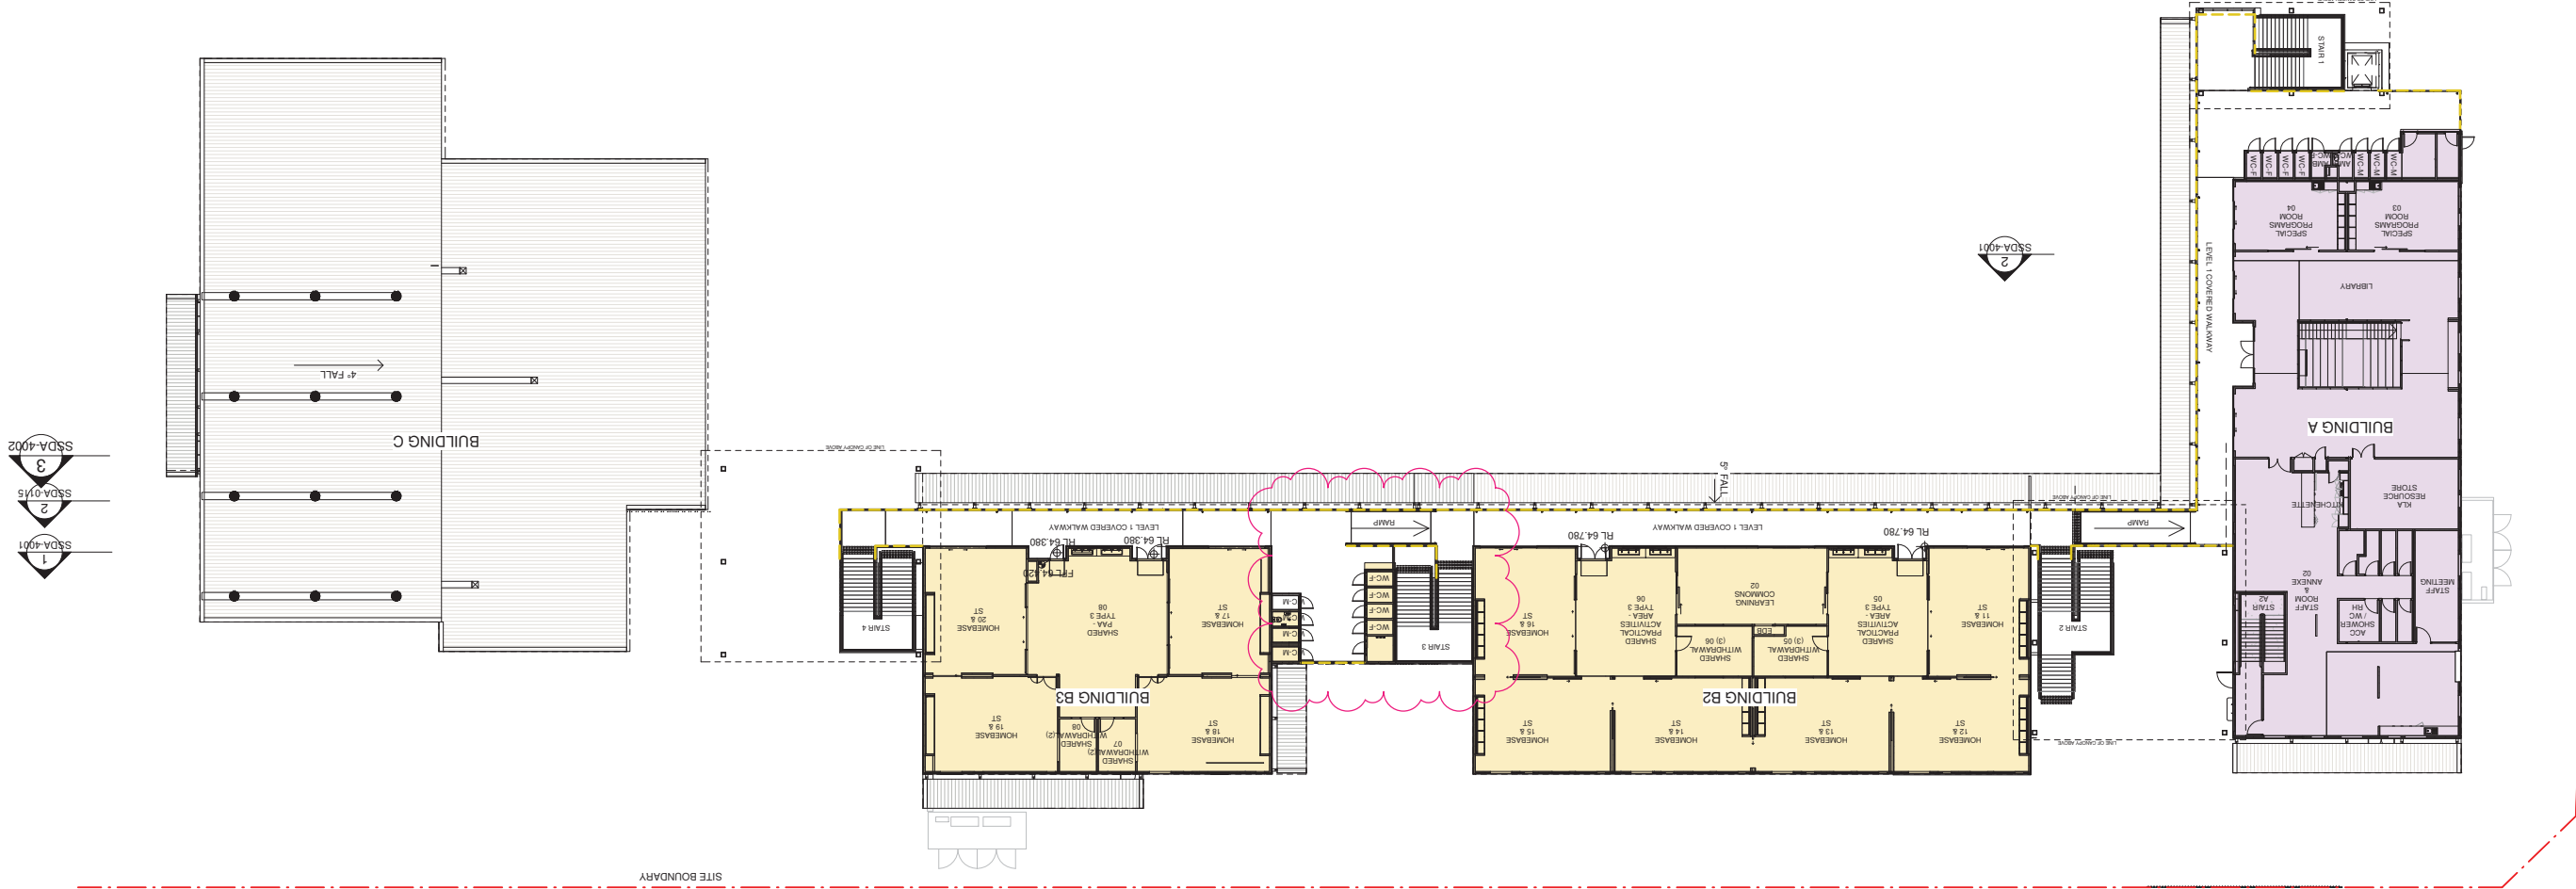

NBSARCHITECTURE.

Architect

Project
NEW PRIMARY SCHOOL IN MULGOA
RISE

at
1-23 Forestwood Drive, Glenmore Park, NSW 2745, Australia

for
SINSW

Sydney
61 2 9922 2344
Any form of replication of this drawing in full or in part without the written permission of NBS+PARTNERS Pty Ltd constitutes an infringement of the copyright.
NBS+PARTNERS Pty Ltd
NBS+PARTNERS Pty Ltd
ABN 16 002 247 565
© 2021


Drawing Reference

20415-NBRS-DW-AR-SSDA-1001

Revision

09

Date 11/11/2021 8:10:42 PM
Scale 1:250 @ A1

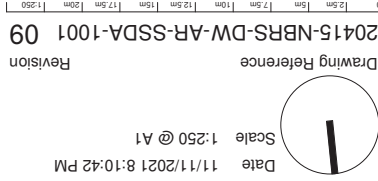

Drawing Title
OVERALL L1 PLAN

QUANTITY SURVEYOR

MBM
AUTUMN LU

02 9270 1062
autumn.lu@mbm.com.au

0407 236 908
r.hahn@rny.com

0424 189 883
JUSTIN CHILLID
ANTHONY MULLIGHAN-WRIGHT

02 8203 1504
jchillid@woolcotts.com.au

0424 189 883
ANTHONY MULLIGHAN-WRIGHT

MULTI SERVICES

NDY
RAYAN HAHN

0407 236 908
r.hahn@rny.com

0424 189 883
JUSTIN CHILLID
ANTHONY MULLIGHAN-WRIGHT

02 8203 1504
jchillid@woolcotts.com.au

0424 189 883
ANTHONY MULLIGHAN-WRIGHT

0424 189 883
ANTHONY MULLIGHAN-WRIGHT

TRAFFIC ENGINEER

PTC
KASIA BALSAM

02 8920 0800
kasia.balsam@pccconsultants.com

0425 285 778
rob.dwyer@pccgroup.com.au

0425 285 778
rob.dwyer@pccgroup.com.au

0425 285 778
rob.dwyer@pccgroup.com.au

0425 285 778
rob.dwyer@pccgroup.com.au

SSDA R1S

RICHARD CROOKES
CONSTRUCTIONS

No.	Date	Description
01	12/04/2021	ISSUE FOR COORDINATION
02	23/04/2021	ISSUE FOR COORDINATION
03	04/05/2021	SSDA ISSUE
04	05/05/2021	SD DESIGN CHANGE
05	19/07/2021	COORDINATION ISSUE
06	28/07/2021	ISSUE FOR COORDINATION
07	06/08/2021	SSDA ISSUE
08	11/08/2021	SSDA R1S
09	11/11/2021	

CHS
JL
JL
JL

SSDA-4001
1
SSDA-4001
2
SSDA-015
3
SSDA-4002

SSDA-4002
1

SSDA-015
3

Issue	No.	Date	Description	Child
	01	12/04/2021	ISSUE FOR COORDINATION	
	02	23/04/2021	ISSUE FOR COORDINATION	
	03	04/05/2021	SSDA ISSUE	
	04	21/07/2021	ISSUE FOR COORDINATION	
	05	28/07/2021	ISSUE FOR COORDINATION	
	06	06/08/2021	SSDA ISSUE	
	07	11/08/2021	SSDA ISSUE	JL
	08	11/11/2021	SSDA RIS	CHS

RICHARD CROOKES
CONSTRUCTIONS

SSDA Rts

TRAFFIC ENGINEER
PTC
KASIA BALSAM
02 8920 0800
kasia.balsam@pticonsultan
TOWN PLANNER
RPS

MULTI SERVICES
NDY
RYAN HAHN
0407 236 908
r.hahn@ndy.com

CIVIL AND STRUCTURAL
WOOLACOTTS
JUSTIN CHIRILLO
02 8203 1504
jchirillo@woolacotts.com.au

QUANTITY SURVEYOR
MBM
AUTUMN LU
02 9270 1062
autumn.lu@wbmpl.com.au

PRELIMINARY

Project
NEW
RISE
at
1-23 For
for
SINSW

Project
NEW PRIMARY SCHOOL IN MULGOA
RISE
at
1-23 Forestwood Drive, Glenmore Park, NSW 2745, Australia


NBRS ARCHITECTURE.
Sydney
61 2 9222 2344
Any form of replication of this drawing in full or in part without the written permission of NBRS+PARTNERS Pty Ltd constitutes an infringement of the copyright.
Nominated Architect:
Andrew Duffin NSW 5602
© 2021

Drawing Reference

Date 11/11/2021
Scale 1:250 @ A1

Date 11/11/2021 8:10:48 PM

Drawing Reference
20415-NBRS-DW-AR-SSDA-1002 08
Revision

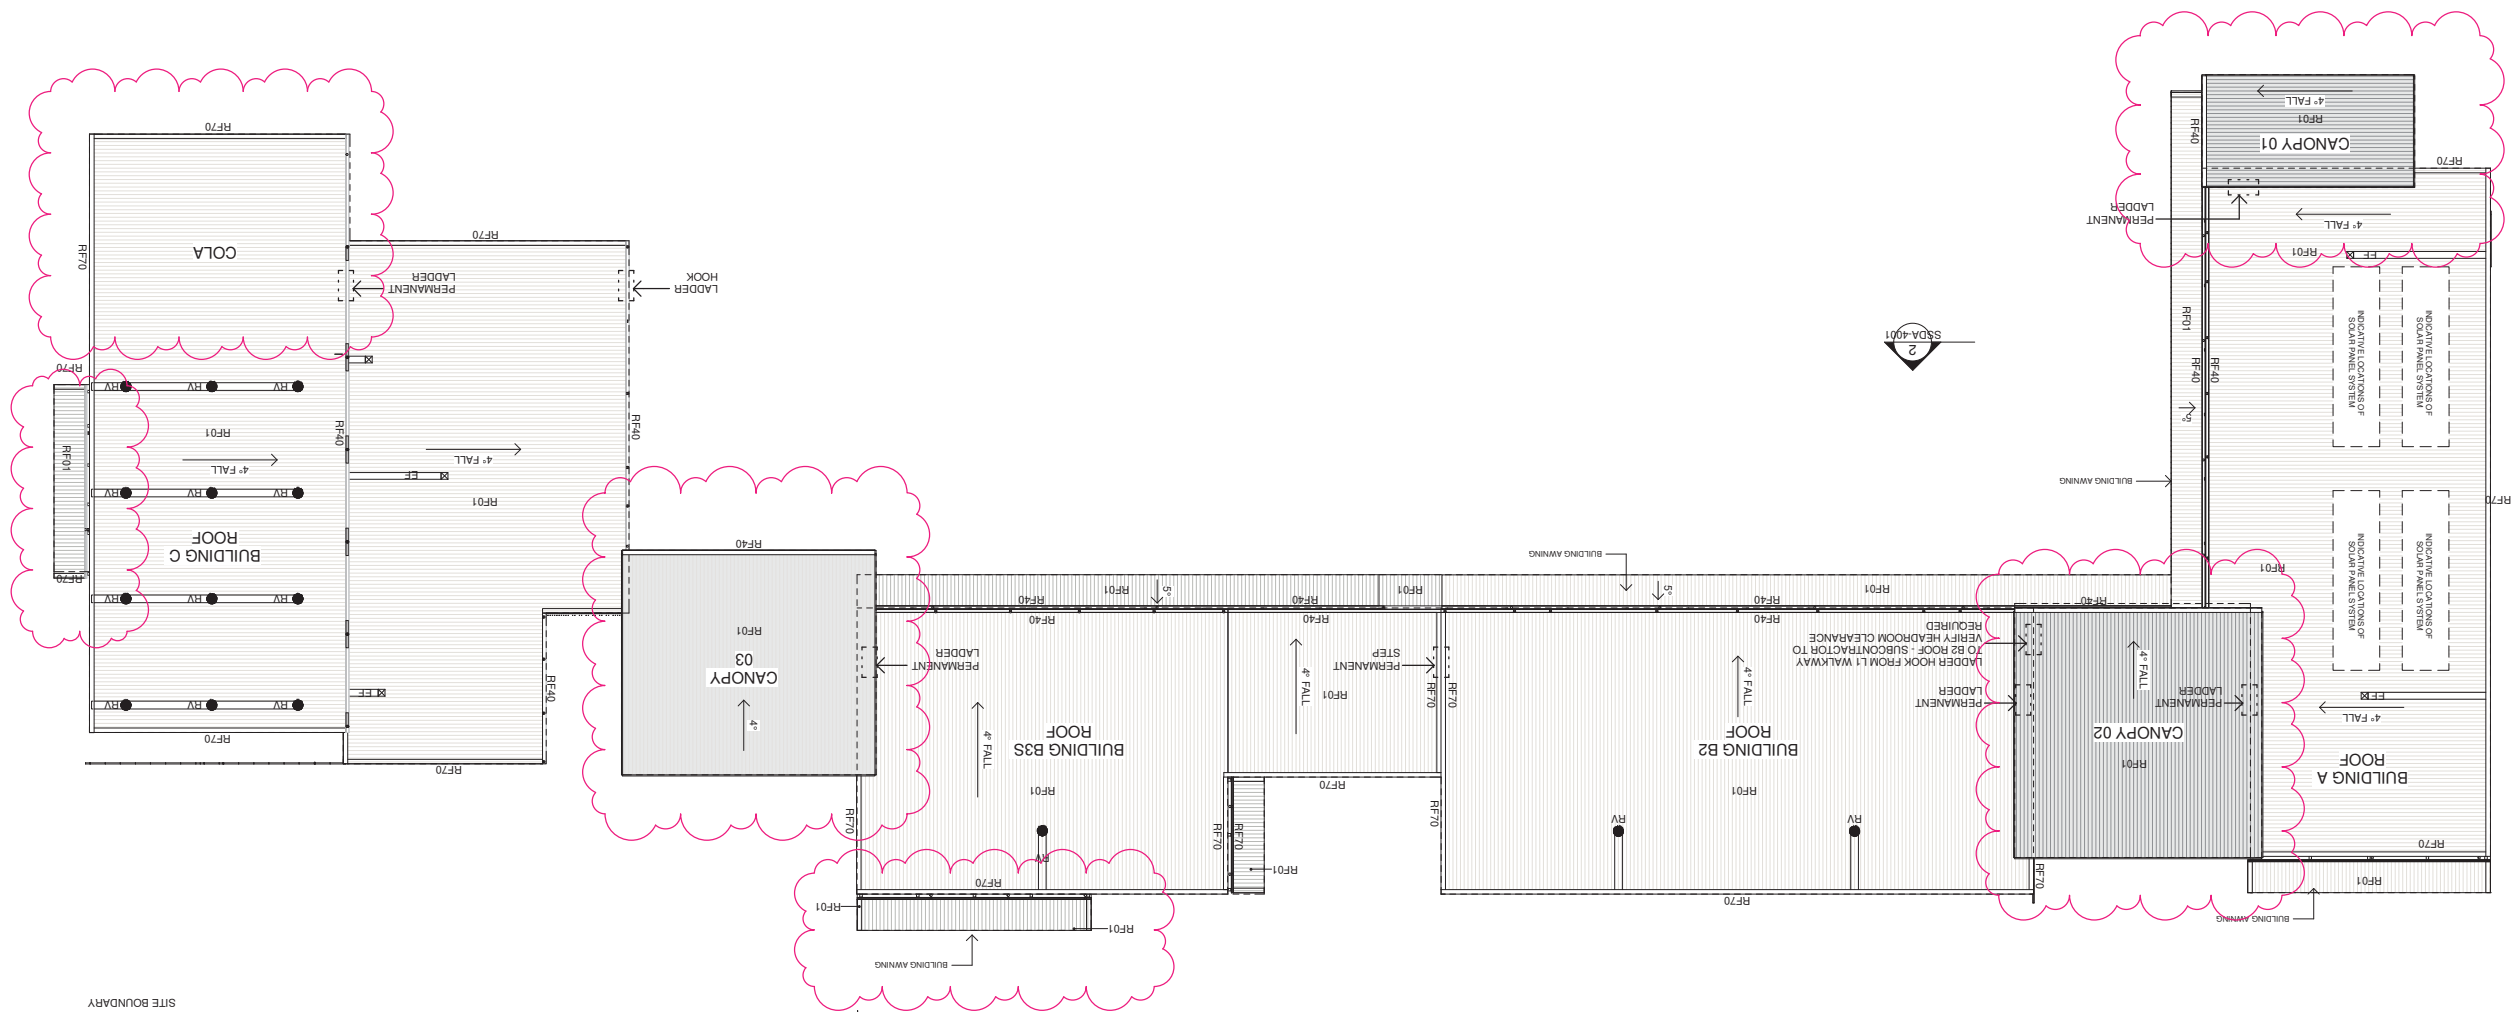

TRAFFIC ENGINEER
KASIA BALSAM
02 8920 0800
kasia.balsam@ptccconsultants.co
RPS
ROB DWYER
0425 285 778
rob.dwyer@rpsgroup.com.au

MULTI SERVICES
NDY
RYAN HAHN
0407 236 908
r.hahn@ndy.com

QUANTITY SURVEYOR
MBM
AUTUMN LU
02 9270 1062
autumn.lu@mbmpl.com.au

FRING PROJECT MANAGER
COLLIERS
ANTHONY MAUGHAN-WRIGHT
0424 189 883
anthony.maughan-wright@colliers.com.au


Project
NEW
RISE
at
1-23 Fore
for
MSNSW

Project
NEW PRIMARY SCHOOL IN MULGOA


Architect
NBSARCHITECTURE.
Sydney
61 2 9922 2244
permission of NBS-PARTNERS Pty Ltd constitutes an infringement of the copyright
Notarised
Andrew Duffin NSW 5602
NBS & Partners Pty Ltd VIC 51197
ABN 16 020 247 5651
© 2021

A circular scale with a thick black needle pointing to the 12 o'clock position. The text "Date" is on the left and "Drawing Reference" is on the right.

Drawing Reference	Revision
20415-NBRS-DW-AR-SSDA-1011	05

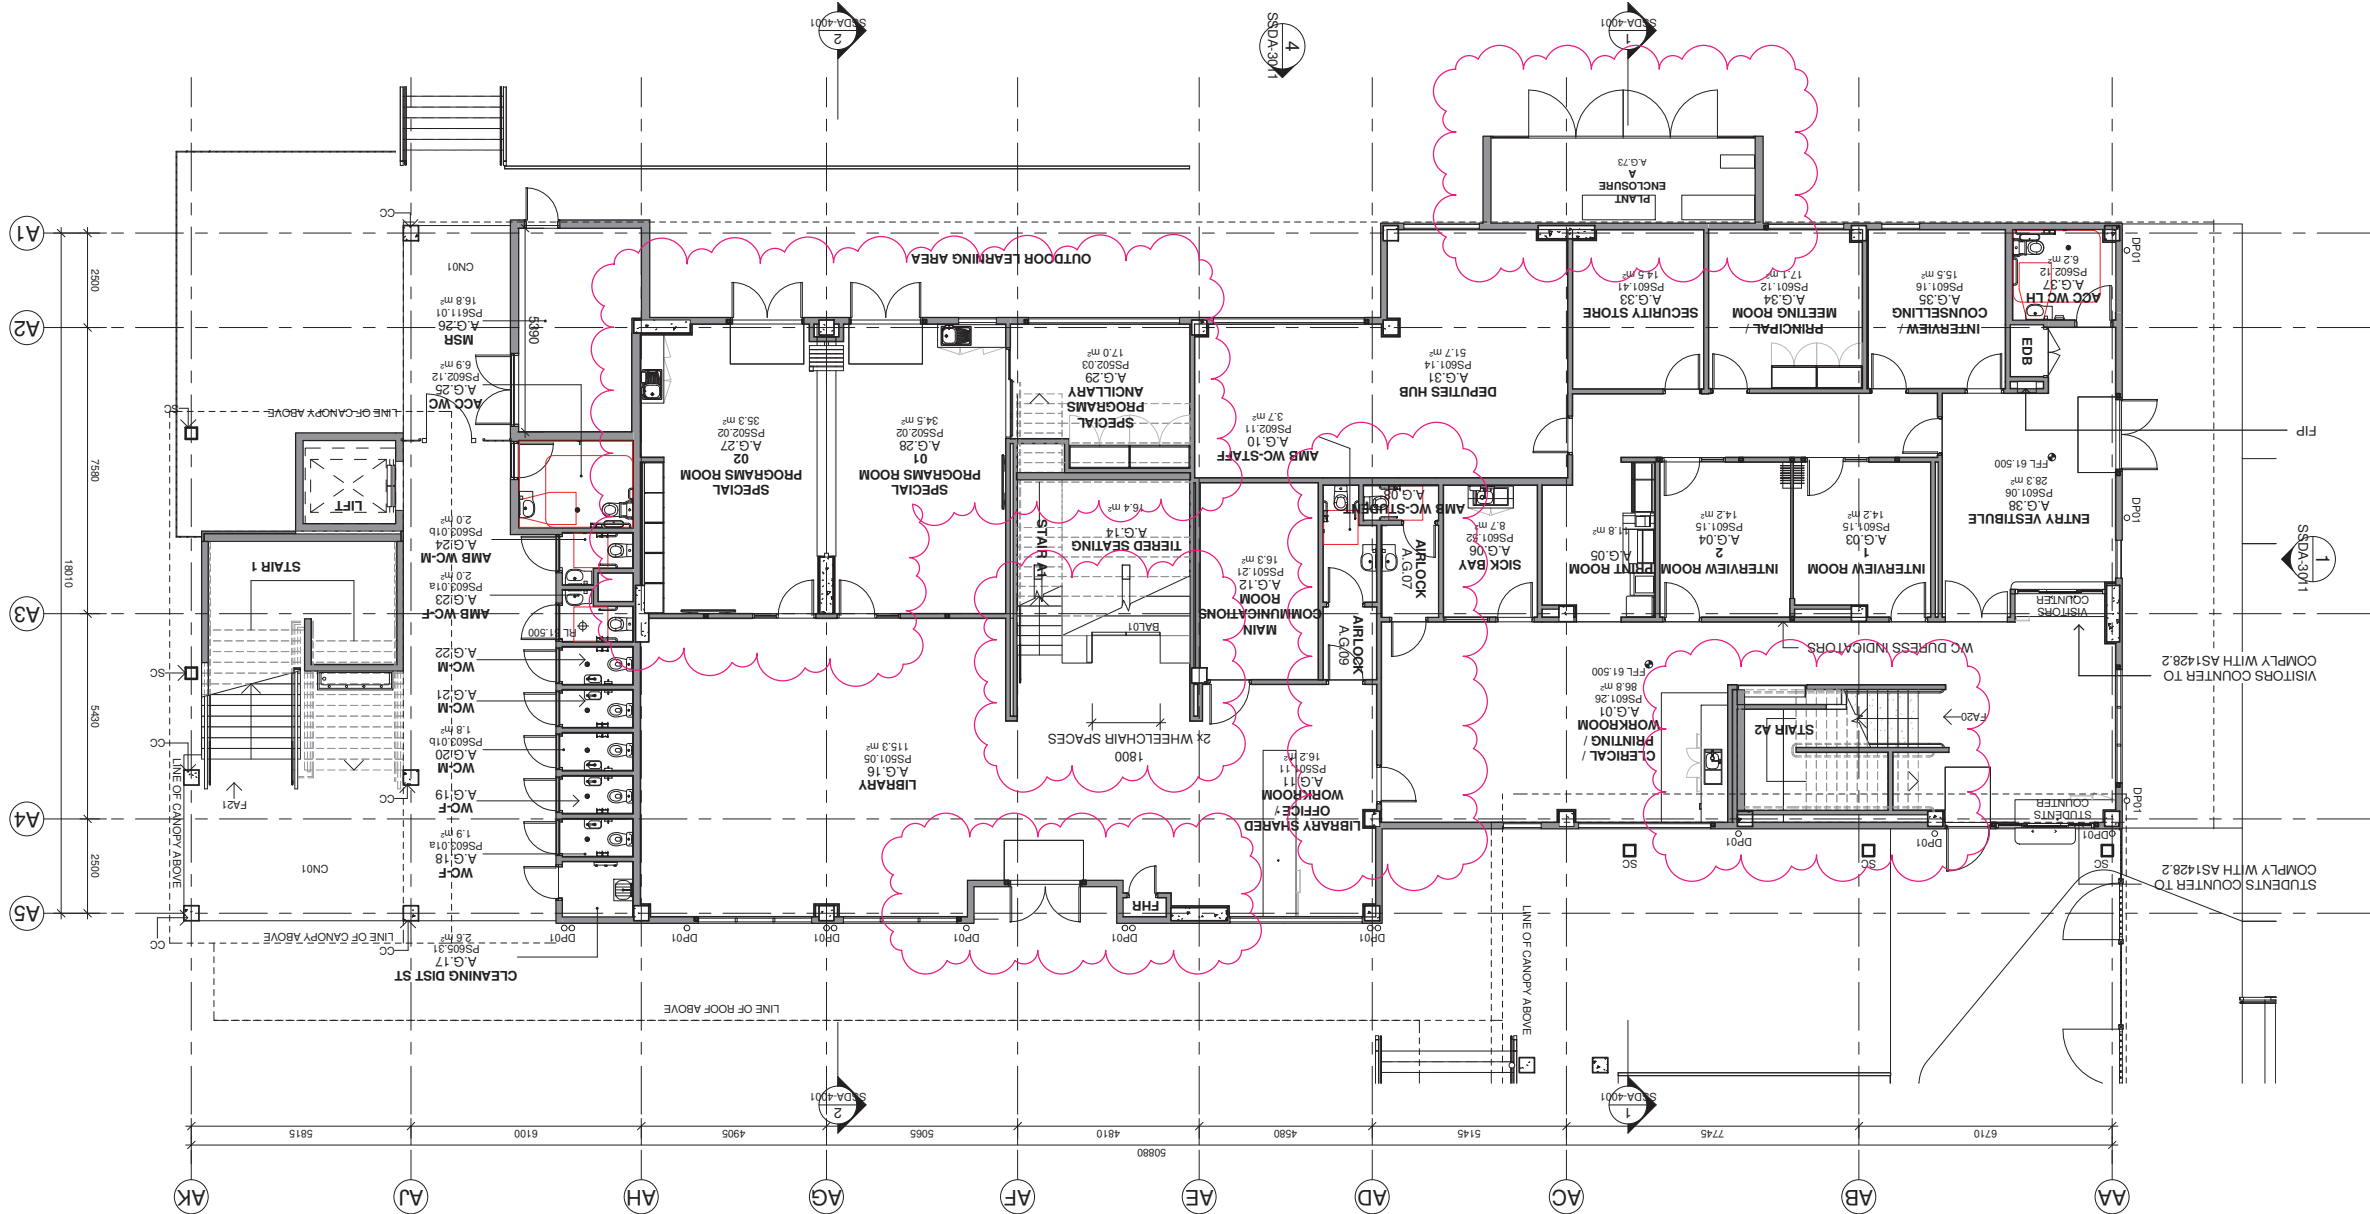

No.	Date	Description
06	11/11/2021	SSDA RIS
05	06/08/2021	SSDA ISSUE
04	28/07/2021	ISSUE FOR COORDINATION
03	04/05/2021	SSDA ISSUE
02	23/04/2021	ISSUE FOR COORDINATION
01	12/04/2021	ISSUE FOR COORDINATION
Issue		
N.T.S.		

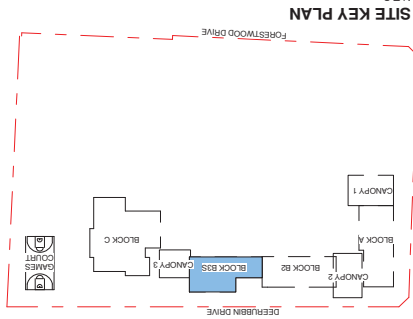

RICHARD CROOKES
CONSTRUCTIONS

TRAFFIC ENGINEER
PTC
KASIA BALSAM
0425 285 778
rob.dwyer@rpsgroup.com.au

MULTI SERVICES
NDY
RYAN HAHN
0407 236 908
r.hahn@rny.com


QUANTITY SURVEYOR
MBM
ALUMIN LU
02 9270 1062
alumin.lu@mbm.com.au


CIVIL AND STRUCTURAL ENGINEERING
COLLIERS
PROJECT MANAGER
ANTHONY MAUGHAN-WRIGHT
0424 189 883
johnli@woolacotts.com.au

Project
NEW PRIMARY SCHOOL IN MULGOA
RISE
at
1-23 Forestwood Drive, Glenmore Park, NSW 2745, Australia


Architect
NBRS ARCHITECTURE
Sydney
61 2 9922 2344
Any form of replication of this drawing in full or in part without the written permission of NBRS+PARTNERS Pty Ltd constitutes an infringement of the copyright.
NBRS+PARTNERS Pty Ltd
ABN 16 002 247 565
© 2021

Drawing Reference
20415-NBRS-DW-AR-SSDA-1012 06
Revision
Date 11/11/2021 7:09:54 PM
Scale 1:100 @ A1

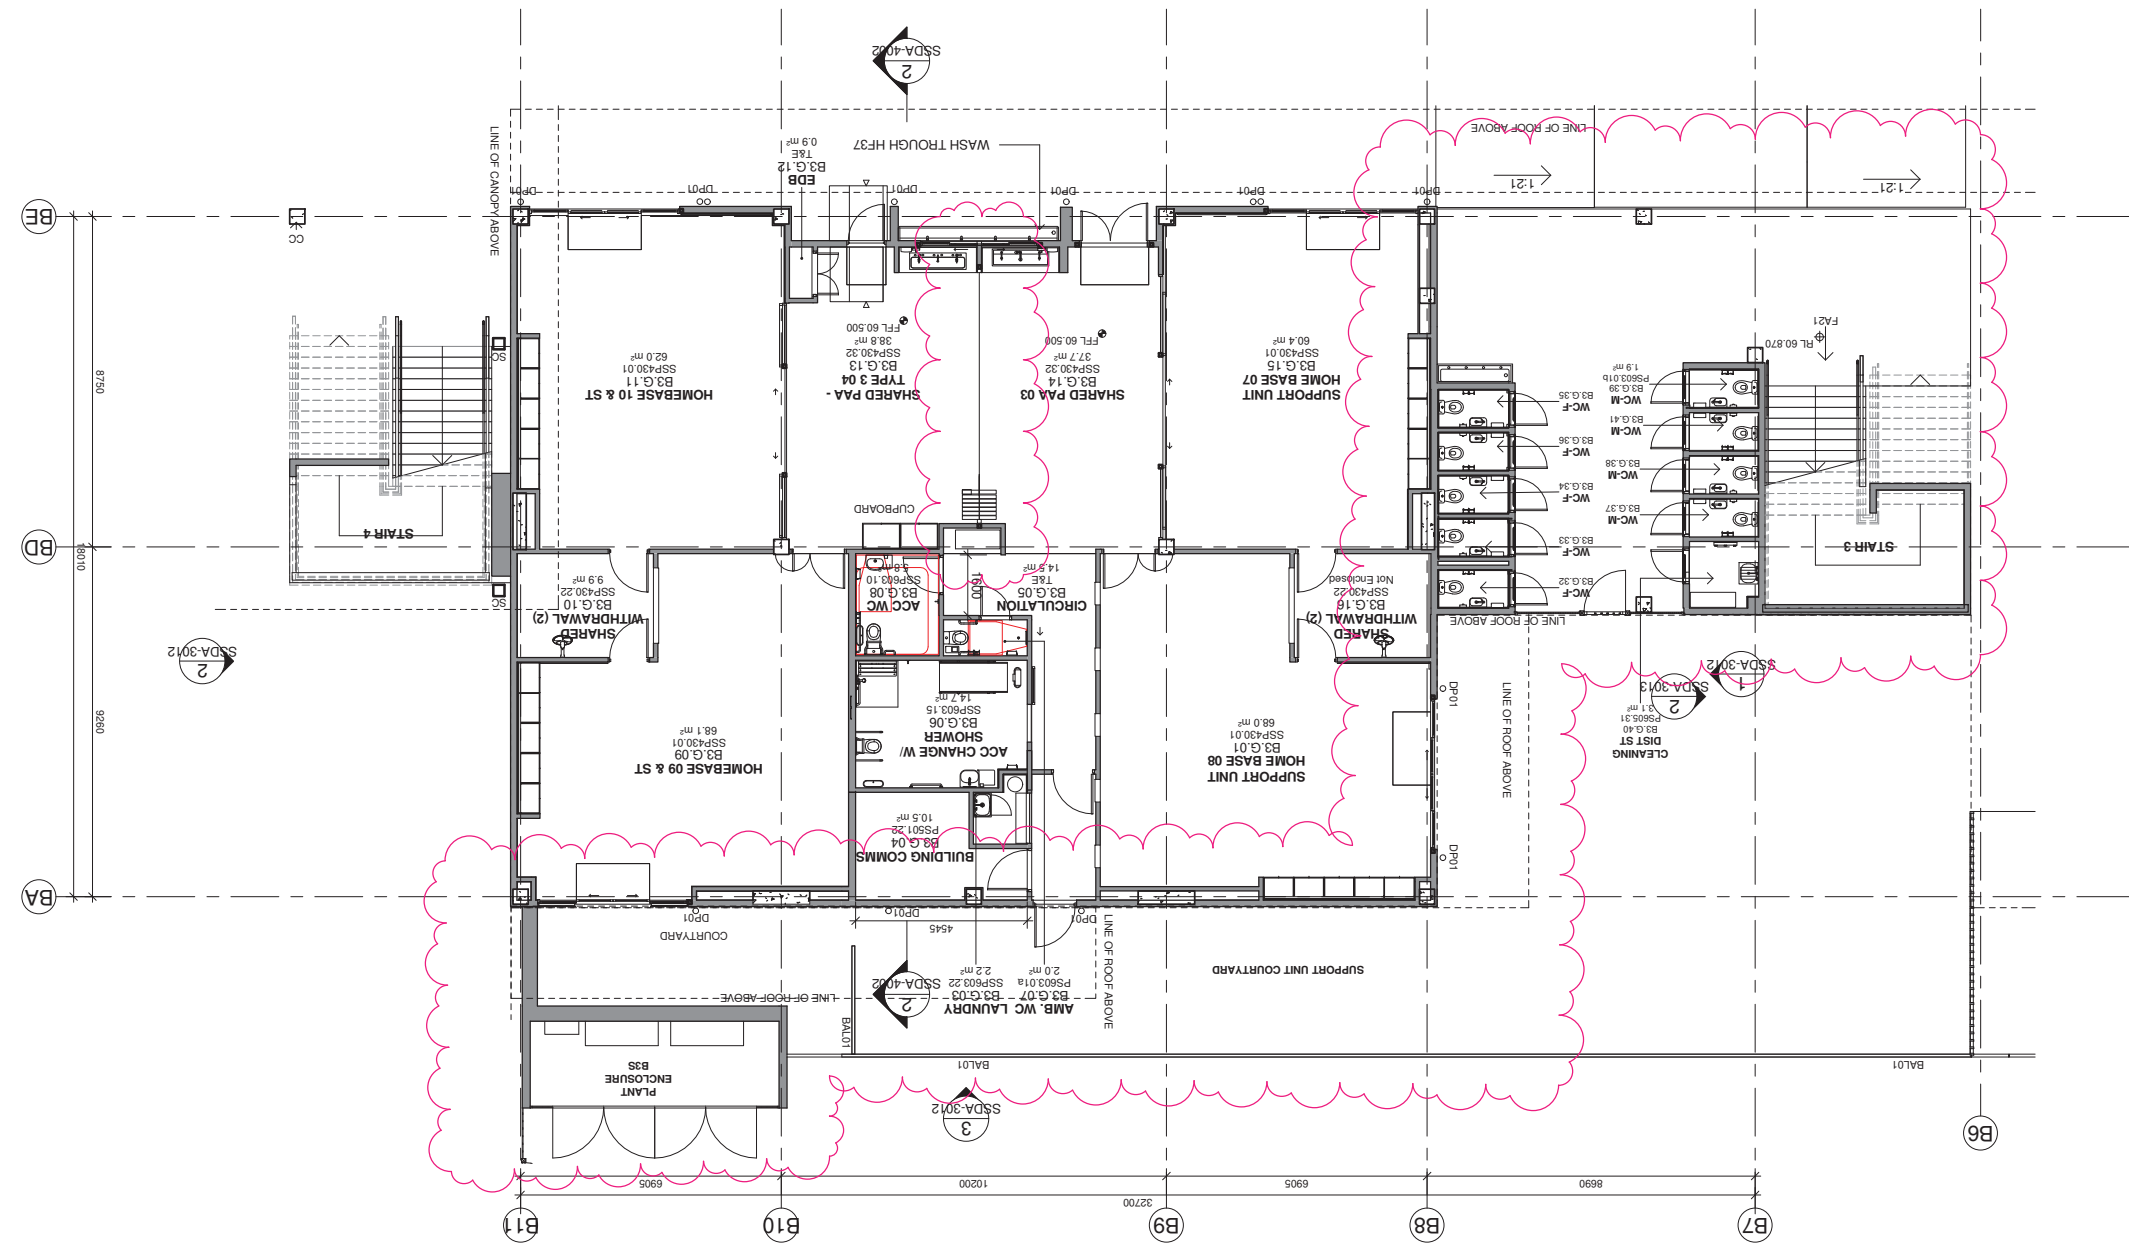

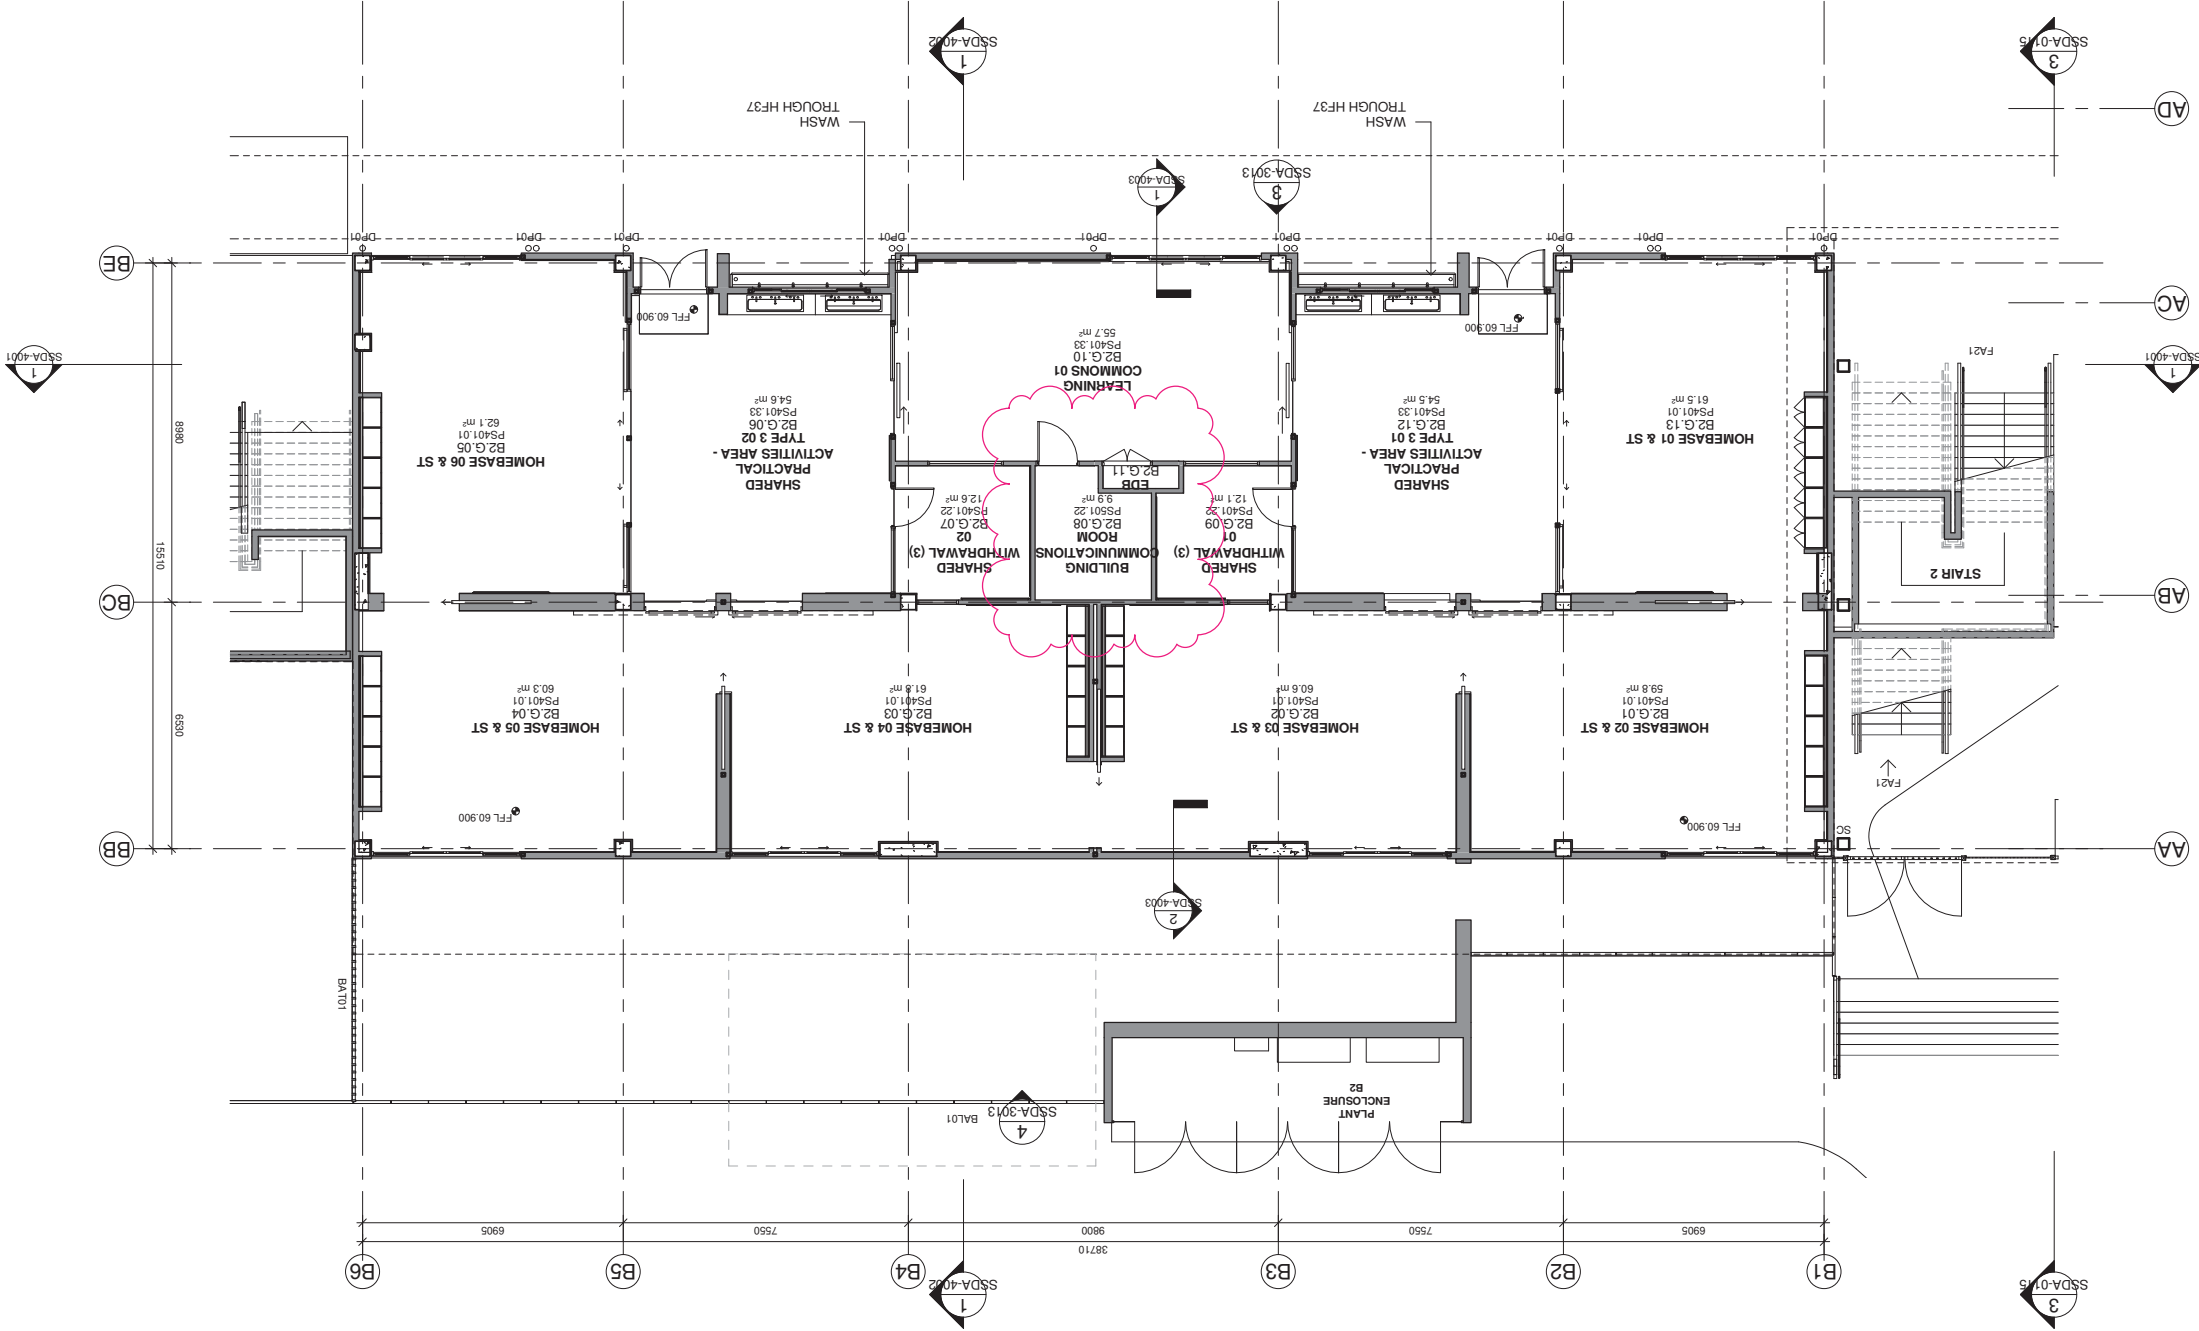

Issue	No.	Date	Description
N.T.S.			
05	11/11/2021	SSDA RIS	
04	06/09/2021	SSDA RIS	
03	04/05/2021	SSDA ISSUE	
02	23/04/2021	ISSUE FOR COORDINATION	
01	12/04/2021	ISSUE FOR COORDINATION	

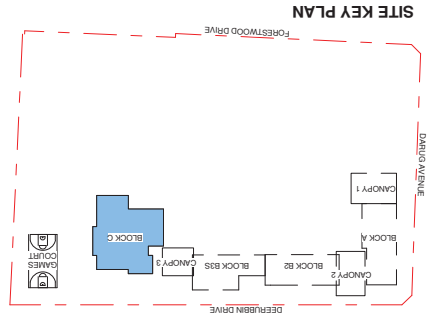

RICHARD CROOKES CONSTRUCTIONS
RCS
TOWN PLANNER
RCS DWYER
0425 285 778
rob.dwyer@rpsgroup.com.au

TRAFFIC ENGINEER
PTC
KASIA BALSAM
02 8920 0800
kasia.balsam@ptcconsultants.co

MULTI SERVICES
NDY
RYAN HAHN
0407 296 908
r.hahn@ndy.com

QUANTITY SURVEYOR
MBM
AUTUMN LU
02 9270 1062
autumn.lu@mbmcl.com.au

COLLIERS PROJECT MANAGER
COLLIERS
ANTHONY MULLIGHAN-WRIGHT
0424 189 883
anthony.mullighan-wright@colliers.com.au

Project
NEW PRIMARY SCHOOL IN MULGOA
RISE
at
1-23 Forestwood Drive, Glenmore Park, NSW 2745, Australia

Architect
NBRS ARCHITECTURE
Sydney
61 2 9922 2344
Any form of replication of this drawing in full or in part without the written permission of NBRS+PARTNERS Pty Ltd constitutes an infringement of the copyright.
NBRS+PARTNERS Pty Ltd
ABN 16 002 247 565
© 2021

Drawing Reference
20415-NBRS-DW-AR-SSDA-1014 05
Revision
Date 11/11/2021 7:10:37 PM
Scale 1:100 @ A1



TRAFFIC ENGINEER
PTC
KASIA BALSAM
02 8920 0800
kasia.balsam@ptcconsultants.co
TOWN PLANNER
RPS
0425 285 778
rob.dwyer@rpsgroup.com.au

MULTI SERVICES
NDY
RYAN HAHN
0407 236 908
r.hahn@ndy.com

QUANTITY SURVEYOR
MBM
AUTUMN LU
02 9270 1062
autumn.lu@mbmpi.com.au



 
Project
NEW
RISE
at
1-23 For
for
MSISW

Project
NEW PRIMARY SCHOOL IN MULGOA


Architect
NBSARCHITECTURE.
Sydney
61 2 9922 2344
copyright © NBS+PARTNERS Pty Ltd constitutes an infringement of the
copy right of NBS+PARTNERS Pty Ltd VIC 51197
Andrew Durlin MSW 5602
NBS+Partners Pty Ltd VIC 51197
ABN 16 020 242 5656
© 2021

A circular scale with a thick black needle pointing to the right. The word 'Date' is written vertically on the left side of the circle, and 'Drawing Reference' is written vertically on the right side.

Date 11/11/2021 8:10:54 PM
Scale 11:000 @ A1

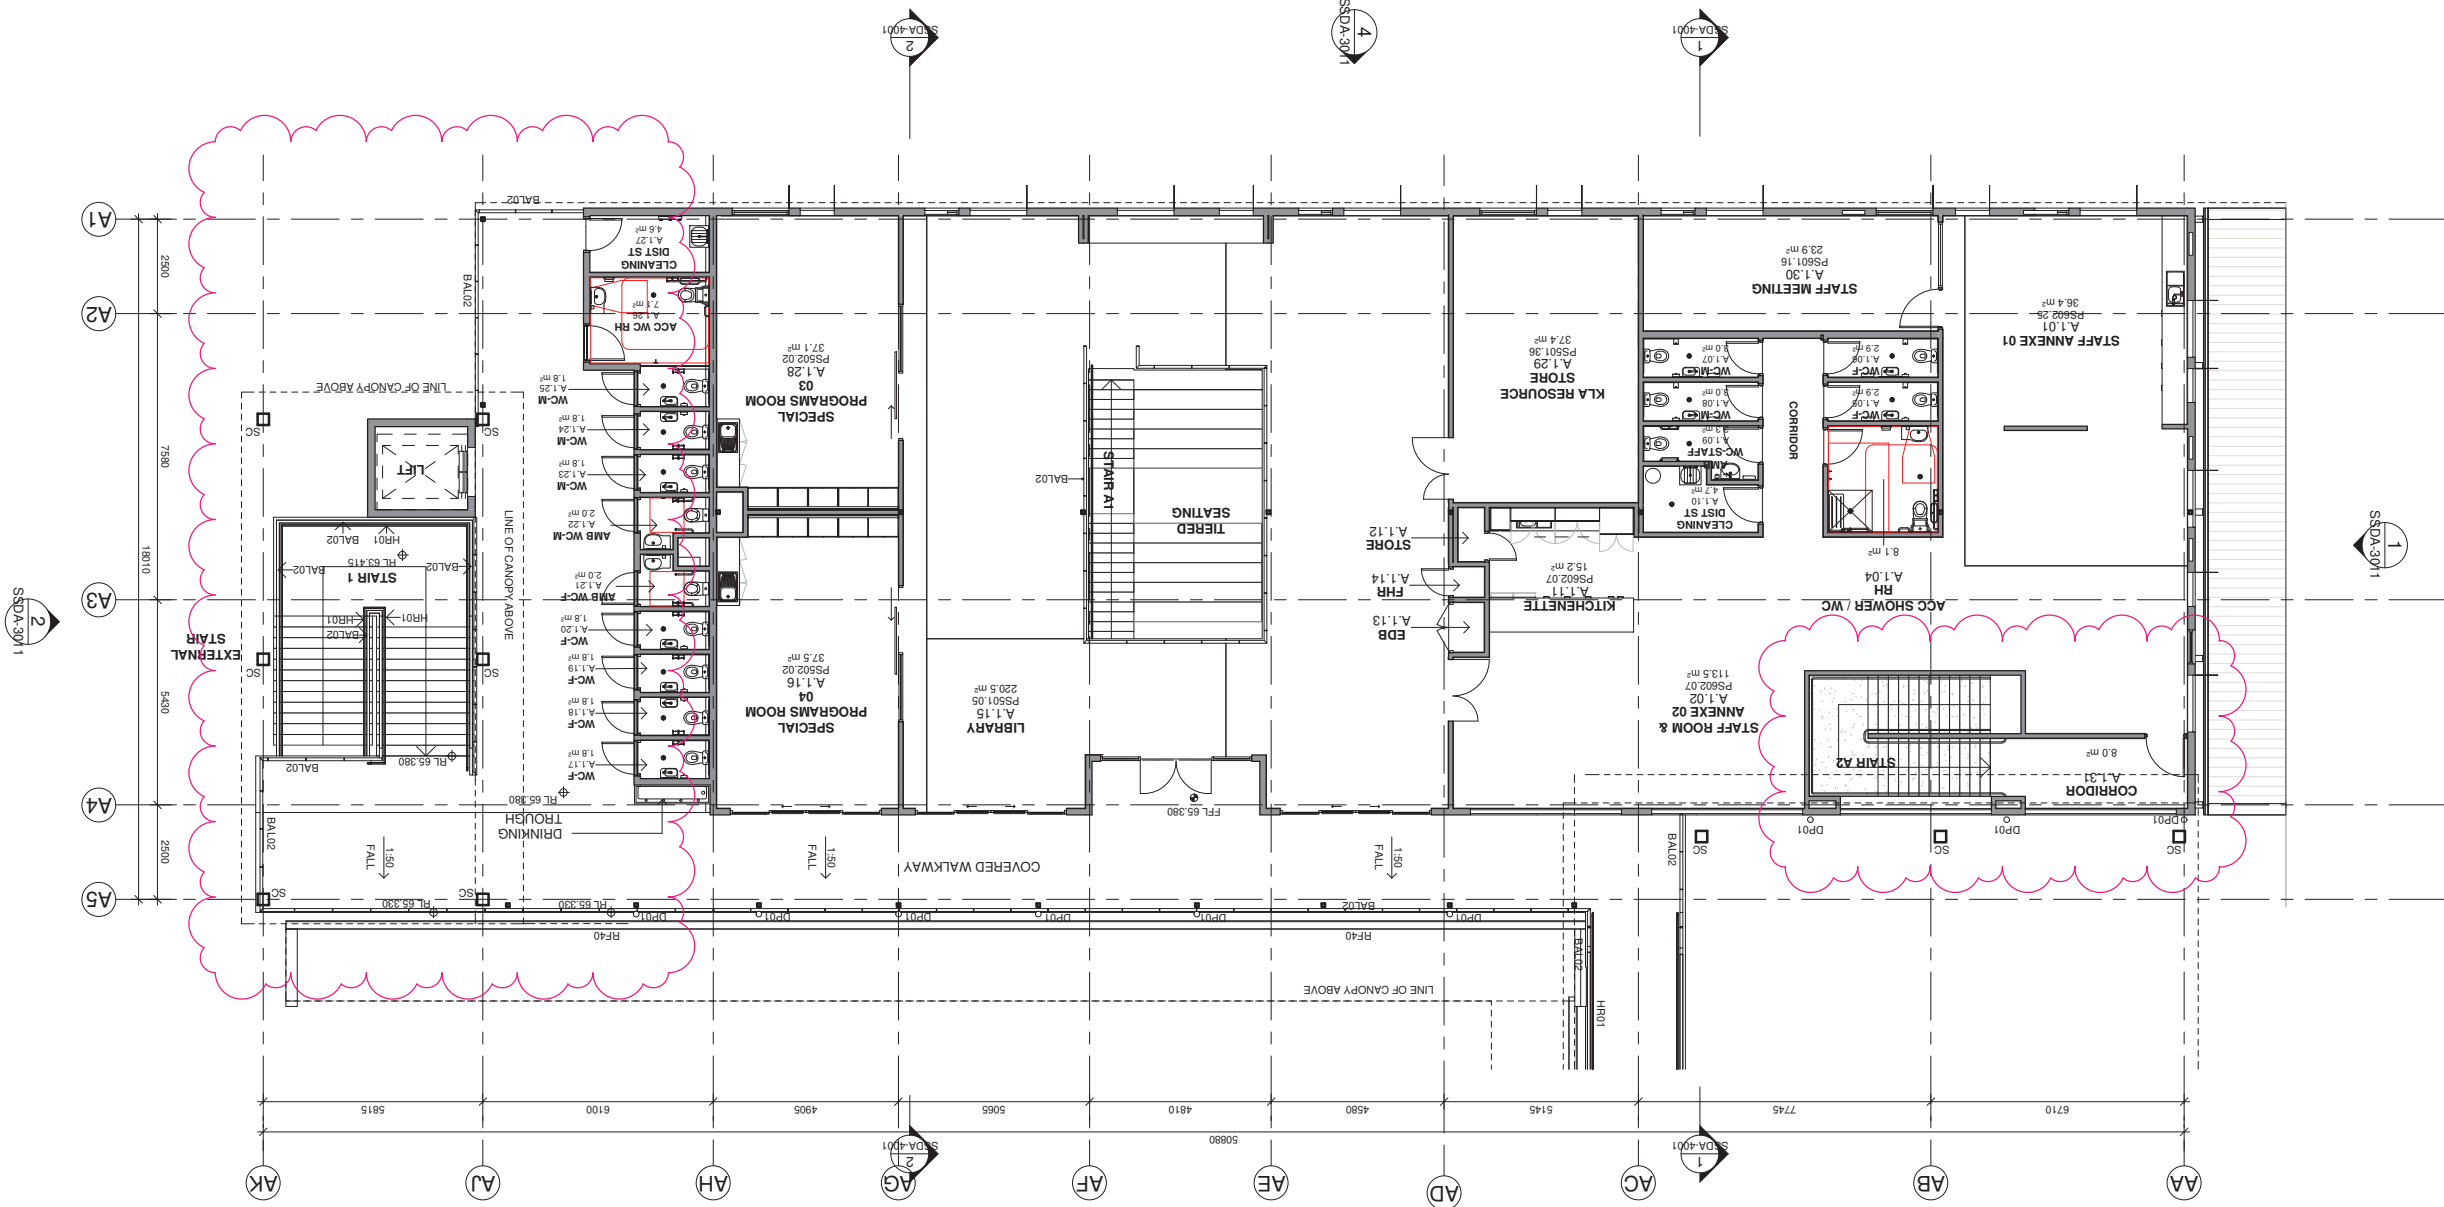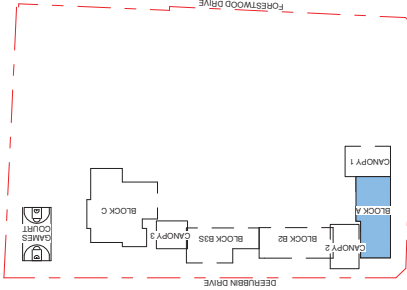

No.	Date	Description
05	11/11/2021	SSDA RIS
04	06/08/2021	SSDA ISSUE
03	04/05/2021	SSDA ISSUE
02	23/04/2021	ISSUE FOR COORDINATION
01	12/04/2021	ISSUE FOR COORDINATION
Issue		
N.T.S.		
CHS		
JL		

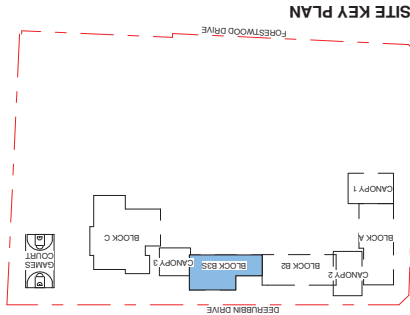

RICHARD CROOKES
CONSTRUCTIONS

TRAFFIC ENGINEER
PTC
KASIA BALSAM
02 8920 0800
kasia.balsam@pticonsultants.co
RPS
ROB DWYER
0425 285 778
rob.dwyer@rpsgroup.com.au


MULTI SERVICES
NDY
RYAN HAHN
0407 296 908
r.hahn@ndy.com
CIVIL AND STRUCTURAL ENGINEERING
WOOLACOTTS
JUSTIN CHILLID
02 8203 1504
jchillid@woolacotts.com.au

QUANTITY SURVEYOR
MBM
AUTUMN LU
02 9270 1062
autumn.lu@bmpl.com.au
COLLIERS
ANTHONY MAUGHAN-WRIGHT
0424 189 883
anthony.maughan-wright@colliers.com

Drawing Title
BLOCK B3 - LEVEL 1 PLAN

Project
NEW PRIMARY SCHOOL IN MULGOA
Rise
at
1-23 Forestwood Drive, Glenmore Park, NSW 2745, Australia
for
SINSW

Architect
NBRSPARTNERS
Sydney
61 2 9922 2344
Any form of replication of this drawing in full or in part without the written permission of NBRSPARTNERS Pty Ltd constitutes an infringement of the copyright.
Nominated Architect:
Andrew Duffin NSW 5602
NBRSPARTNERS Pty Ltd VIC 5197
ABN 16 002 247 565
© 2021

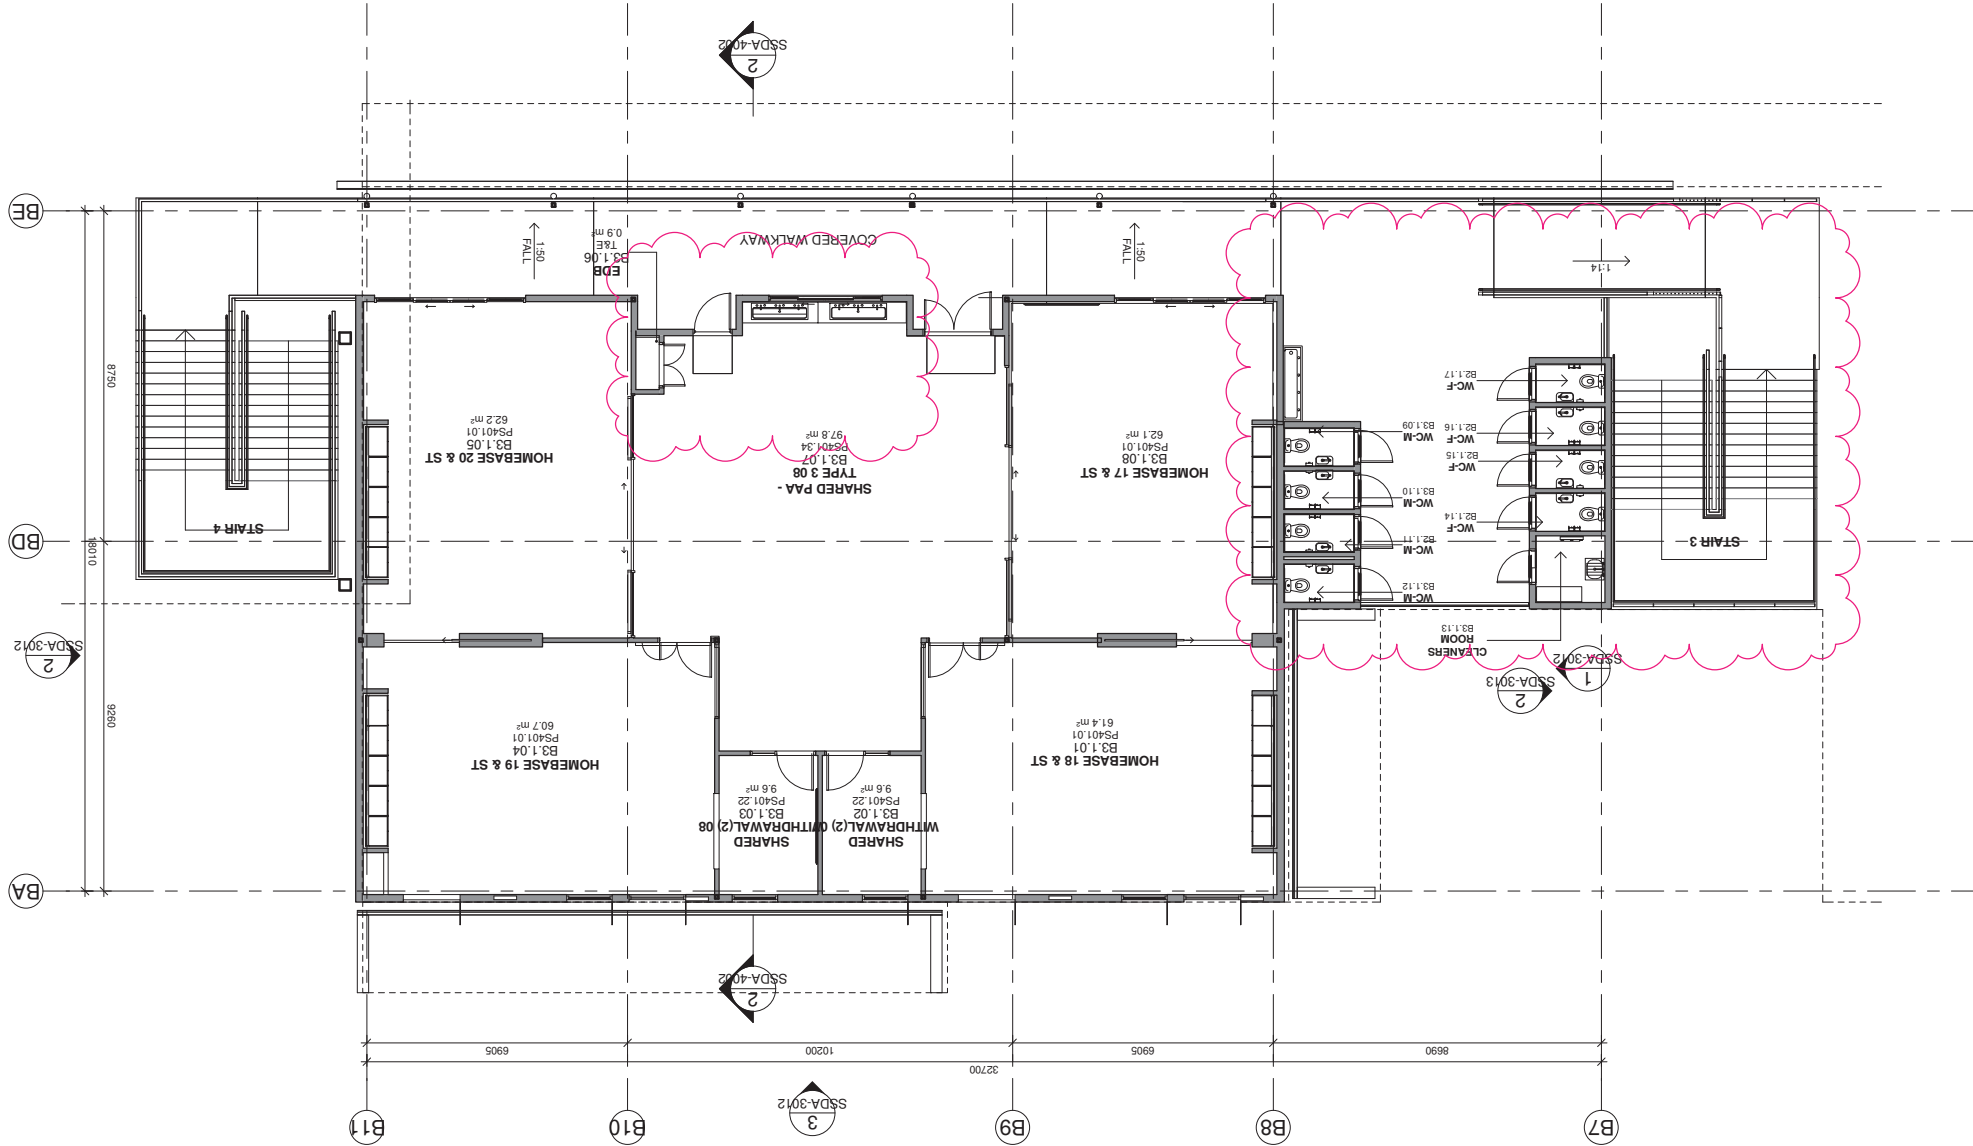

Drawing Reference
20415-NBRS-DW-AR-SSDA-1022 05

Date 11/11/2021 7:11:10 PM
Scale 1:100 @ A1



Issue	No.	Date	Description
01	23/04/2021	ISSUE FOR COORDINATION	
02	04/05/2021	SSDA ISSUE	
03	23/07/2021	COORDINATION ISSUE	
04	06/08/2021	SSDA ISSUE	
05	11/08/2021	SSDA ISSUE	
06	11/11/2021	SSDA RIS	
07	12/11/2021	SSDA RIS	
CHS			
JL			

SSDA RIS

RICHARD CROOKES
CONSTRUCTIONS

TRAFFIC ENGINEER
PTC
KASIA BALSAM
kasia.balsam@pccconsultants.co

TOWN PLANNER
RPS
ROB DWYER
rob.dwyer@rpsgroup.com.au

MULTI SERVICES
NDY
RYAN HAHN
0407 236 908
r.hahn@ndy.com

CIVIL AND STRUCTURAL ENGINEERING
WOOLACOTTS
JUSTIN CHILLID
02 8203 1504
jchillid@woolacotts.com.au

QUANTITY SURVEYOR
MBM
AUTUMN LU
02 9270 1062
autumn.lu@mbm.com.au

COLLIERS
ANTHONY MULLIGHAN-WRIGHT
0424 189 883
anthony.mullighan-wright@colliers.com

SITE ELEVATIONS

Drawing Title

Project
NEW PRIMARY SCHOOL IN MULGOA
RISE

at
1-23 Forestwood Drive, Glenmore Park, NSW 2745, Australia

for
SINISW




Architect
NBSRARCHITECTURE
Sydney
61 2 9922 2344
Any form of replication of this drawing in full or in part without the written permission of NBSR+PARTNERS Pty Ltd constitutes an infringement of the copyright.

NBSR & Partners Pty Ltd VIC 51197
ABN 16 002 247 565
© 2021

Drawing Reference
20415-NBRS-DW-AR-SSDA-3010 07

Revision

Date 15/11/2021 6:13:49 PM
Scale 1:200 @ A1

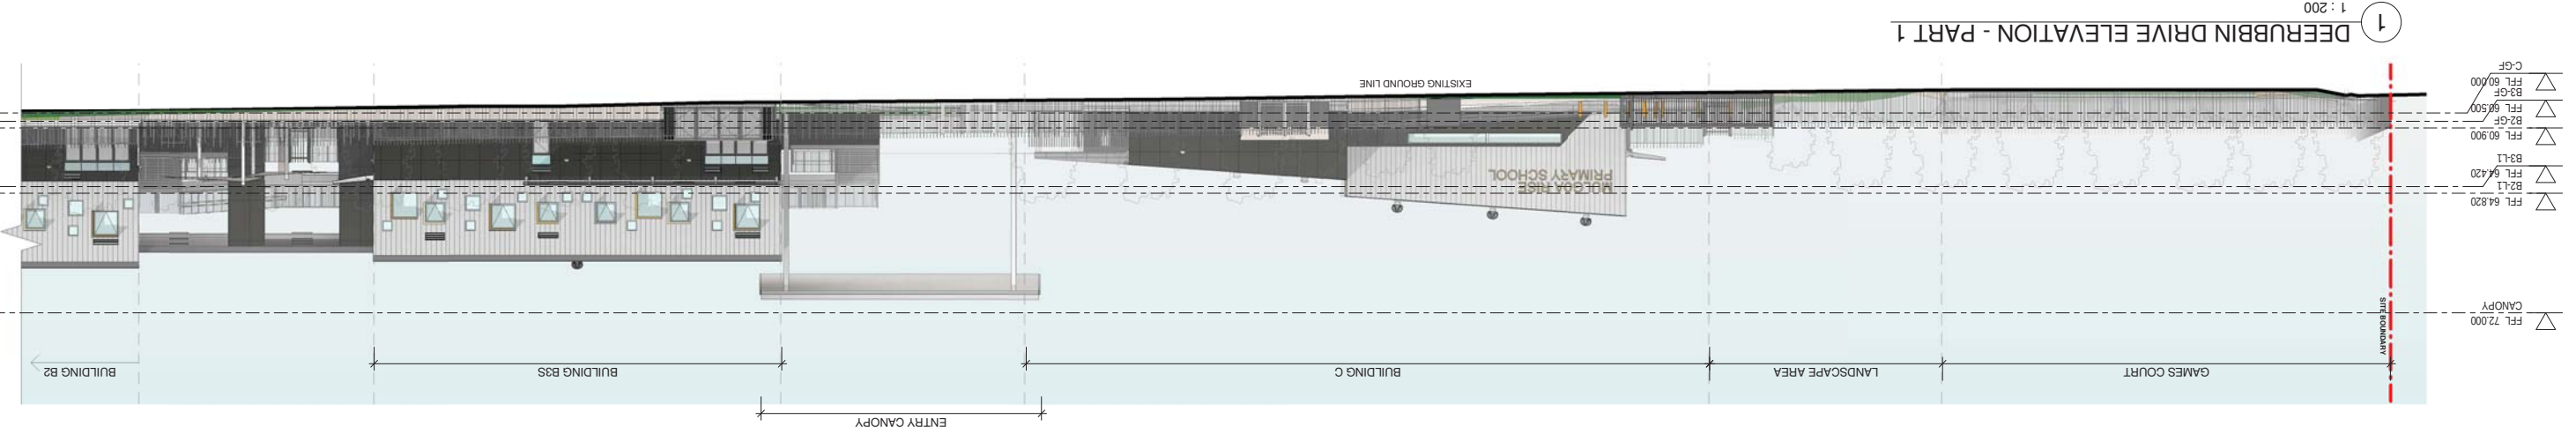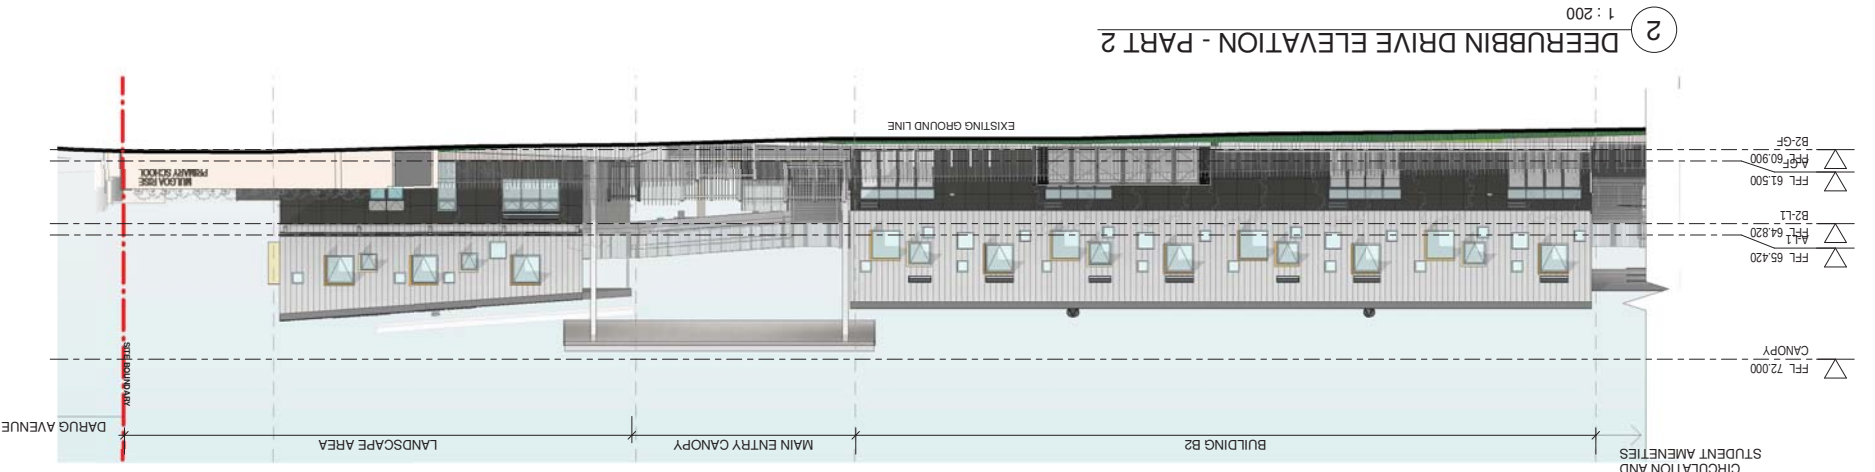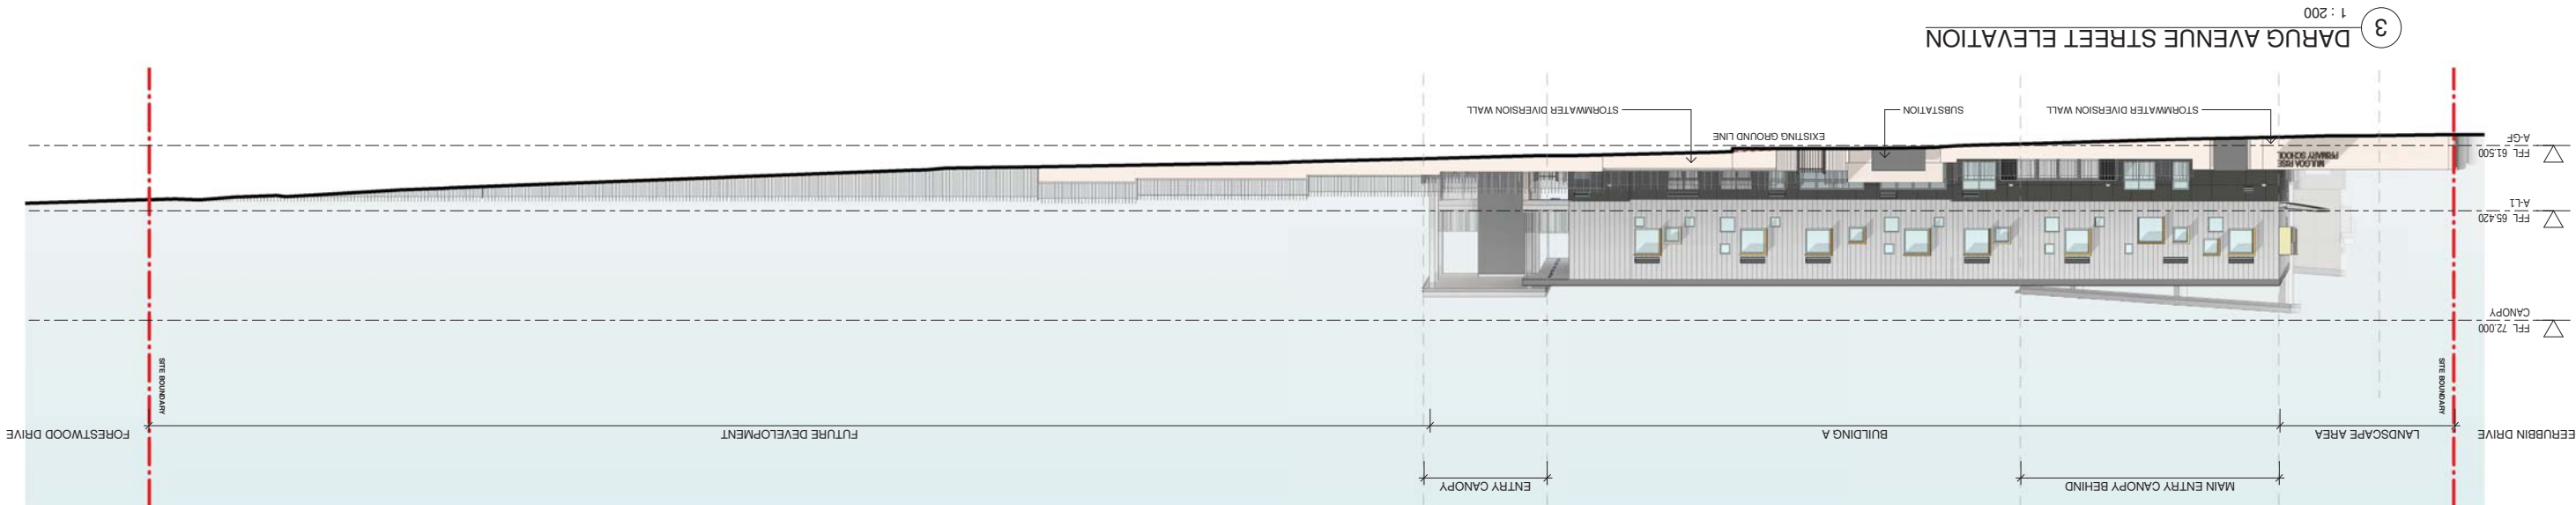

Issue	No.	Date	Description
01	12/04/2021	ISSUE FOR COORDINATION	
02	23/04/2021	ISSUE FOR COORDINATION	
03	04/05/2021	SSDA ISSUE	
04	06/08/2021	SSDA ISSUE	
05	11/08/2021	SSDA ISSUE	
06	11/11/2021	SSDA RIS	
07	12/11/2021	SSDA RIS	

CHS
JL
JL
CHS

RICHARD CROOKES
CONSTRUCTIONS

TRAFFIC ENGINEER
PTC
KASIA BALSAM
0425 285 778
rob.dwyer@rpsgroup.com.au

MULTI SERVICES
NDY
RYAN HAHN
0407 298 908
rahm@ndy.com

QUANTITY SURVEYOR
MBM
ALUMIN LU
02 9270 1062
alumin.lu@mbmpt.com.au

CIVIL AND STRUCTURAL ENGINEERING
WOOLACOTT'S
JUSTIN CHILLID
0424 189 883
anthony.maughan-wright@colliers.com


Project
NEW PRIMARY SCHOOL IN MULGOA
RISE
at
1-23 Forestwood Drive, Glenmore Park, NSW 2745, Australia

Architect
NBRSARCHITECTURE
61 2 9922 2344
Any form of replication of this drawing in full or in part without the written permission of NBRS+PARTNERS Pty Ltd constitutes an infringement of the copyright.
NBRS & Partners Pty Ltd VIC 51197
ABN 16 002 247 565
© 2021

Drawing Reference
20415-NBRS-DW-AR-SSDA-3011 07
Revision

Date 15/11/2021 7:14:41 PM
Scale 1:100 @ A1

4 A WEST ELEVATION
1 : 100

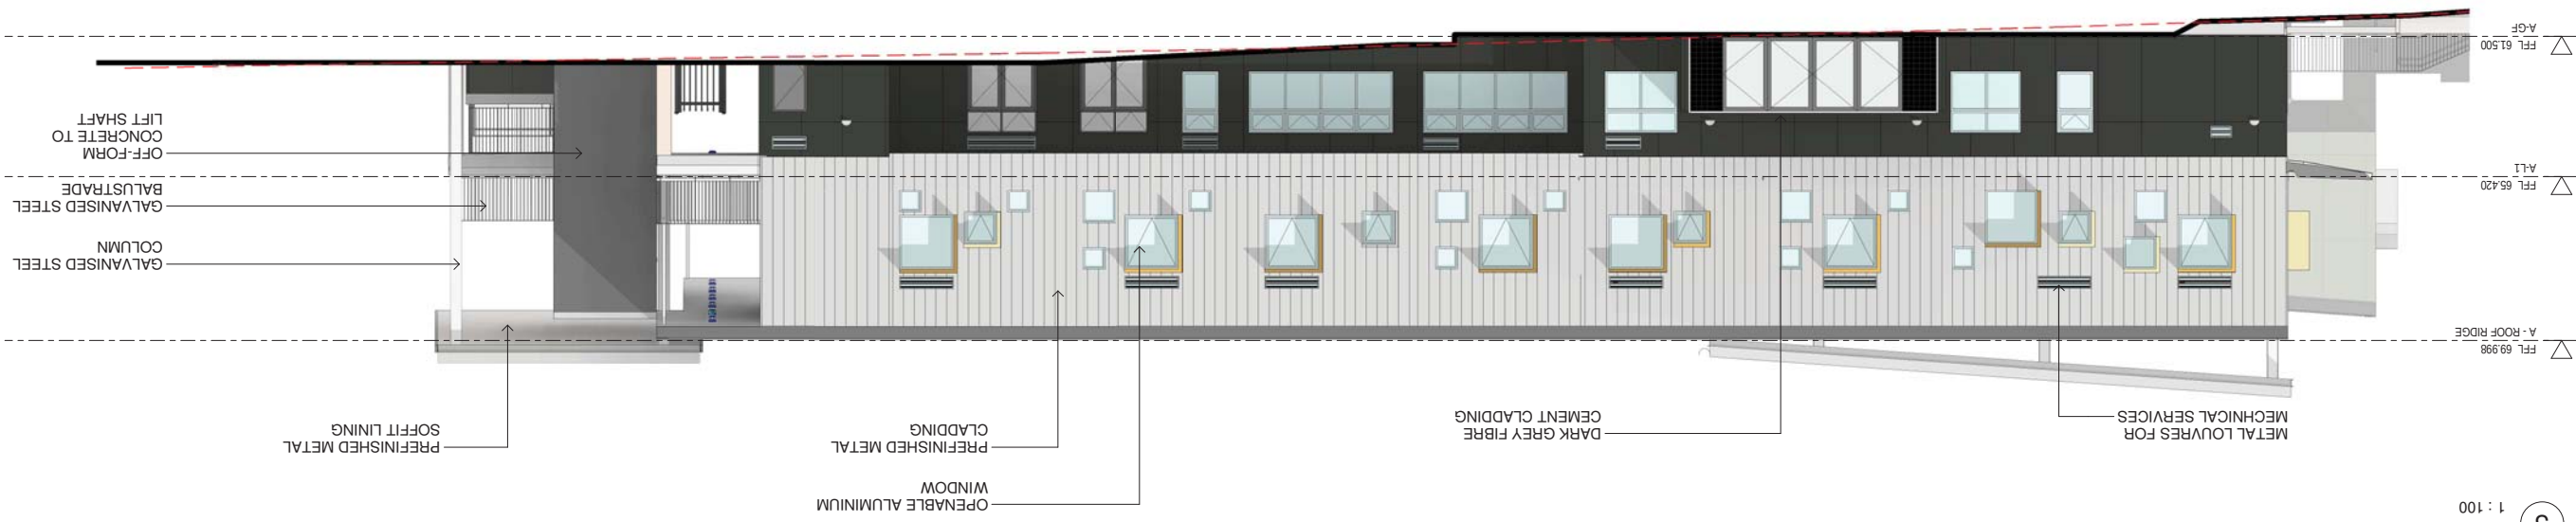


3 A EAST ELEVATION
1 : 100



2 A SOUTH ELEVATION
1 : 100



1 A NORTH ELEVATION
1 : 100

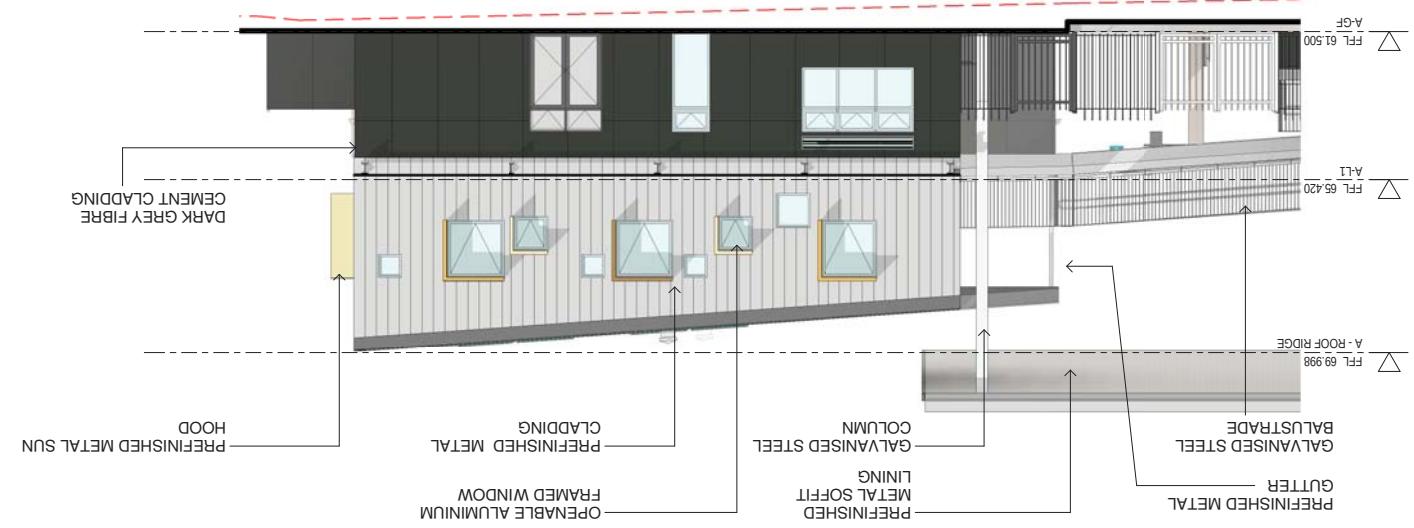

Issue	No.	Date	Description	Chkd
	01	12/04/2021	ISSUE FOR COORDINATION	
	02	23/04/2021	ISSUE FOR COORDINATION	
	03	04/05/2021	SSDA ISSUE	JL
	04	06/08/2021	SSDA ISSUE	JL
	05	11/08/2021	SSDA ISSUE	SHS
	06	11/11/2021	SSDA FIS	SHS
	07	12/11/2021	SSDA FIS	SHS

RICHARD CROOKES
CONSTRUCTIONS

TRAFFIC ENGINEER
PTC
KASIA BALSAM
02 8920 0800
kasia.balsam@ptccconsultants.co

**NDY
MULTI SERVICES**
RYAN HAHN
0407 236 908
r.hahn@ndy.com

QUANTITY SURVEYOR
MBM
AUTUMN LU
02 9270 1062
autumn.lu@mbmpl.com.au

PROJECT MANAGER
COLLIERS
ANTHONY MAUGHAN-WRIGHT
0424 189 883

Drawing Title
BUILDING B3 - ELEVATIONS

Project
NEW
RISE
at
1-23 Fore
for
SINSM

NEW PRIMARY SCHOOL IN MULGOA


NBRS ARCHITECTURE.
Sydney
61 2 9922 2344
Any form of reproduction or use without the written permission of NBRS+PARTNERS Pty Ltd constitutes an infringement of the copyright.
Nominated Architect:

Drawing Reference
20415-NBRS-D1

Date 15/11/2021 7:15:08 PM
Scale 1:100 @ A1

20415-NBRS-DW-AR-SSDA-3012 07


3
B3 NORTH ELEVATION
1 : 100

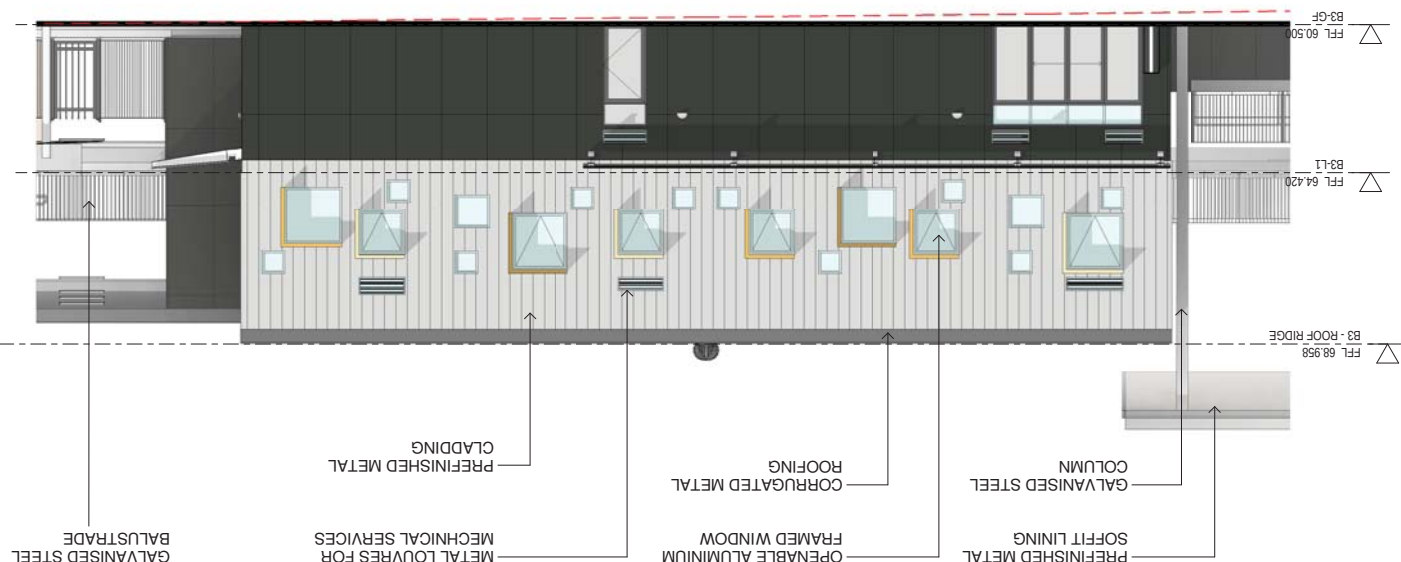


4
B3 SOUTH ELEVATION
1 : 100



1
B3 WEST ELEVATION
1 : 100

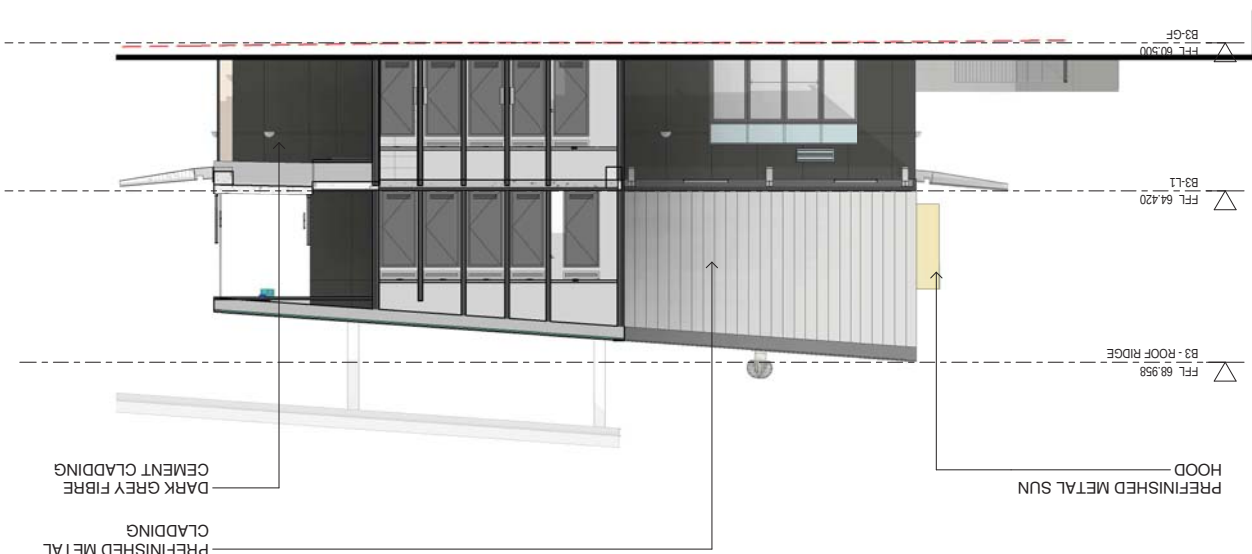

2 B3 EAST ELEVATION 1 : 100

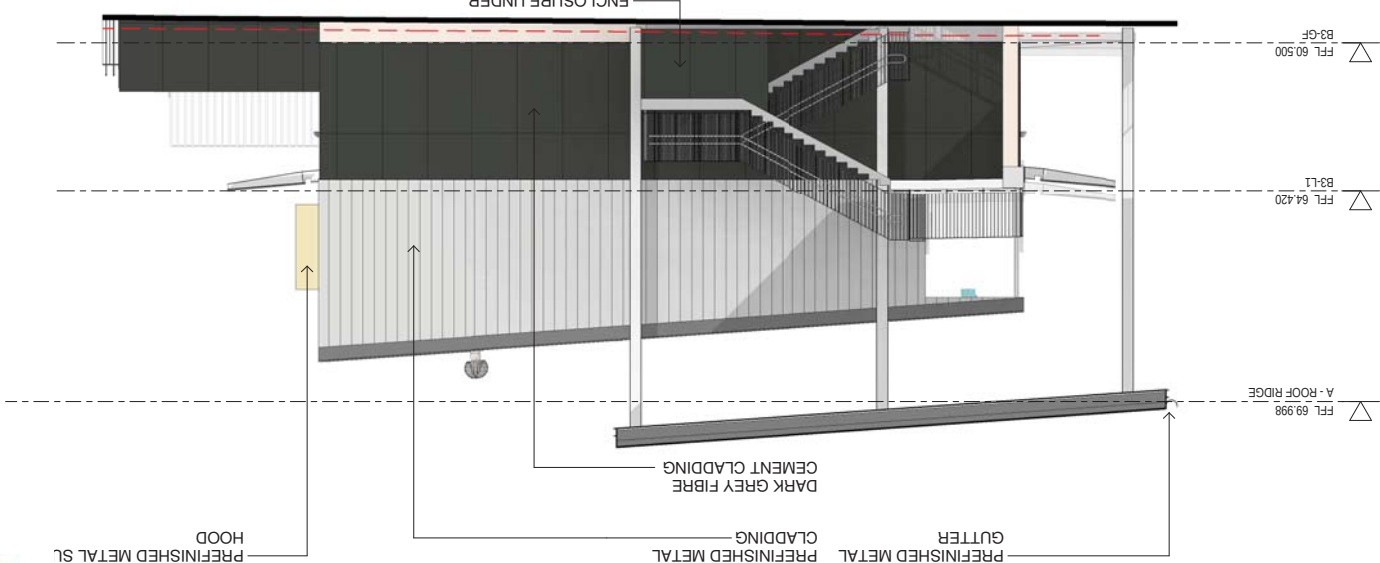

Issue	No.	Date	Description
01	12/04/2021	ISSUE FOR COORDINATION	
02	23/04/2021	ISSUE FOR COORDINATION	
03	04/05/2021	SSDA ISSUE	
04	06/08/2021	SSDA ISSUE	
05	11/10/2021	SSDA ISSUE	
06	11/11/2021	SSDA RIS	
07	12/11/2021	SSDA RIS	

RICHARD CROOKES
CONSTRUCTIONS

TRAFFIC ENGINEER
PTC
KASIA BALSAM
02 9920 0800
kasia.balsam@ptcconsultants.co.uk
rob.dwyer@ptcgroup.com.au

MULTI SERVICES
NDY
RYAN HAHN
0407 296 908
r.hahn@ndy.com
johillio@woolacotts.com.au

QUANTITY SURVEYOR
MBM
AUTUMN LU
02 9270 1062
autumn.lu@mbmpl.com.au


CIVIL AND STRUCTURAL ENGINEERING
WOOLACOTTS
JUSTIN CHILLID
02 8203 1504
0424 189 888
anthony.moughan-wright@colliers.com

Project
NEW PRIMARY SCHOOL IN MULGOA
RISE
at
1-23 Forestwood Drive, Glenmore Park, NSW 2745, Australia

Architect
NBRS ARCHITECTURE
Sydney
61 2 9922 2344
nbarsarchitecture.com
permission of NBRS+PARTNERS Pty Ltd constitutes an infringement of the copyright.

Drawing Reference
20415-NBRS-DW-AR-SSDA-3013 07
Revision


4 B2 NORTH ELEVATION
1 : 100

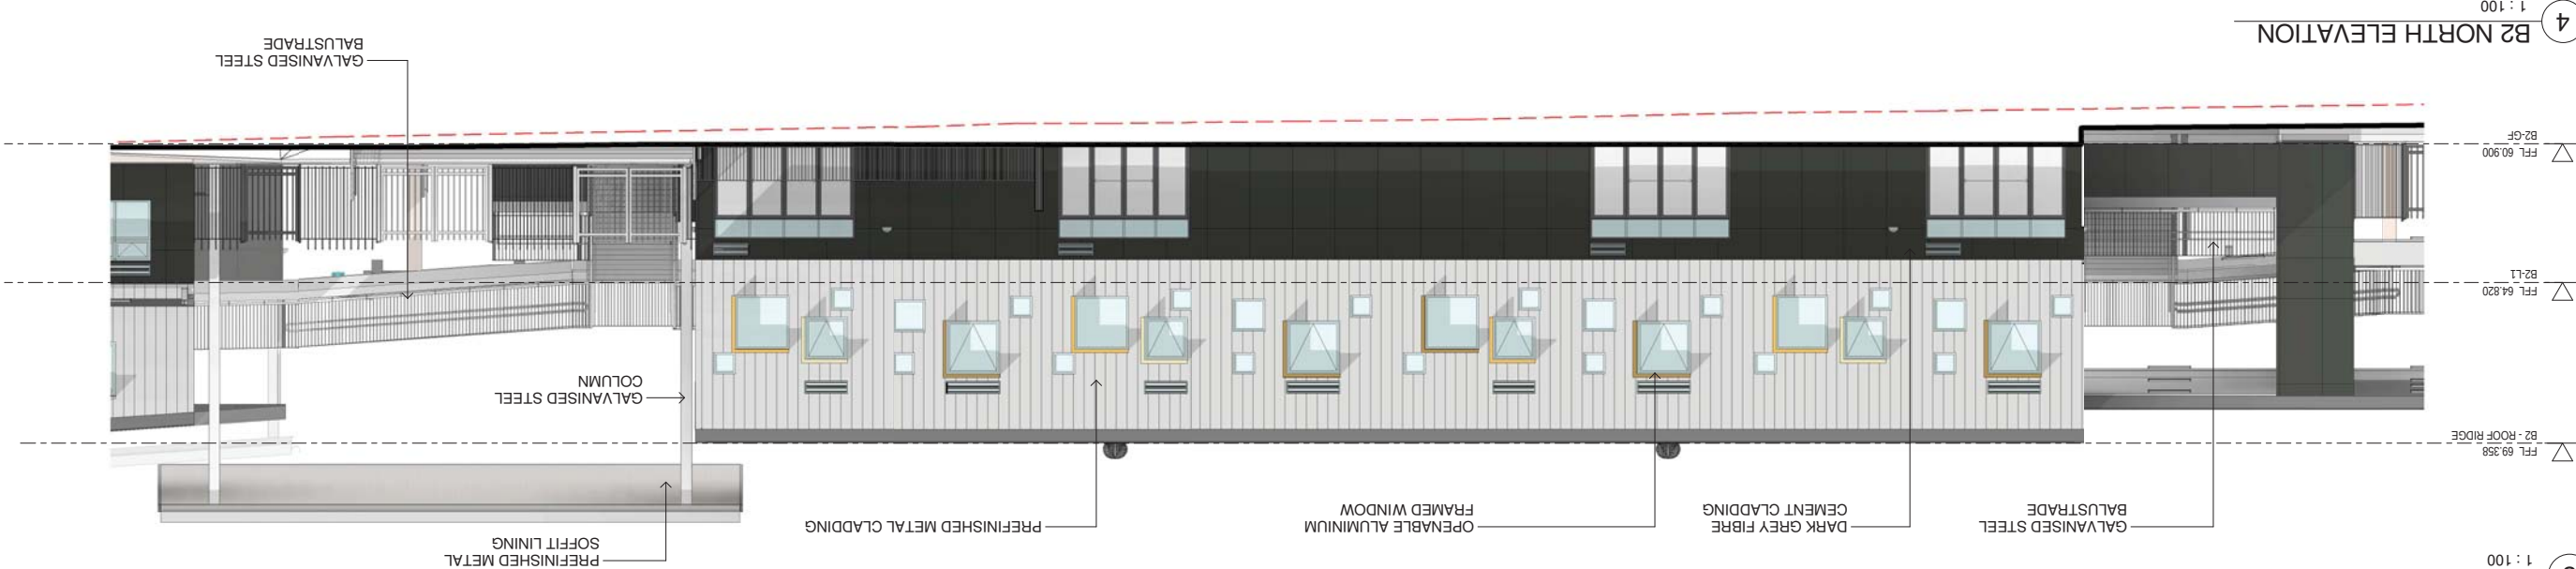


3 B2 SOUTH ELEVATION
1 : 100



2 B2 EAST ELEVATION
1 : 100

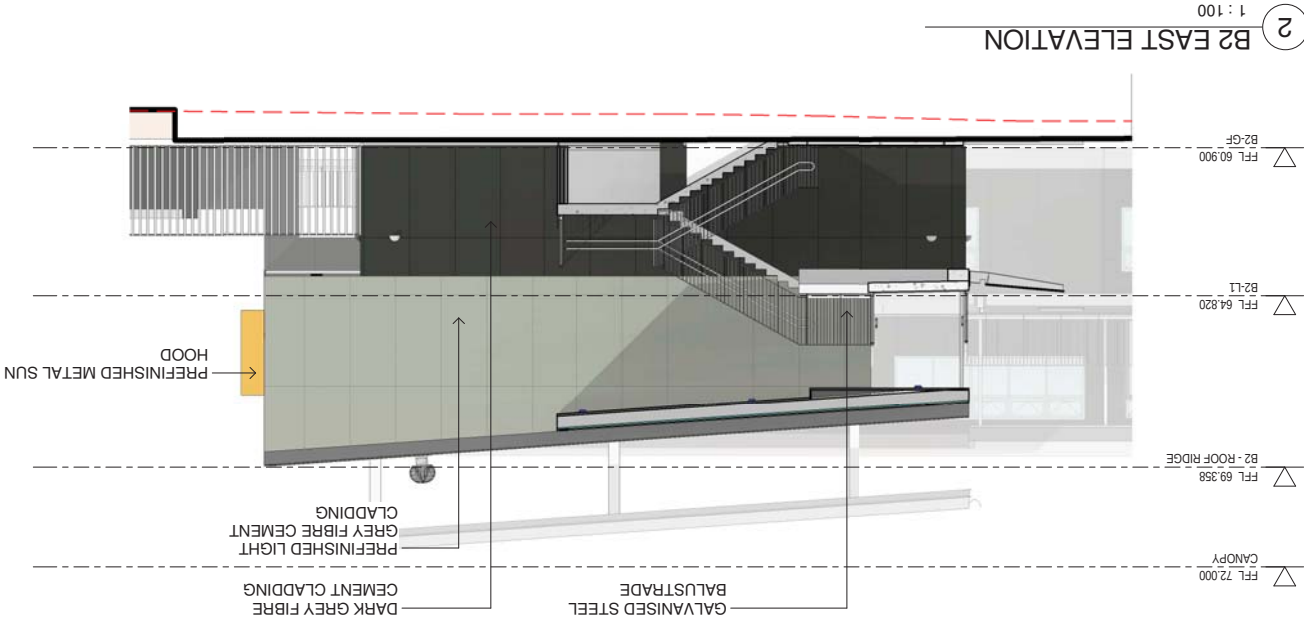

1 B2 WEST ELEVATION
1 : 100

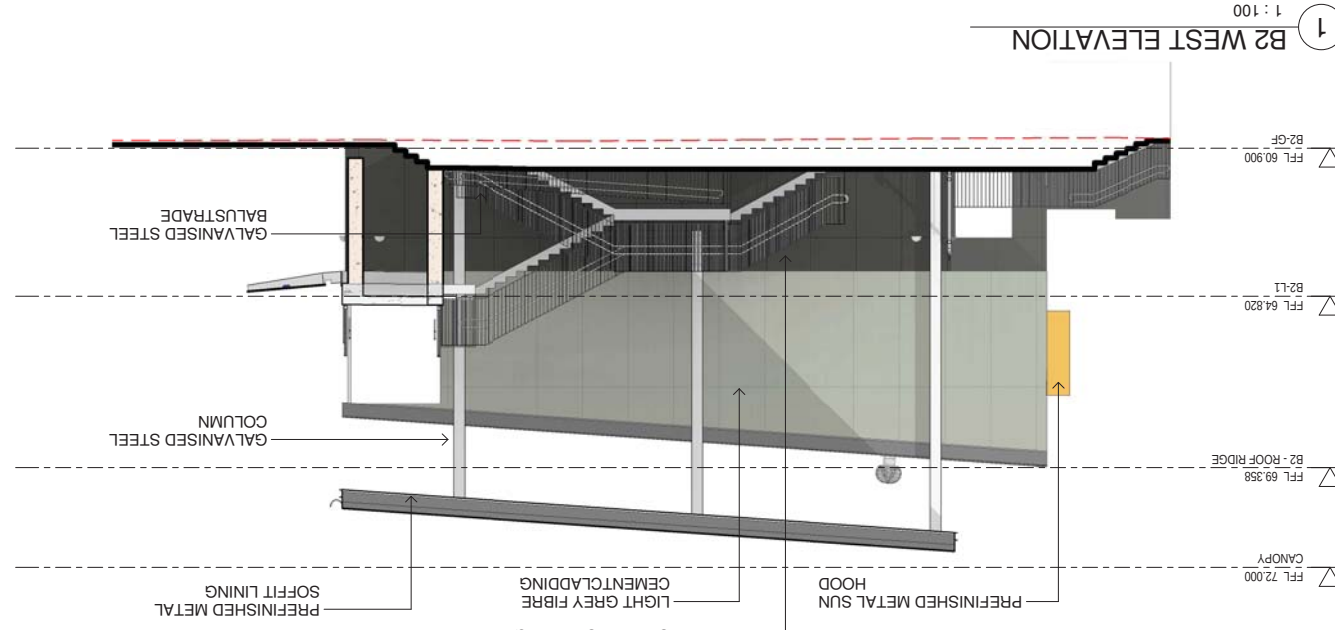

No.	Date	Description
01	12/04/2021	ISSUE FOR COORDINATION
02	23/04/2021	ISSUE FOR COORDINATION
03	04/05/2021	SSDA ISSUE
04	06/08/2021	SSDA ISSUE
05	11/08/2021	SSDA ISSUE
06	11/11/2021	SSDA RIS
07	12/11/2021	SSDA RIS

RICHARD CROOKES
CONSTRUCTIONS

TRAFFIC ENGINEER
PTC
KASIA BALSAM
02 8920 0800
kasia.balsam@ptcconsultants.co
RPS
ROB DWYER
0425 285 778
rob.dwyer@rpsgroup.com.au

MULTI SERVICES
NDY
RYAN HAHN
0407 296 908
r.hahn@ndy.com
CIVIL AND STRUCTURAL ENGINEERING
WOOLACOTTS
JUSTIN CHILLID
02 8203 1504
jchillid@woolacotts.com.au

QUANTITY SURVEYOR
MBM
ALUMIN LU
02 9270 1062
alumin.lu@mbmpl.com.au
COLLIERS
ANTHONY MAUGHAN-WRIGHT
0424 189 883
anthony.maughan-wright@colliers.com

Drawing Title
BUILDING C - ELEVATIONS


Project
NEW PRIMARY SCHOOL IN MULGOA RISE
at
1-23 Forestwood Drive, Glenmore Park, NSW 2745, Australia
for
SINSW

Architect
NBRS ARCHITECTURE.
Sydney
61 2 9922 2344
Any form of replication of this drawing in full or in part without the written permission of NBRS+PARTNERS Pty Ltd constitutes an infringement of the copyright.
NBRS & Partners Pty Ltd VIC 51197
ABN 16 002 247 565
© 2021


Drawing Reference
20415-NBRS-DW-AR-SSDA-3014 07

Date 15/11/2021 7:16:11 PM
Scale 1:100 @ A1


④ C SOUTH ELEVATION
1 : 100

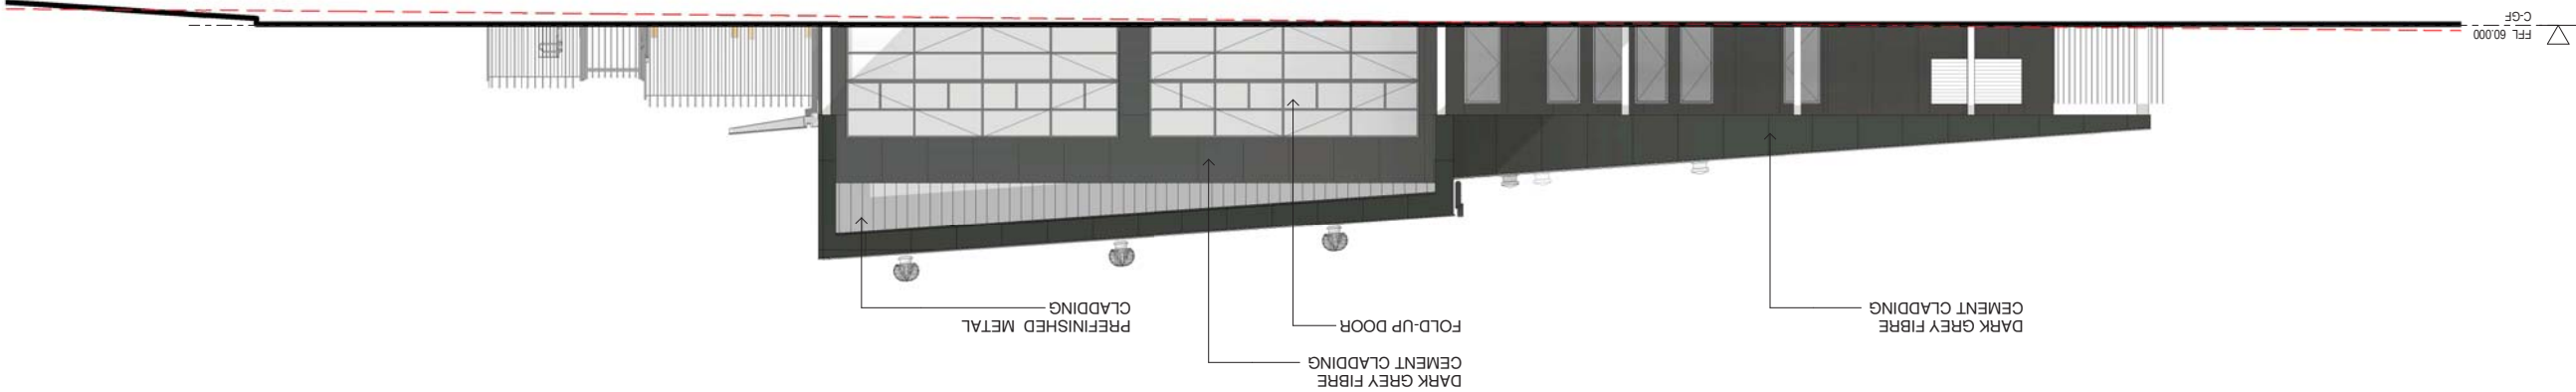

③ C NORTH ELEVATION
1 : 100

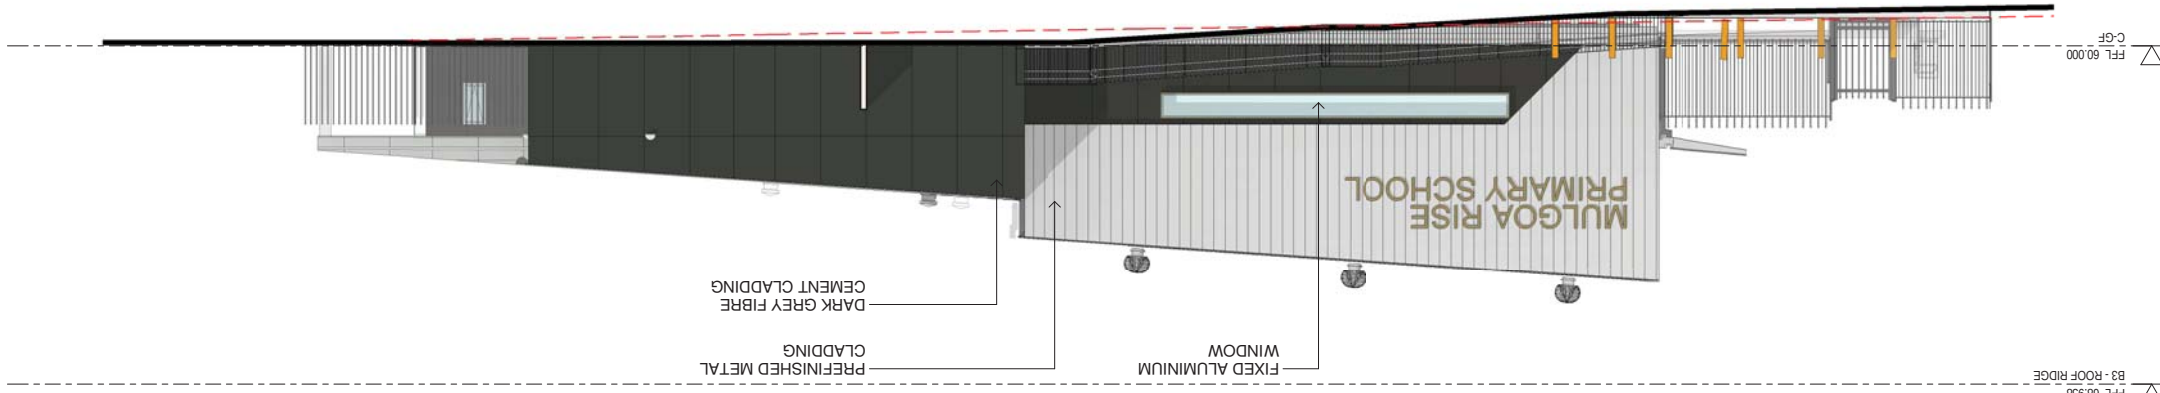

② C WEST ELEVATION
1 : 100

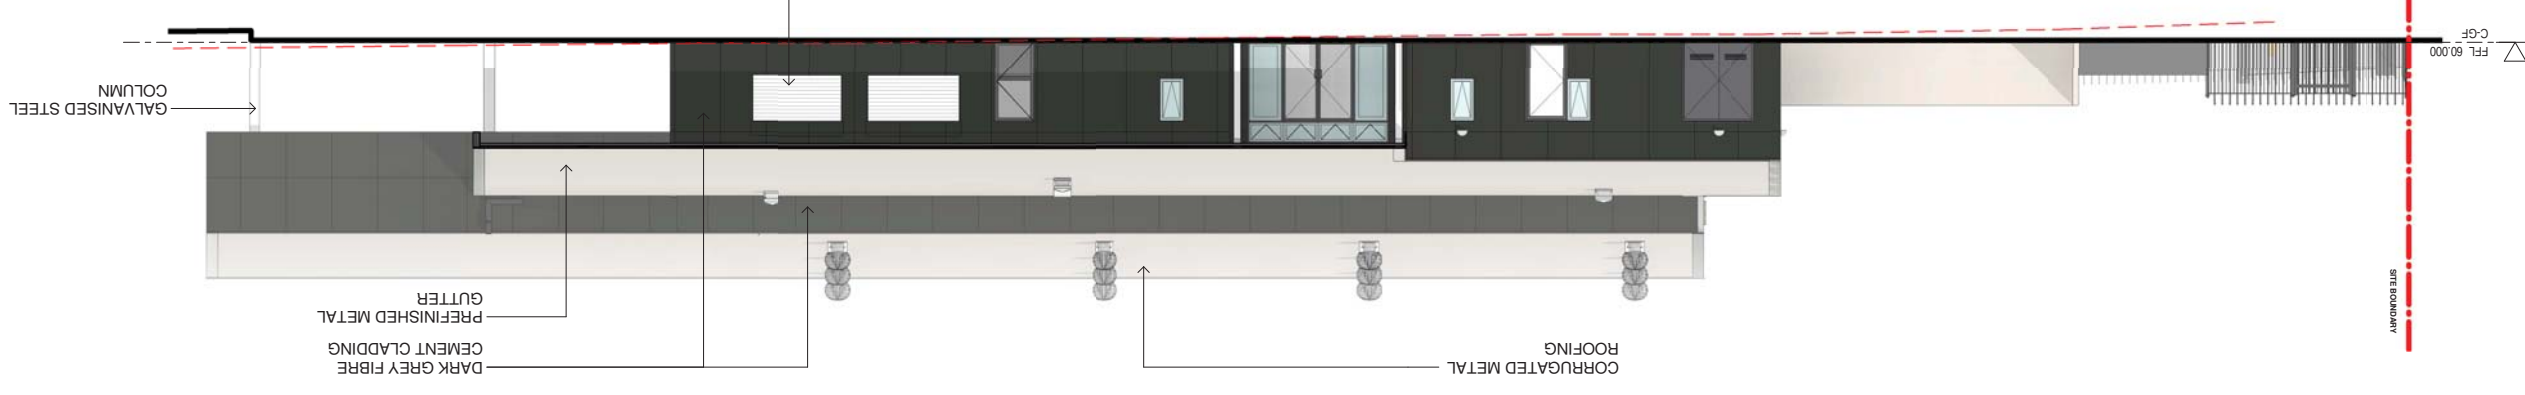

① C EAST ELEVATION
1 : 100



No.	Date	Description
01	12/04/2021	ISSUE FOR COORDINATION
02	23/04/2021	ISSUE FOR COORDINATION
03	04/05/2021	SSDA ISSUE
04	06/09/2021	SSDA ISSUE
05	11/11/2021	SSDA RIS
CHS		



TRAFFIC ENGINEER
PTC
KASIA BALSAM
02 9920 0800
kasia.balsam@pccconsultants.co

TOWN PLANNER
RPS
ROB DWYER
0425 285 778
rob.dwyer@rpsgroup.com.au

MULTI SERVICES
NDY
RYAN HAHN
0407 236 908
r.hahn@ndy.com

CIVIL AND STRUCTURAL ENGINEERING
WOOLACOTTS
JUSTIN CHILLID
02 8203 1504
jchillid@woolacotts.com.au

QUANTITY SURVEYOR
MBM
AUTUMN LU
02 9270 1062
autumn.lu@mbmpl.com.au

COLLIERS PROJECT MANAGER
ANTHONY MULLIGHAN-WRIGHT
0424 189 888
anthony.mullighan-wright@colliers.com

Drawing Title
BUILDING A - SECTIONS

Project
NEW PRIMARY SCHOOL IN MULGOA RISE
at
1-23 Forestwood Drive, Glenmore Park, NSW 2745, Australia



Architect
NBRS ARCHITECTURE.
Sydney
61 2 9922 2344
Any form of replication of this drawing in full or in part without the written permission of NBRS+PARTNERS Pty Ltd constitutes an infringement of the copyright.

Architect
NBRS ARCHITECTURE.
Sydney
61 2 9922 2344
Any form of replication of this drawing in full or in part without the written permission of NBRS+PARTNERS Pty Ltd constitutes an infringement of the copyright.

ABN 16 002 247 565
© 2021

Drawing Reference
20415-NBRS-DW-AR-SSDA-4001 05

Date 11/11/2021 8:11:08 PM
Scale 1:100 @ A1
Revision

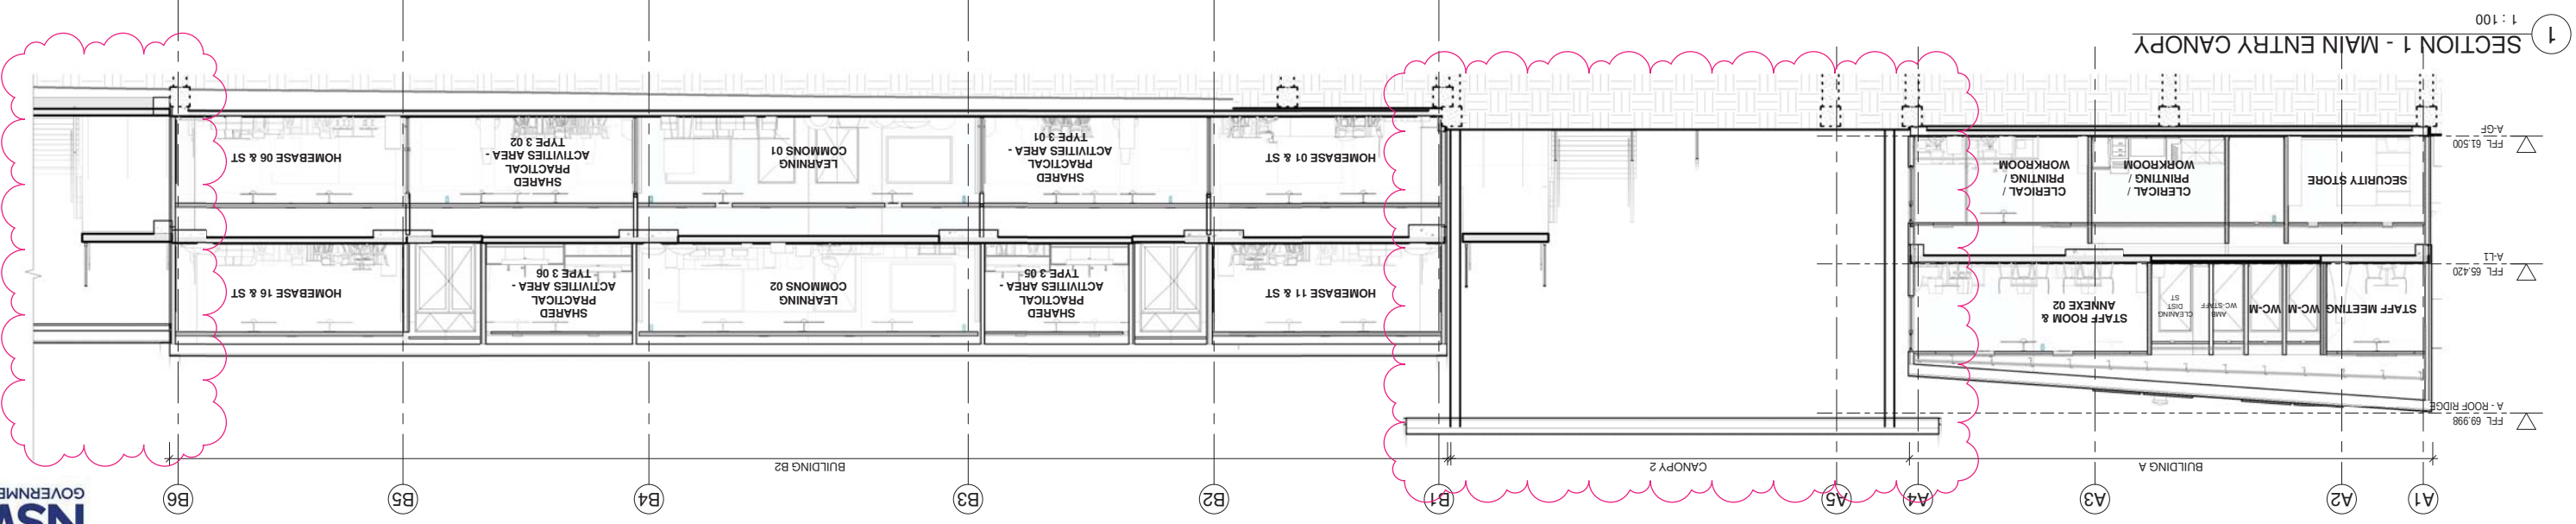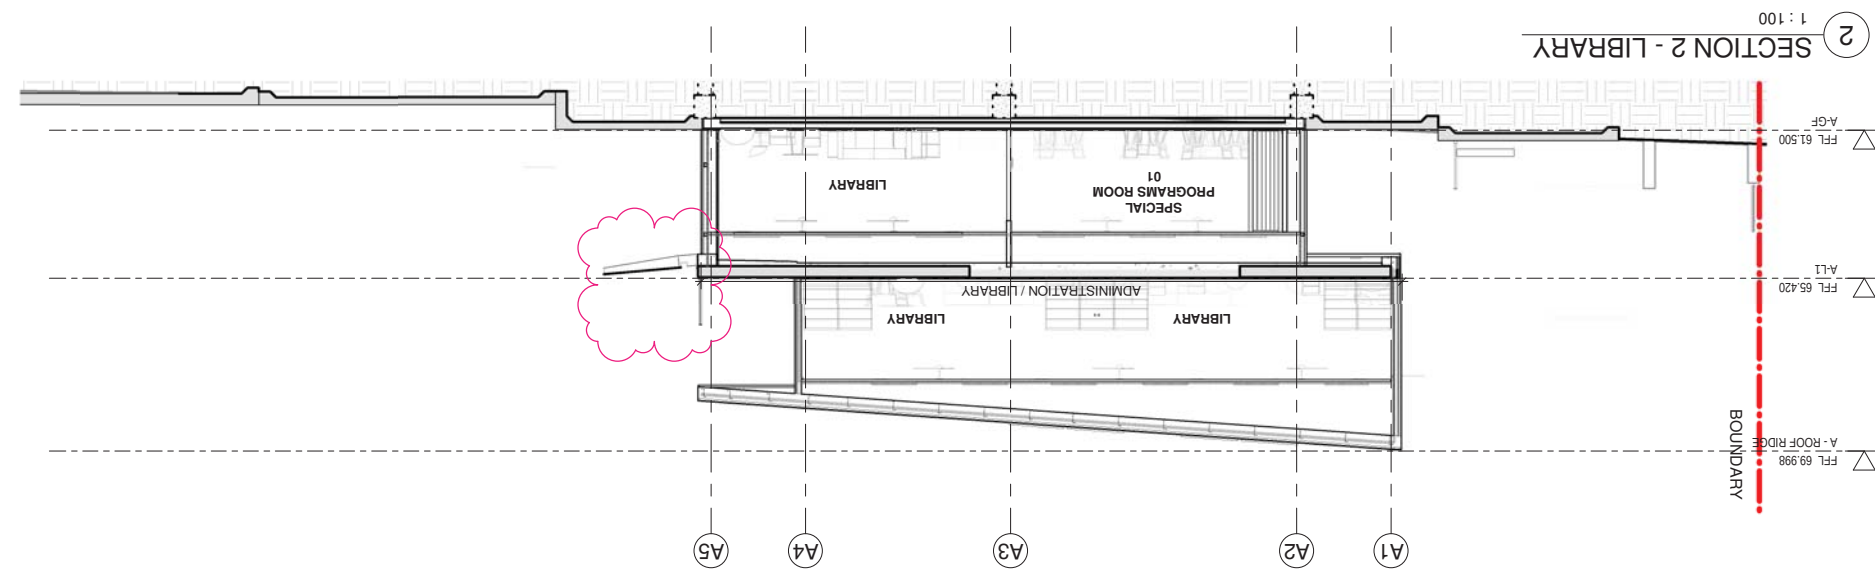

RICHARD CROOKES
CONSTRUCTIONS

TRAFFIC ENGINEER
PTC
KASIA BALSAM
02 8920 0800
kasia.balsam@pticonsultants.co

MULTI SERVICES
NDY
RYAN HAHN
0407 236 908
r.hahn@ndy.com

QUANTITY SURVEYOR
MBM
AUTUMN LU
02 9270 1062
autumn.lu@mbmpl.com.au

Project
NEW
RISE
at
1-23 Fore
for
MSNSW

Project
NEW PRIMARY SCHOOL IN MULGOA
RISE
at
1-23 Forestwood Drive, Glenmore Park, NSW 2745, Australia

NBSARCHITECTURE.
Architect
612 9922 2344
Sydney
Form of replication of this drawing in full or in part without the written permission of NBS:PARTNERS Pty Ltd constitutes an infringement of the copyright.
Nominated Architect:
Andrew Durbin MSW 5602
NBS & Partners Pty Ltd VIC 51197
ABN 16 002 247 561
© 2021

Drawing Reference

Date 11/11/2021 7:16:30 PM
Scale As indicated @ A1

Drawing Reference
Revision
20415-NBRS-DW-AR-SSDA-4002 05

Architectural section drawing of the building. The drawing shows a cross-section of the structure, including the roof, walls, and floor. Key areas are labeled: 'COMMUNAL HALL' (appearing twice, once on each side of the central section) and 'COVERED WALKWAY' (appearing twice, once on each side of the central section). The drawing also includes structural elements like columns and beams. Grid lines are marked at the bottom with circles containing the letters C1, C2, C3, C4, and C5. The drawing is oriented horizontally, with the building's length running from left to right.

4 CANOPY - TYPICAL SECTION DETAIL



Issue	No.	Date	Description
01	12/04/2021	ISSUE FOR COORDINATION	
02	23/04/2021	ISSUE FOR COORDINATION	
03	04/05/2021	SSDA ISSUE	
04	06/09/2021	SSDA ISSUE	
05	11/11/2021	SSDA RIS	
CHS	JL		

RICHARD CROOKES
CONSTRUCTIONS

TRAFFIC ENGINEER
PTC
KASIA BALSAM
02 8920 0800
kasia.balsam@ptcconsultants.co

MULTI SERVICES
NDY
RYAN HAHN
0407 236 908
r.hahn@ndy.com

QUANTITY SURVEYOR
MBM
ARJUN LU
02 9270 1062
arjun.lu@mbmcl.com.au

CIVIL AND STRUCTURAL ENGINEERING
WOOLACOTTS
JUSTIN CHILLID
02 8203 1504
jchillid@woolacotts.com.au

BUILDING - DETAIL SECTIONS

Project
NEW PRIMARY SCHOOL IN MULGOA
Rise
at
1-23 Forestwood Drive, Glenmore Park, NSW 2745, Australia


Architect
NBRS ARCHITECTURE
61 2 9922 2344
Any form of replication of this drawing in full or in part without the written permission of NBRS+PARTNERS Pty Ltd constitutes an infringement of the copyright.
Notwithstanding:
Andrew Duffin NSW 5602
NBRS & Partners Pty Ltd VIC 51197

Drawing Reference
20415-NBRS-DW-AR-SSDA-4003 05
Revision


Date 11/11/2021 7:16:46 PM
Scale 1:20 @ A1



DETAIL WALL SECTION - COVERED WALKWAYS

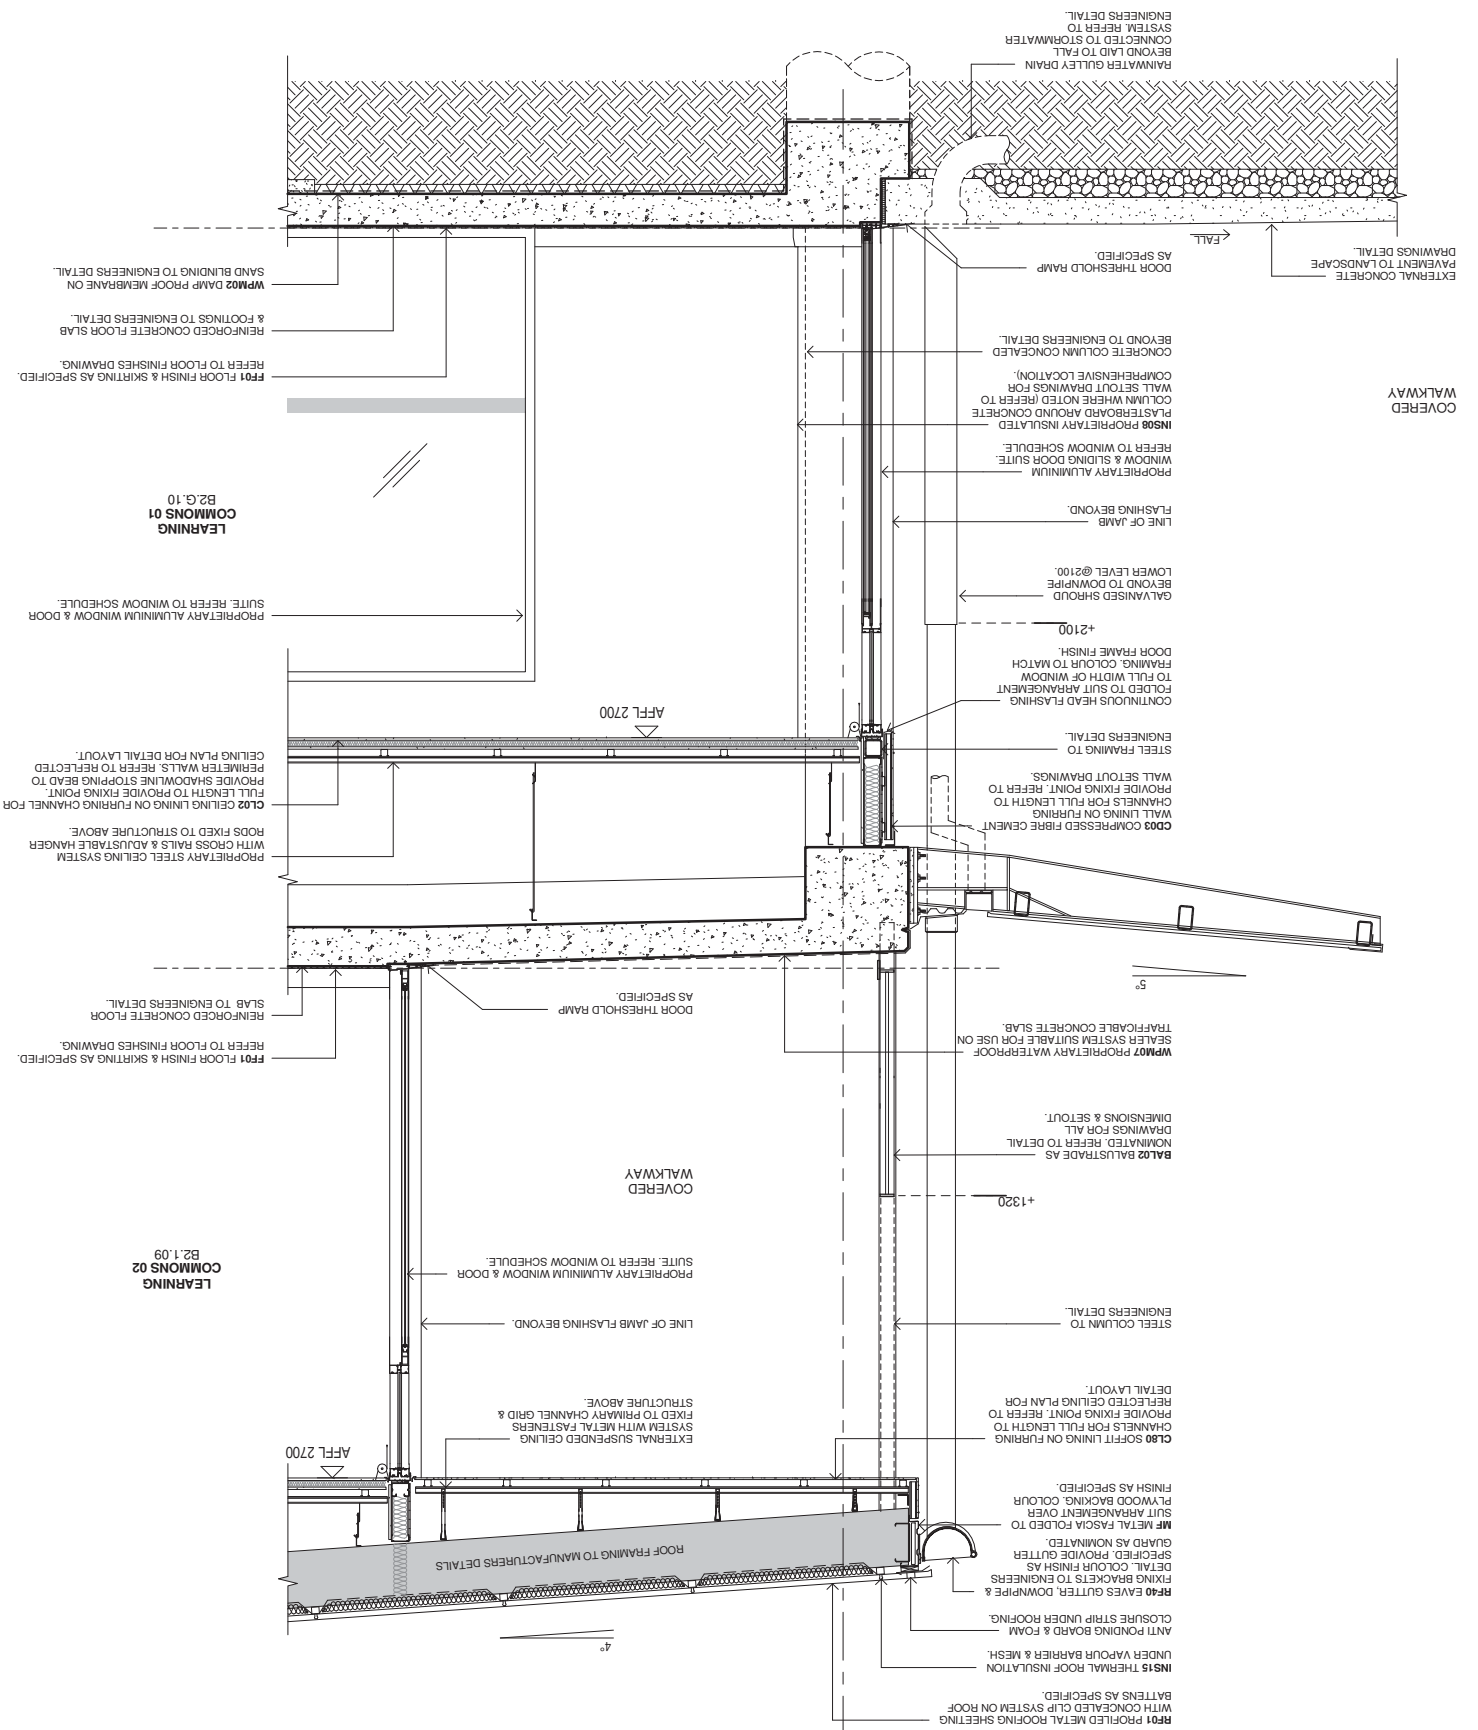

DETAIL WALL SECTION - BUILDING B2

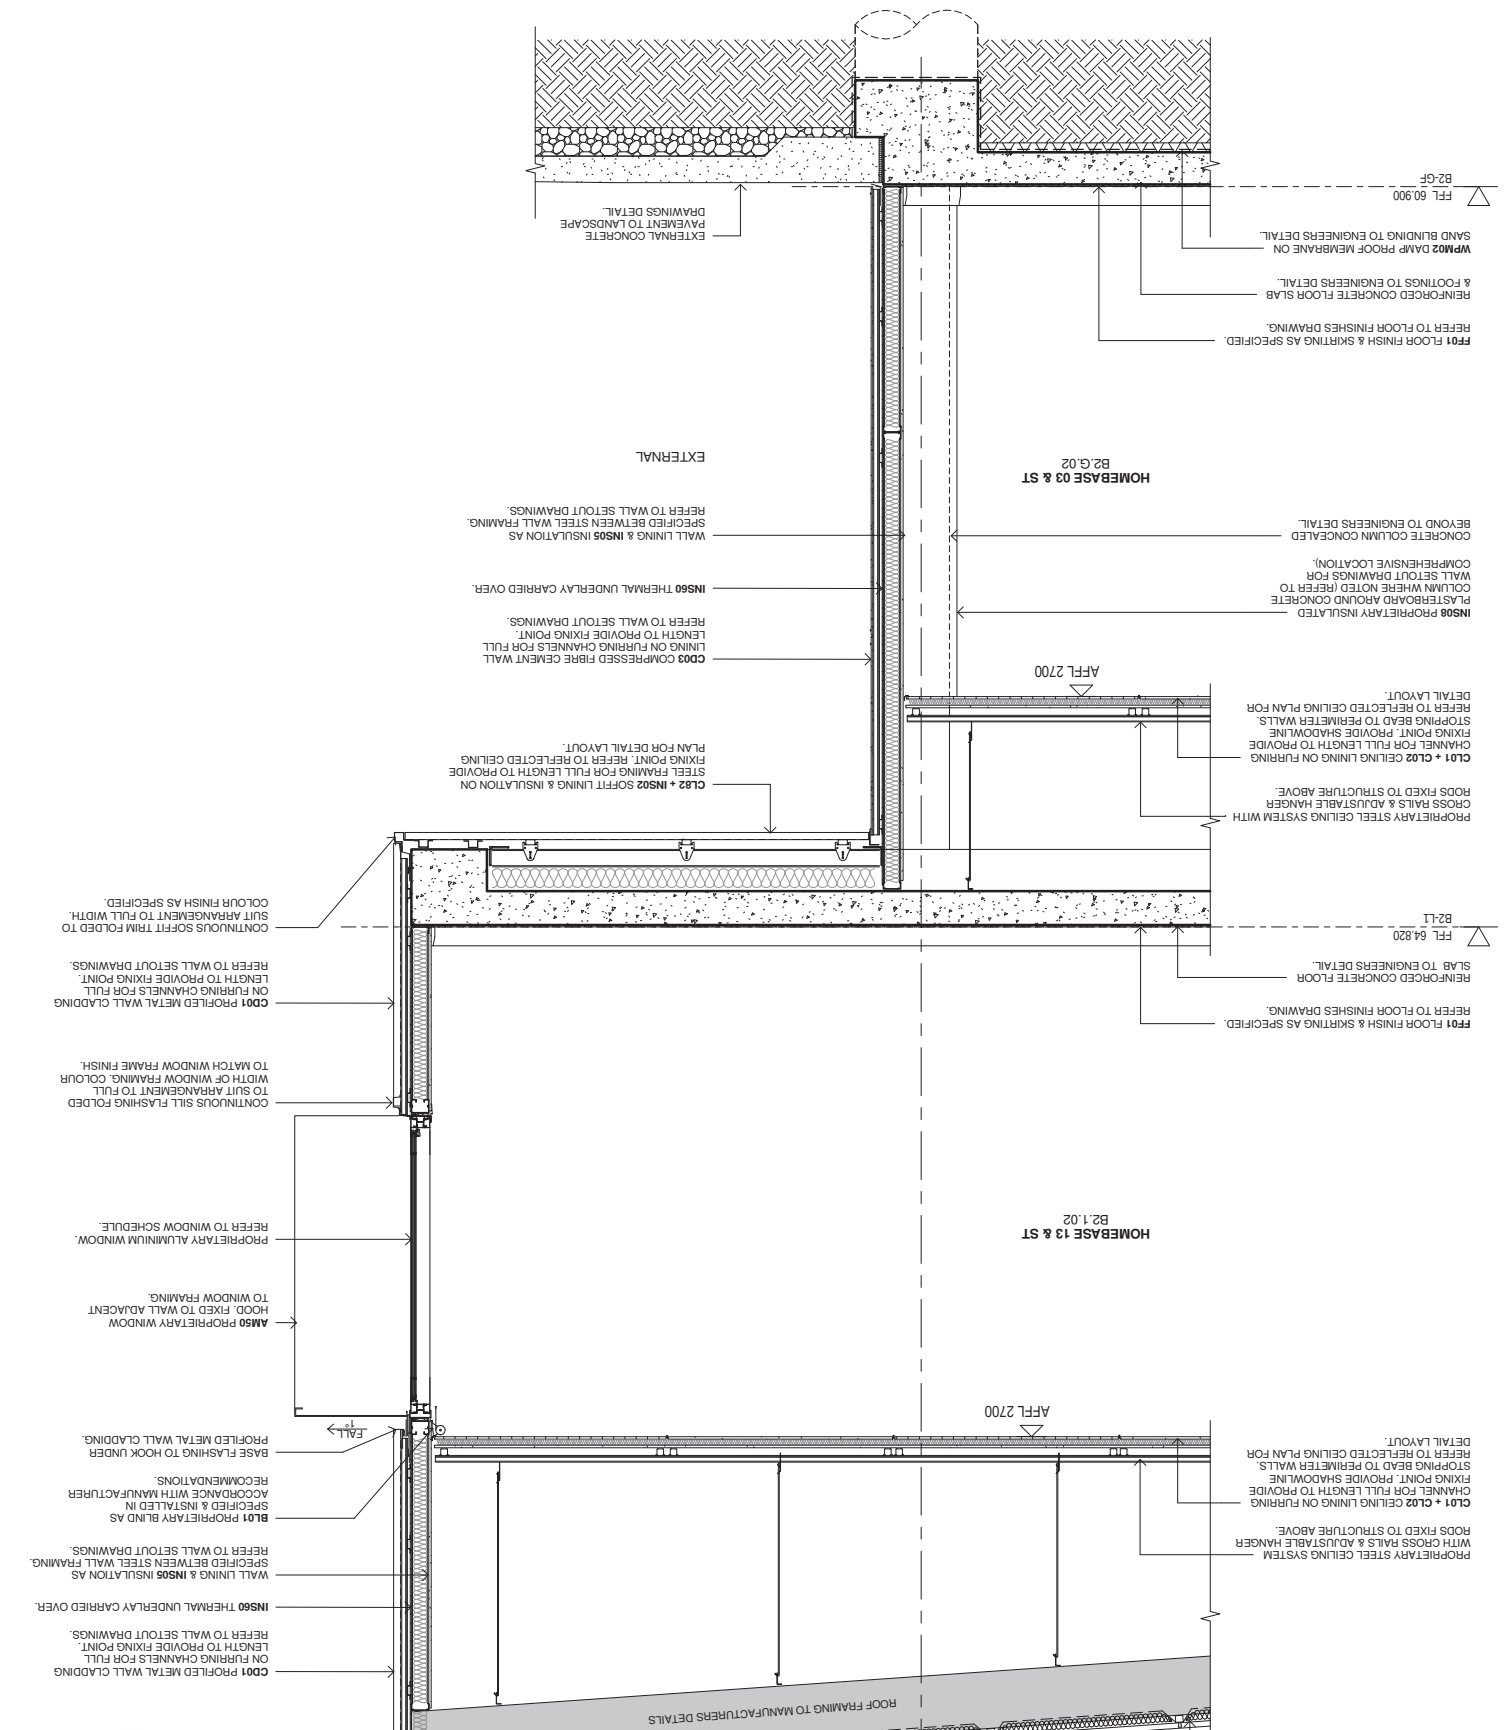



AERIAL PERSPECTIVE - CORNER OF DEERUBBIN DRIVE & DARUG AVE (NTS)

Issue	No.	Date	Description	Chkd
01	04/05/2021	SSDA ISSUE		
02	06/08/2021	SSDA ISSUE		JL
03	11/11/2021	SSDA RIS		CHS

RICHARD CROOKES
CONSTRUCTIONS

SSDA Rts

TRAFFIC ENGINEER
PTC
KASIA BALSAM
02 8920 0800
kasia.balsam@ptcconsultants.co

**MULTI SERVICES
NDY
RYAN HAHN
0407 236 908
r.hahn@ndy.com**

QUANTITY SURVEYOR
MBM
AUTUMN LU
02 9270 1062
autumn.lu@mbmpl.com.au

Drawing Title
3D IMAGE 1

Project
NEW
RISE
at
1-23 Fore
for
MSNW

Project
NEW PRIMARY SCHOOL IN MULGO
RISE
at
1-23 Forestwood Drive, Glenmore Park, NSW 2745, Australia

Architect
NBSARCHITECTURE.
Sydney
61 2 9922 2244
permission of NBS-PARTNERS Pty Ltd constitutes an infringement of the
copyright
NBS & Colin NSW 5502
P/L JV VIC 51197
© 2021

Drawing Reference

Date	11/11/2021 7:16:57
Scale	NOT TO SCALE

Revision 03



PERSPECTIVE - CORNER OF BUILDING A, ADMINISTRATION & LIBRARY

No.	Date	Description
01	04/05/2021	SSDA ISSUE
02	06/08/2021	SSDA RPS
03	11/11/2021	SSDA RPS

RICHARD CROOKES
CONSTRUCTIONS

TRAFFIC ENGINEER
PTC
KASIA BALSAM
02 9920 0800
kasia.balsam@ptcconsultants.co

MULTI SERVICES
NDY
RYAN HAHN
0407 236 908
r.hahn@ndy.com

QUANTITY SURVEYOR
MBM
ALUMIN LU
02 9270 1062
alumin.lu@mbm.com.au

COLLIERS
PROJECT MANAGER
ANTHONY MULLIGHAN-WRIGHT
0424 189 883
anthony.mullighan-wright@colliers.com

CIVIL AND STRUCTURAL ENGINEERING
WOOLACOTTS
JUSTIN CHILLID
02 8203 1504
johnlillio@woolacotts.com.au

for
SINSW

at

Project

NEW PRIMARY SCHOOL IN MULGOA

RISE


Architect

NBR**ARCHITECTURE.**
Sydney
61 2 9922 2344
Any form of replication of this drawing in full or in part without the written permission of NBR+PARTNERS Pty Ltd constitutes an infringement of the copyright.
NBR+PARTNERS Pty Ltd
ABN 16 002 247 565
© 2021

Drawing Reference

20415-NBRS-DW-AR-SSDA-7002 03

Date 11/11/2021 7:17:09 PM
Scale NOT TO SCALE
Revision

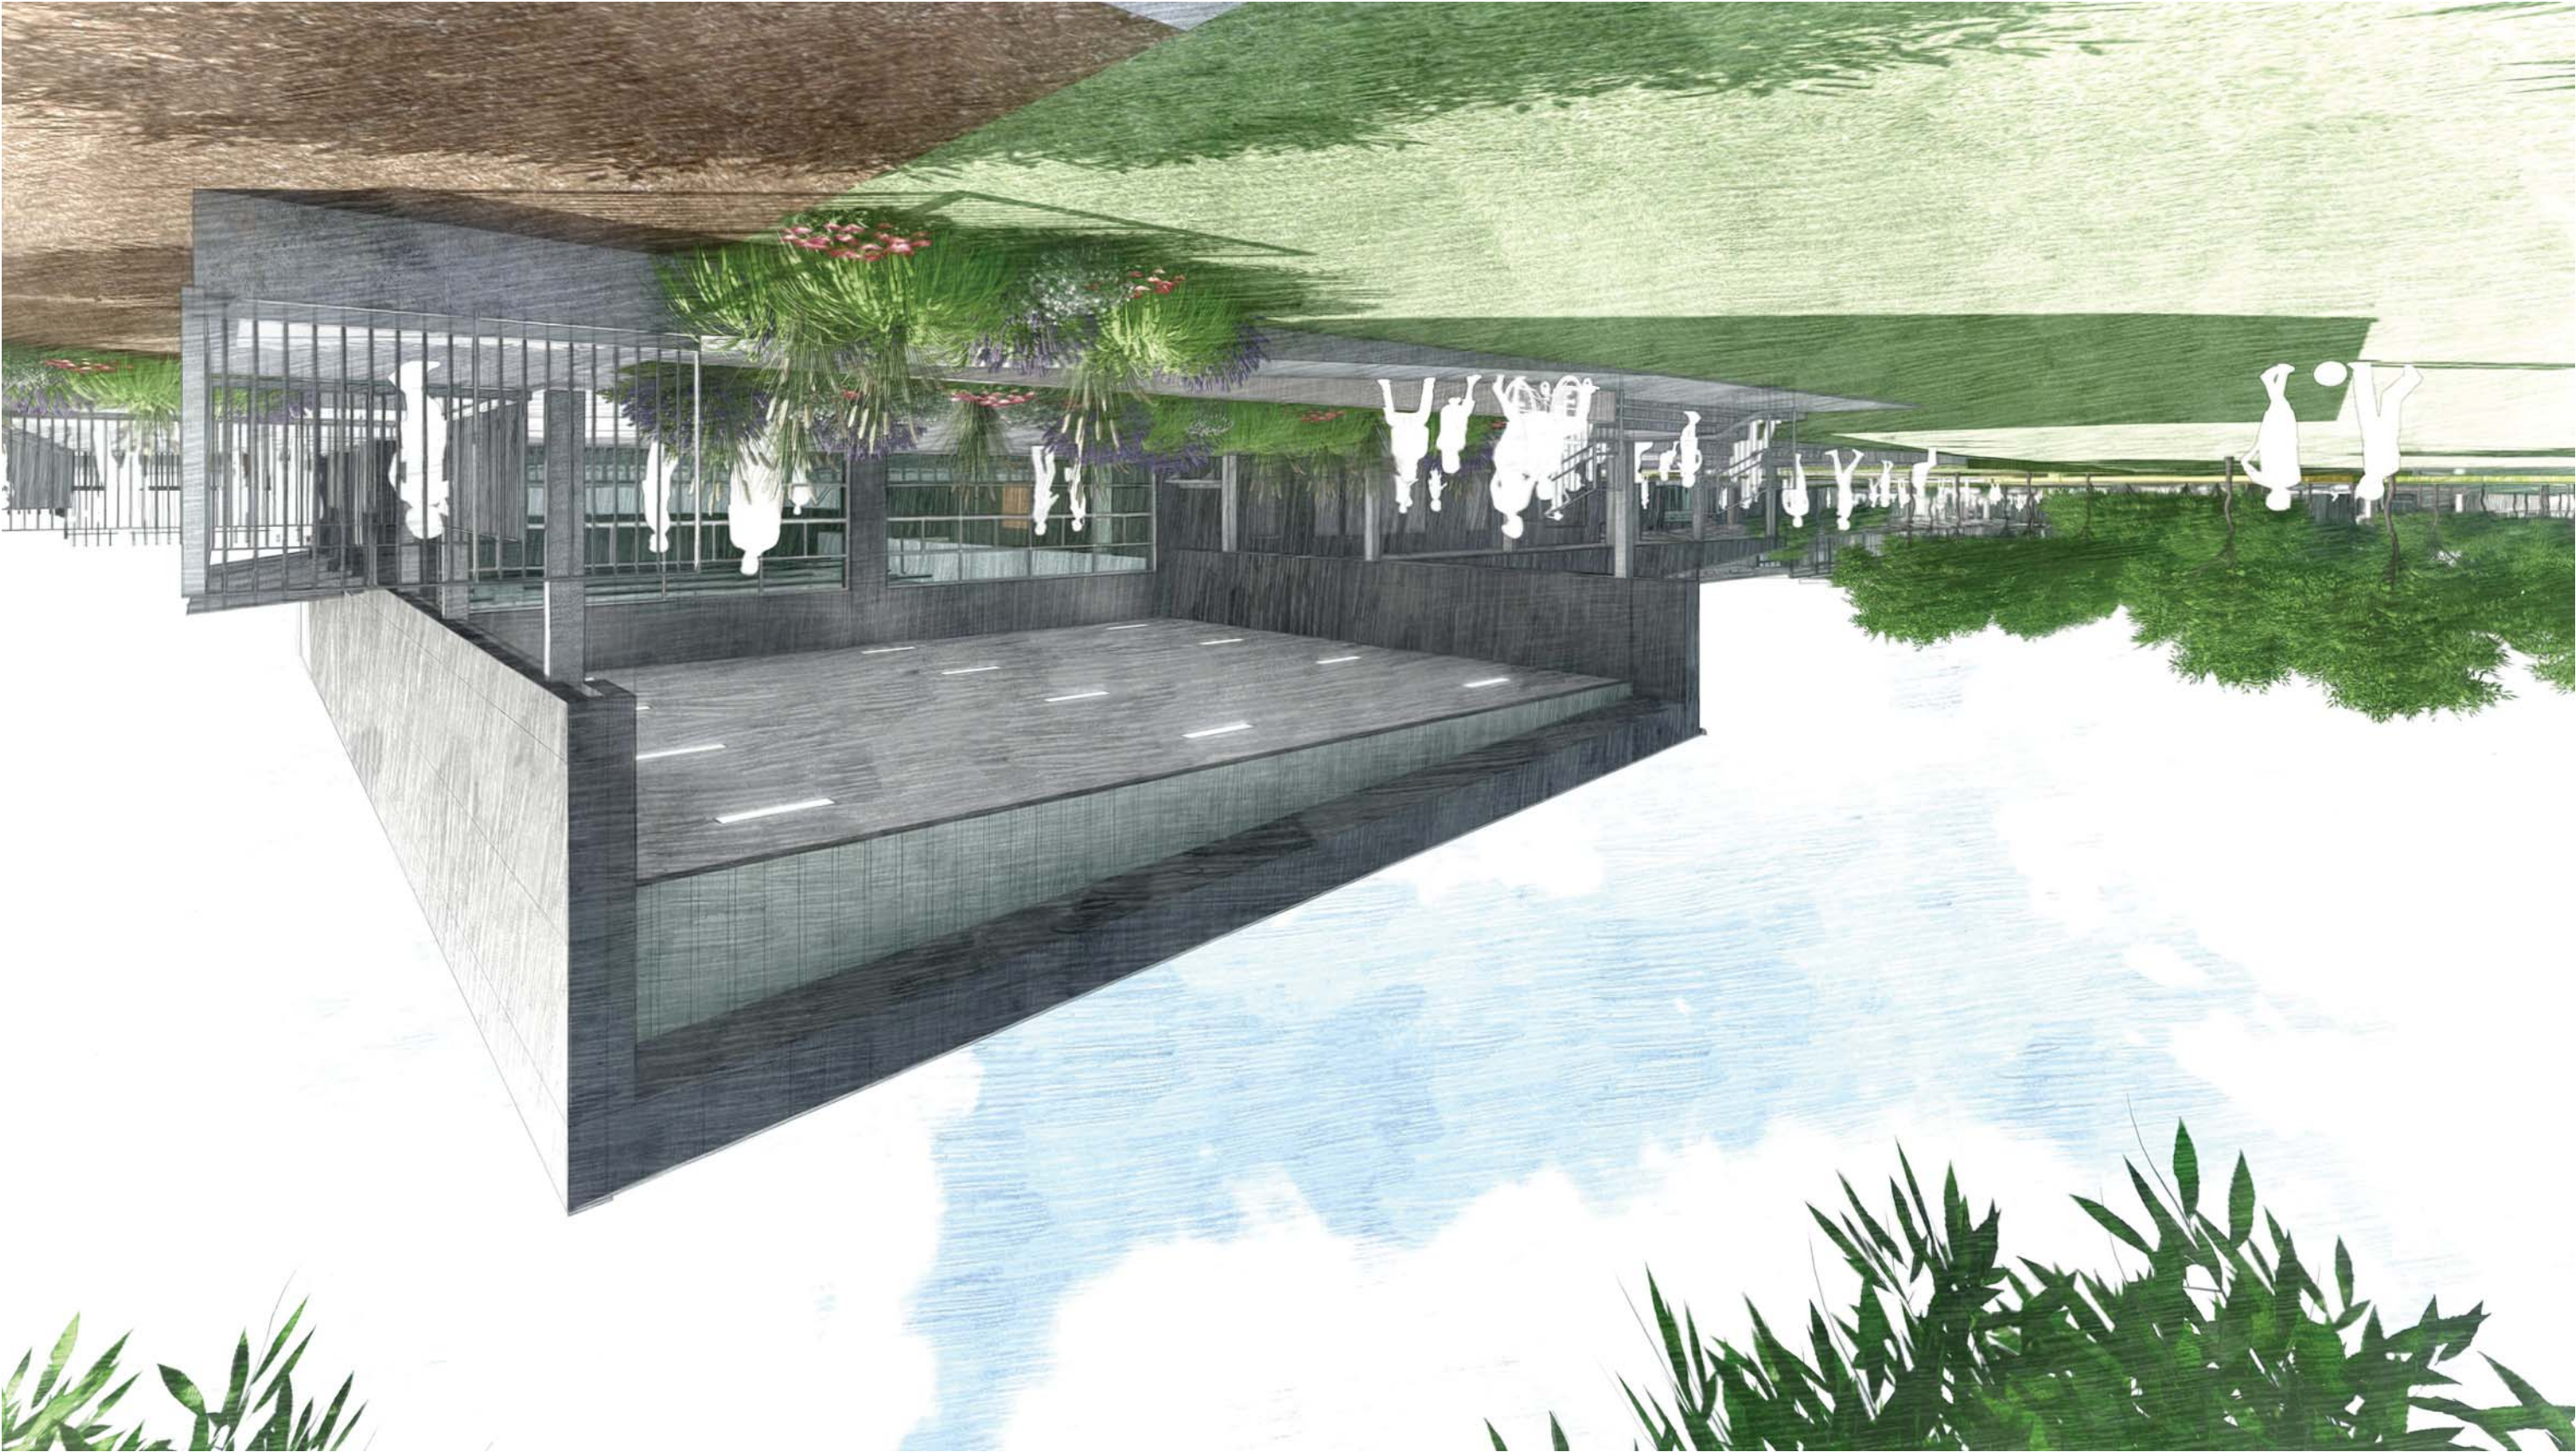

PERSPECTIVE - FROM SOUTH EAST CORNER OF THE MULTIPURPOSE HALL

Issue	No.	Date	Description
01	04/05/2021	SSDA ISSUE	
02	06/08/2021	SSDA ISSUE	
03	11/11/2021	SSDA R/S	

RICHARD CROOKES
CONSTRUCTIONS

SSDA R/S

TRAFFIC ENGINEER
PTC
KASIA BALSAM
02 9920 0800
kasia.balsam@pccconsultants.co

MULTI SERVICES
NDY
RYAN HAHN
0407 236 908
r.hahn@ndy.com

QUANTITY SURVEYOR
MBM
AUTUMN LU
02 9270 1062
autumn.lu@mbmpl.com.au

3D IMAGE 3

Project
NEW PRIMARY SCHOOL IN MULGOA
RISE

Architect
NBRS ARCHITECTURE.
Sydney
61 2 9922 2344
Any form of replication of this drawing in full or in part without the written permission of NBRS+PARTNERS Pty Ltd constitutes an infringement of the copyright.
NBRS & Partners Pty Ltd VIC 51197
A/BN 16 002 247 565
© 2021

Drawing Reference
20415-NBRS-DW-AR-SSDA-7003 03
Revision
Date 11/11/2021 7:17:21 PM
Scale NOT TO SCALE



PERSPECTIVE FROM THE ASSEMBLY / MEETING POINT LOOKING TOWARD THE MAIN COVERED ENTRY

Issue	No.	Date	Description
01	04/05/2021	SSDA ISSUE	
02	06/08/2021	SSDA ISSUE	
03	11/11/2021	SSDA R/S	
JL			
CHS			
Cktd			

RICHARD CROOKES
CONSTRUCTIONS

SSDA R/S

TRAFFIC ENGINEER
PTC
KASIA BALSAM
02 9920 0800
kasia.balsam@pccconsultants.co

MULTI SERVICES
NDY
RYAN HAHN
0407 296 908
r.hahn@ndy.com

QUANTITY SURVEYOR
MBM
ALTIMAN LU
02 9270 1062
altimn.lu@mbmpl.com.au

COLLIERS
PROJECT MANAGER
ANTHONY MAUGHAN-WRIGHT
0424 189 883
anthony.maughan-wright@colliers.com

Drawing Title
3D IMAGE 4

Project
NEW PRIMARY SCHOOL IN MULGOA
RISE
at
1-23 Forestwood Drive, Glenmore Park, NSW 2745, Australia
for
SINSW



Architect
NBSARCHITECTURE.
Sydney
61 2 9922 2344
Any form of replication of this drawing in full or in part without the written permission of NBS+PARTNERS Pty Ltd constitutes an infringement of the copyright.
NBS+PARTNERS Pty Ltd
ABN 16 002 247 565
© 2021

Drawing Reference
20415-NBRS-DW-AR-SSDA-7004 03
Revision

Date 11/11/2021 7:17:33 PM
Scale NOT TO SCALE



Issue	No.	Date	Description
01	12/04/2021	ISSUE FOR COORDINATION	
02	23/04/2021	ISSUE FOR COORDINATION	
03	04/05/2021	SSDA ISSUE	
04	06/09/2021	SSDA ISSUE	
05	11/11/2021	SSDA RIS	

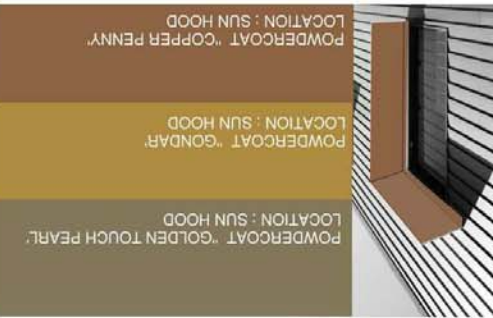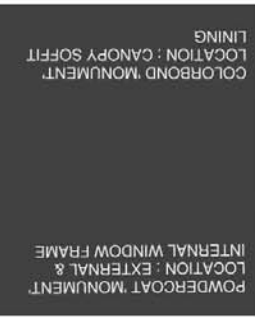

SSDA RIS

RICHARD CROOKES
CONSTRUCTIONS

TRAFFIC ENGINEER
PTC
KASIA BALSAM
02 8920 0800
kasia.balsam@ptcconsultants.co
RPS
RGS DWYER
0425 285 778
rdw.dwyer@rpsgroup.com.au

MULTI SERVICES
NDY
RYAN HAHN
0407 296 908
r.hahn@ndy.com
WOOLACOTTS
0424 189 888
JUSTIN CHILLID
02 8203 1504
jchillid@woolacotts.com.au

QUANTITY SURVEYOR
MBM
ALUN LU
02 9270 1062
alun.lu@mbmpl.com.au
COLLIERS
PROJECT MANAGER
ANTHONY MUGHAN-WRIGHT
0424 189 888
amw@colliers.com

Drawing Title
EXTERNAL FINISHES

Project
NEW PRIMARY SCHOOL IN MULGOA
RISE
at
1-23 Forestwood Drive, Glenmore Park, NSW 2745, Australia
for
SINSW

Architect
NBRS ARCHITECTURE.
Sydney
61 2 9922 2344
Any form of replication of this drawing in full or in part without the written permission of NBRS+PARTNERS Pty Ltd constitutes an infringement of the copyright.
NBRS+PARTNERS Pty Ltd
Andrew Duffin NSW 5602
ABN 16 002 247 565
© 2021

Drawing Reference
20415-NBRS-DW-AR-SSDA-8001 05
Revision

Date 11/11/2021 7:17:45 PM
Scale NOT TO SCALE