


THIS DRAWING HAS BEEN REDUCED

SET OUT POINT SCHEDULE

LOCATION	EASTING	NORTHING
SOP1	294256.6689	1248057.7449

 
REFER TO DRG SN-620 FOR DETAILS

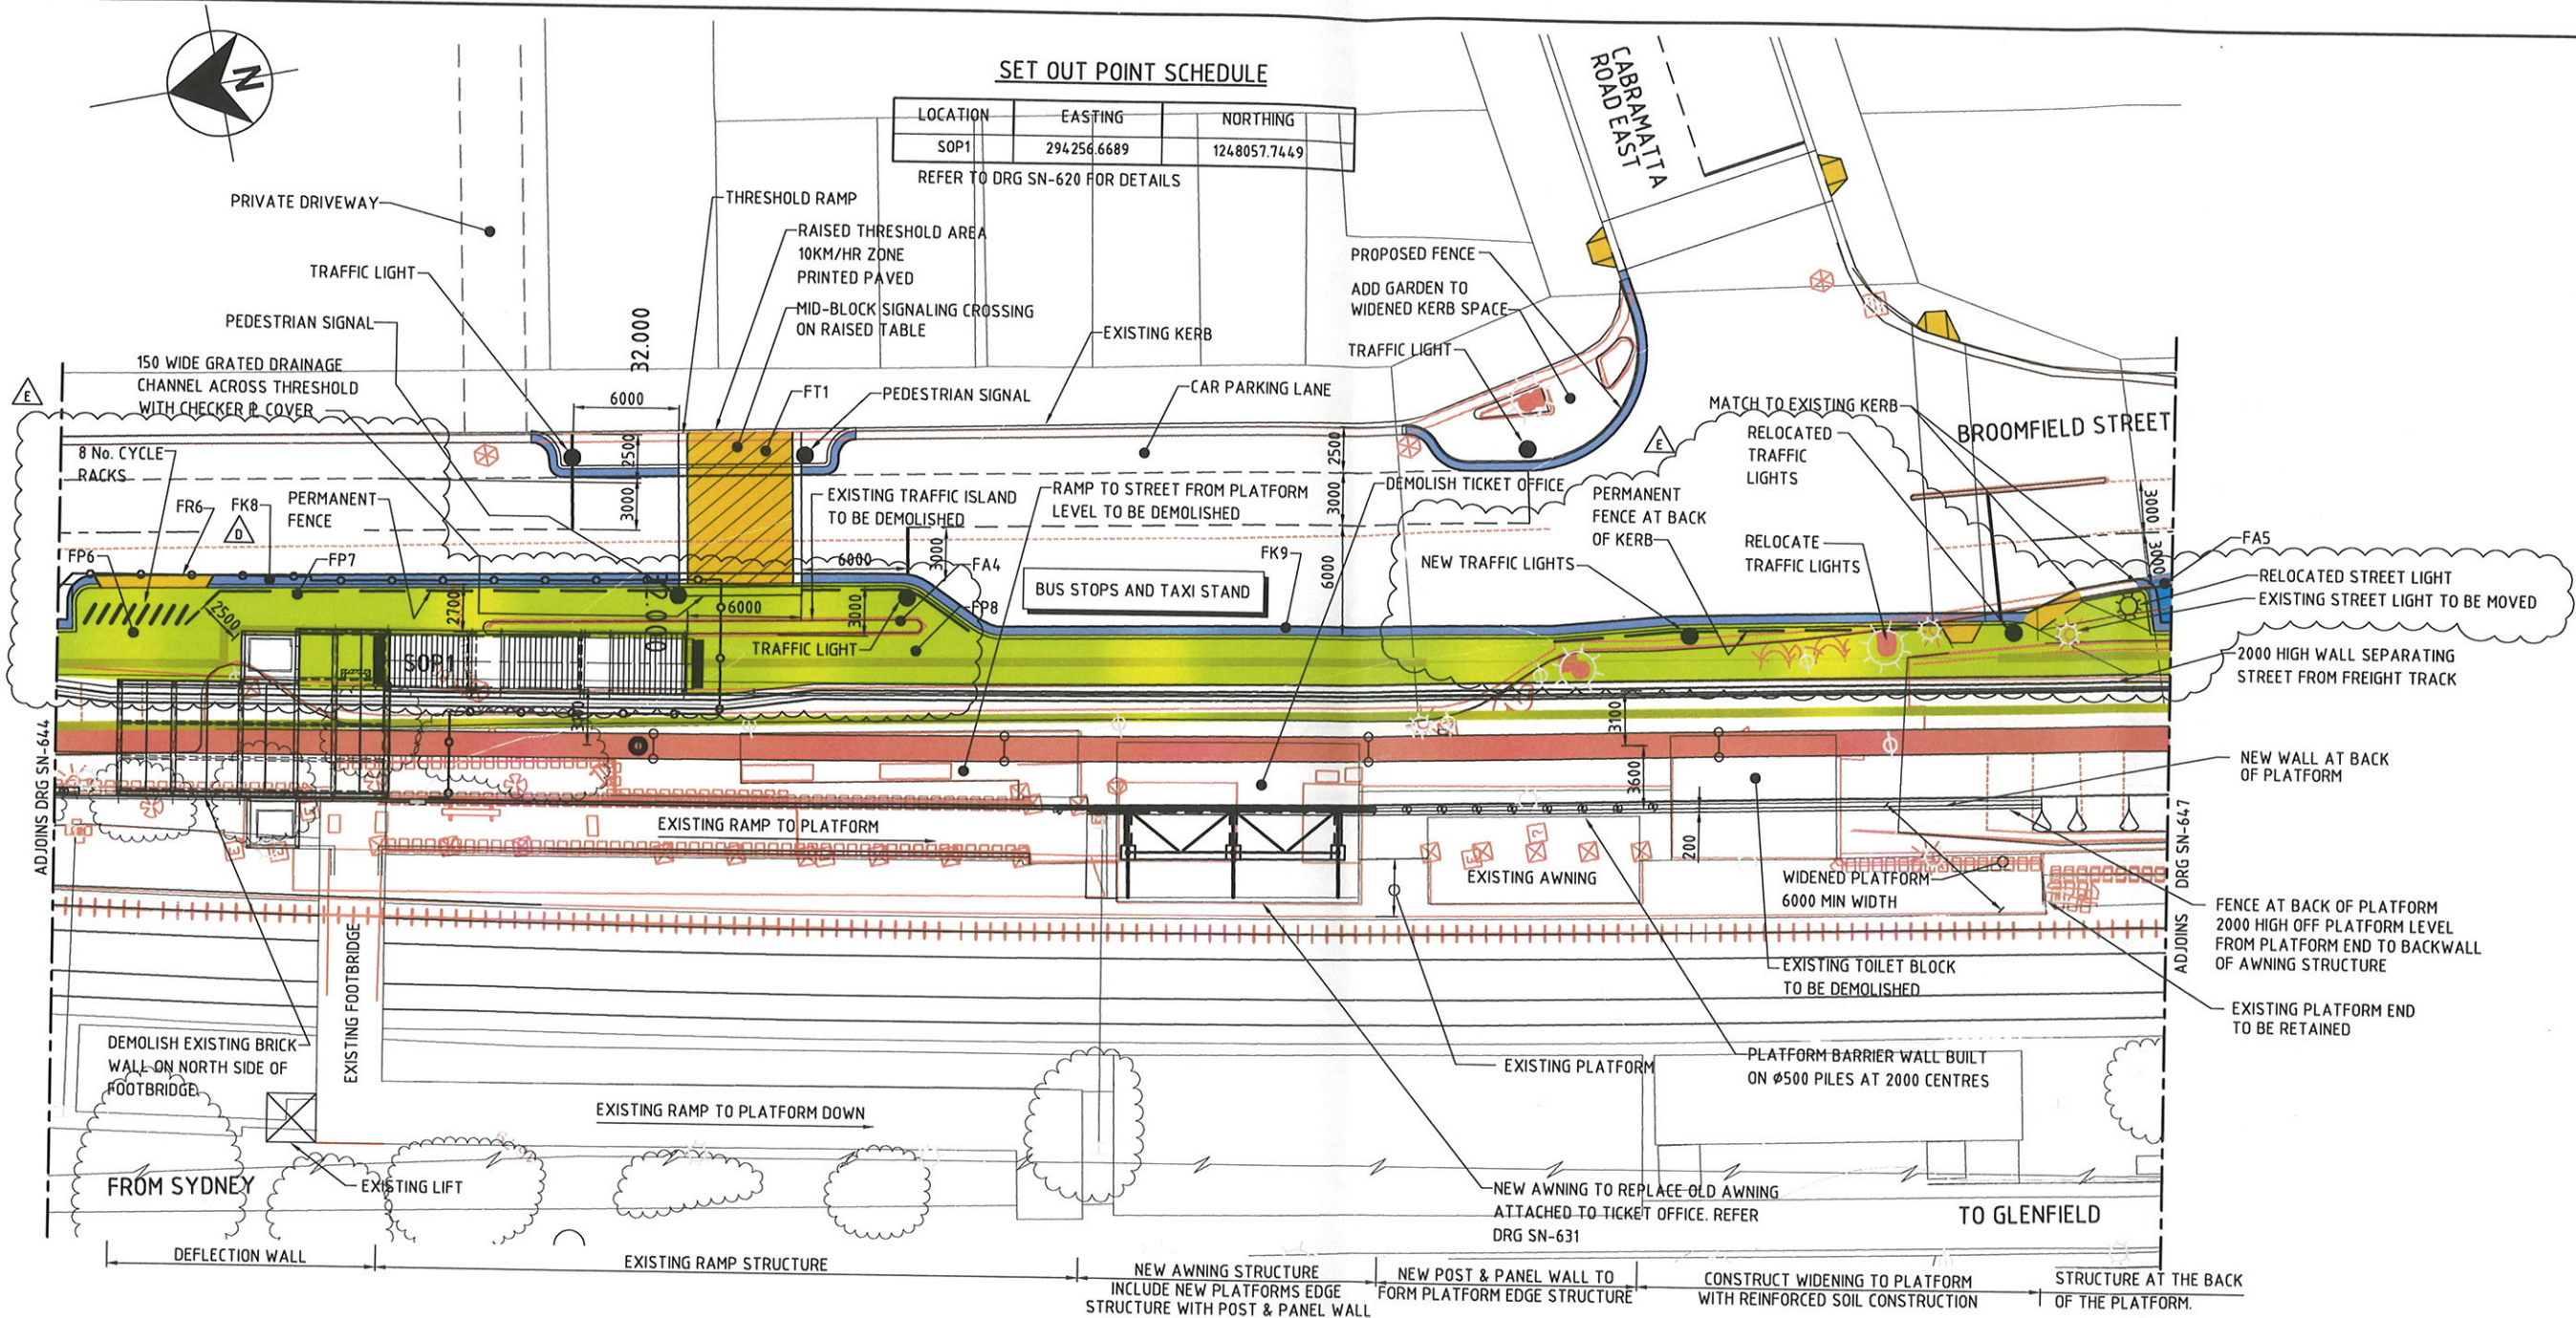

CABRAMATTA STATION SURFACE PLAN
1:200

LEGEND

- NB — NOISE BARRIER
- BANKSTOWN.....(B)
CITY COUNCIL
FAIRFIELD.....(F)
CITY COUNCIL
LIVERPOOL.....(L)
CITY COUNCIL
CAMPELLTOWN.....(C)
CITY COUNCIL
- REFERENCE NUMBER
BR1
- NEW PROPOSED ITEMS:
- KERB
 - ROAD/CAR PARK PAVING
 - DRIVE WAY RAMP
 - CONCRETE
 - GATE
 - FOOTPATH
 - PEDESTRIAN RAMP/CROSSING & SPEED BUMP
- ITEMS TO CONFORM:
- WITH COUNCIL SPECIFICATIONS
 - SITE LEVELS
 - REFER TO CROSS SECTION DETAILS
- (R).....RAMP
(K).....KERB
(P).....PATH
(A).....ASPHALT
(C).....CONCRETE SURF./BASE
(G).....GATE
(IK).....ISLAND KERB
(B).....PLANTER BOX
(D).....DRIVE WAY RAMP
(T).....THRESHOLD



Rev.	Date	Revision Details	Drn	Ver.	App.
E	07.05.09	FOOT PATH, BIKE RACK & FENCE ADDED	AS	GM	PR
D	15.04.09	LARGER STATION LIFT ALTERNATIVE SHOWN	RJT	GM	PR
C	27.03.09	ROUNDOABOUT OPTION REMOVED	ARTS	GM	PR
B	05.03.09	DRG'S AMENDED - PENDING RAILCORP APPROVAL	AS	GM	PR
A	08.12.08	ISSUE FOR CONSTRUCTION-PENDING RAILCORP APPROVAL	AS		



Aurecon Australia Pty Ltd ABN 54 005 139 873 Telephone: +61 2 9485 5599
116 Military Road (PO Box 538) Neutral Bay Facsimile: +61 2 9485 5598
New South Wales 2089 Australia Email: sydney@aurecongroup.com



Client:
Project:
SOUTHERN SYDNEY
FREIGHT LINE

Drawn	Signed	Date
ARTS	ARTS	05.03.09
Designed	Signed	Date
CJM	CJM	05.03.09
Verified	Signed	Date
GM	GM	05.03.09
Approved	Signed	Date
PR	PR	23.03.09

Drawing Title:
CABRAMATTA TO GLENFIELD
STATION
CABRAMATTA STATION
GENERAL ARRANGEMENT SHEET 7

FOR CONSTRUCTION PENDING RAILCORP APPROVAL	
Project No.	559D
Scale	AS SHOWN
Sheet Size	A1
Drawing No.	SN-646
Rev.	E