



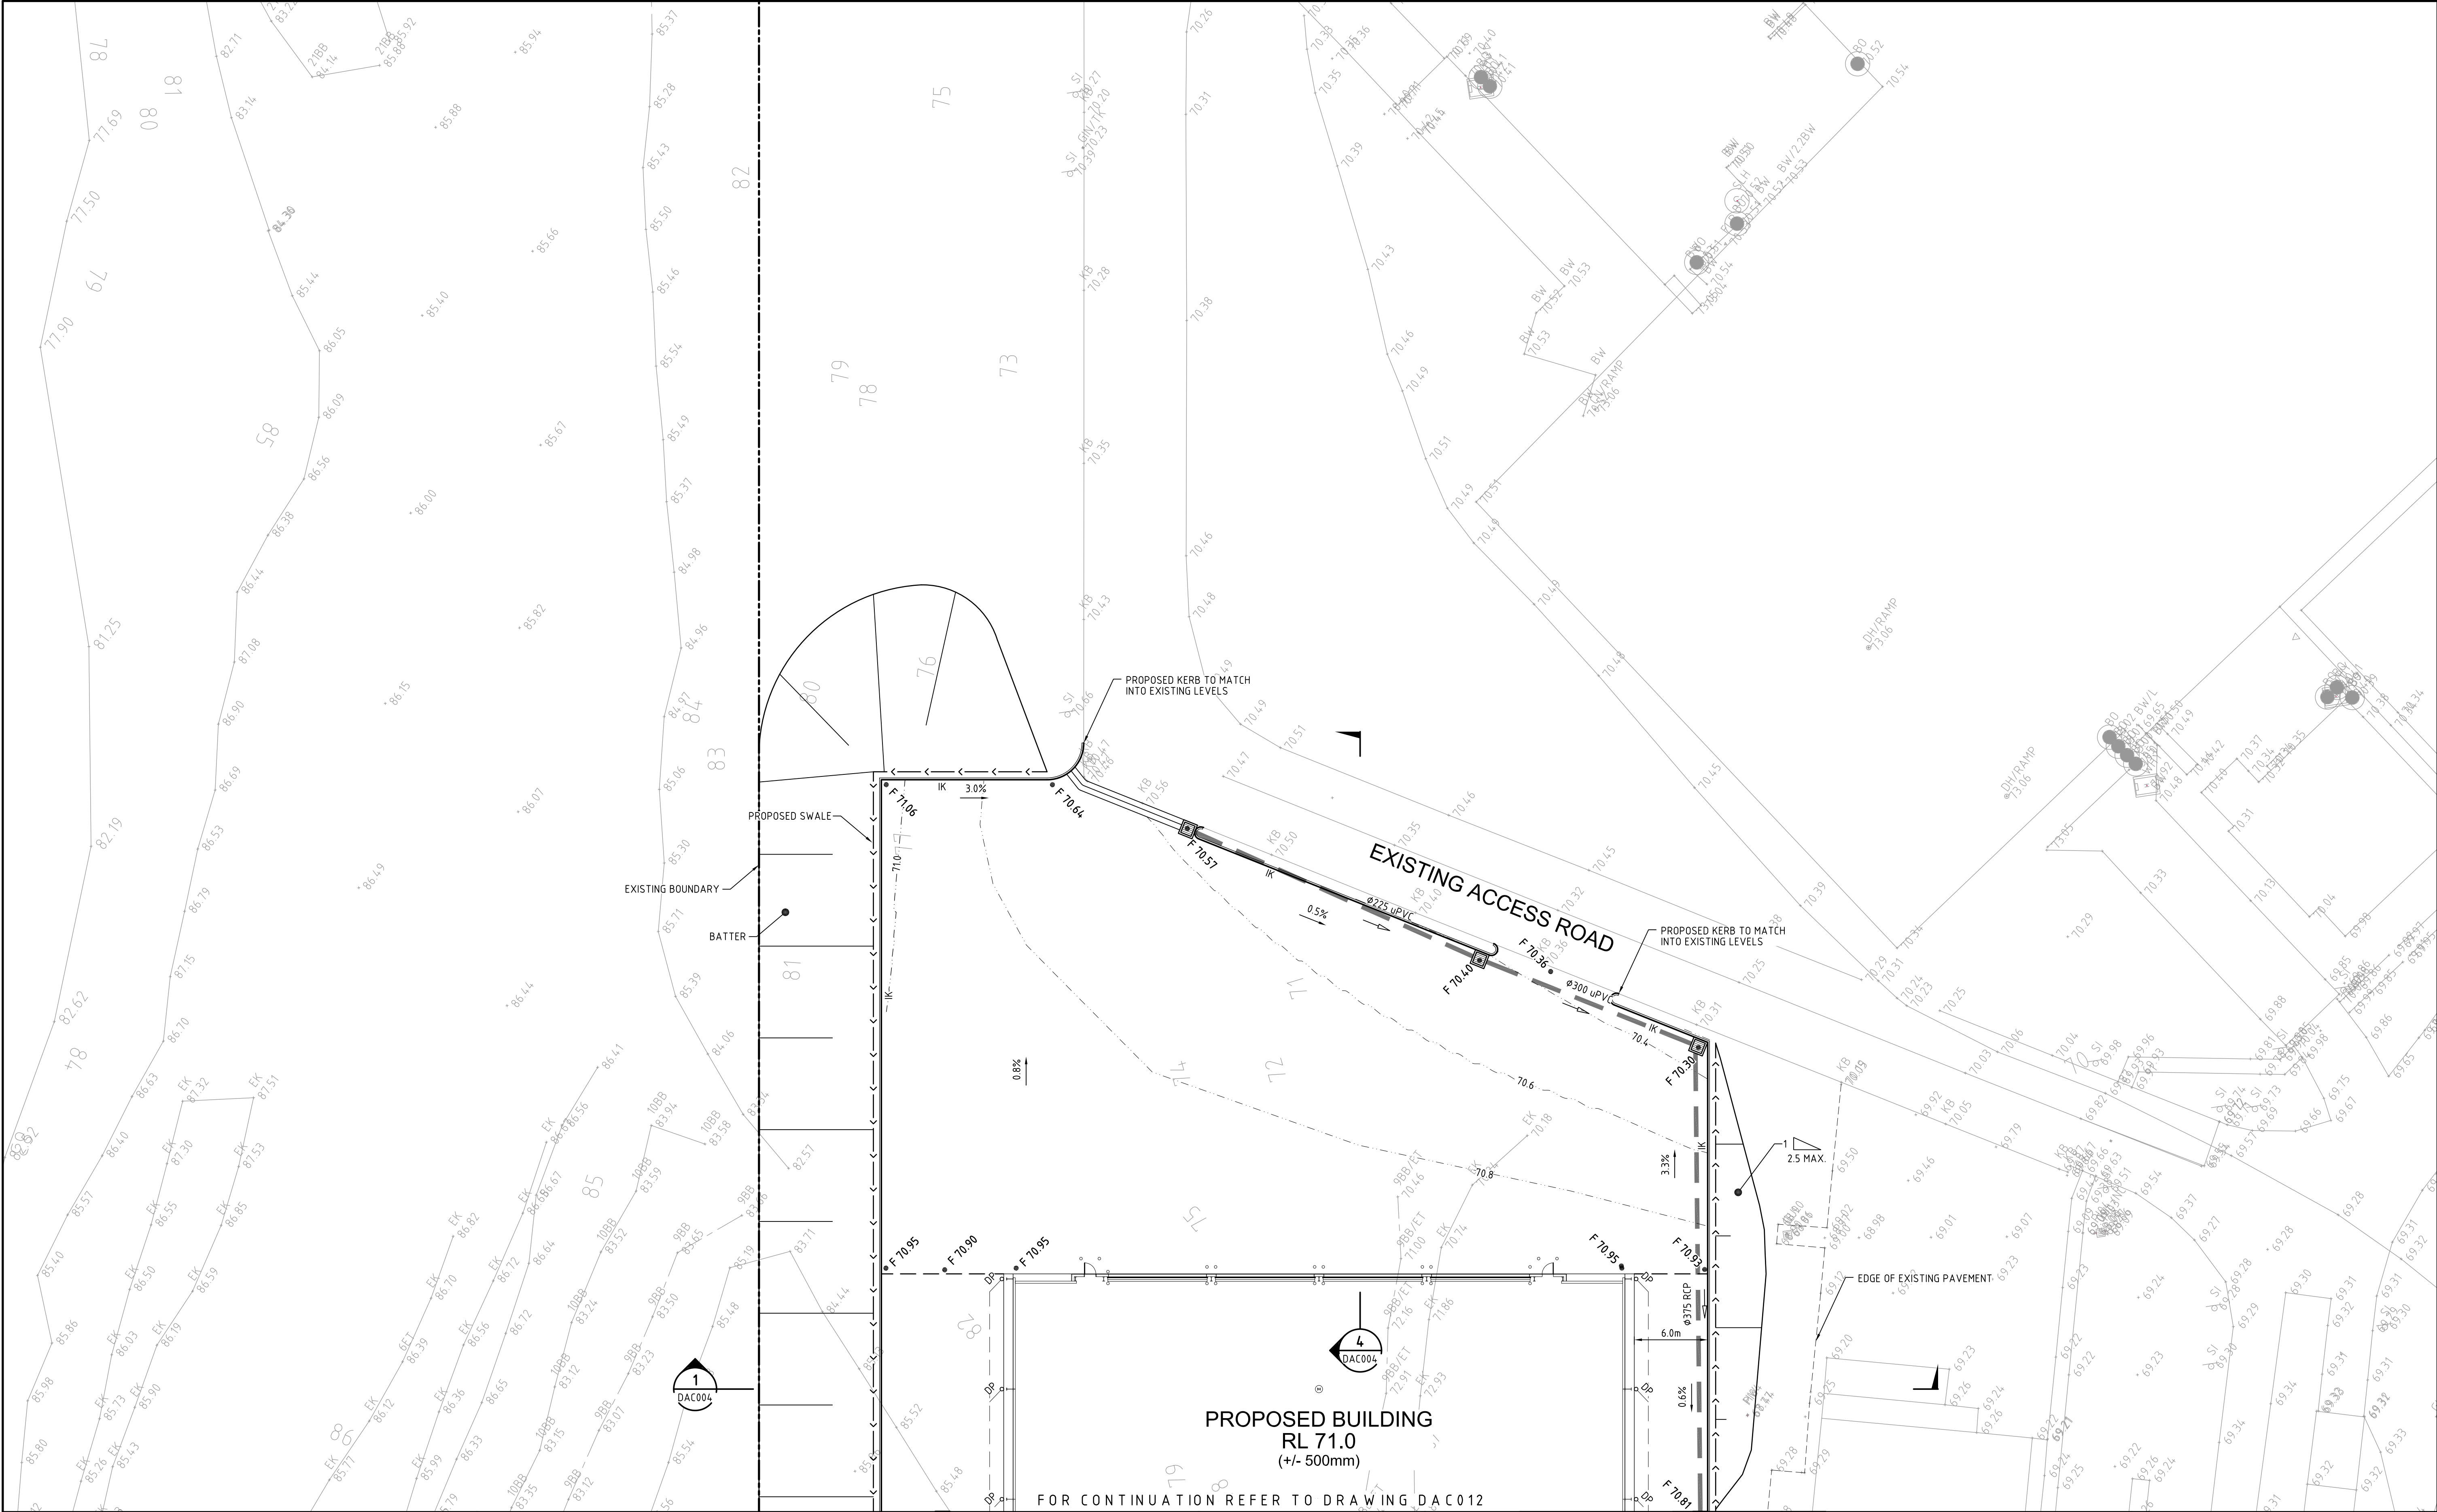

B	ISSUED FOR APPROVAL	03-03-15
A	ISSUED FOR APPROVAL	15-12-14
Issue	Description	Date

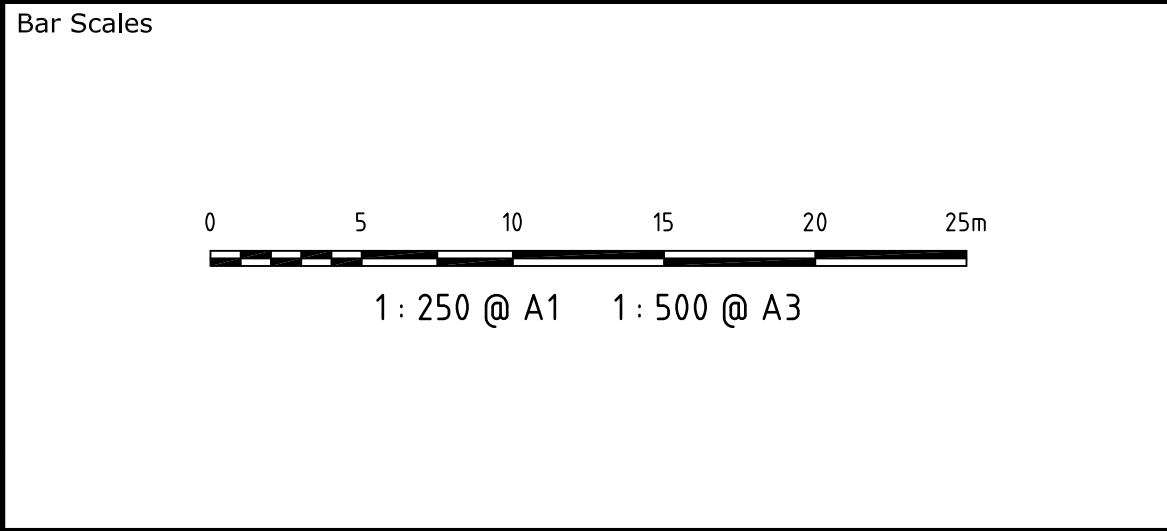

THIS DRAWING CANNOT BE
COPIED OR REPRODUCED IN
ANY FORM OR USED FOR ANY
OTHER PURPOSE OTHER THAN
THAT ORIGINALLY INTENDED
WITHOUT THE WRITTEN
PERMISSION OF AT&L

Client

DIAL A DUMP

Scales	1 : 250	Drawn	FX
		Designed	FX
Grid	MGA	Checked	AM
Height Datum	AHD	Approved	

Project	PRE SORT CENTRE EASTERN CREEK
Title	SITWORKS AND STORMWATER DRAINAGE PLAN - SHEET 1

Civil Engineers and Project Managers		
Suite 702, 154 Pacific Hwy St Leonards NSW 2065 ABN 96 130 882 405 Tel: 02 9439 1777 Fax: 02 9460 8413 www.atl.net.au info@atl.net.au		
Status	FOR APPROVAL	A1
Drawing No.	DAC011	Issue
Project No.	14-232	B