


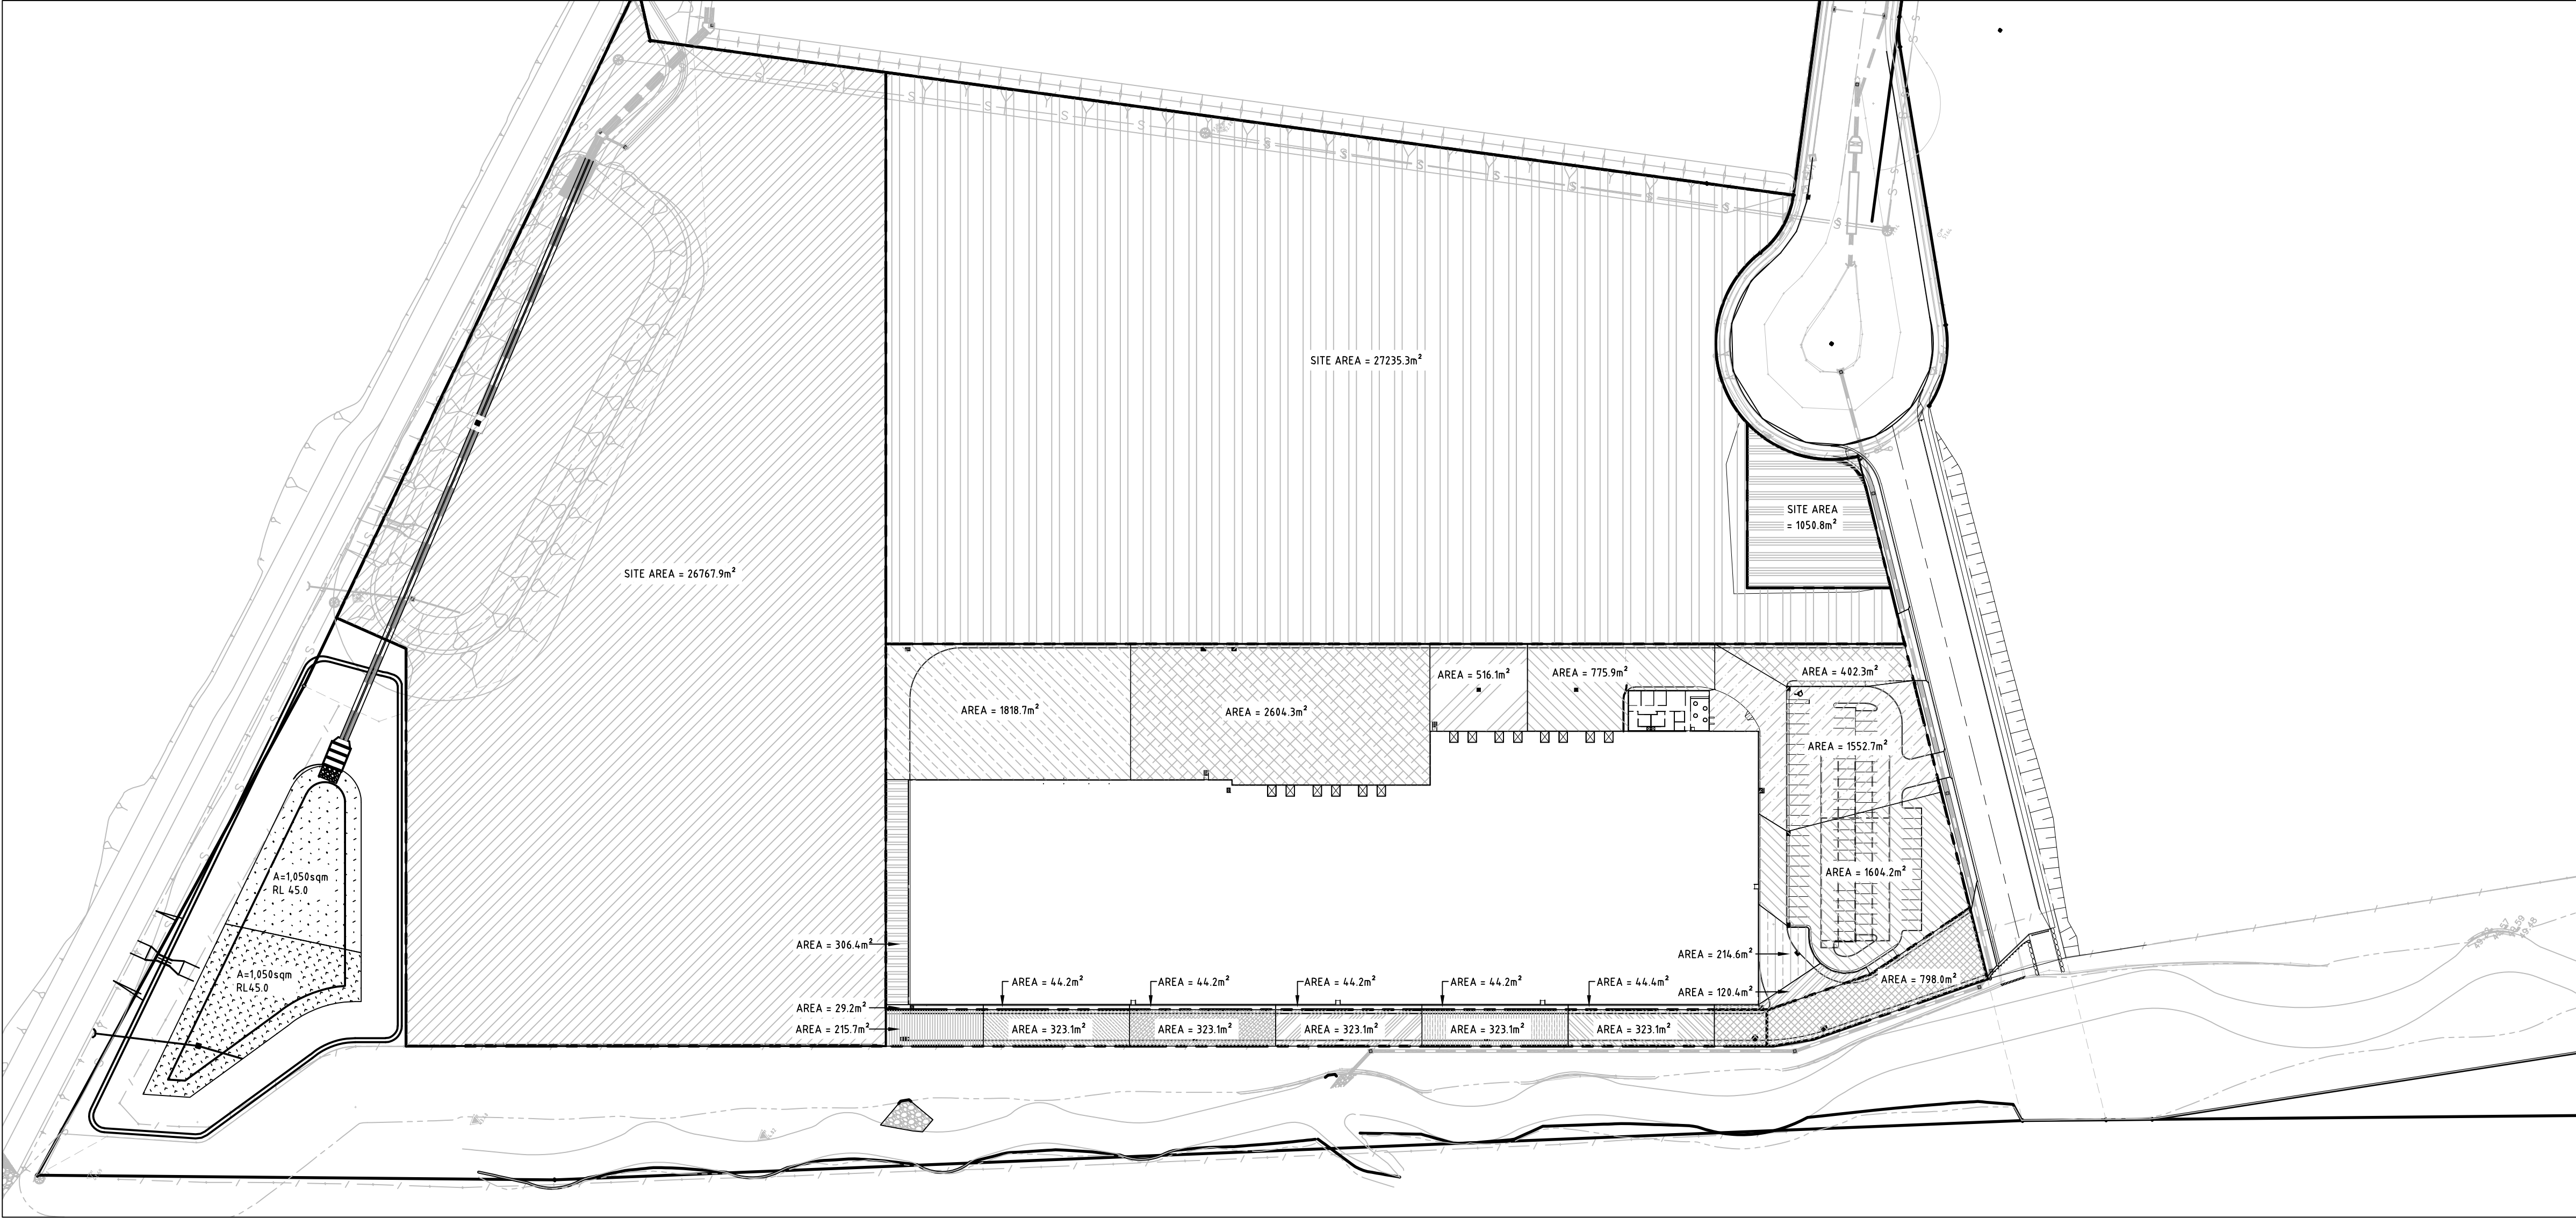


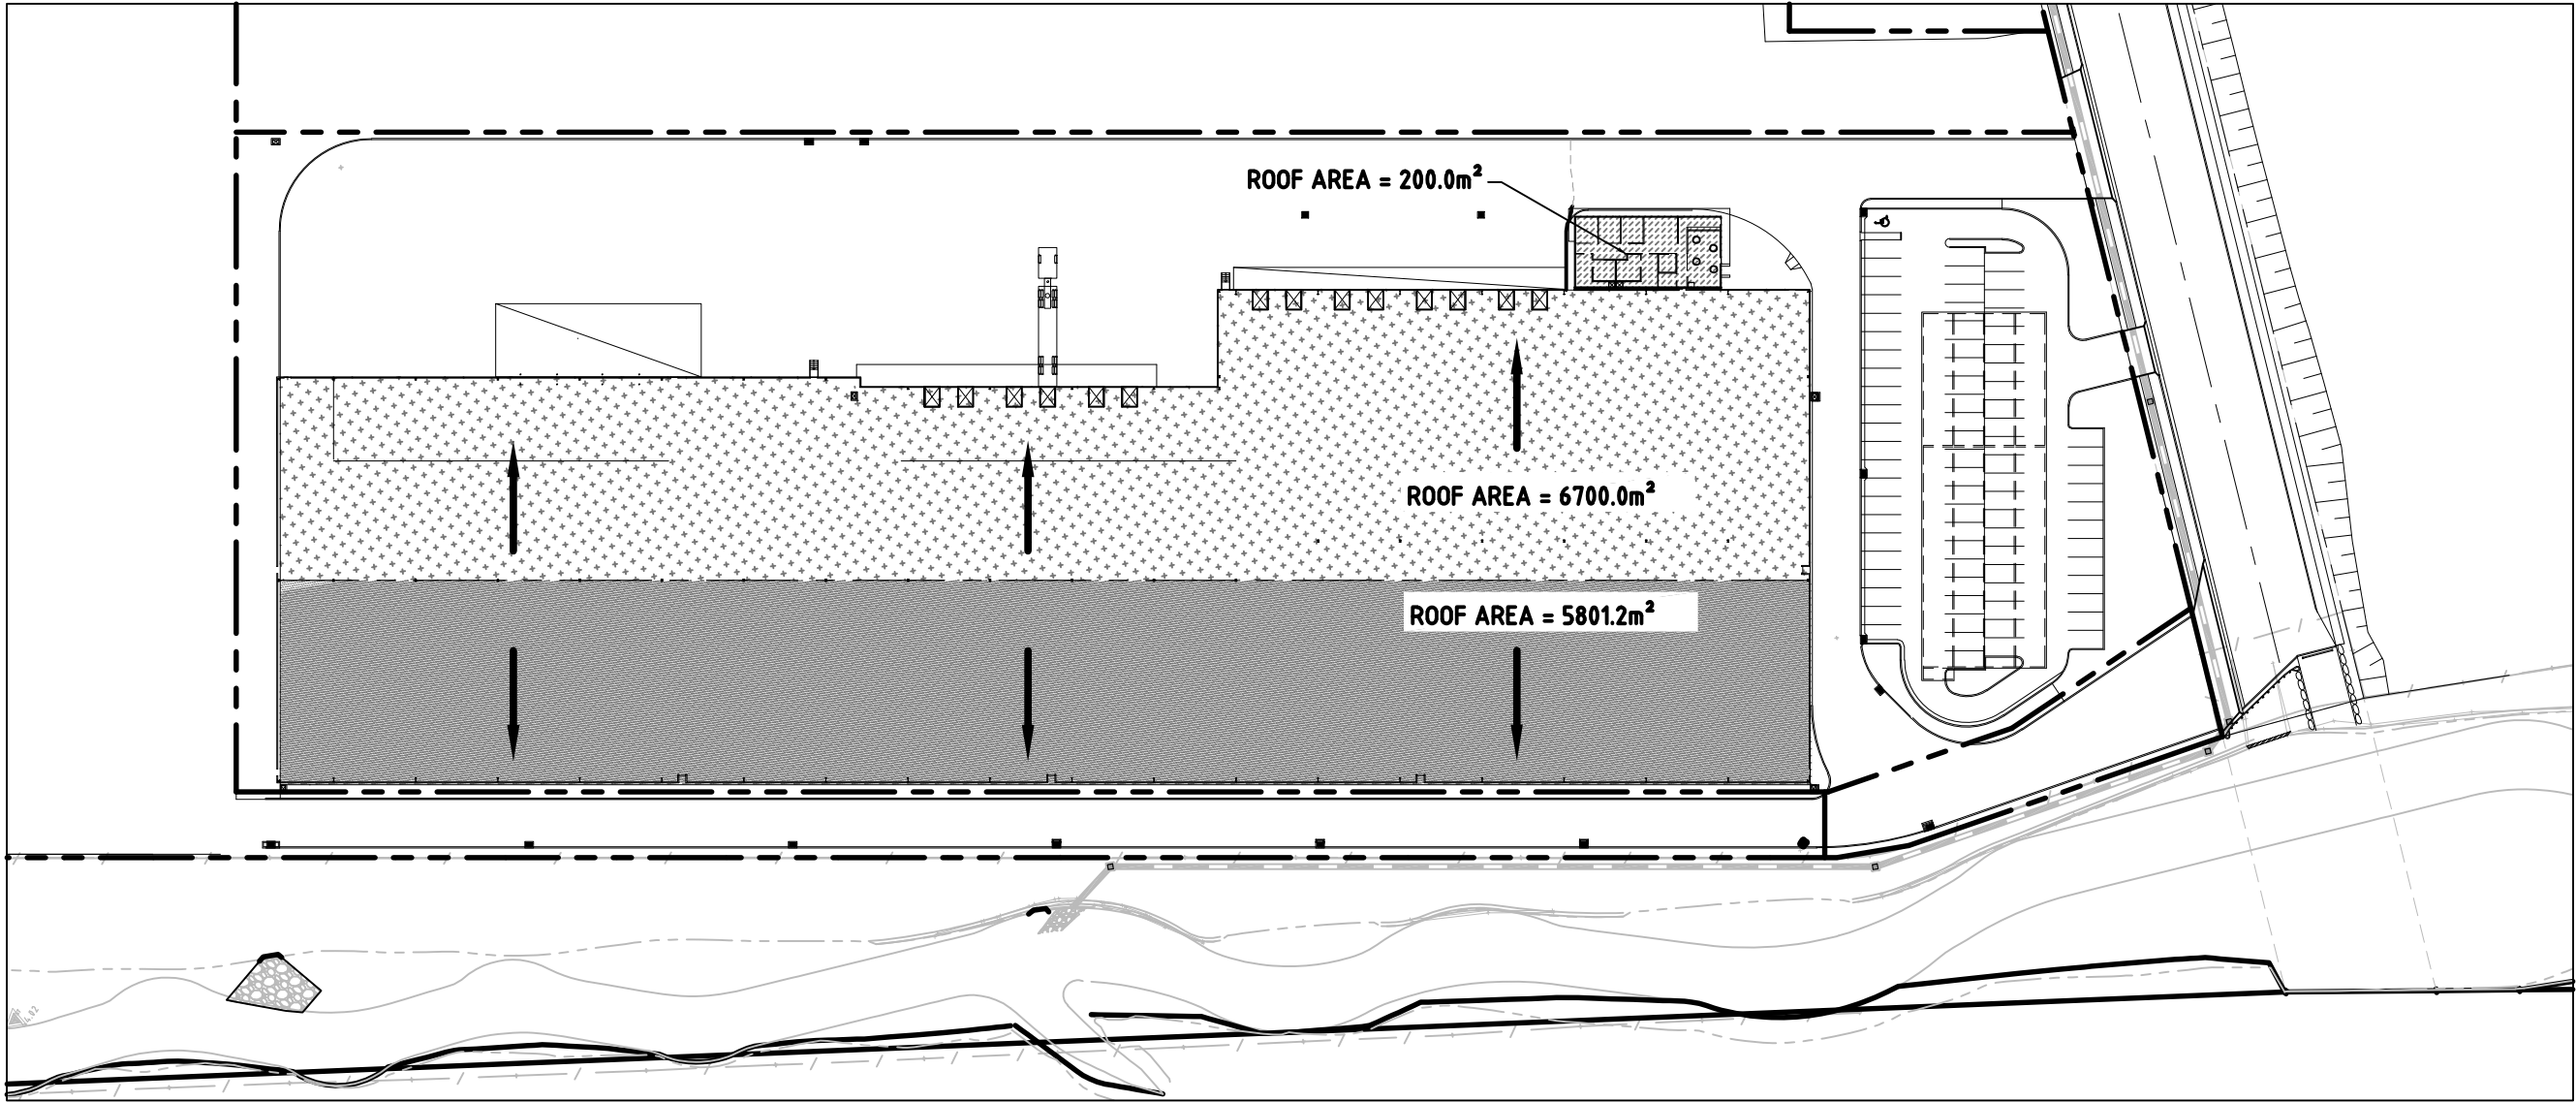

OVERALL SITE AREA CATCHMENTS

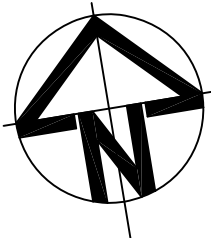

TARGET ROOF AREA CATCHMENTS

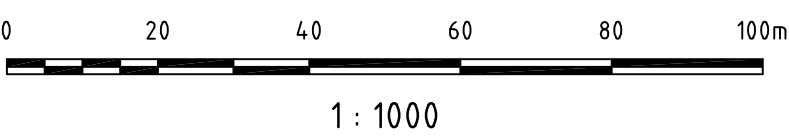

P2	ISSUE FOR DA	MV	MK		19.12.08
P1	ISSUE FOR INFORMATION	MV	MK		12.12.08
Issue	Description	Drwn	Ckd	Appd	Date

Status	FOR INFORMATION NOT TO BE USED FOR CONSTRUCTION	
--------	--	--

Client	hansen yuncken BUILDING VALUE	
Scale (A1)	1 : 1000	Datum AHD
Drawn	MV	Designed MK

Project	SITE H -3 (TARGET) ERSKINE PARK CIVIL WORKS	
Title	ROOFWATER DRAINAGE LAYOUT PLAN	

Hyder		HYDER CONSULTING PTY LTD Level 5 141 Walker St North Sydney, NSW, 2060 ABN 76 104 485 289 Tel: +61 (0)2 8907 9000 Fax: +61 (0)2 8907 9001	
Project Code	AAMK0001	Drawing No.	DA04
Issue	P2		