


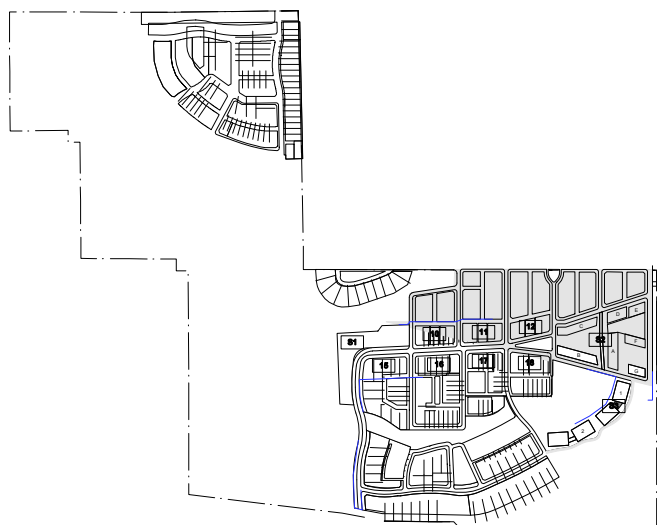

KEY			
LDY	LAUNDRY	L/D	LIVING/DINING
B	BALCONY	K	KITCHEN
B1	BEDROOM1	STO	STORAGE
B2	BEDROOM2	AC	AIR CONDITIONING
B3	BEDROOM3	CPE	CARPARK EXHAUST

REVISED:		
DA2	REVISED DA ISSUE	08.12.07
DA	DA ISSUE	14.6.07
SK3	CLIENT/CONSULTANT ISSUE	1.6.07
SK2	CLIENT/CONSULTANT ISSUE	21.5.07
SK1	CLIENT ISSUE	7.5.07
REV.	DESCRIPTION	DATE

CONSULTANT TEAM	
PLANNING/LANDSCAPE ARCHITECTURE: EDAW 146 Mountain St. Uffington NSW 2070 T (02) 9212 3666 F (02) 9212 4039 A (02) 9212 886 306 E edaw@edaw.com.au P (014) 759 540 E john.shinkhard@edaw.com E John Shinkhard - Project Principal M (014) 551 372 E john.shinkhard@edaw.com Chris Vandy - Urban Design / T (02) 950 707 144 E chris.vandy@edaw.com	ARCHITECTURE & MASTERPLANNING: dKO Architecture C113 36 Niagara St. Uffington NSW 2070 ABN 54 186 185 257 T (02) 9212 3666 F (02) 9212 4039 Q (02) 9212 886 306 T (02) 9280 2244 F (02) 9280 2244 E info@dko.com.au
	ARCHITECTURE (Botanics): Stanic Harding 12/3 Commonwealth St. Surry Hills NSW 2011 ACN 603 681 301 T (02) 9212 681 301 F (02) 9212 681 301 E andy@stanicharding.com.au E andy@stanicharding.com.au

CIVIL / ACOUSTIC ENGINEERING:

Hyver Consulting
 151, Wakearua Street North Sydney NSW 2060
 ABN 76 104 485 289
 Contact: John McDermott - Associate
 Tel: (02) 9807 3900 or (02) 9807 9001
 M 0408 931 071
 E john.mcdermott@hyverconsulting.com.au

TRAFFIC & TRANSPORT PLANNING:

GTA Consultants
 110, B15 Pacific Highway Hay Chatswood NSW 1585
 ACN 005 839 645
 Contact: Alan Stewart - Project Manager
 Tel: (02) 8446 1310
 M 021 8284 1310
 E alan.stewart@gta.com.au

ARCHITECTURE (apartments):

Durbach Block Architects
 Level 5, 71 York Street
 Sydney NSW 2000 Australia
 Tel: (02) 8287 3500
 M 021 8287 3510
 mail@durbachblock.com

BASIS:

Damian O'Toole Town Planning
 12, 29 Shepherd St Chippendale NSW 2008
 ABN 75 105 123 420
 Contact: Damian O'Toole
 Tel: (02) 9280 4547 F: (02) 9280 4577
 M 021 9280 4577
 E damian@townplanning.net.au

ECONOMIC ANALYSIS: Sphere Property Corporation Suite 10, Quay West Centre 96 Gloucester St Sydney NSW 2000 ABN 36 003 463 401 Contact: <u>John Harston - Managing Director</u> T (02) 9252 7066 F (02) 9252 7067 M 0418 293 025 E sphere@sphere.com.au	FLOOD MANAGEMENT / WSUD: Evans & Peck Unit 20, 390 Essendon Valley Way East Roseville NSW 2069 ACN 098 008 818 Contact: <u>Steve Perrens - Principal</u> T (02) 9882 5050 F (02) 9417 8850 M 0413 049 400 E sperrens@evanspeck.com
---	---

BUSHFIRE HAZARD Australian Bushfire Protection Planners RMB 311 Dog Track Rd Somersby NSW 2250 CONTACT: 083 610 1737 Contact: Graham Swain - Principal T(02) 4362 2112 F (02) 4362 2204 M 0427 622 204 E abpp@bigpond.net.au	SOILS CAPABILITY: Sydney Environmental & Soil Laboratory 16 Chivers Rd Pennant Hills NSW 2120 PO Box 357 Pennant Hills NSW 1715 AS 106 810 707 Contact: Simon Lake - Principal T(02) 9980 8558 F (02) 9484 2427 M 0409 126 729 E sjm@sesl.com.au
---	---


EUROPEAN HERITAGE:
City Plan Heritage

ECOLOGY:
Keystone Ecological
PO Box 5095 Empire Bay NSW 2257
ACN 099 456 149
Contact: Elizabeth Ashby - Senior
Ecologist
T(02) 4368 1106 F (02) 4368 2361
E.e.ashby@keystone-ecological.com.au

ACCESSIBILITY CONSULTANT: Morris Goding Accessibility Consultants Unit 106, 56 Bowman St The Coopers Pyrmont NSW 2009 ABN 70 414 330 060 Contact: David Goding T(02) 9692 9322 F (02) 9692 8433 E david@mgac.com.au	INDIGENOUS ARCHAEOLOGY: NSW Archaeology Pty Ltd
---	--

CLIENT:

SILVER SPIRIT PARTNERS

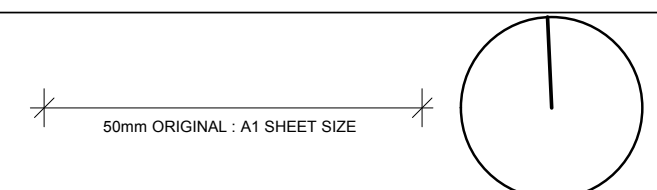

ARCHITECT:
DBA
Durbach Block Architects

Moruya East Village

Moruya Village Square

DRAWING TITLE:
APARTMENTS
LEVEL 1

DRAWN: CB/LL/SH/BD CHECKED: CB/ND
SCALE: 1:200 @ A1 DATE: 08/06/2007

PROJECT NUMBER, SERIES / DRAWING NUMBER:	REV:
1603•103	DA2