


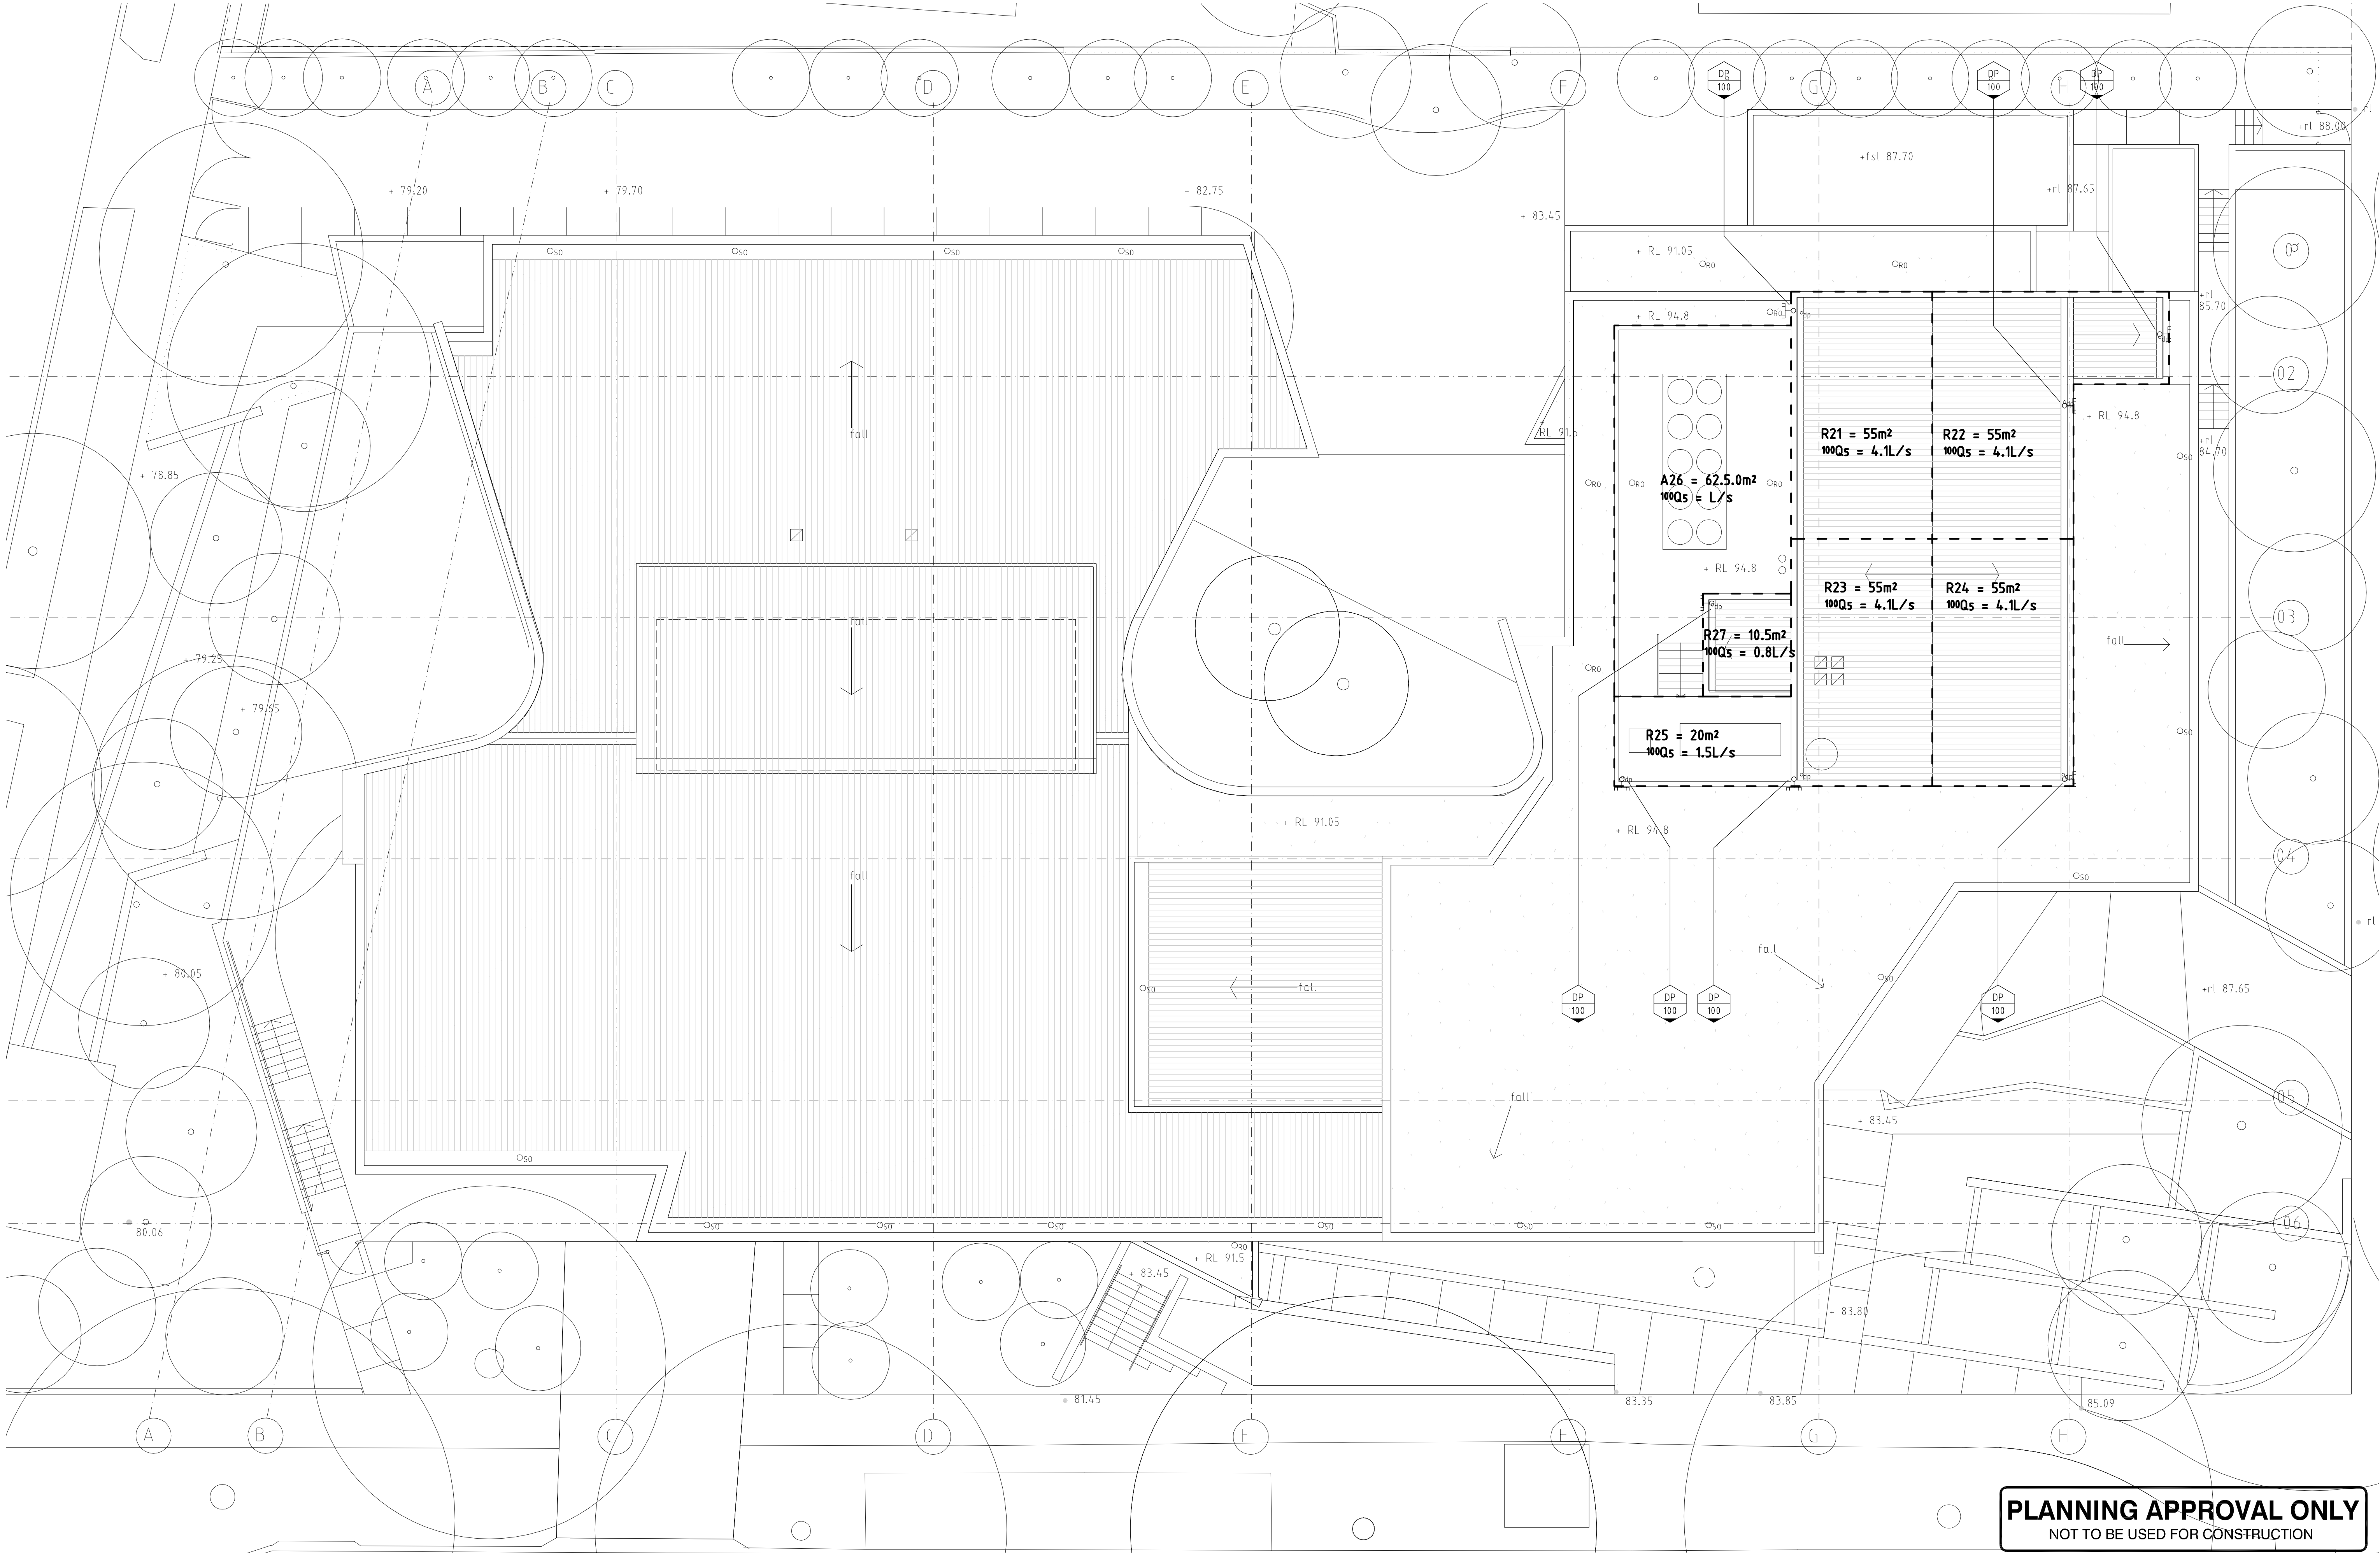


PLANNING APPROVAL ONLY
NOT TO BE USED FOR CONSTRUCTION

Client



Project Manager
Savills
Level 7
AMP Centre 50 Bridge St
Sydney NSW 2000
T 8215 8888 F 8215 8899
www.savills.com.au

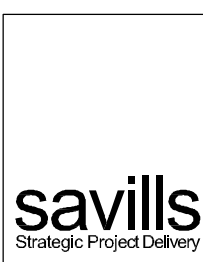

Architects
Daryl Jackson Robin Dyke Pty Ltd
Architects
64 Rose Street Chippendale NSW 2008
T +612 9319 2955 F +612 9698 1116
www.djrd.com.au



Warren Smith & Partners Pty Ltd
A 1st Floor, 123 Clarence Street, Sydney 2000 NSW Australia
T 02 9288 1512 F 02 9290 1295 E wsp@warrensmith.com.au
ABN 90 300 430 126
SERVING THE CONSTRUCTION INDUSTRY
SINCE 1981
Consulting Engineers
Hydraulic Services | Civil Engineering | Fire Protection |
Sydney Water Accredited • Water Servicing Co-ordinator
• Design and Project Management

1	29.10.87	PART 3A MAJOR PROJECT APPLICATION	AH
P1	15.10.07	INITIAL ISSUE	AH
Rev	Date	Amendment	Author

Project

JUSTINIAN HOUSE REDEVELOPMENT
Sydney Melanoma Unit - Mercy Foundation
18 - 22 Sinclair Street
Wollstonecraft NSW 2065

07 3136

project number
ROOF PLAN
STORMWATER
CONCEPT PLAN
drawing title

1:100 @ A1

0 1 2 3 4 5 6
12-Oct-07
HDA-09 1
drawing no. revision