




01 NORTH ELEVATION
1:200 @ A1

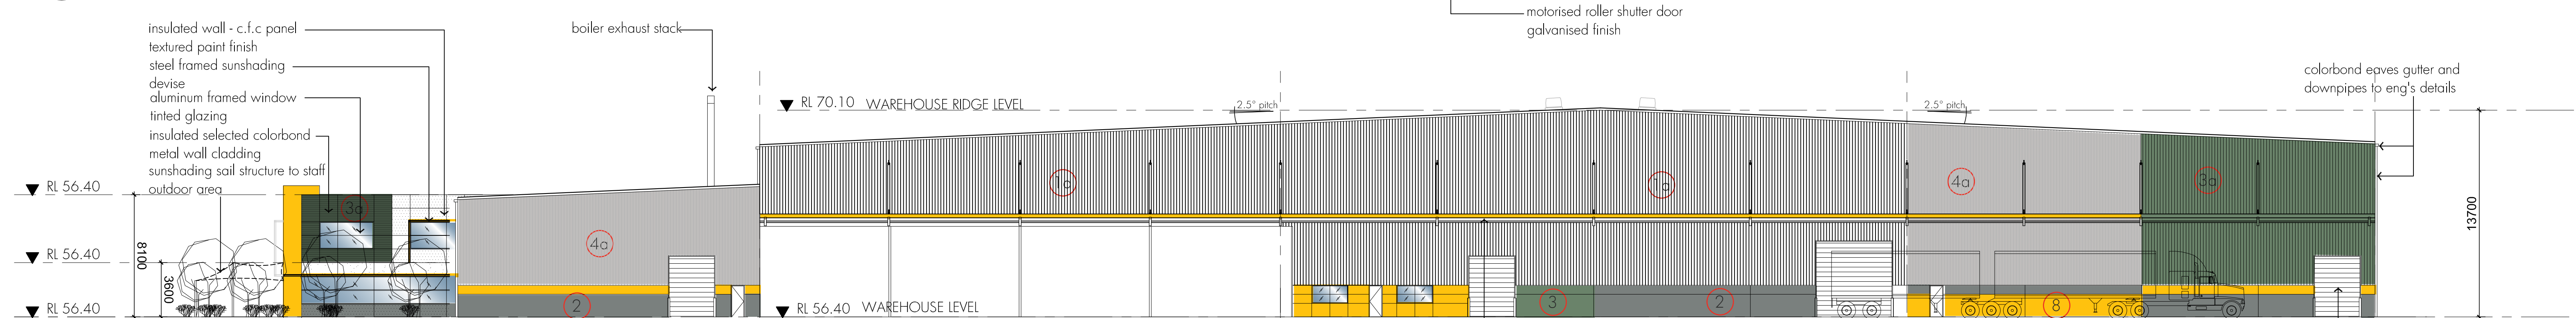

02 SOUTH ELEVATION
1:200 @ A1

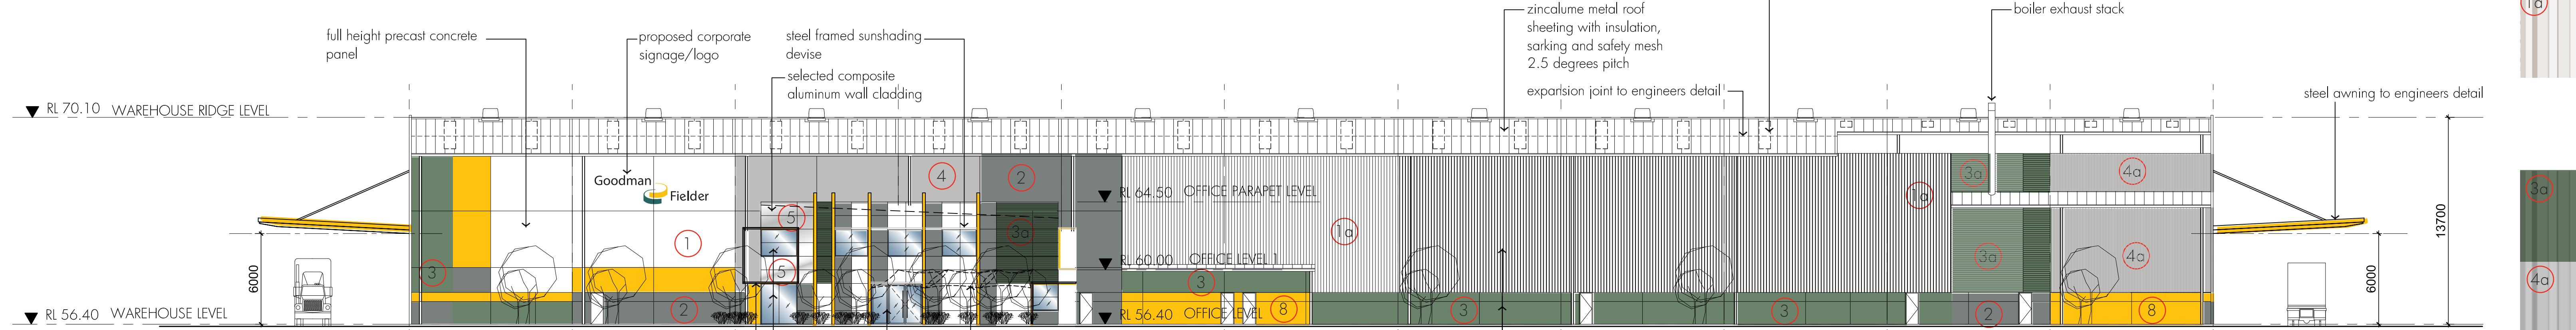


03 WEST ELEVATION
1:200 @ A1

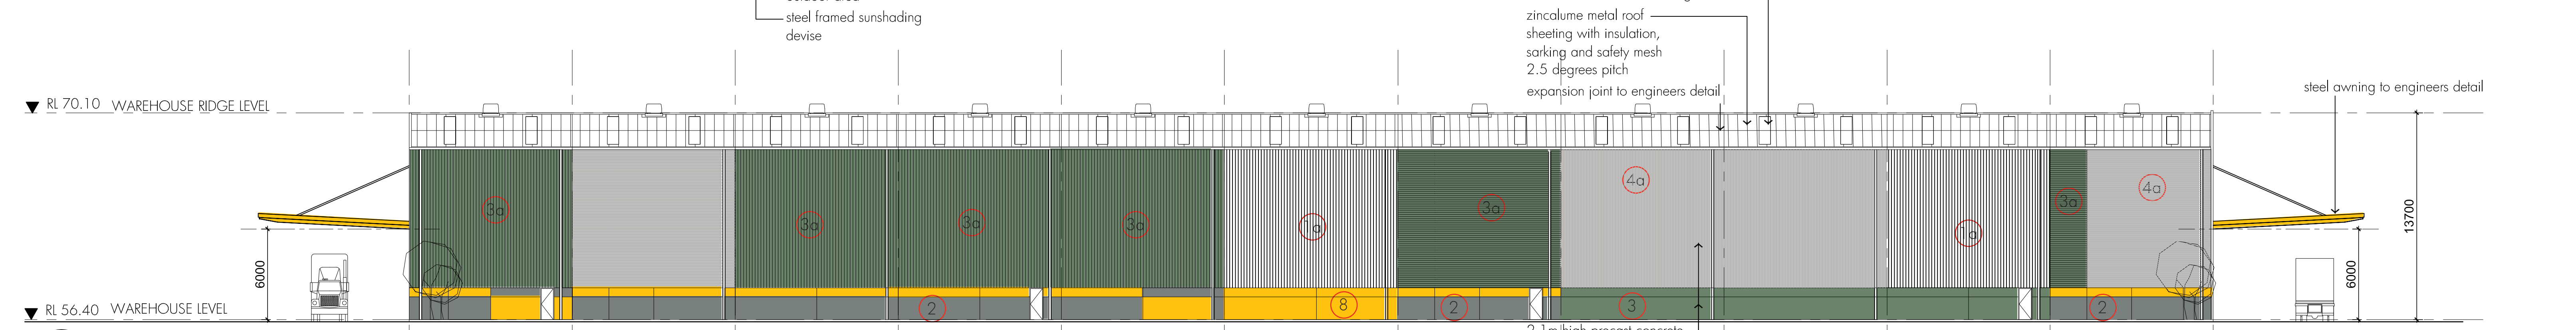

 
04 EAST ELEVATION
1:200 @ A1

LEGEND

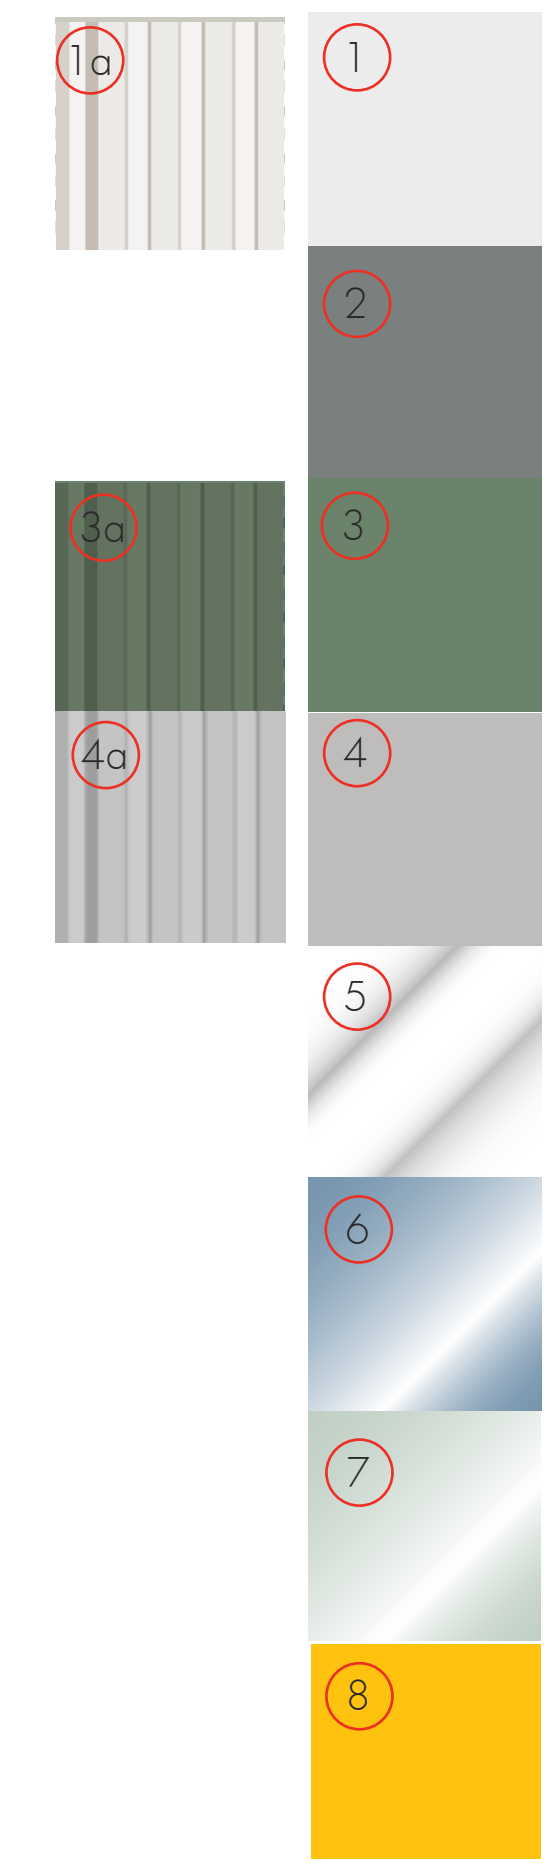

1. NATURAL WHITE
Office and Warehouse precast concrete walls,
Awning perimeter beams
Exit doors
Colorbond metal cladding (1a)
2. MID GREY
Precast concrete wall
3. GREEN WILDNESS (COLORBOND/ DULUX COLOUR MATCH)
Feature precast concrete walls
Exposed Office steel columns
Colorbond metal cladding (3a)
Precast concrete wall (3)
4. SHALE GREY (COLORBOND/ DULUX COLOUR MATCH)
Colorbond metal cladding, gutter, awning soffit
Colorbond metal cladding (4a)
Precast concrete wall (4)
Downpipes, Roller shutter doors
5. PREFINISHED METAL PANELS
Office cladding
6. SHALE GREY POWDERCOATED ALUMINIUM FRAME
TINTED GLAZING
7. WHITE COLOURBACK GLASS
Curtain Wall
8. SUNSHINE ORANGE
Precast concrete wall
Office Blade-wall

external colour & finishes

Notes: DO NOT SCALE OF DRAWING - DIMENSIONS & LEVELS TO BE VERIFIED PRIOR TO COMMENCEMENT OF WORK WITH FIGURED DIMENSIONS IN PREFERENCE TO SCALED DIMENSIONS. MATERIALS & WORKMANSHIP TO BE IN STRICT ACCORDANCE WITH ALL RELEVANT S.A.A. STANDARDS, BCA & LOCAL AUTHORITIES REQUIREMENTS. COPYRIGHT - THIS DRAWING IS SUBJECT TO COPYRIGHT AND IS THE PROPERTY OF THE AUTHOR. THIS DRAWING MUST NOT BE RETAINED, COPIED OR USED WITHOUT THE GIVEN AUTHORITY OF SPSPACE DESIGN PTY LTD. Sheet Size - B1	Revisions:	Structural Consultant:		Hydraulic Consultant:		Electrical Consultant:		Builder:		 Suite 505 147 King Street Sydney NSW 2000 ph: (02) 9232 7760 fax: (02) 9231 2717 email: robpaul@spspacedesign.com.au SPSPACE DESIGN PTY LTD ABN 331 205 266 50	Project:		Drawing		
	A 25/03/08	DA PRELIMINARY ISSUED							 Hansen Yuncken Pty Ltd Level 4, 1 Rosebery Avenue Rosebery NSW 2018 ph: (02) 9770 7600 fax: (02) 9770 7601		 GOODMAN FIELDER		DEVELOPMENT APPLICATION		
	B 10/04/08	ISSUED FOR DA SUBMISSION									SITE E, TEMPLAR ROAD, ERSKINE PARK		OVERALL ELEVATIONS		
		Mechanical Consultant:		Landscape Consultant:		Fire Consultant:		Project Manager:				Scales:	Date:	Drawn:	
												AS SHOWN	25 MARCH 2008	AW	
												Project No:	Drawing No:	Issue:	
												08000	GF-TE-DA-200	B	