


BUILDING STUDIO.


ROYAL NORTH SHORE HOSPITAL CLINICAL SERVICES BUILDING

SECTION 75W COMPARITIVE STUDY
28 FEBRUARY 2013

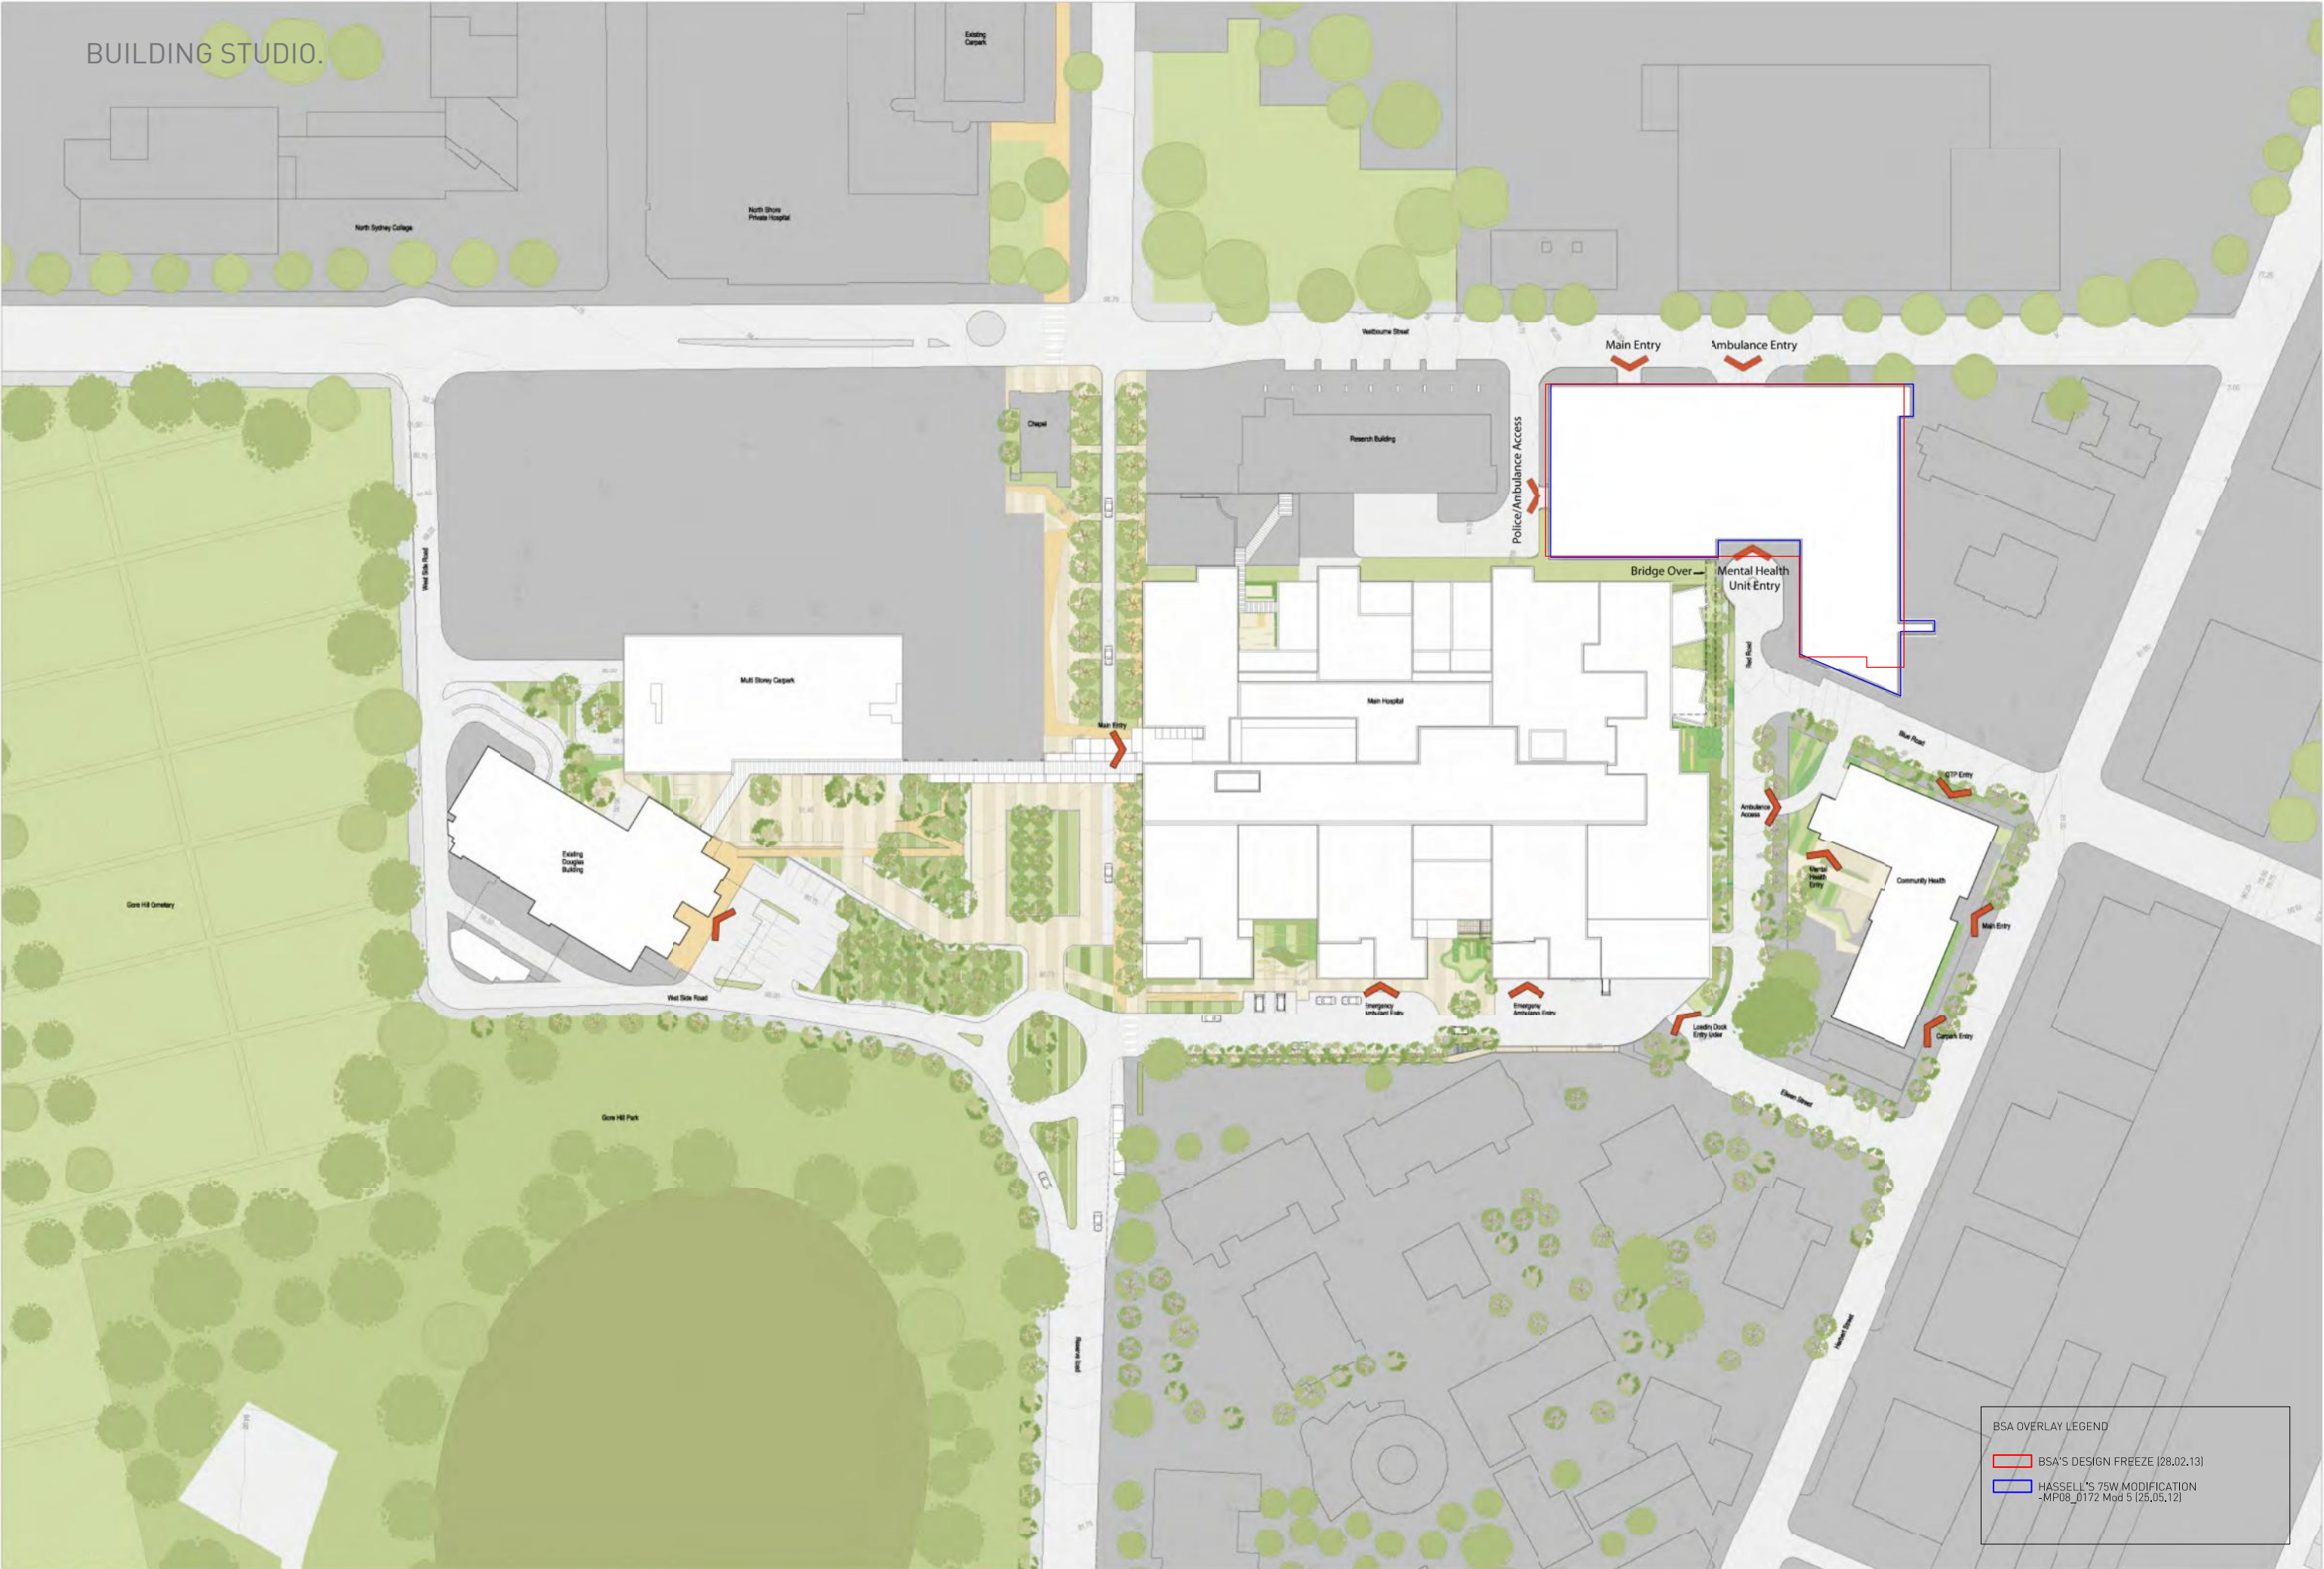

PLANT SPACE

- VERTICAL CIRCULATION
- PLANT
- FS ESCAPE TUNNEL

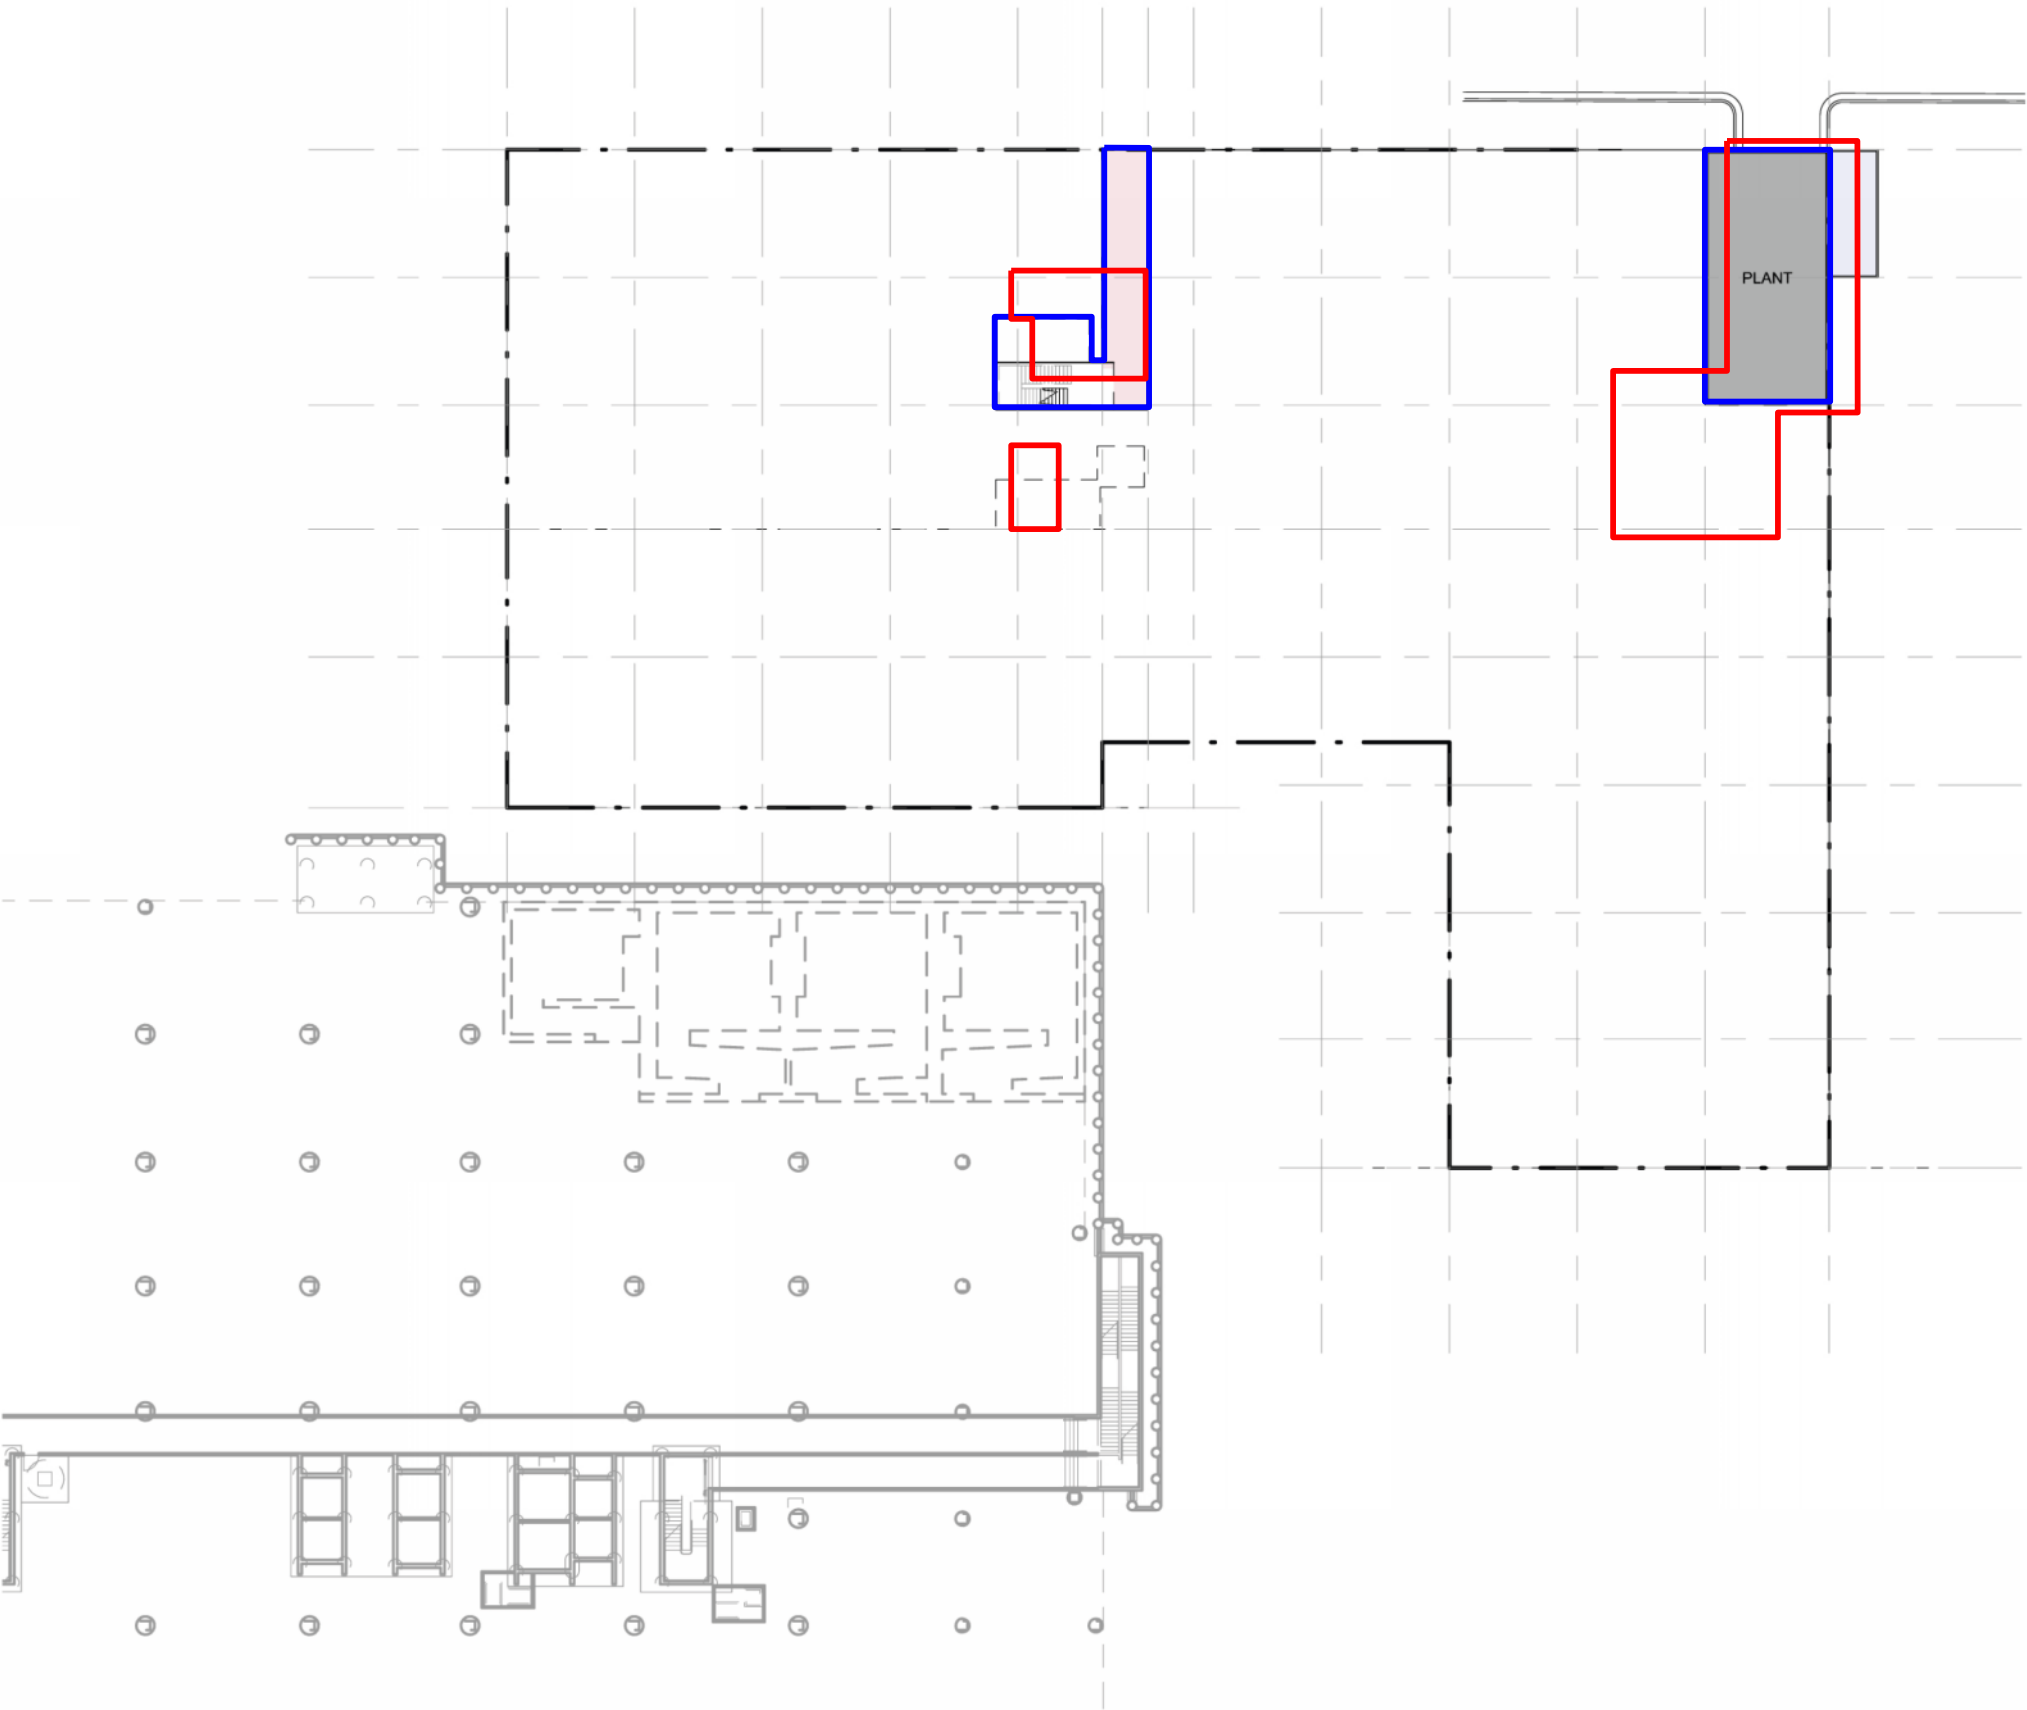

BSA OVERLAY LEGEND

- BSA'S DESIGN FREEZE (28.02.13)
- HASSELL'S 75W MODIFICATION -MP08_0172 Mod 5 (25.05.12)




ROYAL NORTH
SHORE HOSPITAL
CLINICAL
SERVICES
BUILDING



CONCEPT PLAN
Level 0 (RL 80.600)

Project Number AX003226
Scale 1:500 @ A3
Drawing A100
Date 12/12/2011

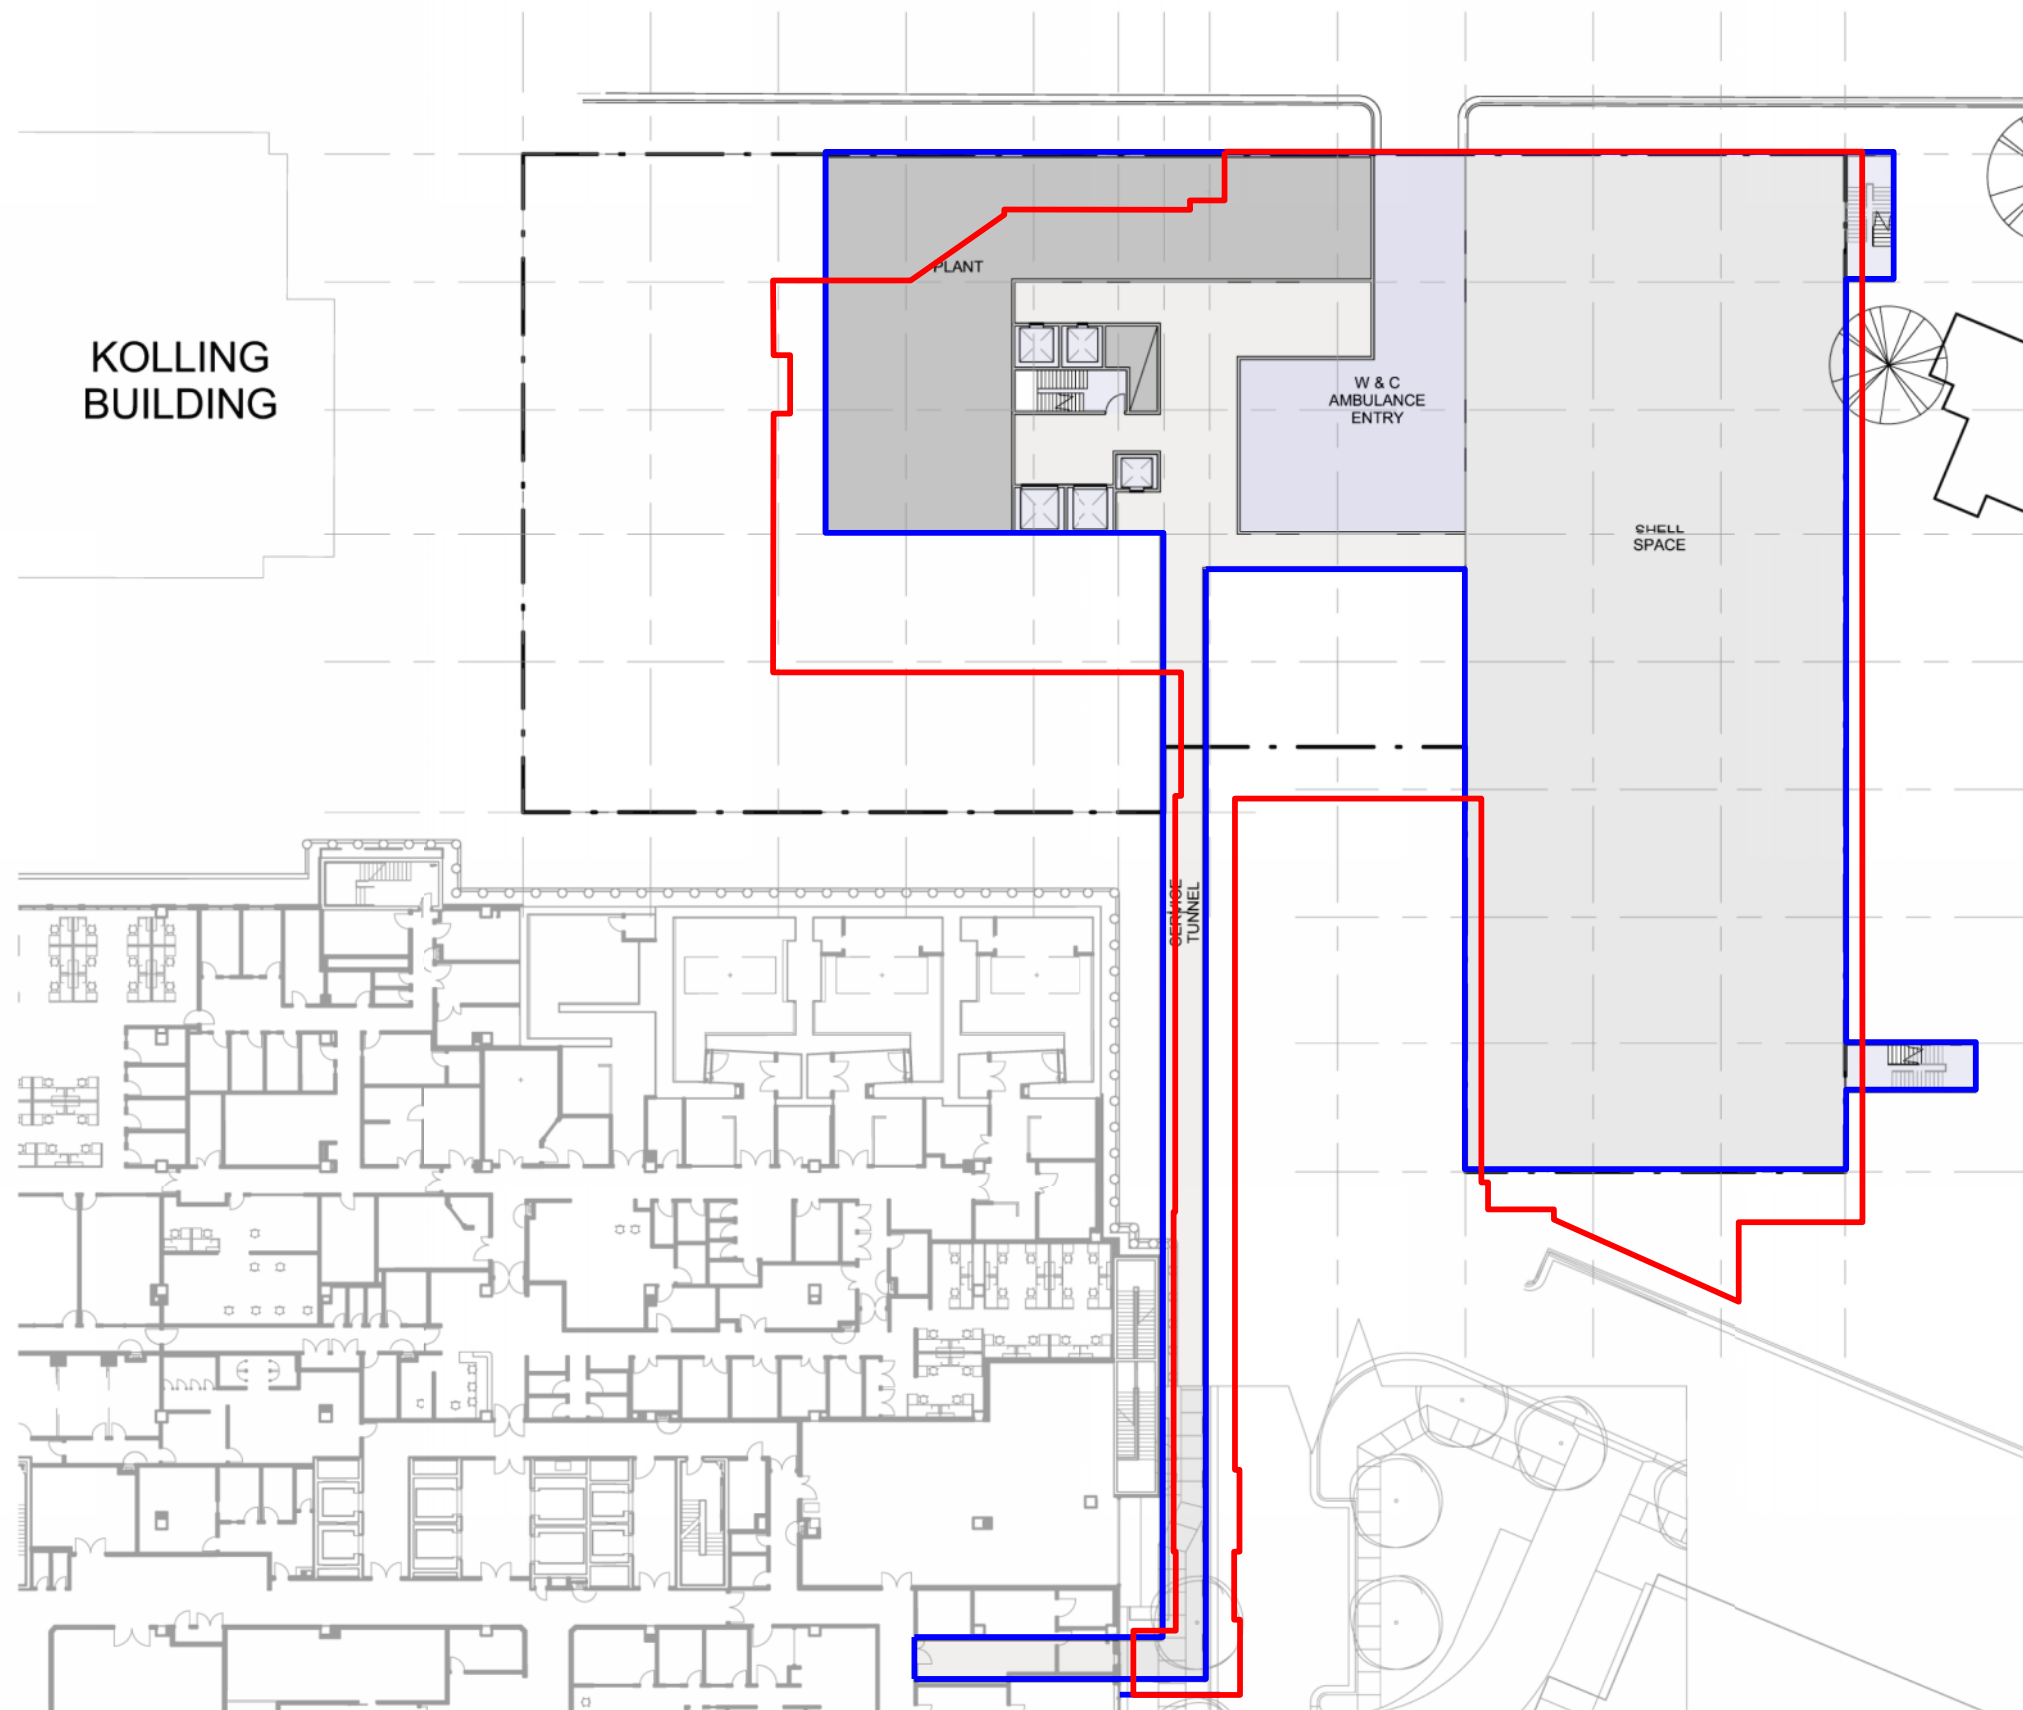


W & C AMBULANCE ENTRY

- CIRCULATION
- SHELL SPACE
- W & C
- VERTICAL CIRCULATION
- PLANT / SHELL SPACE

BSA OVERLAY LEGEND

- BSA'S DESIGN FREEZE (28.02.13)
- HASSELL'S 75W MODIFICATION -MP08_0172 Mod 5 (25.05.12)

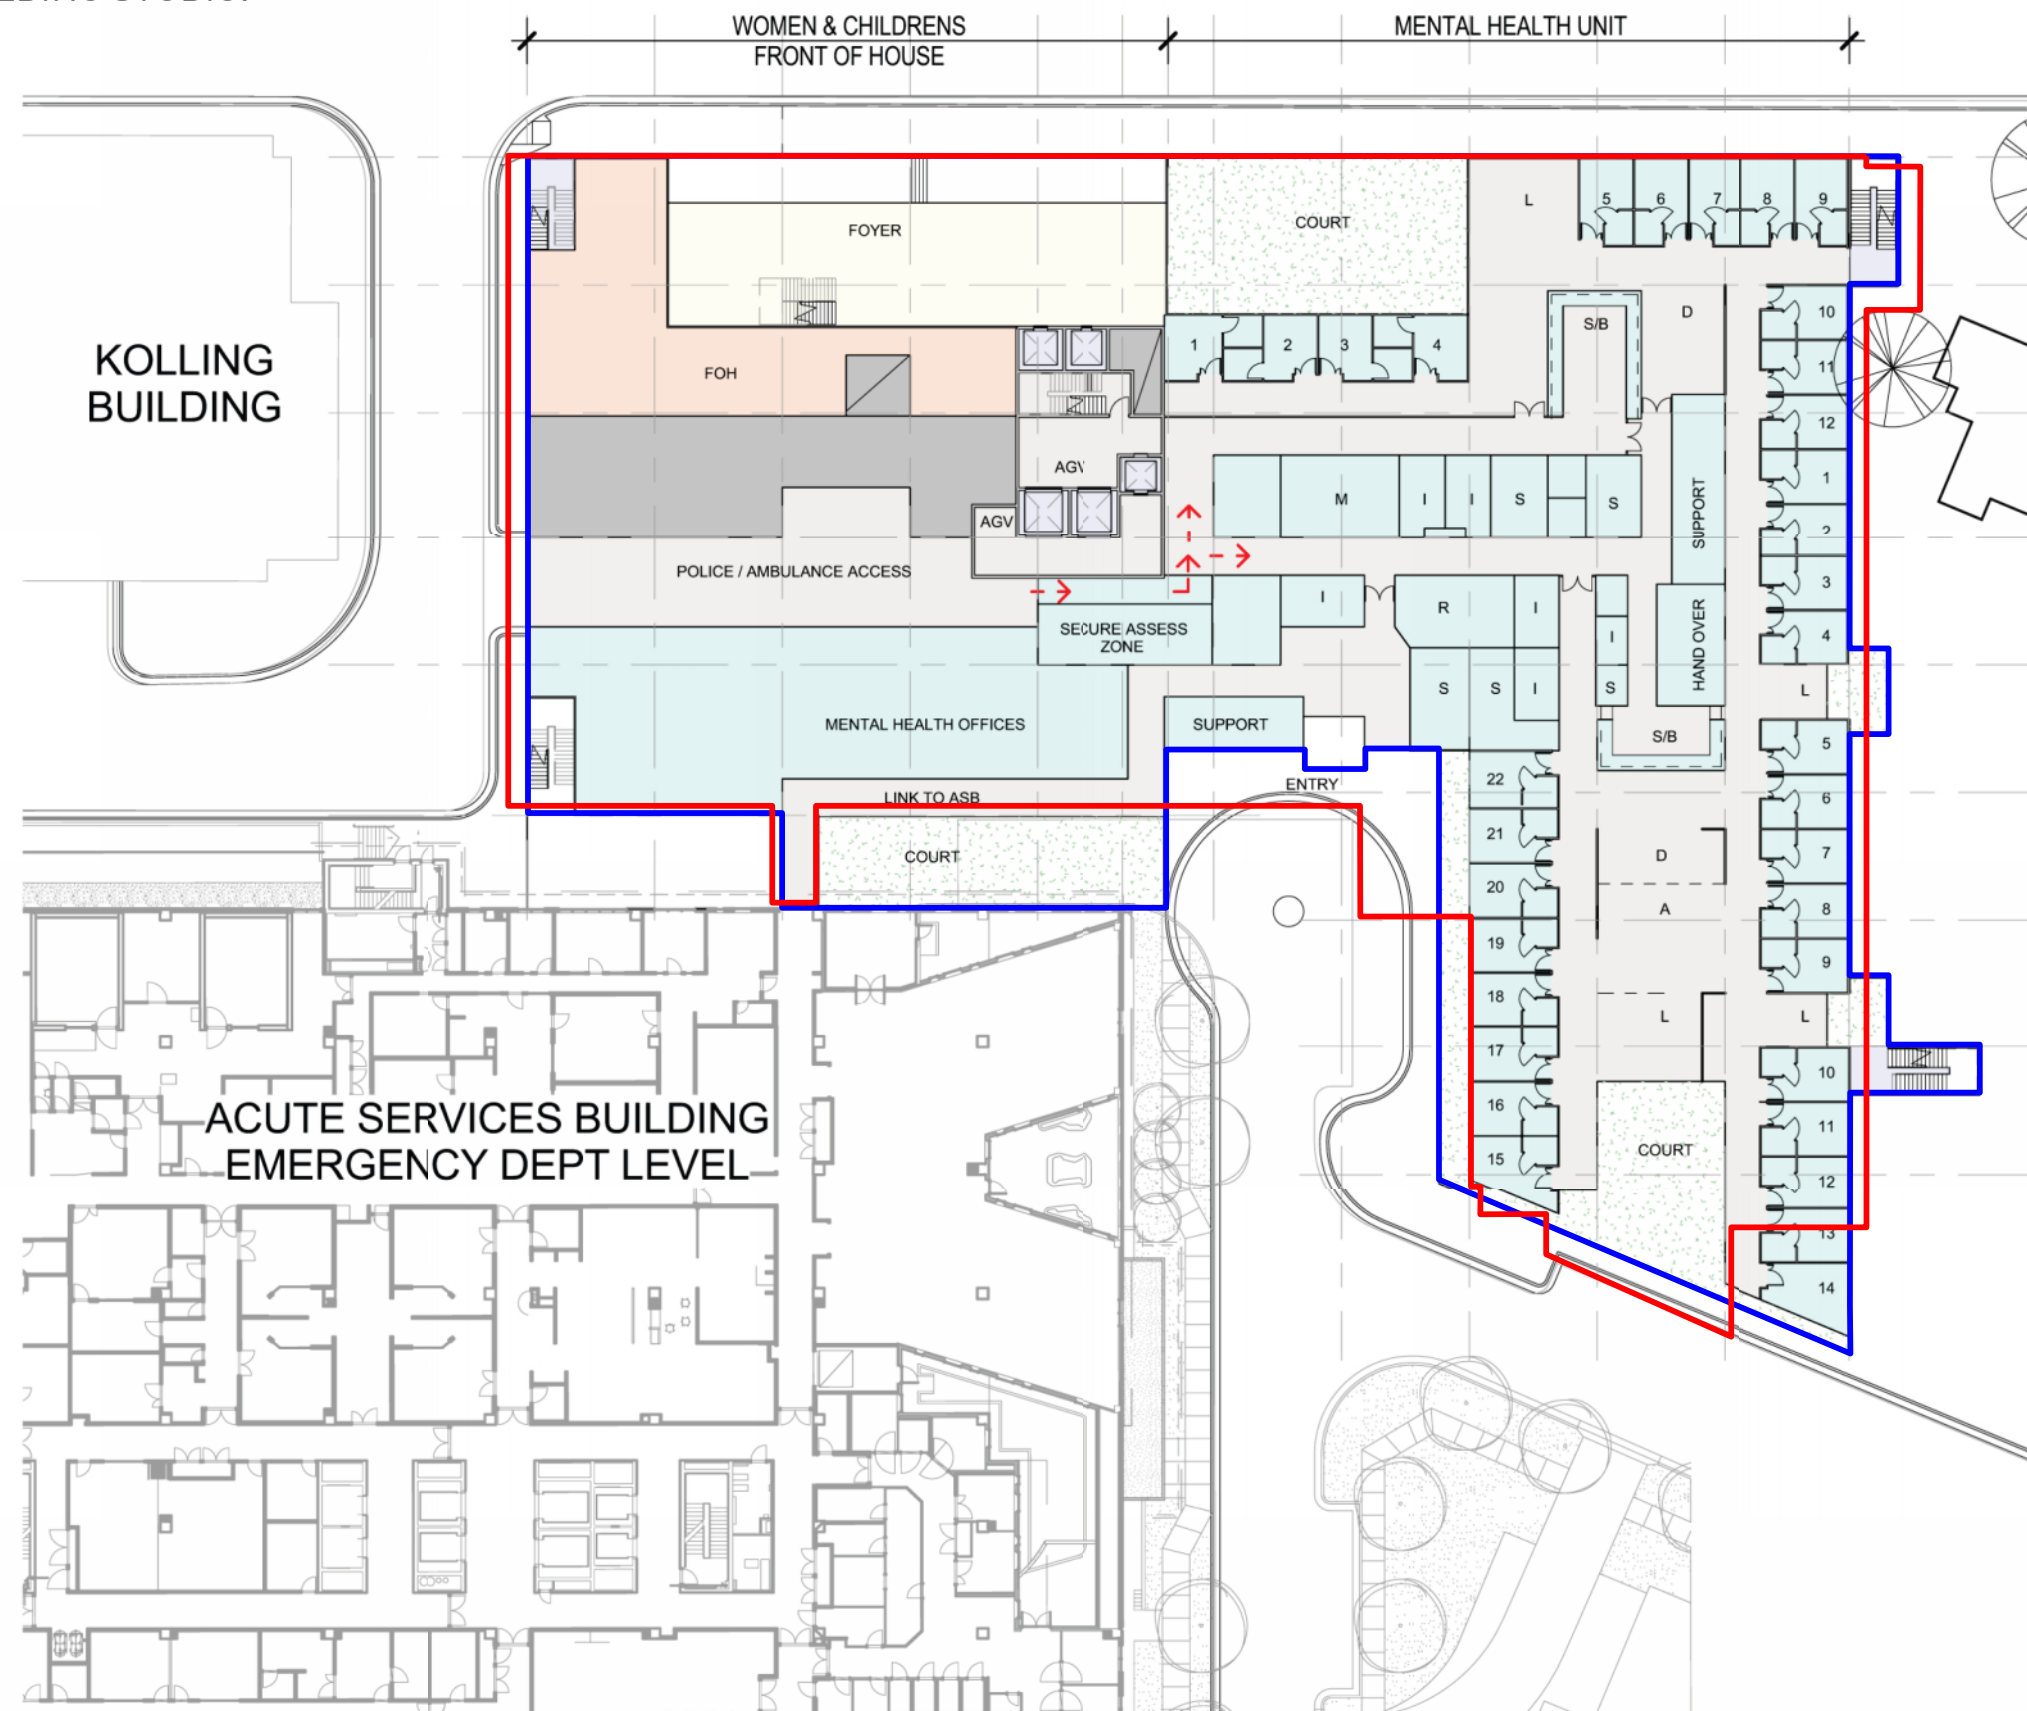


W & C ENTRY AND MENTAL HEALTH IPU & OFFICES

- CIRCULATION
- FOYER
- FRONT OF HOUSE
- MENTAL HEALTH UNIT
- PLANT / SHELL SPACE
- TERRACE
- VERTICAL CIRCULATION

BSA OVERLAY LEGEND

- BSA'S DESIGN FREEZE (28.02.13)
- HASSELL'S 75W MODIFICATION -MP08_0172 Mod 5 (25.05.12)

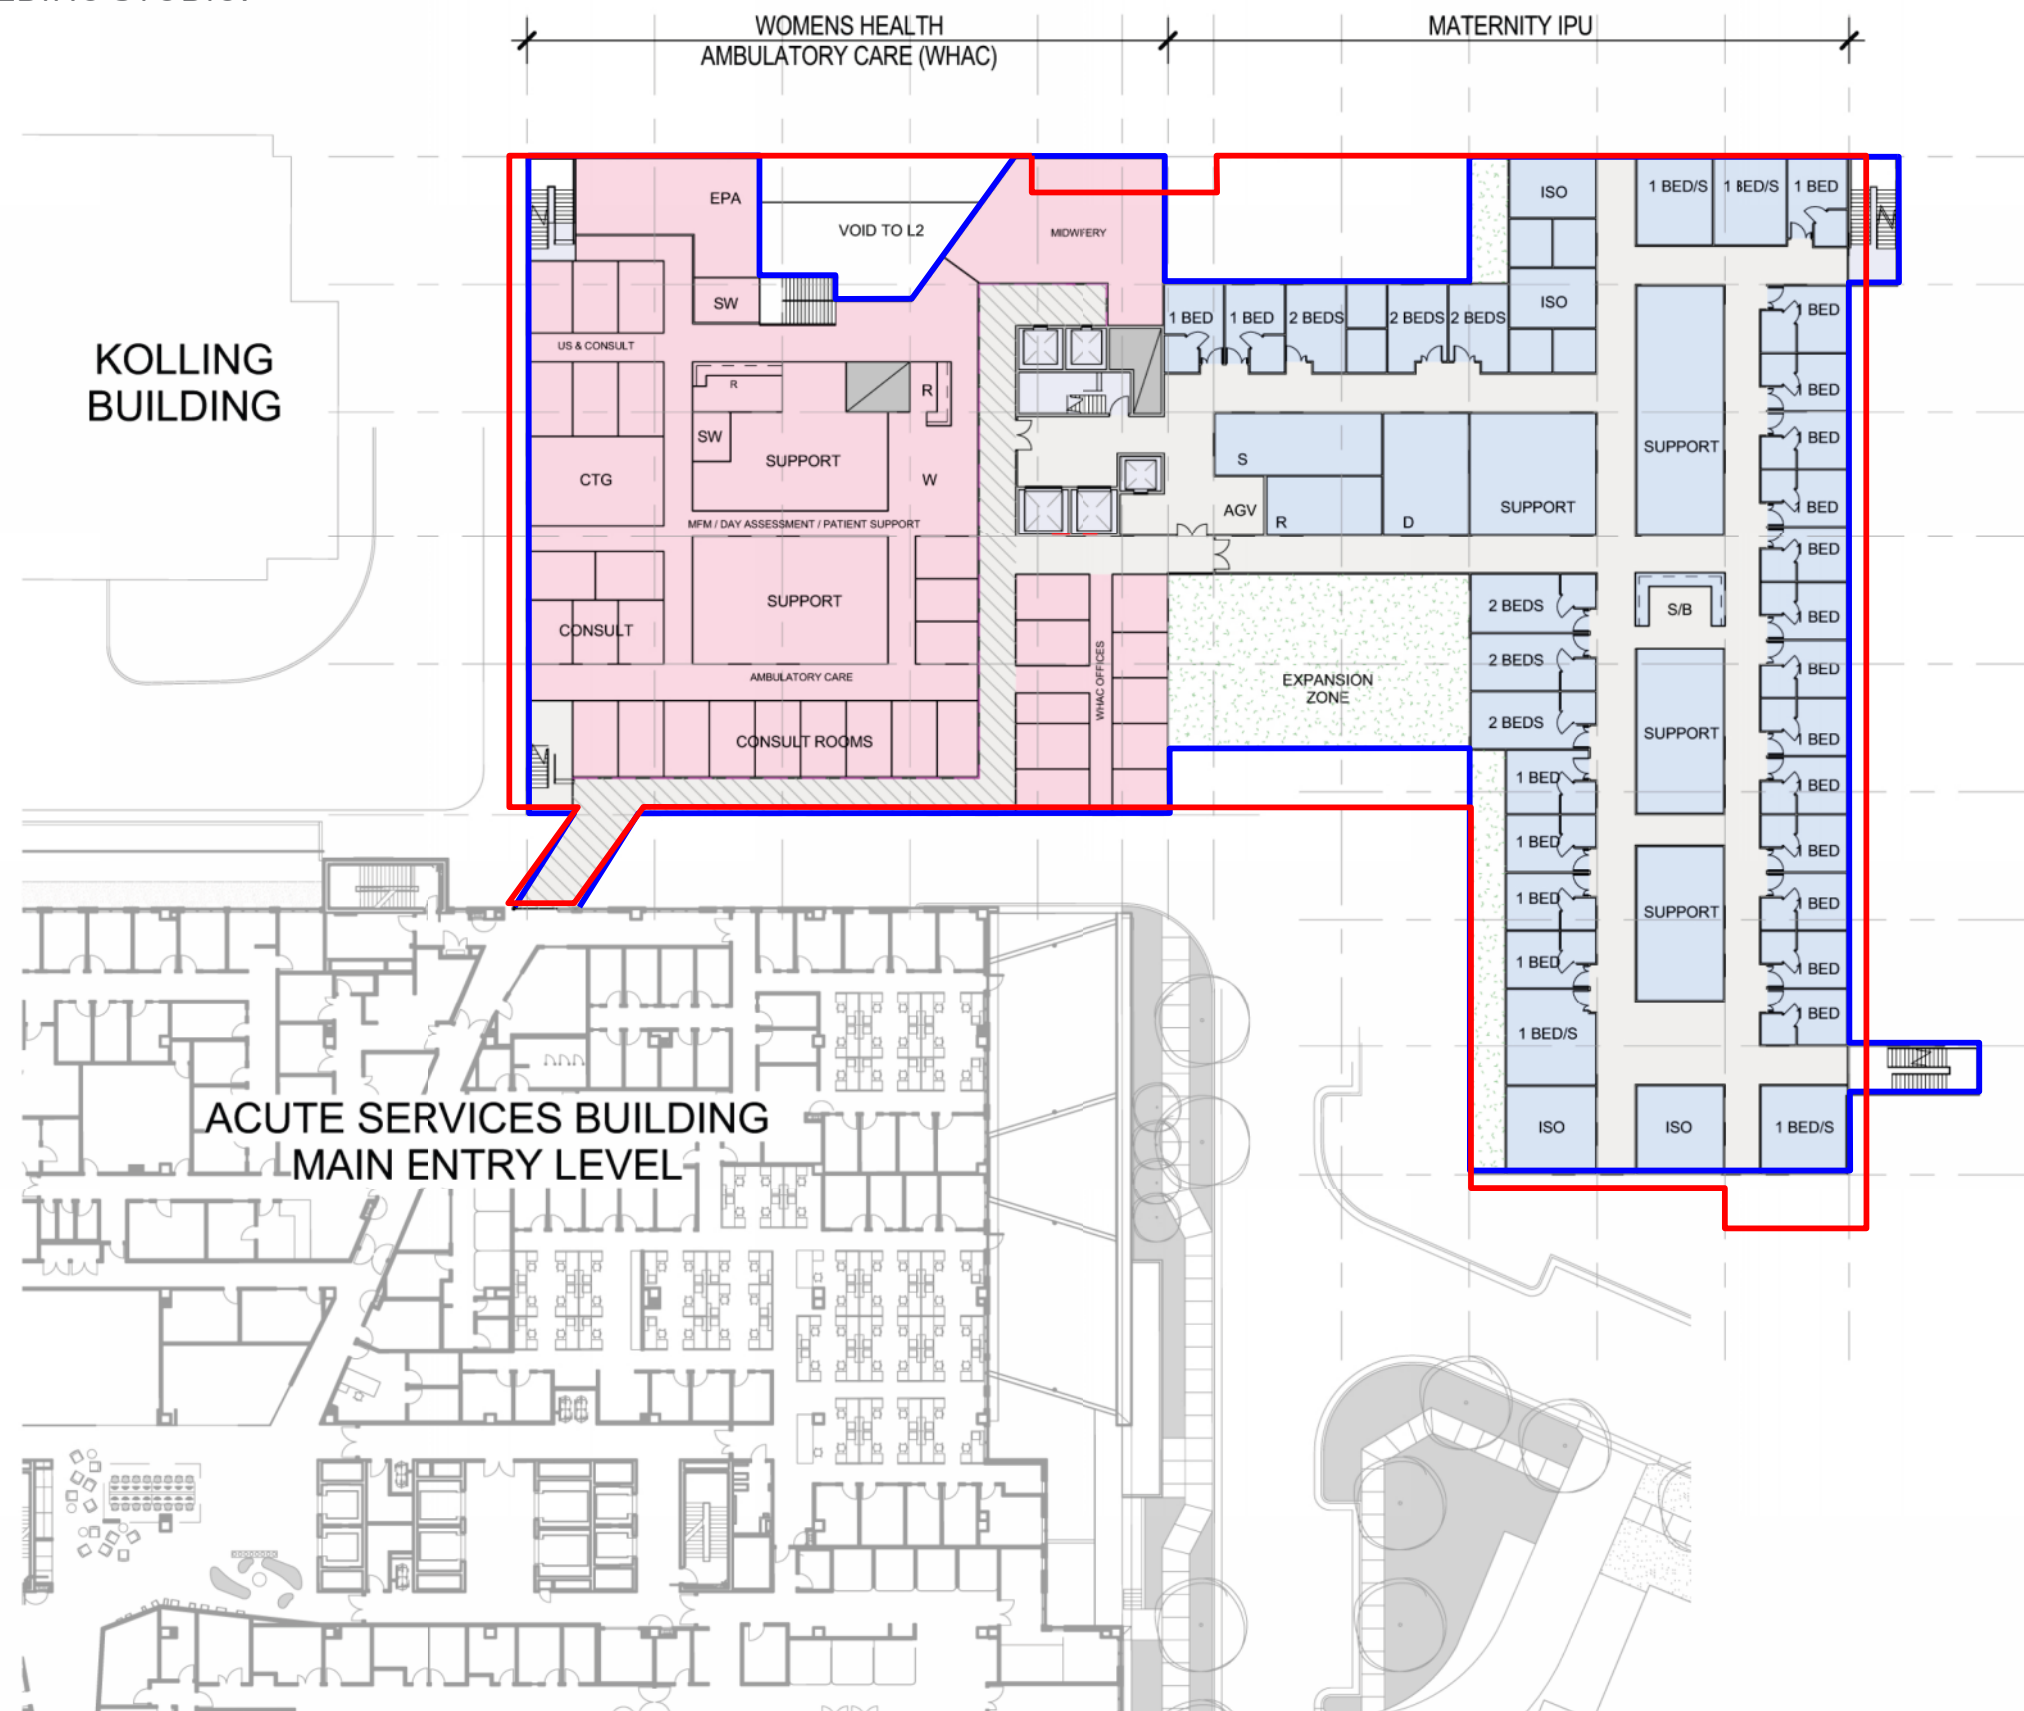


WOMEN'S HEALTH AMBULATORY CARE & MATERNITY IPU

- CIRCULATION
- MATERNITY IPU
- TERRACE
- VERTICAL CIRCULATION
- PLANT / SHELL SPACE
- WOMEN'S HEALTH UNIT AMBULATORY CARE

BSA OVERLAY LEGEND

- BSA'S DESIGN FREEZE (28.02.13)
- HASSELL'S 75W MODIFICATION -MP08_0172 Mod 5 (25.05.12)

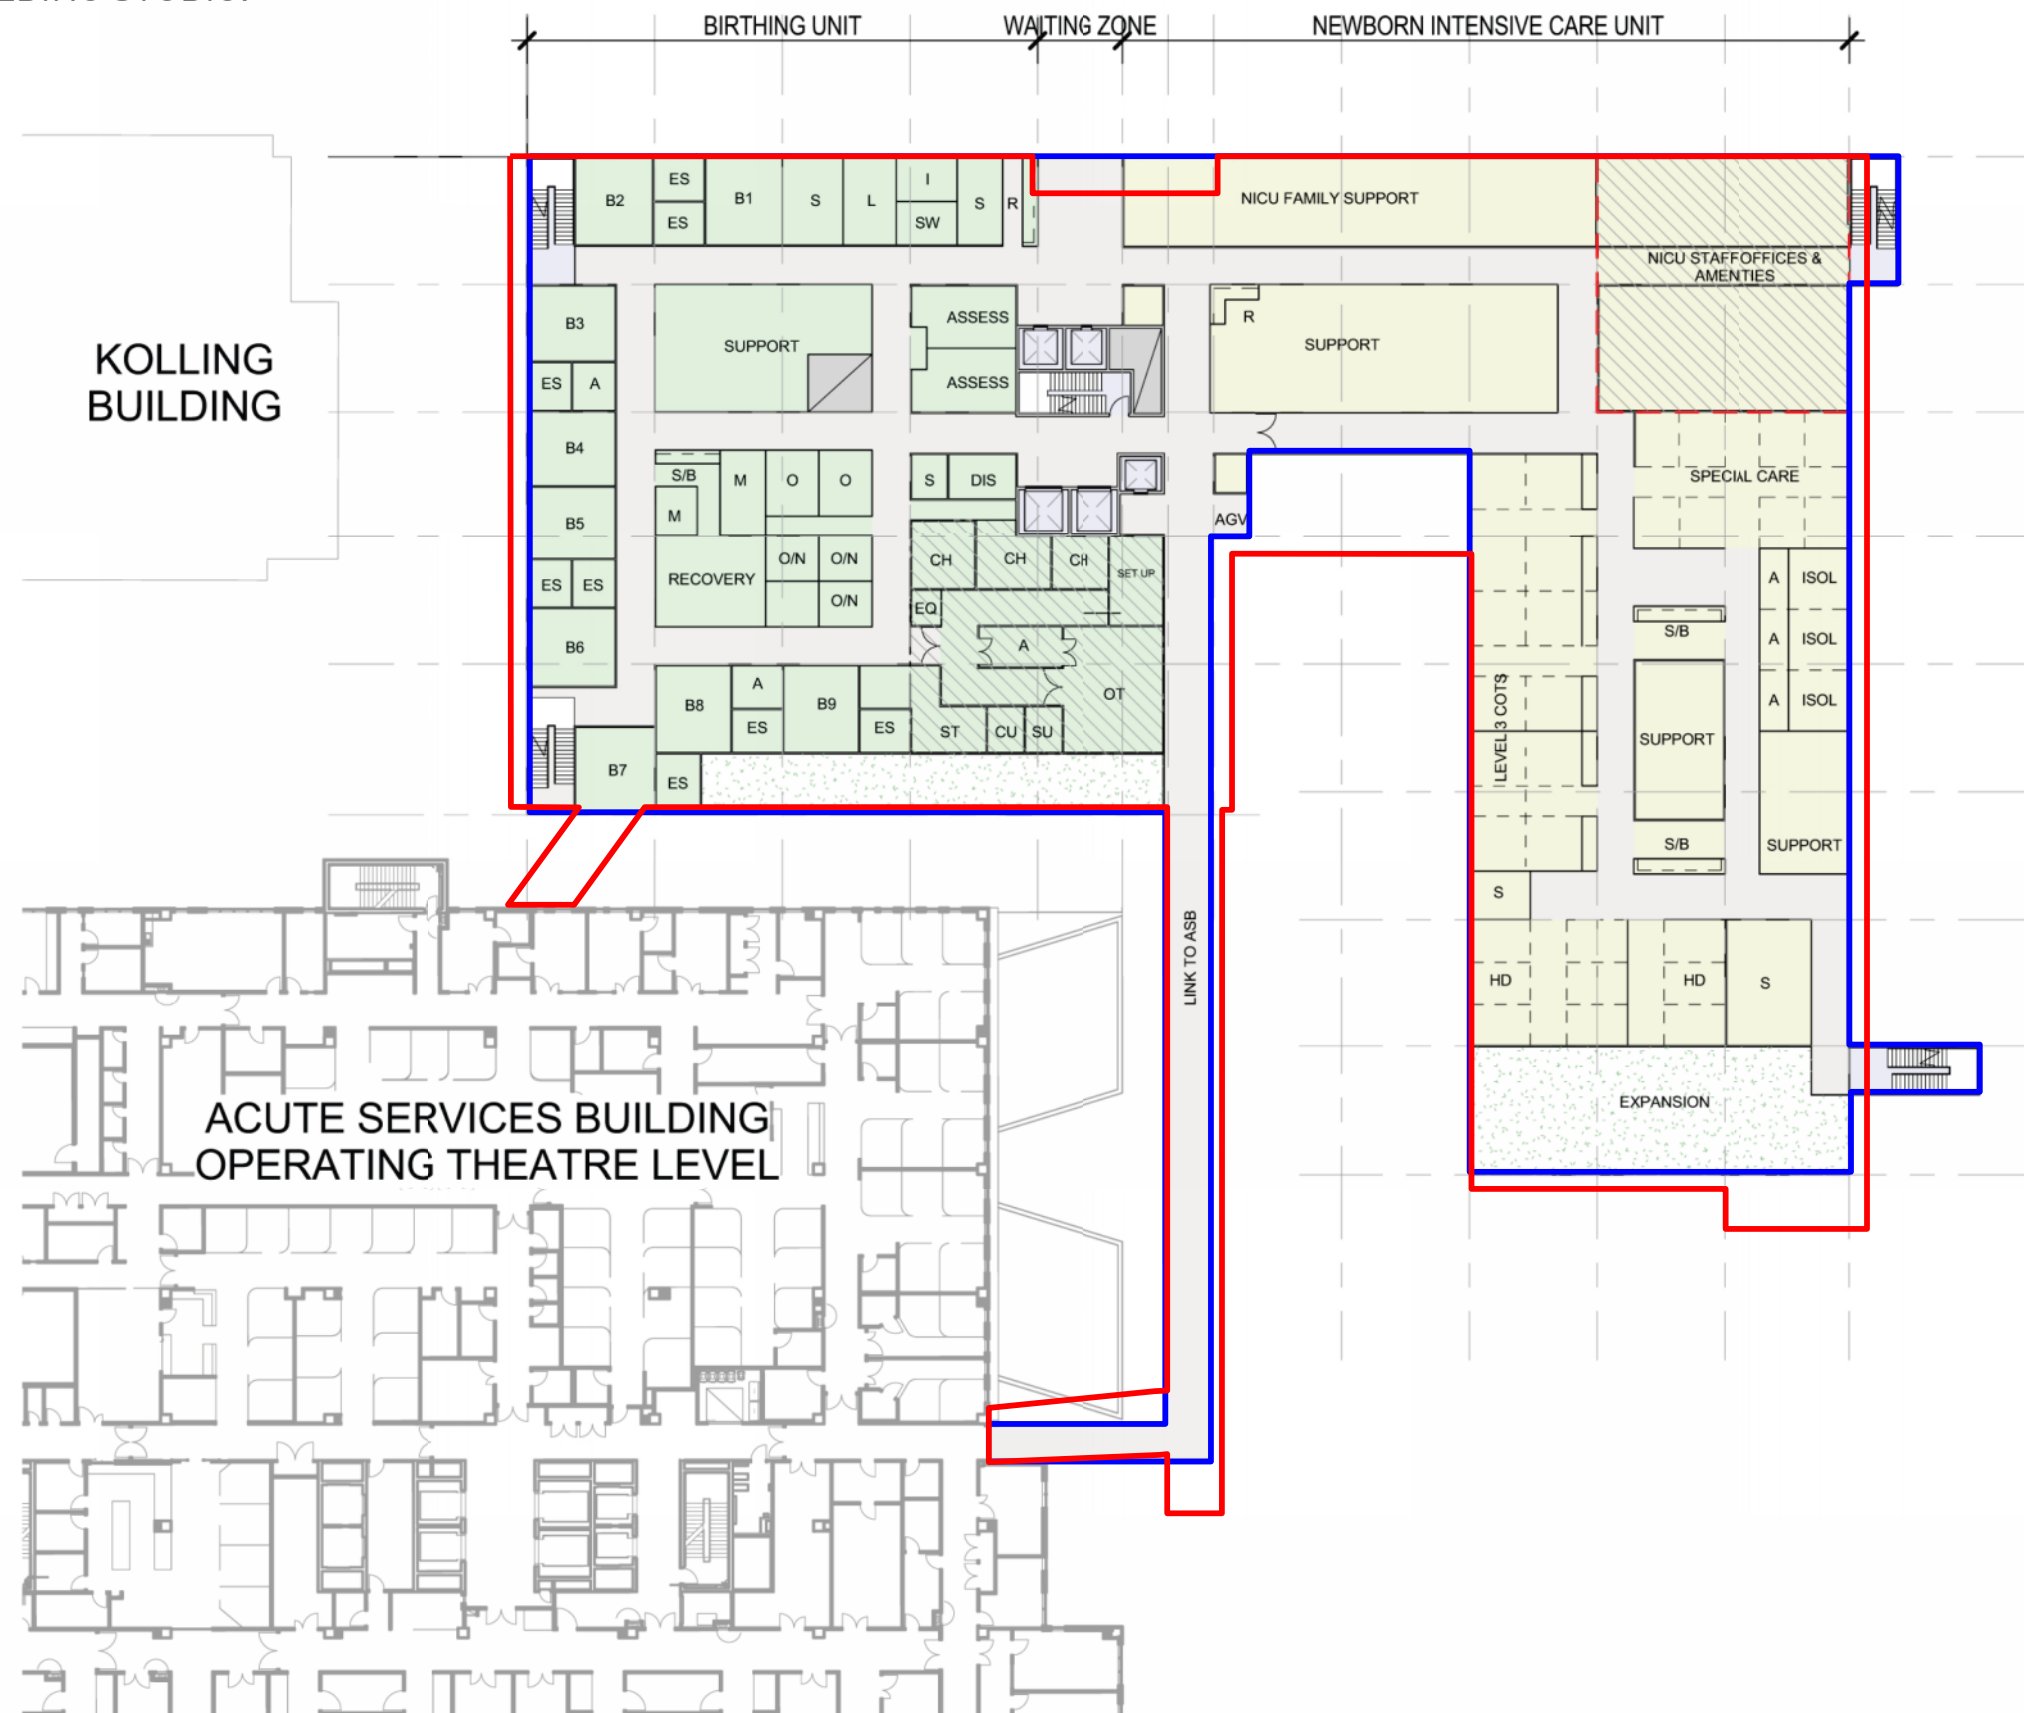

BIRTHING & NICU

- BIRTHING UNIT
- CIRCULATION
- NEWBORN INTENSIVE CARE UNIT
- TERRACE
- VERTICAL CIRCULATION
- ENGINEERING

BSA OVERLAY LEGEND

 BSA'S DESIGN FREEZE (28.02.13)

 HASSELL'S 75W MODIFICATION -MP08_0172 Mod 5 (25.05.12)


INPATIENT WARD

- CIRCULATION
- TERRACE
- VERTICAL CIRCULATION
- ENGINEERING
- IN PATIENT WARD
- SHARED STAFF AREA
- SHARED PATIENT AREA

BSA OVERLAY LEGEND

BSA'S DESIGN FREEZE (28.02.13)

HASSELL'S 75W MODIFICATION
-MP08_0172 Mod 5 (25.05.12)

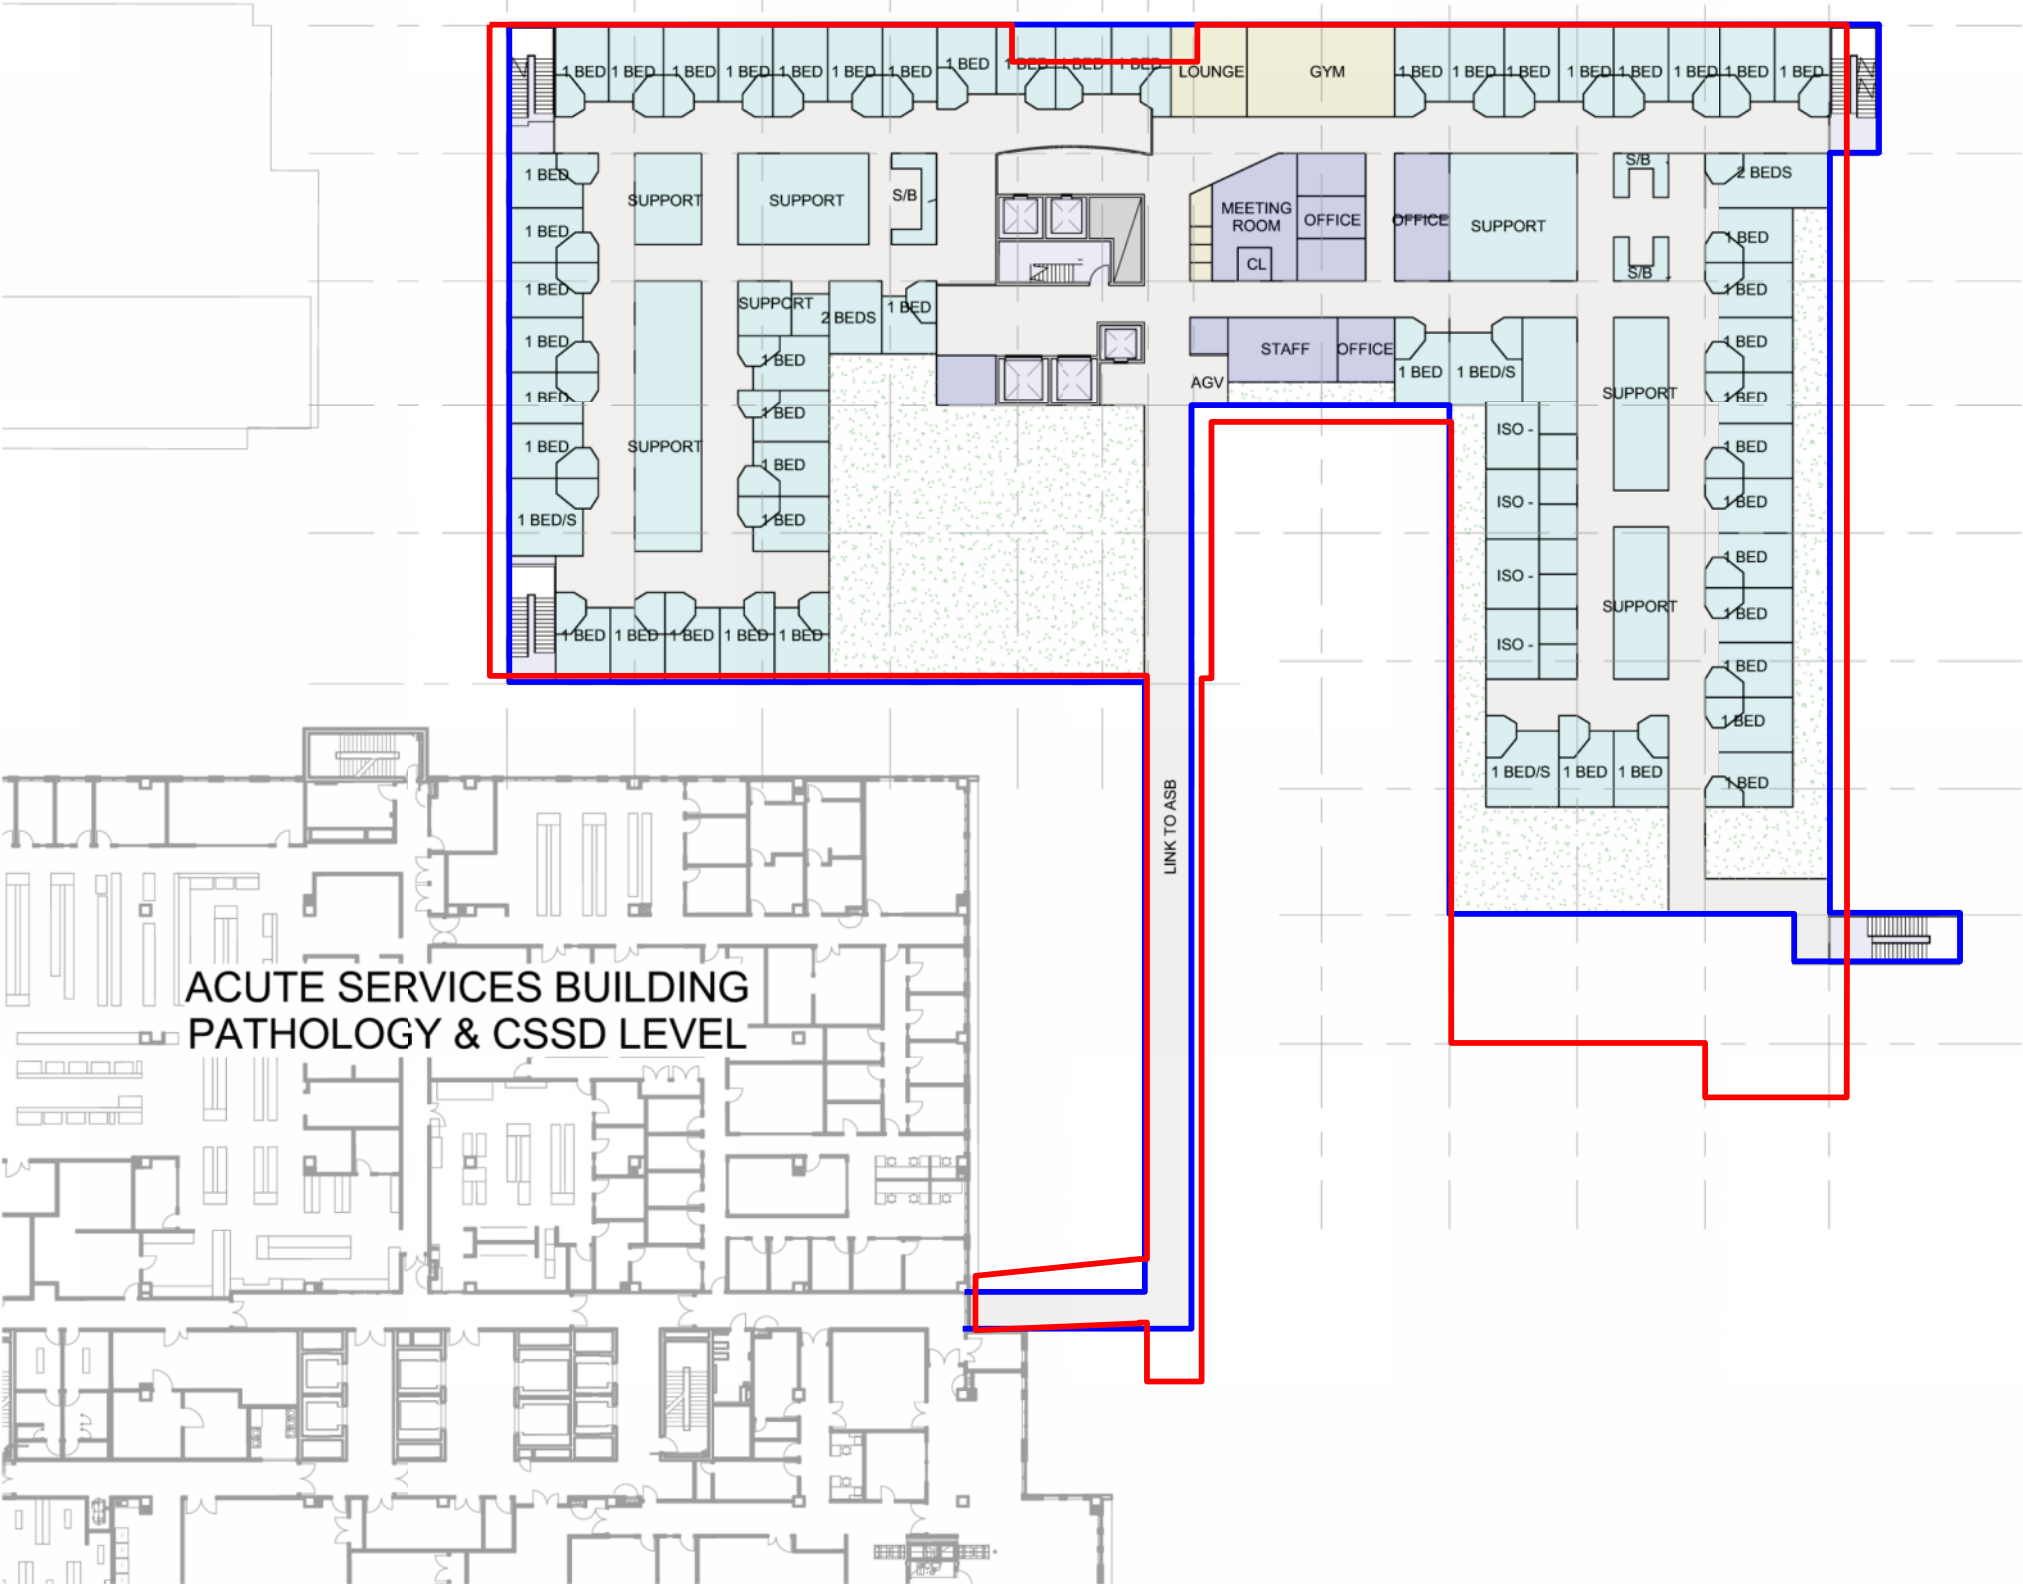









ROYAL NORTH
SHORE HOSPITAL
CLINICAL
SERVICES
BUILDING





CONCEPT PLAN
Level 5 (RL 103.20)

 Project Number AX003226
Scale 1:500 @ A3
Drawing A105
Date 12/12/2011



-  BURNS IPU
-  CIRCULATION
-  OFFICES
-  TERRACE
-  VERTICAL CIRCULATION
-  COMBINED OFFICES
-  BURNS IPU & AMB CARE CLINIC
-  PLANT

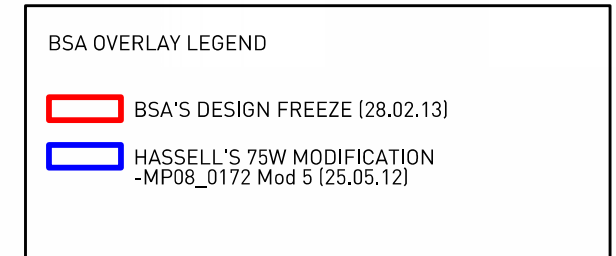

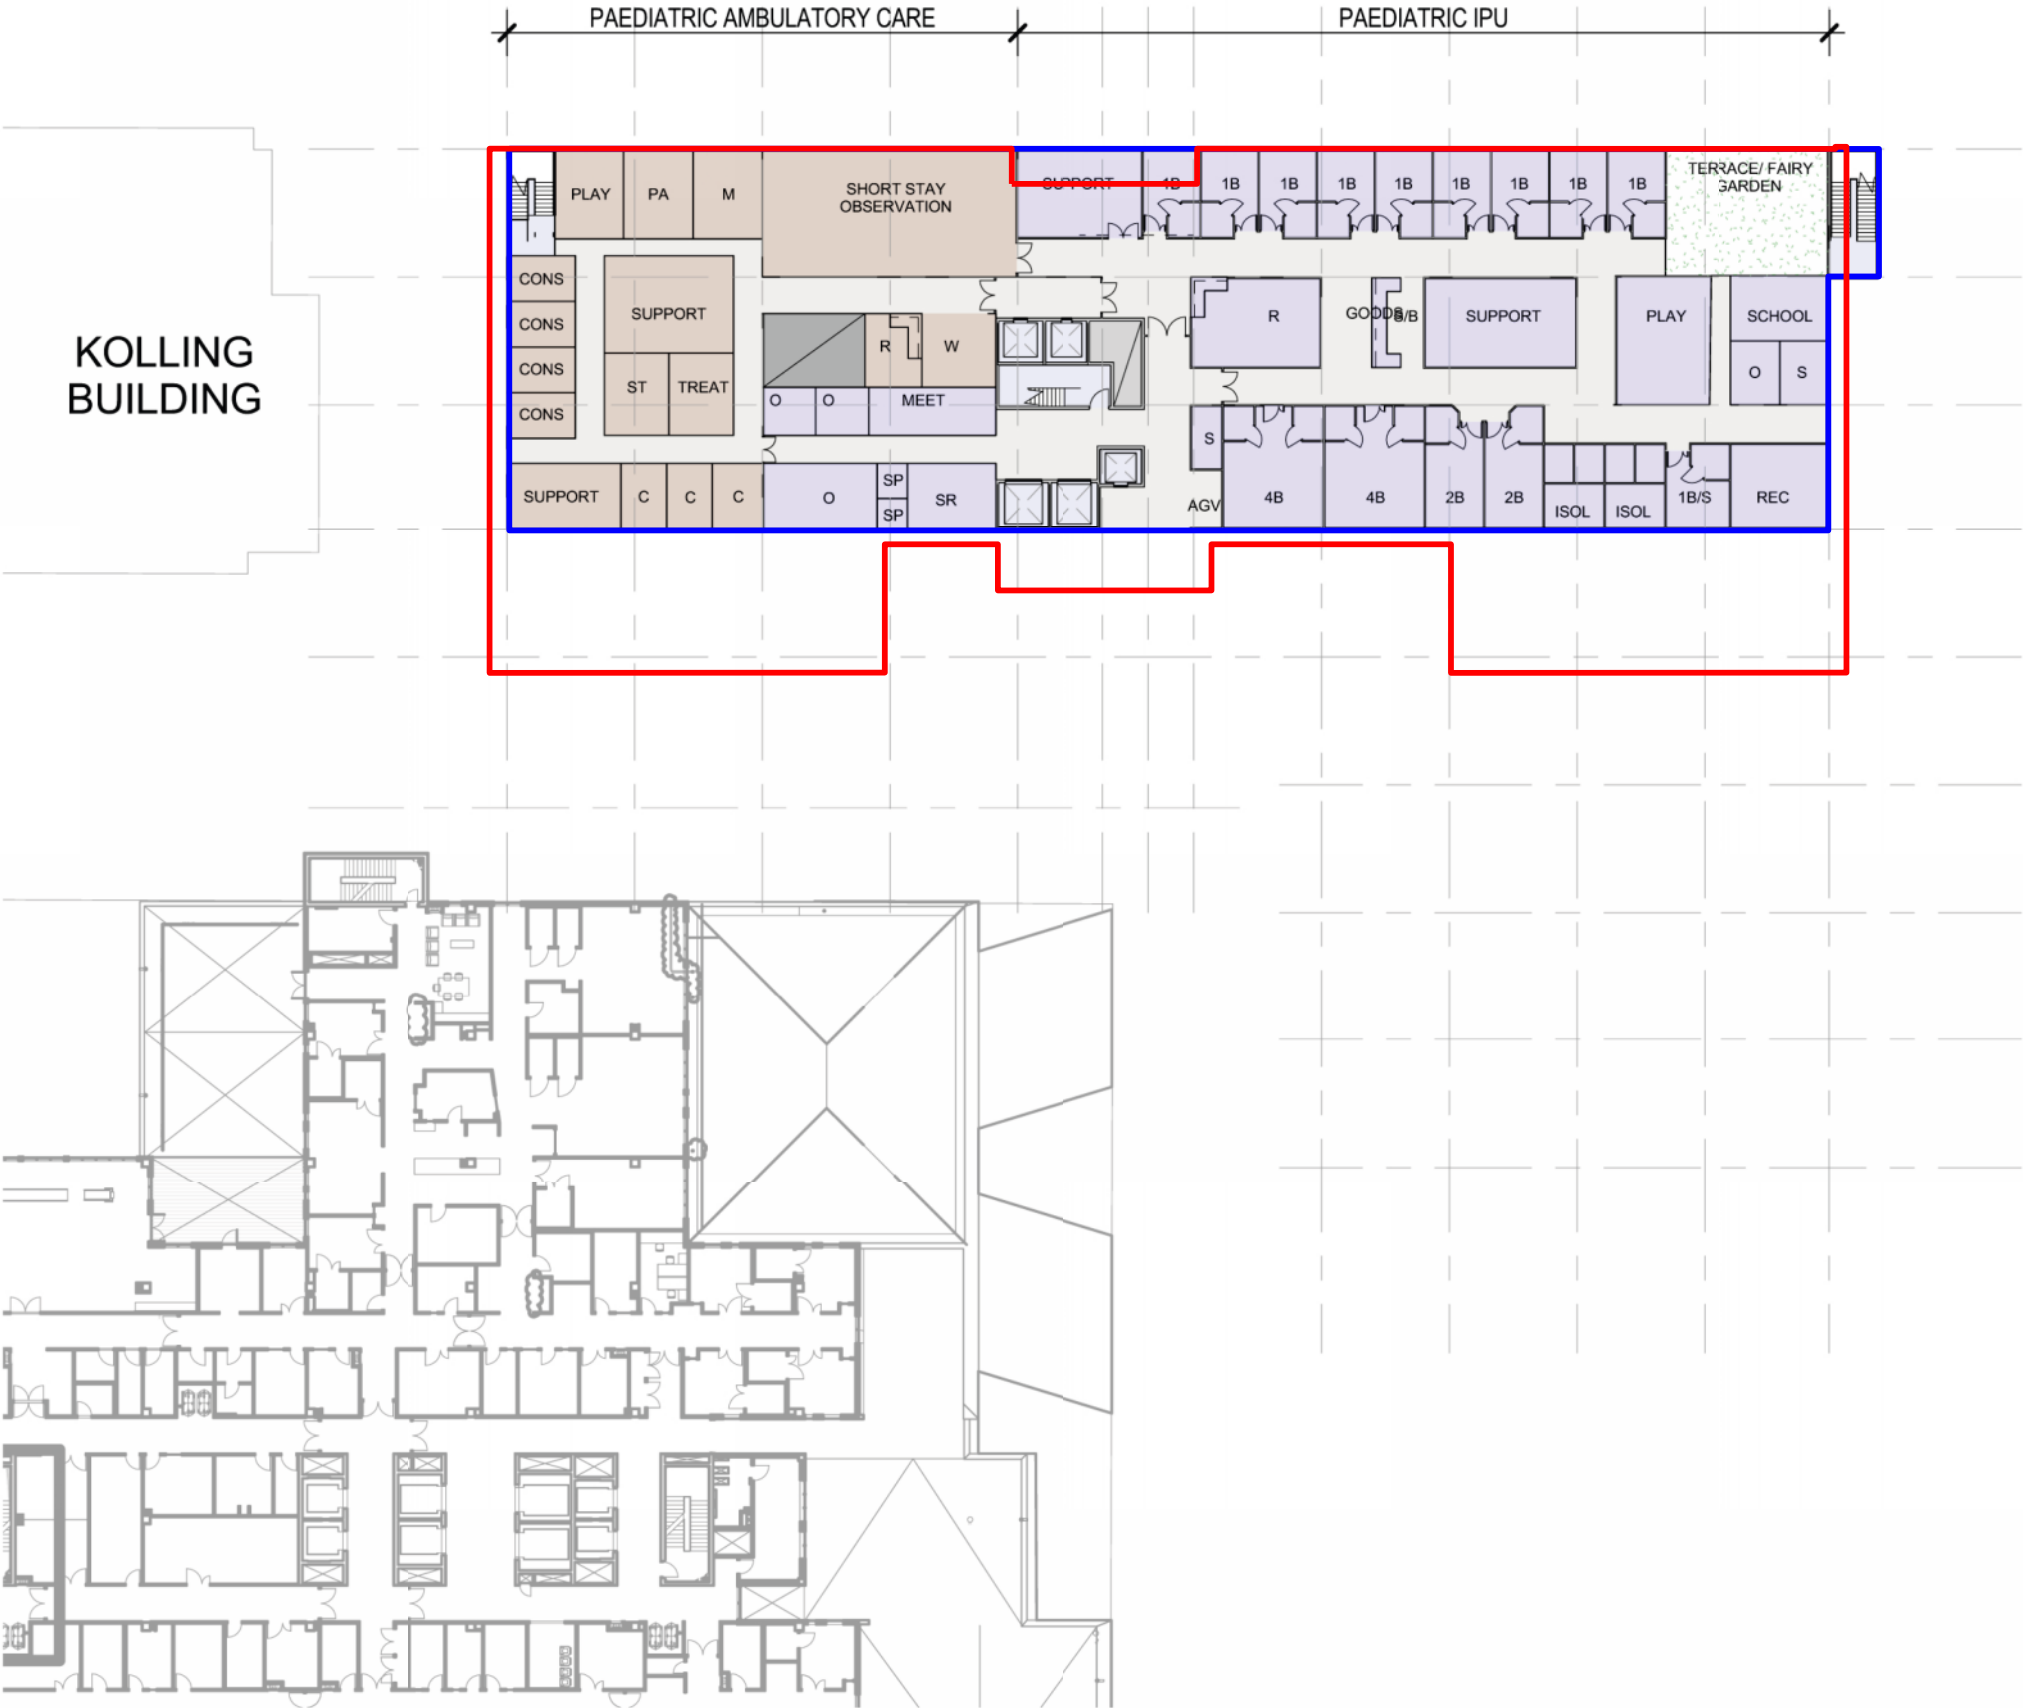

PAEDIATRIC IPU & AMB CARE

- CIRCULATION
- PAEDIATRIC AMBULATORY CARE
- PAEDIATRIC IPU
- TERRACE
- VERTICAL CIRCULATION
- ENGINEERING
- PLANT

BSA OVERLAY LEGEND

- BSA'S DESIGN FREEZE (28.02.13)
- HASSELL'S 75W MODIFICATION -MP08_0172 Mod 5 (25.05.12)



ROYAL NORTH SHORE HOSPITAL
CLINICAL SERVICES BUILDING




CONCEPT PLAN
Level 7 (RL 111.90)

Project Number AX003226
Scale 1:500 @ A3
Drawing A107
Date 12/12/2011

PLANT SPACE

- VERTICAL CIRCULATION
- ENGINEERING
- PLANT

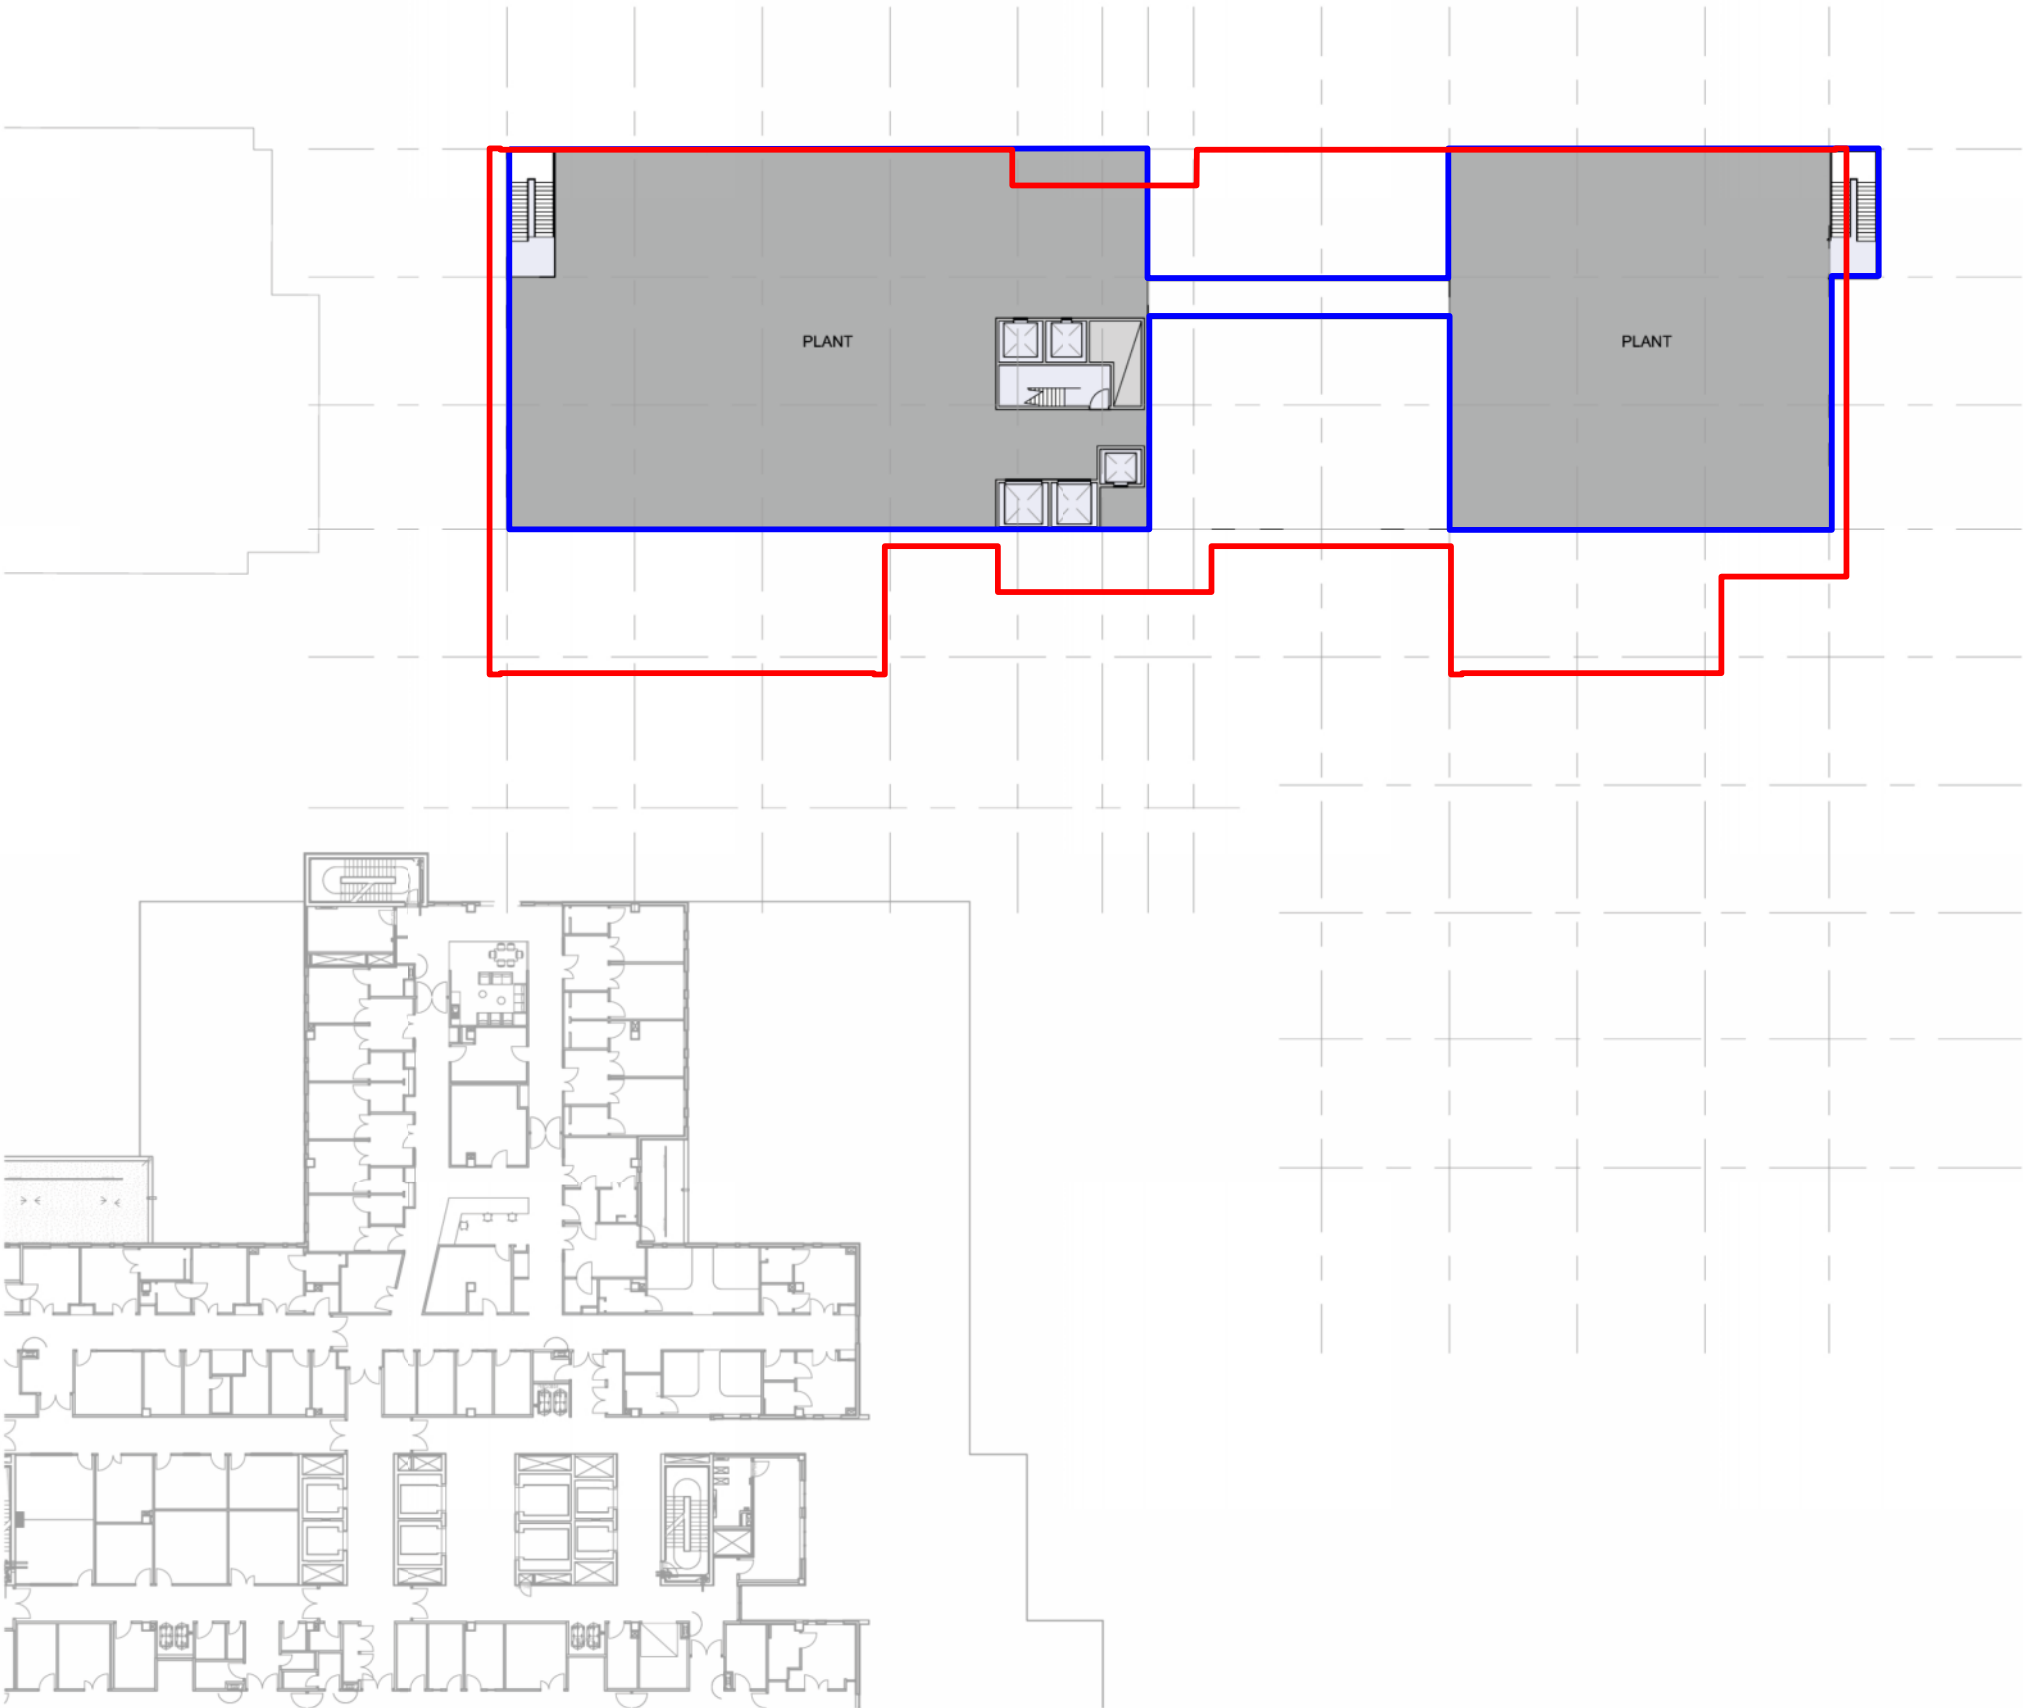

BSA OVERLAY LEGEND

- BSA'S DESIGN FREEZE (28.02.13)
- HASSELL'S 75W MODIFICATION -MP08_0172 Mod 5 (25.05.12)




ROYAL NORTH
SHORE HOSPITAL
CLINICAL
SERVICES
BUILDING



CONCEPT PLAN
Level 08 (RL 116.10)

Project Number AX003226
Scale 1:500 @ A3
Drawing A108
Date 12/12/2011

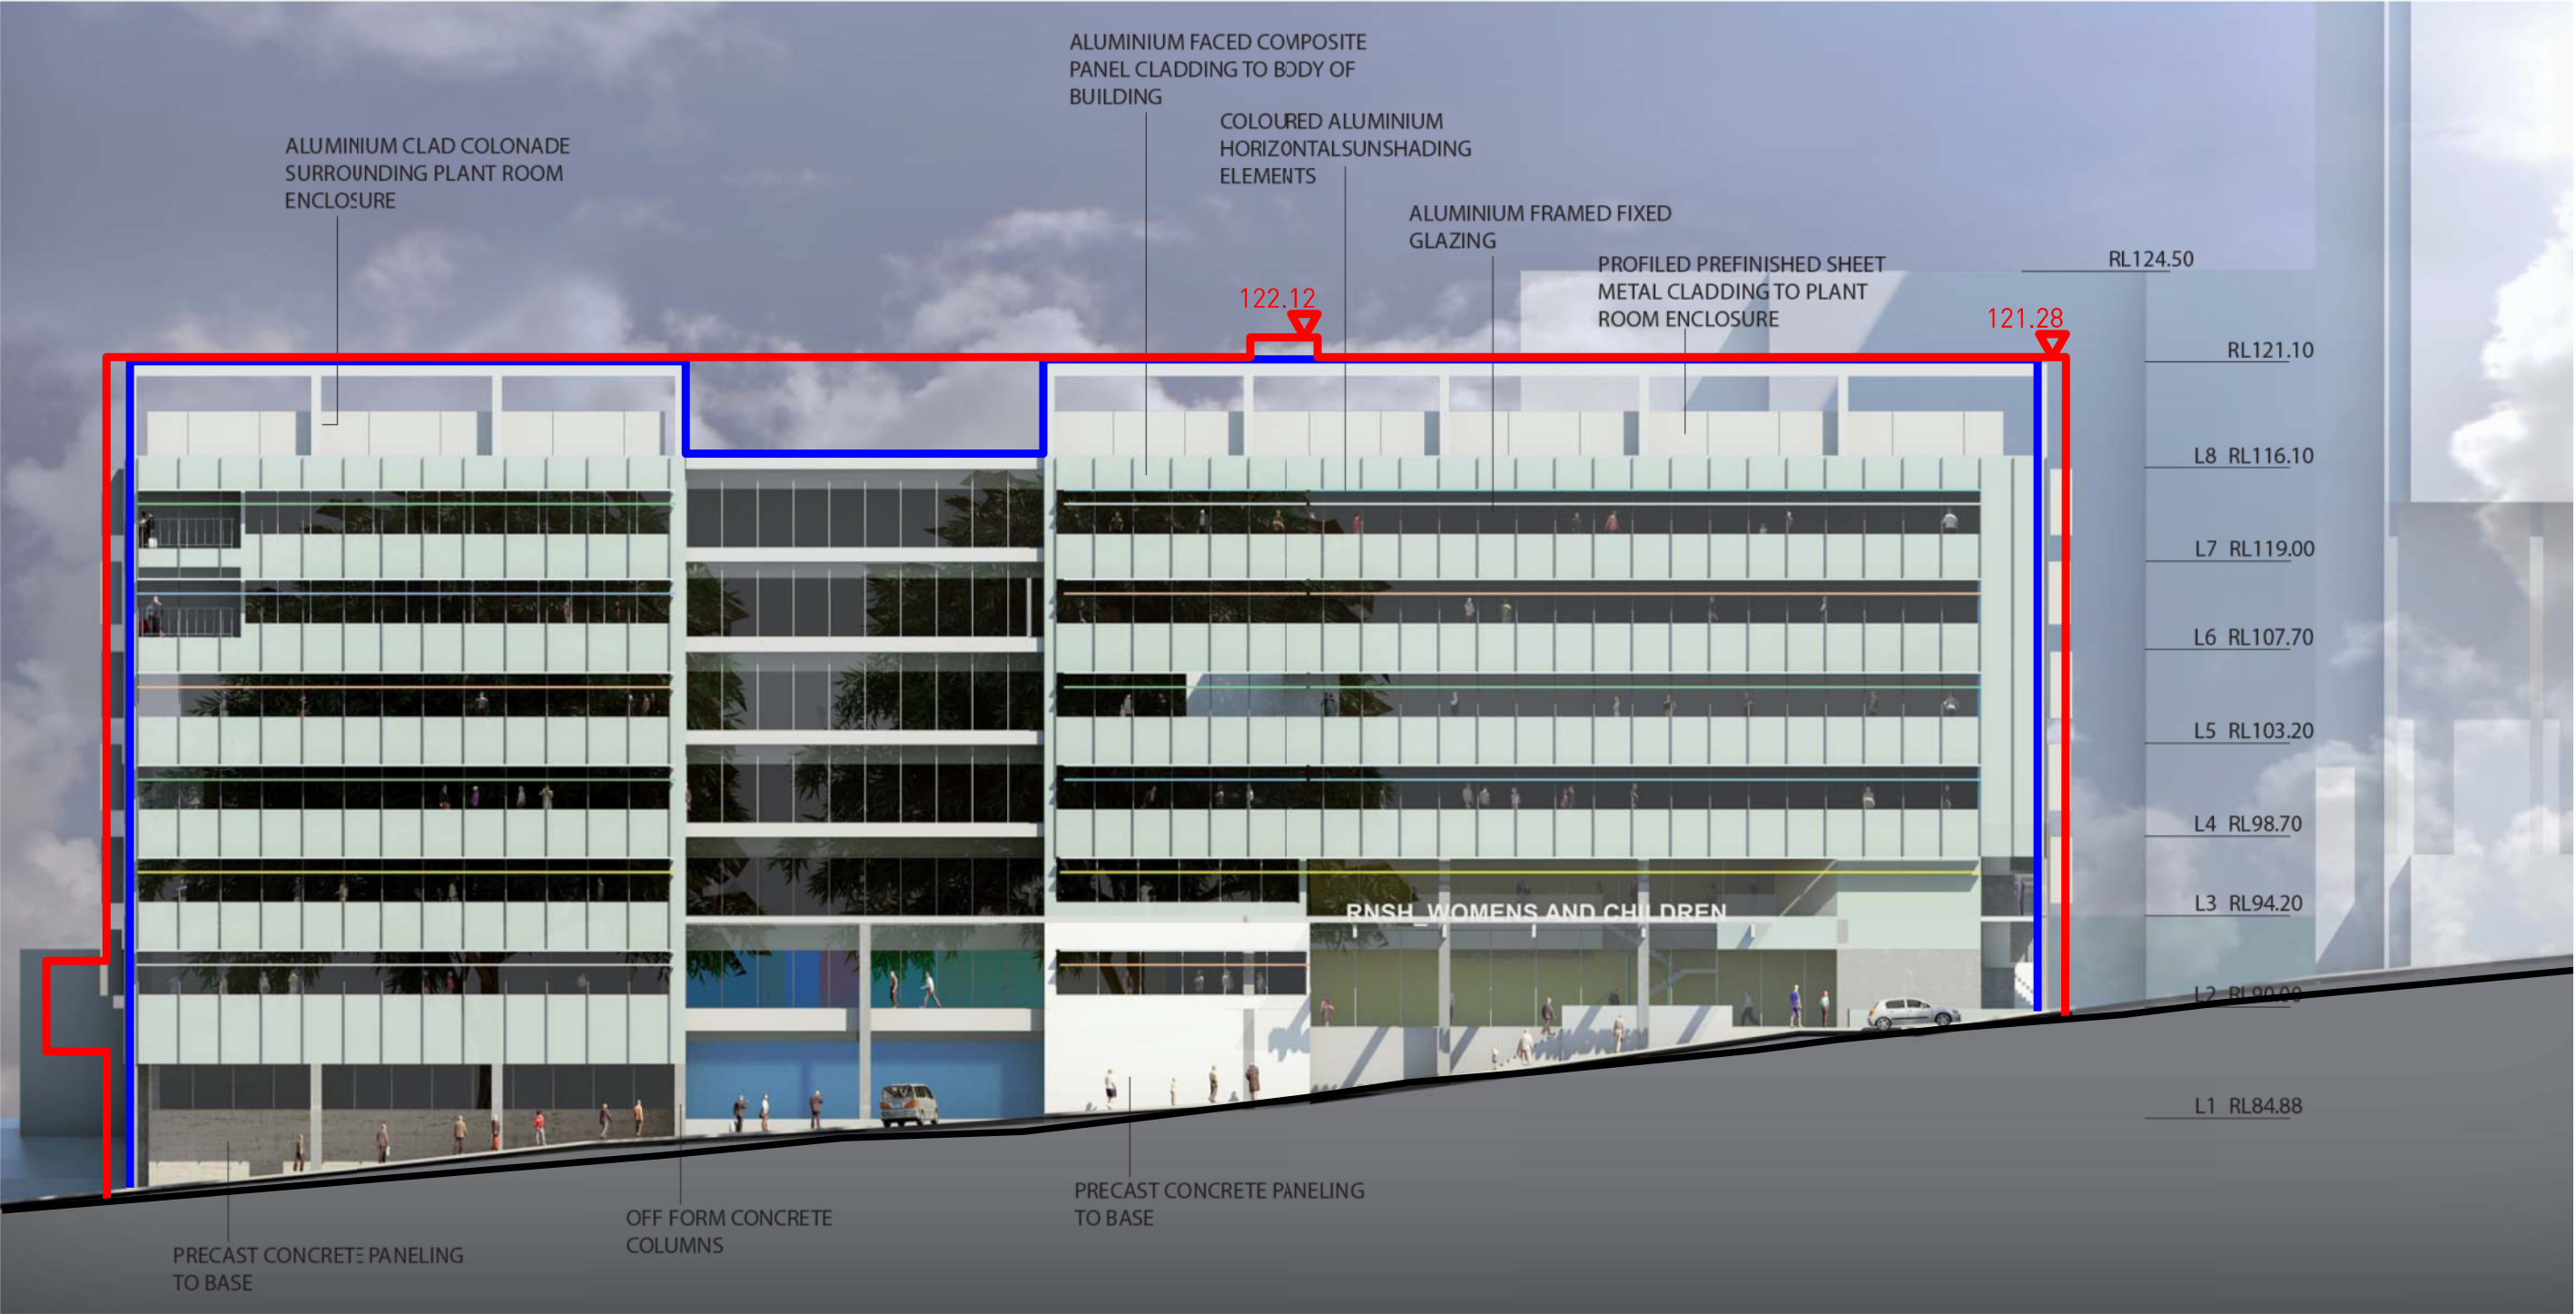


01 NORTH WEST ELEVATION

HASSELL'S 75W MODIFICATION -MP08_0172 Mod 5 (25.05.12)

BSA OVERLAY LEGEND


- BSA'S DESIGN FREEZE (28.02.13)
- HASSELL'S 75W MODIFICATION -MP08_0172 Mod 5 (25.05.12)

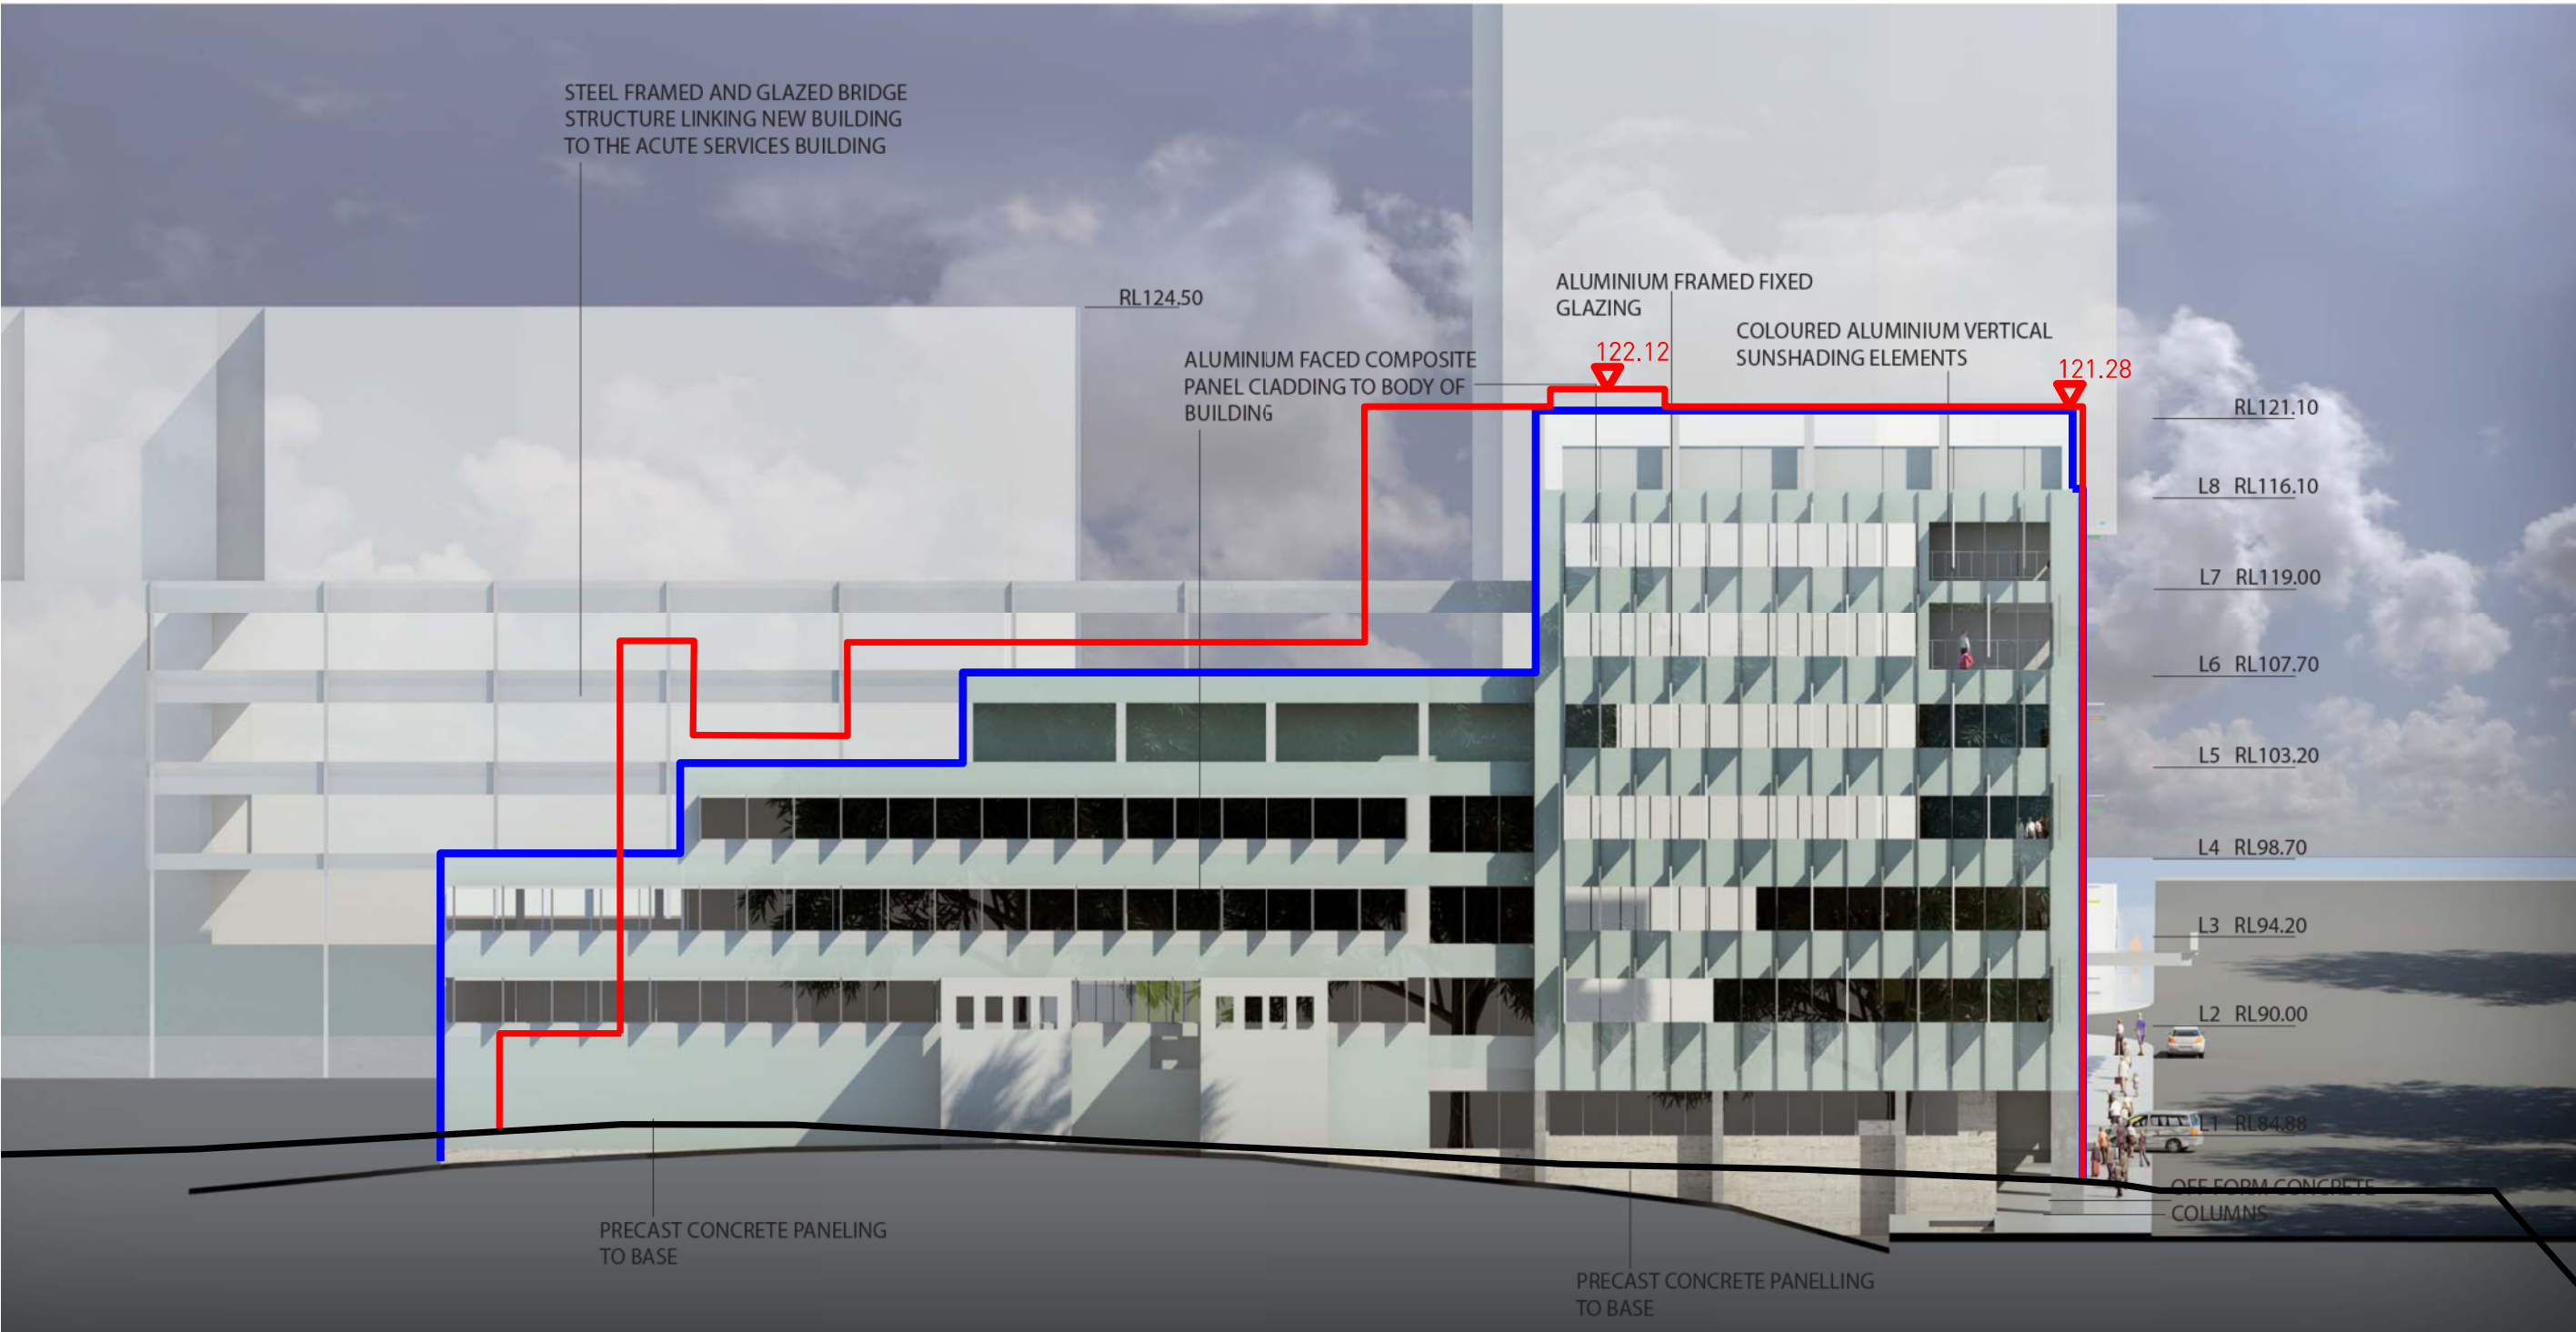

03 NORTH EAST ELEVATION
HASSELL'S 75W MODIFICATION *-MP08_0172 Mod 5 (25.05.12)

BSA OVERLAY LEGEND


- BSA'S DESIGN FREEZE (28.02.13)
- HASSELL'S 75W MODIFICATION -MP08_0172 Mod 5 (25.05.12)

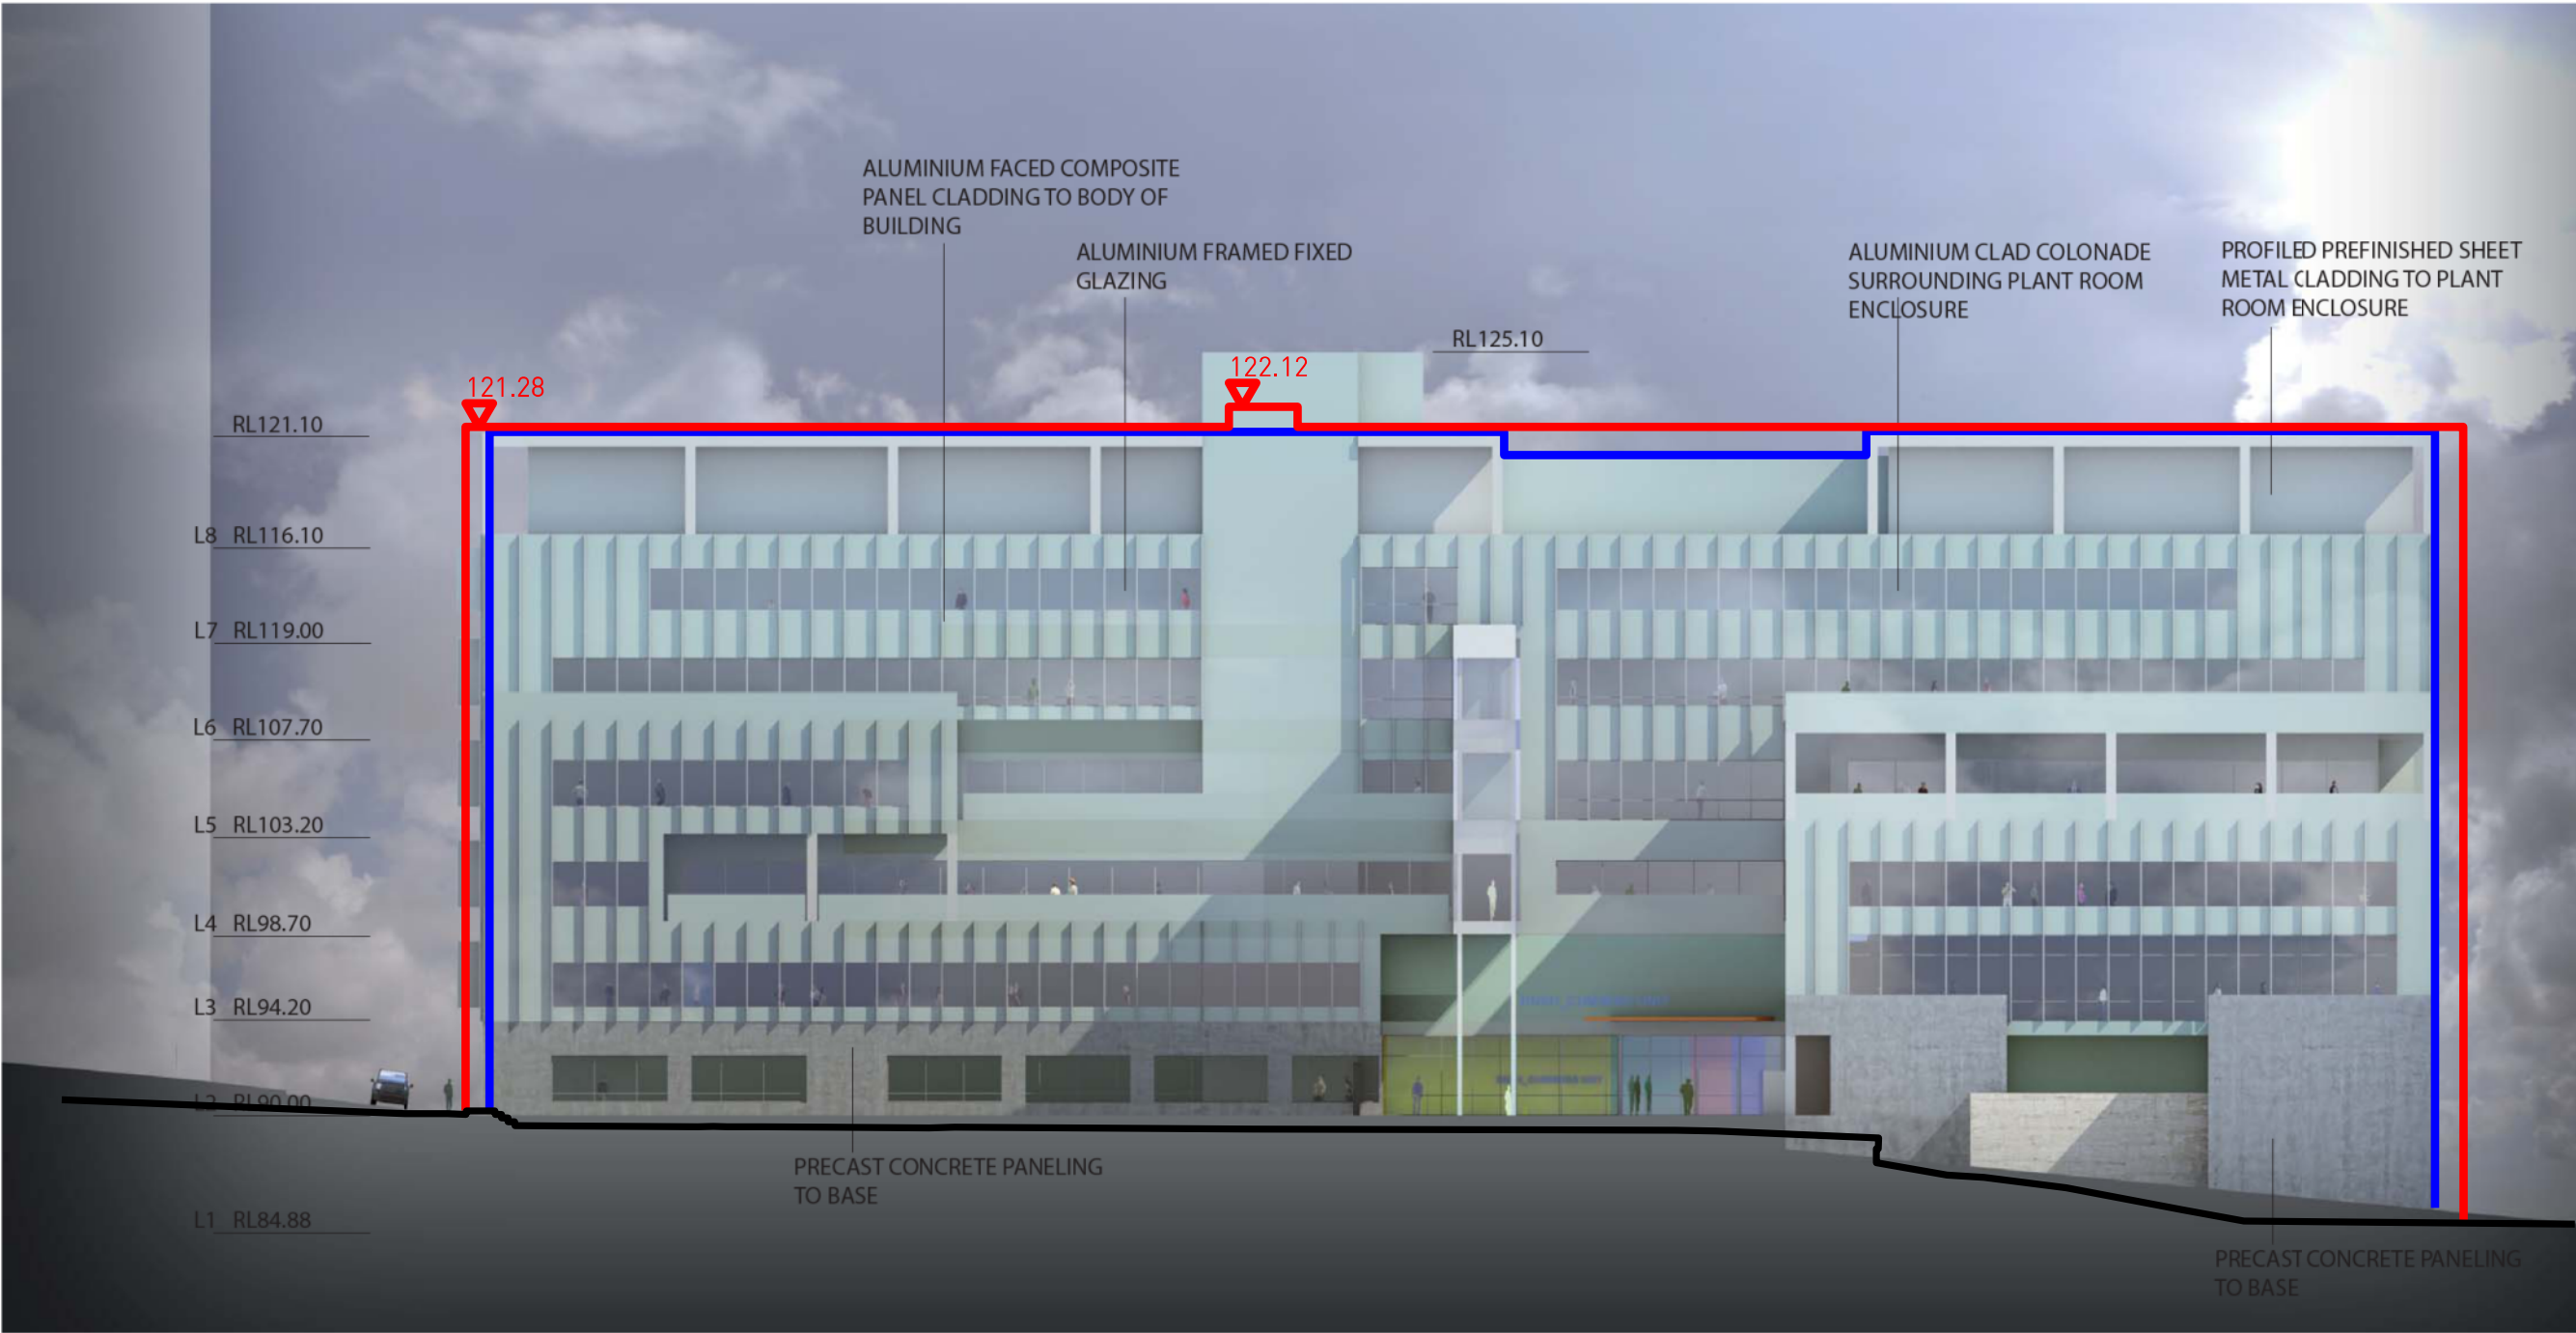

02 SOUTH EAST ELEVATION
HASSELL'S 75W MODIFICATION -MP08_0172 Mod 5 (25.05.12)

BSA OVERLAY LEGEND

- BSA'S DESIGN FREEZE (28.02.13)
- HASSELL'S 75W MODIFICATION -MP08_0172 Mod 5 (25.05.12)

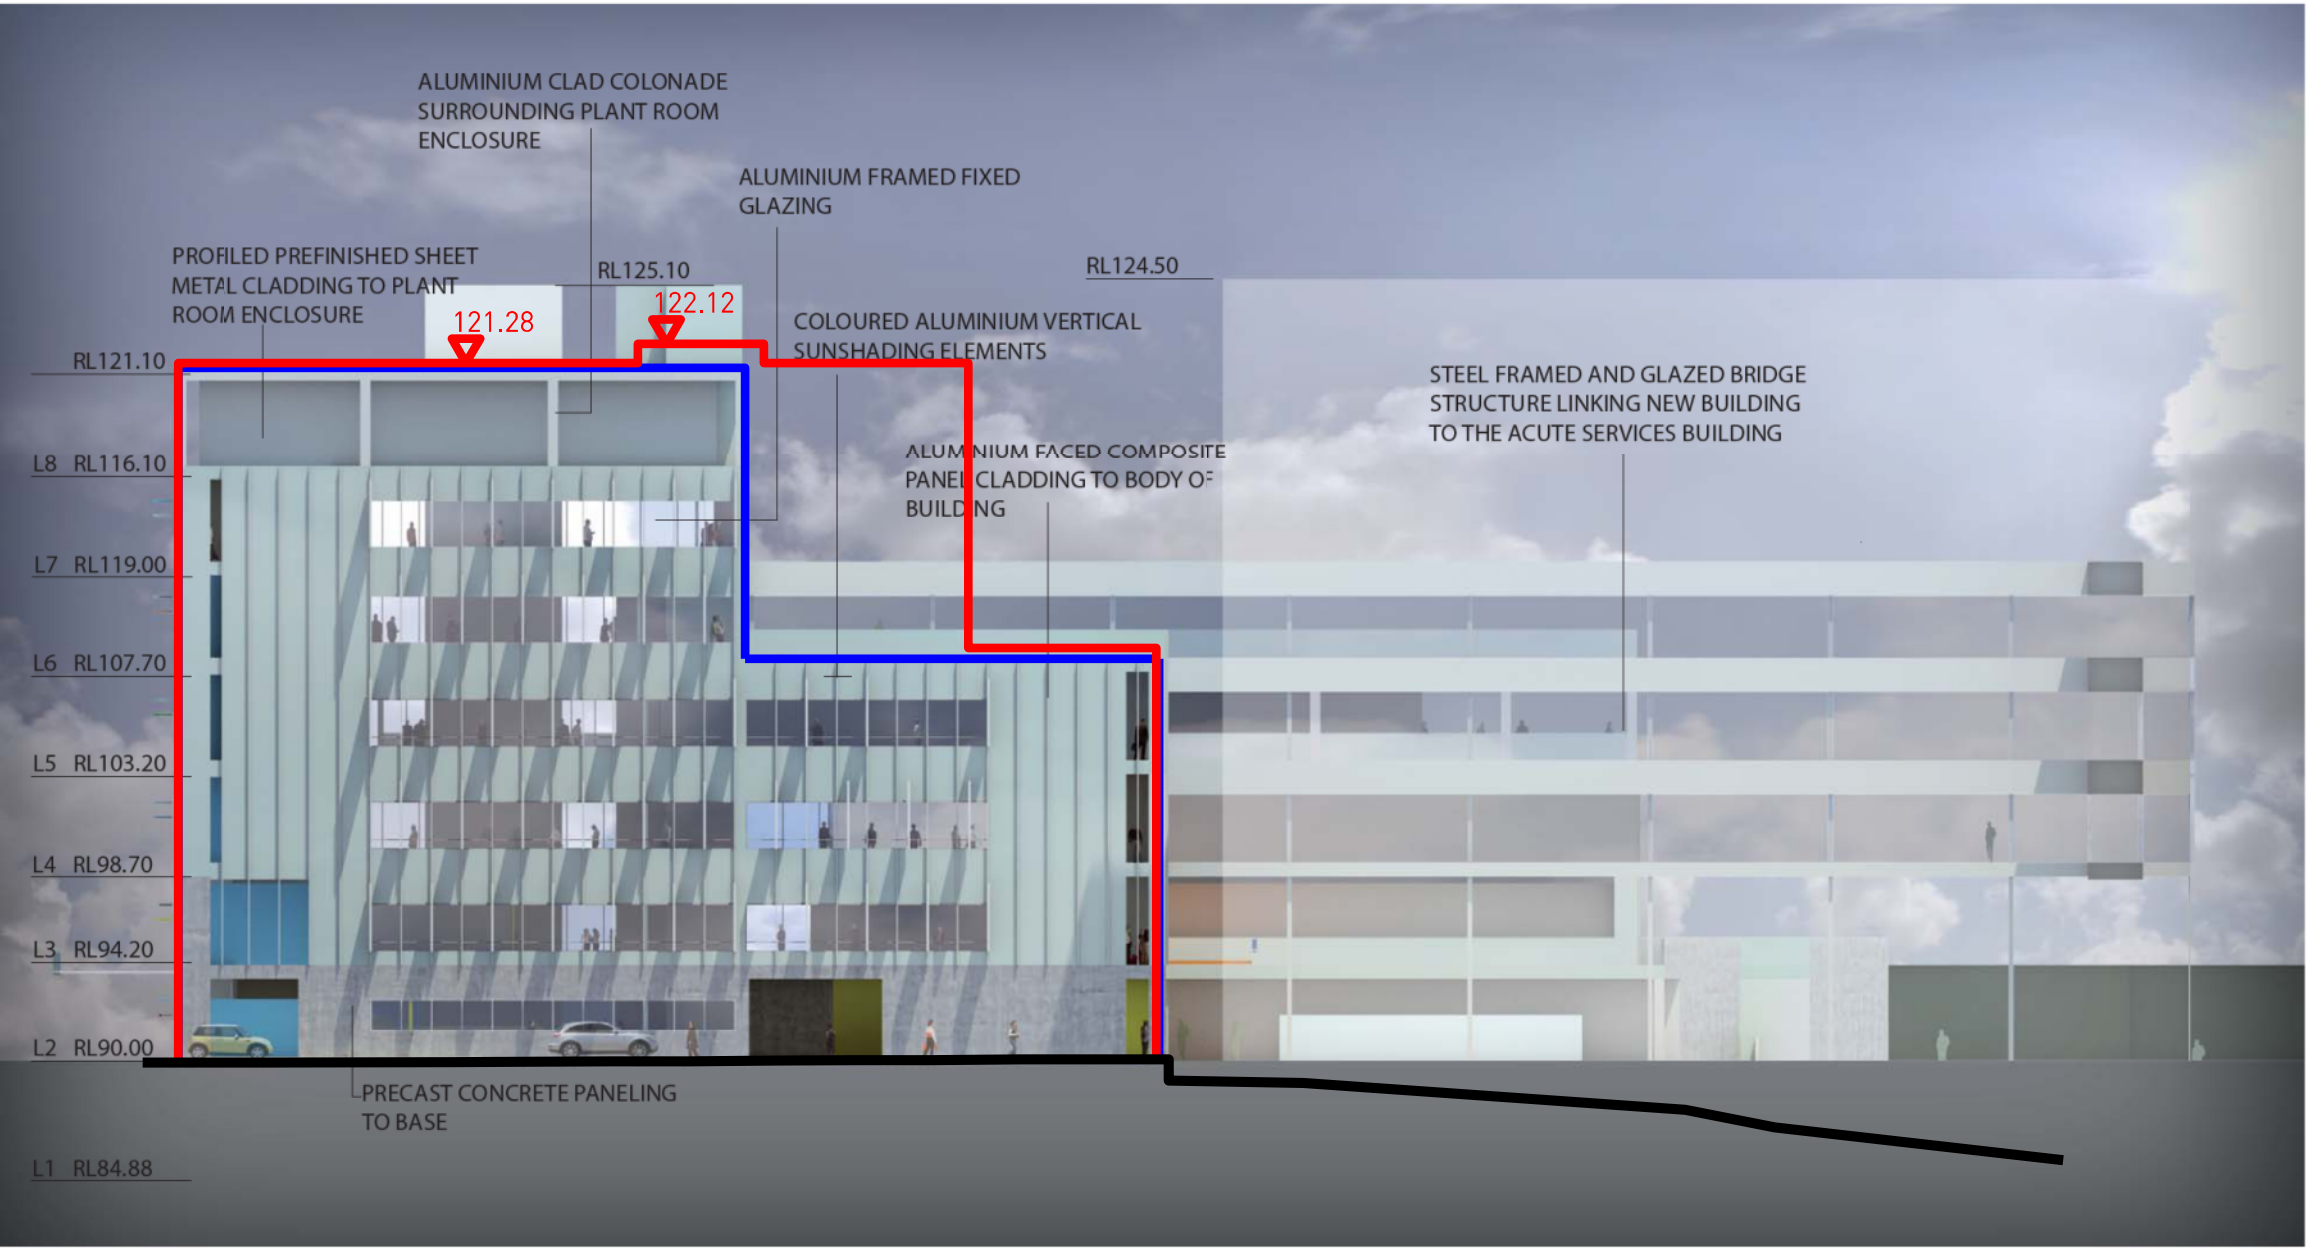

04 SOUTH WEST ELEVATION
HASSELL'S 75W MODIFICATION - MP08_0172 Mod 5 (25.05.12)

- BSA OVERLAY LEGEND
- BSA'S DESIGN FREEZE (28.02.13)
 - HASSELL'S 75W MODIFICATION - MP08_0172 Mod 5 (25.05.12)