


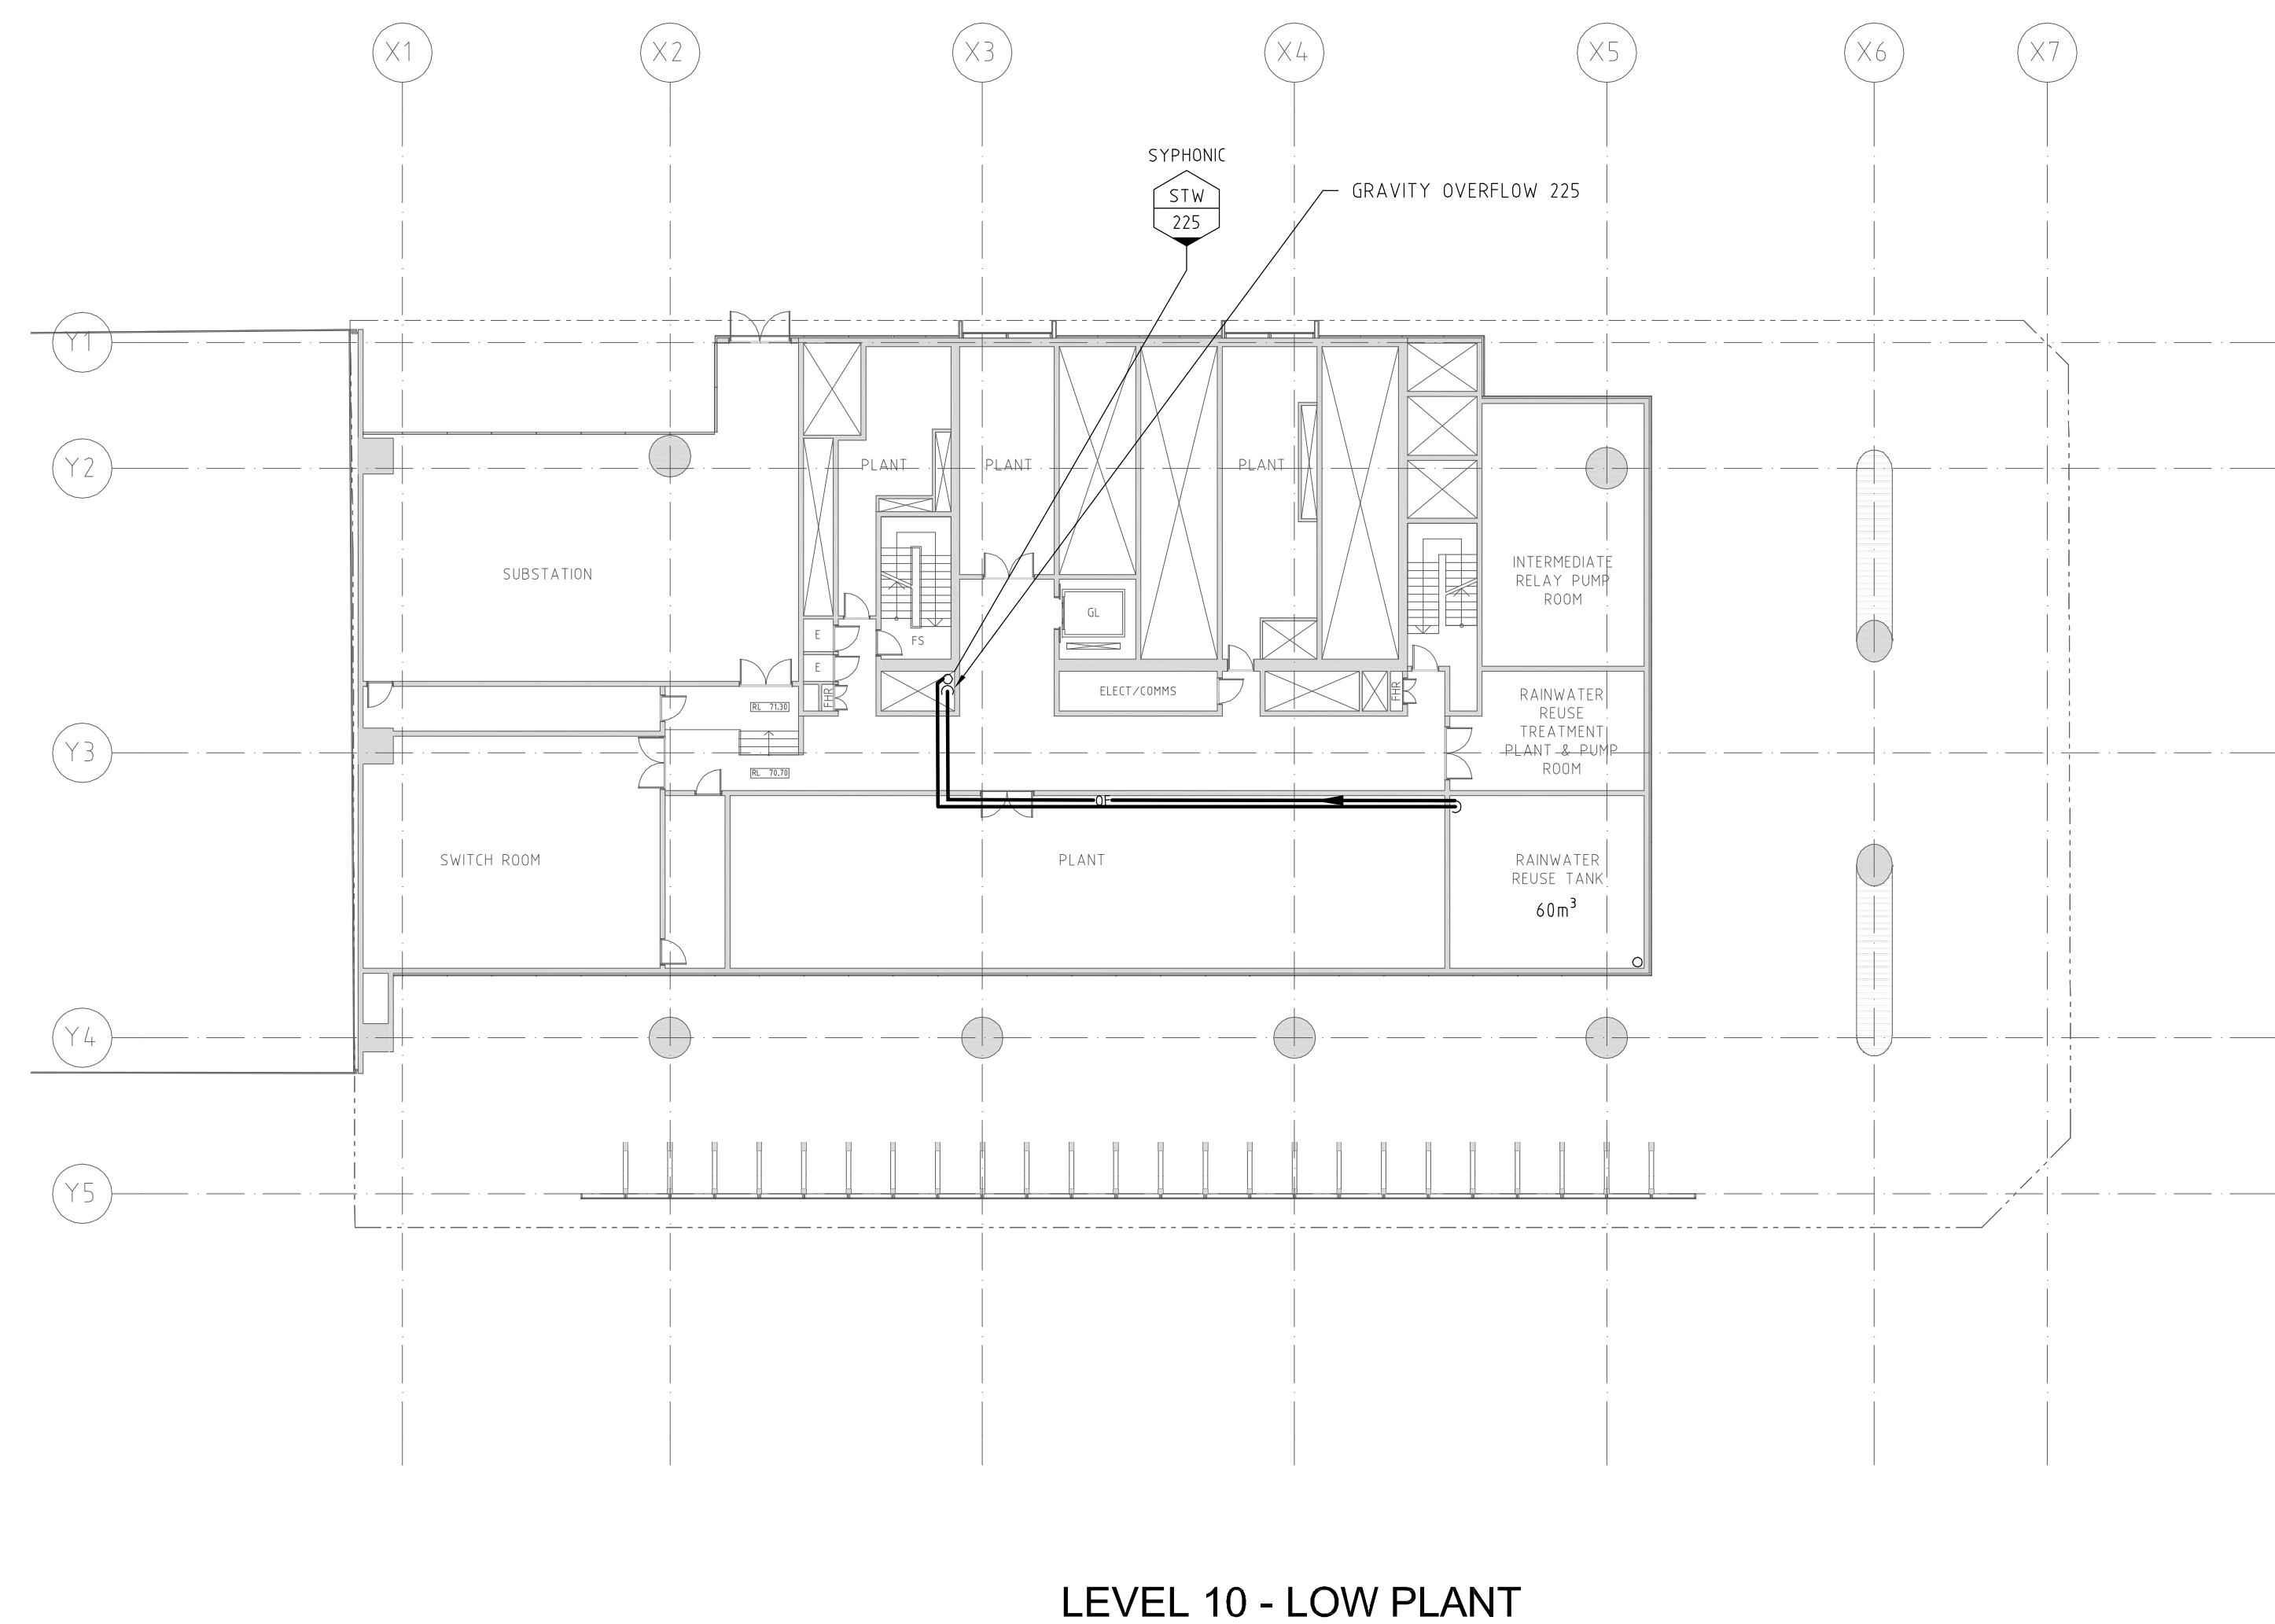


PART 3A APPLICATION

Plot Date: Friday, May 15, 2009 9:27:24 AM



DO NOT SCALE FROM DRAWINGS, CHECK & VERIFY ALL DIMENSIONS & LEVELS BEFORE COMMENCEMENT OF ANY WORK. THIS DRAWING IS NOT TO BE COPIED IN PART OR WHOLE WITHOUT WRITTEN PERMISSION FROM WARREN SMITH AND PARTNERS.	NORTH POINT 	NOTES	ISSUE	AMENDMENT	DATE	ISSUE	AMENDMENT	DATE	CLIENT   LEVEL 4, 100 ARTHUR STREET NORTH SYDNEY, NSW 2060 P: 02 9622 3300 F: 02 9622 3355 W: www.laingoroourke.com.au LEVEL 8, 90 MOUNT STREET NORTH SYDNEY, NSW 2060 P: 02 9622 7725 F: 02 9622 3605 W: www.delmege.com.au	PROJECT DEVELOPMENT 100 MOUNT STREET NORTH SYDNEY	WARREN SMITH & PARTNERS PTY LTD A 1st Floor, 123 Clarence Street, Sydney 2000 NSW Australia T 02 9299 1312 F 02 9290 1295 E wsp@warrensmith.com.au ABN 36 300 430 126  SERVING THE CONSTRUCTION INDUSTRY SINCE 1981 Consulting Engineers Hydraulic Services Civil Engineering Fire Protection Sydney Water Accredited • Water Servicing Co-ordinator • Design and Project Management	TITLE STORMWATER DRAINAGE PLAN SHEET 2 OF 3
			SCALE A1@ 1:200 A3@ 1:400	DRAWN JM	DESIGNED AM	CHECKED L.P.	APPROVED					
DATE MAY 2009	DRAWING No. C-05	ISSUE A	JOB No. 3425									

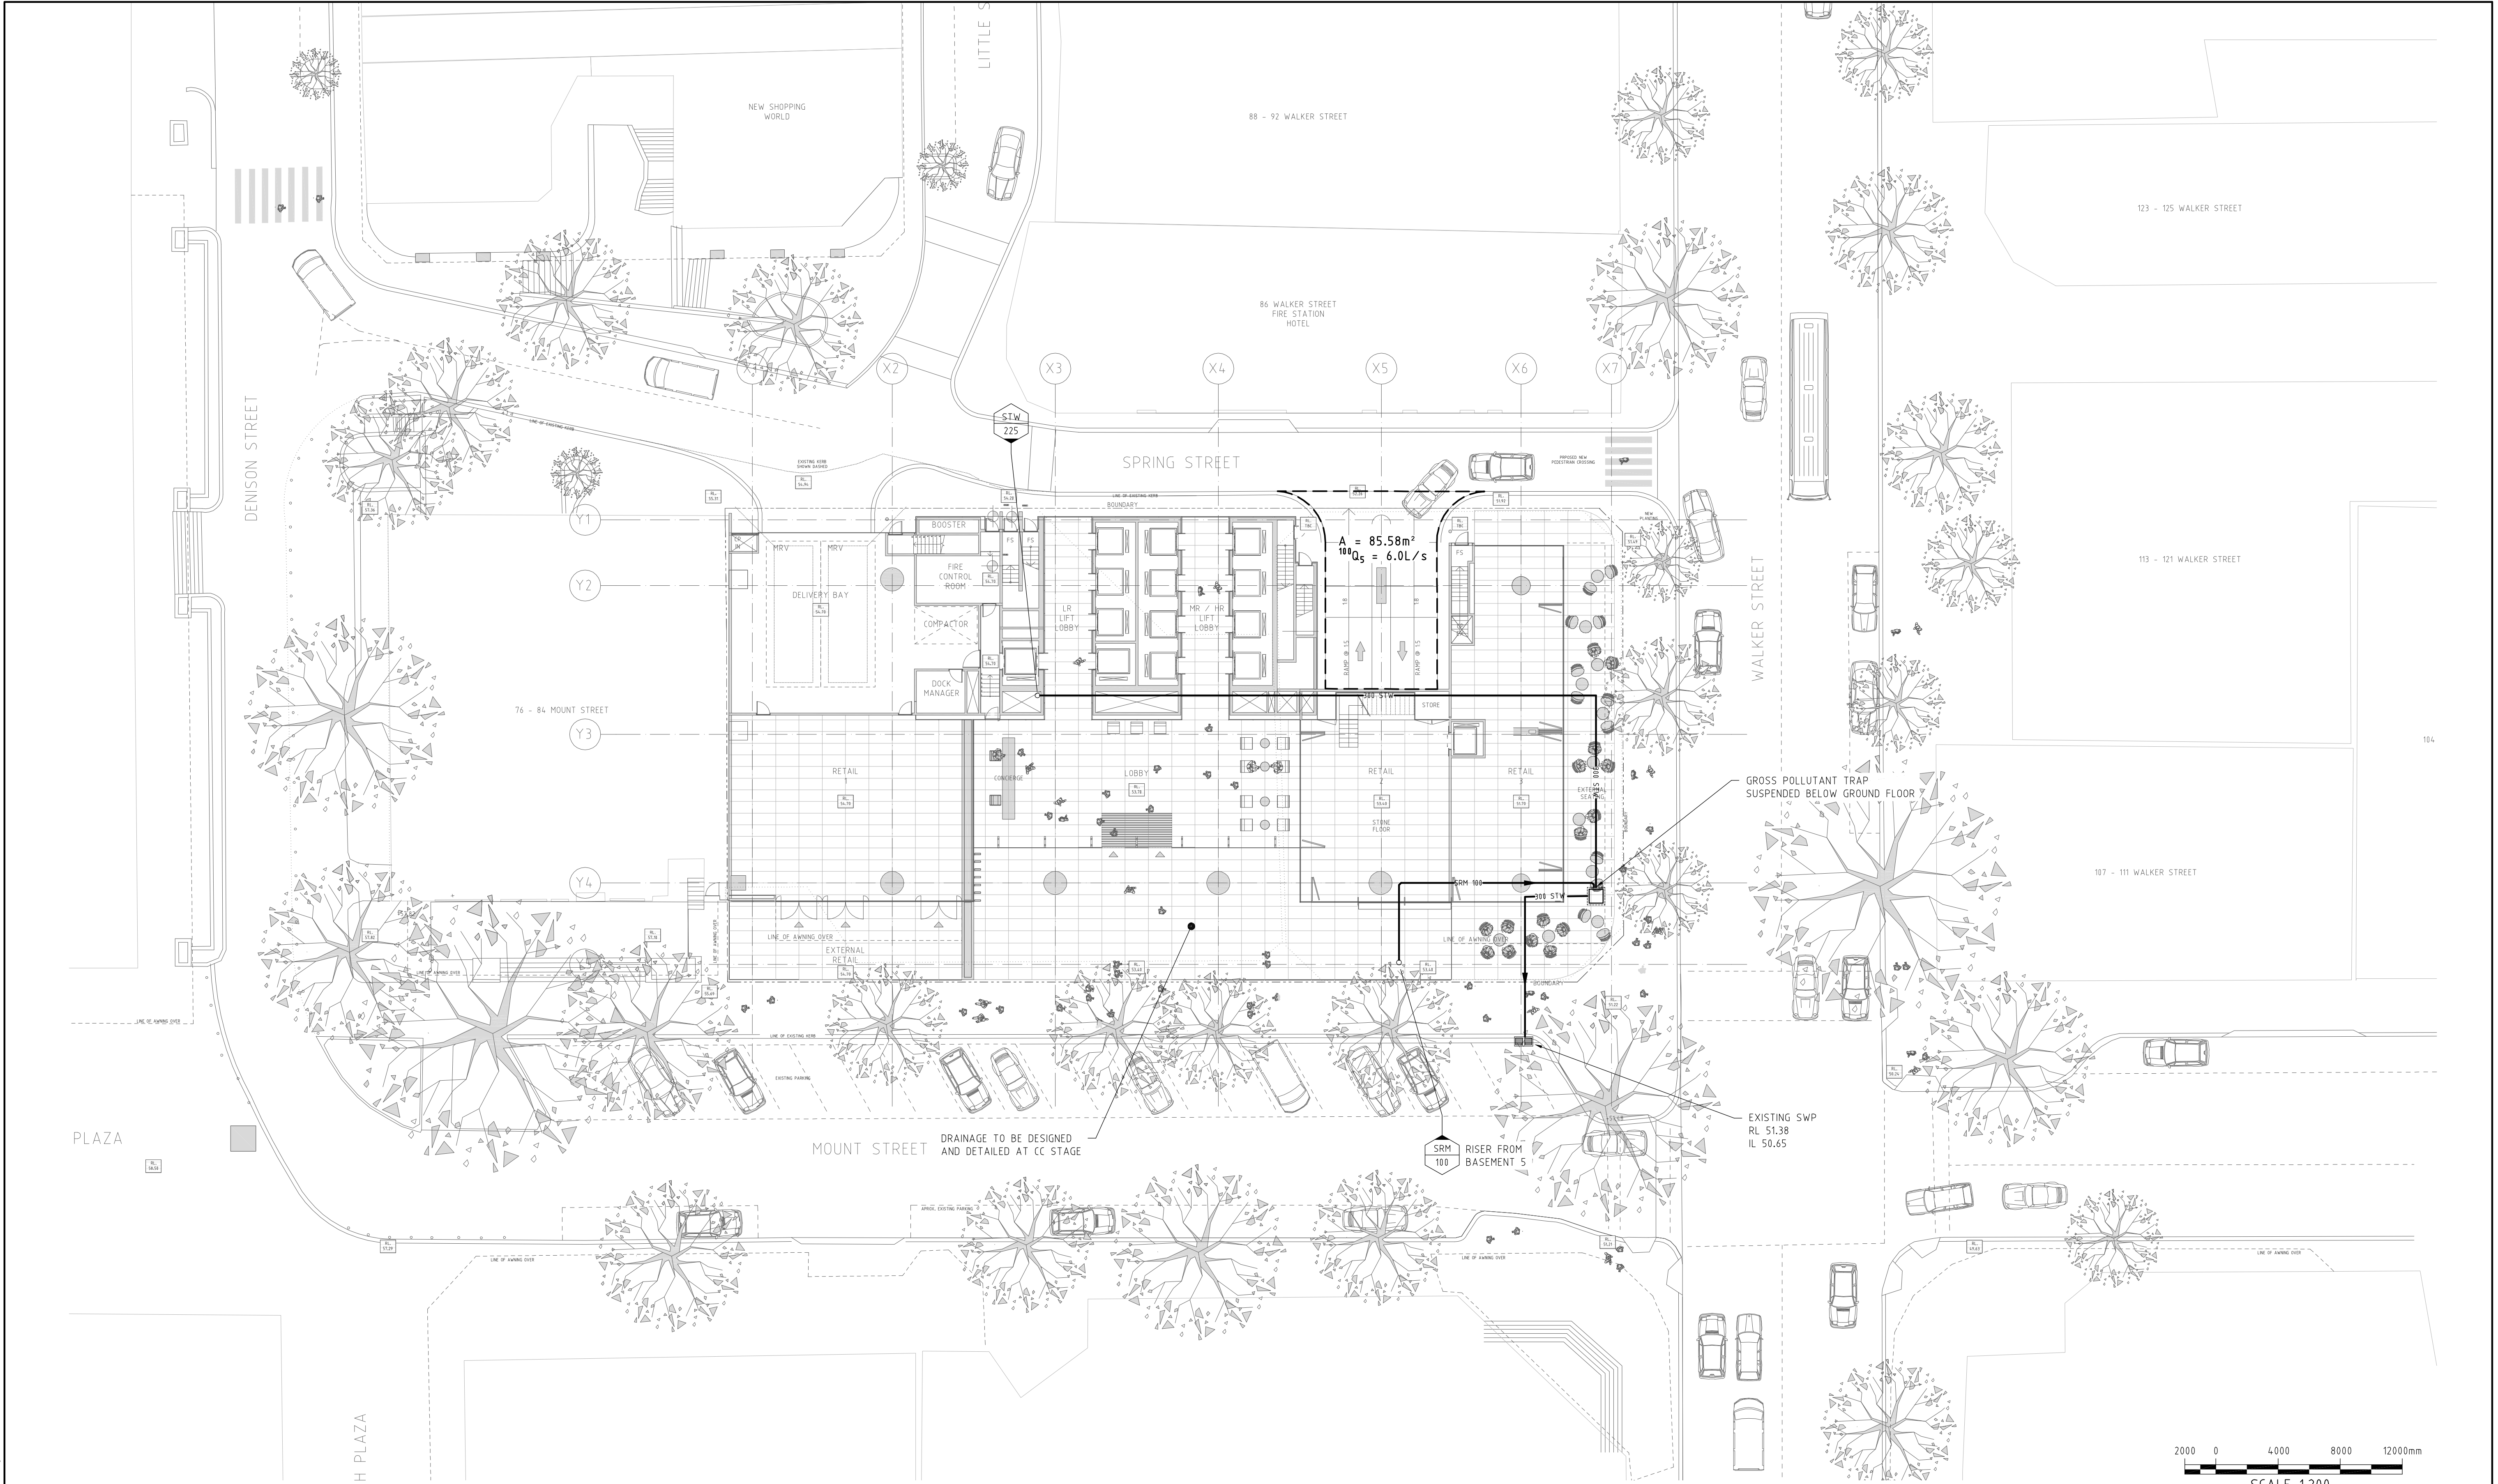

AUSTRALIAN HEIGHT DATUM

DO NOT SCALE FROM DRAWINGS, CHECK & VERIFY ALL DIMENSIONS & LEVELS BEFORE COMMENCEMENT OF ANY WORK.

THIS DRAWING IS NOT TO BE COPIED IN PART OR WHOLE WITHOUT WRITTEN PERMISSION FROM WARREN SMITH AND PARTNERS.

NORTH POINT

NOTES

ISSUE	AMENDMENT	DATE	ISSUE	AMENDMENT	DATE
A	PART 3A APPLICATION	15.05.09			

CLIENT

LAING O'Rourke

LEVEL 4, 100 ARTHUR STREET, NORTH SYDNEY, NSW 2060
P: 02 9603 0303
F: 02 9603 0305
W: www.laingorourke.com.au

PROJECT

DEVELOPMENT
100 MOUNT STREET
NORTH SYDNEY

CLIENT

Delmege

LEVEL 5, 50 MOUNT STREET, NORTH SYDNEY, NSW 2060
P: 02 9603 0303
F: 02 9603 0305
W: www.delmege.com.au

PROJECT

DEVELOPMENT
100 MOUNT STREET
NORTH SYDNEY

WARREN SMITH & PARTNERS Pty Ltd

A 1st Floor, 123 Clarence Street, Sydney 2000 NSW Australia
T 02 9299 1312 F 02 9290 1295 E wsp@warrensmith.com.au
ABN 36 300 430 126

SERVING THE CONSTRUCTION INDUSTRY SINCE 1981

Consulting Engineers
Hydraulic Services | Civil Engineering | Fire Protection | Sydney Water Accredited • Water Servicing Co-ordinator • Design and Project Management

SCALE	DRAWN	DESIGNED	CHECKED	APPROVED
A1@1:200 A3@1:400	JM	AM	L.P.	

DATE	DRAWING No.	ISSUE
MAY 2009		
JOB No.	C-06	A

PART 3A APPLICATION

STORMWATER DRAINAGE PLAN
SHEET 3 OF 3

Plot Date: Friday, May 15, 2009 9:18:43 AM

0 10 20 30 40 50 60 70 80 90 100 110 120 130 140 150

SHEET SIZE: A1

2000 0 4000 8000 12000mm

SCALE 1:200