


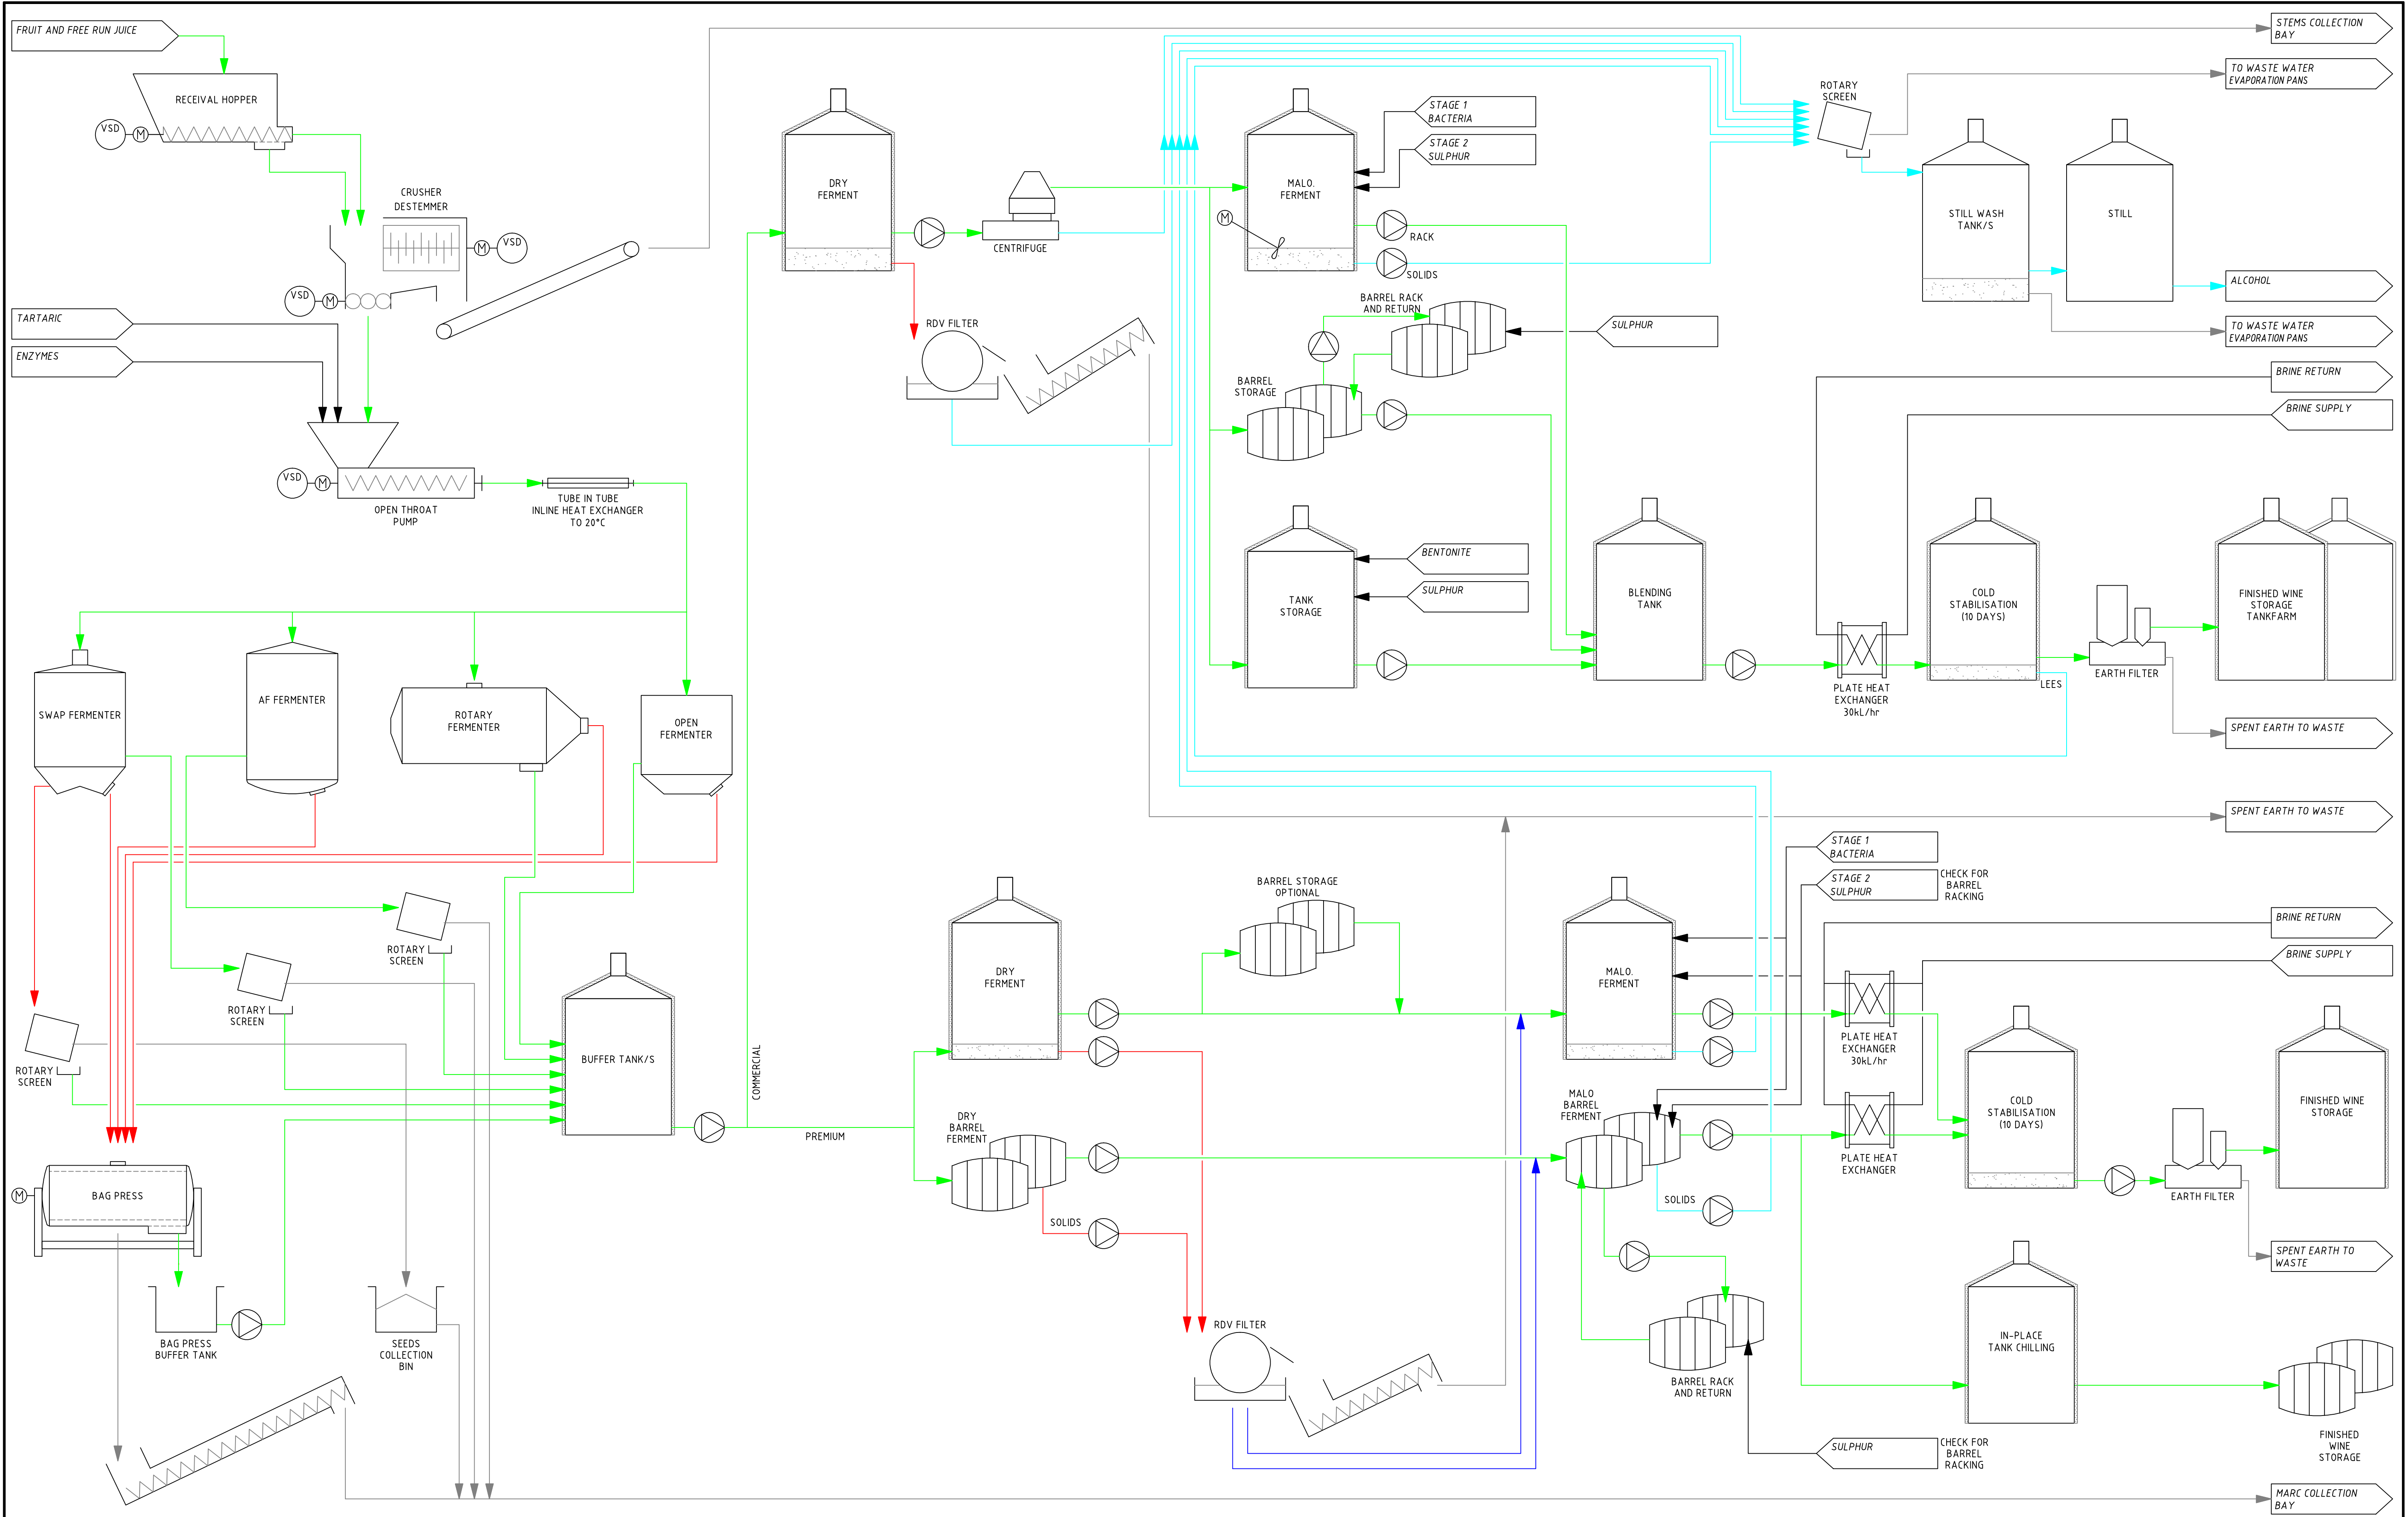

PRELIMINARY ISSUE
NOT TO BE USED FOR CONSTRUCTION


Rev.	A	PRELIMINARY ISSUE	MJB	JL	11.08.08
		Drawing Issue	Drn	Ckd	Date

LINNEY
ENGINEERING SERVICES PTY LTD
FACILITY PLANNING & DESIGN
P. (08) 8343 8484 F. (08) 8343 8466
Inquiries@linneyengineering.com.au
ABN 83 120 383 931

Client: 
HANWOOD WINERY

Project: ENVIRONMENTAL IMPACT STUDY
Title: PROCESS FLOW DIAGRAM
RED WINE PRODUCTION

Designer: M.BOSSY	Date: MAR 2008	Sheet Size: A1
Drawing No: 0802-05-ME001		Scale: NOT TO SCALE
		Rev: A

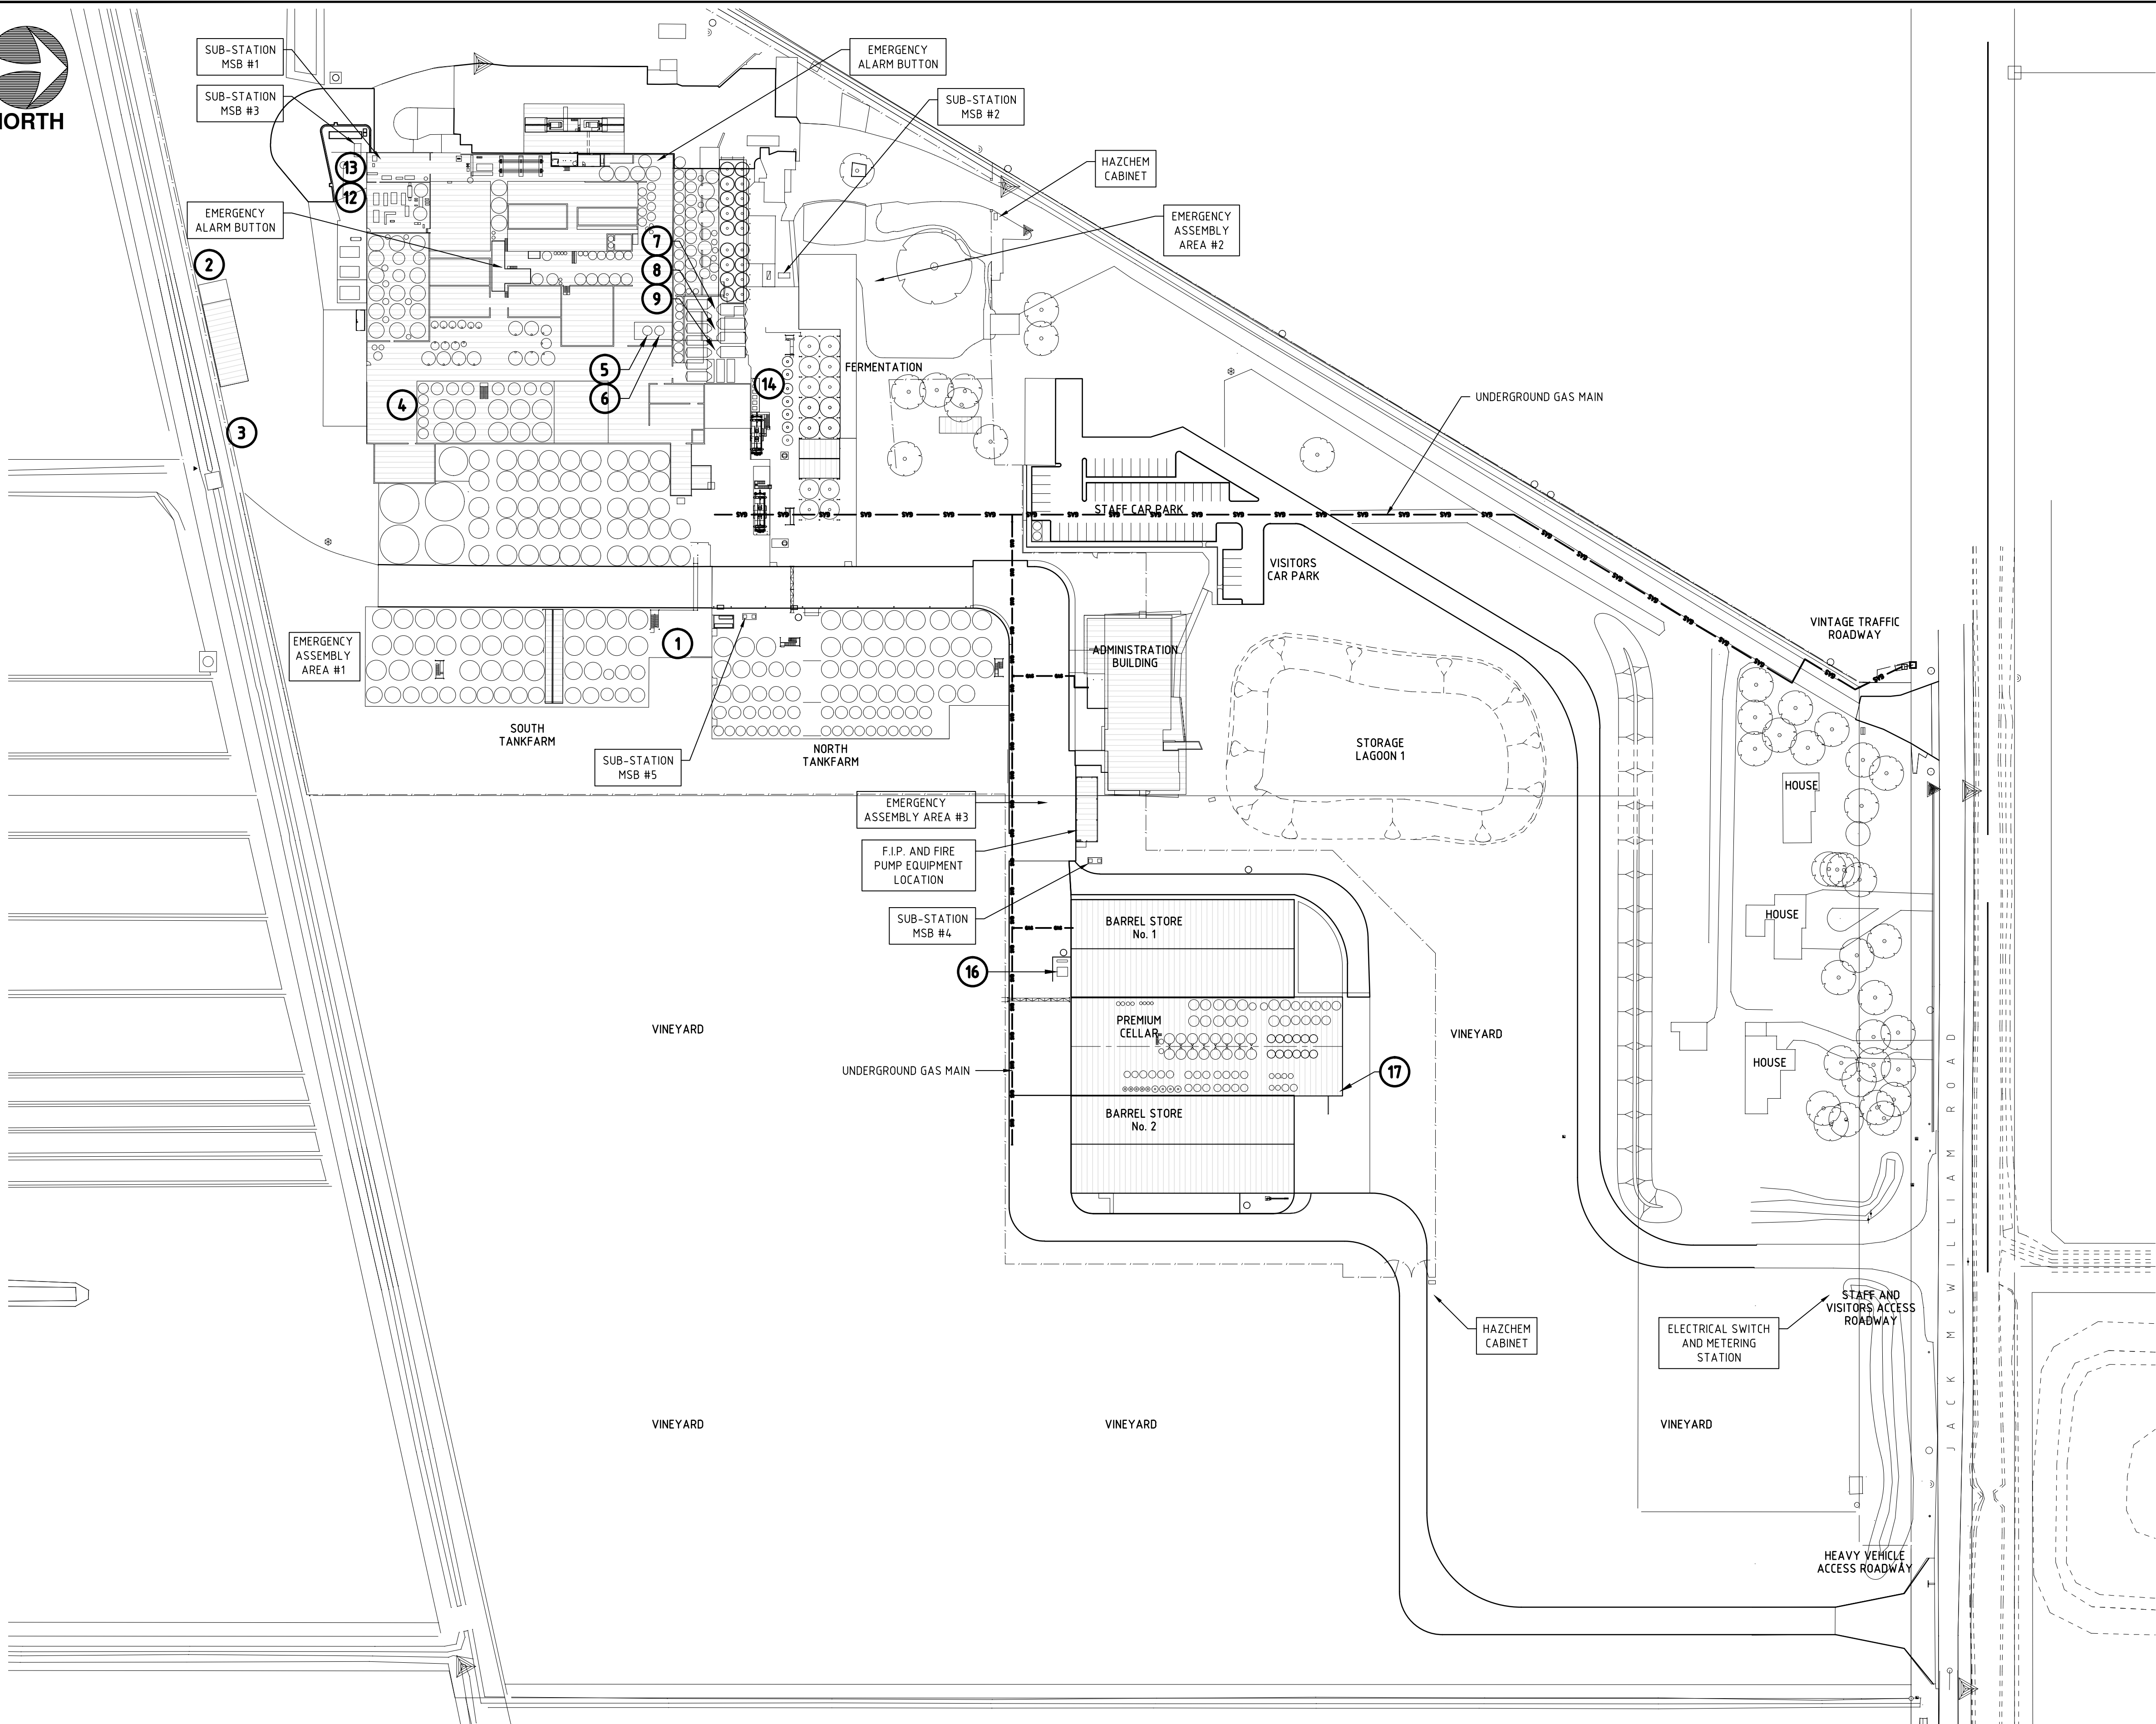

1. CARBON DIOXIDE STORAGE
6KL CLASS 2.2 CARBON DIOXIDE ABOVE GROUND
STORAGE TANK
2. LPG STORAGE
2.2KL CLASS 2.1 LP GAS STORAGE TANK.
3. SULPHUR DIOXIDE STORAGE
600KG CLASS 2.3 SULPHUR DIOXIDE CYLINDER.
4. UNDER COVER STORAGE AREA
2KL CLASS 8 PGIII SODIUM HYDROXIDE SOLUTION
STORAGE TANK.
1KL CLASS 5.1 SUBCLASS 8 PEROXYGEN SANITISER
STORAGE TANK.
5. ETHANOL UNDERGROUND STORAGE
80KL CLASS 3 PGII ETHANOL (ETHYL ALCOHOL)
UNDERGROUND STORAGE TANK.
6. ETHANOL UNDERGROUND STORAGE
80KL CLASS 3 PGII ETHANOL (ETHYL ALCOHOL)
UNDERGROUND STORAGE TANK.
7. ETHANOL UNDERGROUND STORAGE
80KL CLASS 3 PGII ETHANOL (ETHYL ALCOHOL)
UNDERGROUND STORAGE TANK.
8. ETHANOL UNDERGROUND STORAGE
80KL CLASS 3 PGII ETHANOL (ETHYL ALCOHOL)
UNDERGROUND STORAGE TANK.
9. ETHANOL UNDERGROUND STORAGE
80KL CLASS 3 PGII ETHANOL (ETHYL ALCOHOL)
UNDERGROUND STORAGE TANK.
12. AMMONIA STORAGE
1.2KL CLASS 2.3 ANHYDROUS AMMONIA REFRIGERANT
STORAGE TANK.
13. COMPRESSED AIR STORAGE
5.2KL AND 7.5KL CLASS 2.2 COMPRESSED AIR STORAGE
TANKS.
14. COMPRESSED AIR STORAGE
2 x 5KL CLASS 2.2 COMPRESSED AIR STORAGE TANKS.
16. AMMONIA STORAGE
2.5KL CLASS 2.3 ANHYDROUS AMMONIA REFRIGERANT
STORAGE TANK.
17. COMPRESSED AIR STORAGE
2.5KL CLASS 2.2 COMPRESSED AIR STORAGE TANK.

Designer:	Date:	Sheet Size: A1
Drawn By: MBOSSY	Date: DECEMBER 2010	Scale: 1: 1000 (A1) 1: 2000 (A3)
Drawing No: MCW-HANW-AR050	Rev:	C