


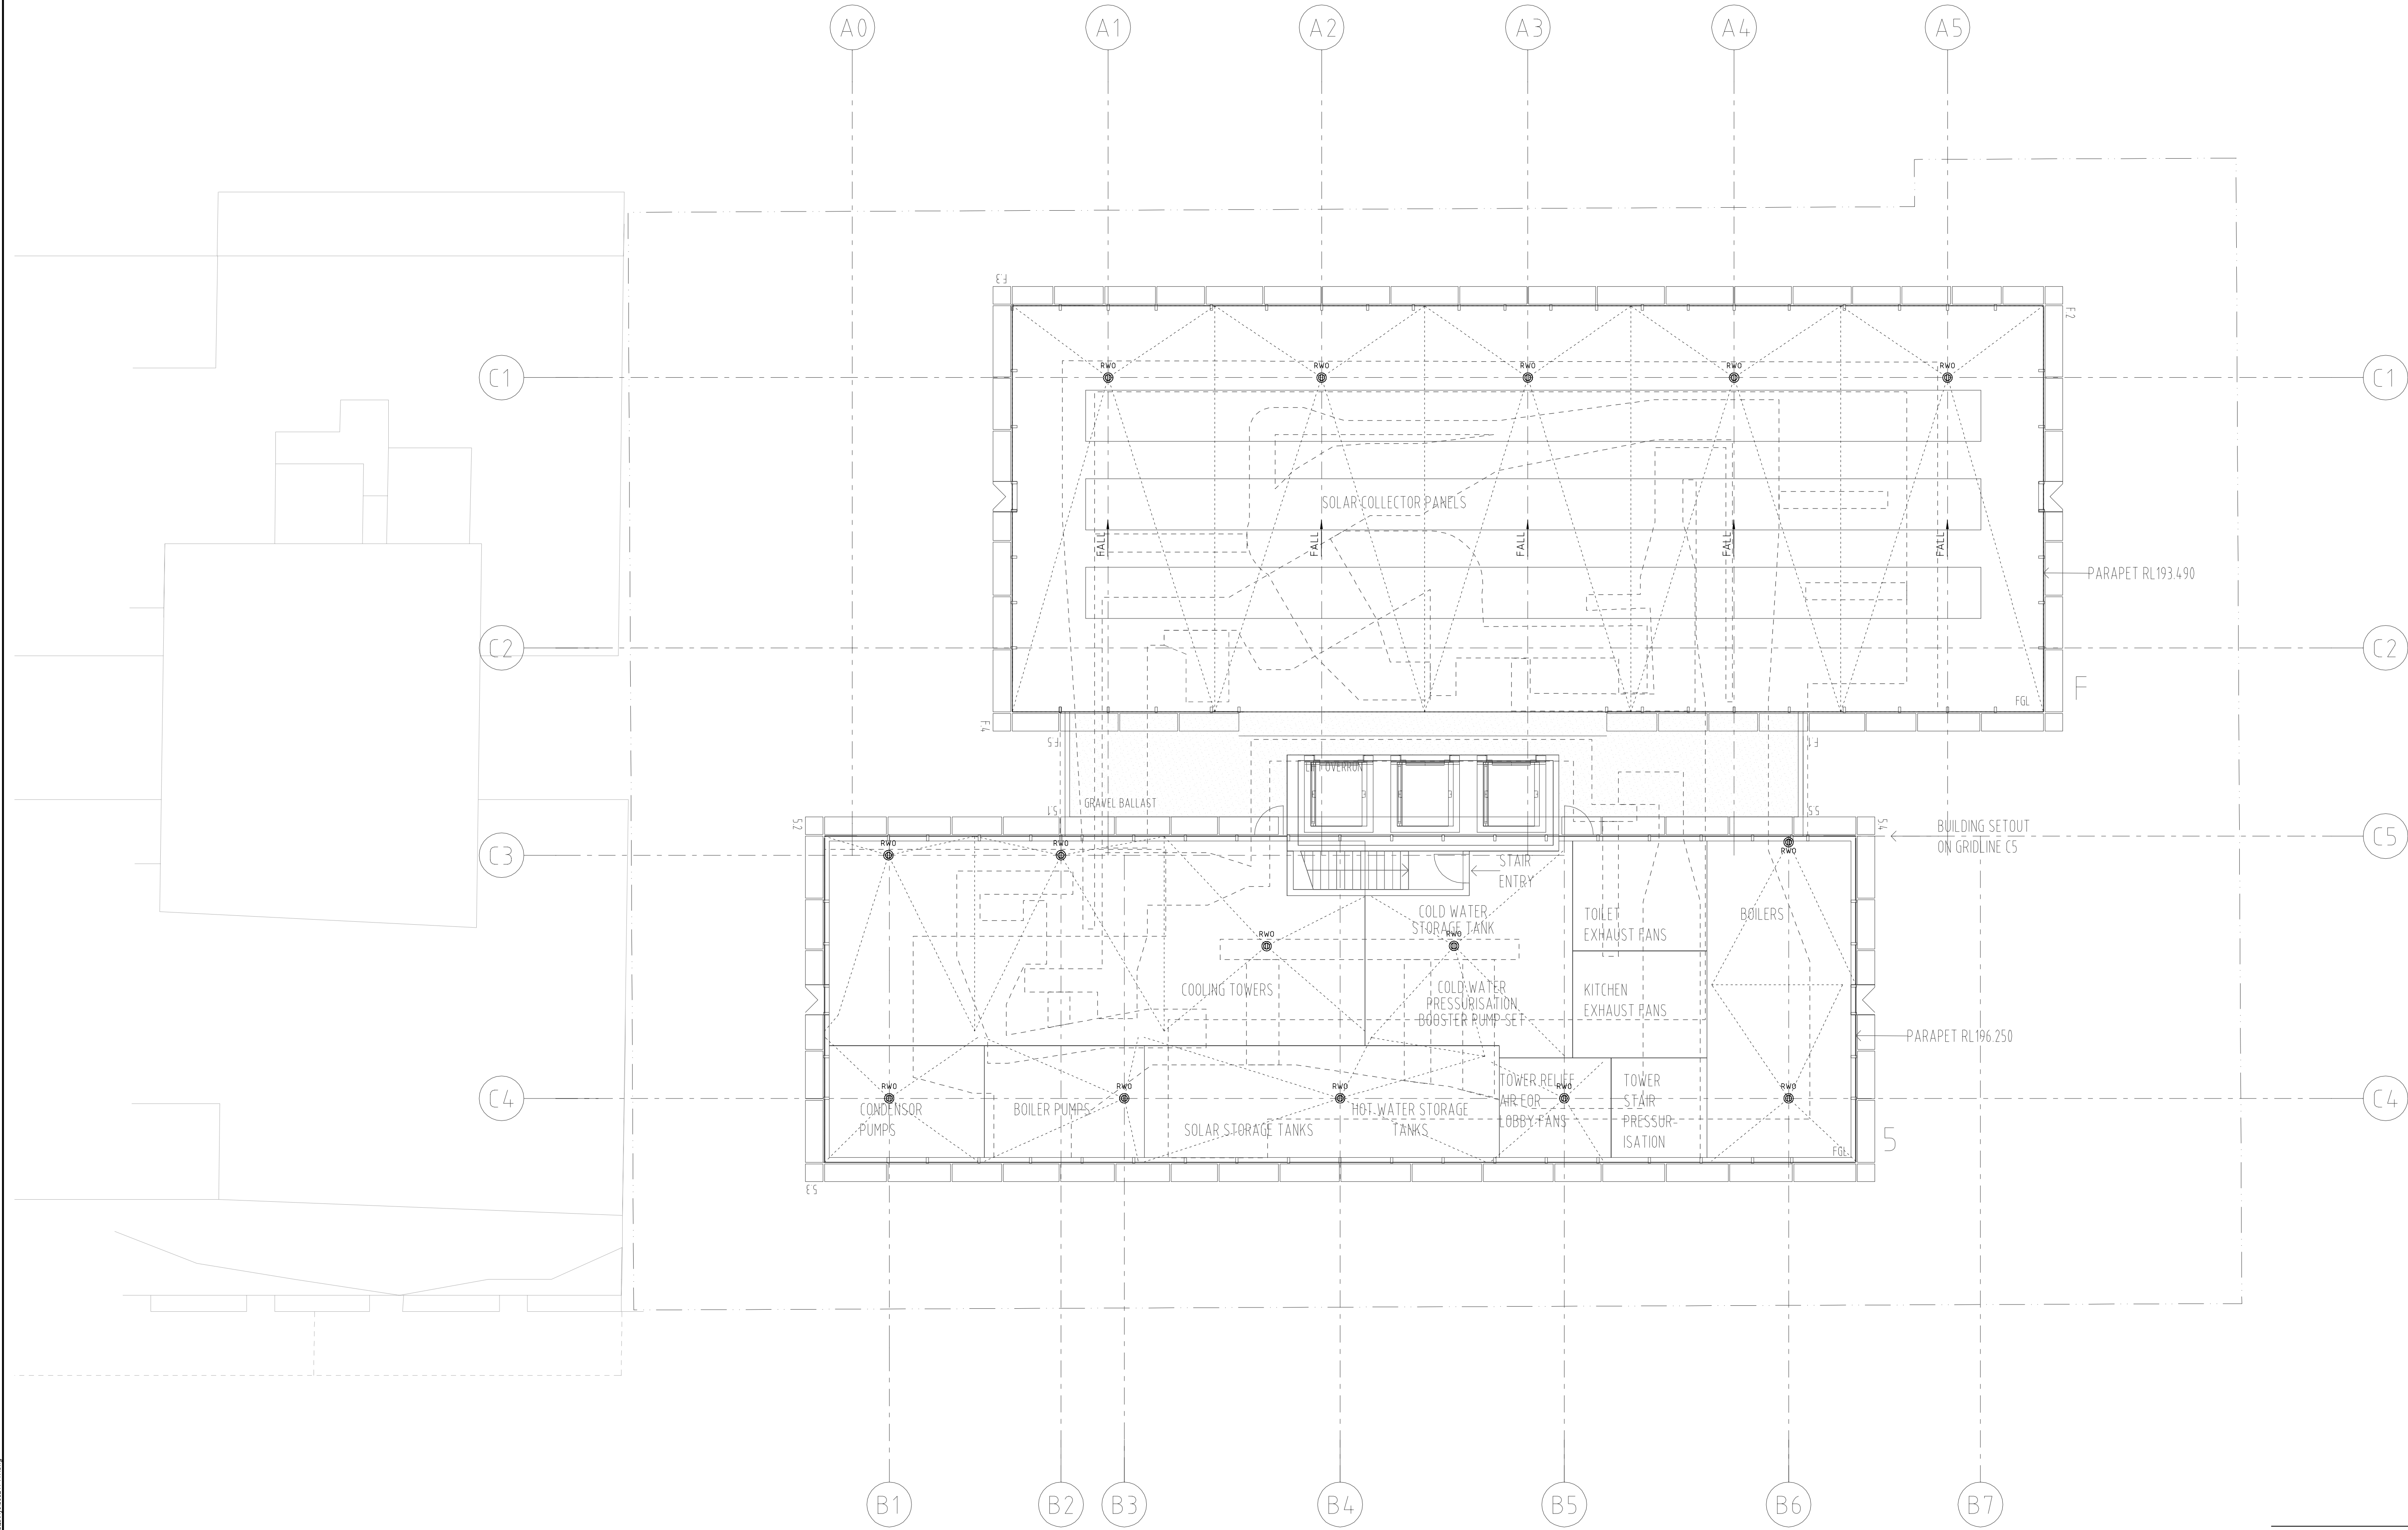

CONCEPT DESIGN
NOT TO BE USED FOR CONSTRUCTION PURPOSES

DO NOT SCALE FROM DRAWINGS, CHECK & VERIFY ALL DIMENSIONS & LEVELS BEFORE COMMENCEMENT OF ANY WORK. THIS DRAWING IS NOT TO BE COPIED IN PART OR WHOLE WITHOUT WRITTEN PERMISSION FROM WARREN SMITH AND PARTNERS.		NORTH POINT 		NOTES		ISSUE 01 02	AMENDMENT CONCEPT DESIGN ISSUE REVISED CONCEPT DESIGN ISSUE	DATE 10/06/10 25/03/11	CLIENT	ARCHITECT Level 5 MCA, 140 George Street Sydney NSW 2000 Australia T +61 2 9251 7077 F +61 2 9251 7072 E fjm@fjmt.com.au W www.fjmt.com.au NO MINOR ARCHITECT RICHARD THORPE (RICHARD THORPE)	Warren Smith & Partners Pty Ltd A 1st Floor, 123 Clarence Street, Sydney 2000 NSW Australia T 02 9299 1312 F 02 9290 1295 E wsp@warrensmith.com.au ABN 36 300 430 126 SERVING THE CONSTRUCTION INDUSTRY SINCE 1981 Consulting Engineers Hydraulic Services Civil Engineering Fire Protection Sydney Water Accredited • Water Servicing Co-ordinator • Design and Project Management		TITLE ROOF PLAN (PLANT) STORMWATER SERVICES PLAN		SCALE 1:100 @ A1 1:200 @ A3	DRAWN DN	DESIGNED DN	CHECKED WJS	APPROVED
								PROJECT Bancor - Atchison Street St Leonards - NSW				DATE March 2010		DRAWING No. H-117		JOB No. 3532		ISSUE 02	

Plot Date: Monday, 28 March 2011 11:13:08 AM

Scale: A 1:100 @ A1, 1:200 @ A3, 1:500 @ A4, 1:1000 @ A5
Plot Date: 28/03/2011 11:13:08
User Name: c:\p\warren.smith\p\warren.smith
C:\P\Warren Smith\p\warren.smith\p\warren.smith