



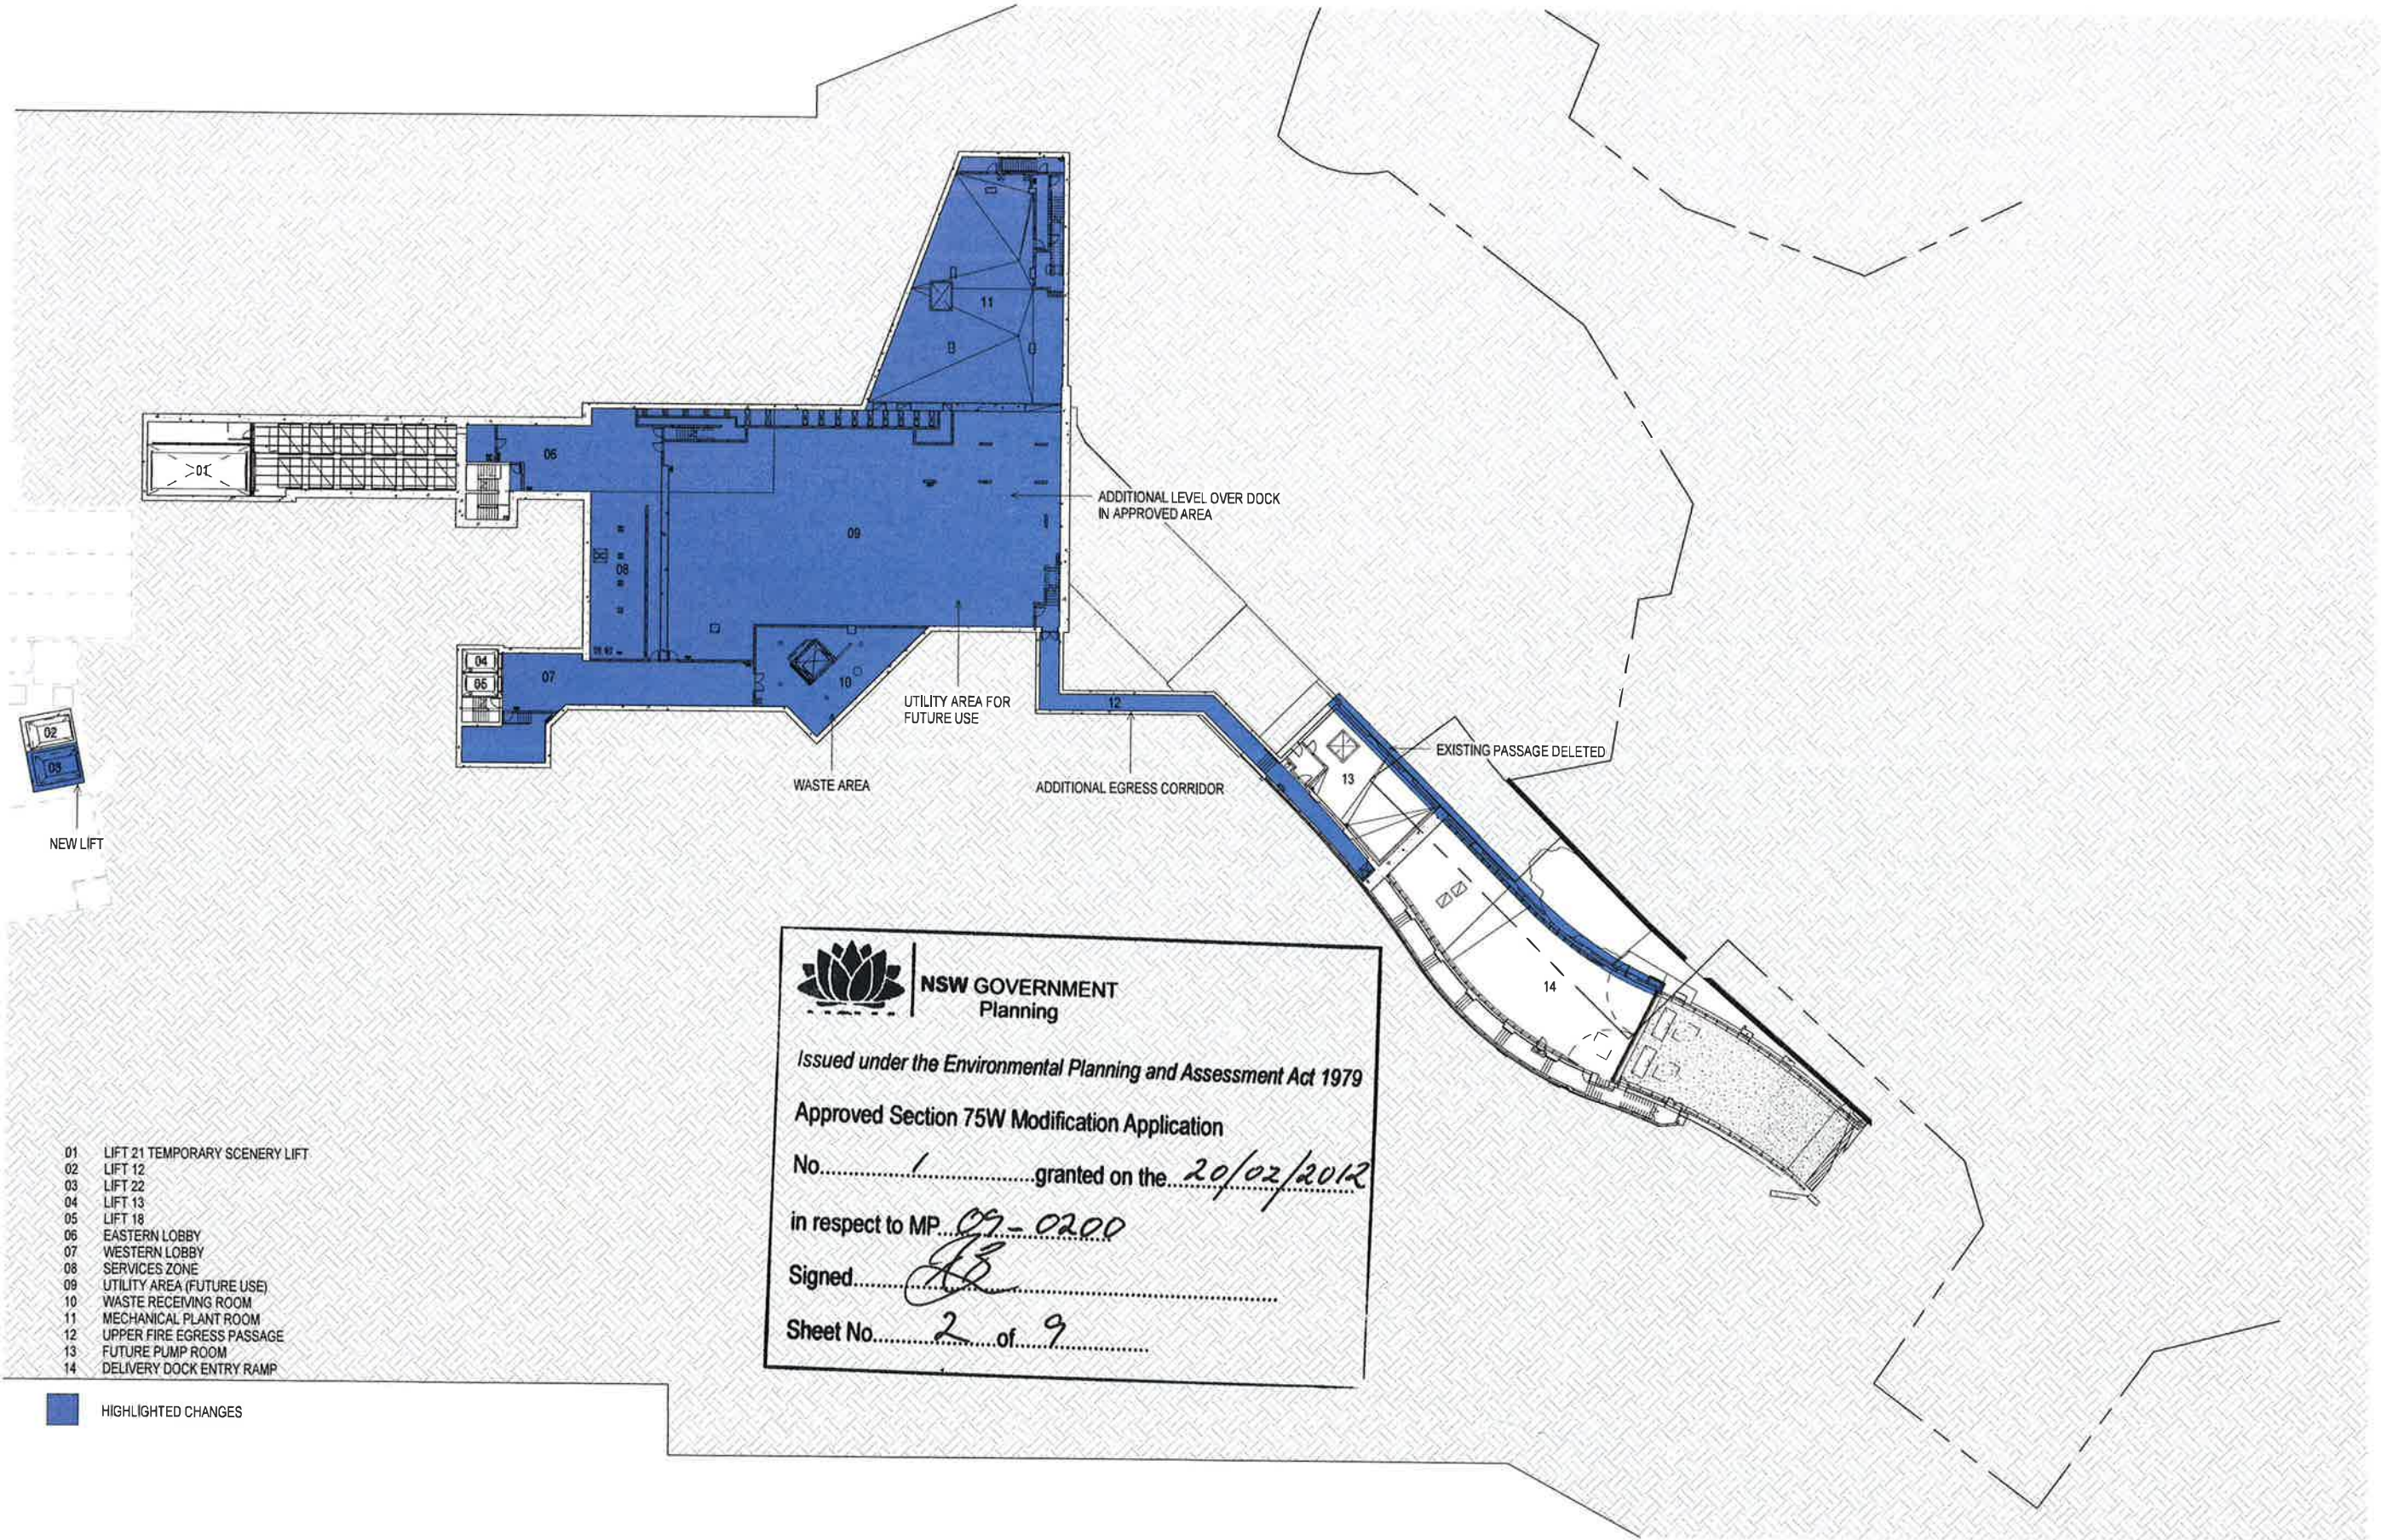

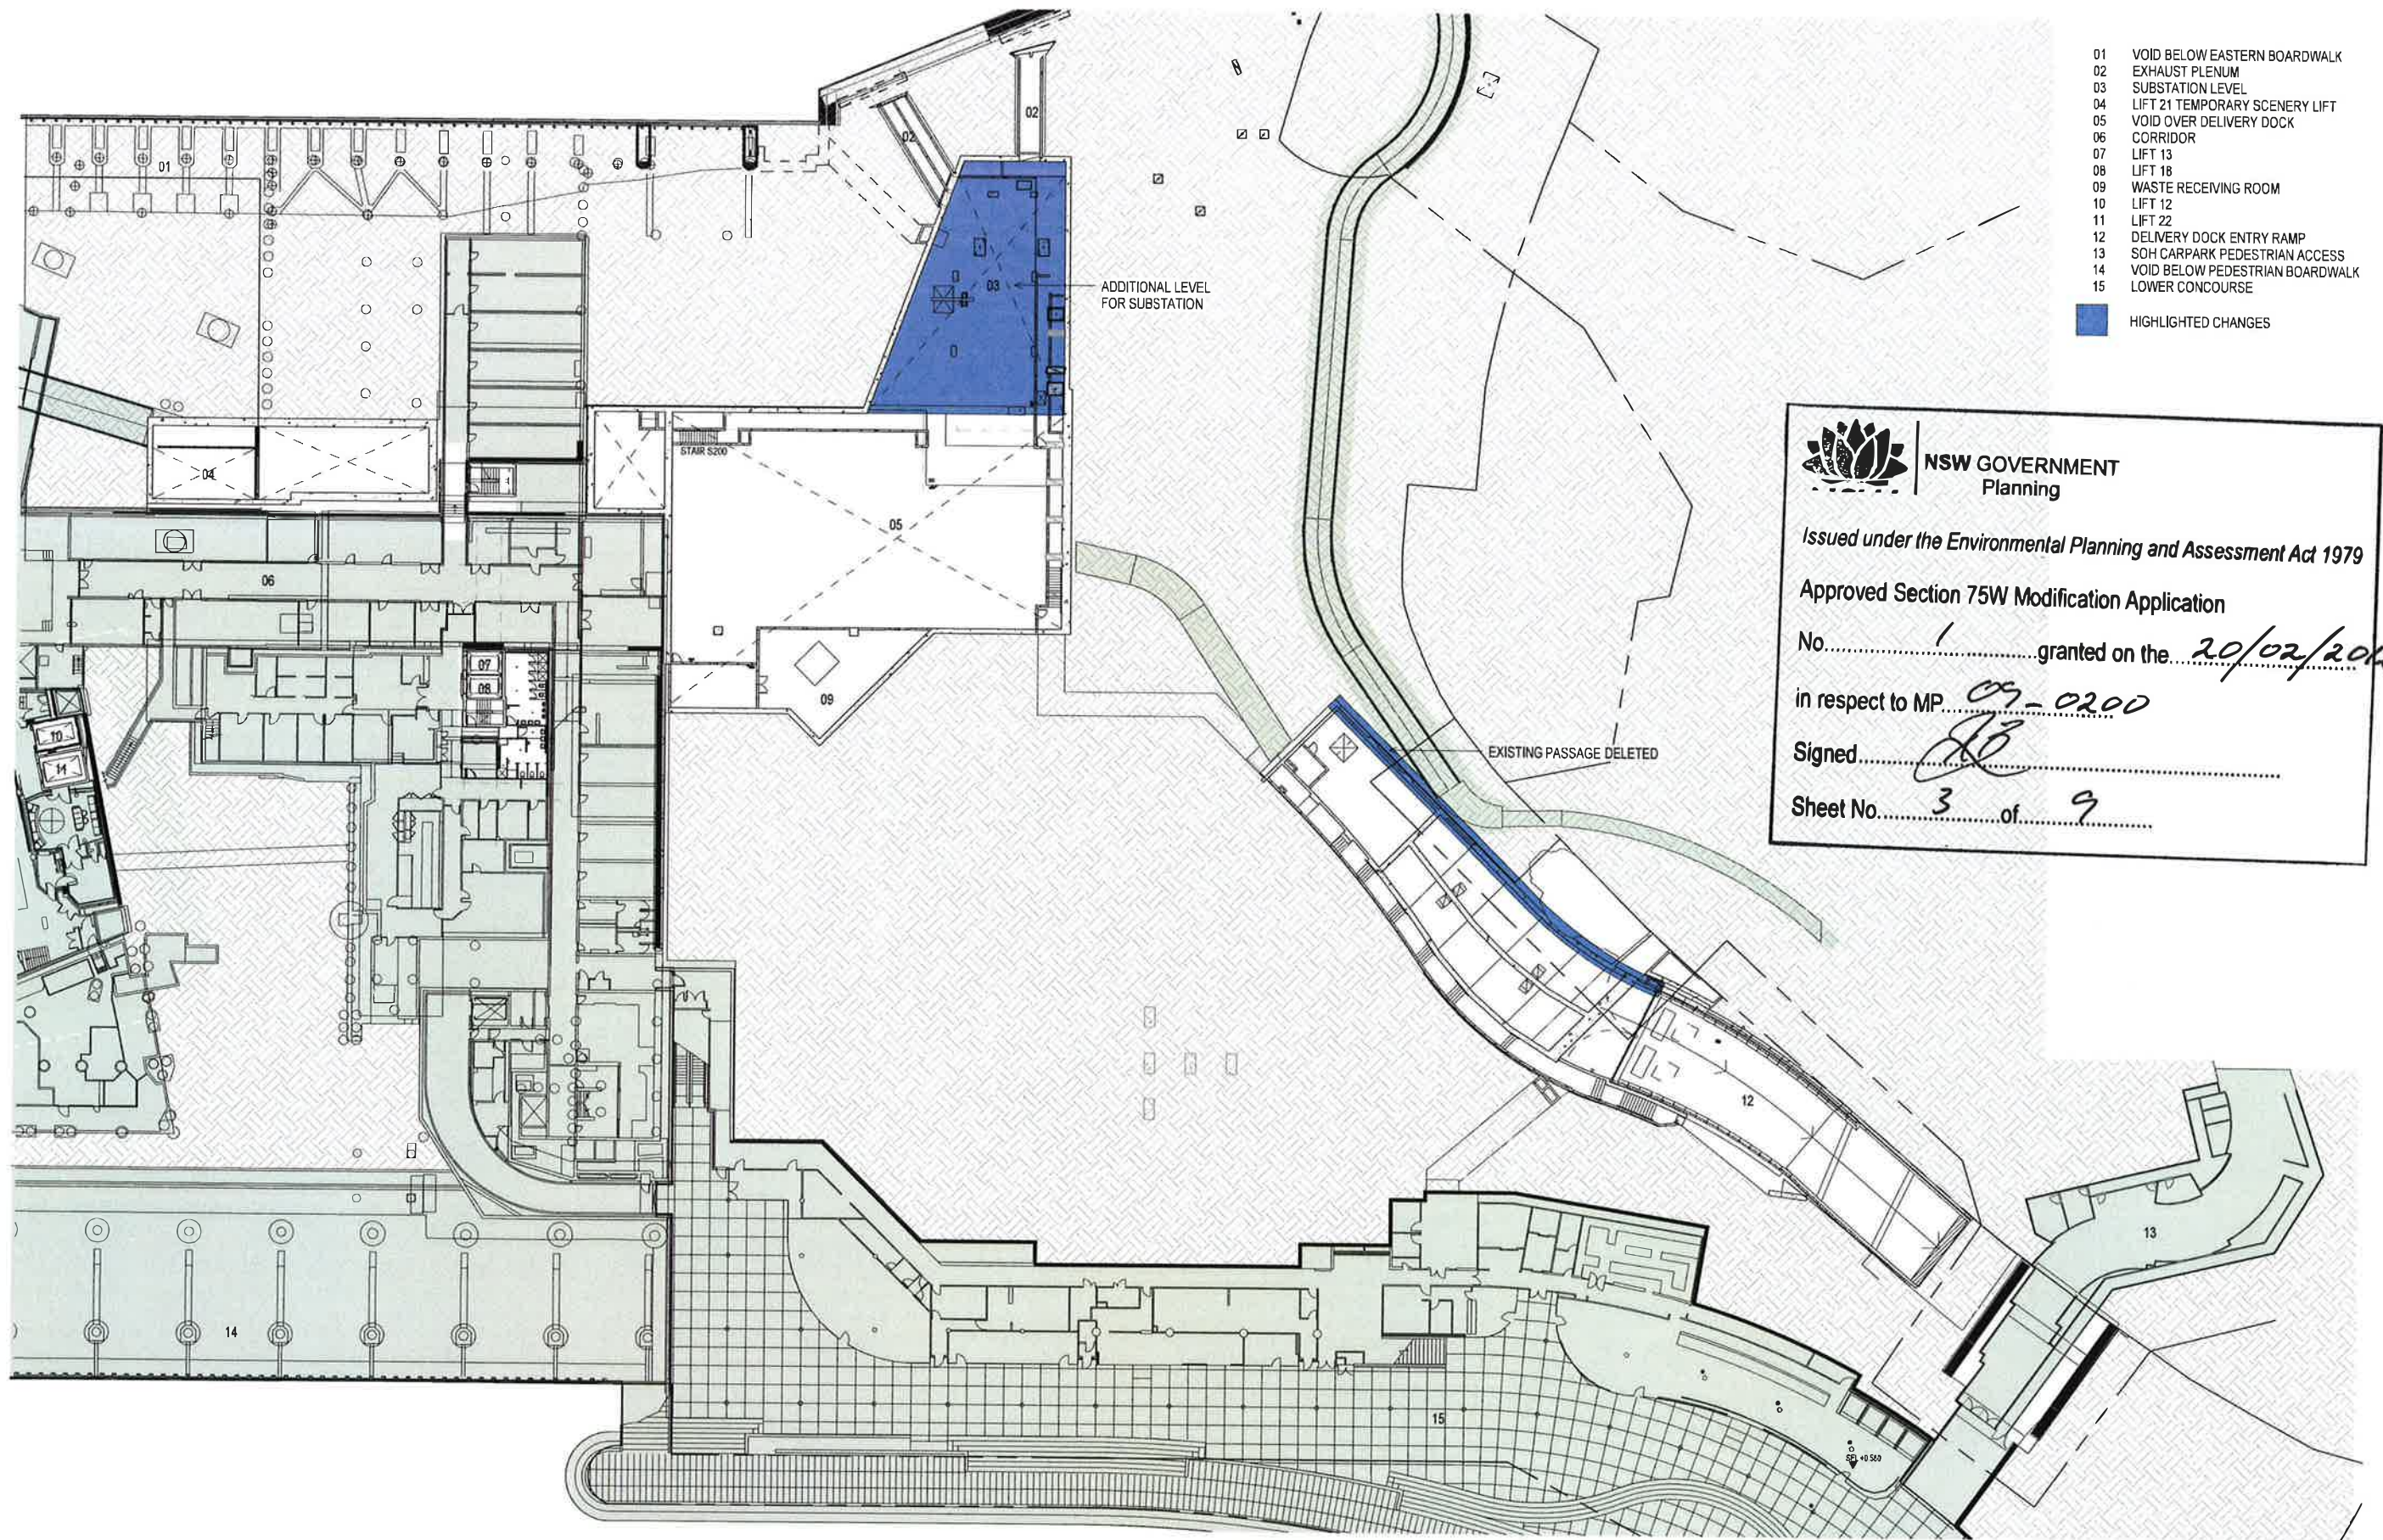

NSW GOVERNMENT
Planning

Issued under the Environmental Planning and Assessment Act 1979

Approved Section 75W Modification Application

No. 1 granted on the 20/02/2012

in respect to MP 09-0200

Signed [Signature]

Sheet No. 3 of 9

ARCHITECT
Scott Carver Pty Ltd
Level 5, 71 Macquarie Street, Sydney NSW 2000
Telephone +61 2 9557 3565
www.scottcarver.com.au


CIVIL / FIRE / SECURITY / STRUCTURE / THEATRE / TRAFFIC
ARUP
Level 10, 201 Kent Street, Sydney NSW 2000
Telephone +61 2 9220 9220
www.arup.com

ACOUSTICS / VERTICAL TRANSPORT
Herman Disney & Young
Level 5, 141 Walker Street, North Sydney NSW 2060
Telephone +61 2 9928 6800
www.hdy.com

FIRE PROTECTION
Warren Smith & Partners Pty Ltd
Level 1, 123 Clarence Street, Sydney NSW 2000
Telephone +61 2 9299 1312
www.warrensmith.com.au

ELECTRICAL / HYDRAULIC / MECHANICAL
Hydro Consulting Pty Ltd
Level 5, 141 Walker Street, North Sydney NSW 2060
Telephone +61 2 9928 6800
www.hydroconsulting.com


QUANTITY SURVEYOR
Rider Levett Bucknall
Level 5, 41 McLaren Street, North Sydney NSW 2060
Telephone +61 2 9522 2277
www.rlbc.com

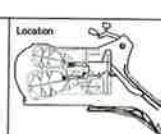

Status
FOR APPROVAL
Consent
BDM-168
Dwn JF Date 20/02/2011
Ctd DS Scale 1:500 (1:1000)

Project
Sydney Opera House - VAPS Project
ARCHITECTURAL
Title
Environmental Assessment Basement Level B1
Plan

SYDNEY OPERA HOUSE
Sydney Opera House Trust, GPO Box 4274 Sydney NSW Australia 2001
Phone +61 2 9250 7541 Fax +61 2 9247 4123
email info@sydneyoperahouse.com
Location Drawing No: BG B4 49-FV-SC001-EA-120 Sheet 3 of 11 Rev 0 A1

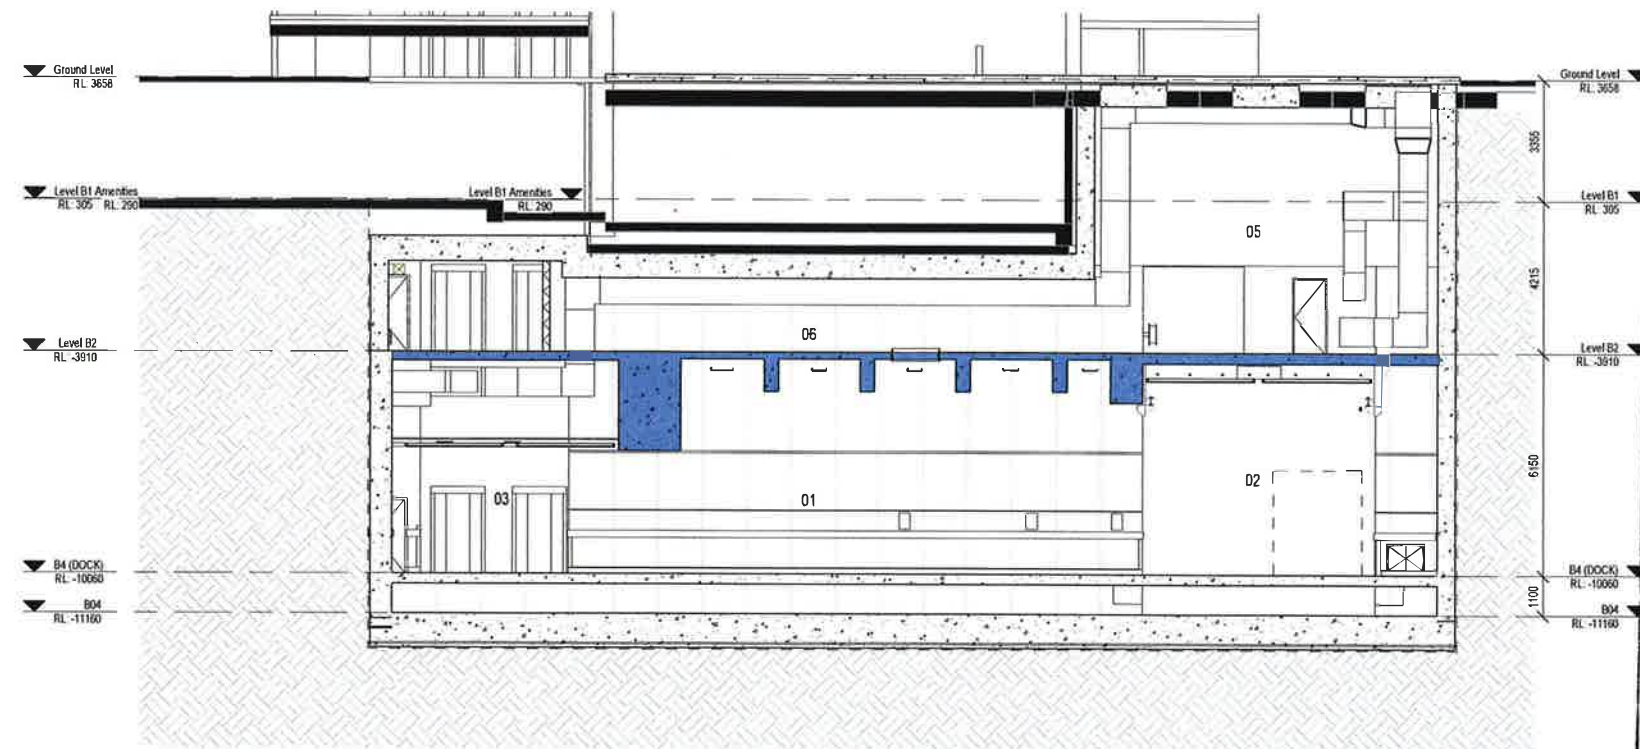

NSW GOVERNMENT
Planning

Issued under the Environmental Planning and Assessment Act 1979


Approved Section 75W Modification Application

No. 1 granted on the 20/02/2012


in respect to MP 09-0200

Signed [Signature]


Sheet No. 4 of 9

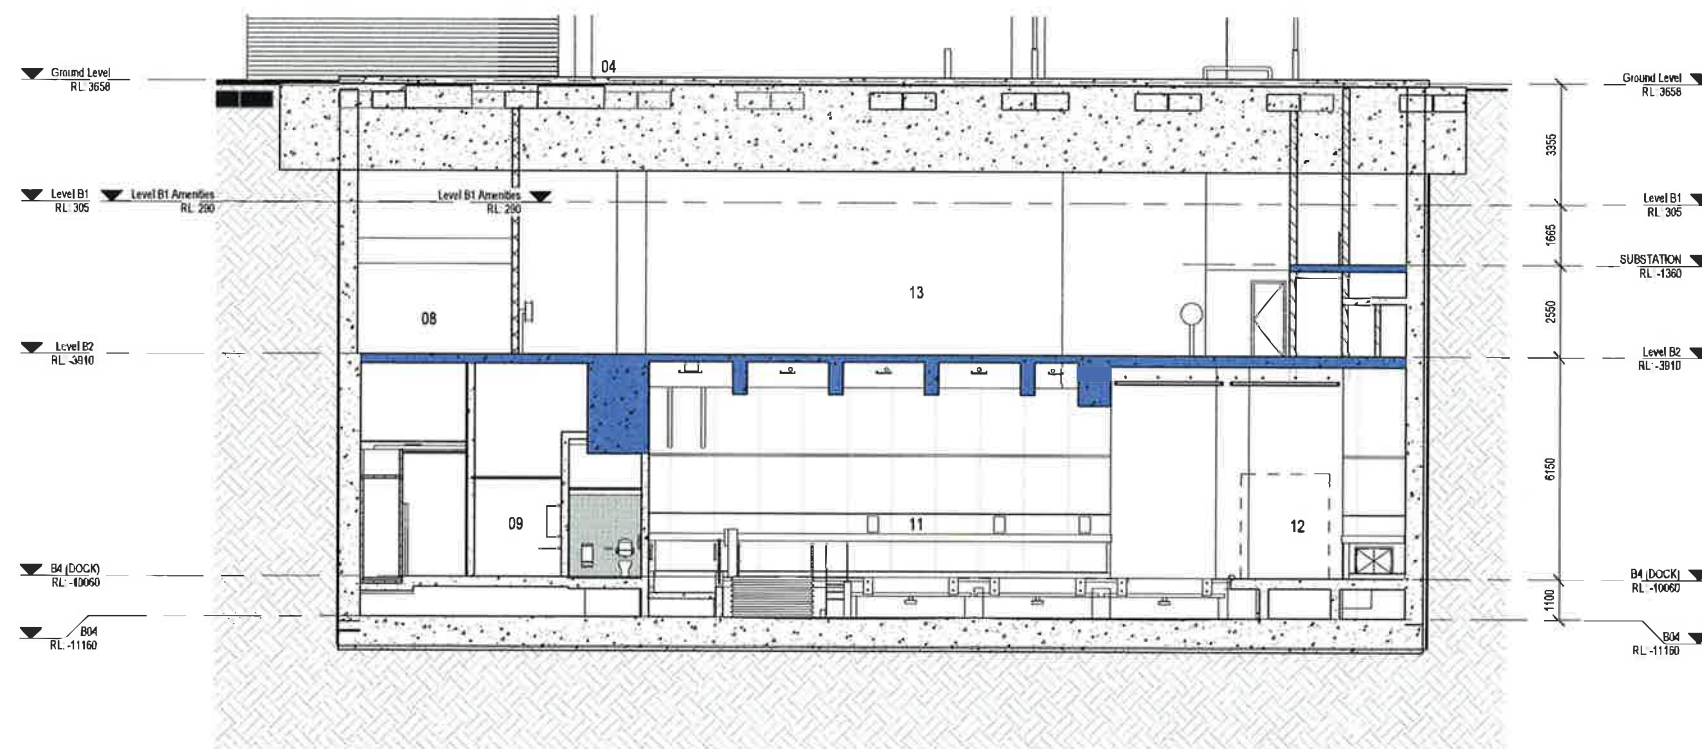

- 01 REAR LOADING DOCK
 - 02 CONCERT HALL CORRIDOR BEHIND
 - 03 LIFT 13 & 18 LOBBY BEHIND
 - 04 VEHICLE CONCOURSE
 - 05 EASTERN LOBBY
 - 06 SERVICES ZONE
 - 07 WESTERN CORRIDOR
 - 08 LOBBY
 - 09 MAIL ROOM
 - 10 TOILET
 - 11 DELIVERY DOCK
 - 12 SIDE LOADING DOCK
 - 13 UTILITY AREA (FUTURE USE)
- HIGHLIGHTED CHANGES

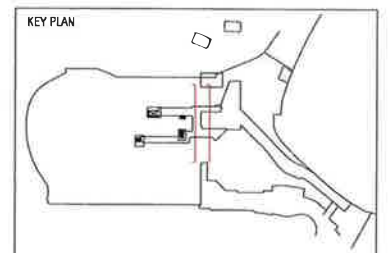

1 ISSUED FOR ENVIRONMENTAL ASSESSMENT Issue Description Drawn By Date	ARCHITECT Scott Carter Pty Ltd Level 8, 71 Macquarie Street, Sydney NSW 2000 Telephone +61 2 8957 3982 www.scotcarter.com.au CIVIL / FIRE / SECURITY / STRUCTURE / THEATRE / TRAFFIC ARUP Level 10, 201 Kent Street, Sydney NSW 2000 Telephone +61 2 9320 9320 www.arup.com	ACOUSTICS / VERTICAL TRANSPORT Norman Dickey & Young Level 1, 80 Miller Street, North Sydney NSW 2060 Telephone +61 2 9528 5800 www.ndy.com FIRE PROTECTION Warren Smith & Partners Pty Ltd Level 1, 123 Clarence Street, Sydney NSW 2000 Telephone +61 2 9298 1312 www.warrensmith.com.au	ELECTRICAL / HYDRAULIC / MECHANICAL Hydrex Consulting Pty Ltd Level 5, 141 Victoria Street, North Sydney NSW 2060 Telephone +61 2 8957 8000 www.hydrexconsulting.com QUANTITY SURVEYOR Rider Levett Bucknall Level 5, 41 Macquarie Street, North Sydney NSW 2060 Telephone +61 2 9622 2277 www.rlb.com	Location Status FOR APPROVAL Contract BDM-168 Drawn JT Check DS Date 20/12/2011 Scale 1:100 (A1 1:200 @ A3)	Project Sydney Opera House - VAPS Project ARCHITECTURAL Title Environmental Assessment Sections W-E Sheet 3 (X38_N & X30_N)	SYDNEY OPERA HOUSE Sydney Opera House Trust, GPO Box 4794, Sydney NSW Australia 2001 Phone +61 2 9258 7541 Fax +61 2 9247 4139 email info@sydneyoperahouse.com © Sydney Opera House Trust Location BG B4 Drawing No: 48-FV-SC001-EA-310 Sheet: 4 of 11 Rev: 0 A1
---	---	--	--	--	--	---

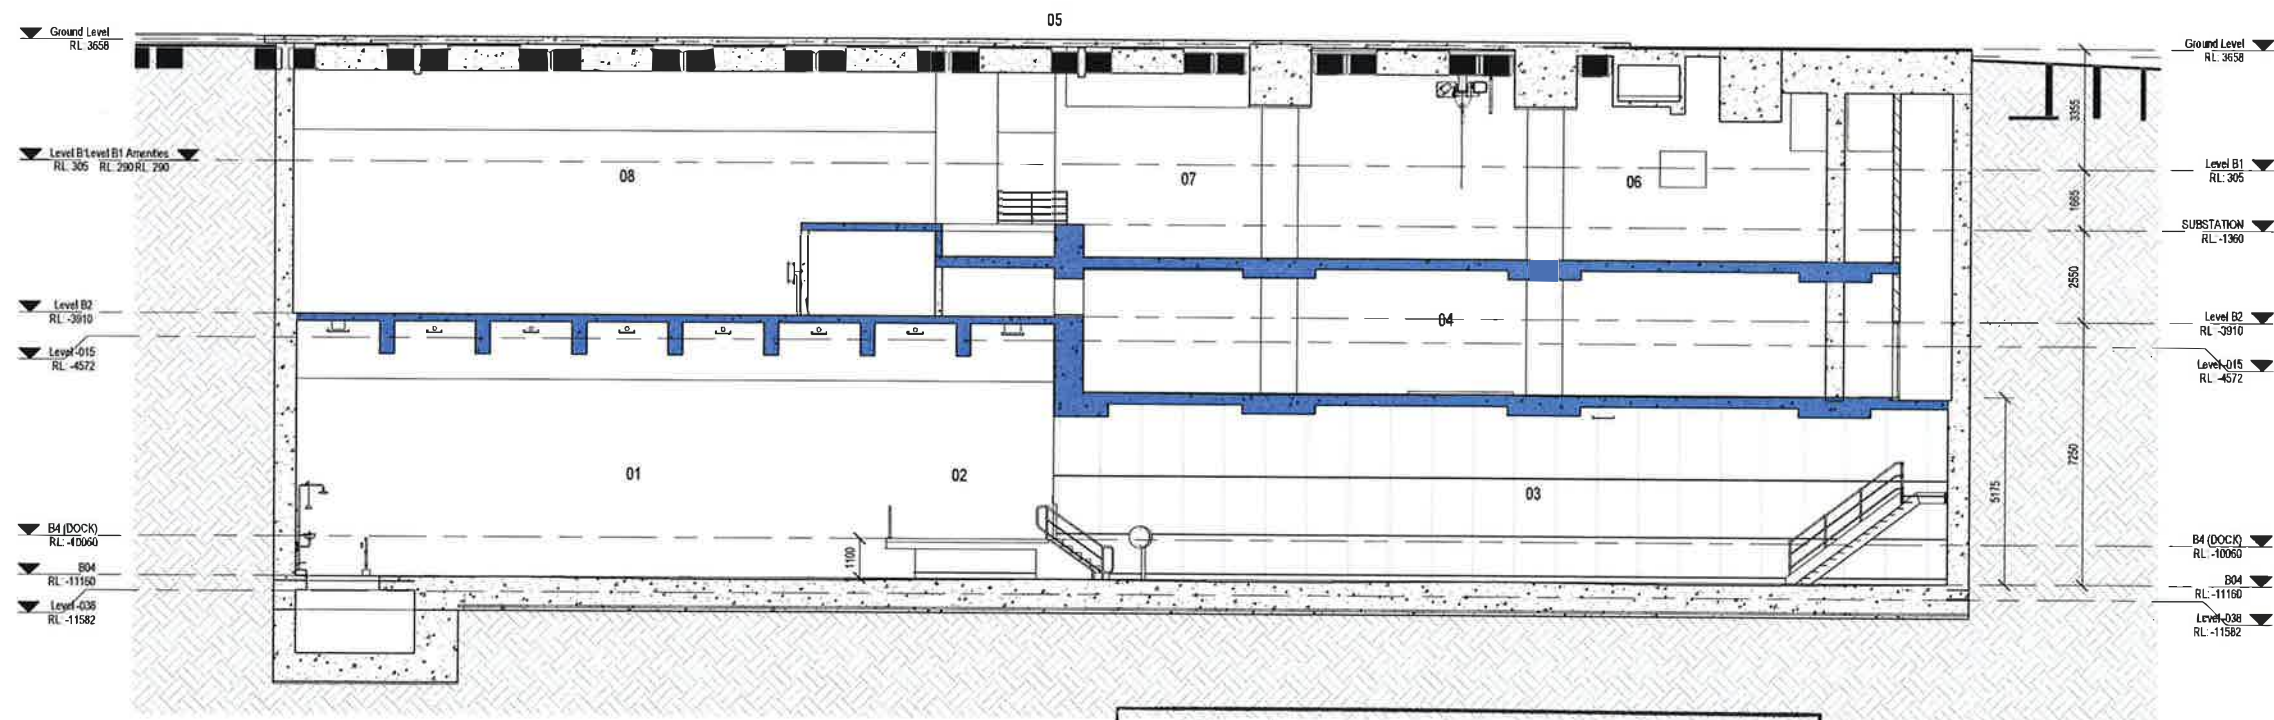

- 01 DELIVERY DOCK
- 02 SIDE LOADING DOCK
- 03 TRUCK TURNING BAY
- 04 MECHANICAL PLANT ROOM
- 05 VEHICLE CONCOURSE
- 06 SUBSTATION 1
- 07 SUBSTATION 2
- 08 UTILITY AREA (FUTURE USE)

HIGHLIGHTED CHANGES



**NSW GOVERNMENT
Planning**

Issued under the Environmental Planning and Assessment Act 1979


Approved Section 75W Modification Application

No. 1 granted on the 20/02/2012


in respect to MP 05-0200

Signed [Signature]

Sheet No. 5 of 9

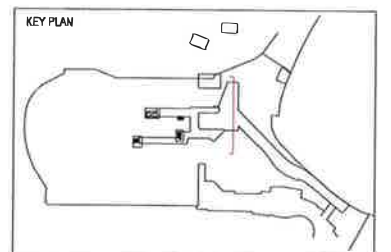

1. RECORD FOR ENVIRONMENTAL ASSESSMENT Issue Description Date 17 05 16.11.2011	ARCHITECT Scott Cayzer Pty Ltd Level 8, 71 Macquarie Street, Sydney NSW 2000 Telephone +61 2 9657 2966 www.scottcayzer.com.au CIVIL / FIRE / SECURITY / STRUCTURE / THEATRE / TRAFFIC ARUP Level 10, 201 Kent Street, Sydney NSW 2000 Telephone +61 2 8320 9320 www.arup.com	ACOUSTICS / VERTICAL TRANSPORT Northern Design & Young Level 1, 60 Miller Street, North Sydney NSW 2060 Telephone +61 2 9628 6600 www.ndy.com FIRE PROTECTION Warren Smith & Partners Pty Ltd Level 1, 123 Clarence Street, Sydney NSW 2000 Telephone +61 2 9288 1312 www.warrensmith.com.au	ELECTRICAL / HYDRAULIC / MECHANICAL Hydro Consulting Pty Ltd Level 5, 141 Walker Street, North Sydney NSW 2060 Telephone +61 2 8007 0000 www.hydroconsulting.com QUANTITY SURVEYOR Rider Levett Bucknall Level 5, 41 Macquarie Street, North Sydney NSW 2060 Telephone +61 2 9922 2277 www.rlbn.com	Location	Status FOR APPROVAL Contract BDM-168 Drawn JT Date 20/11/2011 12:03:01 PM Ckd DS Scale 1:100 @ A1 1:200 @ A0	Project Sydney Opera House - VAPS Project ARCHITECTURAL Title Environmental Assessment Section W-E Sheet 4 (X09_N)	SYDNEY OPERA HOUSE Sydney Opera House Trust, GPO Box 4374, Sydney NSW Australia 2001 Phone: +61 2 9250 7543 Fax: +61 2 9247 4139 email: info@sydneyoperahouse.com © Sydney Opera House Trust Location Drawing No Sheet Rev BG B4 49-FV-SC001-EA-320 5 of 11 0 A1
---	--	--	---	-----------------	--	---	--

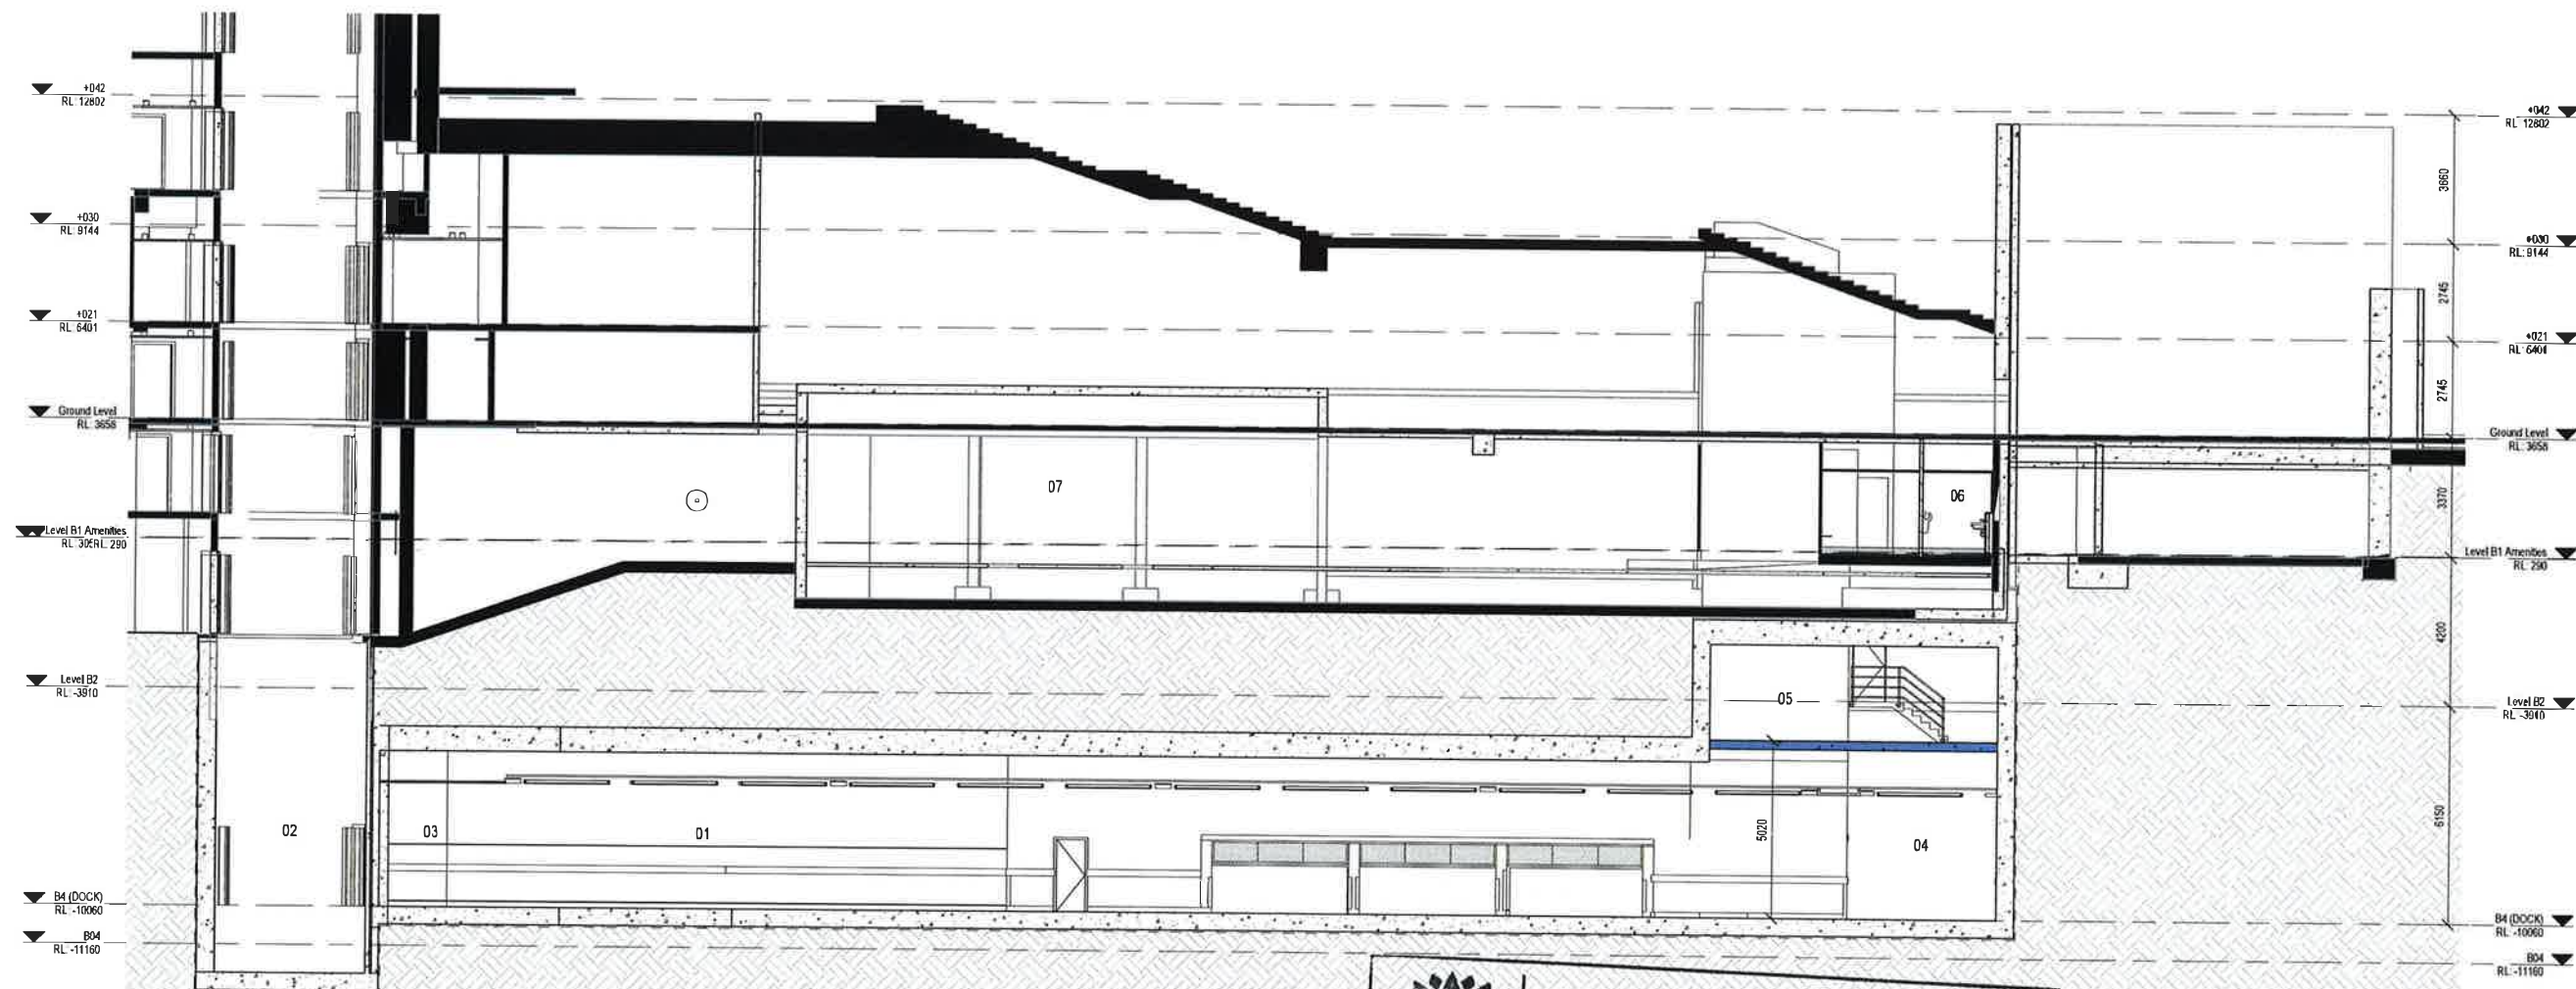

NSW GOVERNMENT
Planning

Issued under the Environmental Planning and Assessment Act 1979


Approved Section 75W Modification Application

No. 1 granted on the 20/02/2012

in respect to MP 0200

Signed [Signature]

Sheet No. 6 of 9

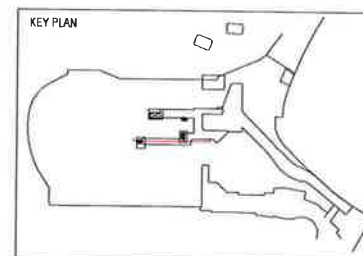


1 ISSUES FOR ENVIRONMENTAL ASSESSMENT					27 Drawn					28 Agreed					15.11.2011 Date					ARCHITECT Scott Carver Pty Ltd Level 8, 71 Macquarie Street, Sydney NSW 2000 Telephone +61 2 9557 3955 www.scottcarver.com.au					CIVIL / FIRE / SECURITY / STRUCTURE / THEATRE / TRAFFIC ARUP Level 10, 201 Kent Street, Sydney NSW 2000 Telephone +61 2 9330 9330 www.arup.com					ACOUSTICS / VERTICAL TRANSPORT Norman Disney & Young Level 1, 80 Miller Street, North Sydney NSW 2060 Telephone +61 2 9928 6690 www.ndy.com					FIRE PROTECTION Warren Smith & Partners Pty Ltd Level 1, 123 Clarence Street, Sydney NSW 2000 Telephone +61 2 9289 1312 www.warrensmith.com.au					ELECTRICAL / HYDRAULIC / MECHANICAL Hyder Consulting Pty Ltd Level 5, 141 Walker Street, North Sydney NSW 2060 Telephone +61 2 9907 9000 www.hyderconsulting.com					QUANTITY SURVEYOR Rider Levett Bucknall Level 5, 41 McLaren Street, North Sydney NSW 2060 Telephone +61 2 9932 2277 www.rlb.com					Location 					Status FOR APPROVAL					Contract BDM-168					Drawn JT					Date 20/11/2011					Chd DS					Scale 1:100 (A1: 1:2500)					Project Sydney Opera House - VAPS Project					ArchitectURAL					Title Environmental Assessment Section N-S Sheet 1 (Y21_E)					Location BG B4					Drawing No 49-FV-SC001-EA-325					Sheet 6 of 11					Rev 0					A1				
---	--	--	--	--	--------------------------------	--	--	--	--	---------------------------------	--	--	--	--	---------------------------------------	--	--	--	--	--	--	--	--	--	---	--	--	--	--	--	--	--	--	--	---	--	--	--	--	---	--	--	--	--	--	--	--	--	--	--	--	--	--	--	---	--	--	--	--	--	--	--	--	--	--------------------------------	--	--	--	--	---------------------------------------	--	--	--	--	------------------------------	--	--	--	--	--	--	--	--	--	---	--	--	--	--	--------------------------	--	--	--	--	--	--	--	--	--	--------------------------------------	--	--	--	--	---	--	--	--	--	-------------------------------------	--	--	--	--	-----------------------------	--	--	--	--	---------------	--	--	--	--





NSW GOVERNMENT
Planning


Issued under the Environmental Planning and Assessment Act 1979
 Approved Section 75W Modification Application
 No. 1 granted on the 20/02/2012
 in respect to MP 09-0200
 Signed [Signature]
 Sheet No. 7 of 9

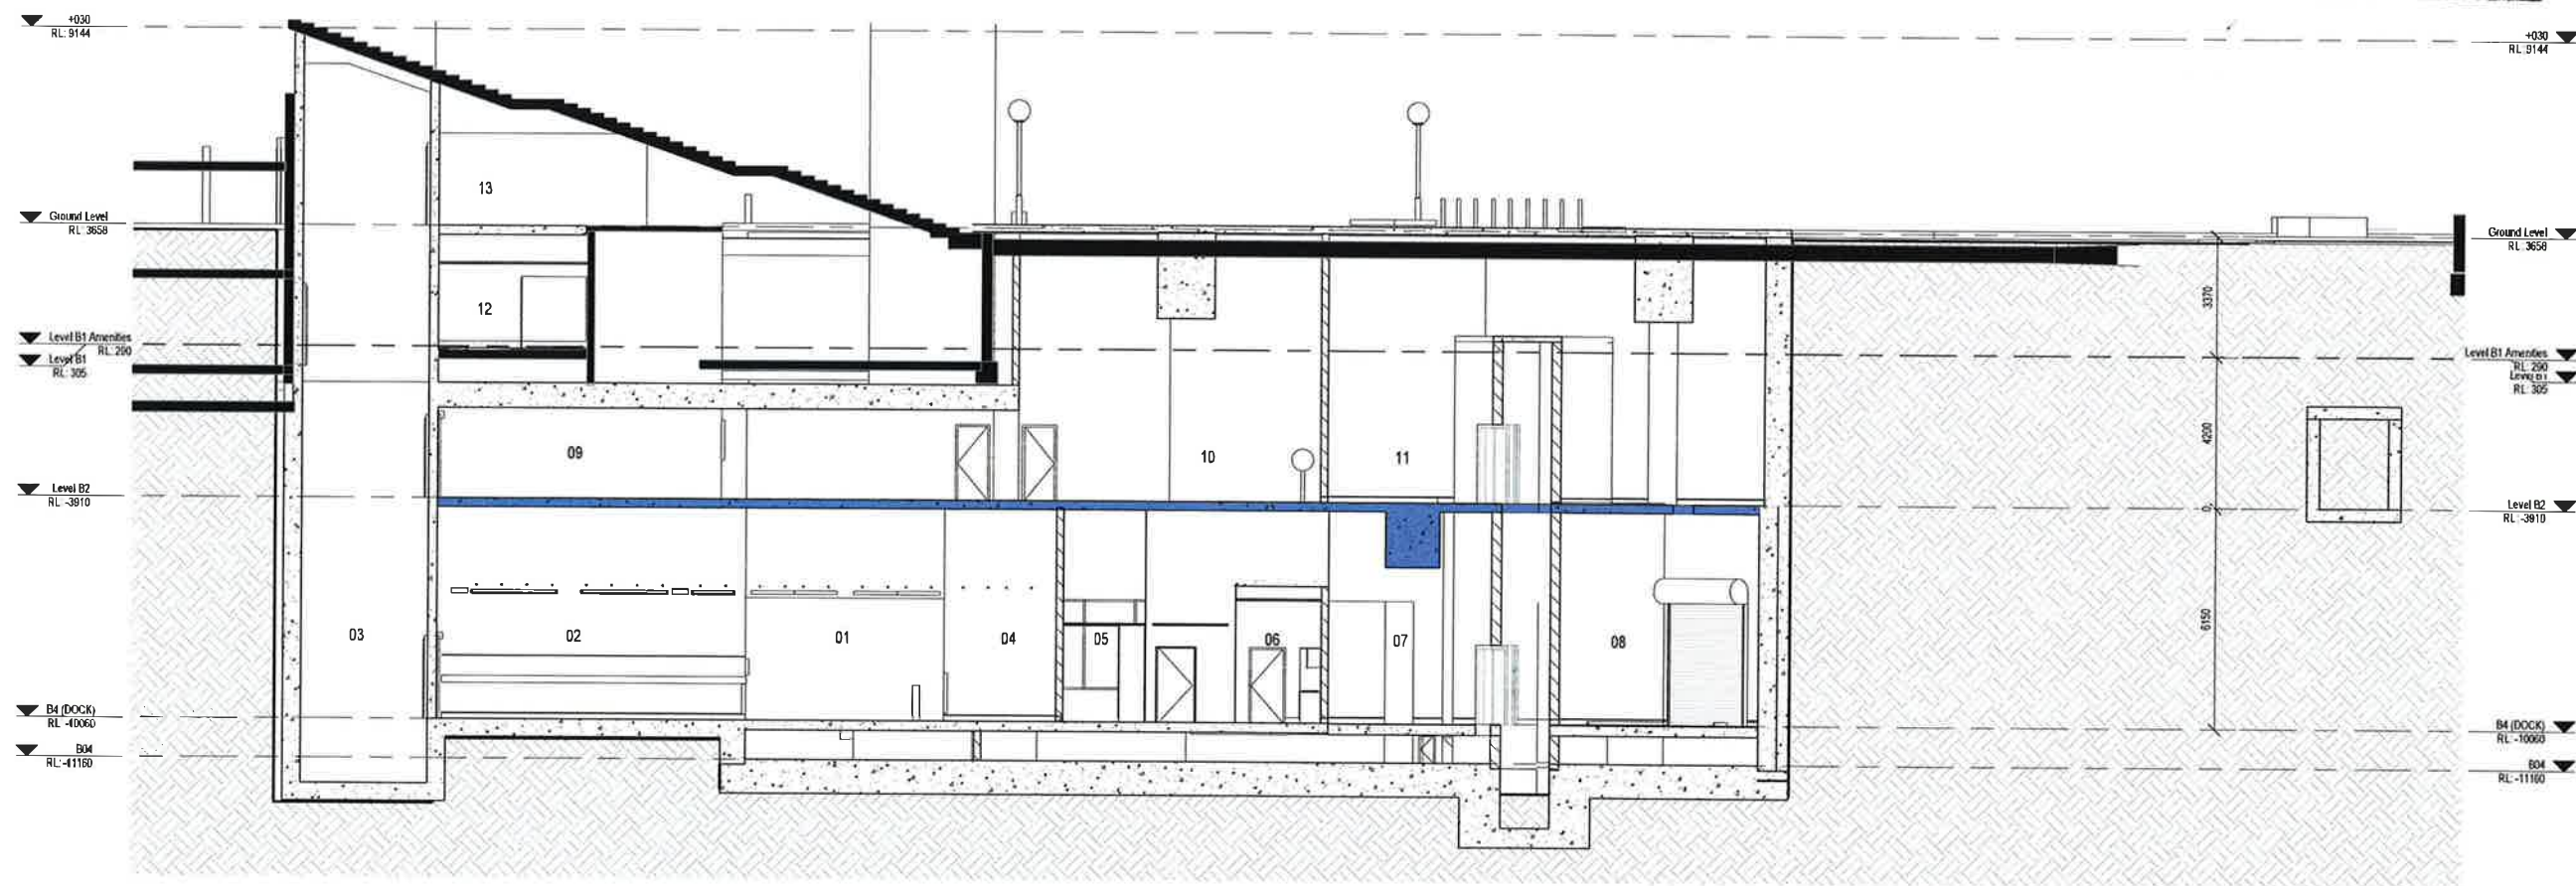

 - 01 REAR LOADING DOCK
 - 02 LIFT LOBBY
 - 03 LIFT 13
 - 04 LOBBY
 - 05 DOCK OFFICE
 - 06 KITCHEN
 - 07 WASTE STORAGE ROOM
 - 08 COMPACTOR ROOM
 - 09 WESTERN LOBBY
 - 10 WESTERN CORRIDOR
 - 11 WASTE RECEIVING ROOM
 - 12 MALE CHANGE ROOM
 - 13 EXISTING LOBBY
- HIGHLIGHTED CHANGES

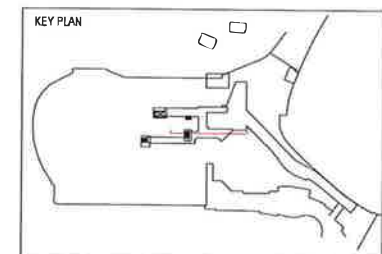

1 ISSUED FOR ENVIRONMENTAL ASSESSMENT Date: _____ Description: _____ Draw: _____ Date: _____				ARCHITECT Scott Carter Pty Ltd Level 8, 71 Macquarie Street, Sydney NSW 2000 Telephone +61 2 9557 3888 www.scottcarter.com.au		CIVIL / FIRE / SECURITY / STRUCTURE / THEATRE / TRAFFIC ARUP Level 10, 201 Kent Street, Sydney NSW 2000 Telephone +61 2 9350 9300 www.arup.com		ACoustics / VERTICAL TRANSPORT Norman Disney & Young Level 1, 80 Miller Street, North Sydney NSW 2060 Telephone +61 2 9928 6500 www.ndy.com		FIRE PROTECTION Warren Smith & Partners Pty Ltd Level 1, 123 Clarence Street, Sydney NSW 2000 Telephone +61 2 9250 1312 www.warrensmith.com.au		ELECTRICAL / HYDRAULIC / MECHANICAL Hydrex Consulting Pty Ltd Level 5, 141 William Street, North Sydney NSW 2060 Telephone +61 2 9407 5000 www.hydrexconsulting.com		QUANTITY SURVEYOR Rider Levett Bucknall Level 5, 41 McLaren Street, North Sydney NSW 2060 Telephone +61 2 9922 2277 www.rlb.com		Location: 		Status: FOR APPROVAL Contract: BDM-168 Drawn: JT Date: 25/11/2011 Cld: 05 Scale: 1:100 (A1, 1:200 (A2))		Project: Sydney Opera House - VAPS Project ARCHITECTURAL Title: Environmental Assessment Section N-S Sheet 2 (Y25_E)		 Sydney Opera House Trust, GPO Box 4274 Sydney NSW Australia 2001 Phone: +61 2 9250 7541 Fax: +61 2 9247 4109 email: info@sydneyoperahouse.com Location: BG B4 Drawing No: 49-FV-SC001-EA-330 Sheet: 7 of 11 Rev: 0 A1			
---	--	--	--	---	--	--	--	---	--	--	--	---	--	---	--	---	--	--	--	--	--	--	--	--	--

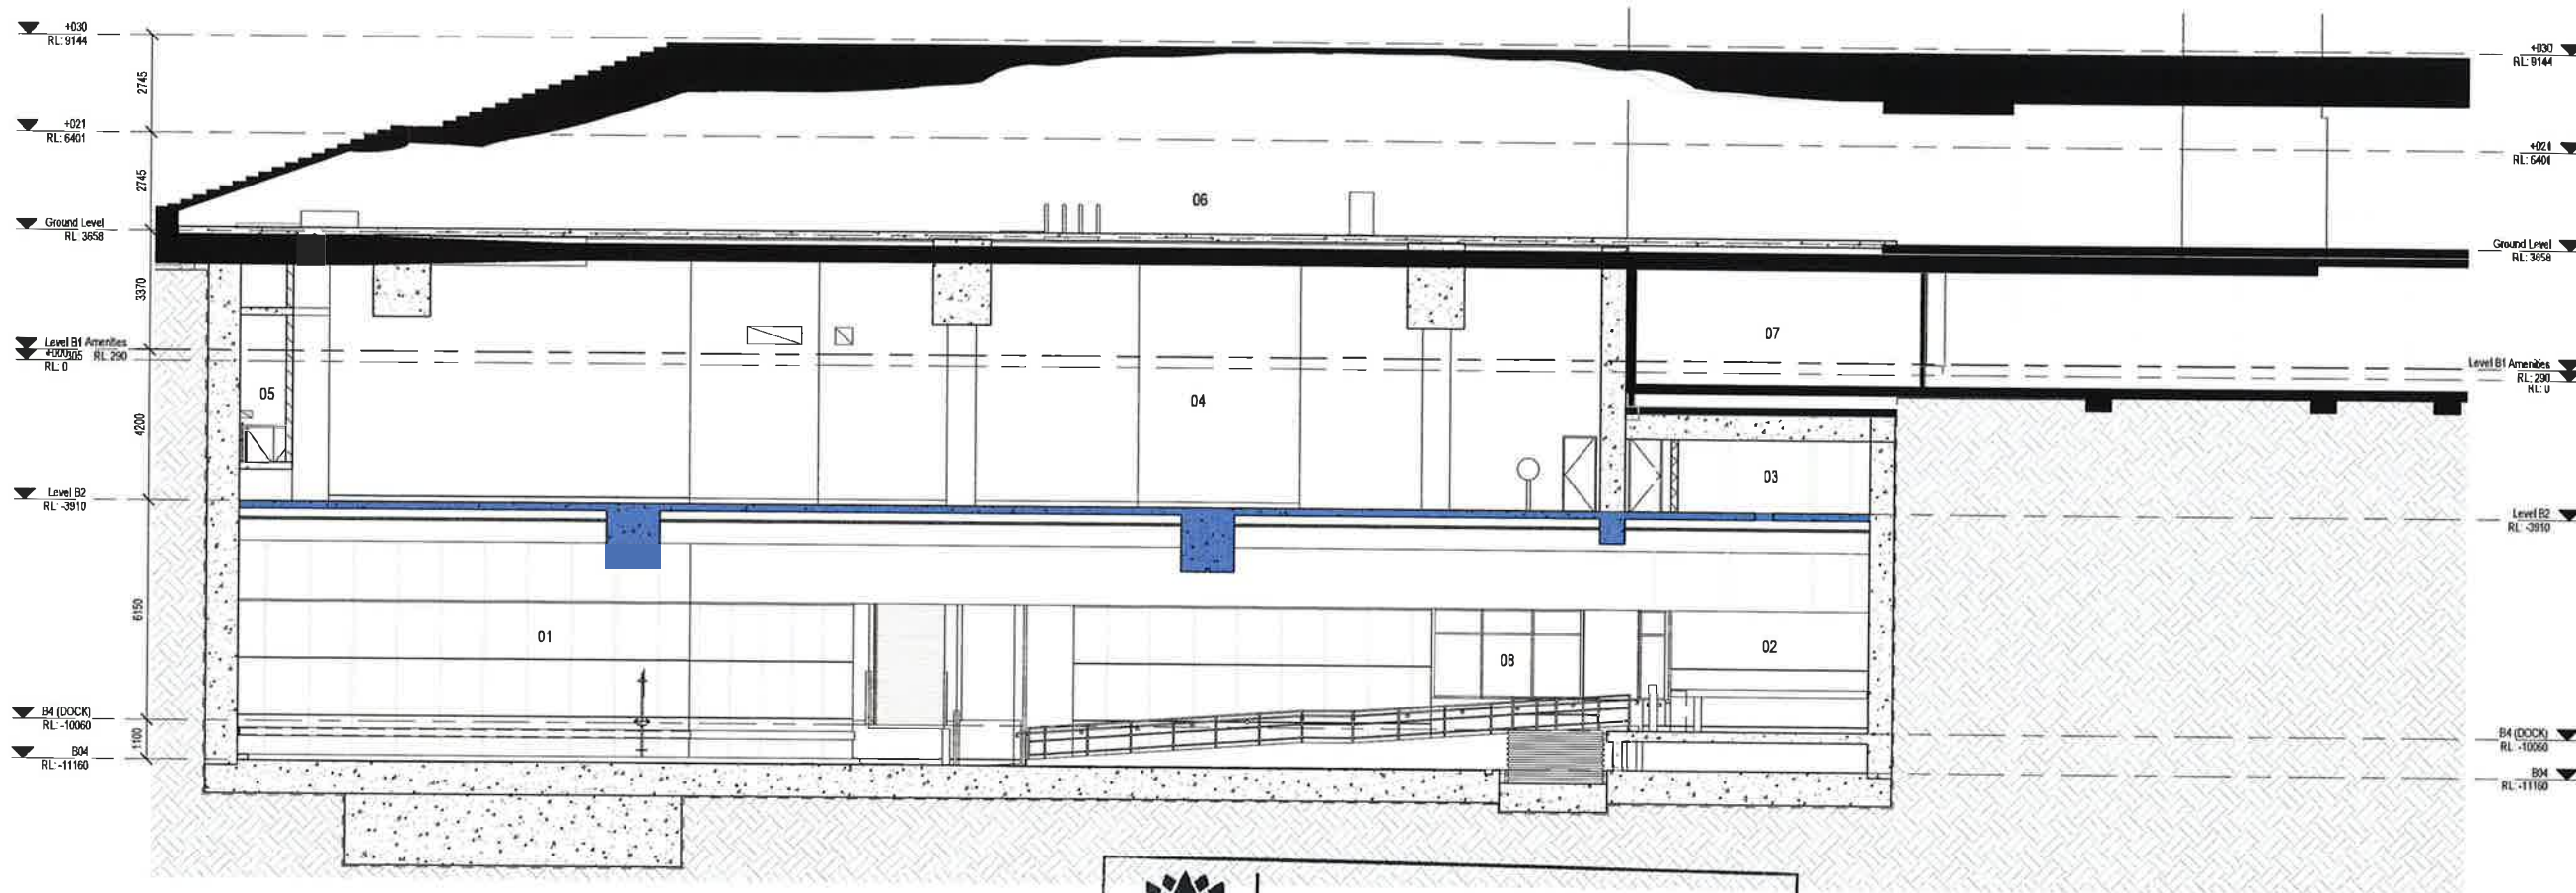

- 01 DELIVERY DOCK
- 02 REAR LOADING DOCK
- 03 SERVICES ZONE
- 04 UTILITY AREA (FUTURE USE)
- 05 UPPER FIRE EGRESS PASSAGE
- 06 VEHICLE CONCOURSE
- 07 ELECTRICAL ROOM
- 08 DOCK OFFICE BEHIND

HIGHLIGHTED CHANGES



NSW GOVERNMENT
Planning

Issued under the Environmental Planning and Assessment Act 1979


Approved Section 75W Modification Application

No. granted on the 20/02/2012



in respect to MP 09-0200

Signed.

Sheet No. 8 of 9

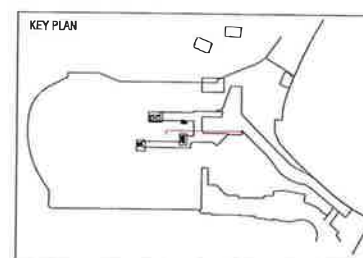

1 ISSUED FOR ENVIRONMENTAL ASSESSMENT Drawn: JT Date: 15.11.2011	ARCHITECT Scott Carver Pty Ltd Level 9, 71 Macquarie Street, Sydney NSW 2000 Telephone +61 2 9557 3666 www.scottcarver.com.au CIVIL / FIRE / SECURITY / STRUCTURE / THEATRE / TRAFFIC ARUP Level 10, 201 Kent Street, Sydney NSW 2000 Telephone +61 2 9220 9320 www.arup.com	ACOUSTICS / VERTICAL TRANSPORT Norman Disney & Young Level 1, 40 Miller Street, North Sydney NSW 2060 Telephone +61 2 9928 6600 www.ndy.com FIRE PROTECTION Warren Smith & Partners Pty Ltd Level 1, 123 Clarence Street, Sydney NSW 2000 Telephone +61 2 9250 1212 www.warrensmith.com.au	ELECTRICAL / HYDRAULIC / MECHANICAL Hydrex Consulting Pty Ltd Level 5, 141 Walker Street, North Sydney NSW 2060 Telephone +61 2 9507 8000 www.hydrexconsulting.com QUANTITY SURVEYOR Rivers Levee Bucknell Level 5, 41 McLaren Street, North Sydney NSW 2060 Telephone +61 2 9522 2277 www.rivers.com	Location Status FOR APPROVAL Contract BDM-168 Drawn: JT Date: 20/11/2011 Ctd: DS Scale: 1:100 (A1, 1:200 (A2))	Project Sydney Opera House - VAPS Project ARCHITECTURAL Title Environmental Assessment Section S-N Sheet 4 (Y29_W)	SYDNEY OPERA HOUSE Sydney Opera House Trust GPO Box 4274 Sydney NSW Australia 2001 Phone +61 2 9250 7541 Fax +61 2 9247 4139 email info@sydneyoperahouse.com Location BG B4 Drawing No: 49-FV-SC001-EA-338 Sheet: 8 of 11 Rev: 0 A1
--	--	--	---	---	---	--

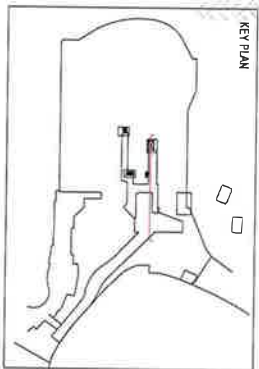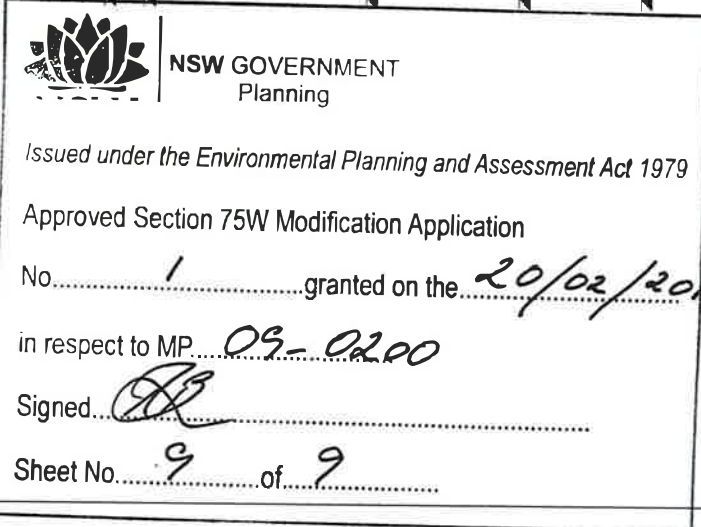

- | | |
|----|--------------------------------|
| 01 | DELIVERY DOCK |
| 02 | REAR LOADING DOCK |
| 03 | TRUCK TURNING BAY |
| 04 | DELIVERY DOCK ENTRY RAMP |
| 05 | OPERA THEATRE CORRIDOR |
| 06 | LIFT 21 TEMPORARY SCENERY LIFT |
| 07 | LOWER MOTOR ROOM |
| 08 | FIRE STAIR S98 |
| 09 | EASTERN LOBBY |
| 10 | UTILITY AREA (FUTURE USE) |
| 11 | UPPER EGRESS PASSAGE |
| | HIGHLIGHTED CHANGES |

HIGHLIGHTED CHANGES