
 
 
 



LEGEND


- 

 
CONCRETE WALL / COLUMN  
REFER TO STRUCTURAL  
ENG SPEC
- 

 
190 BLOCK WALL
- 

 
140 BLOCK WALL
- 

 
92 STUD WALL  
TYPICAL-REFER TO  
SPEC FOR LINING INFO
- 

 
SC STEEL COLUMN REFER TO  
STRUCTURAL ENG SPEC.
- 


WS WALL STIFFENER REFER TO  
STRUCTURAL ENG SPEC.
- 


HR1 HANDRAIL 1  
TIMBER HANDRAIL
- 


HR2 HANDRAIL 2  
EXTERNAL S.S HANDRAIL
- 


HR3 HANDRAIL 3  
INTERNAL S.S HANDRAIL
- 

 
HR4 HANDRAIL 4  
GAL. STEEL HANDRAIL
- 


GB1 GLASS BALUSTRADE  
TYPE 1
- 


GB1 GLASS BALUSTRADE  
TYPE 2
- 


TA TACTILE INDICATORS
- 

SLAB PENETRATION
- 

2HR 2 HOUR FIRE RATED WALL
- 

DRENCH DRENCHERS
- 

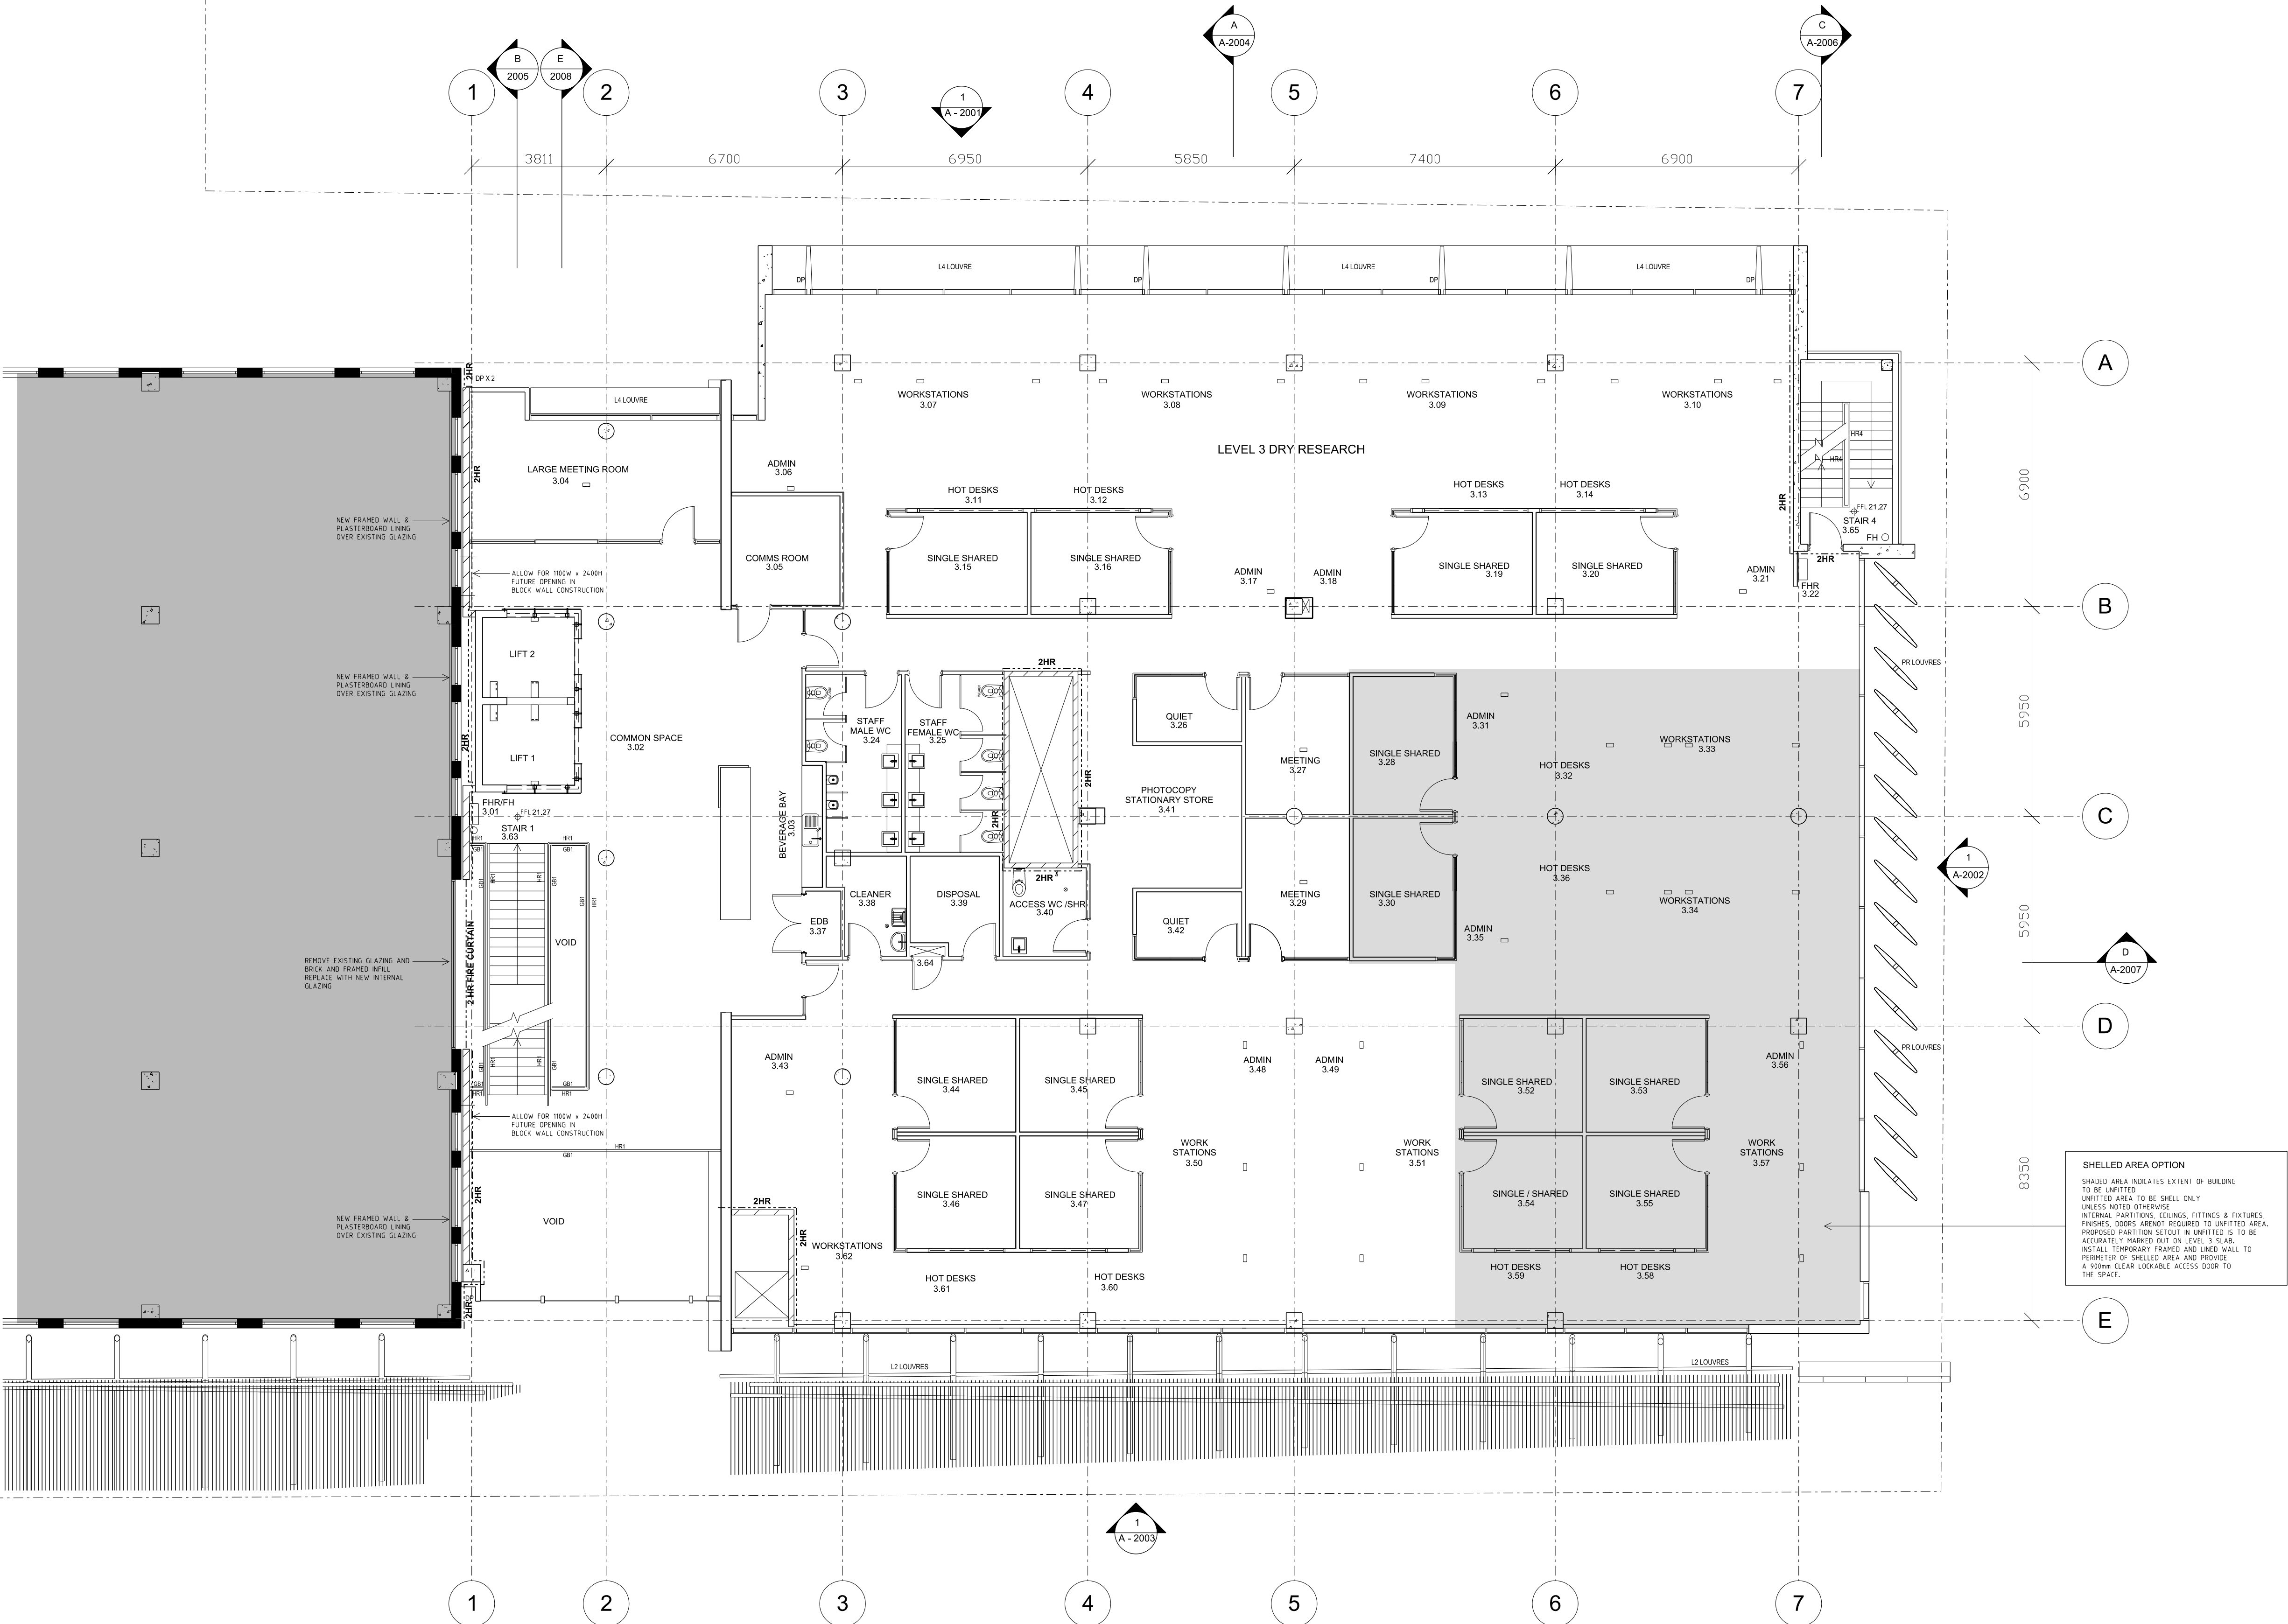
2 HR FIRE CURTAIN FIRE CURTAIN
- 

RS ROLLER SHUTTER
- 

CW CHAIN WIRE FENCE & GATE

GENERAL NOTES

- DOOR NIBS ON HINGE SIDE 100mm  
UNLESS DETAILED OR NOTED OTHERWISE
- LOCATION OF ALL FIXTURES & FITTINGS IN  
DISABLED WC'S & SHOWERS SHALL COMPLY  
WITH AS1428.1
- PENETRATIONS IN SLAB BETWEEN  
FIRE COMPARTMENTS SHALL MAINTAIN  
FIRE SEPARATION BETWEEN FLOORS.  
REFER TO SERVICES ENGINEER'S DOCUMENTS.
- ALSO REFER TO REFLECTED  
CEILING DRAWINGS
- UNLESS NOTED OTHERWISE FINISHED LINE OF  
CORRIDOR SHALL ALIGN.




AMENDMENTS					
ISSUE	DATE	INFORMATION	ISSUE	DATE	INFORMATION
01	19.05.10	ISSUED FOR INFORMATION			
02	04.06.10	ISSUED FOR CO-ORDINATION & REVIEW			

CLIENT



Ingham Health Research Institute

PROJECT DIRECTOR  
PROJECT MANAGER



CAPITAL INSIGHT  
PTY LTD  
77 BERRY ST  
NORTH SYDNEY  
NSW 2060

PRINCIPAL DESIGN CONSULTANT



35 RICHARDS AVE SURRY HILLS  
NSW AUSTRALIA 2010  
ACN 009 369 931  
PH: (02) 8353 8888 FX: (02) 9332 2402  
E: msjarchitects@msjgroup.com.au  
W: msjgroup.com.au  
McConnel Smith & Johnson  
ARCHITECTS

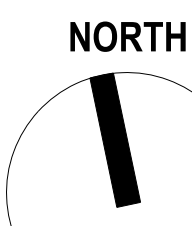
DESIGN CONSULTANTS

TAYLOR THOMPSON &  
WITTING STRUCTURAL  
ENGINEERS

WHIPPS-WOOD  
CONSULTING HYDRAULIC  
ENGINEERS

STEENSEN VARMIING  
MECHANICAL /  
ELECTRICAL ENGINEERS

KEY PLAN



NORTH

PROJECT INGHAM HEALTH RESEARCH INSTITUTE AT LIVERPOOL HOSPITAL		DRAWN JO		SCALE 1:100 @ A1 1:200 @ A3	
DRAWING NAME FLOOR PLAN LEVEL 3		DESIGN MSJ		JOB No.	ISSUE
		CHECKED JZ		09.22	02
DATE 25.03.10				DRAWING NUMBER A-1003	