


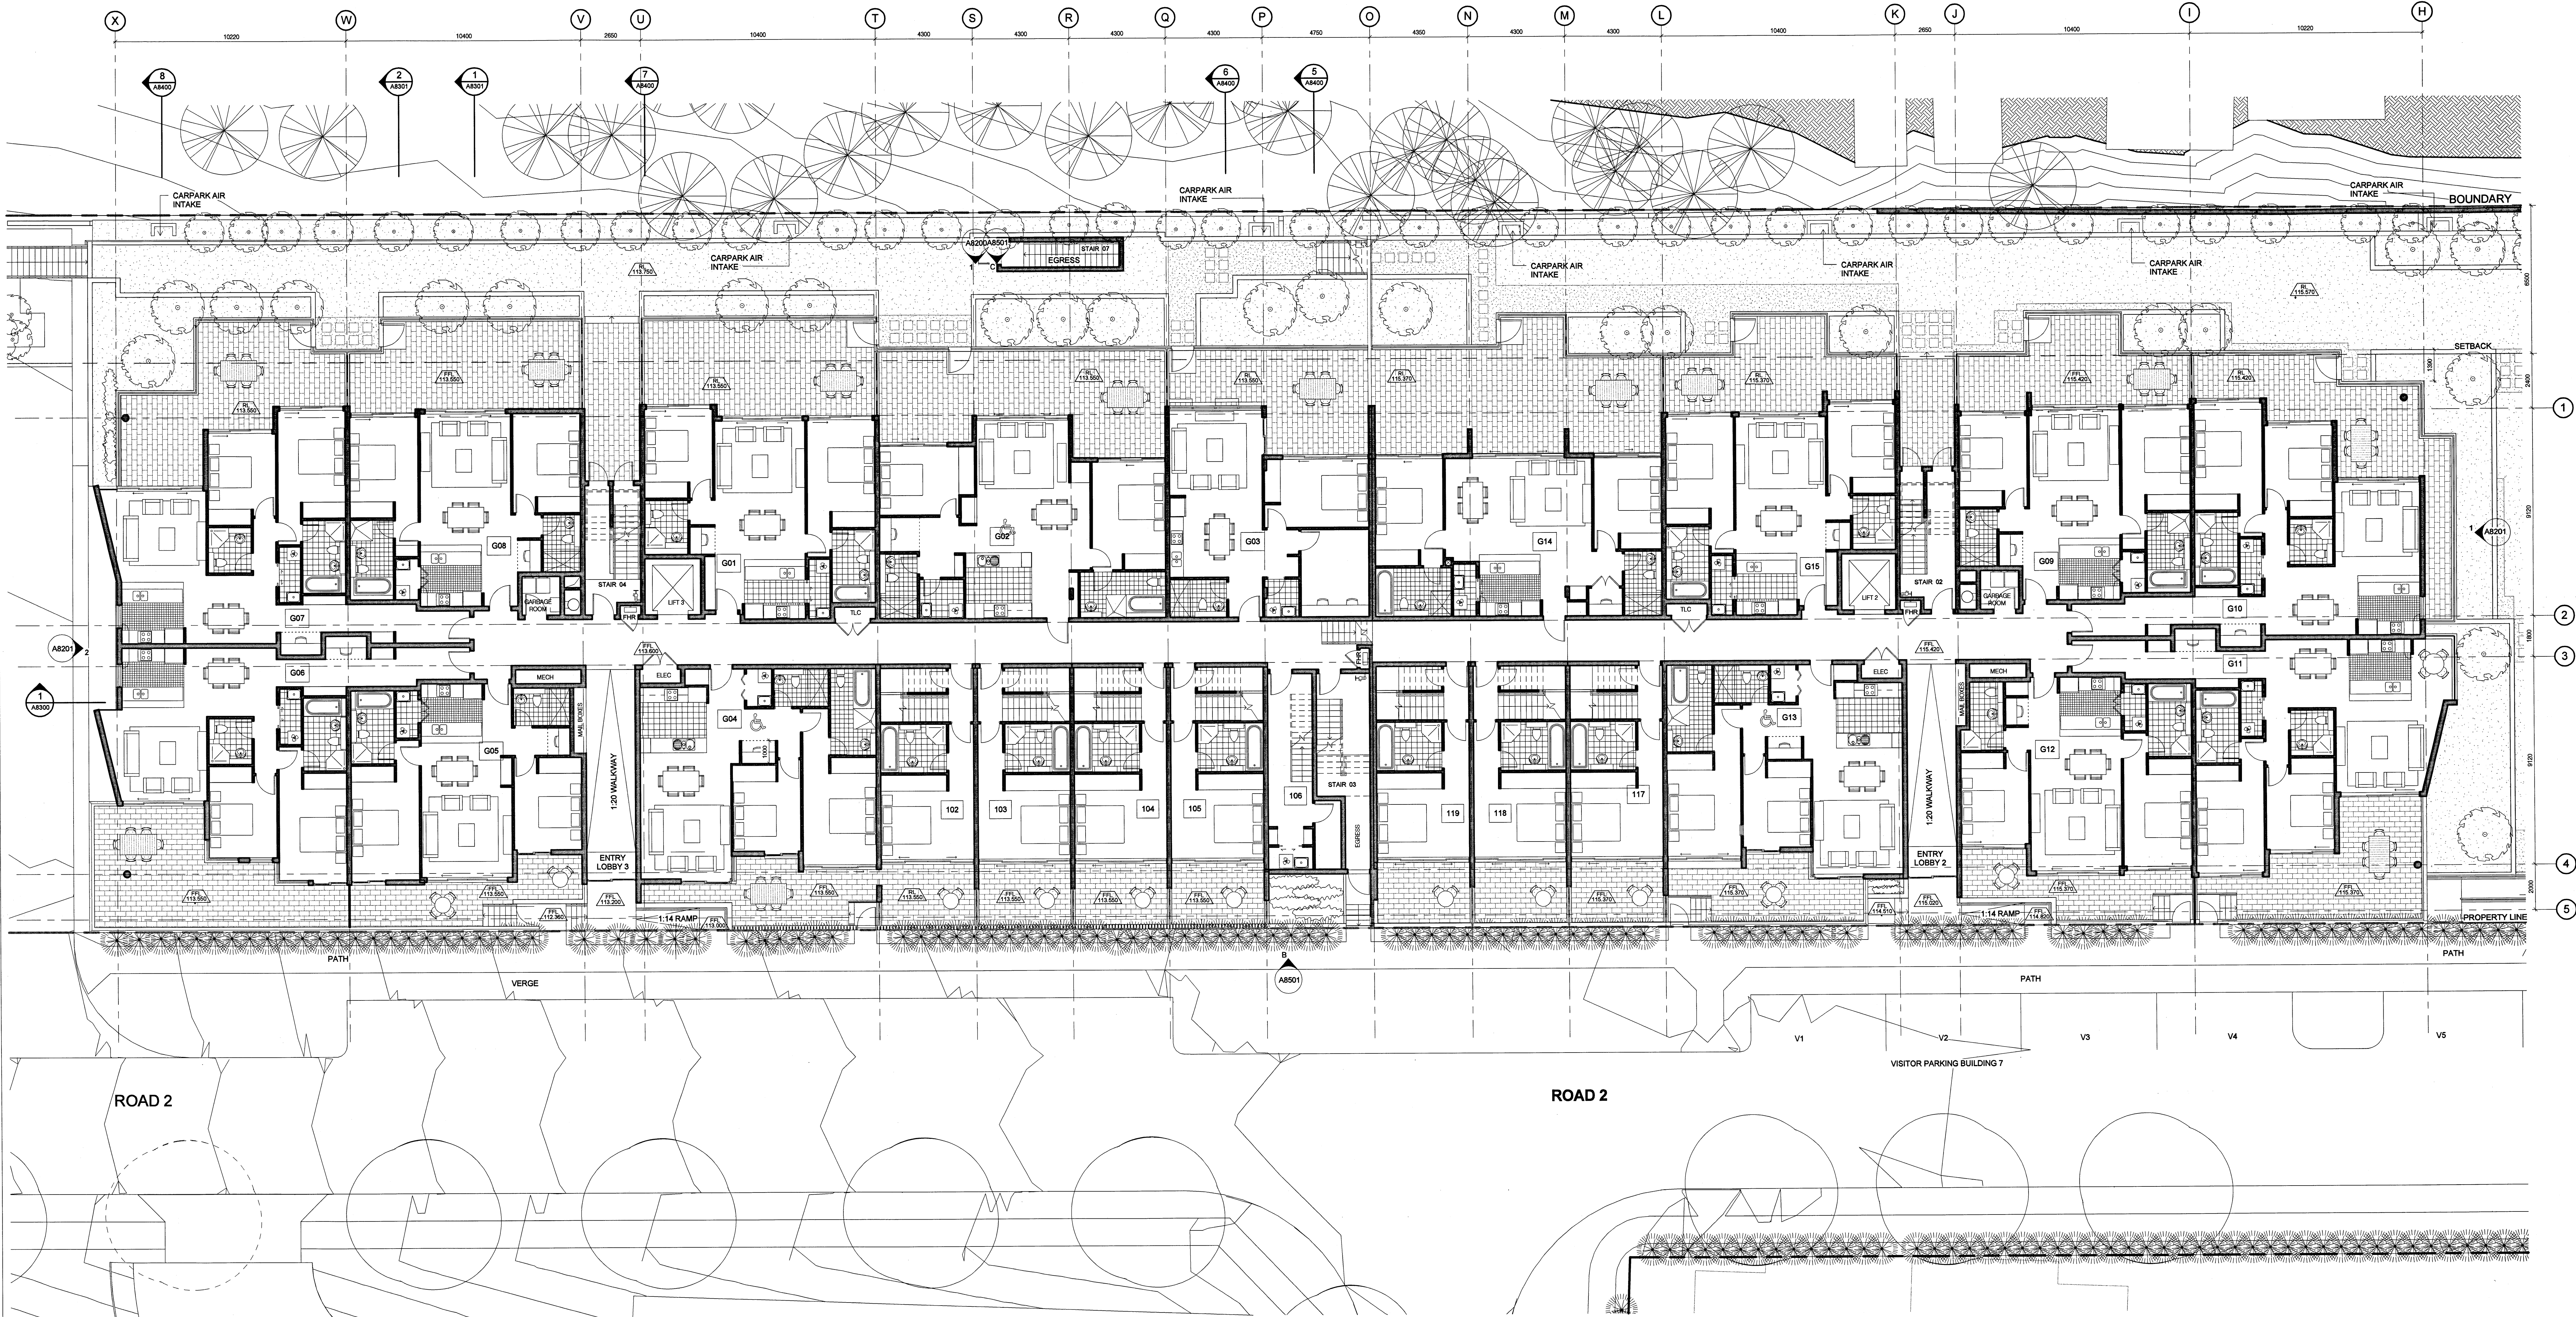

1 BUILDING 8 GROUND FLOOR PLAN
1:100

KEY

FHR FIRE HOSE REEL
HYD FIRE HYDRANT
TLC TELECOM CUPBOARD
ELEC ELECTRICAL CUPBOARD


NOTE:

- Furniture layout shown indicative only.
- Site and Landscape shown for context only. Refer to Landscape Drawings .

Do not scale from drawings. Verify all dimensions on site before commencing work. Copying or the reproduction of this drawing is strictly prohibited without the consent of Peddle Thorp & Walker P/L.

PROJECT APPLICATION
PROJECT APPLICATION RE-ISSUE
13.12.2010
05.04.2011

Key Plan

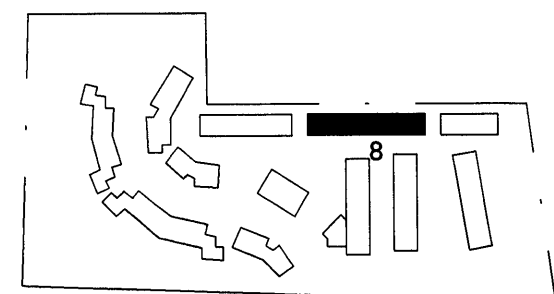

Consultants

Landscape Architects
Daylight/Solar Access
Traffic
Nathans/Bask
Acoustic
Sturt Associates
Heggles
Transport and Traffic Planning Associates
Efficient Living
Acoustic Logic

Suite 91, Level 5, 330 Watlie Street, Ultimo NSW 2007
2 Lincon Street, Lane Cove NSW 2066
Suite 603, Level 6, 282 Victoria Avenue, Chatswood NSW 2067
24B/176 South Creek Road, Cromer NSW 2099
9 Sarah Street, Mascot NSW 2020
Tel: 9211 3744
Tel: 9427 8100
Tel: 9411 5660
Tel: 9944 0332
Tel: 8338 9888

Client

Merton Apartments Pty Ltd
Level 11, 528 Kent Street
Sydney NSW Australia 2000
T (02) 92872888
F (02) 92872777
www.merton.com.au

Architect

PTW Architects
Level 17, 9 Castlereagh St
Sydney NSW Australia 2000
T 612 9232 5877
F 612 9221 4139
www.ptw.com.au

PTW

Title Building 8 Ground Floor Plan

Scale 1:100 @ A0

Drawing

PROJ NO: 209 001
SCALE: 1:100 @A0
DATE: 10/2010

APPROVED: PSC

Project

Epping Park
61 Mables Lane, Epping
Stage 1 (Building 7+8)
A8103
PROJECT
APPLICATION