
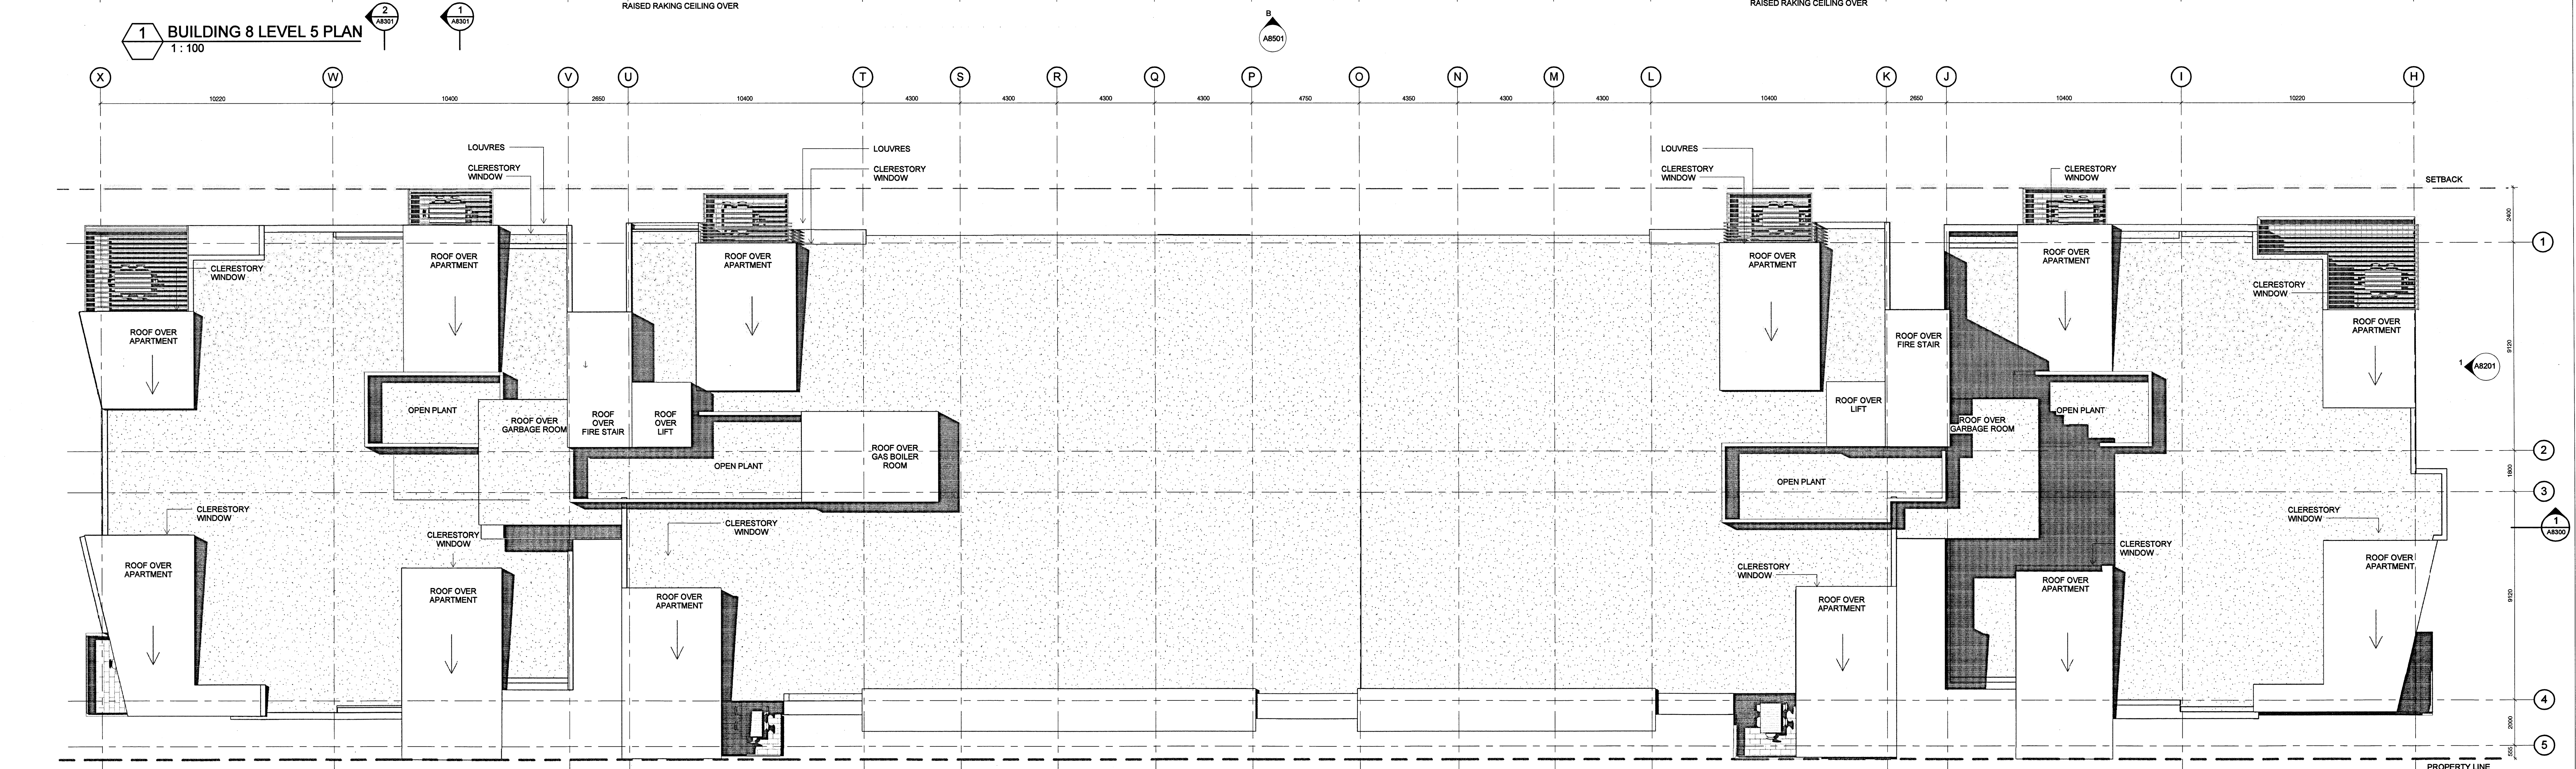


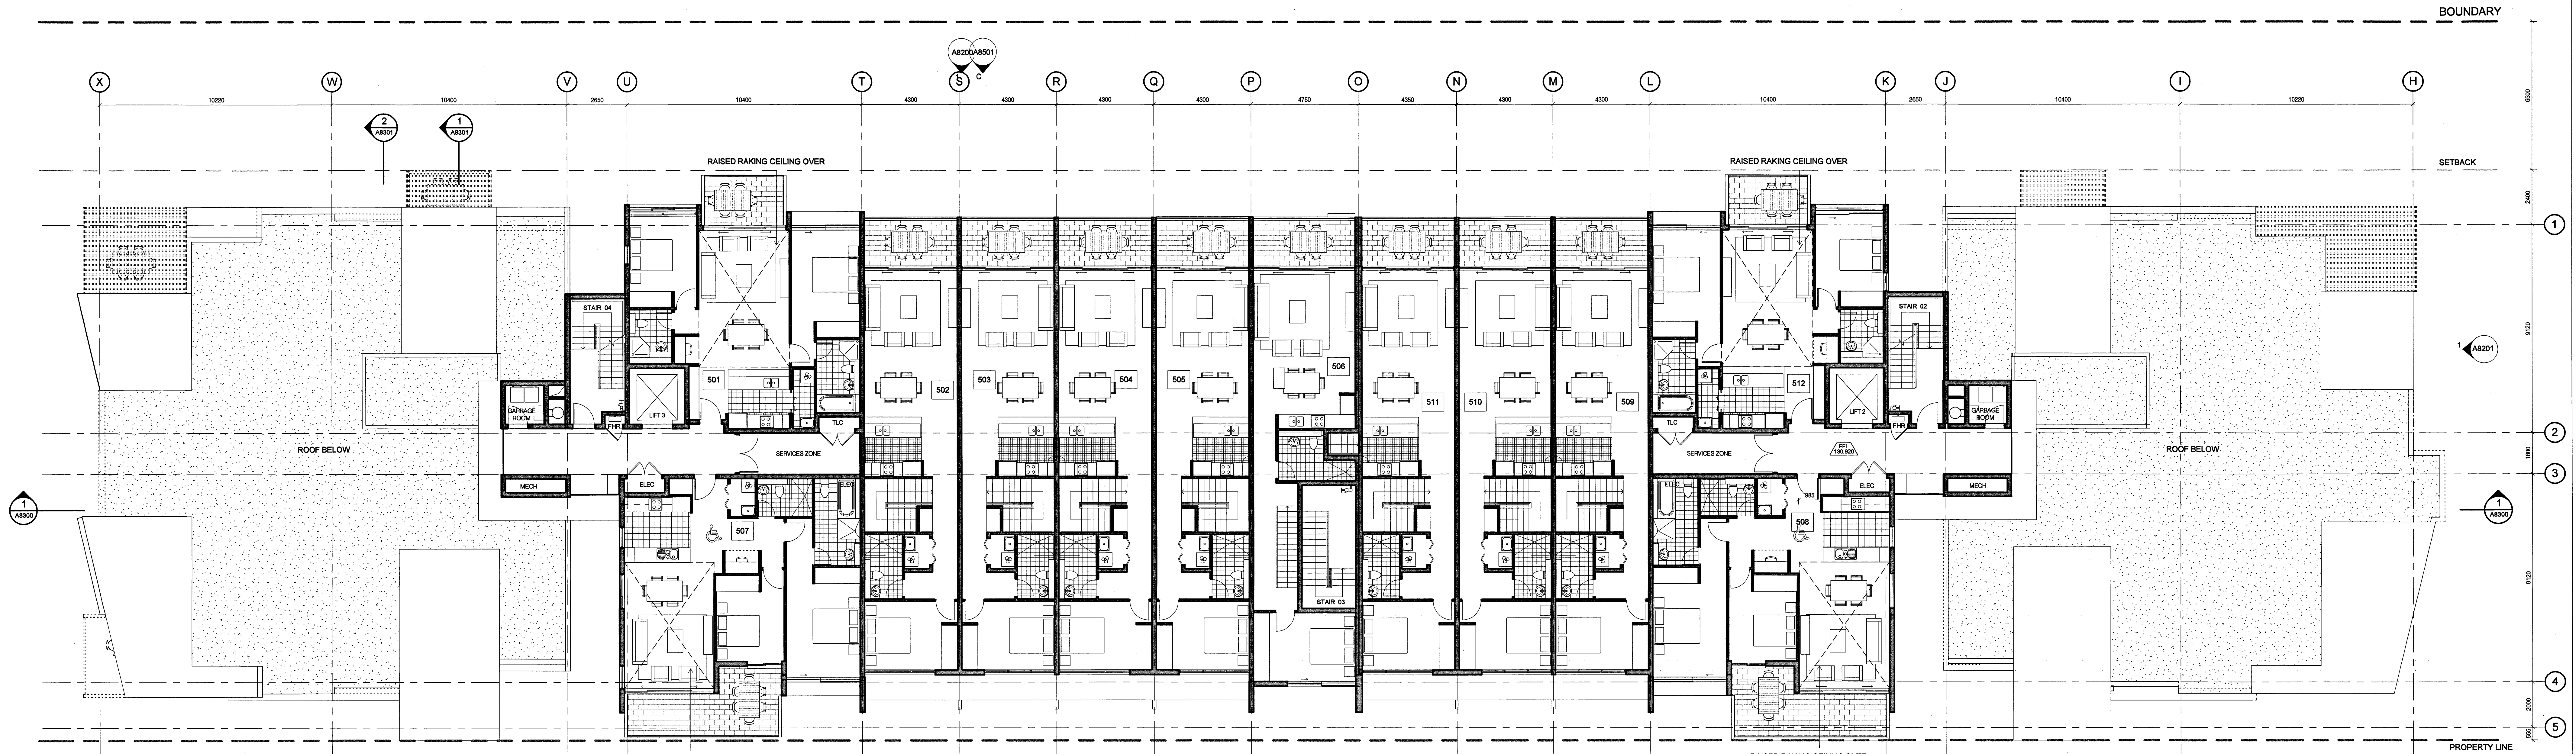

KEY

FHR FIRE HOSE REEL
HYD FIRE HYDRANT
TLC TELECOM CUPBOARD
ELEC ELECTRICAL CUPBOARD

NOTE:

1. Furniture layout shown indicative only.
2. Site and Landscape shown for context only. Refer to Landscape Drawings .

NSW GOVERNMENT
Planning
Issued under the Environmental Planning and Assessment Act 1979
Approved Application No. MP10-0158
granted on the 11/11/2011
Signed [Signature]
Sheet No. 19 of 33

Revision

PROJECT APPLICATION
PROJECT APPLICATION RE-ISSUE
13.12.2010
05.04.2011

Revision

Key Plan

Consultants

Landscape Architects
Daylight/Solar Access
Traffic
Nathers/Bask
Acoustic

Sturt Associates
Heggies
Transport and Traffic Planning Associates
Efficient Living
Acoustic Logic

Suite 91, Level 5, 330 Wattle Street, Ultimo NSW 2007
2 Lincoln Street, Lane Cove NSW 2066
Suite 603, Level 6, 282 Victoria Avenue, Chatswood NSW 2067
24B/176 South Creek Road, Cromer NSW 2099
9 Sarah Street, Mascot NSW 2020

Tel: 9211 3744
Tel: 9427 8100
Tel: 9411 5660
Tel: 9944 0332
Tel: 8338 9888

Client

Merton Apartments Pty Ltd

Level 11, 528 Kent Street
Sydney NSW Australia 2000
T 612 9232 5977
F 612 9221 4139
www.merton.com.au

Architect

PTW Architects

Level 17, 9 Castlereagh St
Sydney NSW Australia 2000
T 612 9232 5977
F 612 9221 4139
www.ptw.com.au

Drawing

Project

PTW

Title Building 8 Level 5 & Roof Plan

Scale 1:100 @ A0

APPROVED: PSC

Epping Park
61 Moles Lane, Epping
Stage 1 (Building 7+8)
A8106
PROJECT
APPLICATION